


# MAIN FLOOR

SCALE: 0.1094" = 1'-0"

ELECTRICAL LEGEND		
ELECTRICAL	COUNT	SYMBOL
fin can w/ exhaust fan	3	
can light 4inch	4	
can light 6inch	8	
Pendant	2	
Ceiling Fan	6	
ceiling light 04	2	
ceiling light 08	1	
electrical panel	1	
Exterior ceiling lightsw	2	
exterior craftsman light fixture	2	
outlet	36	
outlet - exterior	1	
outlet gfi	6	
smoke detector	5	
spotlight double	3	
vanity bar light 02	3	


AREA SCHEDULE		
NAME	AREA	
Heated Area	2248 sq ft.	
Covered Porch Area	395 sq ft.	

Bishop and Hadorn Residence  
 Parcel: 24-68-16-04063-013  
 Columbia County, FL

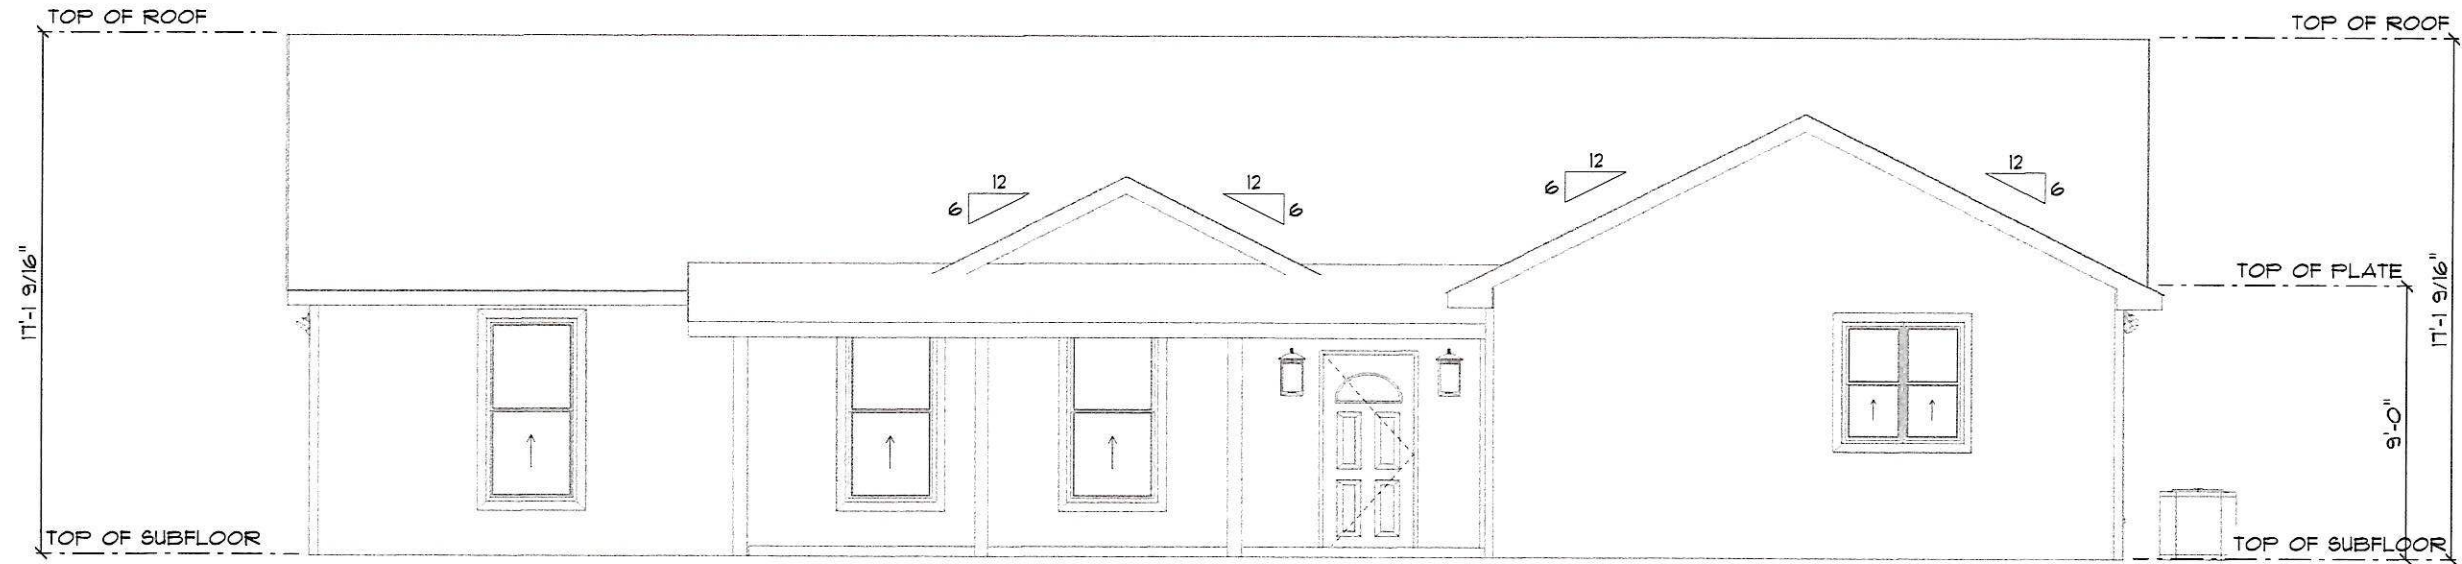


## SOUTH ELEVATION

SCALE: 1/8" = 1'-0"

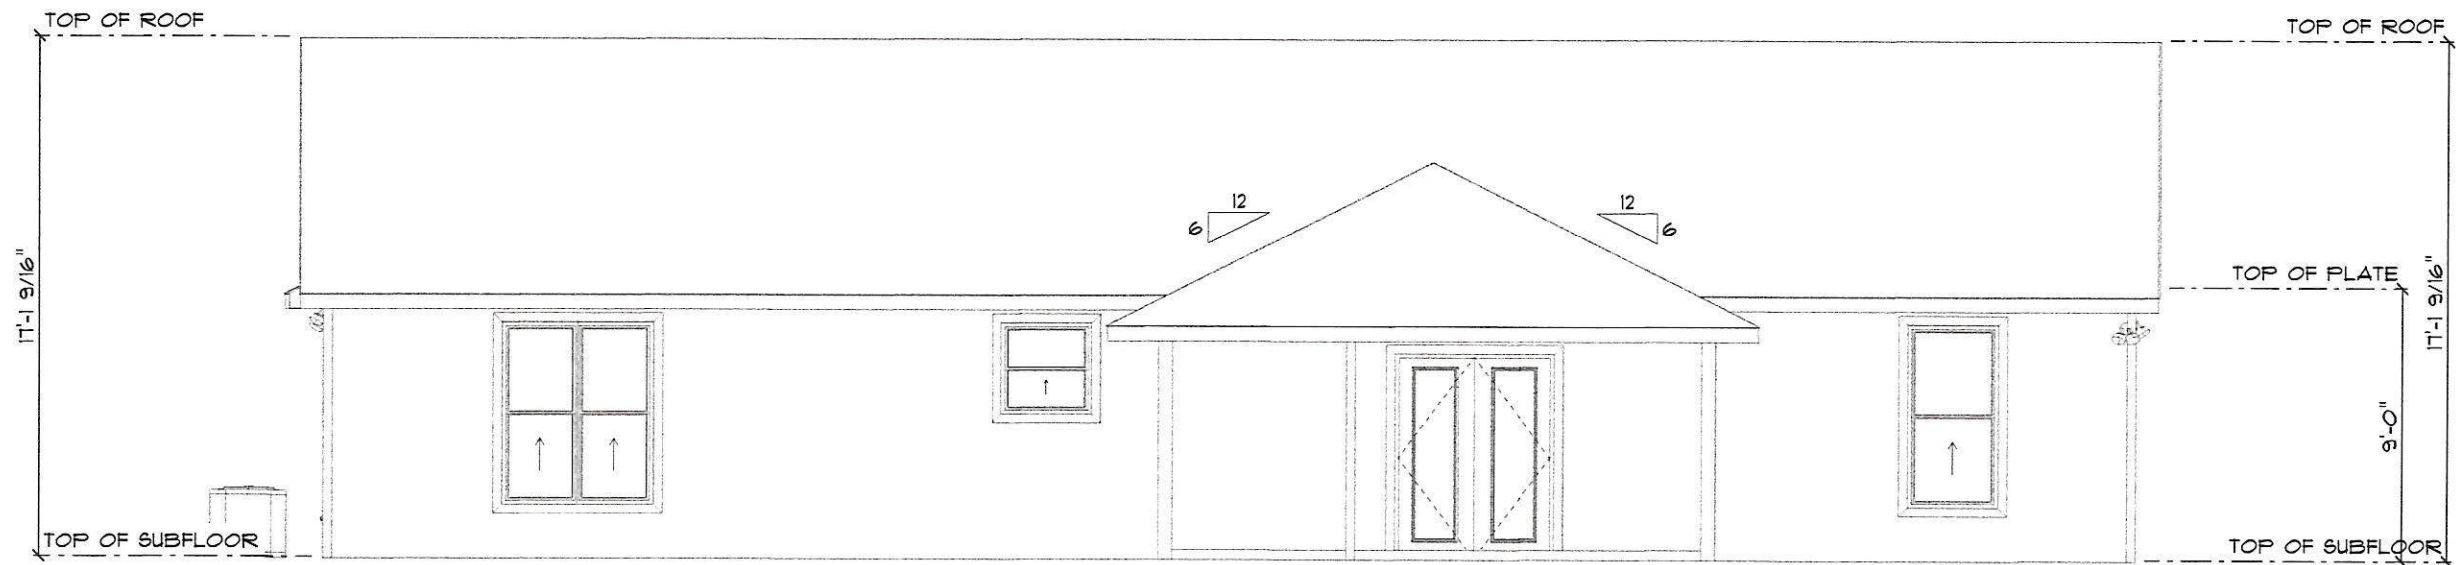


## NORTH ELEVATION

SCALE: 1/8" = 1'-0"

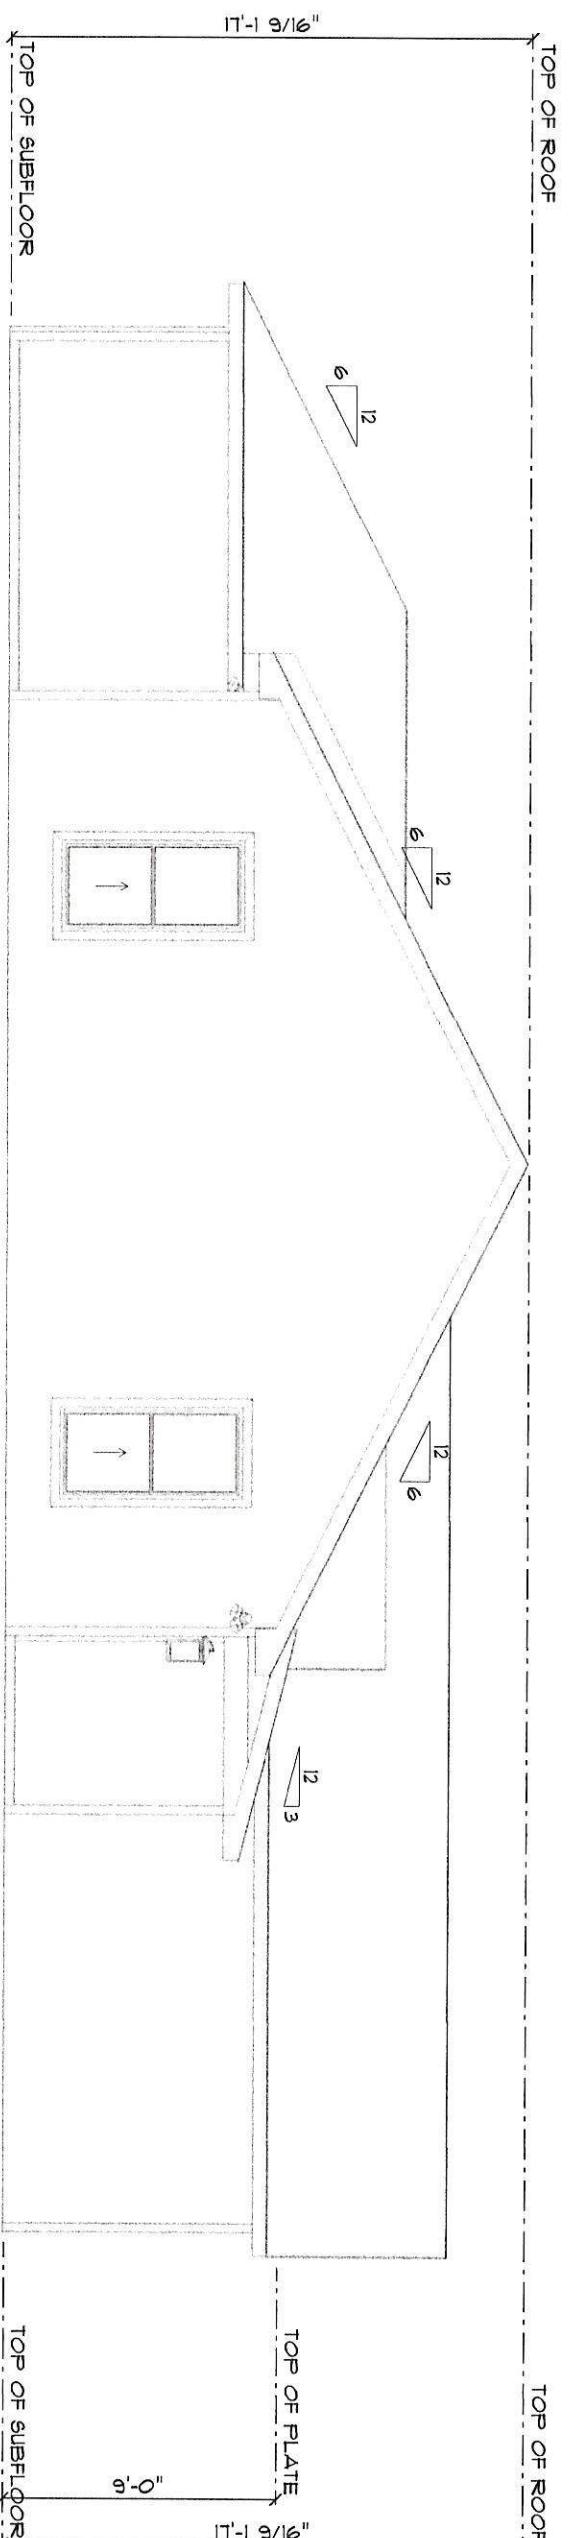

# WEST ELEVATION

SCALE: 1/8" = 1'-0"

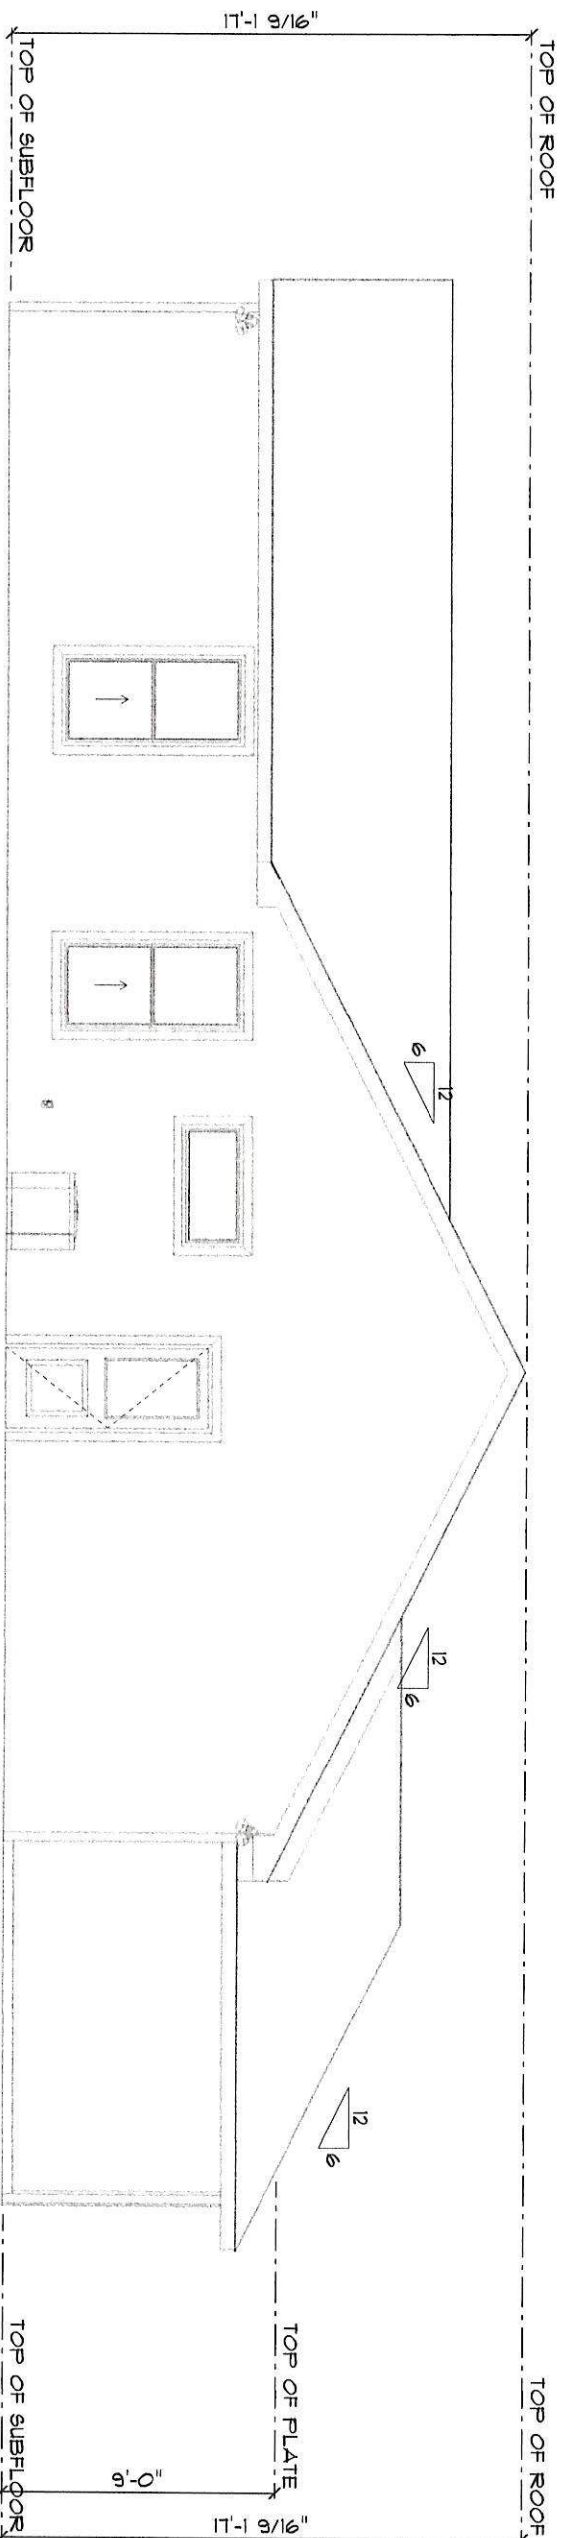

# EAST ELEVATION

SCALE: 1/8" = 1'-0"