


SW Skyline Loop

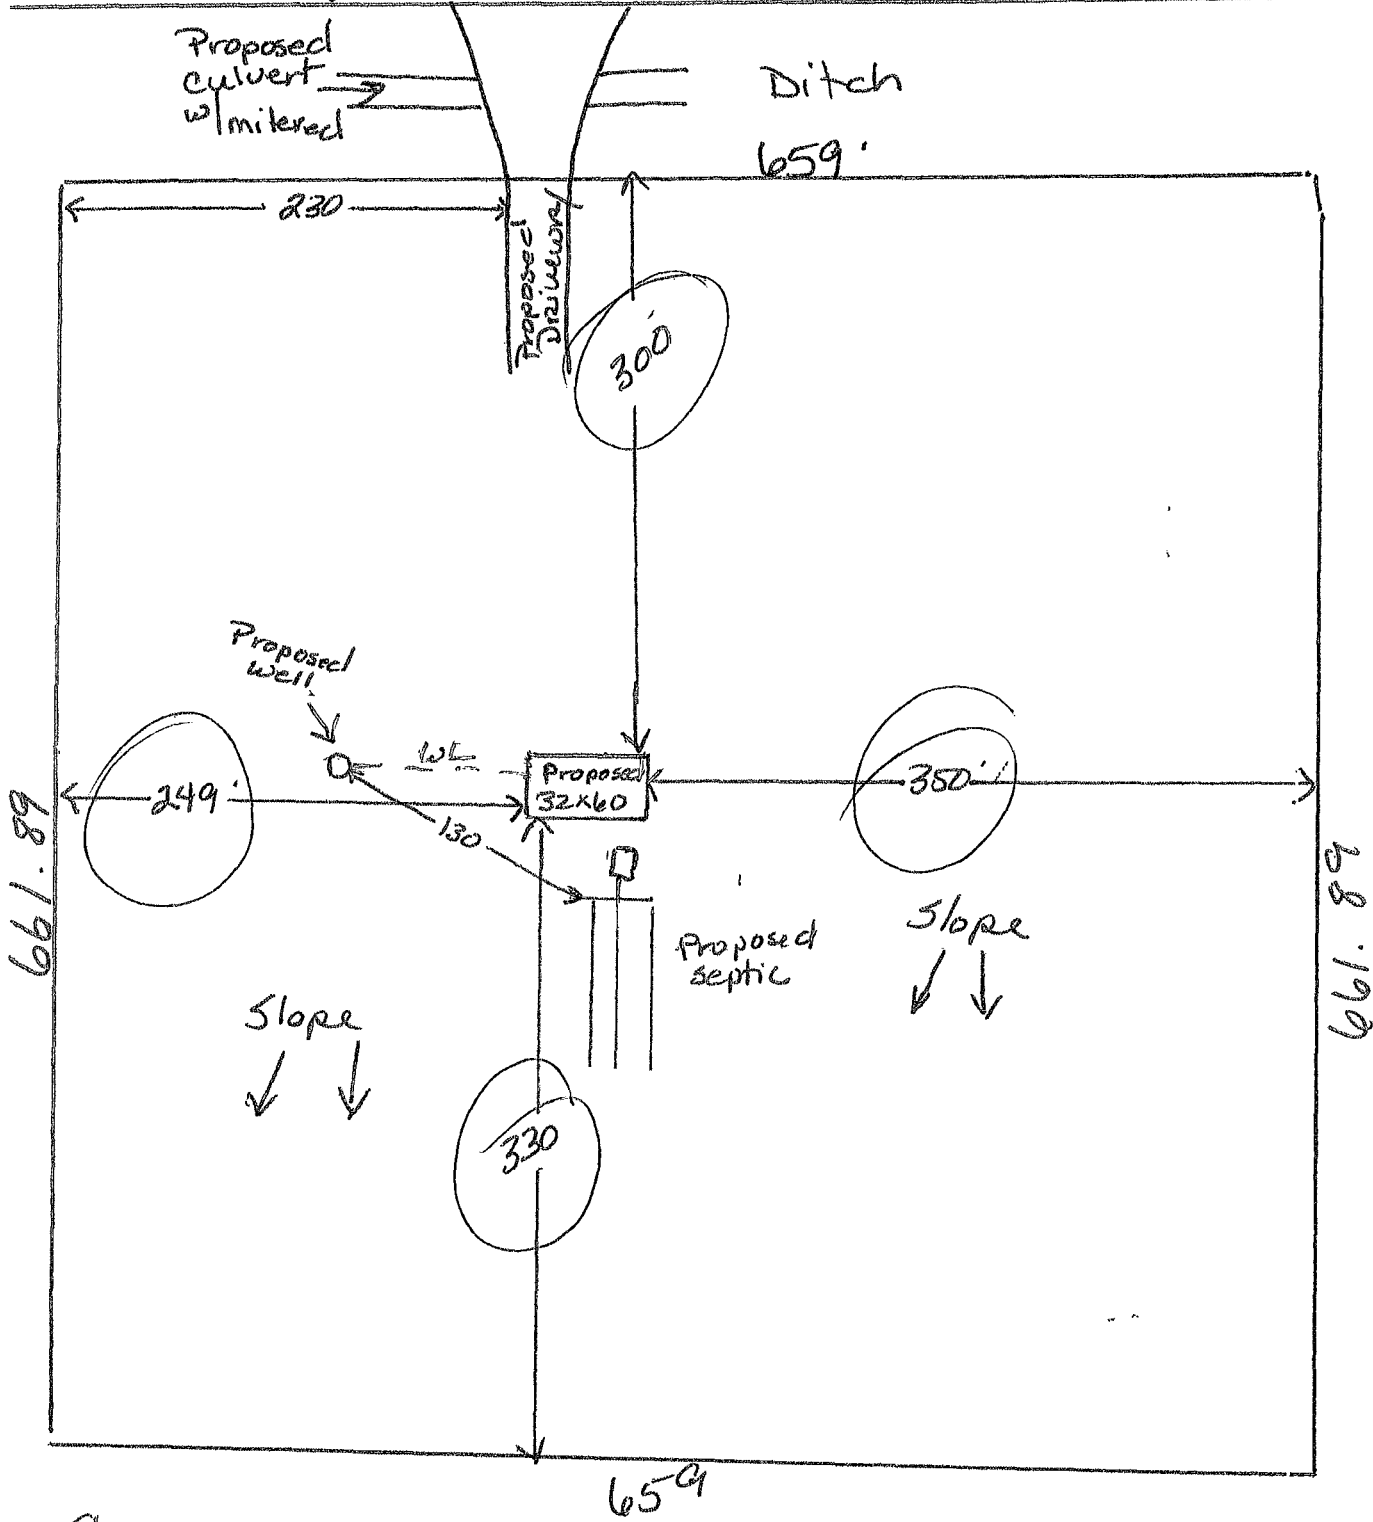

Scale 1" = 100'

Leonard Conkey

57 Casshill Ct.


STATE OF FLORIDA
DEPARTMENT OF HEALTH
APPLICATION FOR ONSITE SEWAGE DISPOSAL SYSTEM CONSTRUCTION PERMIT

Permit Application Number 13-0188

Conley

PART II - SITEPLAN

Scale: 1 inch = 40 feet

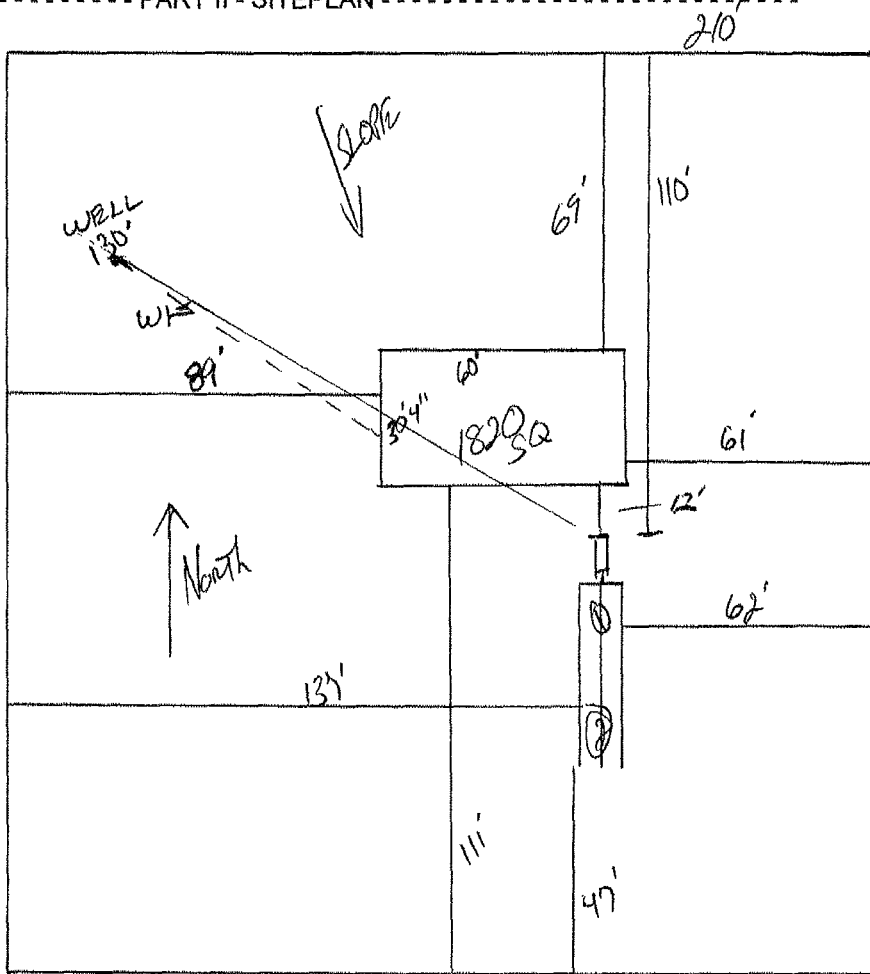

Notes. 1 of 10.01 Areas Site Attached

Site Plan submitted by: *Rodney D Ford* *Wendy Kennell - Agent*
 Plan Approved Not Approved MASTER CONTRACTOR
 By *Sallie Ford Env Health Director Columbia* Date *4.9.13*
 County Health Department

ALL CHANGES MUST BE APPROVED BY THE COUNTY HEALTH DEPARTMENT