


DESIGN CRITERIA

FL. BUILDING CODE	RESIDENTIAL	2011
FL. ELECTRICAL	NAT. ELEC. CODE	2014
FL. PLUMBING	FL.	2011
MECHANICAL	FL.	2011
WIND LOAD DESIGN	ASCE 7-10 (ALL HEIGHTS)	
WIND LOAD DESIGN	FBC, TPI 2014	FBC 2011
ROOF LIVE LOAD	20 PSF	
FLOOR LIVE LOAD	40 PSF	

IT IS THE OWNER AND OR THE CONTRACTORS RESPONSIBILITY TO VERIFY ALL STRUCTURAL ASPECTS OF THESE DRAWINGS. THIS INCLUDES BUT NOT LIMITED TO DIMENSIONS, WALL HEIGHTS AND MATERIAL, WINDOW SIZE AND LOCATION. ALSO ALL STATE AND LOCAL CODES MUST BE FOLLOWED

ALL WINDOWS AND DOORS TO BE INSTALLED PER MANUFACTURERS RECOMMENDATIONS AND MUST COMPLY WITH CURRENT CODES. SUBMIT ATTACHMENT WORKSHEET WITH PERMIT DOCUMENTS

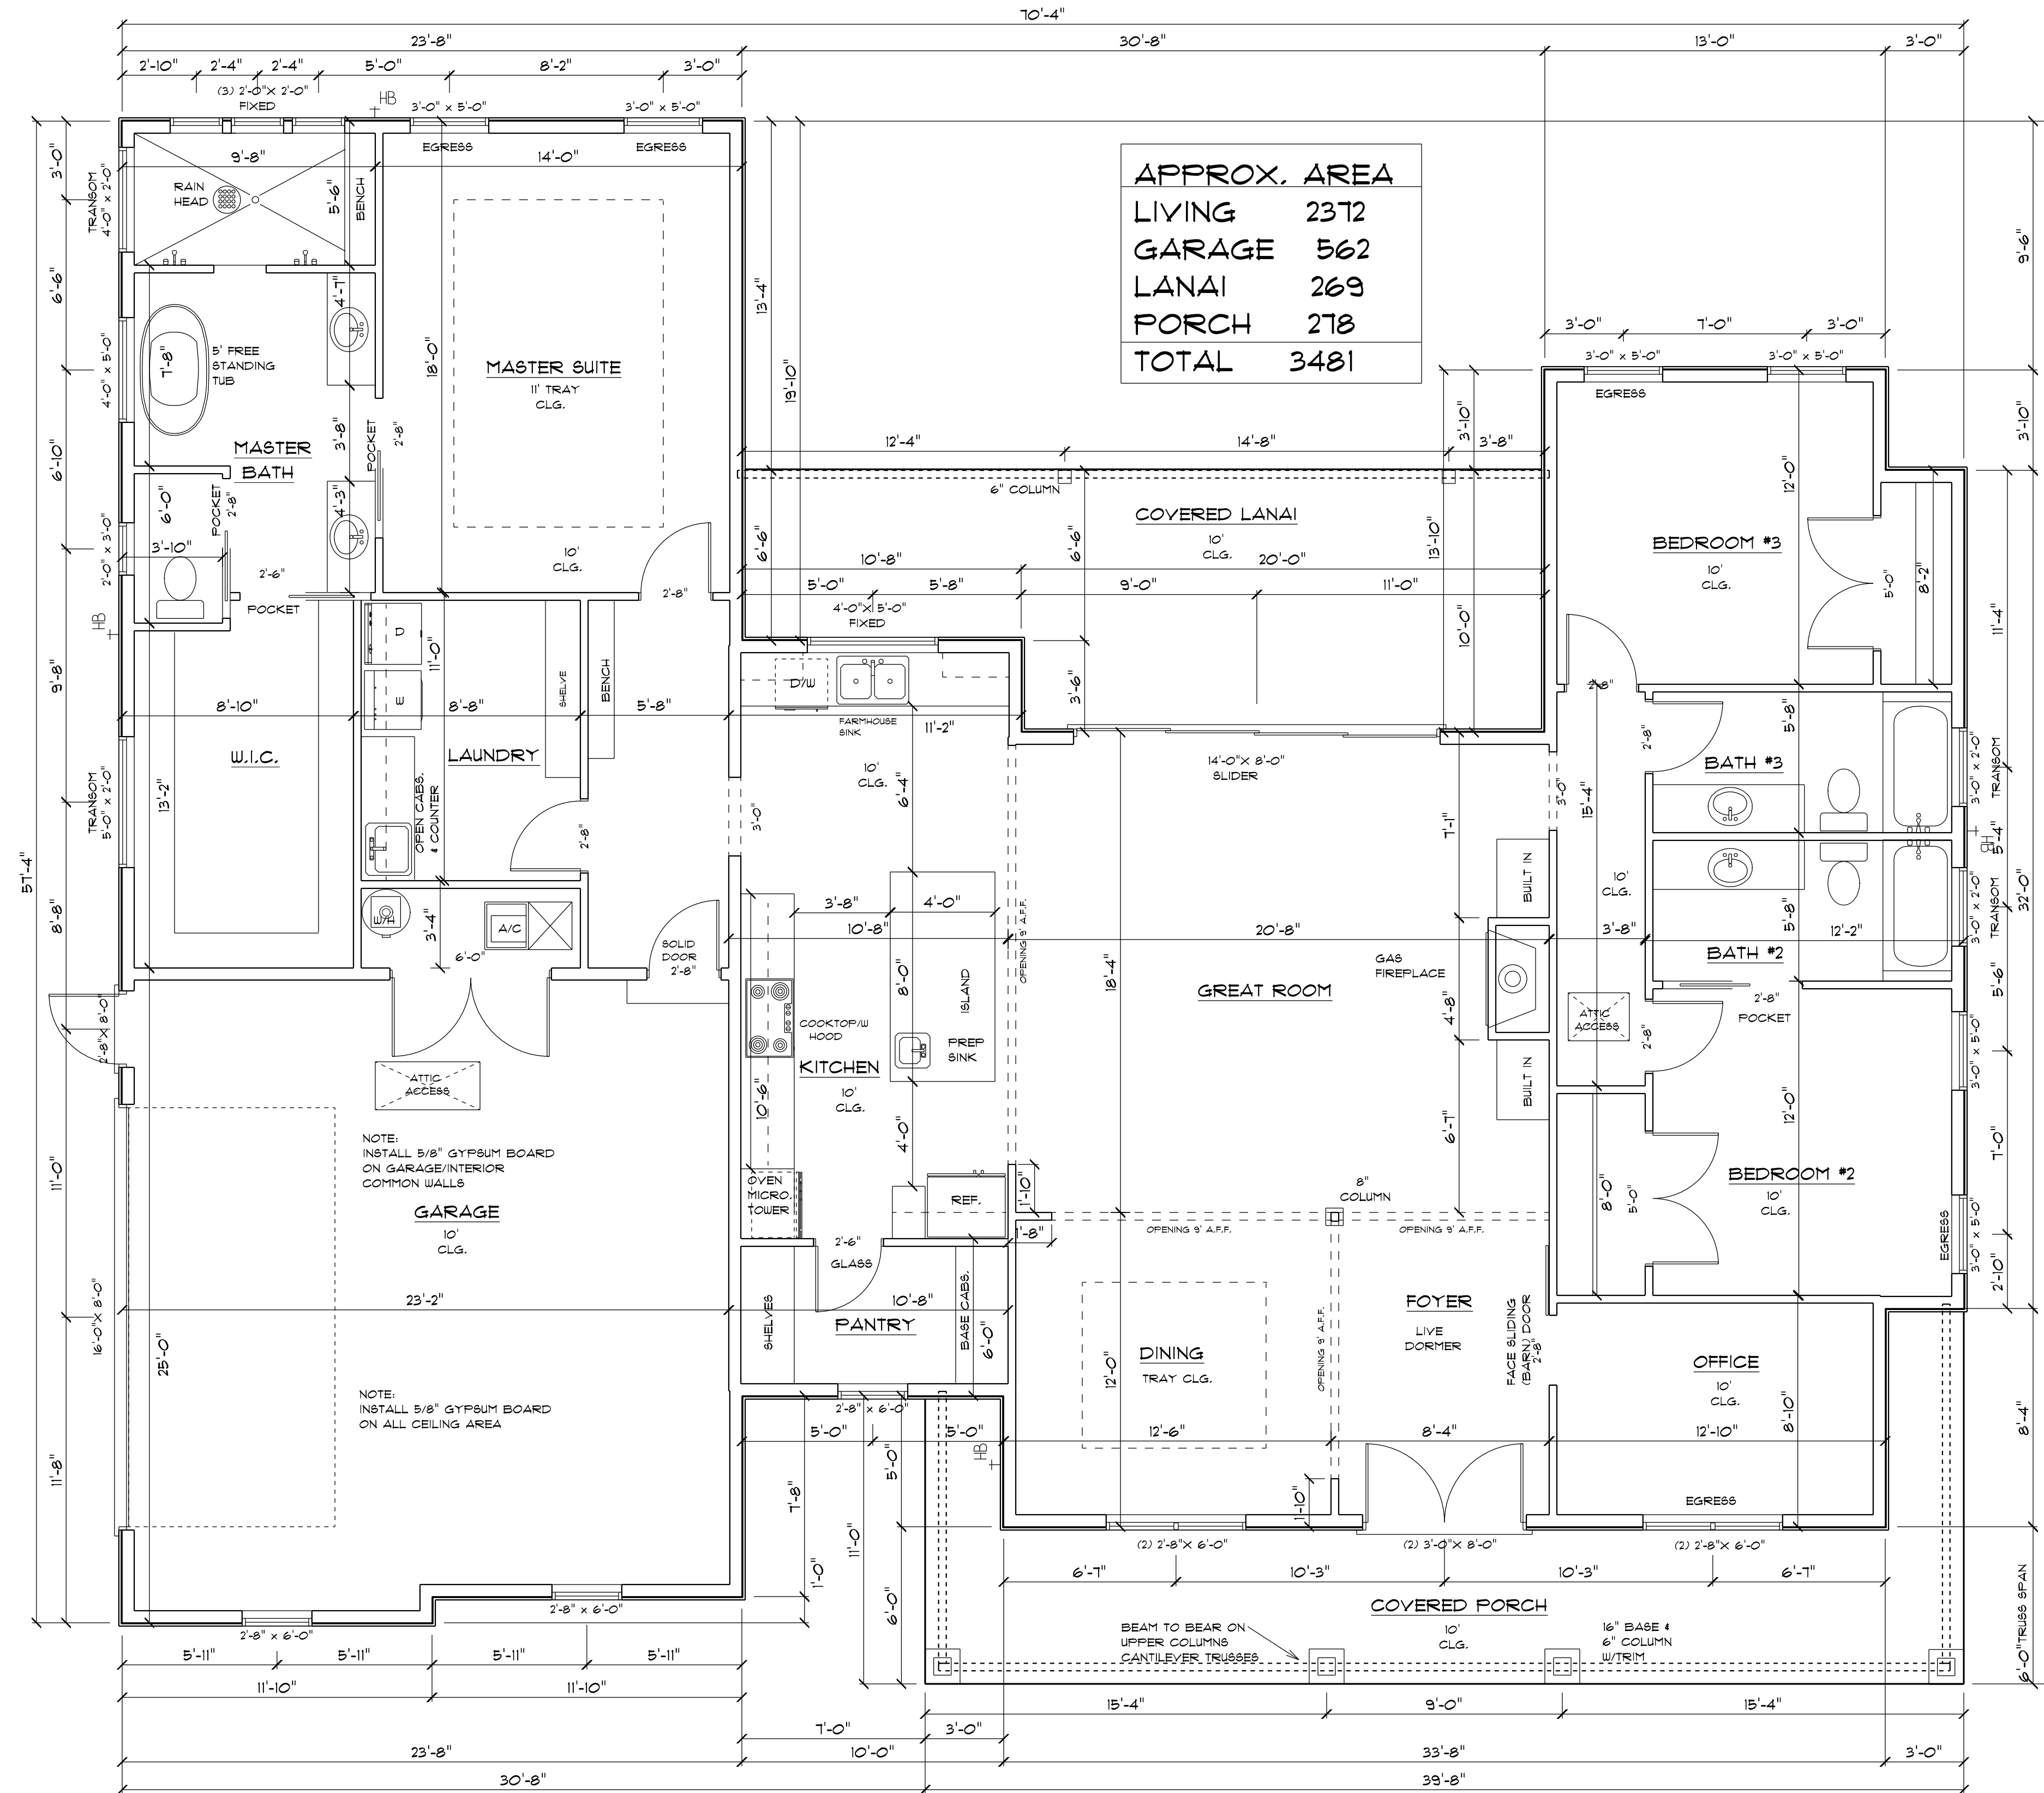

ALL DOORS TO BE 8' TALL

MAIN FLOOR PLAN


DATE 9/9/20

COLACINO DRAFTING+DESIGN PH. 352-472-3462

AMIRA BUILDERS

SCALE 1/4" = 1'
DRAWN BY P.A.C.

THOMAS RESIDENCE

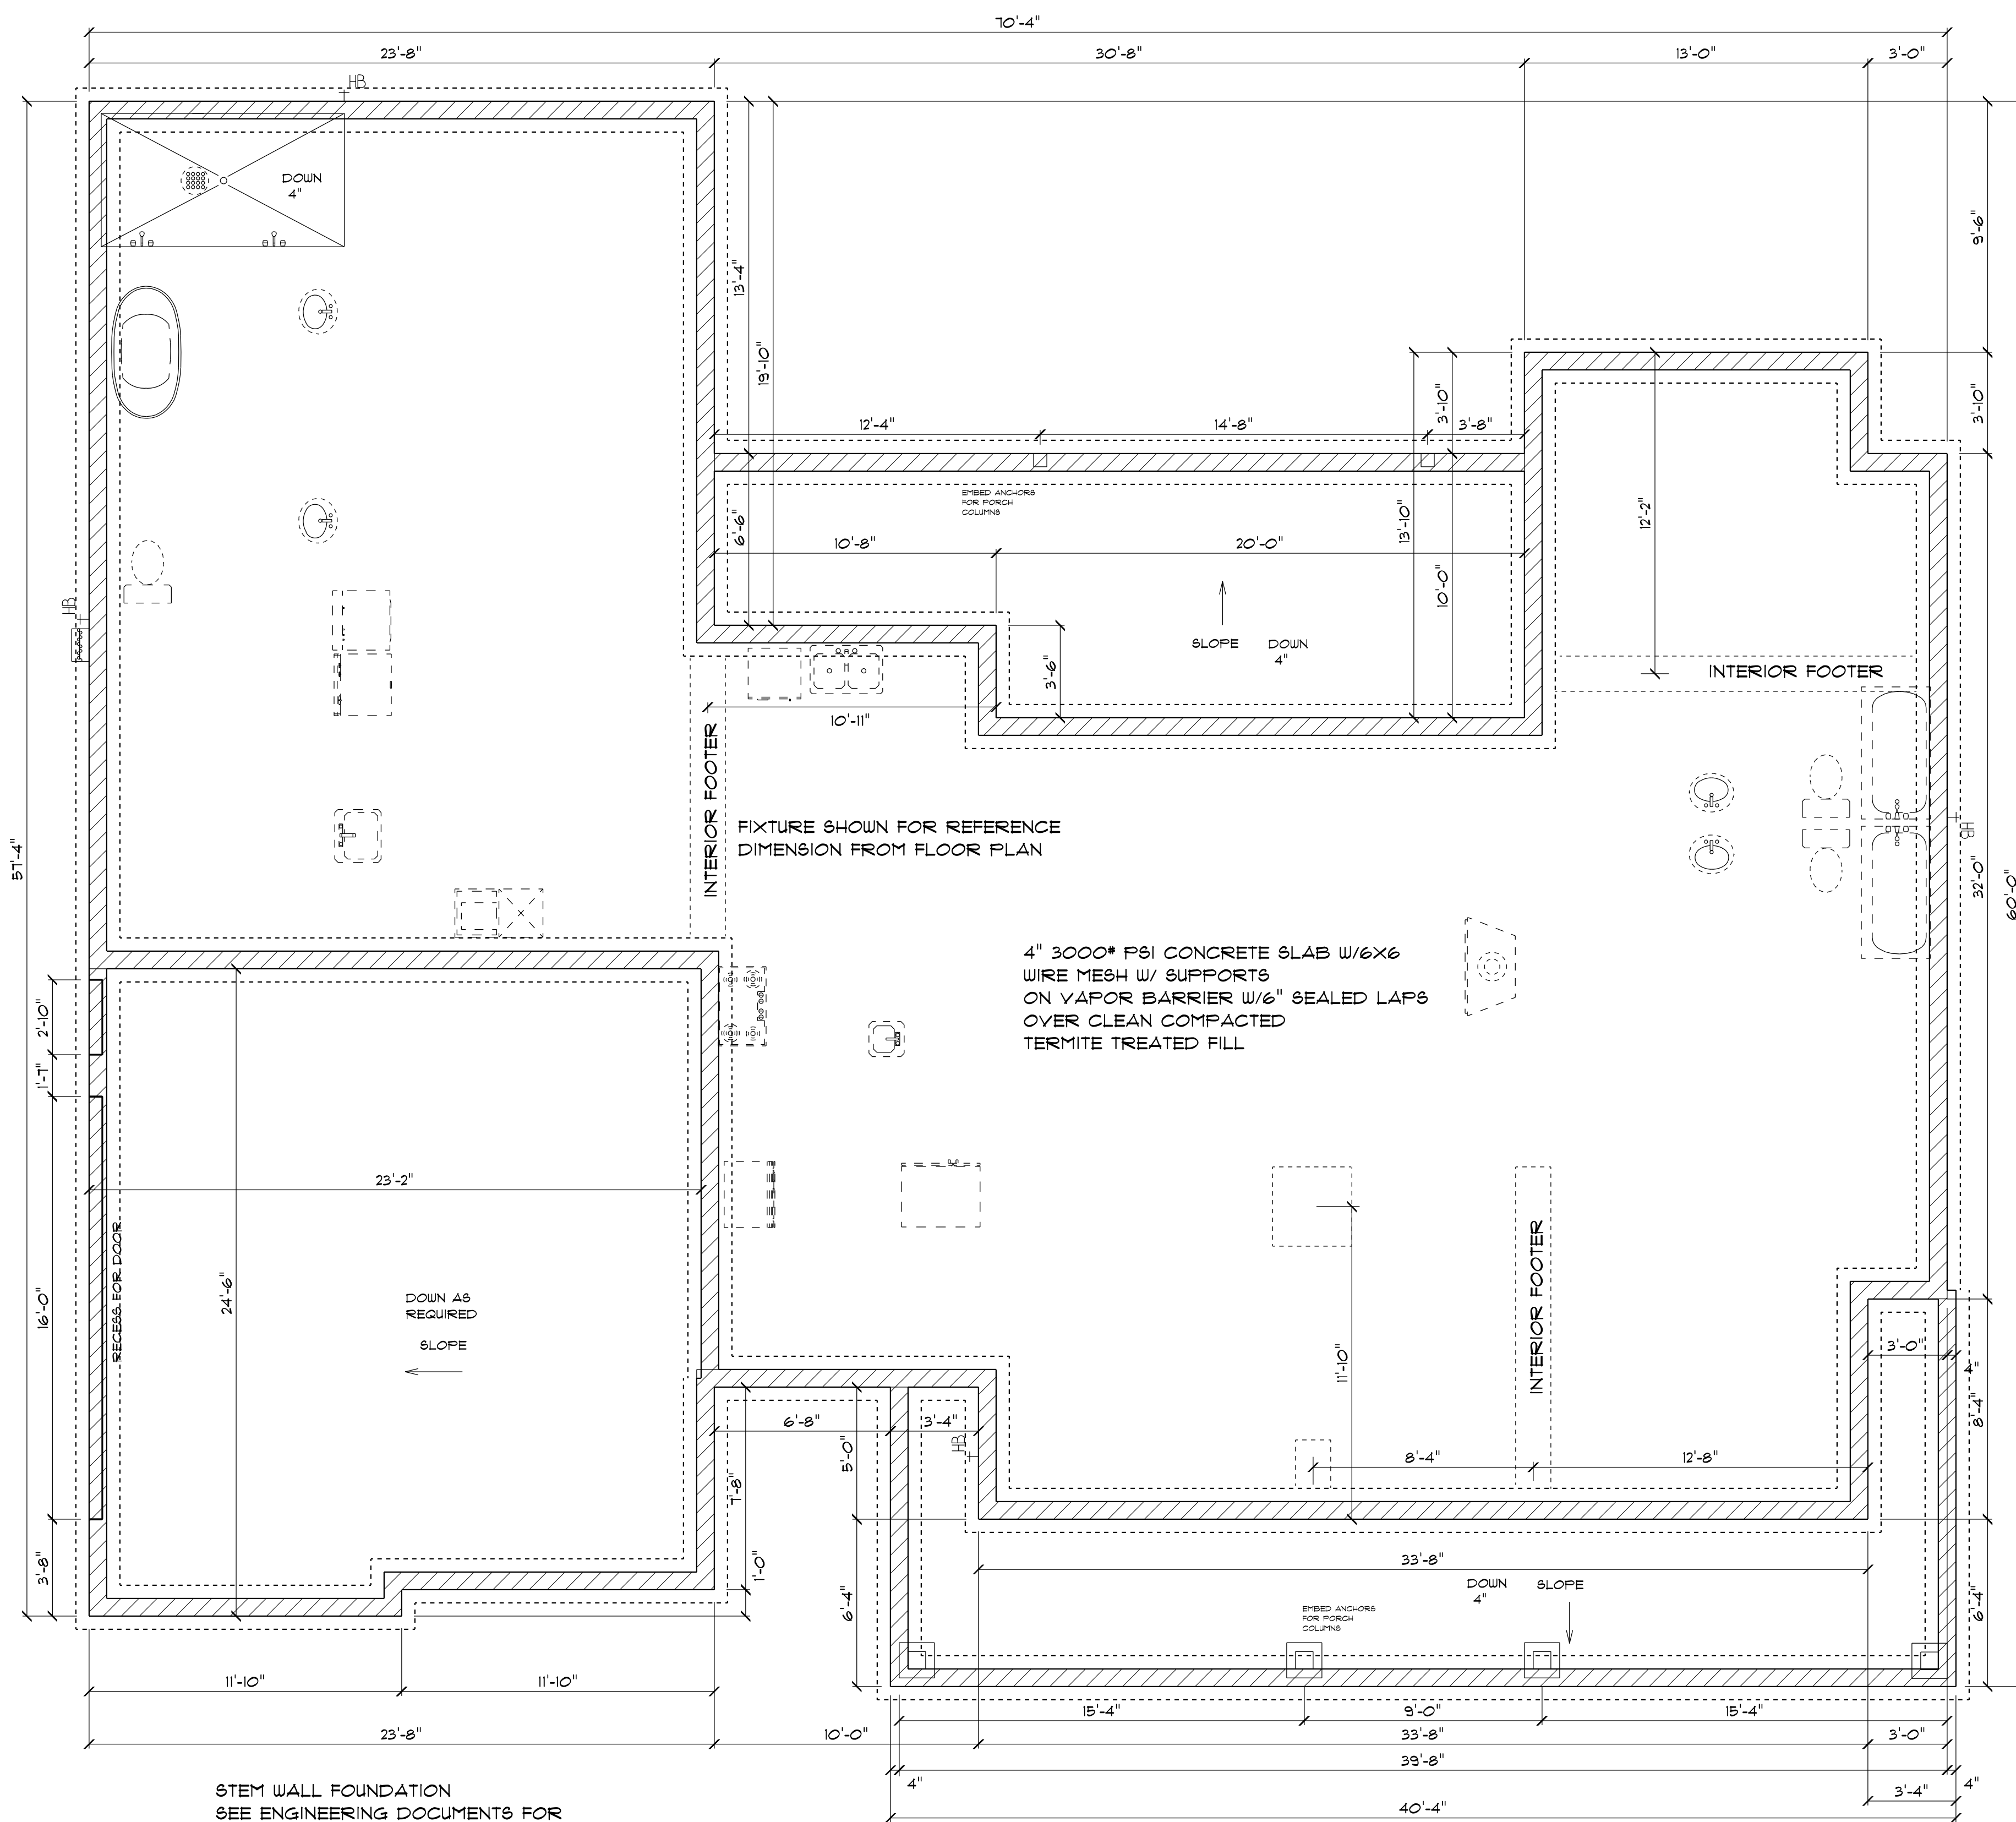

STEM WALL FOUNDATION
 SEE ENGINEERING DOCUMENTS FOR
 ALL FOUNDATION INFORMATION
 AND REQUIREMENTS

FOUNDATION PLAN

NOTE:
 VERIFY INTERIOR BEARING WALLS
 WITH ROOF TRUSS COMPANY






LEFT ELEVATION



RIGHT ELEVATION

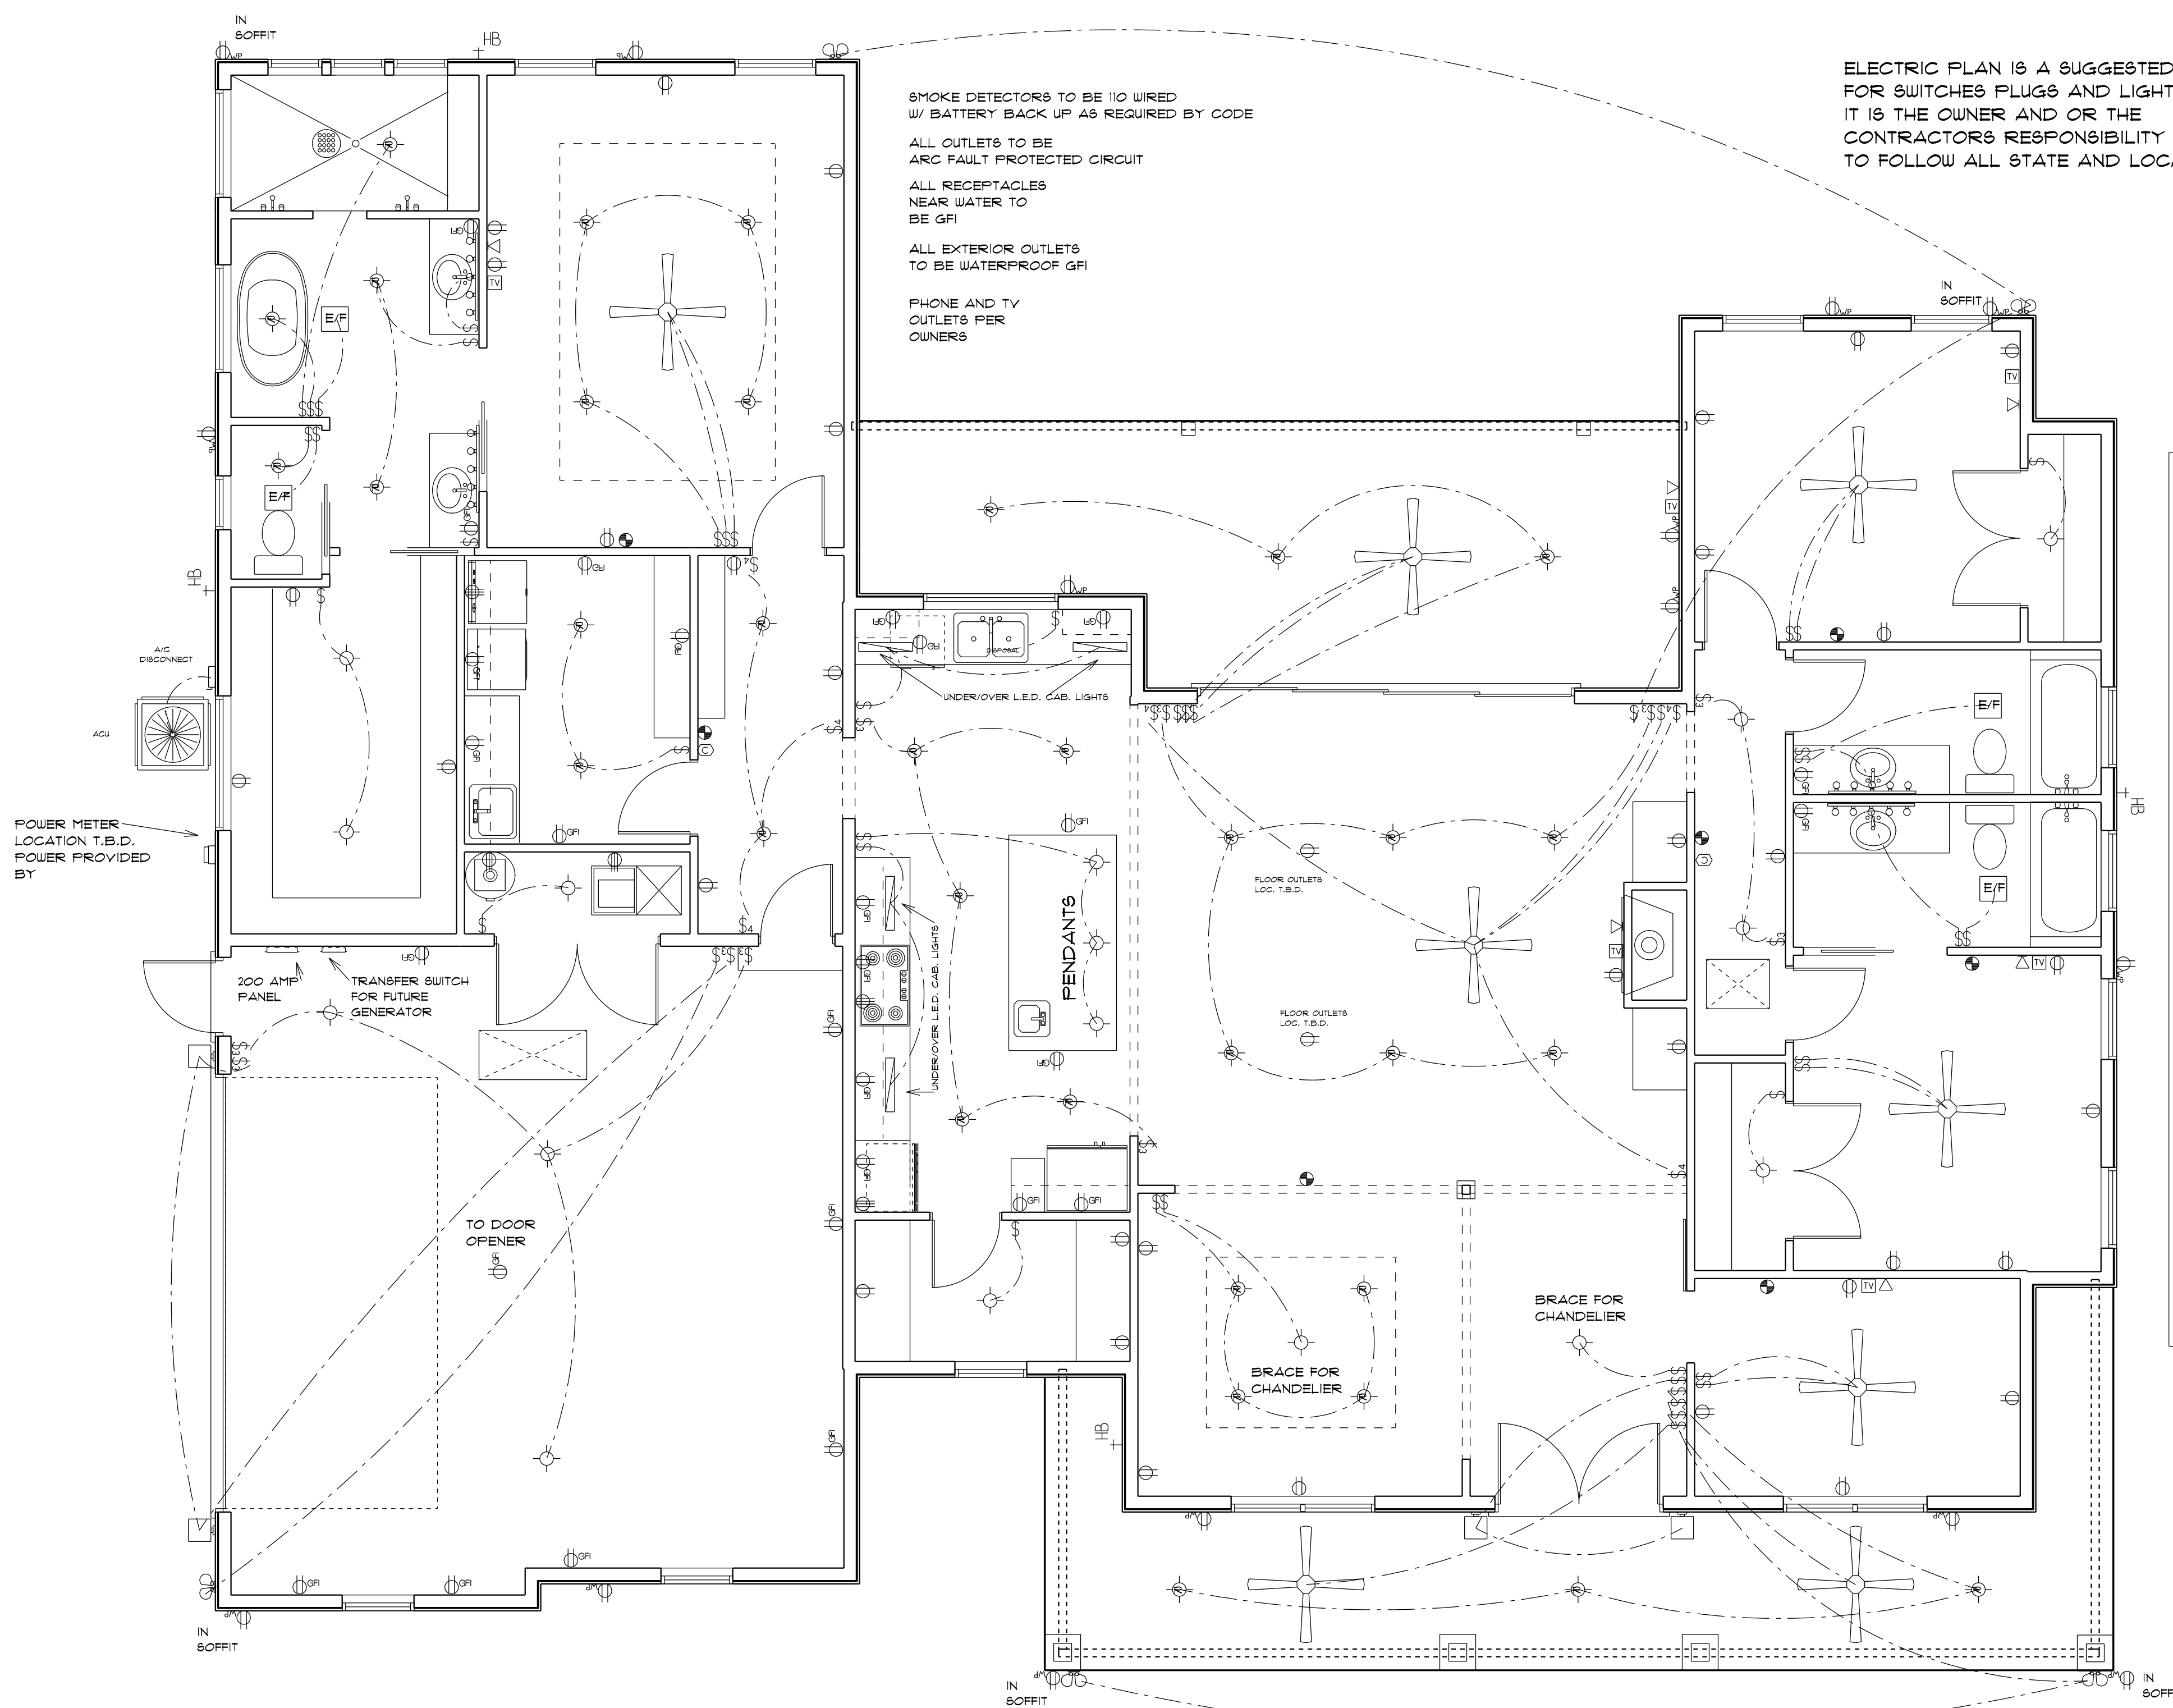

ELECTRIC PLAN IS A SUGGESTED LOCATION
FOR SWITCHES PLUGS AND LIGHTS
IT IS THE OWNER AND OR THE
CONTRACTOR'S RESPONSIBILITY
TO FOLLOW ALL STATE AND LOCAL CODES.

ELECTRICAL	SYMBOL
ceiling fan	
under cab. lights	
exterior light	
spotlight double	
electrical meter	
electrical panel	
A C DISCONNECT	
ACU	
Carbon Monoxide	
DISPOSAL	
EXHAUST FAN	
RECESS LIGHT	
tv outlet	
light	
outlet	
outlet 220v	
outlet gfi	
outlet up	
smoke detector	
switch	
switch 3 way	
switch 4 way	
phone/internet	
vanity bar light	

ALL TV/AV OUTLETS TO BE SET UP
FOR WALL MOUNT EQUIPMENT
VERIFY LOCATION AND HEIGHT
WITH OWNER

ELECTRICAL PLAN

