


REINFORCEMENT REQUIREMENTS:

- ALL STEEL REINFORCEMENT SHALL BE GRADE 60 (60 KSI).
- ALL LONGITUDINAL REBAR SHALL BE RUN CONTINUOUSLY SUCH THAT THE FOUNDATION SYSTEM ACTS IN A MONOLITHIC FASHION.
- ALL REBAR OVERLAPS (LAP SPLICES) SHALL BE AT LEAST 25".

CONCRETE REQUIREMENTS:

- ALL CONCRETE SHALL BE OF AT LEAST 3000PSI 28-DAY COMPRESSIVE STRENGTH.
- ALL CONCRETE GRADE BEAMS AND SLABS SHALL BE RUN CONTINUOUSLY AS TO BEHAVE IN A MONOLITHIC FASHION.
- CONCRETE SLAB THICKNESS SHALL BE 4" ABOVE THE FOOTERS, AS SHOWN IN THE DETAILS.
- STEP DOWNS AND LEDGES IN THE CONCRETE SHALL NOT REDUCE THE CONCRETE COVER REQUIREMENT FOR STEEL REINFORCEMENT.
- A 6 MIL VAPOR BARRIER SHALL BE PLACED PRIOR TO CONCRETE POUR, AS SHOWN IN THE DETAILS.

Florida Building Code 2017 6th Edition

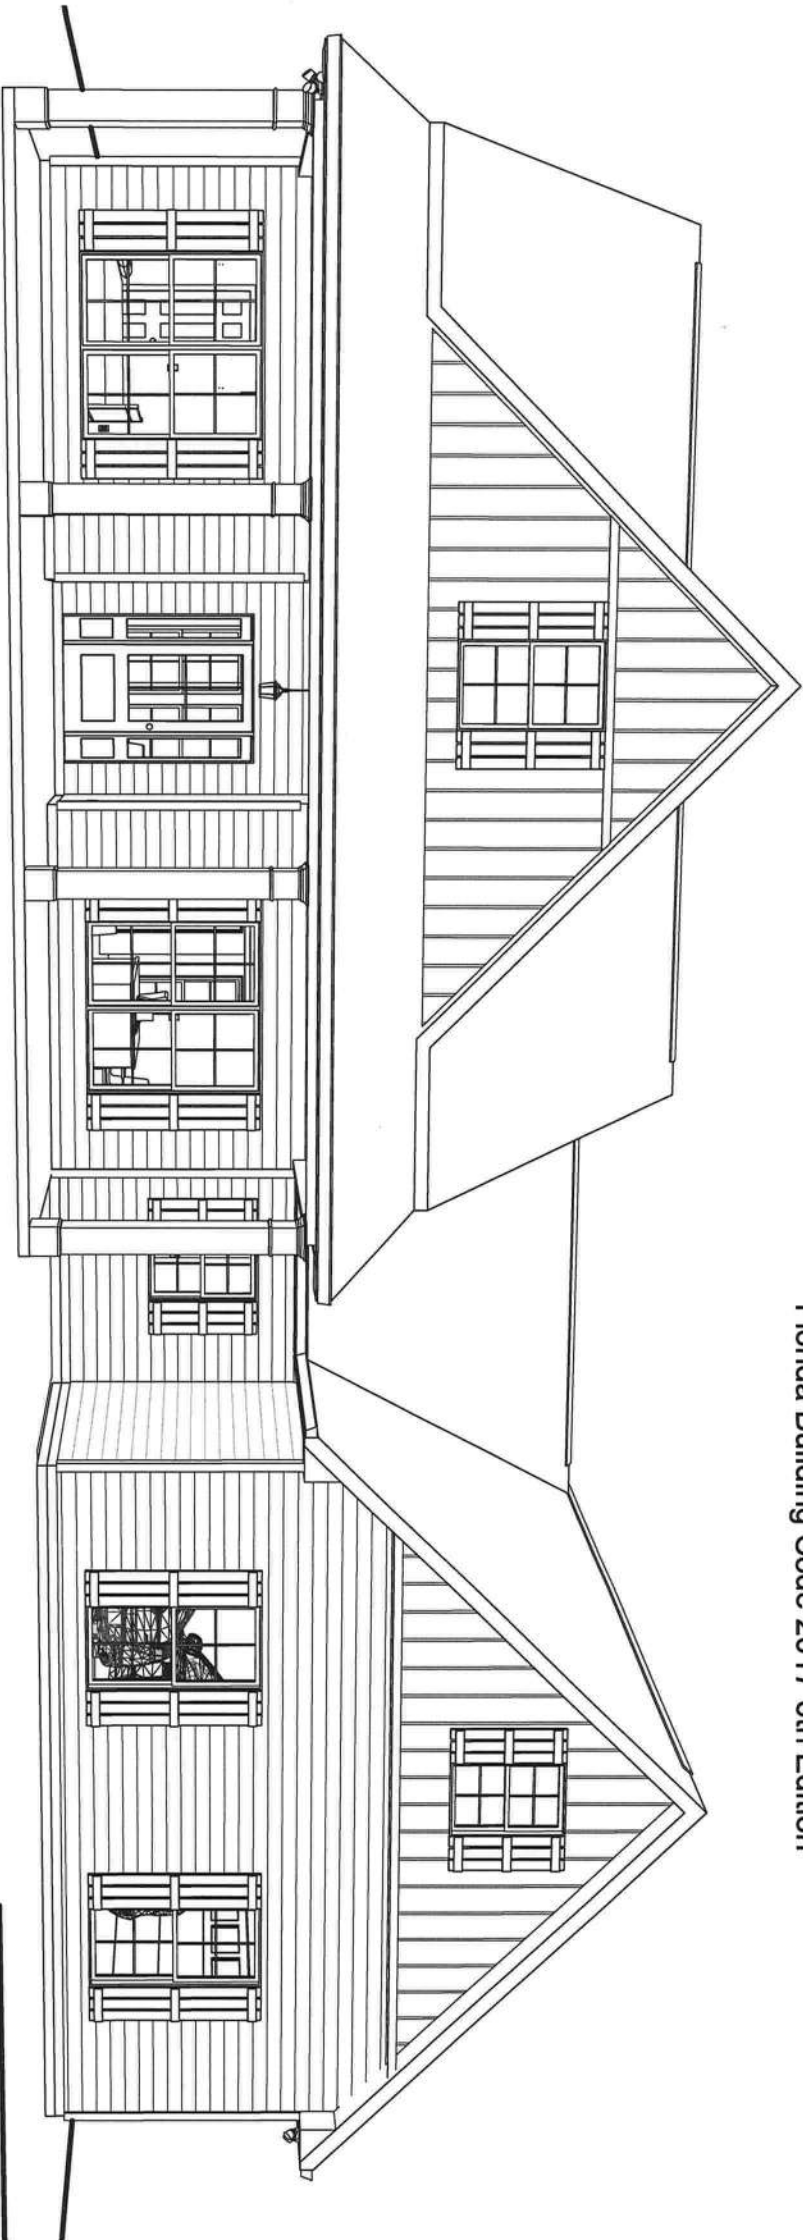

1 FRONT PERSPECTIVE

JAMES
ZALESKI

Digitally signed by JAMES
ZALESKI
Date: 2020.11.06 12:19:57
-05'00'


James Zaleski P.E 51544 2305 Haverhill Rd Tallahassee, FI 32312 PH 850-766-7778

SHEET LIST - CONSTRUCTION

Sheet Number	Sheet Name
C-0	COVER SHEET
E-1	FRONT & REAR ELEVATIONS
E-2	LEFT & RIGHT ELEVATION
E-3	ROOF OVERVIEW
F-1	FOUNDATION
F-1.1	FOUNDATION DETAILS
F-2	FIRST FLOOR PLAN
H-1	FIRST FLOOR ELEC & HVAC
S-1	DETAILS & SECTIONS
S-2	DETAILS AND SECTIONS
S-3	DETAILS AND SECTIONS

GENERAL NOTES

- MIN 9'-1 1/8" CEILING HEIGHT ON FIRST FLOOR
- ALL LOAD BEARING WALLS & EXT. OPENINGS TO HAVE (2) 2X10 HEADERS UNLESS OTHERWISE NOTED
- STANDARD FIRST FLOOR WINDOW HEADERS TO BE FRAMED DOWN 2'-2" FROM T.O.P. EXCEPT AS NOTED
- 7/16" O.S.B. AND HOUSEWRAP REQUIRED
- DIMENSIONS ARE TO SHEATHING EXTERIOR; SUBTRACT 1/2" FROM DIMENSIONS FOR EXTERIOR WINDOW AND DOOR FRAMING LOCATION IF OPENINGS ARE FRAMED BEFORE SHEATHING INSTALLATION
- ALL INTERIOR DOORS ARE EITHER CENTERED ON WALLS OR R.O. STARTED MIN 0'-4" FROM ADJOINING WALL UNLESS OTHERWISE DIMENSIONED
- NUMBER OF STAIR TREADS & RISERS MAY VARY AS A RESULT OF LOCAL BUILDING CODES, STANDARDS AND FINAL GRADE
- CLOSET SHELF HEIGHT OFF FLOOR: SINGLE-68"
- DOUBLE-42" & 84"
- ALL PLUMBING FIXTURES SHOWN ARE A REPRESENTATION OF SIZE AND LOCATION ONLY. ACTUAL STYLE AND BRAND OF FIXTURES MAY VARY PER OFFICE LOCATION
- ALL TUBS/SHOWERS ARE TO HAVE MAILERS AT FLANGE
- INSTALL A 24" WIDE WALKWAY FROM ATTIC ACCESS TO FURNACE PLATFORM
- FRAMER TO INSTALL DRYWALL CLIPS IN LIEU OF DEADWOOD ON ALL WALLS
- PORCH, STOOP, & DECK HARDWARES NOT INCLUDED W/ SLAB FOUNDATION
- RAILINGS ARE A FORCED OPTION WHEN PORCH IS OVER 30" HIGH

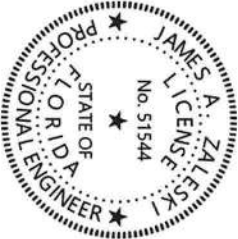

FINAL CONSTRUCTION PLANS

OPT. PAPER SIZE: for 1/4" =1'-0" on 24"x36" PAPER SIZE ENLARGE PRINTS TO 200%

TO REPORT COPYRIGHT VIOLATIONS CALL (770)532-1128 THE USE OF THIS PLAN BY ANYONE OTHER THAN AN AGENT OF "AMERICA'S HOME PLACE, INC." IS IN VIOLATION OF THE FEDERAL COPYRIGHT VIOLATION ACT. \$100 REWARD FOR RECOVERING AN ACTUAL COPYRIGHT INFRINGEMENT.
©COPYRIGHT ALL RIGHTS RESERVED NOTE:VIOLATORS OF THE COPYRIGHT WILL BE PROSECUTED TO THE FULLEST EXTENT OF THE LAW. THIS WORK IS THE INTELLECTUAL PROPERTY OF AMERICA'S HOME PLACE AND SHALL NOT BE REPRODUCED WITHOUT PERMISSION.

Revision Schedule		
Revision Number	Revision Description	Revision Date
	PRELIMINARY	9/23/20

AREAS:	
FIRST FLOOR HEATED	2,198 SF
GARAGE	560 SF
FRONT PORCH	367 SF
REAR PORCH	167 SF
TOTAL UNDER ROOF	3,292 SF

THE: BERGLUND M. FRMHOUSE	
FOR: RALPH AND ELIZABETH BONANZA	
TBD JEANLEA PLACE. COLUMBIA - FL. 32038	
OFFICE: GAINESVILLE	SOLD BY: A. LOCAV

JOB# 59-20-042	
2x6 EXTERIOR WALLS UNLESS OTHERWISE NOTED	
FOUNDATION TYPE: MONOSLAB	

DRAWN BY: AP	
CHECKED BY: B. TOOMBS	
PRINT DATE: 11/6/2020 9:06:32 AM	

PROPERTY OF:  ©COPYRIGHT - 2018

SHEET NUMBER: C-0

COVER SHEET

O.W.H. - 8:12 = 6 11/16"


8:12 @ FRONT RAISED HEEL= 50"

12:12 = 10 3/4"


4:12 PORCH = 4 3/8"

ELEVATION NOTES


- MIN 9'-1 1/8" CEILING HEIGHT ON FIRST FLOOR
- 7/16" O.S.B AND HOUSEWRAP REQUIRED
- ROOF OVERHANGS, AS NOTED, ARE FROM WALL SHEATHING TO OUTSIDE OF FASCIA
- FINAL GRADE TO BE DETERMINED ON SITE
- FOUNDATION DRAWN AS REPRESENTATION ONLY

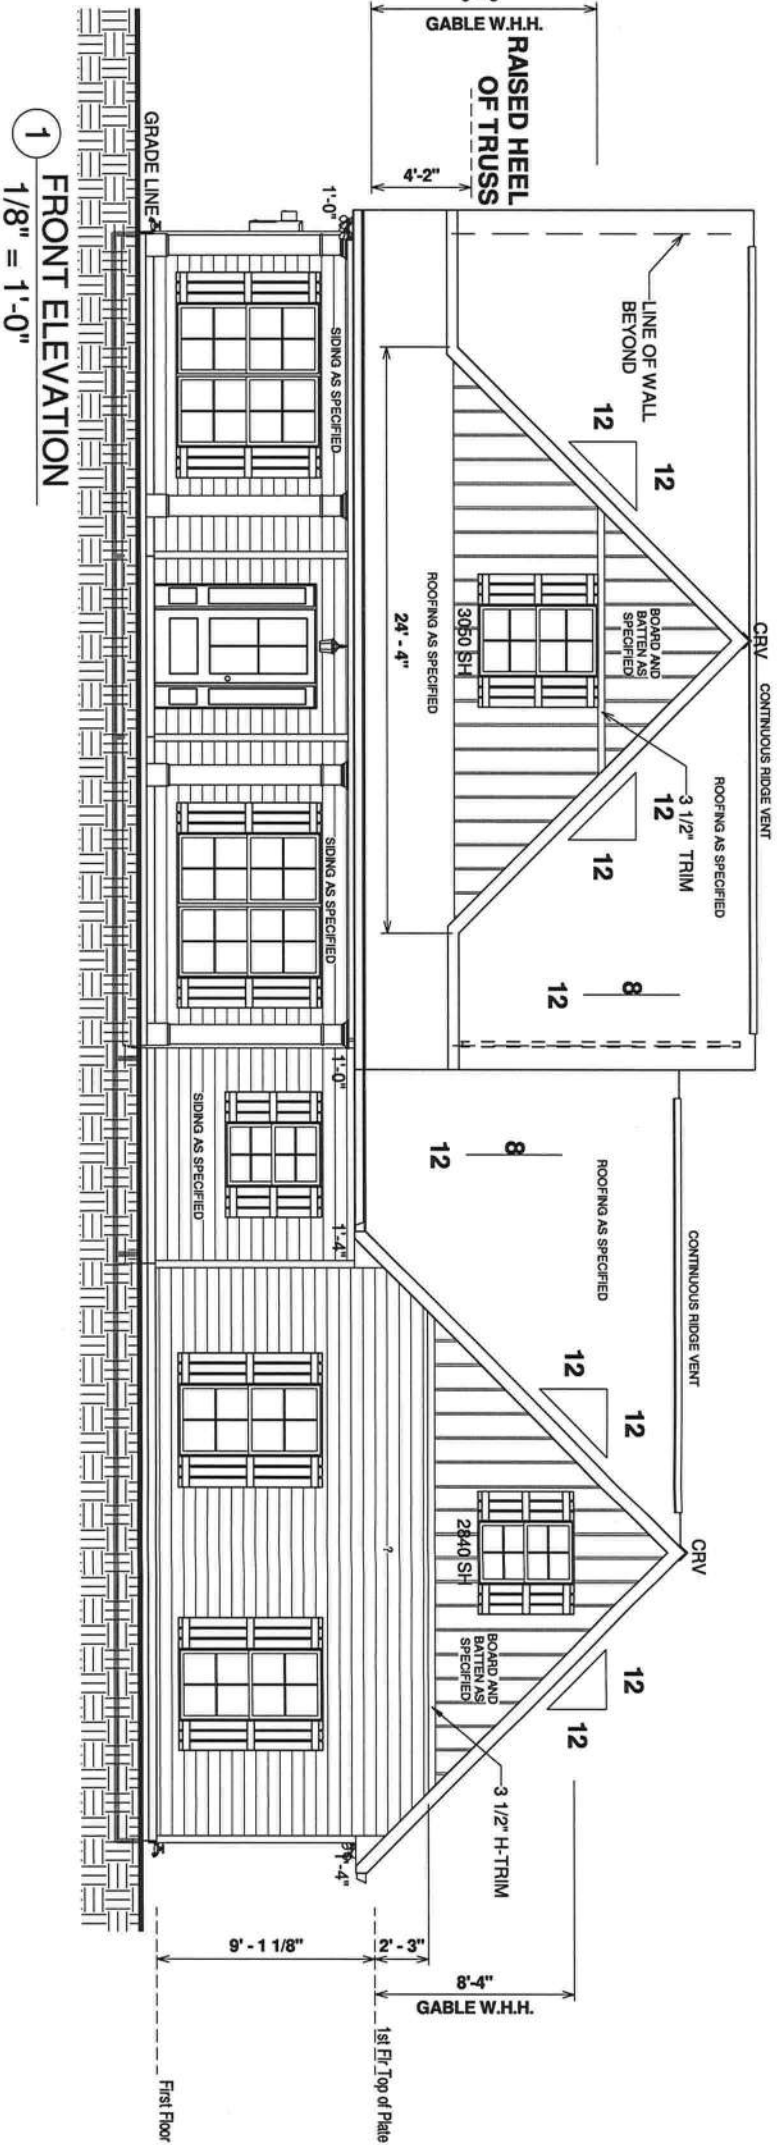

JAMES ZALESKI
Digitally signed
by JAMES ZALESKI
Date: 2020.11.06 12:19:27 -05'00'

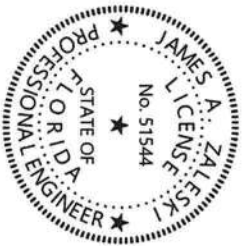

Reviewed for Compliance
James Zaleski PE 51544 2305 Haverhill Rd
Tallahassee, FL 32312 PH 850-766-7778 See Wind Load Details

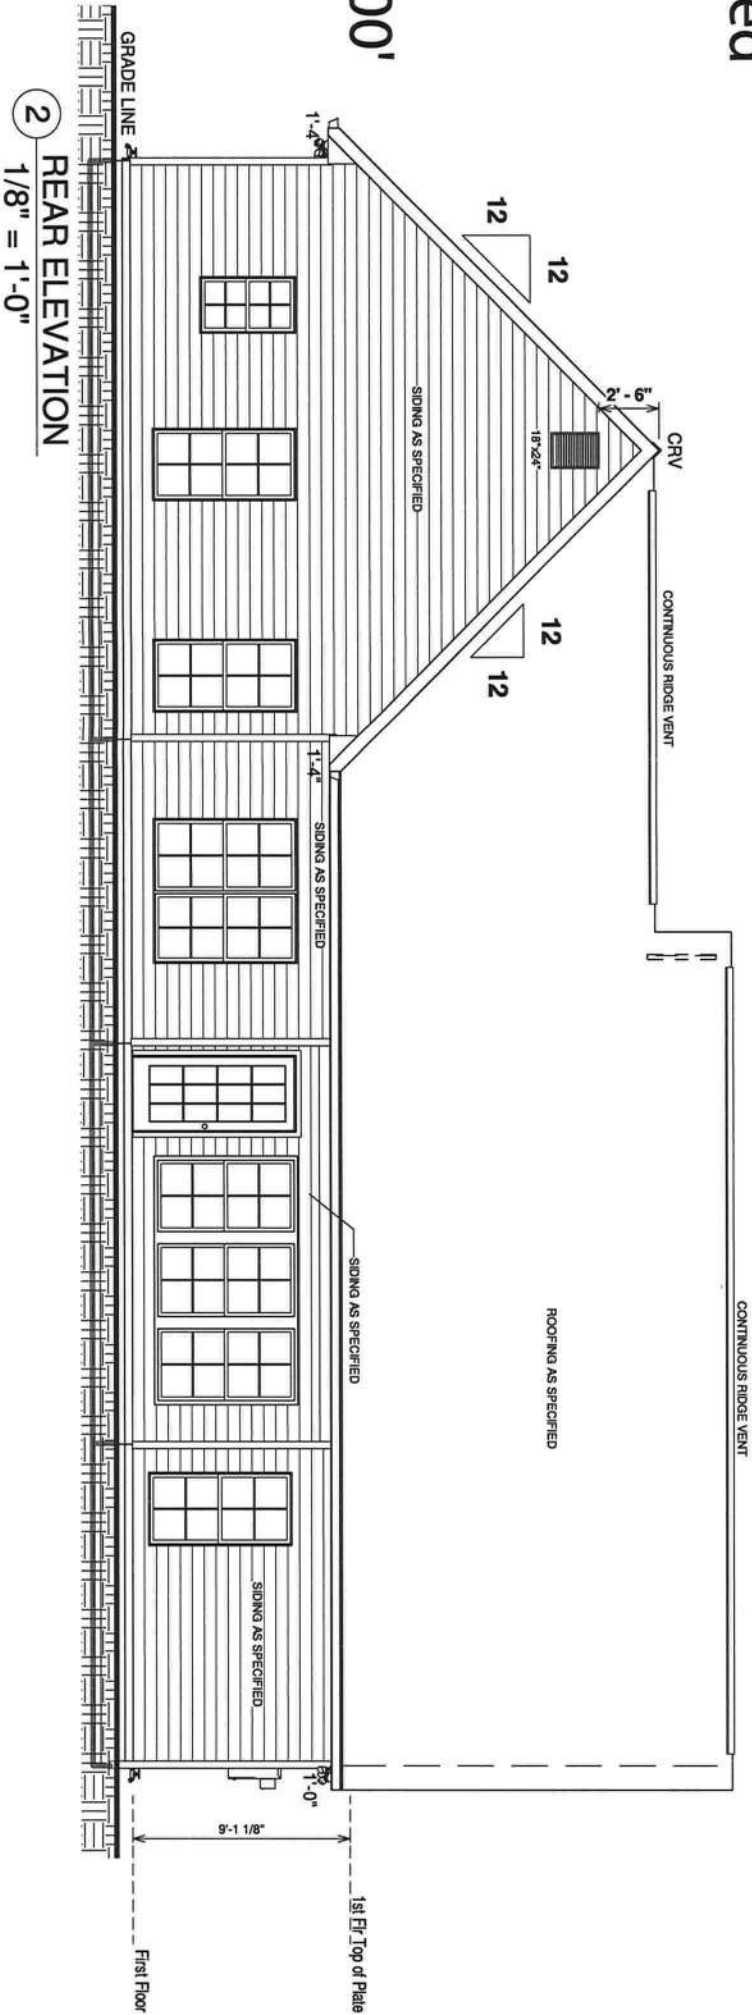

FINAL CONSTRUCTION PLANS

OPT. PAPER SIZE: for 1/4" = 1'-0" on 24"x36" PAPER SIZE ENLARGE PRINTS TO 200%

TO REPORT COPYRIGHT VIOLATIONS CALL (770)532-1128 THE USE OF THIS PLAN BY ANYONE OTHER THAN AN AGENT OF "AMERICAS HOME PLACE, INC." IS IN VIOLATION OF THE FEDERAL COPYRIGHT VIOLATION ACT. \$100 REWARD FOR RECOVERING AN ACTUAL COPYRIGHT INFRINGEMENT.
©COPYRIGHT-ALL RIGHTS RESERVED NOTE:VIOLATORS OF THE COPYRIGHT WILL BE PROSECUTED TO THE FULLEST EXTENT OF THE LAW. THIS WORK IS THE INTELLECTUAL PROPERTY OF AMERICAS HOME PLACE AND SHALL NOT BE REPRODUCED WITHOUT PERMISSION.

Revision Schedule		
Revision Number	Revision Description	Revision Date
PRELIMINARY		9/23/20

AREAS:	
FIRST FLOOR HEATED	2,198 SF
GARAGE	560 SF
FRONT PORCH	367 SF
REAR PORCH	167 SF
TOTAL UNDER ROOF	3,292 SF

THE: BERGLUND M. FRMHOUSE	
FOR: RALPH AND ELIZABETH BONANZA	
TBD JEANLEA PLACE. COLUMBIA - FL. 32038	
OFFICE: GAINESVILLE	SOLD BY: A. LOCAY

JOB# 59-20-042	
2x6 EXTERIOR WALLS UNLESS OTHERWISE NOTED	
FOUNDATION TYPE: MONOSLAB	

DRAWN BY: AP	
CHECKED BY: B. TOOMBS	
PRINT DATE: 11/6/2020 9:06:33 AM	

PROPERTY OF:	
	
©COPYRIGHT - 2018	


SHEET NUMBER:	
E-1	

FRONT & REAR ELEVATIONS

O.W.H. - 8:12 = 6 11/16"
8:12 @ FRONT RAISED HEEL= 50"
12:12 = 10 3/4"
4:12 PORCH = 4 3/8"


ELEVATION NOTES

- MIN 9'-1 1/8" CEILING HEIGHT ON FIRST FLOOR
- 7/16" O.S.B AND HOUSEWRAP REQUIRED
- ROOF OVERHANGS, AS NOTED, ARE FROM WALL SHEATHING TO OUTSIDE OF FASCIA
- FINAL GRADE TO BE DETERMINED ON SITE
- FOUNDATION DRAWN AS REPRESENTATION ONLY

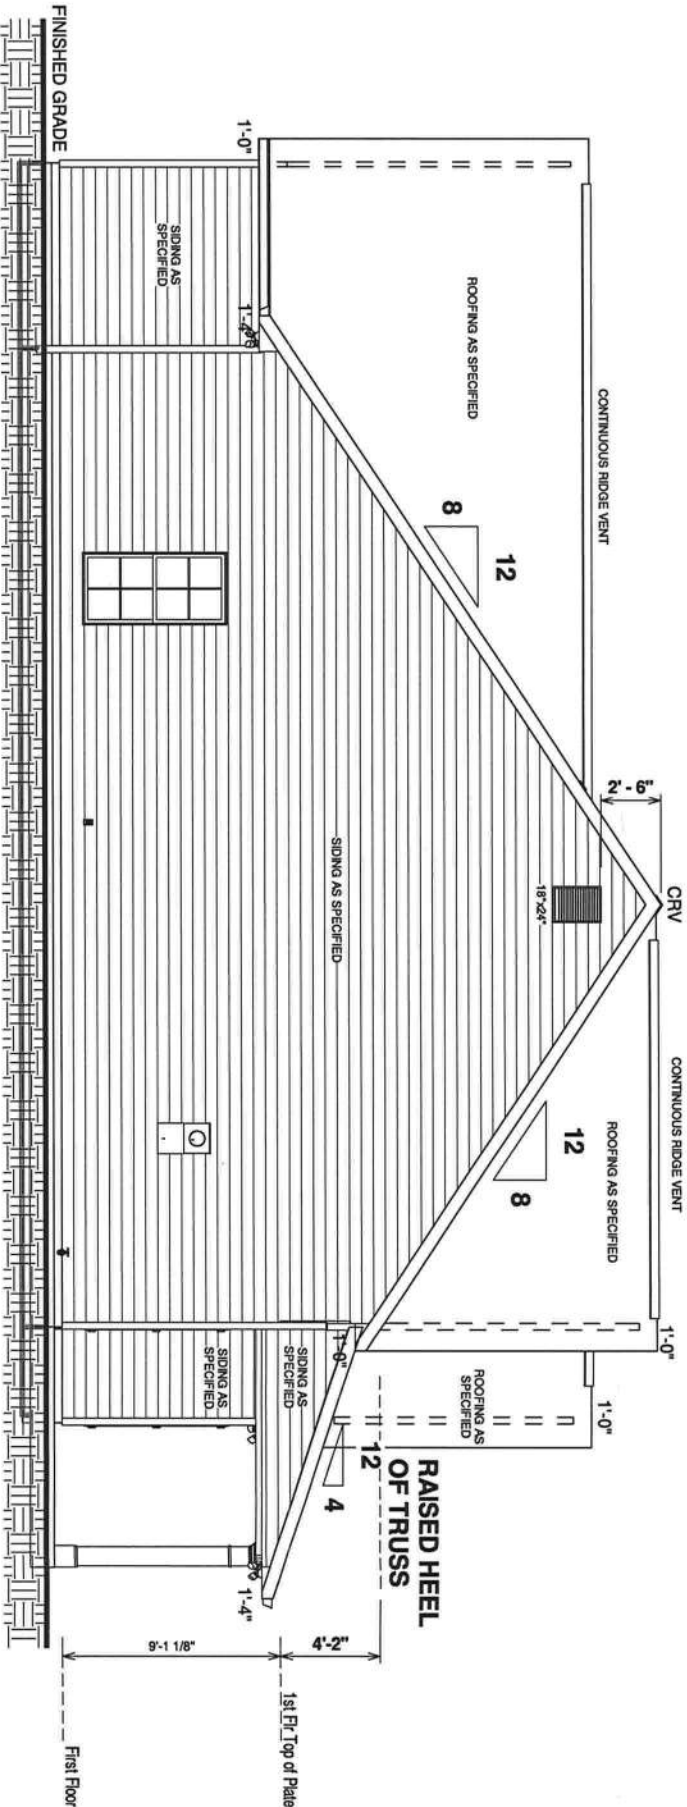


1 LEFT ELEVATION
1/8" = 1'-0"

Digitally signed
by JAMES
ZALESKI
Date: 2020.11.06
12:19:08 -05'00'

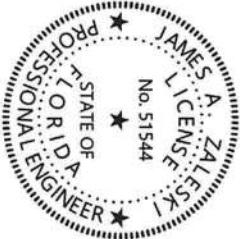

Reviewed for Compliance
James Zaleski PE 51544 2305 Haverhill Rd
Tallahassee, FL 32312 PH 850-766-7778 See Wind Load Details

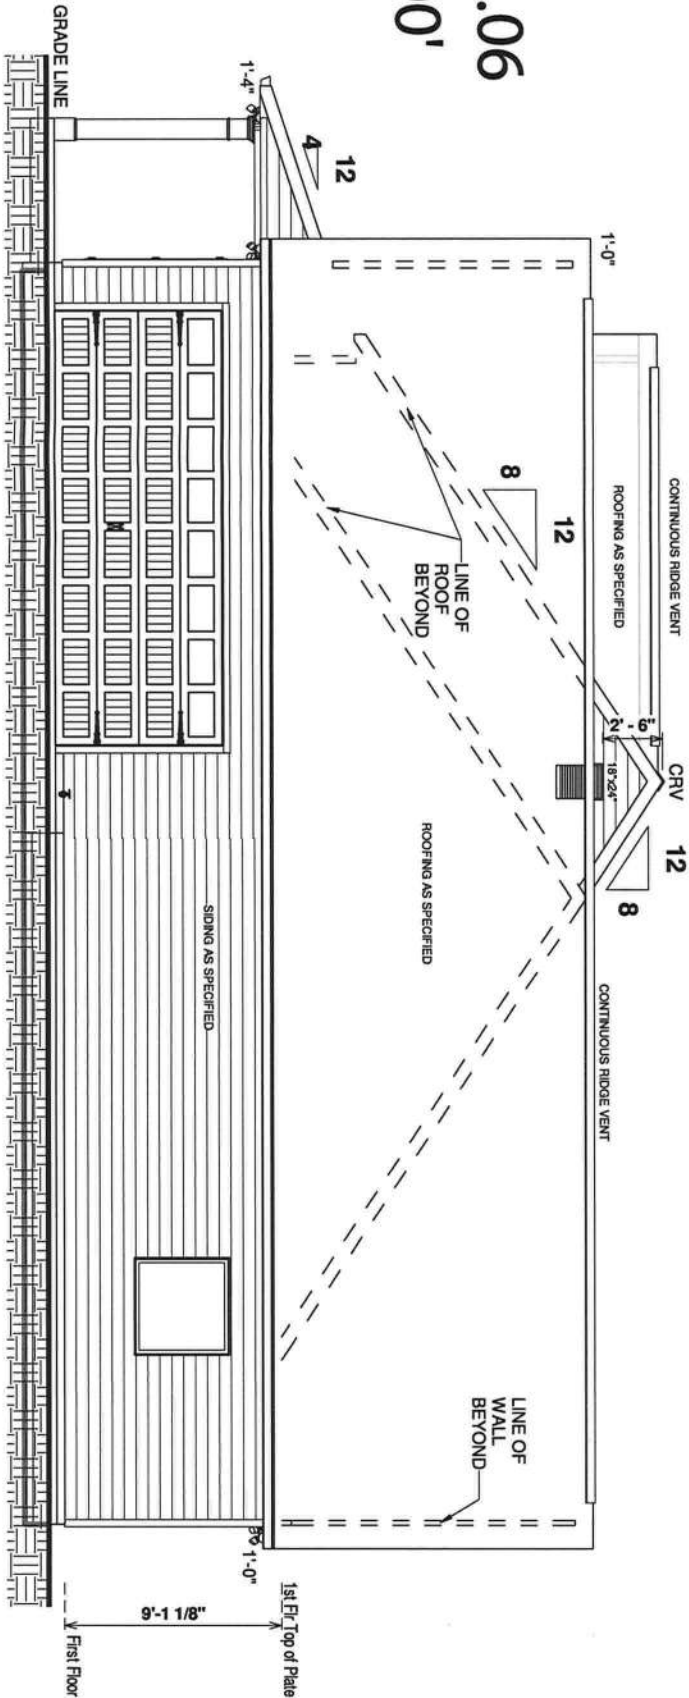

2 RIGHT ELEVATION
1/8" = 1'-0"

FINAL CONSTRUCTION PLANS

OPT. PAPER SIZE: for 1/4" = 1'-0" on 24"x36" PAPER SIZE ENLARGE PRINTS TO 200%

TO REPORT COPYRIGHT VIOLATIONS CALL (770)532-1128 THE USE OF THIS PLAN BY ANYONE OTHER THAN AN AGENT OF "AMERICA'S HOME PLACE, INC." IS IN VIOLATION OF THE FEDERAL COPYRIGHT VIOLATION ACT. \$100 REWARD FOR RECOVERING AN ACTUAL COPYRIGHT INFRINGEMENT.
©COPYRIGHT-ALL RIGHTS RESERVED NOTE:VIOLATORS OF THE COPYRIGHT WILL BE PROSECUTED TO THE FULLEST EXTENT OF THE LAW. THIS WORK IS THE INTELLECTUAL PROPERTY OF AMERICA'S HOME PLACE AND SHALL NOT BE REPRODUCED WITHOUT PERMISSION.

Revision Schedule			Revision		Revision	
Revision Number	Revision Description	Date	Revision Number	Revision Description	Date	Date
	PRELIMINARY	9/23/20				


SHEET NUMBER:		PROPERTY OF:		DRAWN BY:		JOB#		THE:		AREAS:	
E-2		AP		B. TOOMBS		59-20-042		BERGLUND M. FRMHOUSE		FIRST FLOOR HEATED	
		11/6/2020		9:06:34 AM		2x6 EXTERIOR WALLS		FOR: RALPH AND ELIZABETH BONANZA		GARAGE	
						FOUNDATION TYPE:		TBD JEANLEA PLACE.		FRONT PORCH	
						MONOSLAB		COLUMBIA - FL. 32038		REAR PORCH	
								OFFICE: GAINESVILLE		TOTAL UNDER ROOF	
								SOLD BY: A. LOCAY			

O.W.H. - 8:12 = 6 11/16"

8:12 @ FRONT RAISED HEEL= 50"

12:12 = 10 3/4"


4:12 PORCH = 4 3/8"

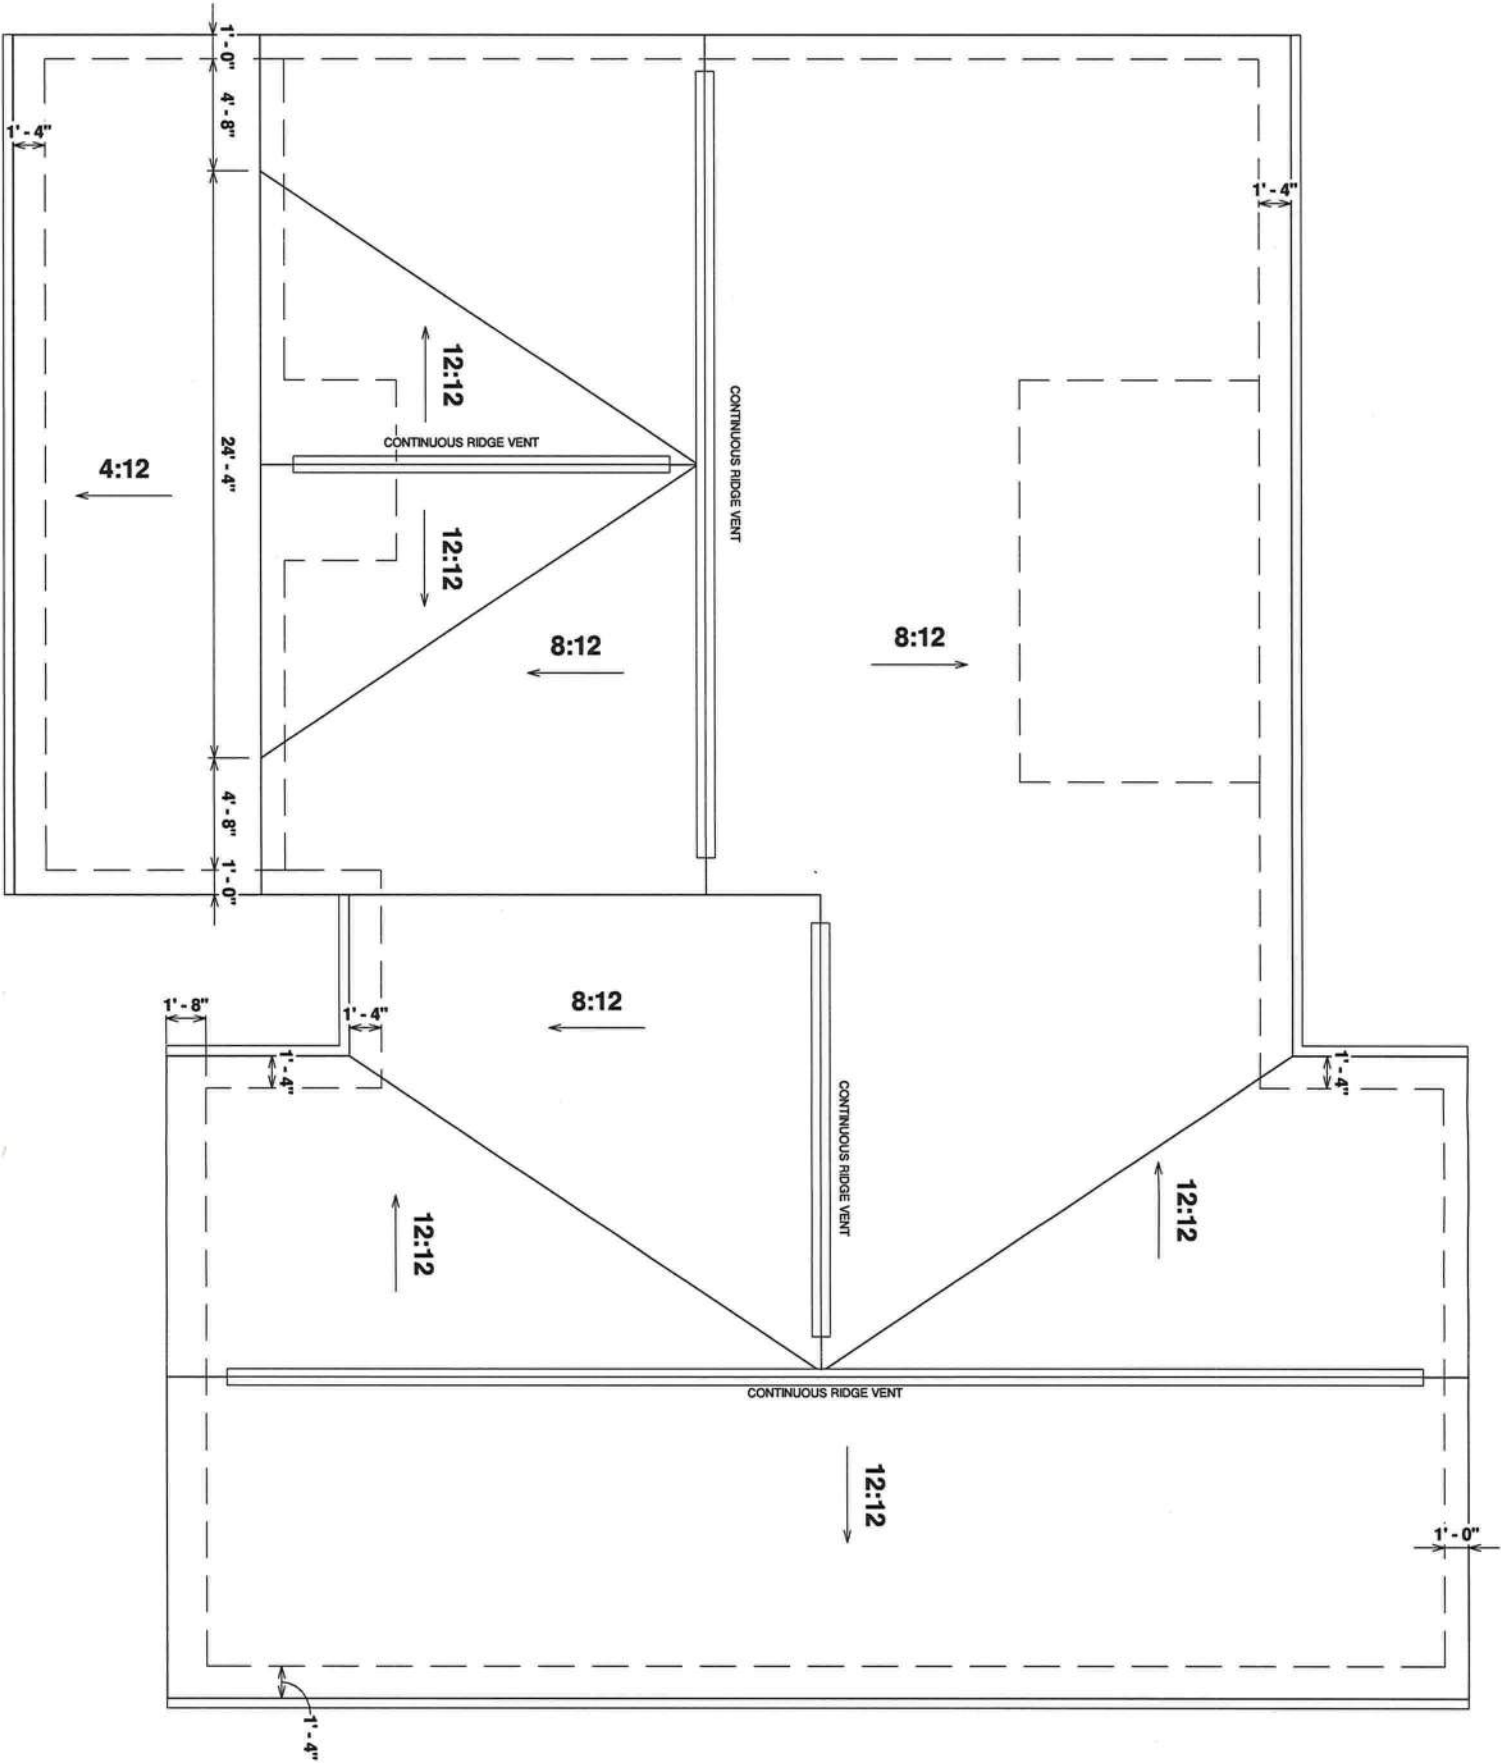

1 ROOF OVERVIEW
1/8" = 1'-0"

Reviewed for Compliance
James Zaleski PE 51544 2305 Haverhill Rd
Tallahassee, FL 32312 PH 850-766-7778 See Wind Load Details

JAMES ZALESKI
Digitally signed by JAMES ZALESKI
Date: 2020.11.06 12:18:50 -05'00'

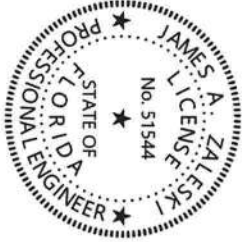

Revision Schedule		
Revision Number	Revision Description	Revision Date
	PRELIMINARY	9/23/20

AREAS:	
FIRST FLOOR HEATED	2,198 SF
GARAGE	560 SF
FRONT PORCH	367 SF
REAR PORCH	167 SF
TOTAL UNDER ROOF	3,292 SF

THE: BERGLUND M. FRMHOUSE	
FOR: RALPH AND ELIZABETH BONANZA	
TBD JEANLEA PLACE. COLUMBIA - FL. 32038	
OFFICE: GAINESVILLE	SOLD BY: A. LOCAY


JOB# 59-20-042
2x6 EXTERIOR WALLS UNLESS OTHERWISE NOTED
FOUNDATION TYPE: MONOSLAB

DRAWN BY: AP
CHECKED BY: B. TOOMBS
PRINT DATE: 11/6/2020 9:06:34 AM


PROPERTY OF:
© COPYRIGHT - 2018

SHEET NUMBER:
E-3


ROOF OVERVIEW

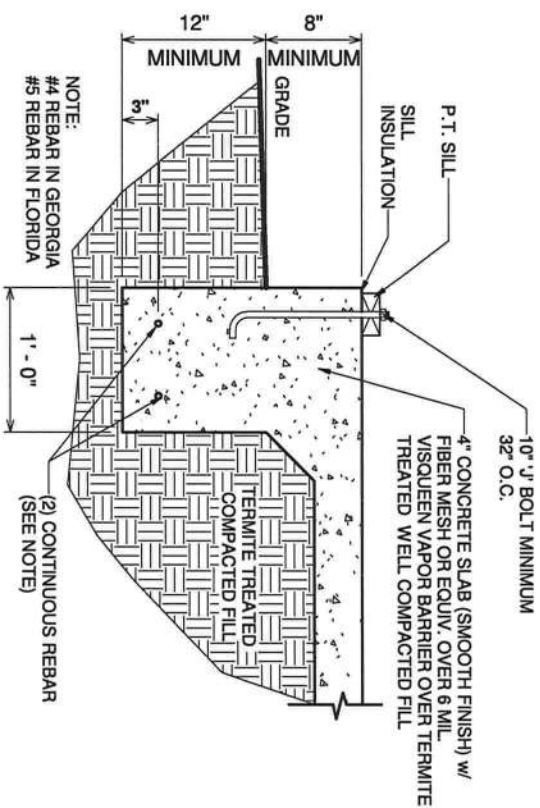

1 STORY MONOSLAB DETAIL

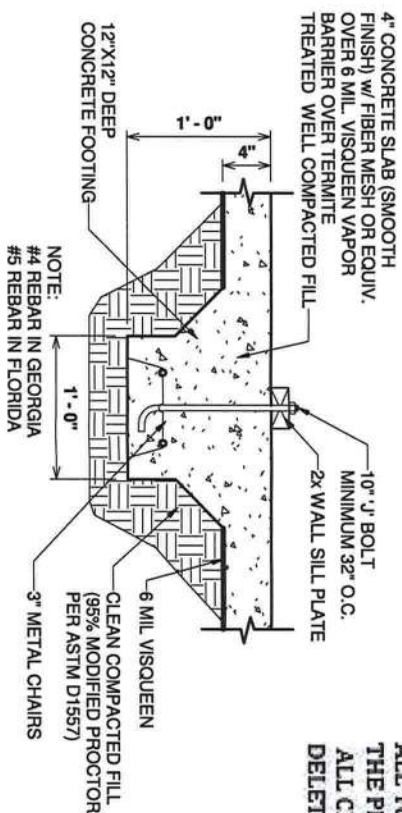
$$3/4" = 1'-0"$$


2 INTERIOR BEARING WALL FOOTER DETAIL

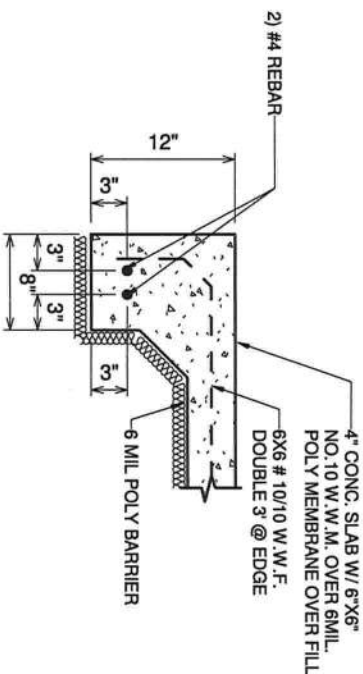
$$3/4" = 1'-0"$$


53.1-EDGE OF TURNED DOWN SLAB

3/4" = 1'-0"

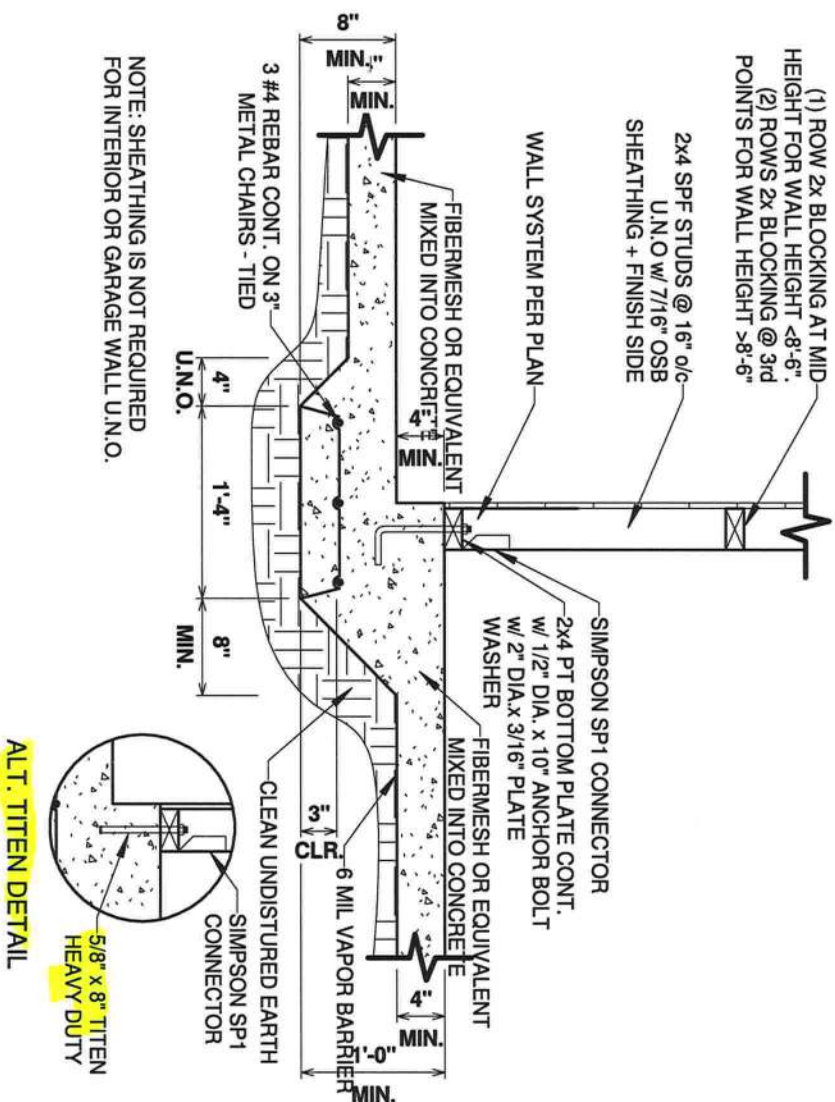

Digitally signed by
JAMES ZALESKI
Date: 2020.11.06
12:18:12 -05'00'

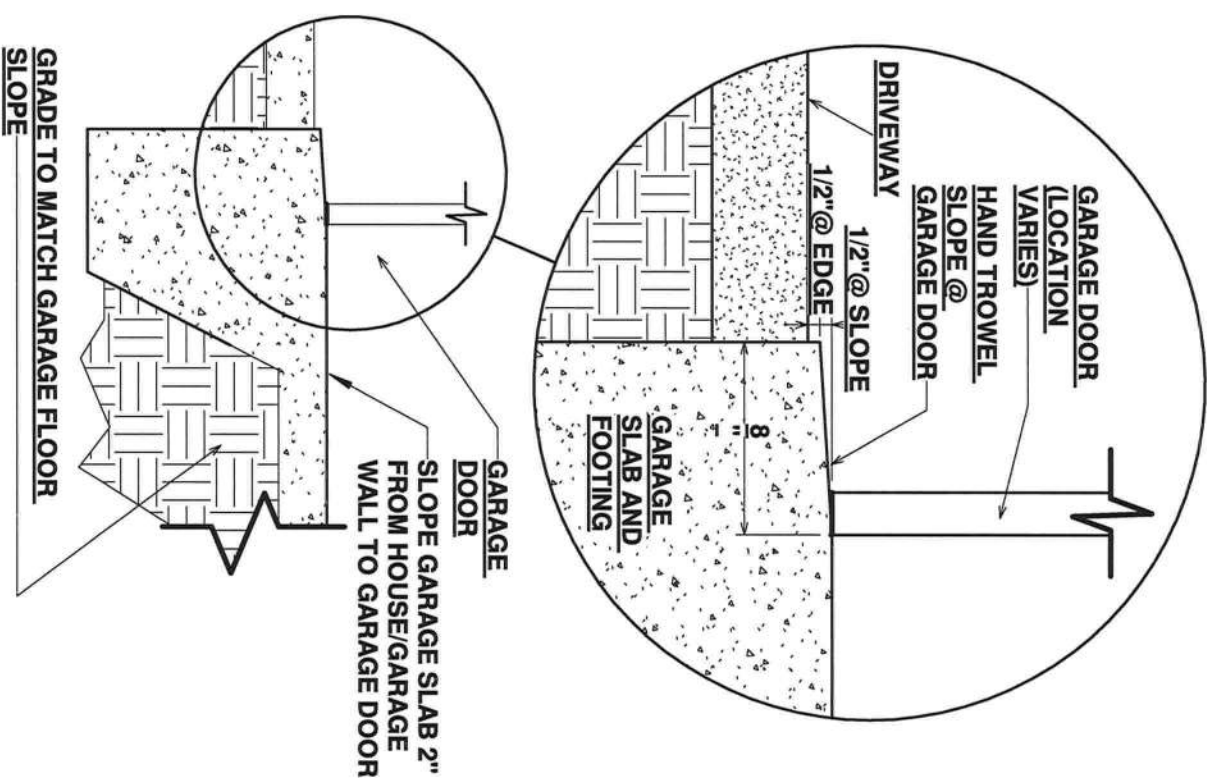


4 GARAGE DOOR SLOPE DETAIL

3/4" = 1'-0"

SOIL:
SATISFACTORY FILL MATERIAL SHALL BE FREE OF VEGETATION AND ORGANIC MATTER, WITH NOT MORE THAN 20 PERCENT BY WEIGHT PASSING THE 200 SIEVE. FILL LIFTS SHALL BE 12 INCHES MAXIMUM.
ALL TOP SOIL CONTAINING UNSUITABLE MATERIAL SHALL BE REMOVED PRIOR TO THE PLACEMENT OF CLEAN FILL MATERIAL.
ALL CLEAN FILL SHALL BE PLACED ON TOP OF UNDISTURBED SOIL, FREE OF DELETERIOUS AND ORGANIC MATERIALS, AS NOTED ABOVE.

3 Section - Bearing Wall at Step - Monoslab - FL
3/4" = 1'-0"

Reviewed for Compliance
James Zaleski PE 54544 2305 Haverhill Rd
Tallahassee, Fl 32312 PH 850-766-7778 See Wind Load Details

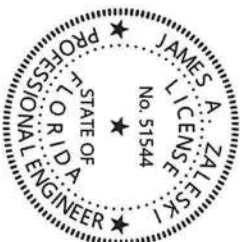

OPT. PAPER SIZE: for 1/4" =1'-0" on 24"x36" PAPER SIZE ENLARGE
FINAL CONSTRUCTION PLANS

Revision Schedule		
Revision Number	Revision Description	Revision Date
	PRELIMINARY	9/23/20

<u>AREAS:</u>	
FIRST FLOOR HEATED	2,198 SF
GARAGE	560 SF
FRONT PORCH	367 SF
REAR PORCH	167 SF
TOTAL UNDER ROOF	3,292 SF

THE:	
BERGLUND M. FRMHOUSE	
FOR: RALPH AND ELIZABETH BONANZA	
TBD JEANLEA PLACE. COLUMBIA - FL. 32038	
OFFICE: GAINESVILLE	SOLD BY: A. LOCAY

DRAWN BY: AP	JOB# 59-20-042
CHECKED BY: B. TOOMBS	2x6 EXTERIOR WALLS UNLESS OTHERWISE NOTED
PRINT DATE: 11/6/2020 9:06:35 AM	FOUNDATION TYPE: MONOSLAB

PROPERTY OF:



COPYRIGHT - 2018


SHEET NUMBER:
F-1.1

SCALE: 3/4" = 1'-0"

FOUNDATION DETAILS

TO REPORT COPYRIGHT VIOLATIONS CALL (770) 423-1228. THE USE OF THIS PLAN BY ANYONE OTHER THAN AN AGENT OF "AMERICA'S HOME PLACE, INC." IS IN VIOLATION OF THE FEDERAL COPYRIGHT VIOLATION ACT. \$100 REWARD FOR RECOVERING AN ACTUAL COPYRIGHT INFRINGEMENT.
©COPYRIGHT-ALL RIGHTS RESERVED. NO PART OF THE COPYRIGHT WILL BE PROSECUTED TO THE FULLEST EXTENT OF THE LAW. THIS WORK IS THE INTELLECTUAL PROPERTY OF AMERICA'S HOME PLACE AND SHALL NOT BE REPRODUCED WITHOUT PERMISSION.

LAYOUT
CORNER

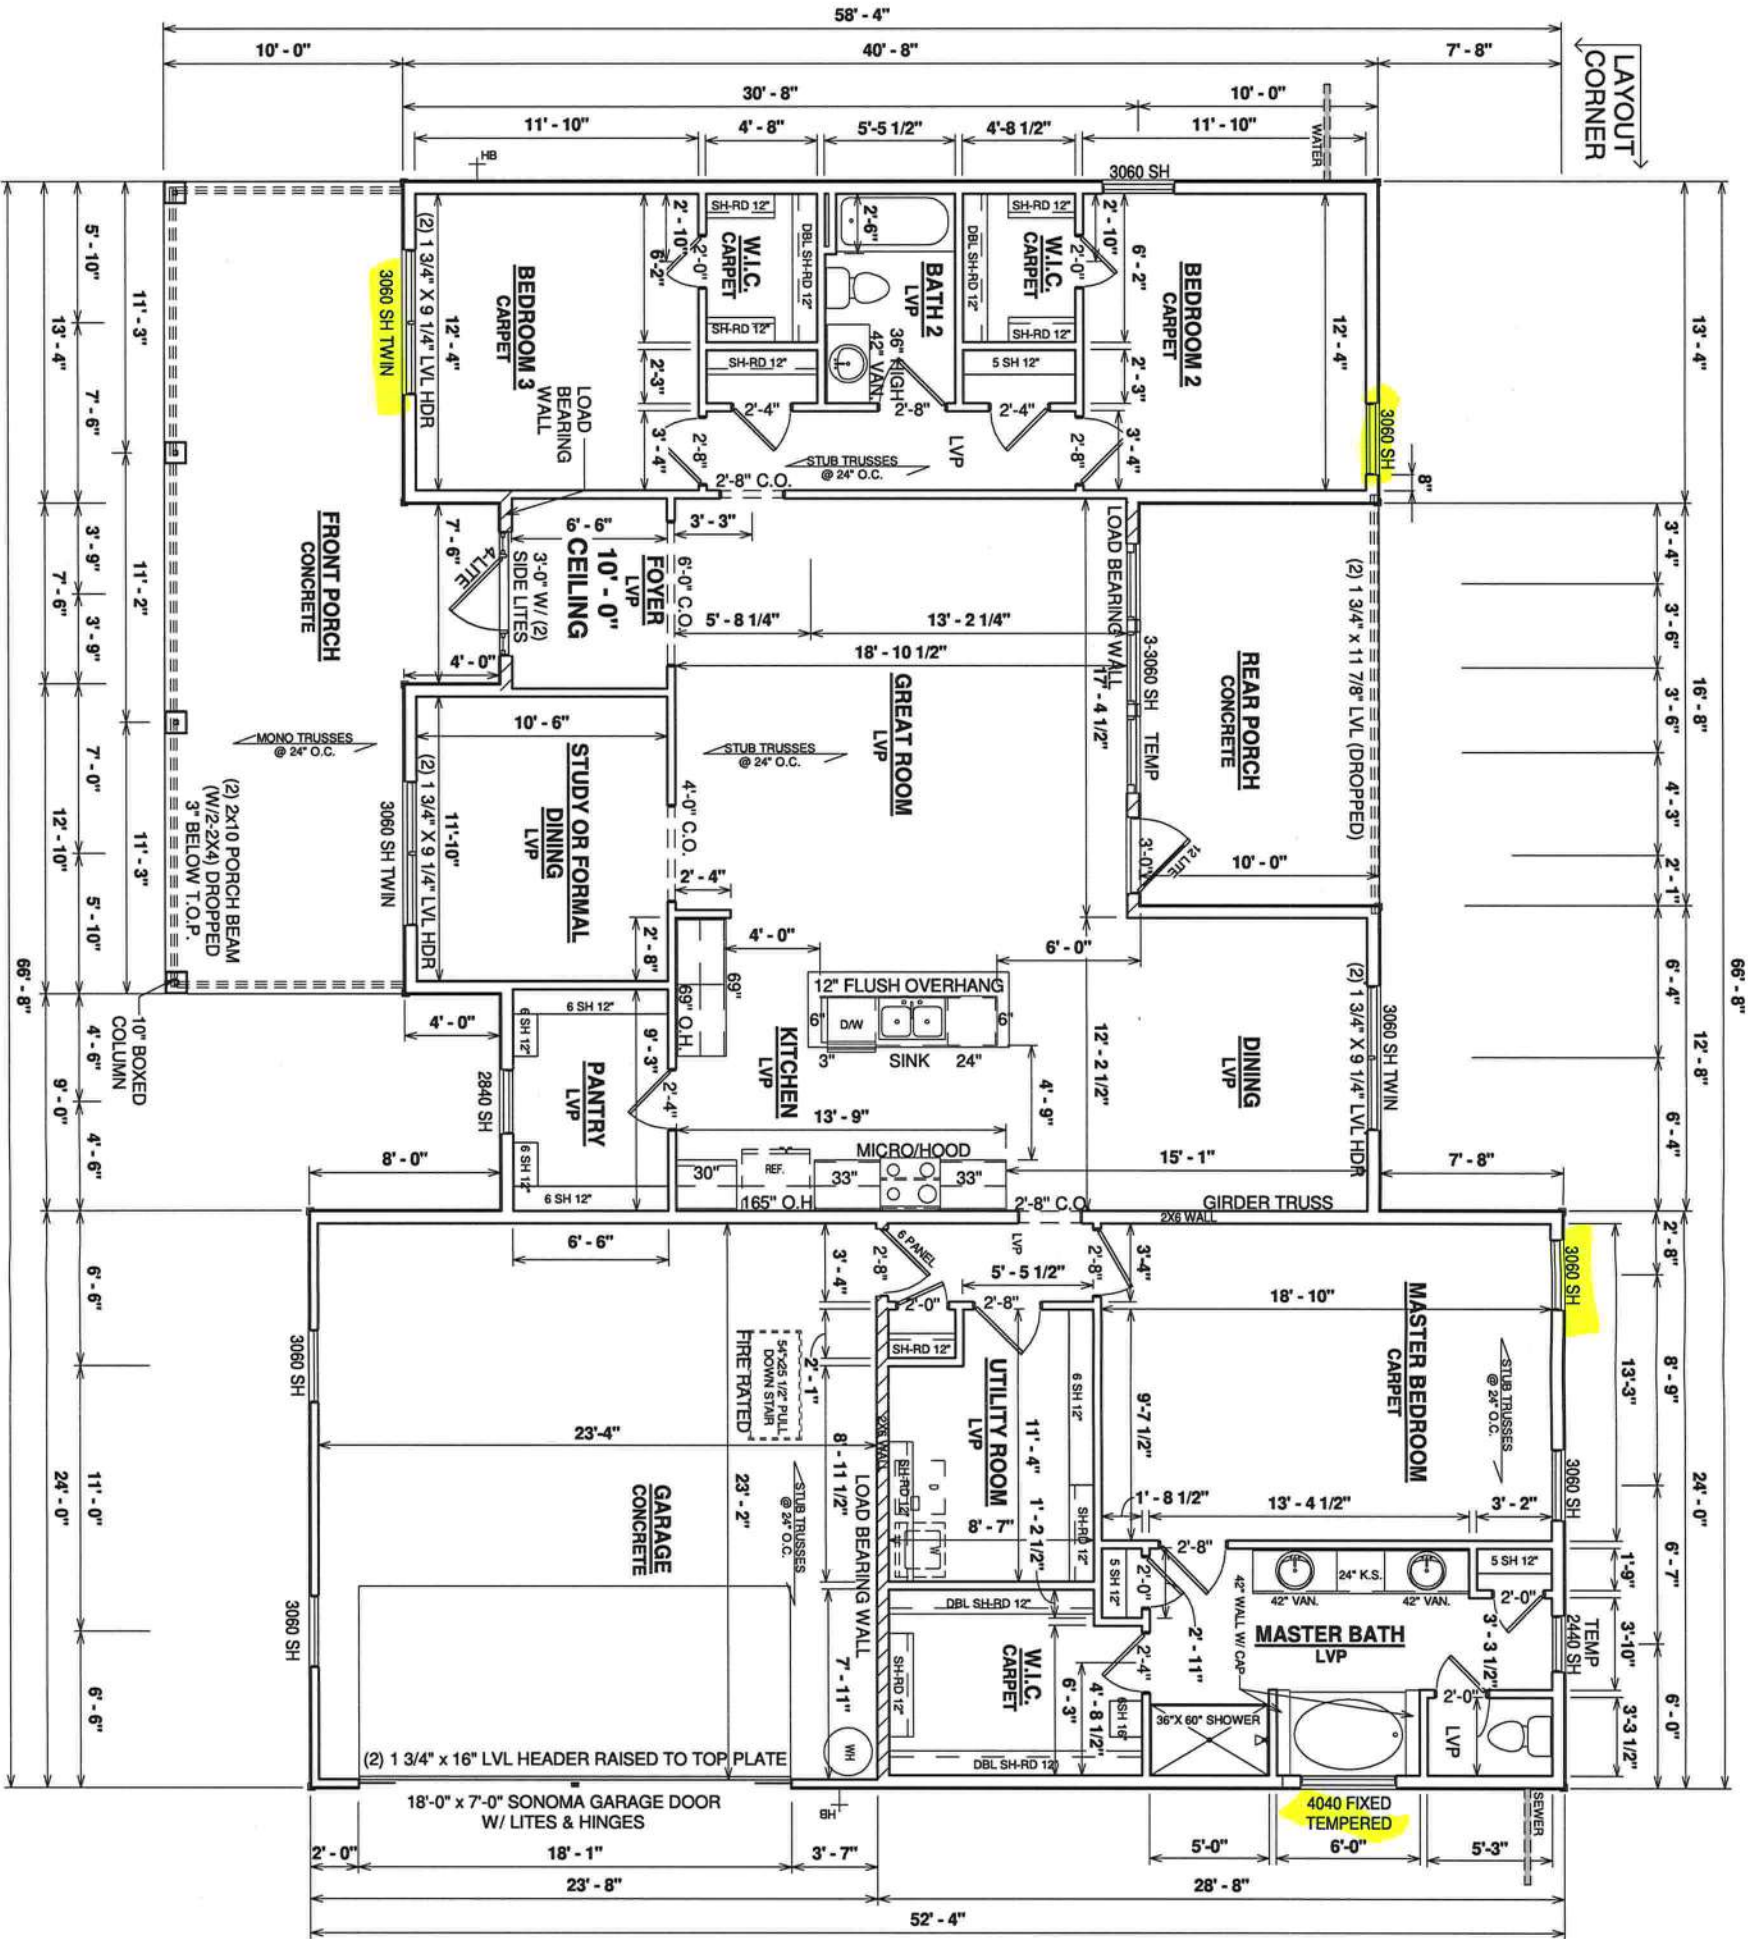

GENERAL NOTES

- MIN 9'-1 1/8" CEILING HEIGHT ON FIRST FLOOR
- ALL LOAD BEARING WALLS & EXT. OPENINGS TO HAVE (2) 2X10 HEADERS UNLESS OTHERWISE NOTED
- STANDARD FIRST FLOOR WINDOW HEADERS TO BE FRAMED DOWN 2'-2" FROM T.O.P. EXCEPT AS NOTED
- 7/16" O.S.B. AND HOUSEWRAP REQUIRED
- DIMENSIONS ARE TO SHEATHING EXTERIOR; SUBTRACT 1/2" FROM DIMENSIONS FOR EXTERIOR WINDOW AND DOOR FRAMING LOCATION IF OPENINGS ARE FRAMED BEFORE SHEATHING INSTALLATION
- ALL INTERIOR DOORS ARE EITHER CENTERED ON WALLS OR R.O. STARTED MIN OF 4" FROM ADJOINING WALL UNLESS OTHERWISE DIMENSIONED
- NUMBER OF STAIR TREADS & RISERS MAY VARY AS A RESULT OF LOCAL BUILDING CODES, STANDARDS AND FINAL GRADE
- CLOSET SHELF HEIGHT OFF FLOOR: SINGLE-68"
- DOUBLE-42" & 84"
- ALL PLUMBING FIXTURES SHOWN ARE A REPRESENTATION OF SIZE AND LOCATION ONLY. ACTUAL STYLE AND BRAND OF FIXTURES MAY VARY PER OFFICE LOCATION
- ALL TUBS/SHOWERS ARE TO HAVE NAILERS AT FLANGE
- INSTALL A 24" WIDE WALKWAY FROM ATTIC ACCESS TO FURNACE PLATFORM
- FRAMER TO INSTALL DRYWALL CLIPS IN LIEU OF DEADWOOD ON ALL WALLS
- PORCH, STOOP, & DECK HARDWARES NOT INCLUDED W/ SLAB FOUNDATION
- RAILINGS ARE A FORCED OPTION WHEN PORCH IS OVER 30" HIGH

19,737 CUBIC FEET

Revision Schedule		
Revision Number	Revision Description	Revision Date
	PRELIMINARY	9/23/20

AREAS:	
FIRST FLOOR HEATED	2,198 SF
GARAGE	560 SF
FRONT PORCH	367 SF
REAR PORCH	167 SF
TOTAL UNDER ROOF	3,292 SF

THE: BERGLUND M. FRMHOUSE	FOR: RALPH AND ELIZABETH BONANZA
TBD JEANLEA PLACE. COLUMBIA - FL. 32038	
OFFICE: GAINESVILLE	SOLD BY: A. LOCAV

DRAWN BY: AP	JOB# 59-20-042
CHECKED BY: B. TOOMBS	2x6 EXTERIOR WALLS UNLESS OTHERWISE NOTED
PRINT DATE: 11/6/2020 9:06:35 AM	FOUNDATION TYPE: MONOSLAB

PROPERTY OF:	NO. 51544
JAMES A. ZALESKI FLORIDA PROFESSIONAL ENGINEER	

SHEET NUMBER: **F-2**


SCALE: 1/8" = 1'-0"

FIRST FLOOR PLAN


1 FIRST FLOOR PLAN- CONSTRUCTION

Reviewed for Compliance
James Zaleski PE 51544 2305 Haverhill Rd
Tallahassee, FL 32312 PH 850-766-7778 See Wind Load Details

OPT. PAPER SIZE: 10' x 14" = 1'-0" on 24"x36" PAPER SIZE ENLARGE PRINTS TO 200%
FINAL CONSTRUCTION PLANS

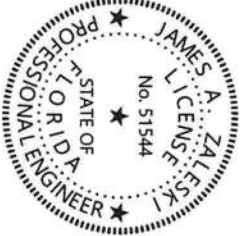

JAMES ZALESKI
Digitally signed by JAMES ZALESKI
Date: 2020.11.06 12:17:43 -05'00'

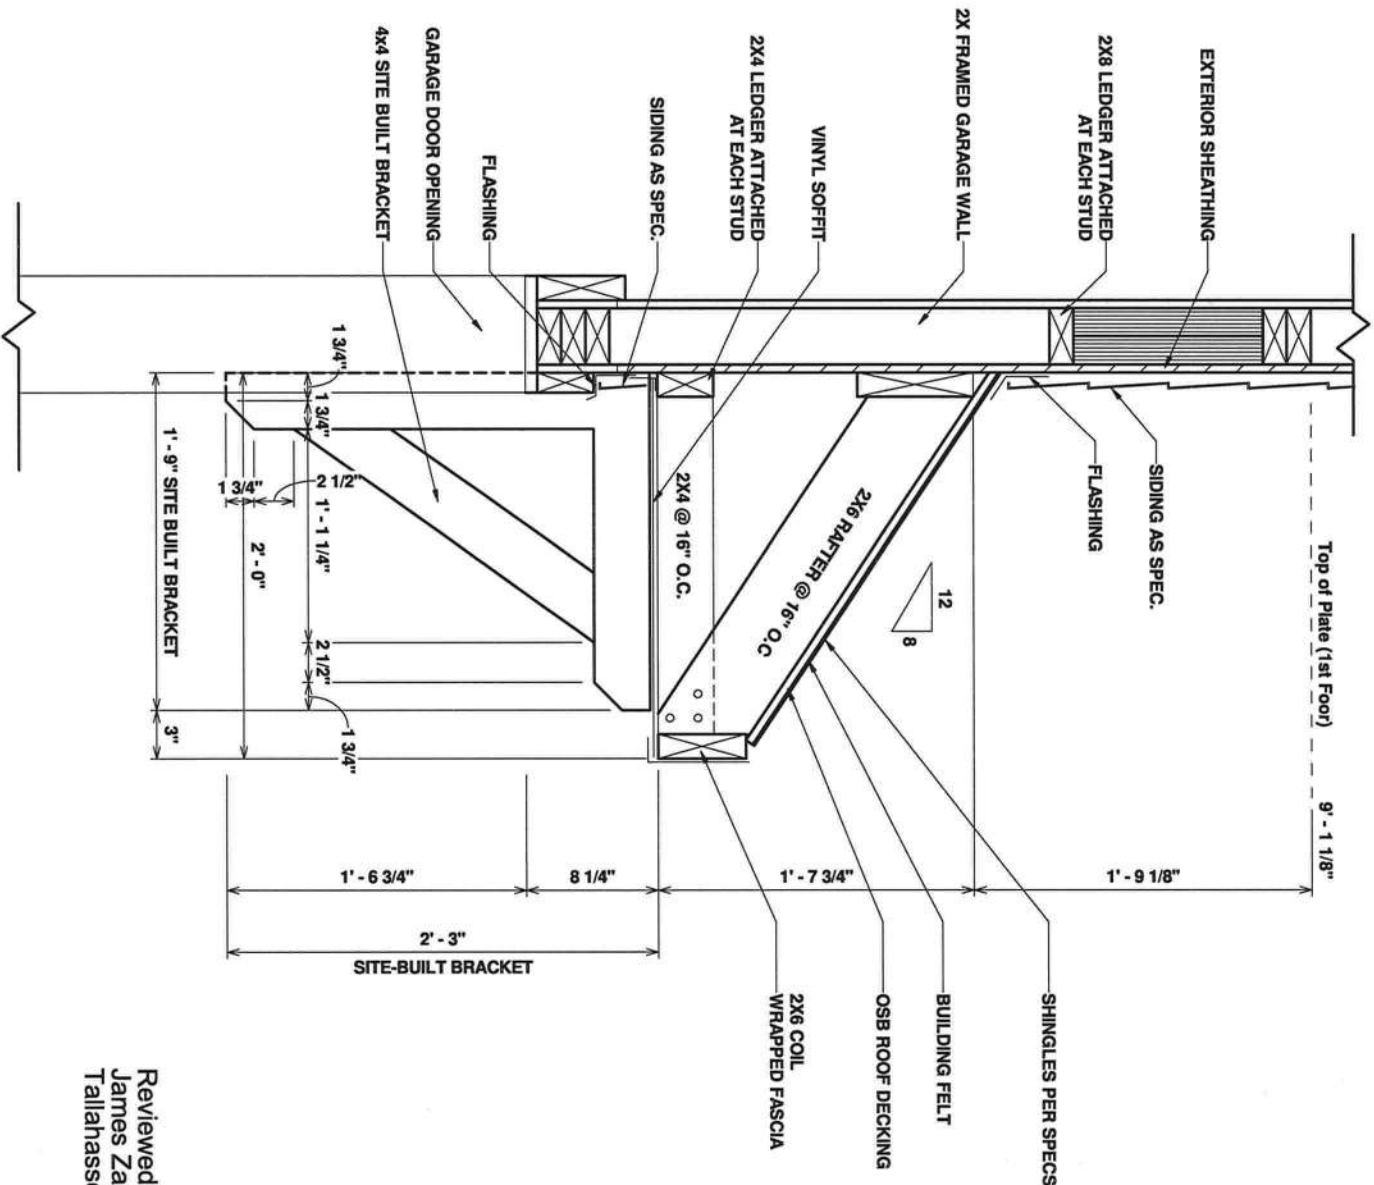

450.4 GARAGE DOOR EYEBROW DETAIL - 8/12 PITCH


(Flat)

1" = 1'-0"

Reviewed for Compliance
James Zaleski PE 51544 2305 Haverhill Rd
Tallahassee, FL 32312 PH 850-766-7778 See Wind Load Details

Digitally signed
by JAMES
ZALESKI

Date: 2020.11.06 12:15:34 -05'00'

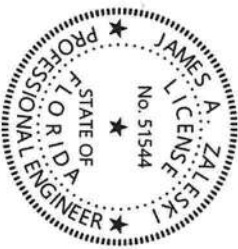

OPT. PAPER SIZE: 10r 1/4" = 1'-0" on 24"x36" PAPER SIZE ENLARGE PRINTS TO 200%
FINAL CONSTRUCTION PLANS

Revision Schedule		
Revision Number	Revision Description	Revision Date
	PRELIMINARY	9/23/20

AREAS:	
FIRST FLOOR HEATED	2,198 SF
GARAGE	560 SF
FRONT PORCH	367 SF
REAR PORCH	167 SF
TOTAL UNDER ROOF	3,292 SF

THE: BERGLUND M. FRMHOUSE	
FOR: RALPH AND ELIZABETH BONANZA	
TBD JEANLEA PLACE. COLUMBIA - FL. 32038	
OFFICE: GAINESVILLE	SOLD BY: A. LOCAY

JOB# 59-20-042
2x6 EXTERIOR WALLS UNLESS OTHERWISE NOTED
FOUNDATION TYPE: MONOSLAB


DRAWN BY: AP
CHECKED BY: B. TOOMBS
PRINT DATE: 11/6/2020 9:06:36 AM

PROPERTY OF:
©COPYRIGHT - 2018


SHEET NUMBER:
S-1

DETAILS & SECTIONS


Reviewed for Compliance
James Zaleski PE 51544 2305 Haverhill Rd
Tallahassee, FL 32312 PH 850-766-7778 See Wind Load Details

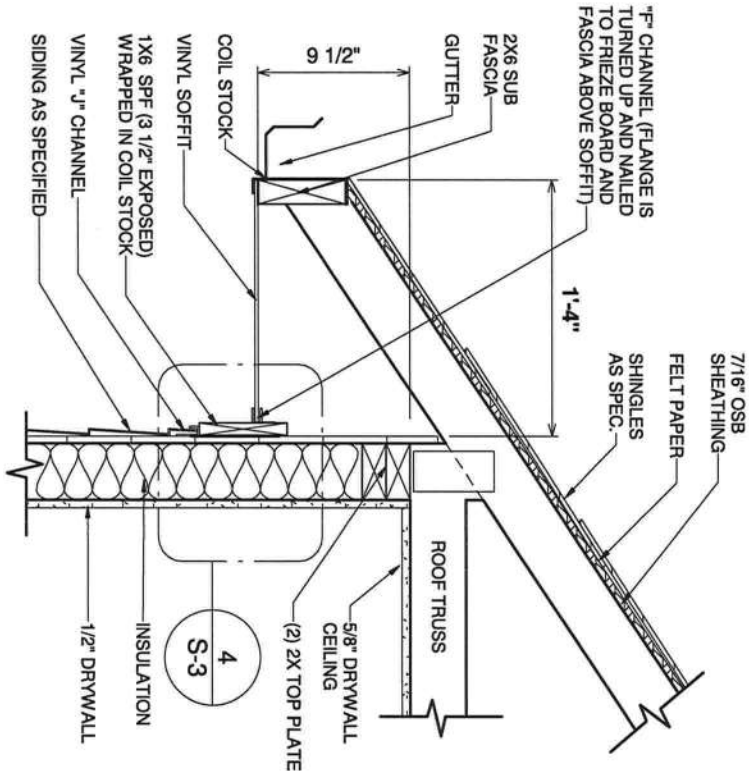


3 400.1 RAFTER TAIL AT SIDING WALL - TYPICAL2
1" = 1'-0"

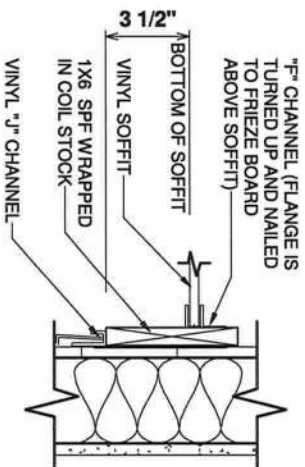

4 400.2 FRIEZE DETAIL AT SIDING
1 1/2" = 1'-0"

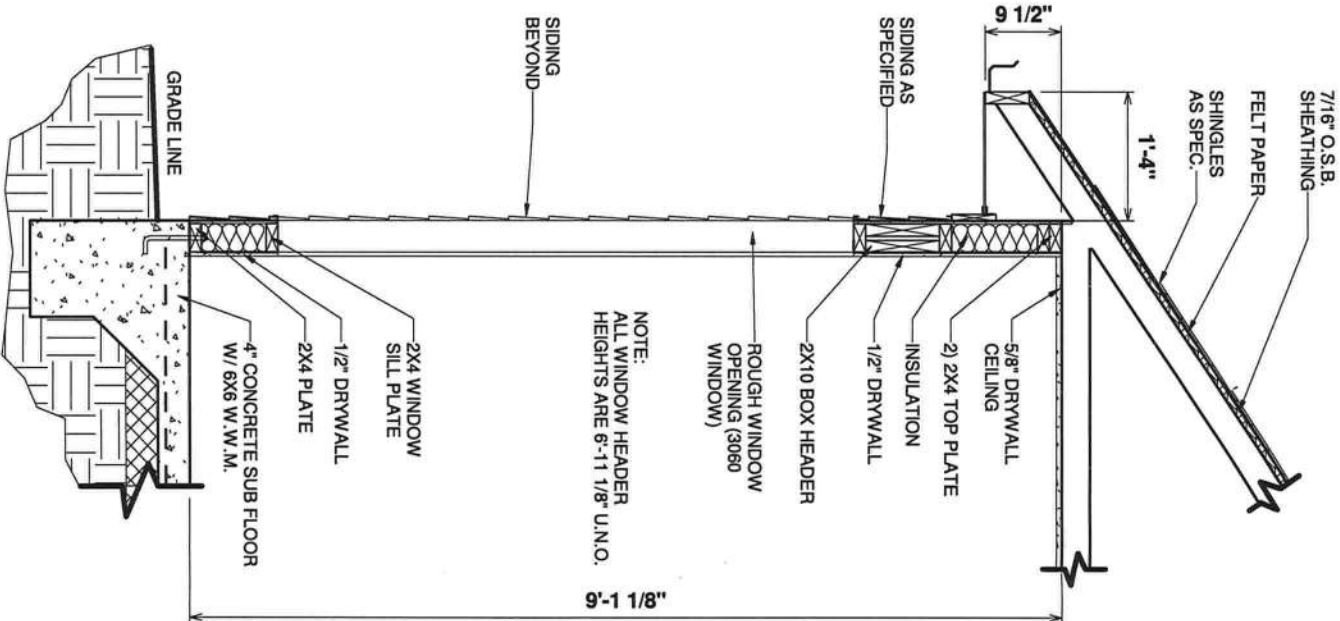


2 220.1.1 1 STORY WALL SECTION ON SLAB AT WINDOW
1/2" = 1'-0"

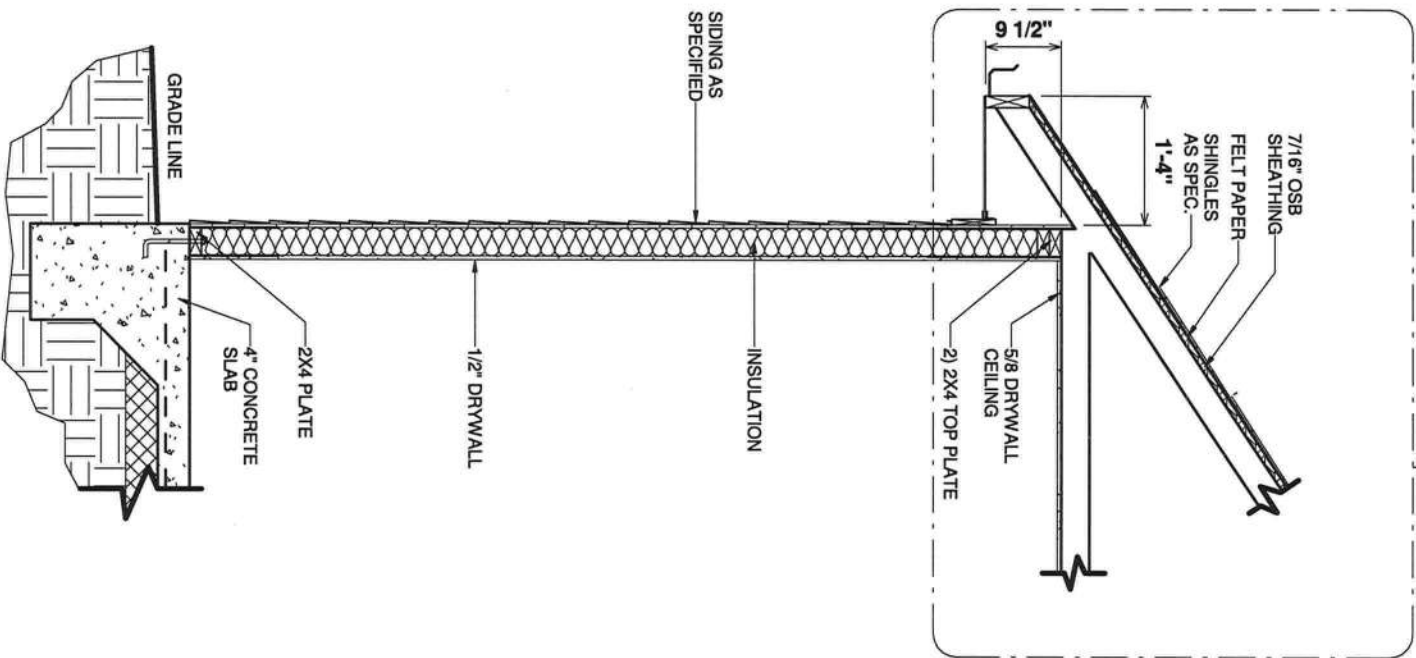

1 220.1 1 STORY WALL SECTION ON SLAB
1/2" = 1'-0"

JAMES ZALESKI
Digitally signed by
JAMES ZALESKI
Date: 2020.11.06
12:14:12 -05'00'

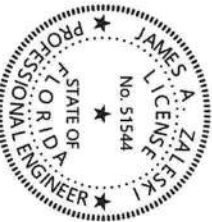

TO REPORT COPYRIGHT VIOLATIONS CALL (770)532-1128 THE USE OF THIS PLAN BY ANYONE OTHER THAN AN AGENT OF "AMERICA'S HOME PLACE, INC." IS IN VIOLATION OF THE FEDERAL COPYRIGHT VIOLATION ACT. \$100 REWARD FOR RECOVERING AN ACTUAL COPYRIGHT INFRINGEMENT.
©COPYRIGHT ALL RIGHTS RESERVED NOTE:VIOLATORS OF THE COPYRIGHT WILL BE PROSECUTED TO THE FULLEST EXTENT OF THE LAW. THIS WORK IS THE INTELLECTUAL PROPERTY OF AMERICA'S HOME PLACE AND SHALL NOT BE REPRODUCED WITHOUT PERMISSION.

OPT. PAPER SIZE: 10r 1/4" = 1'-0" on 24"x36" PAPER SIZE ENLARGE PRINTS TO 200%
FINAL CONSTRUCTION PLANS

Revision Schedule		
Revision Number	Revision Description	Revision Date
	PRELIMINARY	9/23/20

AREAS:	
FIRST FLOOR HEATED	2,198 SF
GARAGE	560 SF
FRONT PORCH	367 SF
REAR PORCH	167 SF
TOTAL UNDER ROOF	3,292 SF

THE: BERGLUND M. FRMHOUSE	
FOR: RALPH AND ELIZABETH BONANZA	
TBD JEANLEA PLACE. COLUMBIA - FL. 32038	
OFFICE: GAINESVILLE	SOLD BY: A. LOCAY

DRAWN BY: AP	JOB# 59-20-042
CHECKED BY: B. TOOMBS	2x6 EXTERIOR WALLS UNLESS OTHERWISE NOTED
PRINT DATE: 11/6/2020 9:06:36 AM	FOUNDATION TYPE: MONOSLAB

PROPERTY OF:	SHEET NUMBER:
 © COPYRIGHT - 2018	S-3

DETAILS AND SECTIONS