


REVISIONS	

SOFTPLAN
ARCHITECTURAL DESIGN SOFTWARE

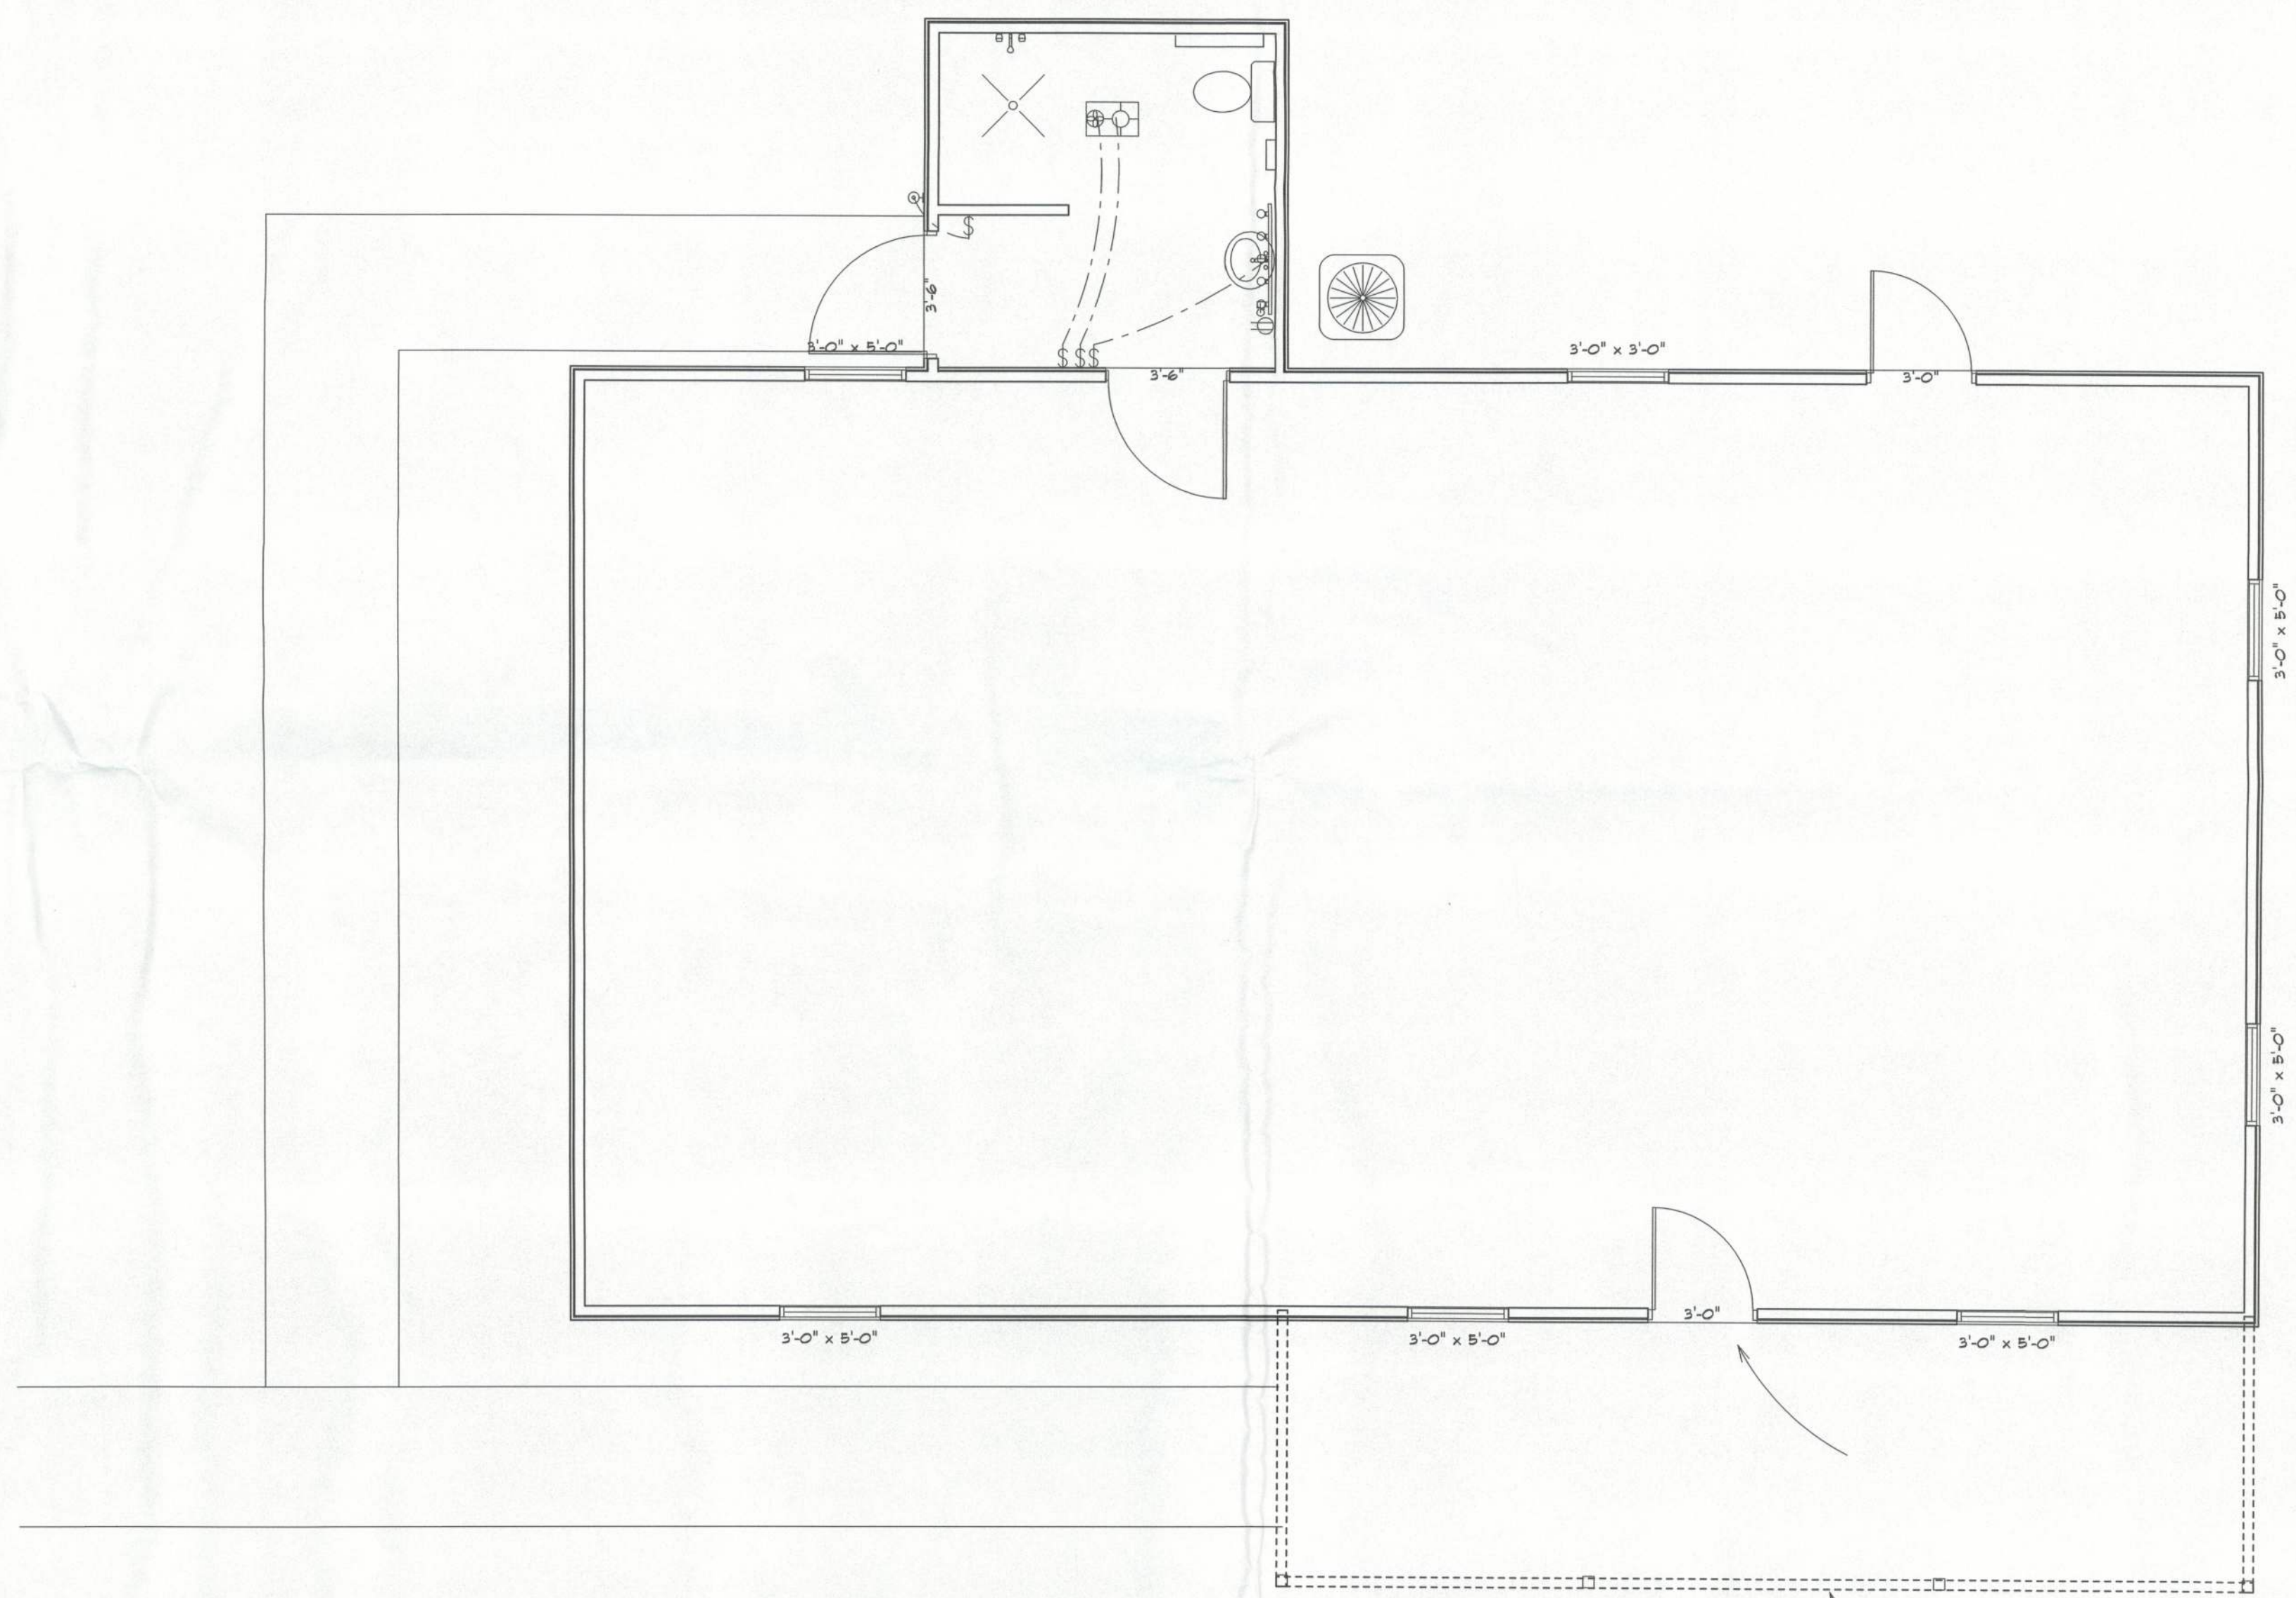

New Bath
Electrical Plan

RESIDENCE
Patric Brannon
353 Murdock Ct.
FL White, FL 32078

ADDRESS:
Columbia County, Florida

Woodman Park Builders, Inc.
Lake City, Florida
Phone: (386) 755 - 2411
Fax: (386) 755-8684
Email:

PRINTED DATE:

DRAWN BY: CHECKED BY:

DESIGNED BY:
Mark Haddock

FINALS DATE:

JOB NUMBER:

DRAWING NUMBER
A-2