

*** PLUMBING & CONCRETE PLAN ***

SCALE : 3/8" = 1'-0"

NEW RESIDENCE
for
JONNY MACK
WRIGHT

Tesna M. Ruffo
2925 SW 6R 47
Lake City, Florida, 32025
Cell: (386) 867-1191
Email: tesnaruffo@gmail.com

PRINTED DATE:
Tuesday, March 3, 2026

DRAWN BY: Daniel Hammond
CHECKED BY: TMR


BUILDING CONTRACTOR
CLINT BOONE

FINALS DATE:

JOB NUMBER:

DRAWING NUMBER
A - 1

OF 5 SHEETS

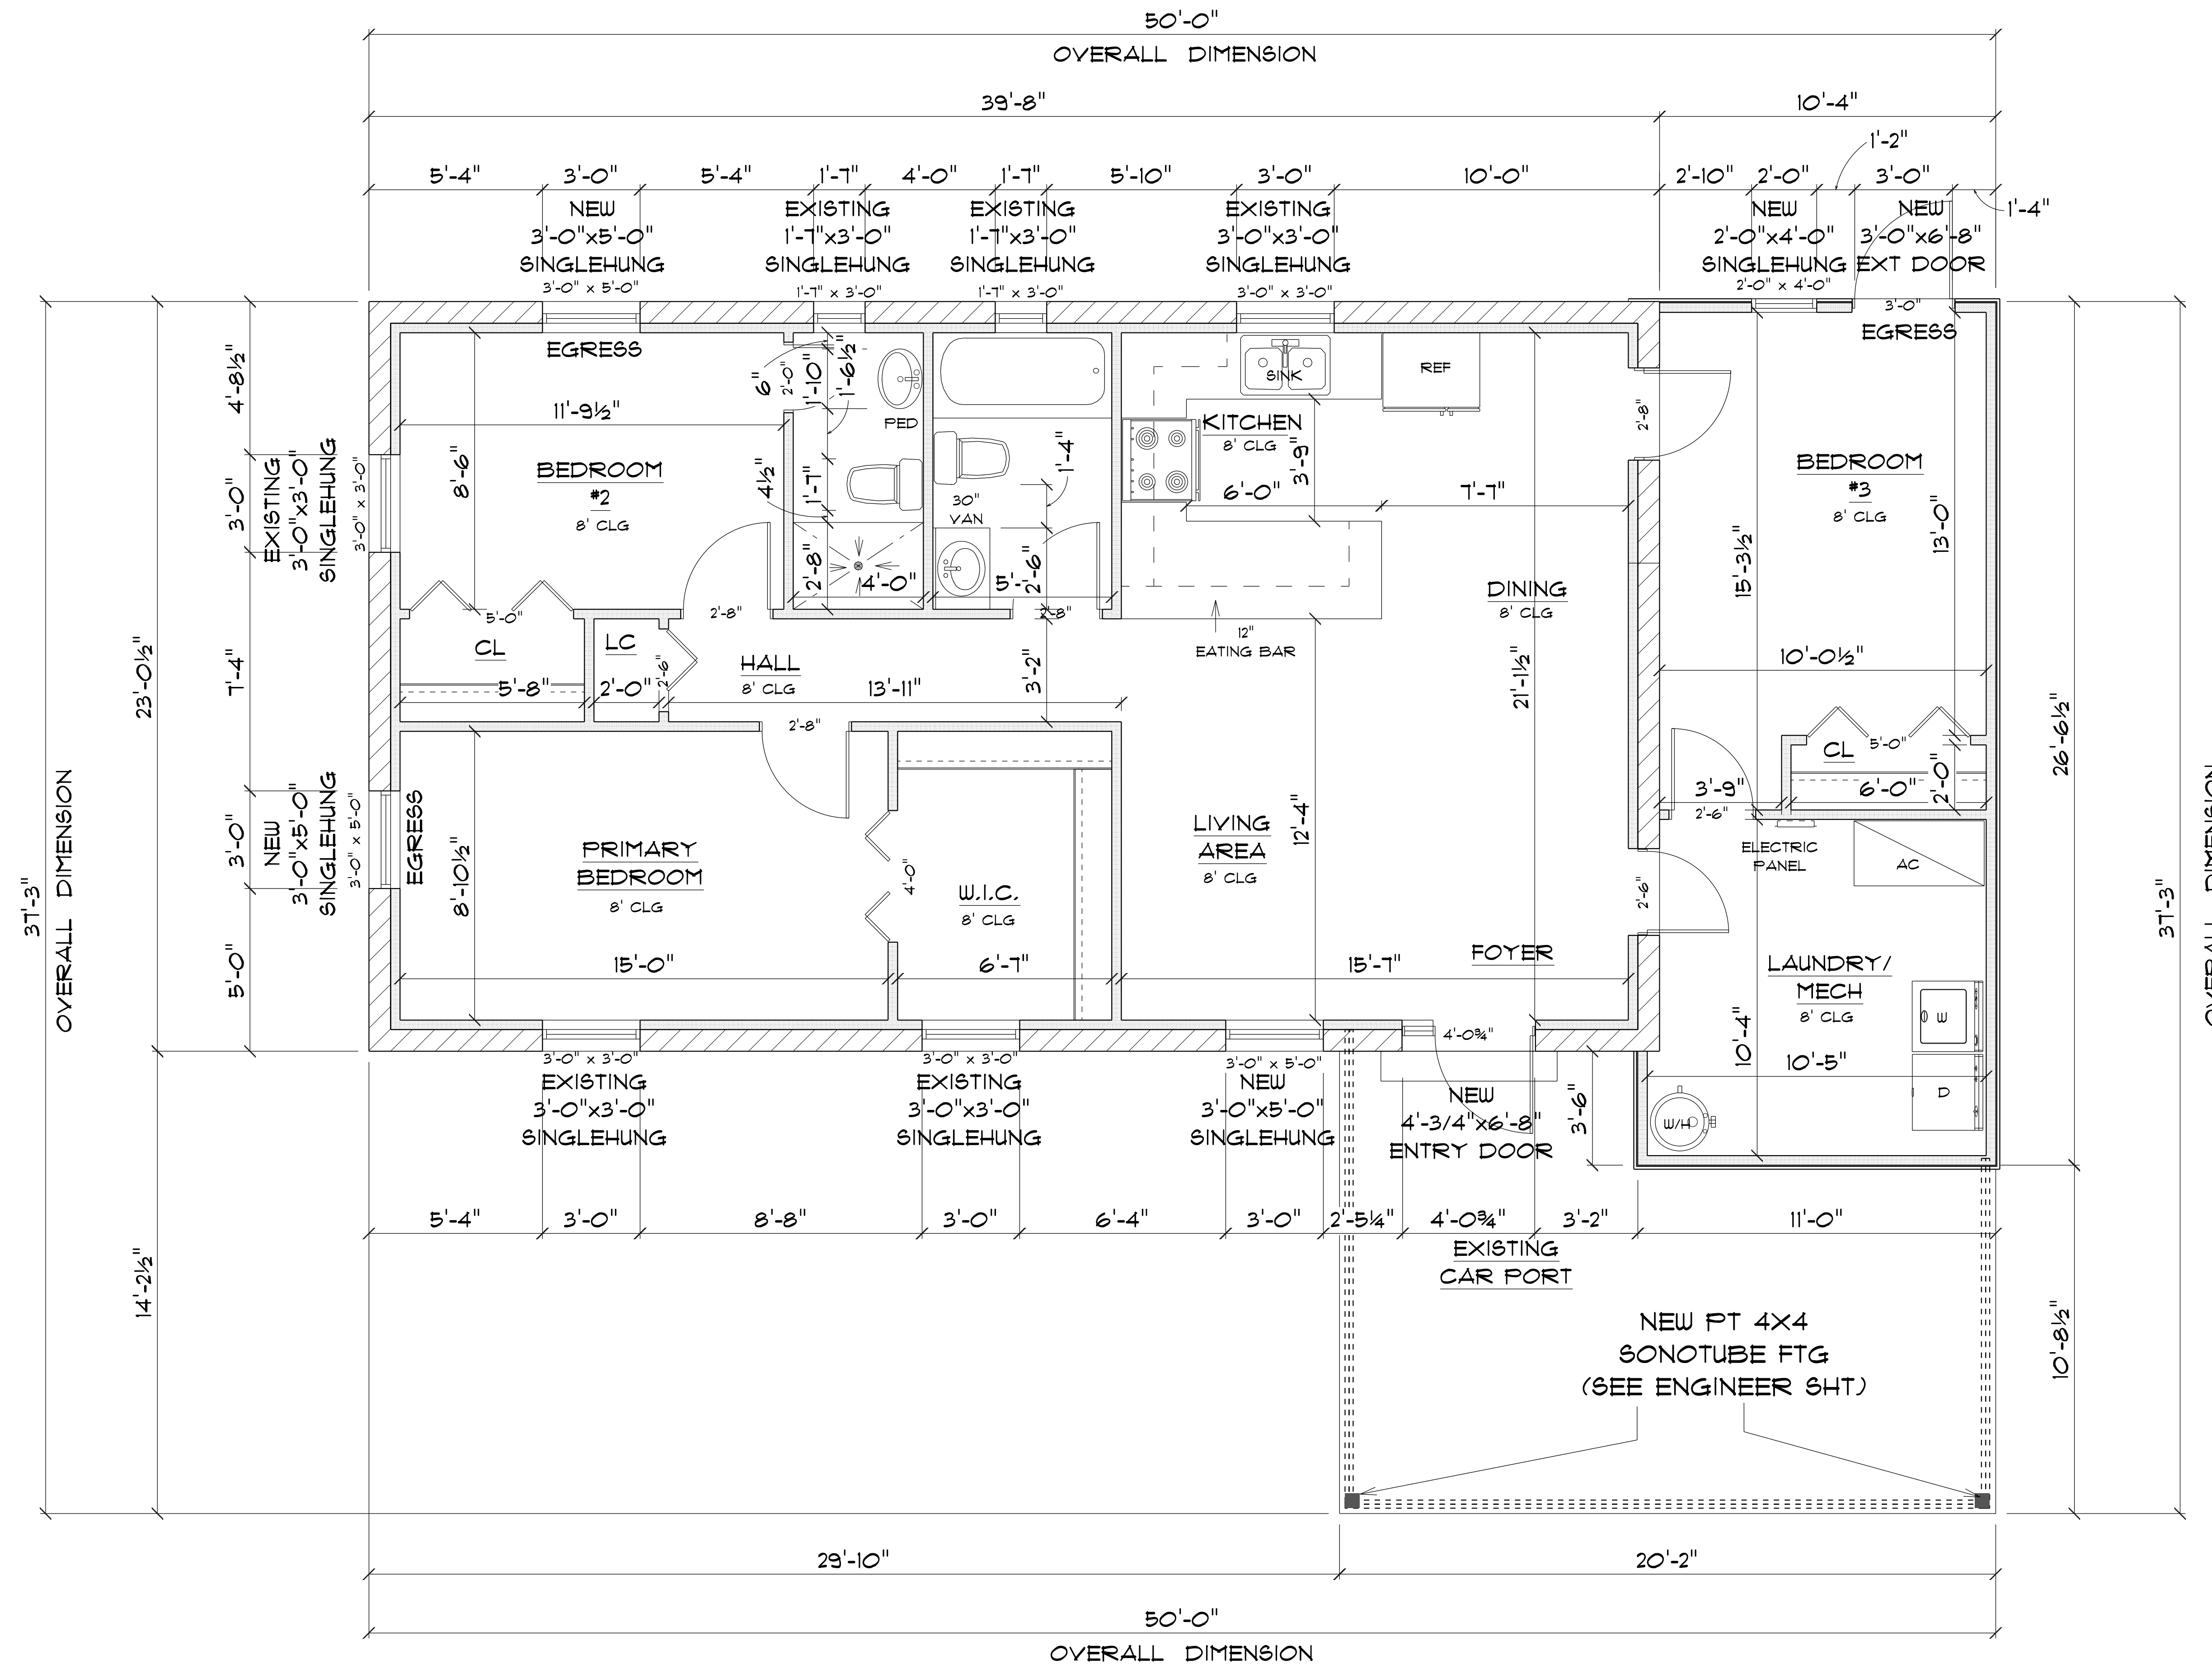

IMPORTANT NOTES:

1. IT IS THE BUILDER'S RESPONSIBILITY TO VERIFY ALL GEOMETRY AND DIMENSIONS BEFORE ORDERING ANY MATERIALS OR BEGINNING CONSTRUCTION.
2. THESE PLANS ARE FOR LAYOUT AND DESIGN PURPOSES ONLY. ALL STRUCTURAL NOTES AND DETAILS TO BE PROVIDED BY AN ENGINEER.

* **PROPOSED** *

* **FLOOR PLAN** *

SCALE : 3/8" = 1'-0"

A/C AREA	=	1,192	S.F.
CARPORT	=	240	S.F.
TOTAL AREA	=	1,432	S.F.

NEW RESIDENCE
for
**JONNY MACK
WRIGHT**

Teena M. Ruffo
2925 SW 6R 41
Lake City, Florida, 32025
Cell: (386) 867-1191
Email: teenaruffo@gmail.com

PRINTED DATE:
Tuesday, March 3, 2026

DRAWN BY: Daniel Hammond
CHECKED BY: TMR


BUILDING CONTRACTOR:
CLINT BOONE

FINALS DATE:

JOB NUMBER:


DRAWING NUMBER:
A - 2

OF 5 SHEETS

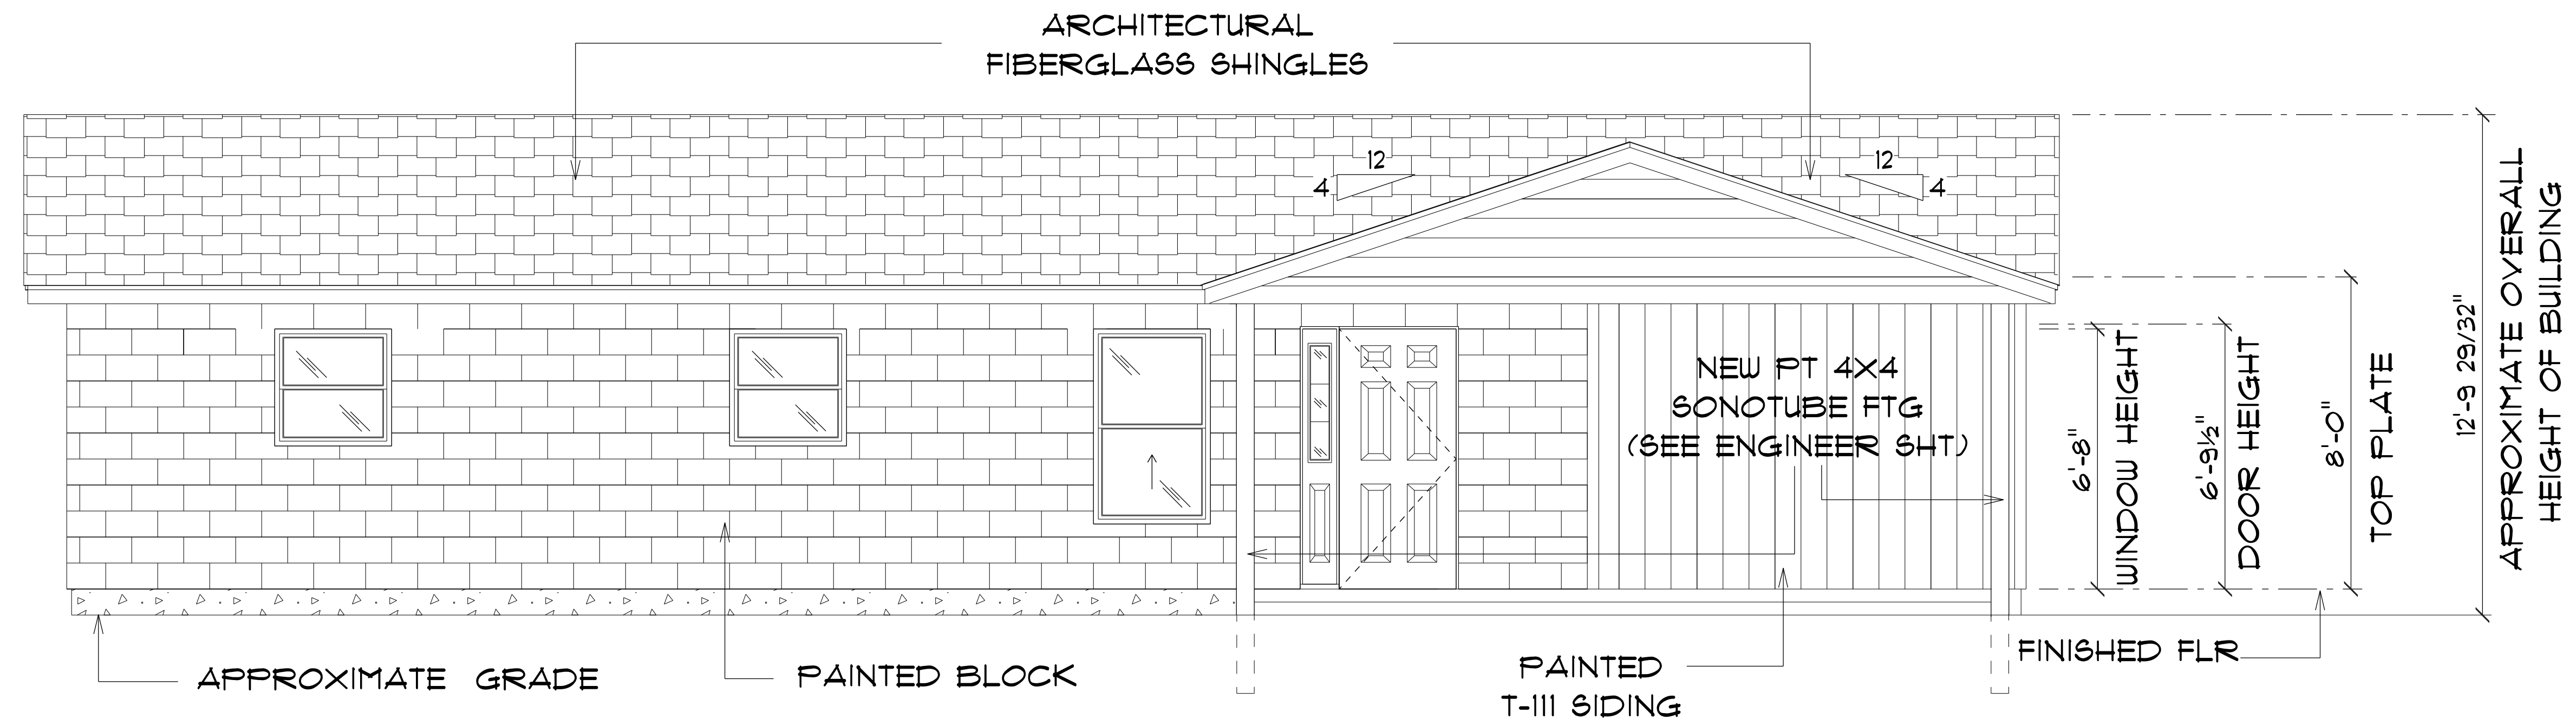

*** FRONT ELEVATION ***

SCALE : 3/8" = 1'-0"

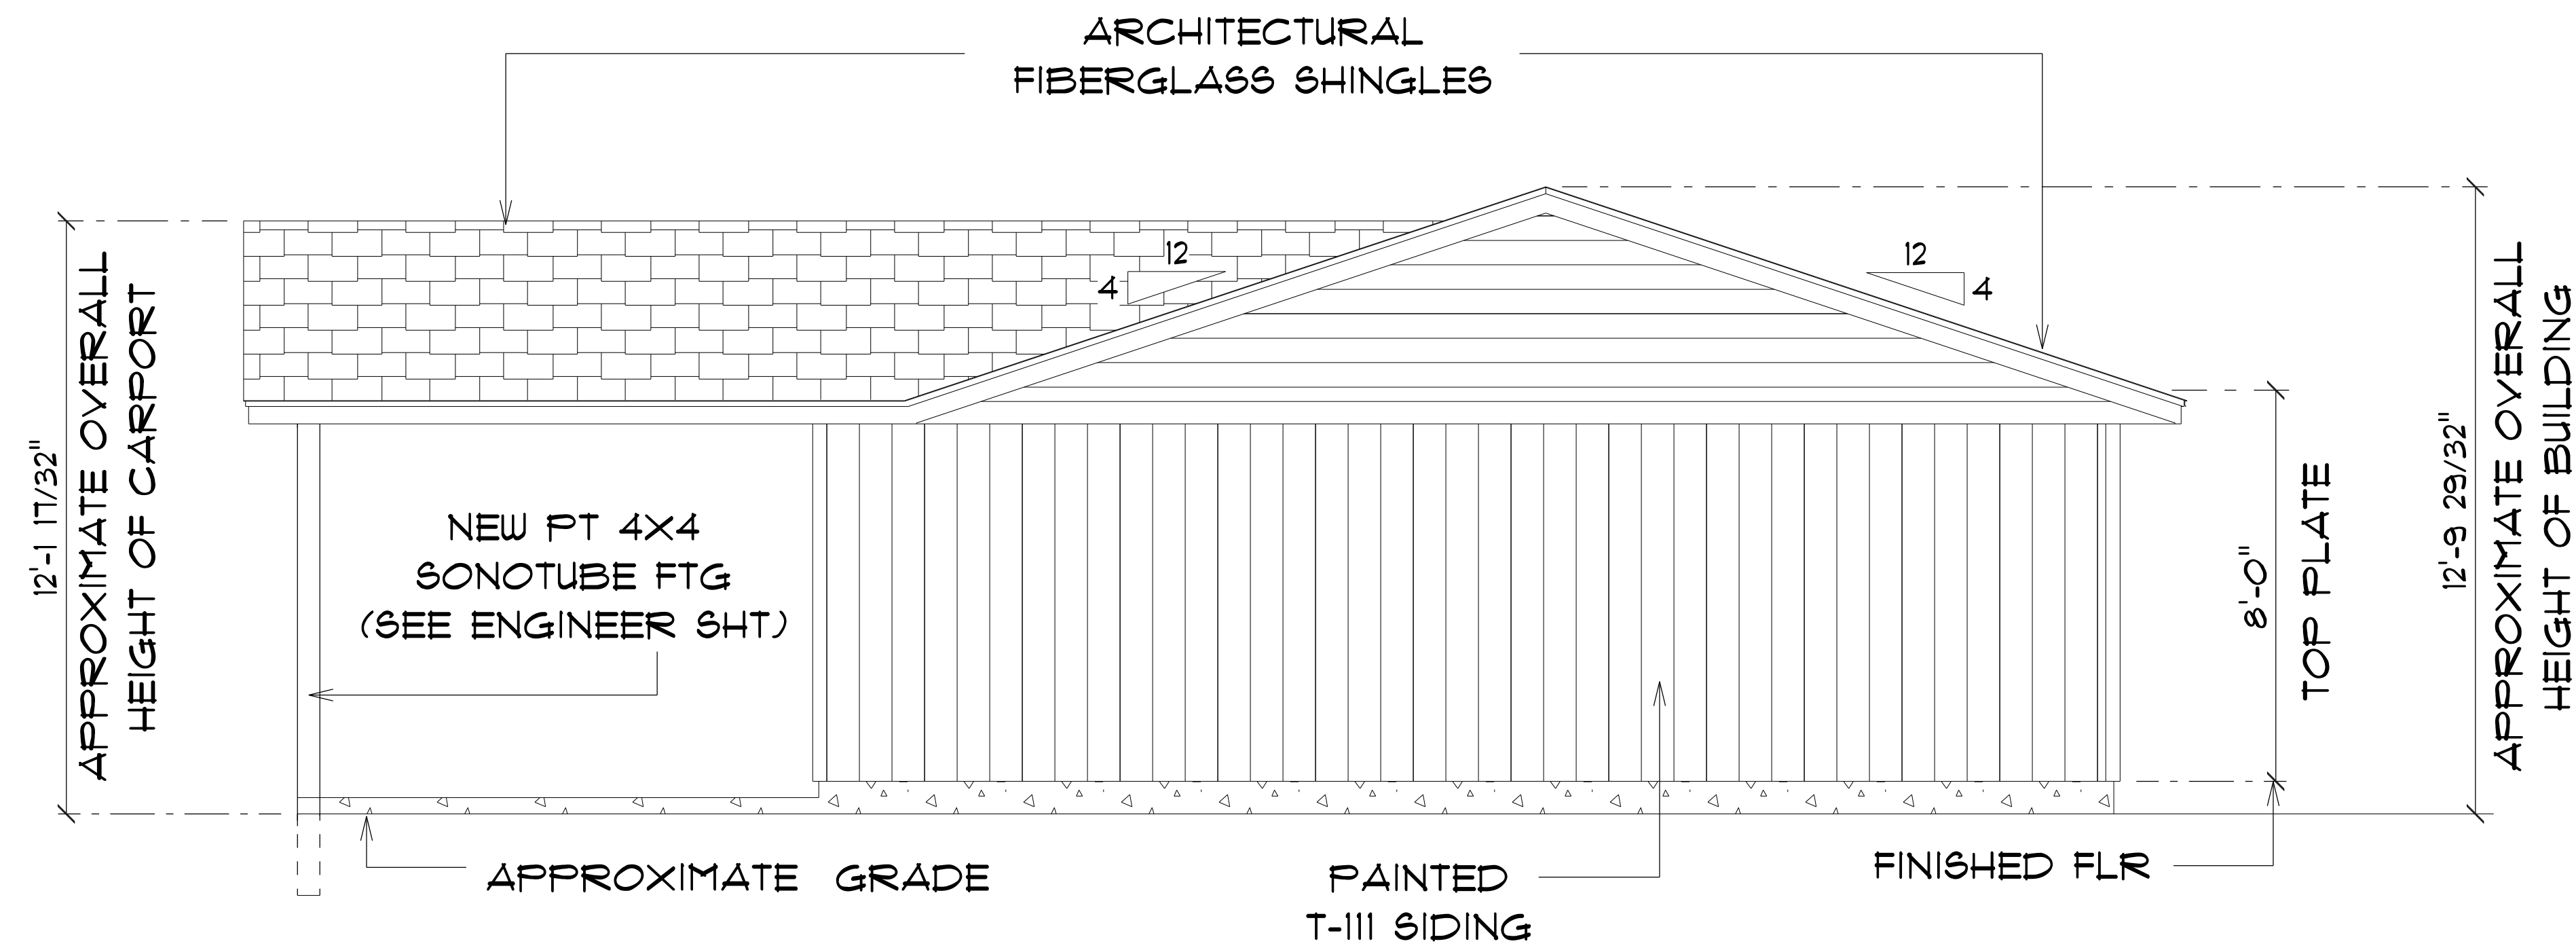

*** RIGHT ELEVATION ***

SCALE : 3/8" = 1'-0"

NEW RESIDENCE
for
JONNY MACK
WRIGHT

Teena M. Ruffo
2925 SW 6R 41
Lake City, Florida, 32026
Cell: (386) 867-1191
Email: teenaruffo@gmail.com

PRINTED DATE:
Tuesday, March 3, 2026

DRAWN BY: Daniel Hammond
CHECKED BY: TMR

BUILDING CONTRACTOR
CLINT BOONE


FINALS DATE:

JOB NUMBER:

DRAWING NUMBER


A - 3

OF 5 SHEETS

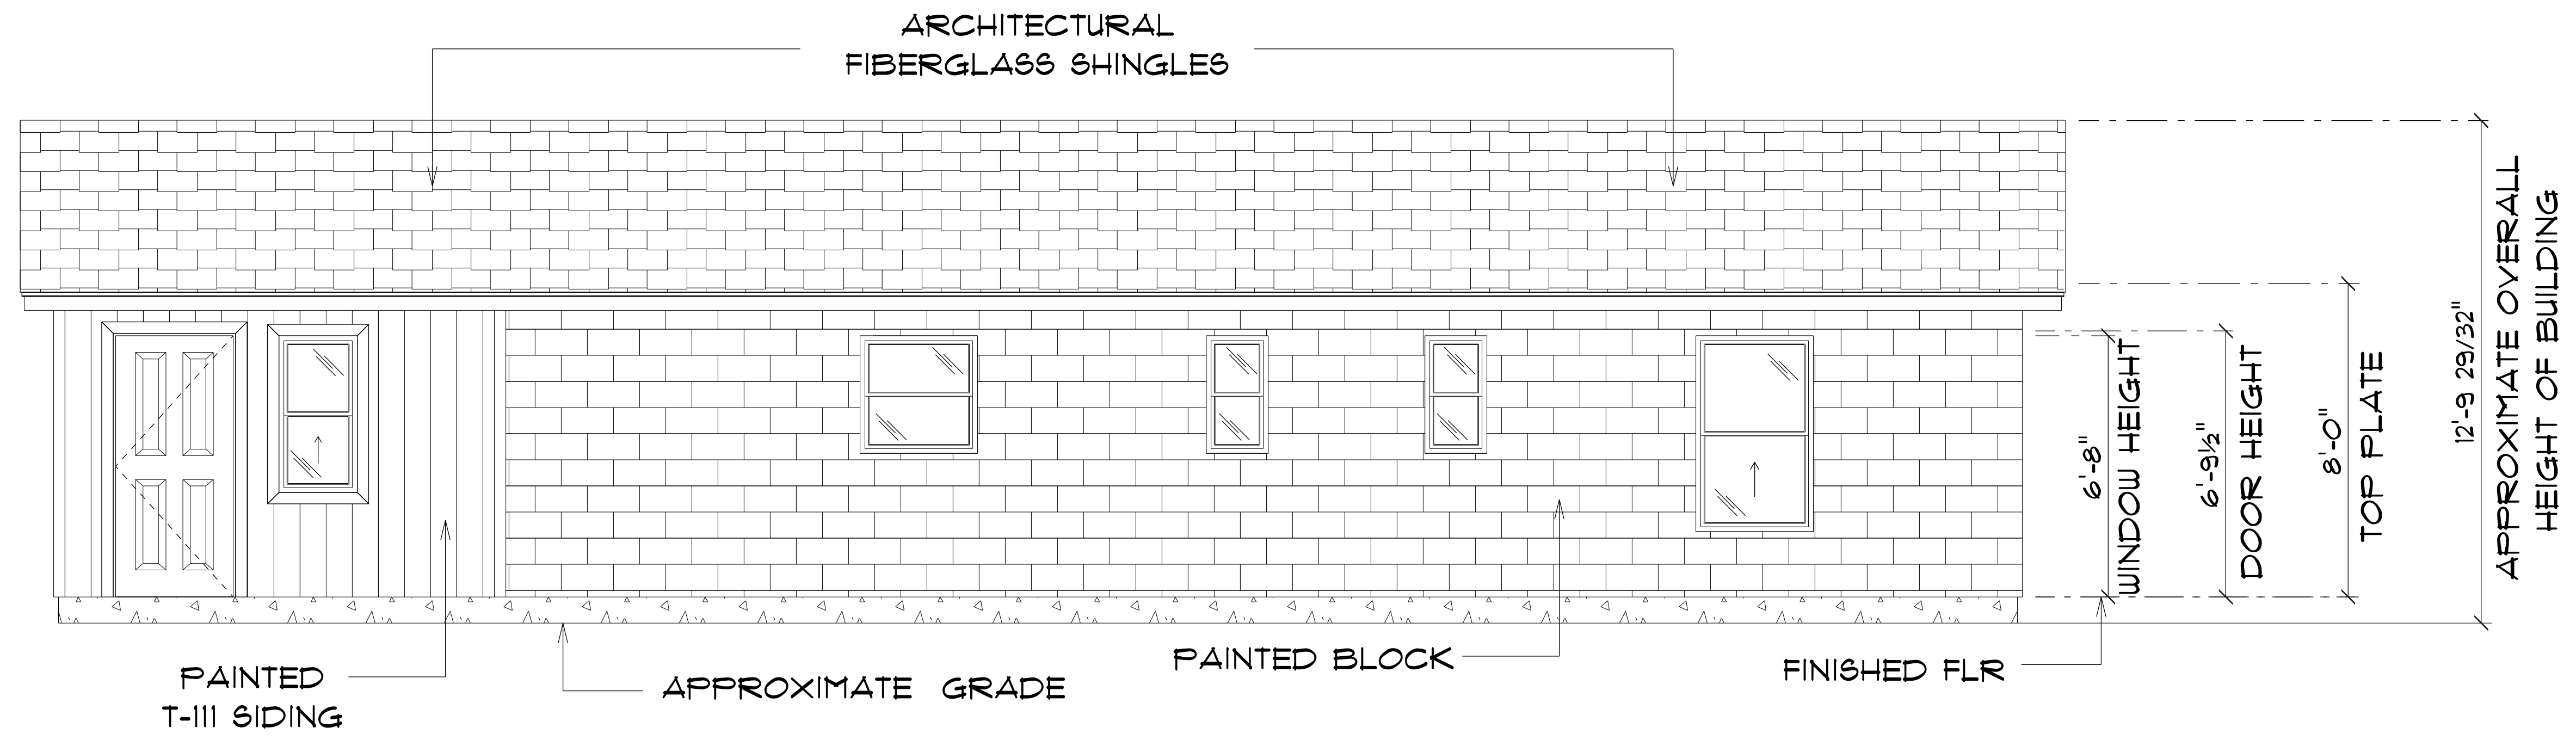

*** REAR ELEVATION ***

SCALE : 3/8" = 1'-0"

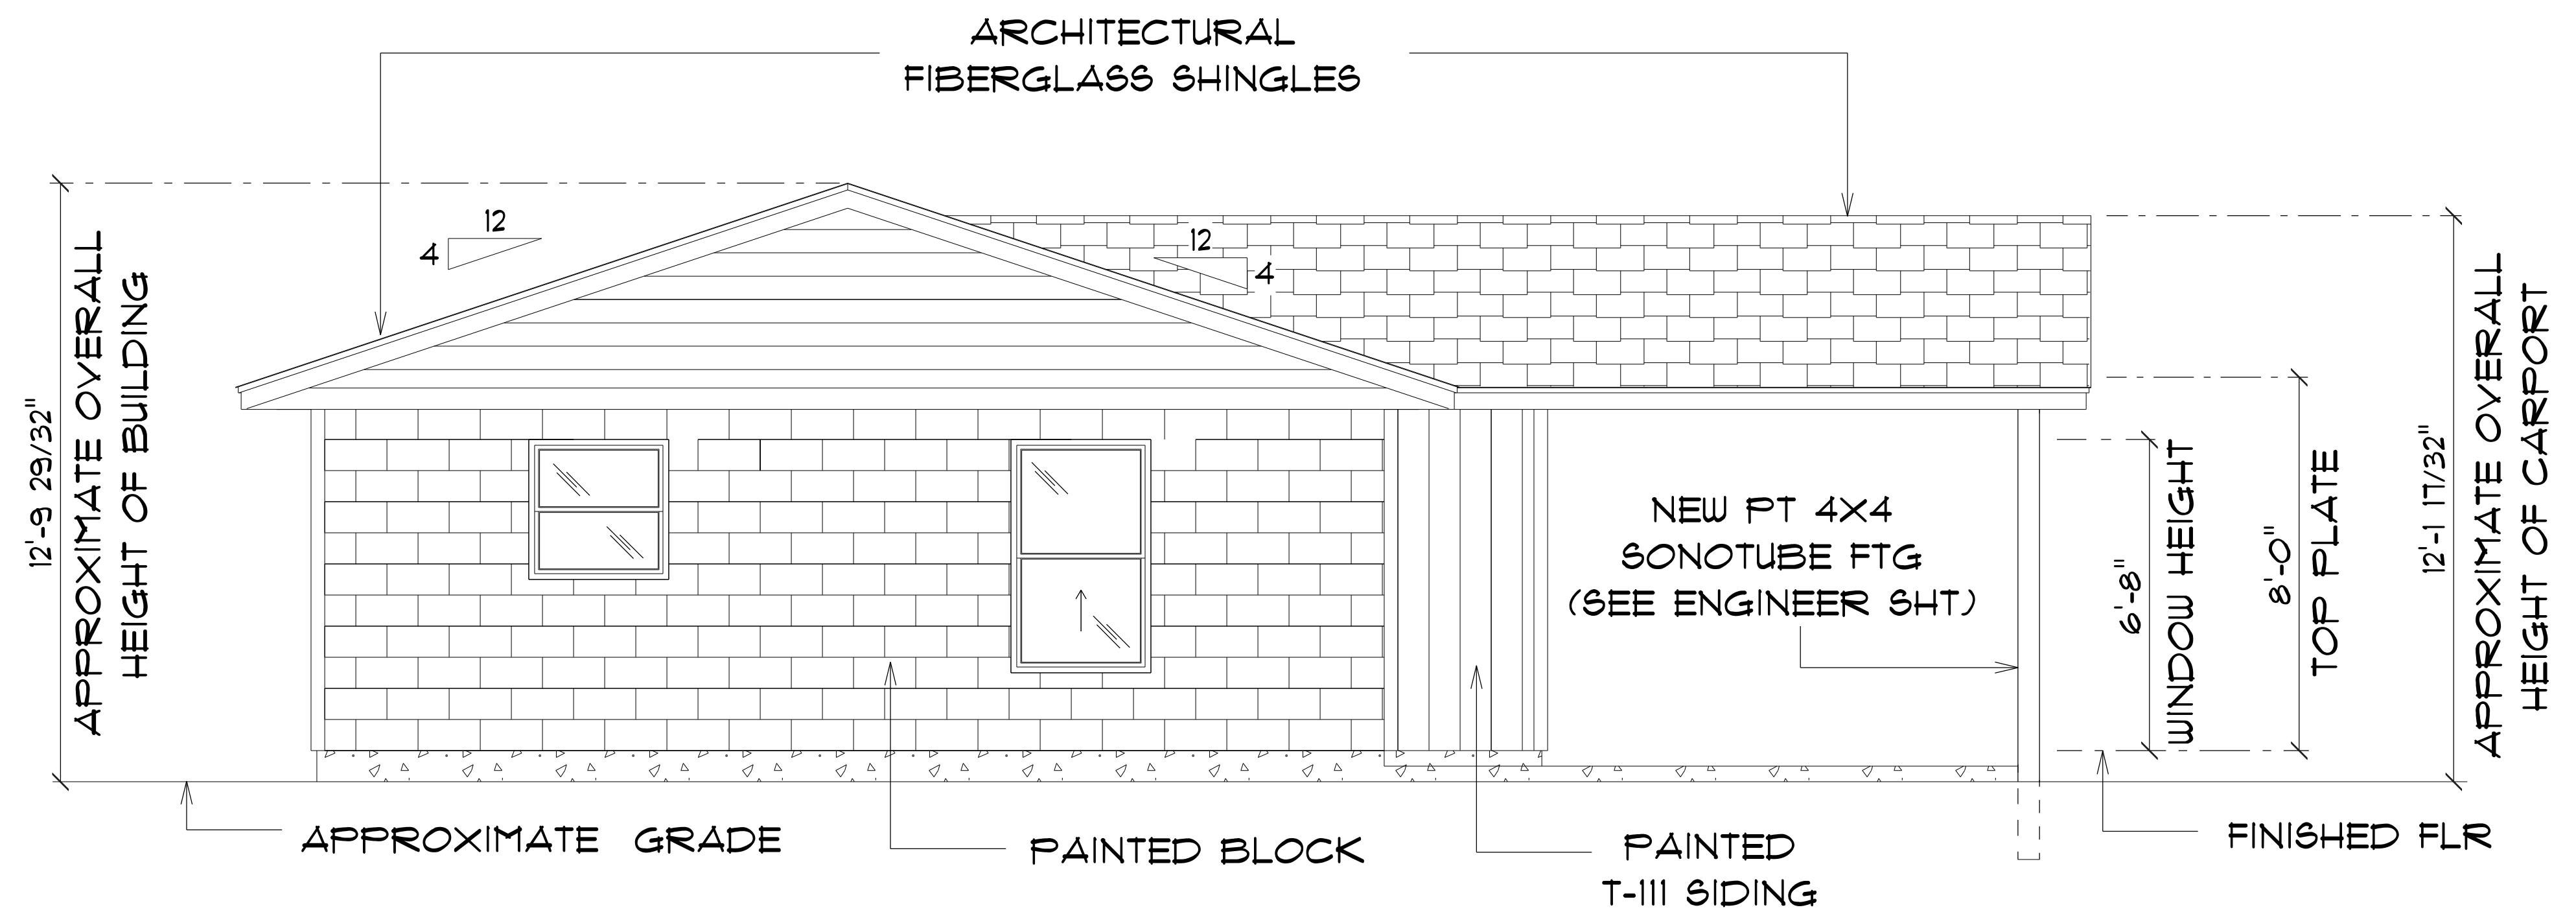

*** LEFT ELEVATION ***

SCALE : 3/8" = 1'-0"

NEW RESIDENCE
for
**JONNY MACK
WRIGHT**

Teena M. Ruffo
2925 SW 8R 47
Lake City, Florida, 32025
Cell: (386) 867-1191
Email: teenaruffo@gmail.com

PRINTED DATE:
Tuesday, March 3, 2026

DRAWN BY: Daniel Hammond CHECKED BY: TMR

BUILDING CONTRACTOR
CLINT BOONE


FINALS DATE:

JOB NUMBER:

DRAWING NUMBER

A - 4

OF 5 SHEETS

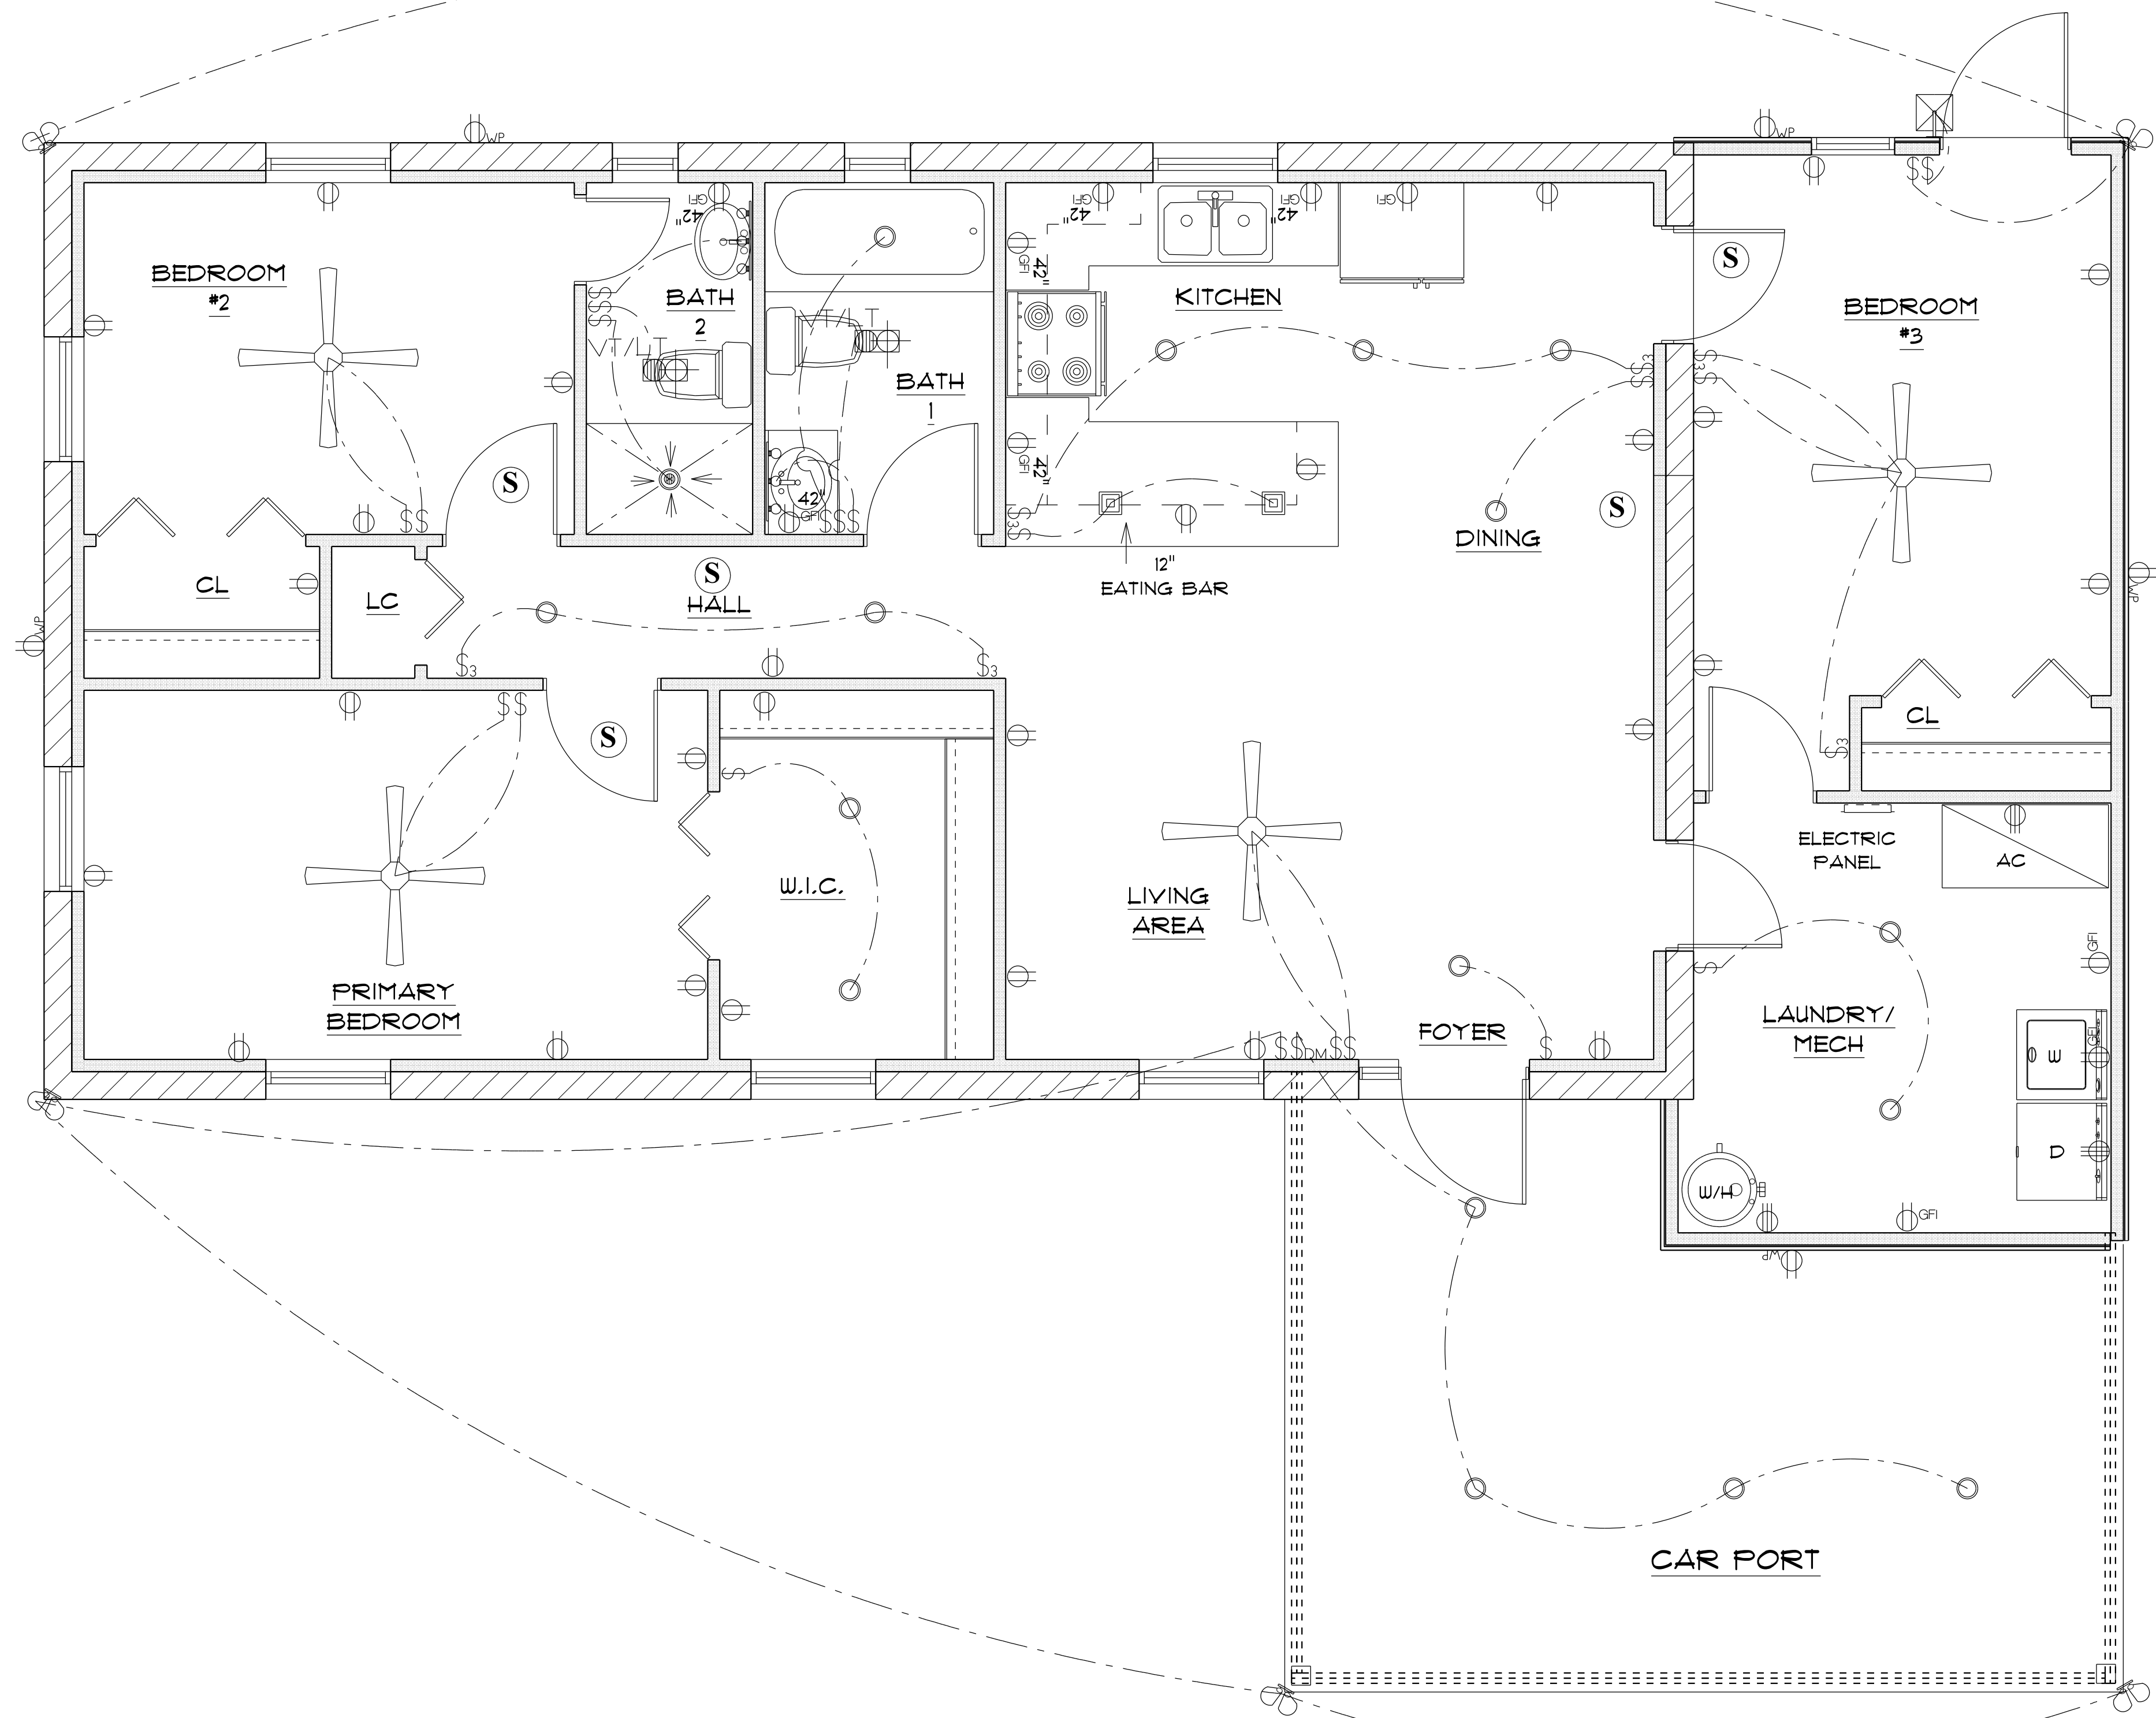

ELECTRICAL LEGEND		
ELECTRICAL	COUNT	SYMBOL
ceiling fan	4	
dimmer switch	1	
electrical panel	1	
exterior craftsman light fixture	1	
outlet	28	
outlet 220v	3	
outlet gfi	10	
outlet up	5	
pendant large	2	
pot light	17	
Smoke Detector	5	
spotlight double	5	
switch	21	
switch 3 way	6	
vanity bar light O2	2	
vent light combo	2	

ELECTRICAL PLAN NOTES

- E-1 WIRE ALL APPLIANCES, HYAC UNITS AND OTHER EQUIPMENT PER MANUFACTURERS SPECIFICATIONS.
- E-2 CONSULT THE OWNER FOR THE NUMBER OF SEPERATE TELEPHONE LINES TO BE INSTALLED.
- E-3 ALL INSTALLATIONS SHALL BE PER NATIONAL ELECTRIC CODE.
- E-4 ALL SMOKE DETECTORS SHALL BE 120V W/BATTERY BACKUP OF THE PHOTOELECTRIC TYPE, AND SHALL BE INTERLOCKED TOGETHER. INSTALL INSIDE AND NEAR ALL BEDROOMS.
- E-5 TELEPHONE, TELEVISION AND OTHER LOW VOLTAGE DEVICES OR OUTLETS SHALL BE AS PER THE OWNERS DIRECTION AND IN ACCORDANCE WITH APPLICABLE SECTIONS OF NATIONAL ELCT. CODE LATEST EDITION.
- E-6 ELECTRICAL CONTRACTOR SHALL BE RESPONSIBLE FOR THE DESIGN AND SIZING OF ELECTRICAL SERVICE AND CIRCUITS.
- E-7 ENTRY OF SERVICE UNDERGROUND OR OVERHEAD) IS TO BE DETERMINED BY THE POWER COMPANY.

*** ELECTRICAL PLAN ***

NEW RESIDENCE
for
**JONNY MACK
WRIGHT**

Teena M. Ruffo
2925 SW 6R 47
Lake City Florida, 32025
Cell: (386) 867-1191
Email: teenaruffo@gmail.com

PRINTED DATE:
Tuesday, March 3, 2026

DRAWN BY: Daniel Hammond
CHECKED BY: TMR

BUILDING CONTRACTOR
CLINT BOONE

FINALS DATE:

JOB NUMBER:

DRAWING NUMBER

A - 5

OF 5 SHEETS