


LINE TABLE

Line	Bearing	Distance
L1	S.88°28'16"W.	343.53'
L2	S.25°07'54"E.	83.02'
L3	S.07°03'44"E.	36.52'
L4	S.61°26'23"E.	34.49'
L5	N.42°46'50"E.	68.15'
L6	S.66°33'44"E.	35.80'
L7	S.63°44'29"E.	44.21'
L8	S.44°21'33"E.	22.24'
L9	S.10°37'19"W.	35.26'
L10	S.19°32'15"W.	25.07'
L11	S.21°44'26"W.	12.48'
L12	S.28°40'37"W.	21.62'
L13	N.88°32'08"E.	159.52'

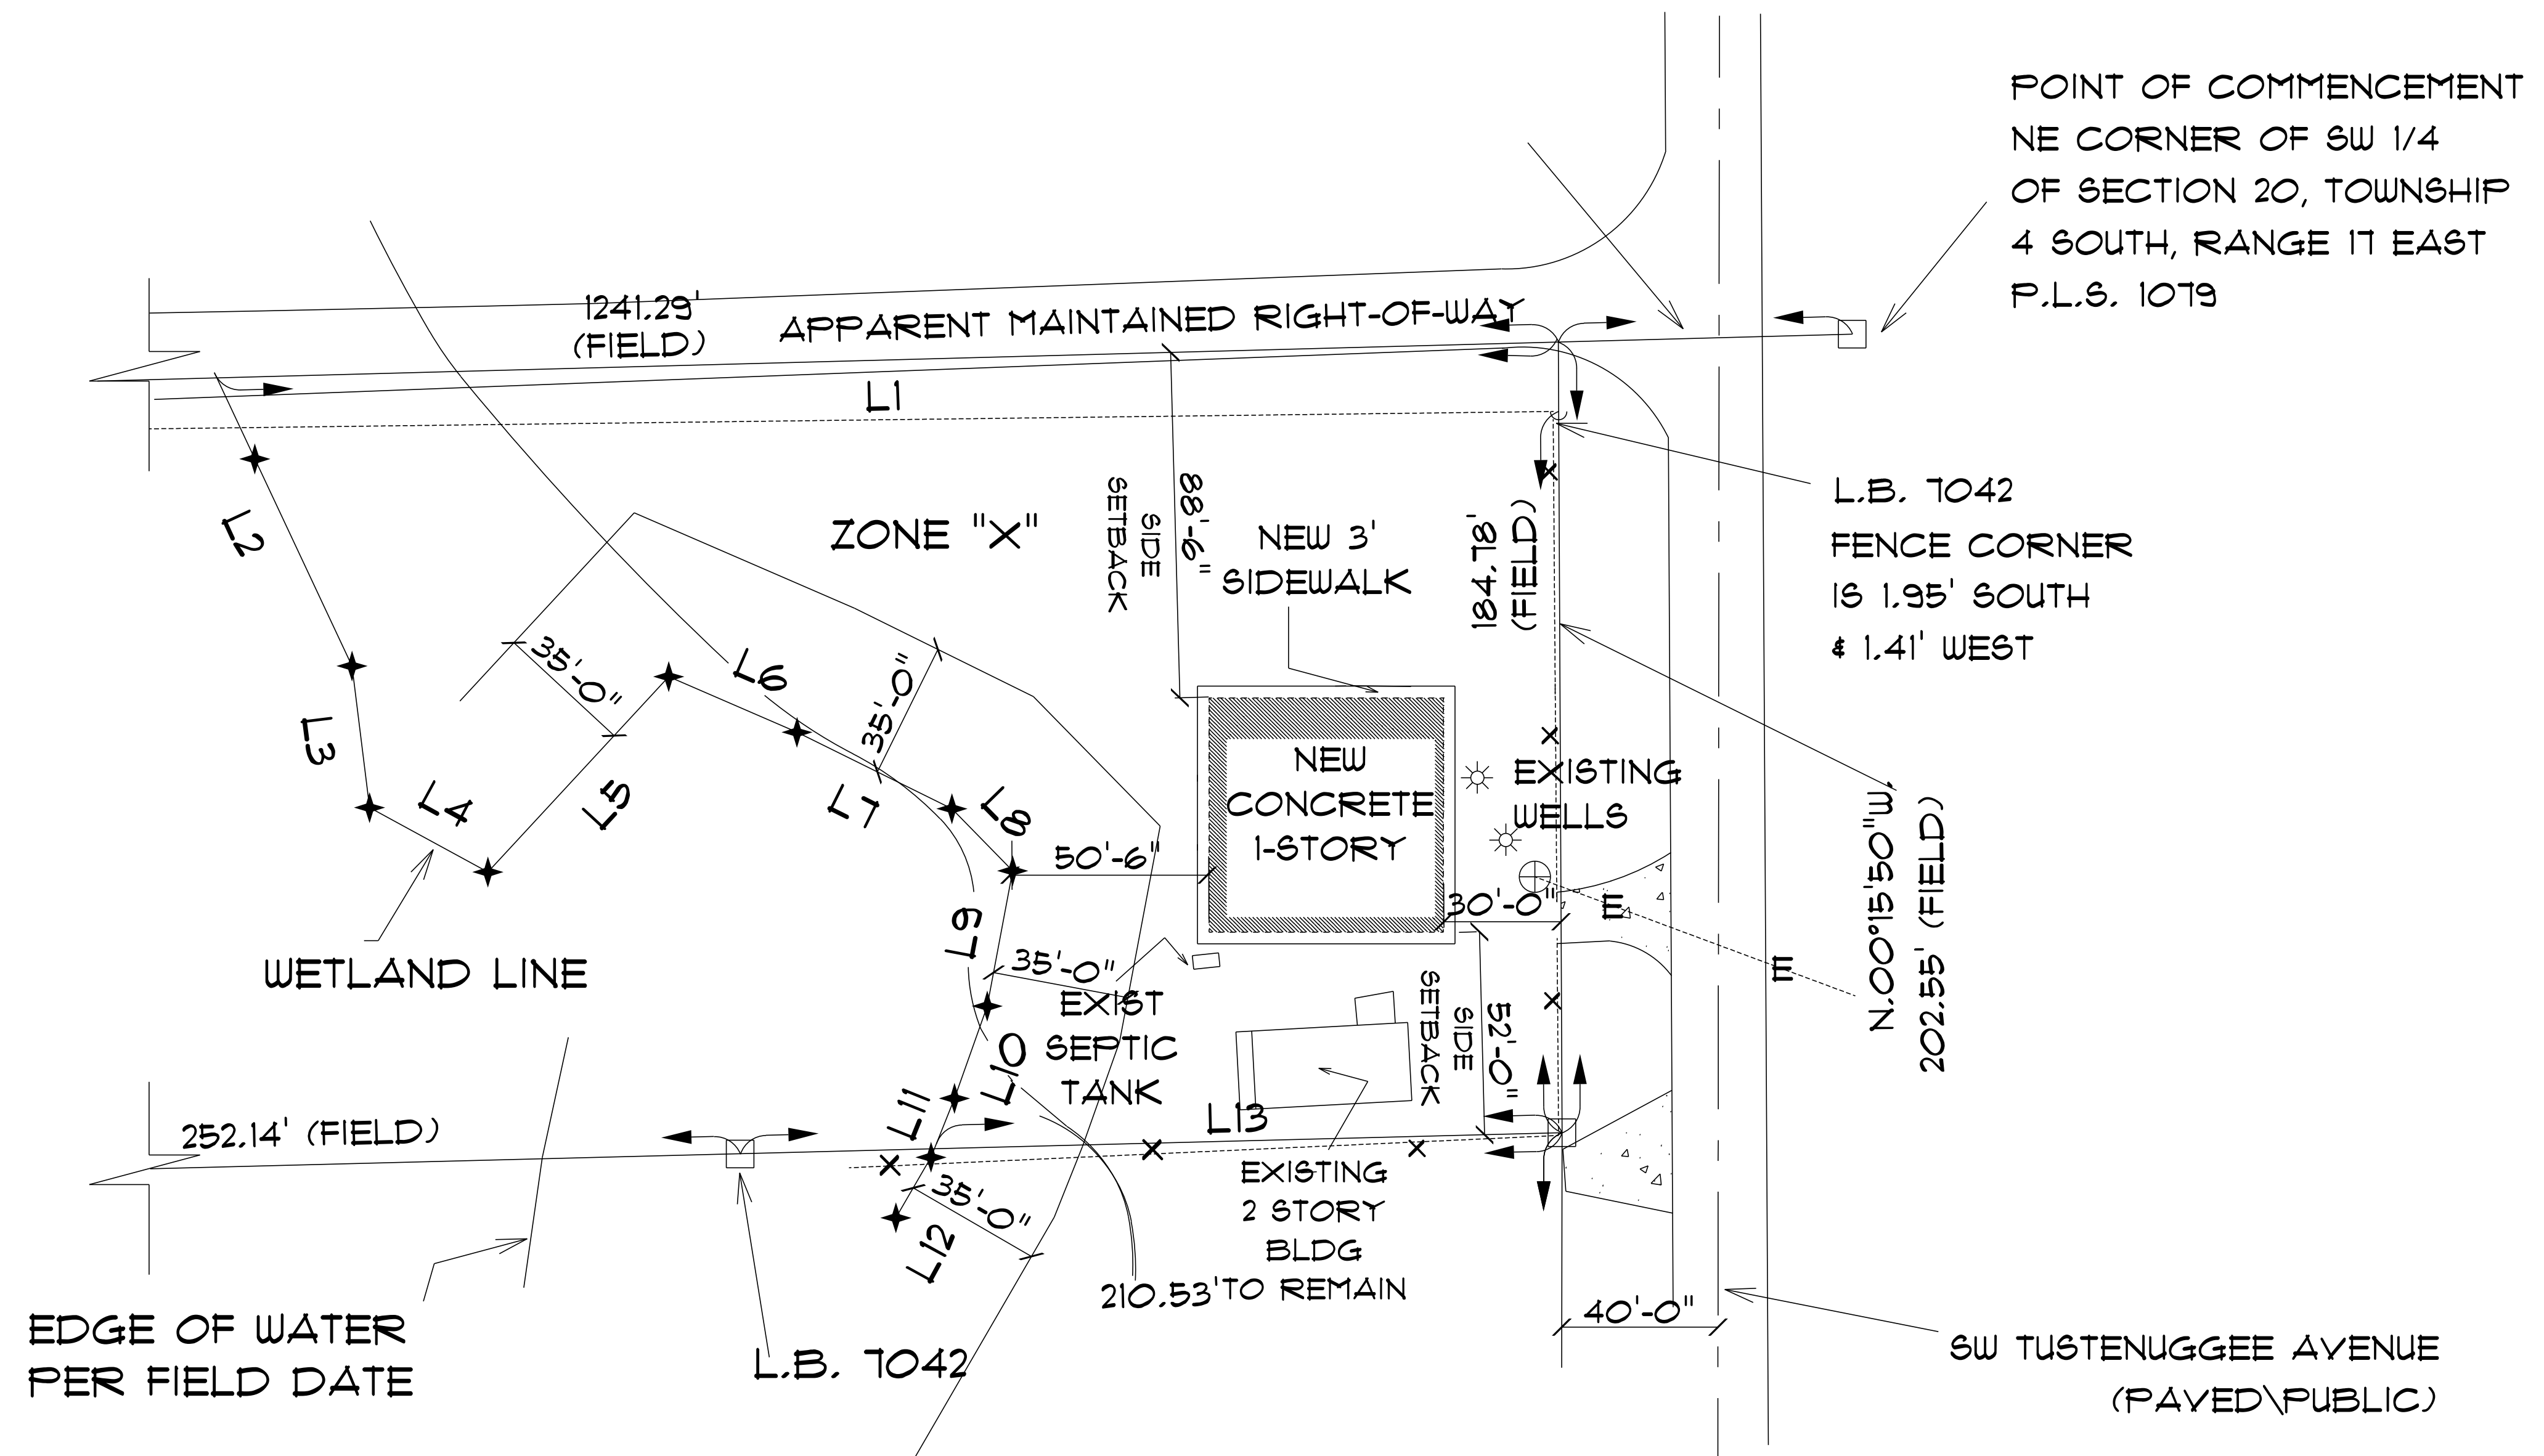

*** PROPOSED ***
*** SITE PLAN ***

SCALE: 1" = 30'

NEW RESIDENCE
 for
DANIEL JACKSON

6W TUSTENUGGEE AVENUE
 LAKE CITY, FLORIDA

Teena M. Ruffo
 2925 SW SR 47
 Lake City, Florida, 32025
 Cell: (386) 867-1191
 Email: teenaruffo@gmail.com

PRINTED DATE:
 Monday, December 19, 2022


DRAWN BY: Teena M. Ruffo CHECKED BY:

BUILDING CONTRACTOR:
 ZECHER CONSTRUCTION

FINALS DATE:

JOB NUMBER:

DRAWING NUMBER:
A-1
 OF 1 SHEETS

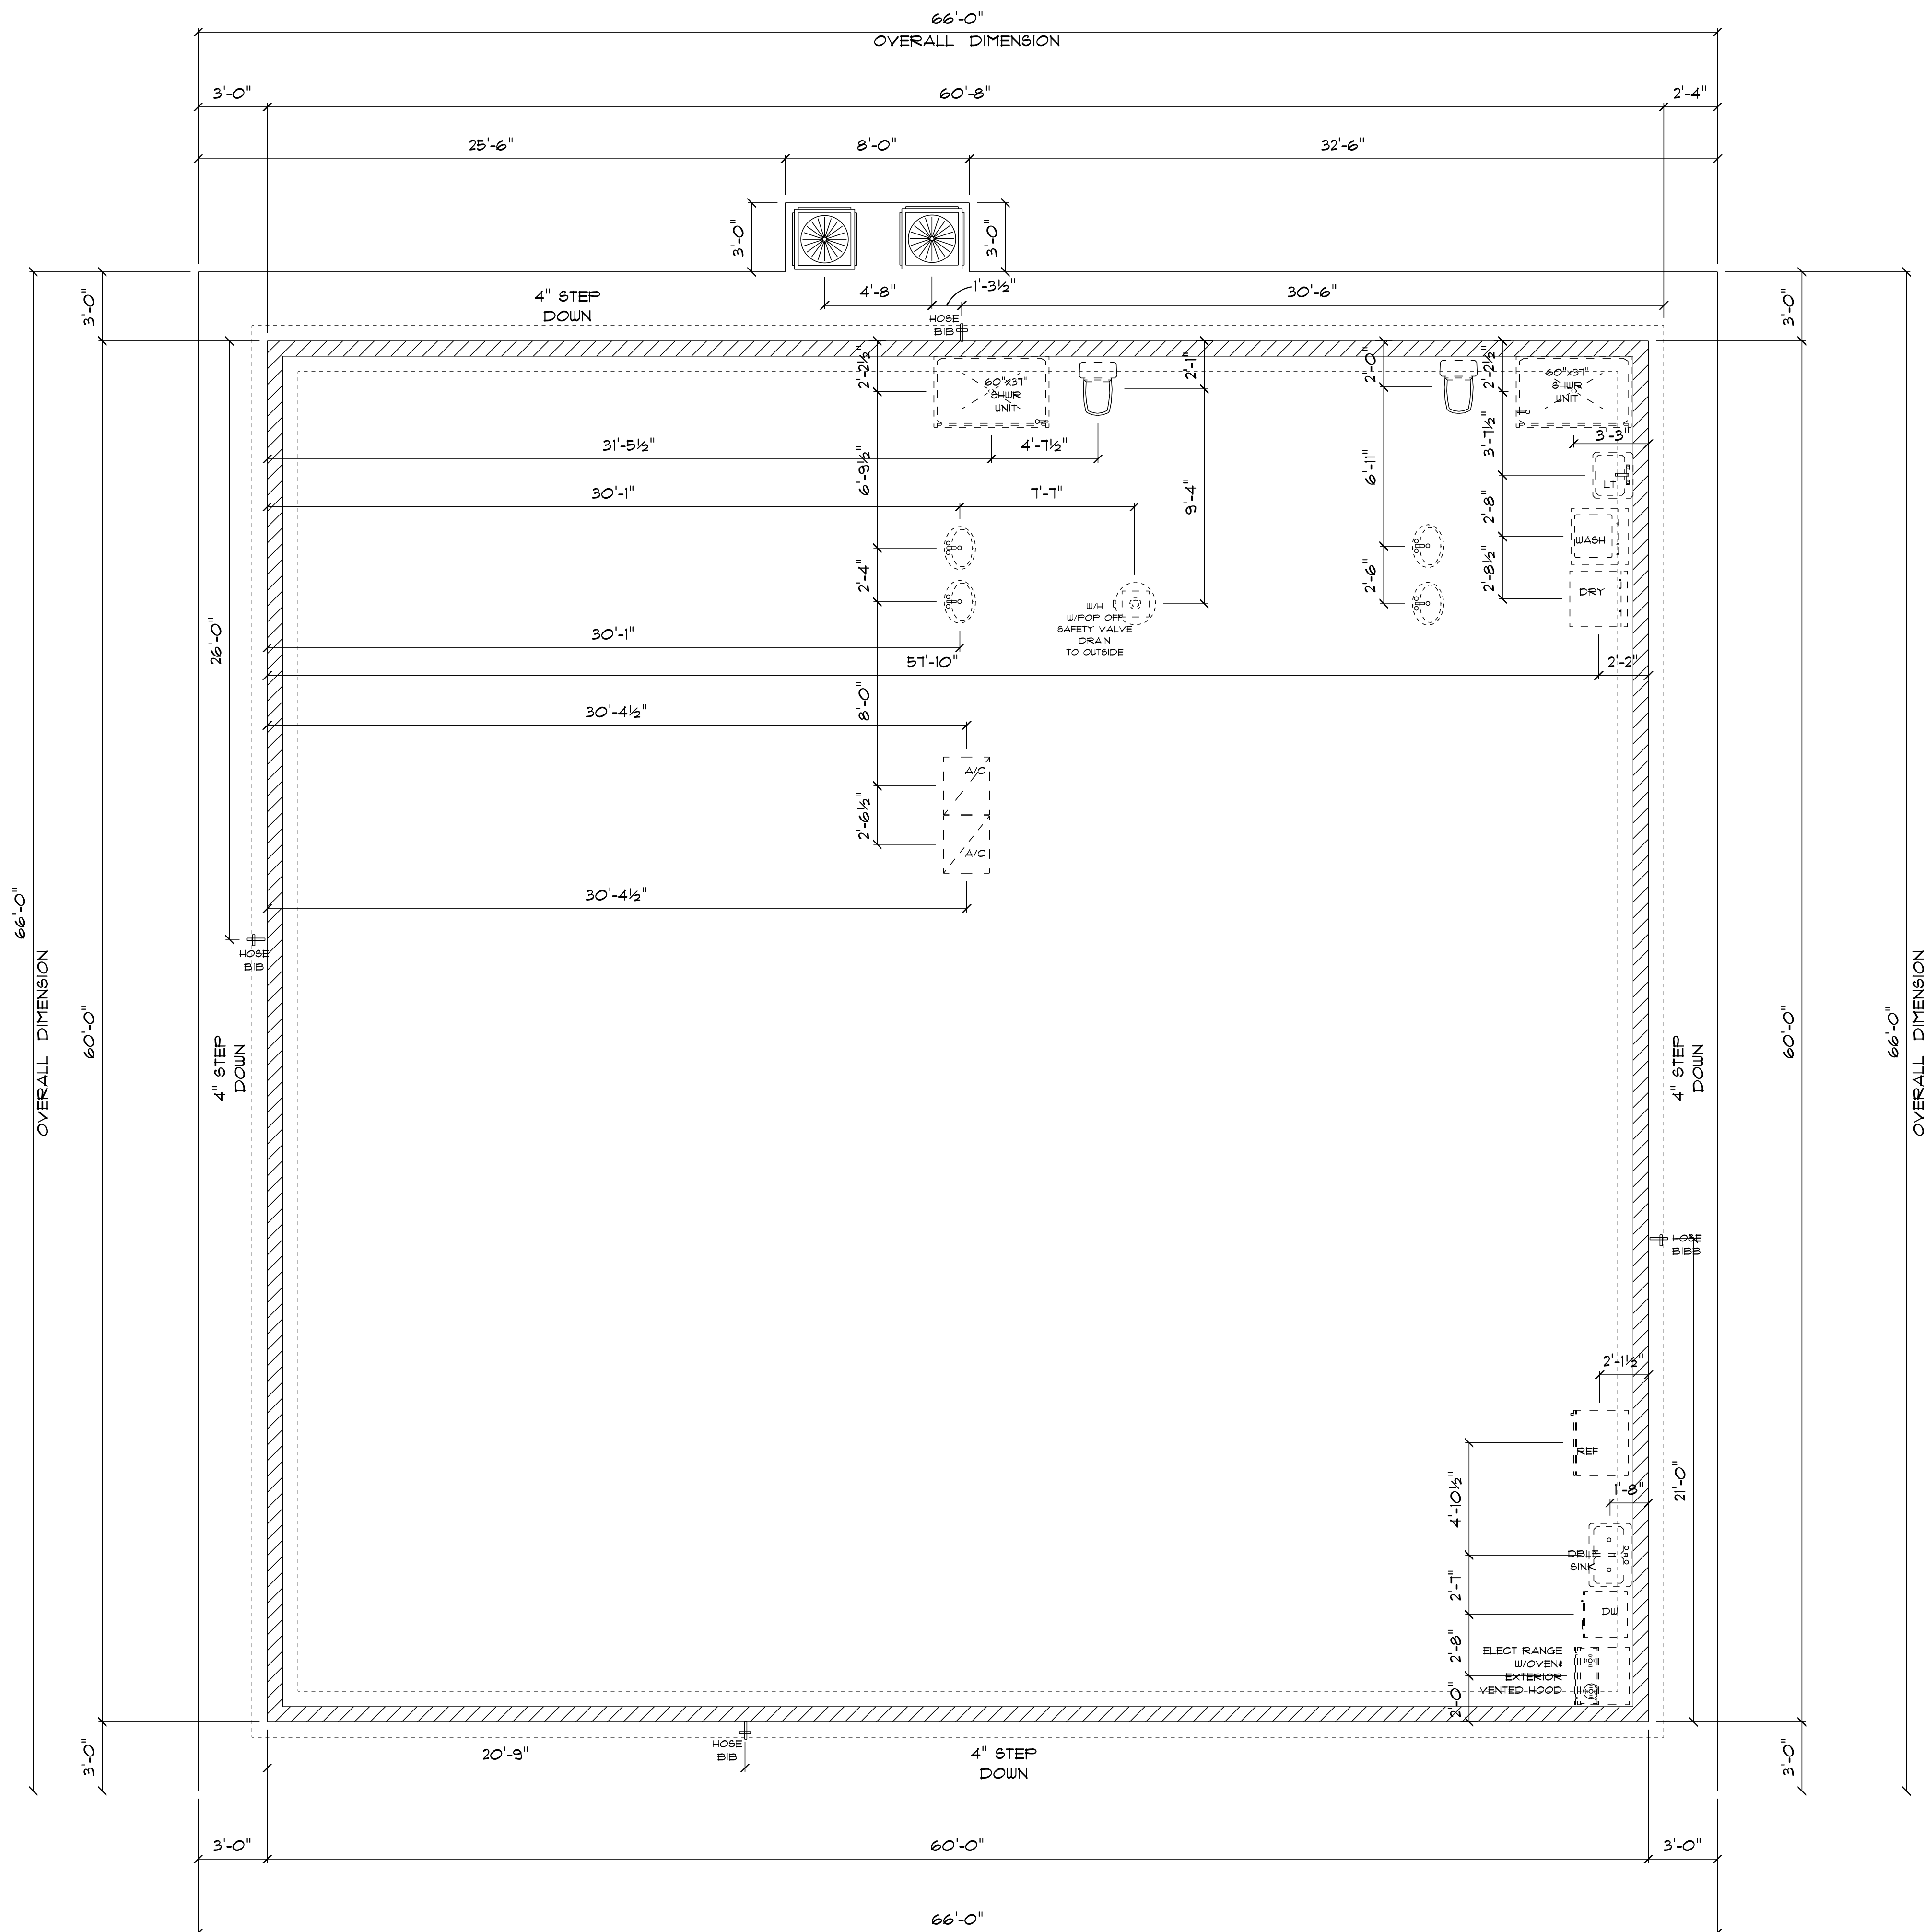

* PLUMBING/ FOUNDATION PLAN *

SCALE : 1/4" = 1'-0"

- IMPORTANT NOTES:**
1. IT IS THE BUILDERS RESPONSIBILITY TO VERIFY ALL GEOMETRY AND DIMENSIONS BEFORE ORDERING ANY MATERIALS OR BEGINNING CONSTRUCTION.
 2. THESE PLANS ARE FOR LAYOUT AND DESIGN PURPOSES ONLY ALL STRUCTURAL NOTES AND DETAILS TO BE PROVIDED BY AN ENGINEER.
 3. ALL CONCRETE BLOCK WALLS INTERIOR AND EXTERIOR ARE POURED SOLID.
 4. ALL INTERIOR AND EXTERIOR DOORS ARE TO BE FLUSH STEEL DOORS W/METAL JAMBS.
 5. ALL EXTERIOR BLOCK WALLS WILL HAVE 3/4" TUFF+ INSULATION W/FURING STRIPS OVER.

NEW RESIDENCE
for
DANIEL JACKSON

6W TUSTENUGGEE AVENUE
LAKE CITY, FLORIDA

Teena M. Ruffo
2925 6W SR 41
Lake City Florida, 32025
Cell: (386) 861 - 1191
Email: teenaruffo@gmail.com

PRINTED DATE:
Monday, December 19, 2022


DRAWN BY: Teena M. Ruffo CHECKED BY:

BUILDING CONTRACTOR:
ZECHER CONSTRUCTION


FINAL DATE:

JOB NUMBER:

DRAWING NUMBER:
A-2
OF 1 SHEETS

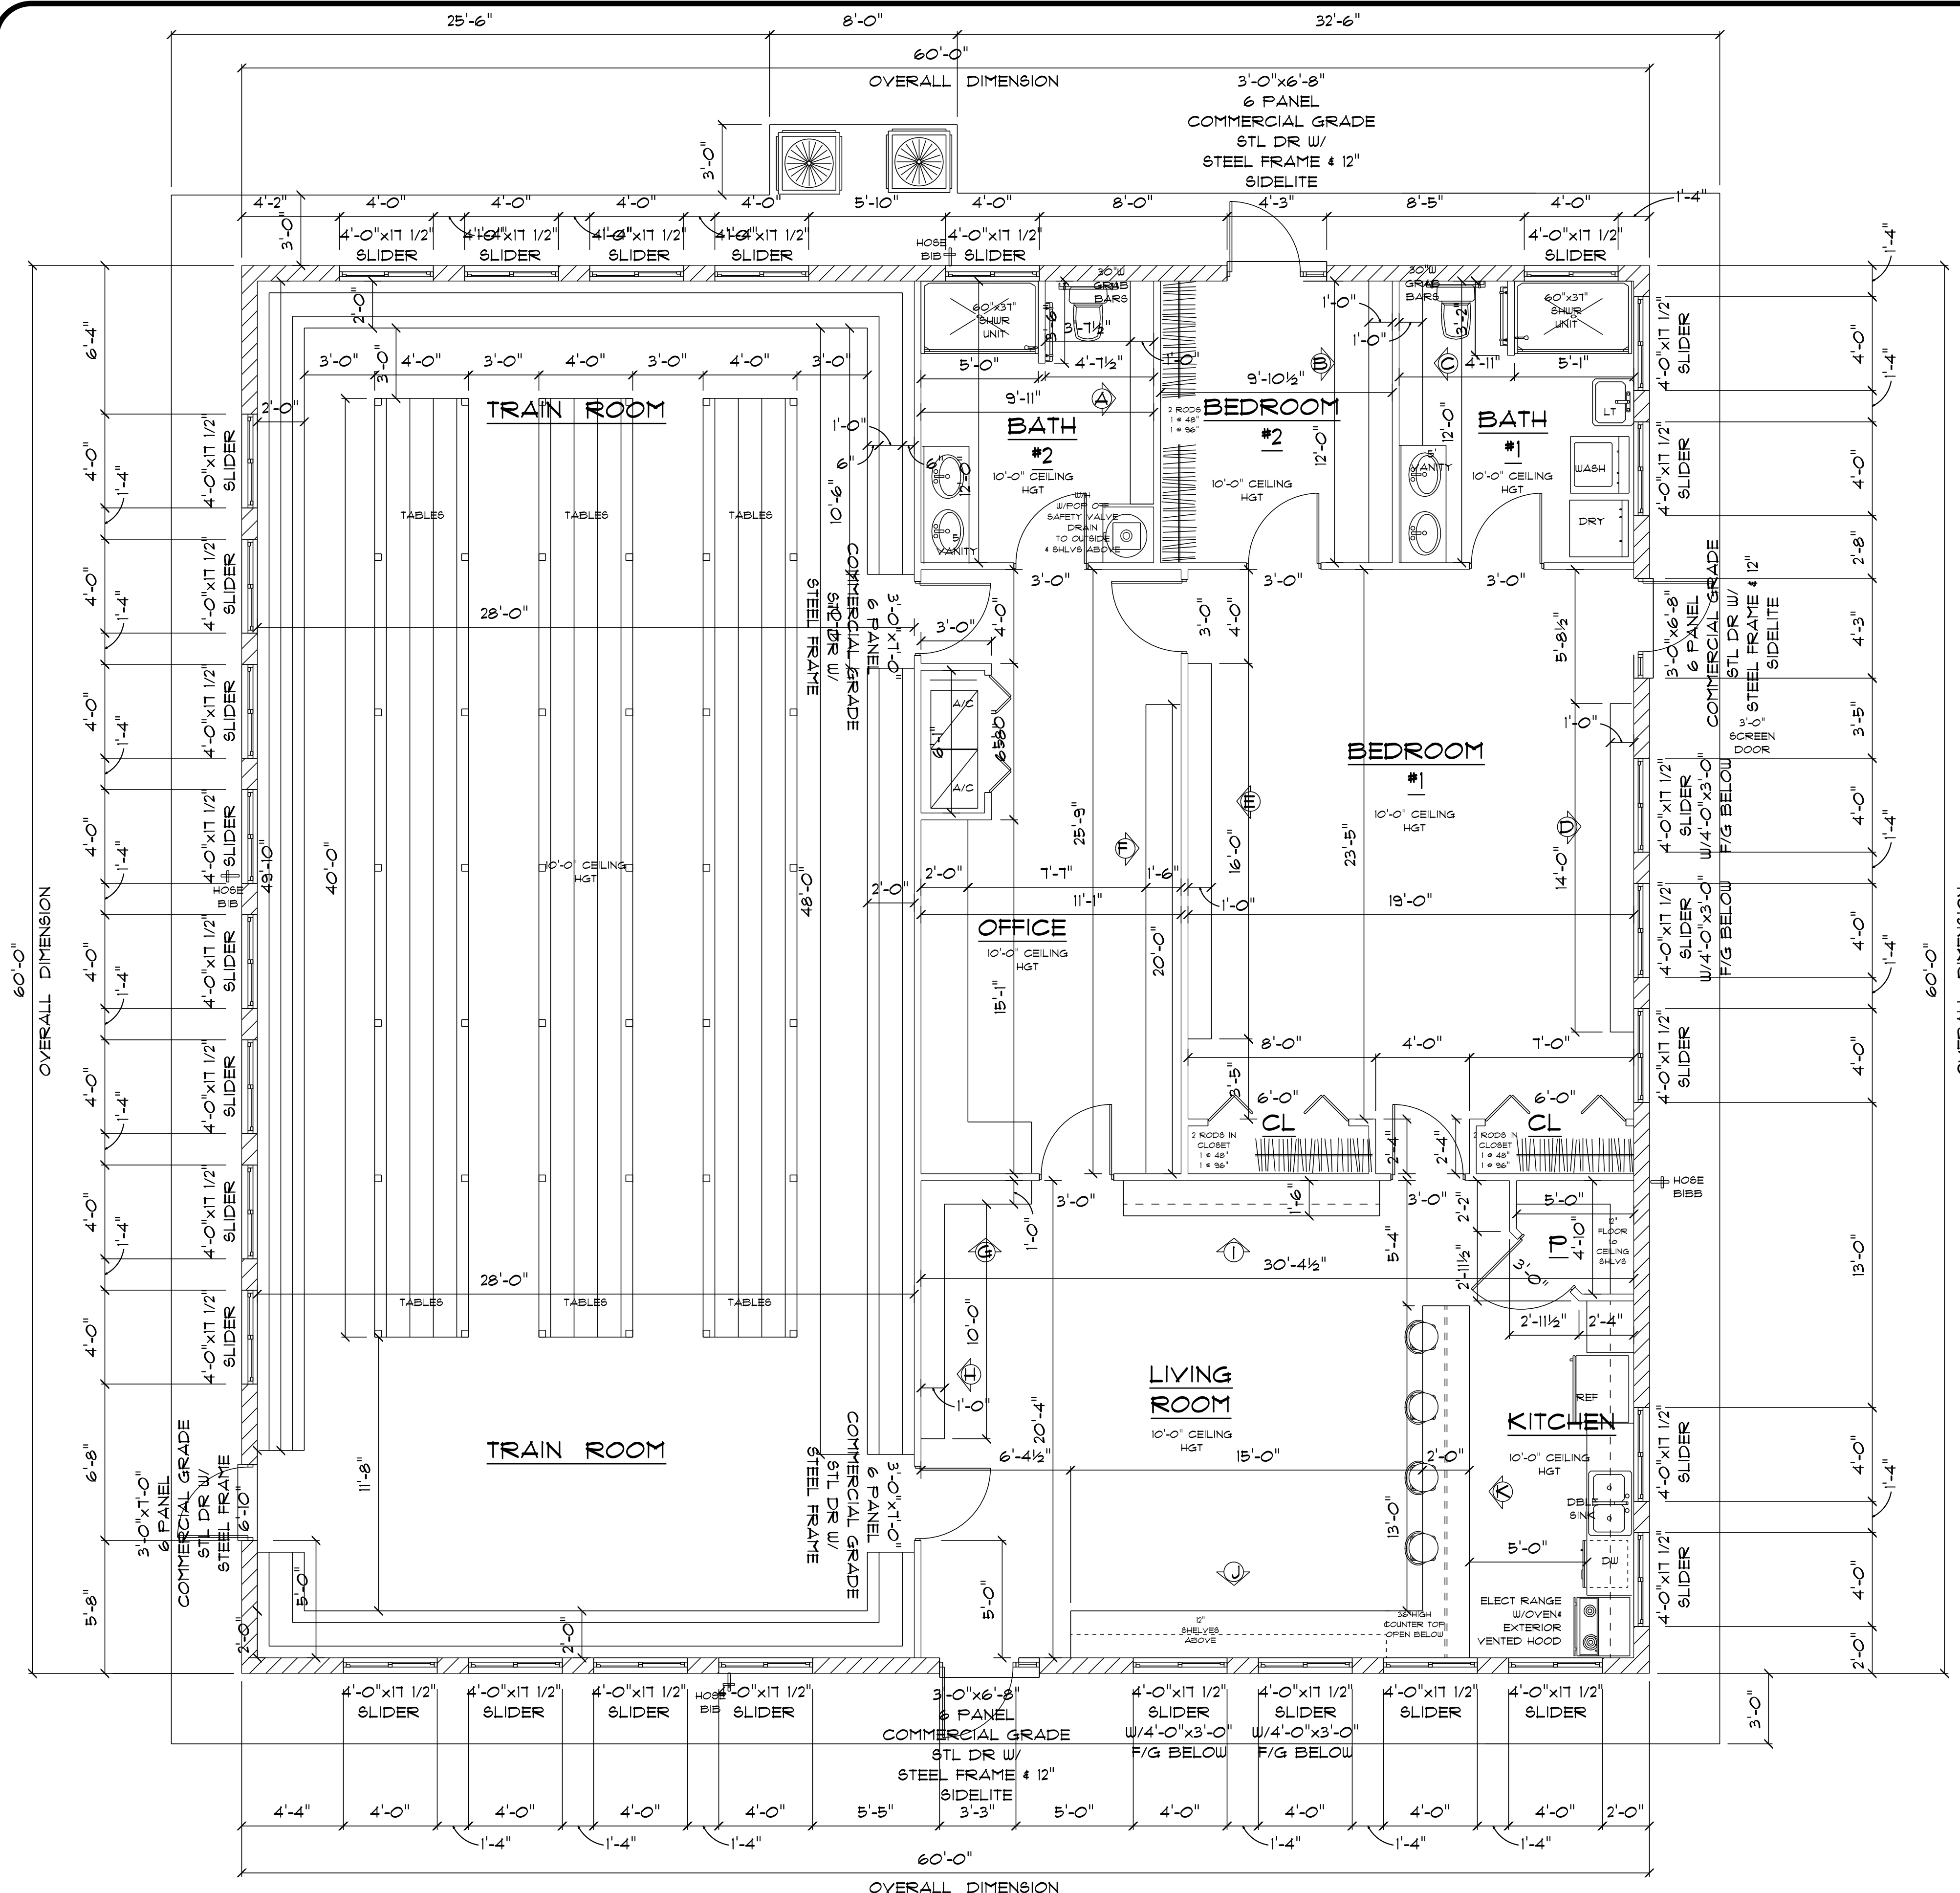


*** FLOOR PLAN ***
 SCALE : 1/4" = 1'-0"

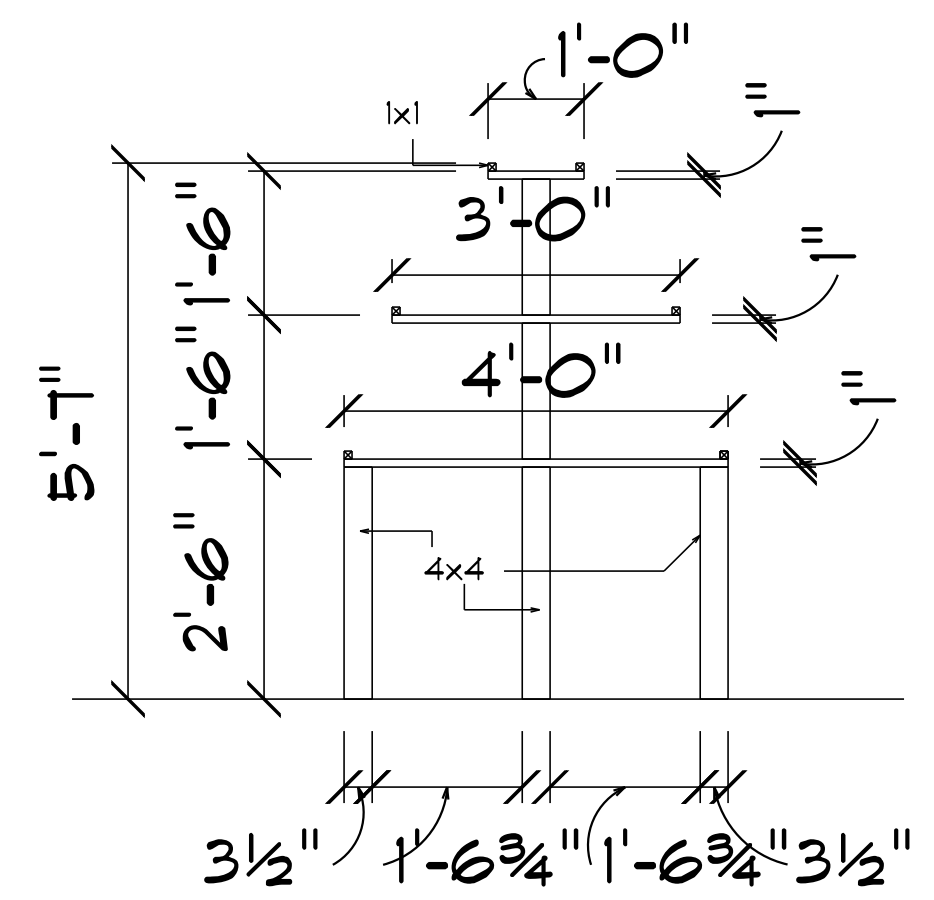

*** CENTER ISLE TRAIN TABLES ***
 SCALE : 1/2" = 1'-0"

NOTE:
 PERSON MUST BE ABLE TO STAND ON THE FIRST 4'-0" WIDE TABLE

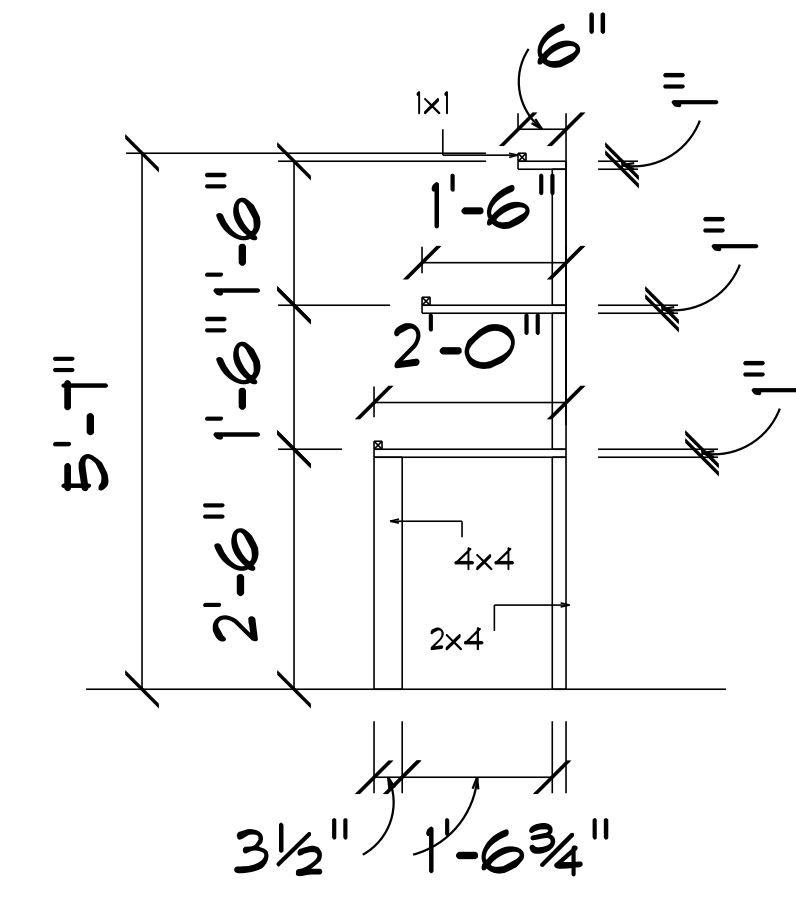

*** WALL TRAIN TABLES ***
 SCALE : 1/2" = 1'-0"

- IMPORTANT NOTES:**
- IT IS THE BUILDERS RESPONSIBILITY TO VERIFY ALL GEOMETRY AND DIMENSIONS BEFORE ORDERING ANY MATERIALS OR BEGINNING CONSTRUCTION.
 - THESE PLANS ARE FOR LAYOUT AND DESIGN PURPOSES ONLY ALL STRUCTURAL NOTES AND DETAILS TO BE PROVIDED BY AN ENGINEER.
 - ALL CONCRETE BLOCK WALLS INTERIOR AND EXTERIOR ARE POURED SOLID.
 - ALL INTERIOR AND EXTERIOR DOORS ARE TO BE FLUSH STEEL DOORS W/METAL JAMBS.
 - ALL EXTERIOR BLOCK WALLS WILL HAVE 3/4" TUFF-R INSULATION W/FURING STRIPS OVER.

A/C LIVING AREA	=	1860 S.F.
A/C TRAIN ROOM	=	1740 S.F.
TOTAL AREA UNDER ROOF	=	3600 S.F.

NEW RESIDENCE
 for
DANIEL JACKSON

6W TUSTENUGGEE AVENUE
 LAKE CITY, FLORIDA

Teena M. Ruffo
 2925 6W SR 41
 Lake City Florida, 32025
 Cell: (386) 861-1191
 Email: teenaruffo@gmail.com

PRINTED DATE:
 Monday, December 19, 2022


DRAWN BY: Teena M. Ruffo CHECKED BY:

BUILDING CONTRACTOR:
 ZECHER CONSTRUCTION

FINALS DATE:

JOB NUMBER:

DRAWING NUMBER:
A-3
 OF 1 SHEETS

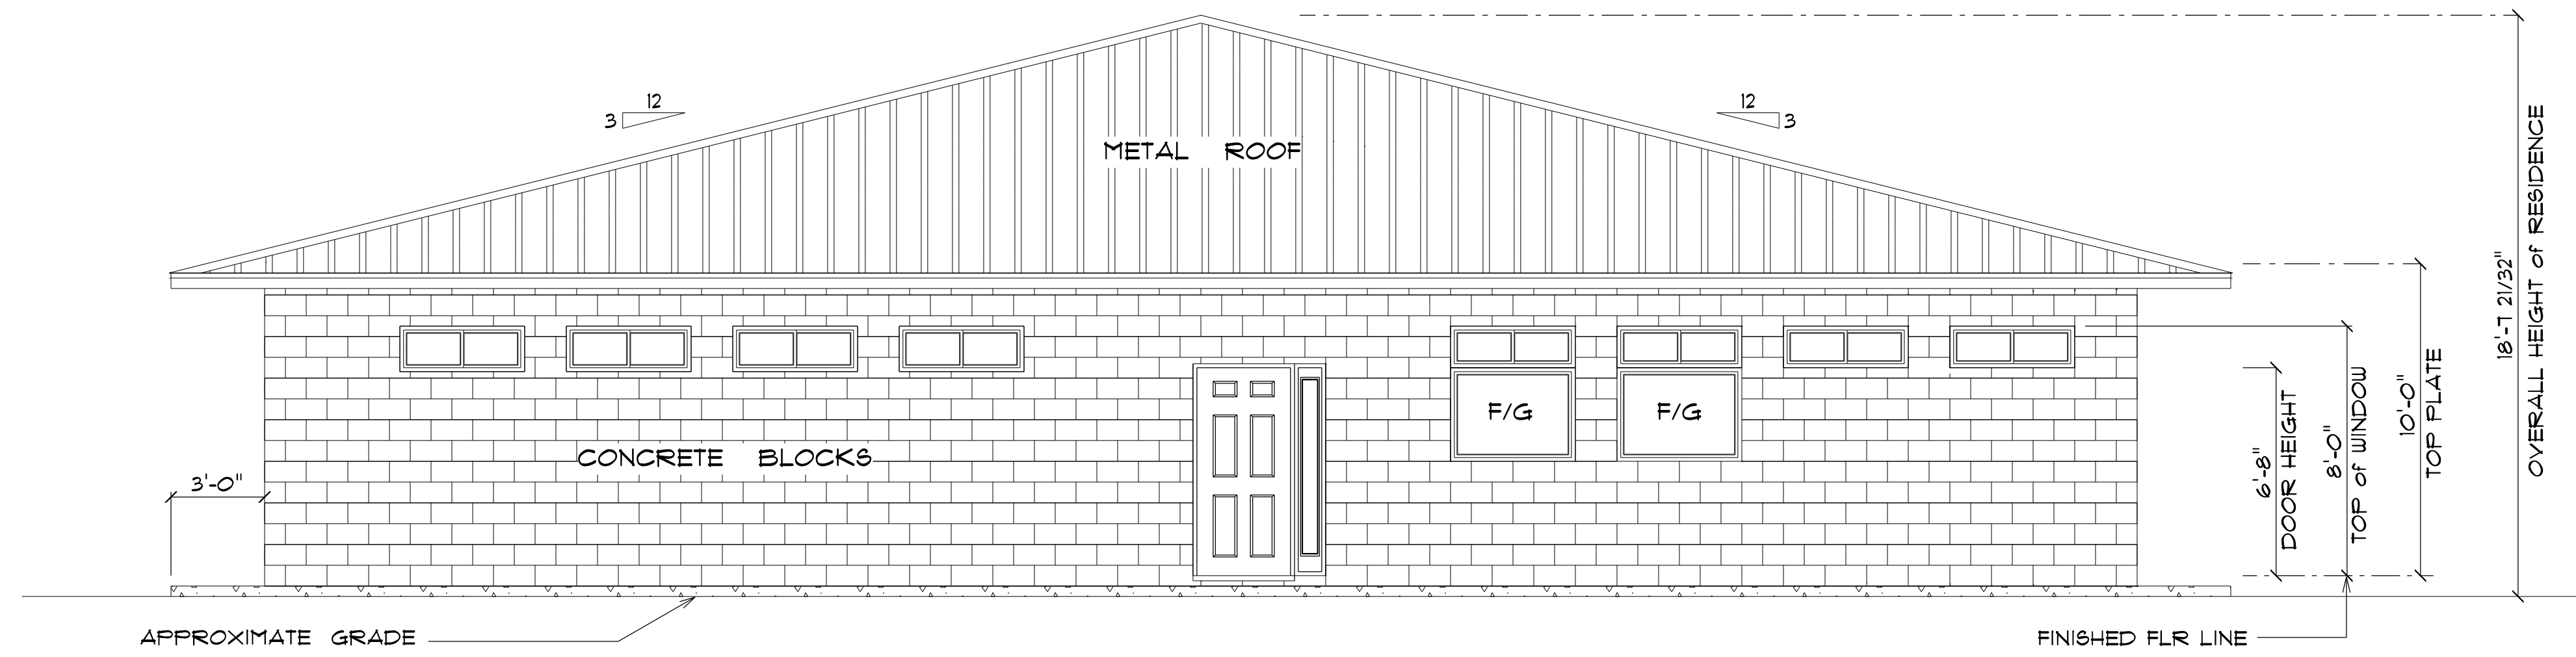


NOTE:
3' PRO-PANEL/GULF RIB STYLE ROOFING
EXPOSED SCREWS 26 GAUGE

*** FRONT ELEVATION ***

SCALE : 1/4" = 1'-0"

NOTE :
36" OVERHANG ON ALL EAVES
3/12 PITCH

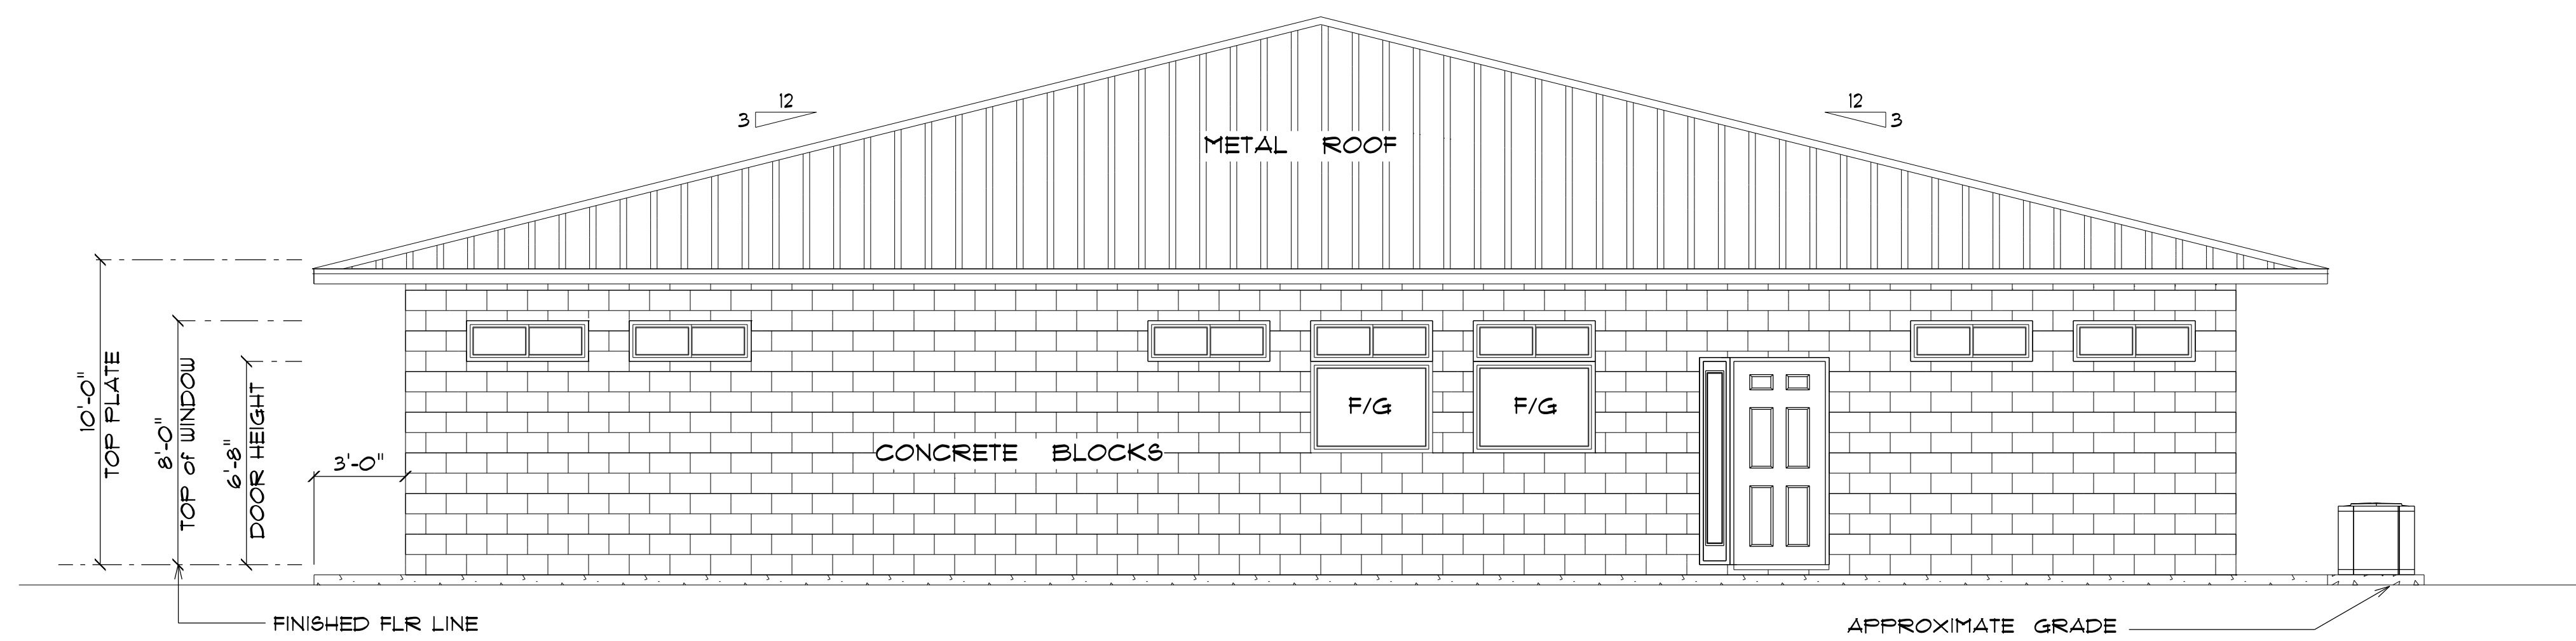

*** RIGHT ELEVATION ***

SCALE : 1/4" = 1'-0"

NEW
RESIDENCE
for
DANIEL JACKSON

6W TUSTENUGGEE AVENUE
LAKE CITY, FLORIDA

Teena M. Ruffo
2925 SW SR 41
Lake City Florida, 32025
Cell: (386) 867-1191
Email: teenaruffo@gmail.com

PRINTED DATE:
Monday, December 19, 2022

DRAWN BY: Teena M. Ruffo

CHECKED BY:

BUILDING CONTRACTOR
ZECHER CONSTRUCTION


FINALS DATE:

JOB NUMBER:

DRAWING NUMBER


A-4

OF 1 SHEETS

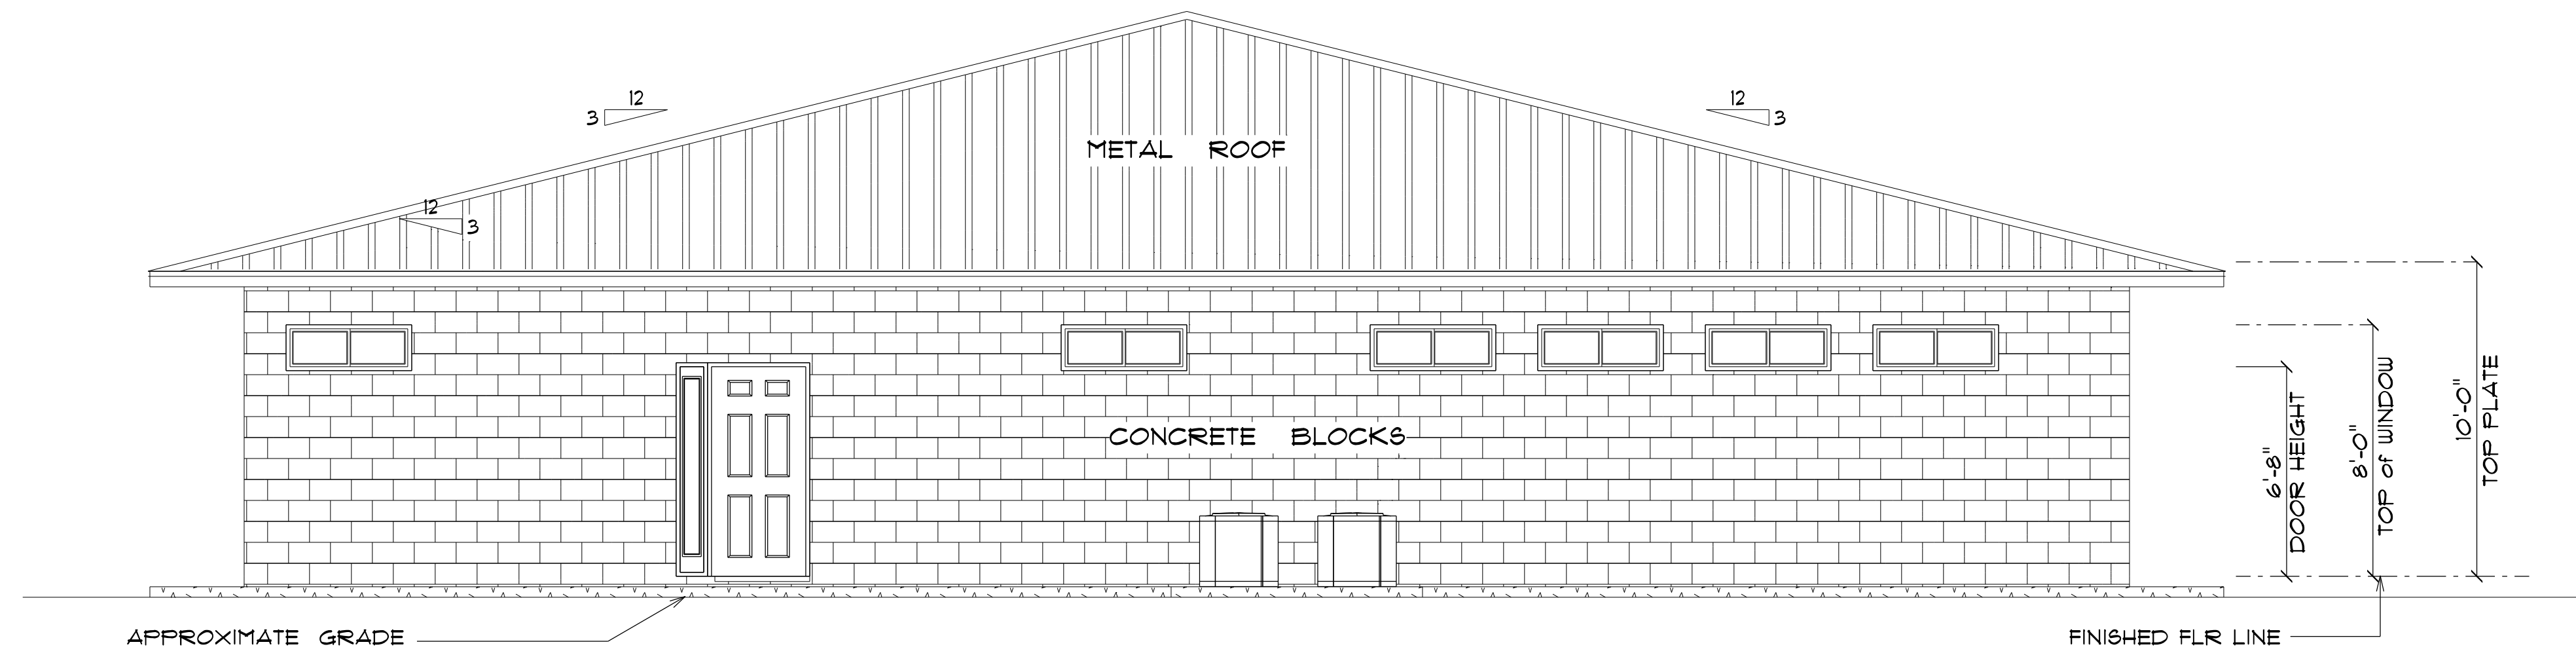

*** REAR ELEVATION ***

SCALE : 1/4" = 1'-0"

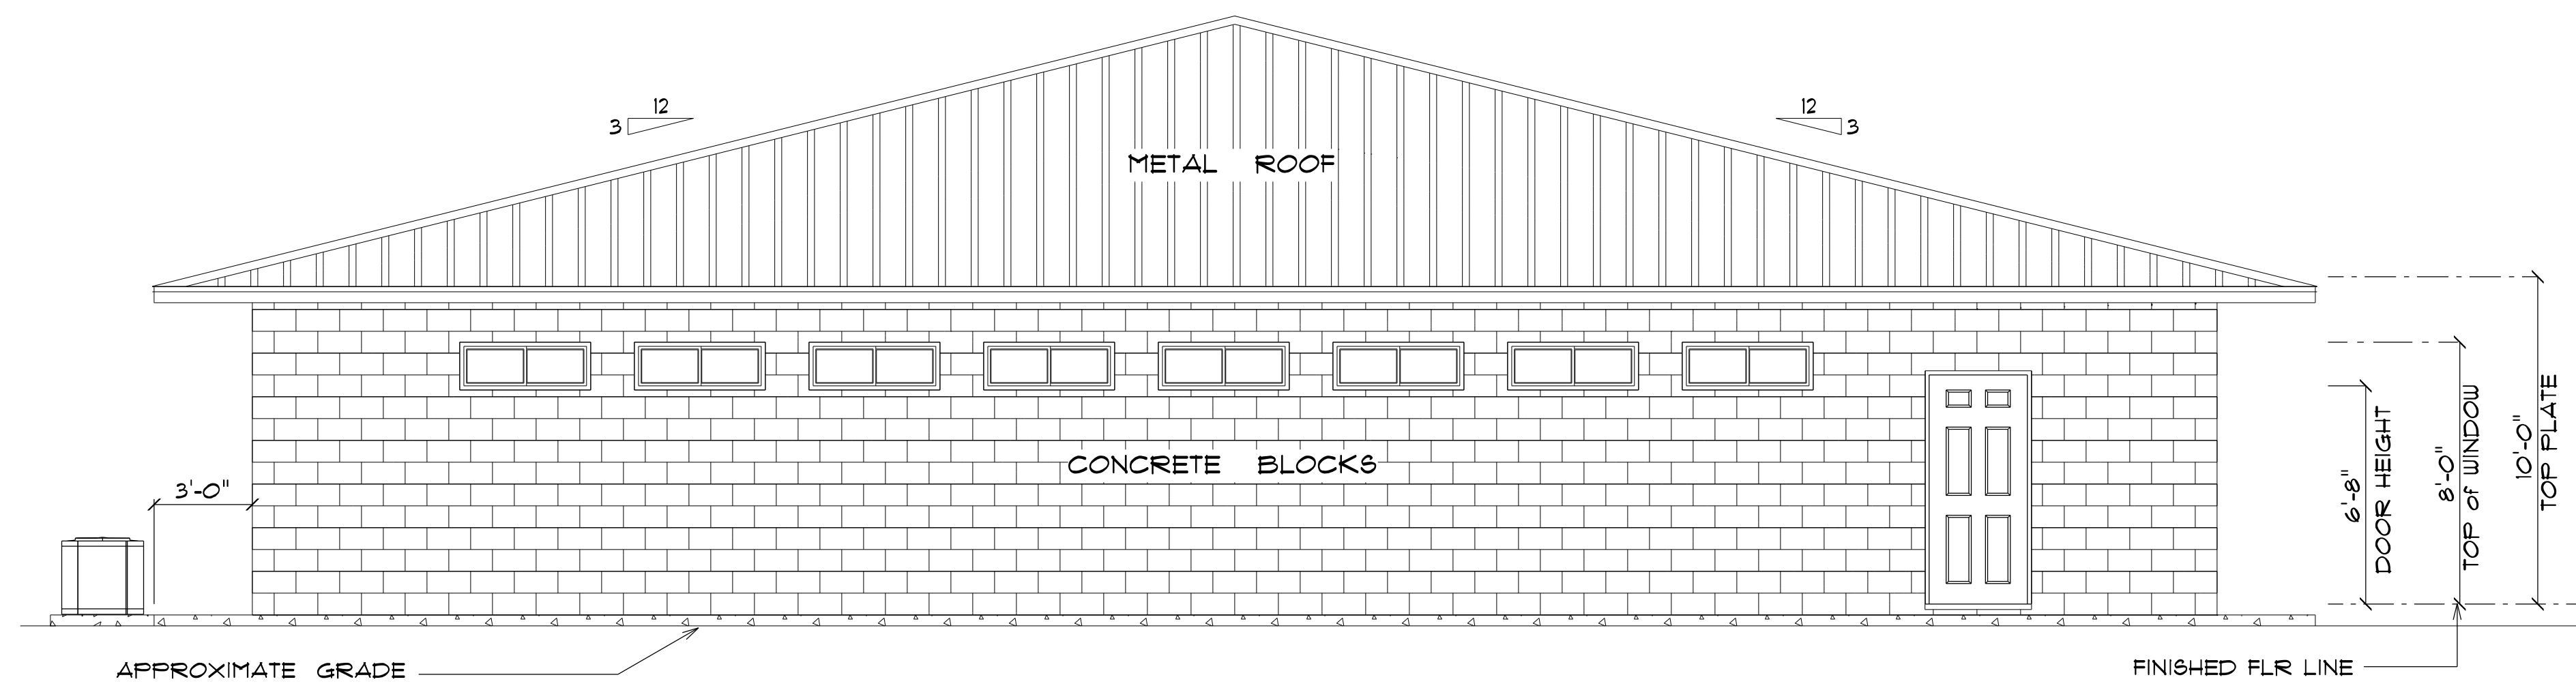

*** LEFT ELEVATION ***

SCALE : 1/4" = 1'-0"

NEW
RESIDENCE
for
DANIEL JACKSON

6W TUSTENUGGEE AVENUE
LAKE CITY FLORIDA

Teena M. Ruffo
2925 SW SR 41
Lake City Florida, 32025
Cell: (386) 867-1191
Email: teenaruffo@gmail.com

PRINTED DATE:
Monday, December 19, 2022

DRAWN BY: Teena M. Ruffo
CHECKED BY:

BUILDING CONTRACTOR:
ZECHER CONSTRUCTION


FINALS DATE:

JOB NUMBER:

DRAWING NUMBER

A-5

OF 1 SHEETS

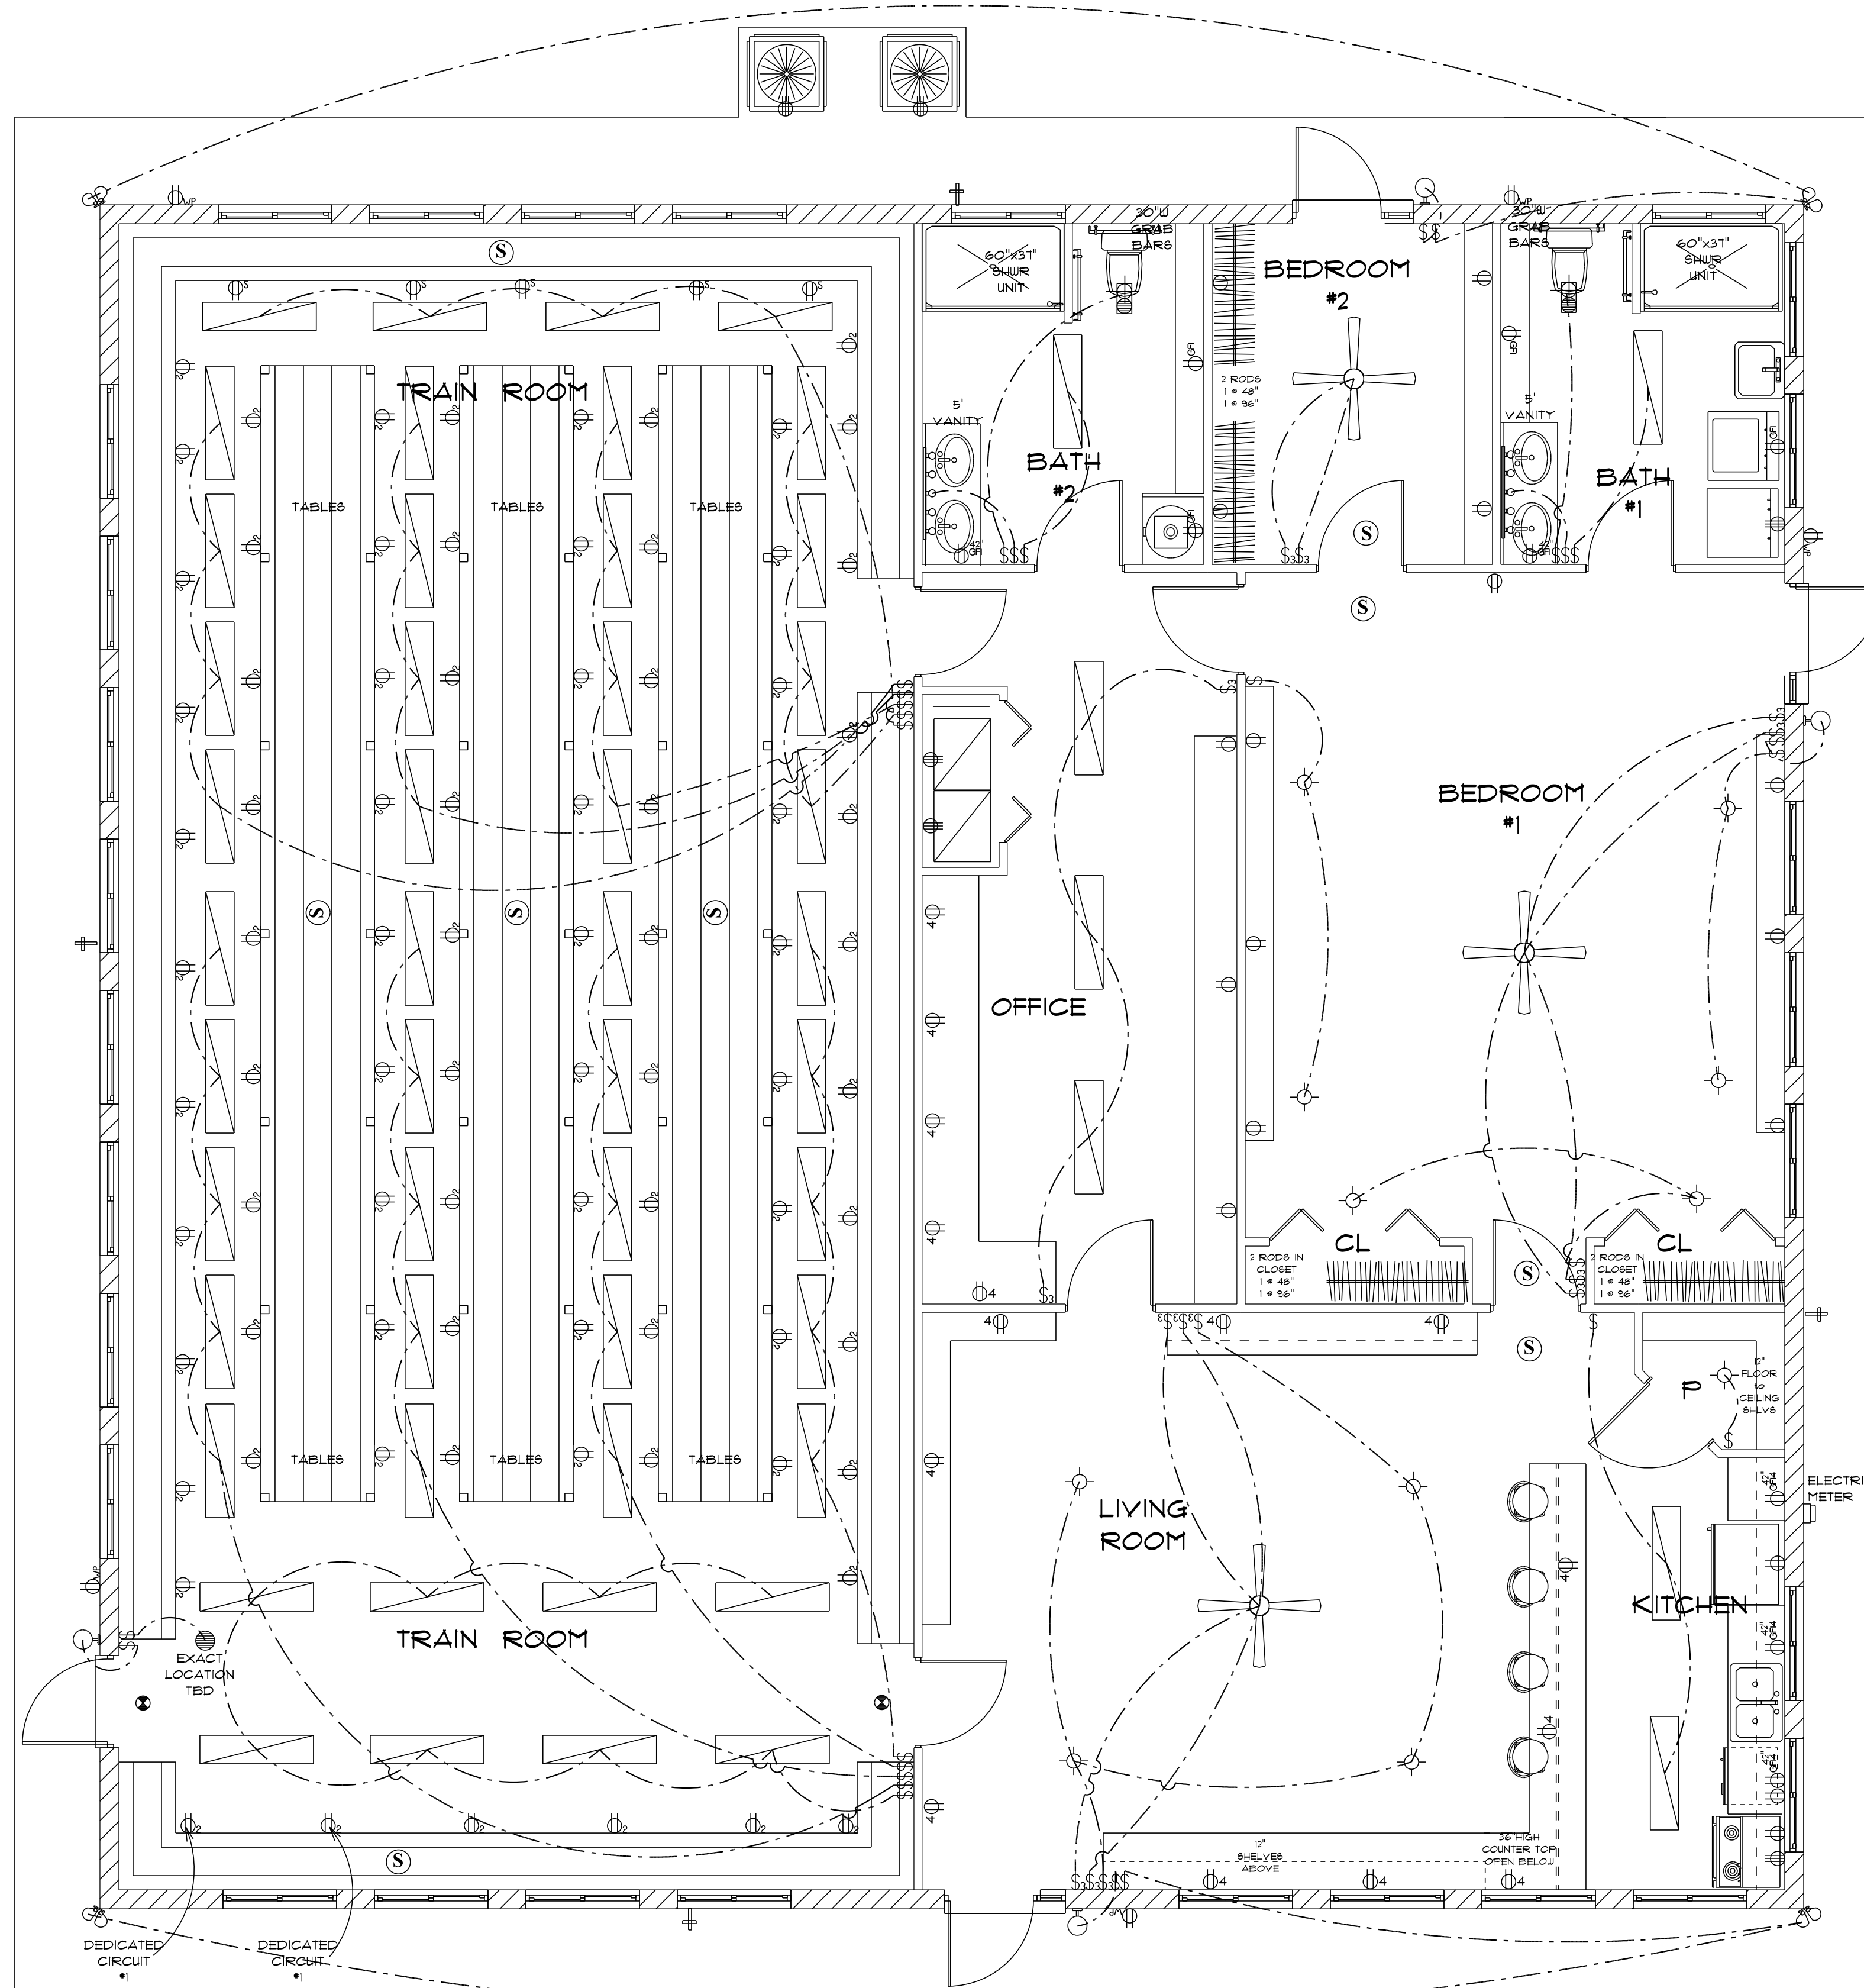

ELECTRICAL LEGEND		
ELECTRICAL	COUNT	SYMBOL
ceiling fan globe O1	3	
fluorescent light 1 x 4	55	
exterior light IO	4	
spotlight double	4	
Smoke Detector	9	
exit	2	
exhaust fan	1	
light	11	
outlet	17	
outlet 220v	6	
outlet double	87	
outlet gfi	6	
outlet wp	5	
switch	28	
switch 3 way	14	
vent light combo	2	
vanity bar light O1	2	
GFI Outlet Quad	3	
Quad Outlet	15	

ELECTRICAL PLAN NOTES

- E-1 WIRE ALL APPLIANCES, HVAC UNITS AND OTHER EQUIPMENT PER MANUFACTURERS SPECIFICATIONS.
- E-2 ALL INSTALLATIONS SHALL BE PER NATIONAL ELECTRIC CODE.
- E-3 ALL SMOKE /CARBON MONOXIDE DETECTORS SHALL BE 120V W/BATTERY BACKUP OF THE PHOTOELECTRIC TYPE, AND SHALL BE INTERLOCKED TOGETHER. INSTALL INSIDE AND NEAR ALL BEDROOMS AS PER CODE.
- E-4 TELEPHONE, TELEVISION AND OTHER LOW VOLTAGE DEVICES OR OUTLETS SHALL BE AS PER THE OWNER'S DIRECTION AND IN ACCORDANCE WITH APPLICABLE SECTIONS OF NATIONAL ELCT. CODE LATEST EDITION.
- E-5 ELECTRICAL CONTRACTOR SHALL BE RESPONSIBLE FOR THE DESIGN AND SIZING OF ELECTRICAL SERVICE AND CIRCUITS.
- E-6 ENTRY OF SERVICE UNDERGROUND OR OVERHEAD) IS TO BE DETERMINED BY THE POWER COMPANY.
- E-7 ALL BEDROOM RECEPTALS ARE TO BE AFCI (ARC FAULT CIRCUIT INTERRUPT.)
- E-8 75% OF ALL PERMANENT LIGHTS TO BE ENERGY EFFICIENT.
- E-9 ALL OUTLETS TO BE 42" A.F.F.


*** ELECTRIC PLAN ***
SCALE : 1/4" = 1'-0"

IMPORTANT NOTE:
EXACT HEIGHT & LOCATION
OF OUTLETS IN TRAIN
ROOM TBD BY OWNER

NEW RESIDENCE
for
DANIEL JACKSON
6W TUSTENUGGEE AVENUE
LAKE CITY, FLORIDA


Teena M. Ruffo
2925 SW SR 41
Lake City, Florida, 32025
Cell: (386) 861 - 1191
Email: teenaruffo@gmail.com

PRINTED DATE: Monday, December 19, 2022	
DRAWN BY: Teena M. Ruffo	CHECKED BY:
BUILDING CONTRACTOR: ZECHER CONSTRUCTION	
FINAL DATE:	
JOB NUMBER:	
DRAWING NUMBER A-6	
OF 1 SHEETS	

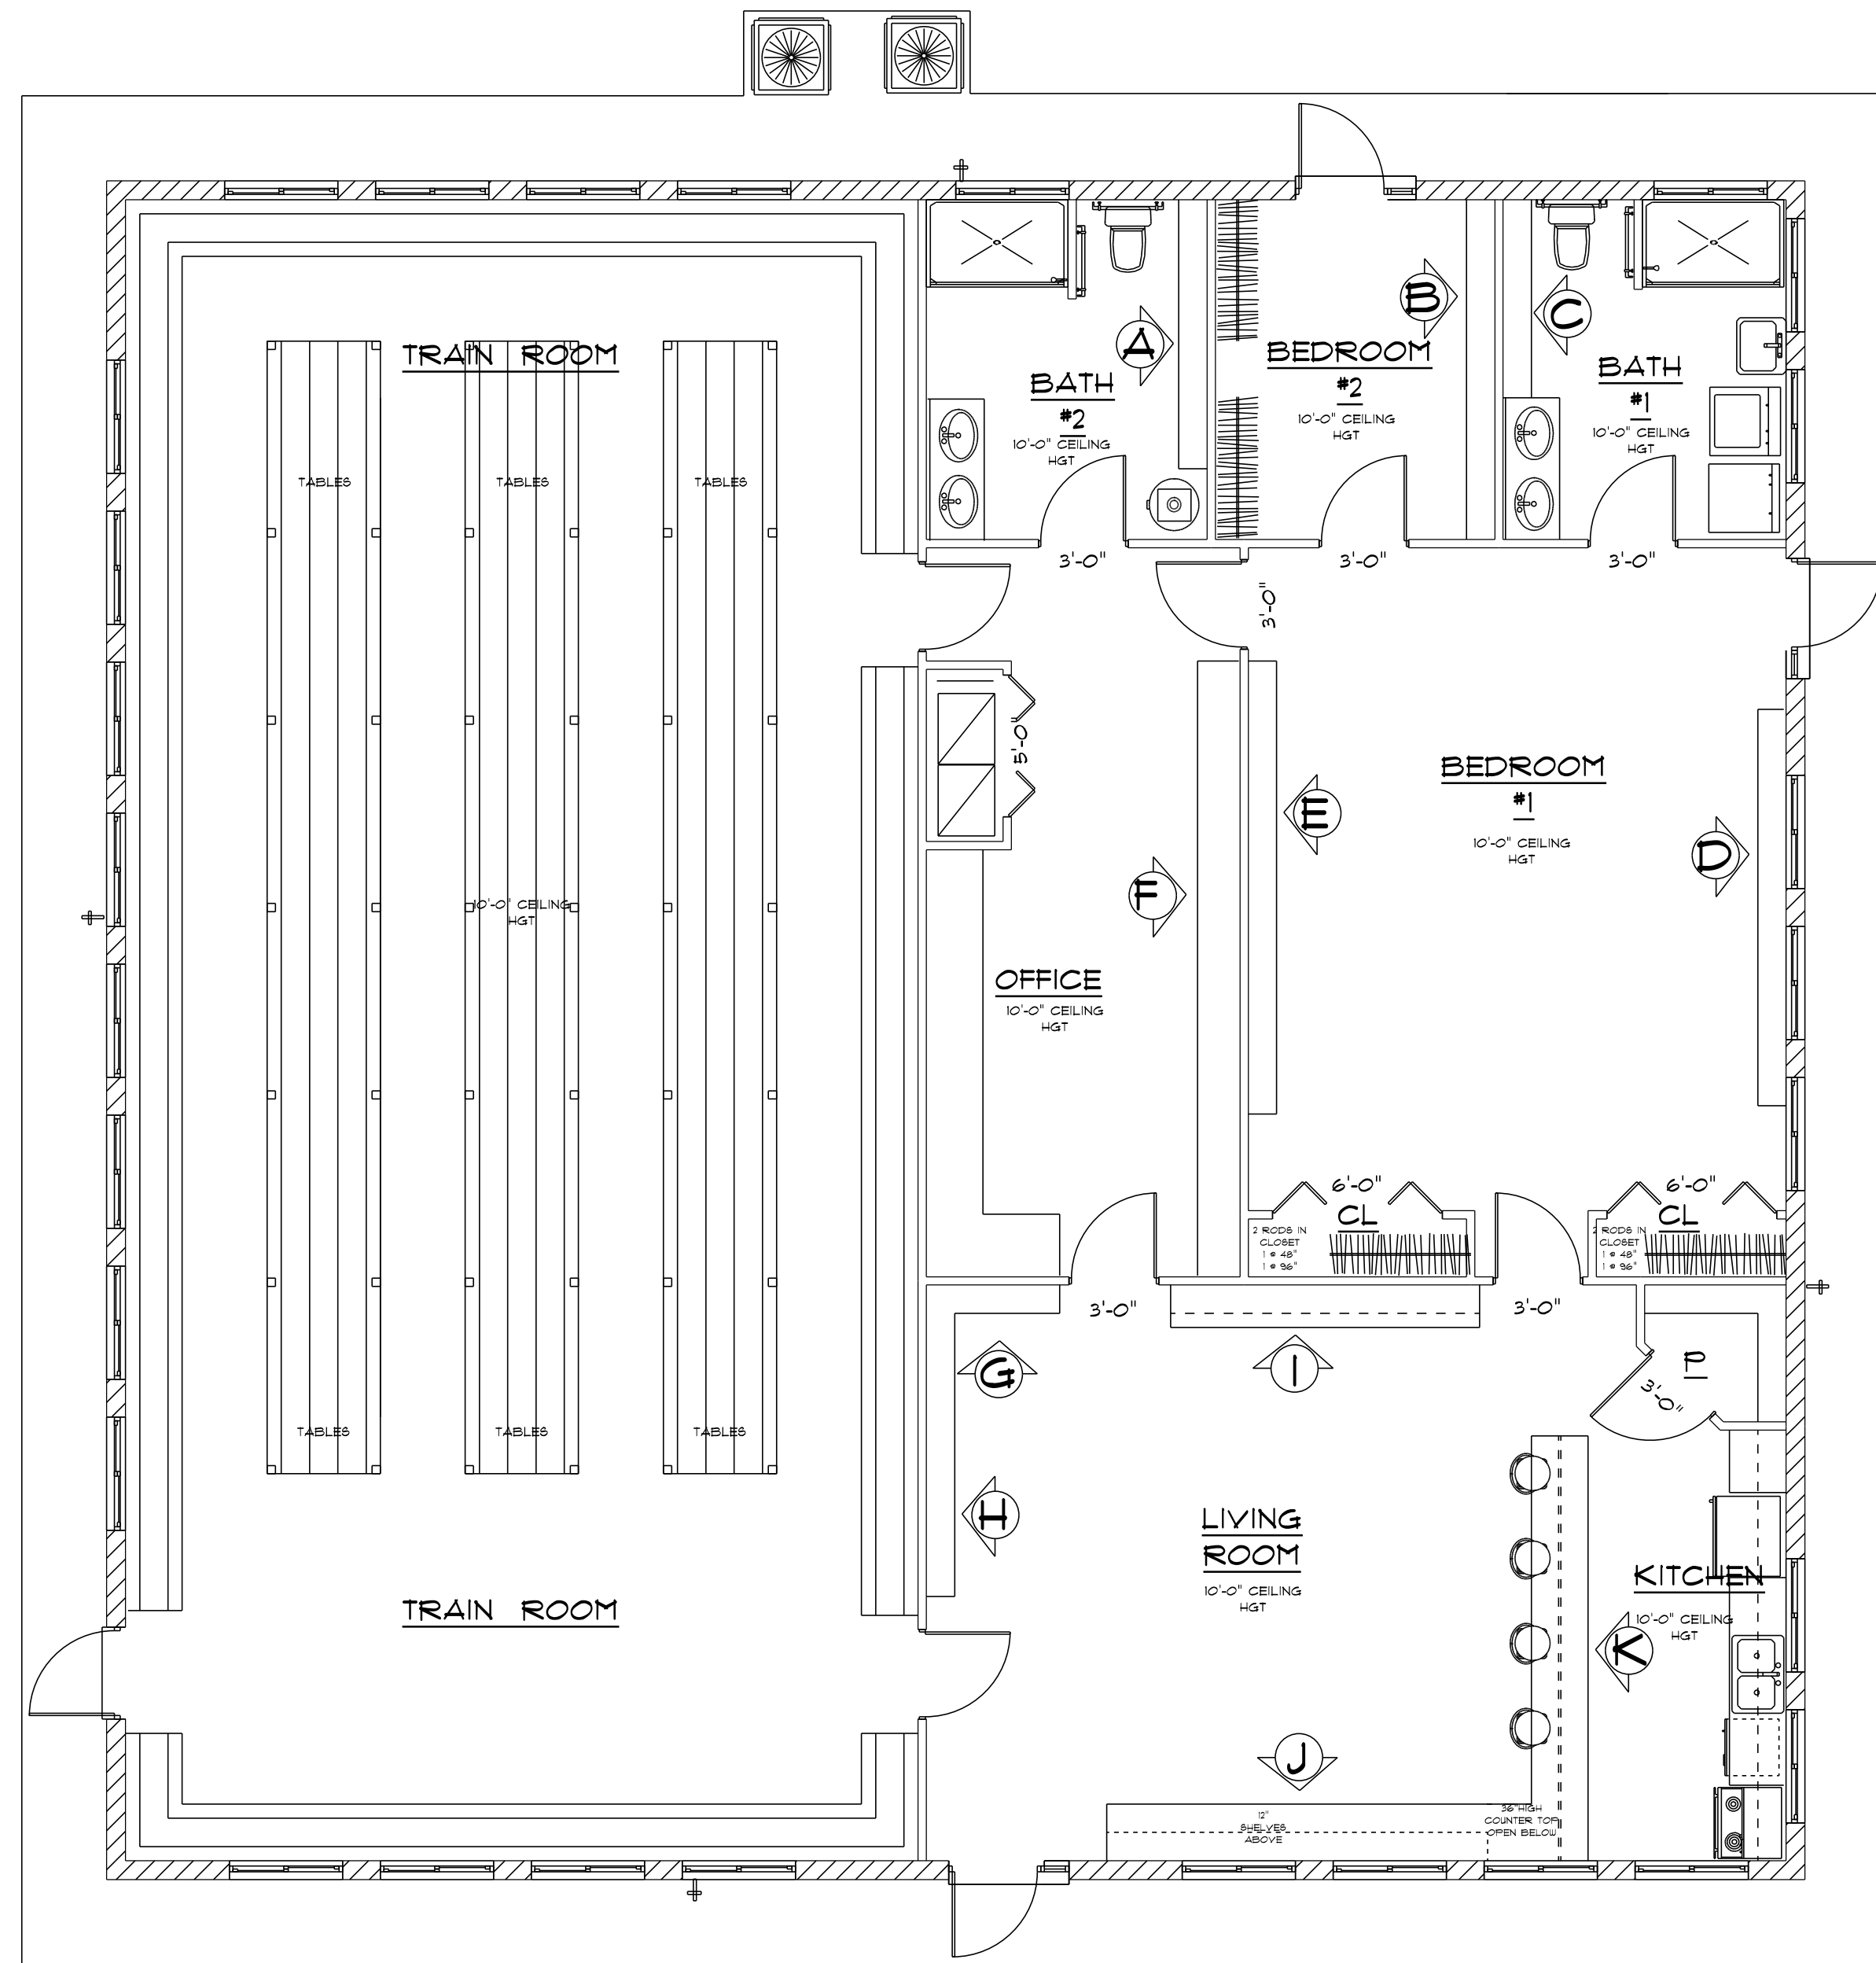

*** SHELIVING PLAN ***

SCALE : 3/16" = 1'-0"

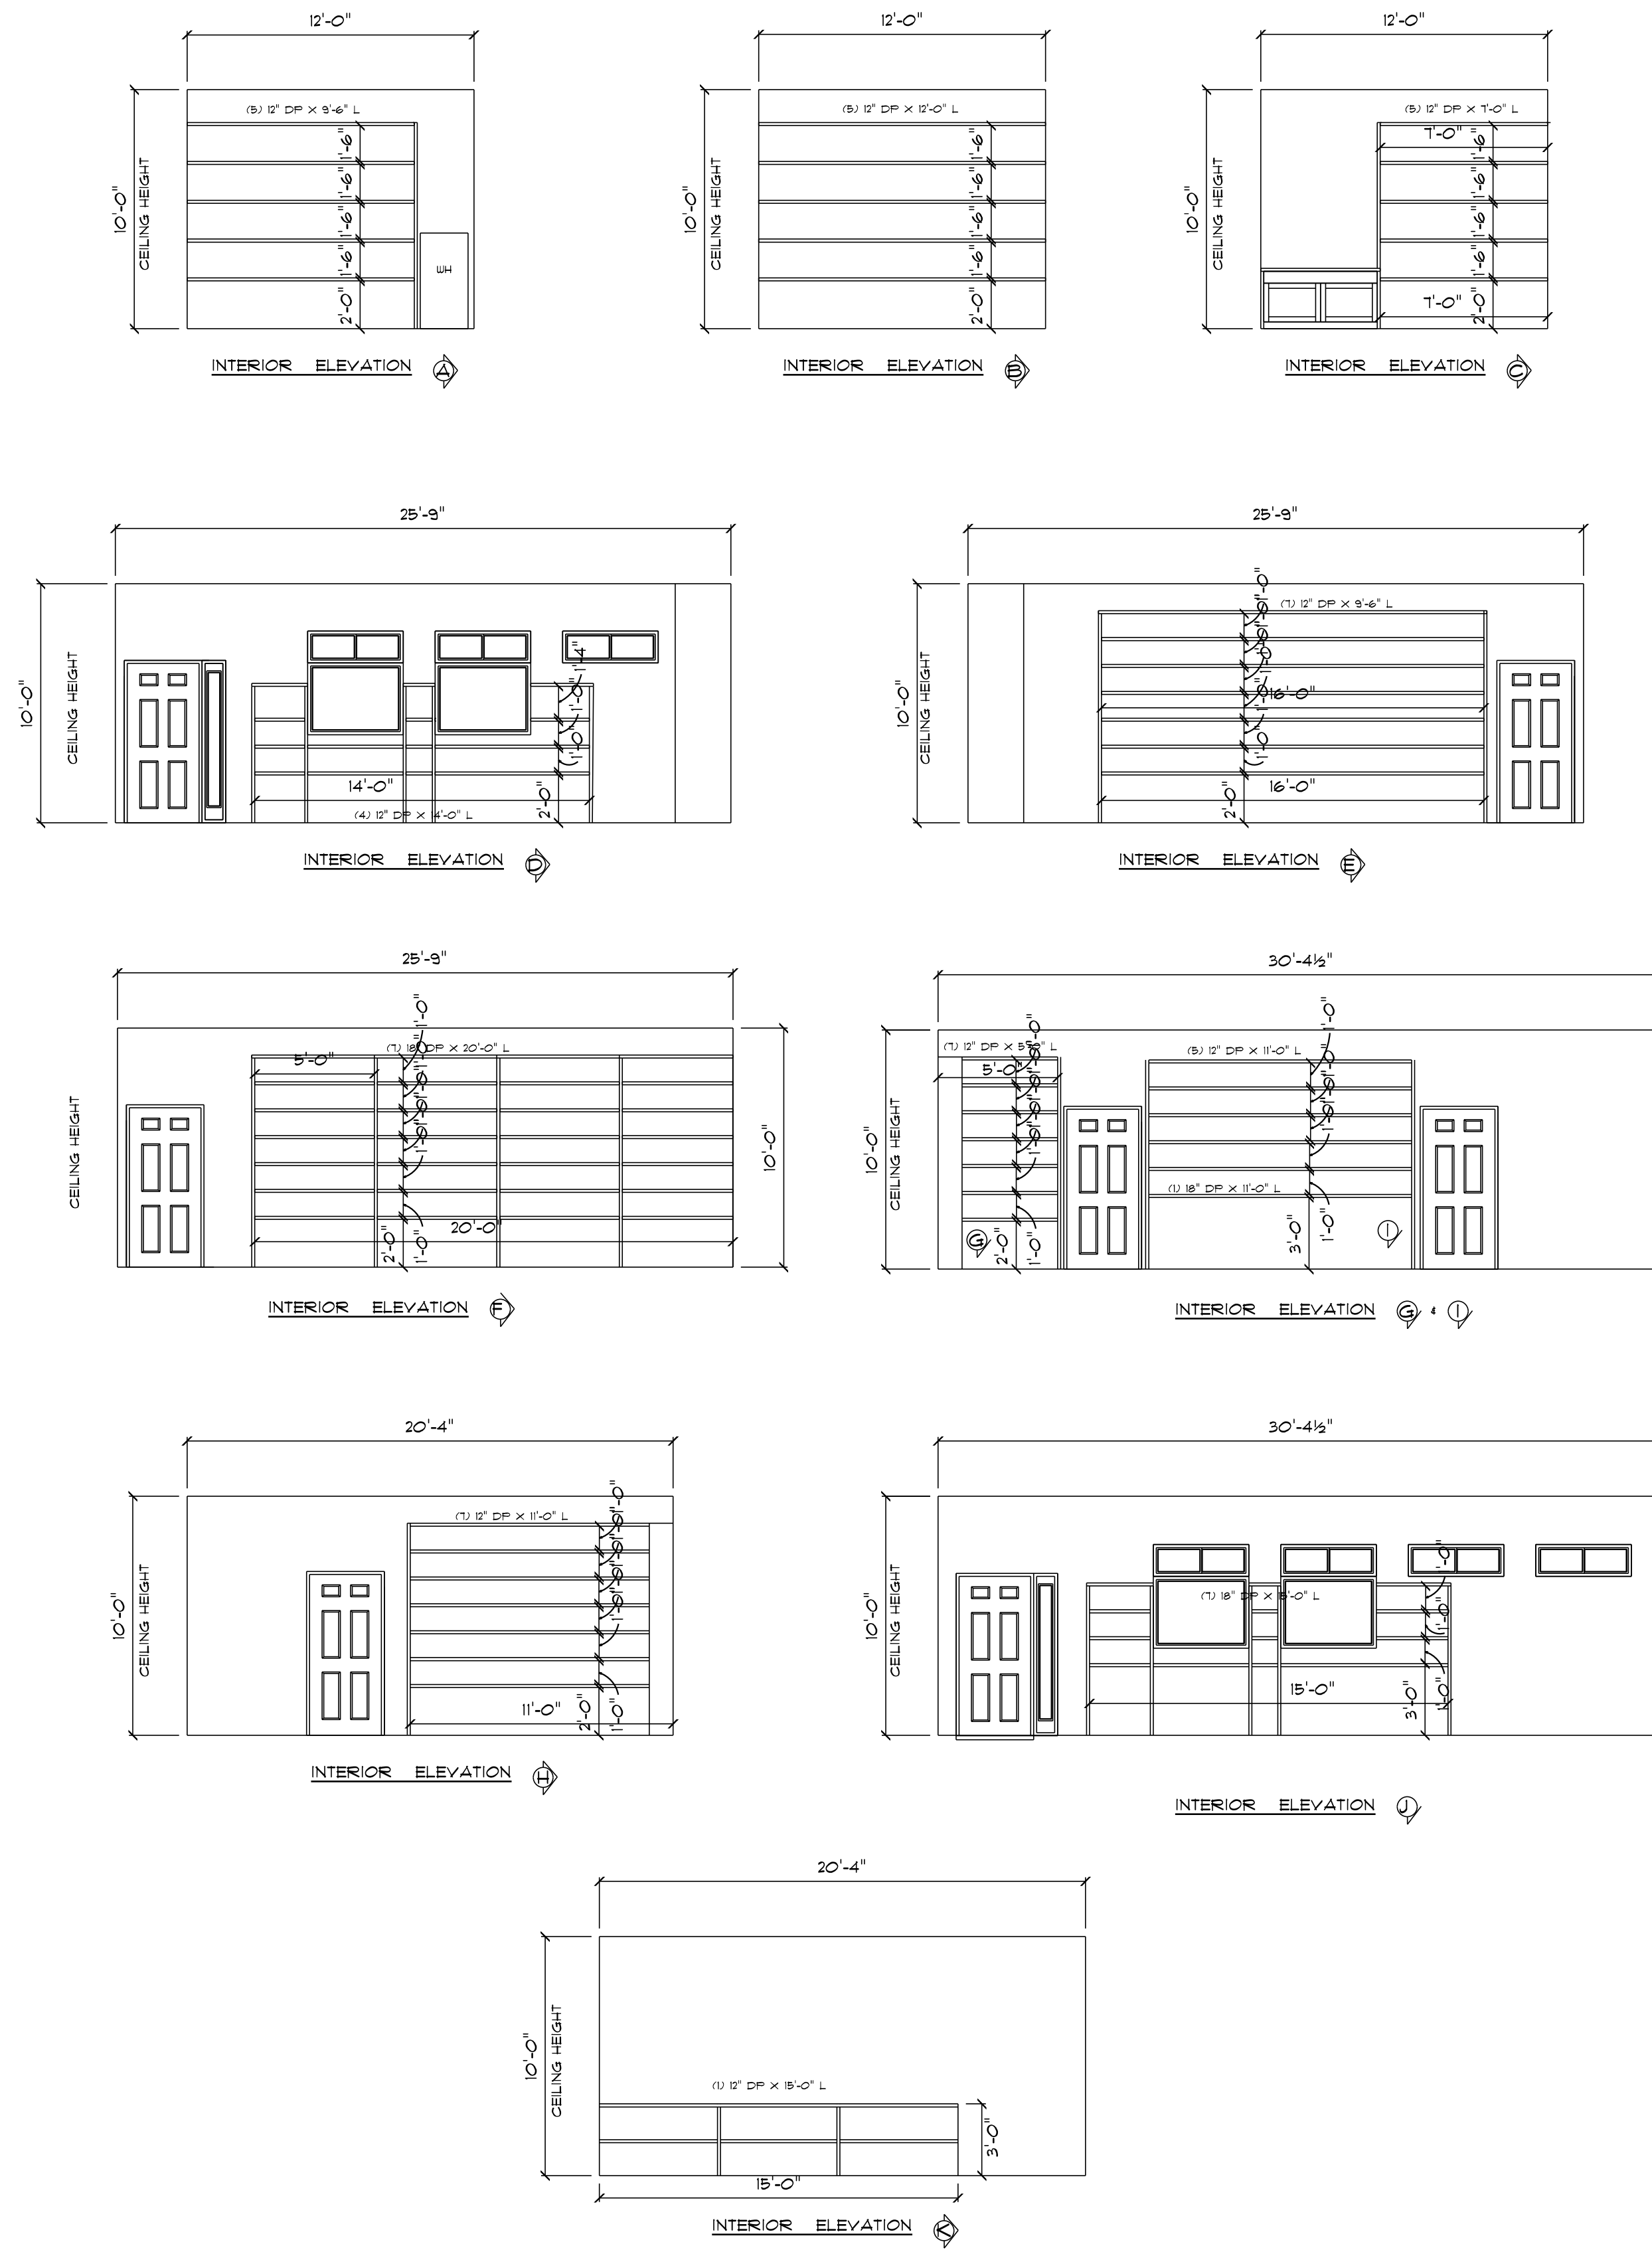

*** SHELIVING DETAILS ***

SCALE : 3/16" = 1'-0"

NEW RESIDENCE
for
DANIEL JACKSON

6W TUSTENUGGEE AVENUE
LAKE CITY, FLORIDA

Teena M. Ruffo
2925 6W SR 41
Lake City Florida, 32025
Cell: (386) 861 - 1191
Email: teenaruffo@gmail.com

PRINTED DATE:
Monday, December 19, 2022

DRAWN BY: Teena M. Ruffo

CHECKED BY:

BUILDING CONTRACTOR
ZECHER CONSTRUCTION

FINALS DATE:

JOB NUMBER:

DRAWING NUMBER

A-7

OF 1 SHEETS