



A-1 TYPICAL WALL SECTION
SCALE: 1" = 1'-0"

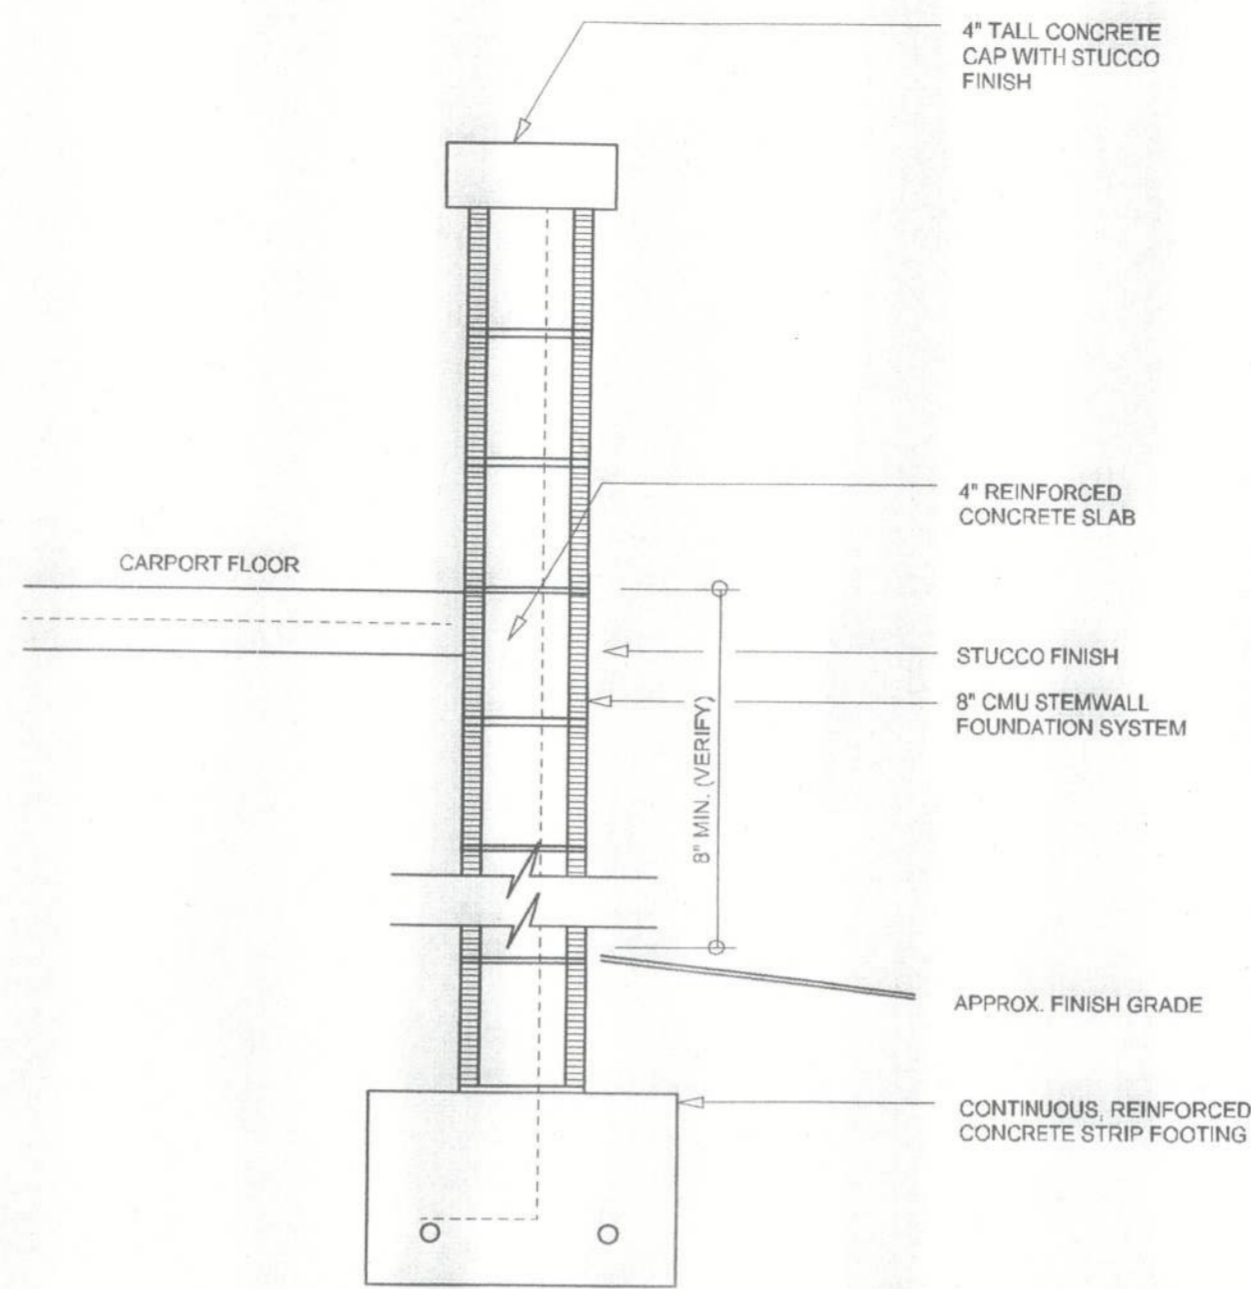

A-2 TYPICAL WALL SECTION
SCALE: 1" = 1'-0"

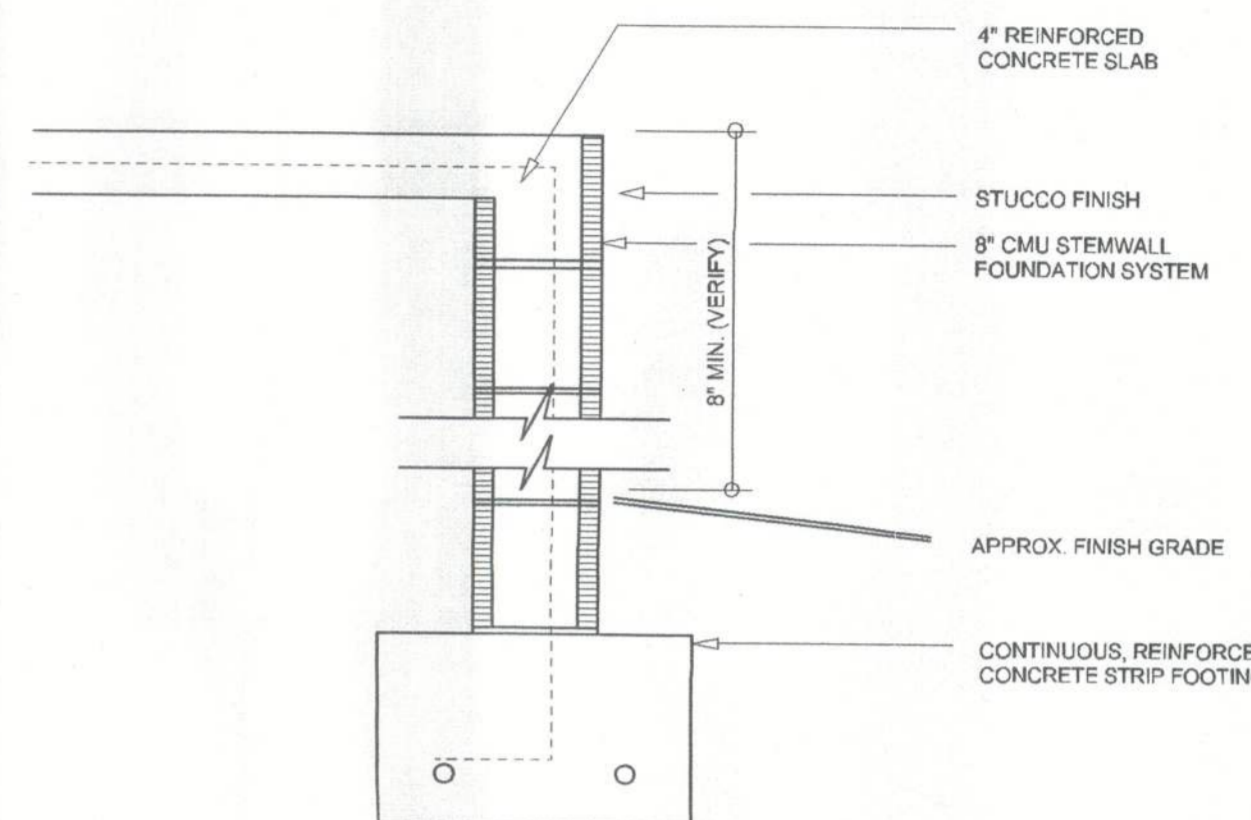


A-3 TYPICAL WALL SECTION
SCALE: 1" = 1'-0"

ELECTRICAL LEGEND	
	CEILING FAN (PRE-WIRE FOR LIGHT KIT)
	DOUBLE SECURITY LIGHT
	RECESSED CAN LIGHT
	BATH EXHAUST FAN
	LIGHT FIXTURE
	DUPLEX OUTLET
	220V OUTLET
	GFI DUPLEX OUTLET
	SMOKE DETECTOR (see note below)
	WALL SWITCH
	3 WAY WALL SWITCH
	WATER PROOF GFI OUTLET
	2 OR 4 TUB FLUORESCENT FIXTURE

NOTE:
ALL BEDROOM RECEPTACLES SHALL BE AFCI (ARC FAULT CIRCUIT INTERRUPT)
ALL SMOKE DETECTORS SHALL HAVE BATTERY BACKUP POWER AND ALL WIRED TOGETHER SO IF ANY ONE UNIT IS ACTUATED THEY ALL ACTIVATE.

ELECTRICAL PLAN
SCALE: 1/4" = 1'-0"

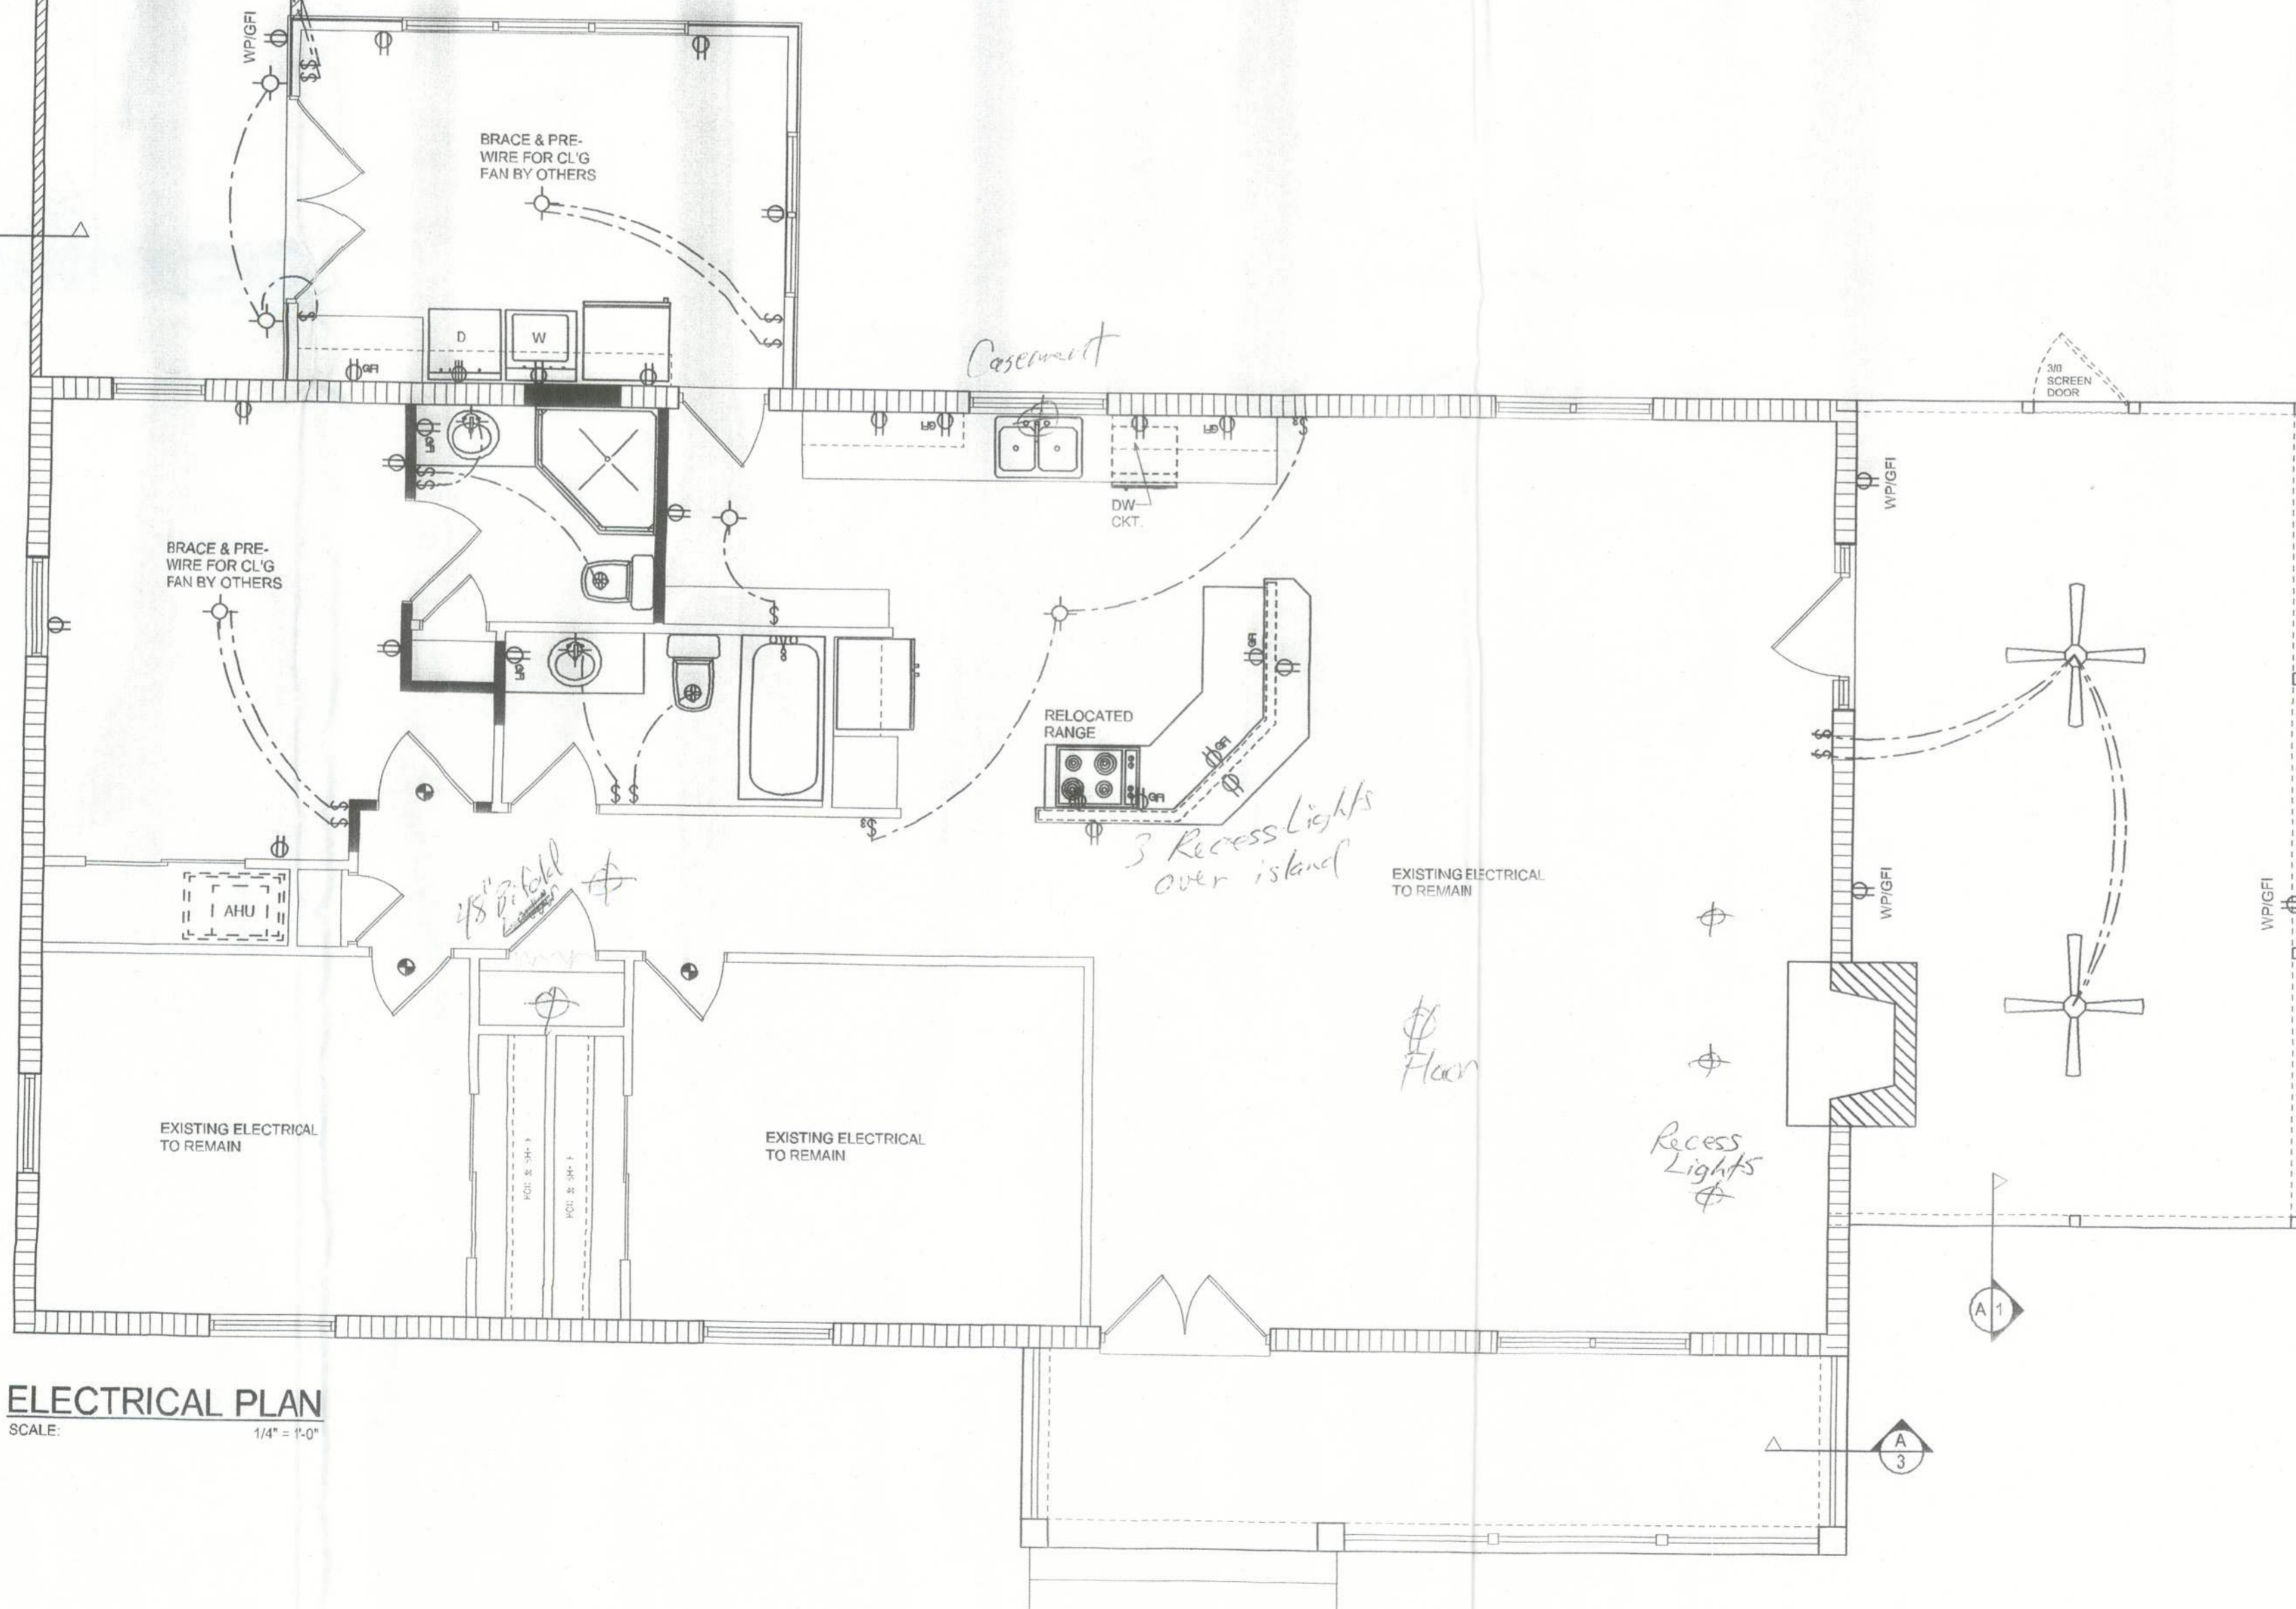

REVISIONS
February 16, 2004
April 20, 2004

SOFTPLAN
ARCHITECTURAL DESIGN SOFTWARE

ELECTRICAL PLAN
SCALE: 1/4" = 1'-0"
FOUNDATION DETAILS
SCALE: 1/4" = 1'-0"

A RESIDENCE REMODEL FOR:
CAROLYN DRAWDY
PROJECT ADDRESS: KING ROAD, COLUMBIA COUNTY, FLORIDA

©WILLIAM MYERS DESIGN
P.O. BOX 1513
LAKE CITY, FL 32806
(386) 758-8406
www.williamyers.net



JOB NUMBER
040205

SHEET NUMBER
A2
OF 3 SHEETS

W.M.