

# DUPREE RESIDENCE

## 11.32kW PV SYSTEM

### 1196 SW DAIRY ST, LAKE CITY, FL 32024

**Castillo Engineering**  
SOLAR DONE RIGHT®

**CASTILLO ENGINEERING SERVICES, LLC**  
COA # 28345  
620 N. WYMORE ROAD,  
SUITE 250,  
MAITLAND, FL 32751  
TEL: (407) 289-2575  
ERMOCRATES E. CASTILLO - FL PE 52590

COPYRIGHTED BY  
CASTILLO ENGINEERING  
SERVICES, LLC

REVISIONS		
DESCRIPTION	DATE	REV
PER CLIENT	07-21-2021	A

PROJECT INSTALLER

**SUNPRO**

Digitally  
Signed by:  
Ermocrates E. Castillo  
Date:  
2021.07.21  
19:00:05

PROJECT NAME

**DUPREE RESIDENCE**

1196 SW DAIRY ST,  
LAKE CITY, FL 32024

SHEET NAME  
COVER SHEET

SHEET SIZE  
**ANSI B**  
11" X 17"

SHEET NUMBER  
**G-01**

**PROJECT DESCRIPTION:**

31x365 LG: LG365N1C-N6 (365W) MODULES  
ROOF MOUNTED SOLAR PHOTOVOLTAIC MODULES

SYSTEM SIZE: 11.32 kW DC STC  
ARRAY AREA #1: 565.60 SQ FT.  
ARRAY AREA #2: 39.01 SQ FT.

**EQUIPMENT SUMMARY**

31 LG: LG365N1C-N6 (365W) MODULES  
31 ENPHASE IQ7PLUS-72-2-US MICROINVERTERS  
01 ENPHASE ENCHARGE 10 BATTERY  
01 ENPHASE ENPOWER SMART SWITCH

RACKING: UNIRAC LIGHT RAIL  
ATTACHMENT: S-5-PROTEA BRACKET

**DESIGN CRITERIA:**

WIND SPEED (ULT): 120  
WIND SPEED (ASD): 93  
RISK CATEGORY: II  
EXPOSURE: B

**CODES AND STANDARDS**

**GOVERNING CODES :**  
FLORIDA RESIDENTIAL CODE, 7TH EDITION 2020 (FRC)  
FLORIDA PLUMBING CODE, 7TH EDITION 2020 (FPC)  
FLORIDA BUILDING CODE, 7TH EDITION 2020 EDITION (FBC)  
FLORIDA MECHANICAL CODE, 7TH EDITION 2020 (FMC)  
NATIONAL ELECTRICAL CODE 2017 (NEC)  
ASCE 7-16

**OWNER**

DUPREE, RICHARD-JASON

**INSTALLER**

SUNPRO SOLAR  
4492- EAGLE FALLS PLACE  
TAMPA, FL 33619  
PH: (866) 450-1012

**ENGINEER**

Castillo Engineering Services LLC  
620 N. Wymore Road, Suite 250, Maitland, FL 32751  
TEL: (407) 289-2575  
Ermocrates E. Castillo  
License#: FL PE 52590


**SHEET INDEX**

SHEET #	SHEET DESCRIPTION
G-01	COVER SHEET
A-00	NOTES AND DESCRIPTION
A-01	ROOF PLAN
S-01	MODULE LAYOUT
S-01.1	PARTIAL PRESSURE AND MODULES EXPOSURE
S-02	ATTACHMENT DETAIL
S-02.1	STRUCTURE CALCULATION
E-01	ELECTRICAL LINE DIAGRAM
E-02	WIRING CALCULATIONS
E-03	SYSTEM LABELING
DS-01-08	DATA SHEETS

**HOUSE PHOTO**



**VICINITY MAP**

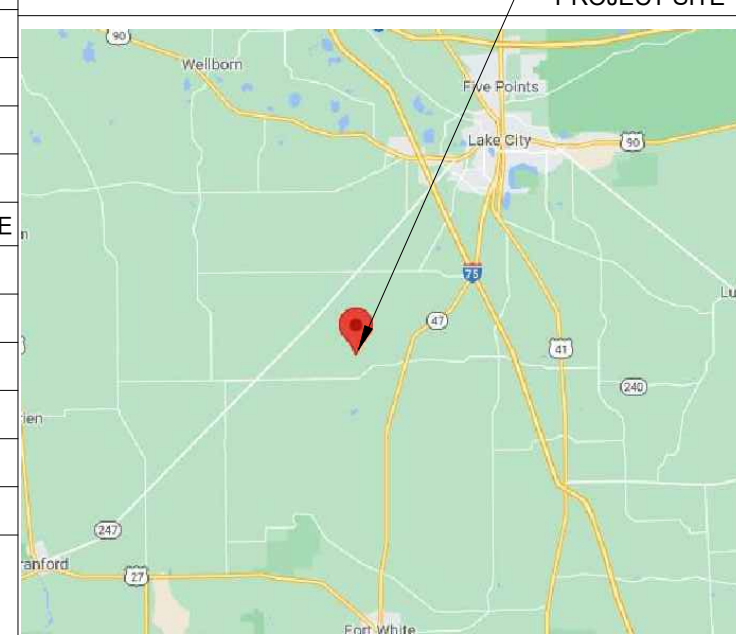


**STRUCTURAL CERTIFICATION:**


I ERMOCRATES CASTILLO PE# 52590 AN ENGINEER LICENSED PURSUANT TO CHAPTER 471, CERTIFY THAT THE INSTALLATION OF THE MODULES IS IN COMPLIANCE WITH, FBC 2020, RESIDENTIAL 7th EDITION, CHAPTER 3 SECTION 324, AND FBC: 2020, 7th ED., SECTION 101.4.9, SECTION 458: MANUFACTURED BUILDINGS, AS WELL AS CHAPTER 16. THE MANUFACTURED BUILDING STRUCTURE WILL SAFELY ACCOMMODATE WIND LATERAL AND UPLIFT FORCES, AND EQUIPMENT DEAD LOADS.


**ELECTRICAL CERTIFICATION:**


I ERMOCRATES CASTILLO PE# 52590 AN ENGINEER LICENSED PURSUANT TO CHAPTER 471, CERTIFY THAT THE PV ELECTRICAL SYSTEM AND ELECTRICAL COMPONENTS ARE DESIGNED AND APPROVED USING THE STANDARDS CONTAINED IN THE MOST RECENT VERSION OF THE FLORIDA BUILDING CODE. FBC 107, THE NEC 2017, AND THOSE SET FORTH BY THE FLORIDA SOLAR ENERGY CENTER CERTIFICATION

 **Symbols:**

 
Section.....  Sheet where section is located

 
Elevation .....  Detail ID Letter  
Sheet where section is located

 
Detail .....  Detail ID Letter  
Sheet where section is located

Detail .....  Detail ID Letter  
(Enlarged Plan) ← Area to be enlarged  
Sheet where section is located

Keyed Notes ..... 1 Keyed note designation on applicable sheet

Ground Terminal ..... 

 
Grounding Point/rod.... 


Solar Panel .....  or 00 ← Module with Source Circuit number


Combiner Box ..... CB


AC Disconnect ..... ACD

Main Distribution Panel ..... MDP


Fuse ..... 


Overcurrent Breaker .. 

 
Inverter ..... 


Transformer ..... 


Automatic ..... ATS  
Transfer Switch

Vent, Attic fan (Roof obstruction) 

PV Roof Attachment 

Trusses 

Conduit 

Fire Access 

**Abbreviations:**

ACD	AC Disconnect
AC	Alternating Current
APPROX	Approximate
AWG	American Wire Gauge
BAT	Enphase Encharge Battery
CB	Combiner Box
DC	Direct Current
DISC	Disconnect
(E)	Existing
EL	Elevation
EQ	Equal
GP	Generation Panel
JB	Junction Box
MCB	Main Combiner Box
MFR	Manufacturer
MID	Microgrid Interconnect Device
MIN	Minimum
MISC	Miscellaneous
MDP	Main Distribution Panel
(N)	New
NAVD	North American Vertical datum
OCPD	Over Current Protection Device
POCC	Point Of Common Coupling
PV	Photovoltaic
SF	Squarefoot/feet
STC	Standard Test Conditions
SD	Soladeck
TBD	To Be Determined
TYP	Typical
UNO	Unless Noted Otherwise
UM	Utility meter
VIF	Verify In Field
WP	Weather Proof

**System Description**

This system is a grid-tied, PV system, with PV generation consisting of 31 LG: LG365N1C-N6 (365W) MODULES with a combined STC rated dc output power of 11315 W. The modules are connected into 31 ENPHASE IQ7PLUS-72-2-US MICROINVERTERS. The inverter has electronic maximum power point tracking to maximize energy captured by the PV modules. The inverter also has an internal ground fault detection and interruption device that is set to disconnect the array in the event that a ground fault that exceeds one ampere should occur. The inverter has DC and AC disconnect integrated system and labels are provided as required by the *National Electrical Code*

When the sun is shining, power from the PV array is fed into the inverter, where it is converted from DC to AC. The inverter output is then used to contribute to the power requirements of the occupancy. If PV power meets the requirements of the loads of the occupancy, any remaining PV power is sold back to the utility. When utility power is available, but PV power is not available, building loads are supplied by the utility.

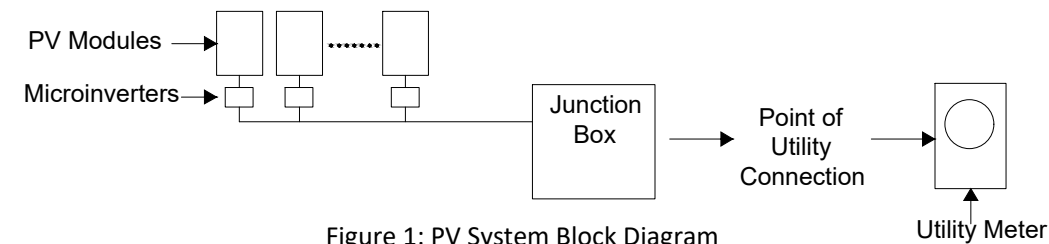


Figure 1: PV System Block Diagram

The inverter meets the requirements of IEEE 1547 and UL 1741.


**FALL PROTECTION:**

ANCHORAGES USED FOR ATTACHMENT OF PERSONAL FALL ARREST EQUIPMENT MUST BE INDEPENDENT OF ANY ANCHORAGE BEING USED TO SUPPORT OR SUSPEND PLATFORMS, AND CAPABLE OF SUPPORTING AT LEAST 5,000 POUNDS PER EMPLOYEE ATTACHED, OR MUST BE DESIGNED AND USED AS FOLLOWS:

- AS PART OF A COMPLETE PERSONAL FALL ARREST SYSTEM WHICH MAINTAINS A SAFETY FACTOR OF AT LEAST TWO.
- UNDER THE SUPERVISION OF A QUALIFIED PERSON

**ADDITIONAL INFORMATION**

- 29 CFR 1926 SUBPART M, FALL PROTECTION. OSHA STANDARD.
- 1926.502, FALL PROTECTION SYSTEMS CRITERIA AND PRACTICES
- 1926.502(D)(15)

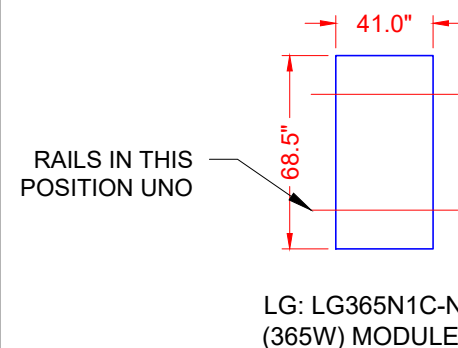

LG: LG365N1C-N6 (365W) MODULES

ALLOWABLE DESIGN PRESSURE	PSF
DOWN PRESSURE	125
UPLIFT PRESSURE, 2 RAILS	88

REVISIONS		
DESCRIPTION	DATE	REV

PROJECT INSTALLER



Digitally signed by: Ermocrates E Castillo  
Date: 2021.07.21 19:00:06

The firm has been duly licensed, bonded and insured by the State of Florida. The professional seal and signature are not to be used for any other project without the express written consent of the firm.

PROJECT NAME

**DUPREE RESIDENCE**  
1196 SW DAIRY ST,  
LAKE CITY, FL 32024

SHEET NAME  
NOTES AND DESCRIPTION


SHEET SIZE  
**ANSI B**  
11" X 17"

SHEET NUMBER  
**A-00**



SW DAIRY ST

804'-3"

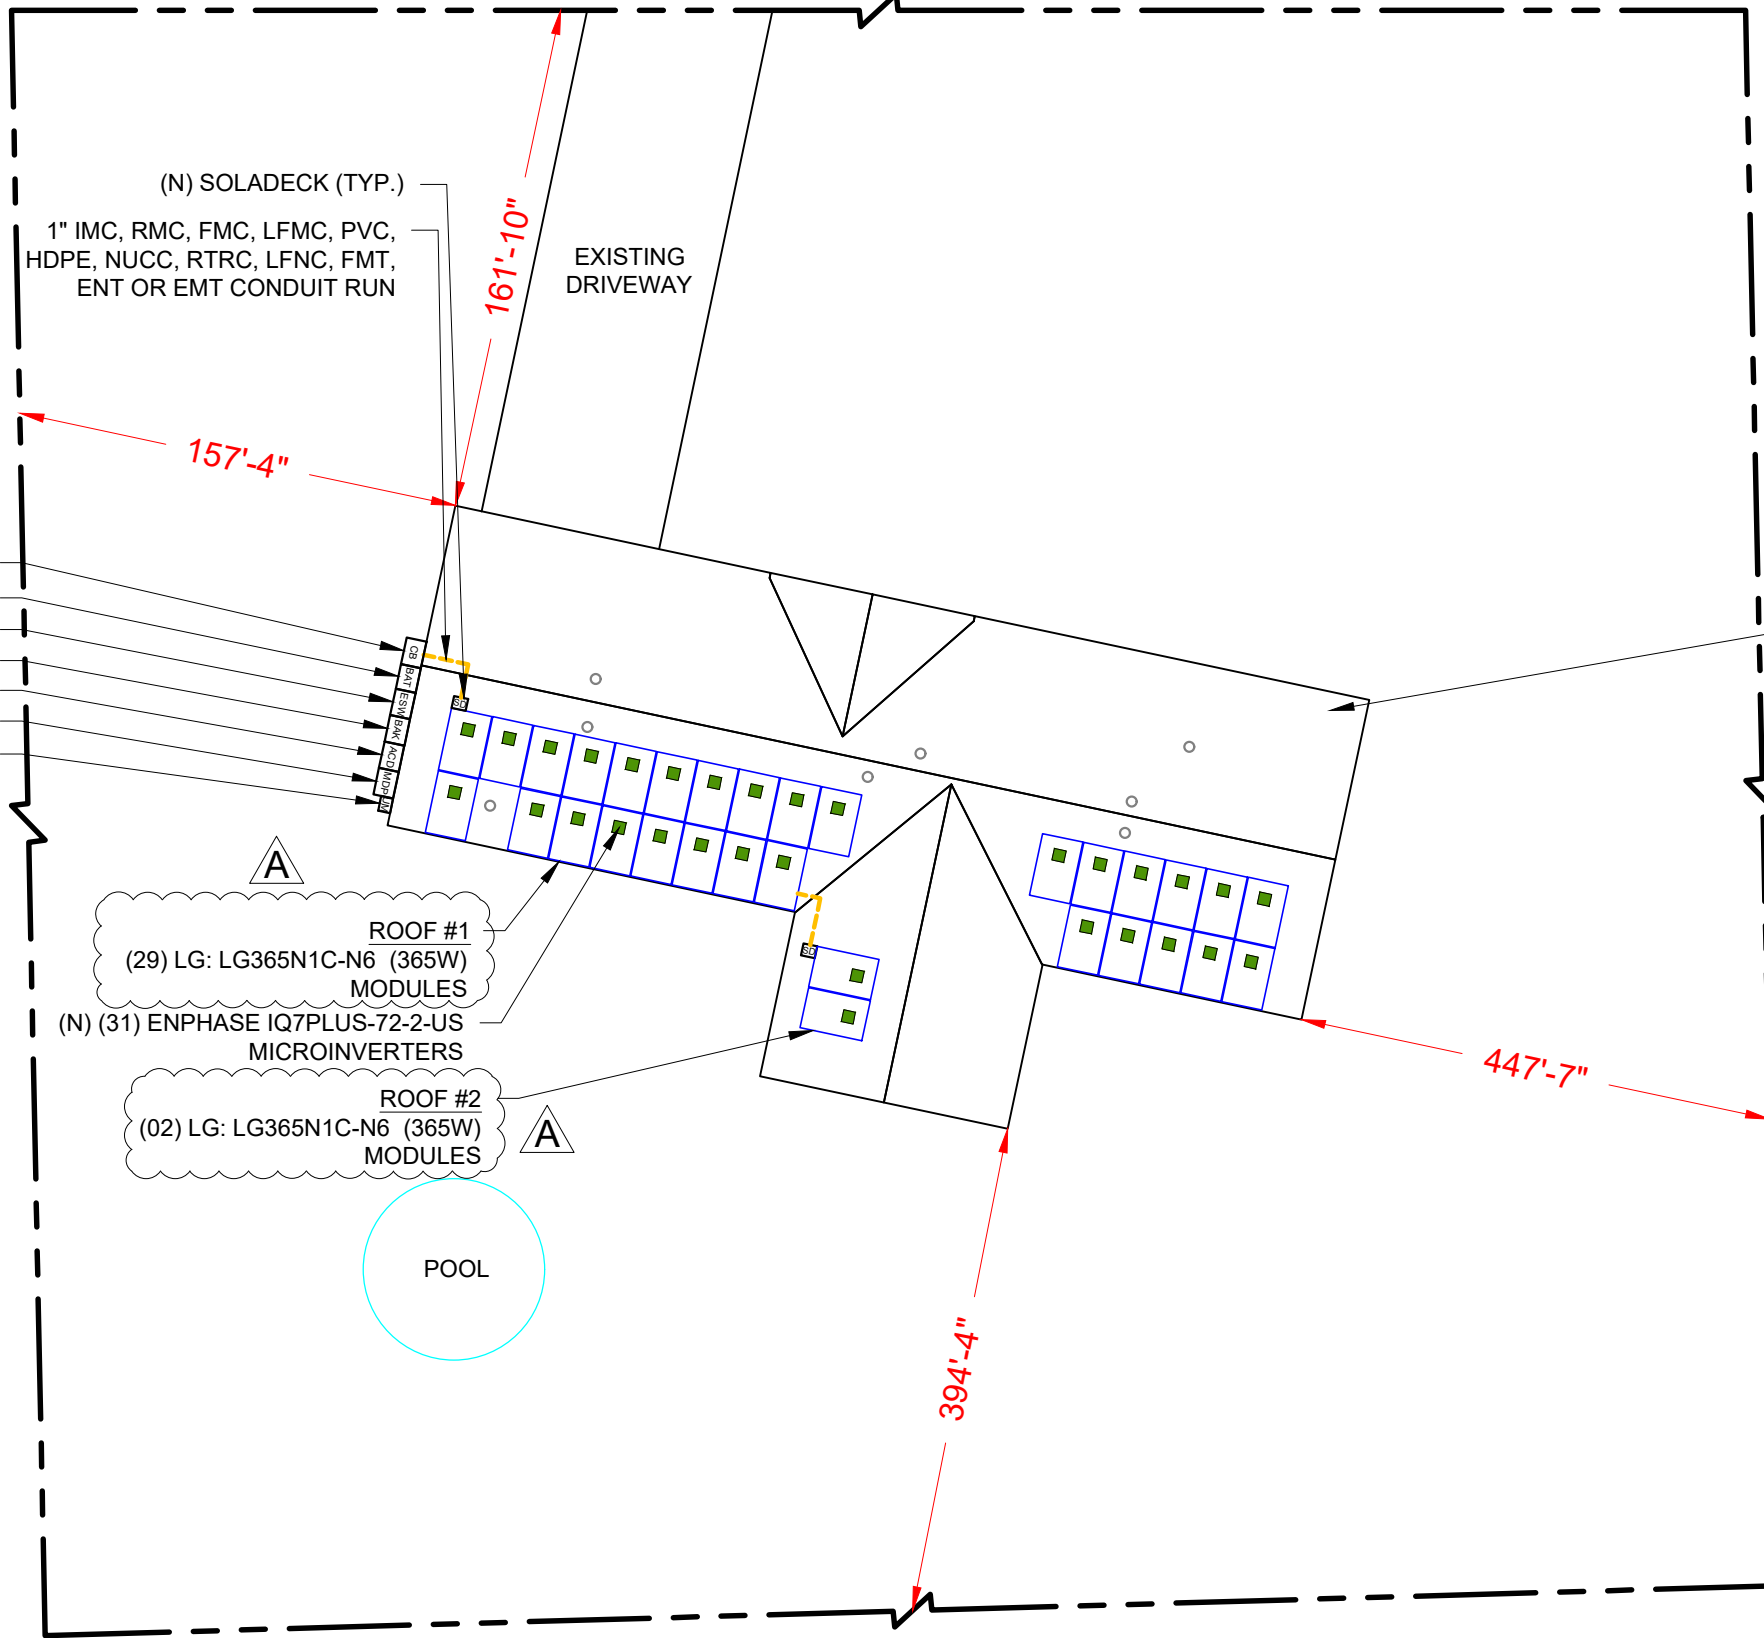

REVISIONS		
DESCRIPTION	DATE	REV
PER CLIENT	07-21-2021	A

PROJECT INSTALLER



Digitally signed by:  
Ermocrates E Castillo  
Date: 2021.07.21 19:00:07

STATE OF FLORIDA  
PROFESSIONAL ENGINEER

PROJECT NAME

**DUPREE RESIDENCE**  
1196 SW DAIRY ST,  
LAKE CITY, FL 32024

SHEET NAME  
ROOF PLAN

SHEET SIZE  
ANSI B  
11" X 17"

SHEET NUMBER  
A-01


1 ROOF PLAN PROPERTY LINES

A-01

SCALE: 1/16" = 1'-0"

**MODULE TYPE, DIMENSIONS & WEIGHT**

NUMBER OF MODULES = 31 MODULES  
 MODULE TYPE = LG: LG365N1C-N6 (365W) MODULES  
 WEIGHT = 41.01LBS / 18.6 KG.  
 MODULE DIMENSIONS = 68.5" x 41.0" = 19.50 SF  
 UNIT WEIGHT OF ARRAY = 2.10 PSF

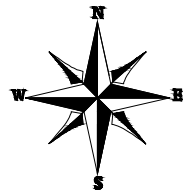

ROOF	ROOF TYPE	ARRAY AREA (Sq. Ft.)	ROOF AREA (Sq. Ft.)	ROOF AREA COVERED BY ARRAY (%)	TILT	AZIMUTH	SEAM SPACING
#1	METAL	565.60	922.13	61.34	22.6°	192°	9" O.C.
#2	METAL	39.01	216.24	18.04	22.6°	282°	9" O.C.

**GENERAL INSTALLATION PLAN NOTES:**

1) ROOF ATTACHMENTS TO SEAM SHALL BE INSTALLED AS SHOWN IN SHEET S-02 AND AS FOLLOWS FOR EACH WIND ZONE:

WIND ZONES	NON-EXPOSED MODULES		EDGE / EXPOSED MODULES	
	SPAN	CANTILEVER	SPAN	CANTILEVER
ZONE 1	36"	12"	36"	12"
ZONE 1'	X	X	X	X
ZONE 2e	36"	12"	36"	12"
ZONE 2n	36"	12"	36"	12"
ZONE 2r	36"	12"	36"	12"
ZONE 3e	36"	12"	36"	12"
ZONE 3r	36"	12"	36"	12"

SEE SHEET S-02.1 FOR SUPPORTING CALCULATIONS.

2) EXISTING RESIDENTIAL BUILDING IS A METAL ROOF WITH MEAN ROOF HEIGHT IS 15 FT AND SEAM SPACING 9" O.C. EXISTING ROOF SLOPE FOR SOLAR SYSTEM RETROFIT IS 22.6 DEGREES. CONTRACTOR TO FIELD VERIFY AND SHALL REPORT TO THE ENGINEER IF ANY DISCREPANCIES EXIST BETWEEN PLANS AND IN FIELD CONDITIONS.

\*I CERTIFY THAT THE INSTALLATION OF THE MODULES IS IN COMPLIANCE WITH, FBC 2020, RESIDENTIAL 7th EDITION, CHAPTER 3 SECTION 324, AND FBC: 2020, 7th ED., SECTION 101.4.9, SECTION 458: MANUFACTURED BUILDINGS, AS WELL AS CHAPTER 16. THE MANUFACTURED BUILDING STRUCTURE WILL SAFELY ACCOMMODATE WIND LATERAL AND UPLIFT FORCES, AND EQUIPMENT DEAD LOADS.\*



**CASTILLO ENGINEERING SERVICES, LLC**  
 COA # 28345  
 620 N. WYMORE ROAD,  
 SUITE 250,  
 MAITLAND, FL 32751  
 TEL: (407) 289-2575  
 ERMOCRATES E. CASTILLO - FL PE 52590

COPYRIGHTED BY  
 CASTILLO ENGINEERING SERVICES, LLC

REVISIONS		
DESCRIPTION	DATE	REV
PER CLIENT	07-21-2021	A

PROJECT INSTALLER



Digitally signed by:  
 Ermocrates E. Castillo  
 Date: 2021.07.21 19:00:08

PROJECT NAME

**DUPREE RESIDENCE**  
 1196 SW DAIRY ST,  
 LAKE CITY, FL 32024

SHEET NAME


MODULE LAYOUT

SHEET SIZE

**ANSI B**  
 11" X 17"

SHEET NUMBER

**S-01**

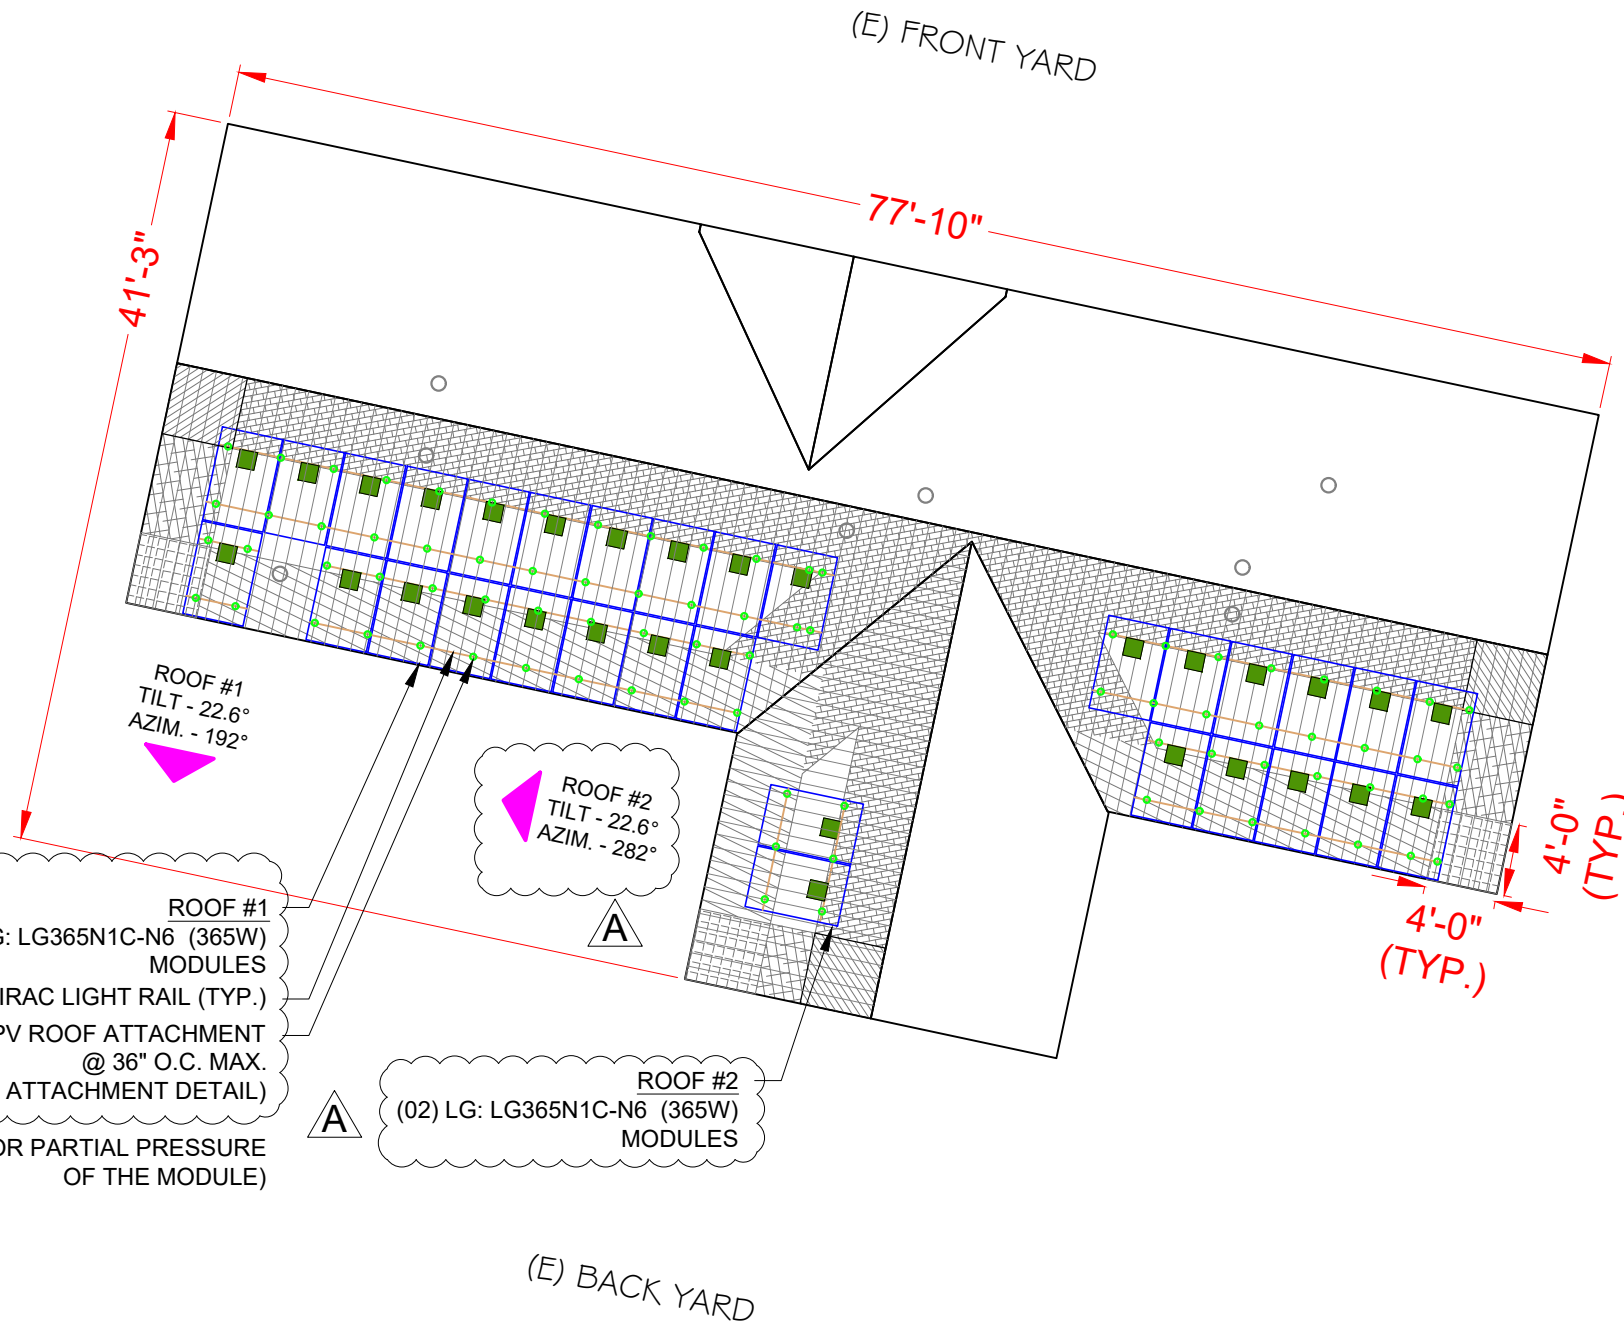


**ROOF #1**  
 (29) LG: LG365N1C-N6 (365W) MODULES  
 (N) UNIRAC LIGHT RAIL (TYP.)  
 (84) PV ROOF ATTACHMENT @ 36" O.C. MAX.  
 (SEE SHEET S-02 FOR ATTACHMENT DETAIL)  
 (SEE SHEET S-01.1 FOR PARTIAL PRESSURE OF THE MODULE)

**ROOF #2**  
 (02) LG: LG365N1C-N6 (365W) MODULES

**LEGEND**

- EDGE MODULE
- EXPOSED MODULE
- NON- EXPOSED MODULE
- MISSING MODULE
- MIN. MODULE EDGE DISTANCE LINE
- MODULE EXPOSURE LINE
- WIND ZONE 1 (TYP)
- WIND ZONE 2e (TYP)
- WIND ZONE 2n (TYP)
- WIND ZONE 2r (TYP)
- WIND ZONE 3r (TYP)
- WIND ZONE 3e (TYP)

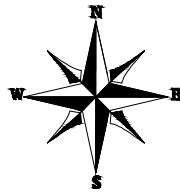

	1	1'	2e	2n	2r	3e	3r	
	18.60	0.00	18.60	26.10	26.10	26.10	29.30	
	Module Size		19.5		Sqft.			
Edge Modules modules								
	1	1'	2e	2n	2r	3e	3r	Partial Pressure
P1	3.79	0.00	11.17	1.15	0.00	3.38	0.00	20.34
P2	4.94	0.00	14.56	0.00	0.00	0.00	0.00	18.60
P3	3.14	0.00	14.56	0.00	1.81	0.00	0.00	19.30
P4	4.67	0.00	0.00	0.00	14.83	0.00	0.00	24.30
P5	4.04	0.00	11.89	0.91	0.00	2.67	0.00	19.98
P6	4.68	0.00	14.56	0.00	0.26	0.00	0.00	18.70

ALLOWABLE MODULE UPLIFT PRESSURE 2 RAILS: 88 PSF



	1	1'	2e	2n	2r	3e	3r	
	16.00	0.00	16.00	17.40	17.40	17.40	19.50	
	Module Size		19.5		Sqft.			
Non-Exposed modules								
	1	1'	2e	2n	2r	3e	3r	Partial Pressure
P8	9.46	0.00	5.86	0.00	4.18	0.00	0.00	16.30
P9	12.70	0.00	0.00	2.85	3.22	0.00	0.72	16.57
P10	15.27	0.00	0.00	0.00	4.23	0.00	0.00	16.30
P11	15.56	0.00	0.00	0.00	3.94	0.00	0.00	16.28
P12	11.94	0.00	0.00	3.62	3.03	0.00	0.92	16.64
P13	9.51	0.00	0.00	0.00	9.99	0.00	0.00	16.72


ALLOWABLE MODULE UPLIFT PRESSURE 2 RAILS: 88 PSF

	1	1'	2e	2n	2r	3e	3r	
	18.60	0.00	18.60	26.10	26.10	26.10	29.30	
	Module Size		19.5		Sqft.			
Exposed modules								
	1	1'	2e	2n	2r	3e	3r	Partial Pressure
P7	9.46	0.00	5.86	0.00	4.18	0.00	0.00	20.21

ALLOWABLE MODULE UPLIFT PRESSURE 2 RAILS: 88 PSF



(E) FRONT YARD

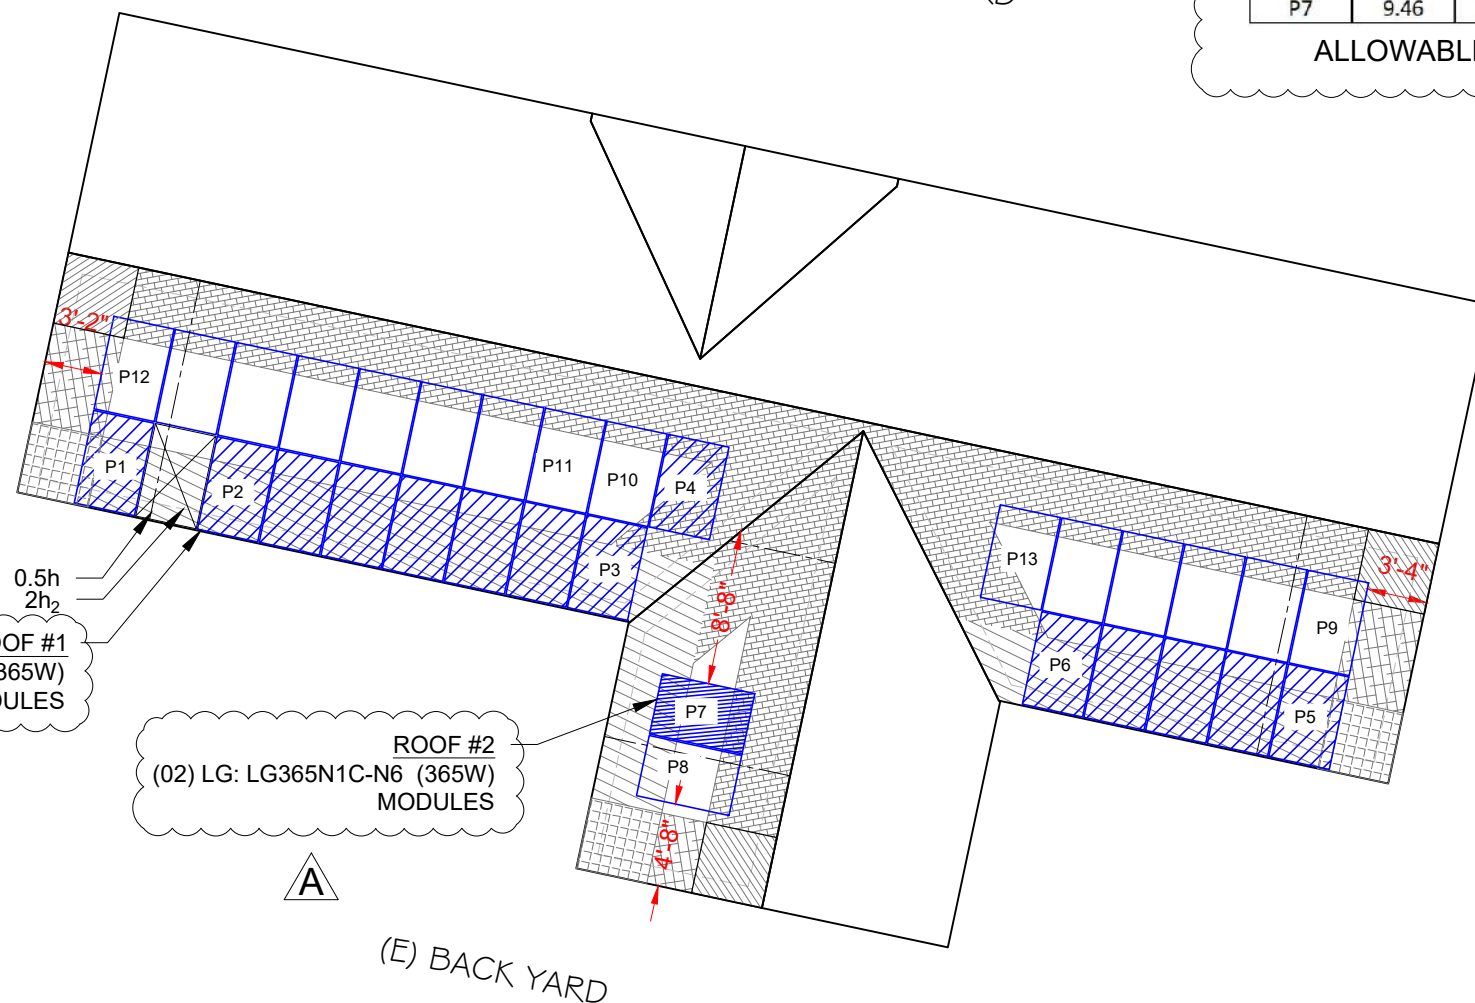

NOTE : PARTIAL PRESSURES OF THE WIND ZONES ON ALL MODULES HAVE BEEN VERIFIED AND ARE WITHIN THE ALLOWABLE PER THE MANUFACTURER SPECIFICATION, INSTALLER SHOULD FOLLOW THE LAYOUT TO AVOID HIGHER ZONAL PARTIAL PRESSURES. ANY CHANGES IN LAYOUT SHOULD BE REPORTED BACK TO THE ENGINEER OF RECORD.

2h<sub>2</sub> DISTANCE : 12"  
0.5h DISTANCE : 7' - 6"

**LEGEND**

- EDGE MODULE
- EXPOSED MODULE
- NON- EXPOSED MODULE
- MISSING MODULE
- MIN. MODULE EDGE DISTANCE LINE
- MODULE EXPOSURE LINE
- WIND ZONE 1 (TYP)
- WIND ZONE 2e (TYP)
- WIND ZONE 2n (TYP)
- WIND ZONE 2r (TYP)
- WIND ZONE 3r (TYP)
- WIND ZONE 3e (TYP)

REVISIONS		
DESCRIPTION	DATE	REV
PER CLIENT	07-21-2021	A

PROJECT INSTALLER



Digitally signed by: Ermocrates E Castillo  
Date: 2021.07.21 19:00:09

PROJECT NAME

**DUPREE RESIDENCE**  
1196 SW DAIRY ST,  
LAKE CITY, FL 32024

SHEET NAME  
PARTIAL PRESSURE AND MODULES EXPOSURE

SHEET SIZE  
ANSI B  
11" X 17"

SHEET NUMBER  
S-01.1

REVISIONS

DESCRIPTION	DATE	REV

PROJECT INSTALLER



Digitally signed by:  
Ermocrates E. Castillo  
Date: 2021.07.21 19:00:10

This form has been electronically signed and sealed by Ermocrates E. Castillo, PE on the State of Florida. This document is the digital equivalent of a physical document. It is not a physical document and does not require a physical signature or seal.

PROJECT NAME

DUPREE RESIDENCE

1196 SW DAIRY ST,  
LAKE CITY, FL 32024

SHEET NAME



ATTACHMENT DETAIL

SHEET SIZE



ANSI B  
11" X 17"

SHEET NUMBER

S-02

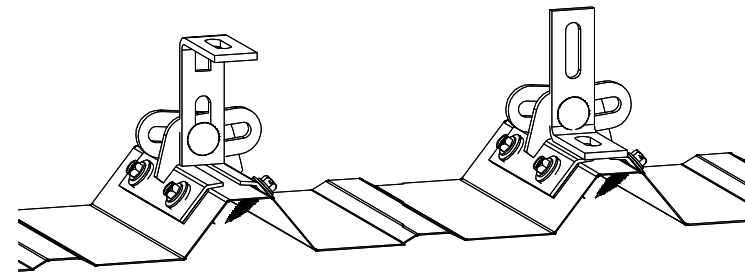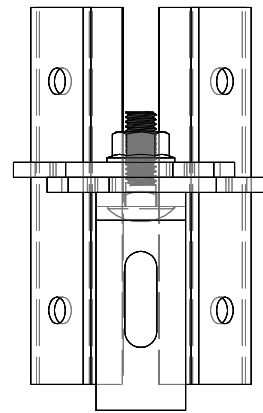


**ProteaBracket**

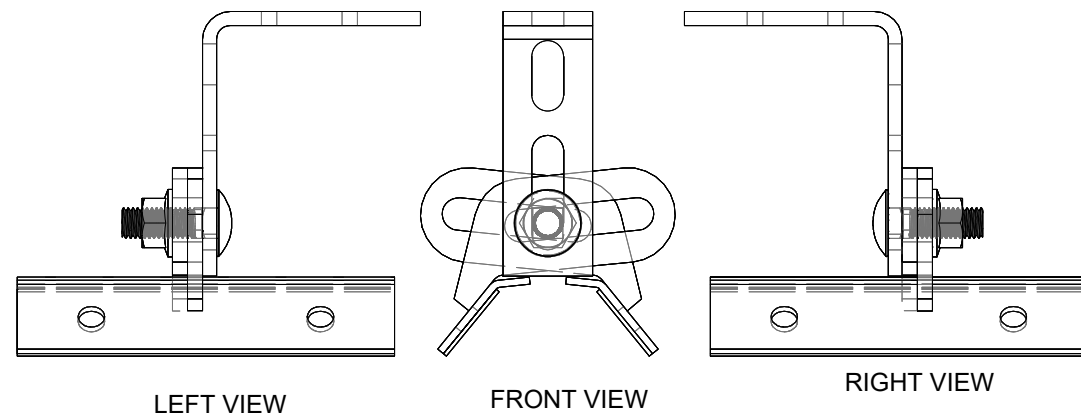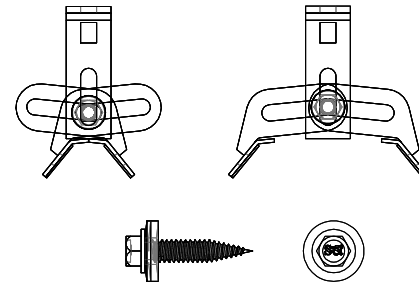


FOR STANDING SEAM SPECIFIC MECHANICAL LOAD TEST INFORMATION AND CLAMP INSTALLATION INFORMATION PLEASE VISIT: [WWW.S-5.COM](http://WWW.S-5.COM)

**1 ATTACHMENT DETAILS**  
S-02 SCALE: 3" = 1'-0"

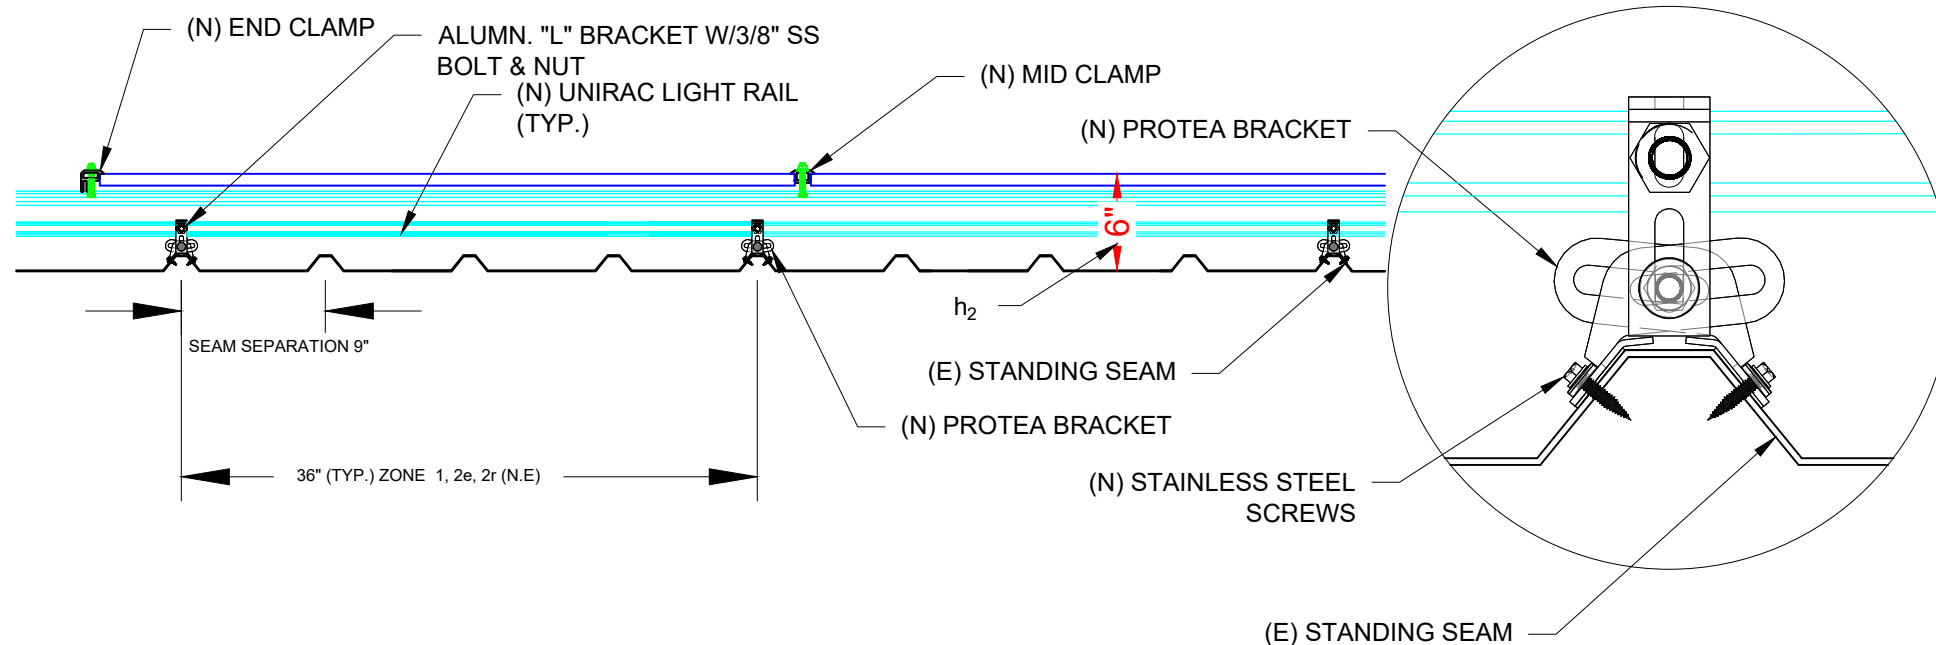

**2 ATTACHEMENT DETAIL**  
S-02 SCALE: 3" = 1'-0"

**3 ENLARGE SECTION**  
S-02 SCALE: NTS

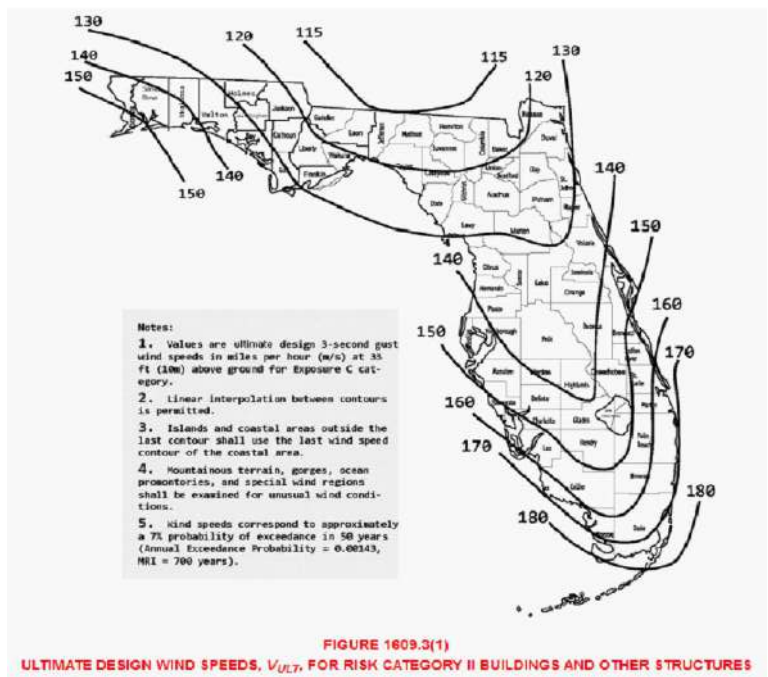

**WIND LOAD CALCULATIONS FOR MODULES INSTALLED ON ROOFS WITH A HEIGHT LESS THAN 60'**

SITE INFORMATION			
FBC VERSION	2020	RISK CATEGORY	II
MEAN ROOF HEIGHT (ft)	15.0	EXPOSURE CATEGORY	B
ROOF LENGTH (ft)	77.8	ROOF SLOPE	5 / 12
ROOF WIDTH (ft)	41.3	ROOF SLOPE (°)	22.6
PARAPET HEIGHT (ft)	0.0	ROOF TYPE	GABLE
MODULE LENGTH (in)	68.5	ULTIMATE WIND SPEED	120 mph
MODULE WIDTH (in)	41.00	NOMINAL WIND SPEED	93 mph
MODULE ORIENTATION	PORTRAIT	EXPOSURE FACTOR ( $C_e$ )	1.000
MODULE AREA (sq. ft.)	19.50	TEMPERATURE FACTOR ( $C_t$ )	1.000
GROUND SNOW LOAD (psf)	0.0	IMPORTANCE FACTOR ( $I_s$ )	1.000
DEAD LOAD (psf)	3.0	SLOPE FACTOR ( $C_s$ )	0.910
SLOPED ROOF SNOW LOAD (psf)	0.0	$K_D$	0.850
EFFECTIVE WIND AREA (ft <sup>2</sup> )	19.5	$K_{ZF}$	1.000
GROUND ELEVATION (ft)	90.0	$K_{G}$	0.997
HVHZ	NO	$K_z$	0.575

DESIGN CALCULATIONS			
VELOCITY PRESSURE ( $q$ ) = $.00256 \cdot K_e \cdot K_z \cdot K_{ZF} \cdot K_D \cdot V^2$			
VELOCITY PRESSURE (ASD) 10.8 psf			
WIDTH OF PRESSURE COEFFICIENT	41.3' * 10% = 4.13'	ZONE WIDTH A	4 FT
	15' * 40% = 6'	ZONE 2 WIDTH	N/A (FOR (°) < 7°)
		ZONE 3 WIDTH	N/A (FOR (°) < 7°)
EXTERNAL PRESSURE COEFFICIENT	ZONE 1	0.467	-1.506
	ZONE 1'	X	X
	ZONE 2e	0.467	-1.506
	ZONE 2n	0.467	-2.179
	ZONE 2r	0.467	-2.179
	ZONE 3e	0.467	-2.179
	ZONE 3r	0.467	-2.471
INTERNAL PRESSURE COEFFICIENT (+/-)	0.18		

DESIGN PRESSURES					
ROOF ZONE	DOWN	UP			
1	16.0	-18.2	psf		
1'	X	X	psf		
2e	16.0	-18.2	psf	Module allowable uplift pressure	88 psf
2n	16.0	-25.4	psf	Module allowable down pressure	125 psf
2r	16.0	-25.4	psf		
3e	16.0	-25.4	psf		
3r	16.0	-28.6	psf		

ARRAY FACTORS			
ARRAY EDGE FACTOR (EXPOSED)	1.5	SOLAR PANEL PRESSURE	
ARRAY EDGE FACTOR (NON-EXPOSED)	1	EQUALIZATION FACTOR	0.684

ADJUSTED DESIGN PRESSURES				
ROOF ZONE	DOWN	UP (Exposed)	UP (N. Exposed)	
1	16.0	-18.6	-16.0	psf
1'	X	X	X	psf
2e	16.0	-18.6	-16.0	psf
2n	16.0	-26.1	-17.4	psf
2r	16.0	-26.1	-17.4	psf
3e	16.0	-26.1	-17.4	psf
3r	16.0	-29.3	-19.5	psf

ATTACHMENTS USED		
ATTACHMENT MODEL	S-5 protea	
ATTACHMENT STRENGTH	422	lbs

MAX DESIGN LOADS ALLOWABLE						
LIMIT MAX SPAN TO		36 in				
RAFTER/SEAM SPACING		9 in		NO. OF RAILS	Exposed: 2	Non. Exp: 2
ROOF ZONE	DOWN	UP (Exposed)	UP (N. Exposed)	SPANS (E)	SPANS (N.E)	
1	137.0	159.6	137.0	36 in	36 in	
1'	X	X	X	X in	X in	
2e	137.0	159.6	137.0	36 in	36 in	
2n	137.0	223.2	148.8	36 in	36 in	
2r	137.0	223.2	148.8	36 in	36 in	
3e	137.0	223.2	148.8	36 in	36 in	
3r	137.0	250.8	167.2	36 in	36 in	

**Castillo Engineering**  
 SOLAR DONE RIGHT®  
 CASTILLO ENGINEERING SERVICES, LLC  
 COA # 28345  
 620 N. WYMORE ROAD, SUITE 250,  
 MAITLAND, FL 32751  
 TEL: (407) 289-2575  
 ERMOCRATES E. CASTILLO - FL PE 52590

COPYRIGHTED BY CASTILLO ENGINEERING SERVICES, LLC

REVISIONS		
DESCRIPTION	DATE	REV

PROJECT INSTALLER

**SUNPRO**

Digitally signed by Ermocrates E. Castillo  
 Date: 2021.07.21 19:00:11

STATE OF FLORIDA PROFESSIONAL ENGINEERING


PROJECT NAME

**DUPREE RESIDENCE**  
 1196 SW DAIRY ST,  
 LAKE CITY, FL 32024

SHEET NAME  
 STRUCTURE CALCULATION

SHEET SIZE  
 ANSI B  
 11" X 17"

SHEET NUMBER  
 S-02.1

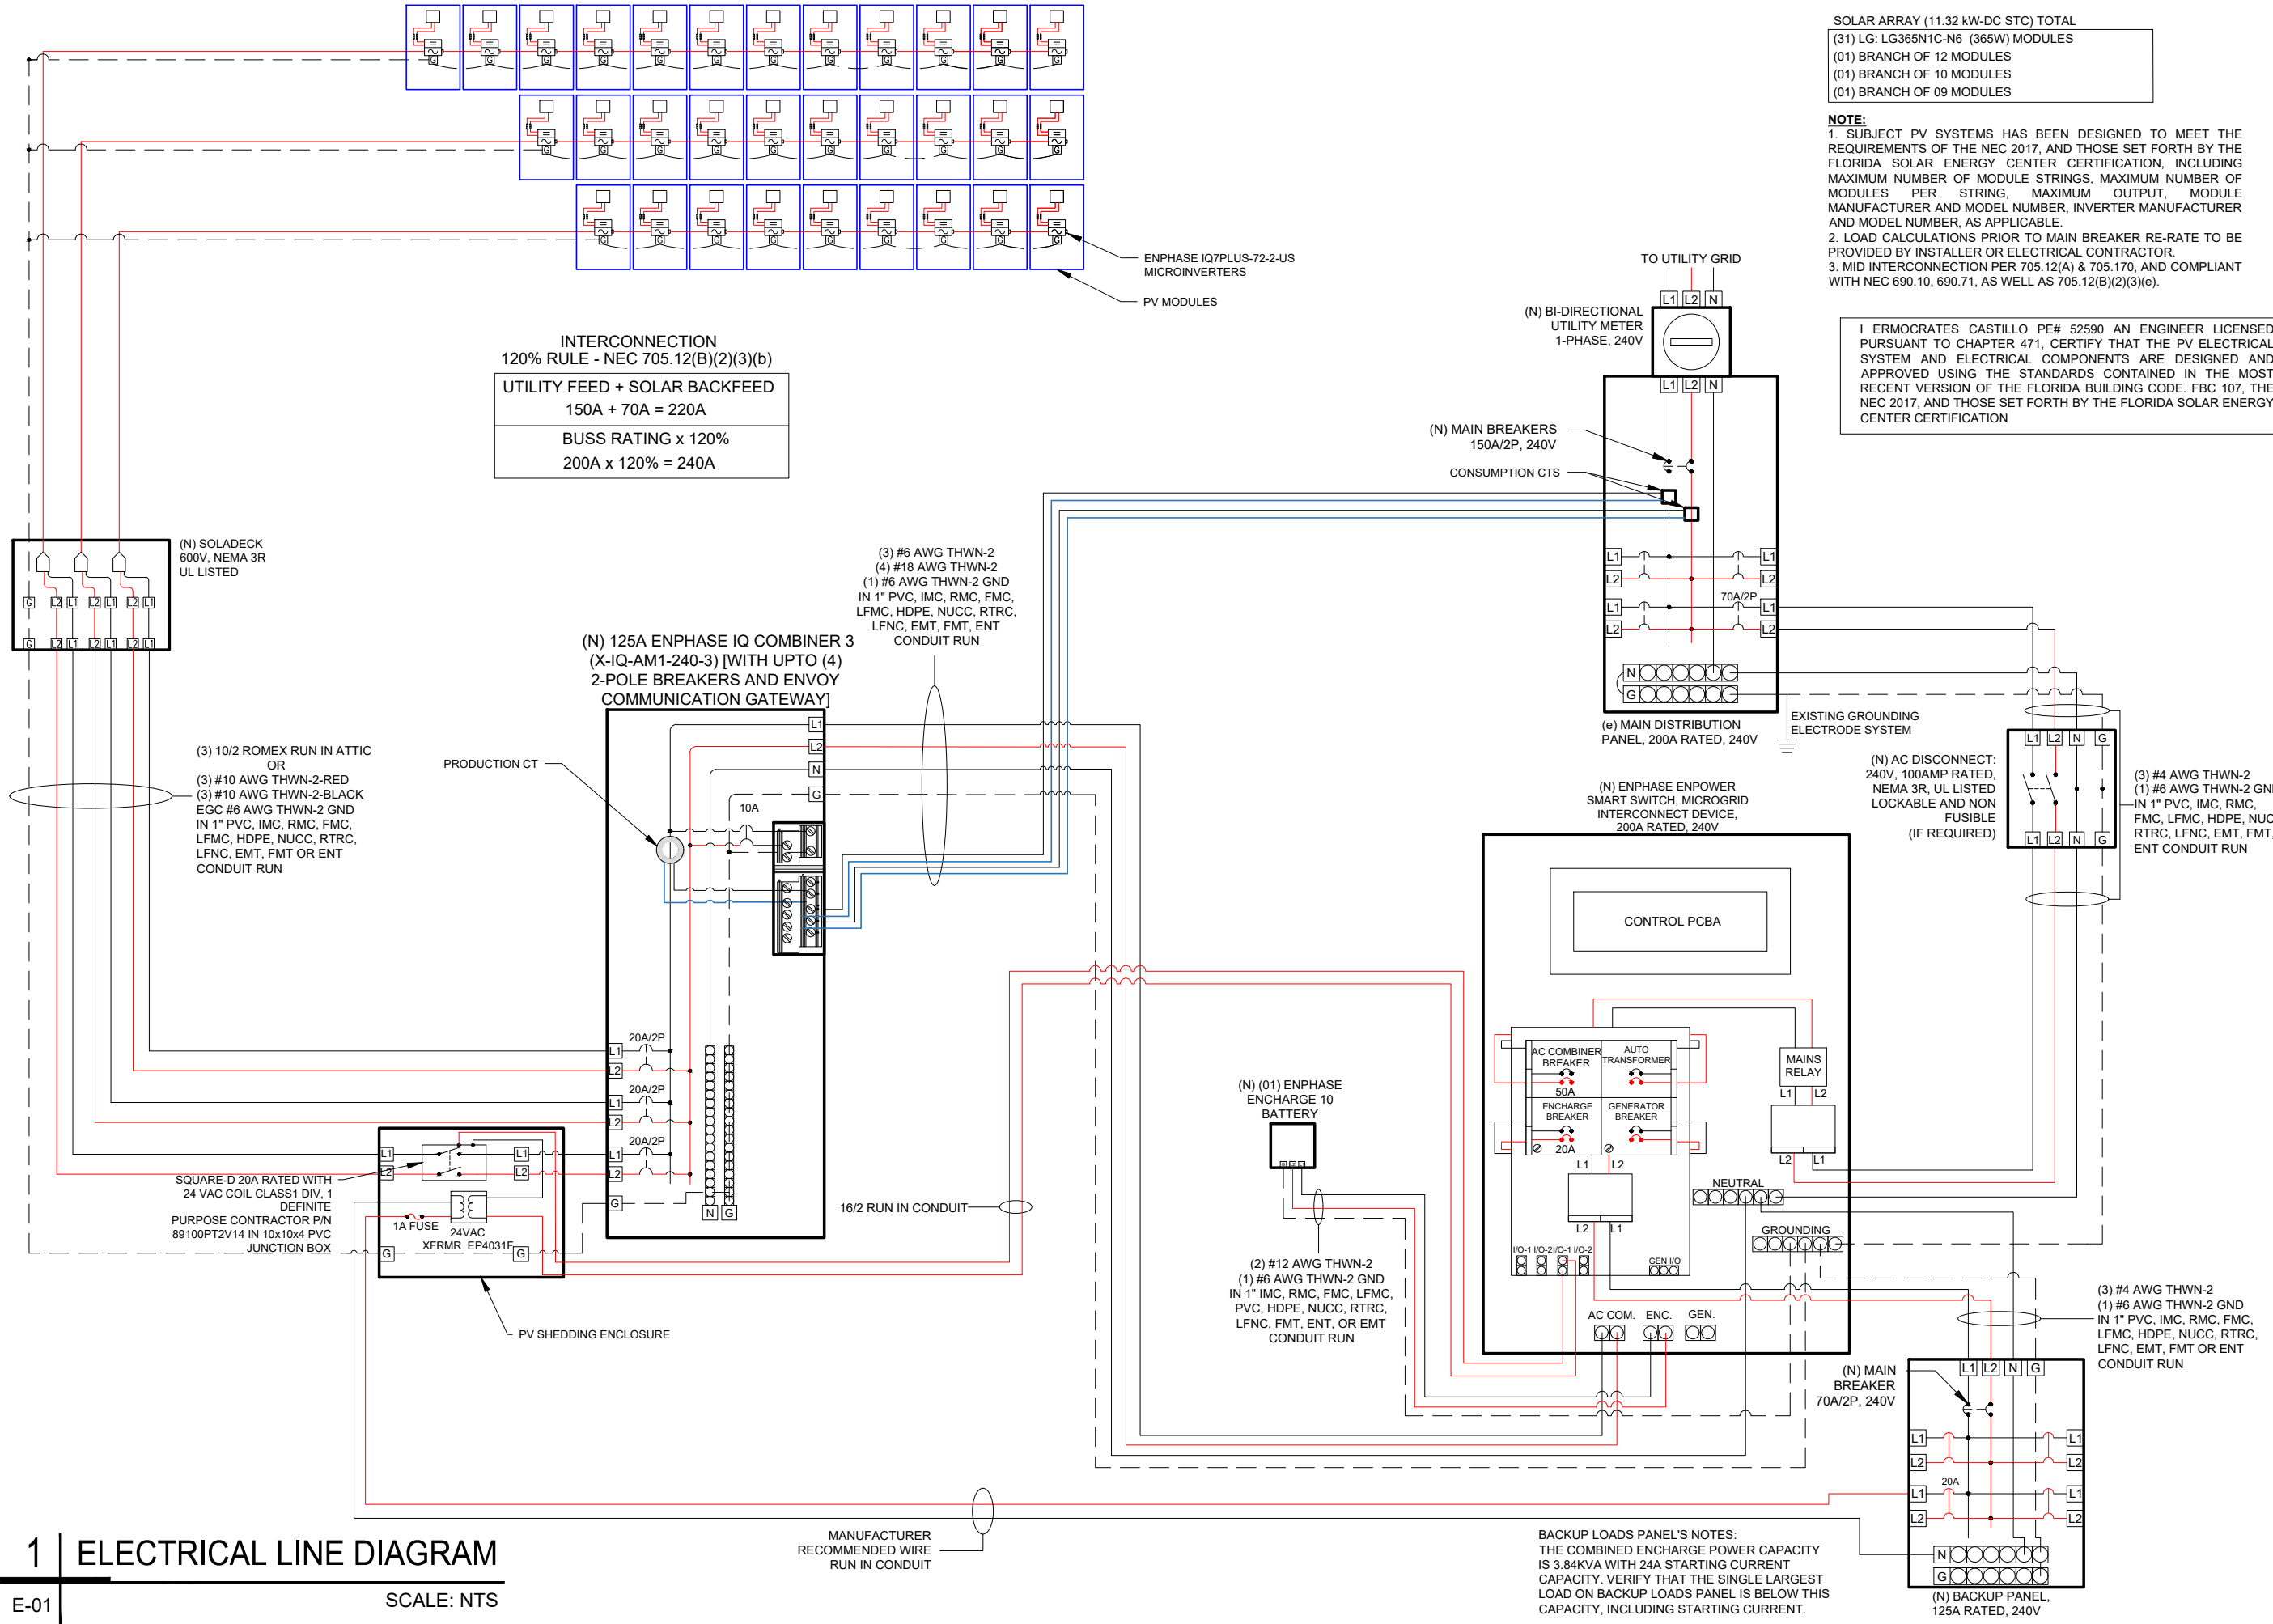

SOLAR ARRAY (11.32 kW-DC STC) TOTAL  
 (31) LG: LG365N1C-N6 (365W) MODULES  
 (01) BRANCH OF 12 MODULES  
 (01) BRANCH OF 10 MODULES  
 (01) BRANCH OF 09 MODULES

**NOTE:**  
 1. SUBJECT PV SYSTEMS HAS BEEN DESIGNED TO MEET THE REQUIREMENTS OF THE NEC 2017, AND THOSE SET FORTH BY THE FLORIDA SOLAR ENERGY CENTER CERTIFICATION, INCLUDING MAXIMUM NUMBER OF MODULE STRINGS, MAXIMUM NUMBER OF MODULES PER STRING, MAXIMUM OUTPUT, MODULE MANUFACTURER AND MODEL NUMBER, INVERTER MANUFACTURER AND MODEL NUMBER, AS APPLICABLE.  
 2. LOAD CALCULATIONS PRIOR TO MAIN BREAKER RE-RATE TO BE PROVIDED BY INSTALLER OR ELECTRICAL CONTRACTOR.  
 3. MID INTERCONNECTION PER 705.12(A) & 705.170, AND COMPLIANT WITH NEC 690.10, 690.71, AS WELL AS 705.12(B)(2)(3)(e).

I ERMOCRATES CASTILLO PE# 52590 AN ENGINEER LICENSED PURSUANT TO CHAPTER 471, CERTIFY THAT THE PV ELECTRICAL SYSTEM AND ELECTRICAL COMPONENTS ARE DESIGNED AND APPROVED USING THE STANDARDS CONTAINED IN THE MOST RECENT VERSION OF THE FLORIDA BUILDING CODE, FBC 107, THE NEC 2017, AND THOSE SET FORTH BY THE FLORIDA SOLAR ENERGY CENTER CERTIFICATION

INTERCONNECTION  
 120% RULE - NEC 705.12(B)(2)(3)(b)  
 UTILITY FEED + SOLAR BACKFEED  
 150A + 70A = 220A  
 BUSS RATING x 120%  
 200A x 120% = 240A

(N) SOLADECK  
 600V, NEMA 3R  
 UL LISTED

(3) #6 AWG THWN-2  
 (4) #18 AWG THWN-2  
 (1) #6 AWG THWN-2 GND  
 IN 1" PVC, IMC, RMC, FMC,  
 LFMC, HDPE, NUCC, RTRC,  
 LFNC, EMT, FMT, ENT  
 CONDUIT RUN

(N) 125A ENPHASE IQ COMBINER 3  
 (X-IQ-AM1-240-3) [WITH UPTO (4)  
 2-POLE BREAKERS AND ENVOY  
 COMMUNICATION GATEWAY]

(3) 10/2 ROMEX RUN IN ATTIC  
 OR  
 (3) #10 AWG THWN-2-RED  
 (3) #10 AWG THWN-2-BLACK  
 EGC #6 AWG THWN-2 GND  
 IN 1" PVC, IMC, RMC, FMC,  
 LFMC, HDPE, NUCC, RTRC,  
 LFNC, EMT, FMT OR ENT  
 CONDUIT RUN

SQUARE-D 20A RATED WITH  
 24 VAC COIL CLASS1 DIV. 1  
 DEFINITE  
 PURPOSE CONTRACTOR P/N  
 89100PT2V14 IN 10x10x4 PVC  
 JUNCTION BOX

PV SHEDDING ENCLOSURE

(N) (01) ENPHASE  
 ENCHARGE 10  
 BATTERY

(2) #12 AWG THWN-2  
 (1) #6 AWG THWN-2 GND  
 IN 1" IMC, RMC, FMC, LFMC,  
 PVC, HDPE, NUCC, RTRC,  
 LFNC, FMT, ENT, OR EMT  
 CONDUIT RUN

(N) AC DISCONNECT:  
 240V, 100AMP RATED,  
 NEMA 3R, UL LISTED  
 LOCKABLE AND NON  
 FUSIBLE  
 (IF REQUIRED)

(3) #4 AWG THWN-2  
 (1) #6 AWG THWN-2 GND  
 IN 1" PVC, IMC, RMC,  
 FMC, LFMC, HDPE, NUCC,  
 RTRC, LFNC, EMT, FMT,  
 ENT CONDUIT RUN

BACKUP LOADS PANEL'S NOTES:  
 THE COMBINED ENCHARGE POWER CAPACITY  
 IS 3.84KVA WITH 24A STARTING CURRENT  
 CAPACITY. VERIFY THAT THE SINGLE LARGEST  
 LOAD ON BACKUP LOADS PANEL IS BELOW THIS  
 CAPACITY, INCLUDING STARTING CURRENT.

**Castillo Engineering**  
 SOLAR DONE RIGHT®  
 CASTILLO ENGINEERING SERVICES, LLC  
 COA # 28345  
 620 N. WYMORE ROAD, SUITE 250,  
 MAITLAND, FL 32751  
 TEL: (407) 289-2575  
 ERMOCRATES E. CASTILLO - FL PE 52590

COPYRIGHTED BY CASTILLO ENGINEERING SERVICES, LLC

REVISIONS		
DESCRIPTION	DATE	REV

PROJECT INSTALLER



Digitally signed by:  
 Ermocrates Castillo  
 Date: 2021.07.21 19:00:12

PROJECT NAME

**DUPREE RESIDENCE**  
 1196 SW DAIRY ST,  
 LAKE CITY, FL 32024

SHEET NAME  
 ELECTRICAL LINE DIAGRAM

SHEET SIZE  
 ANSI B  
 11" X 17"

SHEET NUMBER  
 E-01

# AC CONDUCTOR AMPACITY CALCULATIONS: FROM ROOF TOP SOLADECK TO LOAD CENTER

MODULE MANUFACTURER	LG
MODULE MODEL	LG365N10-A6
INVERTER MANUFACTURER	ENPHASE
INVERTER MODEL	ENPHASE IQ 7 PLUS
MODULES/BRANCH CIRCUIT 1	12
MODULES/BRANCH CIRCUIT 2	10
MODULES/BRANCH CIRCUIT 3	9
TOTAL ARRAY POWER (KW)	11.32
SYSTEM AC VOLTAGE	240V 1-PHASE

DESIGN TEMPERATURE	
MIN. AMBIENT TEMP. °F	32
MAX. AMBIENT TEMP. °F	117
CALCULATED MAX. V <sub>DC</sub>	45
CALCULATED MIN V <sub>MP</sub>	27
CONDUIT FILL	
NUMBER OF CONDUITS	1

AMPACITY CALCULATIONS											
CIRCUIT	MAX AMPS	1.25 X MAX AMPS	AWG	90 °C AMPACITY	AMBIENT TEMP °F	TEMP DERATE	CONDUIT FILL	FILL DERATE	DERATED AMPACITY	MAXIMUM CIRCUIT BREAKER	
CIRCUIT 1	14.5	18.1	#10	40	130	0.76	6	0.8	24.32	20 A	
CIRCUIT 2	12.1	15.1	#10	40	130	0.76	6	0.8	24.32	20 A	
CIRCUIT 3	10.9	13.6	#10	40	130	0.76	6	0.8	24.32	20 A	
ENPHASE COMBINER OUTPUT	37.5	46.8	#6	75	95	0.96	3	1	72	50 A	
ENPOWER TO ENCHARGE	16.0	20.0	#12	30	95	0.96	3	1	28.8	20 A	
ENPOWER TO BACK UP PANEL	56.0	70.0	#4	95	95	0.96	3	1	91.2	70 A	
ENPOWER TO MAIN PANEL	56.0	70.0	#4	95	95	0.96	3	1	91.2	70 A	

MAXIMUM CIRCUIT VOLTAGE DROP	2%
------------------------------	----

VOLTAGE DROP CALCULATIONS					
CIRCUIT	AWG	CIRCULAR MILLS	I	V	MAX LENGTH
CIRCUIT 1	#10	10380	14.5	240	133 FEET
CIRCUIT 2	#10	10380	12.1	240	160 FEET
CIRCUIT 3	#10	10380	10.9	240	178 FEET
ENPHASE COMBINER OUTPUT	#6	26240	37.5	240	130 FEET
ENPOWER TO ENCHARGE	#12	6530	16.0	240	76 FEET
ENPOWER TO BACK UP PANEL	#4	41740	56.0	240	139 FEET
ENPOWER TO MAIN PANEL	#4	41740	56.0	240	139 FEET

NOTES	
TEMP DERATE BASED ON NEC TABLE 310.15(B)(2)(A)	
CONDUIT FILL DERATE BASED ON NEC TABLE 310.15(B)(3)(A)	
MAXIMUM V <sub>DC</sub> CALCULATED USING MODULE MANUFACTURE TEMPERATURE COEFFICIENTS PER NEC 690.7(A)	
UNLESS OTHERWISE SPECIFIED, ALL WIRING MUST BE THHN OR THWN-2 COPPER	
ALL WIRE SIZES LISTED ARE THE MINIMUM ALLOWABLE	
<span style="background-color: #90EE90;"> </span> IN ANY CELL INDICATES THAT THE SYSTEM IS SAFE AND COMPLIES WITH NEC REQUIREMENTS	
<span style="background-color: #FF0000;"> </span> IN ANY CELL INDICATES A POTENTIALLY UNSAFE CONDITION	
<span style="background-color: #FFFF00;"> </span> INFORMATION INPUT BY SYSTEM DESIGNER	
<span style="background-color: #ADD8E6;"> </span> INFORMATION OBTAINED FROM MANUFACTURER DATASHEETS	

I ERMOCRATES CASTILLO PE# 52590 AN ENGINEER LICENSED PURSUANT TO CHAPTER 471, CERTIFY THAT THE PV ELECTRICAL SYSTEM AND ELECTRICAL COMPONENTS ARE DESIGNED AND APPROVED USING THE STANDARDS CONTAINED IN THE MOST RECENT VERSION OF THE FLORIDA BUILDING CODE. FBC 107, THE NEC 2017, AND THOSE SET FORTH BY THE FLORIDA SOLAR ENERGY CENTER CERTIFICATION

# AC CONDUCTOR AMPACITY CALCULATIONS: FROM AC COMBINER BOX TO MSP

MODULE PROPERTIES			
V <sub>DC</sub>	41.6	I <sub>SC</sub>	11.27
V <sub>MPP</sub>	34.5	I <sub>MP</sub>	10.58
T <sub>C V<sub>DC</sub></sub>	-0.26%/°C	T <sub>C V<sub>MP</sub></sub>	-0.34%/°C
P <sub>MP</sub>	365.0	N <sub>DDT</sub>	45 °C

INVERTER PROPERTIES	
OUTPUT VOLTAGE	240 L-L 1-PH
MAX INPUT DC VOLTAGE	60 V <sub>DC</sub>
OPERATING RANGE	16 - 60 V <sub>DC</sub>
MPPT VOLTAGE RANGE	27 - 45 V <sub>DC</sub>
START VOLTAGE	22 V <sub>DC</sub>
MAX INPUT POWER	440 W <sub>DC</sub>
CONTINUOUS AC POWER	290 VA

## ELECTRICAL NOTES

- ALL EQUIPMENT TO BE LISTED BY UL OR OTHER NRTL, AND LABELED FOR ITS APPLICATION.
- ALL CONDUCTORS SHALL BE COPPER, RATED FOR 600 V AND 90 DEGREE C WET ENVIRONMENT. THE TERMINALS ARE RATED FOR 75 DEGREE C.
- THE WIRES ARE SIZED ACCORDING TO NEC 110.14.
- WIRING, CONDUIT, AND RACEWAYS MOUNTED ON ROOFTOPS SHALL BE ROUTED DIRECTLY TO, AND LOCATED AS CLOSE AS POSSIBLE TO THE NEAREST RIDGE, HIP, OR VALLEY.
- WORKING CLEARANCES AROUND ALL NEW AND EXISTING ELECTRICAL EQUIPMENT SHALL COMPLY WITH NEC 110.26.
- DRAWINGS INDICATE THE GENERAL ARRANGEMENT OF SYSTEMS. CONTRACTOR SHALL FURNISH ALL NECESSARY OUTLETS, SUPPORTS, FITTINGS AND ACCESSORIES TO FULFILL APPLICABLE CODES AND STANDARDS.
- WHERE SIZES OF JUNCTION BOXES, RACEWAYS, AND CONDUITS ARE NOT SPECIFIED, THE CONTRACTOR SHALL SIZE THEM ACCORDINGLY.
- ALL WIRE TERMINATIONS SHALL BE APPROPRIATELY LABELED AND READILY VISIBLE.
- MODULE GROUNDING CLIPS TO BE INSTALLED BETWEEN MODULE FRAME AND MODULE SUPPORT RAIL, PER THE GROUNDING CLIP MANUFACTURER'S INSTRUCTION.
- MODULE SUPPORT RAIL TO BE BONDED TO CONTINUOUS COPPER G.E.C. VIA WEEB LUG OR ILSCO GBL-4DBT LAY-IN LUG.
- THE POLARITY OF THE GROUNDED CONDUCTORS IS NEGATIVE .
- UTILITY HAS 24-HR UNRESTRICTED ACCESS TO ALL PHOTOVOLTAIC SYSTEM COMPONENTS LOCATED AT THE SERVICE ENTRANCE.
- MODULES CONFORM TO AND ARE LISTED UNDER UL 1703.
- RACKING CONFORMS TO AND IS LISTED UNDER UL 2703.
- CONDUCTORS EXPOSED TO SUNLIGHT SHALL BE LISTED AS SUNLIGHT RESISTANT PER NEC ARTICLE 300.6 (C) (1) AND ARTICLE 310.10 (D).
- CONDUCTORS EXPOSED TO WET LOCATIONS SHALL BE SUITABLE FOR USE IN WET LOCATIONS PER NEC ARTICLE 310.10 (C).

ENPHASE IQ7PLUS-72-2-US MICROINVERTER		
Input Data (DC)		
Recommended Input Power (STC)		245-400W +
Maximum Input DC Voltage		60V
Peak Power Tracking Voltage		27V-45V
Operating Range		16V-60V
Min. / Max. Start Voltage		22V / 60V
Max DC Short Circuit Current		15A
Output Data (AC)		
Maximum Output Power		290W
Nominal Output Current		1.21A
Nominal Voltage / Range		240V/211-264V
Nominal Frequency / Range		60 Hz
Extended Frequency / Range		47-68 Hz
Power Factor at rated power		1.0
Maximum unit per 20A Branch Circuit		13 (240 VAC)



CASTILLO ENGINEERING SERVICES, LLC  
COA # 28345  
620 N. WYMORE ROAD, SUITE 250,  
MAITLAND, FL 32751  
TEL: (407) 289-2575  
ERMOCRATES E. CASTILLO - FL PE 52590

COPYRIGHTED BY CASTILLO ENGINEERING SERVICES, LLC

REVISIONS		
DESCRIPTION	DATE	REV

PROJECT INSTALLER



Digitally signed by:  
Ermocrates E. Castillo  
Date: 2021.07.21 19:00:13

PROJECT NAME

**DUPREE RESIDENCE**  
1196 SW DAIRY ST,  
LAKE CITY, FL 32024

SHEET NAME

WIRING CALCULATIONS

SHEET SIZE  
**ANSI B  
11" X 17"**

SHEET NUMBER  
**E-02**

# WARNING

**ELECTRIC SHOCK HAZARD**  
TERMINALS ON BOTH LINE AND  
LOAD SIDES MAY BE ENERGIZED  
IN THE OPEN POSITION

LABEL LOCATION:  
AC DISCONNECT, POINT OF INTERCONNECTION  
(PER CODE: NEC 690.13(B))

# WARNING DUAL POWER SOURCE SECOND SOURCE IS PHOTOVOLTAIC SYSTEM

LABEL LOCATION:  
POINT OF INTERCONNECTION  
(PER CODE: NEC 705.12(B)(2)(3)(b))

# PHOTOVOLTAIC SYSTEM WITH RAPID SHUTDOWN SWITCH

LABEL LOCATION:  
AC DISCONNECT  
(PER CODE: NEC690.56(C)(3))

- ADHESIVE FASTENED SIGNS:
- THE LABEL SHALL BE SUITABLE FOR THE ENVIRONMENT WHERE IT IS INSTALLED.
  - WHERE REQUIRED ELSEWHERE IN THIS CODE, ALL FIELD APPLIED LABELS, WARNINGS, AND MARKINGS SHOULD COMPLY WITH ANSI Z535.4 [NEC 110.21(B) FIELD MARKING].
  - ADHESIVE FASTENED SIGNS MAY BE ACCEPTABLE IF PROPERLY ADHERED. VINYL SIGNS SHALL BE WEATHER RESISTANT [IFC 605.11.1.3]

# SOLAR CONNECTION LINE SIDE TAP

LABEL LOCATION:  
POINT OF INTERCONNECTION  
(PER CODE: NEC 705.12(A))

# AC COMBINER BOX

LABEL LOCATION:  
COMBINER BOX  
(PER CODE: NEC690.52)

# SOLAR BREAKER

LABEL LOCATION:  
POINT OF INTERCONNECTION  
(PER CODE: NEC 705.12(B)(2)(3)(b))

# PHOTOVOLTAIC SYSTEM AC DISCONNECT RATED AC OPERATING CURRENT 37.5 AMPS AC NOMINAL OPERATING VOLTAGE 240 VOLTS

LABEL LOCATION:  
AC DISCONNECT, POINT OF INTERCONNECTION  
(PER CODE: NEC690.54)

# WARNING INVERTER OUTPUT CONNECTION DO NOT RELOCATE THIS OVERCURRENT DEVICE

LABEL LOCATION:  
POINT OF INTERCONNECTION  
(PER CODE: NEC 705.12(B)(2)(3)(b))

DATA PER PANEL

NOMINAL OPERATING AC VOLTAGE -	240	V
NOMINAL OPERATING AC FREQUENCY-	60	Hz
MAXIMUM AC POWER-	290	VA
MAXIMUM AC CURRENT-	1.21	A
MAXIMUM OVERCURRENT DEVICE RATING FOR AC MODULE PROTECTION PER CIRCUIT-	20	A

LABEL LOCATION:  
COMBINER BOX  
(PER CODE: NEC690.52)

# AC DISCONNECT

LABEL LOCATION:  
AC DISCONNECT, POINT OF INTERCONNECTION  
(PER CODE: NEC690.54)

# PHOTOVOLTAIC SYSTEM MICROINVERTERS LOCATED UNDER EACH PV MODULE IN ROOF TOP ARRAY


LABEL LOCATION:  
INVERTER  
(PER CODE: NEC690.52)

# 11.32 KW SOLAR DISCONNECT LOCATED

LABEL LOCATION:  
AC DISCONNECT, POINT OF INTERCONNECTION  
(PER CODE: NEC690.54)

# SOLAR PV SYSTEM EQUIPPED WITH RAPID SHUTDOWN

TURN RAPID SHUTDOWN  
SWITCH TO THE  
"OFF" POSITION TO  
SHUT DOWN PV SYSTEM  
AND REDUCE  
SHOCK HAZARD  
IN THE ARRAY

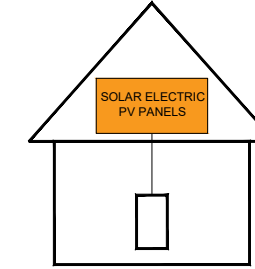

LABEL LOCATION:  
AC DISCONNECT, POINT OF INTERCONNECTION  
(PER CODE: NEC 690.56(C)(1)(a), IFC 605.11.3.1(1))

REVISIONS		
DESCRIPTION	DATE	REV

PROJECT INSTALLER



Digitally signed by:  
Ermocrates E Castillo  
Date: 2021.07.21 19:00:14

PROJECT NAME

DUPREE RESIDENCE  
1196 SW DAIRY ST,  
LAKE CITY, FL 32024

SHEET NAME  
SYSTEM LABELING

SHEET SIZE  
ANSI B  
11" X 17"


SHEET NUMBER  
E-03

# LG NeON<sup>®</sup>2

LG365N1C-A6

## 365W

The LG NeON<sup>®</sup> 2 is LG's best selling solar module and one of the most powerful and versatile modules on the market today. The cells are designed to appear all-black at a distance, and the performance warranty guarantees 90.6% of labeled power output at 25 years.

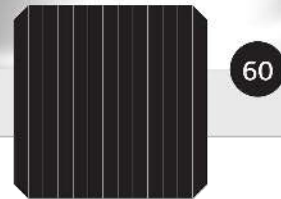

### Features



#### Enhanced Performance Warranty

LG NeON<sup>®</sup> 2 has an enhanced performance warranty. After 25 years, LG NeON<sup>®</sup> 2 is guaranteed at least 90.6% of initial performance.



#### 25-Year Limited Product Warranty

The NeON<sup>®</sup> 2 is covered by a 25-year limited product warranty. In addition, up to \$450 of labor costs will be covered in the rare case that a module needs to be repaired or replaced.



#### Solid Performance on Hot Days

LG NeON<sup>®</sup> 2 performs well on hot days due to its low temperature coefficient.



#### Roof Aesthetics

LG NeON<sup>®</sup> 2 has been designed with aesthetics in mind using thinner wires that appear all black at a distance.

When you go solar, ask for the brand you can trust: LG Solar

#### About LG Electronics USA, Inc.

LG Electronics is a global leader in electronic products in the clean energy markets by offering solar PV panels and energy storage systems. The company first embarked on a solar energy source research program in 1985, supported by LG Group's vast experience in the semi-conductor, LCD, chemistry and materials industries. In 2010, LG Solar successfully released its first Mono<sup>®</sup> series to the market, which is now available in 32 countries. The NeON<sup>®</sup> (previous Mono<sup>®</sup> NeON), NeON<sup>®</sup>2, NeON<sup>®</sup>2 Bifacial won the "Intersolar AWARD" in 2013, 2015 and 2016, which demonstrates LG's leadership and innovation in the solar industry.



# LG NeON<sup>®</sup>2

LG365N1C-A6

#### General Data

Cell Properties (Material/Type)	Monocrystalline/N-type
Cell Maker	LG
Cell Configuration	60 Cells (6 x 10)
Module Dimensions (L x W x H)	1,740mm x 1,042mm x 40mm
Weight	18.6 kg
Glass (Material)	Tempered Glass with AR Coating
Backsheet (Color)	White
Frame (Material)	Anodized Aluminium
Junction Box (Protection Degree)	IP 68 with 3 Bypass Diodes
Cables (Length)	1,100mm x 2EA
Connector (Type/Maker)	MC 4/MC

#### Certifications and Warranty

Certifications <sup>1</sup>	IEC 61215-1/-1-1/2 : 2016, IEC 61730-1/2 : 2016, UL 61730-1 : 2017, UL 61730-2 : 2017, ISO 9001, ISO 14001, ISO 50001
	OH-SAS 18001
Salt Mist Corrosion Test	IEC 61701:2011 Severity 6
Ammonia Corrosion Test	IEC 62716 : 2013
Module Fire Performance	Type 1 (UL 61730)
Fire Rating	Class C (UL 790)
Solar Module Product Warranty	25 Year Limited
Solar Module Output Warranty	Linear Warranty*

\*Improved: 1<sup>st</sup> year 98.5%, from 2-24th year: -0.33%/year down, 90.6% at year 25

#### Temperature Characteristics


NMOT <sup>2</sup>	[°C]	42 ± 3
Pmax	[%/°C]	-0.34
Voc	[%/°C]	-0.26
Isc	[%/°C]	0.03

<sup>2</sup>NMOT (Nominal Module Operating Temperature): Irradiance: 800 W/m<sup>2</sup>, Ambient temperature: 20°C, Wind speed 1 m/s, Spectrum AM 1.5

#### Electrical Properties (NMOT)

Model	LG365N1C-A6	
Maximum Power (Pmax)	[W]	365
MPP Voltage (Vmpp)	[V]	32.4
MPP Current (Impp)	[A]	8.44
Open Circuit Voltage (Voc)	[V]	39.2
Short Circuit Current (Isc)	[A]	9.06

#### I-V Curves

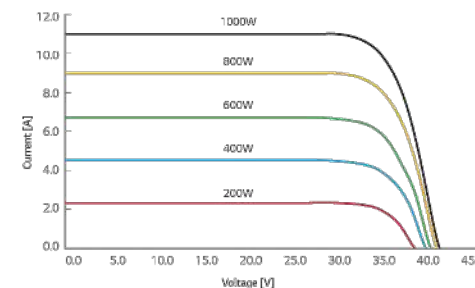

#### Electrical Properties (STC\*)

Model	LG365N1C-A6	
Maximum Power (Pmax)	[W]	365
MPP Voltage (Vmpp)	[V]	34.5
MPP Current (Impp)	[A]	10.58
Open Circuit Voltage (Voc, ± 5%)	[V]	41.6
Short Circuit Current (Isc, ± 5%)	[A]	11.27
Module Efficiency	[%]	20.1
Bifaciality Coefficient of Power	[%]	10
Power Tolerance	[%]	0 - +3

\*STC (Standard Test Condition): Irradiance 1000 W/m<sup>2</sup>, cell temperature 25°C, AM 1.5  
Measure tolerance of Pmax: ± 3%

#### Operating Conditions


Operating Temperature	[°C]	-40 - +85
Maximum System Voltage	[V]	1,000
Maximum Series Fuse Rating	[A]	20
Mechanical Test Load <sup>1</sup> (Front)	[Pa/psf]	5,400
Mechanical Test Load <sup>1</sup> (Rear)	[Pa/psf]	4,000

<sup>1</sup>Based on IEC 61215-2 : 2016 (Test Load = Design Load x Safety Factor (1.5))  
Mechanical Test Loads 6,000Pa / 5,400Pa based on IEC 61215 : 2005

#### Packaging Configuration

Number of Modules per Pallet	[EA]	25
Number of Modules per 40' Container	[EA]	650
Number of Modules per 53' Container	[EA]	850
Packaging Box Dimensions (L x W x H)	[mm]	1,790 x 1,120 x 1,213
Packaging Box Dimensions (L x W x H)	[in]	70.5 x 44.1 x 47.8
Packaging Box Gross Weight	[kg]	500
Packaging Box Gross Weight	[lb]	1,102

#### Dimensions (mm/inch)

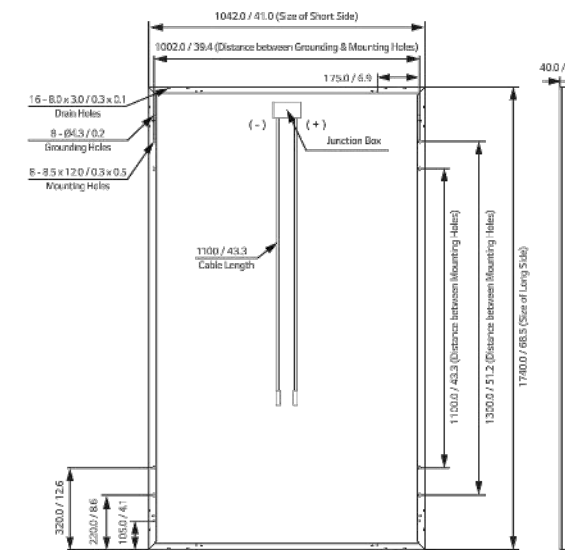

**CASTILLO ENGINEERING SERVICES, LLC**  
COA # 28345  
620 N. WYMORE ROAD, SUITE 250,  
MAITLAND, FL 32751  
TEL: (407) 289-2575  
ERMOCRATES E. CASTILLO - FL PE 52590

COPYRIGHTED BY  
CASTILLO ENGINEERING SERVICES, LLC

#### REVISIONS

DESCRIPTION	DATE	REV

#### PROJECT INSTALLER



Digitally signed by:  
Ermocrates E Castillo  
Date: 2021.07.21 19:00:15

#### PROJECT NAME

DUPREE RESIDENCE

1196 SW DAIRY ST,  
LAKE CITY, FL 32024

#### SHEET NAME

DATA SHEET

#### SHEET SIZE

ANSI B  
11" X 17"

#### SHEET NUMBER

DS-01



LG Electronics USA, Inc.  
Solar Business Division  
2000 Millbrook Drive  
Lincolnshire, IL 60069  
www.lg-solar.com

Product specifications are subject to change without notice.  
LG365N1C-A6.pdf  
011821

© 2021 LG Electronics USA, Inc. All rights reserved.



**LG Electronics U.S.A., Inc.**  
 111 Sylvan Avenue  
 Englewood Cliffs, NJ 07632  
 201.816.2000

Friday, February 5, 2021

**RE: Mechanical Load Testing to Determine Structural Performance under Uniform Static Pressure**

To: Castillo Engineering,


Upon your request we have conducted in house tests to determine the structural performance of the LG Module frames listed below. Our test results meet the requirements you presented in our conference call on January 29<sup>th</sup>. We will present the test criteria, results, and product limitations that may result from these test conditions in this letter.

The specifications and conditions presented in this letter apply retroactively to the following LG module(s);

	2 Rails	3 Rails
<b>Front</b>	9,000Pa	9,000Pa
<b>Rear</b>	6,350Pa	9,000Pa
<b>Model</b>	LGxxxN1C(K)-N5(L5), LGxxxN1C(K)-A6(B6) LGxxxQ1C(K)-V5, LGxxxQ1C(K)-A6	

\*The result is based on test load.

Our R&D department has tested these modules to determine the structural performance of under uniform static loading to represent the effects of a wind load on the module. This test was designed only to determine structural performance; the revised specifications apply only to the mechanical performance of the module. *A safety factor of 1.5 should be applied to these test loads for obtaining design loads. It is not recommend designing any system to the full test load.*

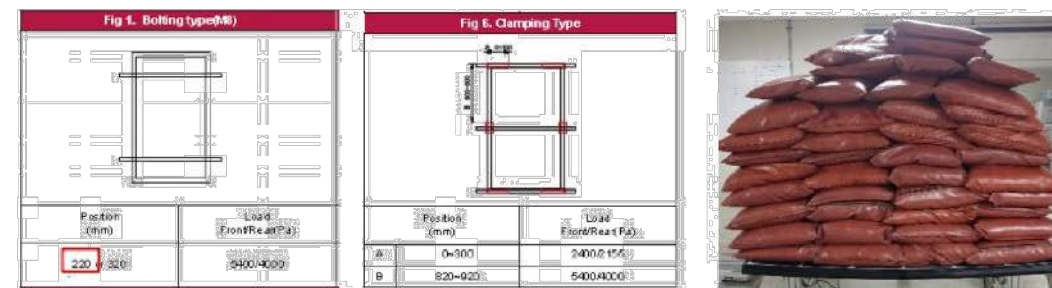

The scope of this test does not include electrical functionality or performance testing. Subjecting the module to these pressures may result in power degradation or total power loss. The electrical function and power generation warranties and specifications of these products are not altered by this document.

If you have any additional questions or concerns about this letter or the test protocol, contact your LG Solar Sales Representative.



**CASTILLO ENGINEERING SERVICES, LLC**  
 COA # 28345  
 620 N. WYMORE ROAD,  
 SUITE 250,  
 MAITLAND, FL 32751  
 TEL: (407) 289-2575  
 ERMOCRATES E. CASTILLO - FL PE 52590

COPYRIGHTED BY  
 CASTILLO ENGINEERING  
 SERVICES, LLC

REVISIONS		
DESCRIPTION	DATE	REV

PROJECT INSTALLER



Digitally signed by:  
 Ermocrates E Castillo  
 Date: 2021.07.21 19:00:17

STATE OF FLORIDA  
 PROFESSIONAL ENGINEERING

PROJECT NAME

**DUPREE RESIDENCE**  
 1196 SW DAIRY ST,  
 LAKE CITY, FL 32024

SHEET NAME  
 DATA SHEET

SHEET SIZE  
 ANSI B  
 11" X 17"

SHEET NUMBER  
 DS-02

# Enphase IQ 7 and IQ 7+ Microinverters

The high-powered smart grid-ready **Enphase IQ 7 Micro™** and **Enphase IQ 7+ Micro™** dramatically simplify the installation process while achieving the highest system efficiency.

Part of the Enphase IQ System, the IQ 7 and IQ 7+ Microinverters integrate seamlessly with the Enphase IQ Envoy™, Enphase Q Aggregator™, Enphase IQ Battery™, and the Enphase Enlighten™ monitoring and analysis software.

IQ Series Microinverters extend the reliability standards set forth by previous generations and undergo over a million hours of power-on testing, enabling Enphase to provide an industry-leading warranty of up to 25 years.



### Easy to Install

- Lightweight and simple
- Faster installation with improved, lighter two-wire cabling
- Built-in rapid shutdown compliant (NEC 2014 & 2017)

### Productive and Reliable

- Optimized for high powered 60-cell and 72-cell\* modules
- More than a million hours of testing
- Class II double-insulated enclosure
- UL listed

### Smart Grid Ready

- Complies with advanced grid support, voltage and frequency ride-through requirements
- Remotely updates to respond to changing grid requirements
- Configurable for varying grid profiles
- Meets CA Rule 21 (UL 1741-SA)

\* The IQ 7+ Micro is required to support 72-cell modules.



To learn more about Enphase offerings, visit [enphase.com](https://enphase.com)



## Enphase IQ 7 and IQ 7+ Microinverters

INPUT DATA (DC)	IQ7-60-2-US	IQ7PLUS-72-2-US	
Commonly used module pairings <sup>1</sup>	235 W - 350 W +	235 W - 440 W +	
Module compatibility	60-cell PV modules only	60-cell and 72-cell PV modules	
Maximum input DC voltage	48 V	60 V	
Peak power tracking voltage	27 V - 37 V	27 V - 45 V	
Operating range	16 V - 48 V	16 V - 60 V	
Min/Max start voltage	22 V / 48 V	22 V / 60 V	
Max DC short circuit current (module Isc)	15 A	15 A	
Overvoltage class DC port	II	II	
DC port backfeed current	0 A	0 A	
PV array configuration	1 x 1 ungrounded array; No additional DC side protection required; AC side protection requires max 20A per branch circuit		
OUTPUT DATA (AC)	IQ 7 Microinverter	IQ 7+ Microinverter	
Peak output power	250 VA	295 VA	
Maximum continuous output power	240 VA	290 VA	
Nominal (L-L) voltage/range <sup>2</sup>	240 V / 211-264 V	208 V / 183-229 V	240 V / 211-264 V
Maximum continuous output current	1.0 A	1.15 A	1.21 A
Nominal frequency	60 Hz	60 Hz	
Extended frequency range	47 - 68 Hz	47 - 68 Hz	
AC short circuit fault current over 3 cycles	5.8 Arms	5.8 Arms	
Maximum units per 20 A (L-L) branch circuit <sup>3</sup>	16 (240 VAC) 13 (208 VAC)	13 (240 VAC) 11 (208 VAC)	
Overvoltage class AC port	III	III	
AC port backfeed current	0 A	0 A	
Power factor setting	1.0	1.0	
Power factor (adjustable)	0.7 leading ... 0.7 lagging	0.7 leading ... 0.7 lagging	
EFFICIENCY	@240 V	@208 V	@240 V
Peak CEC efficiency	97.6 %	97.6 %	97.5 %
CEC weighted efficiency	97.0 %	97.0 %	97.0 %
MECHANICAL DATA	IQ 7 Microinverter		
Ambient temperature range	-40°C to +65°C		
Relative humidity range	4% to 100% (condensing)		
Connector type	MC4 (or Amphenol H4 UTX with additional Q-DCC-5 adapter)		
Dimensions (WxHxD)	212 mm x 175 mm x 30.2 mm (without bracket)		
Weight	1.08 kg (2.38 lbs)		
Cooling	Natural convection - No fans		
Approved for wet locations	Yes		
Pollution degree	PD3		
Enclosure	Class II double-insulated, corrosion resistant polymeric enclosure		
Environmental category / UV exposure rating	NEMA Type 6 / outdoor		
FEATURES			
Communication	Power Line Communication (PLC)		
Monitoring	Enlighten Manager and MyEnlighten monitoring options. Both options require installation of an Enphase IQ Envoy.		
Disconnecting means	The AC and DC connectors have been evaluated and approved by UL for use as the load-break disconnect required by NEC 690.		
Compliance	CA Rule 21 (UL 1741-SA) UL 62109-1, UL1741/IEEE1547, FCC Part 15 Class B, ICES-0003 Class B, CAN/CSA-C22.2 NO. 107.1-01 This product is UL Listed as PV Rapid Shut Down Equipment and conforms with NEC-2014 and NEC-2017 section 690.12 and C22.1-2015 Rule 64-218 Rapid Shutdown of PV Systems, for AC and DC conductors, when installed according manufacturer's instructions.		

1. No enforced DC/AC ratio. See the compatibility calculator at <https://enphase.com/en-us/support/module-compatibility>.  
 2. Nominal voltage range can be extended beyond nominal if required by the utility.  
 3. Limits may vary. Refer to local requirements to define the number of microinverters per branch in your area.

To learn more about Enphase offerings, visit [enphase.com](https://enphase.com)

© 2018 Enphase Energy. All rights reserved. All trademarks or brands used are the property of Enphase Energy, Inc. 2018-02-08



REVISIONS		
DESCRIPTION	DATE	REV

### PROJECT INSTALLER



Digitally signed by:  
 Ermocrates E. Castillo  
 Date: 2021.07.21 19:00:18

### PROJECT NAME

**DUPREE RESIDENCE**  
 1196 SW DAIRY ST,  
 LAKE CITY, FL 32024

### SHEET NAME

DATA SHEET

### SHEET SIZE


ANSI B  
 11" X 17"

### SHEET NUMBER

DS-03

## Enphase IQ Combiner 3 (X-IQ-AM1-240-3)

The **Enphase IQ Combiner 3™** with Enphase IQ Envoy™ consolidates interconnection equipment into a single enclosure and streamlines PV and storage installations by providing a consistent, pre-wired solution for residential applications. It offers up to four 2-pole input circuits and Eaton BR series busbar assembly.

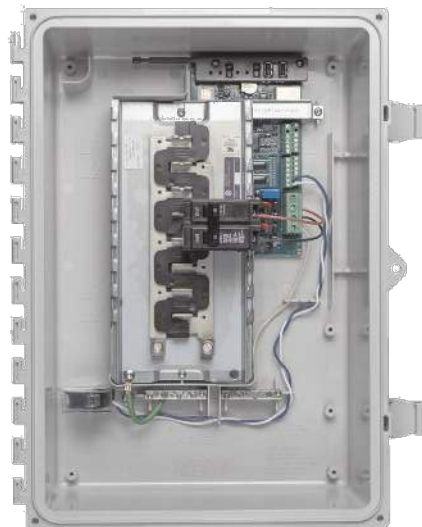

### Smart

- Includes IQ Envoy for communication and control
- Flexible networking supports Wi-Fi, Ethernet, or cellular
- Optional AC receptacle available for PLC bridging
- Provides production metering and optional consumption monitoring

### Simple

- Reduced size from previous combiner
- Centered mounting brackets support single stud mounting
- Supports back and side conduit entry
- Up to four 2-pole branch circuits for 240 VAC plug-in breakers (not included)
- 80 A total PV or storage branch circuits

### Reliable

- Durable NRTL-certified NEMA type 3R enclosure
- Five-year warranty
- UL listed



LISTED  
To learn more about Enphase offerings, visit [enphase.com](http://enphase.com)



## Enphase IQ Combiner 3

MODEL NUMBER	
IQ Combiner 3 X-IQ-AM1-240-3	IQ Combiner 3 with Enphase IQ Envoy™ printed circuit board for integrated revenue grade PV production metering (ANSI C12.20 +/- 0.5%) and optional* consumption monitoring (+/- 2.5%).
ACCESSORIES and REPLACEMENT PARTS (not included, order separately)	
Enphase Mobile Connect™ CELLMODEM-03 (4G / 12-year data plan) CELLMODEM-01 (3G / 5-year data plan) CELLMODEM-M1 (4G based LTE-M / 5-year data plan)	Plug and play industrial grade cellular modem with data plan for systems up to 60 microinverters. (Available in the US, Canada, Mexico, Puerto Rico, and the US Virgin Islands, where there is adequate cellular service in the installation area.)
Consumption Monitoring* CT CT-200-SPLIT	Split core current transformers enable whole home consumption metering (+/- 2.5%).
Circuit Breakers BRK-10A-2-240 BRK-15A-2-240 BRK-20A-2P-240	Supports Eaton BR210, BR215, BR220, BR230, BR240, BR250, and BR260 circuit breakers. Circuit breaker, 2 pole, 10A, Eaton BR210 Circuit breaker, 2 pole, 15A, Eaton BR215 Circuit breaker, 2 pole, 20A, Eaton BR220
EPLC-01	Power line carrier (communication bridge pair), quantity 2
XA-PLUG-120-3	Accessory receptacle for Power Line Carrier in IQ Combiner 3 (required for EPLC-01)
XA-ENV-PCBA-3	Replacement IQ Envoy printed circuit board (PCB) for Combiner 3
ELECTRICAL SPECIFICATIONS	
Rating	Continuous duty
System voltage	120/240 VAC, 60 Hz
Eaton BR series busbar rating	125 A
Max. continuous current rating (output to grid)	65 A
Max. fuse/circuit rating (output)	90 A
Branch circuits (solar and/or storage)	Up to four 2-pole Eaton BR series Distributed Generation (DG) breakers only (not included)
Max. continuous current rating (input from PV)	64 A
Max. total branch circuit breaker rating (input)	80A of distributed generation / 90A with IQ Envoy breaker included
Production Metering CT	200 A solid core pre-installed and wired to IQ Envoy
MECHANICAL DATA	
Dimensions (WxHxD)	49.5 x 37.5 x 16.8 cm (19.5" x 14.75" x 6.63"). Height is 21.06" (53.5 cm with mounting brackets).
Weight	7.5 kg (16.5 lbs)
Ambient temperature range	-40° C to +46° C (-40° to 115° F)
Cooling	Natural convection, plus heat shield
Enclosure environmental rating	Outdoor, NRTL-certified, NEMA type 3R, polycarbonate construction
Wire sizes	<ul style="list-style-type: none"> <li>• 20 A to 50 A breaker inputs: 14 to 4 AWG copper conductors</li> <li>• 60 A breaker branch input: 4 to 1/0 AWG copper conductors</li> <li>• Main lug combined output: 10 to 2/0 AWG copper conductors</li> <li>• Neutral and ground: 14 to 1/0 copper conductors</li> </ul> Always follow local code requirements for conductor sizing.
Altitude	To 2000 meters (6,560 feet)
INTERNET CONNECTION OPTIONS	
Integrated Wi-Fi	802.11b/g/n
Ethernet	Optional, 802.3, Cat5E (or Cat 6) UTP Ethernet cable (not included)
Cellular	Optional, CELLMODEM-01 (3G) or CELLMODEM-03 (4G) or CELLMODEM-M1 (4G based LTE-M) (not included)
COMPLIANCE	
Compliance, Combiner	UL 1741 CAN/CSA C22.2 No. 107.1 47 CFR, Part 15, Class B, ICES 003 Production metering: ANSI C12.20 accuracy class 0.5 (PV production)
Compliance, IQ Envoy	UL 60601-1/CANCSA 22.2 No. 61010-1

To learn more about Enphase offerings, visit [enphase.com](http://enphase.com)

© 2018 Enphase Energy. All rights reserved. All trademarks or brands in this document are registered by their respective owner.  
2018-09-13



REVISIONS		
DESCRIPTION	DATE	REV

### PROJECT INSTALLER



Digitally signed by:  
Ermocrates F Castillo  
Date: 2021.07.21 19:00:19

### PROJECT NAME

DUPREE RESIDENCE  
1196 SW DAIRY ST,  
LAKE CITY, FL 32024

### SHEET NAME

DATA SHEET

### SHEET SIZE

ANSI B  
11" X 17"

### SHEET NUMBER

DS-04

# Enphase Encharge 10

The **Enphase Encharge 10™** all-in-one AC-coupled storage system is **reliable, smart, simple, and safe**. It is comprised of three base Encharge 3™ storage units, has a total usable energy capacity of 10.08 kWh and twelve embedded grid-forming microinverters with 3.84 kW power rating. It provides backup capability and installers can quickly design the right system size to meet the needs of both new and retrofit solar customers.



### Reliable

- Proven high reliability IQ Series Microinverters
- Ten-year limited warranty
- Three independent Encharge storage base units
- Twelve embedded IQ 8X-BAT Microinverters
- Passive cooling (no moving parts/fans)

### Smart

- Grid-forming capability for backup operation
- Remote software and firmware upgrade
- Mobile app-based monitoring and control
- Support for self consumption
- Utility time of use (TOU) optimization

### Simple

- Fully integrated AC battery system
- Quick and easy plug-and-play installation
- Interconnects with standard household AC wiring

### Safe

- Cells safety tested
- Lithium iron phosphate (LFP) chemistry for maximum safety and longevity

## Enphase Encharge 10

MODEL NUMBER	
ENCHARGE-10-1P-NA	Encharge 10 battery storage system with integrated Enphase Microinverters and battery management unit (BMU). Includes: - Three Encharge 3.36 kWh base units (B3-A01-US001-1-3) - One Encharge 10 cover kit with cover, wall mounting bracket, watertight conduit hubs, and interconnect kit for wiring between batteries (B10-C-1050-0)
ACCESSORIES	
ENCHARG-HNDL-R1	One set of Encharge base unit installation handles
OUTPUT (AC) @ 240 VAC <sup>1</sup>	
Rated (continuous) output power <sup>2</sup>	3.84 kVA
Peak output power	5.7 kVA (10 seconds)
Nominal voltage / range	240 / 211 – 264 VAC
Nominal frequency / range	60 / 57 – 61 Hz
Rated output current	16 A
Power factor (adjustable)	0.85 leading ... 0.85 lagging
Maximum units per 20 A branch circuit	1 unit (single phase)
Interconnection	Single-phase
Maximum AC short circuit fault current over 3 cycles	69.6 Arms
Round trip efficiency <sup>2</sup>	89%
BATTERY	
Total capacity	10.5 kWh
Usable capacity	10.08 kWh
Round trip efficiency	96%
Nominal DC voltage	67.2 V
Maximum DC voltage	73.5 V
Ambient operating temperature range	-15° C to 55° C (5° F to 131° F) non-condensing
Optimum operating temperature range	0° C to 30° C (32° F to 86° F)
Chemistry	Lithium iron phosphate (LFP)
MECHANICAL DATA	
Dimensions (WxHxD)	1070 mm x 664 mm x 319 mm (42.13 in x 26.14 in x 12.56 in)
Weight	Three individual 44.2 kg (97.4 lbs) base units plus 21.1 kg (48.7 lbs) cover and mounting bracket; total 154.7 kg (341 lbs)
Enclosure	Outdoor – NEMA type 3R
IQ 8X-BAT microinverter enclosure	NEMA type 6
Cooling	Natural convection – No fans
Altitude	Up to 2500 meters (8200 feet)
Mounting	Wall mount
FEATURES AND COMPLIANCE	
Compatibility	Compatible with grid-tied PV systems. Compatible with Enphase IQ Series Micros, Enphase Enpower, and Enphase IQ Envoy for backup operation.
Communication	Wireless 2.4 GHz and 915 MHz
Services	Backup, self-consumption, TOU, Demand Charge, NEM Integrity
Monitoring	Enlighten Manager and MyEnlighten monitoring options; API integration
Compliance (pending)	UL 9540, UN 38.3, UL 9540A, UL 1998, UL 991, NEMA Type 3R, AC156 EMI: 47 CFR, Part 15, Class B, ICES 003 Cell Module: UL 1973, UN 38.3 Inverters: UL 62109-1, IEC 62109-2, UL 1741SA, CAN/CSA C22.2 No. 107.1-16
LIMITED WARRANTY	
Limited Warranty <sup>3</sup>	>70% capacity, up to 10 years or 4000 cycles

1. Supported in backup/off grid operations  
2. AC to Battery to AC at 50% power rating.  
3. Whichever occurs first. Restrictions apply.

To learn more about Enphase offerings, visit [enphase.com](http://enphase.com)

© 2020 Enphase Energy. All rights reserved. Enphase, the Enphase logo, Encharge 10, and other trademarks or service names are the trademarks of Enphase Energy, Inc. Data subject to change. 2020-03-29



To learn more about Enphase offerings, visit [enphase.com](http://enphase.com)



**Castillo Engineering**  
SOLAR DONE RIGHT®

CASTILLO ENGINEERING SERVICES, LLC  
COA # 28345  
620 N. WYMORE ROAD, SUITE 250,  
MAITLAND, FL 32751  
TEL: (407) 289-2575  
ERMOCRATES E. CASTILLO - FL PE 52590

COPYRIGHTED BY CASTILLO ENGINEERING SERVICES, LLC

REVISIONS		
DESCRIPTION	DATE	REV

PROJECT INSTALLER



Digitally signed by: Ermocrates E. Castillo  
Date: 2021.07.21 19:00:20

PROJECT NAME

DUPREE RESIDENCE  
1196 SW DAIRY ST,  
LAKE CITY, FL 32024

SHEET NAME  
DATA SHEET

SHEET SIZE  
ANSI B  
11" X 17"

SHEET NUMBER  
DS-05

# Enphase Enpower

The **Enphase Enpower™** smart switch connects the home to grid power, the Encharge storage system, and solar PV. It provides microgrid interconnection device (MID) functionality by automatically detecting and seamlessly transitioning the home energy system from grid power to backup power in the event of a grid failure. It consolidates interconnection equipment into a single enclosure and streamlines grid independent capabilities of PV and storage installations by providing a consistent, pre-wired solution for residential applications.



### Reliable

- Durable NEMA type 3R enclosure
- Ten-year limited warranty

### Smart

- Controls safe connectivity to the grid
- Automatically detects grid outages
- Provides seamless transition to backup

### Simple

- Connects to the load or service equipment<sup>1</sup> side of the main load panel
- Centered mounting brackets support single stud mounting
- Supports conduit entry from the bottom, bottom left side, and bottom right side
- Supports whole home and partial home backup and subpanel backup
- Up to 200A main breaker support
- Includes neutral-forming transformer for split phase 120/240V backup operation

1. Enpower is not suitable for use as service equipment in Canada.

To learn more about Enphase offerings, visit [enphase.com](https://enphase.com)



## Enphase Enpower

MODEL NUMBER	
EP200G101-M240US00	Enphase Enpower smart switch with neutral-forming transformer (NFT), Microgrid Interconnect Device (MID), breakers, and screws. Streamlines grid-independent capabilities of PV and storage installations.
ACCESSORIES and REPLACEMENT PARTS	
XA-E3-PCBA-ENS	Replacement Enpower controller printed circuit board
Circuit breakers (as needed) <sup>2,3</sup>	Not included, must order separately:
BRK-100A-2P-240V	• Main breaker, 2 pole, 100A, 25kAIC, CSR2100N or CSR2100
BRK-125A-2P-240V	• Main breaker, 2 pole, 125A, 25kAIC, CSR2125N
BRK-150A-2P-240V	• Main breaker, 2 pole, 150A, 25kAIC, CSR2150N
BRK-175A-2P-240V	• Main breaker, 2 pole, 175A, 25kAIC, CSR2175N
BRK-200A-2P-240V	• Main breaker, 2 pole, 200A, 25kAIC, CSR2200N
BRK-20A-2P-240V-B	• Circuit breaker, 2 pole, 20A, 10kAIC, BR220B
BRK-30A-2P-240V	• Circuit breaker, 2 pole, 30A, 10kAIC, BR230B
BRK-40A-2P-240V	• Circuit breaker, 2 pole, 40A, 10kAIC, BR240B
BRK-60A-2P-240V	• Circuit breaker, 2 pole, 60A, 10kAIC, BR260
BRK-80A-2P-240V	• Circuit breaker, 2 pole, 80A, 10kAIC, BR280
EP200G-HNDL-R1	Enpower installation handle kit (order separately)
ELECTRICAL SPECIFICATIONS	
Assembly rating	Continuous operation at 100% of its rating
Nominal voltage / range (L-L)	240 VAC / 100 - 310 VAC
Voltage measurement accuracy	±1% V nominal (±1.2V L-N and ±2.4V L-L)
Nominal frequency / range	60 Hz / 56 - 63 Hz
Frequency measurement accuracy	±0.1 Hz
Maximum continuous current rating	160A
Maximum output overcurrent protection device	200A
Maximum input overcurrent protection device	200A
Maximum overcurrent protection device rating for storage branch circuit <sup>4</sup>	80A
Maximum overcurrent protection device rating for PV combiner branch circuit <sup>4</sup>	80A
Neutral Forming Transformer (NFT)	<ul style="list-style-type: none"> <li>• Breaker rating (pre-installed): 40A between L1 and Neutral; 40A between L2 and Neutral</li> <li>• Continuous rated power: 3600VA</li> <li>• Maximum continuous unbalance current: 30A @ 120V</li> <li>• Peak rated power: 8800VA for 30 seconds</li> <li>• Peak unbalanced current: 80A @ 120V for 30 seconds</li> </ul>
MECHANICAL DATA	
Dimensions (WxHxD)	50cm x 91.6cm x 24.6cm (19.7 in x 36 in x 9.7 in)
Weight	38.5 kg (85 lbs)
Ambient temperature range	-40° C to +50° C (-40° F to 122° F)
Cooling	Natural convection, plus heat shield
Enclosure environmental rating	Outdoor, NEMA type 3R, polycarbonate construction
Altitude	To 2500 meters (8200 feet)
WIRE SIZES	
Connections	<ul style="list-style-type: none"> <li>• Main lugs, backup load lugs, and CSR breakers</li> <li>• BR breakers (wire provided)</li> <li>• AC combiner lugs, Encharge lugs, and generator (reserved for future use) lugs</li> <li>• Neutral (large lugs)</li> </ul>
	Cu/AL: 2 AWG - 300 KCMIL 6 AWG 14 AWG - 2 AWG Cu/AL: 6 AWG - 300 KCMIL
Neutral and ground bars	<ul style="list-style-type: none"> <li>Large holes (5/16-24 UNF)</li> <li>Small holes (10-32 UNF)</li> </ul>
	14 AWG - 1/0 AWG 14 AWG - 6 AWG
COMPLIANCE	
Compliance	UL 1741, UL 1741 SA, UL1998, UL869A <sup>5</sup> , UL67 <sup>5</sup> , UL508 <sup>5</sup> , UL50E <sup>5</sup> , CSA 22.2 No. 107.1, 47 CFR, Part 15, Class B, ICES 003, AC156.

2. Compatible with BRHDK125 Hold-Down Kit to comply with 2017 NEC 710.15E for back-fed circuit breakers.  
3. The kAIC of Enpower is the same as the kAIC of the main breaker being installed as listed.  
4. Not included. Installer must provide properly rated breaker per circuit breaker list above.  
5. Sections from these standards were used during the safety evaluation and included in the UL 1741 listing.

To learn more about Enphase offerings, visit [enphase.com](https://enphase.com)

© 2020 Enphase Energy. All rights reserved. Enphase, the Enphase logo, Enpower, and other trademarks or service names are the trademarks of Enphase Energy, Inc. Data subject to change. 2020-06-16



REVISIONS		
DESCRIPTION	DATE	REV

### PROJECT INSTALLER



Digitally  
signed by:  
Ermocrates  
E Castillo  
Date:  
2021.07.21  
19:00:21

### PROJECT NAME

DUPREE RESIDENCE  
1196 SW DAIRY ST,  
LAKE CITY, FL 32024

### SHEET NAME

DATA SHEET


SHEET SIZE  
ANSI B  
11" X 17"

SHEET NUMBER  
DS-06

# SOLARMOUNT




**SOLARMOUNT** defined the standard in solar racking. Features are designed to get installers off the roof faster. Our grounding & bonding process eliminates copper wire and grounding straps to reduce costs. Systems can be configured with standard or light rail to meet your design requirements at the lowest cost possible. The superior aesthetics package provides a streamlined clean edge for enhanced curb appeal, with no special brackets required for installation.

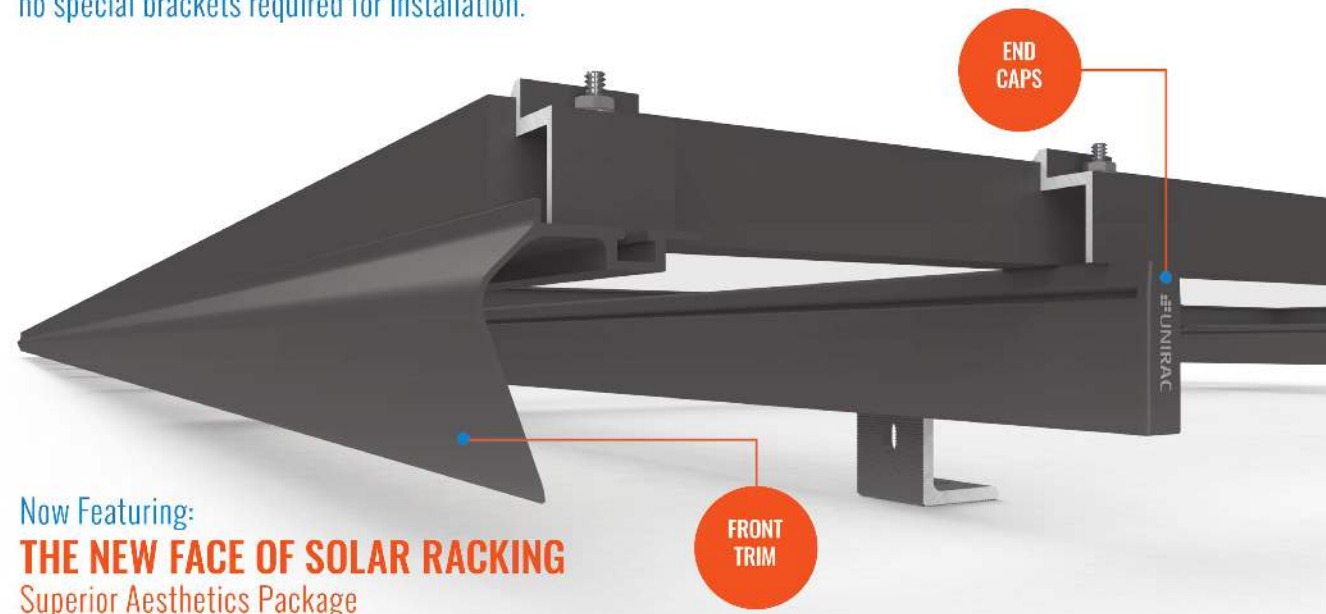

Now Featuring:  
**THE NEW FACE OF SOLAR RACKING**  
Superior Aesthetics Package



**LOSE ALL OF THE COPPER & LUGS**  
System grounding through Enphase microinverters and trunk cables

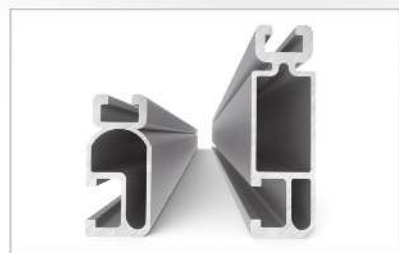

**SMALL IS THE NEXT NEW BIG THING**  
Light Rail is Fully Compatible with all SM Components



**ENHANCED DESIGN & LAYOUT TOOLS**  
Featuring Google Map Capabilities within U-Builder

## FAST INSTALLATION. SUPERIOR AESTHETICS

OPTIMIZED COMPONENTS • VERSATILITY • DESIGN TOOLS • QUALITY PROVIDER

# SOLARMOUNT



## OPTIMIZED COMPONENTS

### INTEGRATED BONDING & PRE-ASSEMBLED PARTS

Components are pre-assembled and optimized to reduce installation steps and save labor time. Our new grounding & bonding process eliminates copper wire and grounding straps or bonding jumpers to reduce costs. Utilize the microinverter mount with a wire management clip for an easier installation.

## VERSATILITY

### ONE PRODUCT - MANY APPLICATIONS

Quickly set modules flush to the roof or at a desired tilt angle. Change module orientation to portrait or landscape while securing a large variety of framed modules on flat, low slope or steep pitched roofs. Available in mill, clear and dark anodized finishes to outperform your projects financial and aesthetic aspirations.

## AUTOMATED DESIGN TOOL DESIGN PLATFORM AT YOUR SERVICE

Creating a bill of materials is just a few clicks away with U-Builder, a powerful online tool that streamlines the process of designing a code compliant solar mounting system. Save time by creating a user profile, and recall preferences and projects automatically when you log in. You will enjoy the ability to share projects with customers: there's no need to print results and send to a distributor, just click and share.



## UNIRAC CUSTOMER SERVICE MEANS THE HIGHEST LEVEL OF PRODUCT SUPPORT

- UNMATCHED EXPERIENCE
- CERTIFIED QUALITY
- ENGINEERING EXCELLENCE
- BANKABLE WARRANTY
- DESIGN TOOLS
- PERMIT DOCUMENTATION

### TECHNICAL SUPPORT

Unirac's technical support team is dedicated to answering questions & addressing issues in real time. An online library of documents including engineering reports, stamped letters and technical data sheets greatly simplifies your permitting and project planning process.

### CERTIFIED QUALITY PROVIDER


Unirac is the only PV mounting vendor with ISO certifications for 9001:2015, 14001:2015 and OHSAS 18001:2007, which means we deliver the highest standards for fit, form, and function. These certifications demonstrate our excellence and commitment to first class business practices.

### BANKABLE WARRANTY


Don't leave your project to chance. Unirac has the financial strength to back our products and reduce your risk. Have peace of mind knowing you are receiving products of exceptional quality. SOLARMOUNT is covered by a twenty five (25) year limited product warranty and a five (5) year limited finish warranty.

PROTECT YOUR REPUTATION WITH QUALITY RACKING SOLUTIONS BACKED BY ENGINEERING EXCELLENCE AND A SUPERIOR SUPPLY CHAIN

PUB20171128 - PRINTED

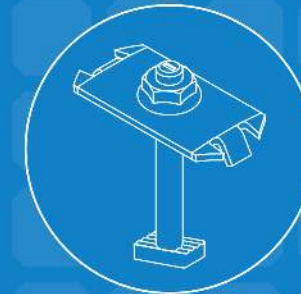

INTEGRATED BONDING MIDCLAMP

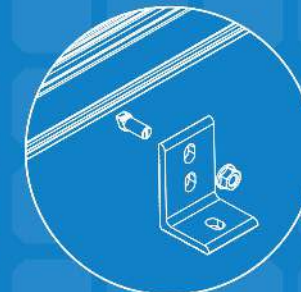

INTEGRATED BONDING SPLICE BAR



INTEGRATED BONDING L-FOOT w/ T-BOLT



INTEGRATED BONDING MICROINVERTER MOUNT w/ WIRE MANAGEMENT



CASTILLO ENGINEERING SERVICES, LLC  
COA # 28345  
620 N. WYMORE ROAD, SUITE 250,  
MAITLAND, FL 32751  
TEL: (407) 289-2575  
ERMOCRATES E. CASTILLO - FL PE 52590

COPYRIGHTED BY CASTILLO ENGINEERING SERVICES, LLC

REVISIONS		
DESCRIPTION	DATE	REV

PROJECT INSTALLER



Digitally signed by: Ermocrates E Castillo  
Date: 2021.07.21 19:00:22

PROJECT NAME

DUPREE RESIDENCE

1196 SW DAIRY ST,  
LAKE CITY, FL 32024

SHEET NAME

DATA SHEET

SHEET SIZE

ANSI B  
11" X 17"

SHEET NUMBER

DS-07

# S-5!<sup>®</sup>

## The Right Way!

### ProteaBracket<sup>™</sup>


ProteaBracket<sup>™</sup> is the most versatile standing seam metal roof attachment solution on the market, fitting most trapezoidal sheet profiles with and without intermediate insulation. It features an adjustable attachment base and multiple solar module attachment options (illustrated on back) to accommodate varying widths and heights. There are no messy sealants to apply and no chance for leaks; the ProteaBracket comes with factory-applied, adhesive rubber sealant to ensure quick installation and a weather-proof fit.

Installation is simple! The ProteaBracket is mounted directly onto the crown of the panel, straddling the profile. No surface preparation is necessary; simply wipe away excess oil and debris, align, and apply. Secure ProteaBracket through its pre-punched holes, using the hardened drill point S-5!<sup>®</sup> screws.

ProteaBracket is the perfect match for our S-5-PV Kit and spares you the hassle of cold-bridging! For a solar attachment solution that is both economical and easy to use, choose ProteaBracket.\*



S-5!<sup>®</sup> ProteaBracket<sup>™</sup> is a versatile bracket that adjusts easily to most trapezoidal roof profiles.

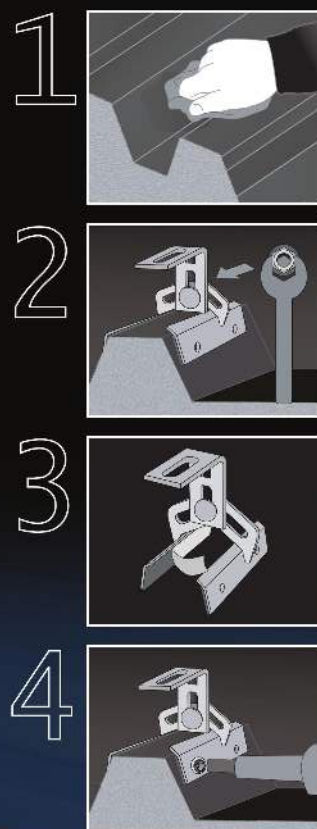

ProteaBracket<sup>™</sup>

888-825-3432 | www.S-5.com

# S-5!<sup>®</sup>

## The Right Way!

ProteaBracket<sup>™</sup> is the perfect solar attachment solution for most trapezoidal exposed-fastened metal roof profiles! No messy sealants to apply. The factory-applied adhesive rubber sealant weather-proofs and makes installation easy!

Each ProteaBracket<sup>™</sup> comes with a factory-applied, adhesive rubber sealant on the base. A structural A2 stainless steel bimetal attachment bracket, ProteaBracket is compatible with most common metal roofing materials. All four pre-punched holes must be used to achieve tested strength. Mounting hardware is furnished with the ProteaBracket. For design assistance, ask your distributor, or visit [www.S-5.com](http://www.S-5.com) for the independent lab test data that can be used for load-critical designs and applications. Also, please visit our website for more information including metallurgical compatibilities and specifications. S-5!<sup>®</sup> holding strength is unmatched in the industry.

### Multiple Attachment Options:

Side Rail Option




Top Rail Option



S-5-PV Kit Option




### ProteaBracket<sup>™</sup>

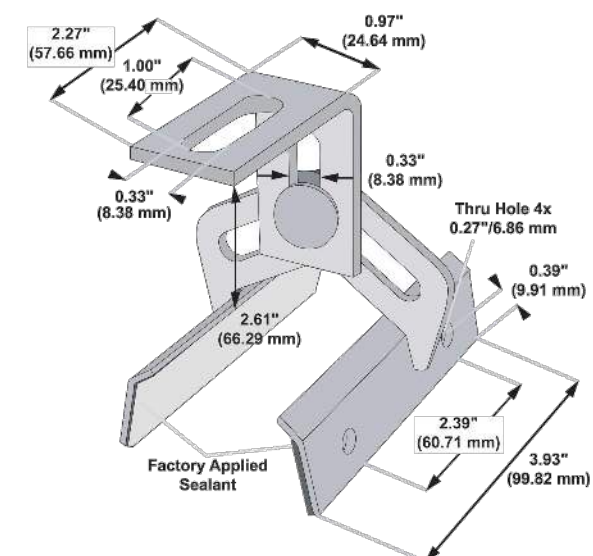

Please note: All measurements are rounded to the second decimal place.

### Example Applications

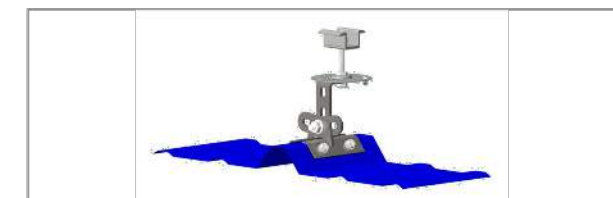

S-5-PV Kit demonstrated with a ProteaBracket on a trapezoidal profile.

### Example Profile



### S-5!<sup>®</sup> Warning! Please use this product responsibly!

Products are protected by multiple U.S. and foreign patents. For published data regarding holding strength, bolt torque, patents, and trademarks, visit the S-5! website at [www.S-5.com](http://www.S-5.com).

Copyright 2013, Metal Roof Innovations, Ltd. S-5! products are patent protected. S-5! aggressively protects its patents, trademarks, and copyrights. Version 112513.

Distributed by



CASTILLO ENGINEERING SERVICES, LLC  
COA # 28345  
620 N. WYMORE ROAD, SUITE 250,  
MAITLAND, FL 32751  
TEL: (407) 289-2575  
ERMOCRATES E. CASTILLO - FL PE 52590

COPYRIGHTED BY CASTILLO ENGINEERING SERVICES, LLC

REVISIONS		
DESCRIPTION	DATE	REV

PROJECT INSTALLER



Digitally signed by: Ermocrates F Castillo  
Date: 2021.07.21 19:00:23

PROJECT NAME

DUPREE RESIDENCE

1196 SW DAIRY ST,  
LAKE CITY, FL 32024

SHEET NAME

DATA SHEET

SHEET SIZE

ANSI B  
11" X 17"

SHEET NUMBER

DS-08

The right way to attach almost anything to metal roofs!

\*When ProteaBracket is used in conjunction with the S-5-PV Kit, an additional nut is required during installation.