

CONSTRUCTION CODE REQUIREMENTS

THESE PLANS WERE PREPARED AND SHALL COMPLY WITH THE

a. FLORIDA STATE:

- 2023 FLORIDA BUILDING CODE 8th EDITION, RESIDENTIAL, CHAPTER NO. 45, SECTION: R4501
- 2023 FLORIDA BUILDING CODE 8th EDITION, ENERGY CONSERVATION, CHAPTER NO. 4 SECTION: R403.10 POOLS AND PERMANENT SPA ENERGY CONSUMPTION (MANDATORY) SECTION: R403.11 PORTABLE SPA (MANDATORY) SECTION: R403.12 RESIDENTIAL POOL AND PERMANENT SPA
- 2023 FLORIDA STATUTES, CHAPTER NO. 515 RESIDENTIAL SWIMMING POOL SAFETY ACT

b. FEDERAL GOVERNMENT:

- 2014 ANSI/ APSP/ ICC-3: AMERICAN NATIONAL STANDARD FOR PERMANENTLY INSTALLED RESIDENTIAL SPAS SWIM SPAS R4501.6.1
- 2012 ANSI/ APSP/ ICC-5: AMERICAN NATIONAL STANDARD FOR RESIDENTIAL INGROUND SWIMMING POOLS R4501.6.1
- 2020 ANSI/APSP/ICC-7: AMERICAN NATIONAL STANDARD FOR SUCTION ENTRAPMENT AVOIDANCE IN SWIMMING POOLS, WADING POOLS, SPAS, HOT TUBS AND CATCH BASINS R4501.6.1, R4501.6.3, R4501.6.6
- 2013 ANSI/ASHRAE-15: SAFETY STANDARDS FOR REFRIGERATION SYSTEMS.
- 2012 ANSI/ APSP/ ICC 4-12 AMERICA NATIONAL STANDARD FOR ABOVE-GROUND/ ON-GROUND RESIDENTIAL SWIMMING POOLS R4501.6.1.
- 2013 ANSI/ APSP/ ICC 6-13 AMERICA NATIONAL STANDARD FOR RESIDENTIAL PORTABLE SPAS AND SWIM SPAS
- 2020 NATIONAL ELECTRICAL CODE (NEC) ARTICLE NO. 680

IMPORTANT NOTE:

POOL CONTRACTOR IS RESPONSIBLE FOR CONFORMING TO ALL ABOVE LISTED CODE REQUIREMENTS AS WELL AS ANY ADDITIONAL REQUIREMENTS PER LOCAL MUNICIPALITY THAT MAY BE MORE STRINGENT THAN THE ABOVE LISTED CODES REQUIREMENTS.

GENERAL POOL / SPA REQUIREMENTS:

- THE POOL CONTRACTOR IS RESPONSIBLE FOR FURNISHING ALL DETAIL DESIGN REQUIREMENTS FOR EACH INDIVIDUAL POOL IN ACCORDANCE WITH THE FLORIDA BUILDING CODE, AND ALL CONSTRUCTION SHALL MEET ALL APPLICABLE CODES INCLUDING PLUMBING, ELECTRICAL AND GAS.
- SEE ANSI/ NSPI-5 FOR DIVING WATER ENVELOPS.
- SLIDERS SHALL ALSO MEET THE MANUFACTURER'S INSTALLATION REQUIREMENTS.
- LADDER OR STAIRS ARE TO BE PROVIDED. ENTRY/ EXIT REQUIRED AT THE SHALLOW END AND DEEP END IF OVER 5 FEET DEEP ACCEPTABLE ARE STAIRS (10" MINIMUM TREAD WITH 240 SQUARE INCH MINIMUM AREA, 12" RISER WITH INTERMEDIATE TREADS AND RISERS UNIFORM). LADDERS, UNDERWATER SEATS, AND SWIM-OUTS (MAXIMUM 20" BELLOW WATERLINE
- OUTDOOR SWIMMING POOLS ARE TO HAVE BARRIERS THAT COMPLY WITH THE FLORIDA BUILDING CODE.
- ALL WALL SURROUNDING INDOOR SWIMMING POOLS SHALL COMPLY WITH THE FLORIDA BUILDING CODE.
- FINAL ELECTRICAL, AND BARRIER CODE, INSPECTIONS SHALL BE COMPLETED PRIOR TO FILING THE POOL WITH WATER.

SPECIAL SPA REQUIREMENTS:

- MAXIMUM WATER DEPTH 4', MAXIMUM SEAT DEPTH 28".
- FLOOR SLOPE 1:12
- MIN. TREAD 10" X 12" MAX. RISER.
- INTERMITTENTLY THE SPA SHALL HAVE A ONE HOUR TURNOVER, IF CONTINUOUS A SIX HOUR TURN OVER.
- MAXIMUM TEMPERATURE 104 DEGREES.

GENERAL STRUCTURAL NOTES:

1. THE MINIMUM CONCRETE COVER FOR #3 REBAR IS TO BE 2".
2. CONTINUOUS #3 REBAR SPLICES SHALL BE 18" (40 BAR DIAMETERS) MINIMUM LAP, STEEL TO BE BENT, LAPPED, AND PLACED IN CONFORMANCE WITH A.C.J. STANDARDS AND SPECS.
3. CONCRETE SHALL HAVE A MINIMUM COMPRESSIVE STRENGTH OF NOT LESS THAN 3000 PSI AT 28 DAYS U.N.O.

ELECTRICAL REQUIREMENTS:

- WIRING AND BONDING AND ALL ELECTRICAL SHALL CONFORM TO NEC ARTICLE 680.
- NO OUTLET OR OVERHEAD POWER WITHIN 10', IF WITHIN 15' PROJECT WITH GF.
- BRASS FITINGS TO J-BOX OR TRANSFORMER WHICHEVER IS FIRST WHICHEVER IS FIRST, EXCEPT WHERE PVC IS APPROVED.
- BONDING GRID PER NEC 680, 26
- OR
- NEC, 680, 26 (B) (2) (b) ALTERNATE MEANS EQUIPOTENT BONDING CONDUCTOR MUST FOLLOWING REQUIREMENTS:

- (1) 8 AWS BARE SOLID COPPER BONDING CONDUCTOR
- (2) THE BONDING CONDUCTOR MUST FOLLOW THE CONTOUR OF THE PERIMETER SURFACE
- (3) LISTED SPLICING DEVICES
- (4) BONDING CONDUCTOR MUST BE 18 TO 24 INC. FROM THE INSIDE WALLS OF THE POOL
- (5) BONDING CONDUCTOR MUST BE WITHIN OR UNDER THE PERIMETER SURFACE 4 TO 6 IN. BELOW THE SUBGRADE.

- ALL CONTROL ENCLOSURES (INCLUDING ACCESSORY ELECTRONIC EQUIPMENT WITH METAL ENCLOSURES), PUMP MOTORS, HEATERS, LIGHTS, LIGHT TRANSFORMERS, HANDRAIL AND LADDER DECK ANCHORS, WINDOW AND DOOR FRAMES WITHIN 5 FEET OR LESS OF THE WATER'S EDGE ARE TO BE GROUNDED IN ACCORDANCE WITH ARTICLE 680 OF THE 2020 NEC.

- ALL POOL PUMP MOTOR(S) TO HAVE GFCI PROTECTION (NEC 680.22 (B), FBC SECTION 27), AND FRC 4101.16

VELOCITY AND FLOW RATE NOTES:

- WATER VELOCITY IN FIELD-FABRICATED PIPING IS BASED ON THE MAXIMUM SYSTEM FLOW RATE. MAXIMUM WATER VELOCITY IN BRANCH SUCTION PIPING SHALL BE LIMITED TO 6 FEET PER SECOND (FPS) WHEN ONE OF A PAIR IS BLOCKED. IN NORMAL OPERATION THEN, THE BRANCH SUCTION PIPING VELOCITY 3 FEET PER SECOND. ALL OTHER SUCTION PIPING VELOCITIES SHALL BE 8 FPS FOR RESIDENTIAL POOLS.

- THE MAXIMUM SYSTEM FLOW RATE SHALL BE DETERMINED BY ONE OF THE FOLLOWING:

TDH CALCULATION FOR THE CIRCULATION SYSTEM OF EACH PUMP, OR A SIMPLIFIED TDH CALCULATION. DETERMINES THE MAXIMUM SYSTEM NOW RATE USING THE SHORTEST DISTANCE BETWEEN THE POOL AND THE PUMP. OMITTING THE CALCULATIONS FOR FIT LINGS/ VALVES, AND USING THE BEST PERFORMANCE RATINGS FOR FILTERS AND HEATERS: OR

THE MAXIMUM FLOW CAPACITY OF THE PUMP, WHICH SHALL BE LIMITED BY THE CRITERIA OF ANSI/APSP/ICC-7 SEC. 4.4.

FILTERS

FILTER SIZE TO BE DETERMINED BASED ON CALCULATED FLOW RATE (GPM) DIVIDED BY THE FOLLOWING FILTER CAPACITY (PER APSP -15):

- A. CARTRIDGE = 0.375
- B. SAND = 15
- C. D.E. = 2

- FILTER BACKWASH VALVE (WHEN USED) MUST BE 2" (MIN.)

OR DIAMETER OF THE RETURN PIPE, WHICHEVER IS GREATER.

EQUIPMENT/PIPING REQUIREMENTS:

-THE MAXIMUM SYSTEM FLOW RATE "SEE TDH CALCULATIONS FOR NOTES".

- EQUIPMENT FOUNDATIONS AND ENCLOSURES ALL POOL MOTORS AND EQUIPMENT SHALL BE INSTALLED IN COMPLIANCE WITH THE MANUFACTURER'S RECOMMENDATIONS.

-ACCESSIBILITY AND CLEARANCE, EQUIPMENT SHALL BE SO INSTALLED AS TO PROVIDE READY ACCESSIBILITY FOR CLEANING, OPERATING, MAINTENANCE AND SERVICING.

-CIRCULATION SYSTEMS, COMPONENTS AND EQUIPMENT SHALL COMPLY WITH NSF 50.

- THE MAXIMUM TURNOVER RATE IS 12 HOURS.

- ALL FILTERS SHALL HAVE AN AIR RELEASE AND PRESSURE GAUGE.

- SURFACE SKIMMERS SHALL MEET NSF 50 AND THERE SHALL BE ONE FOR EVERY 800 SQUARE FEEL OR SURFACE AREA ANDA 25 GPM MINIMUM EACH.

- RETURN INLETS SHALL BE A MINIMUM OF ONE FOR EVERY 300 SQUARE FEET, RETURN VELOCITY 10FT/S, SPACING OF 10 FEET MINIMUM APART, EXCEPT THERAPY JETS AND SWIM JETS.

- HYDROSTATIC RELIEF DEVICE, IN AREAS OF ANTICIPATED WATER TABLE AN APPROVED HYDROSTATIC REFIEF DEVICE SHALL BE INSTALLED.

VALVES SHALL BE APPROVED BY THE FLORIDA BUILDING CODE.

- HEATER SHALL MEET ANSE-Z21.56 OR UL 1261 OU UL 559 AND ANSI/APSP.

- DISINFECTANT EQUIPMENT SHALL COMPLY WITH NSF-50 ANSI/NSPI-4 AND ANSI/NSPI-5 BYPASS ON HEATERS.

- PRIMER AND GLUE ON EXPOSED ABOVE-GROUND ARE PIPING NOT REQUIRED TO BE COLORED.

-PIPING SHALL BE SCHEDULE 40 PVC, NSF-PW, MAXIMUM PRESSURE VELOCITY 10 FT/S, AND SUCTION 8 FT/S.

- MAIN DRAINS ARE OPTIONS "SEE TDH CALCULATIONS" OF THIS SET FOR DETAILS AND SPECIFICATIONS.

- VACCUM CLEANER SUCTION FITTINGS SHALL BE PROTECTED BY A PERMANENTLY SELF-CLOSING FLAPPER VALVE MEETING ANSI/ASME A112.12.8M AND ANSI/APSP/ICC-7

- ALL RETURN INLETS MUST BE DIRECTIONAL INLET FITTINGS.

- THE FOLLOWING SHALL BE LABELED AT THE CIRCULATION EQUIPMENT LOCATION:

- PIPE
- VALVES
- PUMP(S) OFF SWITCH

- WHERE REQUIRED MEET 2023 FBC GAS AND MECHANICAL CODES (OR CODES CURRENTLY ENFORCER WITH MUNICIPALITY)

ENTRAPMENT PROTECTION FOR SUCTION OUTLETS:

- ENTRAPMENT PROTECTION FOR SUCTION OUTLETS SHALL BE INSTALLED IN ACCORDANCE WITH REQUIREMENTS OF ANSI/APSP/ICC-7.

PUMPS:

-HAIR AND LINT STRAINERS ARE TO BE USED WITH RECIRCULATION SYSTEMS.

-FILTRATION PUMPS TO BE SIZED (BASED ON CALCULATED FLOW RATE IN GPM) TO TURNOVER POOL VOLUME IN SIX (6) HOUR MINIMUM OR 36 GPM (MIN.) WHICHEVER IS GREATER.

-FILTER COMPONENTS SHALL HAVE SUFFICIENT CAPACITY TP PROVIDE A COMPLETE TURNOVER OF POOL WATER IM TWELVE (12) HOUR OR LESS.

- RECIRCULATION PUMPS LESS THAN ONE HORSEPOWER (1 HP) SHALL BE TWO OR MORE PUMPS WITH ADEQUATE CONTROLLER. THE DEFAULT CIRCULATION MUST BE THE RESIDENTIAL FILTRATION (SLOWER) SPEED. THE SIMPLIFIED TOTAL DYNAMIC HEAD SHEET TO BE CALCULATED AND PLUMBING SIZE DETERMINED BASED ON (HIGHER) SPEED. THE HIGHER SPEED OVERRIDE IS NOT TO EXCEED ONE NORMAL DAY'S CYCLE OR 24 HOURS, WHICHEVER IS LESS I.E.: CONTROLLER RESETS PUMP TO SLOWER SPEED AT THE START OF THE NEXT CIRCULATIONS CYCLE.

- PUMPS THAT ARE USED FOR CIRCULATION ONLY (WITHOUT FILTRATION). SPA THERAPY PUMPS OR WATER FEATURE PUMPS ARE "EXEMPT" FROM THIS REQUIREMENT.

- POOL FILTRATION PUMPS SUCTION LINE (BEFORE PUMP) SHALL HAVE A STRAIGHT LENGTH OF PIPE (4 PIPE DIAMETERS MIN.) I.E.: 2" SUCTION LINE SHOULD HAVE (4 X 2" DIA.) 8" OF STRAIGHT PIPE FOM SUCTION INLET TO THE FIRST PVC FITTING.

SUCTION TYPE - SKIMMER / VACUUM NOTES:

- WHEN MAIN DRAINS ARE NOT INCLUDED, THE SKIMMER OR SURFACE OVERFLOW MUST BE HYDRAULICALLY DESIGNED TO THE MAXIMUM FLOW RATE OF THE POOL. SKIMMERS SHALL BE VENTED TO ATMOSPHERE THROUGH OPENINGS IN THE LID, OR THROUGH A SEPARATE VENT PIPE, DESIGNED IN ACCORDANCE WITH ANSI/PHTA/ICC -7 SECTION 4.5. SKIMMER EQUALIZER LINES SHALL NOT BE USED ON NEW CONSTRUCTION. EXISTING EQUALIZER(S) SOFAs SHALL COMPLY WITH ALL REQUIREMENTS OF ANSI/APSP/ICC-7, INCLUDING THE PROPER INSTALLATION OF A CERTIFIED SOFA. IF SKIMMER EQUALIZER LINES DO NOT COMPLY WITH THESE REQUIREMENTS, THEY SHALL BE CAPPED OFF OR REMOVED.

- WALL VACUUM FITTING (S). WHEN USED, VACUUM CLEANER FITTING(S) SHALL BE LOCATED IN AN ACCESSIBLE POSITION(S) AT LEAST 6 INCHES (152 MM) AND NO GREATER THAN 12 INCHES (457 MM) BELOW THE WATER LEVEL AND THE SELF-CLOSING, SELF-LATCHING FITTING SHALL COMPLY WITH IAPMO SPS-4.IN ADDITION, THE VACUUM PIPING SHALL BE EQUIPPED WITH A VALVE TO REMAIN IN THE CLOSED POSITION WHEN NOT IN USED.

SUCTION TYPE - MAIN DRAIN / SUBMERGED SUCTION OUTLET NOTES:

- DUAL OUTLETS, I.E., TWO LISTED SUCTION OUTLETS, ARE PIPED TO A SINGLE, COMMON SUCTION LINE TO THE PUMPS(S). THE TEE FEEDING FROM THE COMMON LINE BETWEEN THE SUCTION OUTLETS, TO THE PUMPS(S) SHALL BE LOCATED APPROXIMATELY MIDWAY.

- BETWEEN THE OUTLETS WITH NOW OUT OF THE BRANCH OF THE TEE. THE FLOW RATING OF EACH COVER/ GRATE SHALL BE AT LEAST EQUAL TO THE SYSTEMS MAXIMUM FLOW RATE.

- DUAL OUTLETS SHALL BE SEPARATED BY A MINIMUM OF 3 FEET (914 MM) MEASURED FROM CENTER TO CENTER OF THE SUCTION PIPES OR LOCATED ON TWO (2) DIFFERENT PLANES, I.E. ONE (1) ON THE BOTTOM AND ONE (1) ON THE VERTICAL WALL, OR ONE (1) EACH ON TWO (2) SEPARATE VERTICAL WALLS.

- THREE OR MORE LISTED SUCTION OUTLETS ARE PIPED IN PARALLEL TWO OF THE OUTLETS SHALL BE PIPED WITH THE TEE FEEDING THE SUCTION LINE TO THE PUMP(S) LOCATED APPROXIMATELY MIDWAY BETWEEN THE TWO OUTLETS. THE ADDITIONAL OUTLET (S) SHALL BE PERMITTED WHEN PIPED ACCORDING TO ANSI/APSP-7.


- A SINGLE LISTED CHANNEL OUTLET SHALL BE CONSIDERED ACCEPTABLE IF THE SIZE OF THE PERFORATED AREA IS 3" OR GREATER IN WIDTH AND 31" OR GREATER IN LENGTH.

- SINGLE OUTLET SWIM-JET SYSTEMS CONSIST OF A COMBINATION FITTING THAT INCORPORATES A SUCTION OUTLET AND INLET IN A SINGLE HOUSING THAT IS DESIGNED TO MOVE A LARGE VOLUME OF WATER AT HIGH VELOCITY IN A SINGLE DIRECTION. SUCH SYSTEMS SHALL BE TESTED AND LISTED BY A NATIONALLY RECOGNIZED TESTING LABORATORY AS CONFORMING TO THE MOST RECENT EDITION OF ASME/ ANSI 112.19.8 AND INCLUDE A PERMANENTLY MARKED FLOW RATING TESTED TO PREVENT HAIR ENTRAPMENT. THEY ARE NOT GOVERNED BY THE VELOCITY LIMITATIONS OF ANSI/ APSP-7-4.4.



This item has been digitally signed and sealed by Richard E. Walker, P.E. on the date adjacent to the seal. Printed copies of this document are not considered signed and sealed and the signature must be verified on any electronic copies.

FLORIDA ENGINEERING LLC
4161 TAMiami TRAIL, UNIT 101
PORT CHARLOTTE, FLORIDA 33952
(941) 391-5980
FLEng.com
Orders@FLEng.com

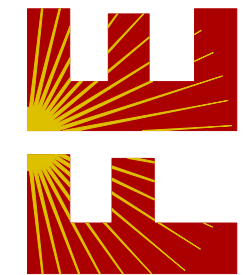


PROJECT NO. 2605893

CA CERT. #30782

**SCOPE OF WORK:
RESIDENTIAL SWIMMING POOL ENGINEERING
(POOL NOT DESIGNED FOR DIVING)**

SHEET NO.	DRAWING INDEX
S/01	GENERAL NOTES
S/02	PLAN/ ELEVATIONS
S/03	DETAILS

CONTRACTOR: HYDRO FUN POOLS LLC 310 SW DEER RUN DR FORT WHITE, FL 32038		PROJECT ADDRESS: COLE 312 SW THISTLEWOOD LN, FORT WHITE, FLORIDA, 32038
DESIGN DATE:	03/03/2026	
REVISION 1:	DATE	SHEET : 01
REVISION 2:	DATE	
DRAWN BY:	GE-RJ	
SCALE:	NTS	

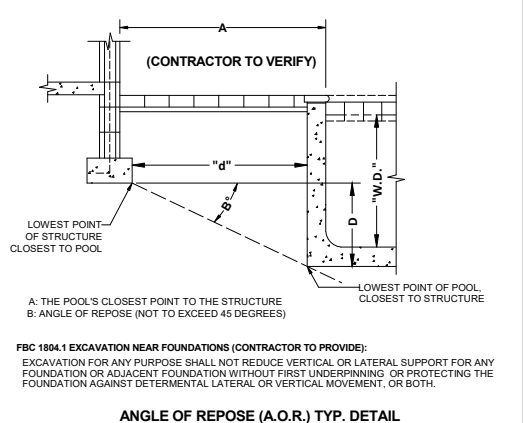

REFER SPECIAL STRUCTURAL NOTES (THIS SHEET) FOR THE ANGLE OF REPOSE CASE AT THE LOCATIONS AS LISTED BELOW:

1) HORIZONTAL DISTANCE "A" IS LESSER THAN WATER DEPTH (W.D.)
2) HORIZONTAL DISTANCE "d" IS LESSER THE VERTICAL DEPTH "D".

ENTRAPMENT PROTECTION FOR SUCTION OUTLETS SHALL BE INSTALLED IN ACCORDANCE WITH THE REQUIREMENTS OF ANSI/APSP/ICC-7 & FBC R4501.6.6.

BLOCKABLE DUAL OUTLETS (MAIN DRAINS) SHALL BE SEPARATED BY A MINIMUM OF 3 FEET MEASURED FROM CENTER TO CENTER OF THE SUCTION OUTLET FITTING ASSEMBLY (SOFA) OR LOCATED ON TWO (2) DIFFERENT PLANES I.E., ONE (1) ON THE BOTTOM AND ONE (1) ON THE VERTICAL WALL, OR ONE (1) EACH ON TWO (2) SEPARATE VERTICAL WALLS. SUCTION OUTLETS SHALL NOT BE INSTALLED IN SEATING AREAS.

AN UNBLOCKABLE SOFA REQUIRES THAT THE SUCTION OUTLET FITTING ASSEMBLY (SOFA) BE CERTIFIED AS UNBLOCKABLE, AND BE DESIGNED BY THE MANUFACTURER AS UNBLOCKABLE, AND THE MANUFACTURER'S INSTRUCTIONS MUST STATE THE SOFA IS AUTHORIZED FOR USE AS AN UNBLOCKABLE IN ACCORDANCE WITH ANSI/ APSP/ ICC - 16 2017.

ENTRY/ EXIT REQUIRED AT THE SHALLOW END AND DEEP END IF OVER 5 FEET DEEP. ACCEPTABLE ARE STAIRS (10" MINIMUM TREAD WITH 240 SQUARE INCH MINIMUM AREA, 12" RISER (MAX.) WITH INTERMEDIATE TREADS AND RISERS UNIFORM), LADDERS, UNDERWATER SEATS, AND SWIM-OUTS (MAXIMUM 20" BELLOW WATERLINE).


THE NUMBERS OF RETURN INLETS SHALL BE BASED ON A MINIMUM OF (1) RETURN INLET PER 300 SQ. FT. OF POOL SURFACE AREA OR FRACTION THEREOF.

APPROVED SURFACE SKIMMERS ARE REQUIRED AND SHALL BE INSTALLED IN STRICT ACCORDANCE WITH THE MANUFACTURER'S INSTALLATION INSTRUCTIONS. SKIMMERS SHALL BE INSTALLED ON THE BASIS OF ONE PER 800 SQUARE FEET (74 M2) OF SURFACE AREA OR FRACTION THEREOF, AND SHALL BE DESIGNED FOR A FLOW RATE OF AT LEAST 25 GALLONS PER MINUTE (GPM) (1.6 L/S) PER SKIMMER.

ANY GLAZING WITHIN 5 FT. OF POOL SHALL BE SHALL CONFORM TO FBC R308.4.5.

WHERE A WALL OF DWELLING SERVES AS PART OF THE BARRIER, ONE OF THE FOLLOWING SHALL APPLY:
1) ALL DOORS AND WINDOWS PROVIDING DIRECT ACCESS FROM THE HOME/ DWELLING TO THE POOL SHALL BE EQUIPPED W/ AN EXIT ALARM COMPLYING W/ UL 2017.
2) ALL DOORS PROVIDING DIRECT ACCESS FROM THE HOME TO THE POOL MUST BE EQUIPPED W/ A SELF-CLOSING, SELF-LATCHING DEVICE W/ POSITIVE MECHANICAL LATCHING/ LOCKING INSTALLED A MIN. OF 54 INCHES ABOVE THE THRESHOLD, WHICH IS APPROVED BY THE AUTHORITY HAVING JURISDICTION.
3) A SWIMMING POOL ALARM THAT COMPLIES TO ASTM STANDARD F2208.



NOTE:
1) WHEN PROVIDED SHALL BE AT 20" MAX. BELOW THE WATERLINE AS SHOWN, AND SHALL BE VISUALLY SET APART FROM THE POOL.
2) MIN. UNOBSTRUCTED WALKING SURFACE OF 240 SQ. INCHES.

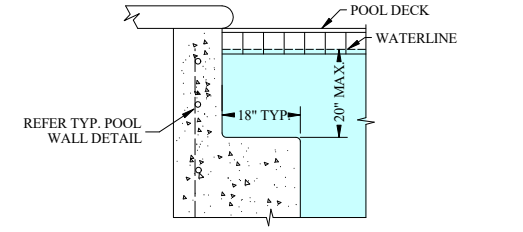

SWIMOUT BENCH TYPICAL DETAIL

POOL PLAN

CONTRACTOR SHALL VERIFY THE DECK DIMENSIONS, ELEVATIONS, AND MAY REQUIRE TO PROVIDE A SEPARATE SITE PLAN.

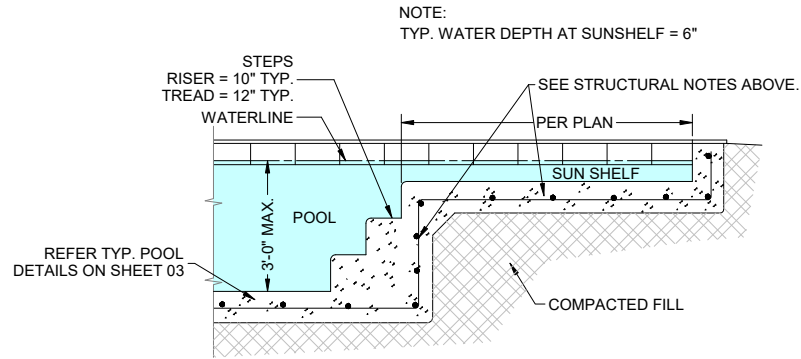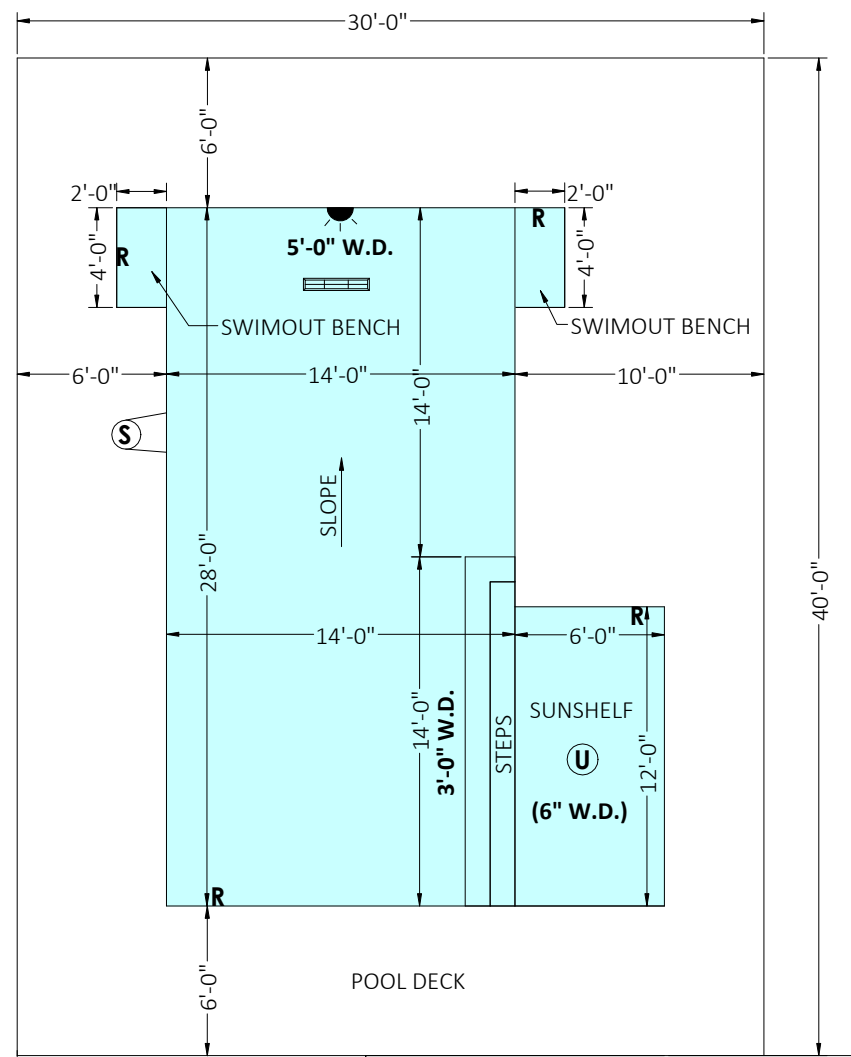


TYPICAL SUN SHELF W/STEPS DETAIL
SCALE: NTS

This item has been digitally signed and sealed by Richard E. Walker, P.E. on the date adjacent to the seal. Printed copies of this document are not considered signed and sealed and the signature must be verified on any electronic copies.

SCOPE OF WORK:
RESIDENTIAL SWIMMING POOL ENGINEERING
(POOL NOT DESIGNED FOR DIVING)

DRAWING LEGENDS
(ALL MAY NOT APPLY)

SYMBOLS	INDICATES
	MAIN DRAIN
	RETURN
	SKIMMER
	LIGHT
	UMBRELLA HOLE

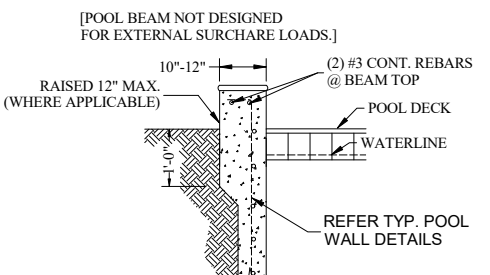

TYPICAL POOL BEAM DETAIL

POOL/ SPA STRUCTURAL AND SITE NOTE:
(CONTRACTOR TO VERIFY, AND CONSULT ENGINEERS OTHERWISE)

GENERAL SITE NOTES:
- BASED ON THE DIGITAL REPRESENTATION OF FEMA FLOOD MAPPING, THIS SITE APPEARS TO BE IN A FEMA FLOOD MAP ZONE "X".

GENERAL STRUCTURAL NOTES (ALSO SEE SPECIAL NOTE WHERE APPLICABLE):
- WALL/ FLOOR CONCRETE, SHORT -CRETE, AND GUNITE SHALL BE 3,000 PSI MINIMUM.
- REINFORCING STEEL SHALL BE ASTM A615 GRADE 60; MINIMUM CONCRETE COVER FOR REBAR SHALL BE 3" MEASURED FROM SOIL FACE, UNLESS OTHERWISE NOTED.
- WALL AND FLOOR THICKNESS AND REINFORCING SHALL BE PROVIDED AS PER TABLE 1 BELOW.

TYPICAL WALL/ FLOOR THICKNESS & REINFORCEMENT SCHEDULE U.N.O.

MAX.WATER DEPTH	WALL/ FLOOR THICKNESS	WALL/ FLOOR REINFORCEMENT SPACING (O.C. EACH WAY)	
		#3 REBAR (18" MIN. SPLICE)	#4 REBAR (24" MIN. SPLICE)
5'-0"	6"	12"	18"

SPECIAL STRUCTURAL NOTES [ANGLE OF REPOSE NOTE (A.O.R.) - WHEN APPLICABLE]
- AT THE LOCATION WHERE POOL IS WITHIN A.O.R. OF EXISTING STRUCTURAL FOUNDATION, PROVIDE 10" THICK MIN. POOL SPA WALL REINF. W/ #3 REBAR @ 6" EA. WAY; PROVIDE 3" TYP. REBAR COVER MEASURED FROM SOIL FACE OF THE WALL. SEE NOTES BELOW.
A) BEARING PRESSURE AT THE BOTTOM OF THE EX. FOUNDATION SHALL NOT EXCEED 2000 PSF.
B) CONTRACTOR SHALL PROVIDE REQUIRED SHORING FOR EXCAVATION TO PROTECT THE EX. FOUNDATION AGAINST THE DETRIMENTAL VERTICAL AND LATERAL MOVEMENT, OR BOTH AS PER FBC 1804.1
C) CONTRACTOR/ HOUSE E.O.R. SHALL VERIFY THE CAPACITY OF EX. FOUNDATION TO BE ABLE TO SUPPORT THE PROPOSED POOL WHEN APPLICABLE.

DESIGN SOIL STATEMENT:
THE STRUCTURAL FOUNDATION HAS BEEN DESIGNED WITH UNIFIED SOIL CLASSIFICATION SW, SP, SM, GM AND GC; AND THE MINIMUM BEARING CAPACITY OF 2000 PSF AND BASED ON THE 2023 FBC, 8TH EDITION - RESIDENTIAL TABLE R401.4.1 PRESUMPTIVE LOAD -BEARING VALUES OF FOUNDATION MATERIALS OTHER SOILS OR CONDITION WILL REQUIRE GEO-TECHNICAL EVALUATION AND ADDITIONAL ENGINEERING.
PURSUANT TO THE 2023 FBC SECTION R401.4 WHERE THERE IS A REASONABLE INDICATION THAT EXPANSIVE, COMPRESSIBLE, SHIFTING OR OTHER QUESTIONABLE SOIL CHARACTERISTICS ARE PRESENT AND/OR WHERE SHALLOW FOUNDATION WILL BEAR ON COMPACTED FILL MATERIAL MORE THAN 12" IN DEPTH, THE BUILDING OFFICIAL MAY REQUIRE A GEOTECHNICAL INVESTIGATION REPORT TO CONFIRM SUITABILITY OF THE SOIL FOUNDATION.

OUTDOOR RESIDENTIAL SWIMMING POOLS SHALL BE PROVIDED WITH A BARRIER COMPLYING WITH FBC R4501.17.1.1 THROUGH R4501.17.1.14.


EQUIPOTENTIAL BONDING SHALL CONFORM TO 2020 NEC SECTION 680.26.

FOR ALL WALKING SURFACES LOCATED MORE THAN 30" ABOVE GRADE, GUARDS SHALL BE PROVIDED PER FBC R312.

AN APPROVED HYDROSTATIC RELIEF DEVICE SHALL BE INSTALLED AT THE LOCATION OF HIGH GROUNDWATER TABLE.

POOL EQUIPMENT

POOL FLOOR SLOPES NOTE (ANSI/ APSP/ ICC -5)
- THE SLOPE OF THE FLOOR FROM THE SHALLOW END WALL TOWARDS THE DEEP AREA SHALL NOT EXCEED A 1:7 INCLINE TO THE POINT OF THE FIRST SLOPE CHANGE.
- CHANGES IN THE SLOPE BETWEEN SHALLOW AND DEEP AREAS SHALL BE AT A MINIMUM WATER DEPTH OF 2 FT. 9 IN. AND BE AT LEAST 6 FT. FROM SHALLOW END, EXCEPT AS SPECIFIED IN PARA. 6.3 ANSI/APSP/ICC-5 "SHALLOW END DETAIL FOR BEACH AND SLOPING ENTRIES".
- THE SLOPE OF THE FLOOR SHALL NOT EXCEED A 1:3 INCLINE FOR DEEPER AREA AFTER 1:7 INCLINATION.
- IN POOLS WHERE THE POINT OF FIRST SLOPE CHANGE (POINT D, FIGURE BELOW) OCCURS IN WATER DEPTHS LESS THAN 4'-6", A ROPE AND FLOAT ASSEMBLY SHALL BE INSTALLED ACROSS THE WIDTH OF THE POOL GENERALLY PARALLEL TO, AND AT A MIN. OF 1 FT. AND A MAX. OF 2 FT. ON THE SHALLOW SIDE OF THE CHANGE IN FLOOR SLOPE.

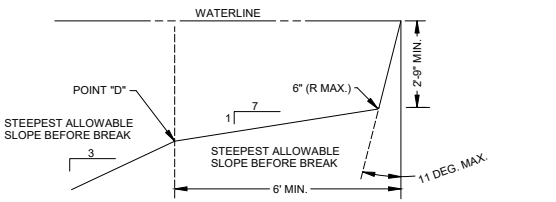

ALLOWABLE POOL FLOOR & WALL GEOMETRY

FLORIDA ENGINEERING LLC
4161 TAMiami TRAIL, UNIT 101
PORT CHARLOTTE, FLORIDA 33952
(941) 391-5980
FLEng.com
Orders@FLEng.com

FLORIDA ENGINEERING LLC

CONTRACTOR:
HYDRO FUN POOLS LLC
310 SW DEER RUN DR
FORT WHITE, FL 32038

PROJECT ADDRESS:
COLE
312 SW THISTLEWOOD LN,
FORT WHITE, FLORIDA, 32038

DESIGN DATE: 03/03/2026

REVISION 1: DATE

REVISION 2: DATE


DRAWN BY: GE-RJ

SCALE: NTS

SHEET :
02


PROJECT NO. 2605893
CA CERT. #30782

DECK OPTIONS

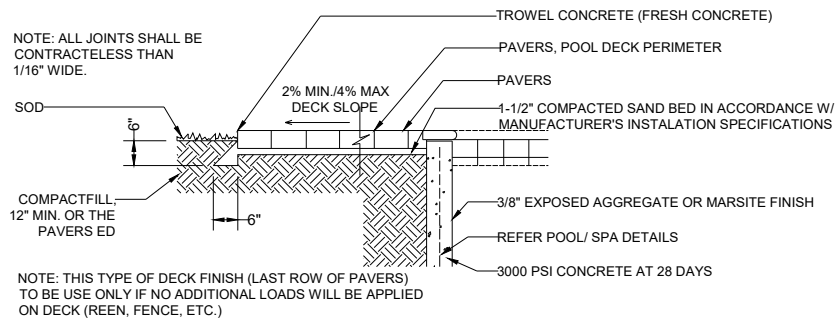


INTERLOCKING PAVERS, FOOTING AND TYP. DECK DETAIL

HANDHOLD SHALL BE PROVIDED AROUND THE POOL EDGE IN ANY AREA WHERE THE WATER DEPTH EXCEEDS 4 FT. AS PER ANS/ APSP -5 SECTION 17.1

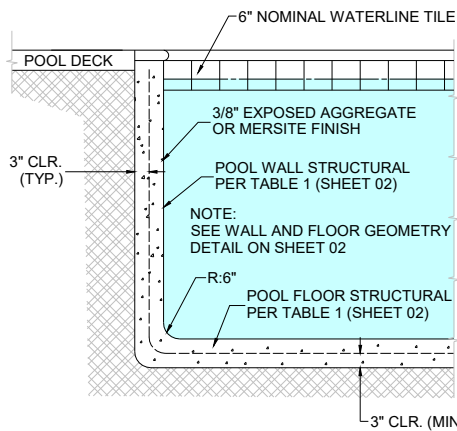


TYPICAL POOL WALL AND FLOOR DETAIL

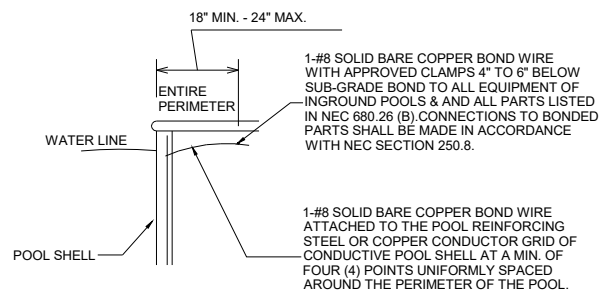


EQUIPOTENTIAL BONDING DETAIL (2020 NEC SEC 680.26 (B) 2(b))


COMMON BONDING GRID PERMITTED TO BE:
 - STRUCTURAL REINFORCING STEEL RODS THAT ARE BONDED TOGETHER
 - SOLID COPPER CONDUCTOR NO. 8 OR LARGER
 AS PER NEC 680.26 (B) (1) EQUIPOTENTIAL BONDING: POURED CONCRETE, PNEUMATICALLY APPLIED OR SPRAYED CONCRETE AND CONCRETE BLOCK WITH PAINTED OR PLASTERED COATINGS SHALL ALL BE CONSIDERED CONDUCTIVE MATERIALS DUE TO WATER PERMEABILITY AND POROSITY.

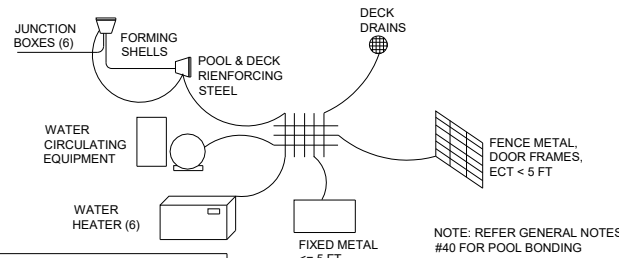

EQUIPOTENTIAL BONDING DETAIL

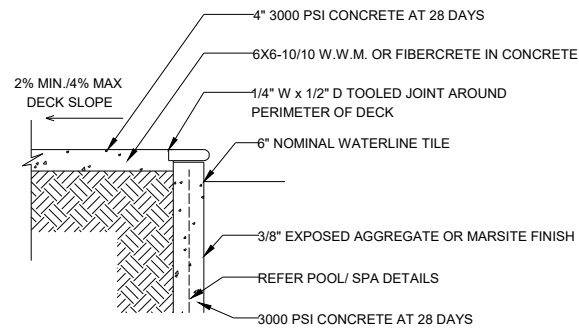


POOL/ SPA CONC. DECK (TYP.) DETAIL

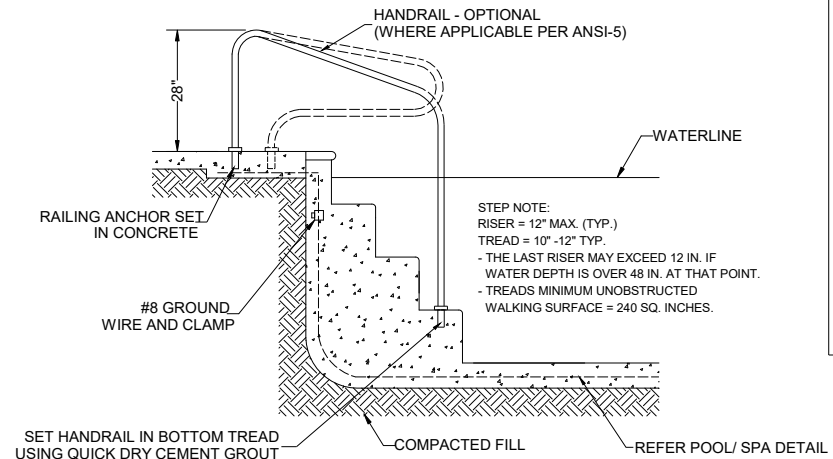


POOL STAIRS (TYP.) DETAIL

This item has been digitally signed and sealed by Richard E. Walker, P.E. on the date adjacent to the seal. Printed copies of this document are not considered signed and sealed and the signature must be verified on any electronic copies.

- WHEN MAIN DRAINS ARE NOT INCLUDED, THE SKIMMER OR SURFACE OVERFLOW MUST BE HYDRAULICALLY DESIGNED TO THE MAXIMUM FLOW RATE OF THE POOL. SKIMMERS SHALL BE VENTED TO ATMOSPHERE THROUGH OPENINGS IN THE LID, OR THROUGH A SEPARATE VENT PIPE, DESIGNED IN ACCORDANCE WITH ANS/PHTA/ICC -7 SECTION 4.5. SKIMMER EQUALIZER LINES SHALL NOT BE USED ON NEW CONSTRUCTION. EXISTING EQUALIZER(S) SOFAs SHALL COMPLY WITH ALL REQUIREMENTS OF ANS/APSP/ICC-7, INCLUDING THE PROPER INSTALLATION OF A CERTIFIED SOFA. IF SKIMMER EQUALIZER LINES DO NOT COMPLY WITH THESE REQUIREMENTS, THEY SHALL BE CAPPED OFF OR REMOVED.

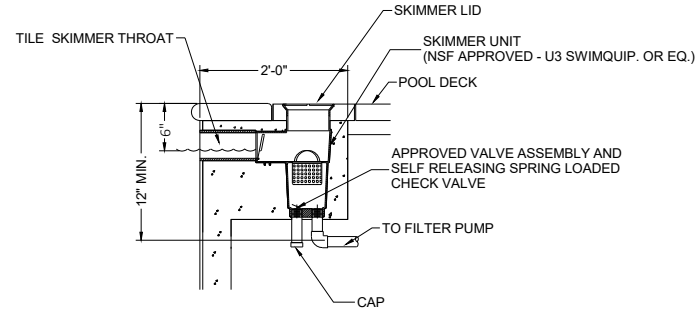


SKIMMER DETAIL (N.T.S.)

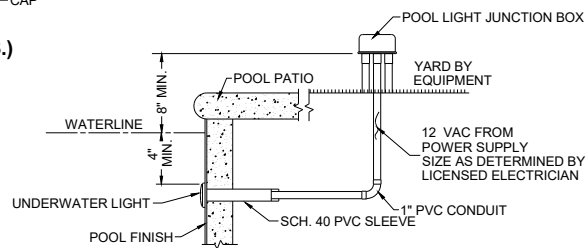


NOTE:
 1. MIN. DISTANCE FROM WATER'S EDGE TO TRANSFORMER = 5'-0"
 2. MIN. DISTANCE FROM WATER'S EDGE TO JUNCTION BOX = 4'-0"


NICHLESS UNDERWATER LIGHT DETAIL

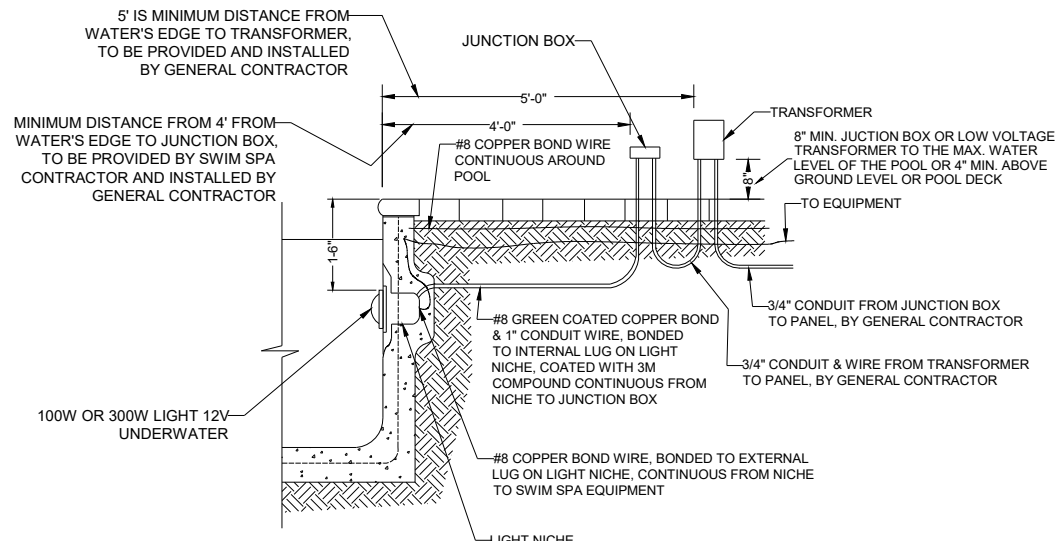

POOL (NICHE) LIGHT & EQUIPOTENT BONDING

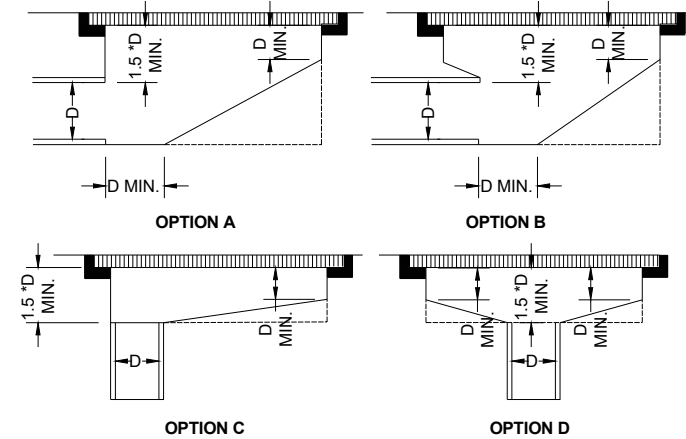


GENERAL NOTES:
 (a) D= INSIDE DIAMETER OF PIPE
 (b) ALL DIMENSIONS SHOWN ARE MINIMUMS
 (c) A BROKEN LINE (- - -) INDICATES SUGGESTED STP CONFIGURATION

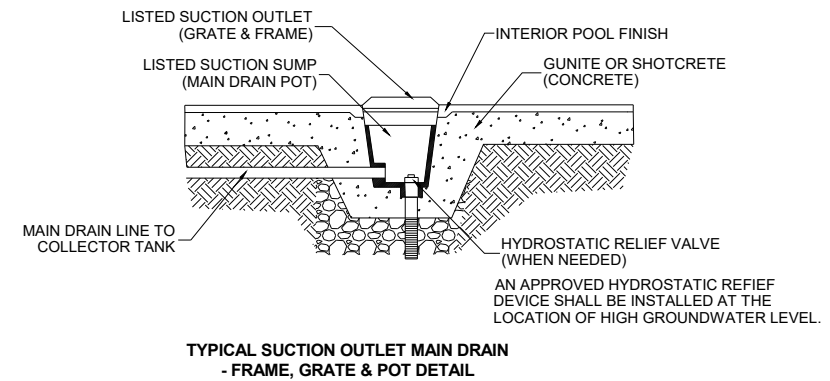

TYPICAL SUCTION OUTLET MAIN DRAIN - FRAME, GRATE & POT DETAIL

FLORIDA ENGINEERING LLC
 4161 TAMiami TRAIL, UNIT 101
 PORT CHARLOTTE, FLORIDA 33952
 (941) 391-5980
 FLEng.com
 Orders@FLEng.com

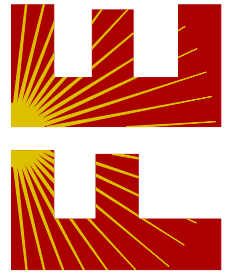

PROJECT NO. 2605893

CA CERT. #30782

CONTRACTOR:
HYDRO FUN POOLS LLC
 310 SW DEER RUN DR
 FORT WHITE, FL 32038

PROJECT ADDRESS:
 COLE
 312 SW THISTLEWOOD LN,
 FORT WHITE, FLORIDA, 32038

DESIGN DATE: 03/03/2026

REVISION 1: DATE

REVISION 2: DATE

DRAWN BY: GE-RJ

SCALE: NTS

SHEET :
03