
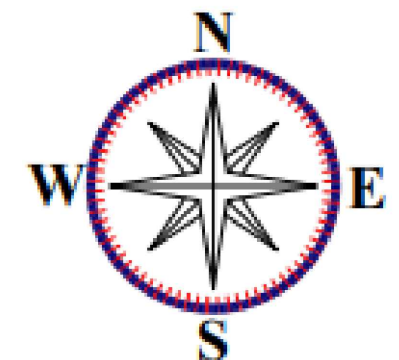


GENERAL NOTES FIRE SAFETY NOTES:
 ROOF ACCESS POINTS SHALL BE DEFINED AS AREAS WHERE FIRE DEPARTMENT LADDERS ARE NOT PLACED OVER OPENINGS (WINDOWS OR DOORS), ARE LOCATED AT STRONG POINTS OF BUILDING CONSTRUCTION, AND ARE IN LOCATIONS WHERE THEY WILL NOT CONFLICT WITH OVERHEAD OBSTRUCTIONS (TREE LIMBS, WIRES, OR SIGNS).

· CABLES, WHEN RUN BETWEEN ARRAYS, SHALL BE ENCLOSED IN CONDUIT.

SW SYDNEY NICOLE CT
FRONT OF HOME

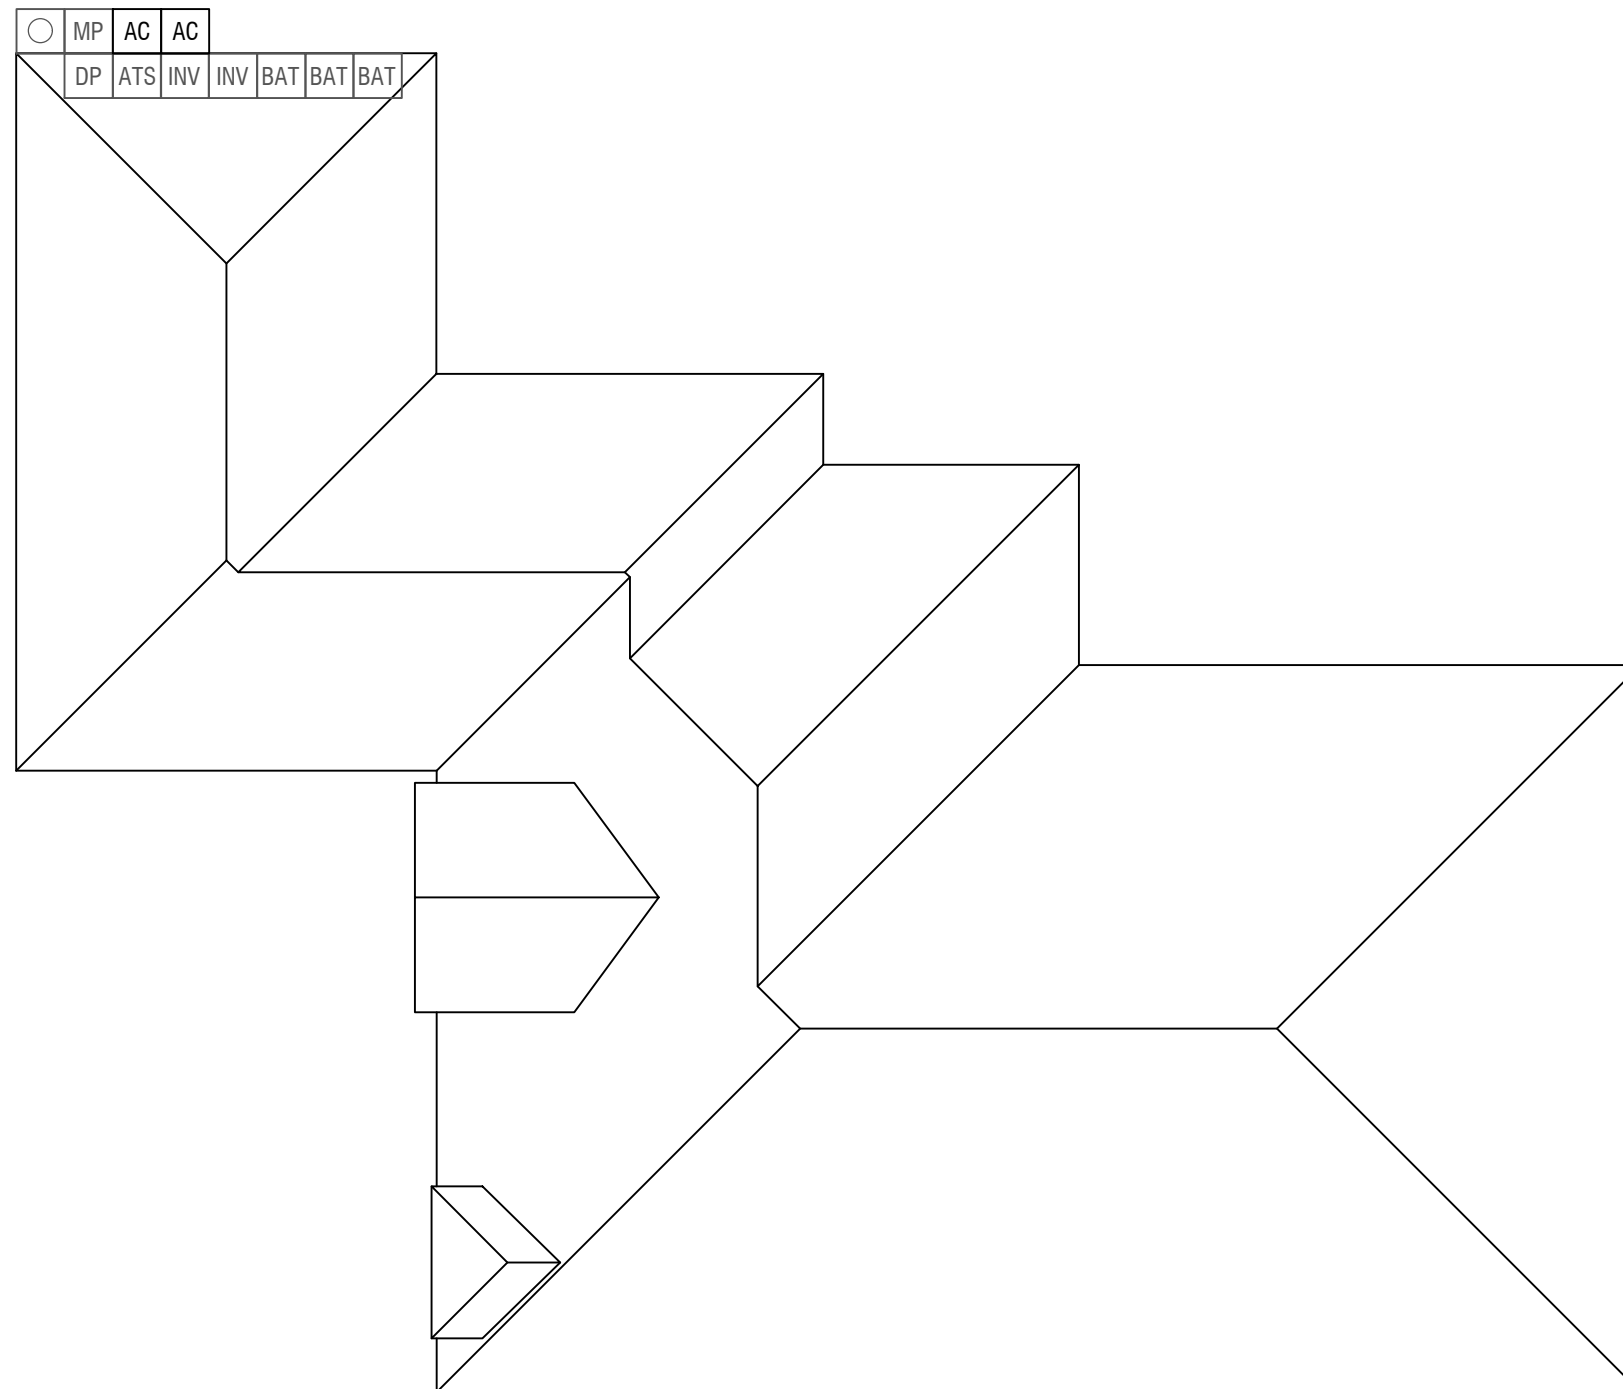

SYSTEM LEGEND

- EXISTING UTILITY METER
- MP EXISTING MAIN SERVICE PANEL
- AC NEW PHOTOVOLTAIC UTILITY DISCONNECT SWITCH. LOCATED WITHIN 10' OF METER.
- INV NEW EG4 12000X0 OFF-GRID INVERTER
- ATS NEW EG4 GRID BOSS MICRO-GRID INTERCONNECTION DEVICE
- BAT NEW EG4 GRID 14.3KWH POWERPRO BATTERY
- DP EXISTING DISTRIBUTION PANEL



REVISIONS		
DESCRIPTION	DATE	REV

PROJECT NAME:	TRENT REICHARDT
PROJECT ADDRESS:	159 SW SYDNEY NICOLE CT, LAKE CITY, FL 32024

SHEET NAME:	SITE PLAN
SHEET NUMBER:	A-01
SHEET SIZE:	ANSI B 11"x17"