


Thomas M. Kelaher, P.E.  
 Structural Consultants  
 Florida Rg. No 40159  
 1108 S.E. 14th Terrace  
 Deerfield Beach, FL 33441  
 Phone (954) 360.9628  
 Fax (954) 360.0173  
 tkelahegr@comcast.net

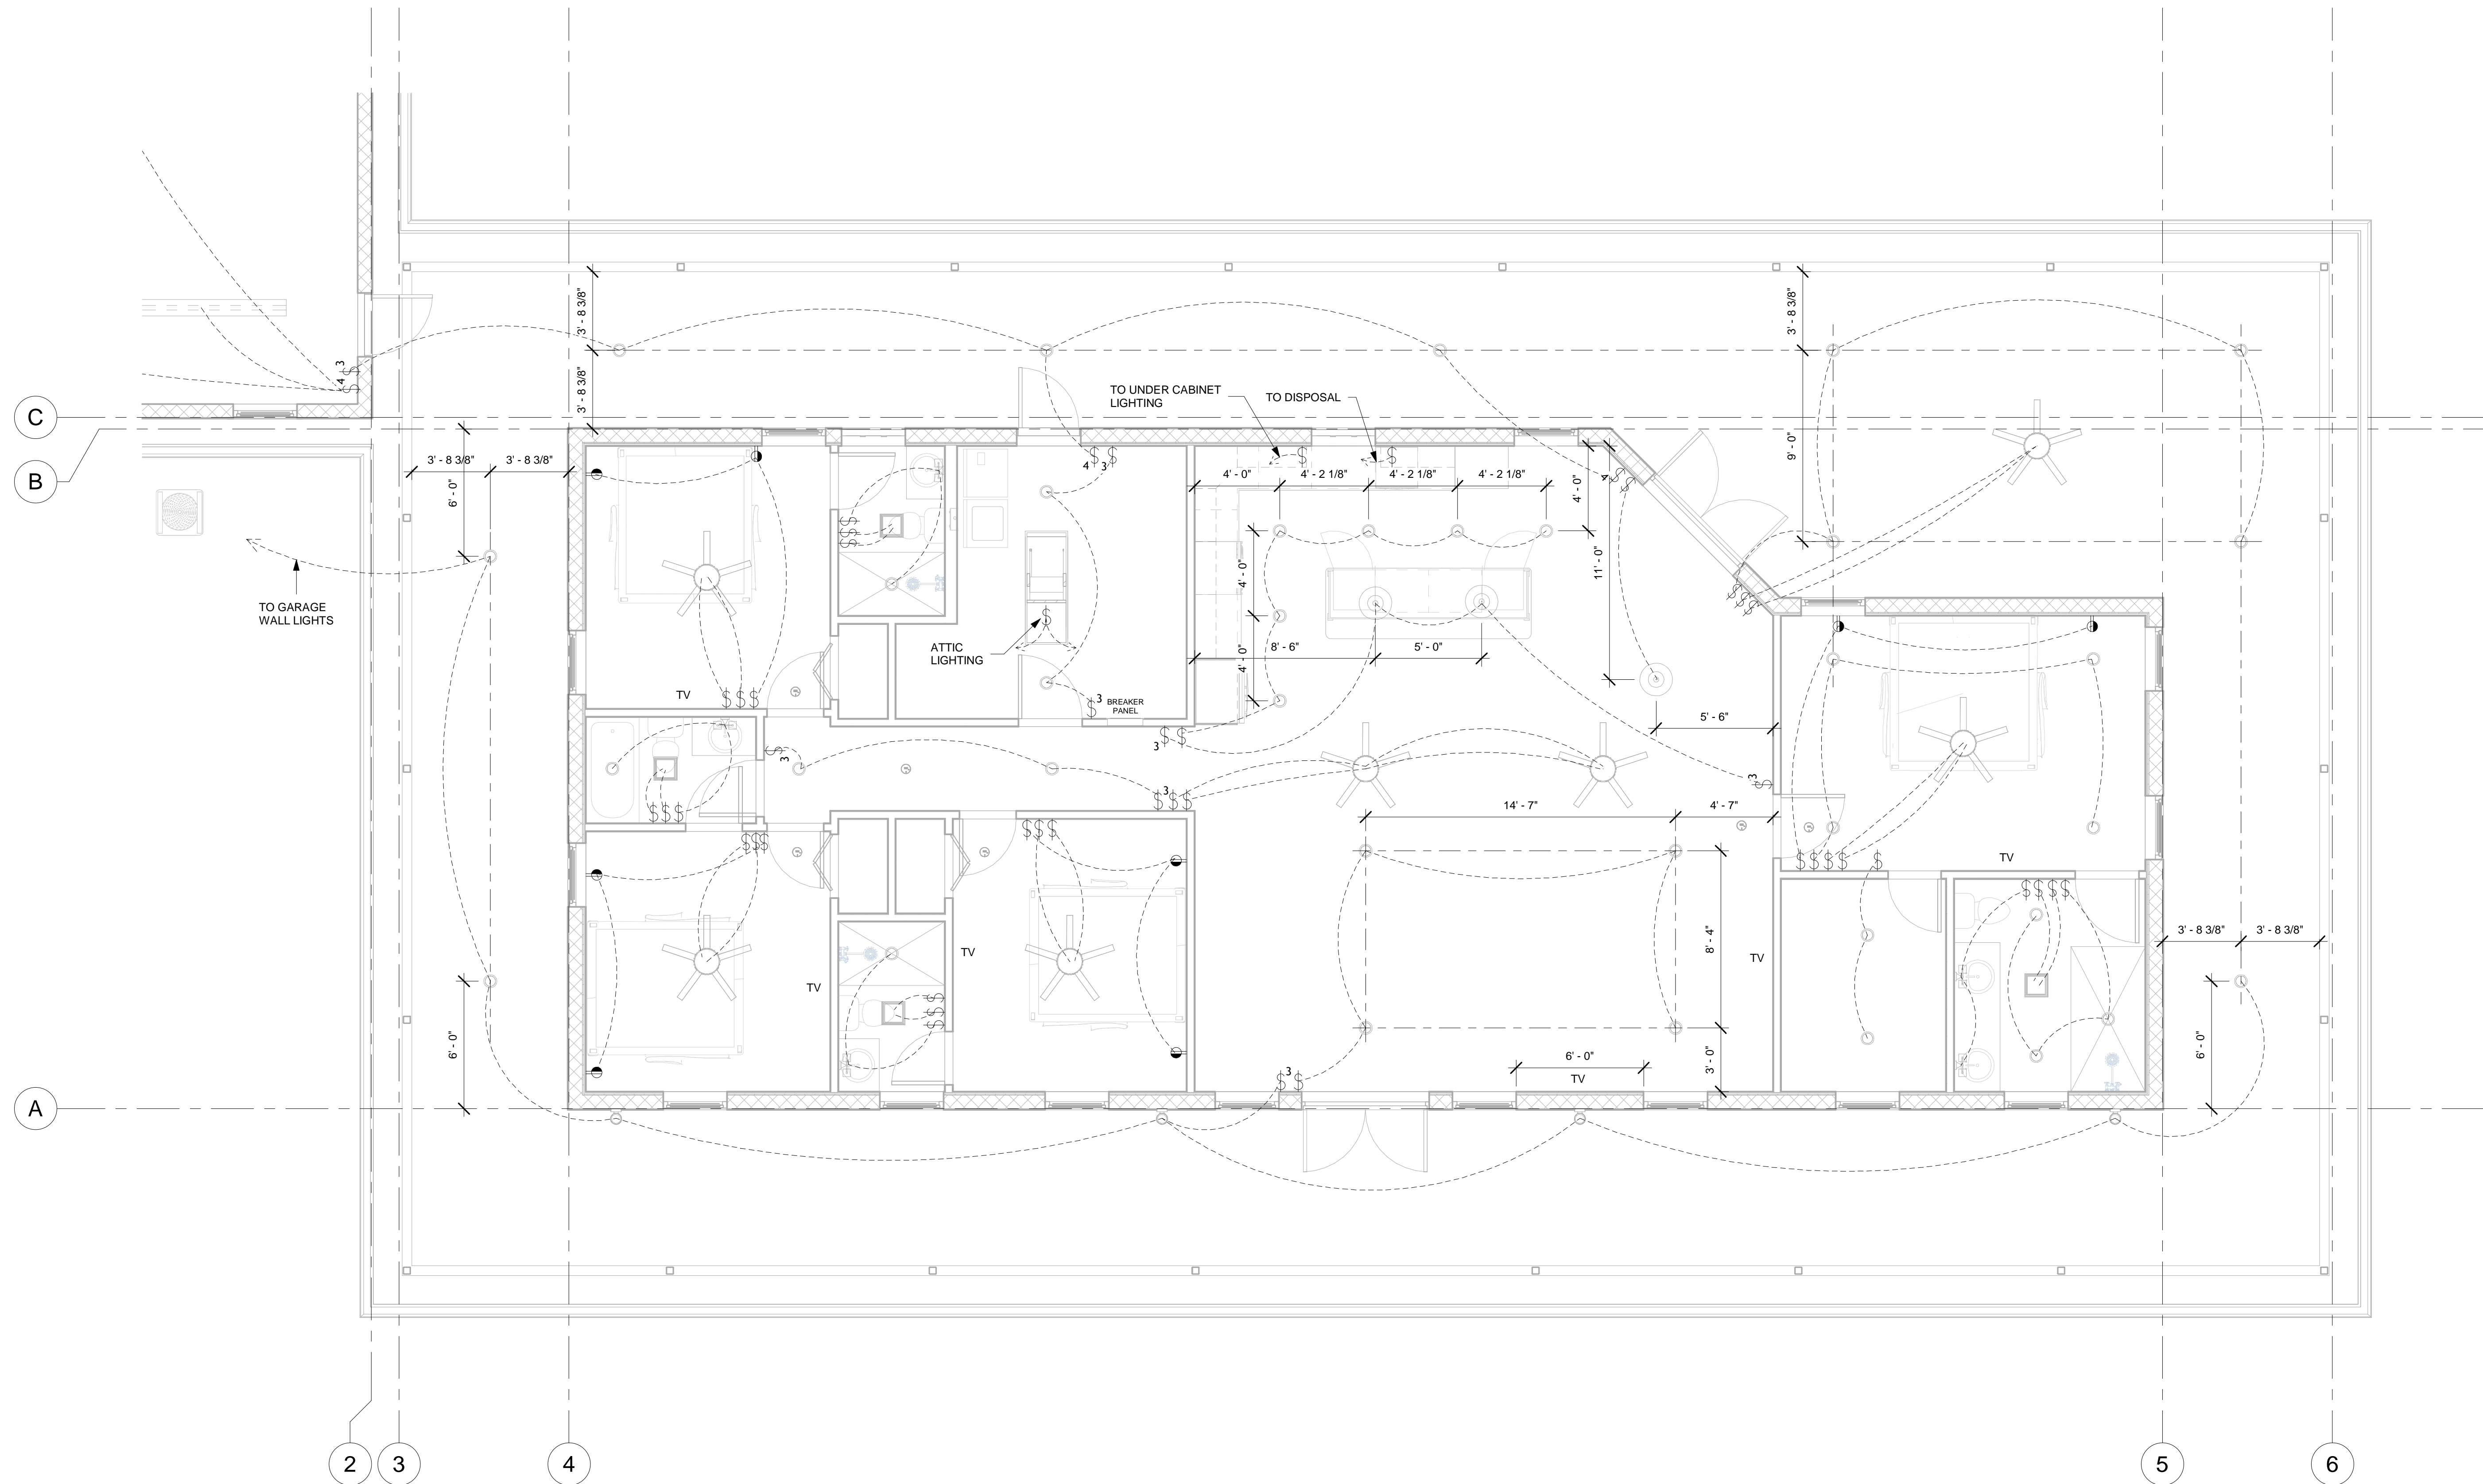

1 **Lighting Plan**  
 1/4" = 1'-0"

**Dana & Carol (Wendy) Anderson  
 Residence**  
 SW Meadowlands Drive  
 Lake City, Florida

| No. | Description | Date |
|-----|-------------|------|
|     |             |      |
|     |             |      |
|     |             |      |

Proposed Residence

Electric - Lighting Plan

|                |            |
|----------------|------------|
| Project number | 24-045     |
| Date           | 12/25/2024 |
| Drawn by       | A.O.       |
| Checked by     | T.K.       |

**E101**

Scale 1/4" = 1'-0"