

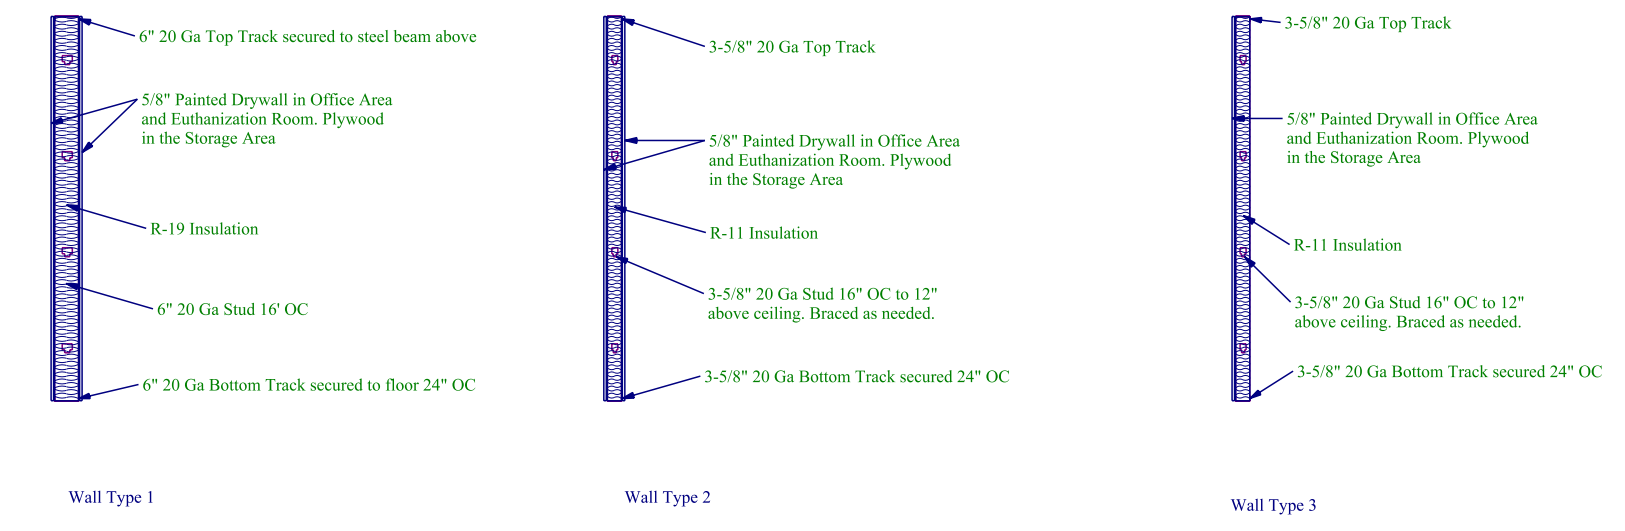



**Animal Control Floor Plan**  
SCALE: 1/8" = 1'-0"

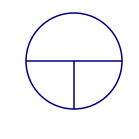




This document involves Confidential proprietary design rights of the Owner and shall remain the property of the Owner. It is submitted under a non-disclosure agreement for a specific purpose and the recipient by accepting this document will not be copied or reproduced in whole or in part, nor its content will be used for any other project without the express written consent of the Owner for which it was delivered, and (b) that any special features peculiar to this design will not be incorporated in other projects.

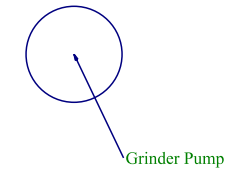


**Animal Control Electrical Plan**  
SCALE: 1/8" = 1'-0"

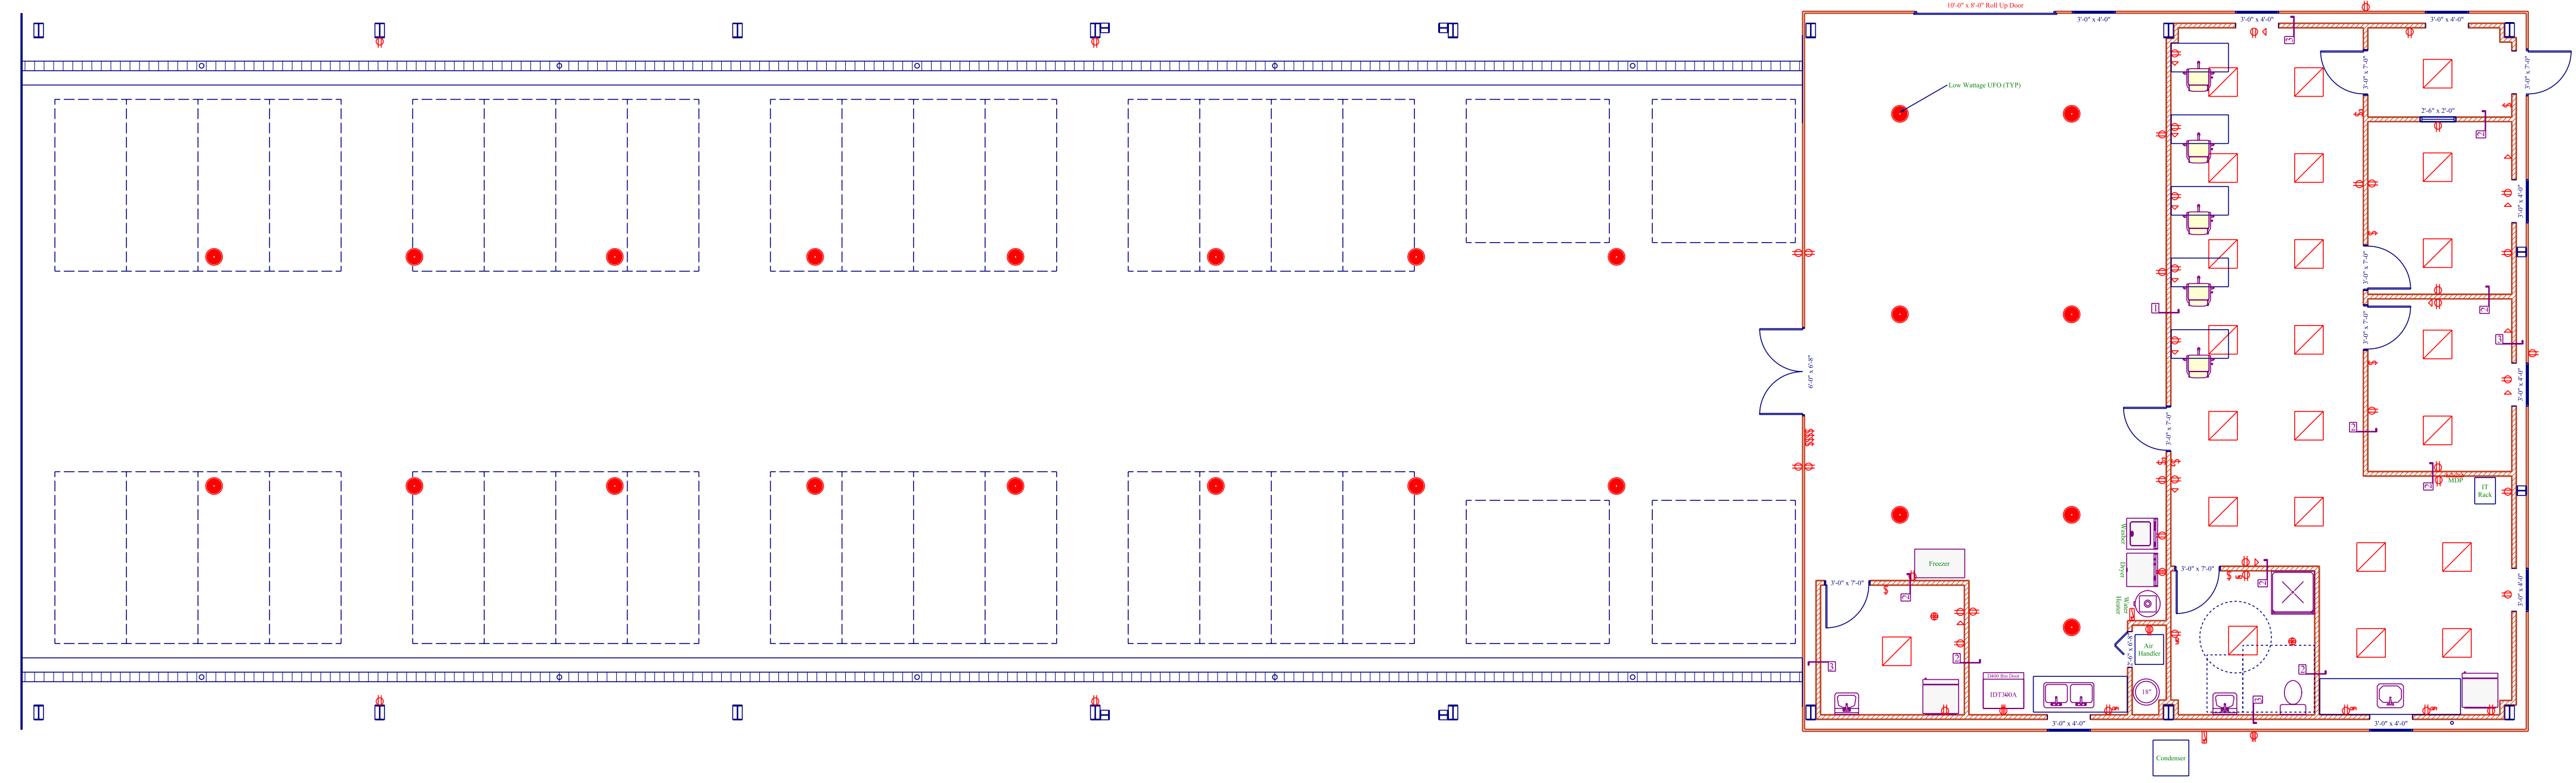

Room No.	Room Name	Panel	Lighting	Other
101	Office	101-1	10	
102	Office	102-1	10	
103	Office	103-1	10	
200	Office	200-1	10	

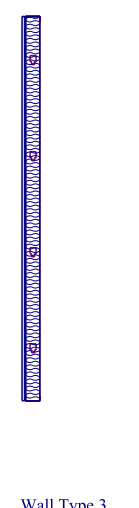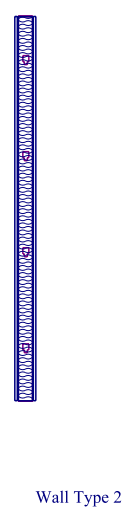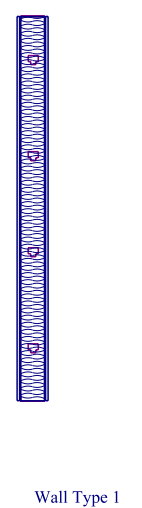

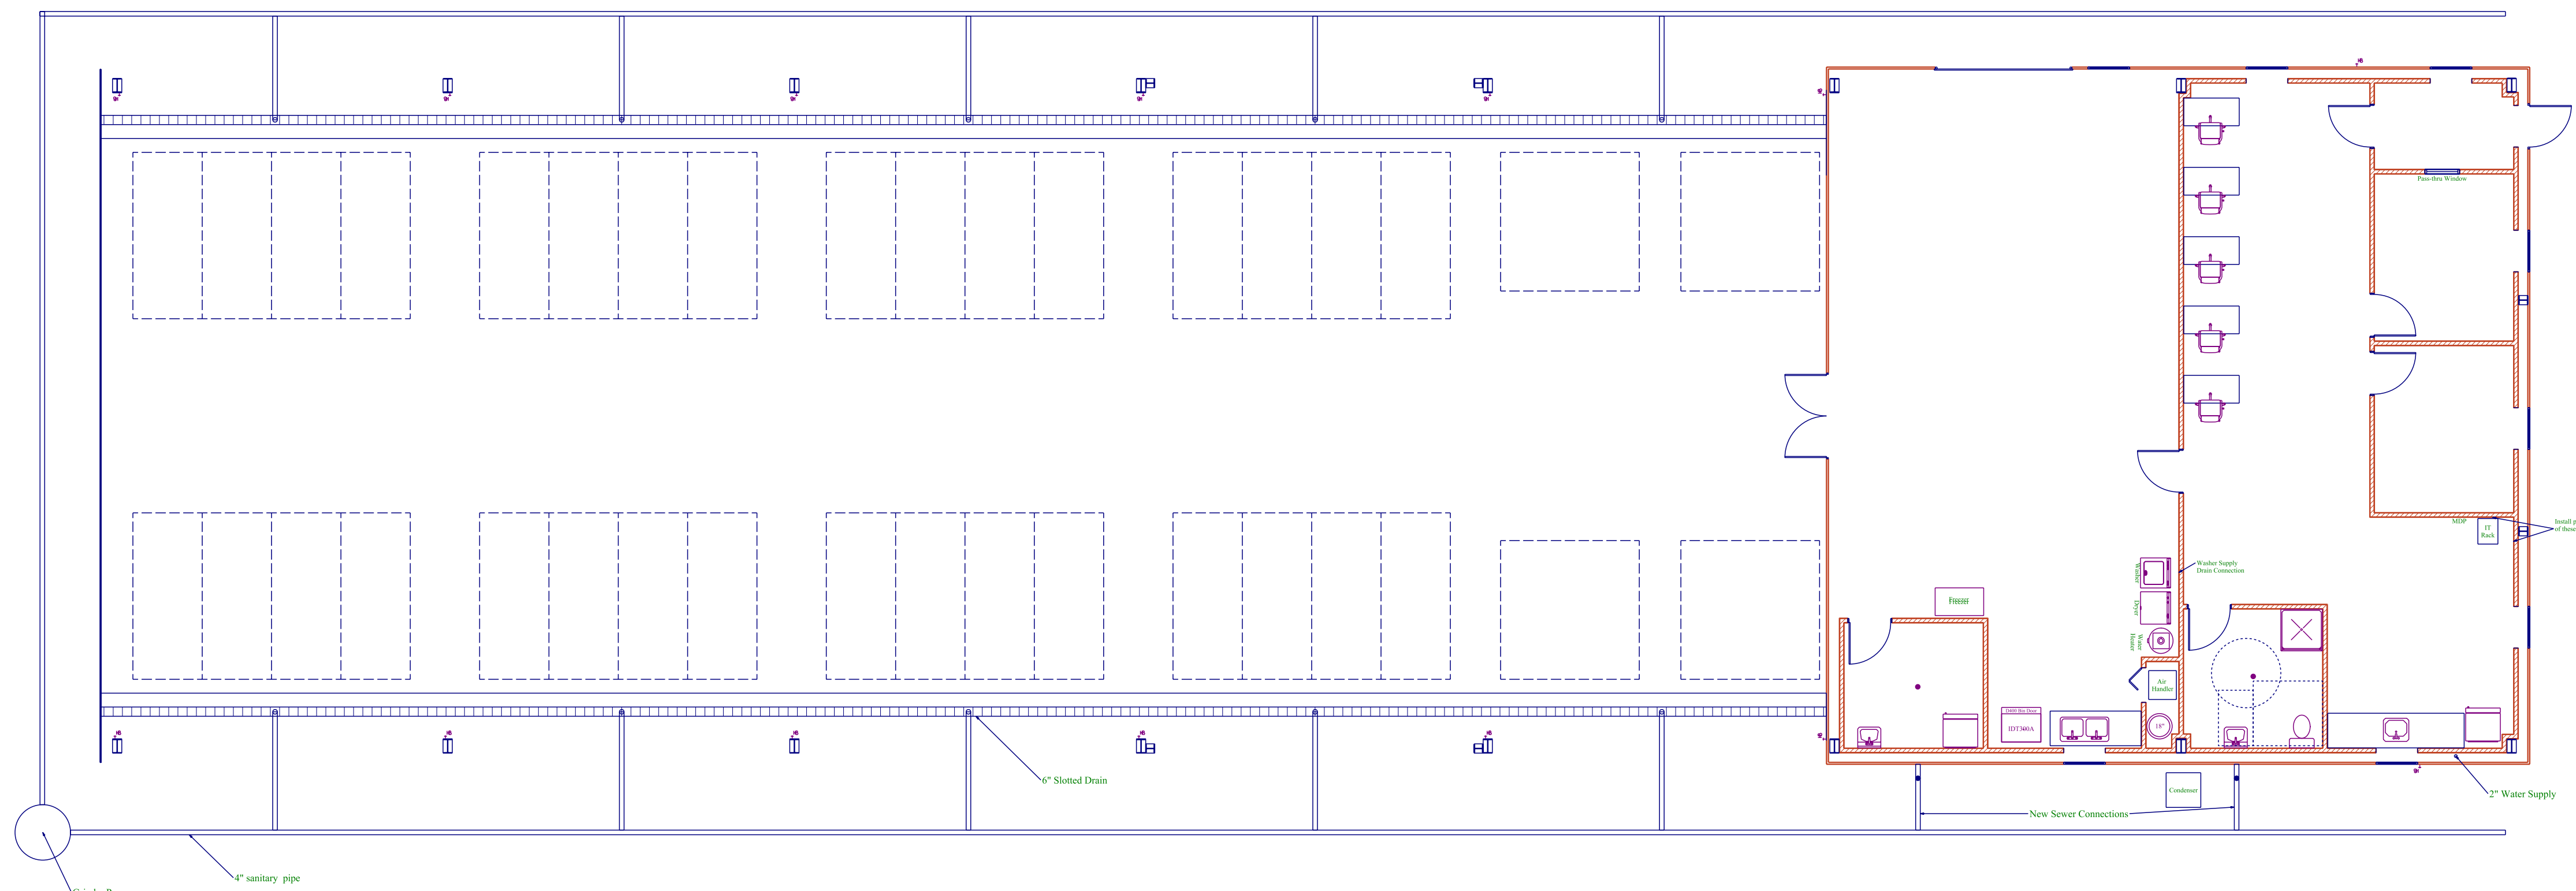

**Animal Control Plumbing Plan**  
 SCALE: 1/8" = 1'-0"

- 6" 20 Ga Top Track secured to steel beam above
  - 5/8" Painted Drywall in Office Area and Euthanization Room. Plywood in the Storage Area
  - R-19 Insulation
  - 6" 20 Ga Stud 16" OC
  - 6" 20 Ga Bottom Track secured to floor 24" OC
- 3-5/8" 20 Ga Top Track
  - 5/8" Painted Drywall in Office Area and Euthanization Room. Plywood in the Storage Area
  - R-11 Insulation
  - 3-5/8" 20 Ga Stud 16" OC to 12" above ceiling. Braced as needed.
  - 3-5/8" 20 Ga Bottom Track secured 24" OC
- 3-5/8" 20 Ga Top Track
  - 5/8" Painted Drywall in Office Area and Euthanization Room. Plywood in the Storage Area
  - R-11 Insulation
  - 3-5/8" 20 Ga Stud 16" OC to 12" above ceiling. Braced as needed.
  - 3-5/8" 20 Ga Bottom Track secured 24" OC