


MAIN FLOOR PLAN

TR-61
 COM-103
 SEE DETAILS


MARY
 2' OVER HANGS + EGGS
 Roseboom Con

L# 135

DATE 8/15/06	
COLACINO DRAFTING & DESIGN	PH. 352-472-3462
SCALE 1/4" = 1'	DRAWN BY P.A.C.
MCALHANY RESIDENCE	

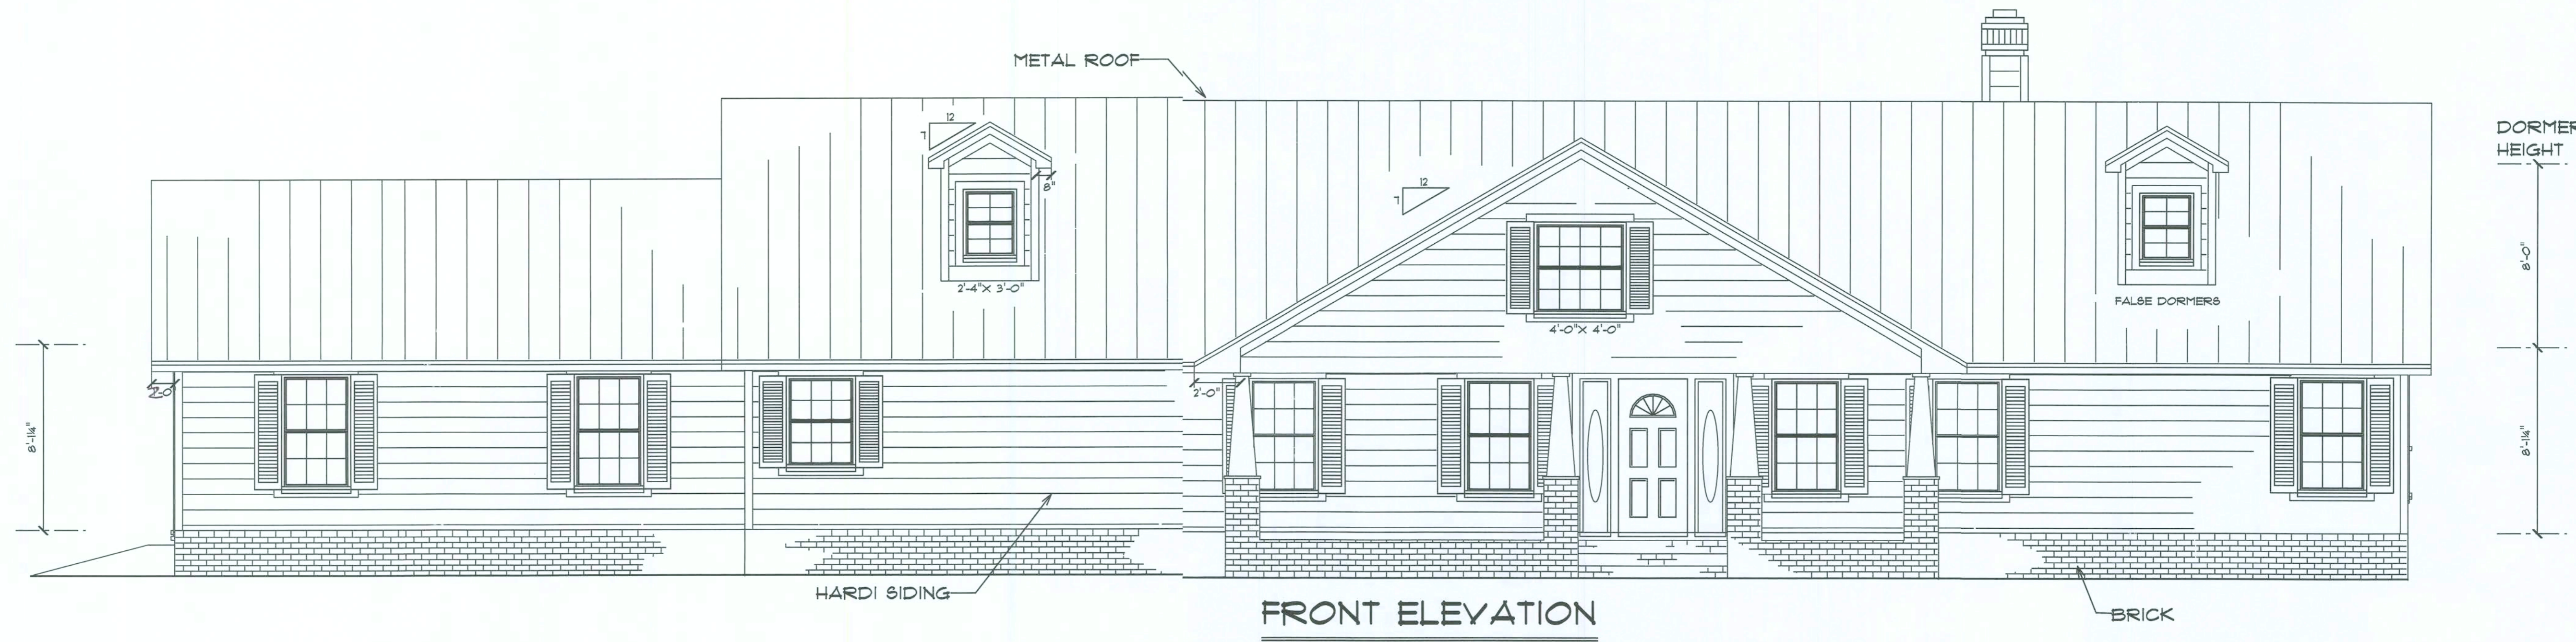

FRONT ELEVATION

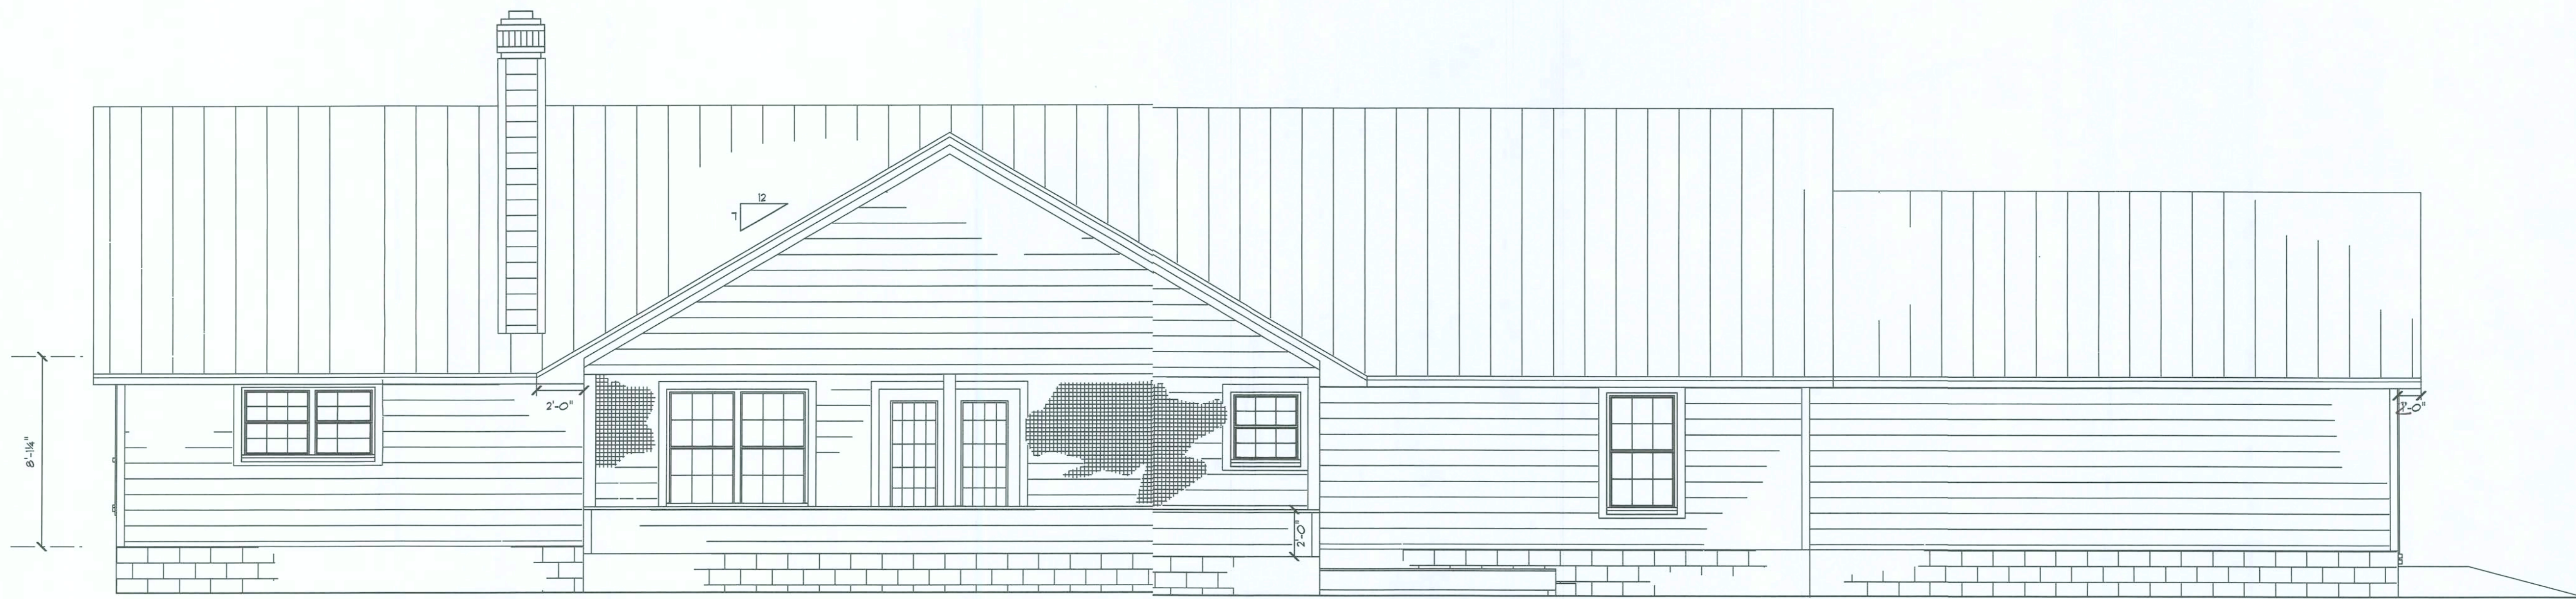

REAR ELEVATION

W


DATE 8/15/06 COLACINO DRAFTING&DESIGN PH. 352-472-3462	SCALE 1/4" = 1' DRAWN BY P.A.C. APPROVED
---	--

McALHANTY RESIDENCE


DATE 8/15/06
 COLACINO
 DRAFTING&DESIGN
 PH. 352-472-3462

SCALE 1/4" = 1'
 DRAWN BY P.A.C.
 APPROVED


McALHANY RESIDENCE

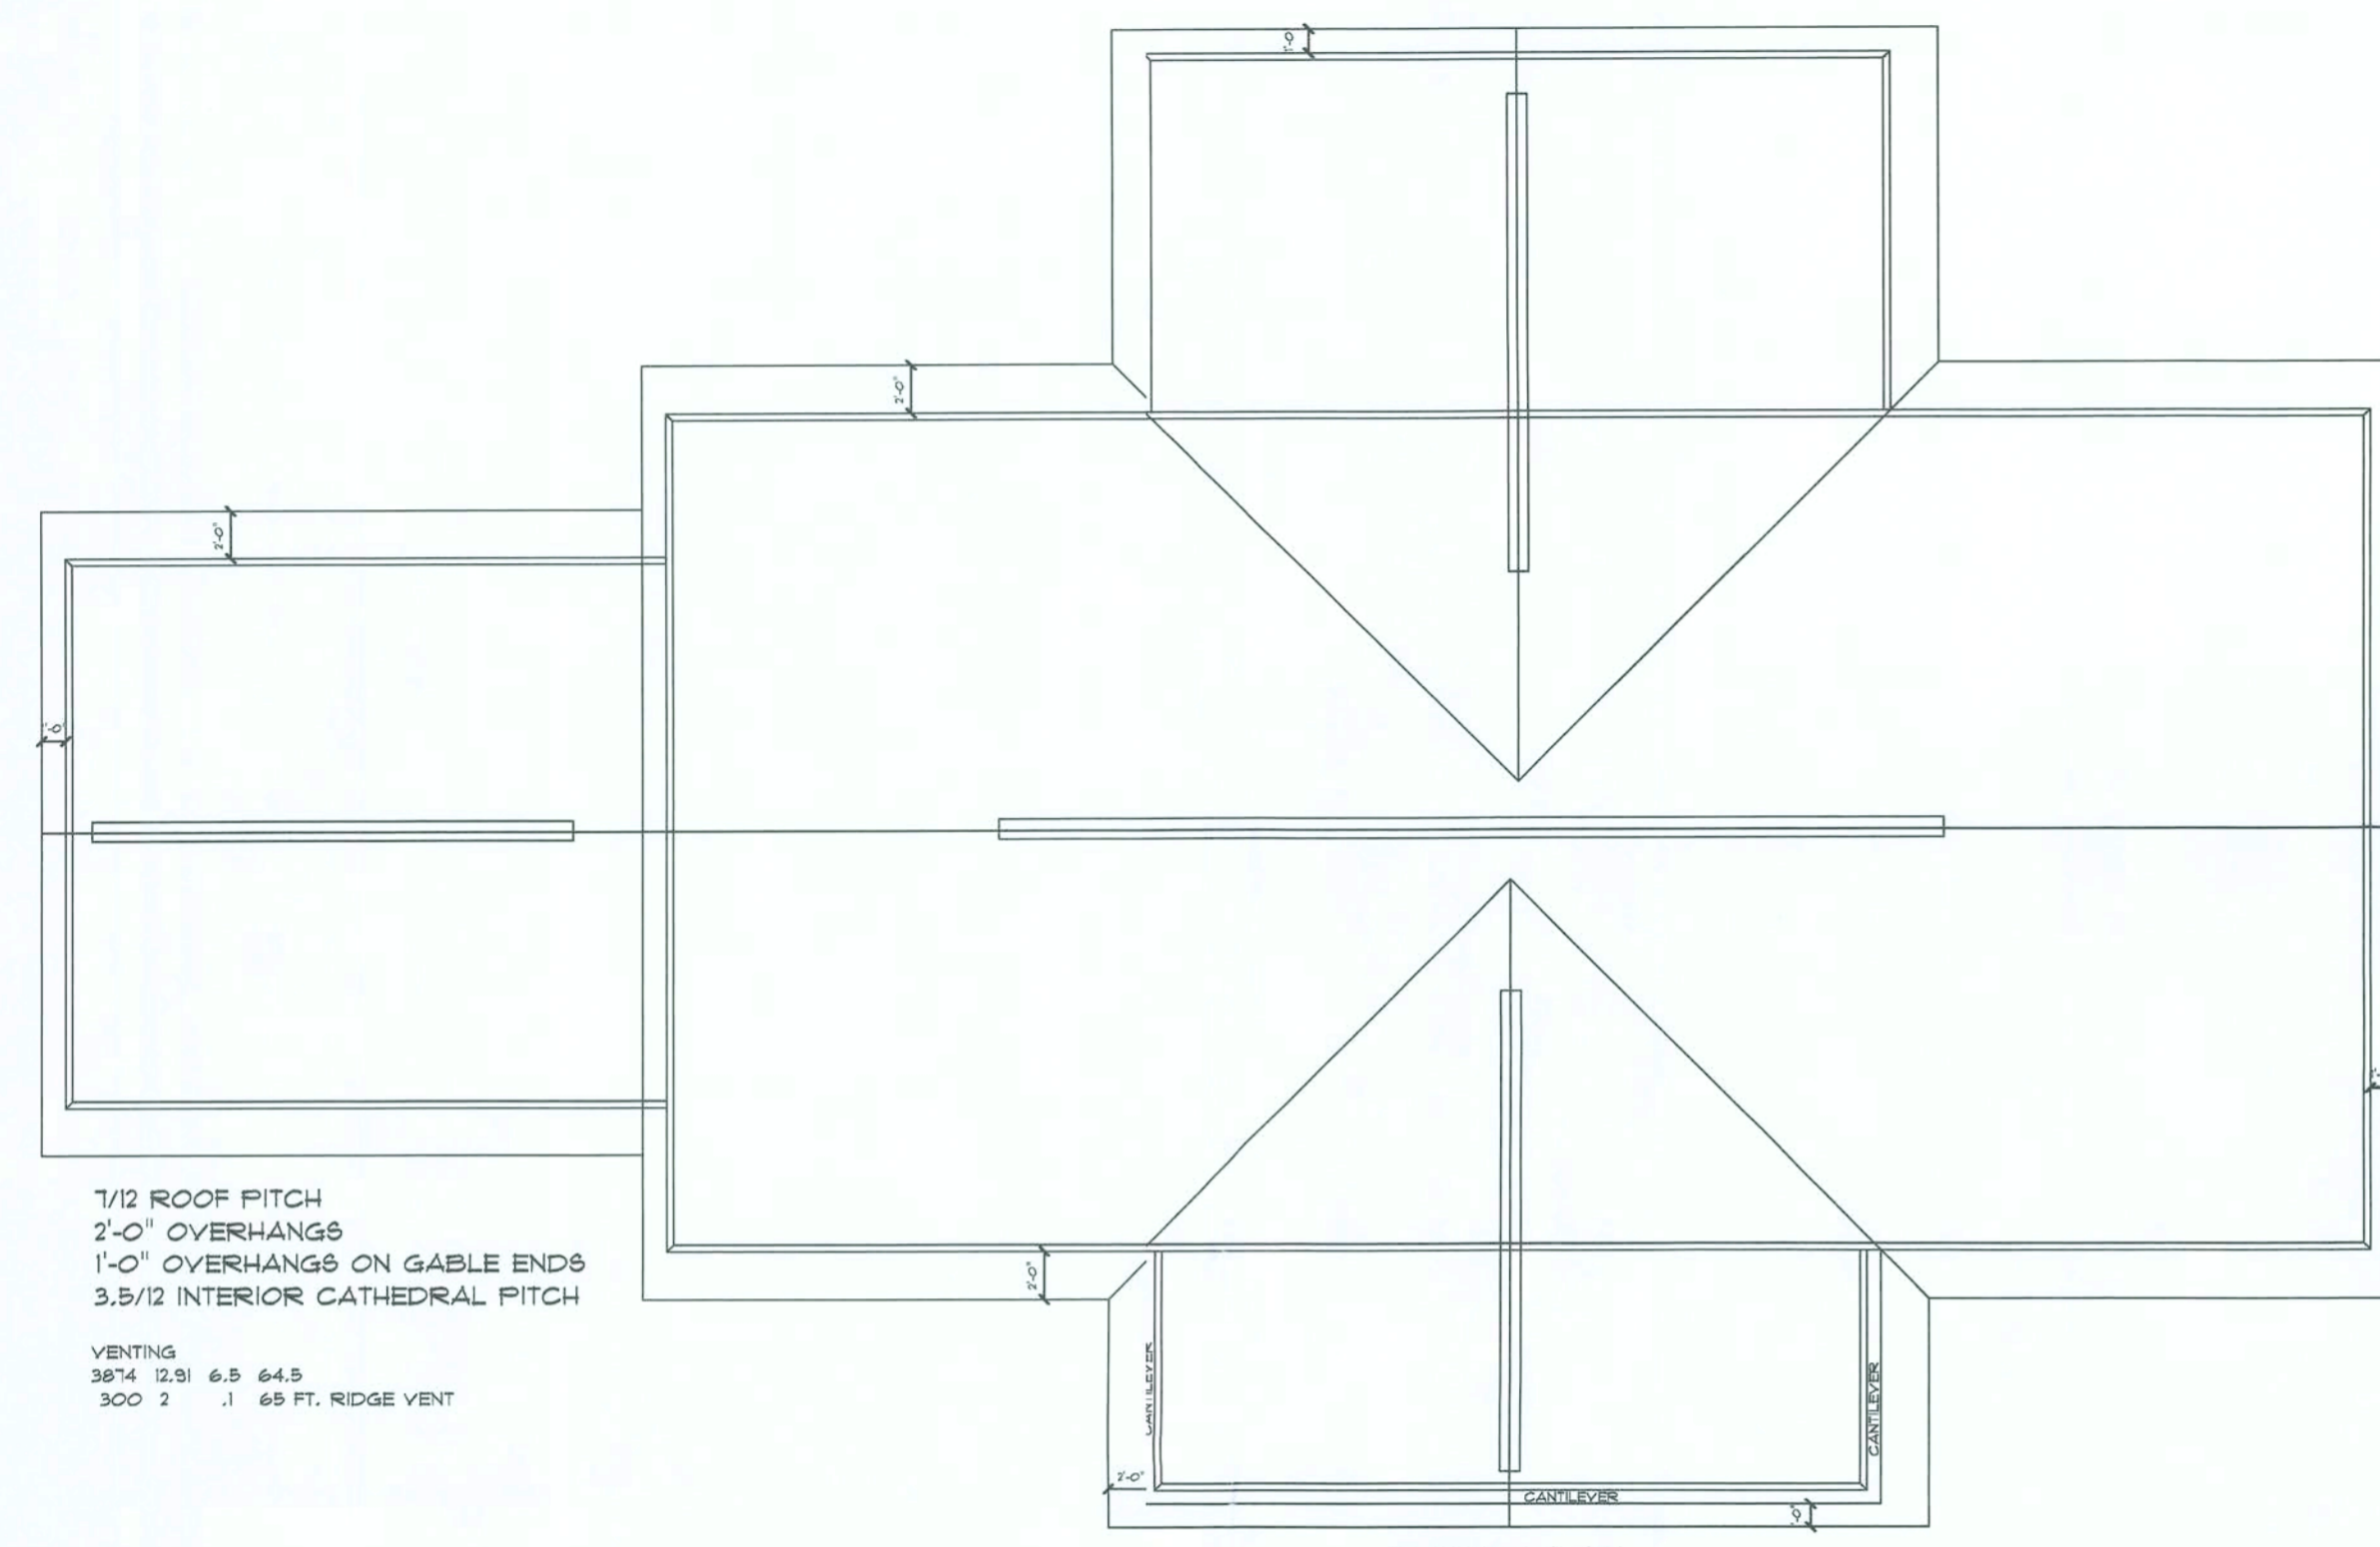

ROOF PLAN
 1/8" SCALE

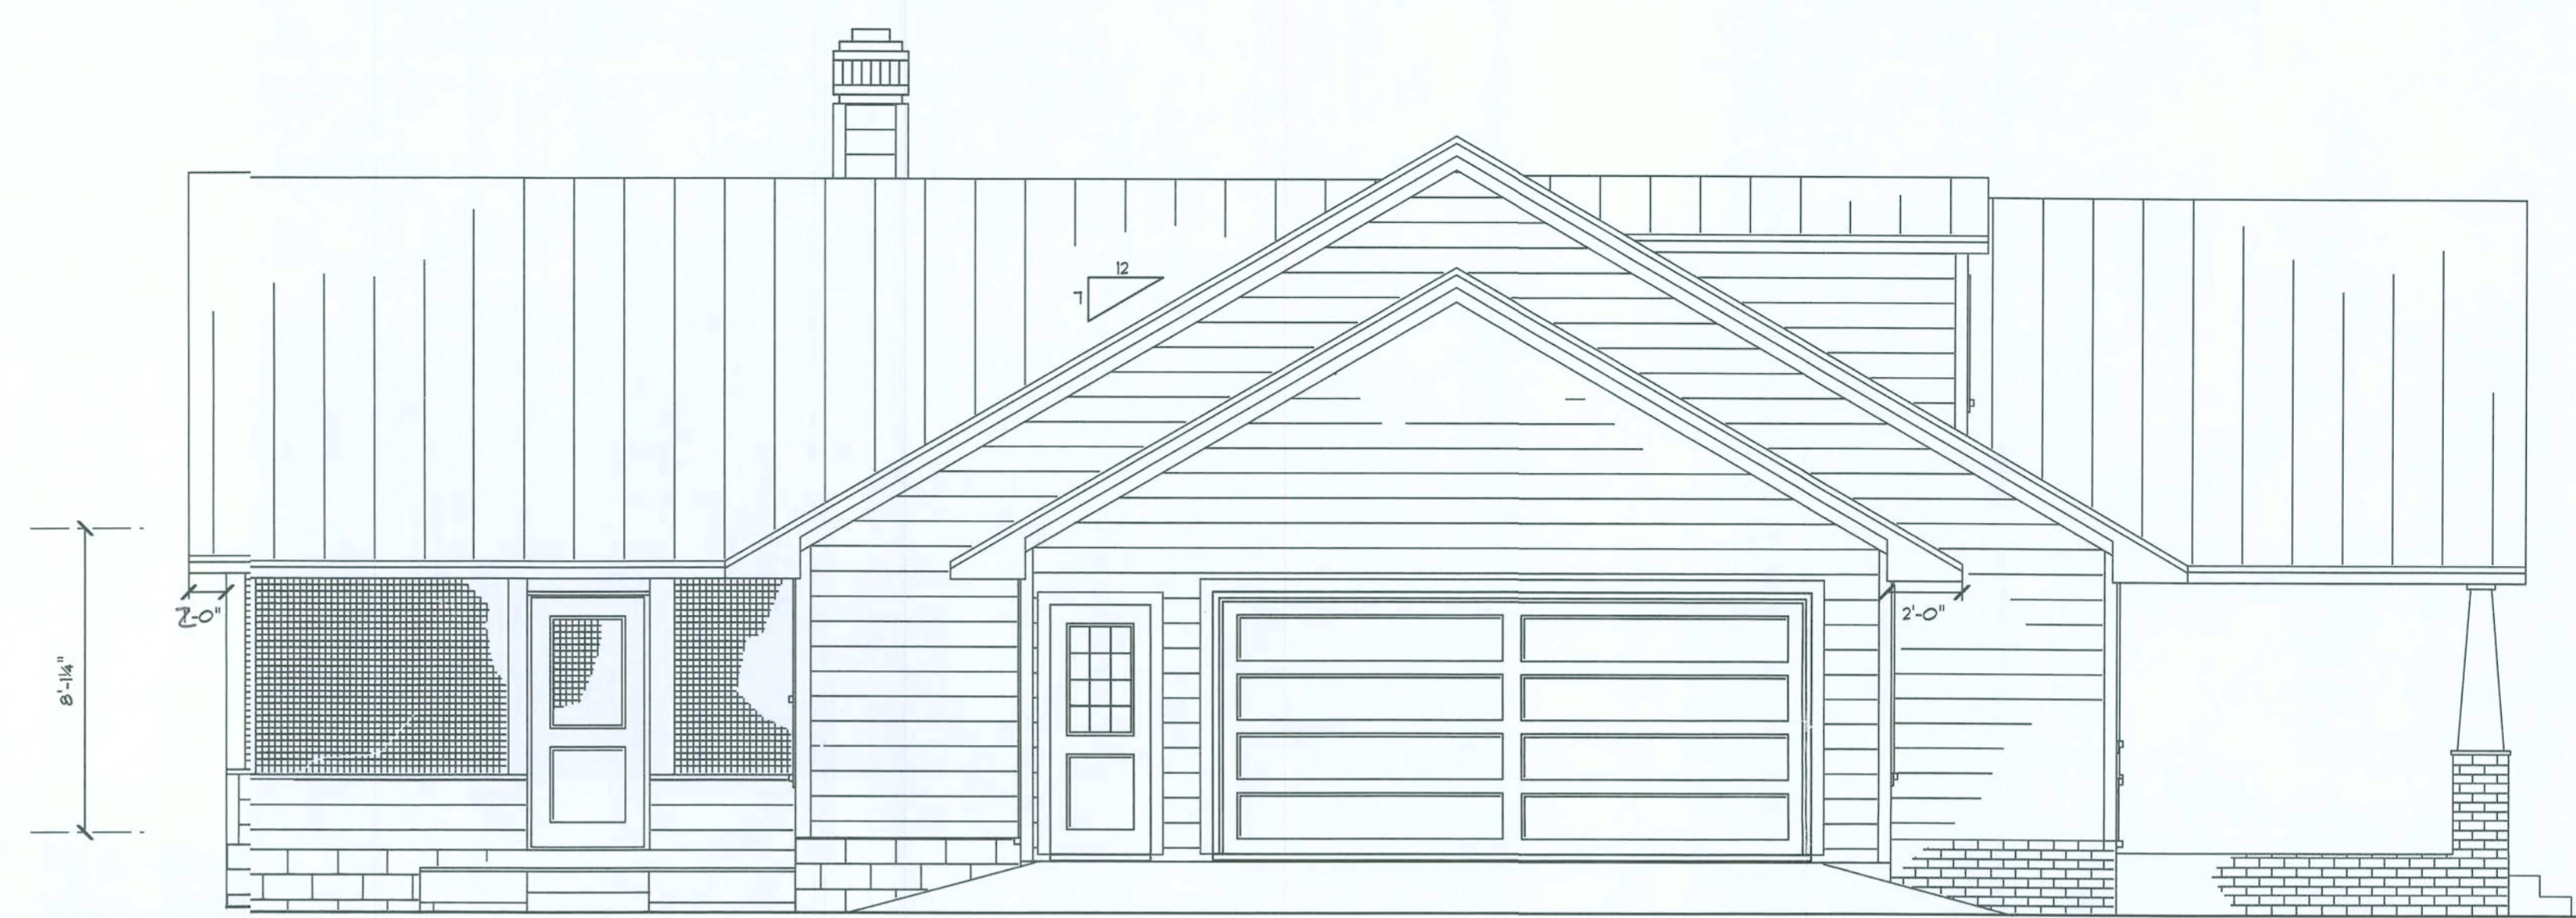


LEFT ELEVATION

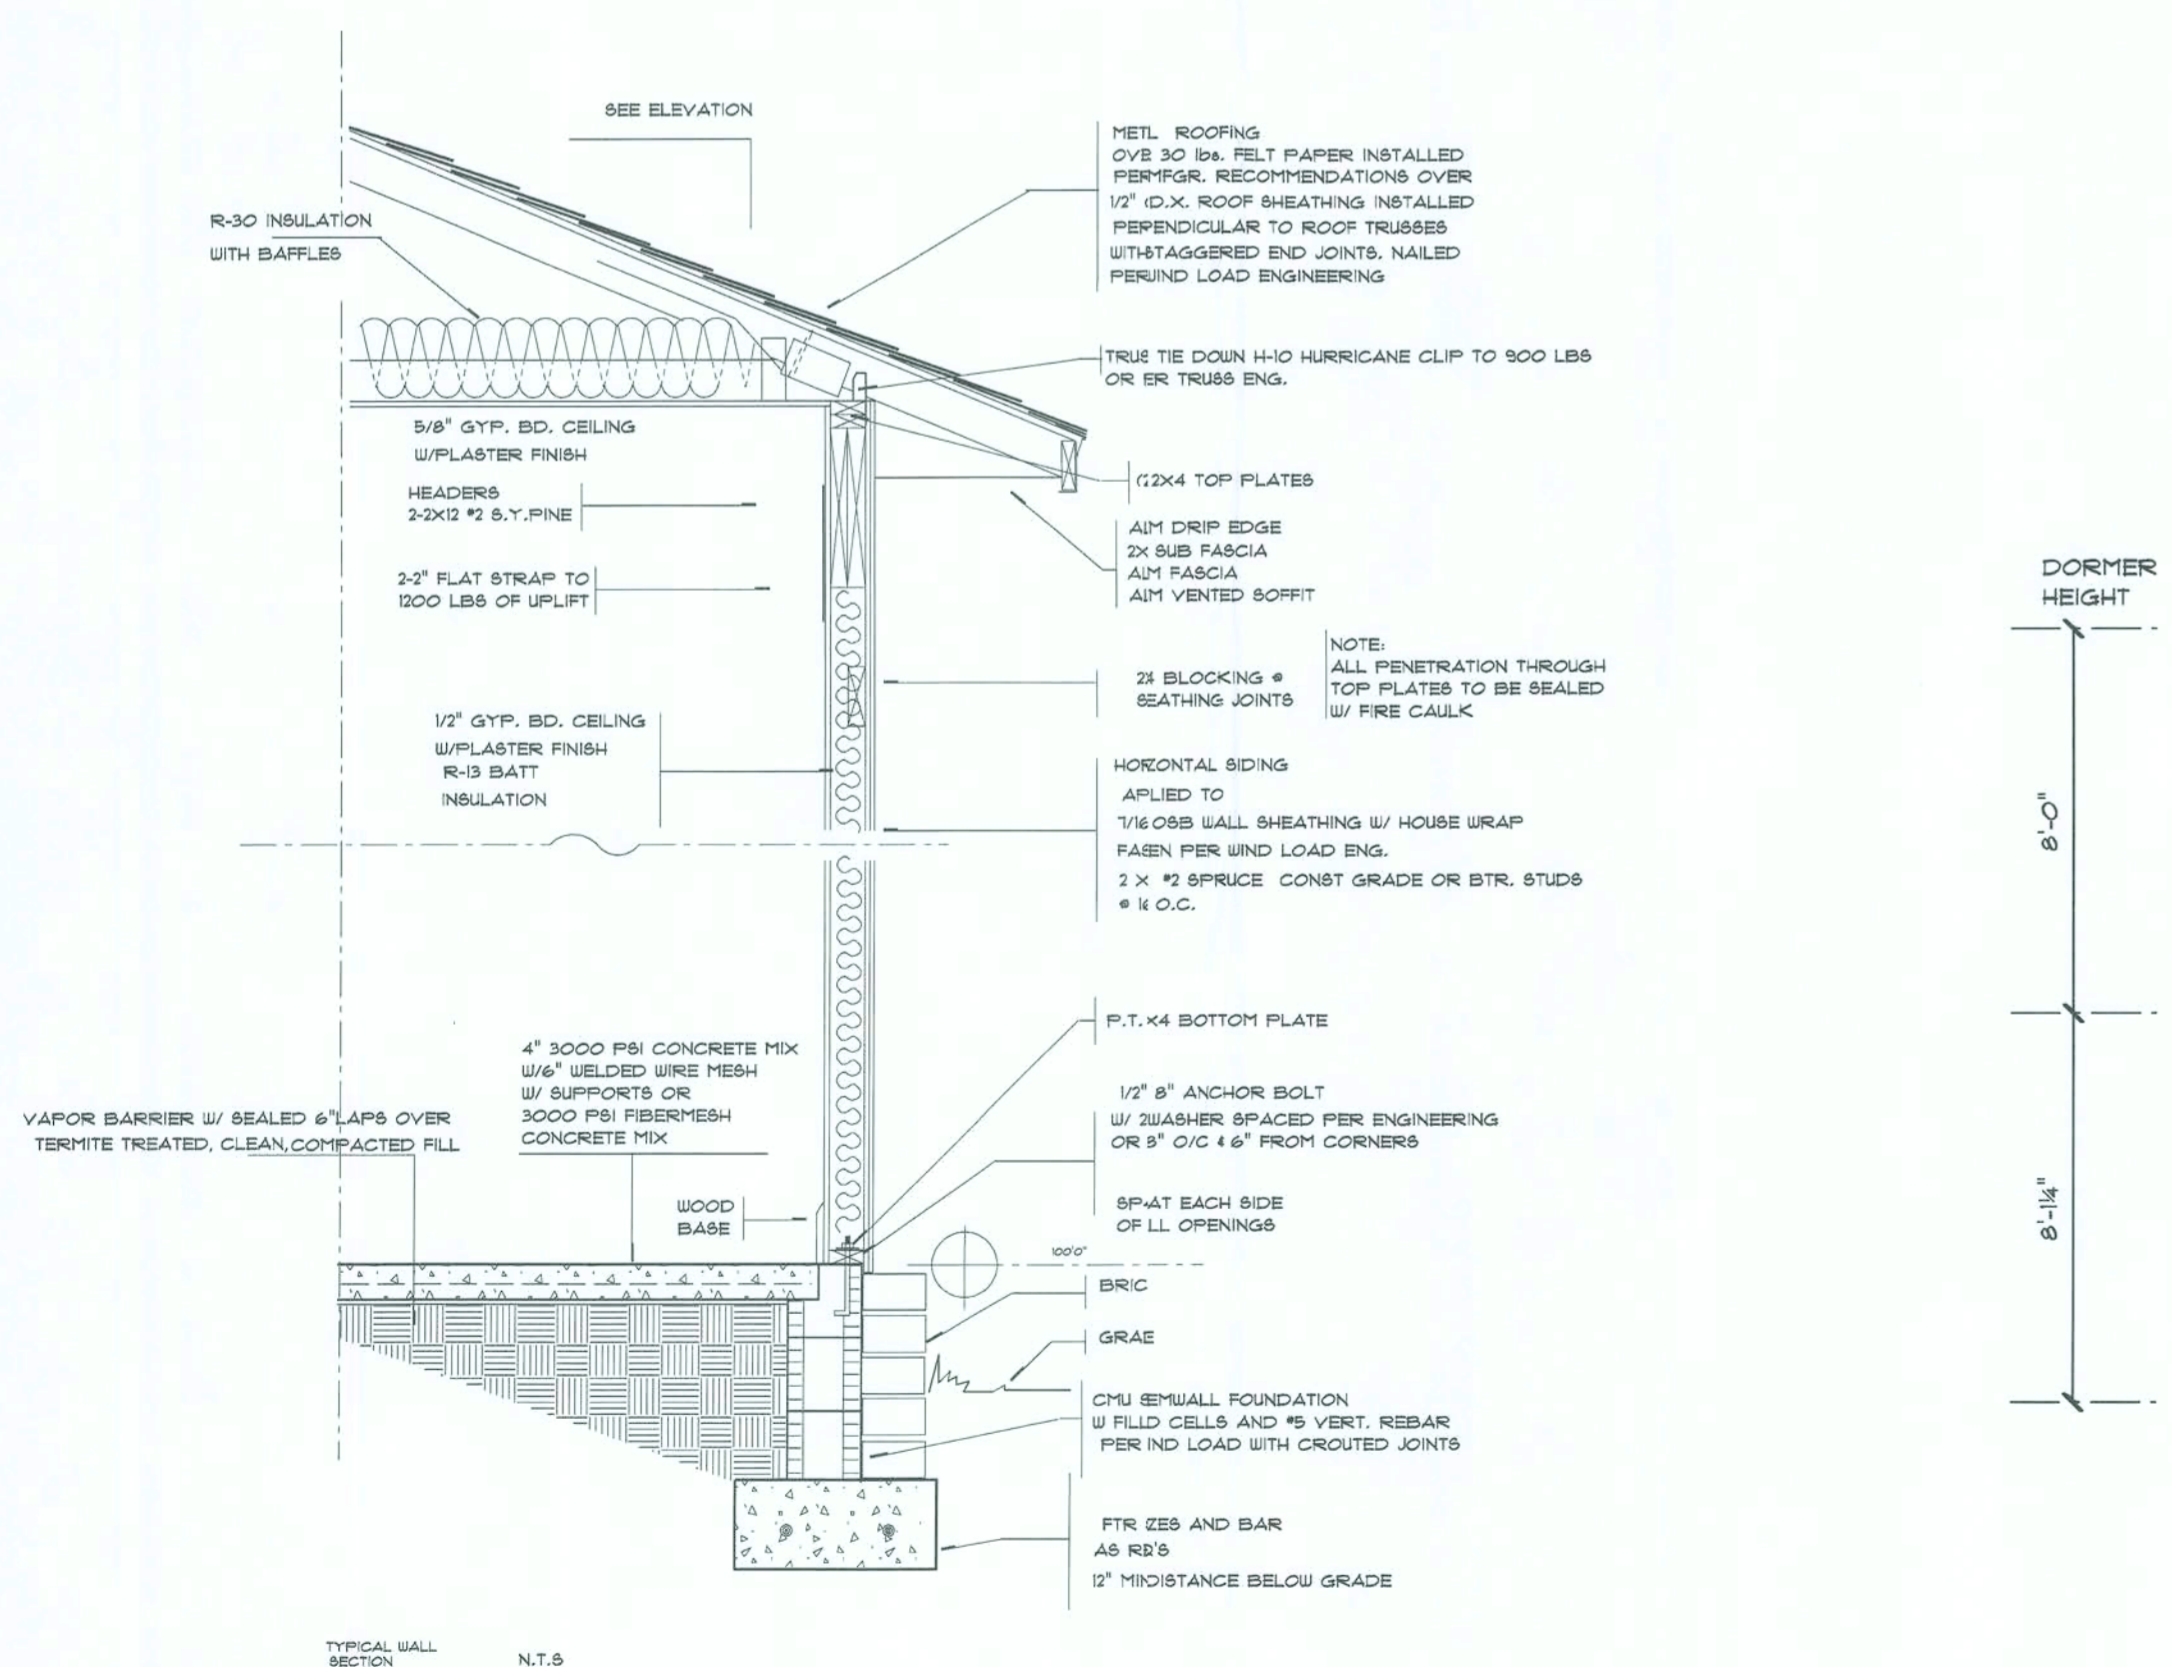

TYPICAL WALL SECTION N.T.S.



RIGHT ELEVATION

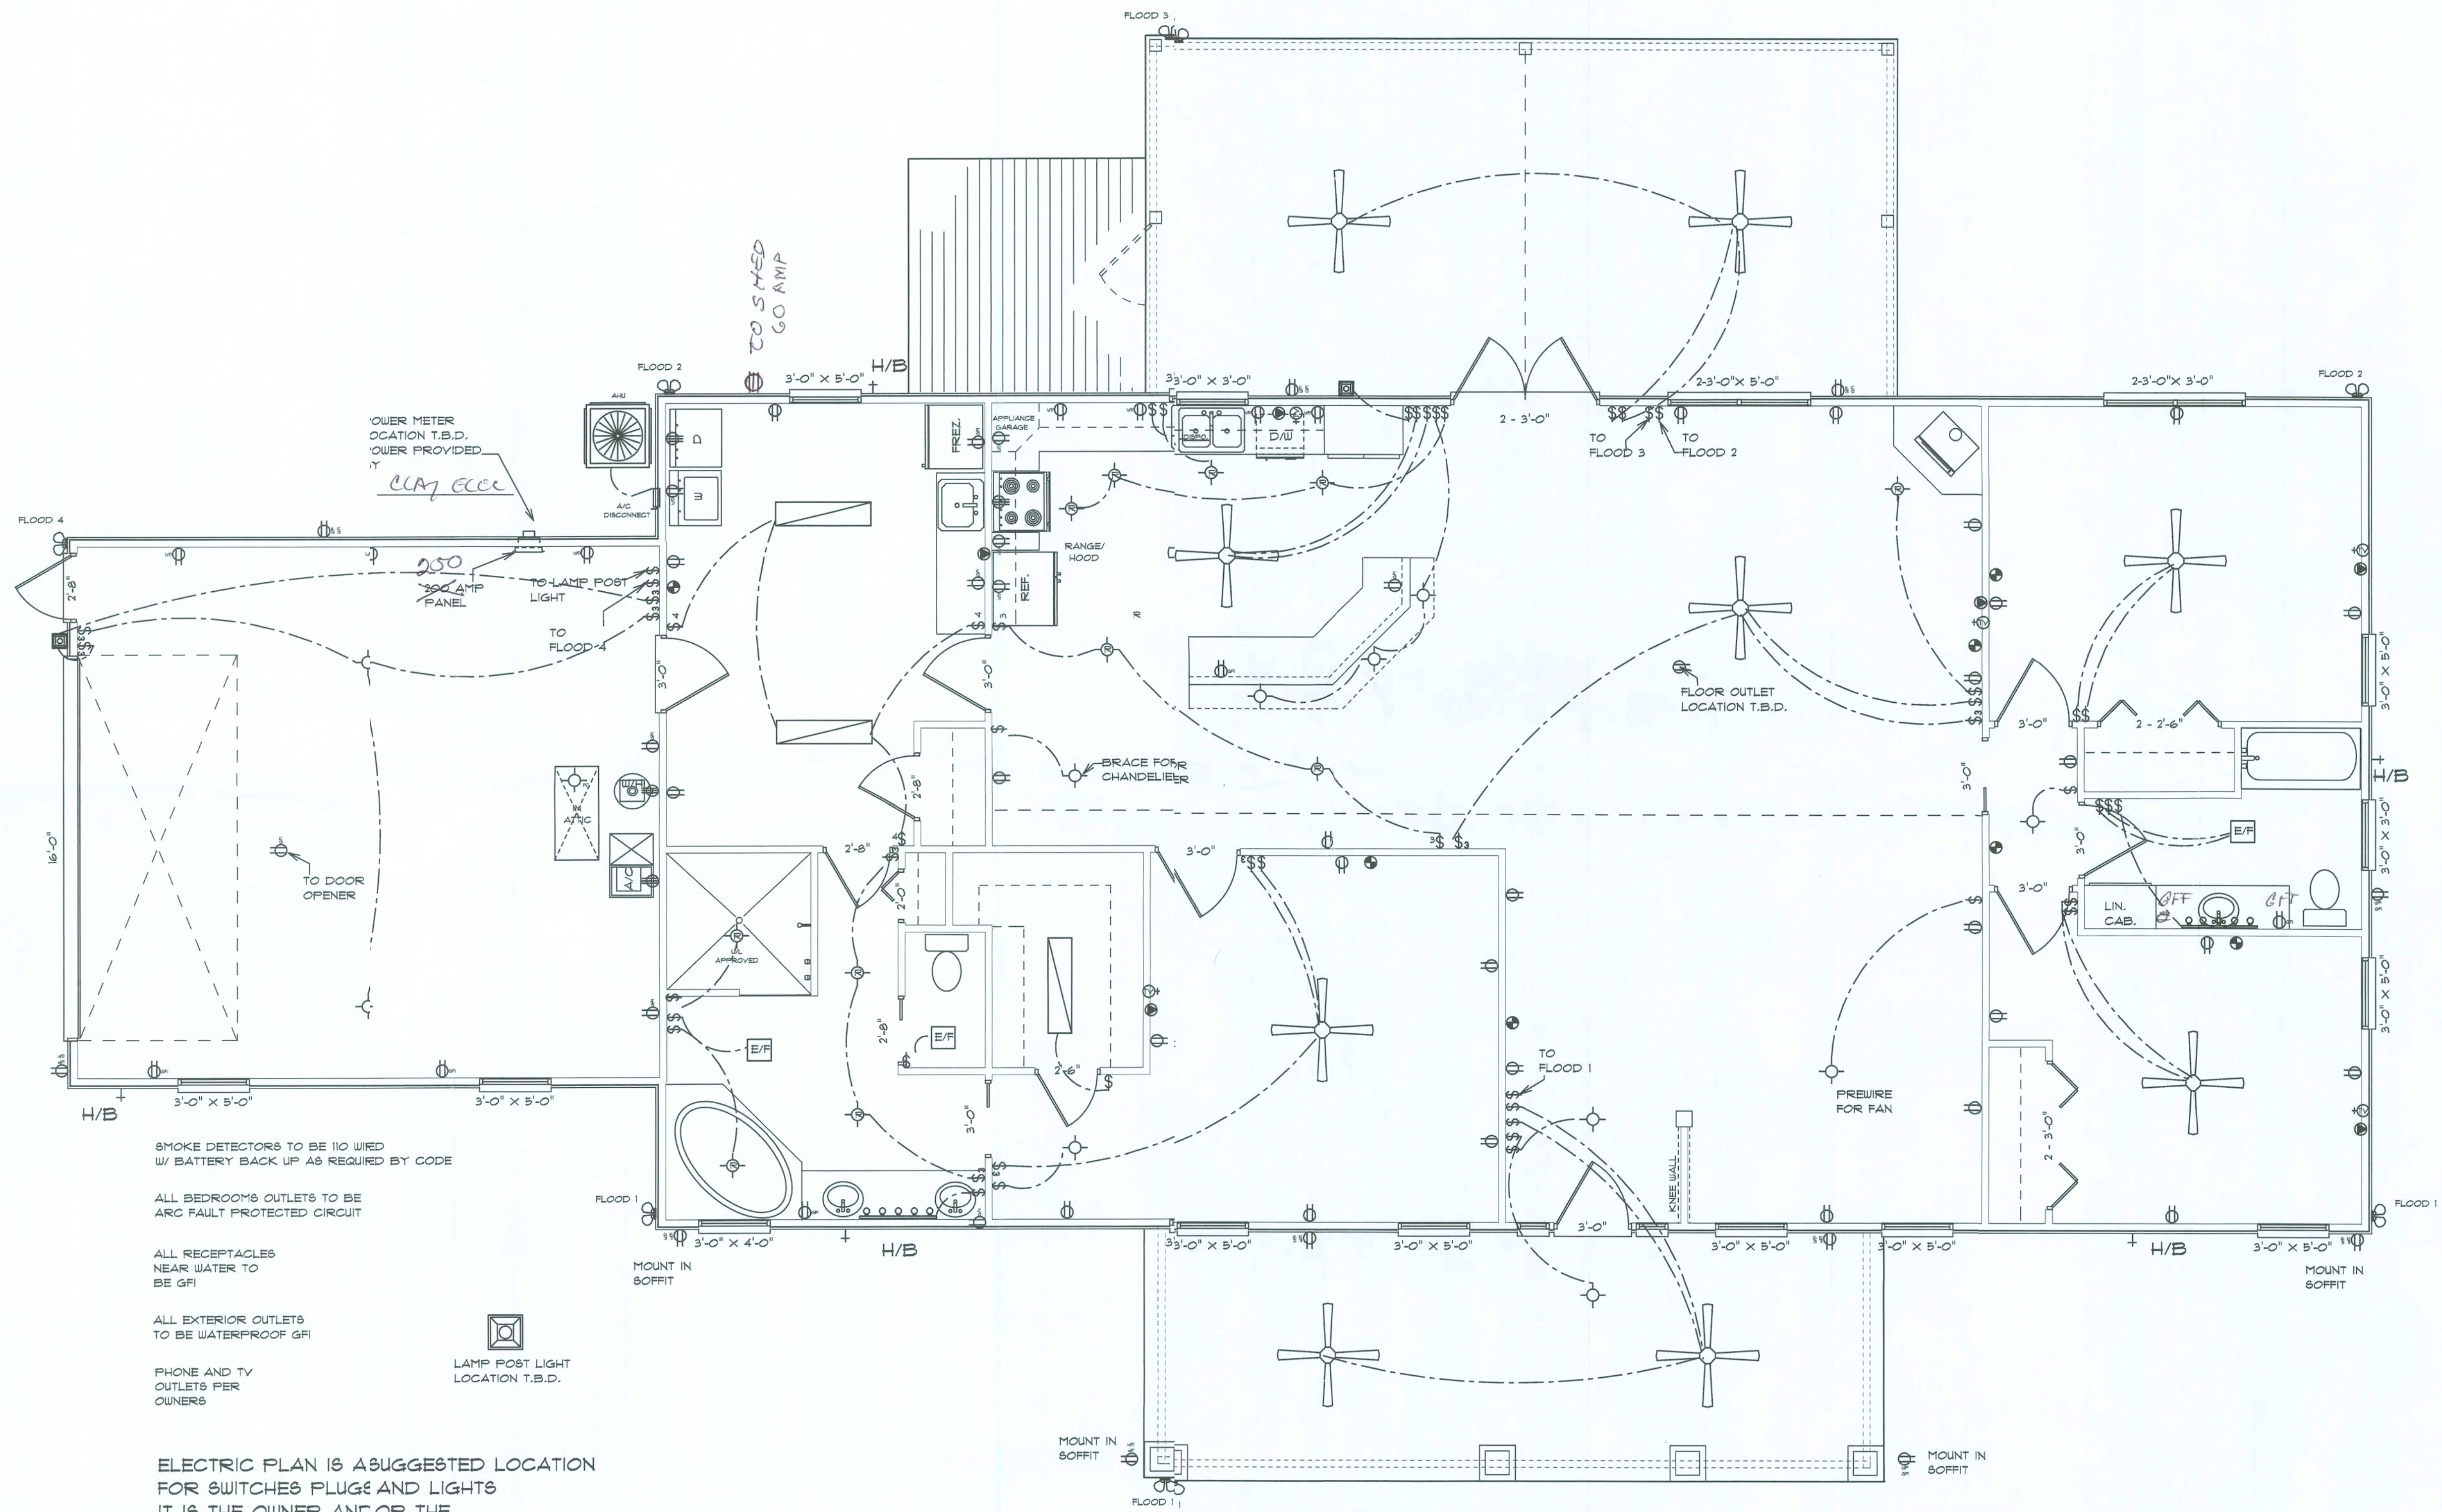

ELECTRICAL SYMBOLS	
OUTLET	⊕
220 OUTLET	⊕⊕
SWITCH	⊞
LIGHT	⊙
RECESS LIGHT	⊙⊕
PULL CHAIN	⊕PC
FLUORESCENT	⊕
CEILING FAN	⊕
WALL MOUNT LIGHT	⊕
VANITY LIGHT	⊕⊕⊕⊕
FLOOD LIGHT	⊕
CLG. LITE/FAN	⊕
PANEL	⊕
SMOKE DETECTOR	⊕
TV/CABLE/INTERNET	⊕
PHONE	⊕

ELECTRICAL PLAN

UT

DATE 8/15/06
 COLACINO DRAFTING & DESIGN
 PH. 352-472-3462

SCALE 1/4" = 1'
 P.A.C.

McALHANY RESIDENCE