

PHOTOVOLTAIC ROOF MOUNT SYSTEM

33 MODULES-ROOF MOUNTED - 14.190 kW DC, 11.400 kW AC

269 S W THOMAS RD, LAKE CITY, FL 32024


This item has been digitally signed and sealed by Richard Pantel, P.E. on the date
 adjacent to the signature. Printed copies of this document are not considered signed and
 sealed and the signature must be verified on all electronic copies.




LUNEX POWER INC.
 4721 N GRADY AVE
 TAMPA FL 33614
 LIC #: CVC57085
 PHONE: 813-540-8807

PROJECT DATA	
PROJECT ADDRESS	269 S W THOMAS RD, LAKE CITY, FL 32024
OWNER:	DELEON KELLY
CONTRACTOR:	LUNEX POWER INC. 4721 N GRADY AVE TAMPA FL 33614 PHONE: 813-540-8807
DESIGNER:	ESR
SCOPE:	14.190 KW DC ROOF MOUNT SOLAR PV SYSTEM WITH 33 QCELLS: Q.TRON BLK M-G2.C+ 430W PV MODULES WITH 33 SOLAREEDGE: U650 POWER OPTIMIZERS 01 SOLAREEDGE: DCA USE11400H-USMNB78INVERTER UPGRADE MAIN SERVICE PANEL TO 200A RATED BUS WITH 200A MAIN BREAKER AUTHORITIES HAVING JURISDICTION: BUILDING: COLUMBIA COUNTY ZONING: COLUMBIA COUNTY UTILITY: FPL
SHEET INDEX	
PV-1	COVER SHEET
PV-2	SITE PLAN
PV-3	ROOF PLAN & MODULES
PV-4	ELECTRICAL PLAN
PV-5	STRUCTURAL DETAIL
PV-6	ELECTRICAL LINE DIAGRAM
PV-7	WIRING CALCULATIONS
PV-7A	FAULT CURRENT CALCULATIONS
PV-8	LABELS
PV-9	PLACARD
PV-10	OPTIMIZER CHART
PV-11+	EQUIPMENT SPECIFICATIONS

GENERAL NOTES	
1.	ALL COMPONENTS ARE UL LISTED AND NEC CERTIFIED, WHERE WARRANTED.
2.	THE SOLAR PV SYSTEM WILL BE INSTALLED IN ACCORDANCE WITH ARTICLE 690 OF THE NEC 2020.
3.	THE UTILITY INTERCONNECTION APPLICATION MUST BE APPROVED AND PV SYSTEM INSPECTED PRIOR TO PARALLEL OPERATION.
4.	ALL CONDUCTORS OF A CIRCUIT, INCLUDING THE EGC, MUST BE INSTALLED IN THE SAME RACEWAY, OR CABLE, OR OTHERWISE RUN WITH THE PV ARRAY CIRCUIT CONDUCTORS WHEN THEY LEAVE THE VICINITY OF THE PV ARRAY.
5.	WHERE METALLIC CONDUIT CONTAINING DC CONDUCTORS IS USED INSIDE THE BUILDING, IT SHALL BE IDENTIFIED AS "CAUTION: SOLAR CIRCUIT" EVERY 10FT.
6.	HEIGHT OF THE AC DISCONNECT SHALL NOT EXCEED 6'-7" PER NEC CODE 240.24.
7.	A GROUNDING ELECTRODE SYSTEM IN ACCORDANCE WITH NEC 690.47 AND 250.50 THROUGH 60 AND 250-166 SHALL BE PROVIDED. PER NEC GROUNDING ELECTRODE SYSTEM OF EXISTING BUILDING MAY BE USED AND BONDED TO THE SERVICE ENTRANCE. IF EXISTING SYSTEM IS INACCESSIBLE OR INADEQUATE A SUPPLEMENTAL GROUNDING ELECTRODE WILL BE USED AT THE INVERTER LOCATION CONSISTING OF A UL LISTED 8 FT. GROUND ROD WITH ACORN CLAMP. GROUNDING ELECTRODE CONDUCTORS SHALL BE NO LESS THAN #8 AWG AND NO LARGER THAN #6 AWG COPPER AND BONDED TO THE EXISTING GROUNDING ELECTRODE TO PROVIDE FOR A COMPLETE SYSTEM.
8.	PHOTOVOLTAIC MODULES ARE TO BE CONSIDERED NON-COMBUSTIBLE.
9.	PHOTOVOLTAIC INSTALLATION WILL NOT OBSTRUCT ANY PLUMBING, MECHANICAL, OR BUILDING ROOF VENTS.
10.	ALL WIRING MUST BE PROPERLY SUPPORTED BY DEVICES OR MECHANICAL MEANS DESIGNED AND LISTED FOR SUCH USE. WIRING MUST BE PERMANENTLY AND COMPLETELY HELD OFF THE ROOF SURFACE.
11.	ALL SIGNAGE TO BE PLACED IN ACCORDANCE WITH THE LOCAL BUILDING CODE. IF EXPOSED TO SUNLIGHT, IT SHALL BE UV RESISTANT. ALL PLAQUES AND SINAGE WILL BE INSTALLED AS REQUIRED BY THE NEC AND AHJ.
12.	INVERTER(S) USED IN UNGROUNDED SYSTEM SHALL BE UL 1741 LISTED.
13.	THE INSTALLATION OF EQUIPMENT AND ALL ASSOCIATED WIRING AND INTERCONNECTION SHALL BE PERFORMED ONLY BY QUALIFIED PERSONS [NEC 690.4(C)]
14.	ALL OUTDOOR EQUIPMENT SHALL BE NEMA 3R RATED (OR BETTER), INCLUDING ALL ROOF MOUNTED TRANSITION BOXES AND SWITCHES.
15.	ALL EQUIPMENT SHALL BE PROPERLY GROUNDED AND BONDED IN ACCORDANCE WITH NEC ARTICLE 250.
16.	SYSTEM GROUNDING SHALL BE IN ACCORDANCE WITH NEC 690.41.
17.	PV SYSTEM CIRCUITS INSTALLED ON OR IN BUILDINGS SHALL INCLUDE A RAPID SHUTDOWN FUNCTION IN ACCORDANCE WITH NEC 690.12
18.	DISCONNECTING MEANS SHALL BE LOCATED IN A VISIBLE, READILY ACCESSIBLE LOCATION WITHIN THE PV SYSTEM EQUIPMENT OR A MAXIMUM OF 10 FEET AWAY FROM THE SYSTEM [NEC 690.13(A)]
19.	ALL WIRING METHODS SHALL BE IN ACCORDANCE WITH NEC 690.31
20.	WORK CLEARANCES AROUND ELECTRICAL EQUIPMENT WILL BE MAINTAINED PER NEC 110.26(A)(1), 110.26(A)(2) AND 110.26(A)(3).
21.	ROOFTOP MOUNTED PHOTOVOLTAIC PANELS AND MODULES SHALL BE TESTED, LISTED & IDENTIFIED IN ACCORDANCE WITH UL1703
22.	ELECTRICAL CONTRACTOR TO PROVIDE CONDUIT EXPANSION JOINTS AND ANCHOR CONDUIT RUNS AS REQUIRED PER NEC.
23.	IN ACCORDANCE WITH 2021 IFC 1205.5, 2018 IFC 1204.4, 2016 IFC 605.11.2 A CLEAR, BRUSH-FREE AREA OF 10FEET(3048MM) SHALL BE REQUIRED FOR ROOF-MOUNTED PHOTOVOLTAIC ARRAYS.

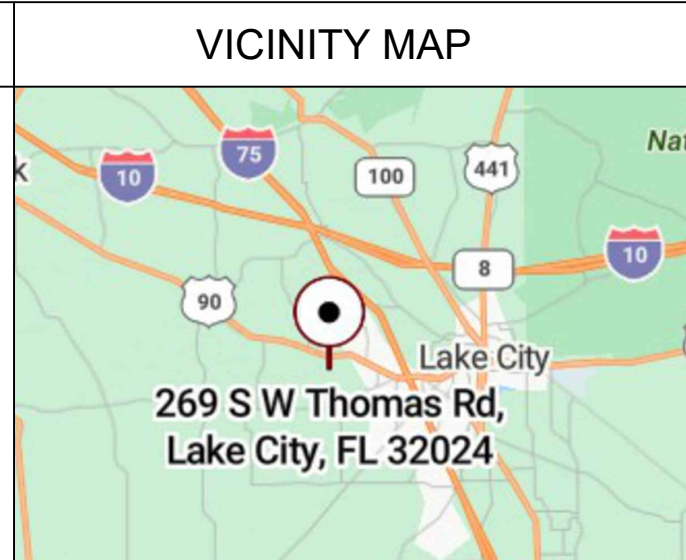

HOUSE PHOTO

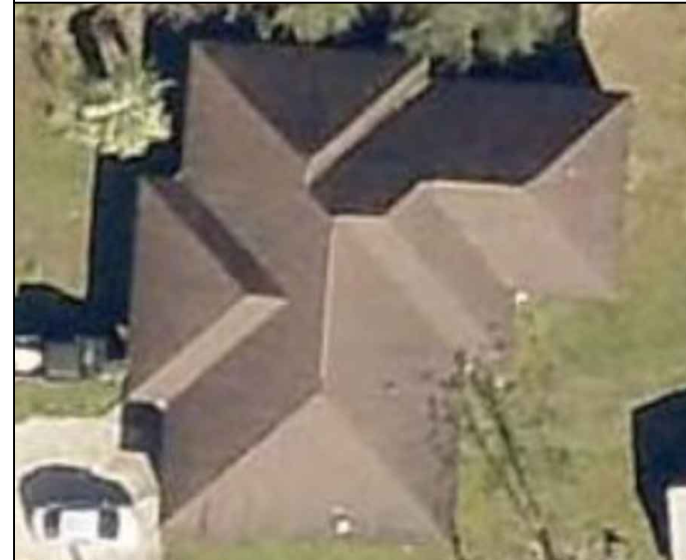

CODE REFERENCES

PROJECT TO COMPLY WITH THE FOLLOWING:
 FLORIDA RESIDENTIAL CODE, 8TH EDITION 2023 (FRC)
 FLORIDA PLUMBING CODE, 8TH EDITION 2023 (FPC)
 FLORIDA BUILDING CODE, 8TH EDITION 2023 (FBC)
 FLORIDA MECHANICAL CODE, 8TH EDITION 2023 (FMC)
 2020 NATIONAL ELECTRICAL CODE
 FLORIDA FIRE PREVENTION CODE, 8TH EDITION 2023 (FFPC)

PROFESSIONAL ENGINEER SEAL

REVISIONS		
DESCRIPTION	DATE	REV
CLIENT COMMENT	12/18/2025	A
CLIENT COMMENT	03/12/2026	B
CLIENT COMMENT	03/13/2026	C

Reviewed and approved
 Richard Pantel, P.E.
 FL Lic. No. 73222
 03/25/2026

DATE: 07/16/2025

PROJECT NAME & ADDRESS

**DELEON KELLY
 RESIDENCE**

269 S W THOMAS RD,
 LAKE CITY, FL 32024

DRAWN BY
ESR

SHEET NAME
COVER SHEET



SHEET SIZE
**ANSI B
 11" X 17"**

SHEET NUMBER
PV-1

PROJECT DESCRIPTION:

33 X QCELLS: Q.TRON BLK M-G2.C+ 430W PV MODULES
 ROOF MOUNTED SOLAR PHOTOVOLTAIC MODULES
 DC SYSTEM SIZE: 33 x 430 = 14.190 kW DC
 AC SYSTEM SIZE: 01 x 11400 = 11.400 kW AC
 EQUIPMENT SUMMARY
 33 QCELLS: Q.TRON BLK M-G2.C+ 430W MONO MODULES
 01 SOLAREDGE: U650 POWER OPTIMIZERS
 01 SOLAREDGE: DCA USE11400H-USMNBE78 INVERTER
 ROOF ARRAY AREA #1:- 167.92 SQ FT.
 ROOF ARRAY AREA #2:- 167.92 SQ FT.
 ROOF ARRAY AREA #3:- 230.89 SQ FT.
 ROOF ARRAY AREA #4:- 62.97 SQ FT.
 ROOF ARRAY AREA #5:- 62.97 SQ FT.

NOTE: VISIBLE, LOCKABLE, LABELED AC DISCONNECT
 LOCATED WITHIN 10' OF UTILITY METER

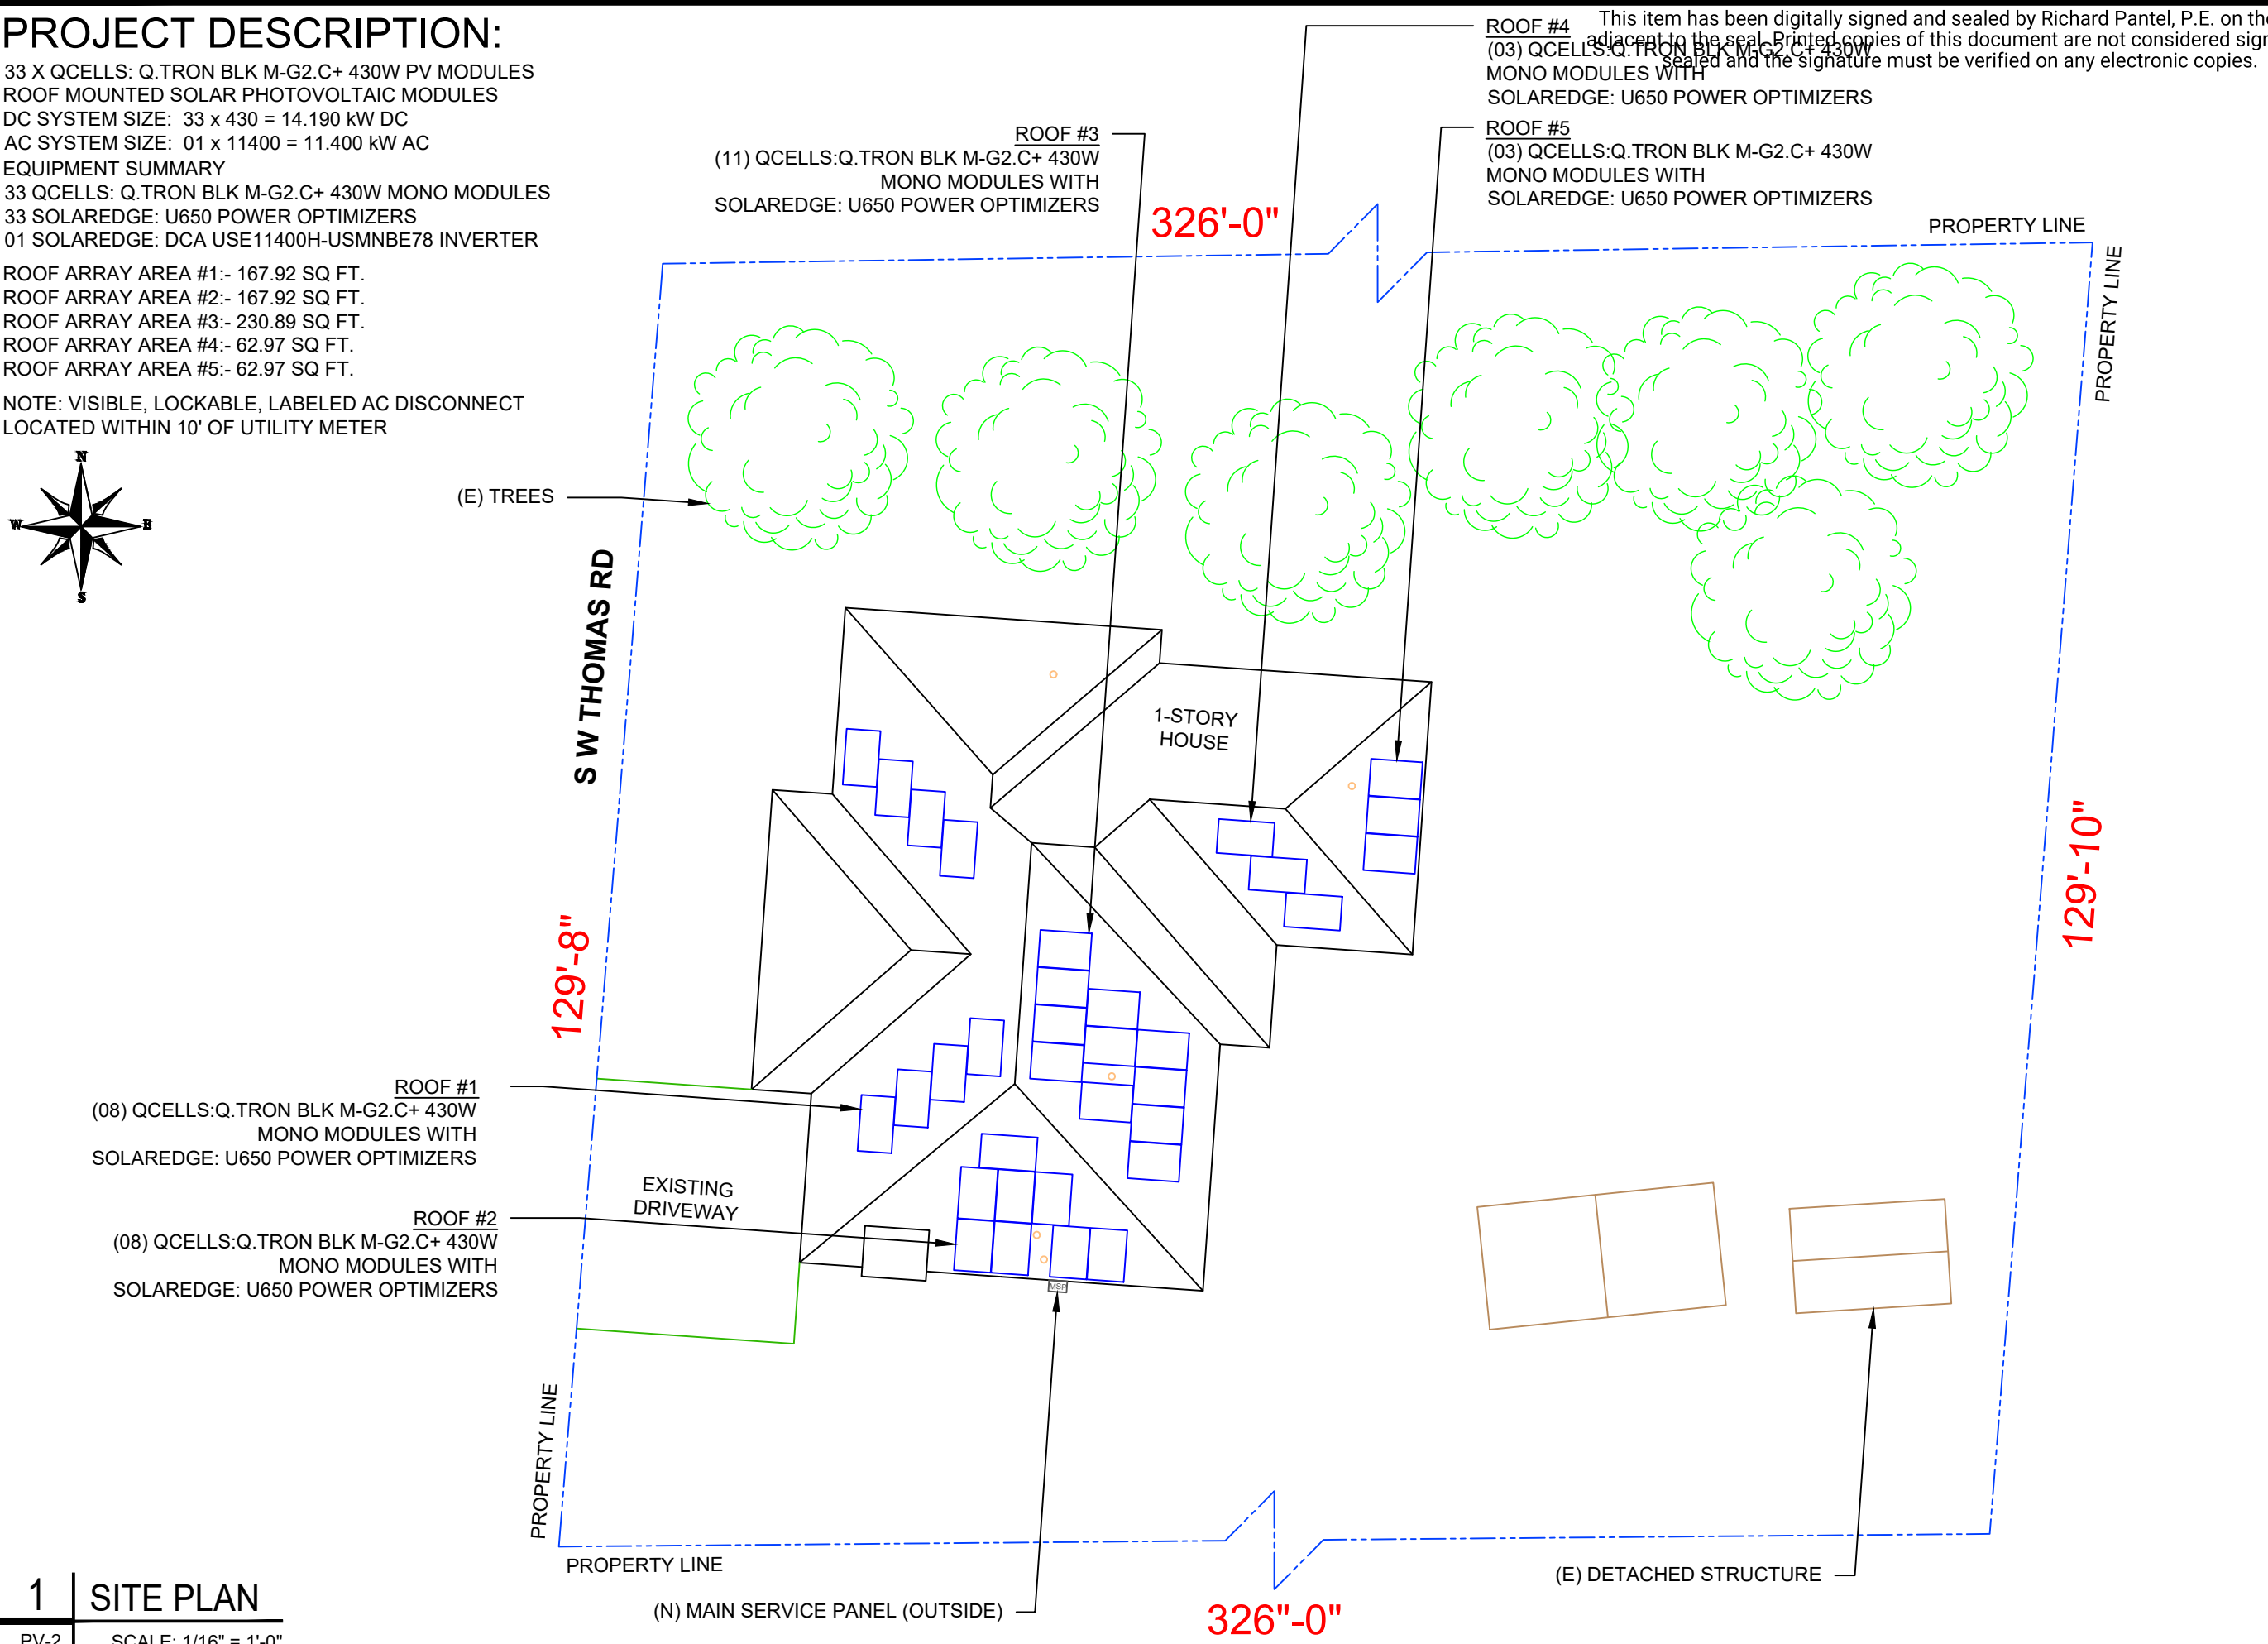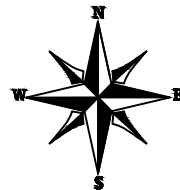


ROOF #4 This item has been digitally signed and sealed by Richard Pantel, P.E. on the date adjacent to the seal. Printed copies of this document are not considered signed and sealed and the signature must be verified on any electronic copies.
 (03) QCELLS: Q.TRON BLK M-G2.C+ 430W MONO MODULES WITH SOLAREDGE: U650 POWER OPTIMIZERS
 ROOF #5
 (03) QCELLS: Q.TRON BLK M-G2.C+ 430W MONO MODULES WITH SOLAREDGE: U650 POWER OPTIMIZERS



LUNEX POWER INC.
 4721 N GRADY AVE
 TAMPA FL 33614
 LIC #: CVC57085
 PHONE: 813-540-8807

REVISIONS		
DESCRIPTION	DATE	REV
CLIENT COMMENT	12/18/2025	A
CLIENT COMMENT	03/12/2026	B
CLIENT COMMENT	03/13/2026	C

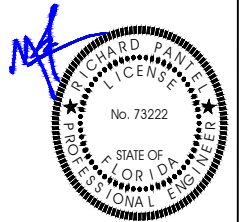

Reviewed and approved
 Richard Pantel, P.E.
 FL Lic. No. 73222
 03/25/2026

DATE: 07/16/2025

PROJECT NAME & ADDRESS

DELEON KELLY
 RESIDENCE
 269 S W THOMAS RD,
 LAKE CITY, FL 32024

DRAWN BY
 ESR

SHEET NAME
 SITE PLAN

SHEET SIZE
 ANSI B
 11" X 17"


SHEET NUMBER
 PV-2

1 | SITE PLAN

PV-2 | SCALE: 1/16" = 1'-0"

MODULE TYPE, DIMENSIONS & WEIGHT

NUMBER OF MODULES = 33 MODULES
 MODULE TYPE = QCELLS: Q.TRON BLK M-G2.C+ 430W MONO MODULES
 MODULE WEIGHT = 46.7 LBS / 21.2 KG.
 MODULE DIMENSIONS = 67.8" x 44.6" = 20.99 SF

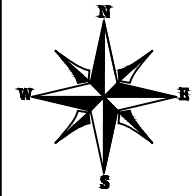

This item has been digitally signed and sealed by Richard Pantel, P.E. on the date adjacent to the seal. Printed copies of this document are not considered signed and sealed and the signature must never be replicated for any electronic copies.

ARRAY AREA & ROOF AREA CALC'S

ROOF	# OF MODULES	AREA (Sq. Ft.)	AREA (Sq. Ft.)	AREA COVERED BY ARRAY (%)
#1	08	167.92	704.32	24
#2	08	167.92	396.61	42
#3	11	230.89	501.28	46
#4	03	62.97	188.66	33
#5	03	62.97	189.75	33
TOTAL	33	692.67	3413.03	20





LUNEX POWER INC.
 4721 N GRADY AVE
 TAMPA FL 33614
 LIC #: CVC57085
 PHONE: 813-540-8807

ROOF DESCRIPTION

ROOF TYPE	COMP. SHINGLE			
ROOF	PITCH	AZIMUTH	TRUSS SIZE	TRUSS SPACING
#1	23°	274°	2"X4"	24"
#2	23°	184°	2"X4"	24"
#3	23°	94°	2"X4"	24"
#4	23°	184°	2"X4"	24"
#5	23°	94°	2"X4"	24"


REVISIONS

DESCRIPTION	DATE	REV
CLIENT COMMENT	12/18/2025	A
CLIENT COMMENT	03/12/2026	B
CLIENT COMMENT	03/13/2026	C

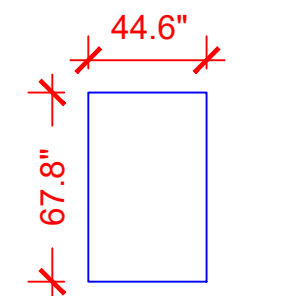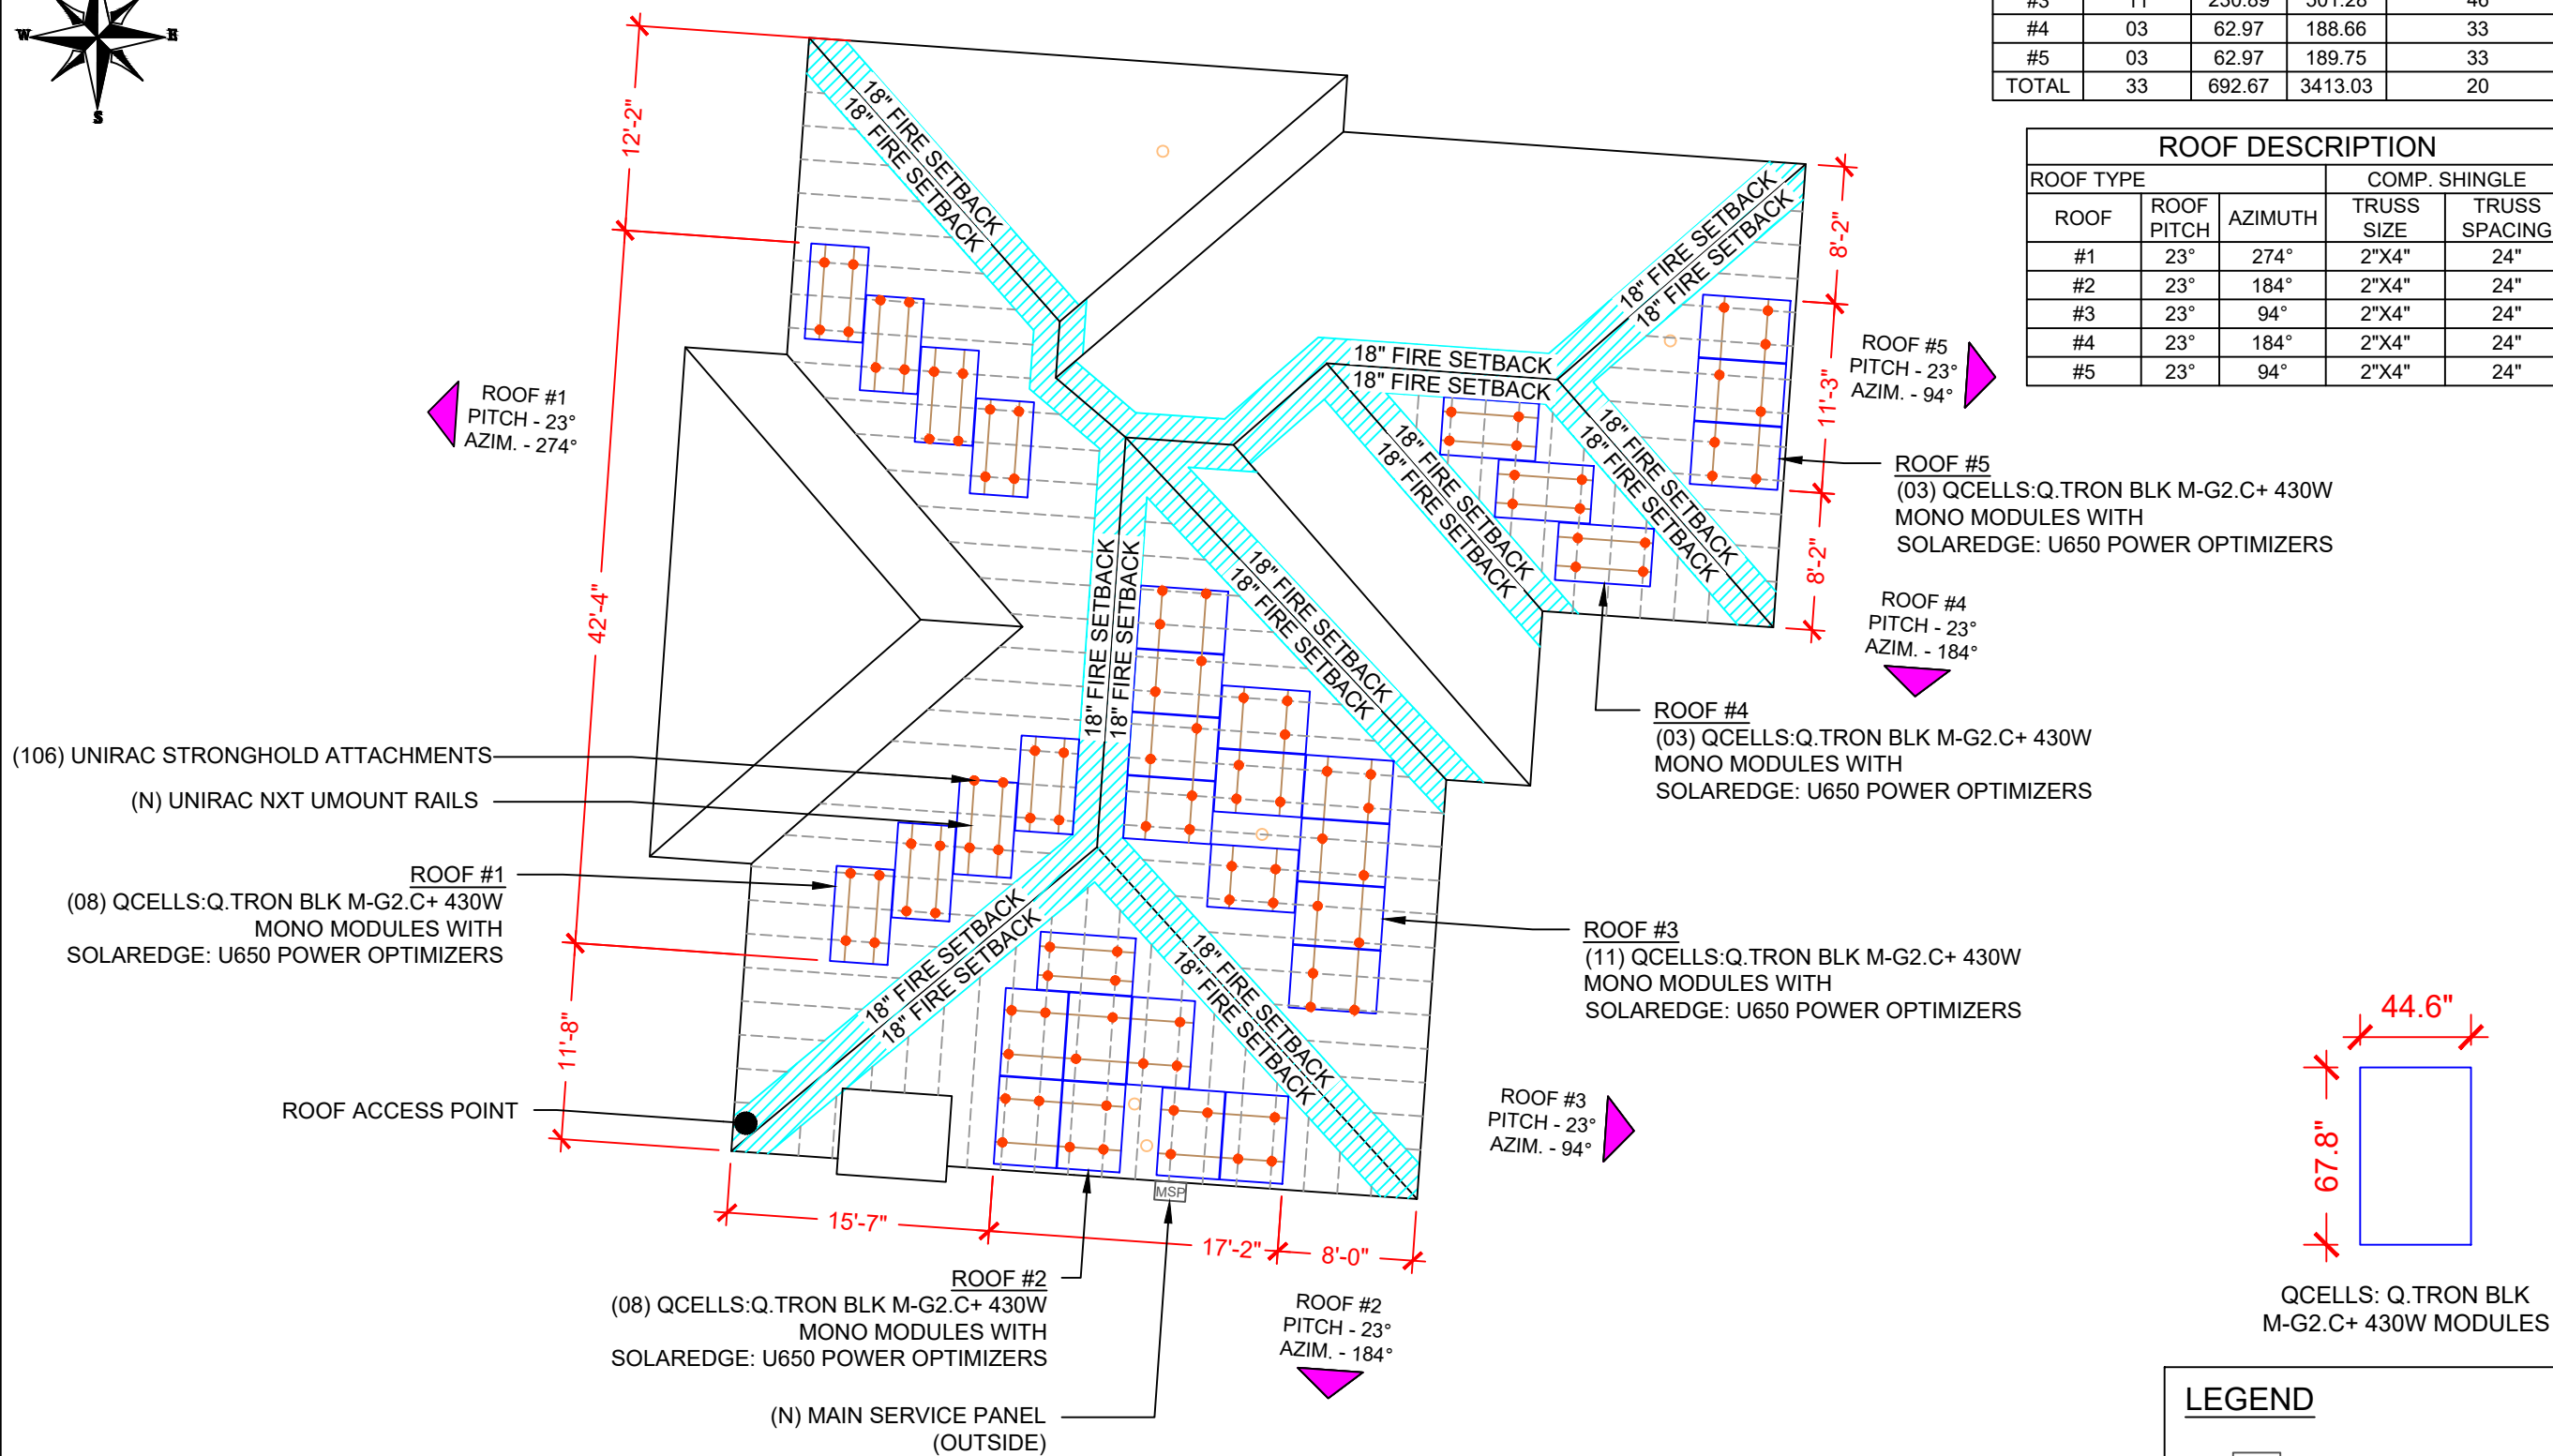

LEGEND

- MSP - MAIN SERVICE PANEL
- VENT, ATTIC FAN (ROOF OBSTRUCTION)
- - ROOF ATTACHMENT
- — - TRUSS

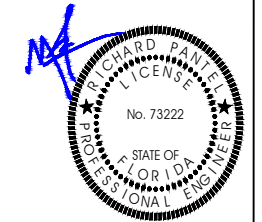

Reviewed and approved
 Richard Pantel, P.E.
 FL Lic. No. 73222
 03/25/2026

DATE: 07/16/2025

PROJECT NAME & ADDRESS

DELEON KELLY
 RESIDENCE
 269 S W THOMAS RD,
 LAKE CITY, FL 32024

DRAWN BY
ESR




SHEET NAME
ROOF PLAN & MODULES


SHEET SIZE
**ANSI B
 11" X 17"**

SHEET NUMBER
PV-3

1 ROOF PLAN & MODULES

PV-3 SCALE: 3/32" = 1'-0"

STRING LEGENDS	
	STRING #1
	STRING #2
	STRING #3

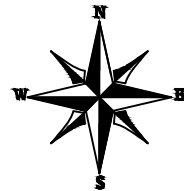



This item has been digitally signed and sealed by Richard Pantel, P.E. on the date adjacent to the seal. Printed copies of this document are not considered signed and sealed and the signature must be verified on any electronic copies.

BILL OF MATERIALS		
EQUIPMENT	QTY	DESCRIPTION
SOLAR PV MODULES	33	QCELLS: Q.TRON BLK M-G2.C+ 430W MODULE
INVERTER	01	SOLAREEDGE: DCA USE11400H-USMNB E78 INVERTER
POWER OPTIMIZERS	33	SOLAREEDGE: U650 POWER OPTIMIZERS
JUNCTION BOX	5	JUNCTION BOXES (JB-1.2)
RAILS	21	UNIRAC NXT U MOUNT RAIL
SPLICES	4	SPLICE KIT
MID MODULE CLAMPS	26	MID MODULE CLAMPS
END CLAMPS	80	END CLAMPS / STOPPER SLEEVE
ATTACHMENTS	106	UNIRAC STRONGHOLD ATTACHMENTS



LUNEX POWER INC.
4721 N GRADY AVE
TAMPA FL 33614
LIC #: CVC57085
PHONE: 813-540-8807

REVISIONS		
DESCRIPTION	DATE	REV
CLIENT COMMENT	12/18/2025	A
CLIENT COMMENT	03/12/2026	B
CLIENT COMMENT	03/13/2026	C

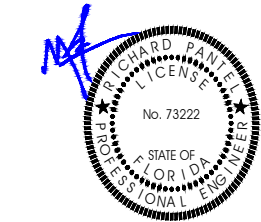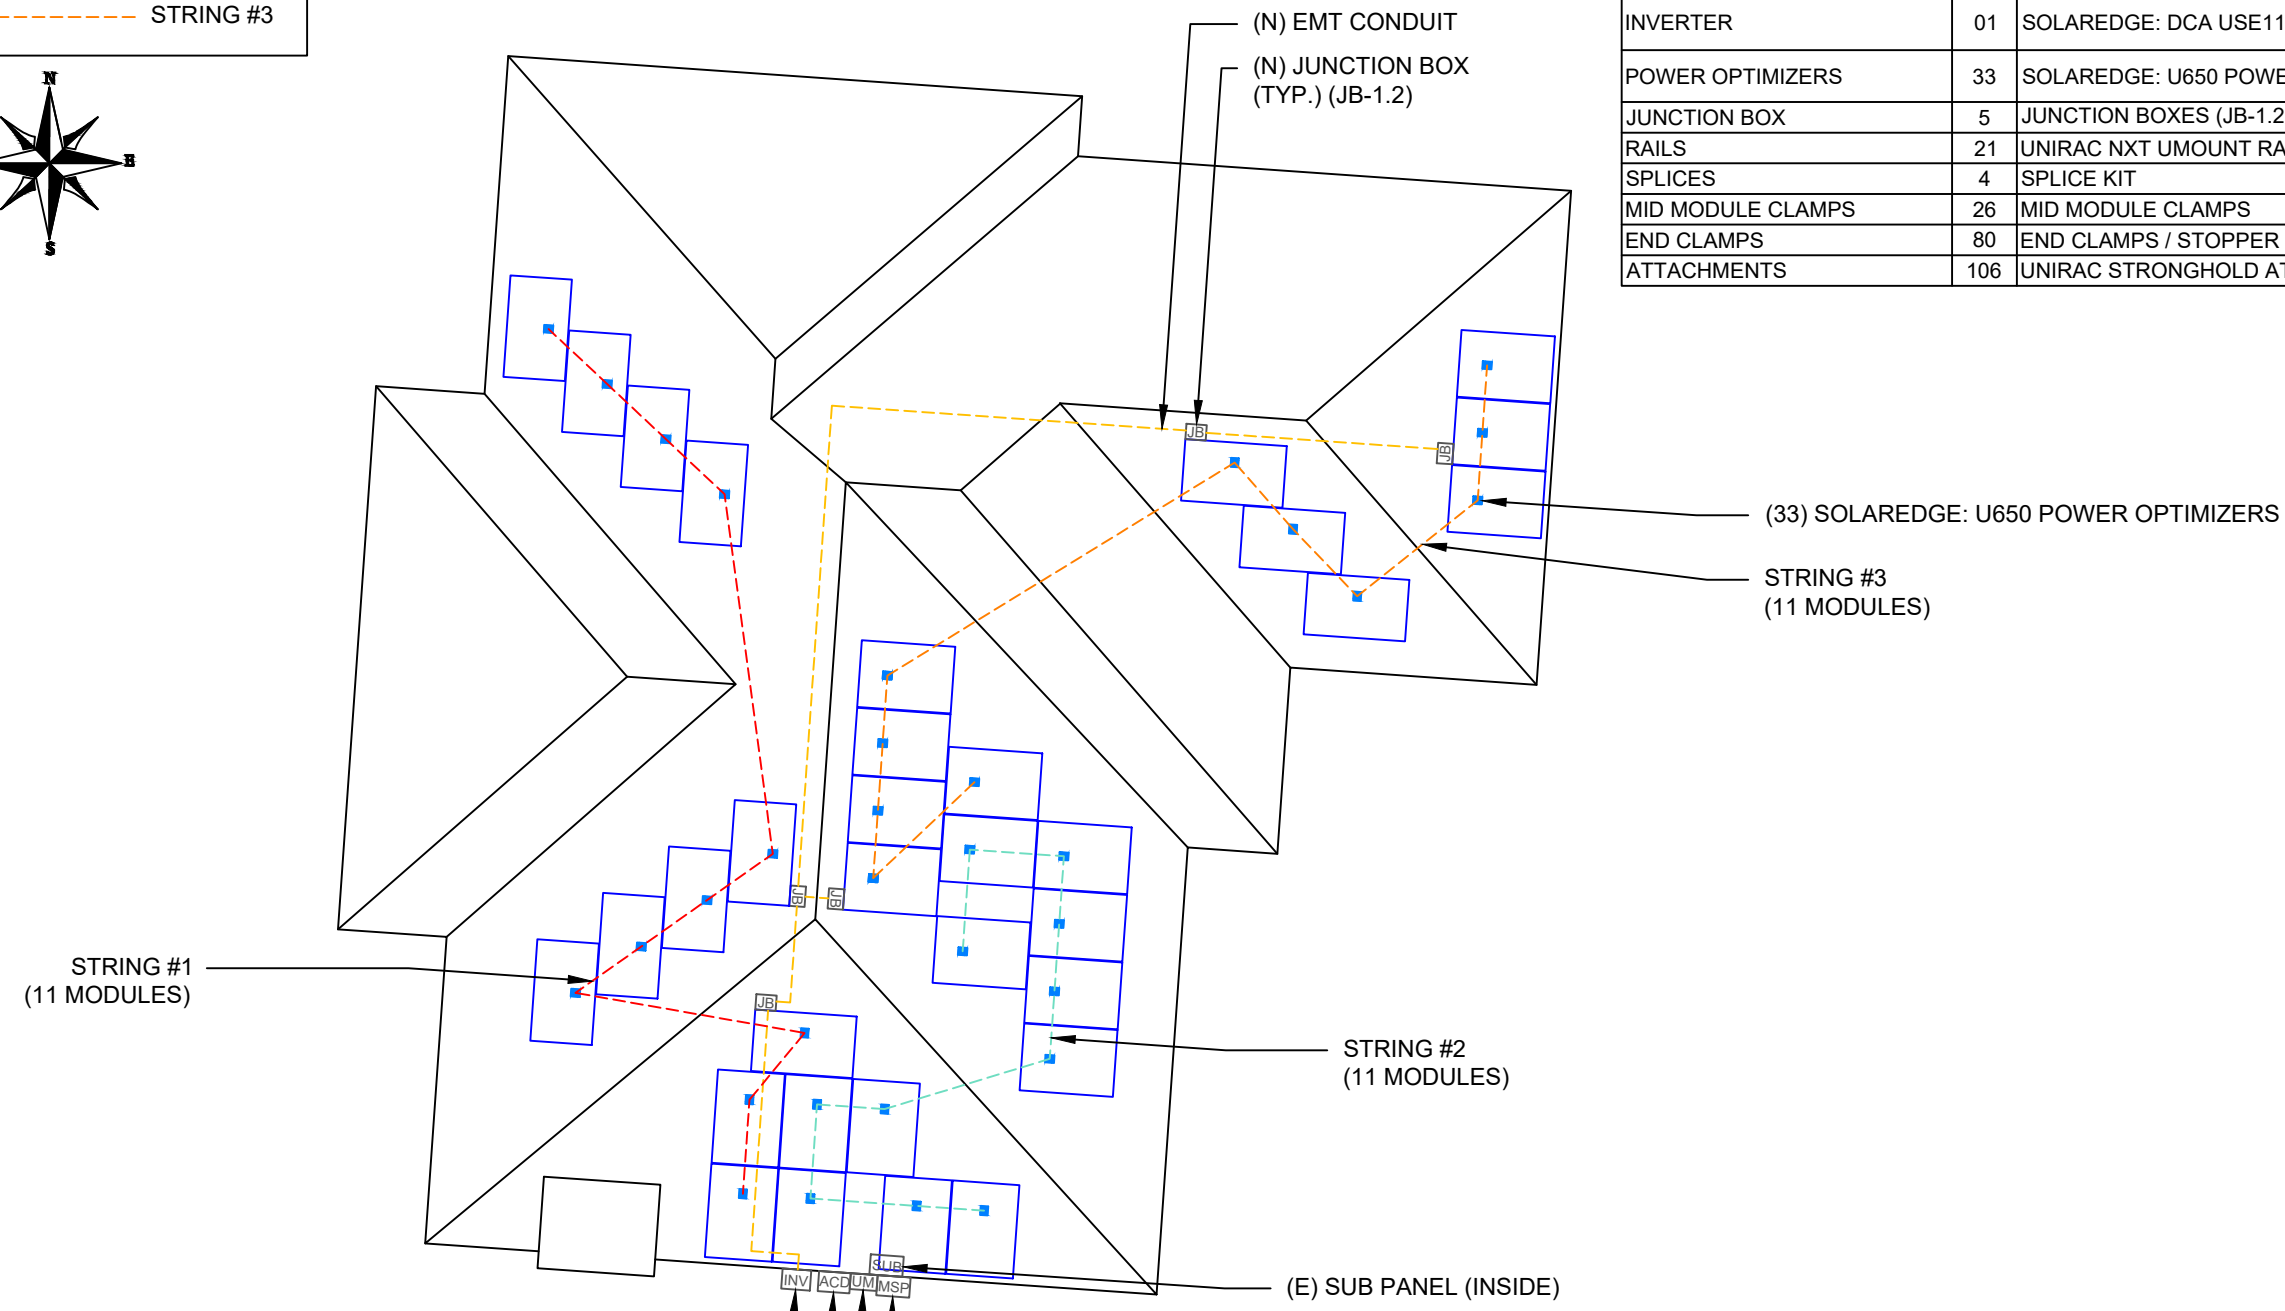

Reviewed and approved
Richard Pantel, P.E.
FL Lic. No. 73222
03/25/2026

DATE: 07/16/2025

PROJECT NAME & ADDRESS

DELEON KELLY
RESIDENCE
269 S W THOMAS RD,
LAKE CITY, FL 32024

DRAWN BY

ESR

SHEET NAME




 
 


ELECTRICAL PLAN

SHEET SIZE

ANSI B
11" X 17"

SHEET NUMBER

PV-4

LEGEND	
	- SUB PANEL
	- JUNCTION BOX
	- INVERTER
	- AC DISCONNECT
	- UTILITY METER
	- MAIN SERVICE PANEL
	- CONDUIT

1 | ELECTRICAL PLAN

PV-4 | SCALE: 3/32" = 1'-0"


DESCRIPTION: CANTILEVER
 CANTILEVER CONSIDER 1/3RD OF ROOF ATTACHMENT SPACING.
 ATTACHMENT SPACING= 48" O/C
 CANTILEVER = 16"

This item has been digitally signed and sealed by Richard Pantel, P.E. on the date adjacent to the seal. Printed copies of this document are not considered signed and sealed and the signature must be verified on any electronic copies.




LUNEX POWER INC.
 4721 N GRADY AVE
 TAMPA FL 33614
 LIC #: CVC57085
 PHONE: 813-540-8807

REVISIONS		
DESCRIPTION	DATE	REV
CLIENT COMMENT	12/18/2025	A
CLIENT COMMENT	03/12/2026	B
CLIENT COMMENT	03/13/2026	C

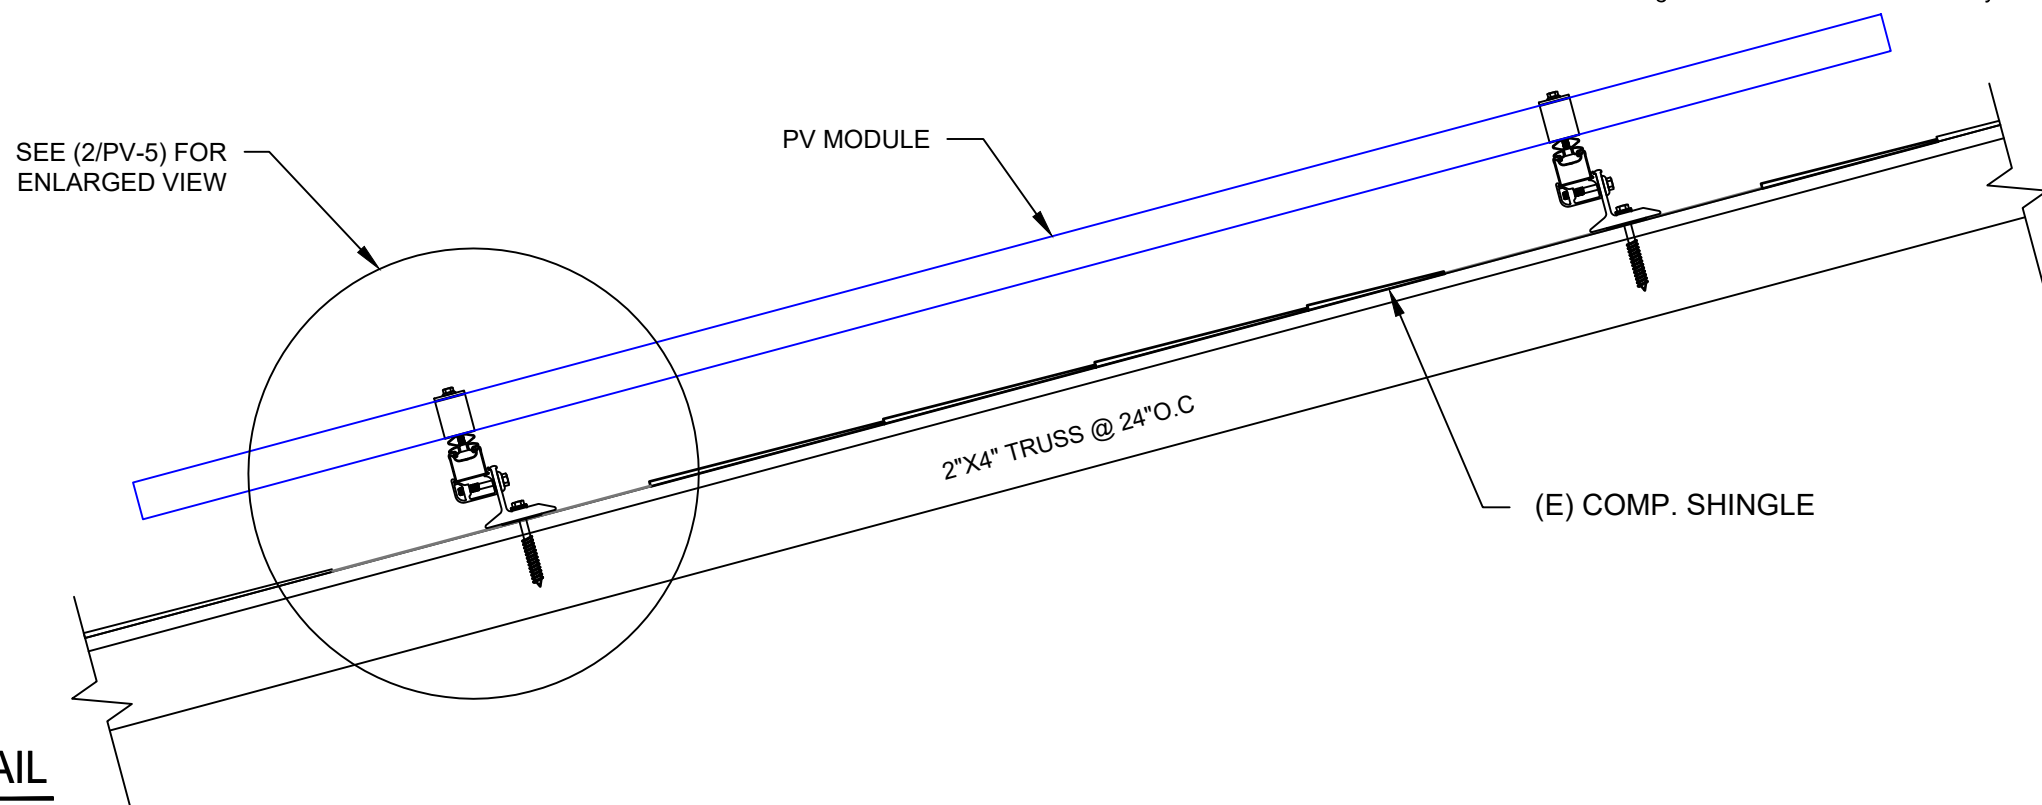

1 | **ATTACHMENT DETAIL**
 PV-5 | SCALE: NTS

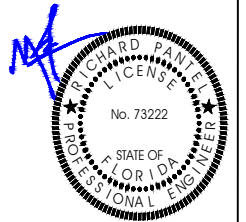


Reviewed and approved
 Richard Pantel, P.E.
 FL Lic. No. 73222
 03/25/2026

DATE: 07/16/2025

PROJECT NAME & ADDRESS

DELEON KELLY
 RESIDENCE
 269 S W THOMAS RD,
 LAKE CITY, FL 32024

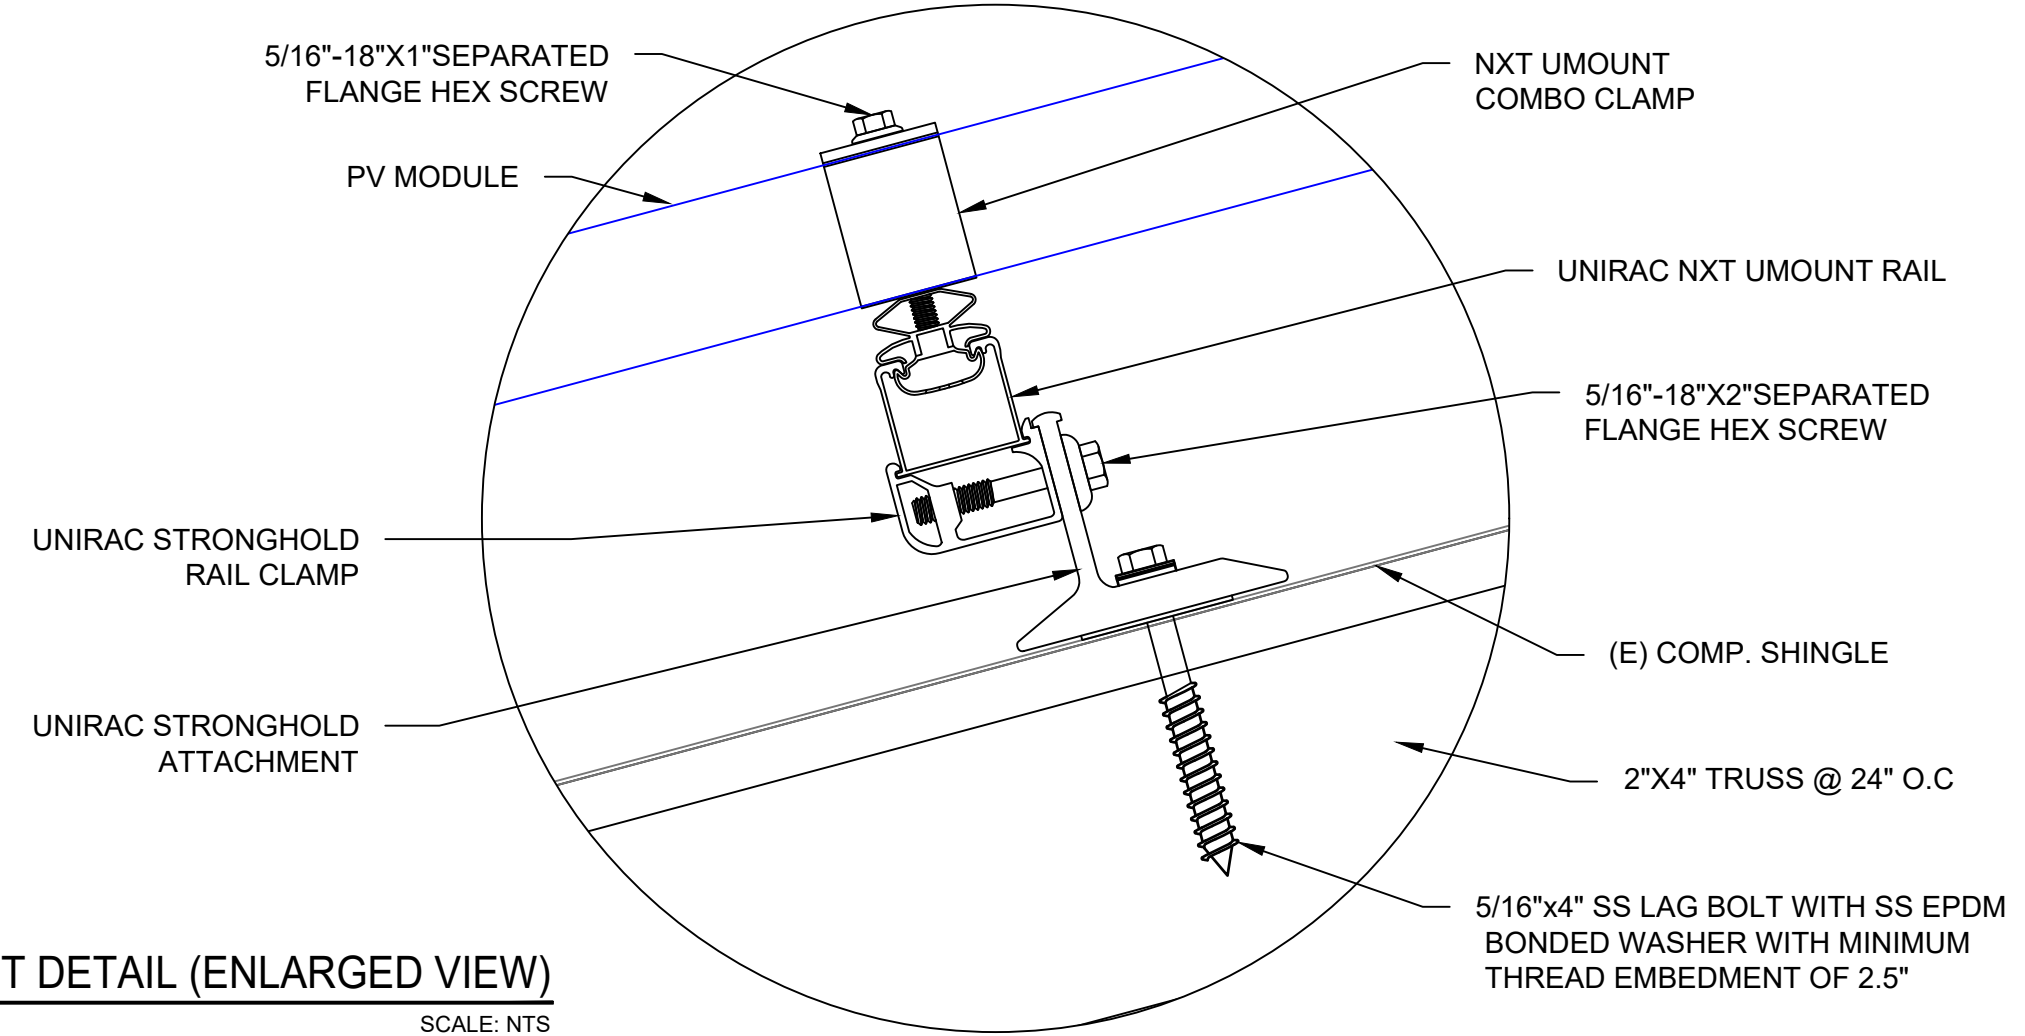

2 | **ATTACHMENT DETAIL (ENLARGED VIEW)**
 PV-5 | SCALE: NTS

DRAWN BY
 ESR

SHEET NAME
 STRUCTURAL DETAIL

SHEET SIZE
 ANSI B
 11" X 17"

SHEET NUMBER
 PV-5

DC SYSTEM SIZE: 33 x 430 = 14.190KW DC
 AC SYSTEM SIZE: 01 x 11400 = 11.400KW AC

(33) QCELLS: Q.TRON BLK M-G2.C+ 430W MONO MODULES WITH
 (33) SOLAREEDGE: U650 POWER OPTIMIZERS
 (01) SOLAREEDGE: DCA USE11400H-USMNB78 INVERTERS

(03) STRINGS OF 11 MODULES ARE CONNECTED IN SERIES

QTY	CONDUCTOR INFORMATION	CONDUIT TYPE	CONDUIT SIZE
1	(6) CU#10AWG - PV WIRE/USE-2	N/A	N/A
1	(1) CU#6AWG - BARE COPPER IN FREE AIR		
2	(6) CU#10AWG - THWN-2 (VE+,VE-)	EMT OR LFMC IN ATTIC	3/4"
1	(1) CU#10AWG - THWN-2 GND		
2	(2) CU#6AWG - THWN-2 (L1,L2)	EMT, PVC	3/4"
1	(1) CU#6AWG - THWN-2 N		
1	(1) CU#6AWG - THWN-2 GND		
2	(2) CU#6AWG - THWN-2 (L1,L2)	EMT, PVC	3/4"
1	(1) CU#6AWG - THWN-2 N		

INTERCONNECTION NOTES:

1. INTERCONNECTION SIZING, LIMITATIONS AND COMPLIANCE DETERMINED IN ACCORDANCE WITH [NEC 705.12], AND [NEC 690.59].
2. GROUND FAULT PROTECTION IN ACCORDANCE WITH [NEC 215.9], [NEC 230.95].
3. ALL EQUIPMENT TO BE RATED FOR BACKFEEDING.
4. PV BREAKER TO BE POSITIONED AT THE OPPOSITE END OF THE BUSBAR RELATIVE TO THE MAIN BREAKER.

DISCONNECT NOTES:

1. DISCONNECTING SWITCHES SHALL BE WIRED SUCH THAT WHEN THE SWITCH IS OPENED THE CONDUCTORS REMAINING LIVE ARE CONNECTED TO THE TERMINALS MARKED "LINE SIDE" (TYPICALLY THE UPPER TERMINALS)
2. AC DISCONNECT MUST BE ACCESSIBLE TO QUALIFIED UTILITY PERSONNEL, BE LOCKABLE, AND BE A VISIBLE-BREAK SWITCH
3. DISCONNECT MEANS AND THEIR LOCATION SHALL BE IN ACCORDANCE WITH [NEC 225.31] AND [NEC 225.32].

RACKING NOTE:


1. BOND EVERY OTHER RAIL WITH #6 BARE COPPER

GROUNDING & GENERAL NOTES:

1. GROUNDING ELECTRODES AND GROUNDING BILDERMANN MUST BE INSTALLED IN ACCORDANCE WITH 250.52 AND 250.54. GROUNDING ELECTRODES SHALL BE PERMITTED TO BE CONNECTED DIRECTLY TO THE PV MODULE FRAME(S) OR SUPPORT STRUCTURE PER [NEC 690.47(B)]
2. PV INVERTER IS UNGROUNDED, TRANSFORMER-LESS TYPE.
3. DC GEC AND AC EGC TO REMAIN UNSPLICED, OR SPLICED TO EXISTING ELECTRODE
4. ANY EXISTING WIRING INVOLVED WITH PV SYSTEM CONNECTION THAT IS FOUND TO BE INADEQUATE PER CODE SHALL BE CORRECTED PRIOR TO FINAL INSPECTION.
5. JUNCTION BOX QUANTITIES, AND PLACEMENT SUBJECT TO CHANGE IN THE FIELD - JUNCTION BOX DEPICTED ON ELECTRICAL DIAGRAM REPRESENT WIRE TYPE TRANSITIONS.
6. AC DISCONNECT NOTED IN EQUIPMENT SCHEDULE OPTIONAL IF OTHER AC DISCONNECTING MEANS IS LOCATED WITHIN 10' OF SERVICE DISCONNECT.
7. RACEWAYS AND CABLES EXPOSED TO SUNLIGHT ON ROOFTOPS SHOULD BE INSTALLED MORE THAN 7/8" ABOVE THE ROOF USING CONDUIT SUPPORTS.
8. ALL NEW SERVICE INSTALLATIONS AND REPLACEMENTS REQUIRE A SURGE-PROTECTIVE DEVICE (SPD) IN ACCORDANCE WITH [CEC 230.67]. THE SPD SHALL BE TYPE 1 OR TYPE 2 AND IS REQUIRED TO BE AN INTEGRAL PART OF THE SERVICE EQUIPMENT OR LOCATED IMMEDIATELY ADJACENT THERETO.

INSTALLER / ELECTRICIAN NOTE:

EC IS TO MEASURE VOLTAGE BEFORE STARTING WORK. IF RESULT IS ANY OTHER VOLTAGE MEASURED THAN 120/240V IS OBSERVED, DO NOT PROCEED. CONTACT ENGINEER.

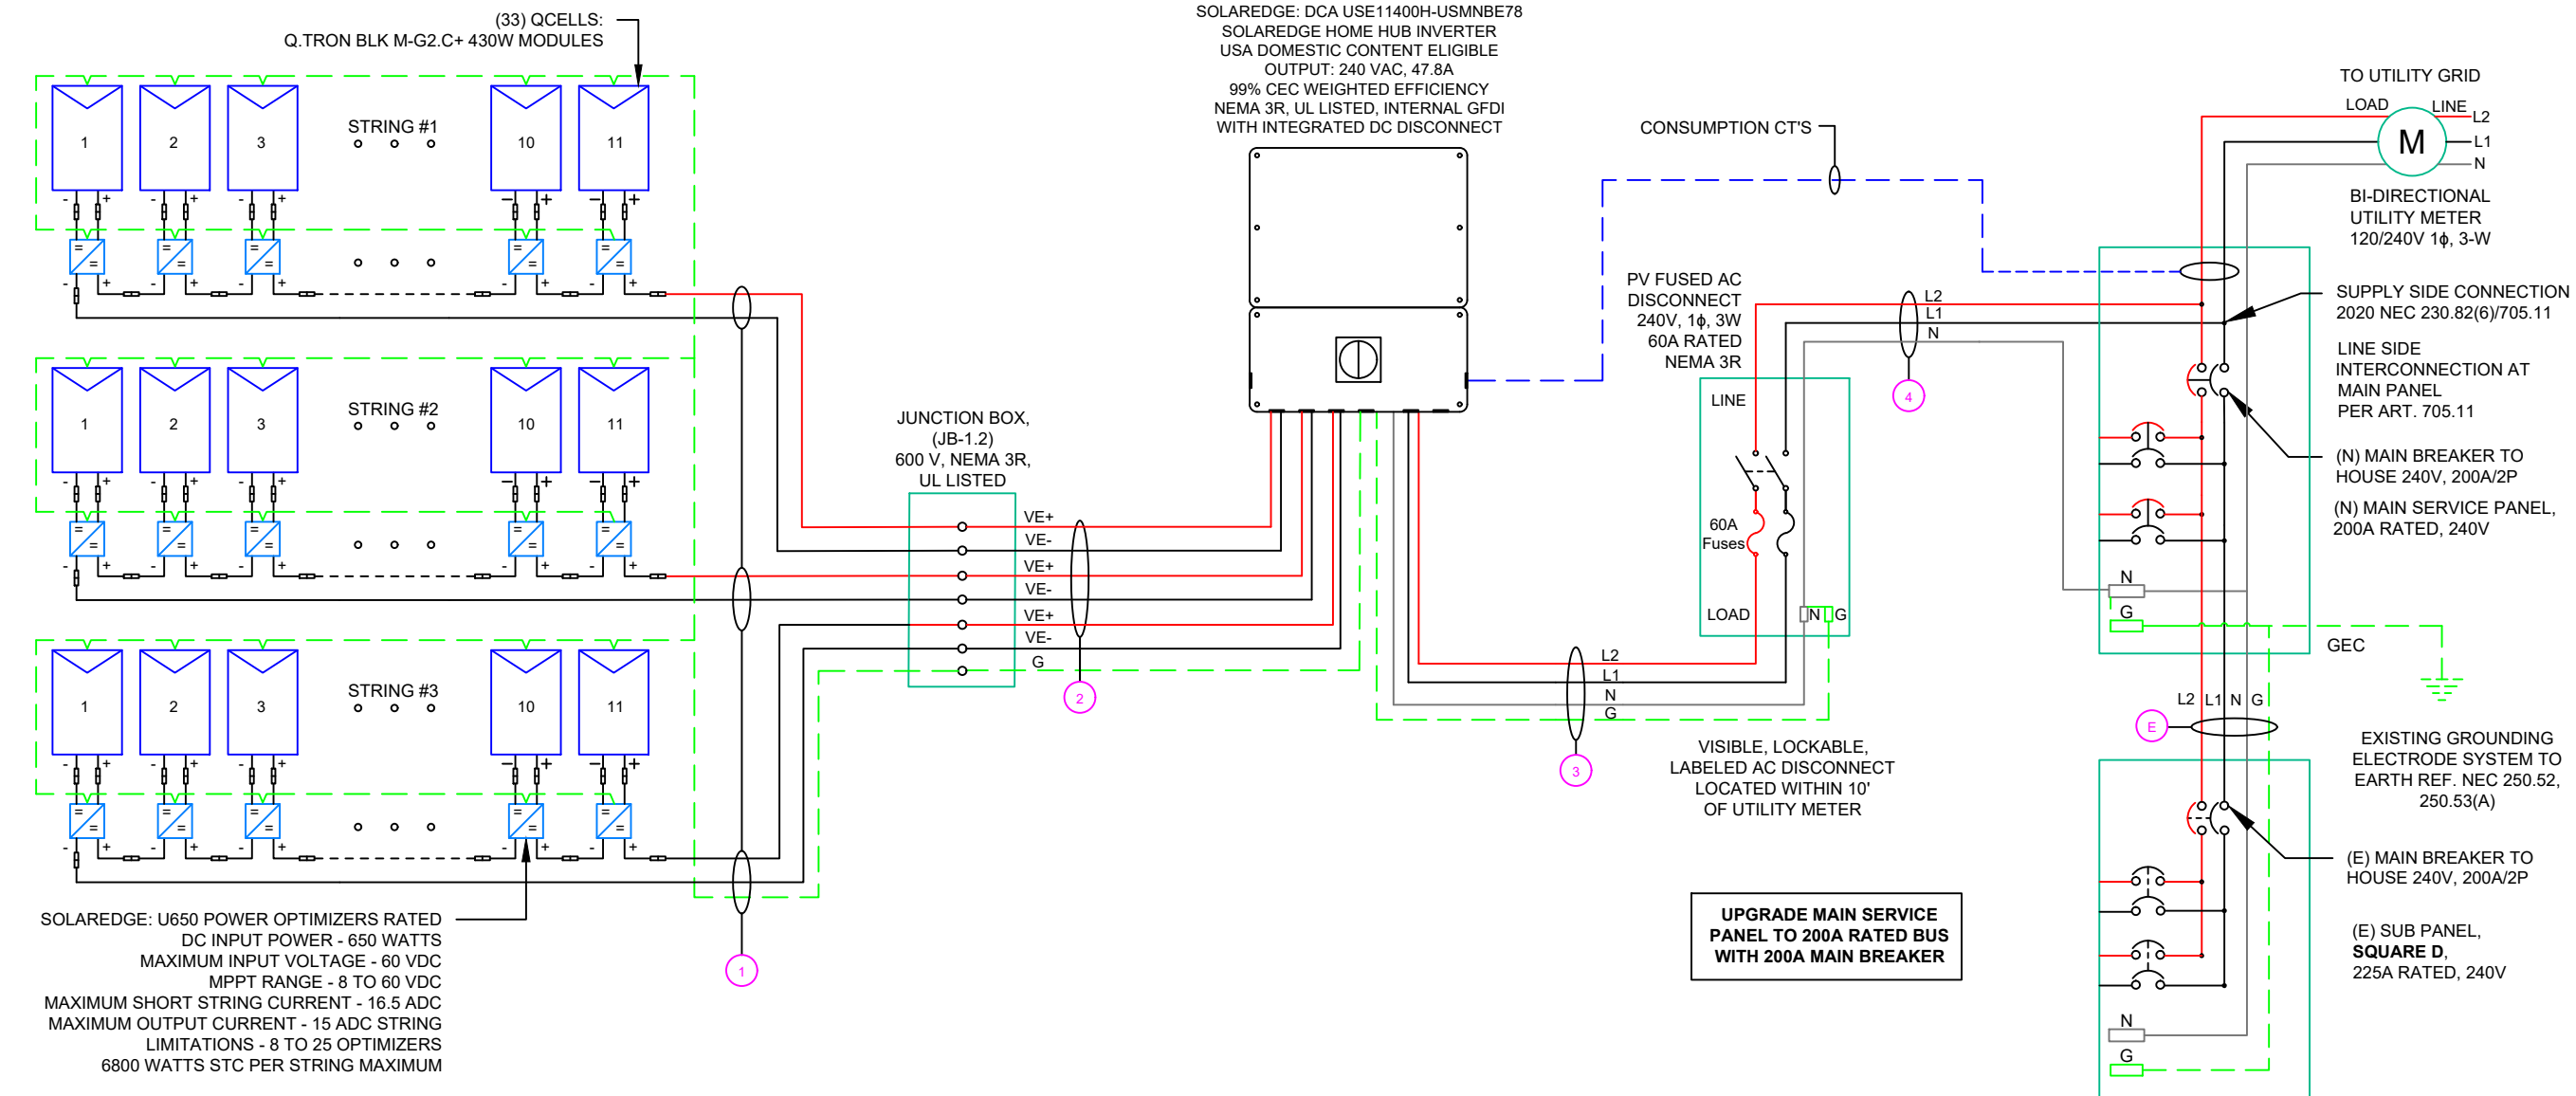

SOLAREEDGE: U650 POWER OPTIMIZERS RATED
 DC INPUT POWER - 650 WATTS
 MAXIMUM INPUT VOLTAGE - 60 VDC
 MPPT RANGE - 8 TO 60 VDC
 MAXIMUM SHORT STRING CURRENT - 16.5 ADC
 MAXIMUM OUTPUT CURRENT - 15 ADC STRING
 LIMITATIONS - 8 TO 25 OPTIMIZERS
 6800 WATTS STC PER STRING MAXIMUM

SOLAREEDGE: DCA USE11400H-USMNB78
 SOLAREEDGE HOME HUB INVERTER
 USA DOMESTIC CONTENT ELIGIBLE
 OUTPUT: 240 VAC, 47.8A
 99% CEC WEIGHTED EFFICIENCY
 NEMA 3R, UL LISTED, INTERNAL GFDI
 WITH INTEGRATED DC DISCONNECT

JUNCTION BOX,
 (JB-1,2)
 600 V, NEMA 3R,
 UL LISTED

VISIBLE, LOCKABLE,
 LABELED AC DISCONNECT
 LOCATED WITHIN 10'
 OF UTILITY METER

UPGRADE MAIN SERVICE
 PANEL TO 200A RATED BUS
 WITH 200A MAIN BREAKER

TO UTILITY GRID

LOAD LINE L2
 L1
 N

BI-DIRECTIONAL
 UTILITY METER
 120/240V 1φ, 3-W

SUPPLY SIDE CONNECTION
 2020 NEC 230.82(6)/705.11

LINE SIDE
 INTERCONNECTION AT
 MAIN PANEL
 PER ART. 705.11

(N) MAIN BREAKER TO
 HOUSE 240V, 200A/2P

(N) MAIN SERVICE PANEL,
 200A RATED, 240V

GEC

EXISTING GROUNDING
 ELECTRODE SYSTEM TO
 EARTH REF. NEC 250.52,
 250.53(A)

(E) MAIN BREAKER TO
 HOUSE 240V, 200A/2P


(E) SUB PANEL,
 SQUARE D,
 225A RATED, 240V



LUNEX POWER INC.
 4721 N GRADY AVE
 TAMPA FL 33614
 LIC #: CVC57085
 PHONE: 813-540-8807

REVISIONS

DESCRIPTION	DATE	REV
CLIENT COMMENT	12/18/2025	A
CLIENT COMMENT	03/12/2026	B
CLIENT COMMENT	03/13/2026	C

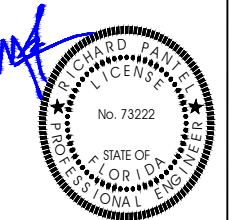

Reviewed and approved
 Richard Pantel, P.E.
 FL Lic. No. 73222
 03/25/2026

DATE: 07/16/2025

PROJECT NAME & ADDRESS

DELEON KELLY
 RESIDENCE
 269 S W THOMAS RD,
 LAKE CITY, FL 32024

DRAWN BY
 ESR

SHEET NAME
 ELECTRICAL LINE DIAGRAM

SHEET SIZE
 ANSI B
 11" X 17"

SHEET NUMBER
 PV-6

1 ELECTRICAL LINE DIAGRAM

PV-6

SCALE: NTS

INVERTER #1 & #2 SPECIFICATIONS	
MANUFACTURER / MODEL #	SOLAREEDGE: DCA USE11400H-USMNB78 INVERTER
NOMINAL AC POWER	11.400 KW
NOMINAL OUTPUT VOLTAGE	240 VAC
NOMINAL OUTPUT CURRENT	47.8A

(N) SOLAR MODULE SPECIFICATIONS	
MANUFACTURER / MODEL #	QCELLS:Q.TRON BLK M-G2.C+ 430 W MODULE
VMP (V)	32.94
IMP (A)	13.05
VOC (V)	39.32
ISC (A)	13.74
TEMP. COEFF. VOC %/°K	-0.24
TEMP. COEFF. P _{MAX} %/°K	-0.30
MODULE DIMENSION	67.8"L x 44.6"W x 1.18"D (In Inch)

AMBIENT TEMPERATURE SCHEDULE	
AMBIENT TEMP (HIGH TEMP 2%)	77°F
RECORD LOW TEMP	-5°
TEMP ADJUSTMENT FOR INSTALLATION METHOD (°C)	35°

PERCENT OF VALUES	NUMBER OF CURRENT CARRYING CONDUCTORS IN EMT
.80	4-6
.70	7-9
.50	10-20

DC FEEDER CALCULATIONS																					
CIRCUIT ORIGIN	CIRCUIT DESTINATION	VOLTAGE (V)	FULL LOAD AMPS "FLA" (A)	FLA*1.56 (A)	OC PD SIZE (A)	GROUND SIZE	CONDUCTOR SIZE	75°C AMPACITY (A)	AMPACITY CHECK #1	AMBIENT TEMP. (°C)	TOTAL CC CONDUCTORS IN RACEWAY	90°C AMPACITY (A)	DERATION FACTOR FOR AMBIENT TEMPERATURE NEC 310.15(B)(1)	DERATION FACTOR FOR CONDUCTORS PER RACEWAY NEC 310.15(C)(1)	90°C AMPACITY DERATED (A)	AMPACITY CHECK #2	FEEDER LENGTH (FEET)	CONDUCTOR RESISTANCE (OHM/KFT)	VOLTAGE DROP AT FLA (%)	CONDUIT SIZE	CONDUIT FILL (%)
STRING 1	JUNCTION BOX	480	15.00	18.75	20	BARE COPPER #6 AWG	CU #10 AWG	35	PASS	37	2	40	0.91	1	36.4	PASS	70	1.24	0.543	N/A	#N/A
STRING 2	JUNCTION BOX	480	15.00	18.75	20	BARE COPPER #6 AWG	CU #10 AWG	35	PASS	37	2	40	0.91	1	36.4	PASS	50	1.24	0.388	N/A	#N/A
STRING 3	JUNCTION BOX	480	15.00	18.75	20	BARE COPPER #6 AWG	CU #10 AWG	35	PASS	37	2	40	0.91	1	36.4	PASS	68	1.24	0.527	N/A	#N/A
JUNCTION BOX	INVERTER	480	15.00	18.75	20	CU #10 AWG	CU #10 AWG	35	PASS	37	6	40	0.91	0.8	29.12	PASS	29	1.24	0.225	3/4" EMT	27.71%

String 1 Voltage Drop	0.767
String 2 Voltage Drop	0.612
String 3 Voltage Drop	0.729

AC FEEDER CALCULATIONS																						
CIRCUIT ORIGIN	CIRCUIT DESTINATION	VOLTAGE (V)	FULL LOAD AMPS "FLA" (A)	FLA*1.25 (A)	OC PD SIZE (A)	NEUTRAL SIZE	GROUND SIZE	CONDUCTOR SIZE	75°C AMPACITY (A)	AMPACITY CHECK #1	AMBIENT TEMP. (°C)	TOTAL CC CONDUCTORS IN RACEWAY	90°C AMPACITY (A)	DERATION FACTOR FOR AMBIENT TEMPERATURE NEC 310.15(B)(1)	DERATION FACTOR FOR CONDUCTORS PER RACEWAY NEC 310.15(C)(1)	90°C AMPACITY DERATED (A)	AMPACITY CHECK #2	FEEDER LENGTH (FEET)	CONDUCTOR RESISTANCE (OHM/KFT)	VOLTAGE DROP AT FLA (%)	CONDUIT SIZE	CONDUIT FILL (%)
INVERTER	AC DISCONNECT	240	47.8	59.75	60	CU #6 AWG	CU #6 AWG	CU #6 AWG	65	PASS	37	2	75	0.91	1	68.25	PASS	5	0.491	0.098	3/4" EMT	38.05%
AC DISCONNECT	POI	240	47.8	59.75	60	CU #6 AWG	N/A	CU #6 AWG	65	PASS	37	2	75	0.91	1	68.25	PASS	5	0.491	0.098	3/4" EMT	28.54%

CUMULATIVE VOLTAGE	0.355
--------------------	-------

ELECTRICAL NOTES


- ALL EQUIPMENT TO BE LISTED BY UL OR OTHER NRTL, AND LABELED FOR ITS APPLICATION.
- ALL CONDUCTORS SHALL BE RATED UPTO 600V FOR RESIDENTIAL AND 1000V FOR COMMERCIAL AND 90 DEGREE C WET ENVIRONMENT.
- WIRING, CONDUIT, AND RACEWAYS MOUNTED ON ROOFTOPS SHALL BE ROUTED DIRECTLY TO, AND LOCATED AS CLOSE AS POSSIBLE TO THE NEAREST RIDGE, HIP, OR VALLEY.
- WORKING CLEARANCES AROUND ALL NEW AND EXISTING ELECTRICAL EQUIPMENT SHALL COMPLY WITH NEC 110.26.
- DRAWINGS INDICATE THE GENERAL ARRANGEMENT OF SYSTEMS. CONTRACTOR SHALL FURNISH ALL NECESSARY OUTLETS, SUPPORTS, FITTINGS AND ACCESSORIES TO FULFILL APPLICABLE CODES AND STANDARDS.
- WHERE SIZES OF JUNCTION BOX, RACEWAYS, AND CONDUITS ARE NOT SPECIFIED, THE CONTRACTOR SHALL SIZE THEM ACCORDINGLY.
- ALL WIRE TERMINATIONS SHALL BE APPROPRIATELY LABELED AND READILY VISIBLE.
- MODULE GROUNDING CLIPS TO BE INSTALLED BETWEEN MODULE FRAME AND MODULE SUPPORT RAIL, PER THE GROUNDING CLIP MANUFACTURER'S INSTRUCTION.
- MODULE SUPPORT RAIL TO BE BONDED TO CONTINUOUS COPPER G.E.C. VIA WEEB LUG OR ILSCO GBL-4DBT LAY-IN LUG.
- TEMPERATURE RATINGS OF ALL CONDUCTORS, TERMINATIONS, BREAKERS, OR OTHER DEVICES ASSOCIATED WITH THE SOLAR PV SYSTEM SHALL BE RATED FOR AT LEAST 75 DEGREE C.

This item has been digitally signed and sealed by Richard Pantel, P.E. on the date 12/18/2025. Printed copies of this document are not considered signed and sealed and the signature must be verified on any electronic copies.



LUNEX POWER INC.
4721 N GRADY AVE
TAMPA FL 33614
LIC #: CVC57085
PHONE: 813-540-8807

REVISIONS		
DESCRIPTION	DATE	REV
CLIENT COMMENT	12/18/2025	A
CLIENT COMMENT	03/12/2026	B
CLIENT COMMENT	03/13/2026	C

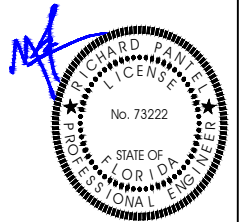

Reviewed and approved
Richard Pantel, P.E.
FL Lic. No. 73222
03/25/2026

DATE: 07/16/2025

PROJECT NAME & ADDRESS

DELEON KELLY
RESIDENCE

269 S W THOMAS RD,
LAKE CITY, FL 32024


DRAWN BY	ESR
SHEET NAME	WIRING CALCULATIONS
SHEET SIZE	ANSI B 11" X 17"
SHEET NUMBER	PV-7

This item has been digitally signed and sealed by Richard Pantel, P.E. on the date adjacent to the seal. Printed copies of this document are not considered signed and sealed and the signature must be verified on any electronic copies.



LUNEX POWER INC.
4721 N GRADY AVE
TAMPA FL 33614
LIC #: CVC57085
PHONE: 813-540-8807

REVISIONS		
DESCRIPTION	DATE	REV
CLIENT COMMENT	12/18/2025	A
CLIENT COMMENT	03/12/2026	B
CLIENT COMMENT	03/13/2026	C

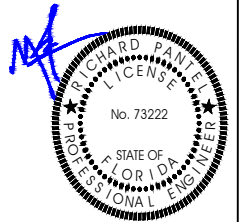

Reviewed and approved
Richard Pantel, P.E.
FL Lic. No. 73222
03/25/2026

DATE: 07/16/2025

PROJECT NAME & ADDRESS

DELEON KELLY
RESIDENCE
269 S W THOMAS RD,
LAKE CITY, FL 32024

DRAWN BY
ESR

SHEET NAME
FAULT CURRENT
CALCULATIONS

SHEET SIZE
ANSI B
11" X 17"

SHEET NUMBER
PV-7A



FAULT - MSP

I_{total s.c. (L-L)} 22,000 AMPS
I_{total s.c. (L-N)} 33,000 AMPS
Voltage (L-L) 240 V

CONDUCTOR RUN - C1

LENGTH 17 FT
SIZE 6
QTY 1
(per phase)
TYPE Three Single Conductors
CONDUIT Steel
WIRE Cu, 600 V

CONDUCTOR



FAULT - AC DISCONNECT

I_{total s.c. (L-L)} 9,627 AMPS
I_{total s.c. (L-N)} 6,795 AMPS
Voltage (L-L) 240 V

CONDUCTOR RUN - C2

LENGTH 5 FT
SIZE 6
QTY 1
(per phase)
TYPE Three Single Conductors
CONDUIT Steel
WIRE Cu, 600 V

CONDUCTOR



FAULT - INVERTER

I_{total s.c. (L-L)} 8,261 AMPS
I_{total s.c. (L-N)} 5,509 AMPS
Voltage (L-L) 240 V

**CAUTION:
AUTHORIZED SOLAR
PERSONNEL ONLY!**

LABEL-1:
LABEL LOCATION:
AC DISCONNECT

⚠ WARNING
ELECTRICAL SHOCK HAZARD
TERMINALS ON THE LINE AND LOAD SIDES MAY
BE ENERGIZED IN THE OPEN POSITION

LABEL- 2:
LABEL LOCATION:
INVERTER(S), AC/DC DISCONNECT(S),
AC COMBINER PANEL (IF APPLICABLE).
PER CODE(S): NEC 2020: 690.13(B)

**⚠ WARNING DUAL POWER SOURCE
SECOND SOURCE IS PHOTOVOLTAIC SYSTEM**

LABEL- 3:
LABEL LOCATION:
UTILITY SERVICE METER AND MAIN
SERVICE PANEL.
PER CODE(S): NEC 2020: 705.12(C)

⚠ WARNING
**TURN OFF PHOTOVOLTAIC AC
DISCONNECT PRIOR TO
WORKING INSIDE PANEL**


LABEL- 4:
LABEL LOCATION:
MAIN SERVICE PANEL
SUBPANEL
MAIN SERVICE DISCONNECT
COMBINER
CODE REF: NEC 110.27(C) & OSHA 1910.145 (f) (7)

⚠ WARNING
**POWER SOURCE OUTPUT
CONNECTION. DO NOT
RELOCATE THIS
OVERCURRENT DEVICE**

LABEL- 5:
LABEL LOCATION:
ADJACENT TO PV BREAKER AND ESS
OCPD (IF APPLICABLE).
PER CODE(S): NEC 2020: 705.12(B)(3)(2),

**SOLAR PV SYSTEM EQUIPPED
WITH RAPID SHUTDOWN**

TURN RAPID SHUTDOWN
SWITCH TO THE
"OFF" POSITION TO
SHUT DOWN PV SYSTEM
AND REDUCE
SHOCK HAZARD
IN THE ARRAY

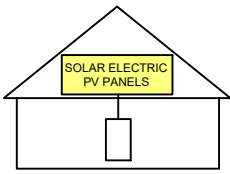

LABEL- 6:
LABEL LOCATION:
ON OR NO MORE THAN 1 M (3 FT) FROM THE SERVICE
DISCONNECTING MEANS TO WHICH THE PV SYSTEMS
ARE CONNECTED.
PER CODE(S): NEC 2020: 690.56(C)

**PHOTOVOLTAIC
AC DISCONNECT**

LABEL- 7:
LABEL LOCATION:
AC DISCONNECT
CODE REF: NEC 690.13(B)

**PHOTOVOLTAIC
AC DISCONNECT**

NOMINAL OPERATING AC VOLATGE **240 V**
RATED AC OUTPUT CURRENT **47.80 A**

LABEL- 8:
LABEL LOCATION:
AC DISCONNECT(S), PHOTOVOLTAIC SYSTEM POINT OF
INTERCONNECTION.
PER CODE(S): NEC 2020: 690.54

**MAIN PHOTOVOLTAIC
SYSTEM DISCONNECT**

LABEL- 9:
LABEL LOCATION:
MAIN SERVICE DISCONNECT (ONLY IF MAIN SERVICE DISCONNECT IS PRESENT)
CODE REF: NEC 690.13(B)

MAXIMUM VOLTAGE: 480 V
MAXIMUM CIRCUIT CURRENT: 60 A
**MAXIMUM RATED OUTPUT
CURRENT OF THE CHARGE
CONTROLLER OR DC-TO-DC
CONVERTER (IF INSTALLED): 15 A**

LABEL- 10:
LABEL LOCATION:
INVERTER
CODE REF: NEC 690.53

This item has been digitally signed and sealed by Richard Pantel, P.E. on the date adjacent to the seal. Printed copies of this document are not considered signed and sealed and the signature must be verified on any electronic copies.

**CAUTION: PHOTOVOLTAIC SYSTEM
FOR SERVICE : LUNEX POWER
813-540-8807**


LABEL-11:

**WARNING: PHOTOVOLTAIC
POWER SOURCE**

LABEL-12:
LABEL LOCATION:
INTERIOR AND EXTERIOR PV CONDUIT EVERY 10 FT,
AT EACH TURN, ABOVE AND BELOW PENETRATIONS,
ON EVERY JB/PULL BOX CONTAINING PV CIRCUITS.
PER CODE(S): NEC 2020: 690.31(D)(2)

**EMERGENCY RESPONDER
THIS SOLAR PV SYSTEM EQUIPPED
WITH RAPID SHUTDOWN**

TURN RAPID SHUTDOWN
SWITCH TO THE 'OFF'
POSITION TO SHUTDOWN
ENTIRE PV SYSTEM.

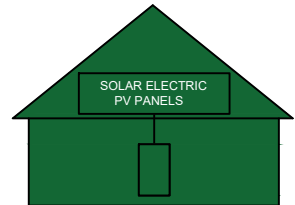

**THE LABEL SHALL BE REFLECTIVE, WITH ALL LETTERS CAPITALIZED AND HAVING
A MINIMUM HEIGHT OF 3/8 IN. (9.5 MM), IN WHITE ON A RED BACKGROUND.**

LABEL- 13:
LABEL LOCATION:
AC DISCONNECT
CODE REF:NFPA 1 (11.12.2.1.1.1.1)
1. THE RAPID SHUTDOWN LABEL SHALL BE LOCATED ON OR NO MORE
THAN 3 FT (1 M) FROM THE SERVICE DISCONNECTING MEANS
2. (HEIGHT OF LABEL IS 3/8 IN. (9.5 MM), IN WHITE ON A RED BACKGROUND)


**RAPID SHUTDOWN SWITCH
FOR SOLAR PV SYSTEM**

LABEL- 14:
LABEL LOCATION:
INSTALLED WITHIN 3' OF RAPID SHUT DOWN
SWITCH PER CODE(S): NEC 2020: 690.56(C)(2)
IFC 2018: 1204.5.3



LUNEX POWER INC.
4721 N GRADY AVE
TAMPA FL 33614
LIC #: CVC57085
PHONE: 813-540-8807

REVISIONS		
DESCRIPTION	DATE	REV
CLIENT COMMENT	12/18/2025	A
CLIENT COMMENT	03/12/2026	B
CLIENT COMMENT	03/13/2026	C

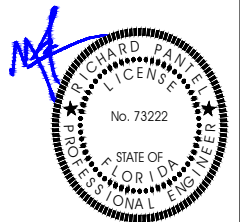

Reviewed and approved
Richard Pantel, P.E.
FL Lic. No. 73222
03/25/2026

DATE: 07/16/2025

PROJECT NAME & ADDRESS

DELEON KELLY
RESIDENCE
269 S W THOMAS RD,
LAKE CITY, FL 32024

DRAWN BY
ESR

SHEET NAME
LABELS

SHEET SIZE
ANSI B
11" X 17"



SHEET NUMBER
PV-8

This item has been digitally signed and sealed by Richard Pantel, P.E. on the date adjacent to the seal. Printed copies of this document are not considered signed and sealed and the signature must be verified on any electronic copies.



LUNEX POWER INC.
 4721 N GRADY AVE
 TAMPA FL 33614
 LIC #: CVC57085
 PHONE: 813-540-8807

REVISIONS		
DESCRIPTION	DATE	REV
CLIENT COMMENT	12/18/2025	A
CLIENT COMMENT	03/12/2026	B
CLIENT COMMENT	03/13/2026	C

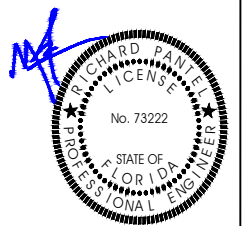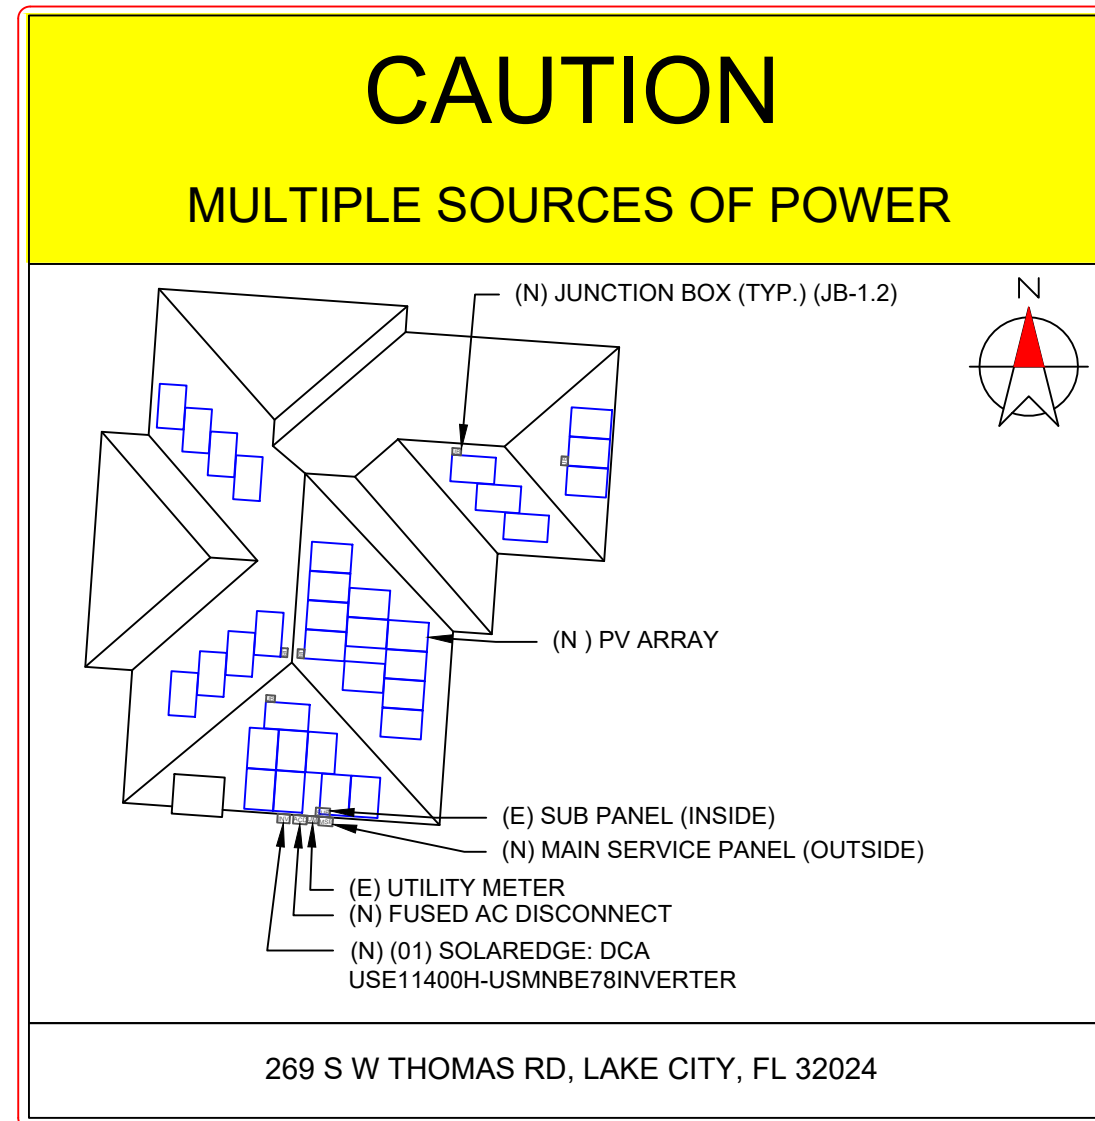

Reviewed and approved
 Richard Pantel, P.E.
 FL Lic. No. 73222
 03/25/2026

DATE: 07/16/2025

PROJECT NAME & ADDRESS

DELEON KELLY
 RESIDENCE
 269 S W THOMAS RD,
 LAKE CITY, FL 32024

DRAWN BY
 ESR

SHEET NAME
 PLACARD

SHEET SIZE
 ANSI B
 11" X 17"

SHEET NUMBER
 PV-9

DIRECTORY

PERMANENT PLAQUE OR DIRECTORY PROVIDING THE LOCATION OF THE SERVICE DISCONNECTING MEANS AND THE PHOTOVOLTAIC SYSTEM.

(ALL PLAQUES AND SIGNAGE WILL BE INSTALLED AS OUTLINED WITHIN: NEC 690.56(A)(B), [NEC 705.10])

LABELING NOTES:

1. LABELS CALLED OUT ACCORDING TO ALL COMMON CONFIGURATIONS. ELECTRICIAN TO DETERMINE EXACT REQUIREMENTS IN THE FIELD PER CURRENT NEC AND LOCAL CODES AND MAKE APPROPRIATE ADJUSTMENTS.
2. LABELING REQUIREMENTS BASED ON THE 2020 NEC, OSHA STANDARD 1910.145, ANSI Z535.
3. MATERIAL BASED ON THE REQUIREMENTS OF THE AUTHORITY HAVING JURISDICTION.
4. LABELS TO BE OF SUFFICIENT DURABILITY TO WITHSTAND THE ENVIRONMENT INVOLVED [NEC 110.21]
5. LABELS TO BE A MINIMUM LETTER HEIGHT OF 3/8", WHITE ON RED BACKGROUND; REFLECTIVE, AND PERMANENTLY AFFIXED [NEC 690.56(C)(1)(A)].

1-10 11-20 21-30 31-40 41-50 51-60 61-70


This item has been digitally signed and sealed by Richard Pantel, P.E. on the date adjacent to the seal. Printed copies of this document are not considered signed and sealed and the signature must be verified on any electronic copies.

OPTIMIZER CHART



LUNEX POWER INC.
 4721 N GRADY AVE
 TAMPA FL 33614
 LIC #: CVC57085
 PHONE: 813-540-8807

REVISIONS		
DESCRIPTION	DATE	REV
CLIENT COMMENT	12/18/2025	A
CLIENT COMMENT	03/12/2026	B
CLIENT COMMENT	03/13/2026	C

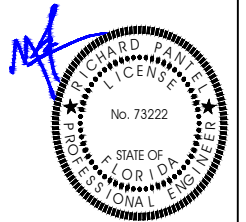

Reviewed and approved
 Richard Pantel, P.E.
 FL Lic. No. 73222
 03/25/2026

DATE: 07/16/2025

PROJECT NAME & ADDRESS



DELEON KELLY
 RESIDENCE
 269 S W THOMAS RD,
 LAKE CITY, FL 32024

DRAWN BY
ESR

SHEET NAME
OPTIMIZER CHART

SHEET SIZE
**ANSI B
 11" X 17"**

SHEET NUMBER
PV-10

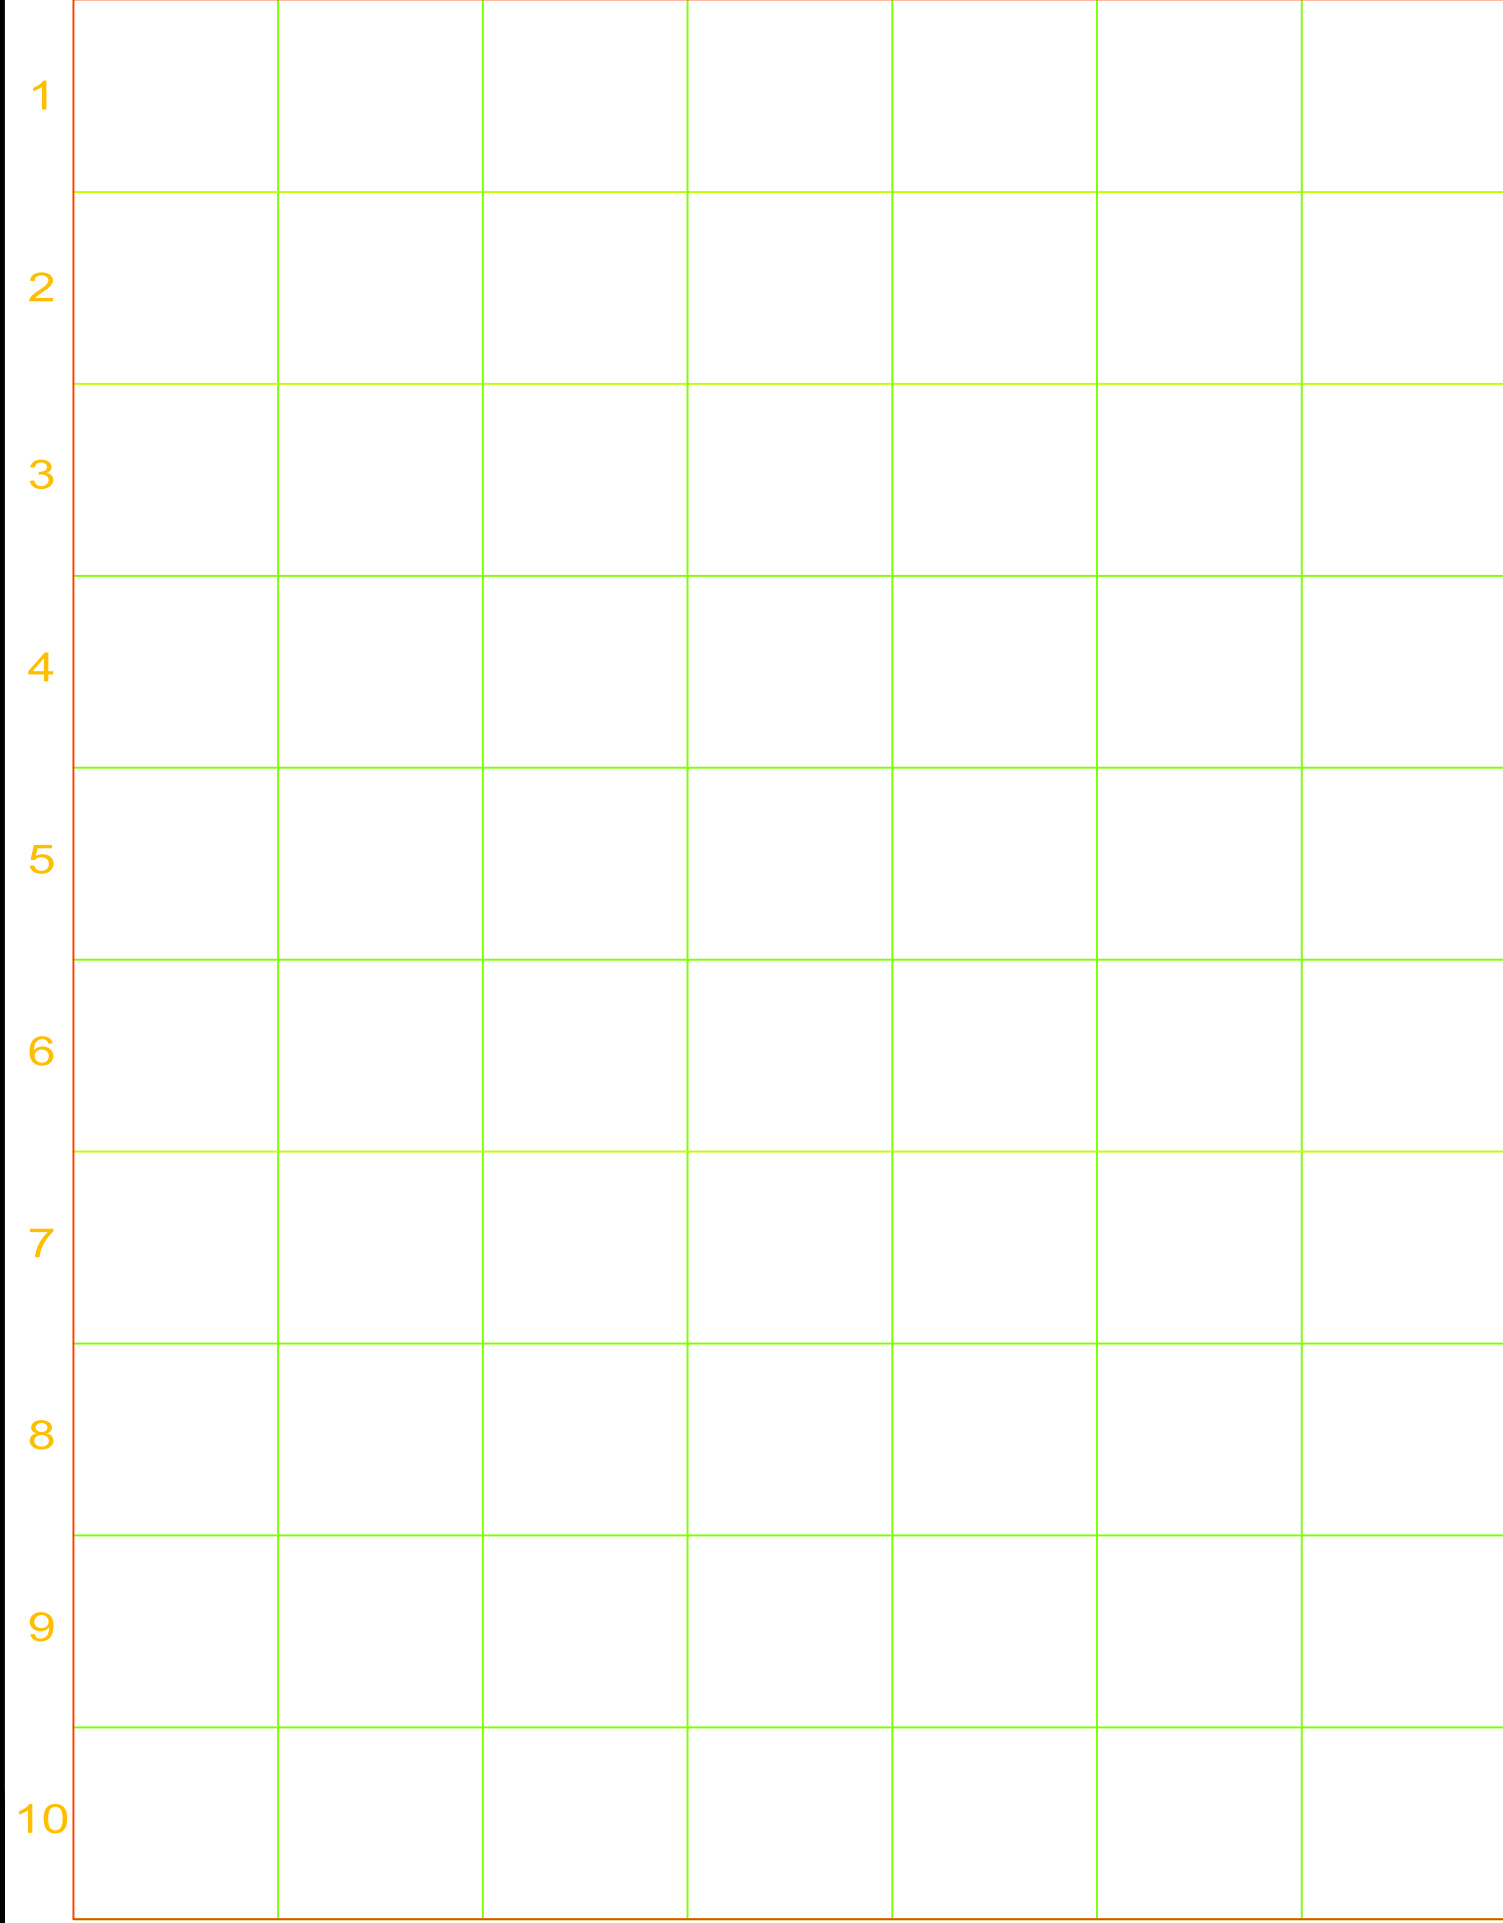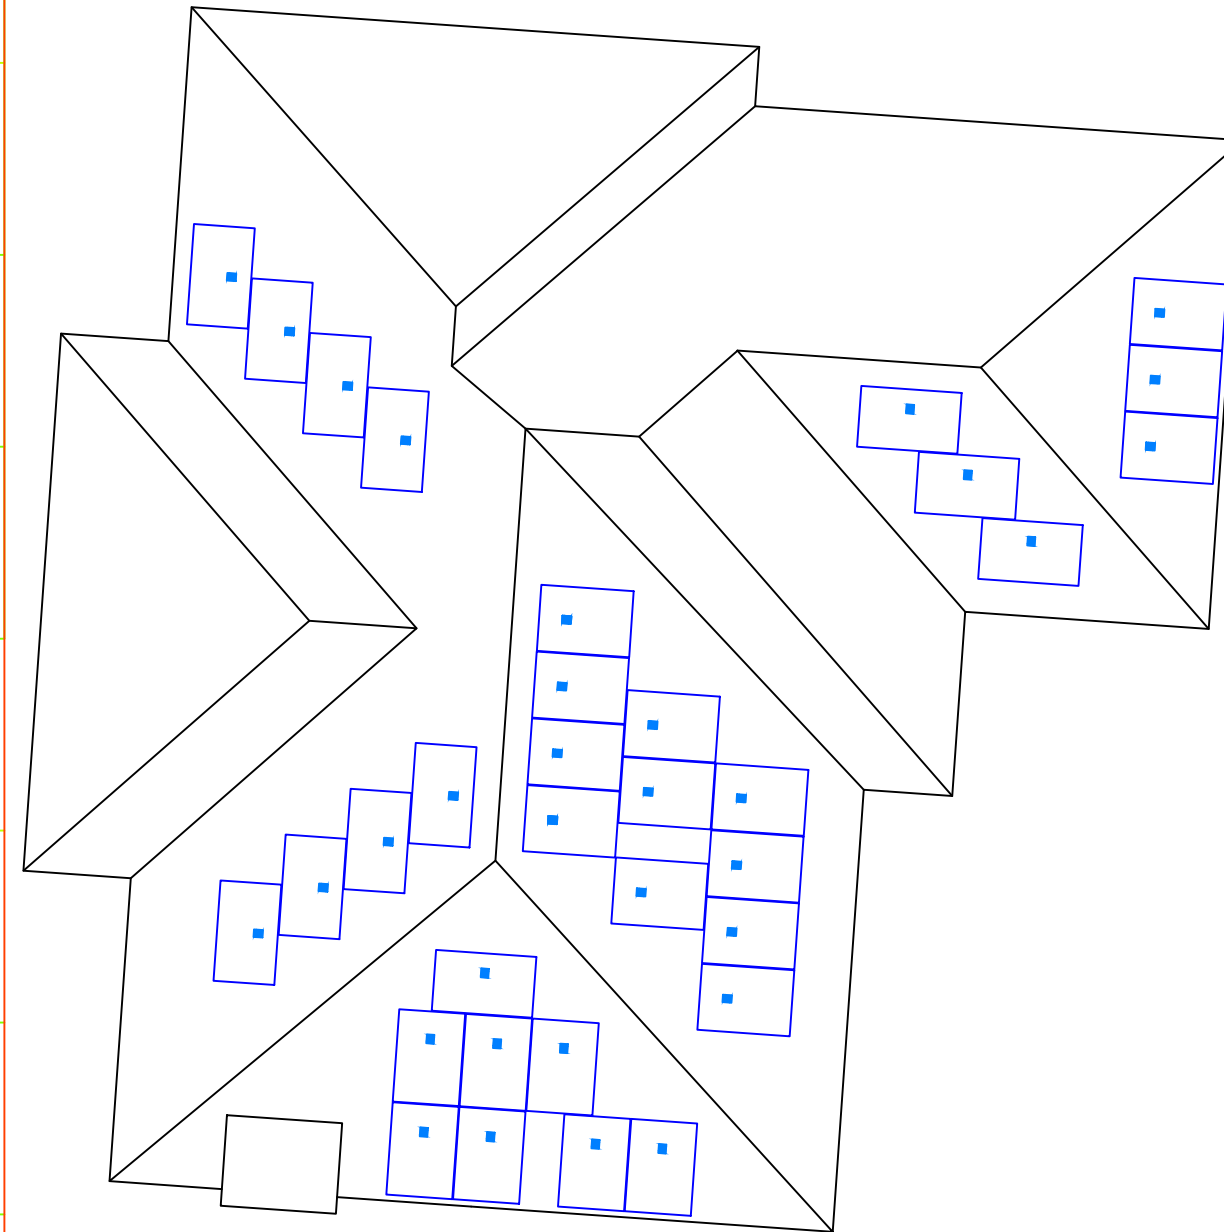

Q.TRON BLK M-G2+ SERIES

410-450 Wp | 108 Cells
22.5% Maximum Module Efficiency
Domestic Content Option Available

MODEL Q.TRON BLK M-G2+ Q.TRON BLK M-G2.F.+
Q.TRON BLK M-G2.C.+ Q.TRON BLK M-G2.H.+



Includes Domestic Content

Q.TRON BLK M-G2.X+ solar modules ("X" can be "C, F, H") contain U.S. manufactured components which can contribute to qualifying for the 10% domestic content bonus to applicable tax credits under the Inflation Reduction Act of 2022.¹



High performance Qcells N-type solar cells

Q.ANTUM NEO Technology with optimized module layout boosts module efficiency up to 22.5%.



A reliable investment

Inclusive 25-year product warranty and 25-year linear performance warranty.²



Enduring high performance

Long-term yield security with Anti LeTID Technology, Anti PID Technology³, Hot-Spot Protect.



Extreme weather rating

High-tech aluminum alloy frame, certified for high snow (8100 Pa) and wind loads (3600 Pa).



Innovative all-weather technology

Optimal yields, whatever the weather with excellent low-light and temperature behaviour.



Far beyond the standard

Qcells' comprehensive quality program ensures high long-term yields and the reliability of your solar system.

¹ This statement should not be relied on as tax advice and is subject to change based on changes made to the Inflation Reduction Act and its implementing rules and regulations. Please consult a qualified tax professional for specific guidance.

² See data sheet on rear for further information.

³ APT test conditions according to IEC/TS 62804-1:2015, method A (-1500V, 96h)


The ideal solution for:



Q.TRON BLK M-G2+ SERIES

Mechanical Specification

Format	67.8 in x 44.6 in x 1.18 in (including frame) (1722 mm x 1134 mm x 30 mm)
Weight	46.7 lbs (21.2 kg)
Front Cover	0.13 in (3.2 mm) thermally pre-stressed glass with anti-reflection technology
Back Cover	Composite film
Frame	Black anodized aluminum
Cell	6 x 18 monocrystalline Q.ANTUM NEO solar half cells
Junction box	2.09-3.98 in x 1.26-2.36 in x 0.59-0.71 in (53-101 mm x 32-60 mm x 15-18 mm), Protection class IP67, with bypass diodes
Cable	4 mm ² Solar cable; (+) ≥ 68.9 in (1750 mm), (-) ≥ 68.9 in (1750 mm)
Connector	Stäubli MC4; IP68

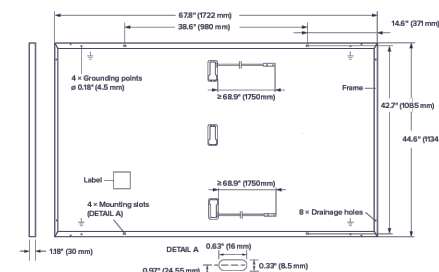

Electrical Characteristics


Power Class		410	415	420	425	430	435	440	445	450
MINIMUM PERFORMANCE AT STANDARD TEST CONDITIONS, STC ¹ (POWER TOLERANCE +5W/-0W)										
Power at MPP ¹	P _{MPP} [W]	410	415	420	425	430	435	440	445	450
Short Circuit Current ¹	I _{SC} [A]	13.41	13.49	13.58	13.66	13.74	13.82	13.90	13.98	14.07
Open Circuit Voltage ¹	V _{OC} [V]	38.19	38.47	38.75	39.03	39.32	39.60	39.88	40.16	40.44
Current at MPP	I _{MPP} [A]	12.76	12.83	12.91	12.98	13.05	13.13	13.20	13.27	13.35
Voltage at MPP	V _{MPP} [V]	32.13	32.34	32.54	32.74	32.94	33.14	33.33	33.52	33.71
Efficiency ¹	η [%]	≥21.0	≥21.3	≥21.5	≥21.8	≥22.0	≥22.3	≥22.5	≥22.8	≥23.0

MINIMUM PERFORMANCE AT NORMAL OPERATING CONDITIONS, NMOT²

Power at MPP	P _{MPP} [W]	309.9	313.7	317.5	321.2	325.0	328.8	332.6	336.4	340.1
Short Circuit Current	I _{SC} [A]	10.81	10.87	10.94	11.00	11.07	11.14	11.20	11.27	11.33
Open Circuit Voltage	V _{OC} [V]	36.23	36.50	36.77	37.04	37.31	37.58	37.84	38.11	38.38
Current at MPP	I _{MPP} [A]	10.04	10.10	10.15	10.21	10.27	10.33	10.38	10.44	10.50
Voltage at MPP	V _{MPP} [V]	30.87	31.07	31.26	31.46	31.65	31.84	32.03	32.22	32.41

¹Measurement tolerances P_{MPP} ± 3%; I_{SC} V_{OC} ± 5% at STC: 1000 W/m², 25 ± 2 °C, AM 1.5 according to IEC 60904-3 • ²800 W/m², NMOT, spectrum AM 1.5


Qcells Performance Warranty

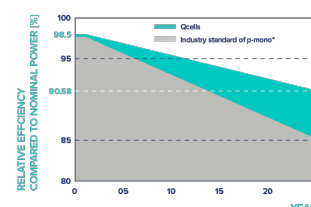

At least 98.5% of nominal power during first year. Thereafter max. 0.33% degradation per year. At least 95.53% of nominal power up to 10 years. At least 90.58% of nominal power up to 25 years.

All data within measurement tolerances. Full warranties in accordance with the warranty terms of the Qcells sales organization of your respective country.

Performance at low Irradiance

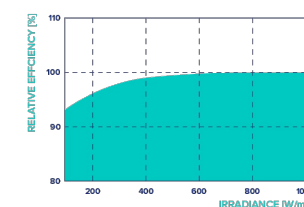

Typical module performance under low irradiance conditions in comparison to STC conditions (25 °C, 1000 W/m²).

Temperature Coefficients

Temperature Coefficient of I _{SC}	α [%/K]	+0.04	Temperature Coefficient of V _{OC}	β [%/K]	-0.24
Temperature Coefficient of P _{MPP}	γ [%/K]	-0.30	Nominal Module Operating Temperature	NMOT [°F]	109 ± 5.4 (43 ± 3 °C)

Properties for System Design

Maximum System Voltage	V _{sys} [V]	1000 (IEC)/1000 (UL)	PV module classification	Class II
Maximum Series Fuse Rating	[A DC]	25	Fire Rating based on ANSI/UL 61730	C / TYPE 2
Max. Design Load, Push/Pull ³	[lbs/ft ²]	113 (5400 Pa)/50 (2400 Pa)	Permitted Module Temperature on Continuous Duty	-40 °F up to +158 °F (-40 °C up to +70 °C)
Max. Test Load, Push/Pull ³	[lbs/ft ²]	169 (8100 Pa)/75 (3600 Pa)		

³ See Installation Manual

Qualifications and Certificates

UL 61730-1 & UL 61730-2, CE-compliant, IEC 61215:2021, IEC 61730:2023,



*Contact your Qcells Sales Representative for details regarding the module's eligibility to be Buy American Act (BAA) compliant.

Qcells pursues minimizing paper output in consideration of the global environment.

Note: Installation instructions must be followed. Contact our technical service for further information on approved installation of this product. Henwei Q CELLS America Inc. 300 Spectrum Center Drive, Suite 500, Irvine, CA 92618, USA | TEL +1 (949) 748-5996 | EMAIL na.support@qcells.com | WEB www.qcells.com/us



LUNEX POWER INC.
4721 N GRADY AVE
TAMPA FL 33614
LIC #: CVC57085
PHONE: 813-540-8807

REVISIONS

DESCRIPTION	DATE	REV
CLIENT COMMENT	12/18/2025	A
CLIENT COMMENT	03/12/2026	B
CLIENT COMMENT	03/13/2026	C

DATE: 07/16/2025

PROJECT NAME & ADDRESS

DELEON KELLY
RESIDENCE
269 S W THOMAS RD,
LAKE CITY, FL 32024

DRAWN BY
ESR

SHEET NAME
EQUIPMENT
SPECIFICATION

SHEET SIZE
ANSI B
11" X 17"

SHEET NUMBER
PV-11

Specifications subject to technical changes © Qcells Q.TRON BLK M-G2+ Series_DCL_410-450_2025-10_Rev03_NA

SolarEdge Home Hub Inverter

USA Domestic Content Eligible*

Single Phase, for North America

SE3800H-US / SE5700H-US / SE7600H-US / SE10000H-US / **SE11400H-US**



HOME BACKUP



SolarEdge's USA-manufactured residential single phase inverter offering for storage and backup applications

- Eligible for domestic content percentage under the enhanced federal income tax credit*
- The ultimate home energy manager in charge of PV production, battery storage, backup operation during a power outage**, EV Charging, and smart energy devices
- Record-breaking 99% weighted efficiency with up to 200% DC oversizing
- Able to start high LRA HVAC systems during backup operation
- Integrates seamlessly with the complete SolarEdge Home Smart Energy Ecosystem, through SolarEdge Home Network
- Module-level monitoring and visibility of battery status, PV production, and self-consumption data
- Fast and easy installation – small and lightweight, with reduced commissioning time
- NEMA 4X-rated, for indoor and outdoor installations
- A scalable solution that supports future homeowner needs through easy connection to a growing ecosystem of products
- Advanced safety features with integrated arc fault protection and rapid shutdown for 690.11 and 690.12
- Advanced reliability with automotive-grade components
- Embedded revenue grade production data, ANSI C12.20 Class 0.5
- Install larger systems while avoiding main panel upgrades with the embedded Power Control System (PCS)

* As it relates to the domestic content rules, the U.S. Department of Treasury and the IRS have not yet issued proposed or final regulations. Rather, the IRS has issued three notices – Notice 2023-38, Notice 2024-41 and Notice 2025-08. These notices provide guidance regarding the domestic content rules. SolarEdge products referenced herein are manufactured with the intent to be eligible for inclusion under the elective safe harbor table in calculating the Domestic Content Percentage under the "Roctop (MLPE)" category (under IRS Notice 2025-08). Eligibility is subject to the installation of qualified USA-Manufactured inverters and Power Optimizers (US02/US03) in the same project. SolarEdge does not provide tax and/or legal advice. You should consult with your own legal and/or tax advisor(s) regarding the eligibility of your project for the TIC or PTC, including the 30% Domestic Content bonus, to determine how the applicable rules apply to your project. The forward-looking statements in this document are accurate as of the date herein and are subject to change. For more information, please contact your local SolarEdge sales representative. PN US5000H-USMNB78 contains the following domestically produced MPCs: per notice 2025-08*, Printed Circuit Board Assemblies (DC-DC) and (AC-AC), Enclosure, Production (24.8%); per notice 2024-41**, Printed Circuit Board Assemblies (DC-DC) and (AC-AC), Enclosure, Production (24.8%); per notice 2025-08*, Printed Circuit Board Assemblies, Enclosure (17.6%).

solaredge.com



SolarEdge Home Hub Inverter

USA Domestic Content Eligible

Single Phase, for North America

SE3800H-US / SE5700H-US / SE7600H-US / SE10000H-US / **SE11400H-US**

Applicable to inverters with part number	USExxxxH-USMNB78				
Model Number ⁽¹⁾	SE3800H-US	SE5700H-US	SE7600H-US	SE10000H-US	SE11400H-US
OUTPUT – AC ON GRID					
Maximum AC Power Output	3800 @ 240V 3300 @ 208V	5760 @ 240V 5000 @ 208V	7600 @ 240V 6600 @ 208V	10,000 @ 240V 8700 @ 208V	11,400 @ 240V 10,000 @ 208V
AC Output Voltage (Nominal)	208 / 240				
AC Output Voltage (Range)	183 – 264				
AC Frequency Range (min - nom - max)	59.3 – 60 – 60.5 ⁽²⁾				
Maximum Continuous Output Current	16	24	32	42	47.8
Maximum Fault Current / Duration	90 / 50				
GFDI Threshold	1				
Total Harmonic Distortion (THD)	< 3				
Power Factor	1, adjustable -0.85 to 0.85				
Utility Monitoring, Islanding Protection, Country Configurable Thresholds	Yes				
Charge Battery from AC (if allowed)	Yes				
Typical Nighttime Power Consumption	< 2.5				
OUTPUT – AC STANDALONE (BACKUP)⁽³⁾					
Rated AC Power in Standalone Operation ⁽⁴⁾	12,500 ⁽⁵⁾⁽⁶⁾				
Maximum Continuous Output Current in Standalone Operation	52				
Locked Rotor Amperage (LRA) ⁽⁷⁾	Up to 106				
AC L-L Output Voltage Range in Standalone Operation	211 – 264				
AC L-N Output Voltage Range in Standalone Operation	105 – 132				
AC Frequency Range in Standalone Operation (min - nom - max)	55 – 60 – 65				
GFDI	1				
THD	< 5				
INPUT – DC (PV AND BATTERY)					
Transformer-less, Ungrounded	Yes				
Maximum Input Voltage	480				
Nominal DC Input Voltage	380				
Reverse-Polarity Protection	Yes				
Ground-Fault Isolation Detection	600kΩ Sensitivity				
Maximum Input Short Circuit Current	45				
Maximum Inverter Efficiency	99.2				
CEC Weighted Efficiency	98.5		99		99 @ 240V 98.5 @ 208V
2-Pole Disconnection	Yes				
DC CONNECTION – PV					
Maximum Input Power	7600 @ 240V 6600 @ 208V	11,520 @ 240V 10,000 @ 208V	15,200 @ 240V 13,200 @ 208V	20,000 @ 240V 17,400 @ 208V	22,800 @ 240V 20,000 @ 208V
Maximum Input Current	20 @ 240V 17 @ 208V	30 @ 240V 26 @ 208V	40 @ 240V 35 @ 208V	53 @ 240V 46 @ 208V	60 @ 240V 53 @ 208V
Number of Ports	3				
Maximum Current per Port	40				

(1) These specifications apply to inverters with part number SExxxxH-USMNB78 and connection unit model number DCD-IPH-US-P4H-F-x.
 (2) For other regional settings please refer to the SolarEdge Inverters, Power Control Options application note.
 (3) Not designed for non-grid connected applications and requires AC for commissioning. Standalone (backup) functionality is only supported for the 240V grid.
 (4) For models SE7600H-US and below, the Rated AC Power in Standalone Operation is configurable between 7,600W with a Maximum Continuous Output Current of 32A or 12,500W with a Maximum Continuous Output Current of 52A, from firmware version 4.23.xc.
 (5) Operational only at ambient temperatures up to 86°F / 30°C. Above 86°F / 30°C, the Maximum Rated AC Power in Standalone Operation is 11,400W.
 (6) Available only for single inverter installations. In multi-inverter installations, the Maximum Rated AC Power in Standalone Operation is 11,400W.
 (7) For more information about USA Locked Rotor Amperage values, see the SolarEdge Home Hub Inverter, LRA application note.

© SolarEdge Technologies, Ltd. All rights reserved. SOLAREDGE, the SolarEdge logo, OPTIMIZED BY SOLAREDGE are trademarks or registered trademarks of SolarEdge Technologies, Inc. All other trademarks mentioned herein are trademarks of their respective owners. Date: April 23, 2025 DS-000272-NAM. Subject to change without notice.



SolarEdge Home Hub Inverter

USA Domestic Content Eligible

Single Phase, for North America

SE3800H-US / SE5700H-US / SE7600H-US / SE10000H-US / **SE11400H-US**

Applicable to inverters with part number	USExxxxH-USMNB78				
Model Number ⁽¹⁾	SE3800H-US	SE5700H-US	SE7600H-US	SE10000H-US	SE11400H-US
DC CONNECTION – BATTERY					
Supported Battery Types	SolarEdge Home Battery 400V				
Number of Batteries per Inverter	Up to 3				
Maximum Continuous Power (Charge and Discharge) ⁽⁸⁾	12,500				
Number of Ports	2				
Maximum Current per Port	40				
2-pole Disconnection	Up to the inverter's rated standalone power				
SMART ENERGY CAPABILITIES					
Consumption Metering	Built-in ⁽⁹⁾				
Standalone & Battery Storage	With Backup Interface (purchased separately) for service up to 200A; up to 3 inverters				
EV Charging	Direct connection to the SolarEdge Home EV Charger ⁽¹⁰⁾				
ADDITIONAL FEATURES					
Supported Communication Interfaces	RS485, Ethernet, Cellular ⁽¹¹⁾ , Wi-Fi (optional), SolarEdge Home Network ⁽¹²⁾ (optional)				
Revenue Grade Metering, ANSI C12.20	Built-in ⁽⁹⁾				
Integrated AC, DC, and Communication Connection Unit	Yes				
Inverter Commissioning	With the SetApp mobile application using built-in Wi-Fi Access Point for local connection				
DC Voltage Rapid Shutdown (PV and Battery)	Yes, NEC 690.12				
STANDARD COMPLIANCE					
Safety	UL 1741, UL 1741SA, UL 1741SB, UL 16998, CSA 22.2#107.1, C22.2#330, C22.3#9, ANSI/CAN/UL 9540				
Grid Connection Standards	IEEE1547-2018 and IEEE-1547.1 Rule 21, Rule 14H				
Emissions	FCC Part 15 Class B				
Power Control System (PCS)	UL 1741 PCS ⁽¹³⁾				
INSTALLATION SPECIFICATIONS					
AC Terminals	L1, L2, N terminal blocks, PE busbar for inverter connection				
DC Terminals	L1, L2 terminal blocks, PE busbar for EV Charger AC connection				
AC Output and EV AC Output Conduit Size / AWG Range	1" maximum / 14 – 4 AWG				
DC Input (PV and Battery) Conduit Size / AWG Range	1" maximum / 14 – 6 AWG				
Dimensions with Connection Unit (H x W x D)	21.06 x 14.6 x 8.2 / 535 x 370 x 208				
Weight with Connection Unit	44.9 / 20.3				
Noise	< 50				
Cooling	Natural Convection				
Operating Temperature Range	-40 to +140 / -40 to +60 ⁽¹⁴⁾				
Protection Rating	NEMA 4X				

(8) Discharge power is limited up to the inverter's rated AC power for on-grid and standalone applications, as well as up to the installed batteries' rating.
 (9) For consumption metering current transformers should be ordered separately. SECT-SPL-225A-T-20 or SEACT1250-400NA-20. Revenue grade metering is only for production metering.
 (10) For more information about the SolarEdge Home EV Charger, refer to the SolarEdge Home EV Charger datasheet.
 (11) Purchased separately. Information concerning the data plan terms and conditions is available in SolarEdge Communication Plan Terms and Conditions.
 (12) SolarEdge Home Network Plugin ENET+HBNP-01 purchased separately. For more information, refer to the SolarEdge Home Network Plugin datasheet.
 (13) Only part numbers USExxxxH-USMNB78 support the PCS meter.
 (14) Full power up to at least 122°F / 50°C. For power derating information refer to the Temperature Derating for North America technical note.

© SolarEdge Technologies, Ltd. All rights reserved. SOLAREDGE, the SolarEdge logo, OPTIMIZED BY SOLAREDGE are trademarks or registered trademarks of SolarEdge Technologies, Inc. All other trademarks mentioned herein are trademarks of their respective owners. Date: April 23, 2025 DS-000272-NAM. Subject to change without notice.



LUNEX POWER INC.
 4721 N GRADY AVE
 TAMPA FL 33614
 LIC #: CVC57085
 PHONE: 813-540-8807

REVISIONS		
DESCRIPTION	DATE	REV
CLIENT COMMENT	12/18/2025	A
CLIENT COMMENT	03/12/2026	B
CLIENT COMMENT	03/13/2026	C

DATE: 07/16/2025

PROJECT NAME & ADDRESS

DELEON KELLY
RESIDENCE

269 S W THOMAS RD,
LAKE CITY, FL 32024

DRAWN BY
ESR

SHEET NAME
EQUIPMENT
SPECIFICATION

SHEET SIZE
ANSI B
11" X 17"

SHEET NUMBER
PV-12

Power Optimizer

USA Domestic Content Eligible*

For North America

U650 / U650B



POWER OPTIMIZER



SolarEdge's USA-manufactured offering for PV power optimization at the module level

- Eligible for domestic content: SolarEdge USA-manufactured Power Optimizers*, when paired with certain SolarEdge inverters, are intended to be eligible for the enhanced federal income tax credit for domestic content
- Specifically designed to work with SolarEdge inverters
- Supports high open circuit voltage (Voc) modules with U650B
- U650B provides improved design flexibility of multifaceted, complex roofs, with extended output voltage that reduces yield factor losses
- Superior efficiency (99.5%)
- Mitigates diverse types of module mismatch loss, from manufacturing tolerance to partial shading
- Flexible system design for maximum space utilization
- Faster installations with simplified wire management and easy assembly using a single bolt
- Compatible with a wide range of modules, including high-powered and bifacial PV modules
- Advanced safety:
 - Patented Sense Connect technology, designed to automatically detect and prevent potential electric arcs at the connector level before an arc is created
 - Patented SafeDC™ – module-level voltage shutdown, for installer and firefighter safety
 - Meets NEC requirements for arc fault protection (AFCI) and Photovoltaic Rapid Shutdown System (PVRSS)

* Manufactured by SolarEdge with the intent to be eligible for inclusion under the elective safe harbor in calculating the Domestic Content Percentage under the "Rooftop (MLPE)" category (under IRS Notice 2024-41). The PCBA, Electrical Parts, and Enclosure are domestically manufactured to meet the requirements of eligibility to be considered for the ITC domestic content bonus adder. SolarEdge does not provide tax and/or legal advice. You should consult with your own legal and/or tax advisor(s) regarding the eligibility of your project for the ITC or PTC, including the 10% domestic content bonus, to determine how the applicable rules apply to your particular project. The forward-looking statements in this datasheet are accurate as of the date herein and are subject to change. For more information, please contact your local SolarEdge sales representative.

solaredge.com



/ Power Optimizer

USA Domestic Content Eligible, for North America

U650 / U650B

	U650	U650B	Units
INPUT			
Rated Input DC Power ⁽¹⁾		650	W
Absolute Maximum Input Voltage (Voc)	60	100	Vdc
MPPT Operating Range	8 – 60	12.5 – 100	Vdc
Maximum Continuous Input Current		15	Adc
Maximum Short-Circuit Current (Isc) of Connected PV Module for SolarEdge Home Hub Single Phase Inverters		16.5	Adc
Maximum Short-Circuit Current (Isc) of Connected PV Module for SolarEdge Home Wave Single Phase Inverters		15	Adc
Maximum Short-Circuit Current (Isc) with Safety Factor ⁽²⁾		25	Adc
Maximum Efficiency		99.5	%
Weighted Efficiency		98.6	%
Overvoltage Category		II	
OUTPUT DURING OPERATION (POWER OPTIMIZER CONNECTED TO OPERATING SOLAREEDGE INVERTER)			
Maximum Output Current		15	Adc
Maximum Output Voltage	60	80	Vdc
OUTPUT DURING STANDBY (POWER OPTIMIZER DISCONNECTED FROM SOLAREEDGE INVERTER OR INVERTER OFF)			
Safety Output Voltage per Power Optimizer		1 ± 0.1	Vdc
STANDARD COMPLIANCE			
Photovoltaic Rapid Shutdown System	CSA C22.2#330, NEC 2014 – 2023		
EMC	FCC Part 15 Class B, IEC 61000-6-2, IEC 61000-6-3		
Safety	CSA C22.2#107.1, IEC 62109-1 (Class II safety), UL 1741		
Material	UL 94 V-0, UV Resistant		
RoHS	Yes		
Fire Safety	VDE-AR-E 2100-712:2013-05		
INSTALLATION SPECIFICATIONS			
Maximum Allowed System Voltage	1000		Vdc
Dimensions (W x L x H)	129 x 155 x 30 / 5.07 x 6.10 x 1.18	129 x 165 x 45 / 5.07 x 6.49 x 1.77	mm / in
Weight	720 / 1.6	790 / 1.74	gr / lb
Input Connector	MC4		
Input Wire Length	0.1 / 0.32		
Output Connector	MC4		
Output Wire Length	(+) 2.3, (-) 0.10 / (+) 7.54, (-) 0.32		
Operating Temperature Range ⁽³⁾	-40 to +85		
Protection Rating	IP68 / NEMA6P		
Relative Humidity	0 – 100		

(1) The Rated Power of the module at STC will not exceed the power optimizer's Rated Input DC Power. Modules with up to +5% power tolerance are allowed.
 (2) The Maximum Isc with Safety Factor is ≥ 1.25 x the Maximum Isc of Connected PV Module. Adjusted for worst case conditions of ambient temperature, irradiance, bifacial gain, and so on, in accordance with NEC and CSA.
 (3) Power derating is applied for ambient temperatures above +85°C / +185°F for U650 and for ambient temperatures above +75°C / 167°F for U650B. Refer to the [Power Optimizers Temperature Derating](#) technical note for details.

PV System Design Using a SolarEdge Inverter	SolarEdge Home Hub Single Phase	Three Phase for 208V Grid	Three Phase for 277/480V Grid	Units
Minimum String Length (Power Optimizers)	U650: 8 U650B: 6	10 ⁽⁴⁾ 8	18 14	
Maximum String Length (Power Optimizers)	25		50 ⁽⁵⁾	
Maximum Usable Power Delivered per String	5700	6000	12,750	W
Maximum Allowed Connected Power per String ⁽⁶⁾⁽⁷⁾	Inverters with Rated AC Power ≤ 5760W Inverters with Rated AC Power ≥ 7600W	Per the inverter's maximum input DC power ⁽⁸⁾ One string: 5700 Two strings or more: 6800	One string: 7200 Two strings or more: 7800	W
Parallel Strings of Different Lengths or Orientations	Yes			

(4) For the SE17.3KUS Three Phase Inverter and the SE50KUS Three Phase Inverter with Synergy Technology, the minimum string length is 11 Power Optimizers.
 (5) A string with more than 30 optimizers does not meet NEC rapid shutdown requirements; safety voltage will be above the 30V requirement.
 (6) For the 208V grid, the maximum is permitted only when the difference in connected power between strings is 1000W or less.
 (7) For the 240V or 277/480V grids, the maximum is permitted only when the difference in connected power between strings is 2000W or less.
 (8) Refer to the [Single String Design Guidelines](#) application note for more details.

© SolarEdge Technologies, Ltd. All rights reserved. SOLAREEDGE, the SolarEdge logo, OPTIMIZED BY SOLAREEDGE are trademarks or registered trademarks of SolarEdge Technologies, Inc. All other trademarks mentioned herein are trademarks of their respective owners. Date: February 1, 2026 DS-000247-NAM. Subject to change without notice.



LUNEX POWER INC.
 4721 N GRADY AVE
 TAMPA FL 33614
 LIC #: CVC57085
 PHONE: 813-540-8807

REVISIONS		
DESCRIPTION	DATE	REV
CLIENT COMMENT	12/18/2025	A
CLIENT COMMENT	03/12/2026	B
CLIENT COMMENT	03/13/2026	C

DATE: 07/16/2025

PROJECT NAME & ADDRESS

DELEON KELLY
 RESIDENCE
 269 S W THOMAS RD,
 LAKE CITY, FL 32024



DRAWN BY
 ESR

SHEET NAME
 EQUIPMENT
 SPECIFICATION

SHEET SIZE
 ANSI B
 11" X 17"

SHEET NUMBER
 PV-13

PART # TABLE		
P/N	DESCRIPTION	LENGTH
084RLM1	NXT UMOUNT RAIL 84" MILL	84"
084RLD1	NXT UMOUNT RAIL 84" DARK	84"
168RLM1	NXT UMOUNT RAIL 168" MILL	168"
168RLD1	NXT UMOUNT RAIL 168" DARK	168"
208RLM1	NXT UMOUNT RAIL 208" MILL	208"
208RLD1	NXT UMOUNT RAIL 208" DARK	208"
246RLM1	NXT UMOUNT RAIL 246" MILL	246"
246RLD1	NXT UMOUNT RAIL 246" DARK	246"
171RLM1	NXT UMOUNT RAIL 171" MILL	171.50"
171RLD1	NXT UMOUNT RAIL 171" DARK	171.50"
096RLM1	NXT UMOUNT RAIL 96" MILL	96"
096RLD1	NXT UMOUNT RAIL 96" DARK	96"
185RLM1	NXT UMOUNT RAIL 185" MILL	185"
185RLD1	NXT UMOUNT RAIL 185" DARK	185"

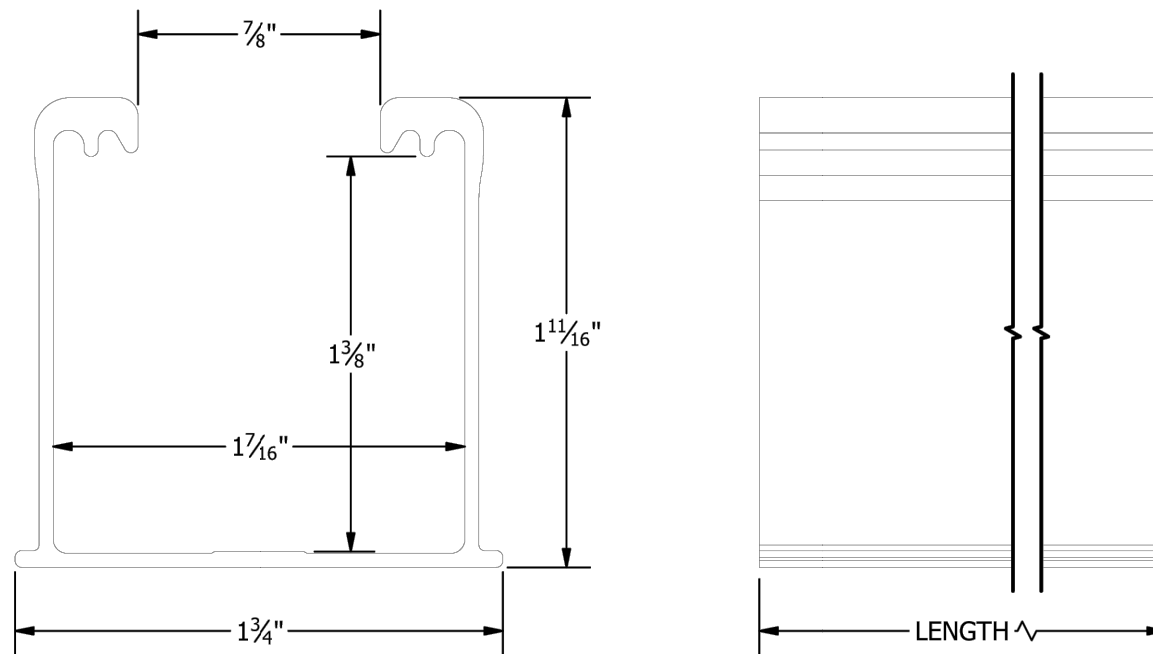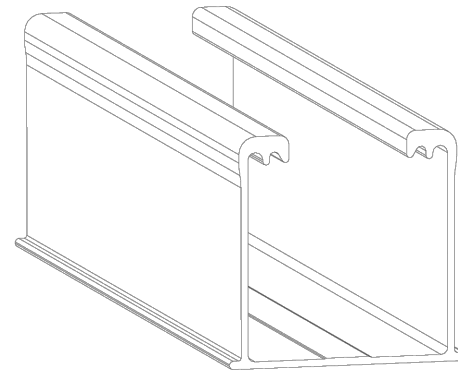

UNIRAC
 1411 BROADWAY BLVD. NE
 ALBUQUERQUE, NM 87102 USA
 PHONE: 505.242.6411
 WWW.UNIRAC.COM

PRODUCT LINE: NXT UMOUNT
 DRAWING TYPE: PART DETAIL
 DESCRIPTION: RAIL
 REVISION DATE: 2/29/2024

DRAWING NOT TO SCALE
 ALL DIMENSIONS ARE
 NOMINAL

PRODUCT PROTECTED BY
 ONE OR MORE US PATENTS
 LEGAL NOTICE

NU-P01
 SHEET



LUNEX POWER INC.
 4721 N GRADY AVE
 TAMPA FL 33614
 LIC #: CVC57085
 PHONE: 813-540-8807

REVISIONS		
DESCRIPTION	DATE	REV
CLIENT COMMENT	12/18/2025	A
CLIENT COMMENT	03/12/2026	B
CLIENT COMMENT	03/13/2026	C

DATE: 07/16/2025

PROJECT NAME & ADDRESS

DELEON KELLY
 RESIDENCE
 269 S W THOMAS RD,
 LAKE CITY, FL 32024




DRAWN BY
 ESR

SHEET NAME
 EQUIPMENT
 SPECIFICATION

SHEET SIZE
 ANSI B
 11" X 17"

SHEET NUMBER
 PV-14

PART # TABLE	
P/N	DESCRIPTION
SHCPKTM1	STRONGHOLD ATT KIT COMP MILL
SHCPKTD1	STRONGHOLD ATT KIT COMP DRK
SHCPKTM1-NS	STRONGHOLD ATT COMP MILL (NS)
SHCPKTD1-NS	STRONGHOLD ATT COMP DRK (NS)

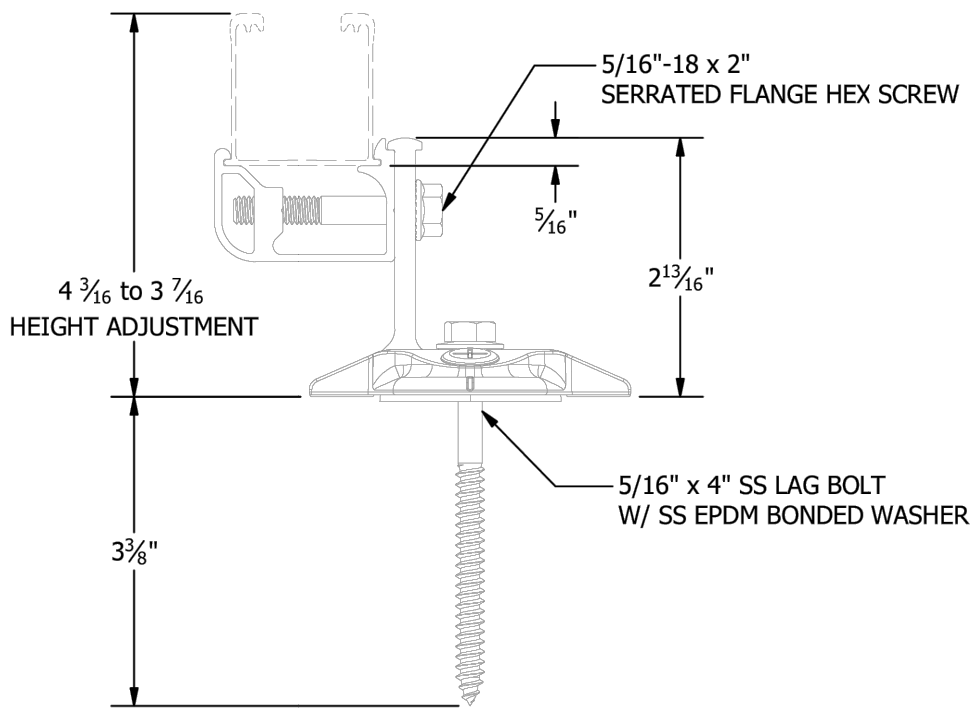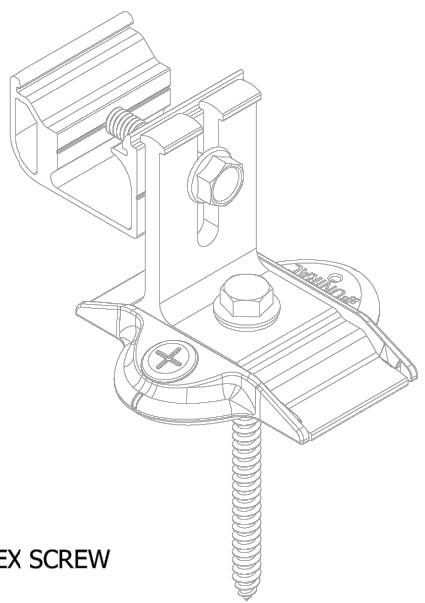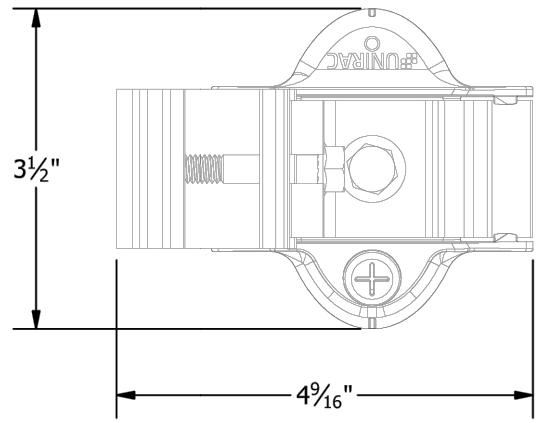

UNIRAC
 1411 BROADWAY BLVD. NE
 ALBUQUERQUE, NM 87102 USA
 PHONE: 505.242.6411
 WWW.UNIRAC.COM

PRODUCT LINE:	NXT UMount
DRAWING TYPE:	PARTS ASSEMBLY
DESCRIPTION:	STRONGHOLD ATTACHMENT
REVISION DATE:	11/17/2022

DRAWING NOT TO SCALE
 ALL DIMENSIONS ARE NOMINAL

PRODUCT PROTECTED BY
 ONE OR MORE US PATENTS
 LEGAL NOTICE

NU-A04
 SHEET



LUNEX POWER INC.
 4721 N GRADY AVE
 TAMPA FL 33614
 LIC #: CVC57085
 PHONE: 813-540-8807

REVISIONS		
DESCRIPTION	DATE	REV
CLIENT COMMENT	12/18/2025	A
CLIENT COMMENT	03/12/2026	B
CLIENT COMMENT	03/13/2026	C

DATE: 07/16/2025

PROJECT NAME & ADDRESS

DELEON KELLY
 RESIDENCE
 269 S W THOMAS RD,
 LAKE CITY, FL 32024

DRAWN BY
 ESR

SHEET NAME
 EQUIPMENT
 SPECIFICATION

SHEET SIZE
 ANSI B
 11" X 17"

SHEET NUMBER
 PV-15



REVISIONS

DESCRIPTION	DATE	REV
CLIENT COMMENT	12/18/2025	A
CLIENT COMMENT	03/12/2026	B
CLIENT COMMENT	03/13/2026	C

DATE: 07/16/2025

PROJECT NAME & ADDRESS

DELEON KELLY
RESIDENCE
269 S W THOMAS RD,
LAKE CITY, FL 32024

DRAWN BY




ESR

SHEET NAME
EQUIPMENT
SPECIFICATION

SHEET SIZE
ANSI B
11" X 17"

SHEET NUMBER


PV-16

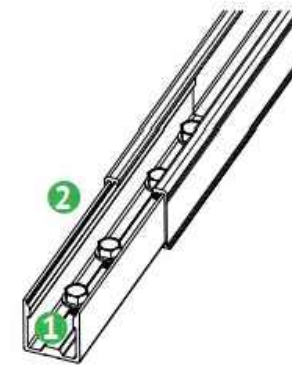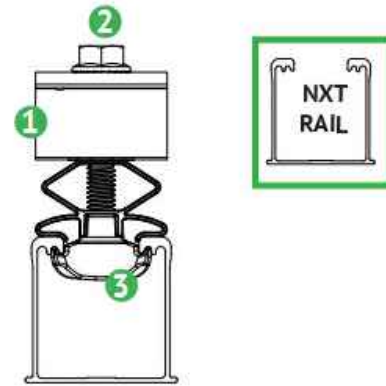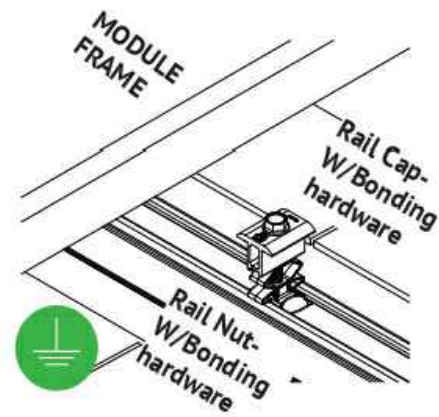

BONDING COMBO MID-END CLAMP ASSEMBLY

- 1 Aluminum combo mid-end clamp cap with stainless steel bonding pins that pierce module frame anodization to bond module to module through clamp
- 2 Stainless steel bolt bonds aluminum clamp to stainless steel Hex bolt
- 3 Aluminum combo mid-end clamp rail nut with stainless steel bonding pins that pierce rail anodization to bond module to module through clamp

NOTE: See Page 19 for installation details.

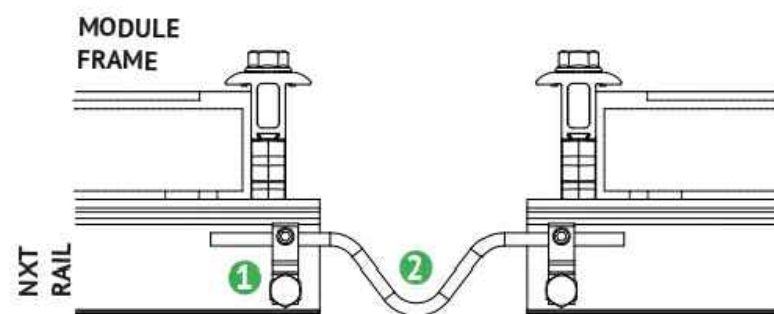

BONDING BETWEEN THERMAL BREAKS

- 1 Lug is connected at the end of each thermal break to the rail.
- 2 Solid copper wire is connected across the gap to bond the two ends.


NOTE: See Page 5 for installation details.

BONDING RAIL SPLICE

- 1 Bonding Hardware creates bond between Splice bar and each rail section.
- 2 Aluminum splice bar spans across rail gap to create rail to rail bond. Rail on at least one side of splice will be grounded.

NOTE:

- See Page 15 for installation details
- Splice certified for single-use only

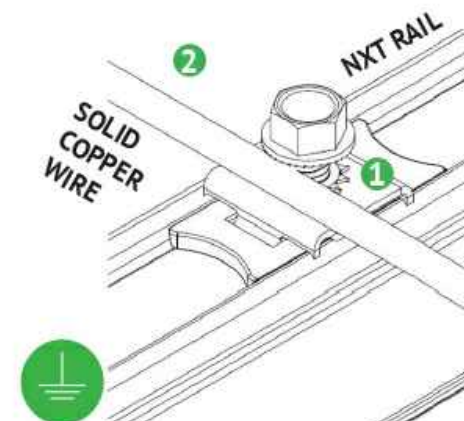

RACK SYSTEM GROUNDING

- 1 Tabs on the stainless-steel washer pierce anodization on the rail to bond rail to ground wire.
- 2 Solid copper wire connected to lug is routed to provide final system ground connection.

NOTE: See Page 16 for installation details and alternate racking system grounding methods.



REVISIONS		
DESCRIPTION	DATE	REV
CLIENT COMMENT	12/18/2025	A
CLIENT COMMENT	03/12/2026	B
CLIENT COMMENT	03/13/2026	C

DATE: 07/16/2025

PROJECT NAME & ADDRESS

DELEON KELLY
RESIDENCE


269 S W THOMAS RD,
LAKE CITY, FL 32024

DRAWN BY
ESR

SHEET NAME
EQUIPMENT
SPECIFICATION

SHEET SIZE
ANSI B
11" X 17"


SHEET NUMBER
PV-17

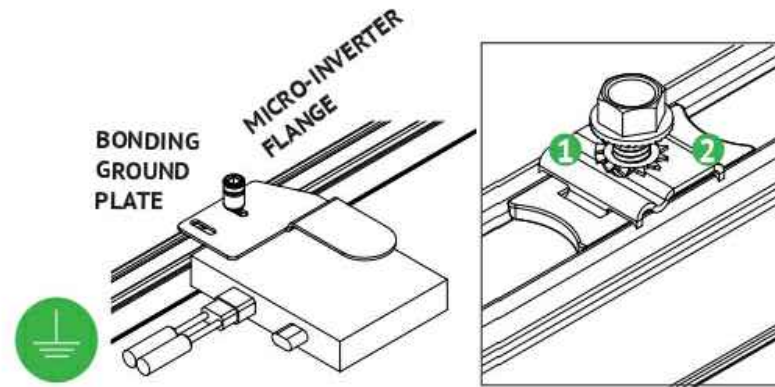

BONDING MICROINVERTER MOUNT

- 1 Stainless steel Tooth lock washer beneath the MLPE flange remove anodization on the MLPE and bonds.
- 2 Tabs on the stainless steel washer remove anodization on the rail and bonds.

NOTE: See Page 17 for installation details

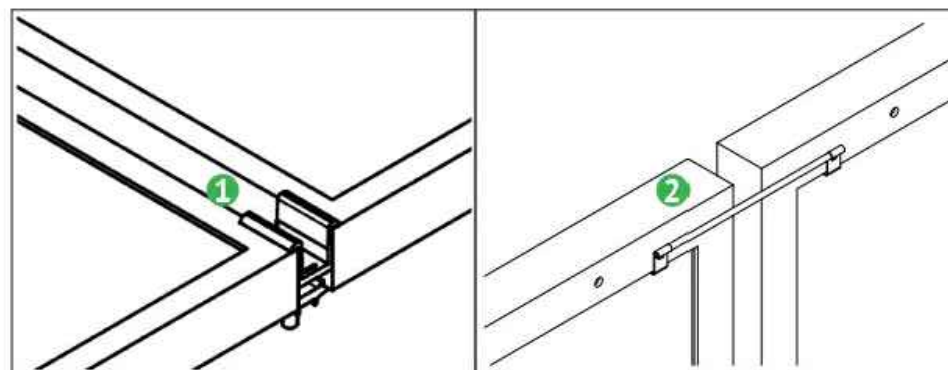

ALTERNATE ROW-TO-ROW BONDING PATHS

- 1 Row-to-row module bonding is accomplished with bonding clamp with 2 integral bonding pins.
- 2 Alternate method by connecting clips on either module to complete the bonding path.

NOTE:

- See Page 16 for installation details
- Row-to-row module bonding certified for single-use only

A. System Specifications and Ratings

- Maximum Voltage: 1,000 Volts
- Maximum Current: **JB-1.2:** 80 Amps; **JB-1.XL:** 120 Amps
- Allowable Wire: 14 AWG – 6 AWG
- Spacing: Please maintain a spacing of at least ½” between uninsulated live parts and fittings for conduit, armored cable, and uninsulated live parts of opposite polarity.
- Enclosure Rating: Type 3R
- Roof Slope Range: 2.5 – 12:12
- Max Side Wall Fitting Size: 1”
- Max Floor Pass-Through Fitting Size: 1”
- Ambient Operating Conditions: (-35°C) - (+75°C)
- Compliance:
 - **JB-1.2:** UL1741, CSA C22.2 No. 290; **JB-1.XL:** UL1741, CSA C22.2 No. 290
 - Approved wire connectors: must conform to UL1741, CSA C22.2 No. 290
- System Marking: **Intertek Symbol and File #5019942**
- Periodic Re-inspections: If re-inspections yield loose components, loose fasteners, or any corrosion between components, components that are found to be affected are to be replaced immediately.



Table 1: Typical Wire Size, Torque Loads and Ratings

	1 Conductor	2 Conductor	Torque				
			Type	NM	Inch Lbs	Voltage	Current
ABB ZS6 terminal block	10-24 awg	16-24 awg	Sol/Str	0.5-0.7	6.2-8.85	600V	30 amp
ABB ZS10 terminal block	6-24 awg	12-20 awg	Sol/Str	1.0-1.6	8.85-14.16	600V	40 amp
ABB ZS16 terminal block	4-24 awg	10-20 awg	Sol/Str	1.6-2.4	14.6-21.24	600V	60 amp
ABB M6/8 terminal block	8-22 awg		Sol/Str	.08-1	8.85	600V	50 amp
Ideal 452 Red <small>WING-NUT Wire Connector</small>	8-18 awg		Sol/Str	Self-Torque	Self-Torque	600V	
Ideal 451 Yellow <small>WING-NUT Wire Connector</small>	10-18 awg		Sol/Str	Self-Torque	Self-Torque	600V	
Ideal, In-Sure <small>Push-In Connector Part #39</small>	10-14 awg		Sol/Str	Self-Torque	Self-Torque	600V	
WAGO, 2204-1201	10-20 awg	16-24 awg	Sol/Str	Self-Torque	Self-Torque	600V	30 amp
WAGO, 221-612	10-20 awg	10-24 awg	Sol/Str	Self-Torque	Self-Torque	600V	30 amp
Dottie DRC75	6-12 awg		Sol/Str	Snap-In	Snap-In		
ESP NG-53	4-6 awg		Sol/Str		45	2000V	
	10-14 awg		Sol/Str		35		
ESP NG-717	4-6 awg		Sol/Str		45	2000V	
	10-14 awg		Sol/Str		35		
Brumall 4-5,3	4-6 awg		Sol/Str		45	2000V	
	10-14 awg		Sol/Str		35		

Table 2: Minimum wire-bending space for conductors through a wall opposite terminals in mm (inches)

Wire size, AWG or kcmil (mm2)	Wires per terminal (pole)			
	1 mm (inch)	2 mm (inch)	3 mm (inch)	4 or More mm (inch)
14-10 (2.1-5.3)	Not Specified	-	-	-
8 (8.4)	38.1 (1-1/2)	-	-	-
6 (13.3)	50.8 (2)	-	-	-

REVISIONS		
DESCRIPTION	DATE	REV
CLIENT COMMENT	12/18/2025	A
CLIENT COMMENT	03/12/2026	B
CLIENT COMMENT	03/13/2026	C

DATE: 07/16/2025

PROJECT NAME & ADDRESS

DELEON KELLY
RESIDENCE
269 S W THOMAS RD,
LAKE CITY, FL 32024

DRAWN BY

ESR

SHEET NAME
EQUIPMENT
SPECIFICATION

SHEET SIZE
ANSI B
11" X 17"

SHEET NUMBER

PV-18