



REVISIONS SCHEDULE			
Jan. 27th, 2022	PROPOSAL		
Mar. 22nd, 2020	REVISIONS		
May 23rd, 2022	PERMIT DRAWINGS		

NEW PROPOSAL FOR:

BOB LAVENDER & WENDI MURRY

LAKE CITY, FLORIDA 32055


RIDGEPOINT
DESIGN

566 SW ARINGTON BLVD., STE 101, LAKE CITY, FL 32025
P: 386-288-1188
E: RIDGEPOINTDESIGN@GMAIL.COM


SHEET NUMBER

A.1

OF 4 SHEETS

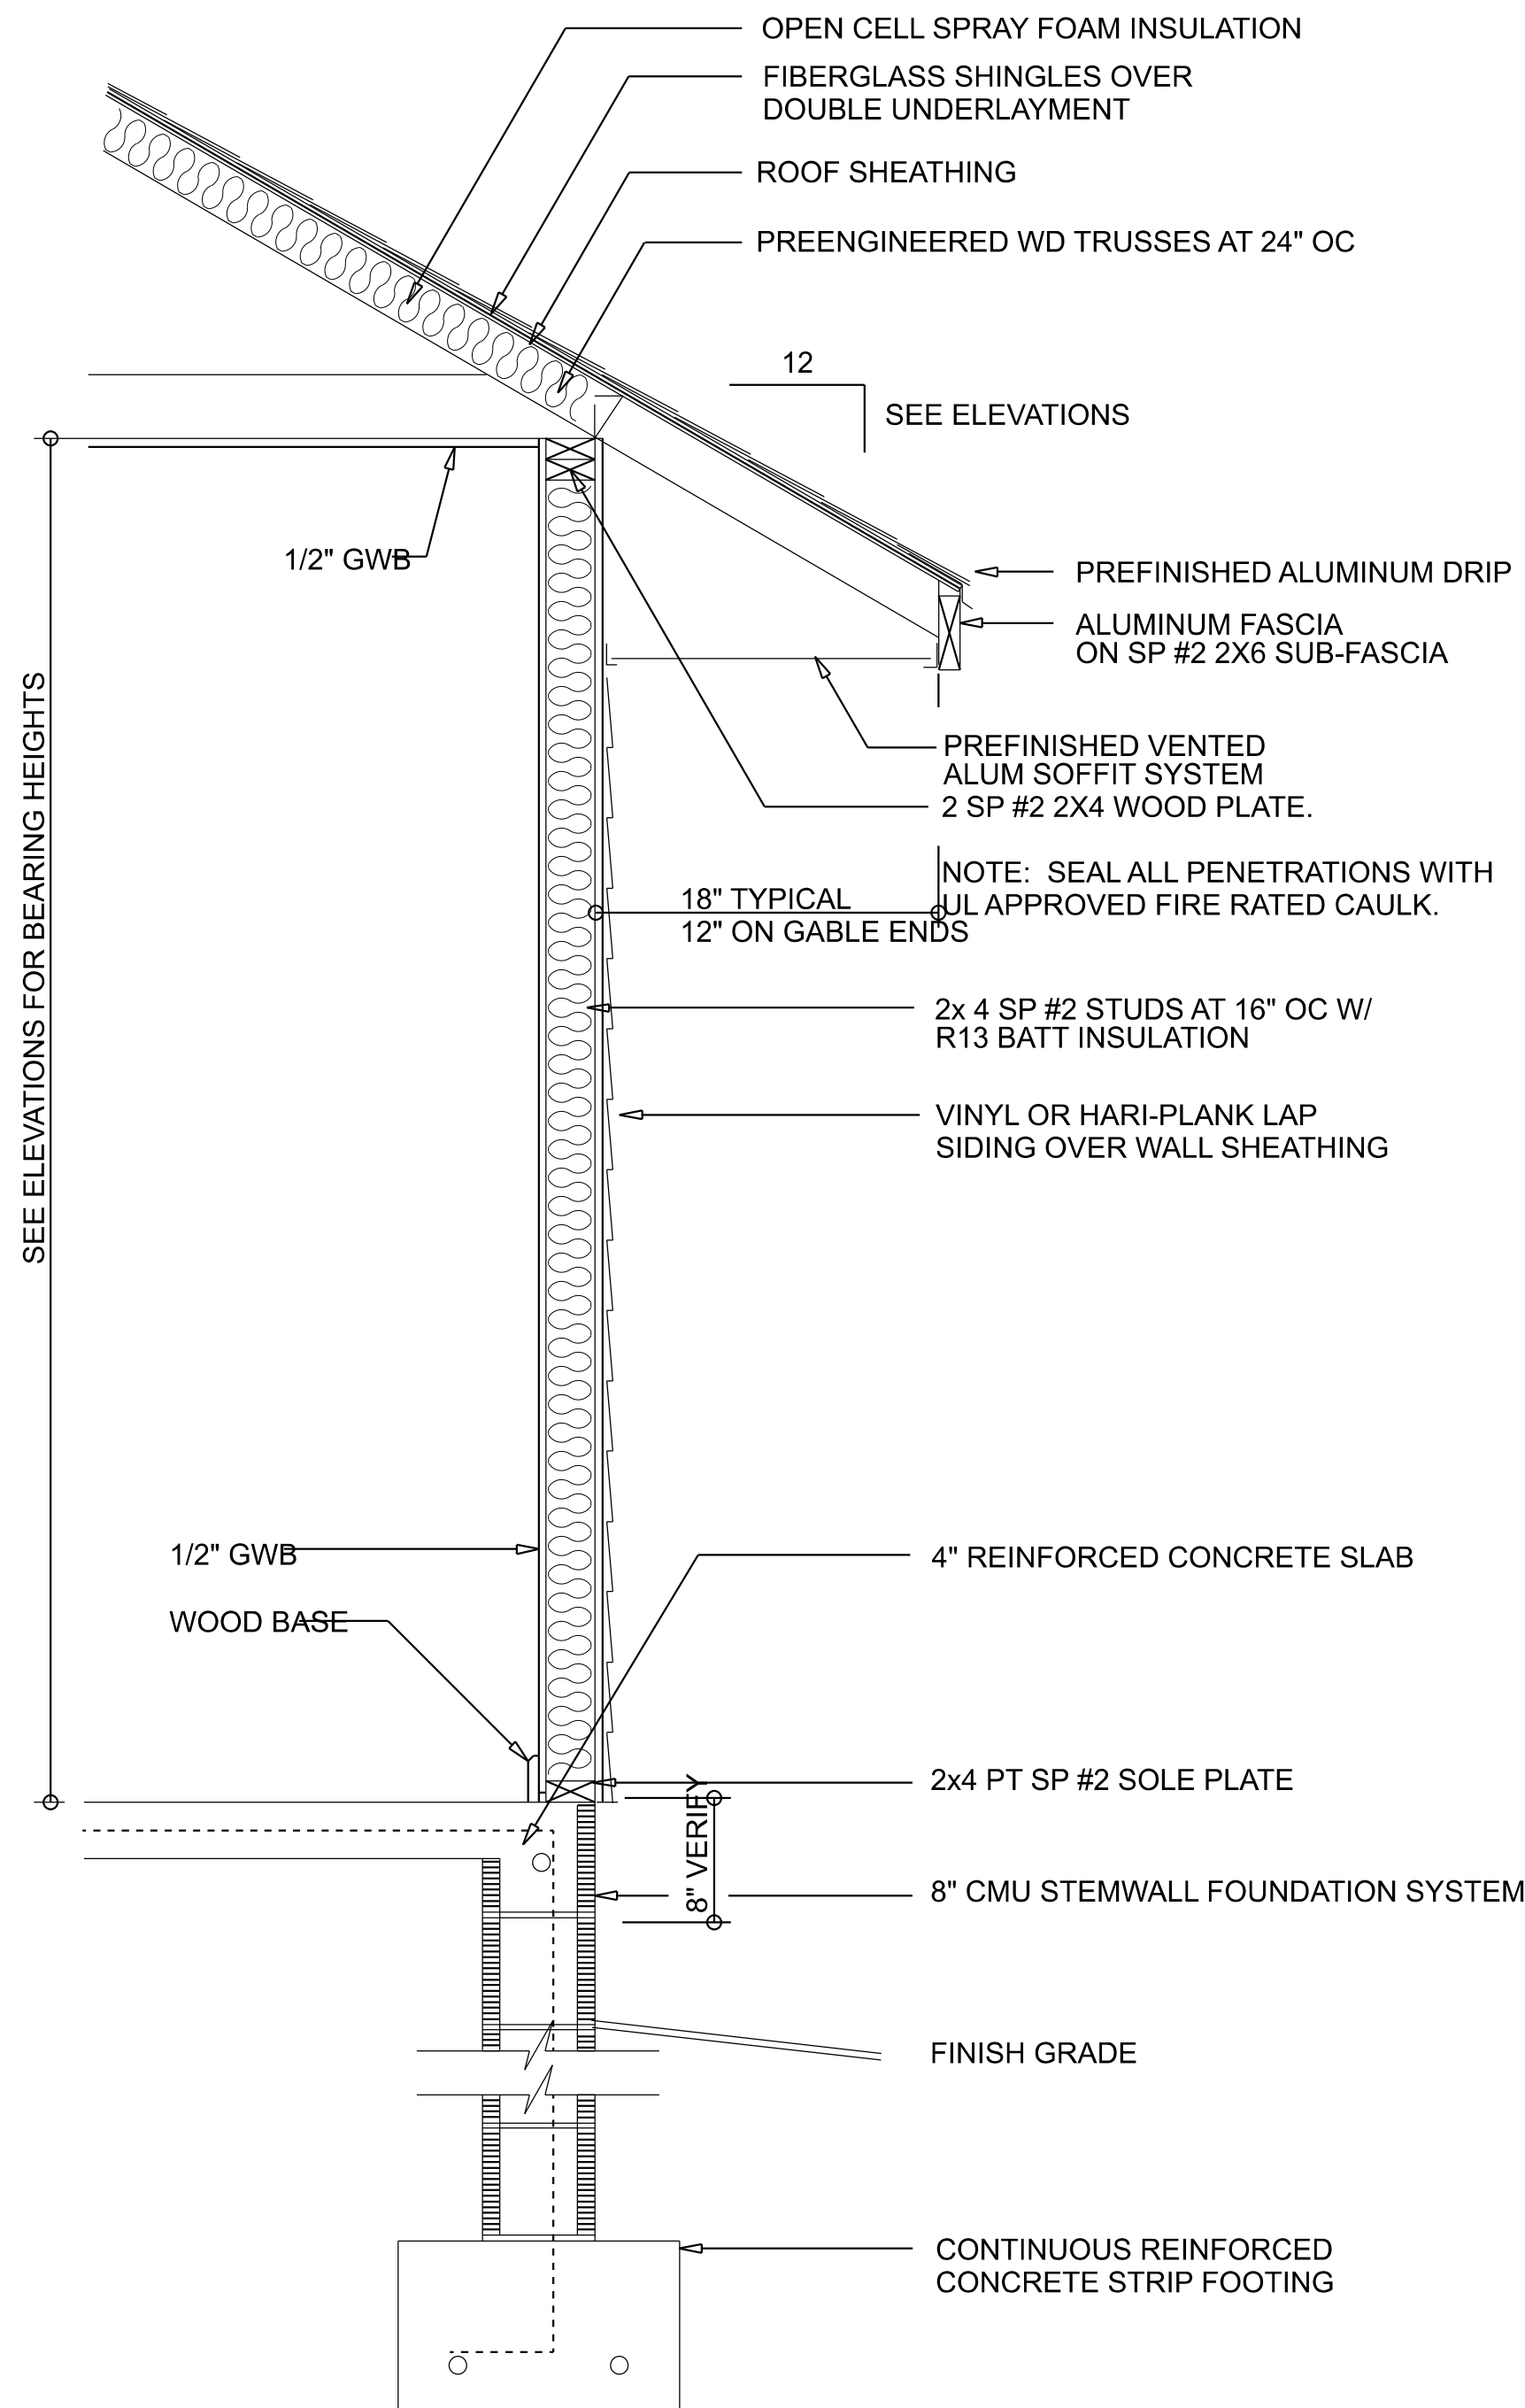

TYPICAL WALL SECTION
SCALE: 1" = 1'-0"

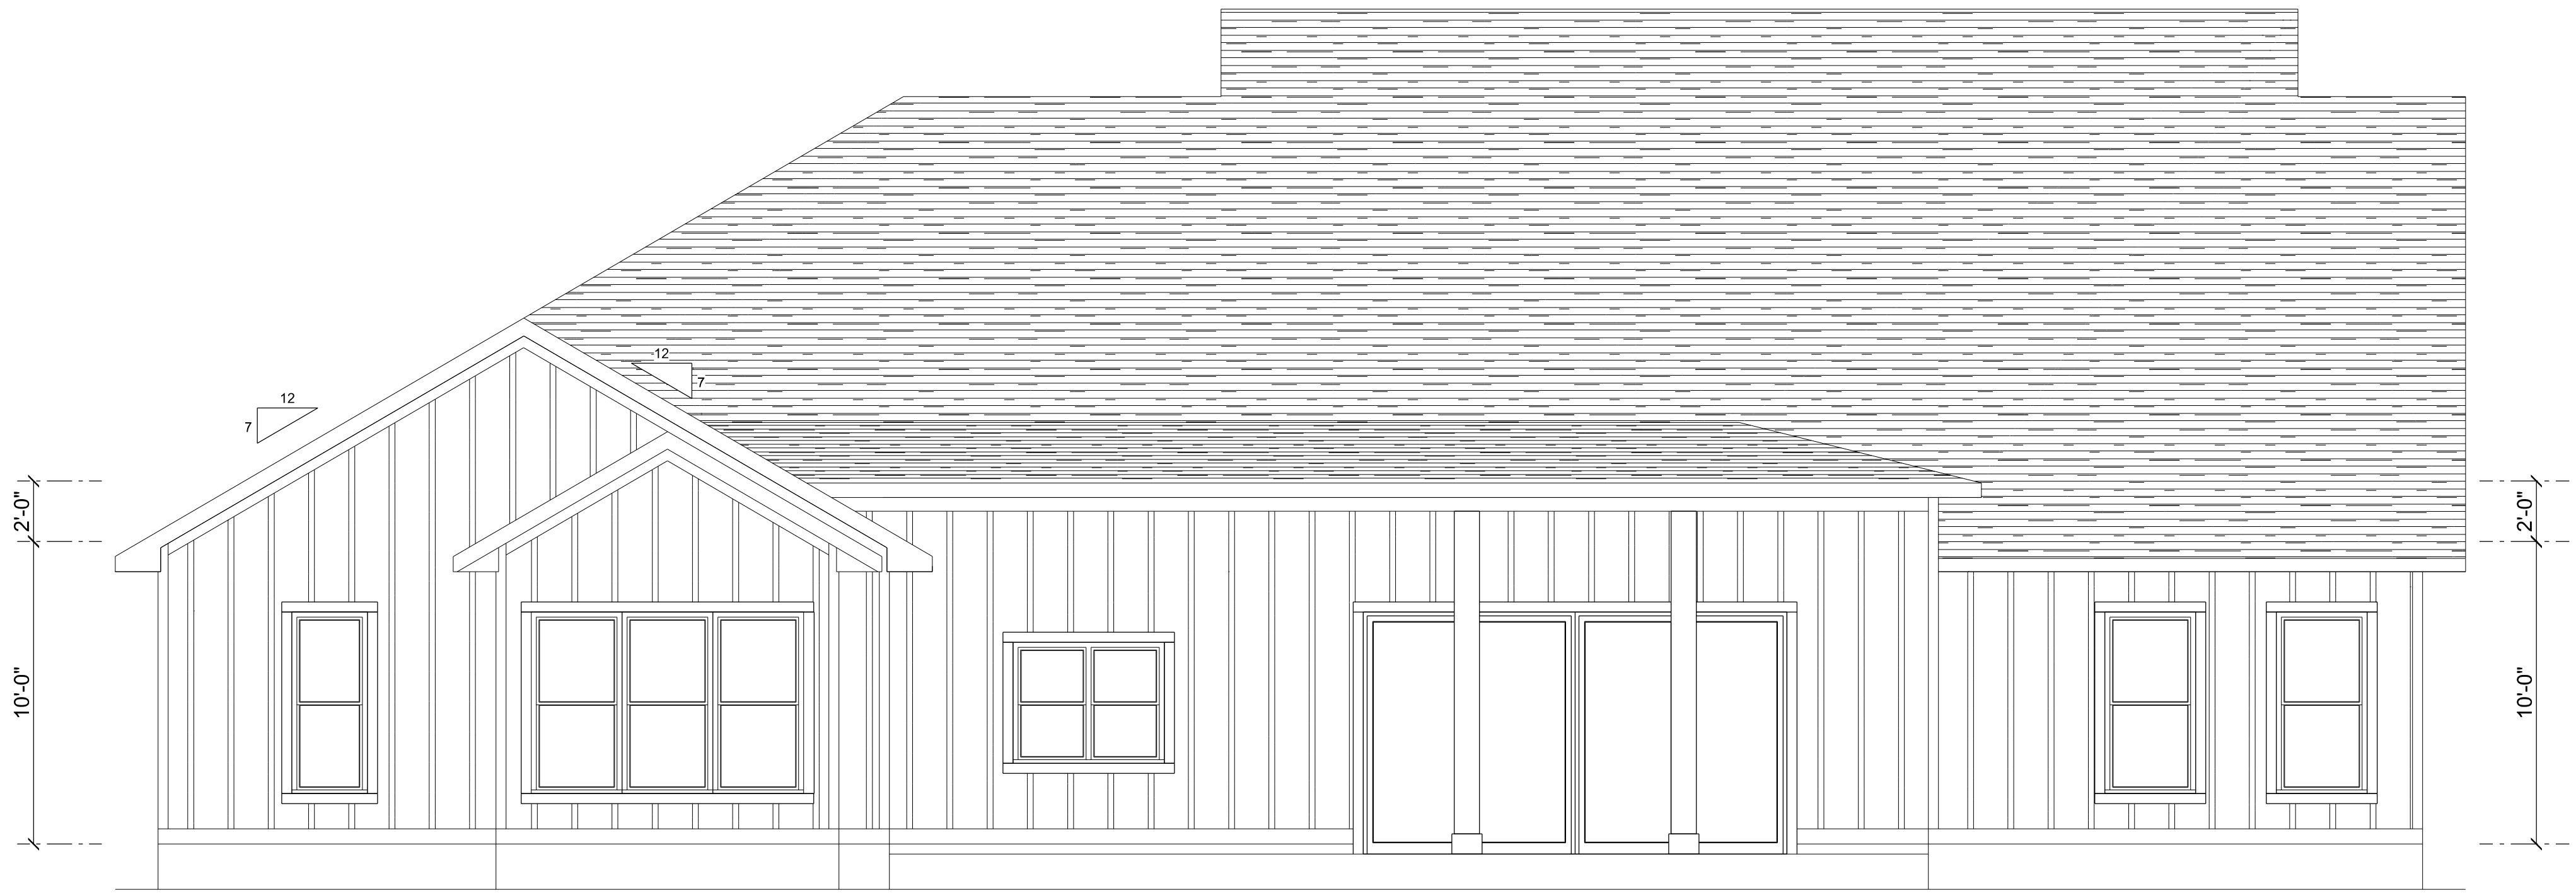


REAR ELEVATION
SCALE: 1/4" = 1'-0"



FRONT ELEVATION
SCALE: 1/4" = 1'-0"




RIGHT ELEVATION
SCALE: 1/4" = 1'-0"

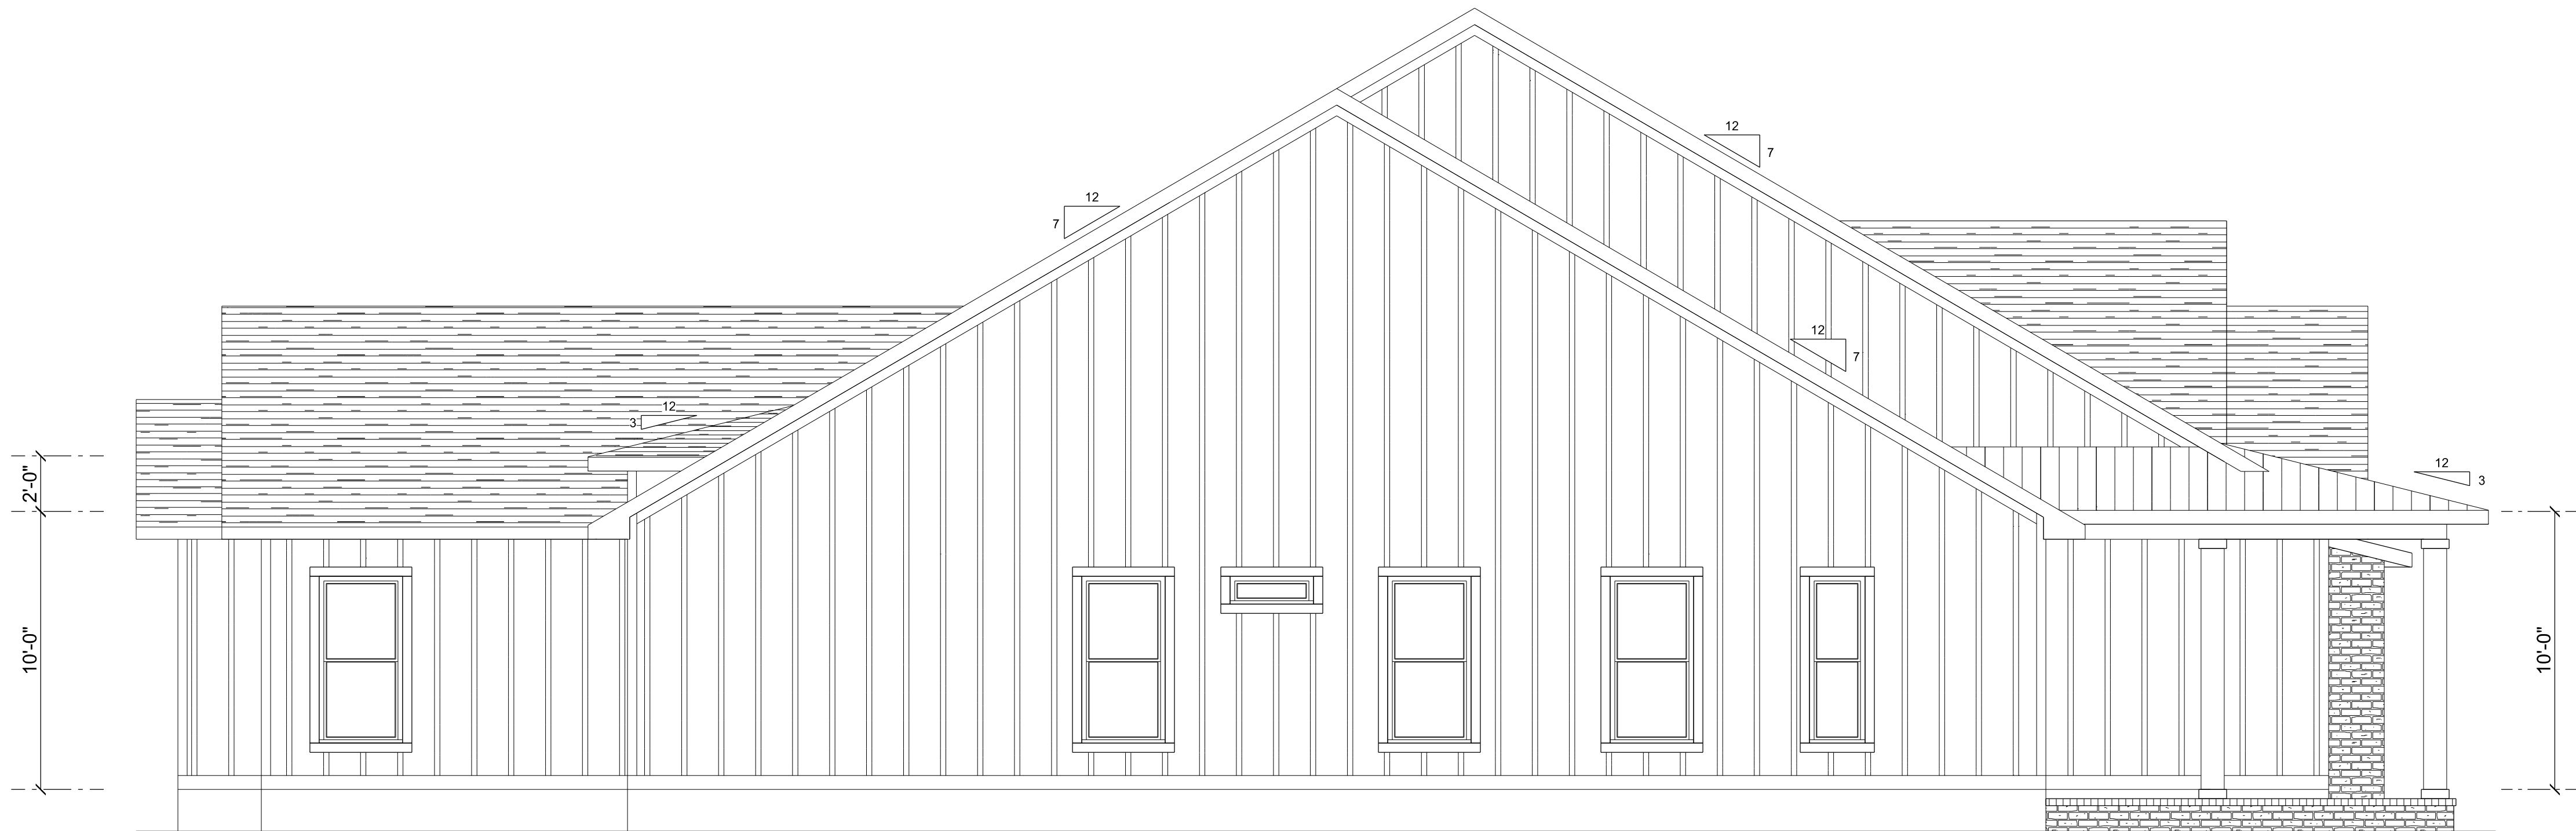

LEFT ELEVATION
SCALE: 1/4" = 1'-0"

REVISIONS SCHEDULE			
Jan. 27th, 2022	PROPOSAL		
Mar. 22nd, 2020	REVISIONS		
May 23rd, 2022	PERMIT DRAWINGS		

NEW PROPOSAL FOR:
BOB LAVENDER & WENDI MURRY
LAKE CITY, FLORIDA 32055

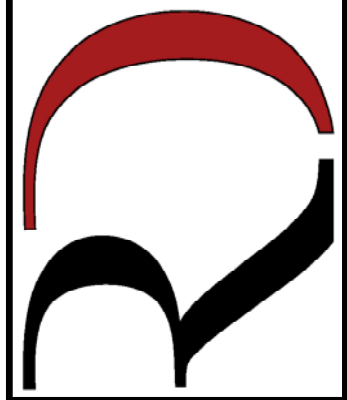

**RIDGEPOINT
DESIGN**
566 SW ARINGTON BLVD., STE 101, LAKE CITY, FL 32025
P: 386-288-1188
E: RIDGEPOINTDESIGN@GMAIL.COM

AREA SUMMARY

HEATED & COOLED	3,021	S.F.
FRONT PORCH	423	S.F.
REAR PORCH	679	S.F.
GARAGE	924	S.F.
GRAND TOTAL	5,047	S.F.


TOTAL CUBIC FOOTAGE OF CONDITIONED SPACE IS: 30,226

Garage fire separations shall comply with the following:

1. The private garage shall be separated from the dwelling unit and its attic area by means of a minimum 1/2-inch (12.7 mm) gypsum board applied to the garage side. Garages beneath habitable rooms shall be separated from all habitable rooms above by not less than 5/8-inch Type X gypsum board or equivalent. Door openings between a private garage and the dwelling unit shall be equipped with either solid wood doors, or solid or honeycomb core steel doors not less than 1 3/8 inches (34.9 mm) thick, or doors in compliance with Section 715.3.3. Openings from a private garage directly into a room used for sleeping purposes shall not be permitted.
2. Ducts in a private garage and ducts penetrating the walls or ceilings separating the dwelling unit from the garage shall be constructed of a minimum 0.019-inch (0.48 mm) sheet steel and shall have no openings into the garage.
3. A separation is not required between a Group R-3 and U carport provided the carport is entirely open on two or more sides and there are not enclosed areas above.
4. When installing an attic access and/or pull-down stair unit in the garage, devise shall have a minimum 20 min. fire rating.

DIMENSIONED FLOOR PLAN

SCALE: 1/4" = 1'-0"

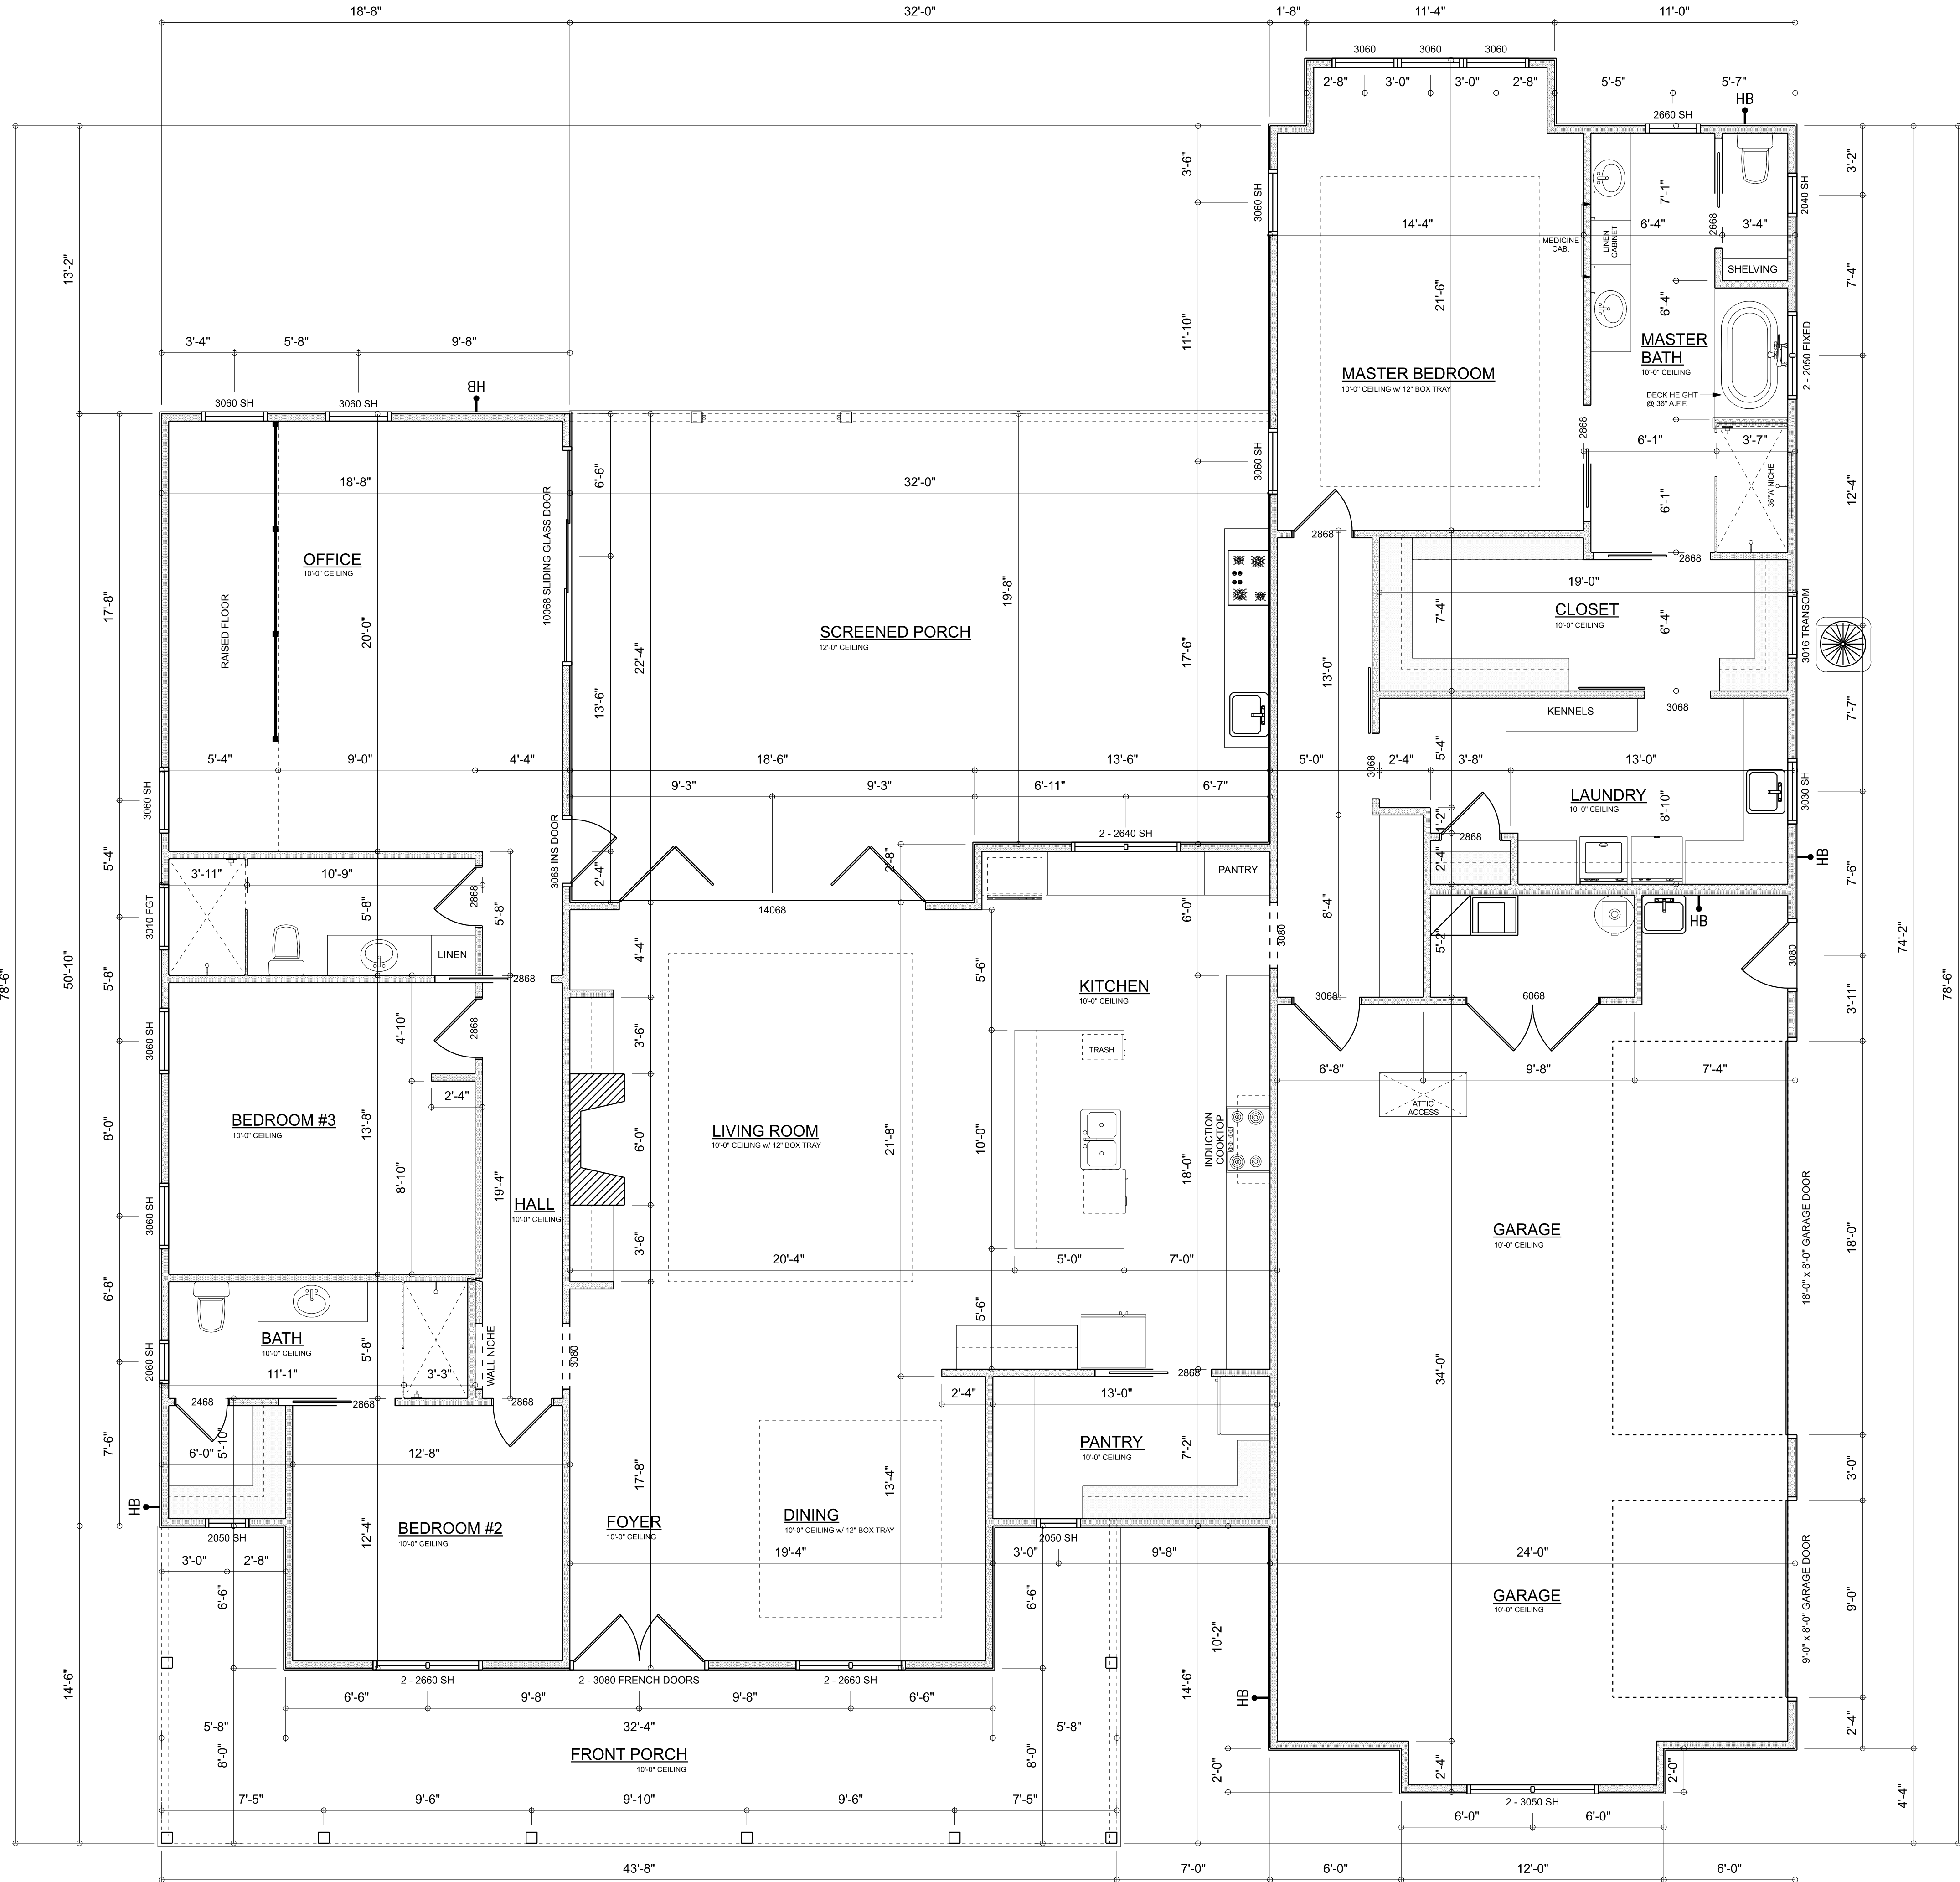


REVISIONS SCHEDULE	
Jan. 27th, 2022	PROPOSAL
Mar. 22nd, 2020	REVISIONS
May 23rd, 2022	PERMIT DRAWINGS

NEW PROPOSAL FOR:
BOB LAVENDER & WENDI MURRY
LAKE CITY, FLORIDA 32055



SHEET NUMBER
A.3
OF 4 SHEETS

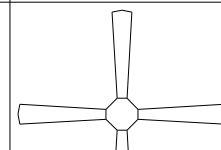ELECTRICAL LEGEND		
ELECTRICAL	COUNT	SYMBOL
CEILING FAN	9	
CAN LIGHT 6inch	47	
CHANDELIER	2	
LED CEILING LIGHT 1x4	5	
PENDANT LIGHT	3	
EXTERIOR SCONCE	6	
MOTION SECURITY LIGHT	5	
CABLE TV OUTLET	6	
EXHAUST FAN	2	
FLOOR OULET DUPLEX	2	
OUTLET	46	
OUTLET 220v	7	
OUTLET GFI	25	
OUTLET WP	10	
SMOKE DETECTOR	6	
STANDARD LIGHT	7	
SWITCH	39	
SWITCH 3 WAY	24	
VANITY BAR LIGHT - SMALL	4	
OUTLET - QUAD	2	
CAT6 OUTLET	12	

ELECTRICAL PLAN NOTES:

INSTALLATION SHALL BE PER 2017 NAT'L ELECTRIC CODE.

WIRE ALL APPLIANCES, HVAC UNITS AND OTHER EQUIPMENT PER MANUF. SPECIFICATIONS

CONSULT WITH THE OWNER FOR THE NUMBER OF SEPERATE TELEPHONE LINES TO BE INSTALLED

ALL SMOKE DETECTORS SHALL BE 120v W/ BATTERY BACKUP OF THE PHOTOELECTRIC TYPE, AND SHALL BE INTERLOCKED TOGETHER. INSTALL INSIDE AND NEAR ALL BEDROOMS

TELEPHONE, TELEVISION AND OTHER LOW VOLTAGE DEVICES OR OUTLETS SHALL BE AS PER THE OWNER'S DIRECTIONS, & IN ACCORDANCE W/ APPLICABLE SECTIONS OF NEC-LATEST EDITION.


ALL RECEPTALS, NOT OTHERWISE NOTED, SHALL BE ARC FAULT INTERRUPTER TYPE, EXCEPT DEDICATED OUTLETS

ALL RECEPTALS IN WET AREAS SHALL BE GROUND FAULT INTERRUPTER TYPE (GFI)

ALL EXTERIOR RECEPTALS SHALL BE WEATHERPROOF GROUD FAULT INTERRUPTER TYPE (WP/GFI)


NOTE:
ELECTRICAL CONTR SHALL PREPARE "AS-BUILT" SHOP DWGS INDICATING ALL ELECTRICAL WORK, INCLUDING ANY CHANGES TO THE ELEC. PLAN, ADDNS TO THE ELEC. PLAN, RISER DIAGRAM, AS-BUILT PANEL SCHEDULE W/ ALL CKTS IDENTIFIED W/ CKT N°. DESCRIPTION & BRKR. SERVICE ENT. & ALL UNDERGROUND WIRE LOCATIONS/ROUTING / DEPTH. RISER DIA. SHALL INCLUDE WIRE SIZES/TYPE & EQUIPMENT TYPE W/ RATINGS & LOADS.
CONTRACTOR SHALL PROVIDE 1 COPY OF AS-BUILT DWGS TO OWNER & 1 COPY TO THE PERMIT ISSUING AUTHORITY

ELECTRICAL PLAN
SCALE: 1/4" = 1'-0"

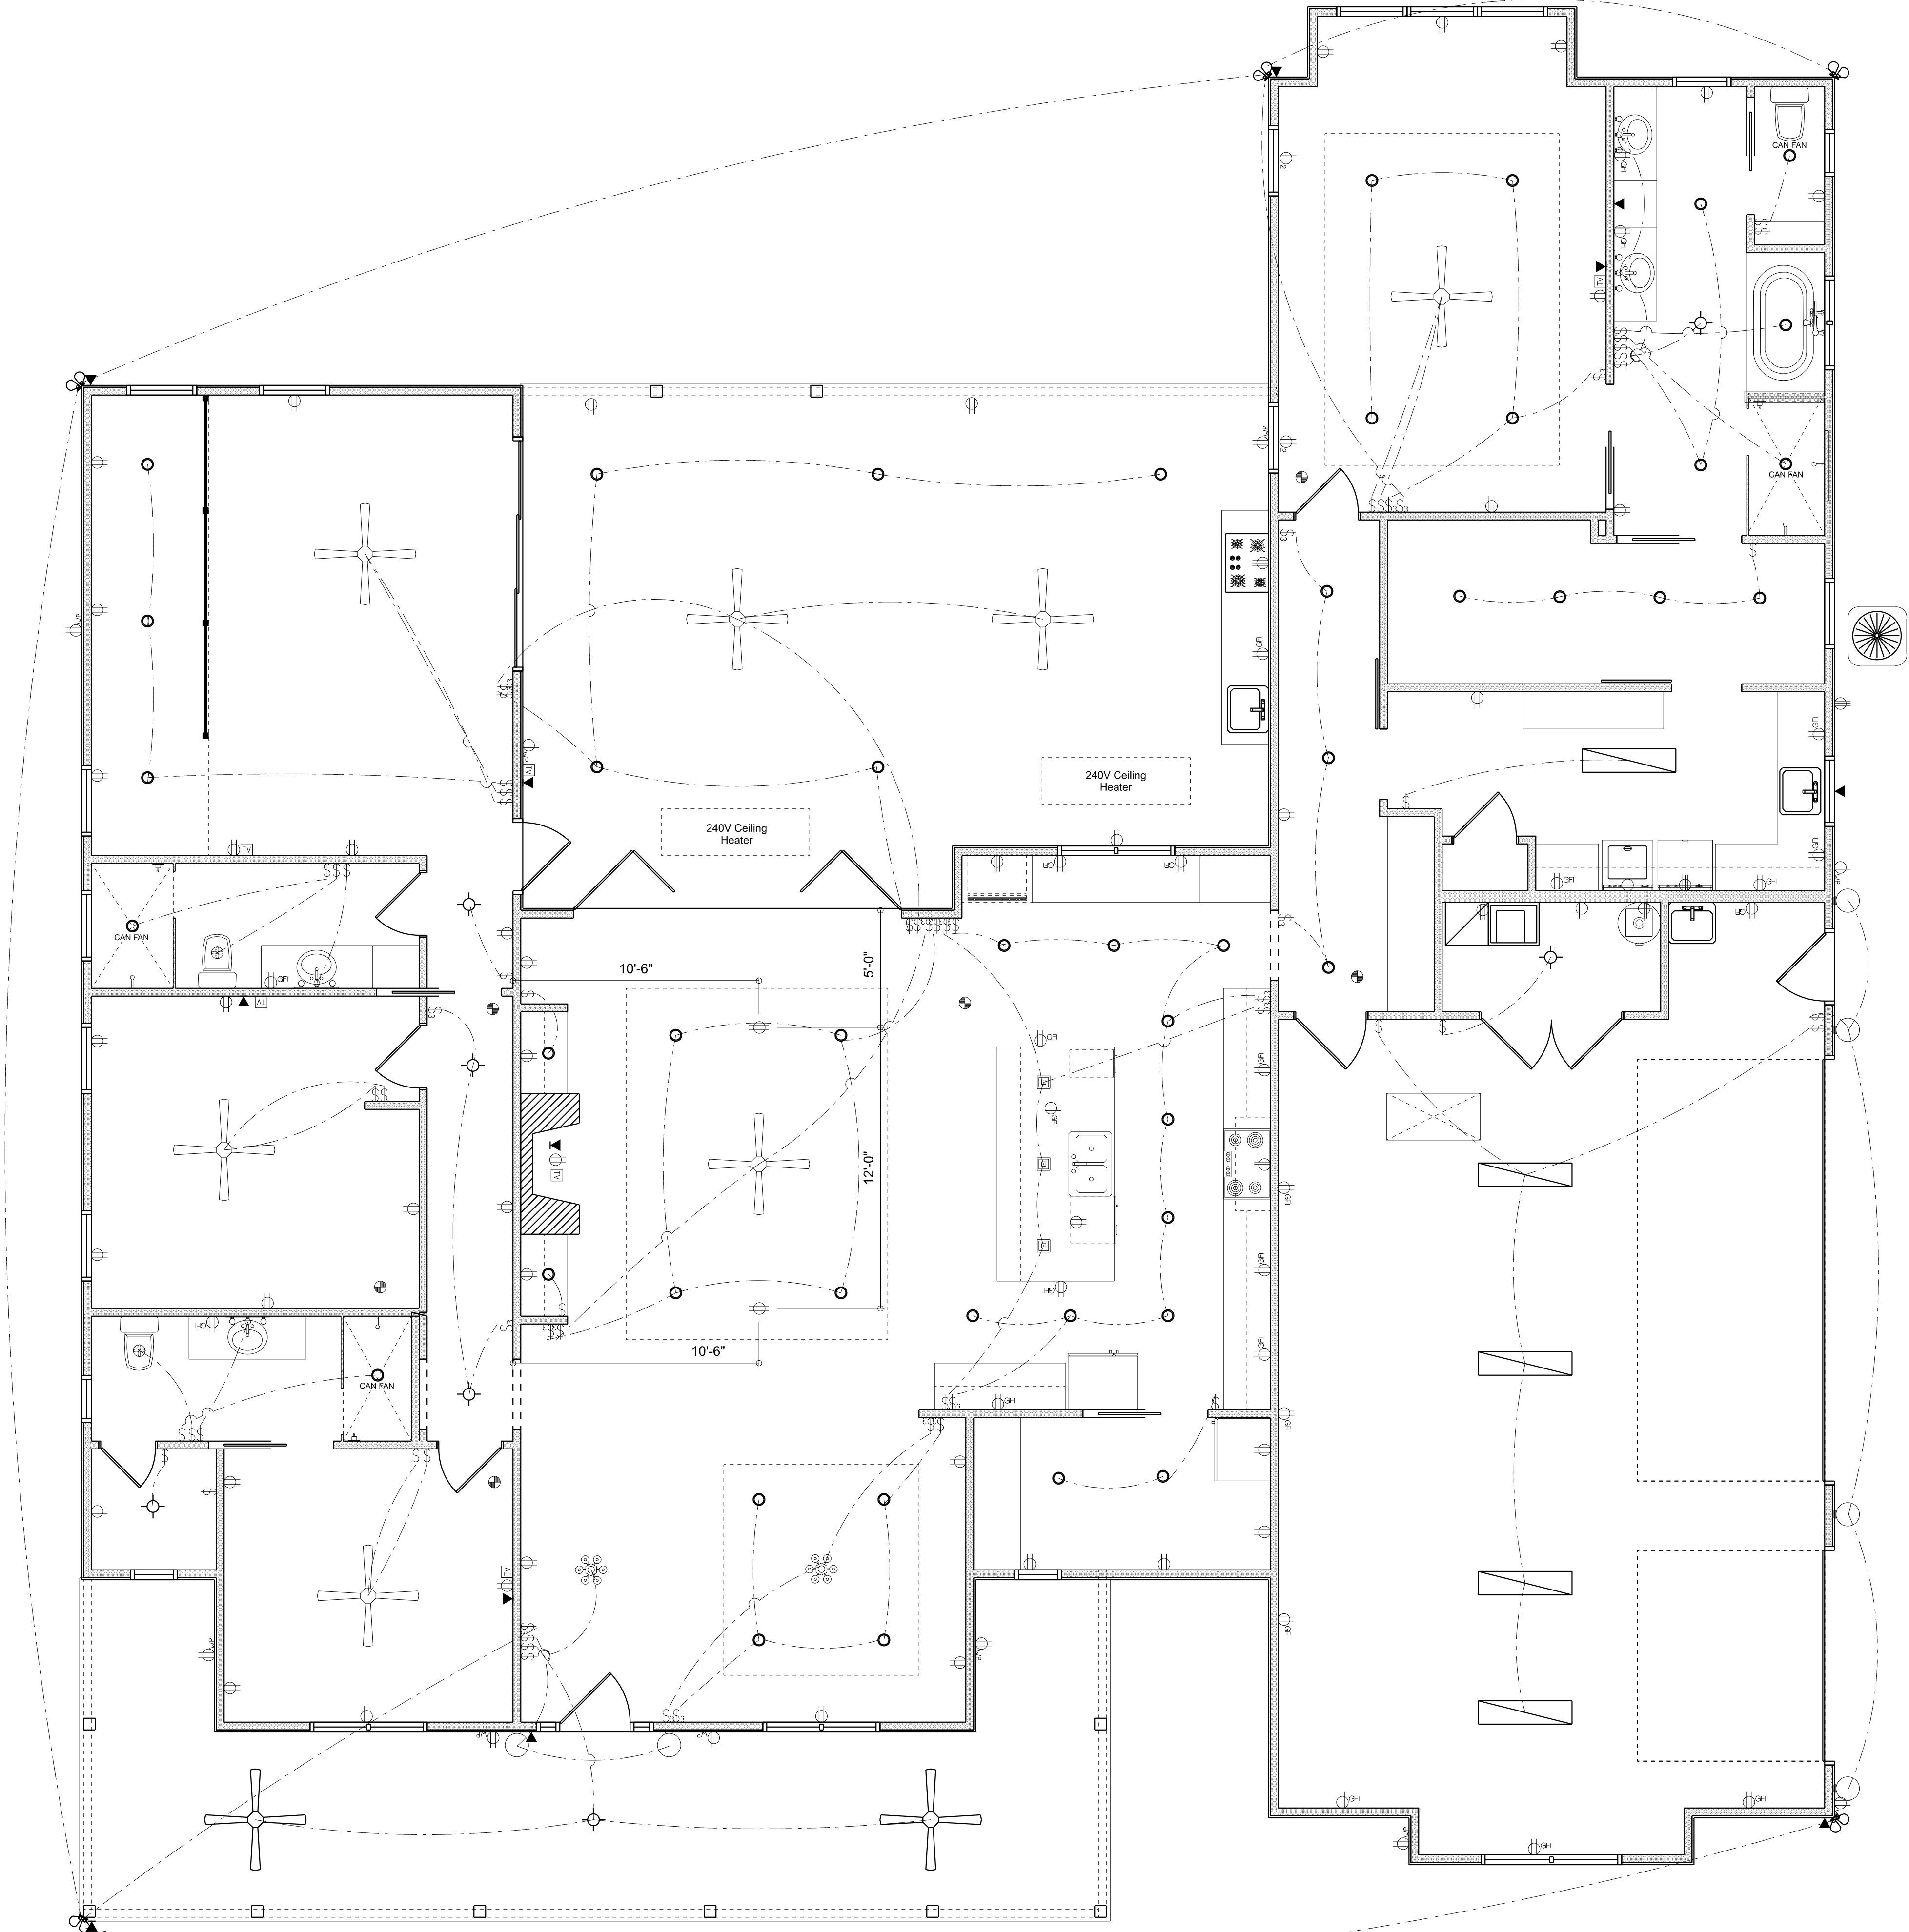

REVISIONS SCHEDULE			
Jan. 27th, 2022	PROPOSAL		
Mar. 22nd, 2020	REVISIONS		
May 23rd, 2022	PERMIT DRAWINGS		

NEW PROPOSAL FOR:
BOB LAVENDER & WENDI MURRY
LAKE CITY, FLORIDA 32055

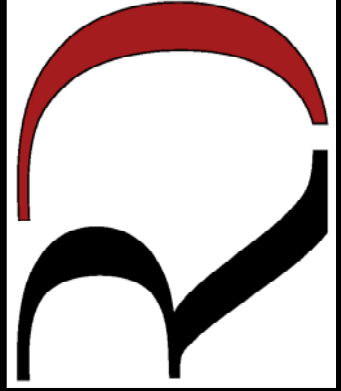**RIDGEPOINT
DESIGN**

566 NW ARINGTON BLVD, STE 101, LAKE CITY, FL 32025
P: 386-288-1188
E: RIDGEPOINTDESIGN@GMAIL.COM