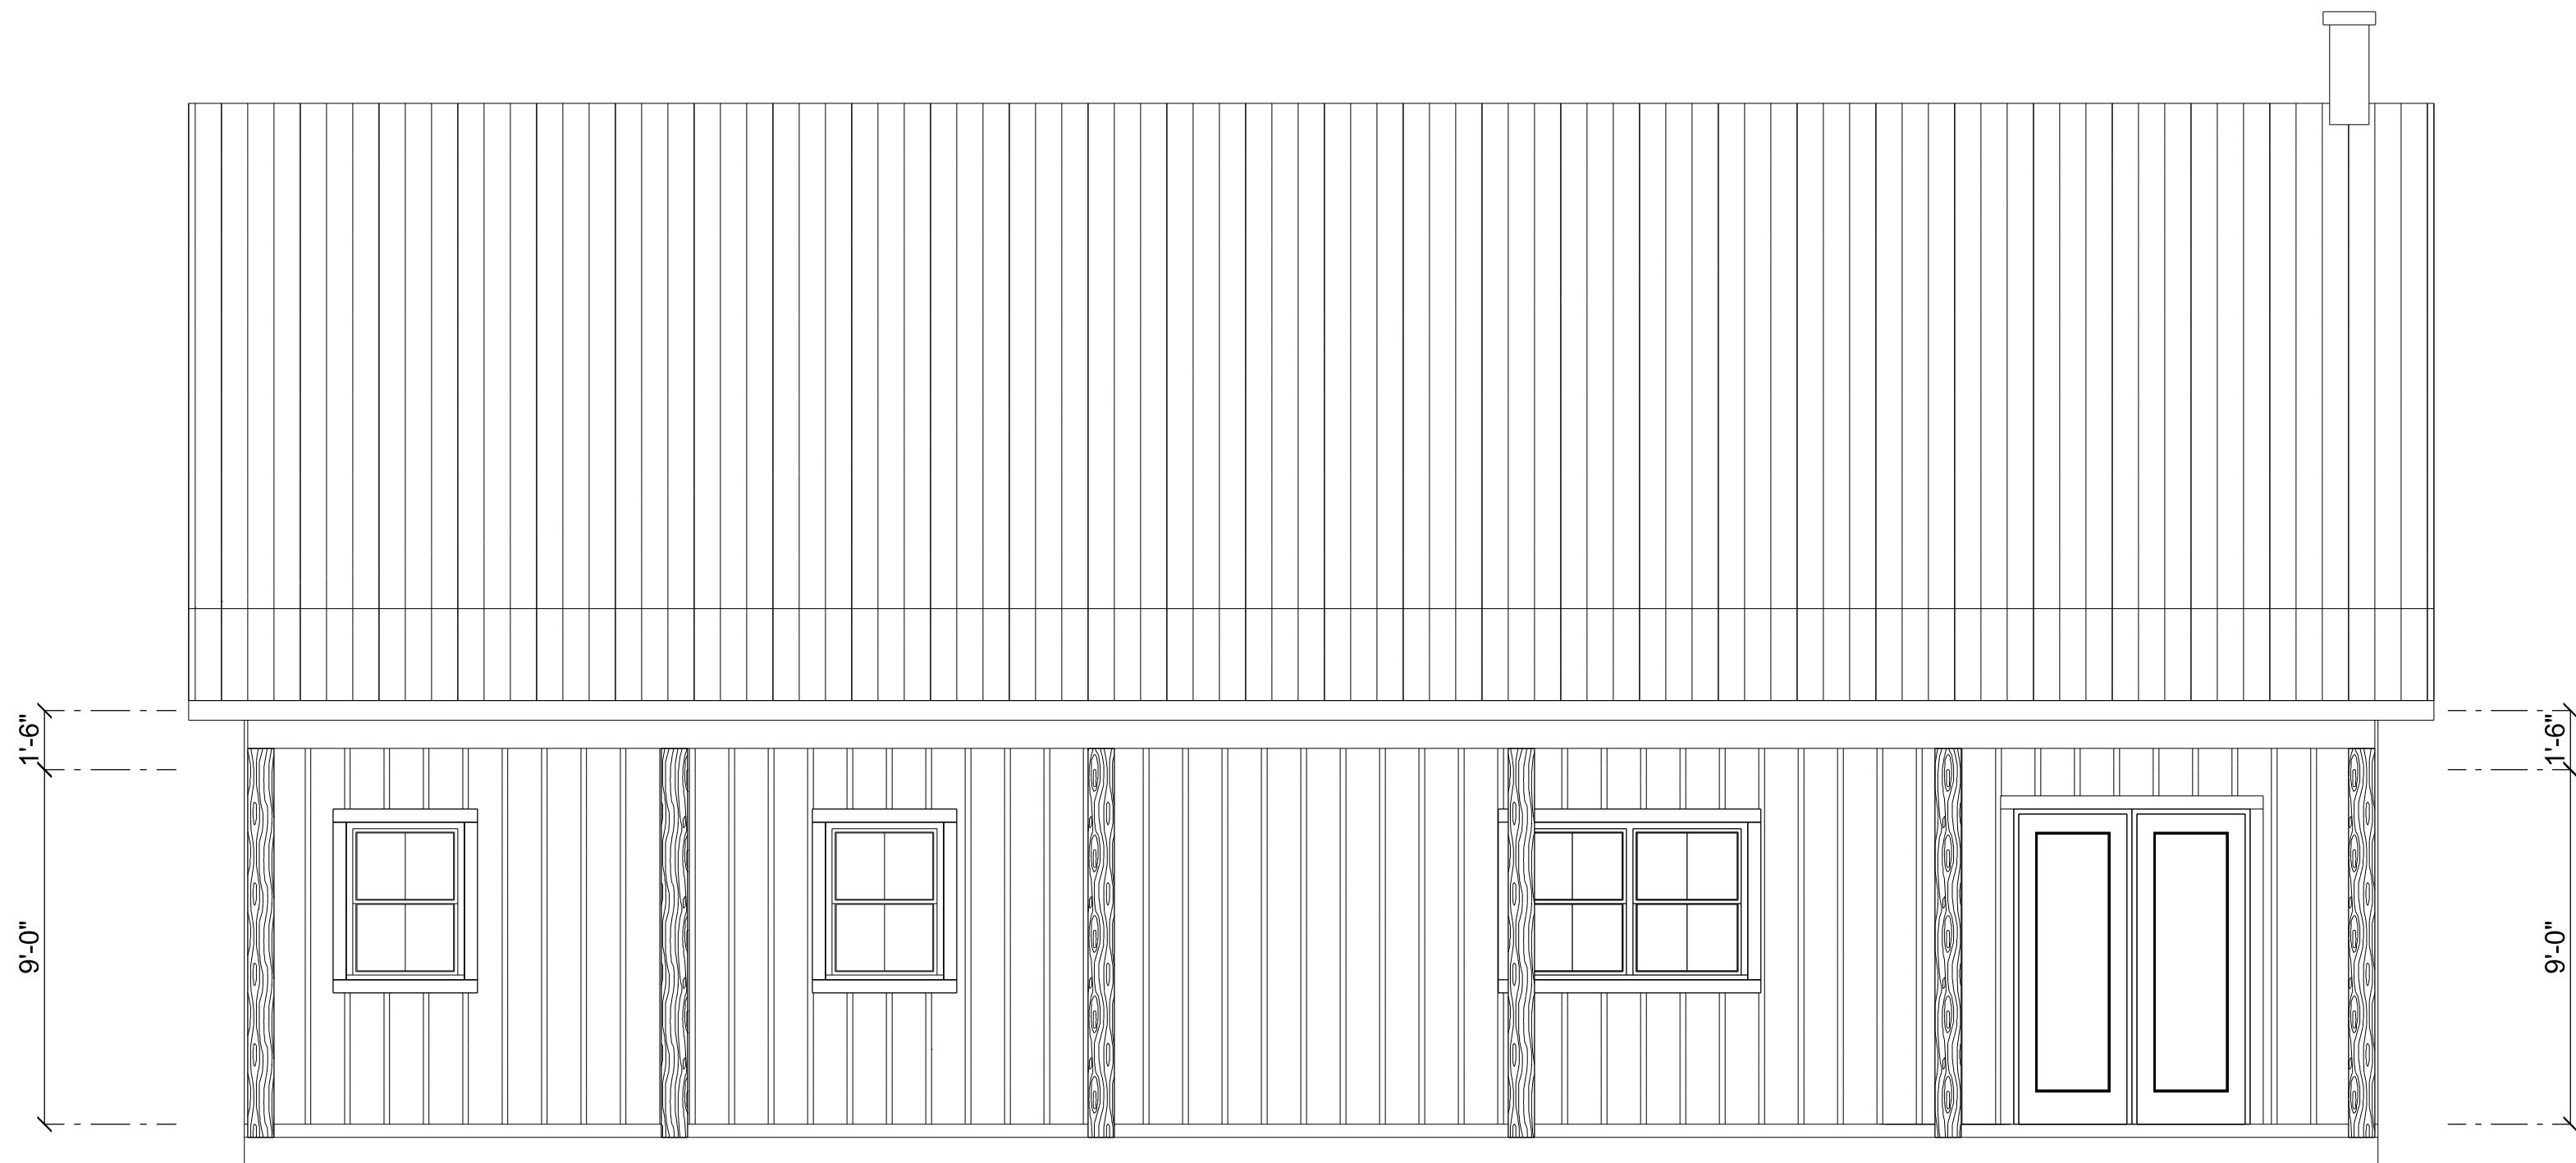




FRONT ELEVATION

SCALE: 1/4" = 1'-0"

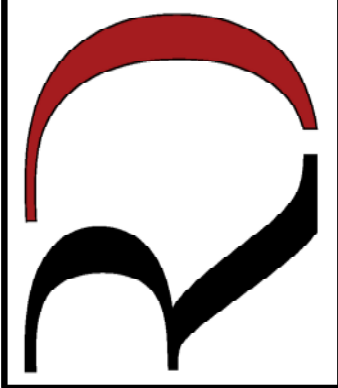


REAR ELEVATION

SCALE: 1/4" = 1'-0"

REVISIONS SCHEDULE			
PROPOSAL	REVISIONS	REVISIONS	REVISIONS
Mar. 17th, 2023	May 16th, 2023	Sep. 5th, 2023	

CUSTOM HOME FOR:
Wehinger Residence
COLUMBIA COUNTY, FLORIDA

**RIDGEPOINT
DESIGN**

566 SW ARLINGTON BLVD STE 101, LAKE CITY, FL 32025
P: 386-288-1188
E: RIDGEPOINTDESIGN@GMAIL.COM



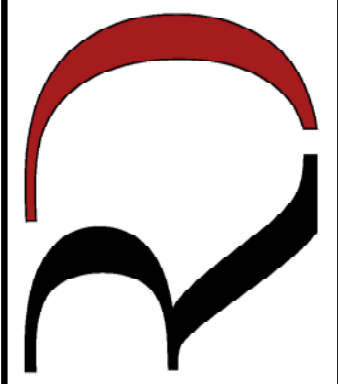
RIGHT ELEVATION
SCALE: 1/4" = 1'-0"



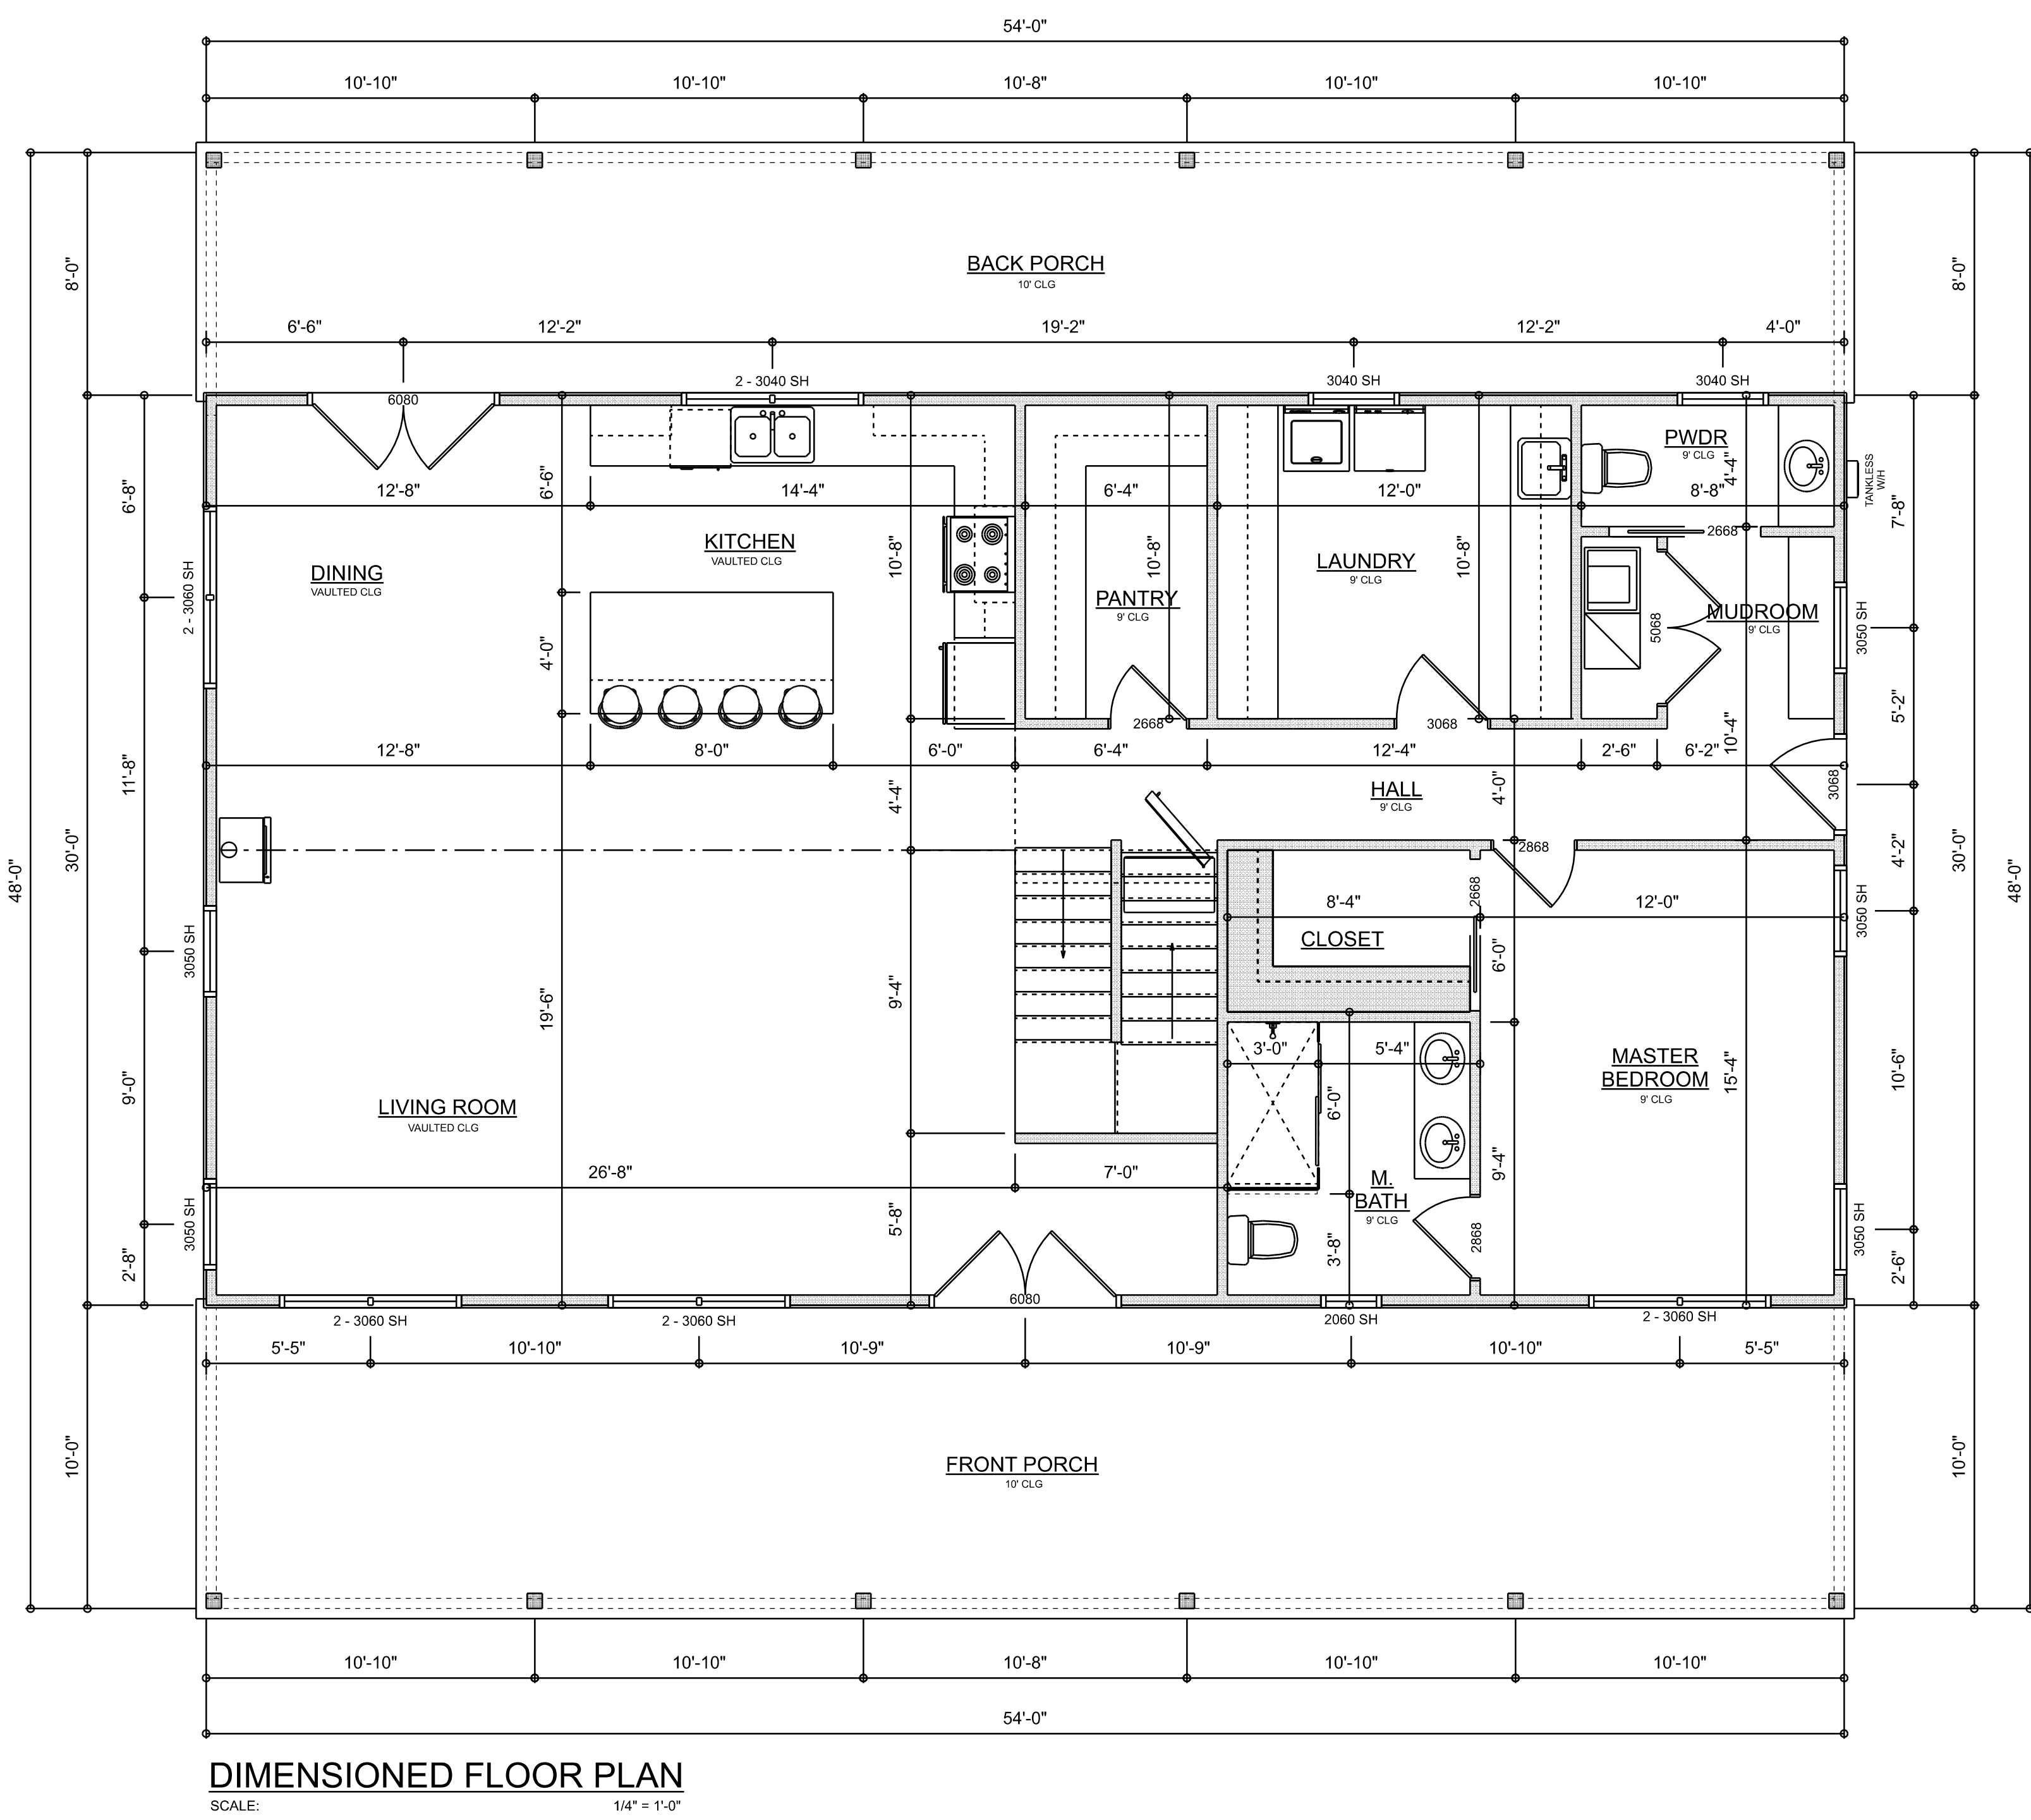
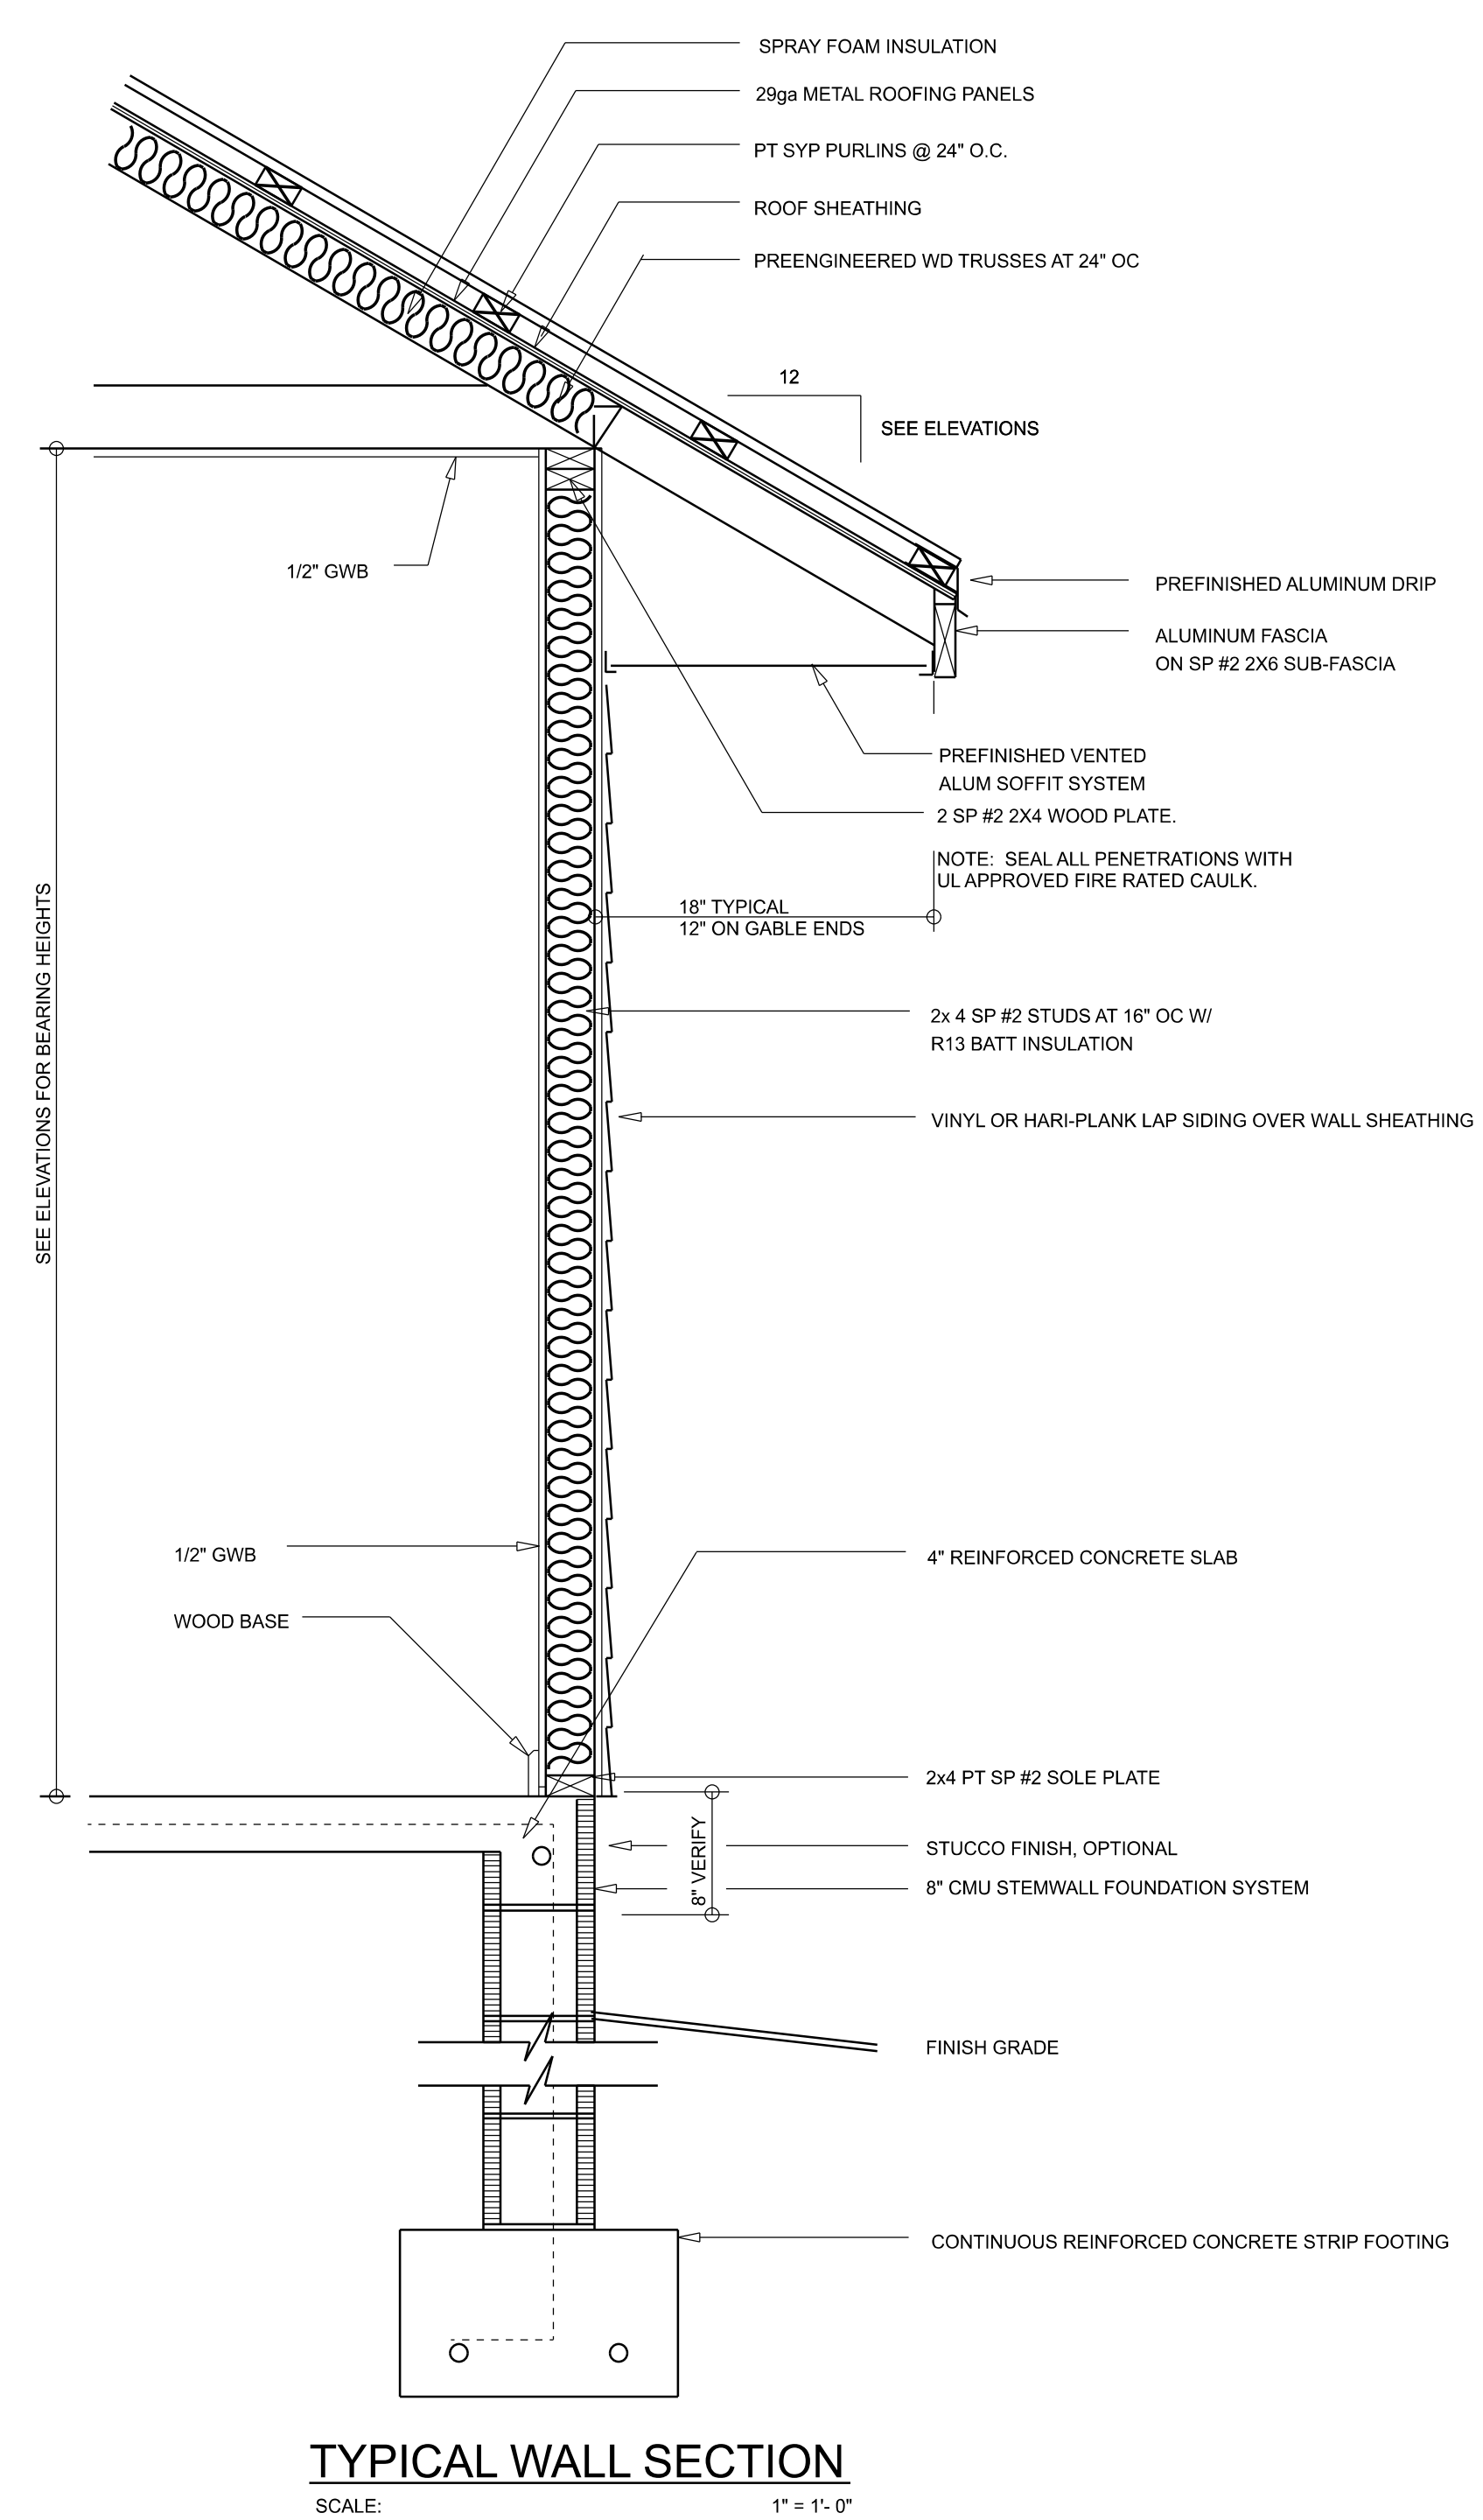
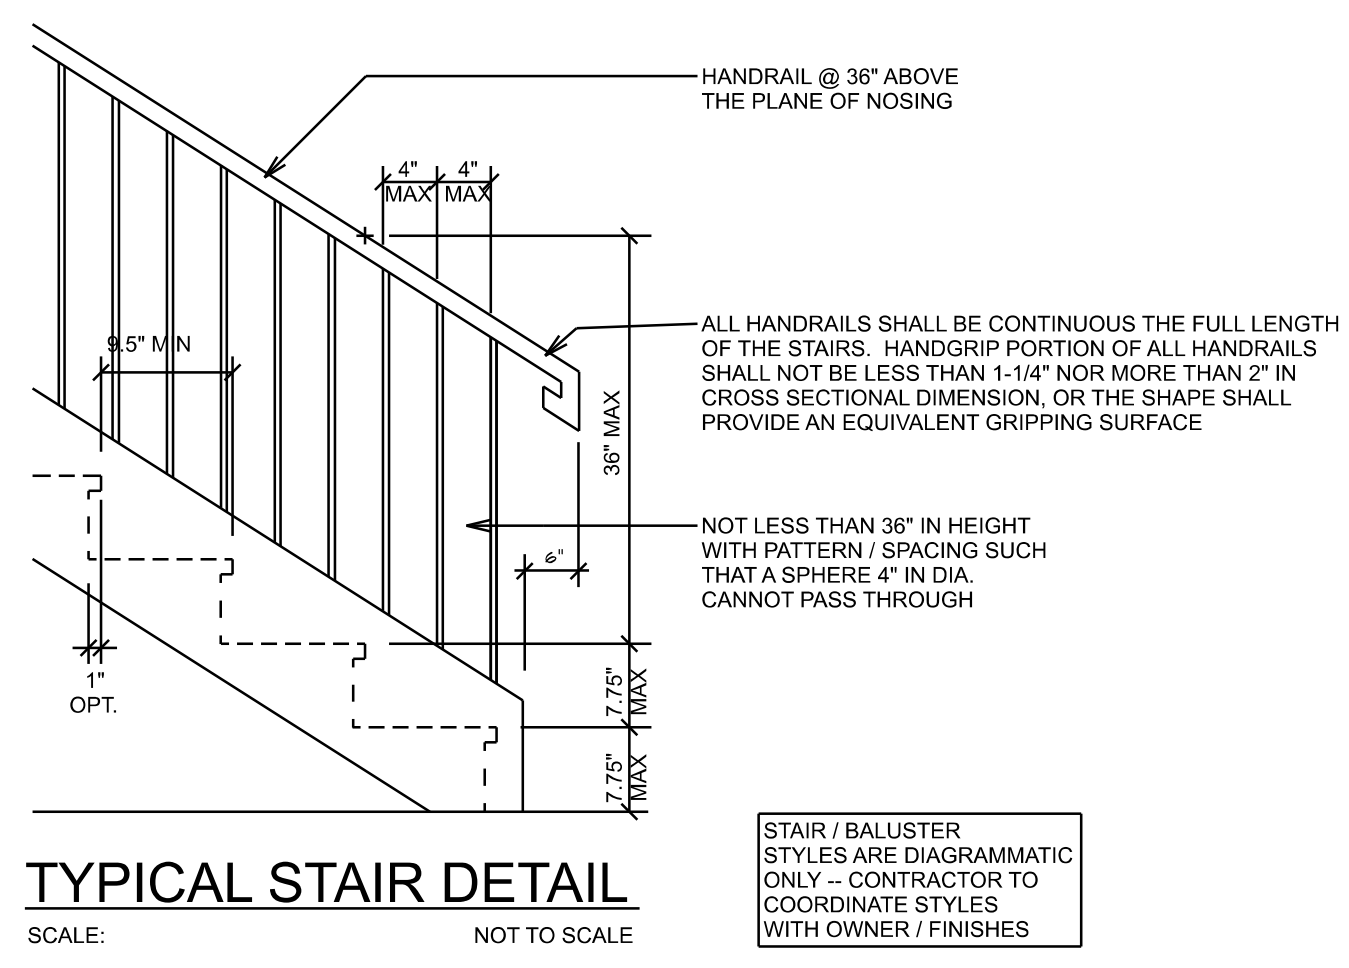
LEFT ELEVATION
SCALE: 1/4" = 1'-0"

REVISIONS SCHEDULE			
PROPOSAL		Mar. 17th, 2023	
REVISIONS		May 16th, 2023	
REVISIONS		Sep. 5th, 2023	

CUSTOM HOME FOR:
Wehinger Residence
COLUMBIA COUNTY, FLORIDA

**RIDGEPOINT
DESIGN**

566 SW ARLINGTON BLVD STE 101, LAKE CITY, FL 32025
P: 386-288-1188
E: RIDGEPOINTDESIGN@GMAIL.COM



AREA SUMMARY		
FIRST FLOOR LIVING	1,620	S.F.
SECOND FLOOR AREA	449	S.F.
TOTAL LIVING	2,069	S.F.
ENTRY PORCH	540	S.F.
REAR PORCH	432	S.F.
TOTAL AREA	3,041	S.F.

REVISIONS SCHEDULE			
PROPOSAL	Mar. 17th, 2023		
REVISIONS	May 16th, 2023		
REVISIONS	Sep. 5th, 2023		

CUSTOM HOME FOR:

Wehinger Residence

COLUMBIA COUNTY, FLORIDA

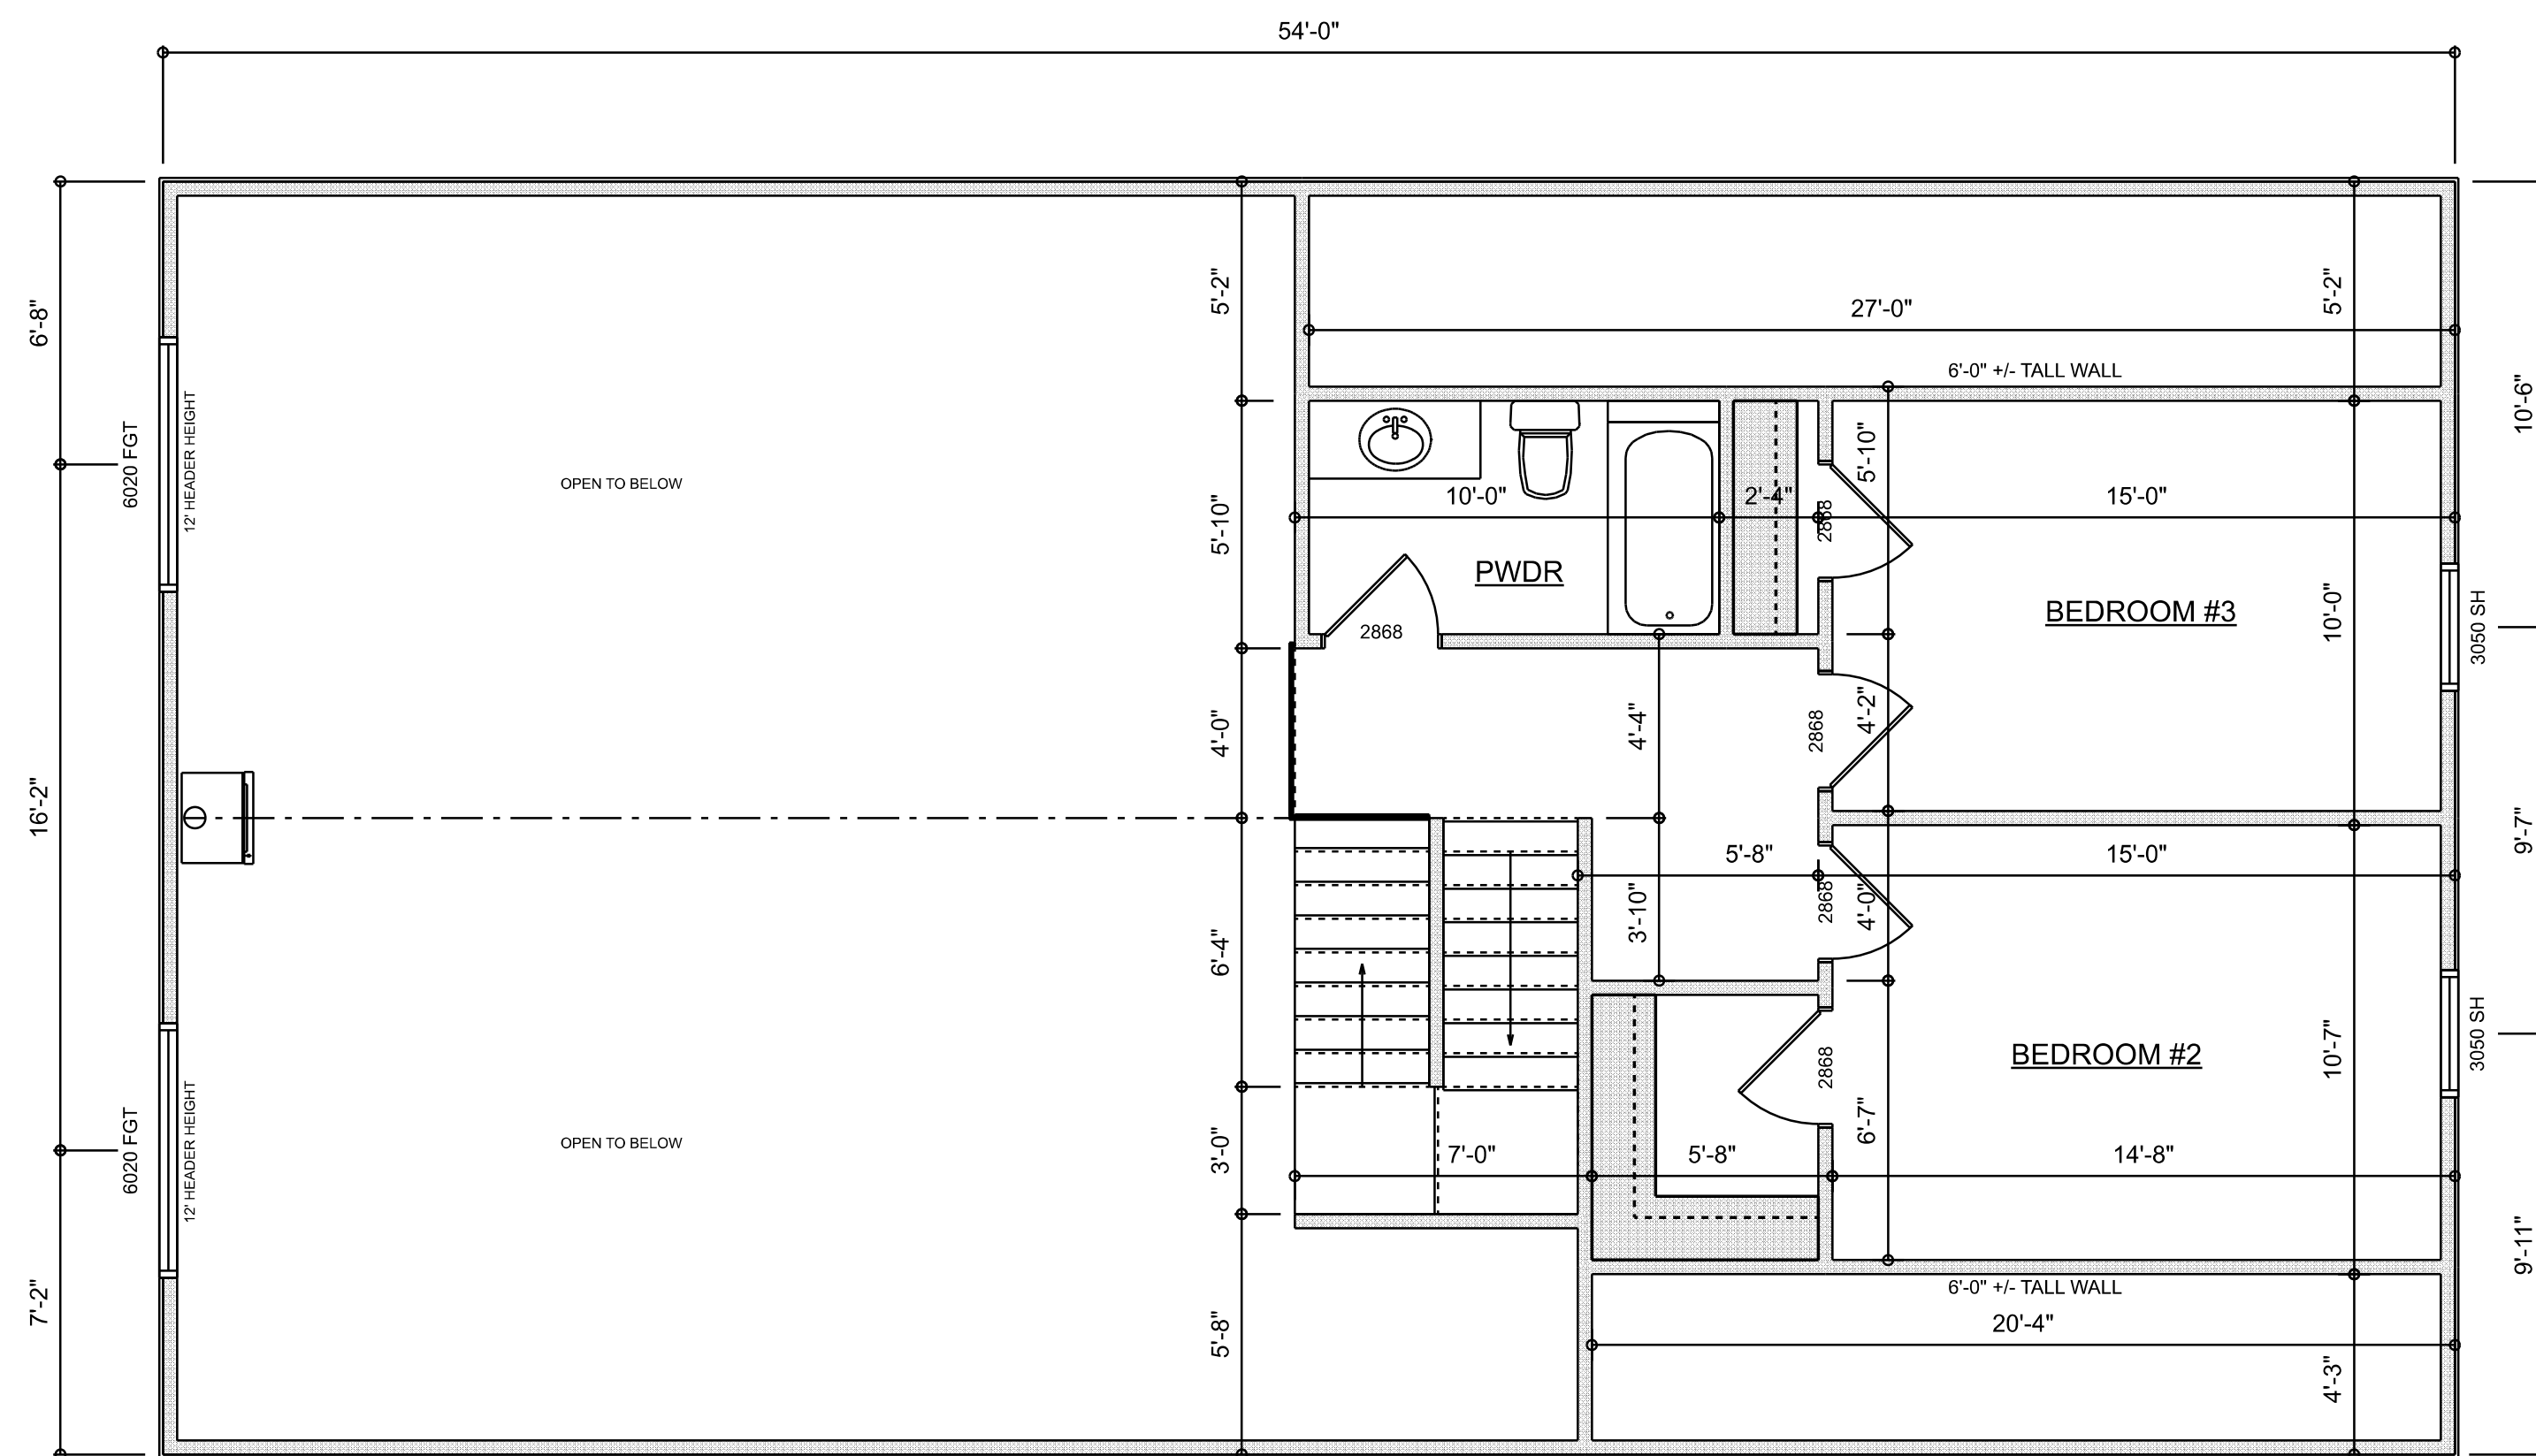
RIDGEPOINT DESIGN

566 SW ARLINGTON BLVD STE 101 LAKE CITY, FL 32025
P: 386-288-1188
E: RIDGEPOINTDESIGN@GMAIL.COM

SHEET NUMBER

A.3

OF 6 SHEETS



DIMENSIONED 2ND FLOOR PLAN
SCALE: 1/4" = 1'-0"

REVISIONS SCHEDULE	
PROPOSAL	Mar. 17th, 2023
REVISIONS	May 16th, 2023
REVISIONS	Sep. 5th, 2023

CUSTOM HOME FOR:
Wehinger Residence
COLUMBIA COUNTY, FLORIDA

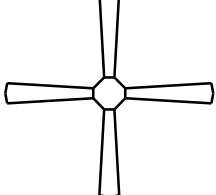


**RIDGEPOINT
DESIGN**

566 SW ARLINGTON BLVD, STE. 104, LAKE CITY, FL 32025
P: 386-288-1188
E: RIDGEPOINTDESIGN@GMAIL.COM

SHEET NUMBER
A.4
OF 6 SHEETS

A.4

ELECTRICAL LEGEND		
ELECTRICAL	COUNT	SYMBOL
CEILING FAN	2	
CAN LIGHT 6inch	22	
CHANDELIER	2	
PENDANT LIGHT	2	
EXTERIOR SCONCE	3	
MOTION SECURITY LIGHT	4	
ELECTRIC PANEL	1	
AC DISCONNECT	2	
EXHAUST FAN & LIGHT COMBO	2	
OUTLET	15	
OUTLET 220v	2	
OUTLET GFI	15	
OUTLET WP	5	
STANDARD LIGHT	6	
SWITCH	19	
SWITCH 3 WAY	8	
VANITY BAR LIGHT - SMALL	3	
CABLE TV OUTLET	2	
CARBON DETECTOR	1	
CAT6 OUTLET	2	
SMOKE DETECTOR	2	

ELECTRICAL PLAN NOTES:

INSTALLATION SHALL BE PER LATEST NAT'L ELECTRIC CODE.

WIRE ALL APPLIANCES, HVAC UNITS AND OTHER EQUIPMENT PER MANUF. SPECIFICATIONS

CONSULT WITH THE OWNER FOR THE NUMBER OF SEPERATE TELEPHONE LINES TO BE INSTALLED

ALL SMOKE DETECTORS SHALL BE 120v W/ BATTERY BACKUP OF THE PHOTOELECTRIC TYPE, AND SHALL BE INTERLOCKED TOGETHER. INSTALL INSIDE AND NEAR ALL BEDROOMS

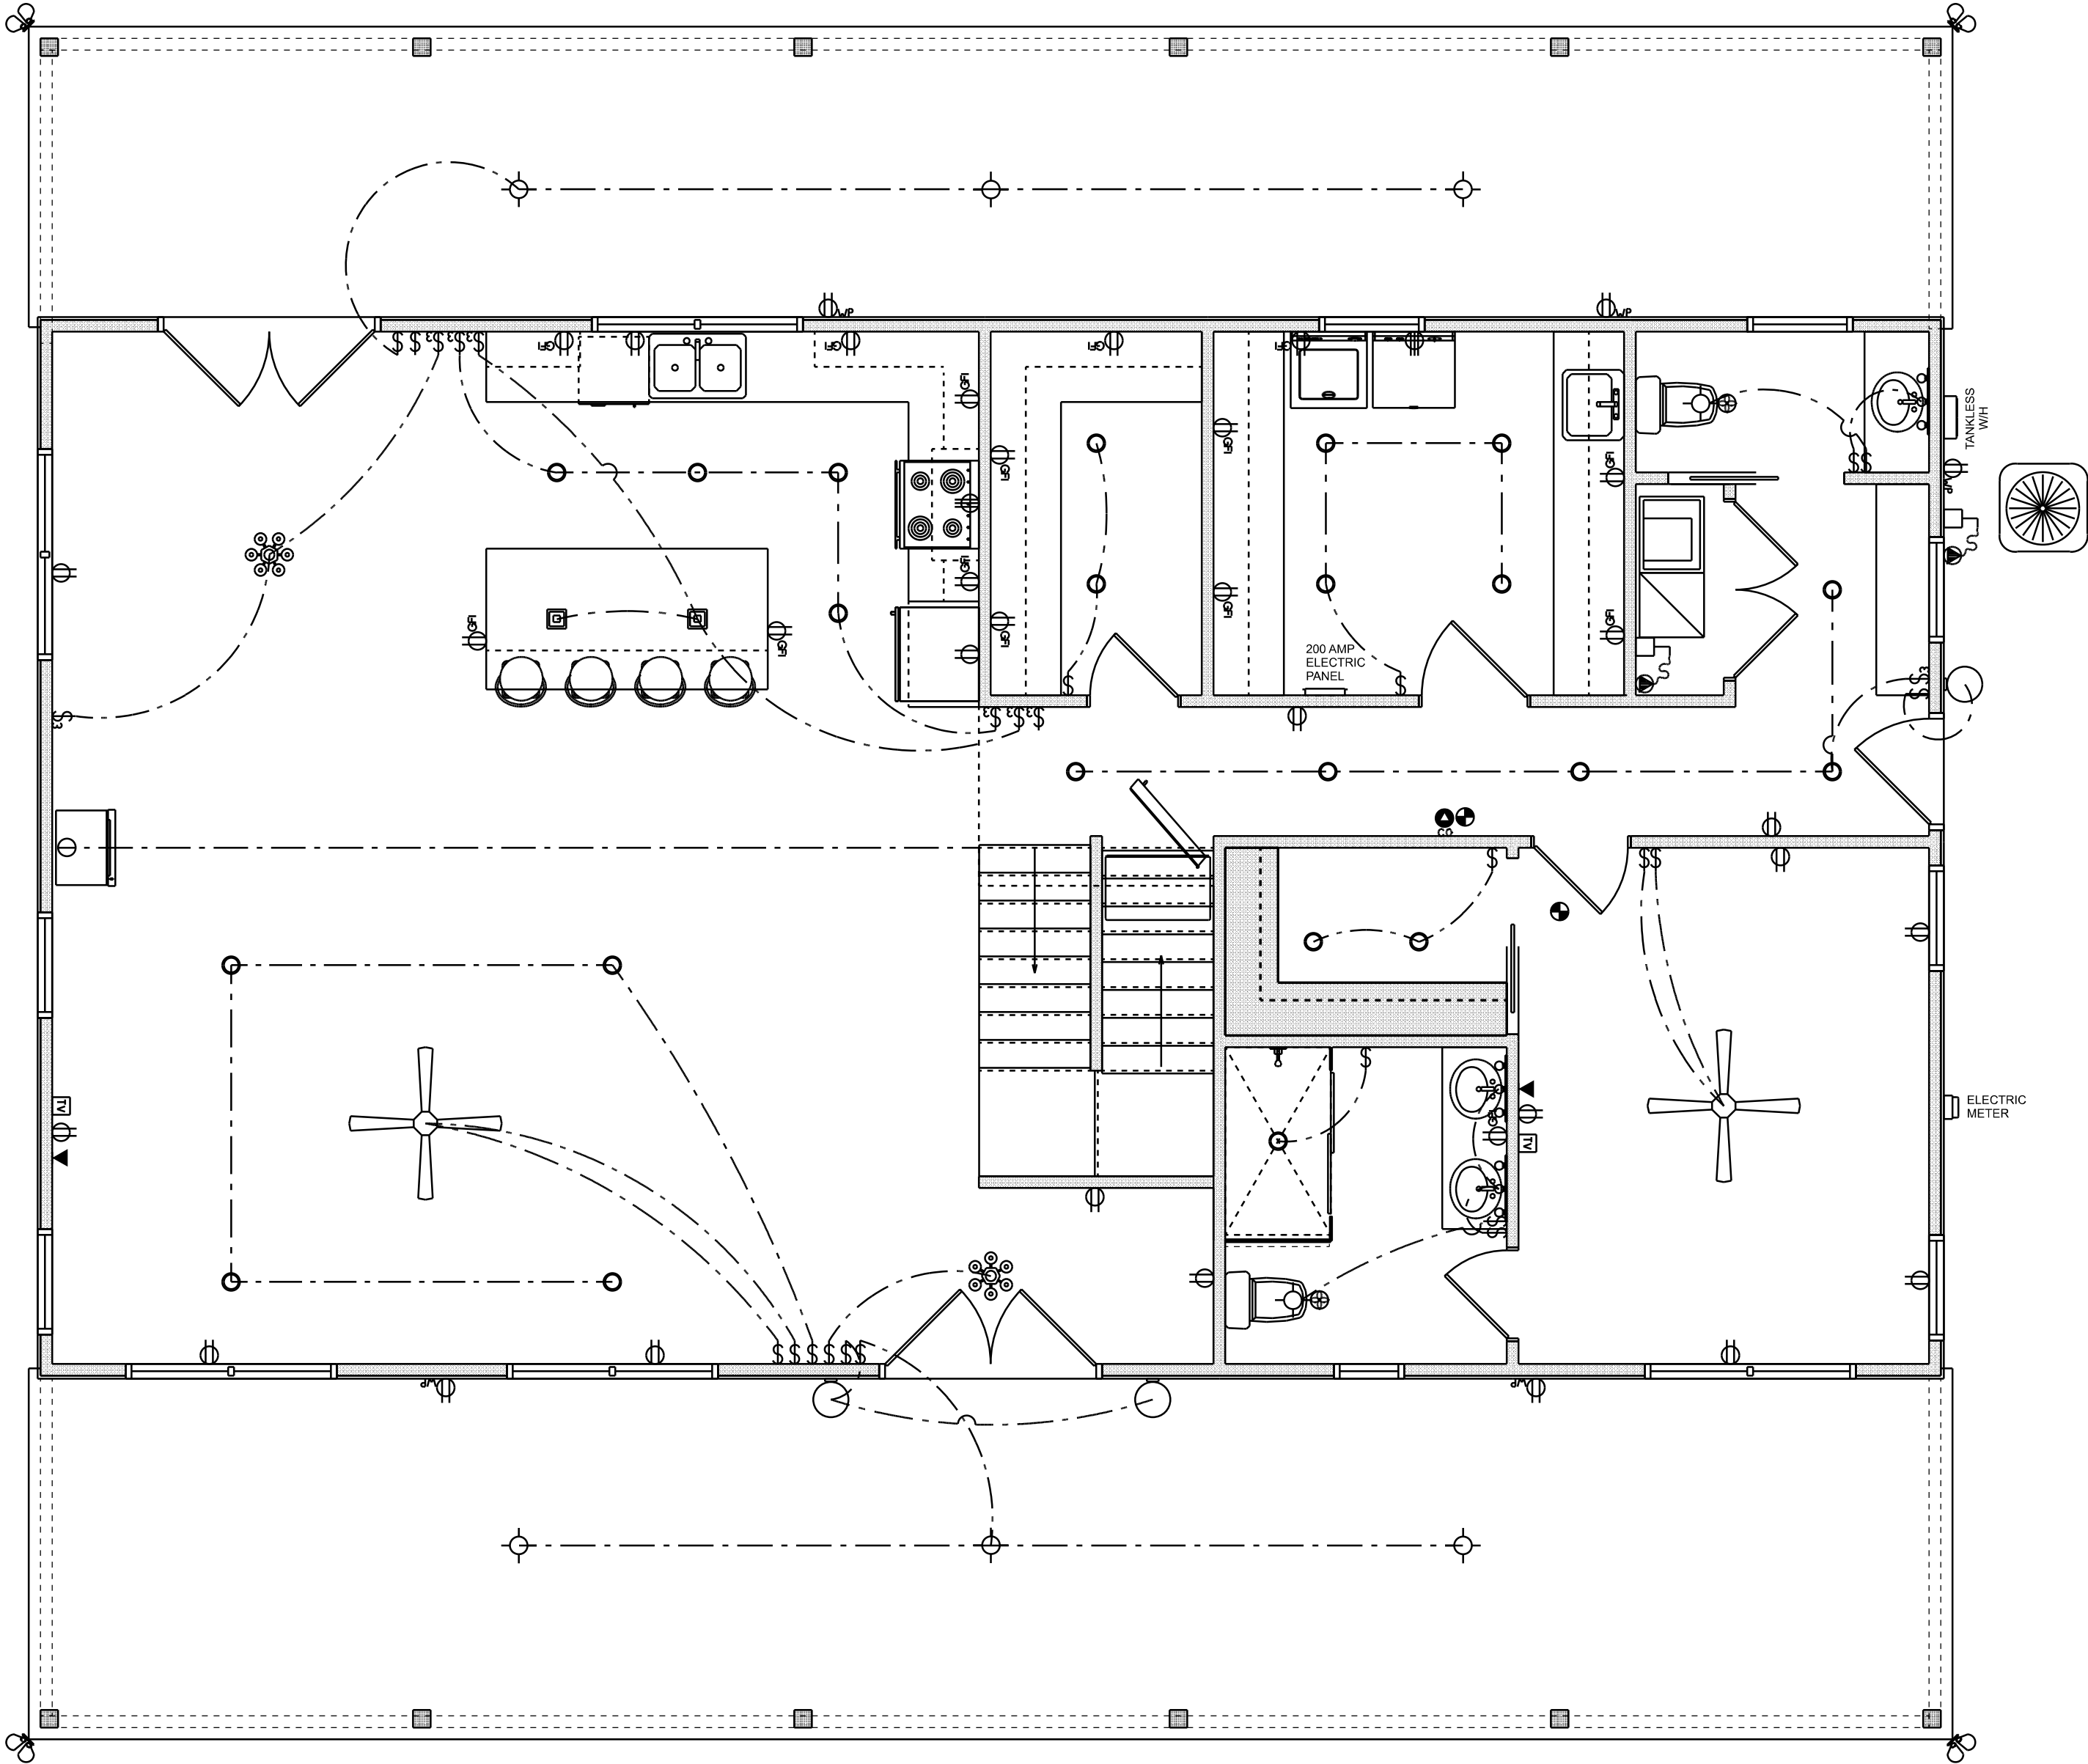
TELEPHONE, TELEVISION AND OTHER LOW VOLTAGE DEVICES OR OUTLETS SHALL BE AS PER THE OWNER'S DIRECTIONS, & IN ACCORDANCE W/ APPLICABLE SECTIONS OF NEC-LATEST EDITION.

ALL RECEPTICALS, NOT OTHERWISE NOTED, SHALL BE ARC FAULT INTERRUPTER TYPE, EXCEPT DEDICATED OUTLETS

ALL RECEPTICALS IN WET AREAS SHALL BE GROUND FAULT INTERRUPTER TYPE (GFI)

ALL EXTERIOR RECEPTICALS SHALL BE WEATHERPROOF GROUD FAULT INTERRUPTER TYPE (WP/GFI)

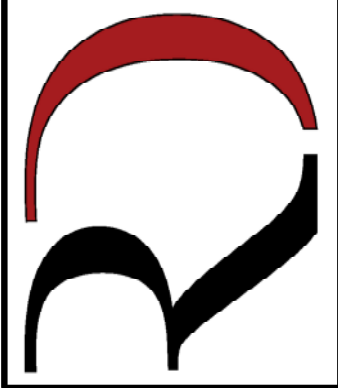
NOTE:
ELECTRICAL CONT'R SHALL PREPARE "AS-BUILT" SHOP DWGS INDICATING ALL ELECTRICAL WORK, INCLUDING ANY CHANGES TO THE ELEC. PLAN, ADD'NS TO THE ELEC. PLAN, RISER DIAGRAM, AS-BUILT PANEL SCHEDULE W/ALL CKTS IDENTIFIED W/ CKT Nr. DESCRIPTION & BRKR, SERVICE ENT. & ALL UNDERGROUND WIRE LOCATIONS/ROUTING / DEPTH, RISER DIA. SHALL INCLUDE WIRE SIZES/TYPE & EQUIPMENT TYPE W/ RATINGS & LOADS.
CONTRACTOR SHALL PROVIDE 1 COPY OF AS-BUILT DWGS TO OWNER & 1 COPY TO THE PERMIT ISSUING AUTHORITY



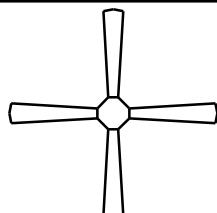
 
 
ELECTRICAL PLAN
SCALE: 1/4" = 1'-0"

REVISIONS SCHEDULE			
PROPOSAL		Mar. 17th, 2023	
REVISIONS		May 16th, 2023	
REVISIONS		Sep. 5th, 2023	

CUSTOM HOME FOR:
Wehinger Residence
COLUMBIA COUNTY, FLORIDA

**RIDGEPOINT
DESIGN**

566 SW ARLINGTON BLVD STE 101, LAKE CITY, FL 32025
P: 386-288-1188
E: RIDGEPOINTDESIGN@GMAIL.COM

ELECTRICAL LEGEND		
ELECTRICAL	COUNT	SYMBOL
CEILING FAN	2	
CAN LIGHT 6inch	4	
CABLE TV OUTLET	2	
CARBON DETECTOR	1	
CAT6 OUTLET	2	
EXHAUST FAN & LIGHT COMBO	1	
OUTLET	10	
OUTLET GFI	1	
SMOKE DETECTOR	3	
SWITCH	9	
VANITY BAR LIGHT - SMALL	1	

ELECTRICAL PLAN NOTES:

INSTALLATION SHALL BE PER LATEST NAT'L ELECTRIC CODE.

WIRE ALL APPLIANCES, HVAC UNITS AND OTHER EQUIPMENT PER MANUF. SPECIFICATIONS

CONSULT WITH THE OWNER FOR THE NUMBER OF SEPERATE TELEPHONE LINES TO BE INSTALLED

ALL SMOKE DETECTORS SHALL BE 120v W/ BATTERY BACKUP OF THE PHOTOELECTRIC TYPE, AND SHALL BE INTERLOCKED TOGETHER. INSTALL INSIDE AND NEAR ALL BEDROOMS

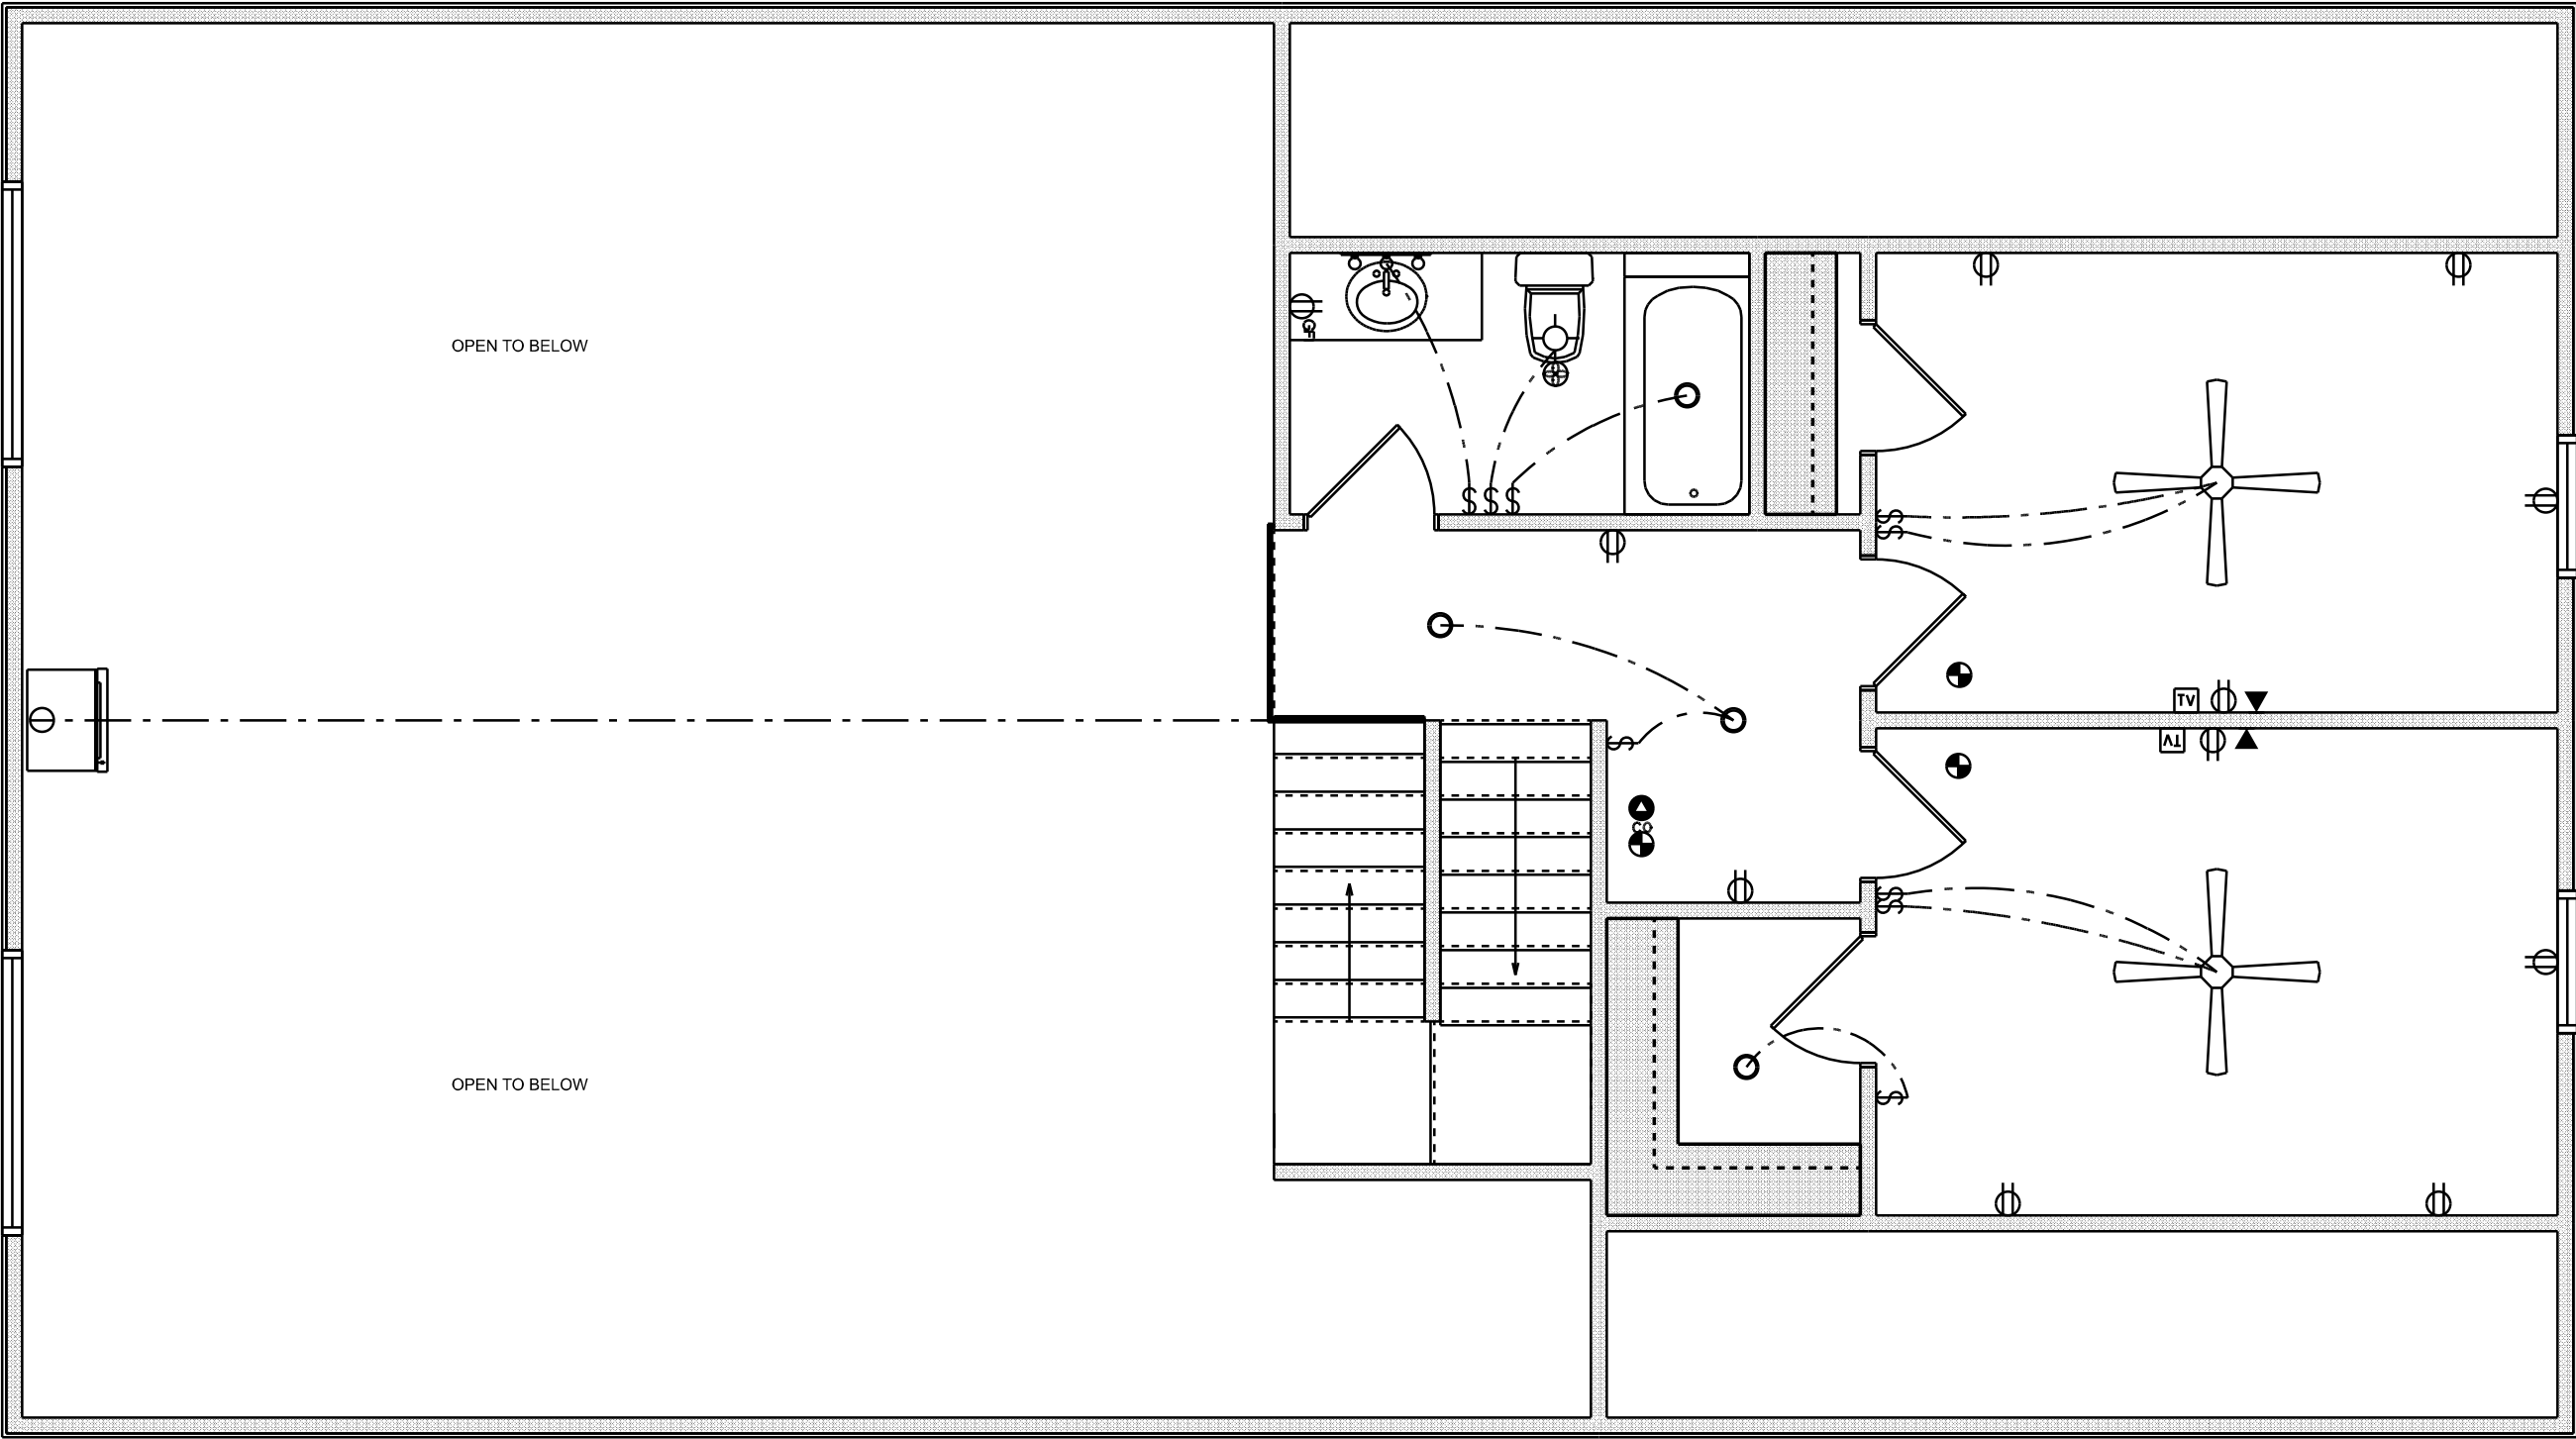
TELEPHONE, TELEVISION AND OTHER LOW VOLTAGE DEVICES OR OUTLETS SHALL BE AS PER THE OWNER'S DIRECTIONS, & IN ACCORDANCE W/ APPLICABLE SECTIONS OF NEC-LATEST EDITION.

ALL RECEPTICALS, NOT OTHERWISE NOTED, SHALL BE ARC FAULT INTERRUPTER TYPE, EXCEPT DEDICATED OUTLETS

ALL RECEPTICALS IN WET AREAS SHALL BE GROUND FAULT INTERRUPTER TYPE (GFI)

ALL EXTERIOR RECEPTICALS SHALL BE WEATHERPROOF GROUD FAULT INTERRUPTER TYPE (WP/GFI)

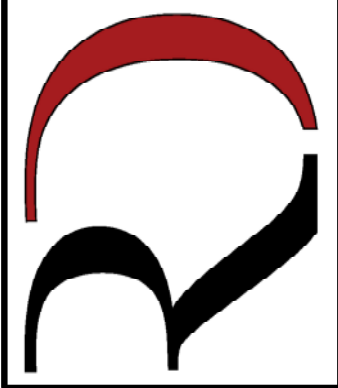
NOTE:
ELECTRICAL CONTR SHALL PREPARE "AS-BUILT" SHOP DWGS INDICATING ALL ELECTRICAL WORK, INCLUDING ANY CHANGES TO THE ELEC. PLAN, ADD'NS TO THE ELEC. PLAN, RISER DIAGRAM, AS-BUILT PANEL SCHEDULE W/ ALL CKTS IDENTIFIED W/ CKT N#: DESCRIPTION & BRKR, SERVICE ENT. & ALL UNDERGROUND WIRE LOCATIONS/ROUTING / DEPTH. RISER DIA. SHALL INCLUDE WIRE SIZES/TYPE & EQUIPMENT TYPE W/ RATINGS & LOADS.
CONTRACTOR SHALL PROVIDE 1 COPY OF AS-BUILT DWGS TO OWNER & 1 COPY TO THE PERMIT ISSUING AUTHORITY



2ND FLOOR ELECTRICAL
SCALE: 1/4" = 1'-0"

REVISIONS SCHEDULE			
PROPOSAL		Mar. 17th, 2023	
REVISIONS		May 16th, 2023	
REVISIONS		Sep. 5th, 2023	

CUSTOM HOME FOR:
Wehinger Residence
COLUMBIA COUNTY, FLORIDA

**RIDGEPOINT
DESIGN**

566 SW ARLINGTON BLVD STE 101, LAKE CITY, FL 32025
P: 386-288-1188
E: RIDGEPOINTDESIGN@GMAIL.COM