



ARCHITECTURAL
DESIGN

P.O. Box 273
Lake City, FL 32056
(386) 754-0181

CONSTRUCTION
DOCUMENTS BY:

ENGINEERED BY:

A CUSTOM HOME BY DON REED CONSTRUCTION:

BASS RESIDENCE

COPYRIGHT: 2006 DDS STUDIOS

EXTERIOR ELEVATIONS

SHEET NUMBER

1 of 4


All work shall comply with
the standard building code,
and all applicable local
codes and ordinances.

Contractor shall verify all
dimensions prior to
commencing construction.




FRONT ELEVATION

SCALE: 1/4" = 1'

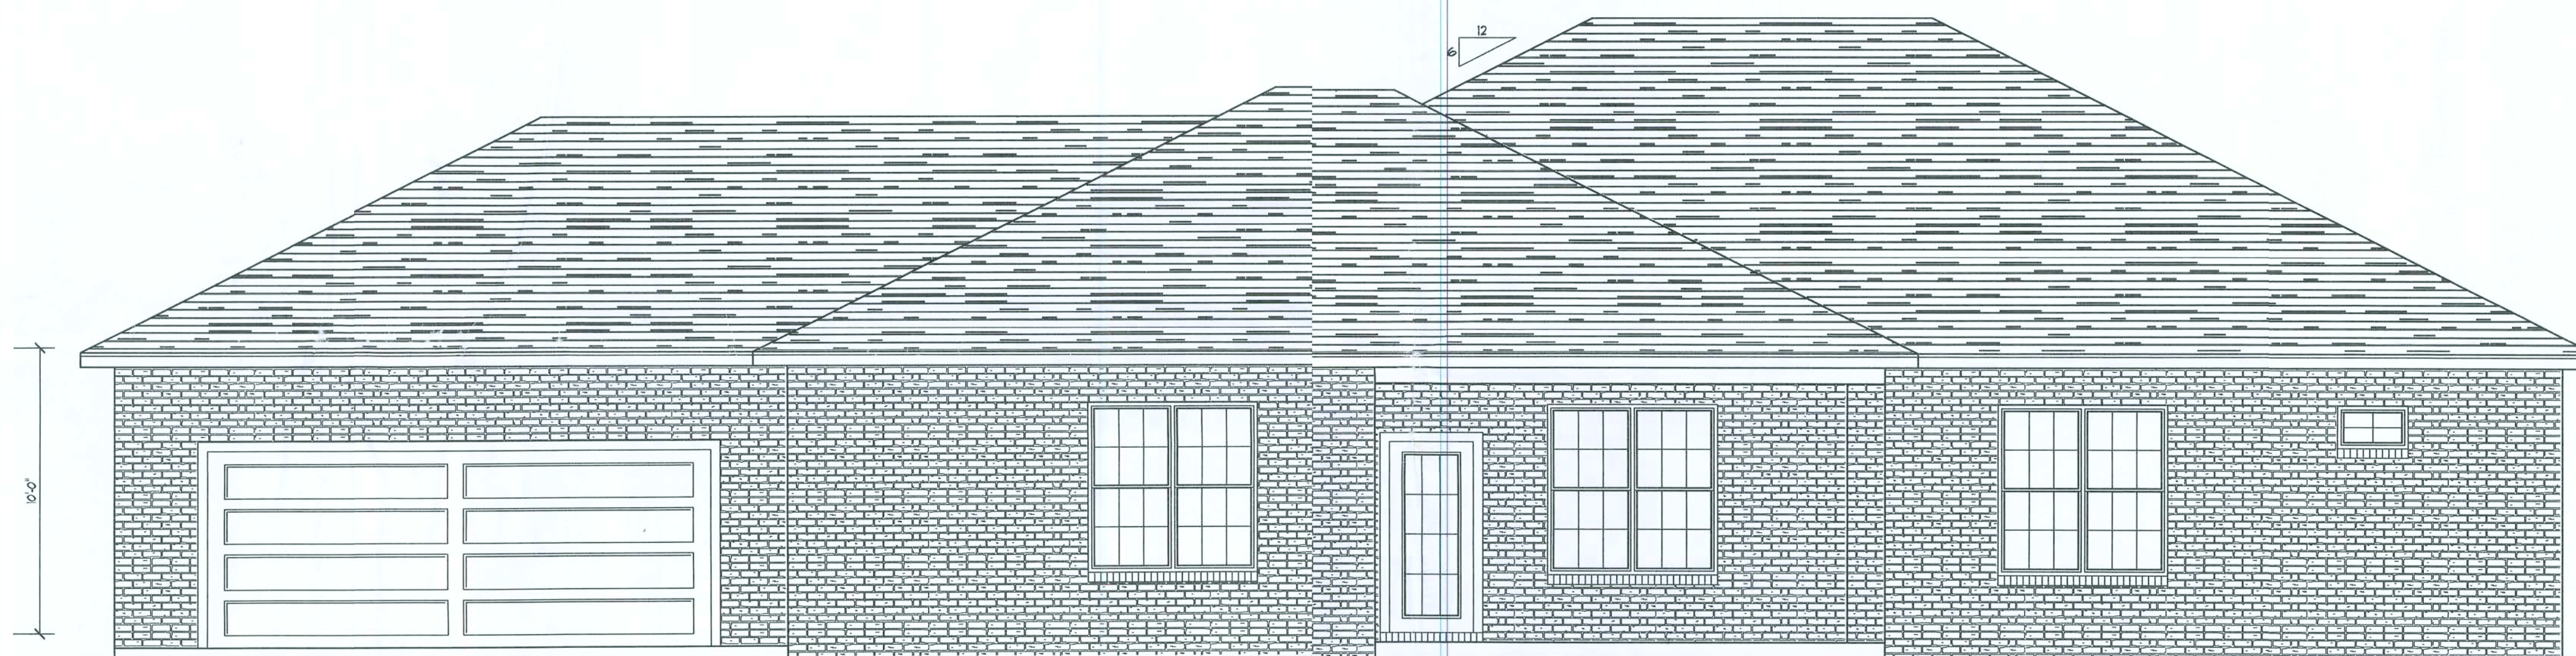

REAR ELEVATION

SCALE: 1/4" = 1'

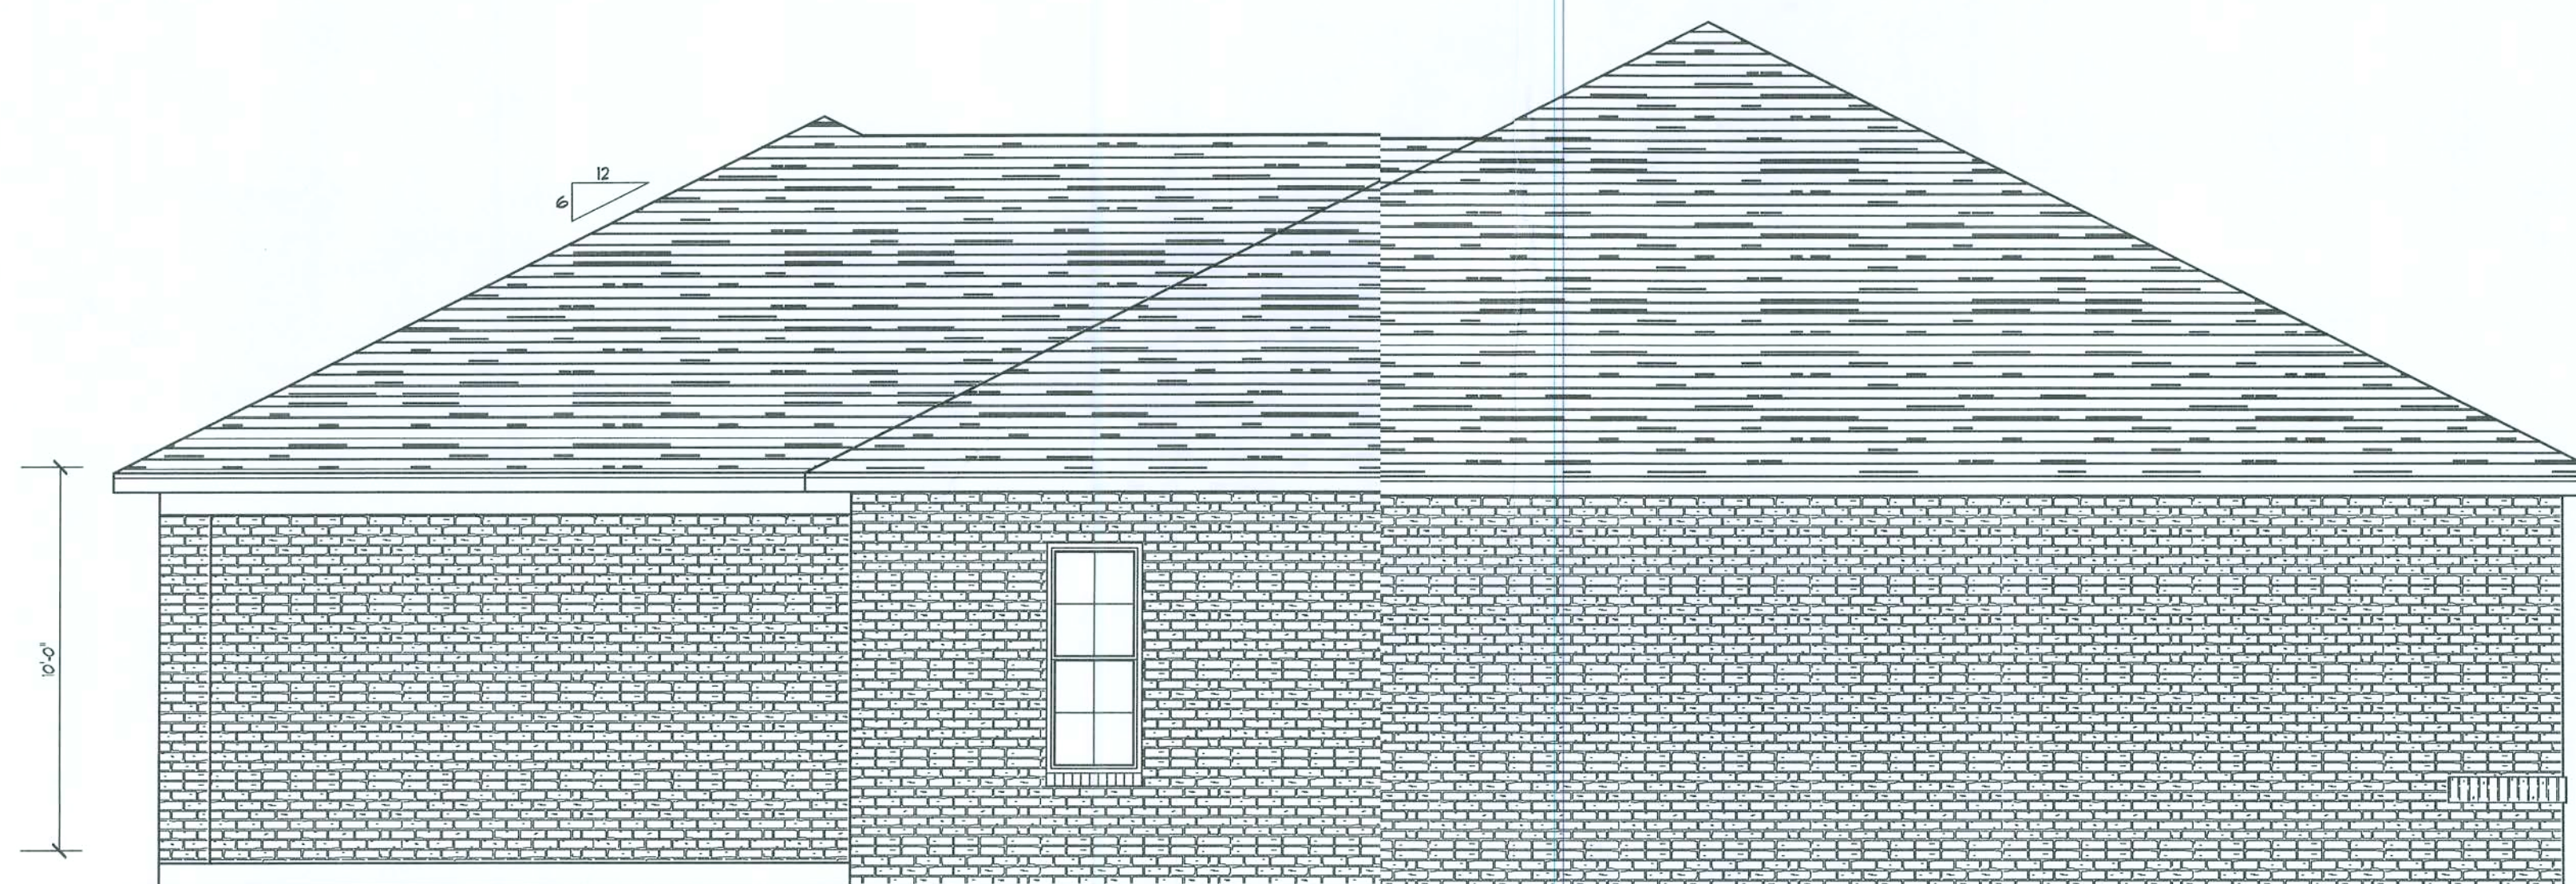

LEFT ELEVATION

SCALE: 1/4" = 1'

ALL DRAWINGS NOT TO BE SCALED. WRITTEN DIMENSIONS TAKE PRECEDENCE OVER SCALED DIMENSIONS

Daniel Shaheen
Daniel Shaheen

August 03, 2006



ARCHITECTURAL
DESIGN

P.O. Box 273
LAKE CITY FL 32356
(386) 754-0181

CONSTRUCTION
DOCUMENTS BY:

ENGINEERED BY:

A CUSTOM HOME BY DON REED CONSTRUCTION:


BASS RESIDENCE

COPYRIGHT: 2006 DDS STUDIOS

ELEVATIONS ROOF
TYPICAL WALL SECTION

SHEET NUMBER
2 of 4

All work shall comply with
the standard building codes,
and all applicable local
codes and ordinances.
Contractor shall verify all
dimensions prior to
commencing construction.

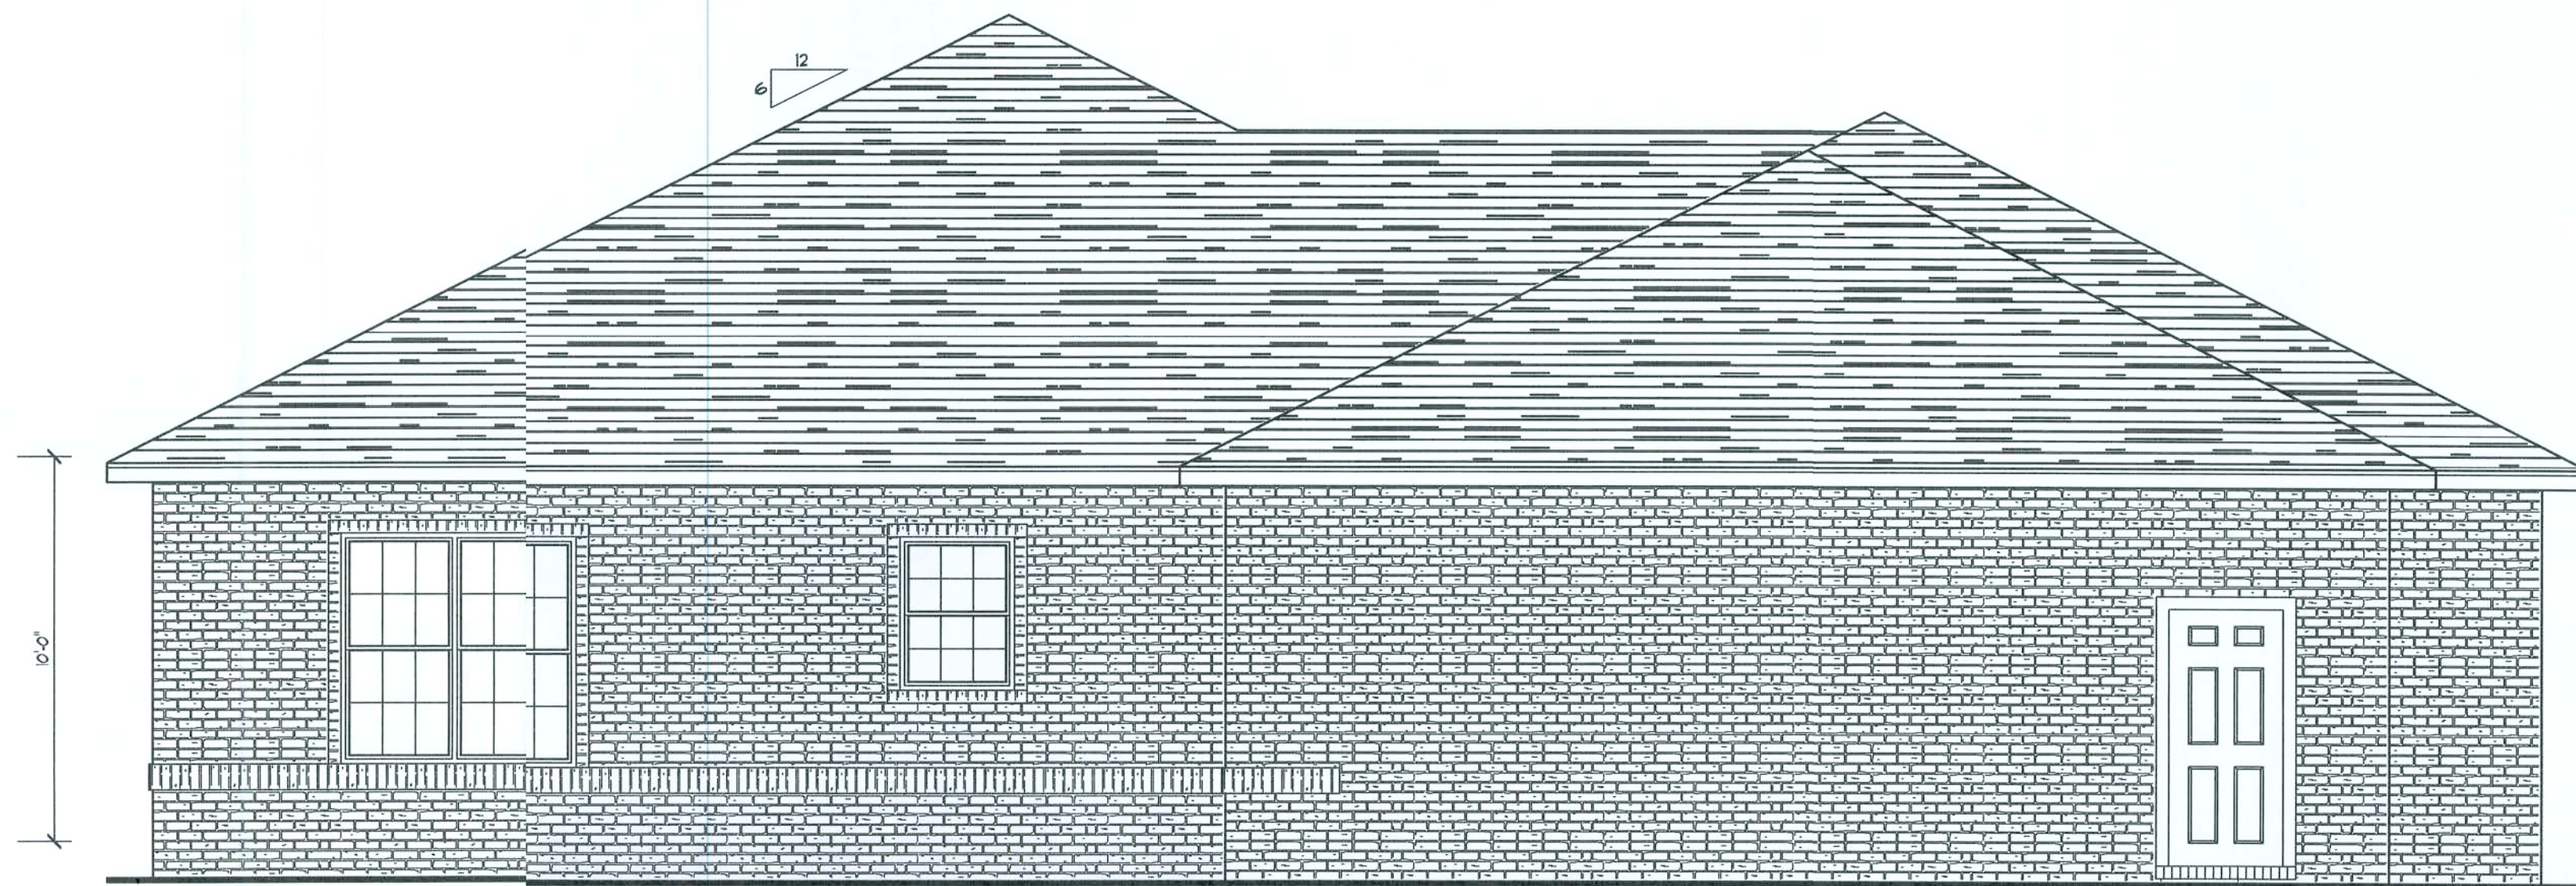


RIGHT ELEVATION

SCALE: 1/4" = 1'


ROOF PLAN NOTES

- R-1 ALL ROOF PITCH 6/12 UNLESS OTHERWISE NOTED
R-2 ALL OVERHANG 18" AND 12" AT GABLES
UNLESS OTHERWISE NOTED
R-3 PROVIDE ATTIC VENTILATION IN AC-
CORDANCE WITH CODE REQUIREMENTS
R-4 SEE EXTERIOR ELEVATIONS AND FLOOR
PLANS TO VERIFY PLATE AND HEEL HEIGHTS
R-5 MOVE ALL VENTS AND OTHER
ROOF PENETRATIONS TO REAR

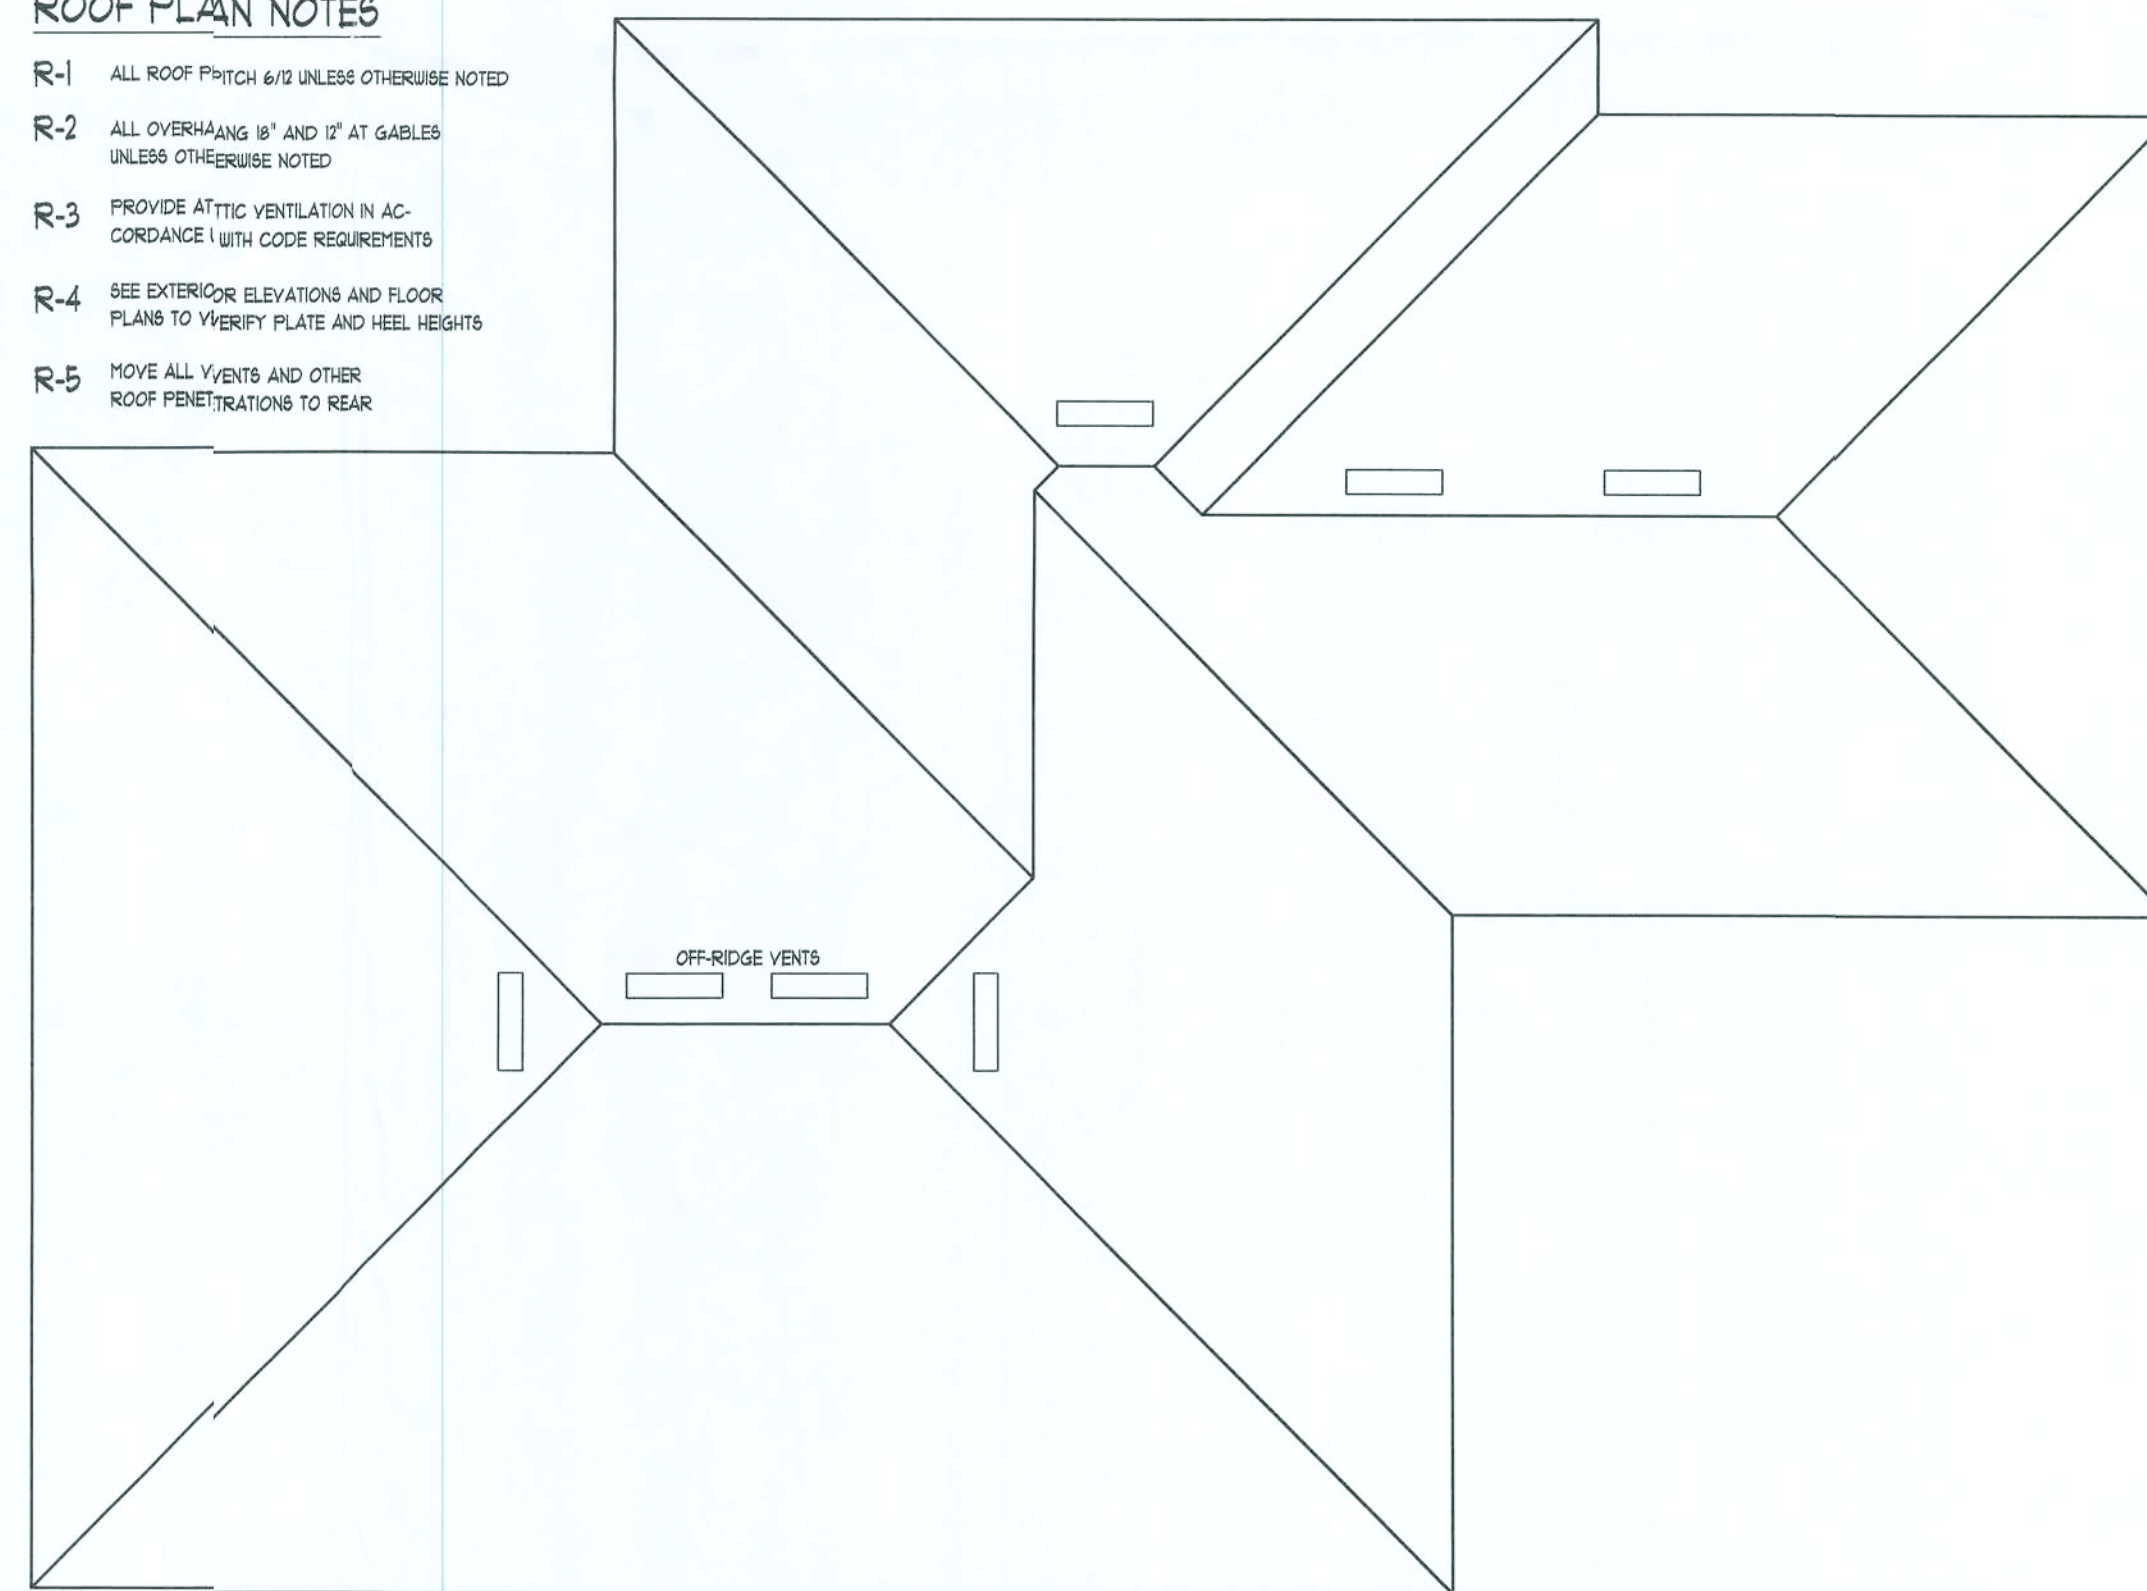

ROOF PLAN

SCALE: 1/8" = 1'

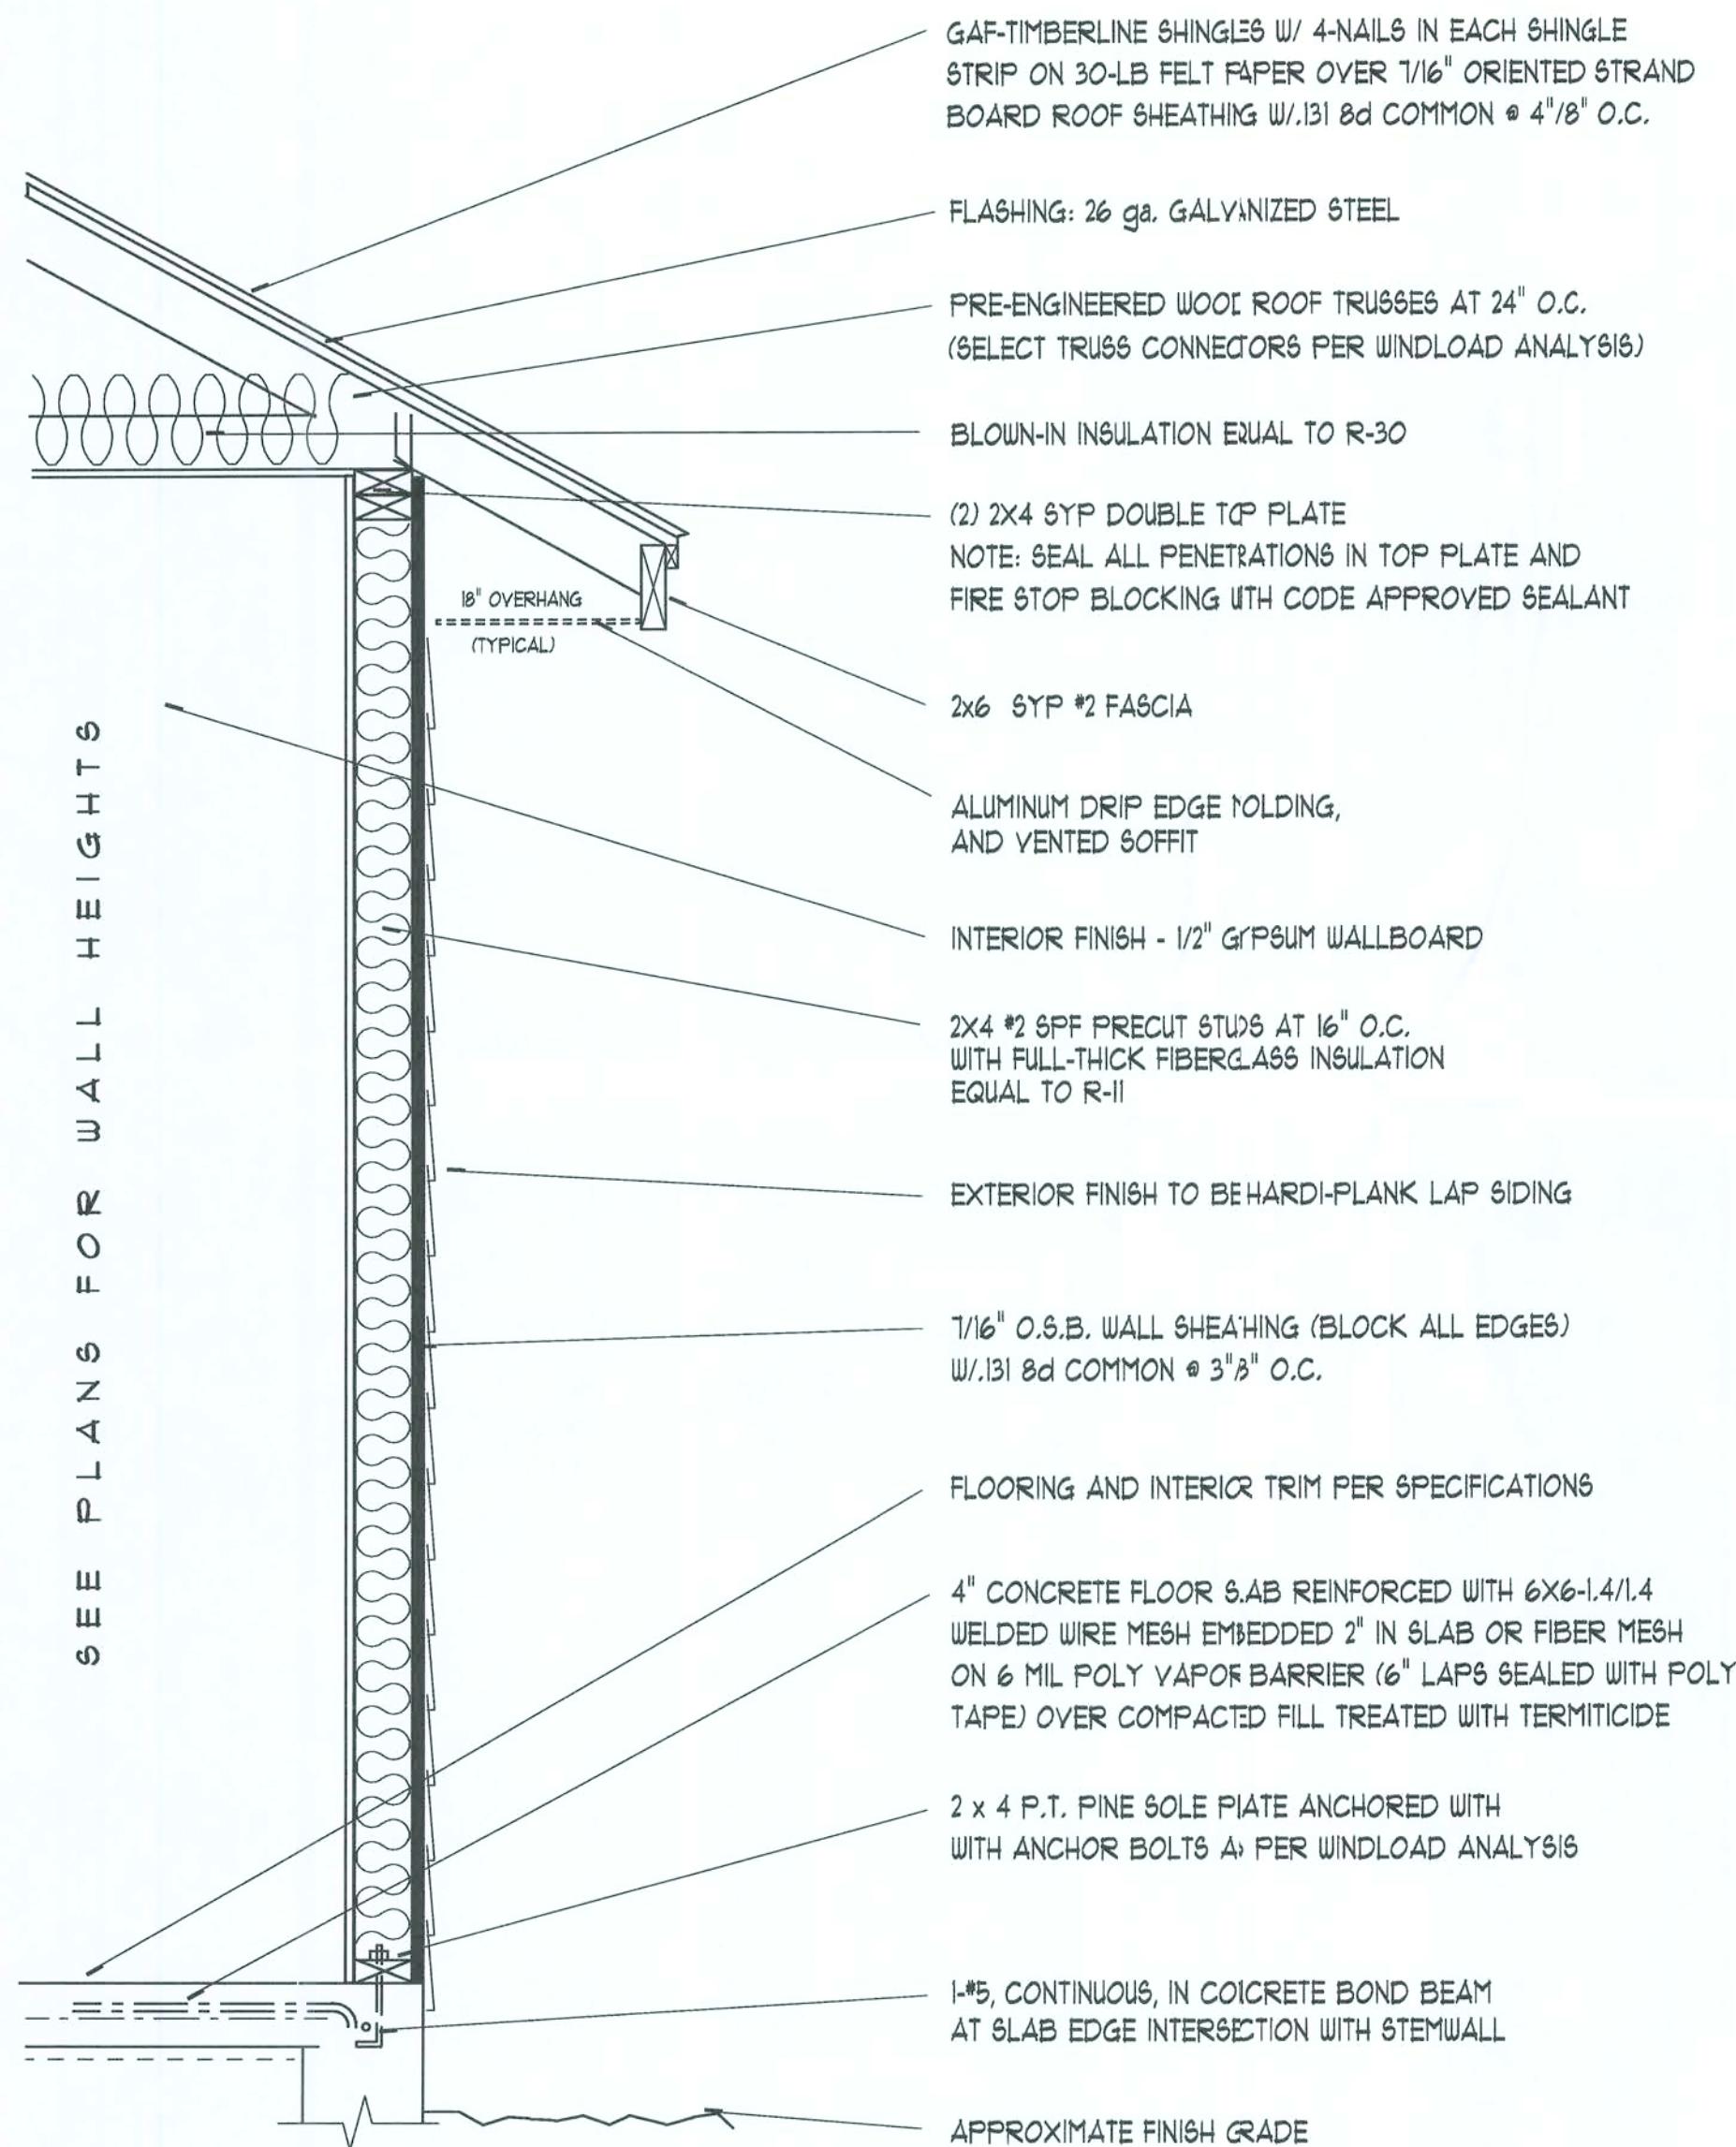


TYPICAL WALL SECTION

SCALE: 1" = 1'0"

ALL DRAWINGS NOT TO BE SCALED, WRITTEN DIMENSIONS TAKE PRECEDENCE OVER SCALED DIMENSIONS

Daniel Shaheen
Daniel Shaheen

August 03, 2006

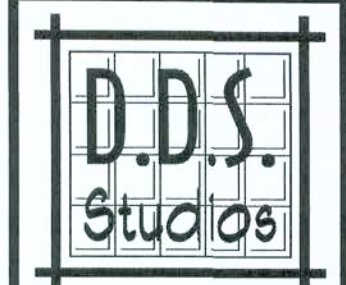

ARCHITECTURAL
DESIGN
P.O. Box 273
LAKE CITY, FL 32056
(386) 754-0181
CONSTRUCTION
DOCUMENTS BY:


ENGINEERED BY:

A CUSTOM HOME BY DON REED CONSTRUCTION:
BASS RESIDENCE
COPYRIGHT: 2006 DDS STUDIOS

FLOOR PLAN

SHEET NUMBER
3 of 4

All work shall comply with the standard building code, and all applicable local codes and ordinances.
Contractor shall verify all dimensions prior to commencing construction.

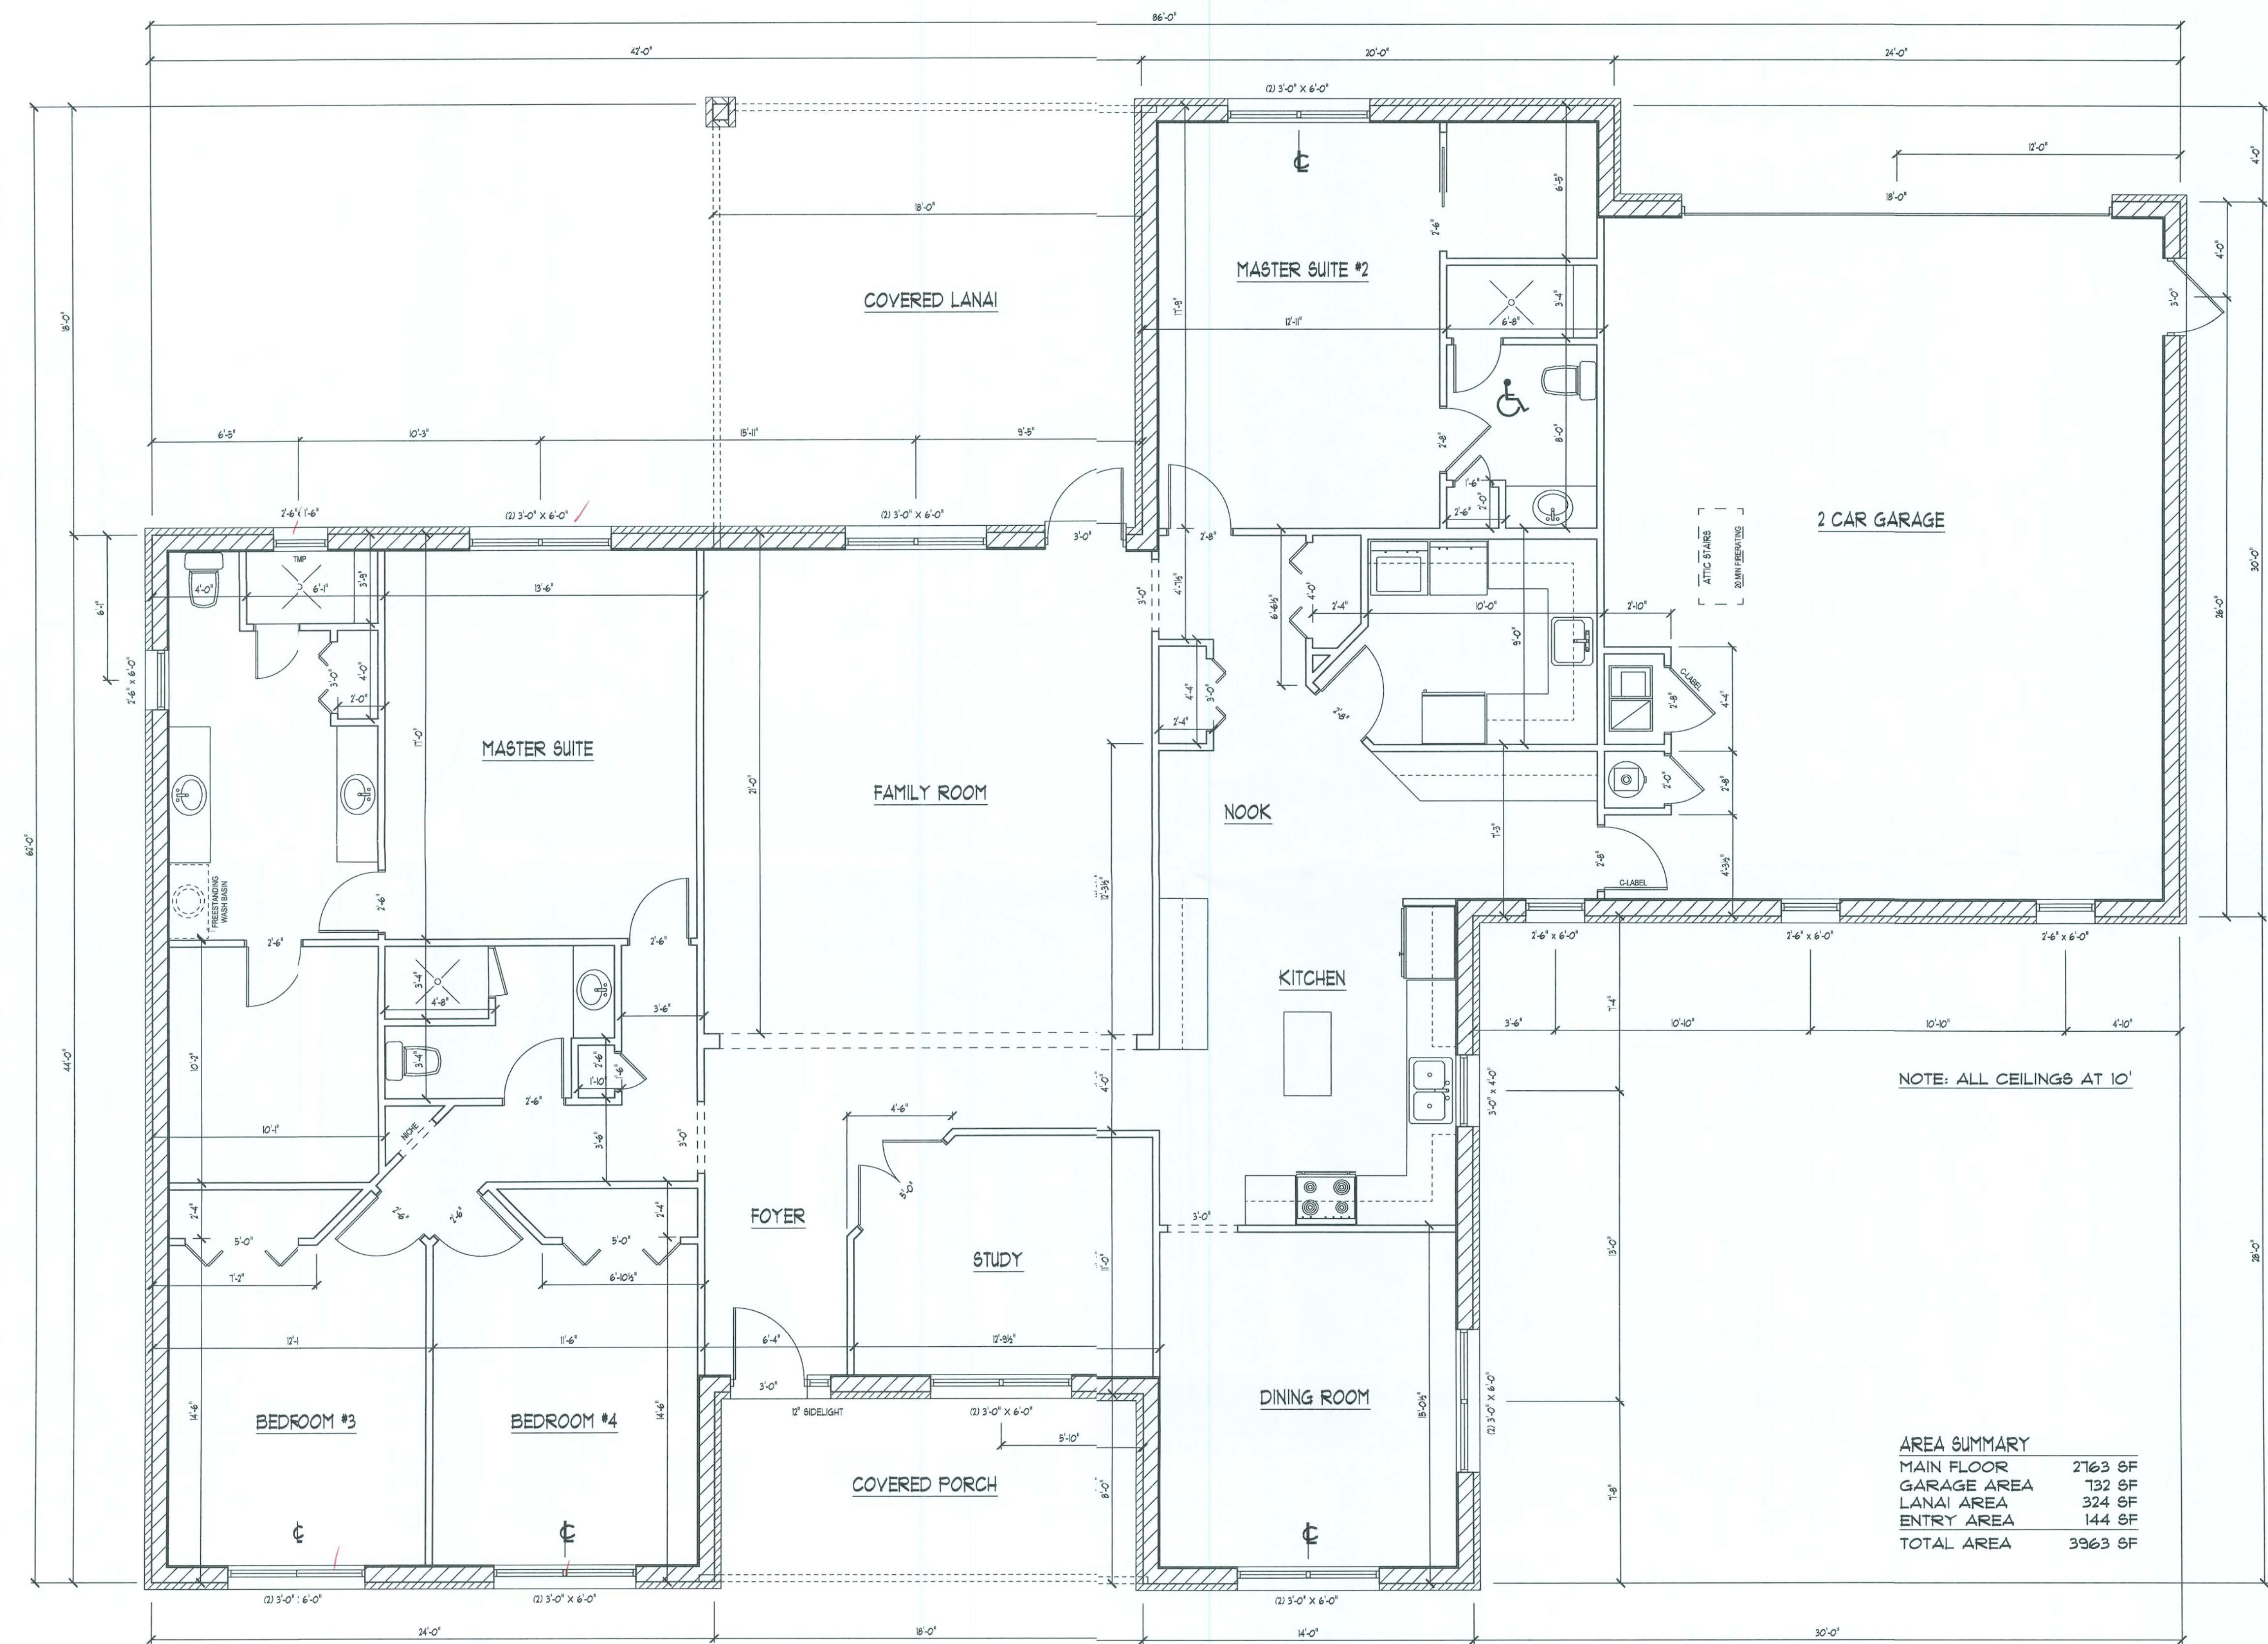

FLOOR PLAN
SCALE: 1/4" = 1'

ALL DRAWINGS NOT TO BE SCALED, WRITTEN DIMENSIONS TAKE PRECEDENCE OVER SCALED DIMENSIONS

Daniel Shaheen
Daniel Shaheen

August 03, 2006



ARCHITECTURAL
DESIGN
P.O. BOX 273
LAKE CITY FL 32056
(386) 754-0161

CONSTRUCTION
DOCUMENTS BY:

ENGINEERED BY:

A CUSTOM HOME BY DON REED CONSTRUCTION:
BASS RESIDENCE
COPYRIGHT: 2006 DDS STUDIOS


ELECTRICAL PLAN

SHEET NUMBER
4 of 4

All work shall comply with the standard building code, and all applicable local codes and ordinances.
Contractor shall verify all dimensions prior to commencing construction.

ELECTRICAL PLAN NOTES

- E-1 ALL WORK SHALL COMPLY WITH THE NATIONAL ELECTRICAL CODE, LATEST EDITION, AND ALL OTHER APPLICABLE LOCAL CODES AND ORDINANCES.
- E-2 NOTE: ALL SMOKE DETECTORS TO BE WIRED TOGETHER TO ACTIVATE ALL ALARMS IF ANY ONE UNIT IS ACTUATED.
- E-3 PROVIDE WIRING AS REQUIRED FOR APPLIANCES, AIR CONDITIONING, HEATING AND WATER HEATING EQUIPMENT.
- E-4 ALL BEDROOM RECEPTACLES SHALL BE AFCI (ARC FAULT CIRCUIT INTERRUPT).

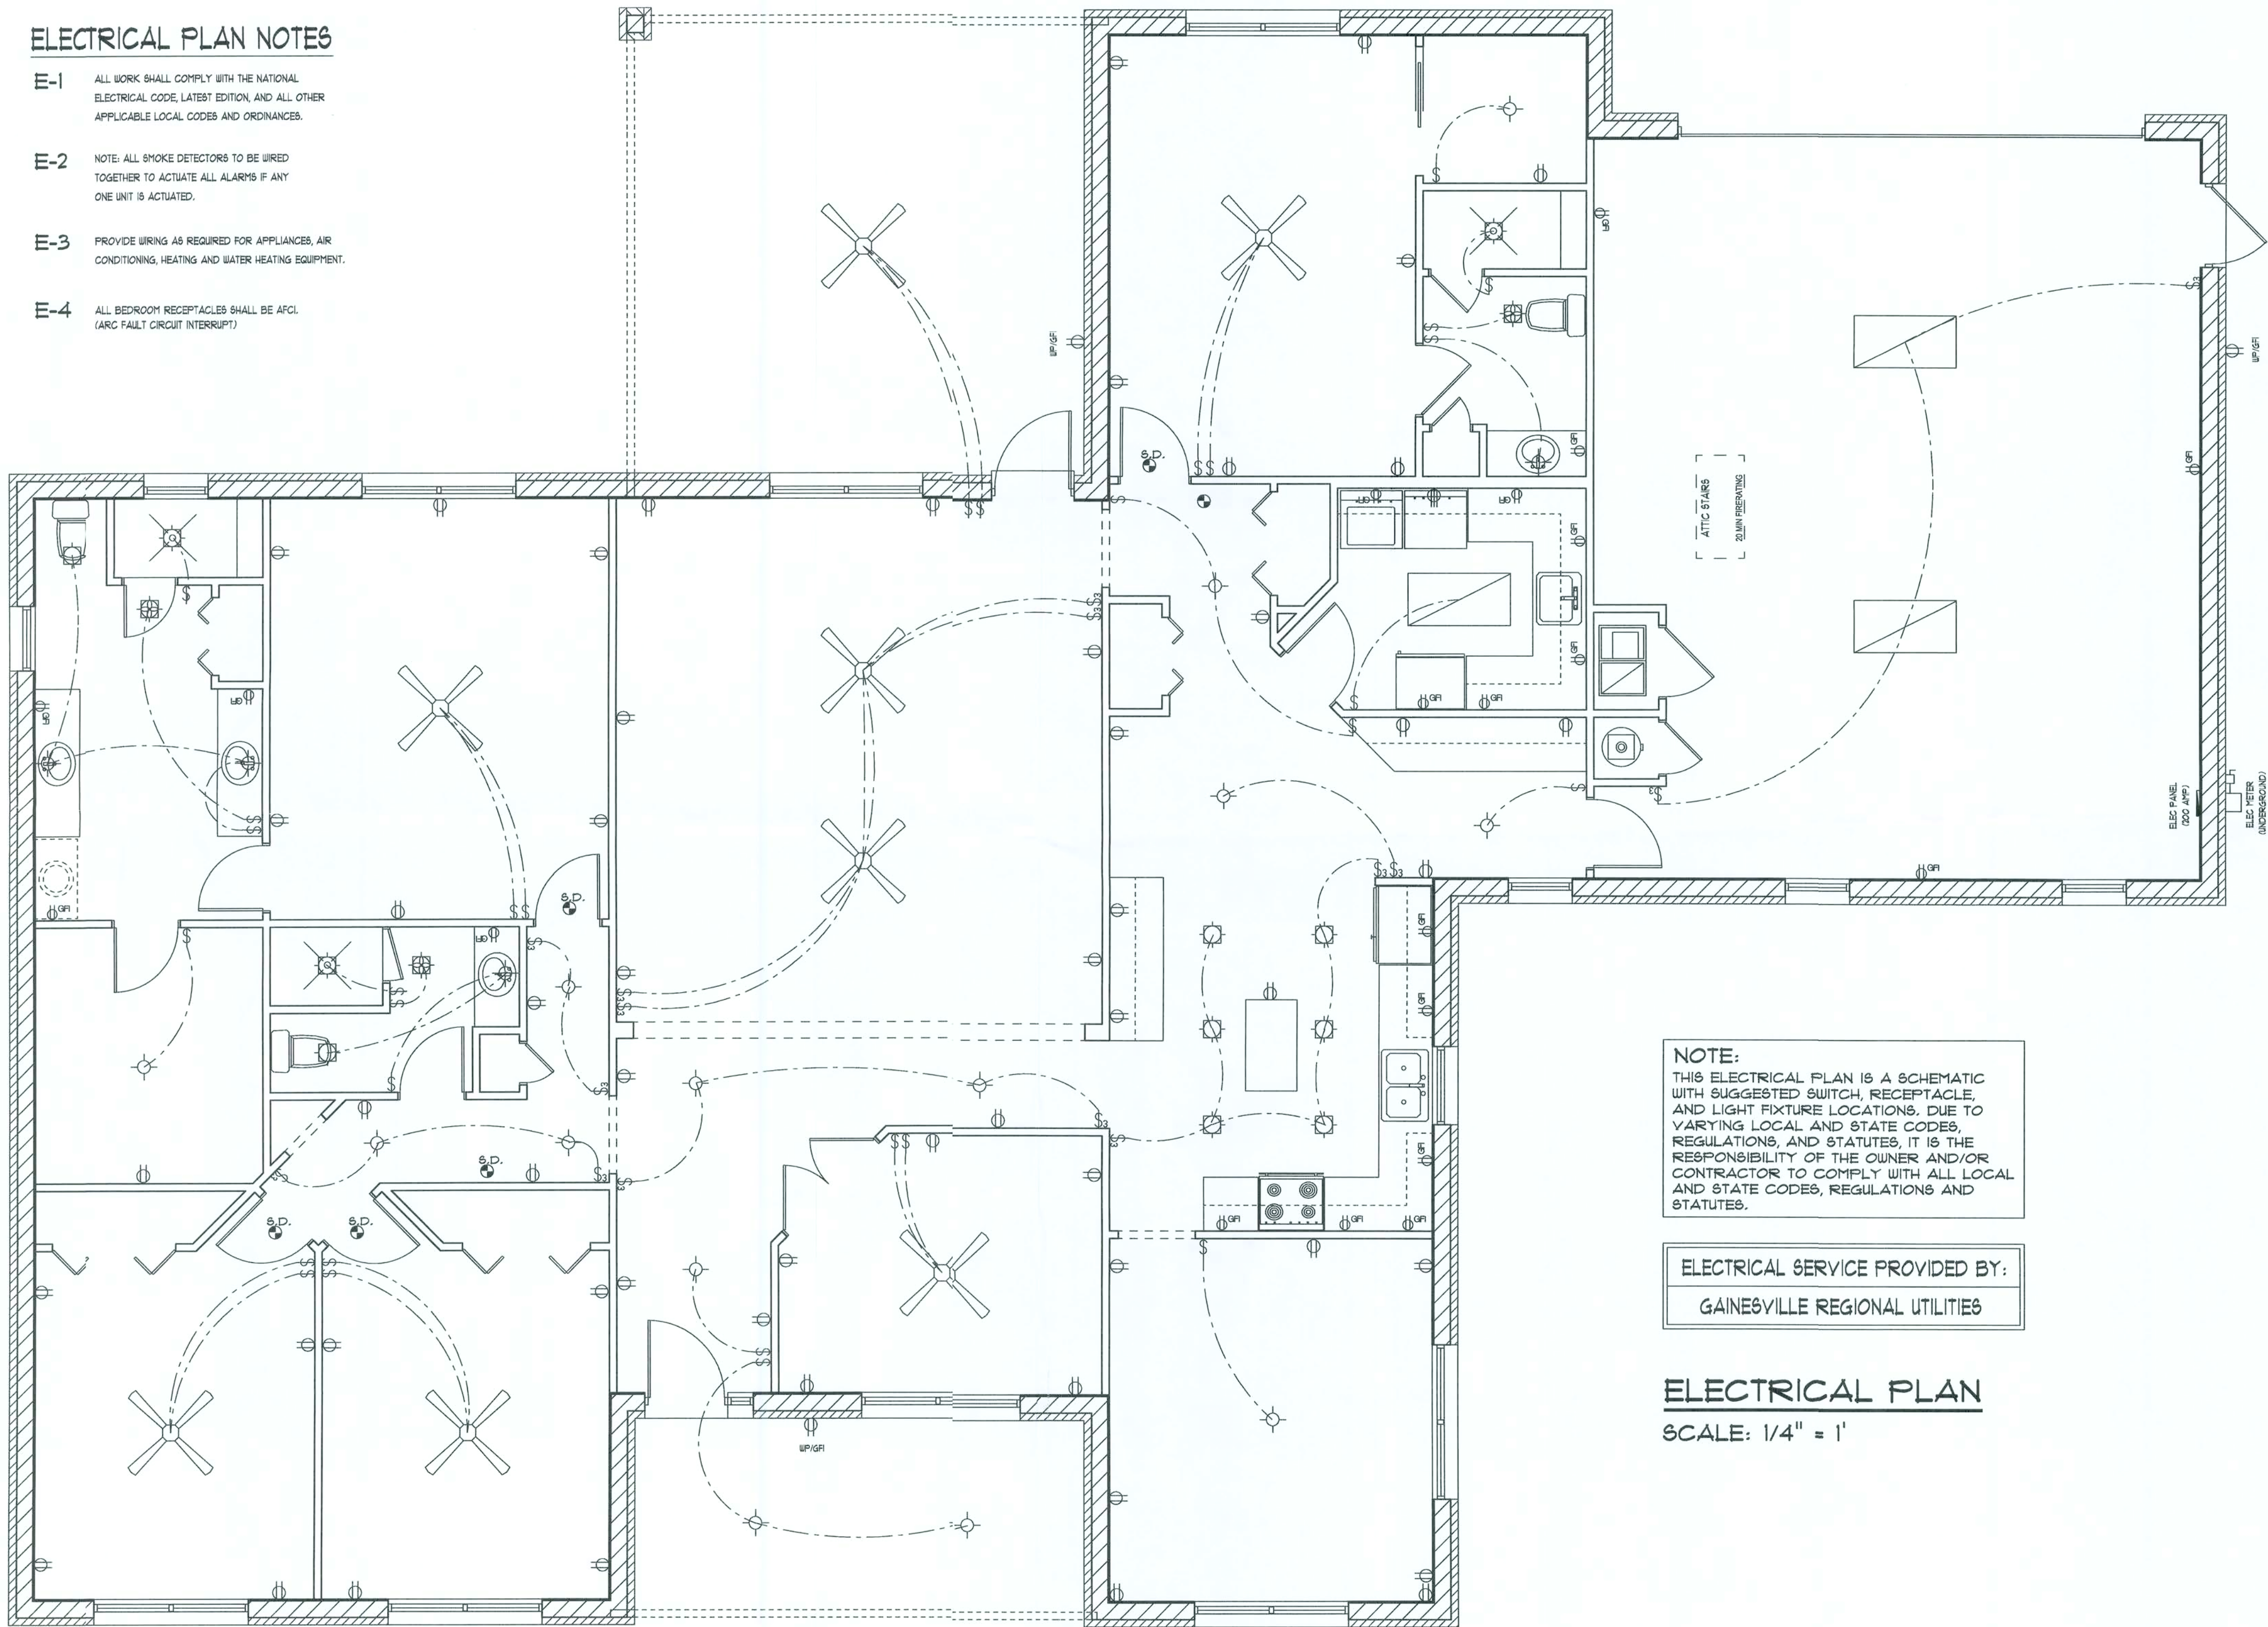

NOTE:
THIS ELECTRICAL PLAN IS A SCHEMATIC WITH SUGGESTED SWITCH, RECEPTACLE, AND LIGHT FIXTURE LOCATIONS. DUE TO VARYING LOCAL AND STATE CODES, REGULATIONS, AND STATUTES, IT IS THE RESPONSIBILITY OF THE OWNER AND/OR CONTRACTOR TO COMPLY WITH ALL LOCAL AND STATE CODES, REGULATIONS AND STATUTES.

ELECTRICAL SERVICE PROVIDED BY:
GAINESVILLE REGIONAL UTILITIES

ELECTRICAL PLAN
SCALE: 1/4" = 1'