



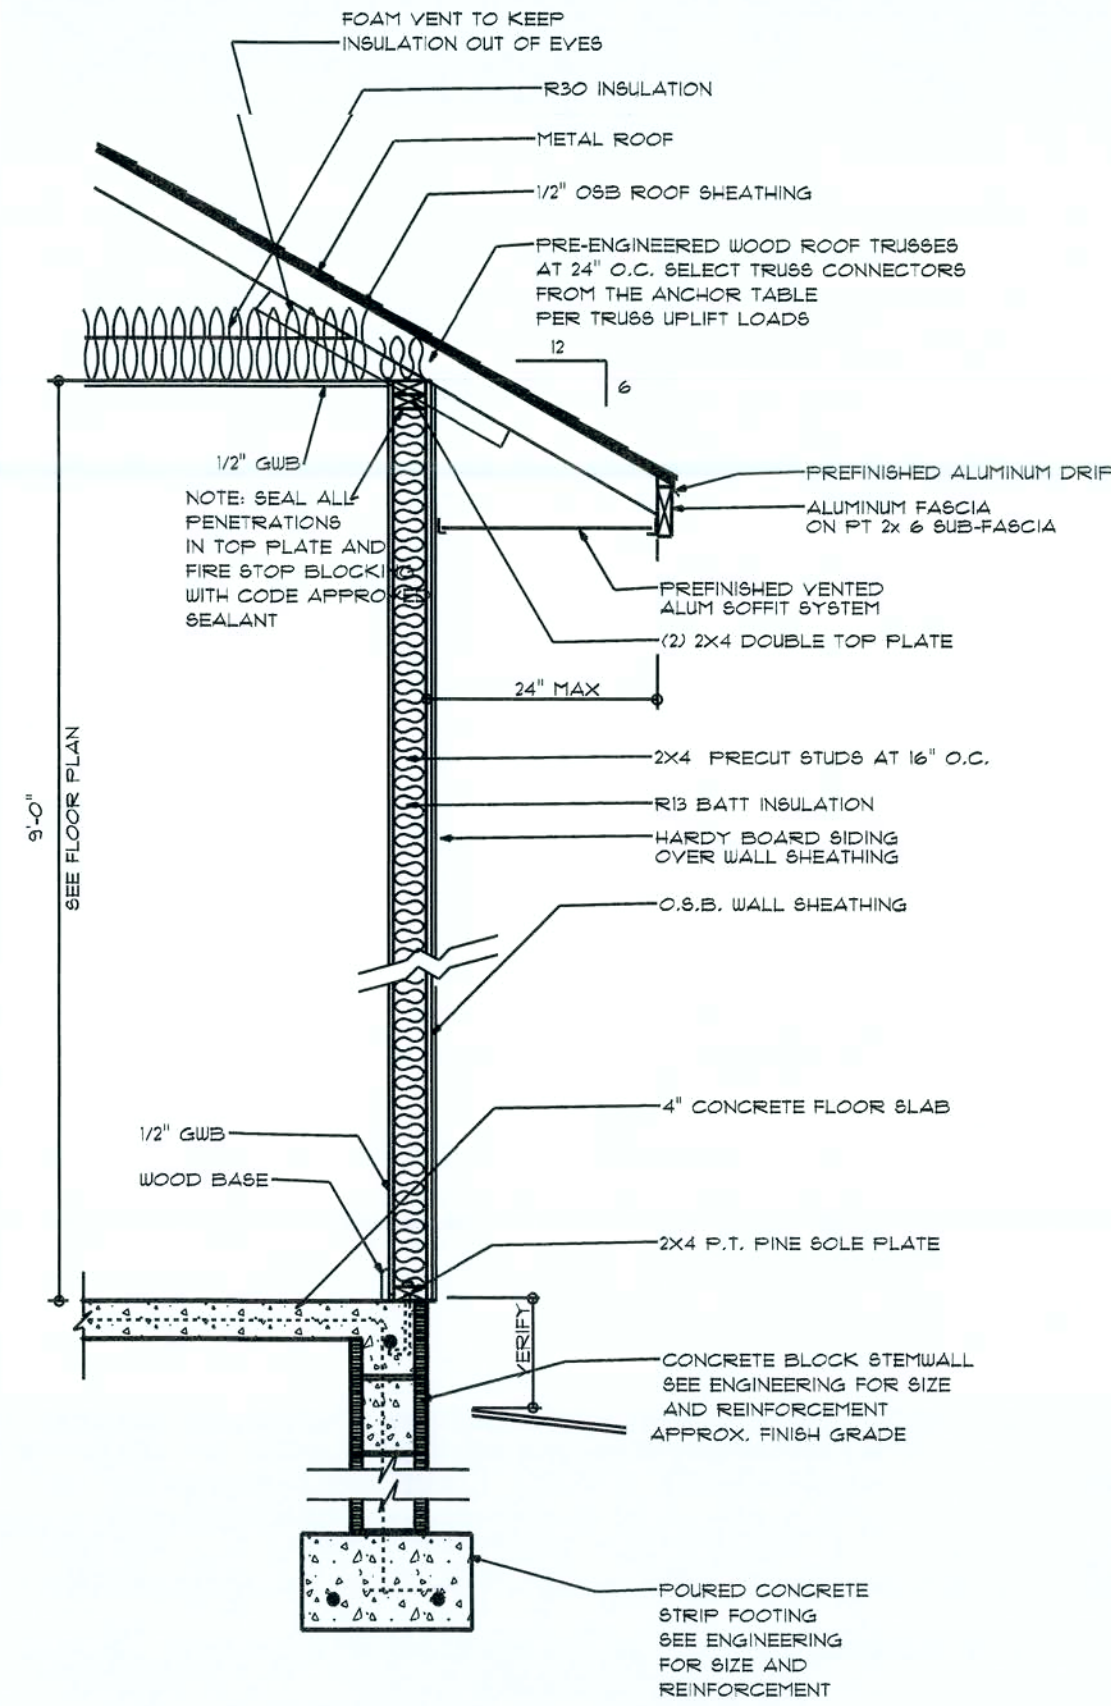

TYPICAL DESIGN WALL SECTION
NON - STRUCTURAL DATA

N.T.S.

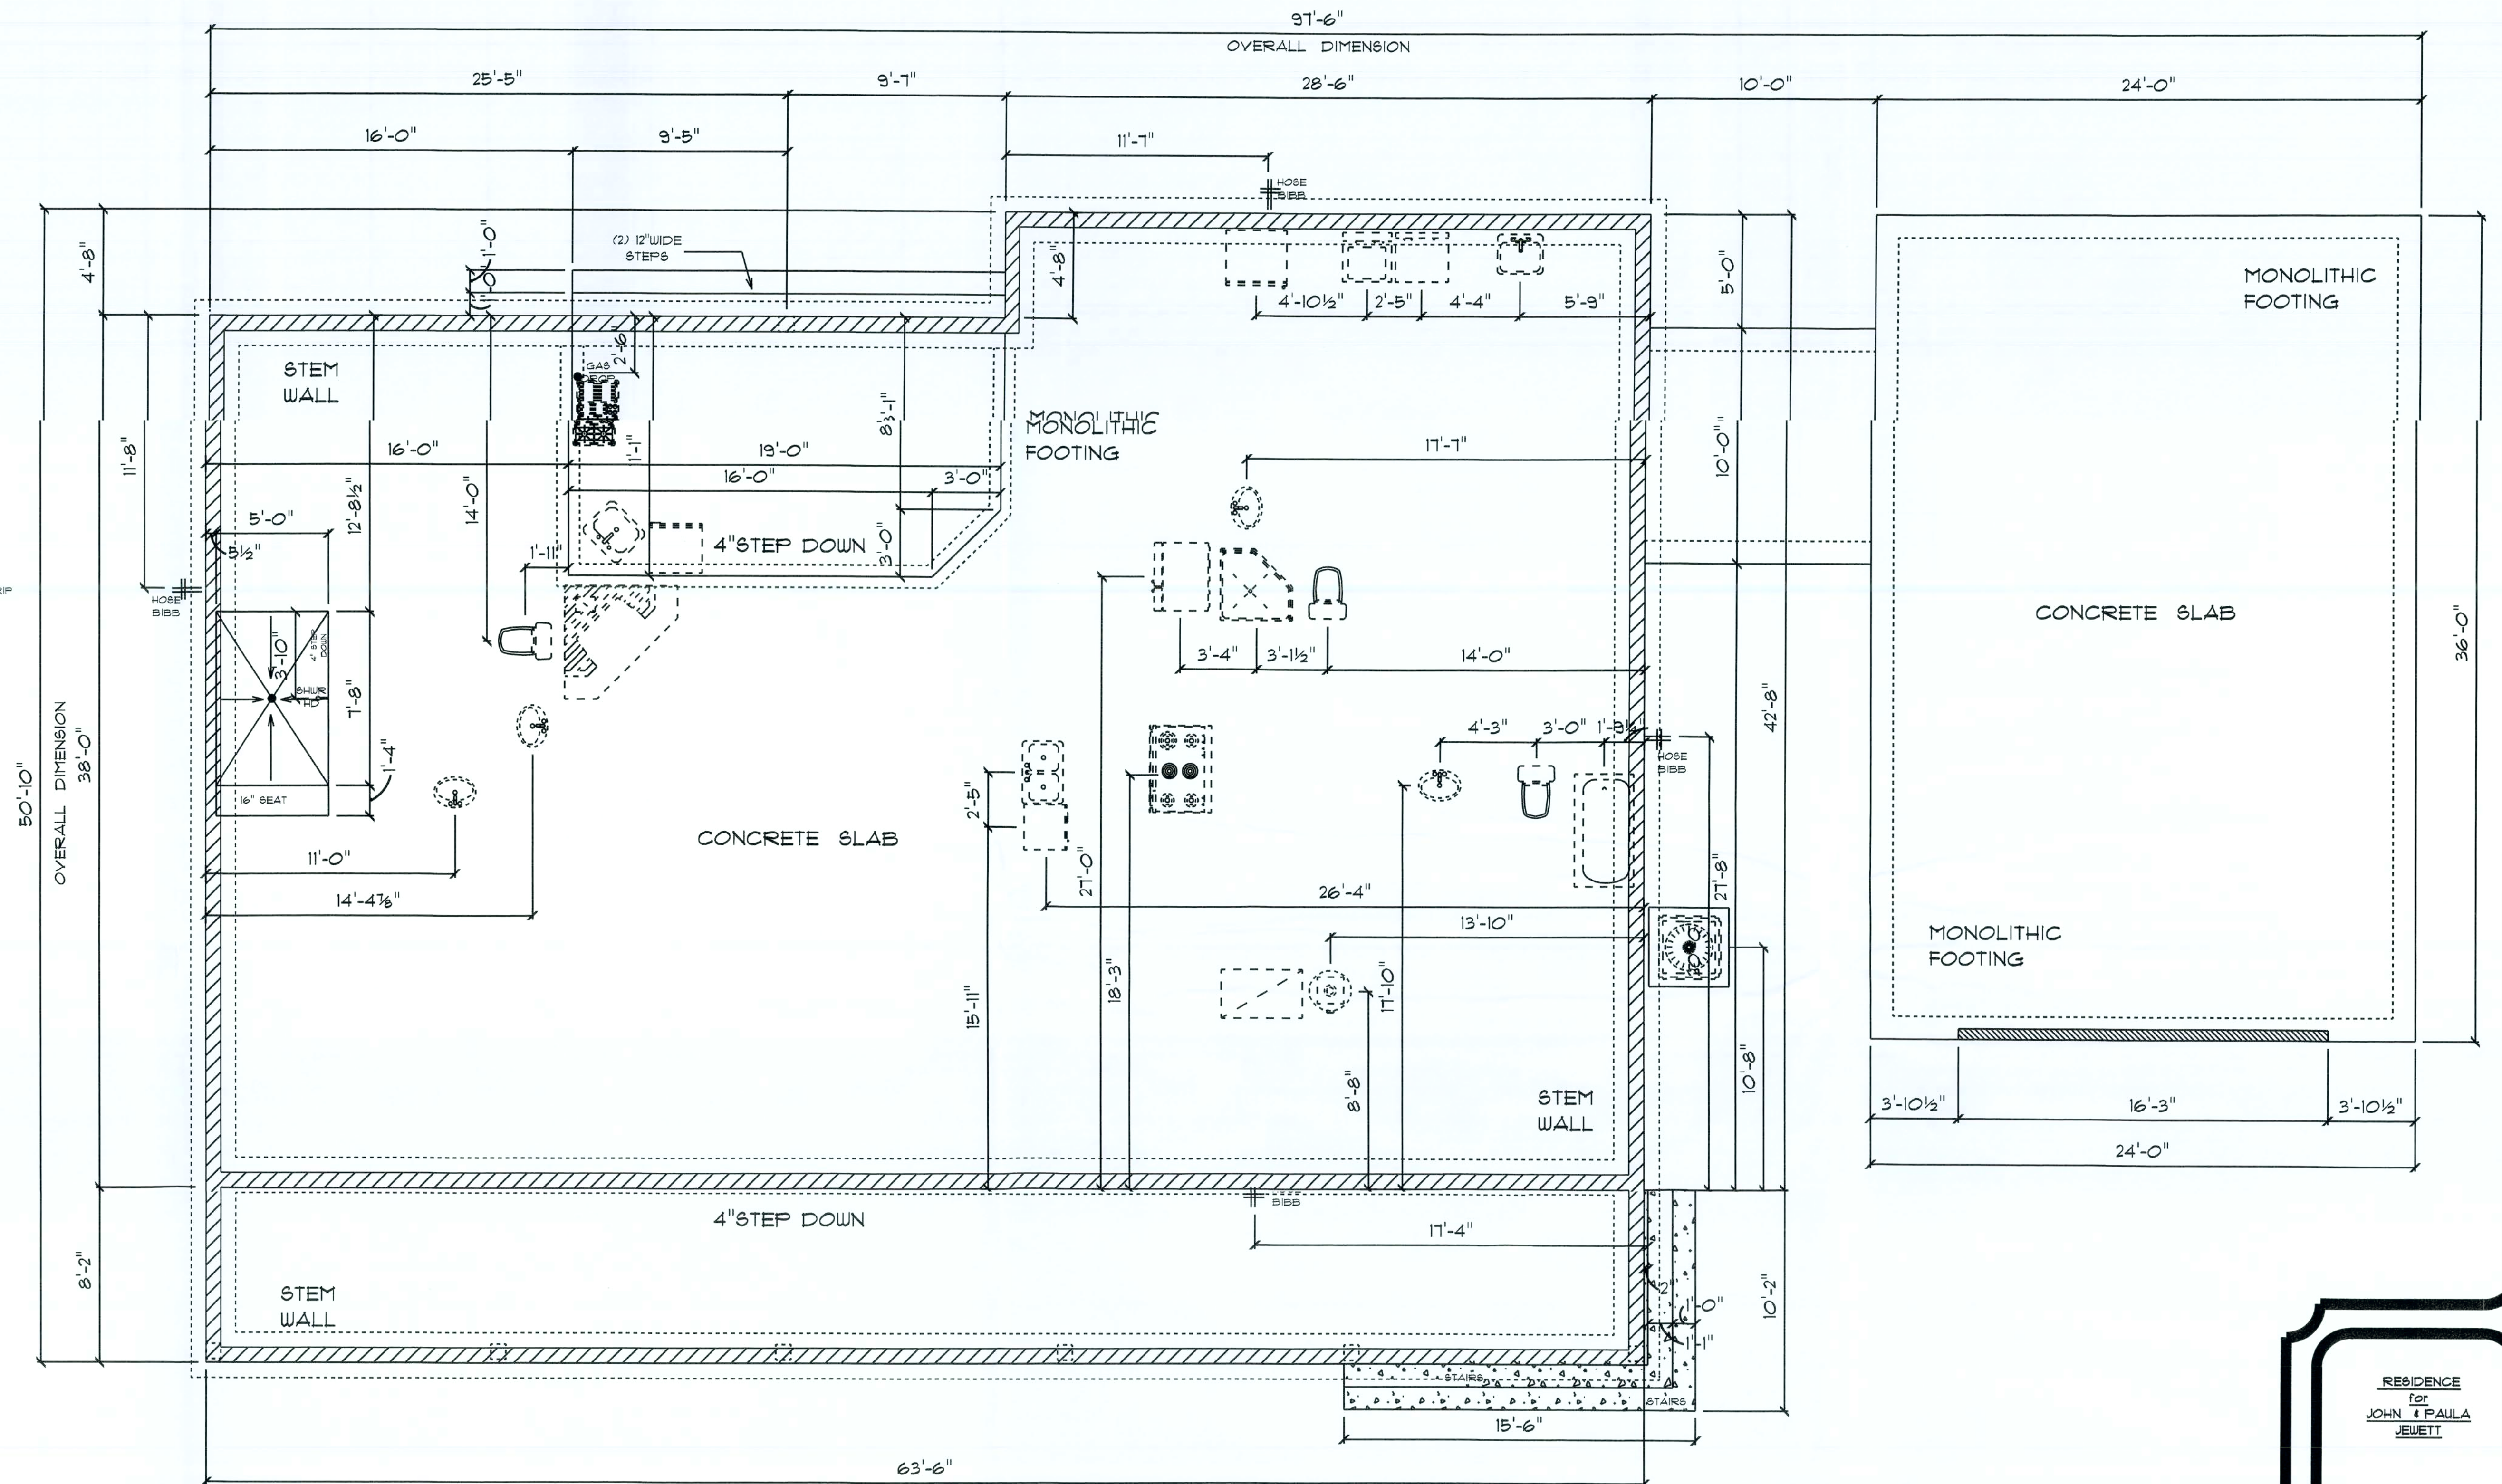

* FOUNDATION PLAN *

SCALE : 1/4" = 1'-0"

IMPORTANT NOTE:

1. IT IS THE BUILDERS RESPONSIBILITY TO VERIFY ALL GEOMETRY AND DIMENSIONS BEFORE ORDERING ANY MATERIALS OR BEGINNING CONSTRUCTION.
2. THESE PLANS ARE FOR LAYOUT AND DESIGN PURPOSES ONLY ALL STRUCTURAL NOTES AND DETAILS TO BE PROVIDED BY AN ENGINEER.
3. ALL EXTERIOR WALLS TO BE 2X6.

RESIDENCE
for
JOHN & PAULA
JEWETT

FLORIDA

Teresa M. Ruffo
2025 SW 3R 41
Lake City Florida 32025
Cell: (386) 861-1191
Email: teranaruffo@gmail.com

PRINTED DATE:
Sunday, April 5, 2020

DRAWN BY: Teresa M. Ruffo

BUILDING CONTRACTOR
TRADEMARK CONST


FINALS DATE:

JOB NUMBER:

DRAWING NUMBER

A-2

OF 6 SHEETS

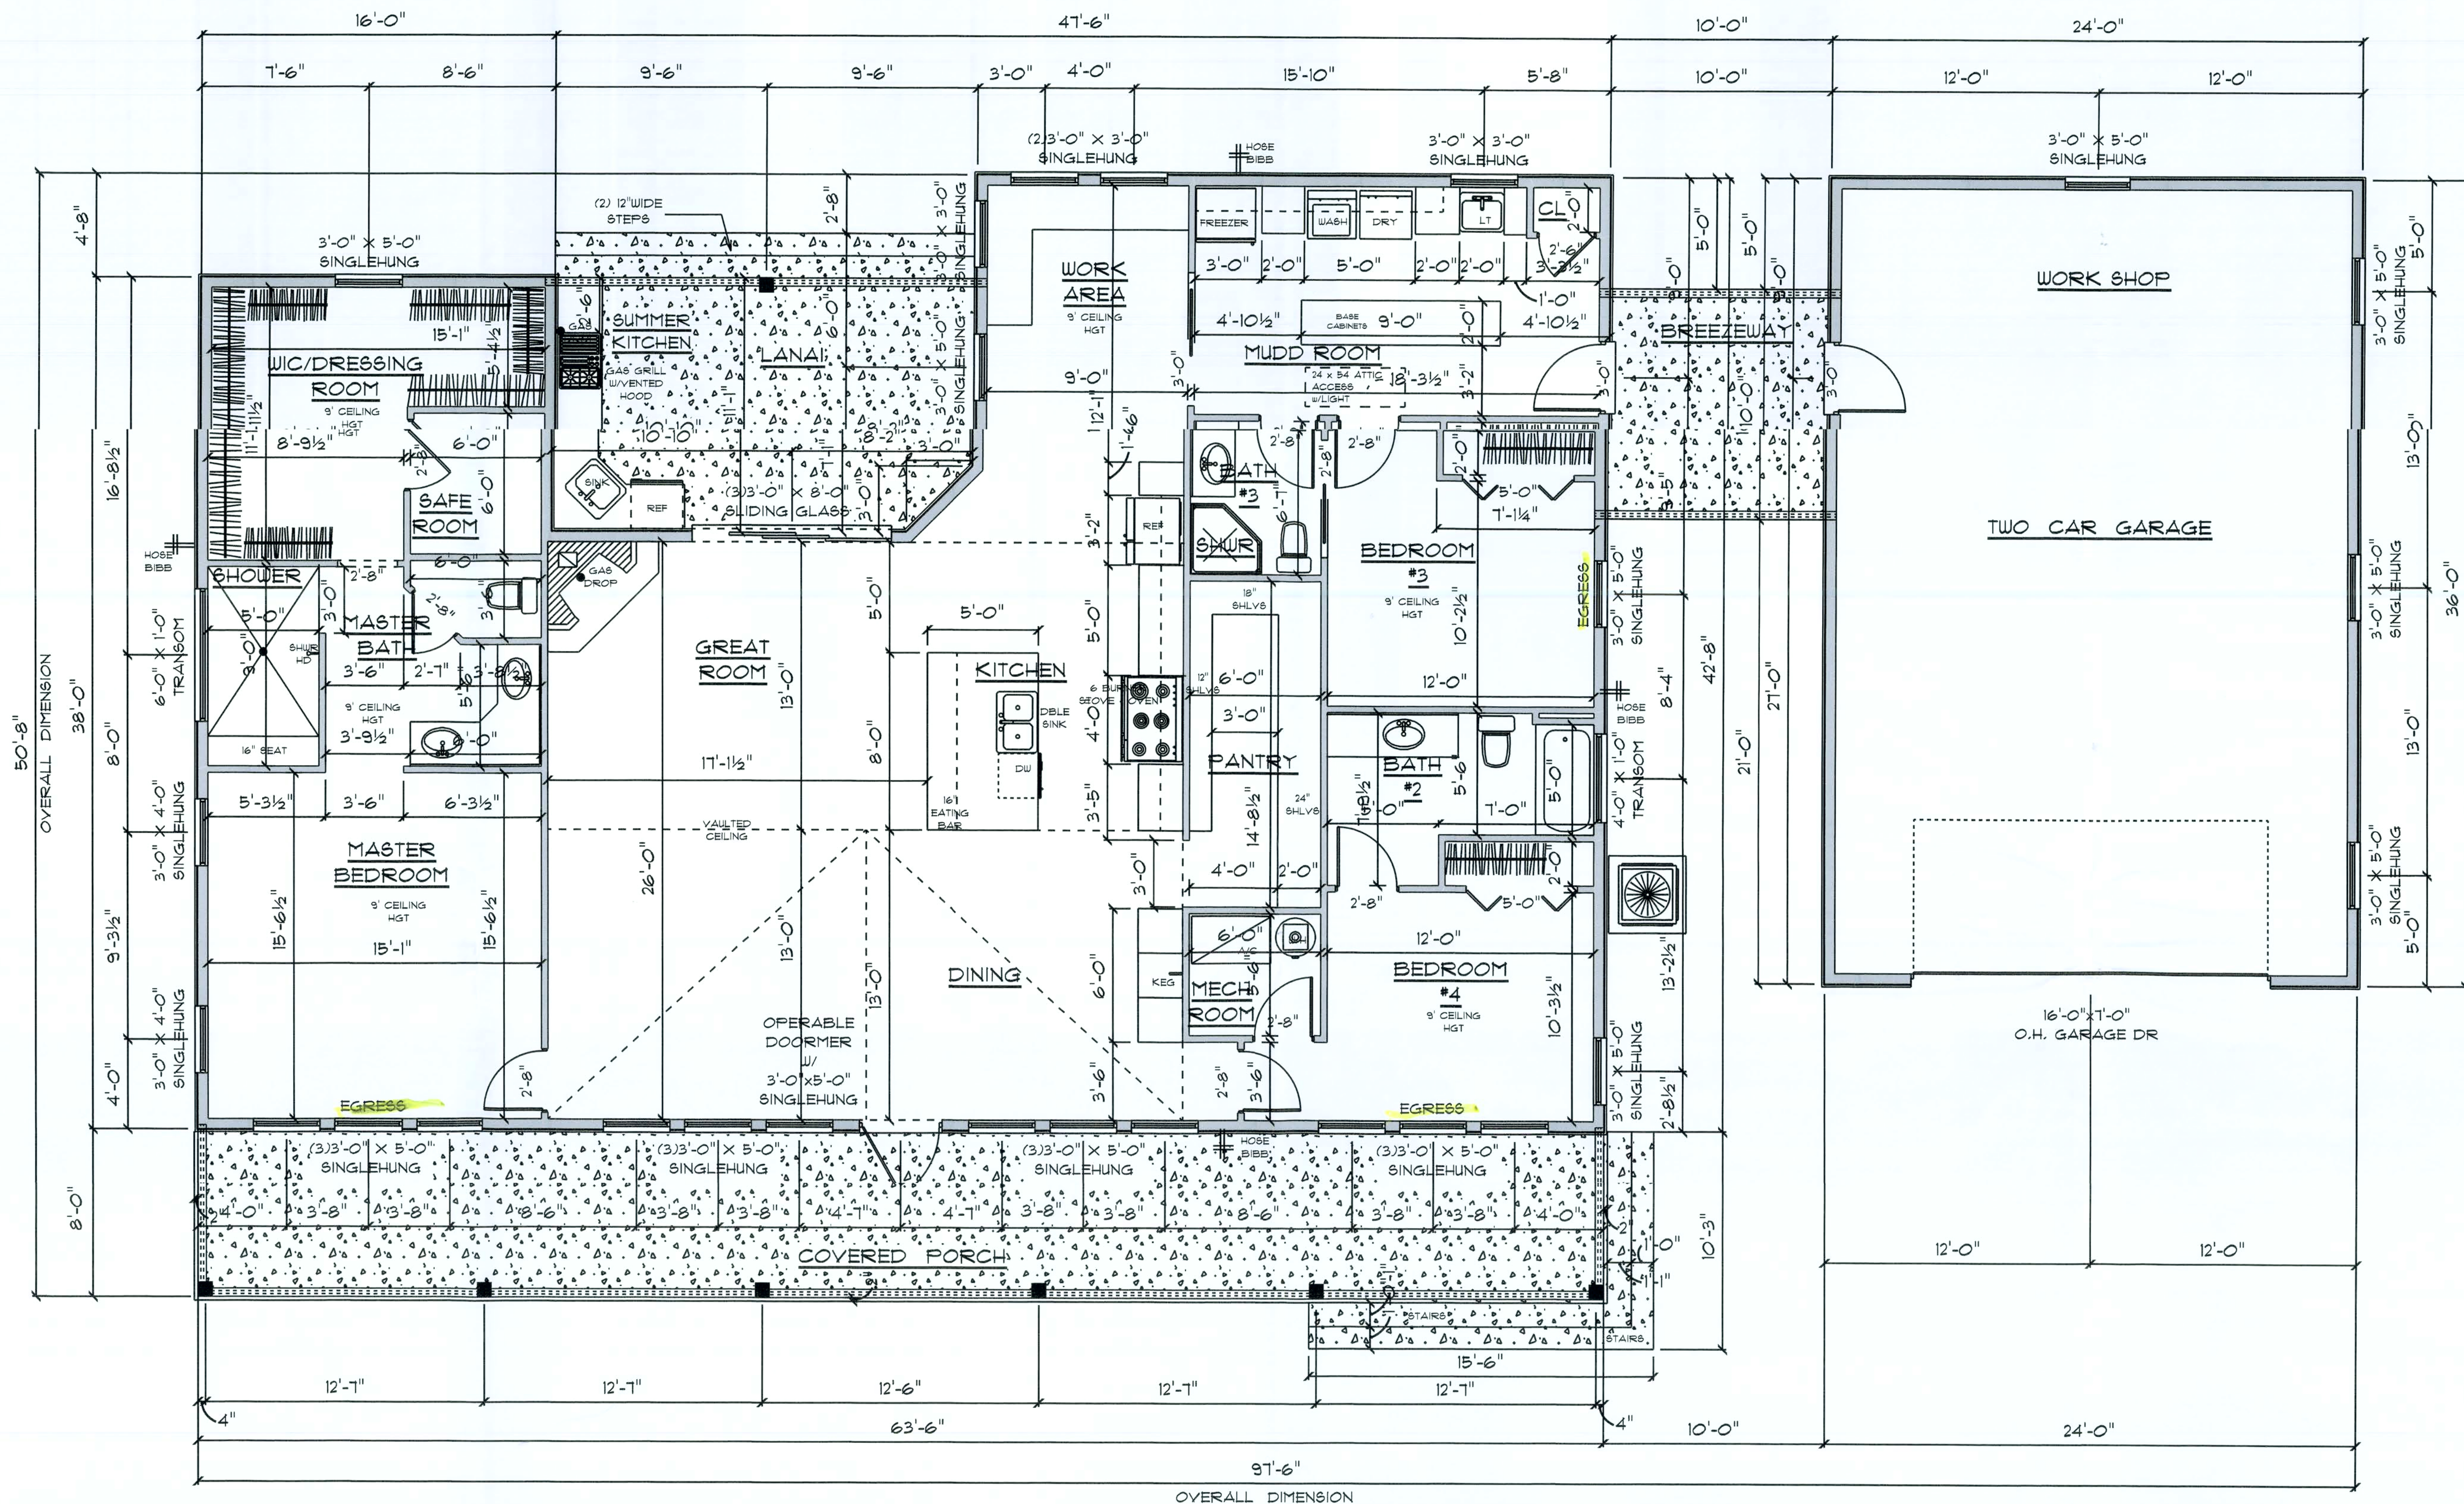

A/C LIVING AREA	=	2320 S.F.
COVERED PORCH	=	272 S.F.
LANAI	=	206 S.F.
2-CAR GARAGE	=	864 S.F.
BREEZEWAY	=	100 S.F.
TOTAL AREA UNDER ROOF	=	3762 S.F.

* FLOOR PLAN *

SCALE : 1/4" = 1'-0"

IMPORTANT NOTE:

1. IT IS THE BUILDERS RESPONSIBILITY TO VERIFY ALL GEOMETRY AND DIMENSIONS BEFORE ORDERING ANY MATERIALS OR BEGINNING CONSTRUCTION.
2. THESE PLANS ARE FOR LAYOUT AND DESIGN PURPOSES ONLY ALL STRUCTURAL NOTES AND DETAILS TO BE PROVIDED BY AN ENGINEER.
3. ALL EXTERIOR WALLS TO BE 2X6.

RESIDENCE
for
JOHN & PAULA
JEWETT

FLORIDA

Teresa M. Ruffo
2025 SW SR 41
Lake City, Florida 33025
Cell: (306) 867-1191
Email: teranaruffo@gmail.com

PRINTED DATE:
Sunday, April 5, 2020

DRAWN BY: Teresa M. Ruffo
CHECKED BY:

BUILDING CONTRACTOR
TRADEMARK CONST

FINALS DATE:

JOB NUMBER:

DRAWING NUMBER

A-3


OF 2 SHEETS



* FRONT ELEVATION *

SCALE : 1/4" = 1'-0"

NOTE :
12" OVERHANG ON ALL GABLE EAVES
24" OVERHANG ON ALL OTHER EAVES
6/12 PITCH MAIN ROOF 3/12 FRONT SHED ROOF
8/12 PITCH ON FRONT FALSE GABLE

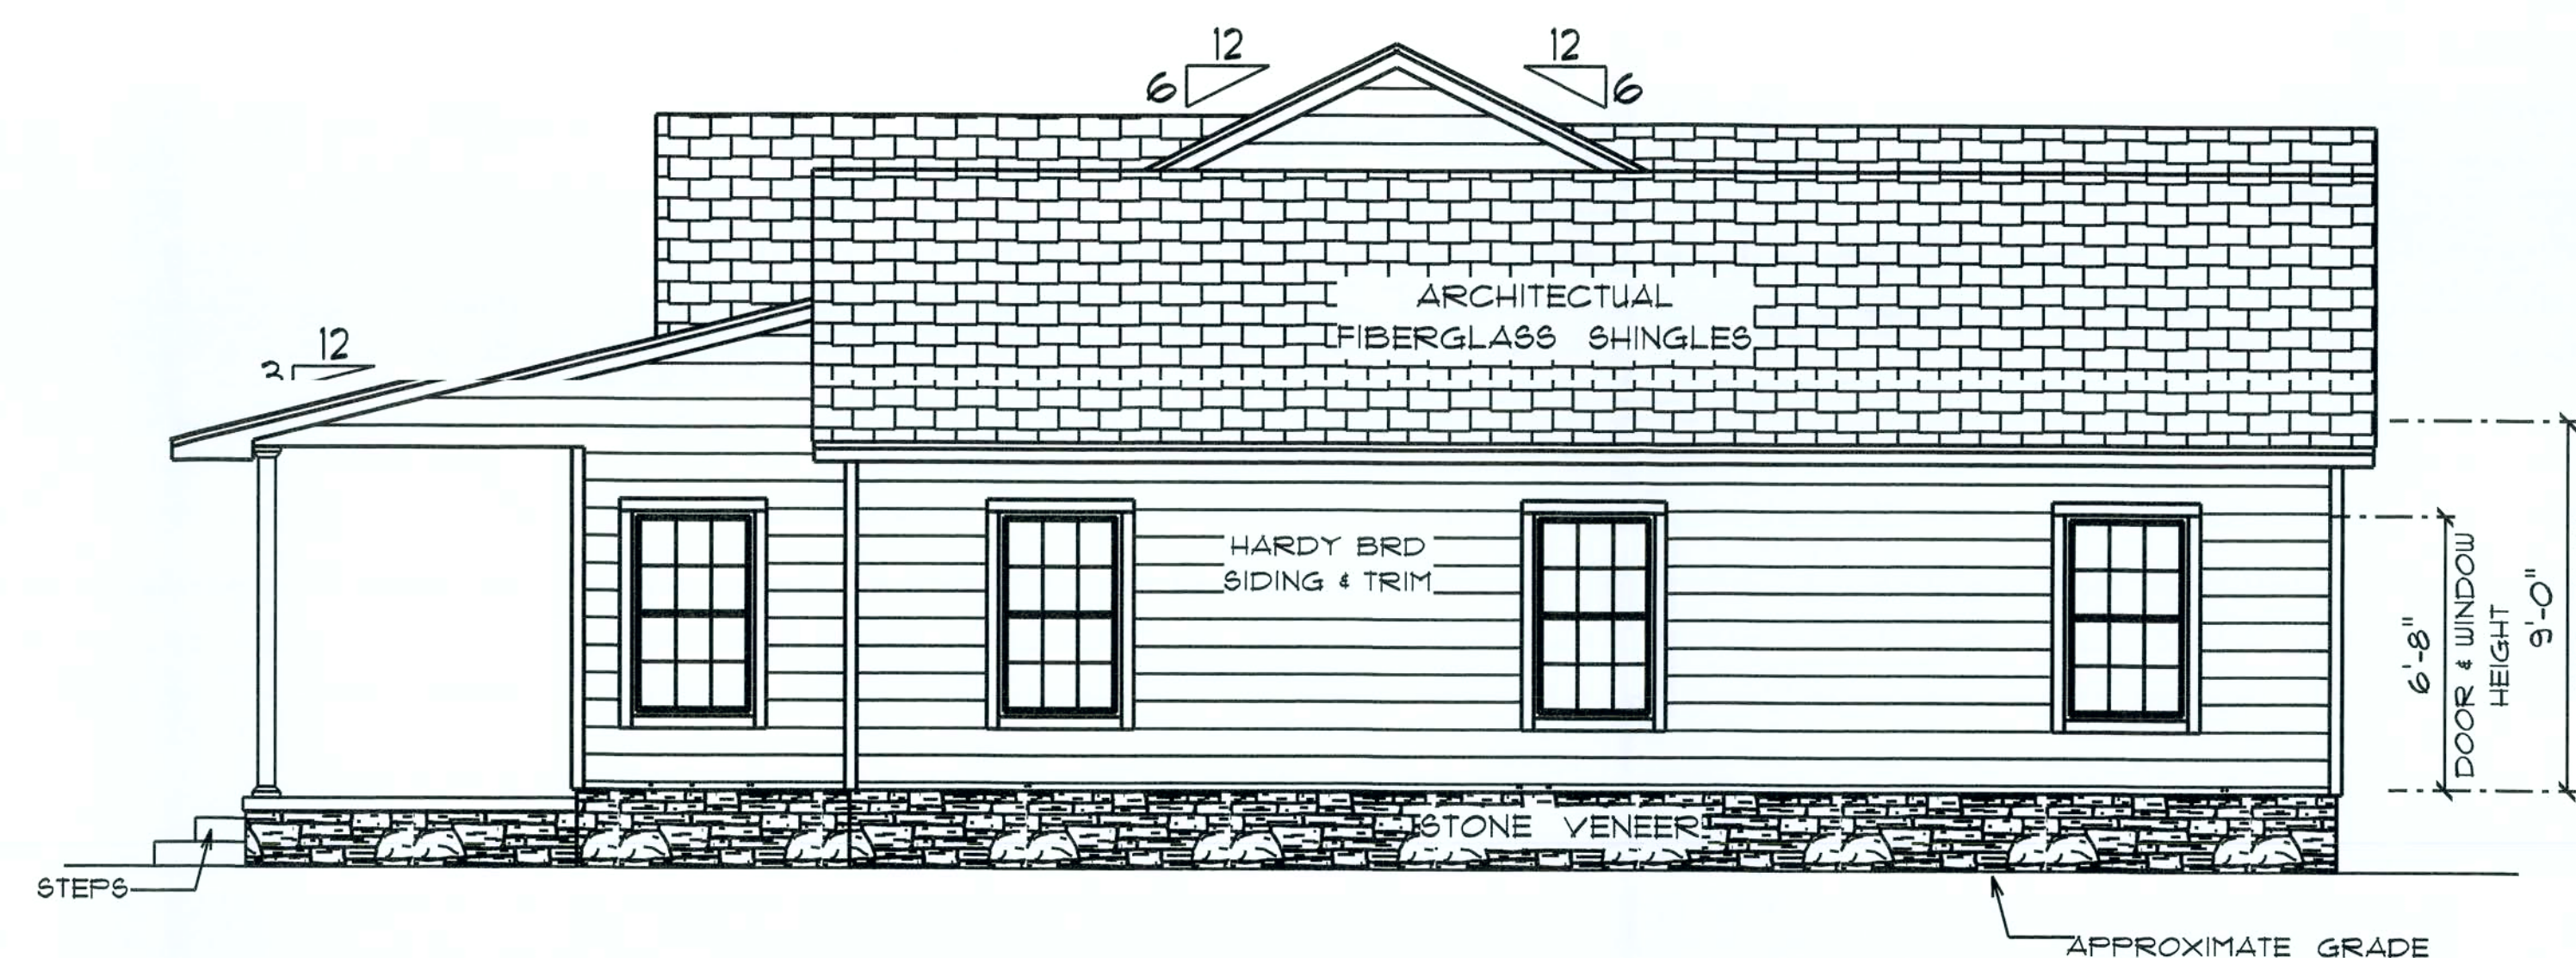

* RIGHT SIDE ELEVATION *

SCALE : 1/4" = 1'-0"

RESIDENCE
for
JOHN & PAULA
JEWETT

FLORIDA

Teresa M. Ruffo
2825 SW 8th 41
Lake City Florida, 32025
Cell: (386) 261-1191
Email: teranaruffo@gmail.com

PRINTED DATE:
Sunday, April 5, 2020

DRAWN BY: Teresa M. Ruffo CHECKED BY:

BUILDING CONTRACTOR TRADEMARK CONST

FINALS DATE:

JOB NUMBER:

DRAWING NUMBER

A-4

OF 6 SHEETS



*** REAR ELEVATION ***

SCALE : 1/4" = 1'-0"



*** LEFT SIDE ELEVATION ***

SCALE : 1/4" = 1'-0"

RESIDENCE
for
JOHN & PAULA
JEWETT

FLORIDA

Teresa M. Ruffo
2935 SW 9R 41
Lake City Florida, 32025
Cell: (386) 861-1191
Email: teresaruffo@gmail.com

PRINTED DATE:
Sunday, April 5, 2020

DRAWN BY: Teresa M. Ruffo CHECKED BY:

BUILDING CONTRACTOR
TRADEMARK CONST


FINAL DATE:

JOB NUMBER:

DRAWING NUMBER

A-5

OF 6 SHEETS

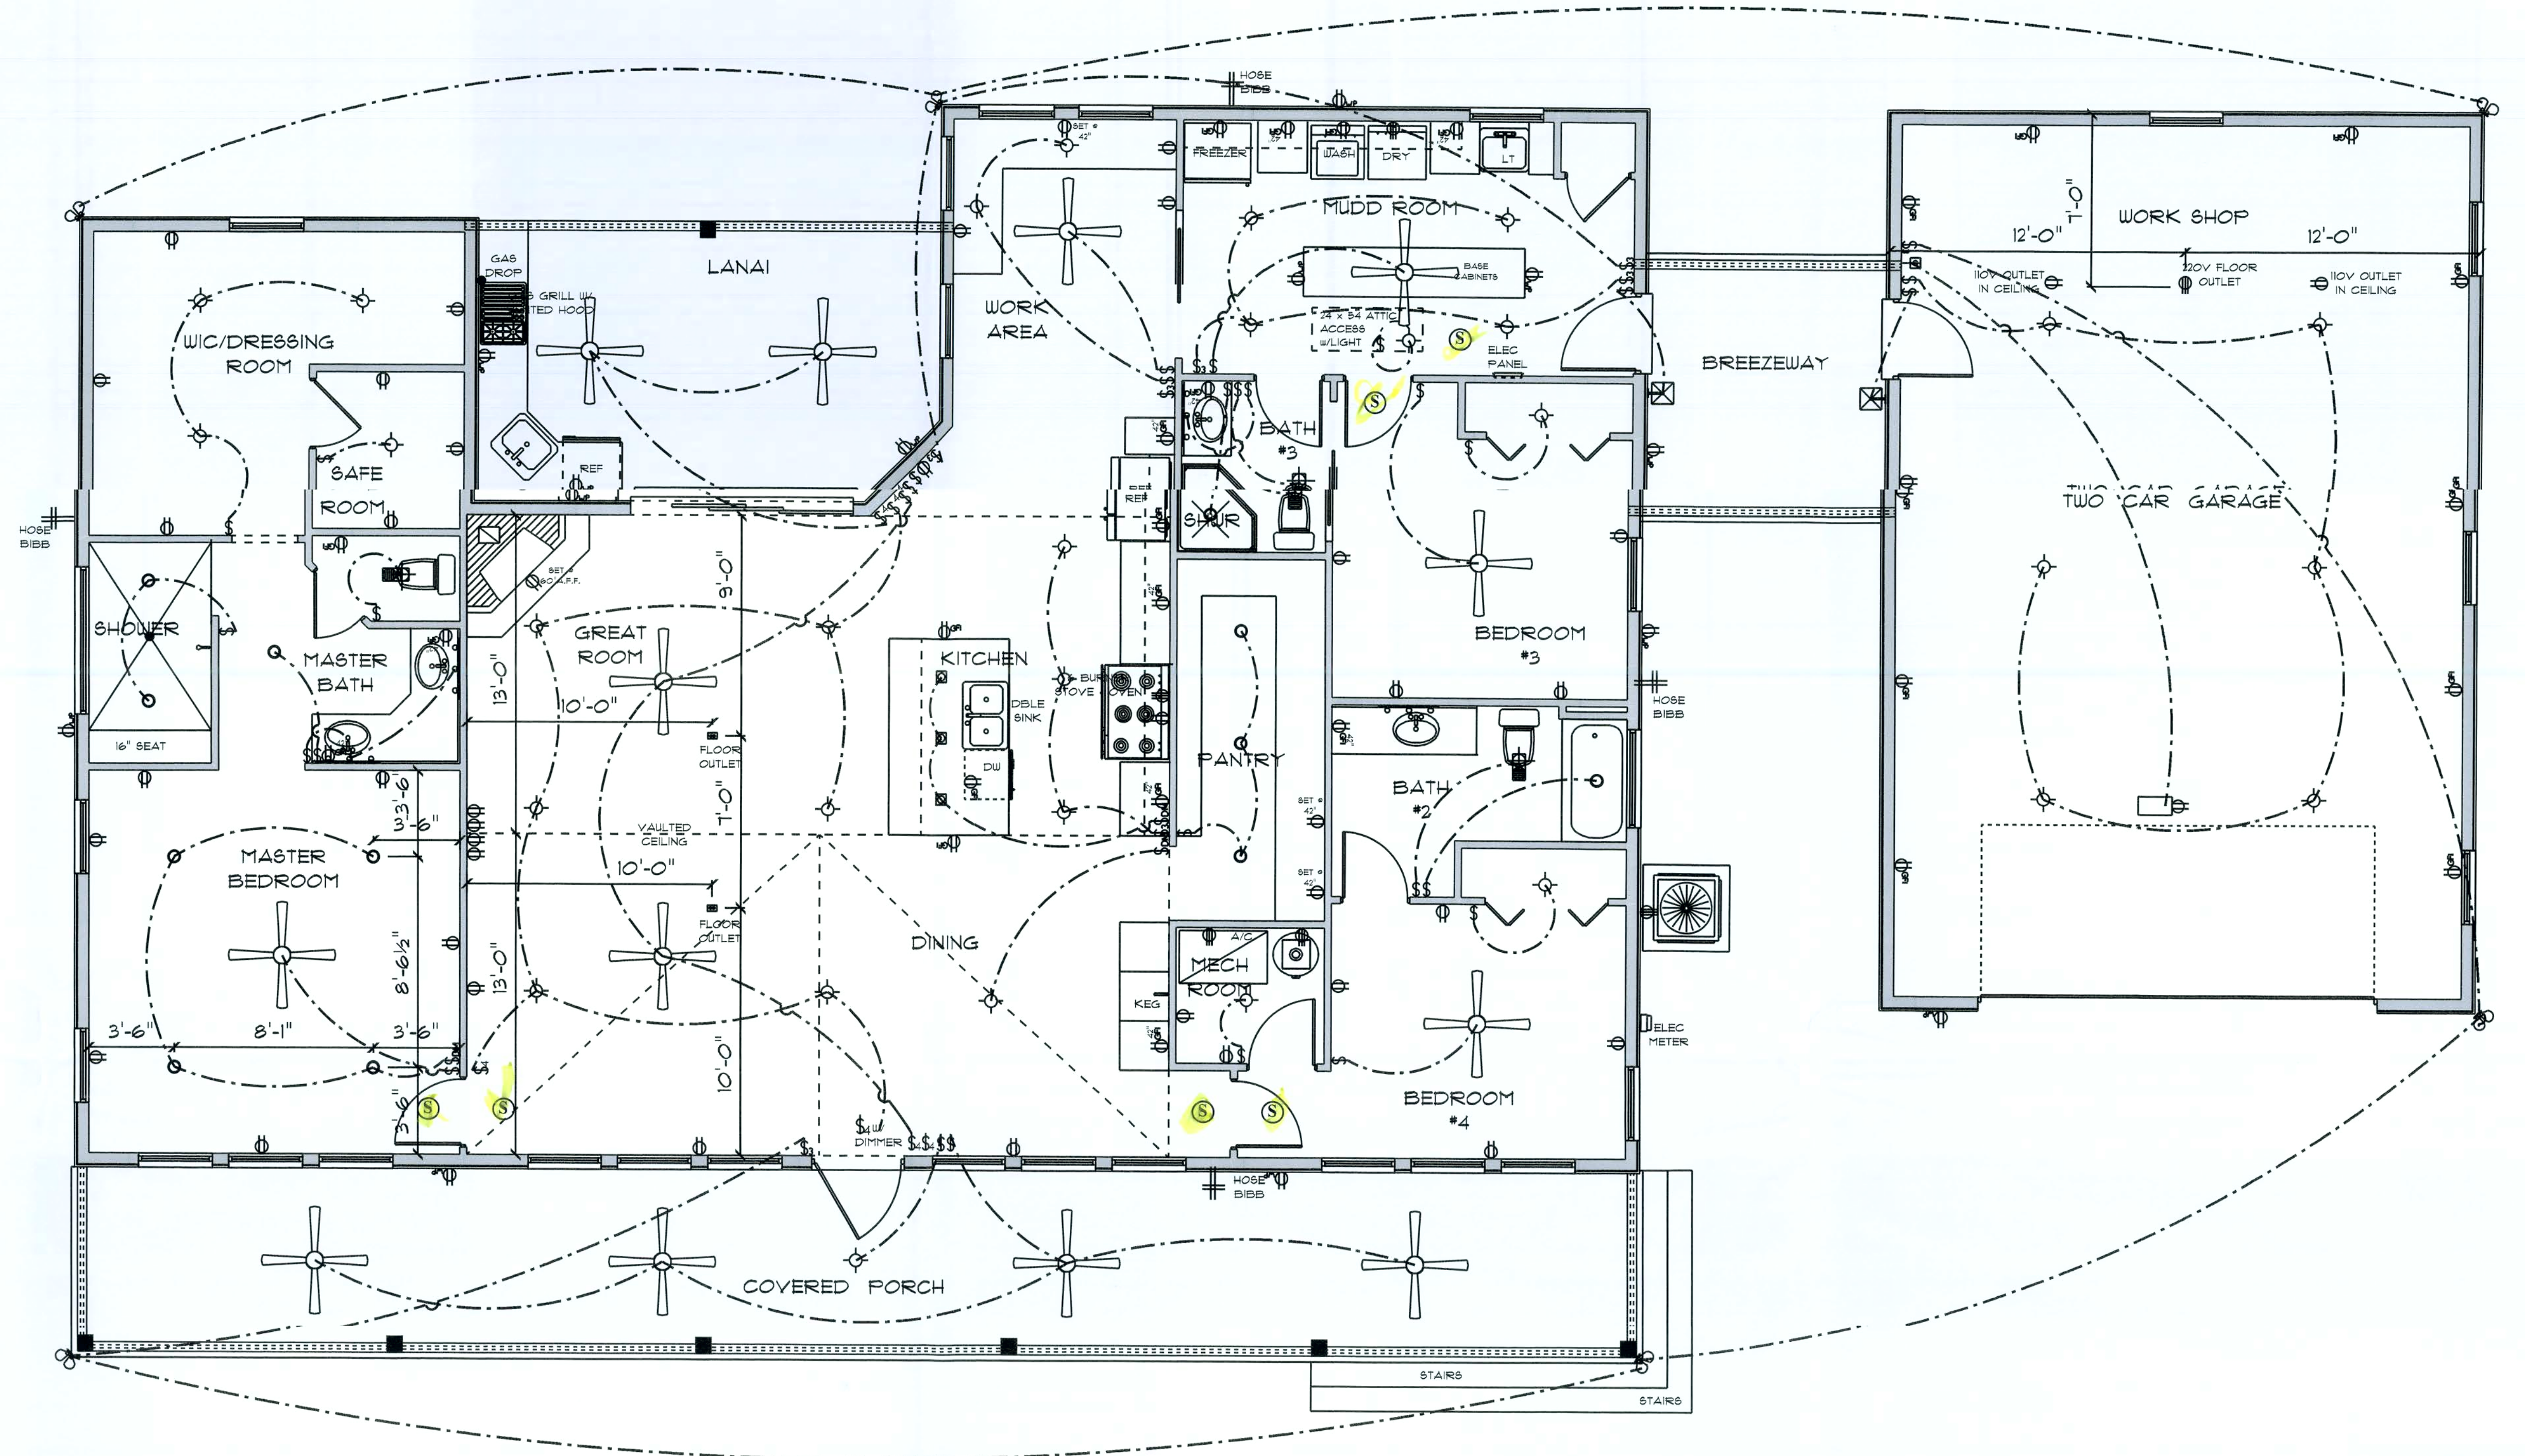

ELECTRICAL LEGEND		
ELECTRICAL	COUNT	SYMBOL
ceiling fan globe 01	13	+
exterior craftsman light fixture	2	⊙
spotlight double	6	•
Smoke Detector	6	⊙
1 Light Mini Pendant	3	•
electrical meter	1	•
electrical panel	1	•
floor outlet single	2	•
4 way switch	5	•
4 way switch with dimmer	1	•
Light	2	•
automatic garage dr opener	1	•
dimmer switch	3	•
garage dr opener	1	•
light	29	•
outlet	41	•
outlet 220v	6	•
outlet gfi	27	•
outlet wp	12	•
switch	29	•
switch 3 way	8	•
vent light combo	3	•
vanity bar light 02	4	•

ELECTRICAL PLAN NOTES

- E-1 WIRE ALL APPLIANCES, HVAC UNITS AND OTHER EQUIPMENT PER MANUFACTURER'S SPECIFICATIONS.
- E-2 ALL INSTALLATIONS SHALL BE PER NATIONAL ELECTRIC CODE.
- E-3 ALL SMOKE /CARBON MONOXIDE DETECTORS SHALL BE 120V W/BATTERY BACKUP OF THE PHOTOELECTRIC TYPE, AND SHALL BE INTERLOCKED TOGETHER. INSTALL INSIDE AND NEAR ALL BEDROOMS AS PER CODE.
- E-4 TELEPHONE, TELEVISION AND OTHER LOW VOLTAGE DEVICES OR OUTLETS SHALL BE AS PER THE OWNER'S DIRECTION AND IN ACCORDANCE WITH APPLICABLE SECTIONS OF NATIONAL ELCT. CODE LATEST EDITION.
- E-5 ELECTRICAL CONTRACTOR SHALL BE RESPONSIBLE FOR THE DESIGN AND SIZING OF ELECTRICAL SERVICE AND CIRCUITS.
- E-6 ENTRY OF SERVICE UNDERGROUND OR OVERHEAD IS TO BE DETERMINED BY THE POWER COMPANY.
- E-7 ALL BEDROOM RECEPTICALS ARE TO BE AFCI (ARC FAULT CIRCUIT INTERRUPT)
- E-8 75% OF ALL PERMANENT LIGHTS TO BE ENERGY EFFICIENT.

* ELECTRICAL PLAN *

SCALE : 1/4" = 1'-0"

RESIDENCE
for
JOHN & PAULA
JEWETT

FLORIDA

Teresa M. Rufo
2925 SW 5R 41
Lake City Florida, 32025
Cell: (386) 861-1191
Email: terarufoc@gmail.com

PRINTED DATE:
Sunday, April 5, 2020

DRAWN BY:
Teresa M. Rufo
BUILDING CONTRACTOR
TRADEMARK CONST

FINALS DATE:

JOB NUMBER:

DRAWING NUMBER

A-6
OF 6 SHEETS