


SQUARE FOOTAGE:	
Heated Sq Ft	1457
Garage/Storage	465
Porches	304
TOTAL AREA	2226

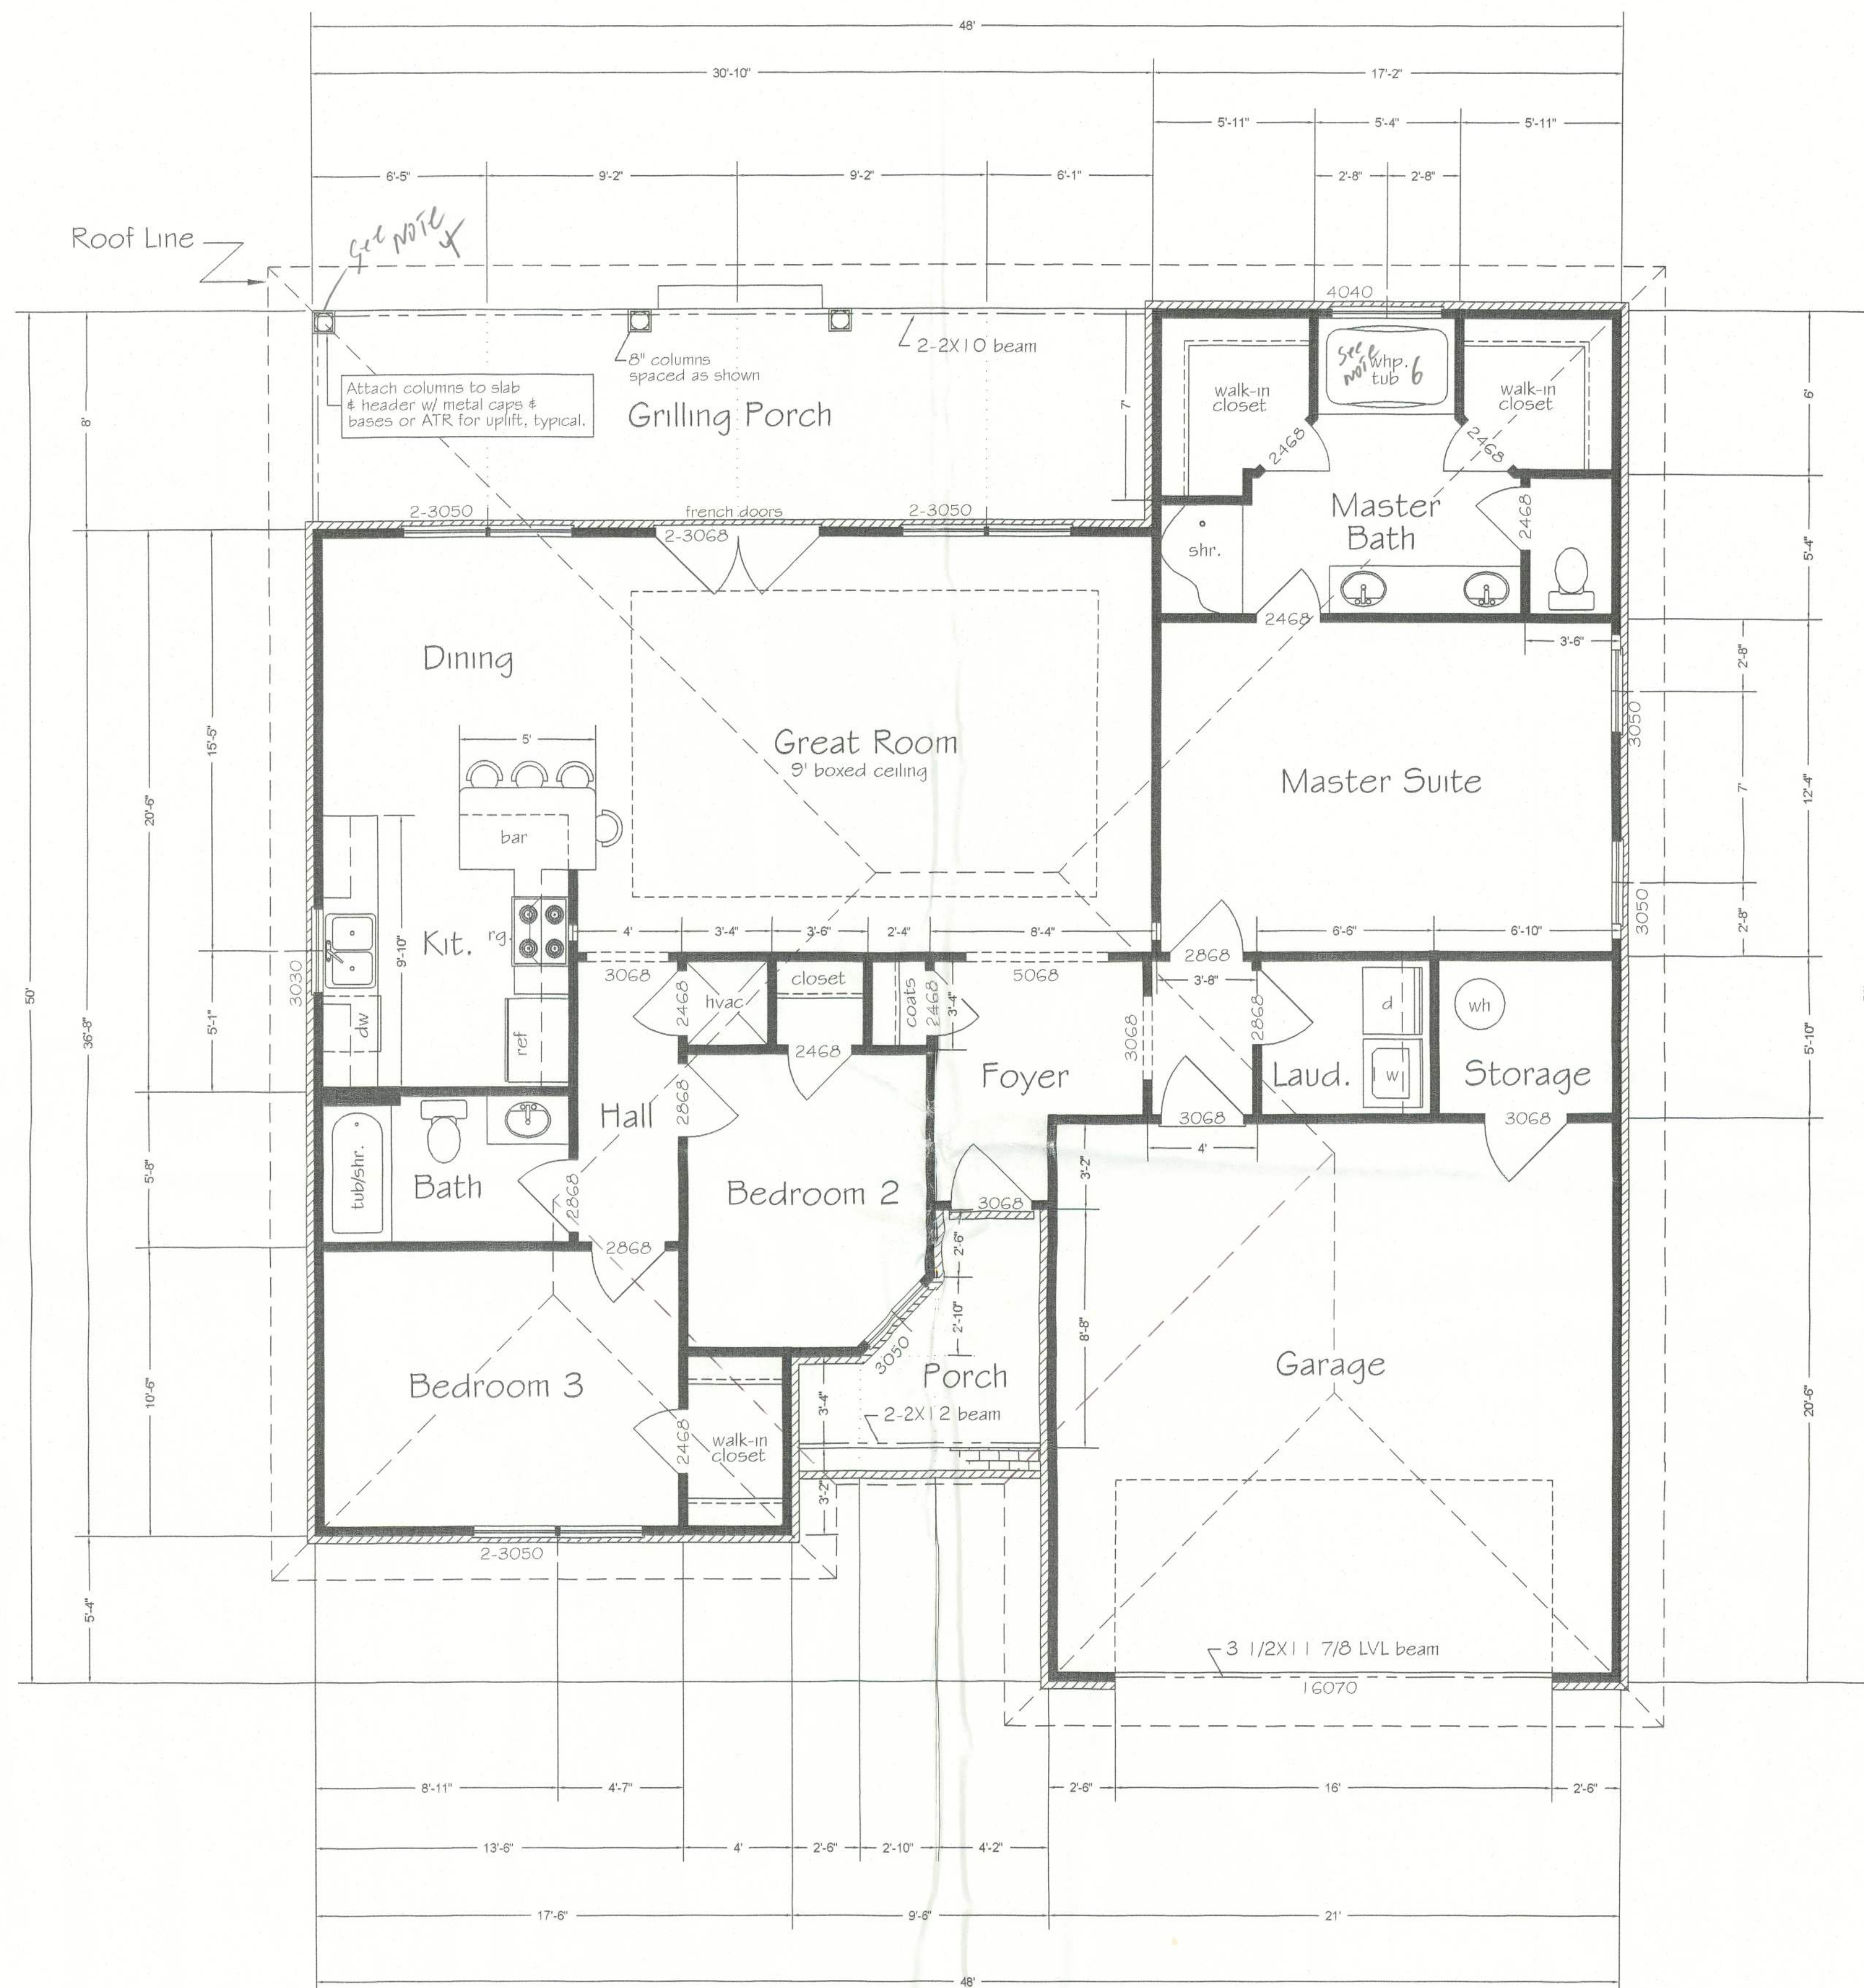

FLOOR PLAN

Scale - 1/4" = 1'

NOTES

1-CHECK ALL DIMENSIONS FOR ACCURACY PRIOR TO CONSTRUCTION.

2-ALL ELECTRICAL, PLUMBING AND MECHANICAL (HVAC) TO BE INSTALLED BY CURRENTLY LICENCED CONTRACTORS CONFORMING TO STATE AND LOCAL CODES WHERE APPLICABLE.

3-ENERGY CALCULATIONS TO BE PROVIDED BY MECHANICAL CONTRACTOR.

4-EXACT DESCRIPTION AND/OR SPECIFICATIONS NOT NOTED ON PLANS TO BE PROVIDED BY OWNER AND/OR CONTRACTOR.(DOORS, WINDOWS, ETC.)

5-ALL CONSTRUCTION MUST CONFORM TO CURRENT STATE AND LOCAL CODES WHERE APPLICABLE.



114-B WEST GREEN STREET
PERRY, FLORIDA 32347
TEL: (850) 584-4408
FAX: (850) 223-1552

CERTIFICATION

WINDLOAD CERTIFICATION:
THESE PLANS WILL COMPLY WITH THE FLORIDA BUILDING CODE FOR A 100 MILE PER HOUR WINDLOAD (THREE SECOND INTERVAL)

John K. Gentry
9-2-05

John K. Gentry, P.E. # 16990
Engineering Business # 25890

PREPARED FOR:
Plumb Level Construction
Columbia County, Florida

PREPARED BY:
COOPER DESIGNS
Jodi Cooper
1772 N.E. CHERVIL DRIVE
LEE, FLORIDA 32059
850-971-5607
E-MAIL: mijocooper@vol.com

PROJECT
FLOOR PLAN
ROOF LINE

DATE August 25, 2005

PROJECT # 05-073

2 SHEET OF 4