



Benson Residence

By Blake Construction

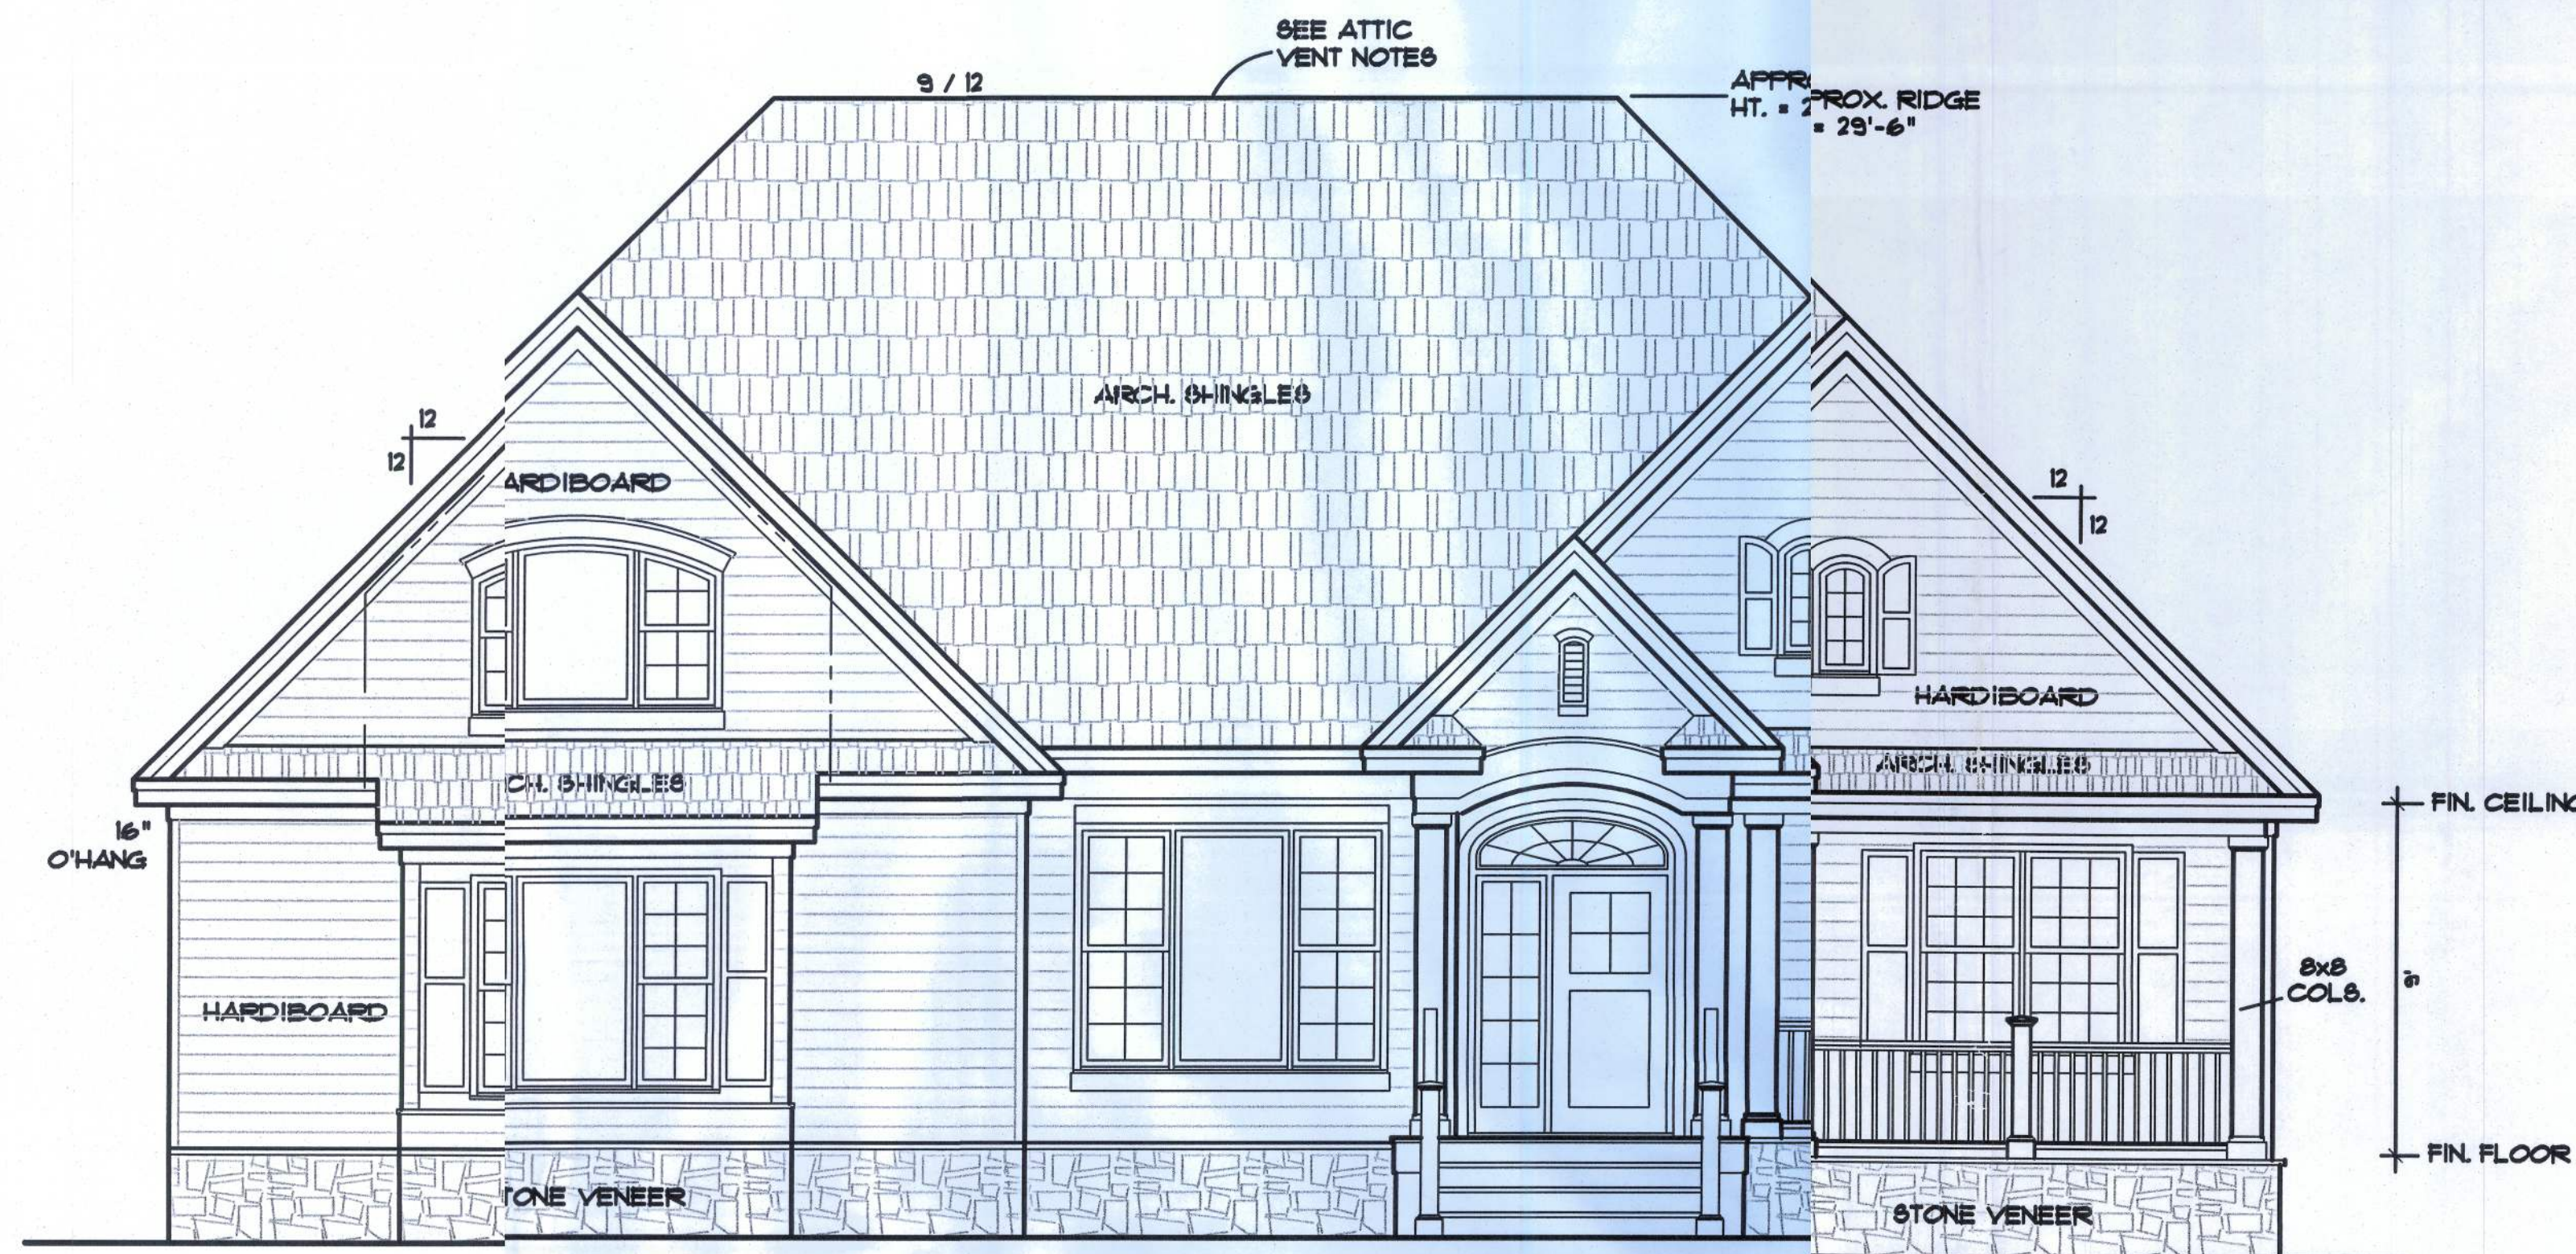


FRONT ELEVATION

SCALE: 1/4 IN. = 1 FT.

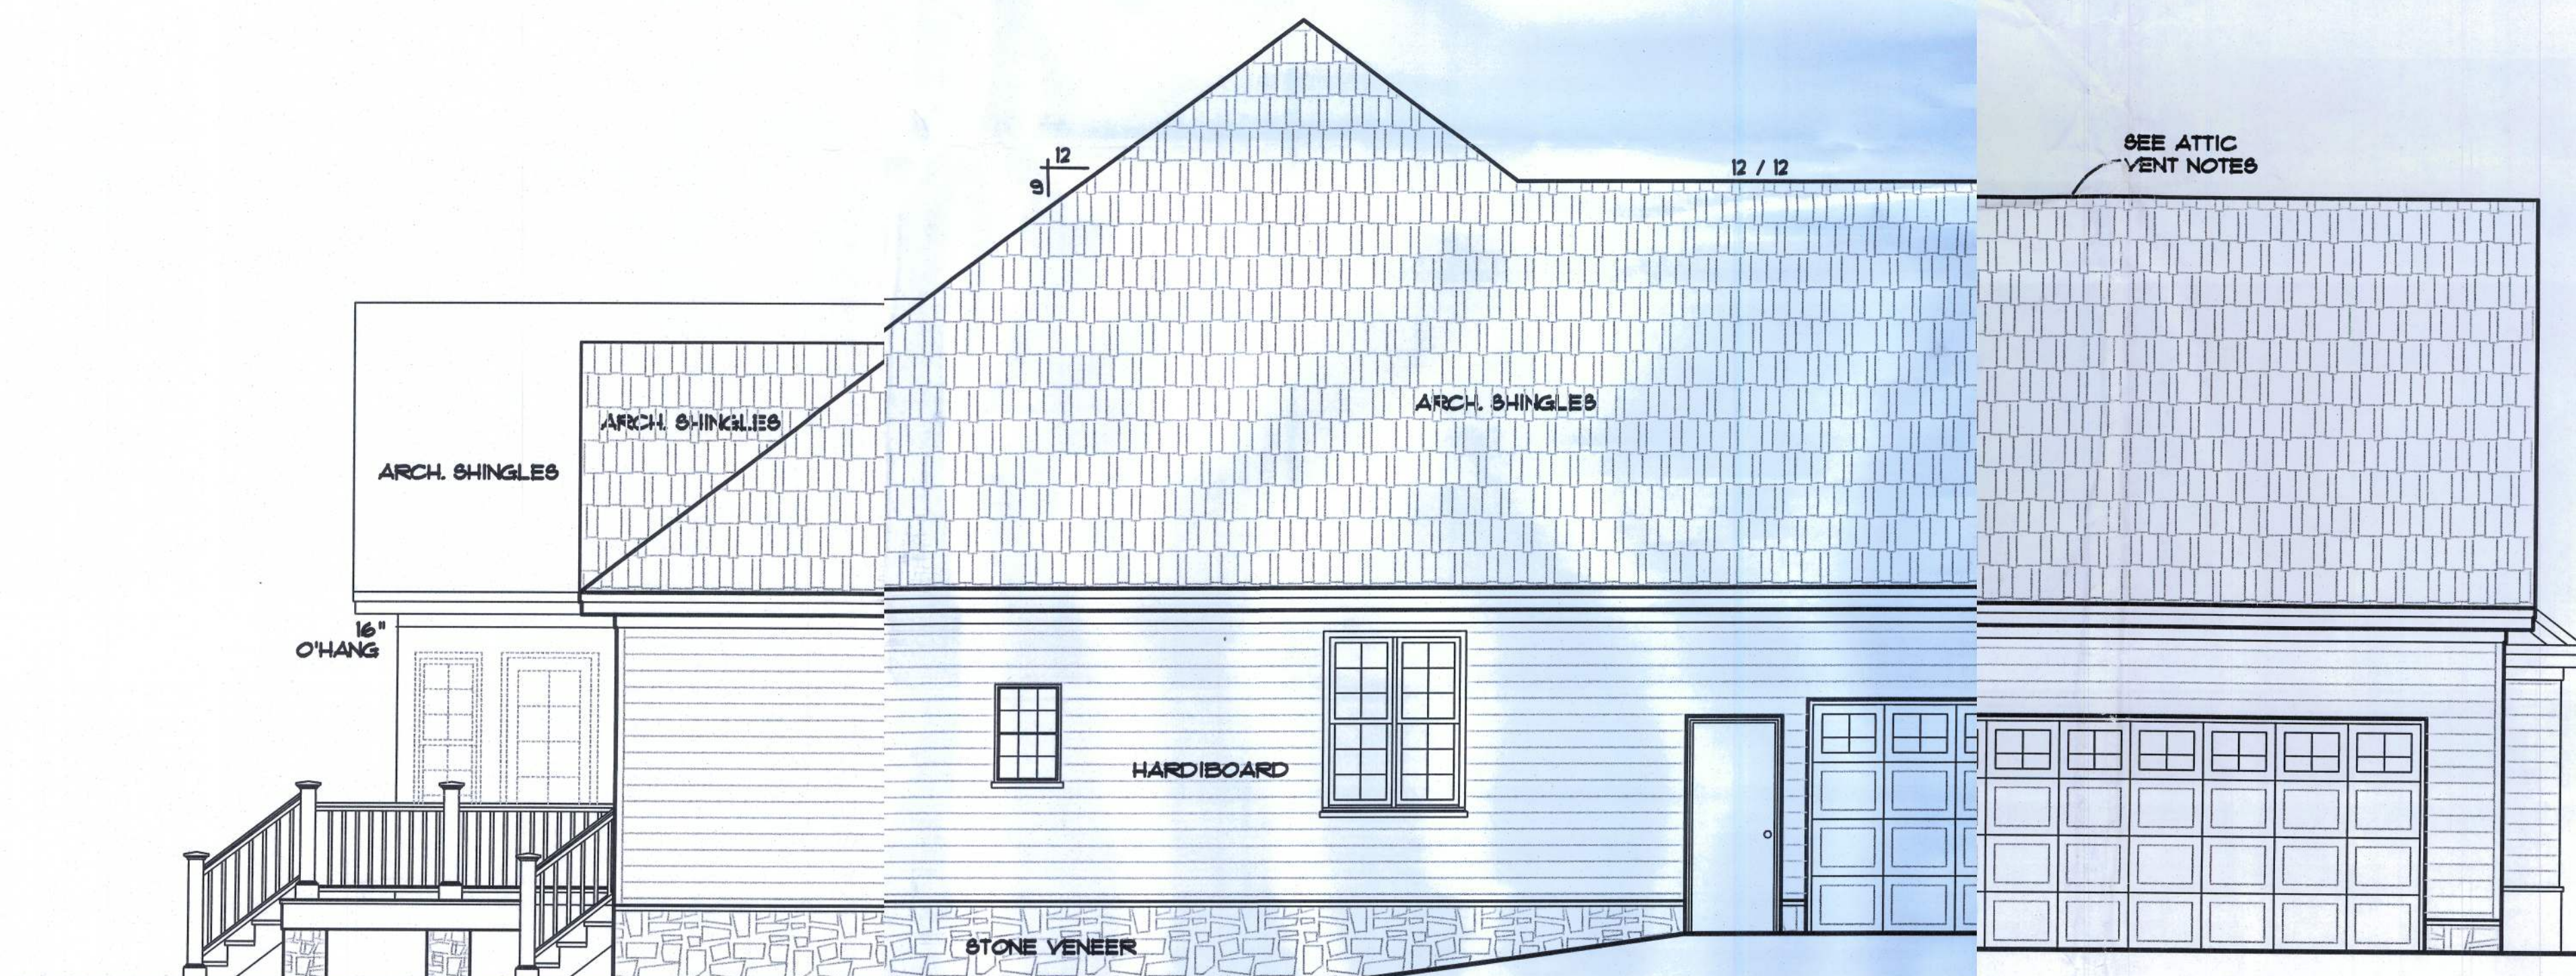

LEFT ELEVATION


SCALE: 1/4 IN. = 1 FT.

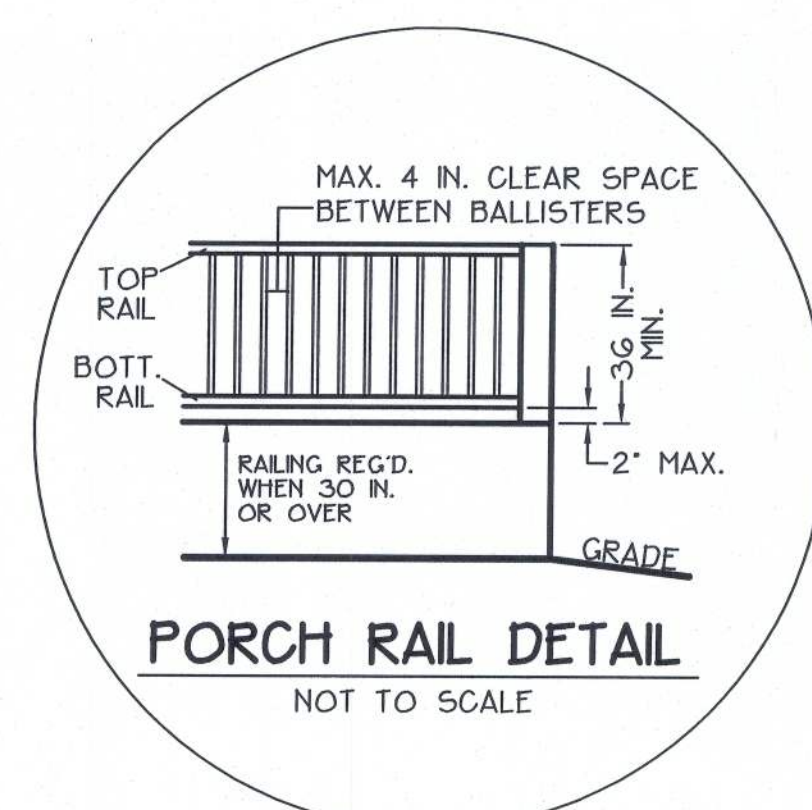

ATTIC VENTILATION

Enclosed attics and enclosed rafter spaces formed where ceilings are applied directly to the underside of roof rafters shall have cross ventilation for each separate space by ventilating openings protected against the entrance of rain. Ventilating openings shall be provided with corrosion-resistant wire mesh, with a 1/8 inch (3.2 mm) minimum to 1/4 inch (6.4 mm) maximum openings.

The total net free ventilating area shall not be less than 1 to 150 of the area of the space ventilated except that the total area is permitted to be reduced to 1 to 300, provided at least 50 percent and not more than 80 percent of the required ventilating area is provided by ventilators located in the upper portion of the space to be ventilated at least 3 feet (914 mm) above eave or cornice vents with the balance of the required ventilation provided by eave or cornice vents.

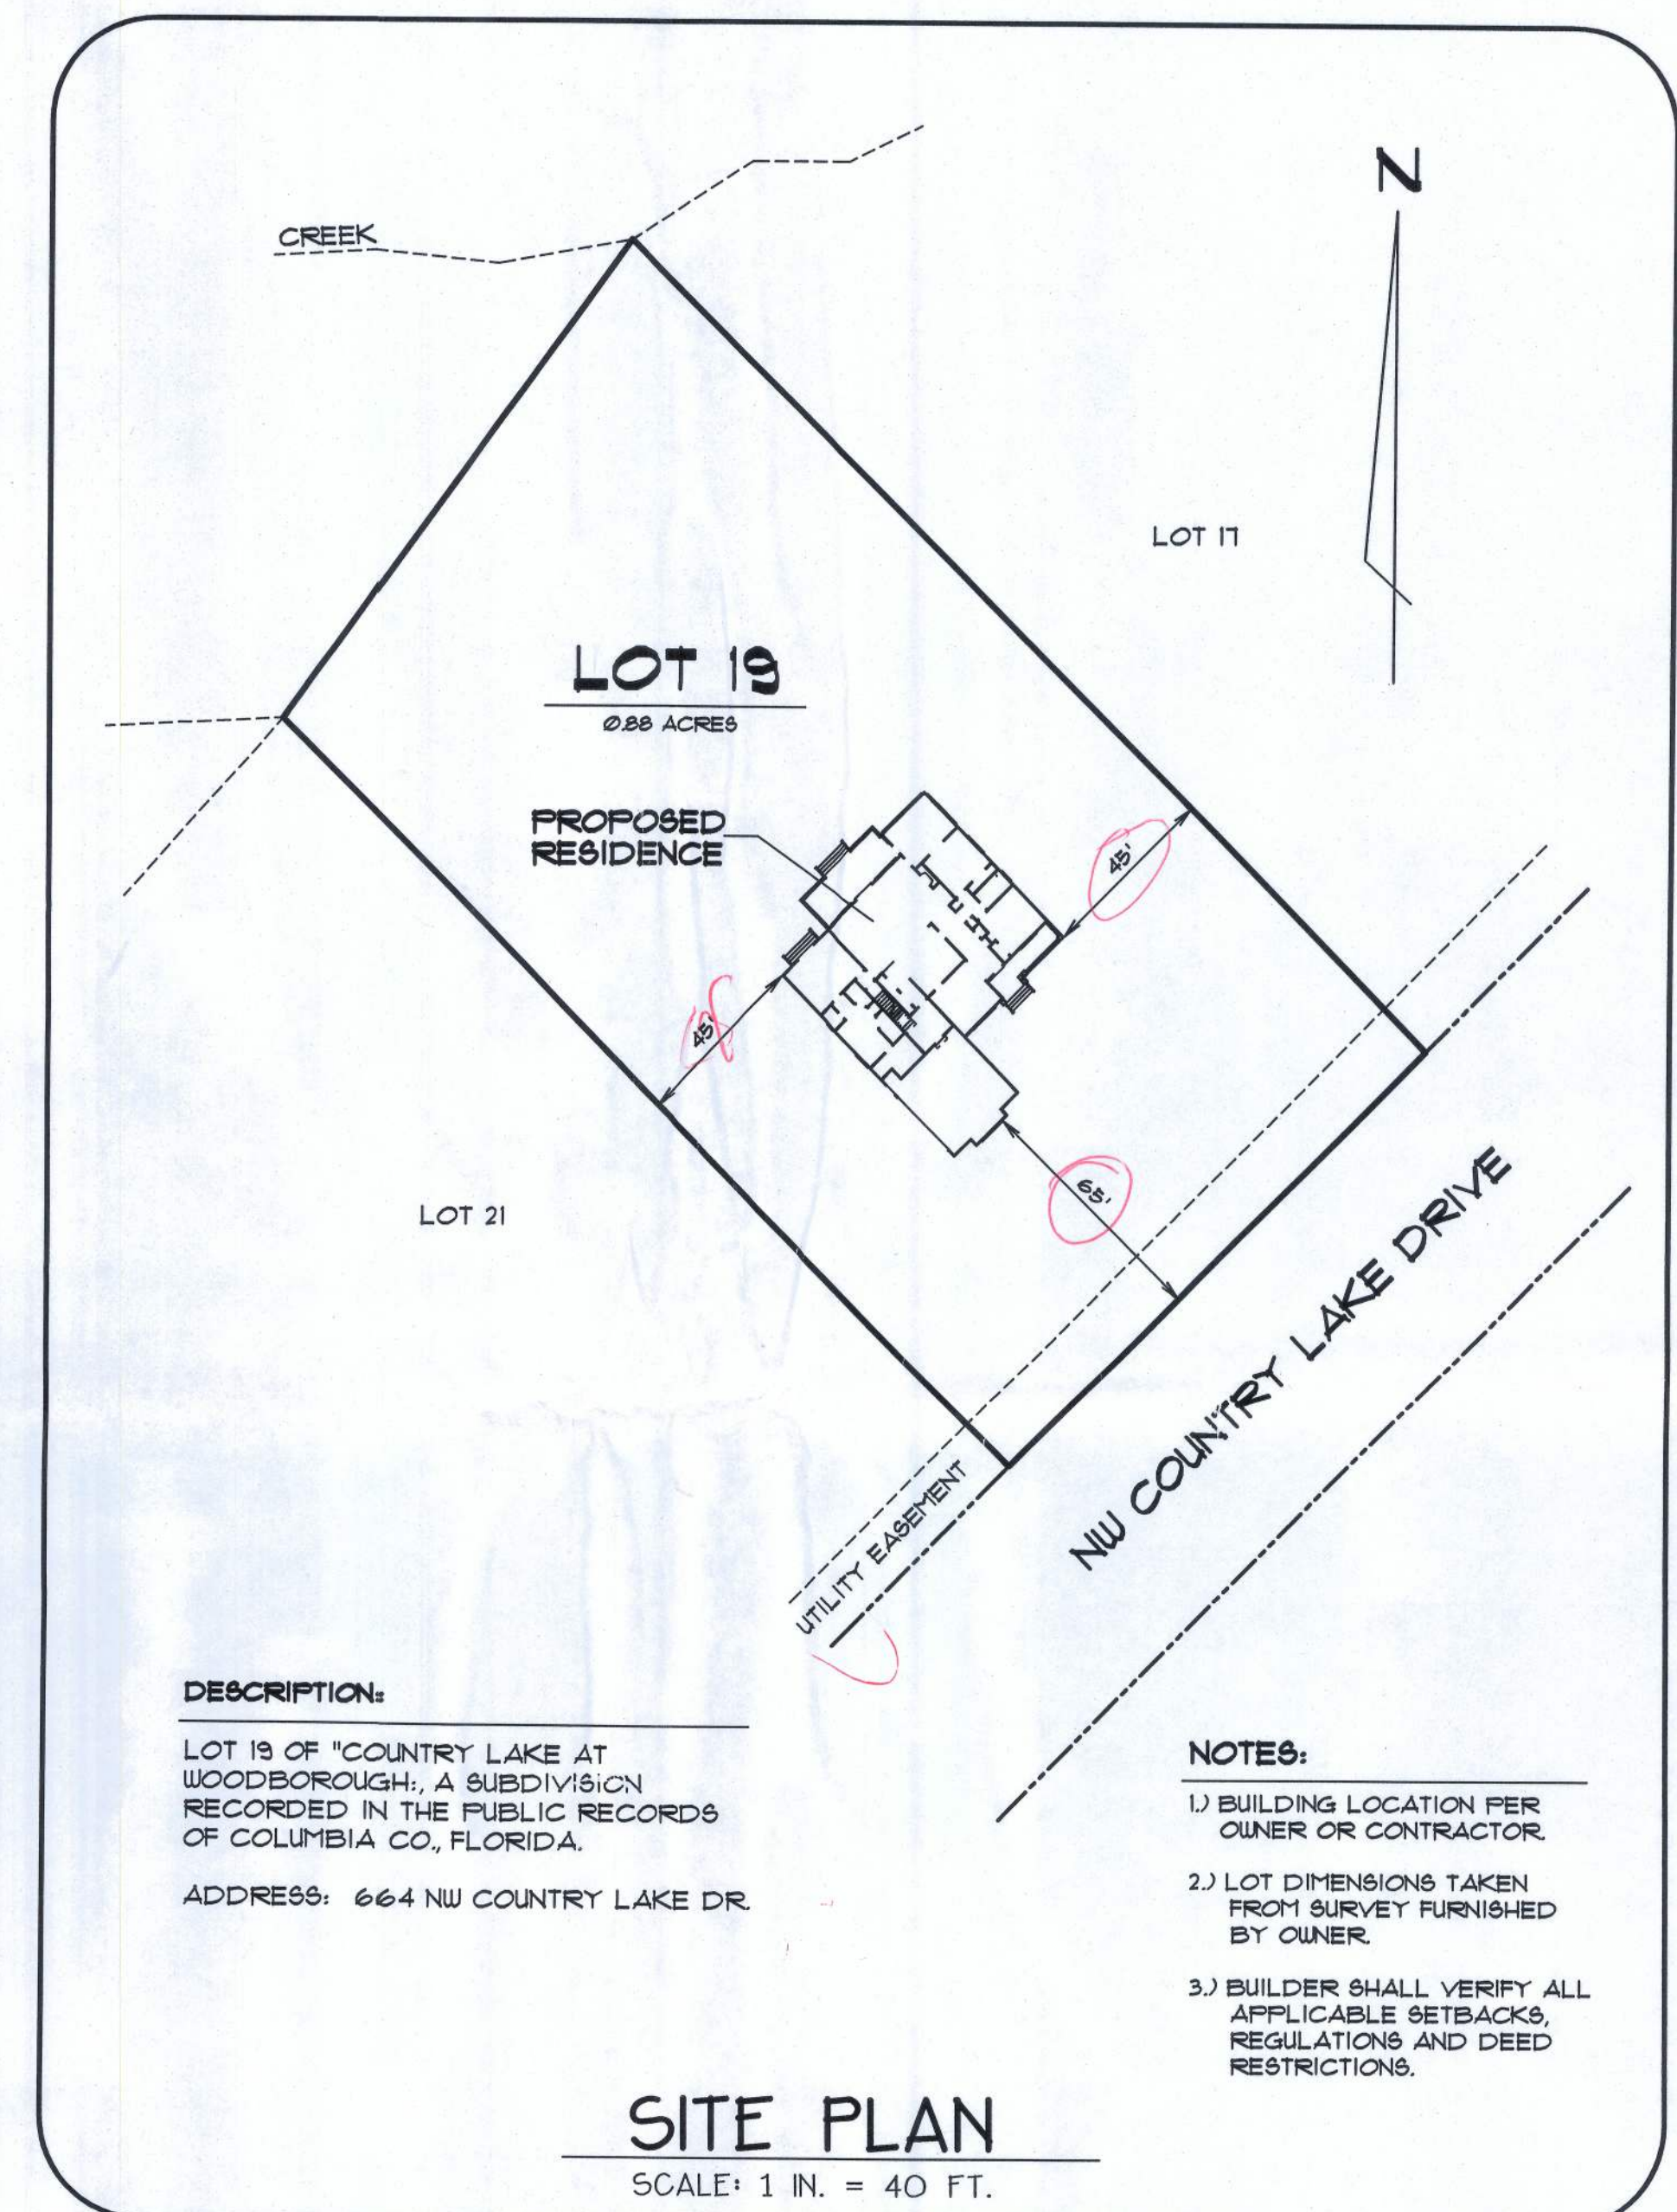

DESCRIPTION:

LOT 19 OF "COUNTRY LAKE AT WOODBOROUGH", A SUBDIVISION RECORDED IN THE PUBLIC RECORDS OF COLUMBIA CO, FLORIDA.

ADDRESS: 664 NW COUNTRY LAKE DR.

NOTES:

- 1) BUILDING LOCATION PER OWNER OR CONTRACTOR.
- 2) LOT DIMENSIONS TAKEN FROM SURVEY FURNISHED BY OWNER.
- 3) BUILDER SHALL VERIFY ALL APPLICABLE SETBACKS, REGULATIONS AND DEED RESTRICTIONS.

SITE PLAN

SCALE: 1 IN. = 40 FT.

Index to Sheets

SHEET A-1	-----	SITE PLAN + ELEVATIONS
SHEET A-2	-----	ELEVATIONS
SHEET A-3	-----	FLOOR PLAN + GEN. NOTES
SHEET A-4	-----	FOUNDATION + SECTIONS
SHEET A-5	-----	ELECTRICAL
SHEET S-1	-----	WIND ENGINEERING

WINDLOAD ENGINEER: Mark Disoway, PE No.53915, POB 868, Lake City, FL 32056, 386-754-5419

CERTIFICATION: These plans and "Windload Engineering", Sheet S-1, attached, comply with Florida Building Code Residential 2004, Section R301.2.1 to the best of my knowledge.

LIMITATION: This design is valid for one building, at specified location, permitted within 90 days of signature date. In case of conflict, structural requirements, scope of work, and builder responsibilities on sheet S-1 control.


664 NW COUNTRY LAKE DR.
LAKE CITY, FL 32055

Location: _____ Job No.: _____




A-1

FILE: 11-003	BENSON RESIDENCE	SHEET: 1 OF 5
DATE: 3-1-11		CAD FILE: 11003
DRAWN: T A D	PREPARED BY: TIM DELBENE Drafting + Technical Services 192 SW Sagewood Gln. Lake City, FL 32024 Phone (386) 755-5891	REV:
CHECK: T A D		REV:

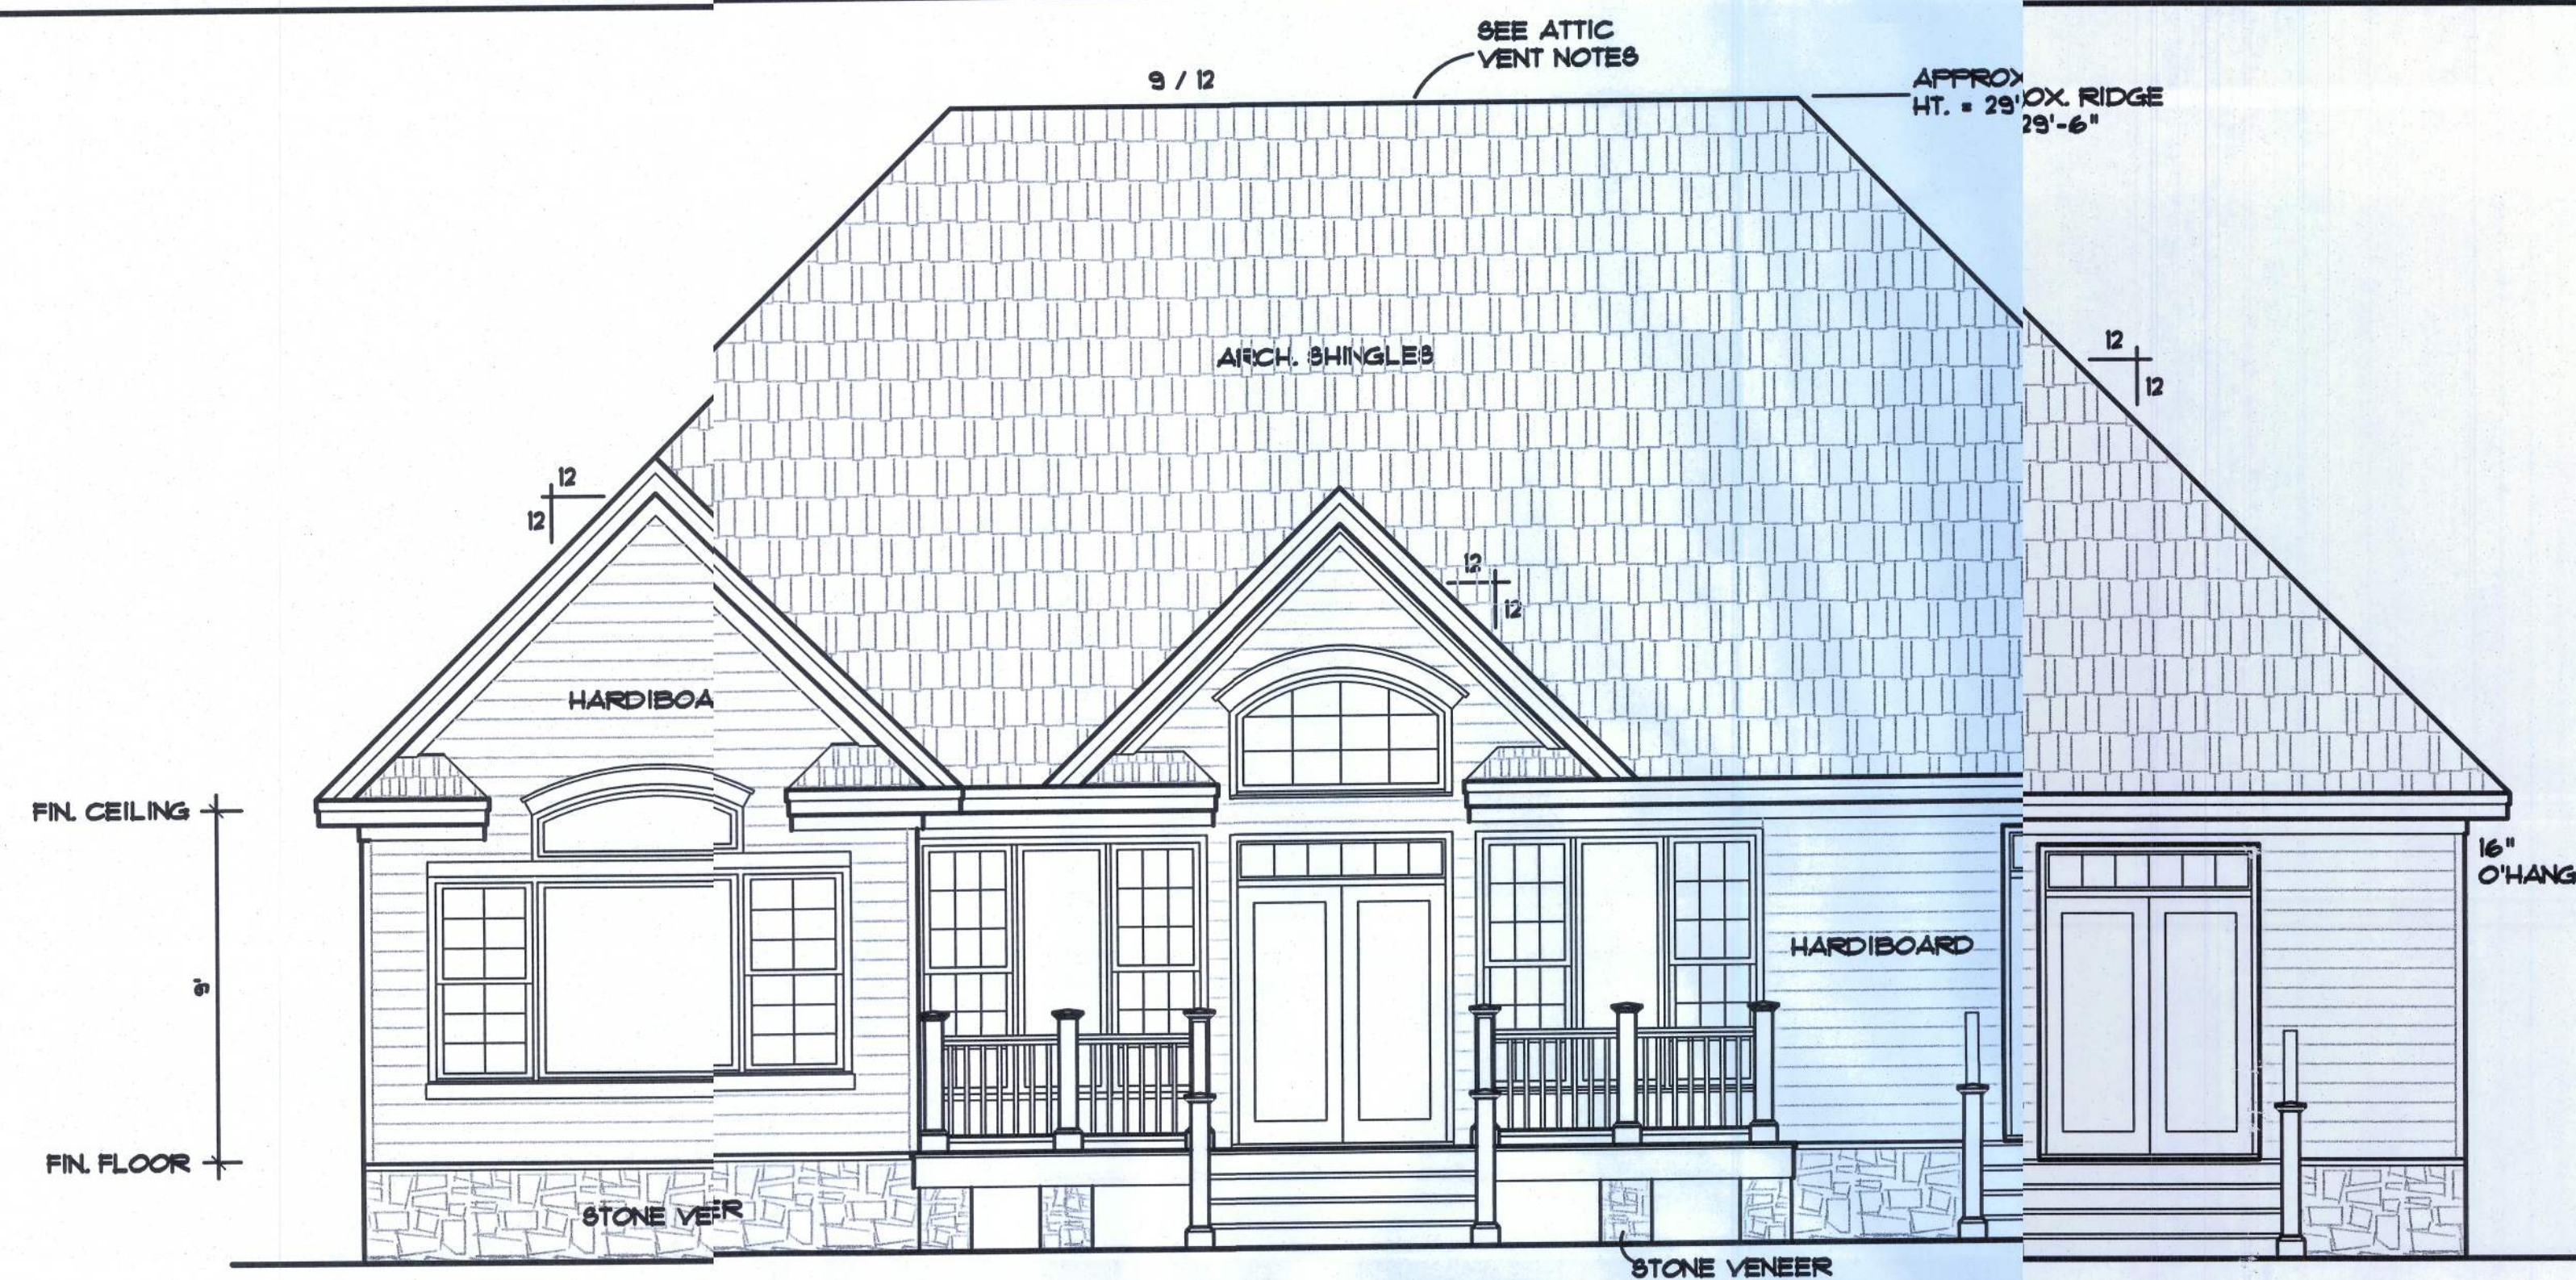

REAR ELEVATION
SCALE: 1/4 IN. = 1 FT.

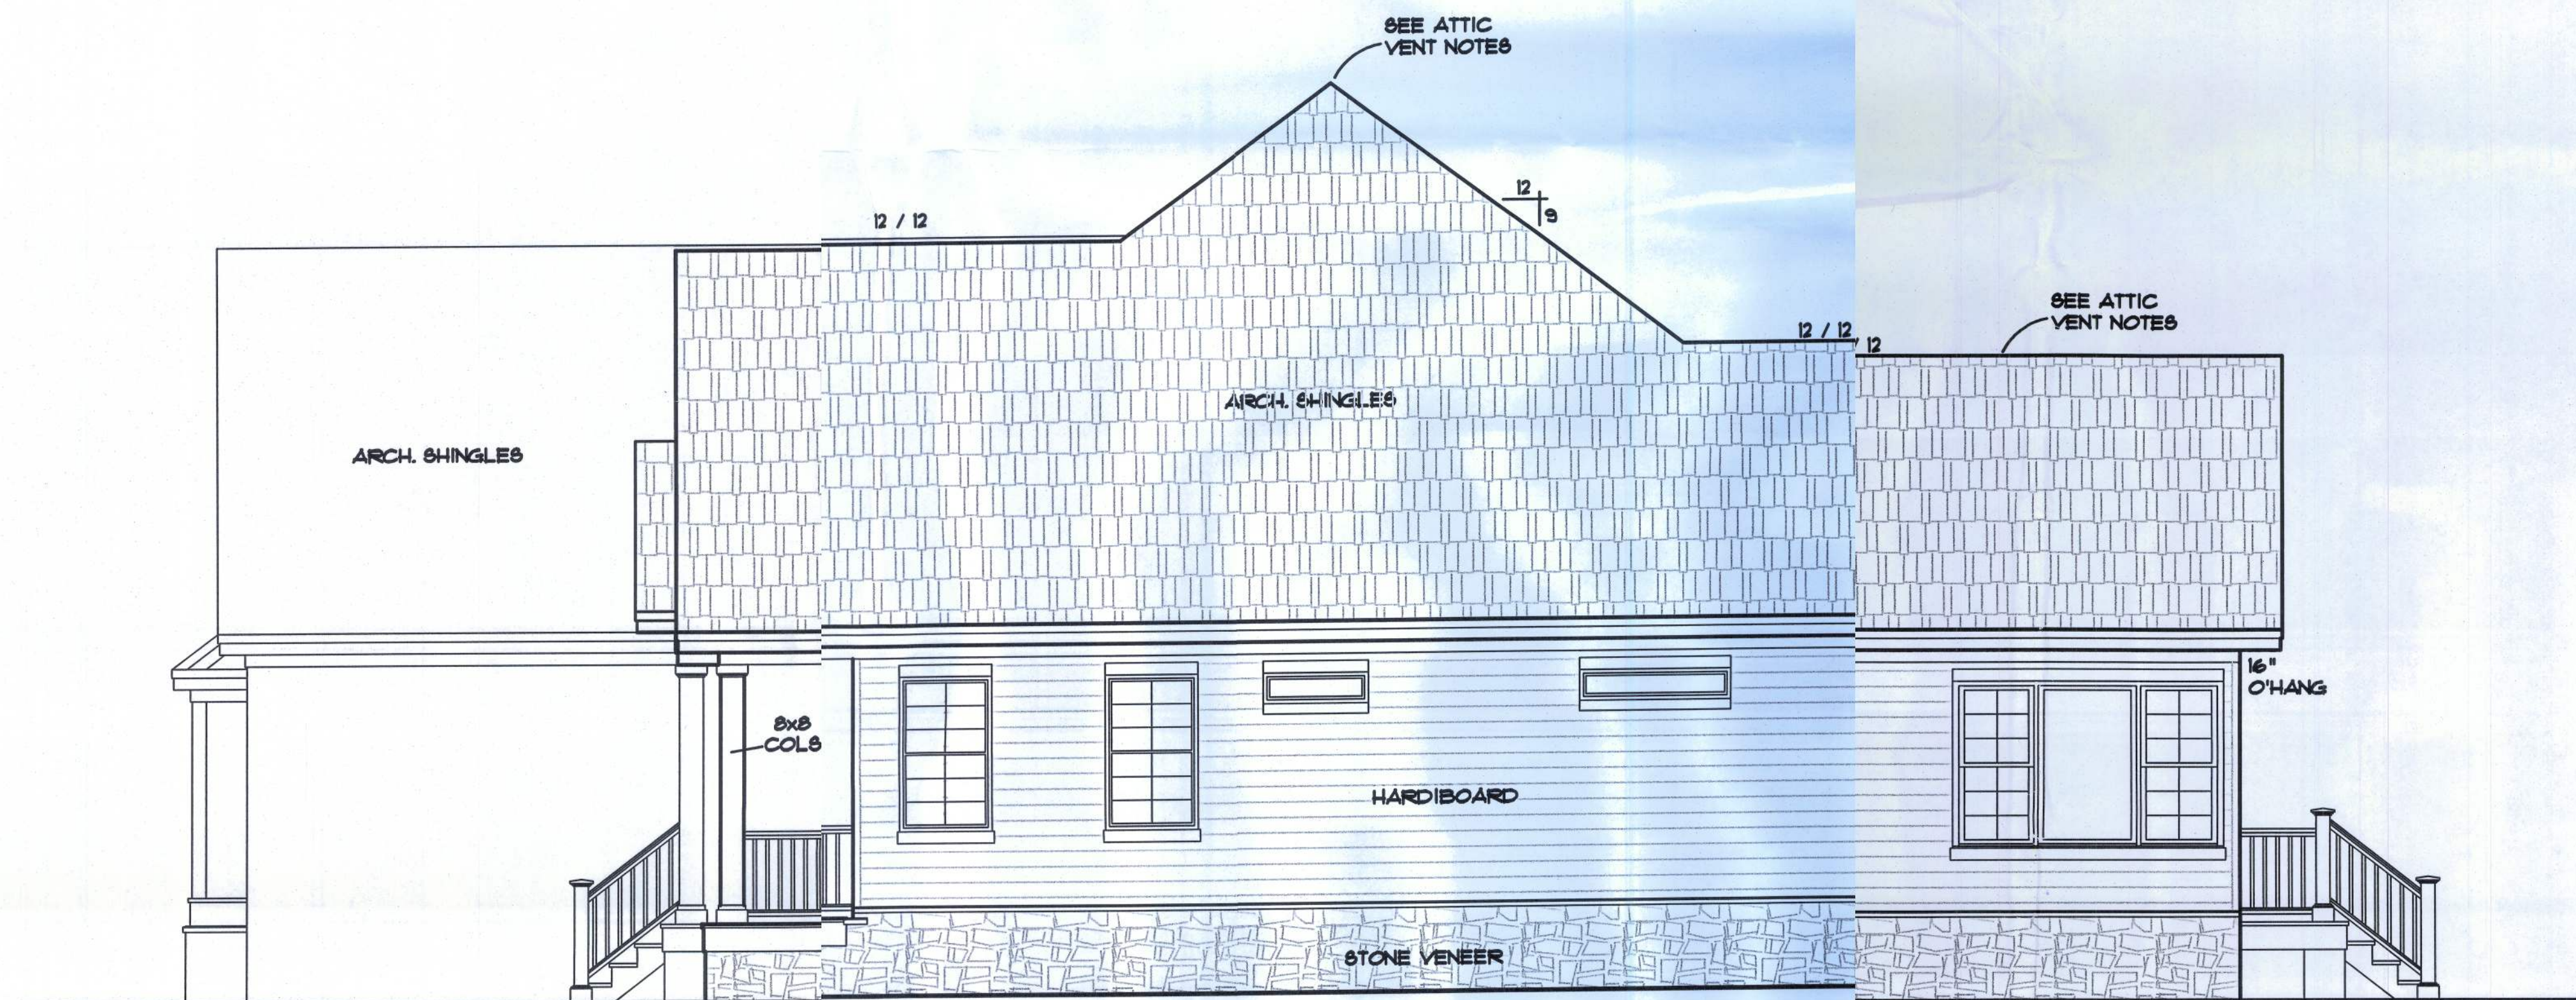


RIGHT ELEVATION
SCALE: 1/4 IN. = 1 FT.

ATTIC VENTILATION


Enclosed attics and enclosed rafter spaces formed w^o ceilings are applied directly to the underside of roof rafters shall've cross ventilation for each separate space by ventilating op^s protected against the entrance of rain. Ventilating openings sh^de provided with corrosion-resistant wire mesh, wit h 1 / 8 inch (3.2m) minimum to 1/4 inch (6.4 mm) maximum openings.

The total net free ventilating area shall not be less n 1 to 150 of the area of the space ventilated except that the total ar is permitted to be reduced to 1 to 300, provided at least 50 percent a not more than 80 percent of the required ventilating area is provided pentilators located in the upper portion of the space to be ventilated a ast 3 feet (914 mm) above eave or cornice vents with the balance che required ventilation provided by eave or cornice vents.

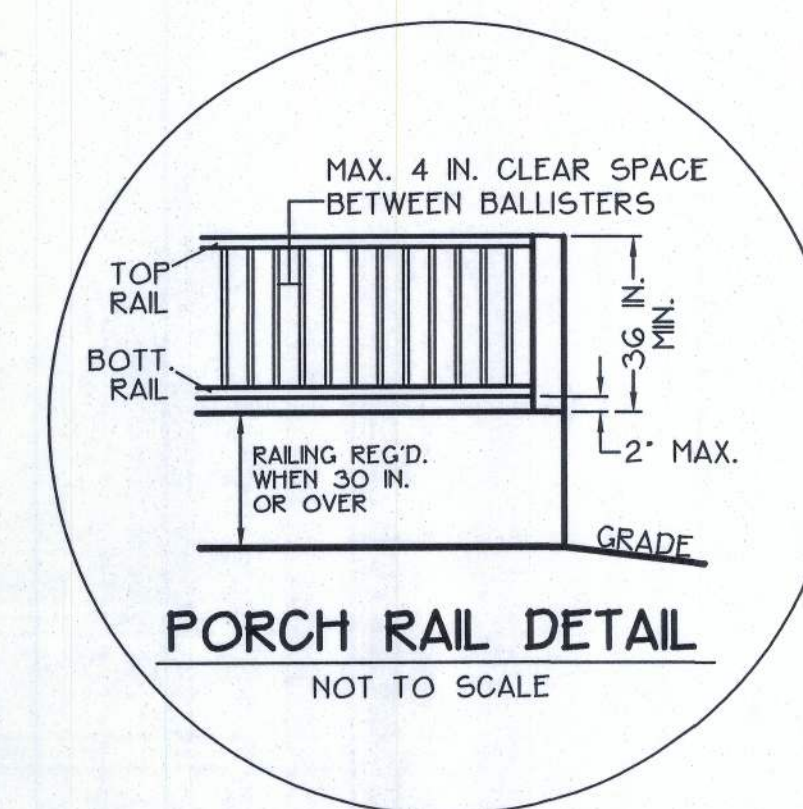

GENERAL NOTES

- 1.) See "Wind Load Detail Sheet S-1" and Wind Engineer's Notes for data pertaining to Wind Design and compliance w/ Florida Building Code.
- 2.) All concrete used to be 2500 PSI strength or greater.
- 3.) HVAC duct and unit size/design is by engineered shop drawings from the AC contractor.
- 4.) Windows to be alum. framed and double glazed. Sizes shown are nominal and may vary with manufacturer.
- 5.) Roof Truss design is the responsibility of the supplier.
- 6.) The Truss Manufacturer shall prepare Shop Drawings indicating Truss placement, Girder locations, Truss-to-Truss Connections and any point loads. The Contractor shall notify the Designer of any point loads in excess of 2.0k for Fnd. Modification.
- 7.) Site analysis or preparation information is not a part of this plan and is the responsibility of the owner.
- 8.) Cabinet and millwork detail is not a part of this plan. The plan is a general design and details shall be the responsibility of the owner and/or contractor.

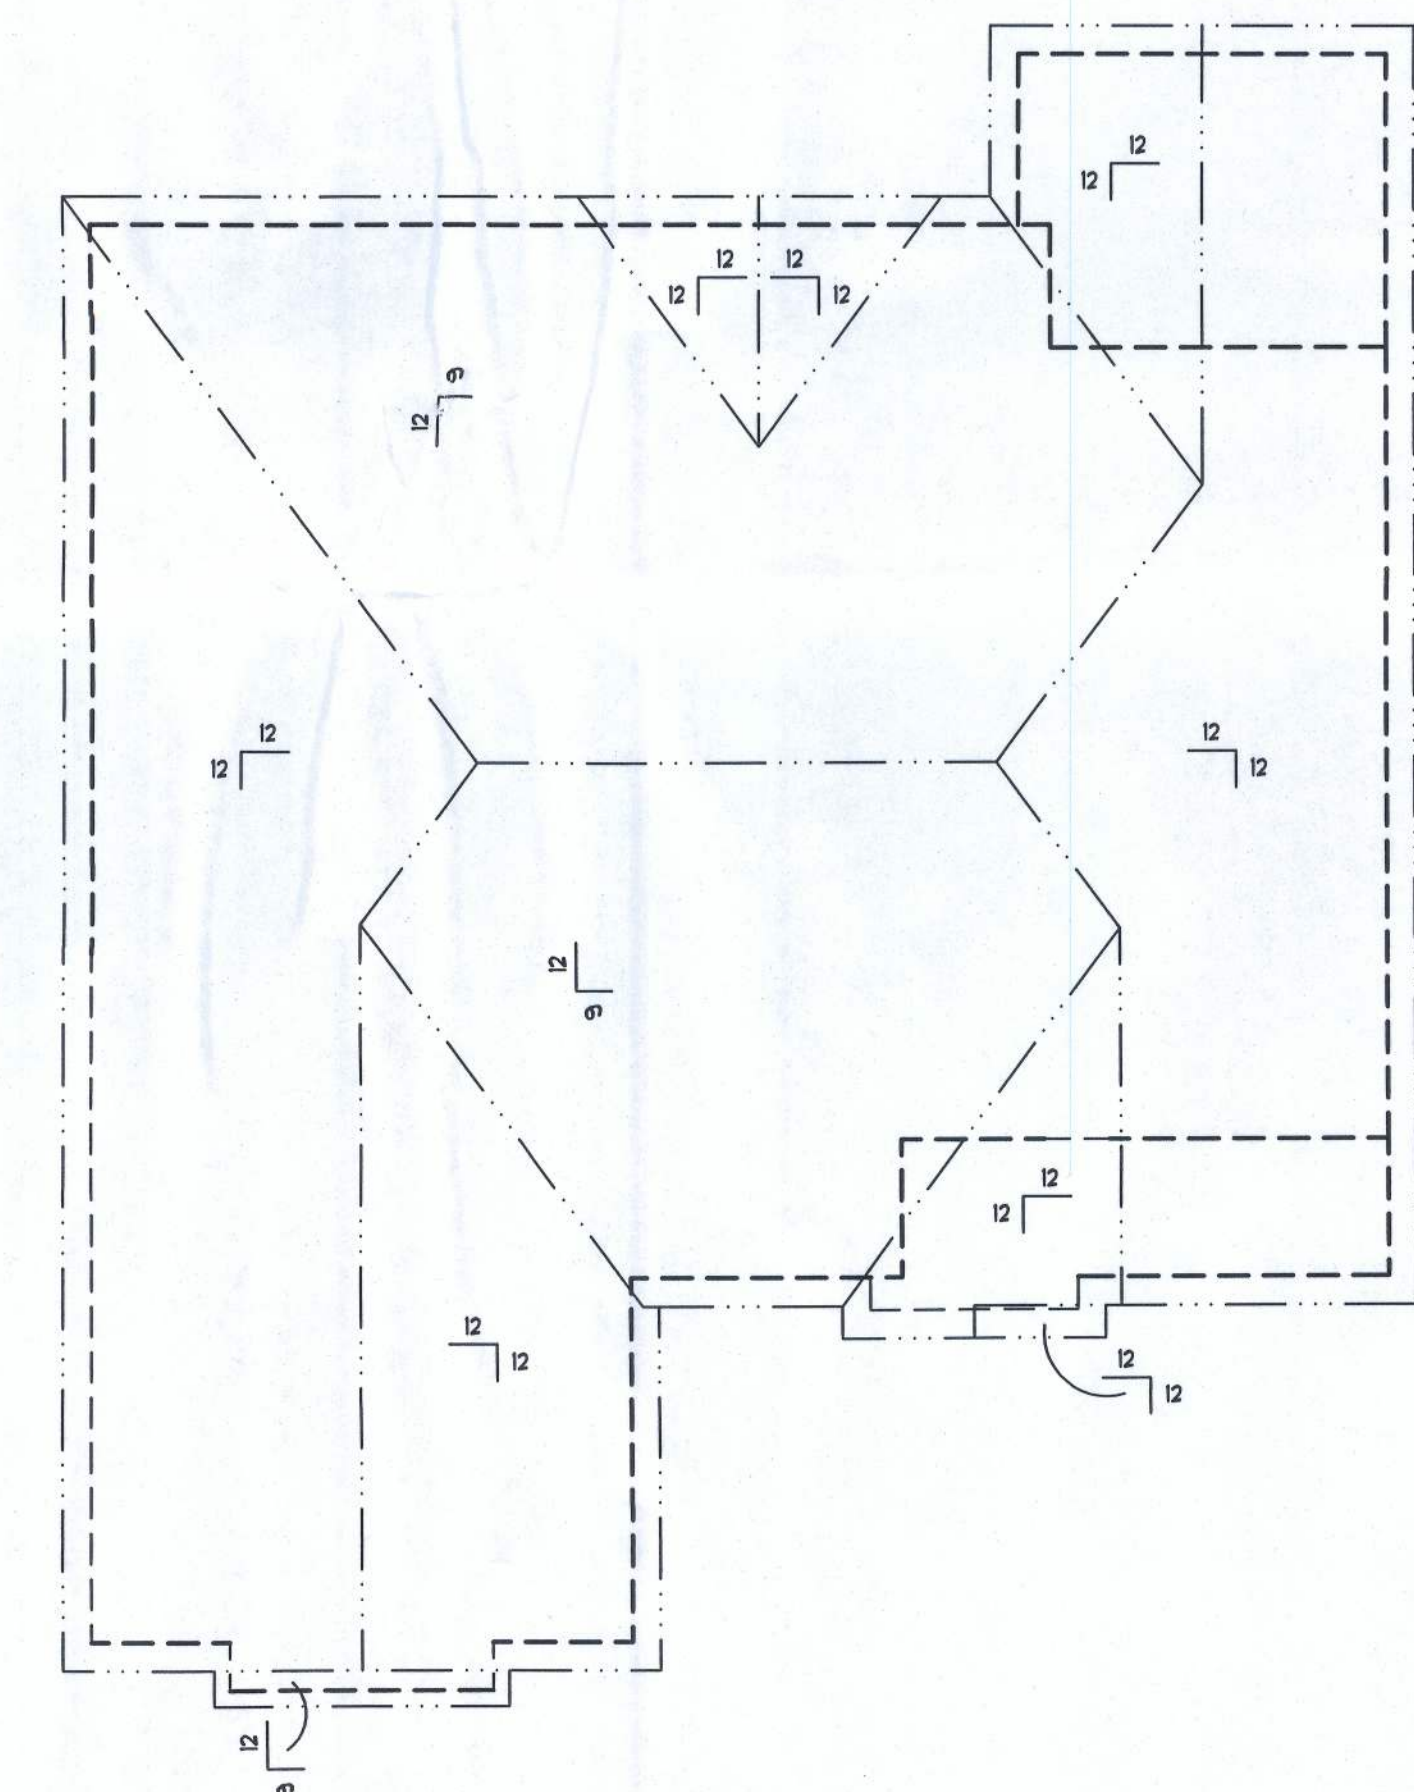

ROOF PLAN
NOT TO SCALE

A-2

WINDLOAD ENGINEER: Mark Disoway, PE No.53915, POB 868, Lake City, FL 32056, 386-754-5419




CERTIFICATION: These plans and "Windload Engineering", Sheet S-1, attached, comply with Florida Building Code Residential 2004, Section R301.2.1 to the best of my knowledge.

LIMITATION: This design is valid for one building, at specified location, permitted within 90 days of signature date. In case of conflict, structural requirements, scope of work, and builder responsibilities on sheet S-1 control.


664 NW COUNTRY LAKE DR.
LAKE CITY, FL 32055

Location: _____ Job No.: _____


FILE: 11-003	BENSON RESIDENCE	SHEET: 2 OF 5
DATE: 3-1-11		CAD FILE: 11003
DRAWN: T A D	PREPARED BY: TIM DELBENE Drafting + Technical Services	REV:
CHECK: T A D	192 SW Sagewood Cir. Lake City, FL 32024 Phone C 386 J 755-5891	REV:

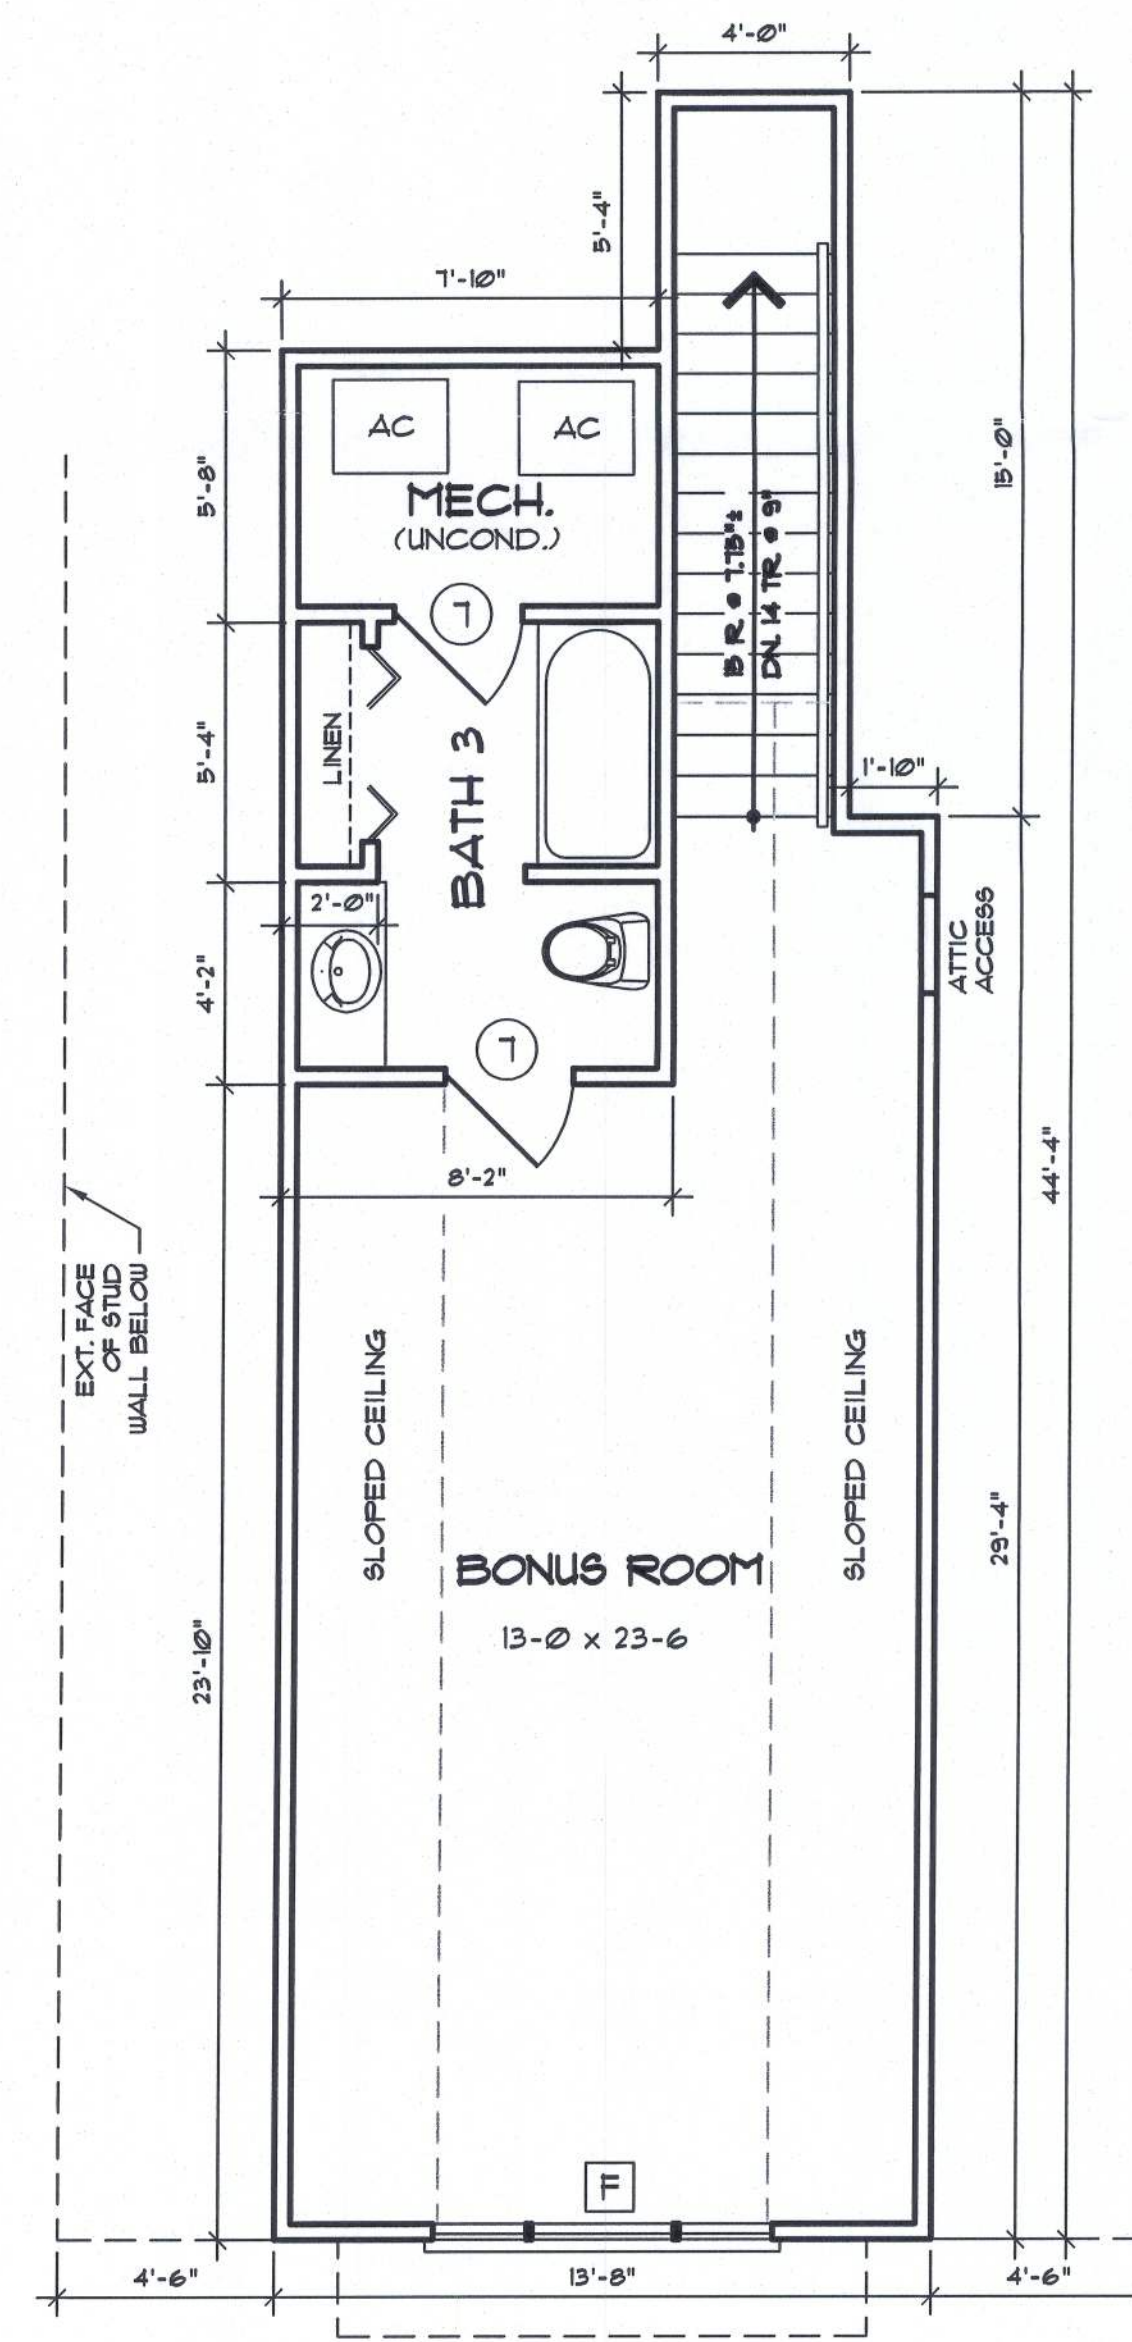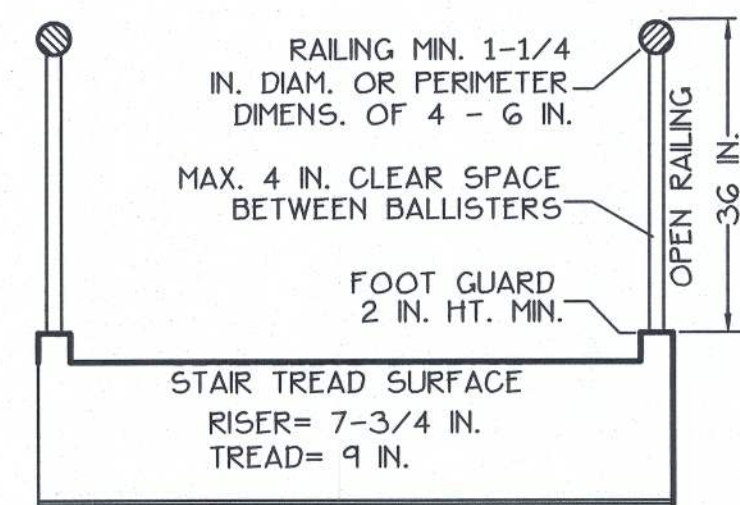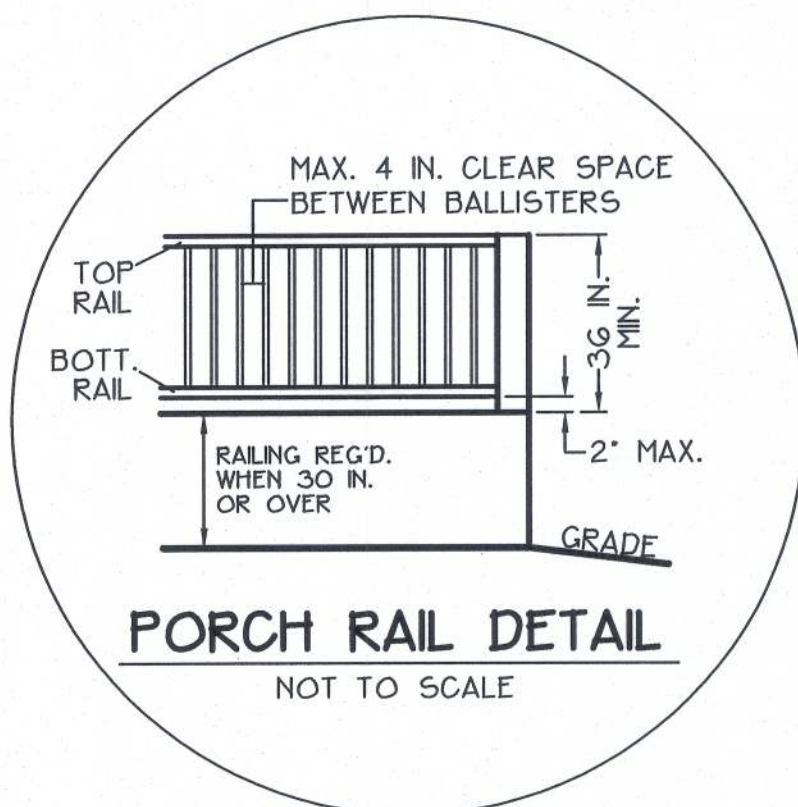

BONUS ROOM
SCALE: 1/4 IN. = 1 FT.

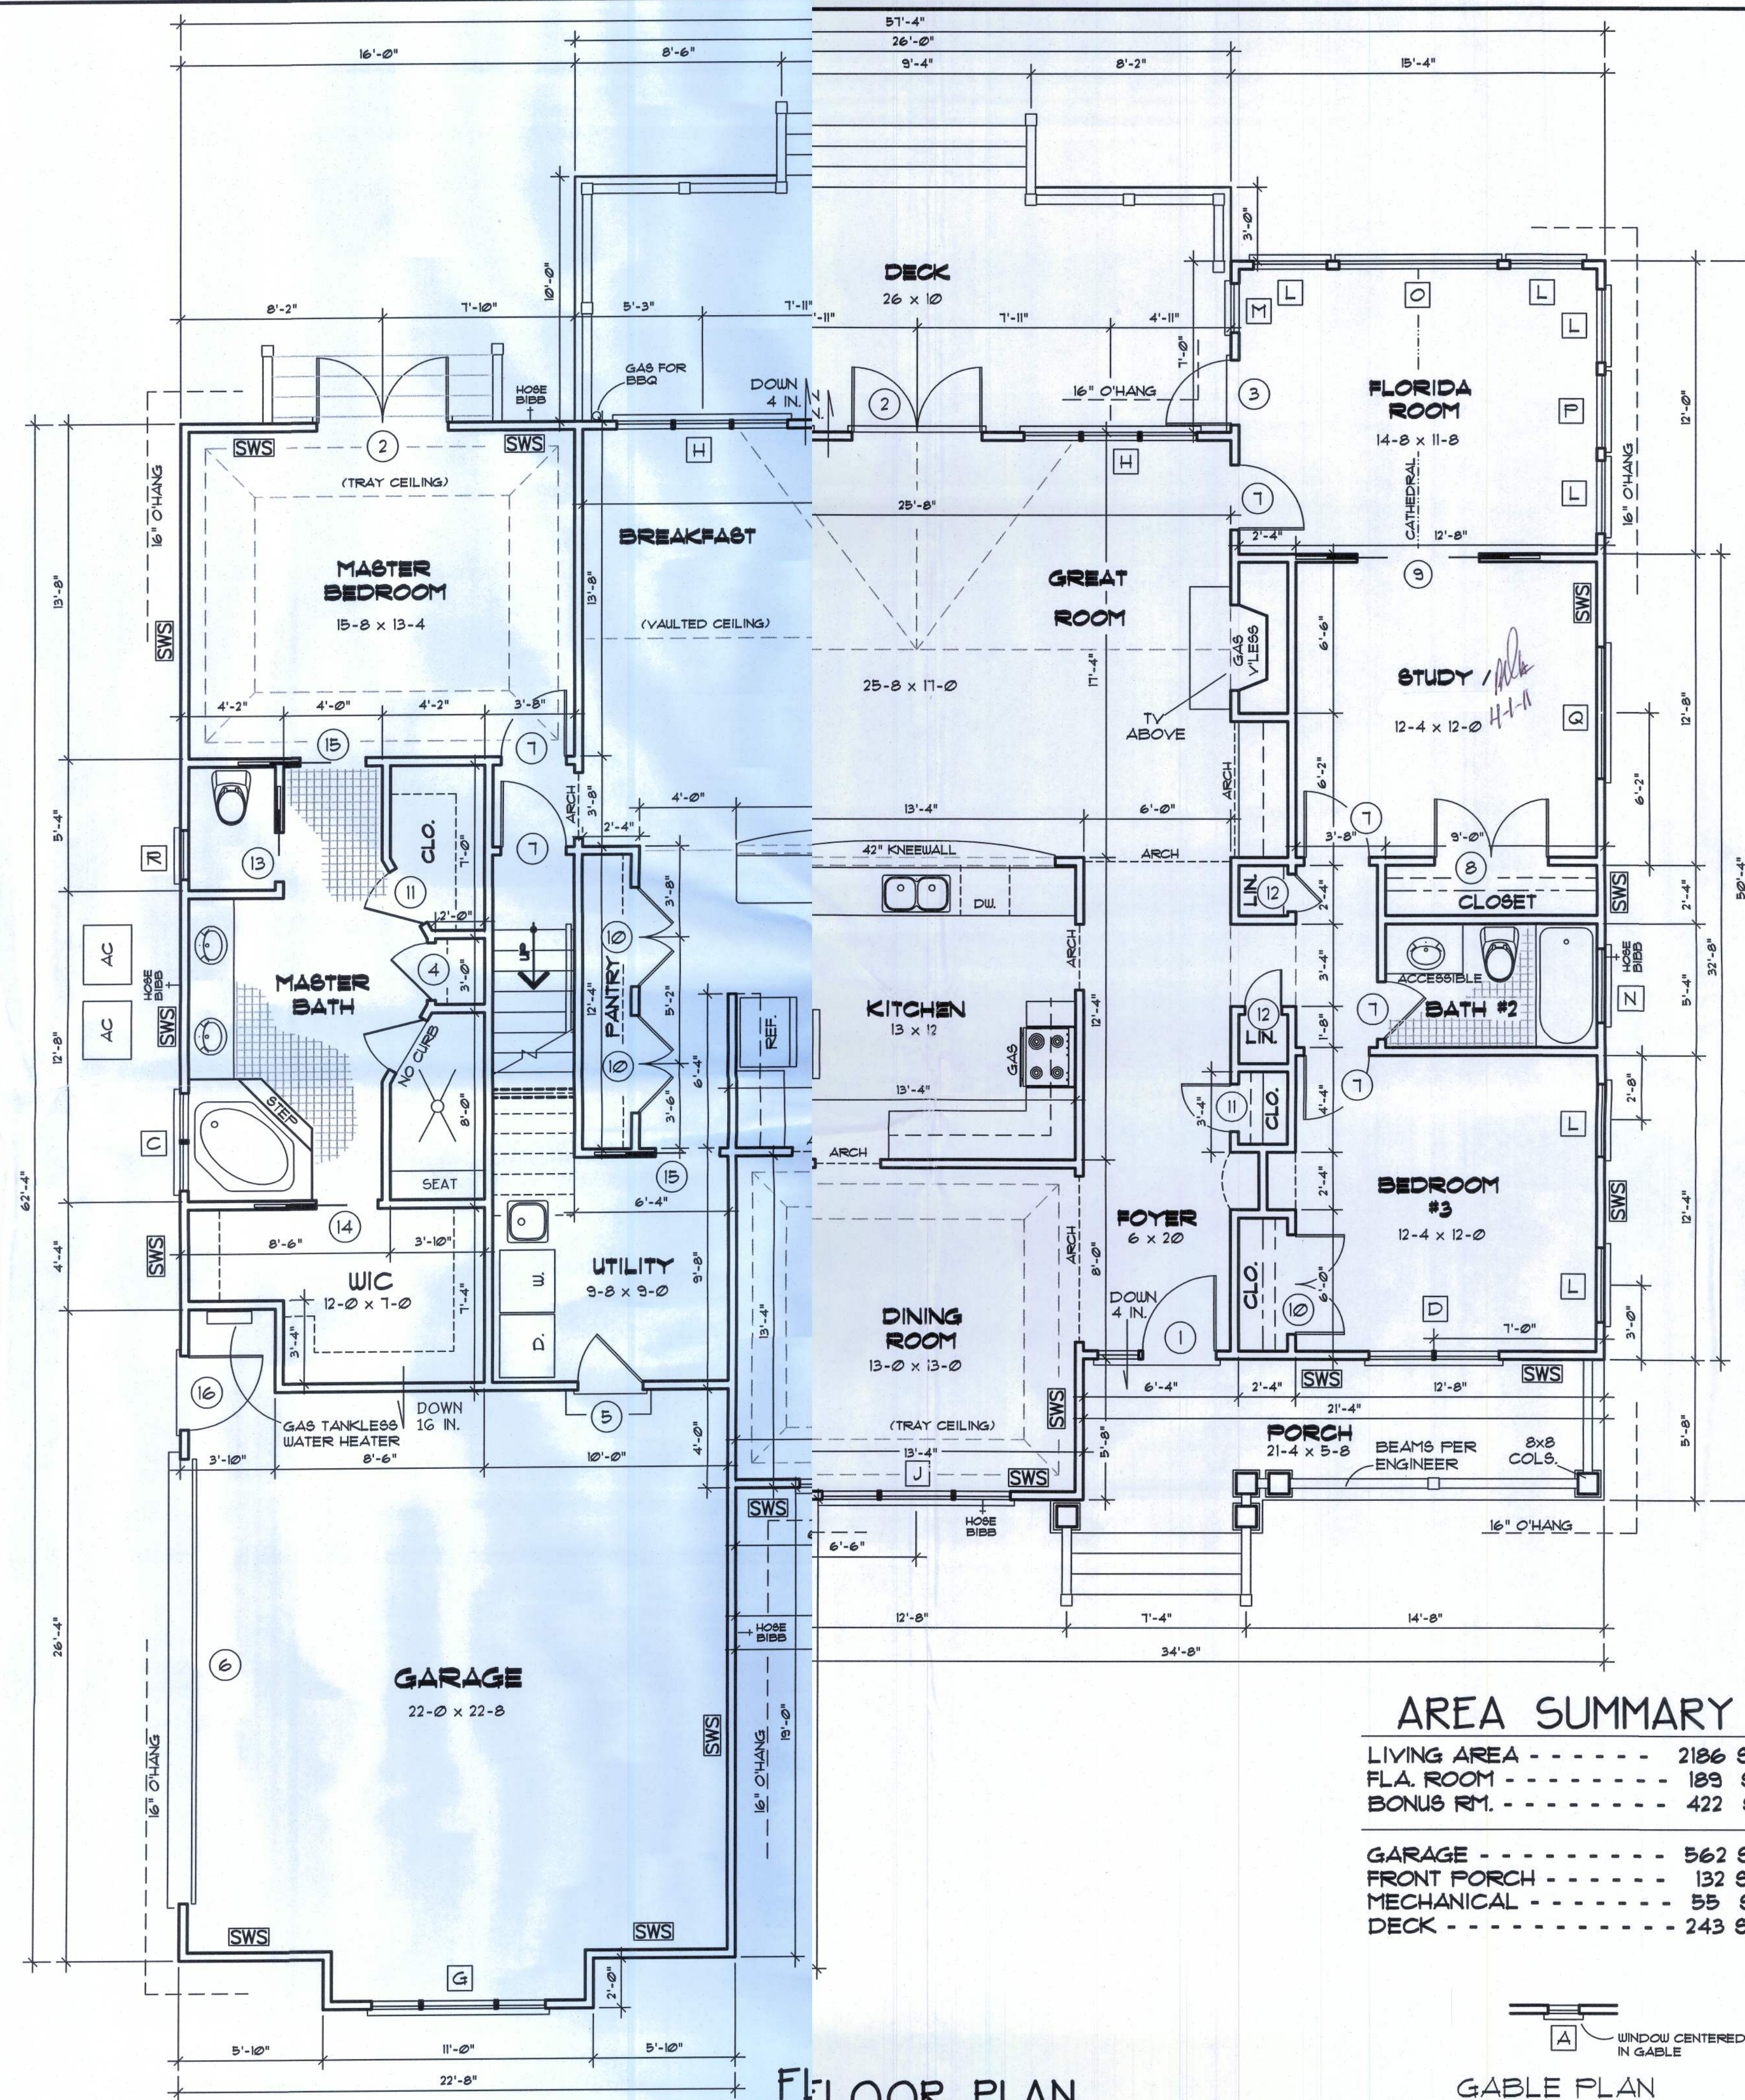


FLOOR PLAN
SCALE: 1/4 IN. = 1 FT.

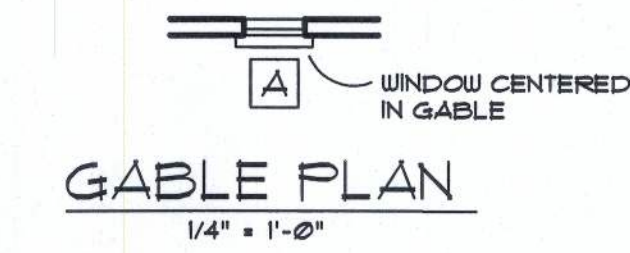

AREA SUMMARY

LIVING AREA	2186 SF
FLA. ROOM	189 SF
BONUS RM.	422 SF
GARAGE	562 SF
FRONT PORCH	132 SF
MECHANICAL	55 SF
DECK	243 SF

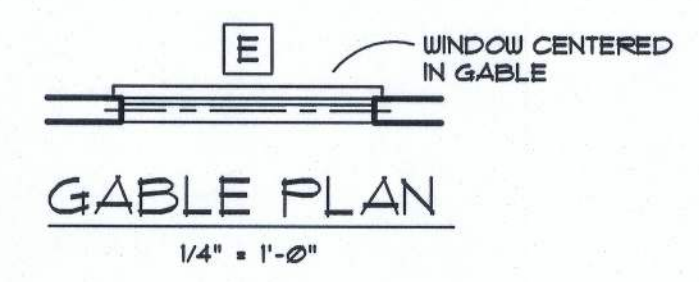

SWS = Indicates a shearwall segment location referring to the labeled section of wall lying between the adjacent window / door openings in either direction. The shearwall areas have a height/width aspect ratio of 3-1/2 : 1 or wider.

MARK	SIZE	QUAN.	DESCRIPTION
A	1'-6" x 3'-0"	1	FIXED, ARCH HEAD (FRONT GABLE)
B			OMITTED
C	(2) 2'-0" x 5'-0"	1	SH. LOW E
D	(2) 2'-0" x 5'-0"	1	SH.
E	5'-0" x 2'-0"	1	FIXED, ARCH HEAD (REAR GABLE)
F	3'-0" x 4'-0"	1	SH, CENTER FIXED, ARCH HEAD *
G	2'-0" x 3'-4"	1	SH, CENTER FIXED
H	(3) 2'-0" x 6'-0"	2	SH, CENTER FIXED LOW E
J	2'-0" x 6'-0"	1	SH, CENTER FIXED
K			OMITTED
L	3'-0" x 5'-0"	6	SH LOW E
M	2'-0" x 5'-0"	1	SH LOW E
N	3'-0" x 1'-0"	1	OPERABLE LOW E
O	6'-0" x 5'-0"	1	FIXED - PICTURE W/ EYEBROW LOW E
P	3'-0" x 5'-0"	1	FIXED - PICTURE LOW E
Q	5'-0" x 1'-0"	1	OPERABLE LOW E
R	2'-0" x 3'-0"	1	SH LOW E

* SEE ELEVATION FOR RADIUS.

MARK	SIZE	QUAN.	DESCRIPTION
1	3'-0" x 6'-8"	1	EXT. HALF GLASS W/ 20" SIDELITE * ELLIPTICAL RANDOM *
2	(2) 2'-0" x 6'-8"	2	EXT. FULL GLASS W/ 12" TRANSOM
3	2'-0" x 6'-8"	1	EXT. FULL GLASS W/ 12" TRANSOM
4	2'-4" x 6'-8"	1	INT.
5	2'-0" x 6'-8"	1	EXT. 1 HOUR FIRE-RATED
6	18'-0" x 7'-0"	1	GARAGE
7	2'-0" x 6'-8"	8	INT.
8	(2) 2'-4" x 6'-8"	1	INT.
9	(2) 2'-6" x 6'-8"	1	DOUBLE POCKET DOOR
10	(2) 2'-0" x 6'-8"	3	INT.
11	2'-6" x 6'-8"	1	INT.
12	1'-6" x 6'-8"	2	INT.
13	2'-0" x 6'-8"	1	POCKET DOOR
14	2'-6" x 6'-8"	1	POCKET DOOR
15	2'-0" x 6'-8"	2	POCKET DOOR
16	3'-0" x 6'-8"	1	EXT. 1 HOUR FIRE-RATED

* SEE ELEVATION FOR TRANSOM.

WINDLOAD ENGINEER: Mark Diasoway, PE No.53915, POB 868, Lake City, FL 32056, 386-754-5419

CERTIFICATION: These plans and "Windload Engineering", Sheet S-1, attached, comply with Florida Building Code Residential 2004, Section R301.2.1 to the best of my knowledge.


LIMITATION: This design is valid for one building, at specified location, permitted within 90 days of signature date. In case of conflict, structural requirements, scope of work, and builder responsibilities on sheet S-1 control.

664 NW COUNTRY LAKE DR.
Location: LAKE CITY, FL 32055 Job No.:

A-3

FILE: 11-003	BENSON RESIDENCE	SHEET: 3 OF 5
DATE: 3-1-11		CAD FILE: 11003
DRAWN: T A D	PREPARED BY: TIM DELBENE	REV:
CHECK: T A D	Drafting + Technical Services	REV:
	192 SW Sagewood Gln., Lake City, FL 32024	REV:
	Phone (386) 755-5891	



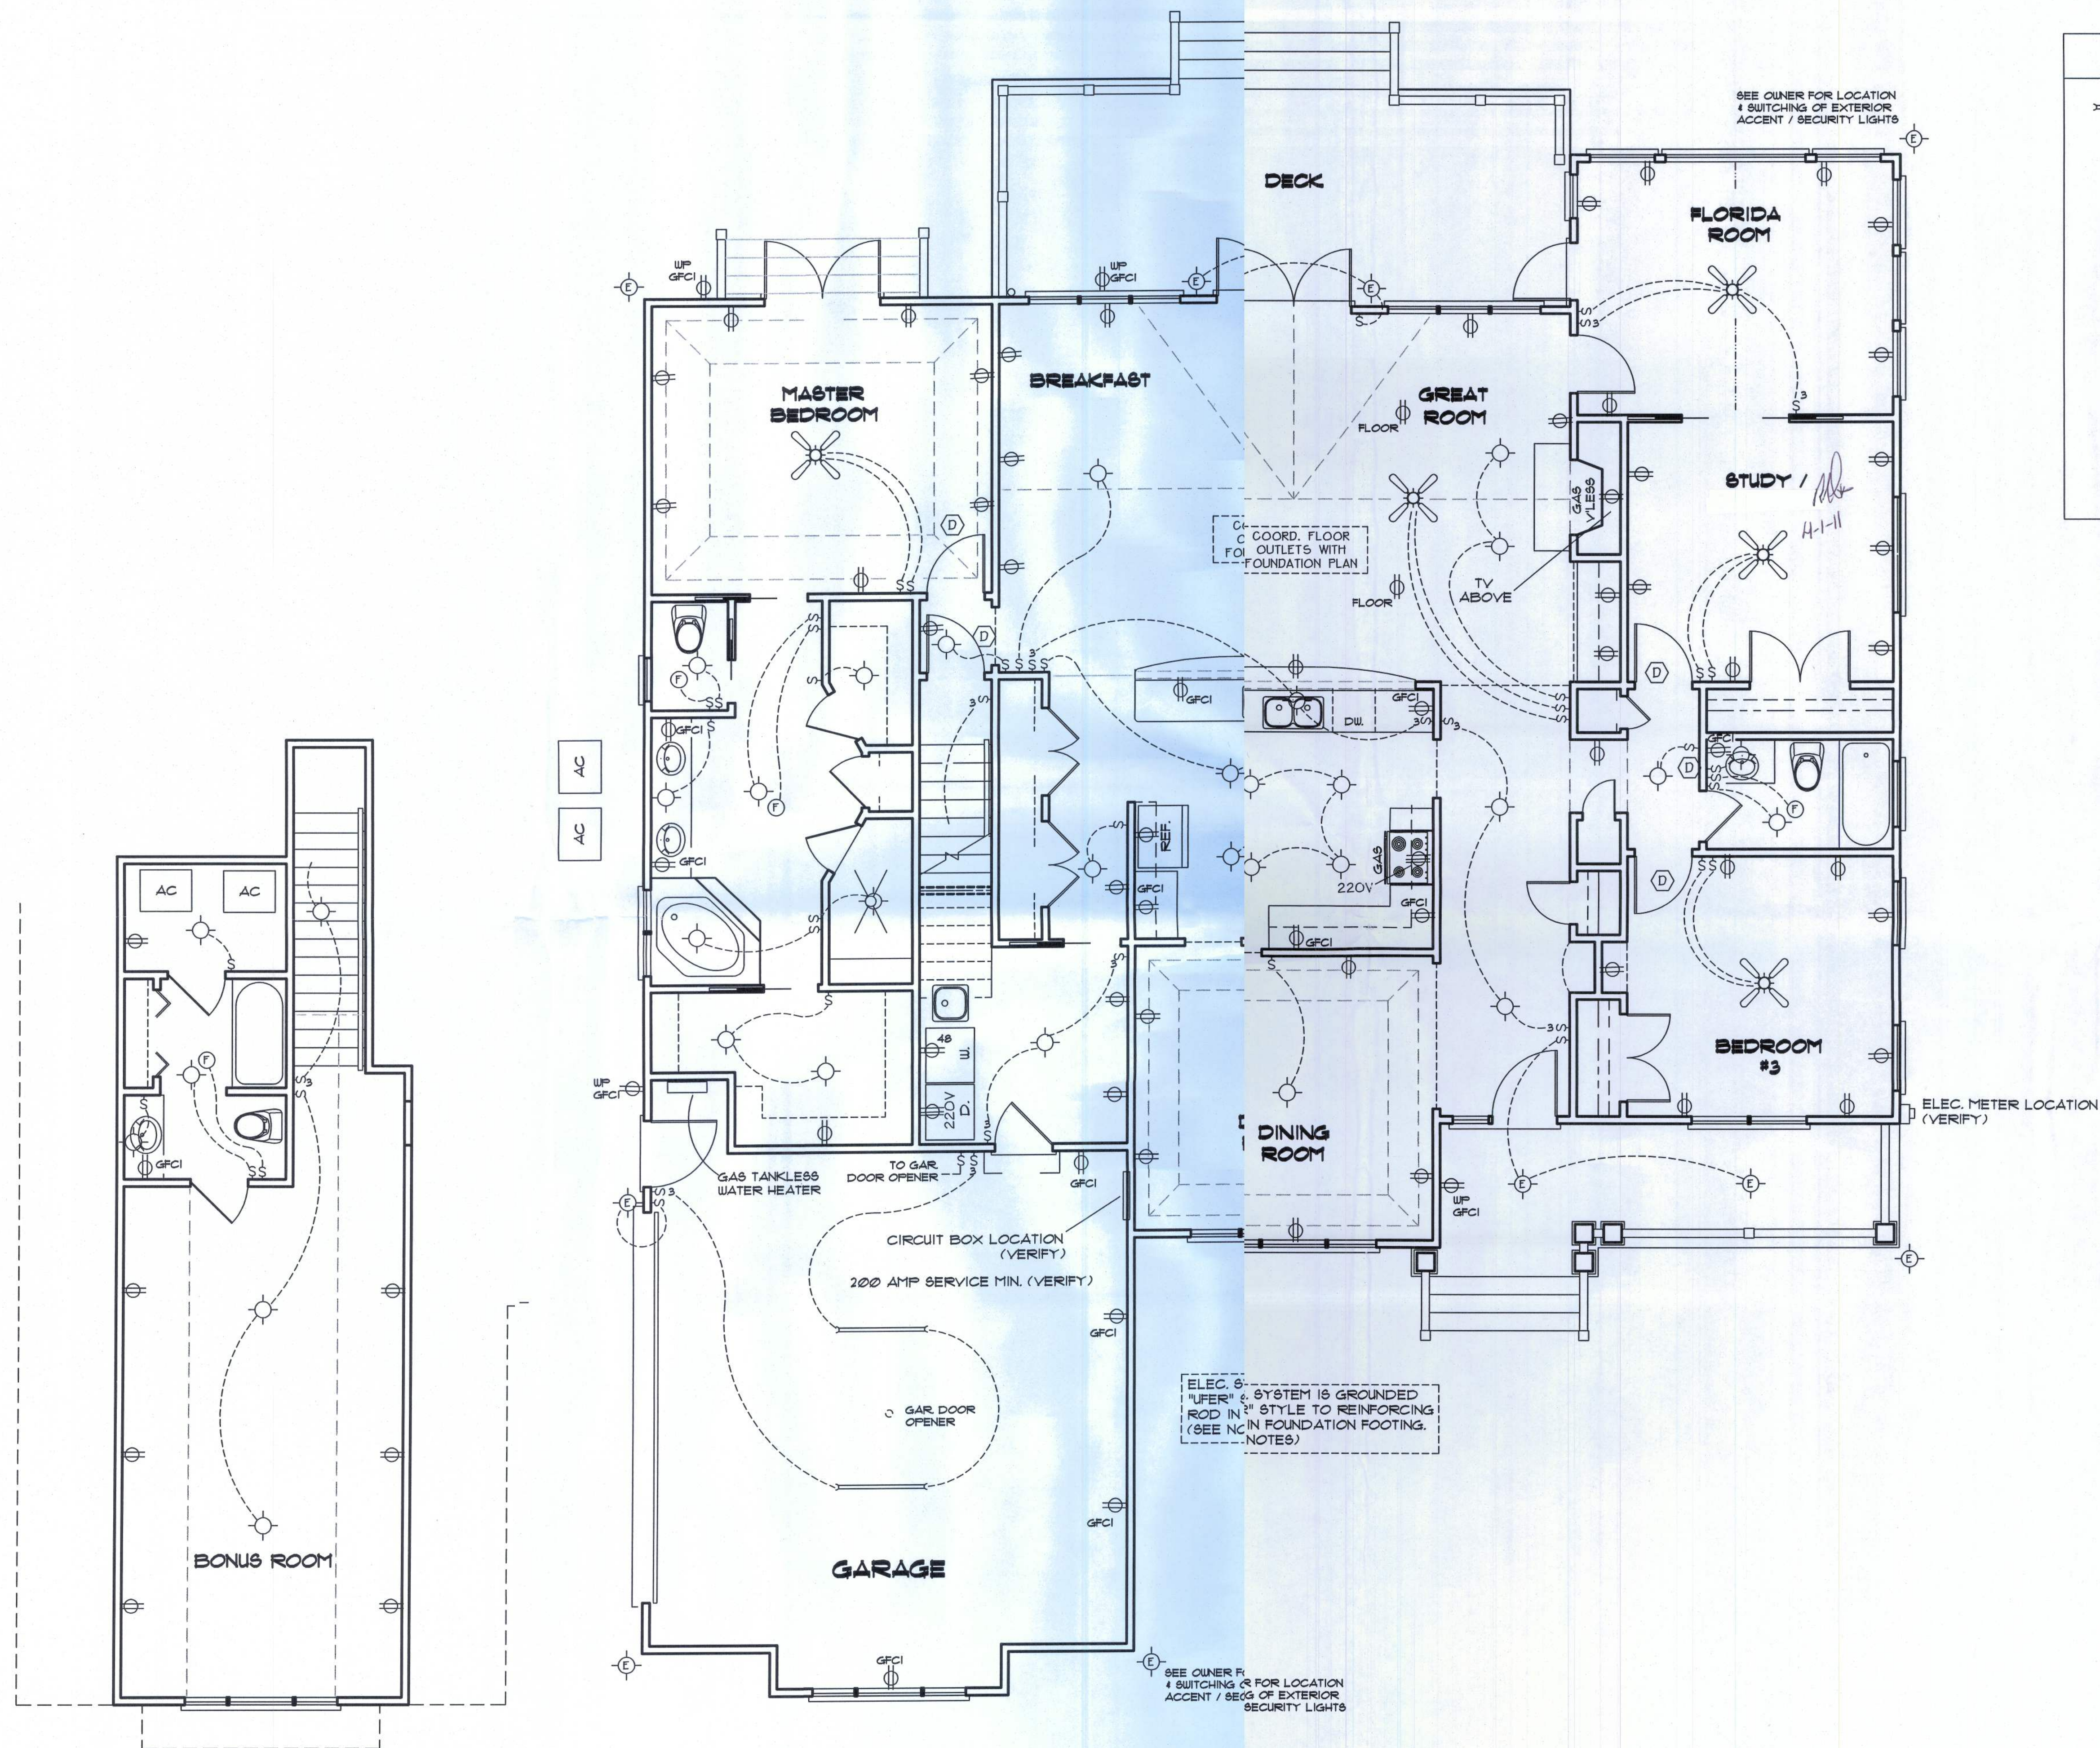

ELECTRICAL SYMBOL LEGEND			
	48" FLOURESCENT LIGHTING FIXTURE		AFCI
	STANDARD CEILING LIGHTING FIXTURE OR CHANDELIER		WEATHER PROOF
	EXTERIOR LIGHTING FIXTURE - WEATHERPROOF		110V DUPLEX OUTLET AFCI, UNLESS NOTED
	RECESSED (CAN) CEILING LIGHTING FIXTURE		110V DUPLEX OUTLET AFCI, UNLESS NOTED (SPECIAL HEIGHT NOTED)
	SGL. POLE LIGHT SWITCH.		110V DUPLEX OUTLET GROUND FAULT CIRCUIT INTERRUPTER TYPE
	THREE-WAY SWITCH.		220 VOLT OUTLET (4 WIRE)
	FOUR-WAY SWITCH.		FAN LOCATION (CEILING)
	DIMMER SWITCH		FAN LOCATION (EXHAUST)
	SMOKE & CARBON MONOXIDE DETECTOR (SEE NOTES)		

ELECTRICAL PLAN NOTES

- ALL INSTALLATIONS ARE PER NAT'L. ELECTRIC CODE (NEC) 2008.
- ALL RECEPTACLES, UNLESS NOTED OTHERWISE, SHALL BE ARC FAULT CIRCUIT INTERRUPTER (AFCI) TYPE. ALSO, RECEPTACLES, UNLESS NOTED, SHALL BE TAMPER RESISTANT.
- GROUNDING OF ELECTRICAL SYSTEM SHALL BE BY "UFER" STYLE GROUNDING METHOD TO REINFORCING ROD IN CONCRETE FOUNDATION FOOTING (NEC 250.52 - GROUNDING ELECTRODES).
- WIRE ALL APPLIANCES, HVAC UNITS AND OTHER EQUIPMENT PER MANUF. SPECIFICATIONS.
- ELECTRICAL CONTR. SHALL BE RESPONSIBLE FOR THE DESIGN & SIZING OF ELECTRICAL SERVICE AND CIRCUITS.
- ENTRY OF SERVICE (UNDERGROUND OR OVERHEAD) TO BE DETERMINED BY POWER COMPANY.
- TELEPHONE, TELEVISION AND OTHER LOW VOLTAGE DEVICES OR OUTLETS SHALL BE AS PER THE OWNER'S DIRECTIONS, & IN ACCORDANCE W/ APPLICABLE SECTIONS OF NEC-LATEST EDITION 2008.
- CONSULT THE OWNER FOR THE NUMBER OF SEPERATE TELEPHONE LINES TO BE INSTALLED.
- LOW VOLTAGE ITEMS (TELEPHONE, CATV, DATA CABLE) IS SHOWN, IF REQUESTED BY OWNER / BUILDER. CONSULT OWNER FOR REQUIREMENTS IF NOT SHOWN ON ELECTRICAL PLAN.
- ALL SMOKE DETECTORS SHALL BE 120V W/ BATTERY BACKUP OF THE PHOTOELECTRIC TYPE, AND SHALL BE INTERLOCKED TOGETHER. INSTALL INSIDE AND NEAR ALL BEDROOMS. THEY SHALL ALSO PROVIDE CARBON MONOXIDE DETECTION.


ELECTRICAL PLAN
NOT TO SCALE

664 NW COUNTRY LAKE DR.
LAKE CITY, FL 32055


A-5

FILE: 11-003	BENSON RESIDENCE	SHEET: 5 OF 5
DATE: 3-1-11		CAD FILE: 11003
DRAWN: T A D	PREPARED BY: TIM DELBENE Drafting & Technical Services	REV:
CHECK: T A D	192 SW Sageswood Gln. Lake City, FL 32024 Phone (386) 755-5891	REV:


REVISIONS	

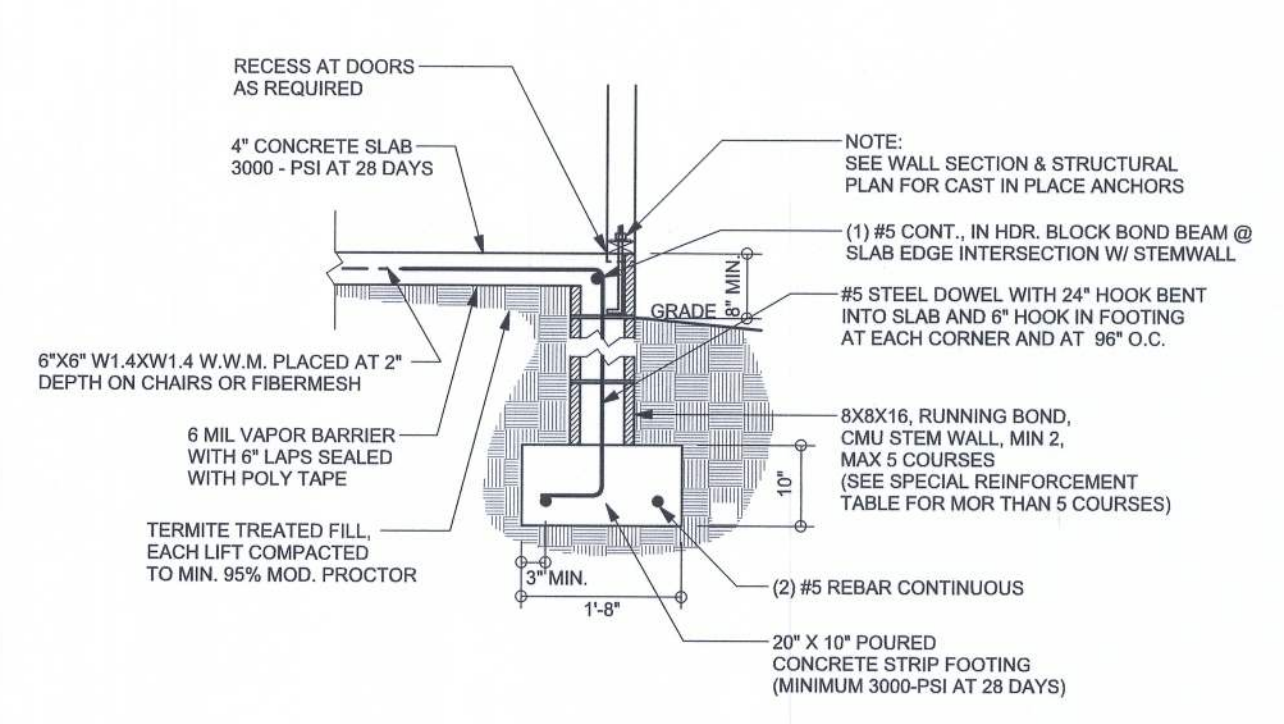


F9 STEM WALL FOOTING
SCALE: 1/2" = 1'-0"

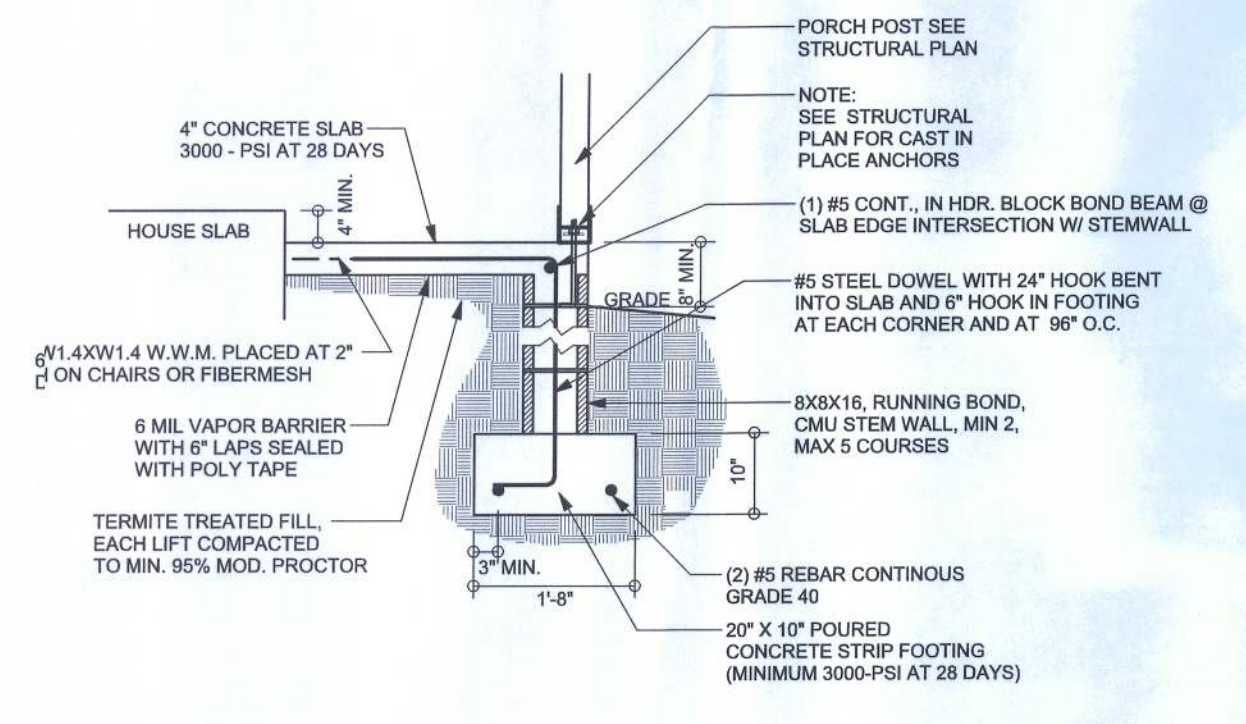


F12 STEM WALL PORCH FOOTING
SCALE: 1/2" = 1'-0"

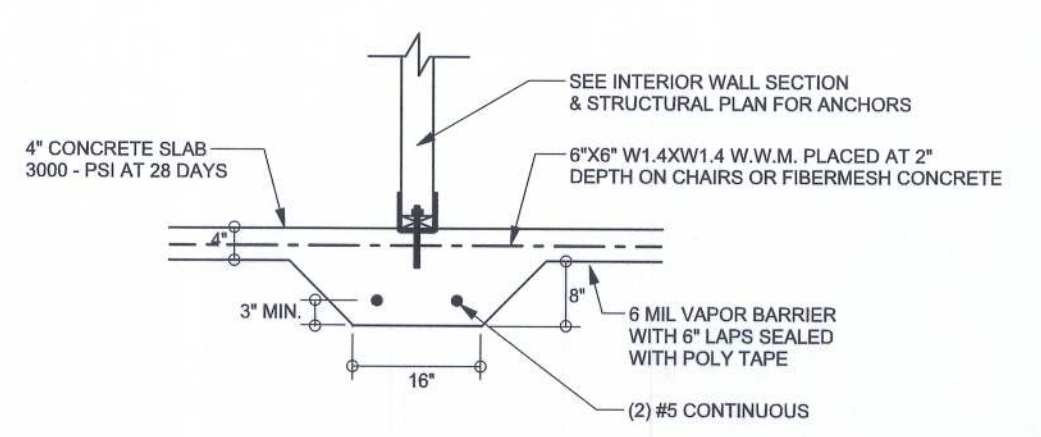

F2 INTERIOR BEARING FOOTING
SCALE: 1/2" = 1'-0"

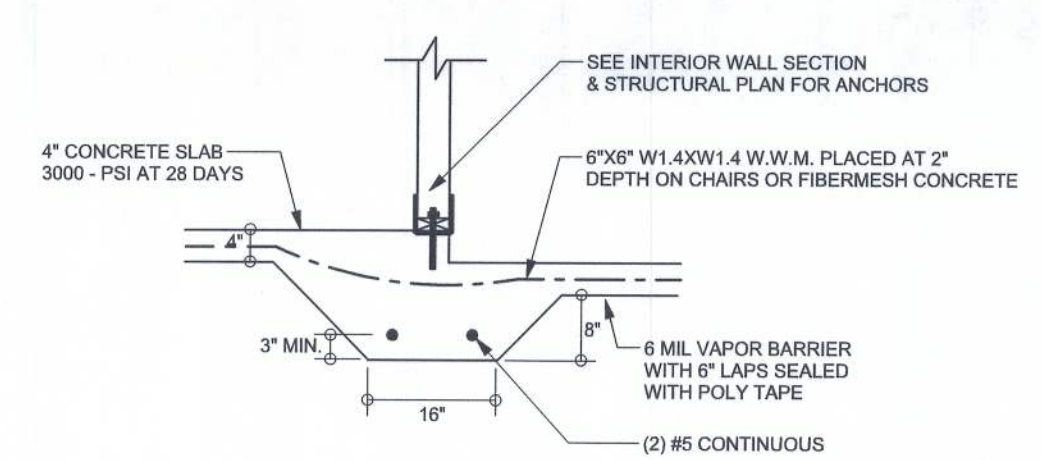

F3 INTERIOR BEARING STEP FOOTING
SCALE: 1/2" = 1'-0"

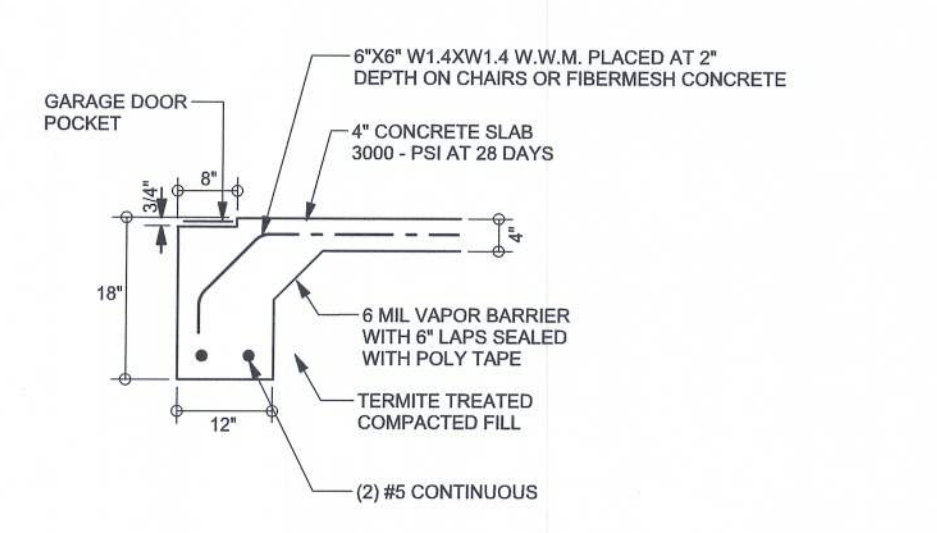


F4 GARAGE DOOR FOOTING
SCALE: 1/2" = 1'-0"

FALL STEM WALL TABLE

The table assumes 60 ksi reinforcing bars with 6" hook in the footing and bent 24" into the reinforced slab at the top. The vertical steel is to be placed toward the tension side of the CMU wall (away from the soil pressure, within 2" of the exterior side of the wall). If the wall is over 8' high, add Duowall ladder reinforcement at 16"OC vertically or a horizontal bond beam with #5 continuous at mid height. For higher parts of the wall 12" CMU may be used with reinforcement as shown in the table below.

STEM WALL HEIGHT (FEET)	UNBALANCED BACKFILL HEIGHT	VERTICAL REINFORCEMENT FOR 8" CMU STEM WALL (INCHES O.C.)			VERTICAL REINFORCEMENT FOR 12" CMU STEM WALL (INCHES O.C.)		
		#5	#7	#8	#5	#7	#8
3.3	3.0	96	96	96	96	96	96
4.0	3.7	96	96	96	96	96	96
4.7	4.3	88	96	96	96	96	96
5.3	5.0	56	96	96	96	96	96
6.0	5.7	40	80	96	80	96	96
6.7	6.3	32	56	80	56	96	96
7.3	7.0	24	40	56	40	80	96
8.0	7.7	16	32	48	32	64	80
8.7	8.3	8	24	32	24	48	64
9.3	9.0	8	16	24	16	40	48

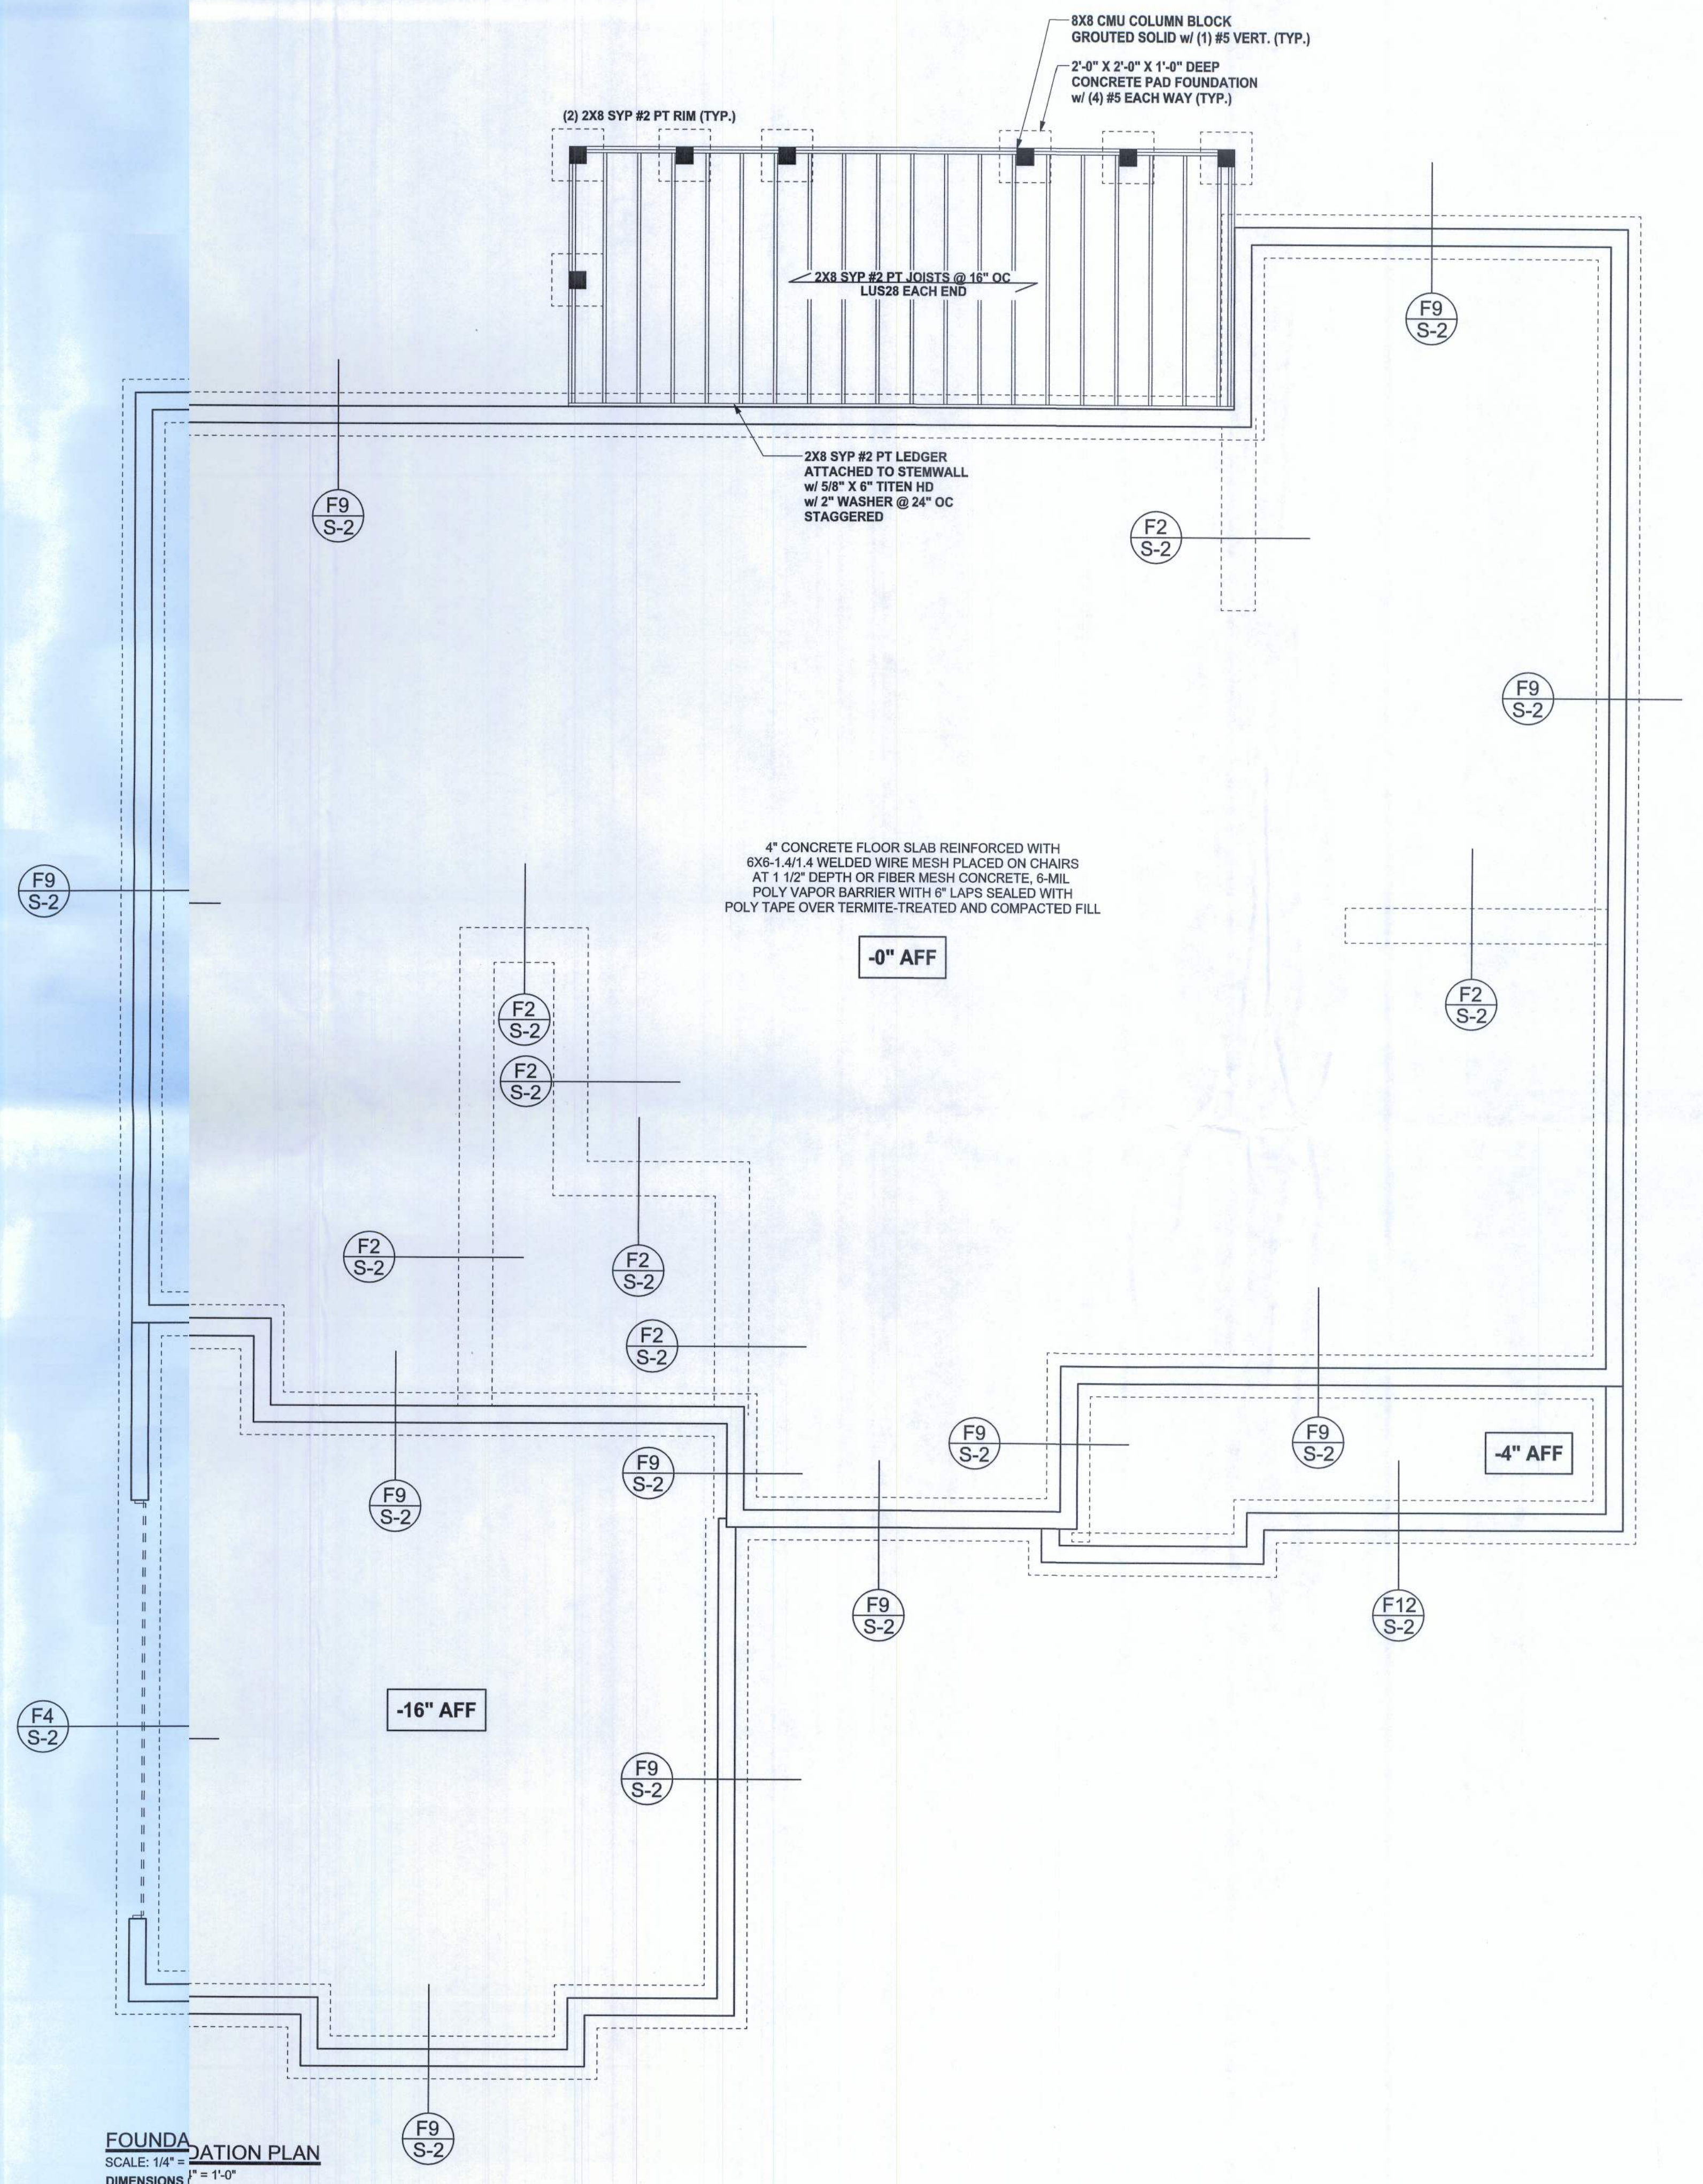

FOUNDATION PLAN
SCALE: 1/4" = 1'-0"
DIMENSIONS ARE NOT EXACTS ON STRUCTURAL SHEETS
FLOOR PLAN EXACT. REFER TO ARCHITECTURAL PLAN FOR ACTUAL DIMENSIONS

WINDLOAD/ENGINEER: Mark Discoway, P.E. No. 5395, POB 868, Lake City, FL 32056, 386/54-5419

DIMENSIONS:
Stated dimensions supersede scaled dimensions. Refer all questions to Mark Discoway, P.E. for resolution. Do not proceed without clarification.

COPYRIGHTS AND PROPERTY RIGHTS:
Mark Discoway, P.E. hereby expressly reserves its copyright and property right in these instruments of service. This document is not to be reproduced, altered or copied in any form or manner without first the express written permission of Mark Discoway.

CERTIFICATION: I hereby certify that I have examined this plan, and that the applicable portions of this plan, relating to wind engineering comply with Section R301.2.1, Florida building code (revised 2007), to the best of my knowledge.

LIMITATION: This design is valid for one building, as specified location.



Blake Construction

Benson Residence

ADDRESS:
14 19 Country Lake @
Woodborough S/D
olumbia County, FL

Mark Discoway P.E.
P.O. Box 868
Lake City, Florida 32056
Phone: (386) 754 - 5419
Fax: (386) 269 - 4871

PRINTED DATE:
March 28, 2011

DRAWN BY: STRUCTURAL BY:
David Discoway

FINAL DATE:
28Mar11

JOB NUMBER:
1103073

(DRAWING NUMBER)
S-2
OF 3 SHEETS



J-1 ALL LOAD BEARING FRAME WALL & PORCH HEADERS SHALL BE A MINIMUM OF (2) 2X12 SYP #2 (U.N.O.)
 J-2 ALL LOAD BEARING FRAME WALL HEADERS SHALL HAVE (1) JACK STUD & (1) KING STUD EACH SIDE (U.N.O.)
 J-3 DIMENSIONS ON STRUCTURAL SHEETS ARE NOT EXACT. REFER TO ARCHITECTURAL FLOOR PLAN FOR ACTUAL DIMENSIONS

J-4 PERMANENT TRUSS BRACING IS TO BE INSTALLED AT LOCATIONS AS SHOWN ON THE SEALED TRUSS DRAWINGS. LATERAL BRACING IS TO BE RESTRAINED PER BCSI-03, BCSI-B1, BCSI-B2, & BCSI-B3. BCSI-B1, BCSI-B2, & BCSI-B3 ARE FURNISHED BY THE TRUSS SUPPLIER, WITH THE SEALED TRUSS PACKAGE

	EXTERIOR WALL
	INTERIOR NON-LOAD BEARING WALL
	INTERIOR LOAD BEARING WALL w/ NO UPLIFT
	INTERIOR LOAD BEARING WALL w/ UPLIFT


The diagram illustrates the components of a header/beam call-out code: **2X12X0', 1J 1K**. The code is enclosed in a box. Arrows point from descriptive labels to the corresponding parts of the code:

- 2X12X0'**: Points to the first part of the code, representing the size of the header material.
- 1J**: Points to the second part of the code, representing the number of jack studs (under header).
- 1K**: Points to the third part of the code, representing the number of king studs (full length).
- 0'**: Points to the fourth part of the code, representing the span of the header.

Below the code box, a legend defines the abbreviations used:

- NUMBER OF KING STUDS (FULL LENGTH)**: Corresponds to 'K'.
- NUMBER OF JACK STUDS (UNDER HEADER)**: Corresponds to 'J'.
- SPAN OF HEADER**: Corresponds to the length value (e.g., '0').
- SIZE OF HEADER MATERIAL**: Corresponds to the 'X' values (e.g., '2X12').
- NUMBER OF PLIES IN HEADER**: Corresponds to the first 'X' value (e.g., '2').

	REQUIRED	ACTUAL
TRANSVERSE	46.8'	81.6'
LONGITUDINAL	53.2'	54.3'

 

USE H2.5A (535lb) FOR ALL TRUSS TO FRAME WALL AND PORCH BEAM CONNECTIONS UNLESS NOTED OTHERWISE

WINDLOAD NGINEER: Mark Disosway,
PE No.53915POB 868, Lake City, FL
32056. 386-74-5419

DIMENSIONS:
Stated dimensions supercede scale dimensions. Refer all questions to Mark Disoswy, P.E. for resolution. Do not proceed without clarification.

COPYRIGHT AND PROPERTY RIGHTS:
Mark Disosway, P.E. hereby expressly reserves its common law copyrights and property right in these instruments of service. This document is not to be reproduced, altered or copied in any form or manner without first the express written permission and consent of Mark Disosway.

CERTIFICATION: I hereby certify that I have examined this plan, and that the applicable portions of the plan, relating to wind engineering, comply with section R301.2.1, Florida building code residential 2007, to the best of my knowledge.

LIMITATION: This design is valid for one building, at specified location.

MARK DISOSWAY
P.E. 53815



PRO

11/11/11

SEAL

Blake Construction

1997, 1998, 1999, 2678, 26

Benison Residence

100

ADDRESS:
Lot 19 Country Lake @

Entire Security Lake @
 Voodborough S/D
 Columbia County, FL

Mark Disosway P.E.

P.O. Box 868
Lake City, Florida 3205

Phone: (386) 754 - 5411
Fax: (386) 269 - 4871

PRINTED DATE: 1-22-2014

March 28, 2011	
DRAWN BY:	STRUCTURAL

		David Disow
--	--	-------------

[illegible]

FINALS DATE: 28Mar1'	
------------------------------------	--

JCB NUMBER:
1103073

DRAWING NUMBER

S-3

OF 3 SHEETS

CONNECTIONS, WALL, & HEADER DESIGN IS BASED ON REACTIONS & UPLIFTS FROM TRUSS ENGINEERING FURNISHED BY BUILDER. BUILDERS FIRST SOURCE JOB #366563