
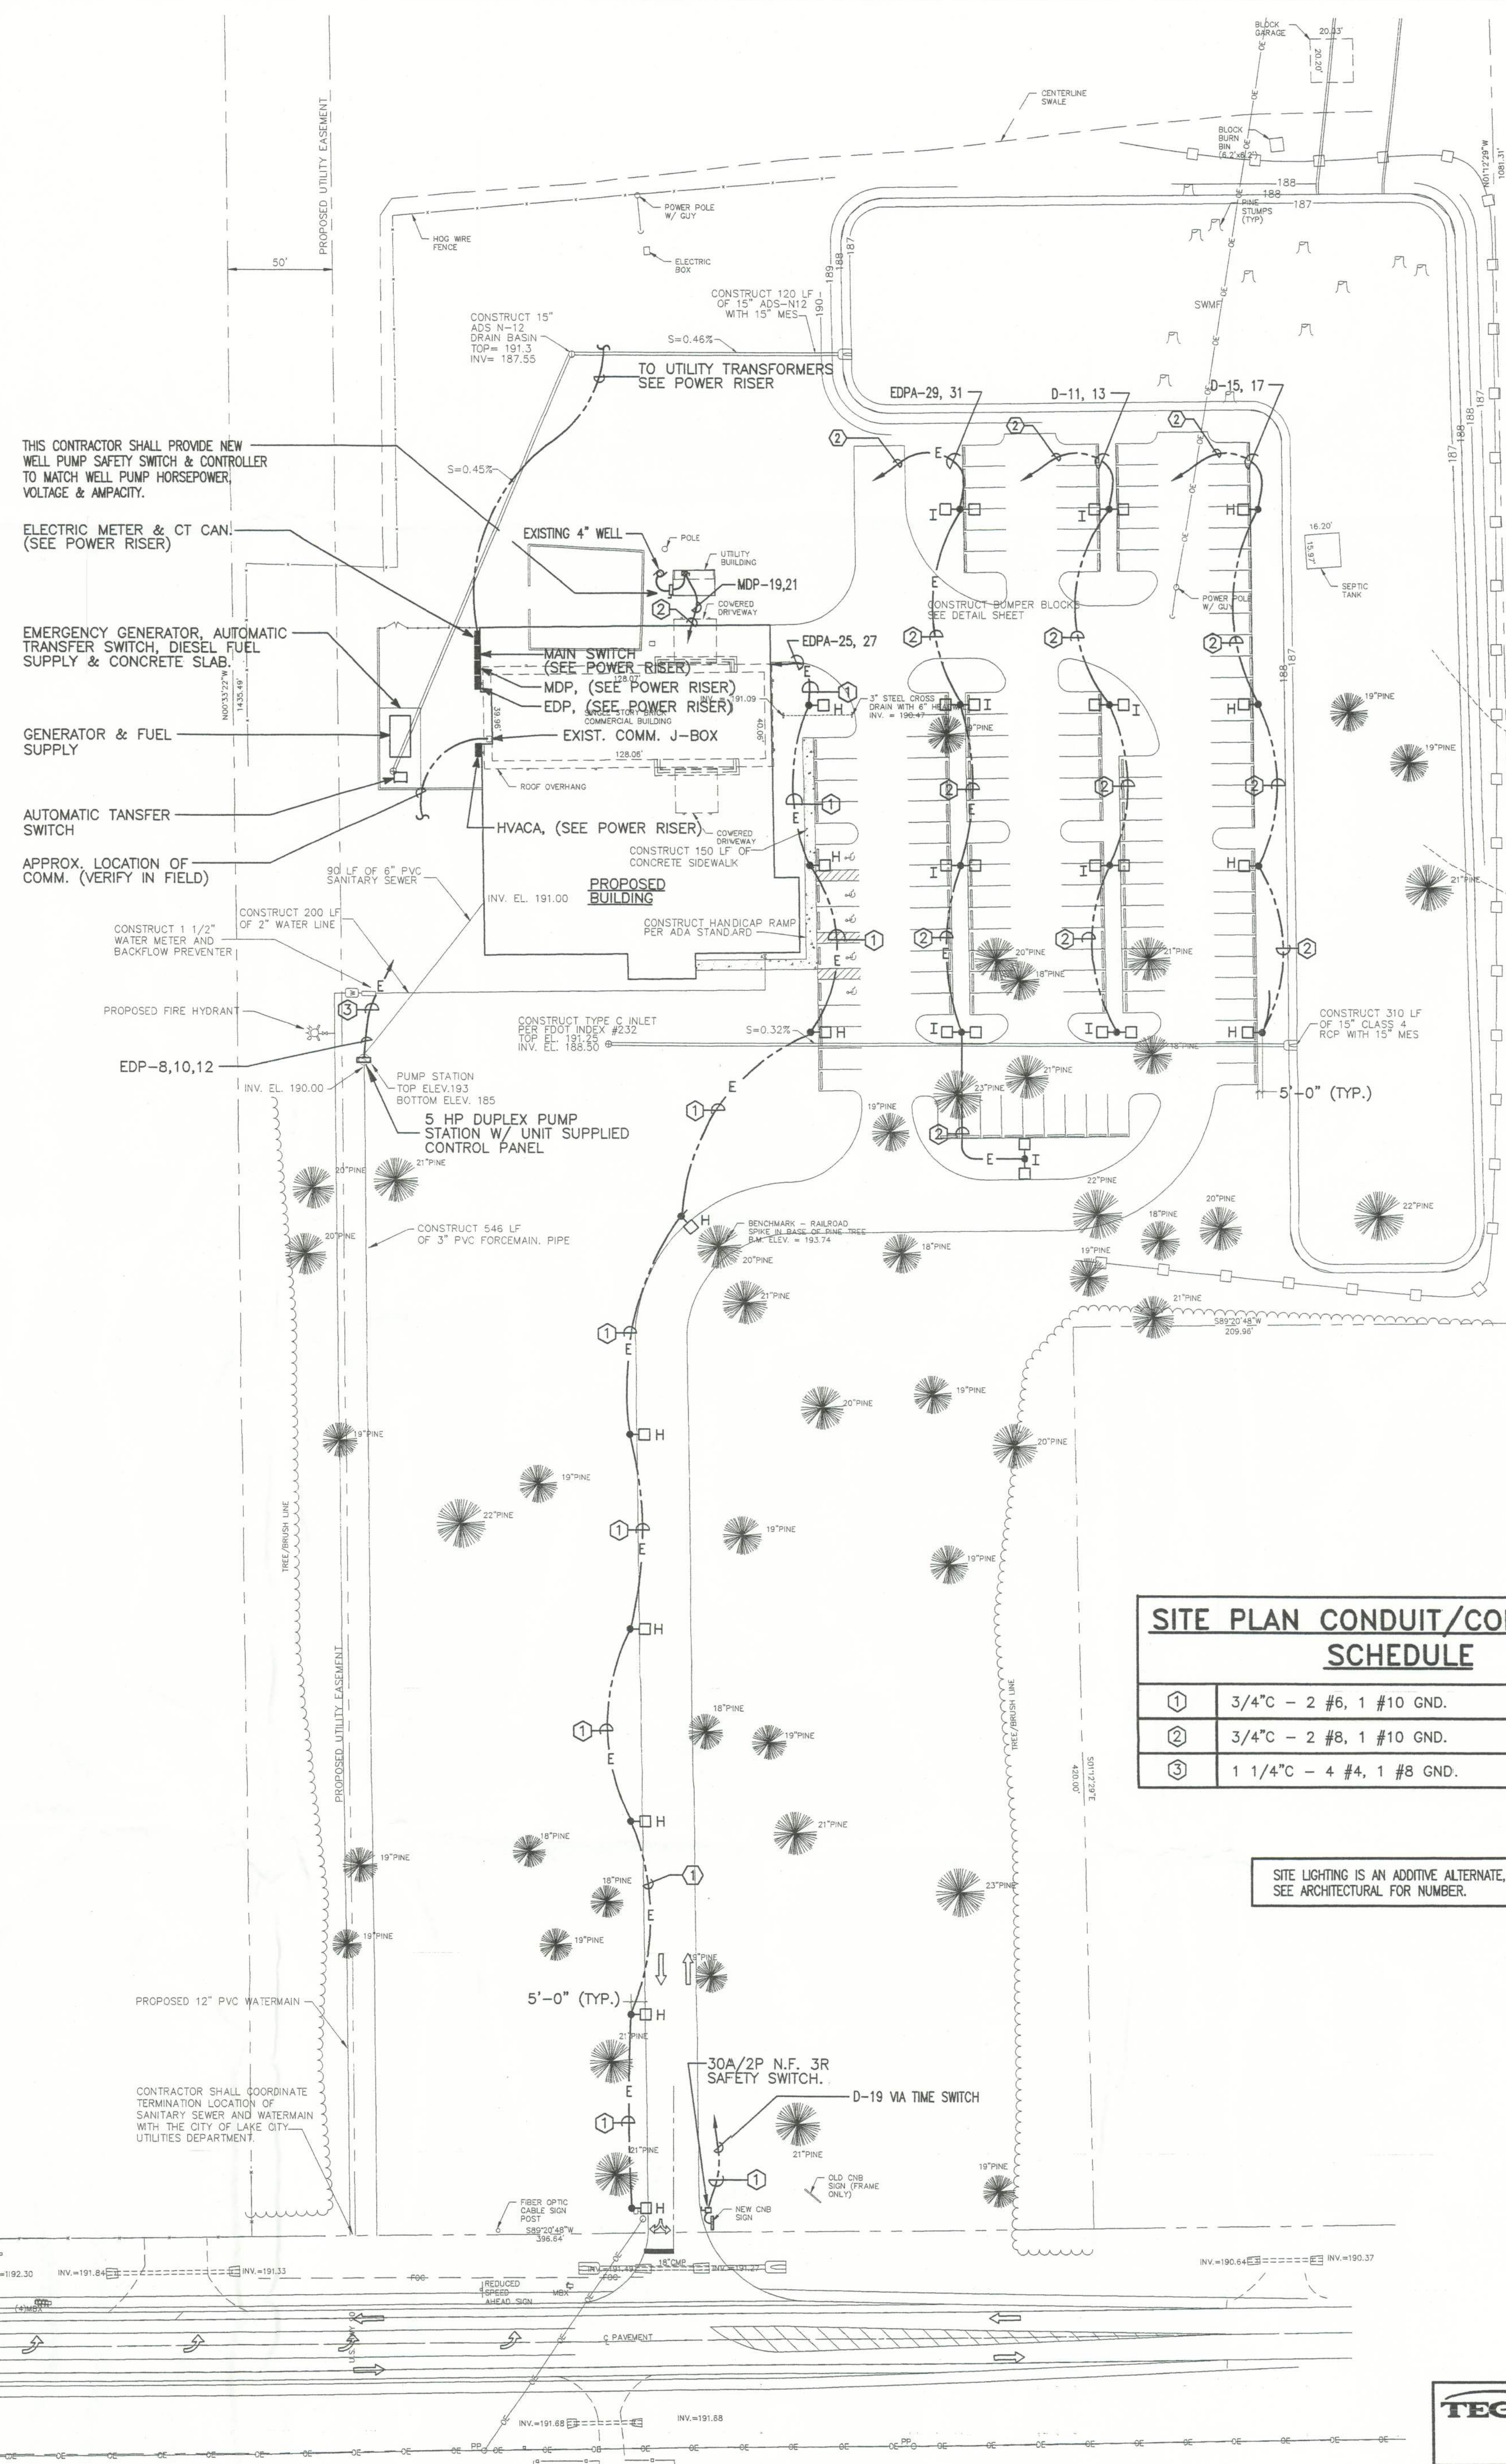


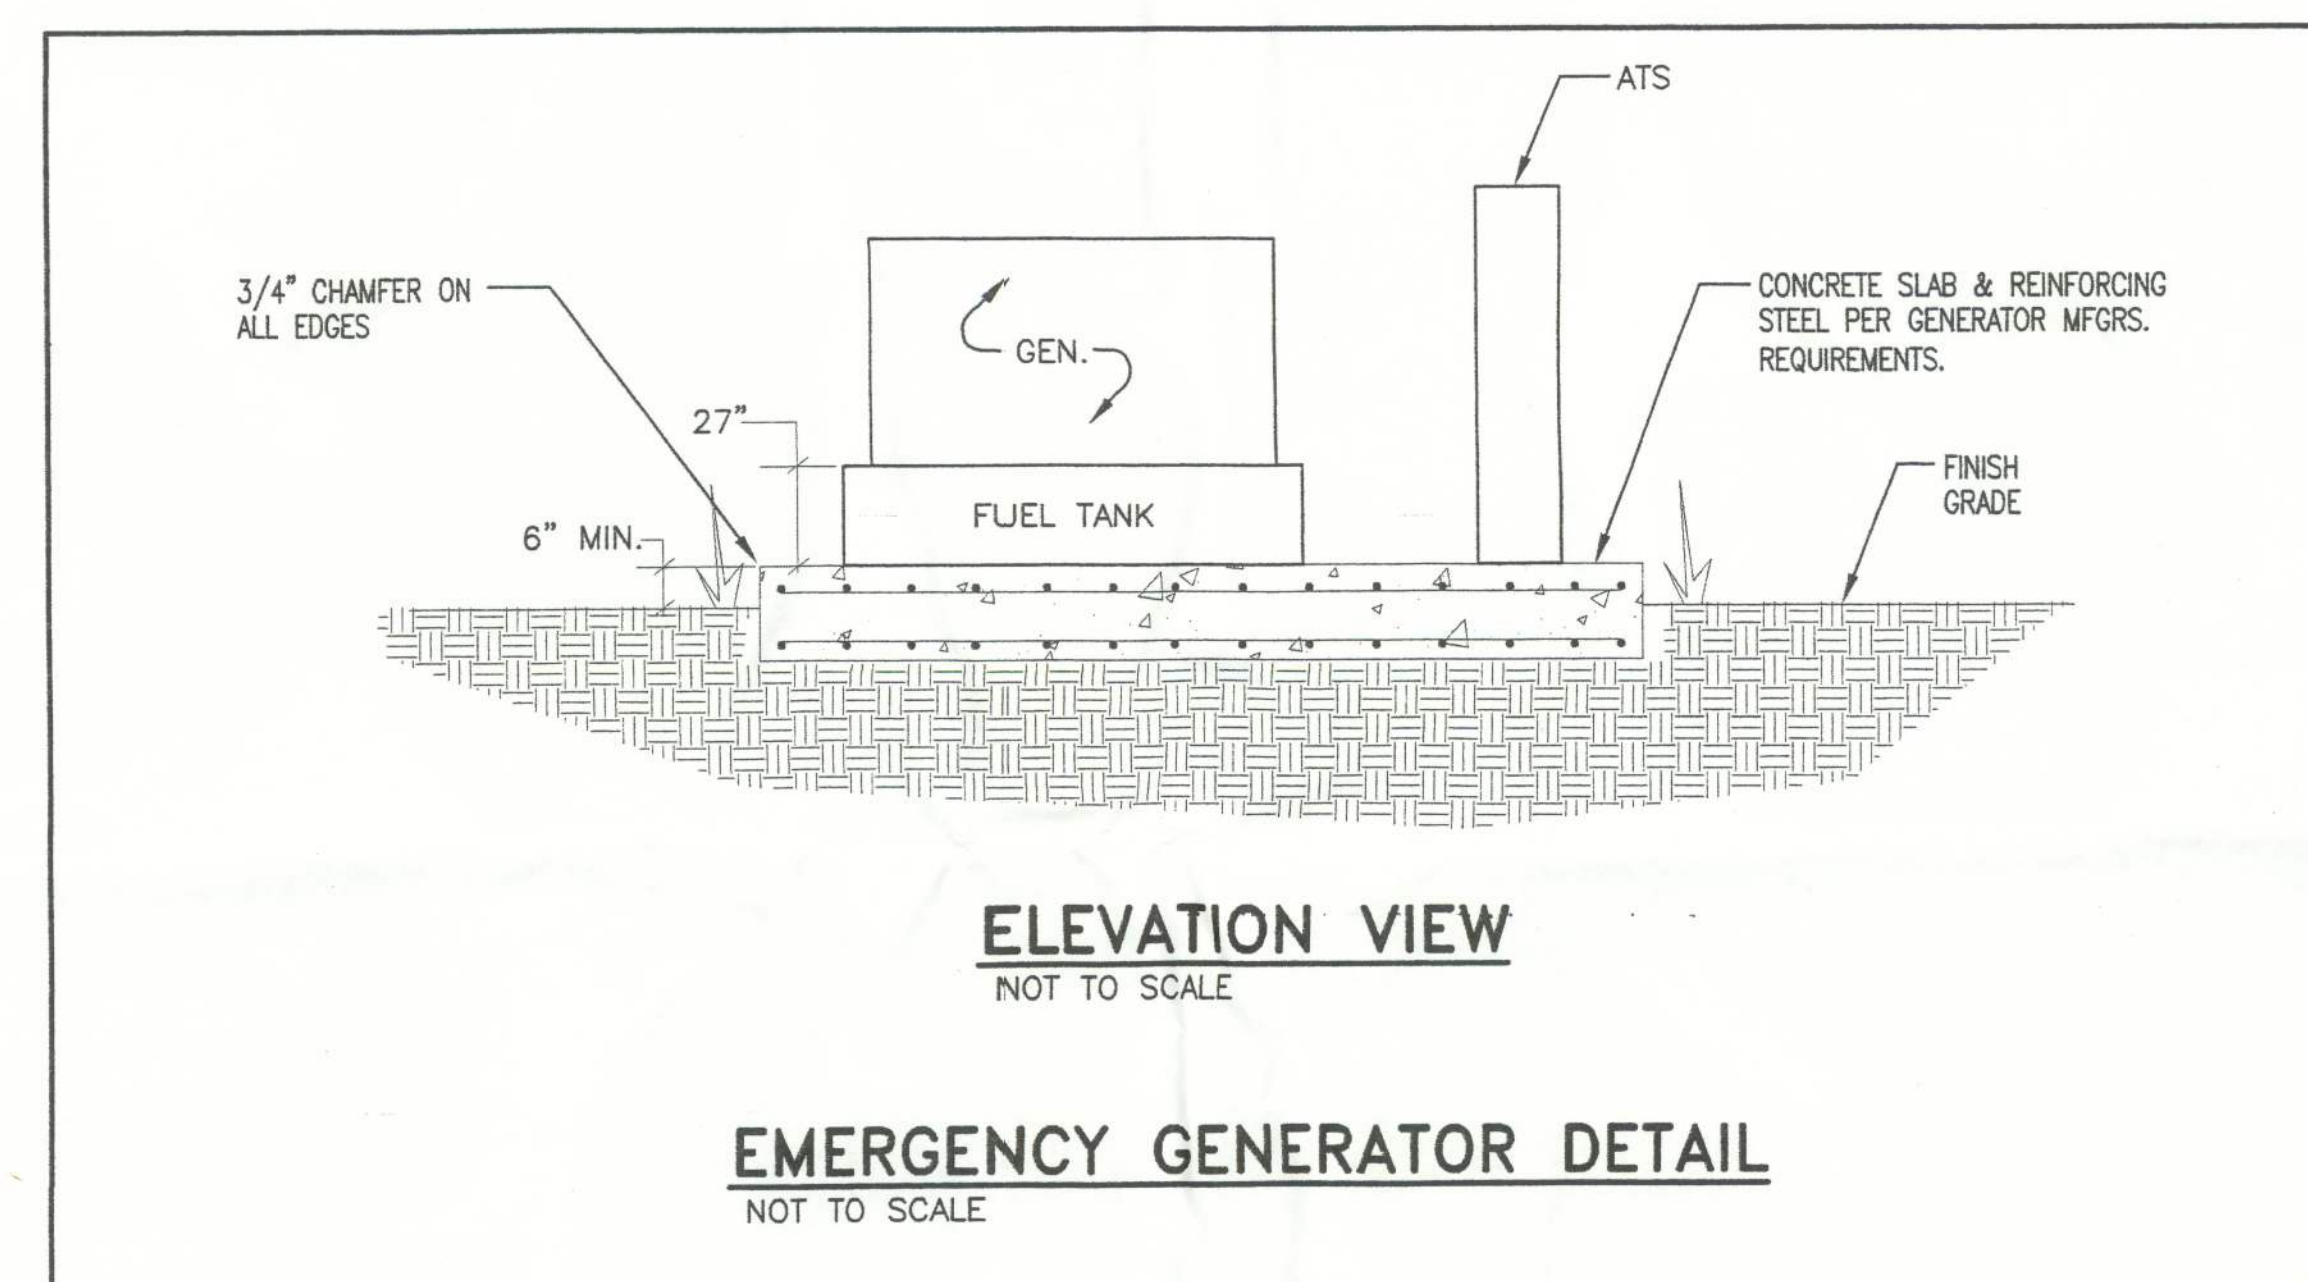

SHEET TITLE
ELECTRICAL SITE PLAN
LIGHTING, POWER & SECURITY
E-2 10 of 39