




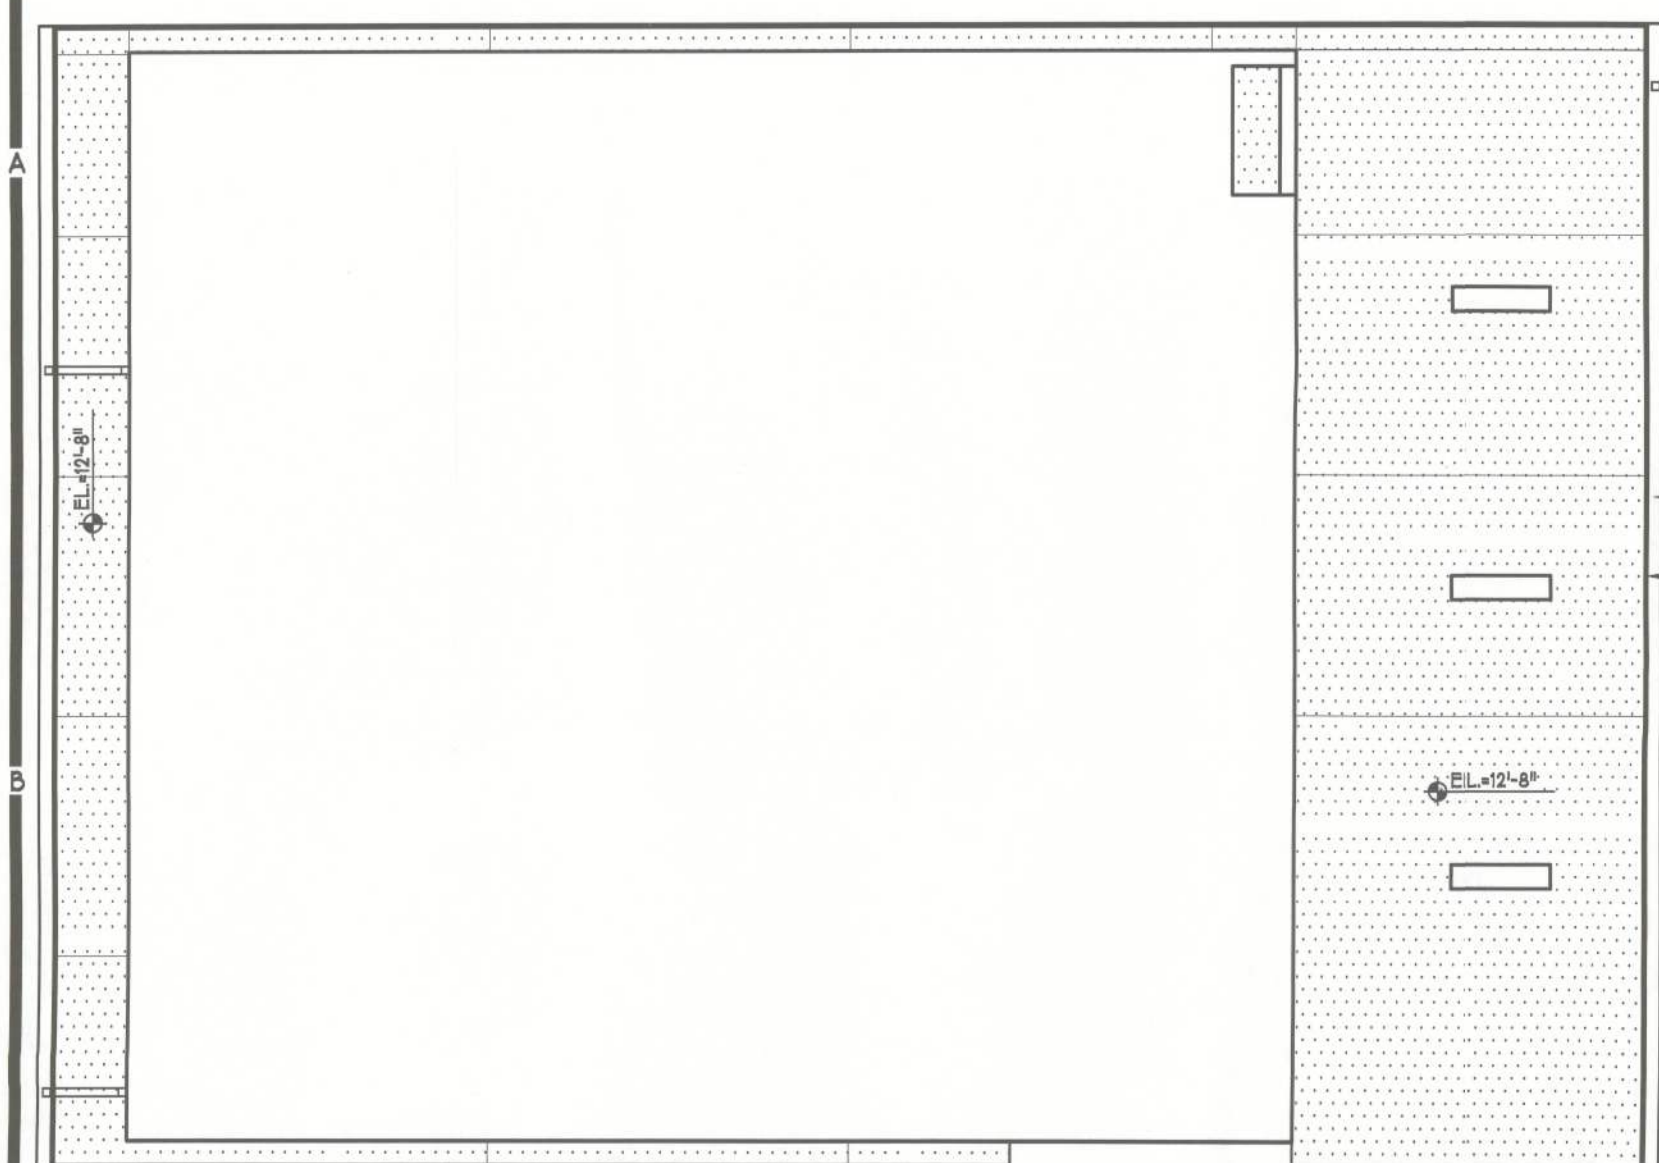


SOFFIT DETAIL AT WAREHOUSE
1B A6.1 SCALE: 1/8" = 1'-0"

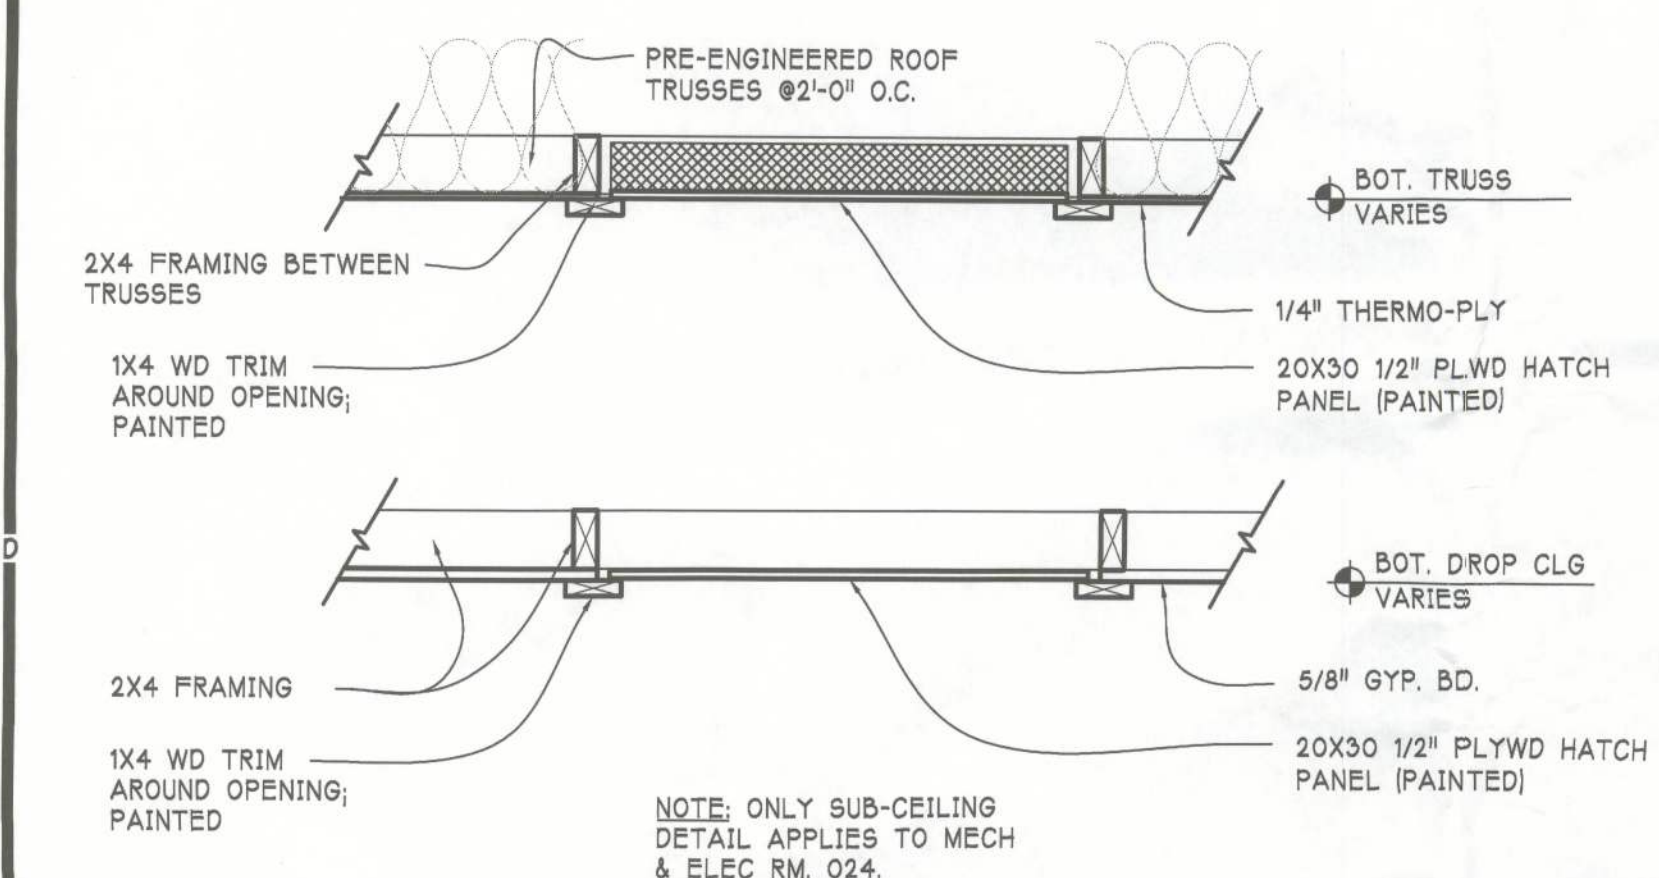


CEILING PANEL DETAIL
1E A6.1 SCALE: 1" = 1'-0"

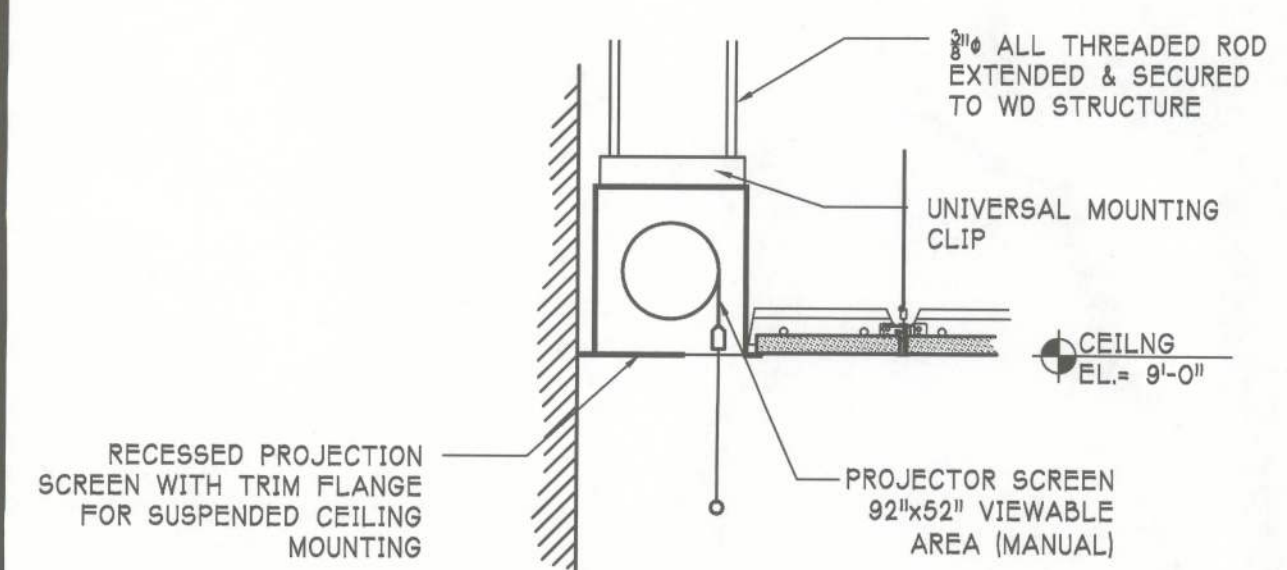

RECESSED PROJECTOR SCREEN DETAIL
1G A6.1 SCALE: 1" = 1'-0"

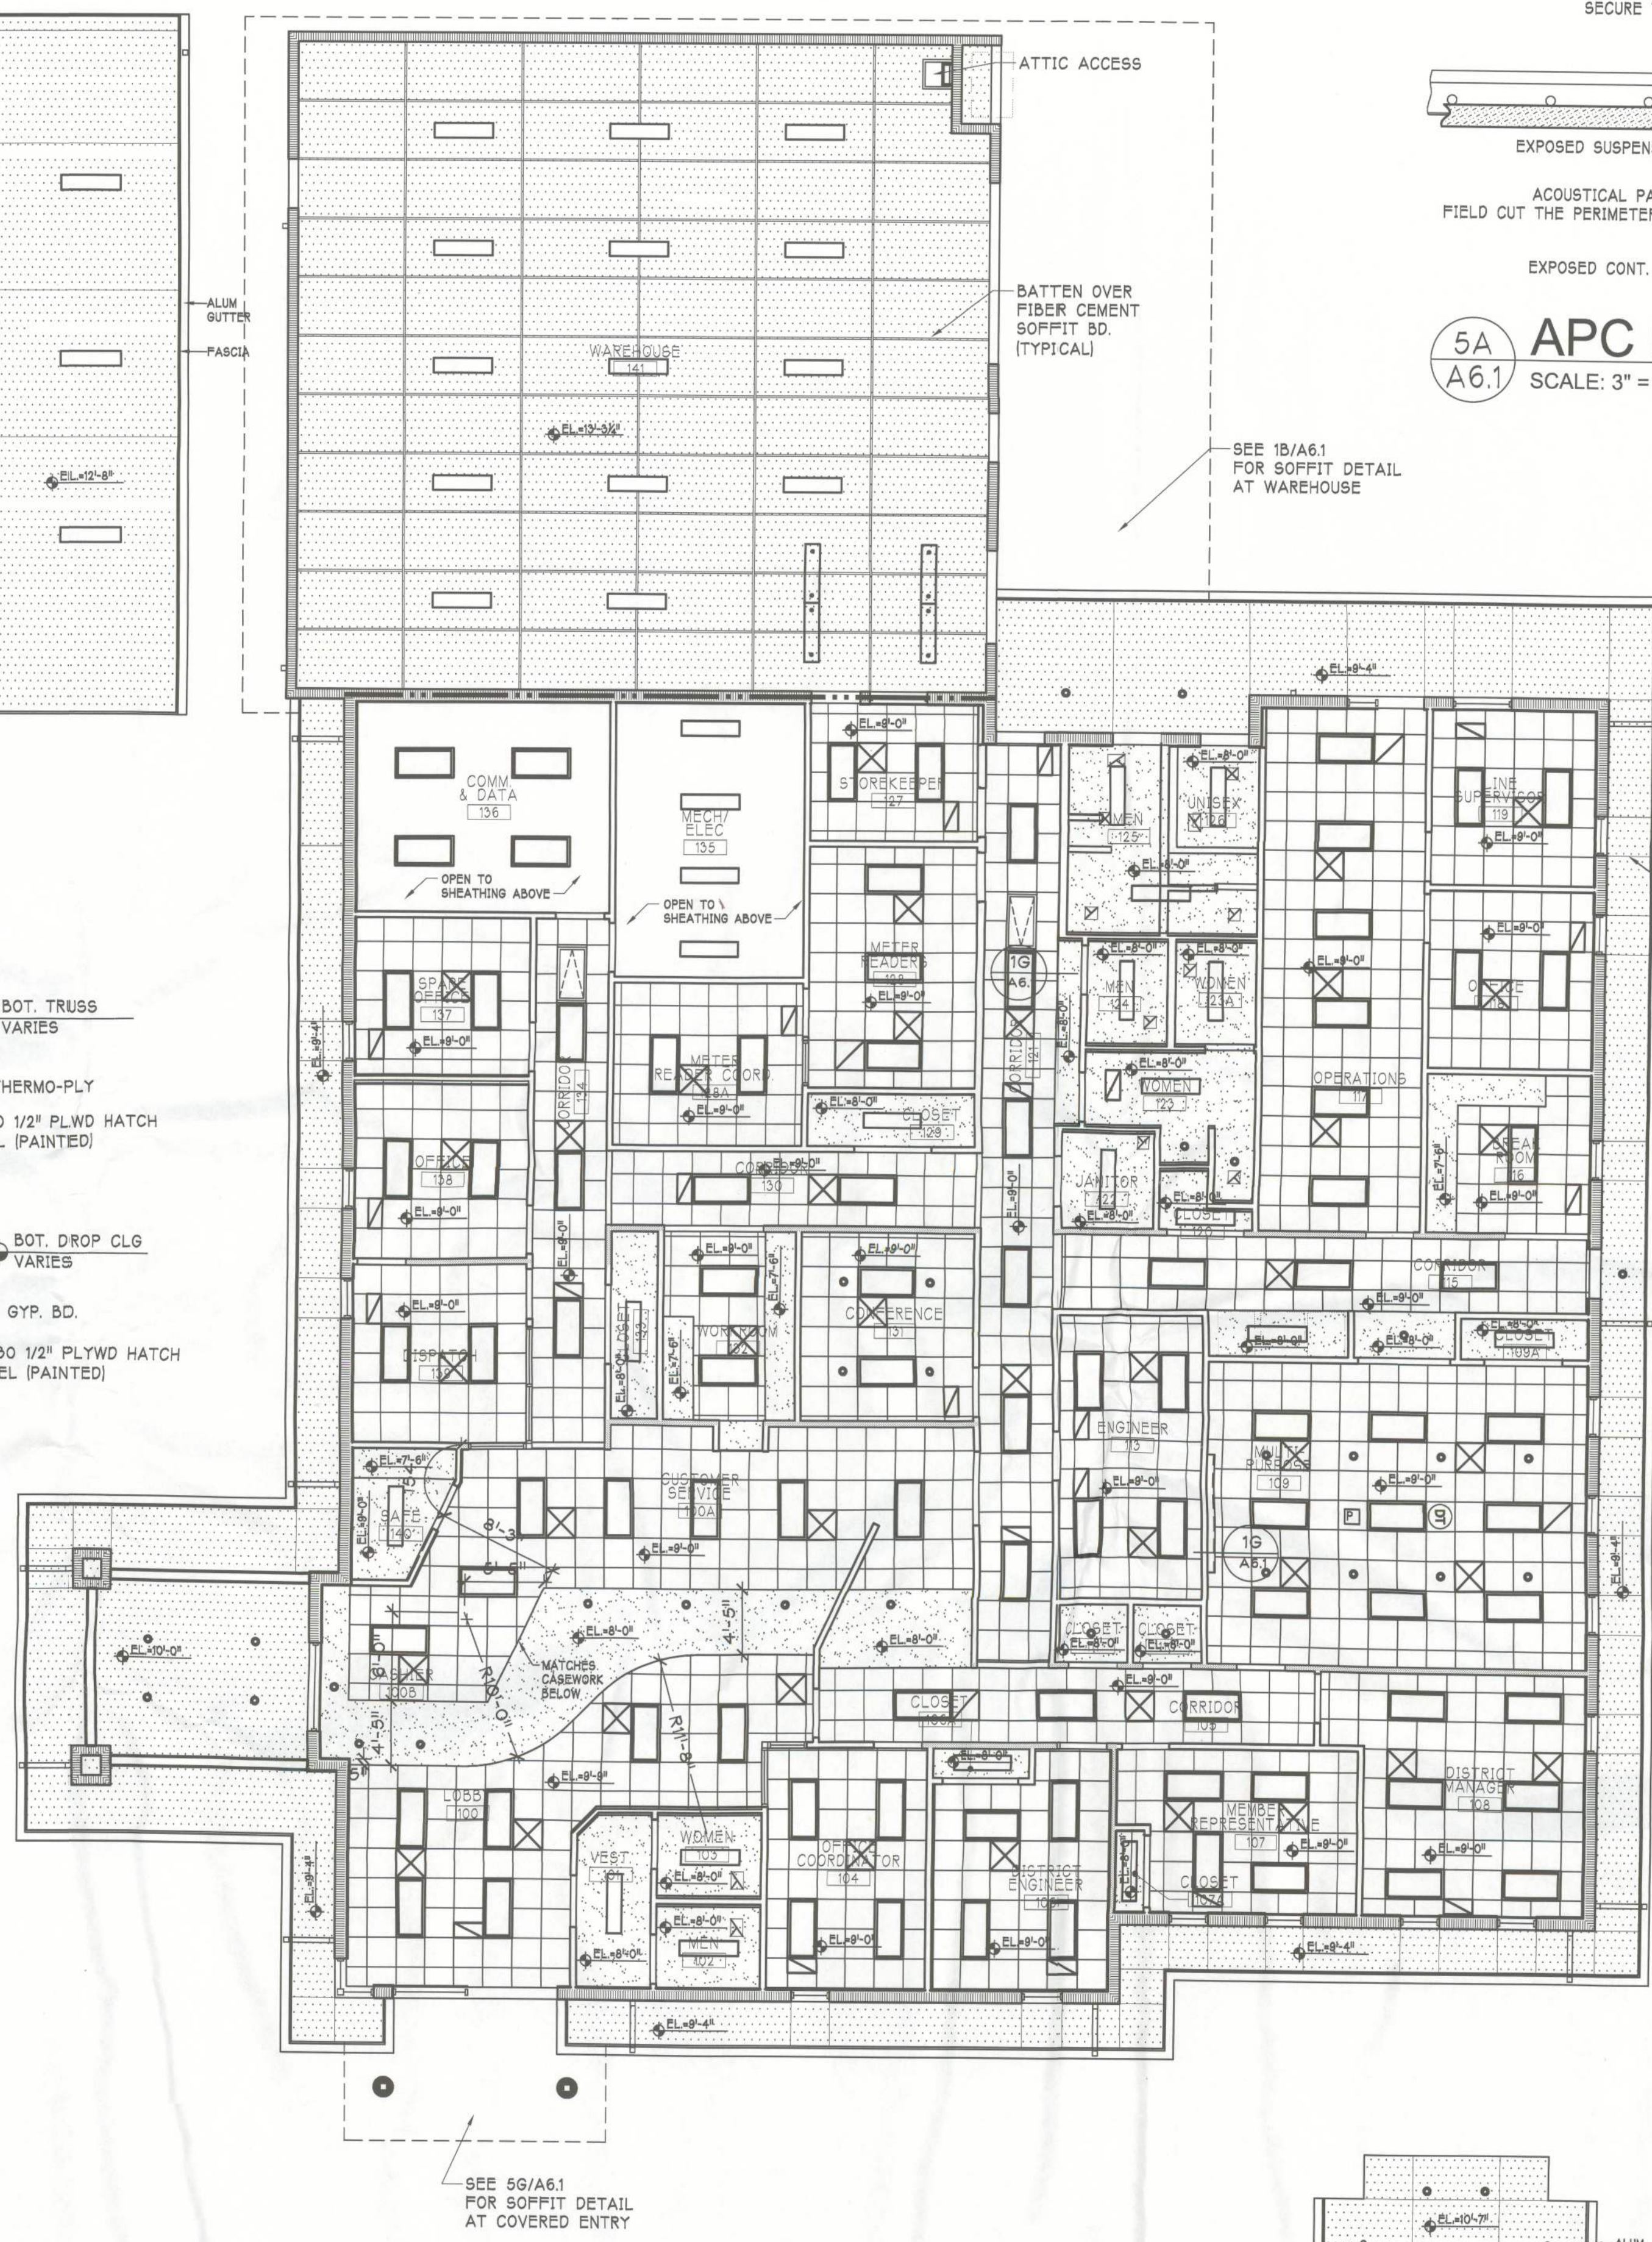

REFLECTED CEILING PLAN
SCALE: 1/8" = 1'-0"

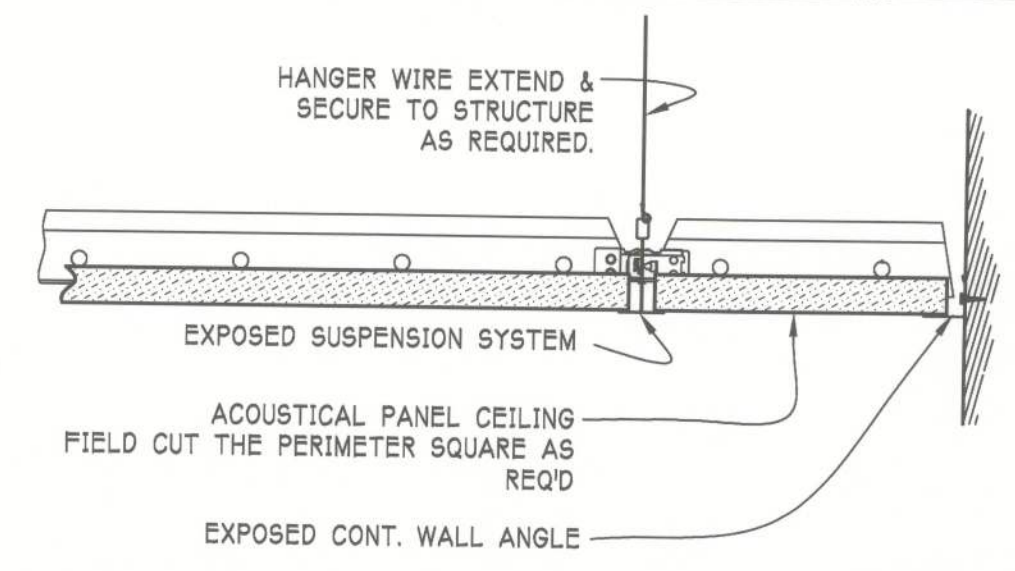

5A APC DETAIL (TYP.)
A6.1 SCALE: 3" = 1'-0"


SOFFIT DETAIL AT COVERED ENTRY
5G A6.1 SCALE: 1/8" = 1'-0"

REFLECTED CEILING PLAN LEGEND:

	2x4' RECESSED FLUORESCENT LIGHT		2x4' SURFACED MOUNTED FLUORESCENT LIGHT
	1x4' RECESSED FLUORESCENT LIGHT		1x4' SURFACED MOUNTED FLUORESCENT LIGHT
	FINISH CEILING HEIGHT ABOVE FINISH FLOOR OF SPACE TAGGED		1x4' HANGING FLUORESCENT LIGHT
	GYPSUM BOARD SOFFIT OR CEILING		RECESSED COMPACT FLUORESCENT LIGHT
	2x2' ACOUSTICAL PANEL CEILING (APC-1)		WALL SCONCE
	EXTEND PARTITION TO BOTTOM CORD OF TRUSS		RETURN AIR GRILLE
	3/8" CEMENT PLASTER ON MTL. LATH SOFFIT		SUPPLY AIR DIFFUSER
	ATTIC ACCESS W/ PULL DOWN LADDER		EXHAUST GRILLE
			CEILING PROJECTOR MOUNT
			ATTIC ACCESS PANEL (SEE 1E/A6.1)

GENERAL CEILING NOTES:

- ALL CEILING HEIGHTS SHOWN ARE FROM FINISH FLOOR OF SPACE TAGGED.
- SEE MECHANICAL AND ELECTRICAL PLANS FOR TYPES OF FIXTURES, ROUTE OF DUCTWORK, ETC. FOR ADDITIONAL INFORMATION NOT SHOWN.
- ALL CEILING GRID, SUPPLY AND RETURN DIFFUSERS, CEILING ACCESS PANELS AND LIGHT FIXTURE TRIM TO MATCH COLOR OF CEILING TILE.
- COORDINATE LOCATION OF ATTIC ACCESS HATCH AND OTHER CEILING ACCESSORIES WITH ROOF TRUSSES.
- PROVIDE ATTIC ACCESS HATCHES AT BOTH FINISHED CEILING & SUB CEILING AT BOTTOM CORD OF TRUSSES. COORDINATE LOCATION OF HATCH W/TRUSSES. (SEE DETAIL 1E/A6.1)

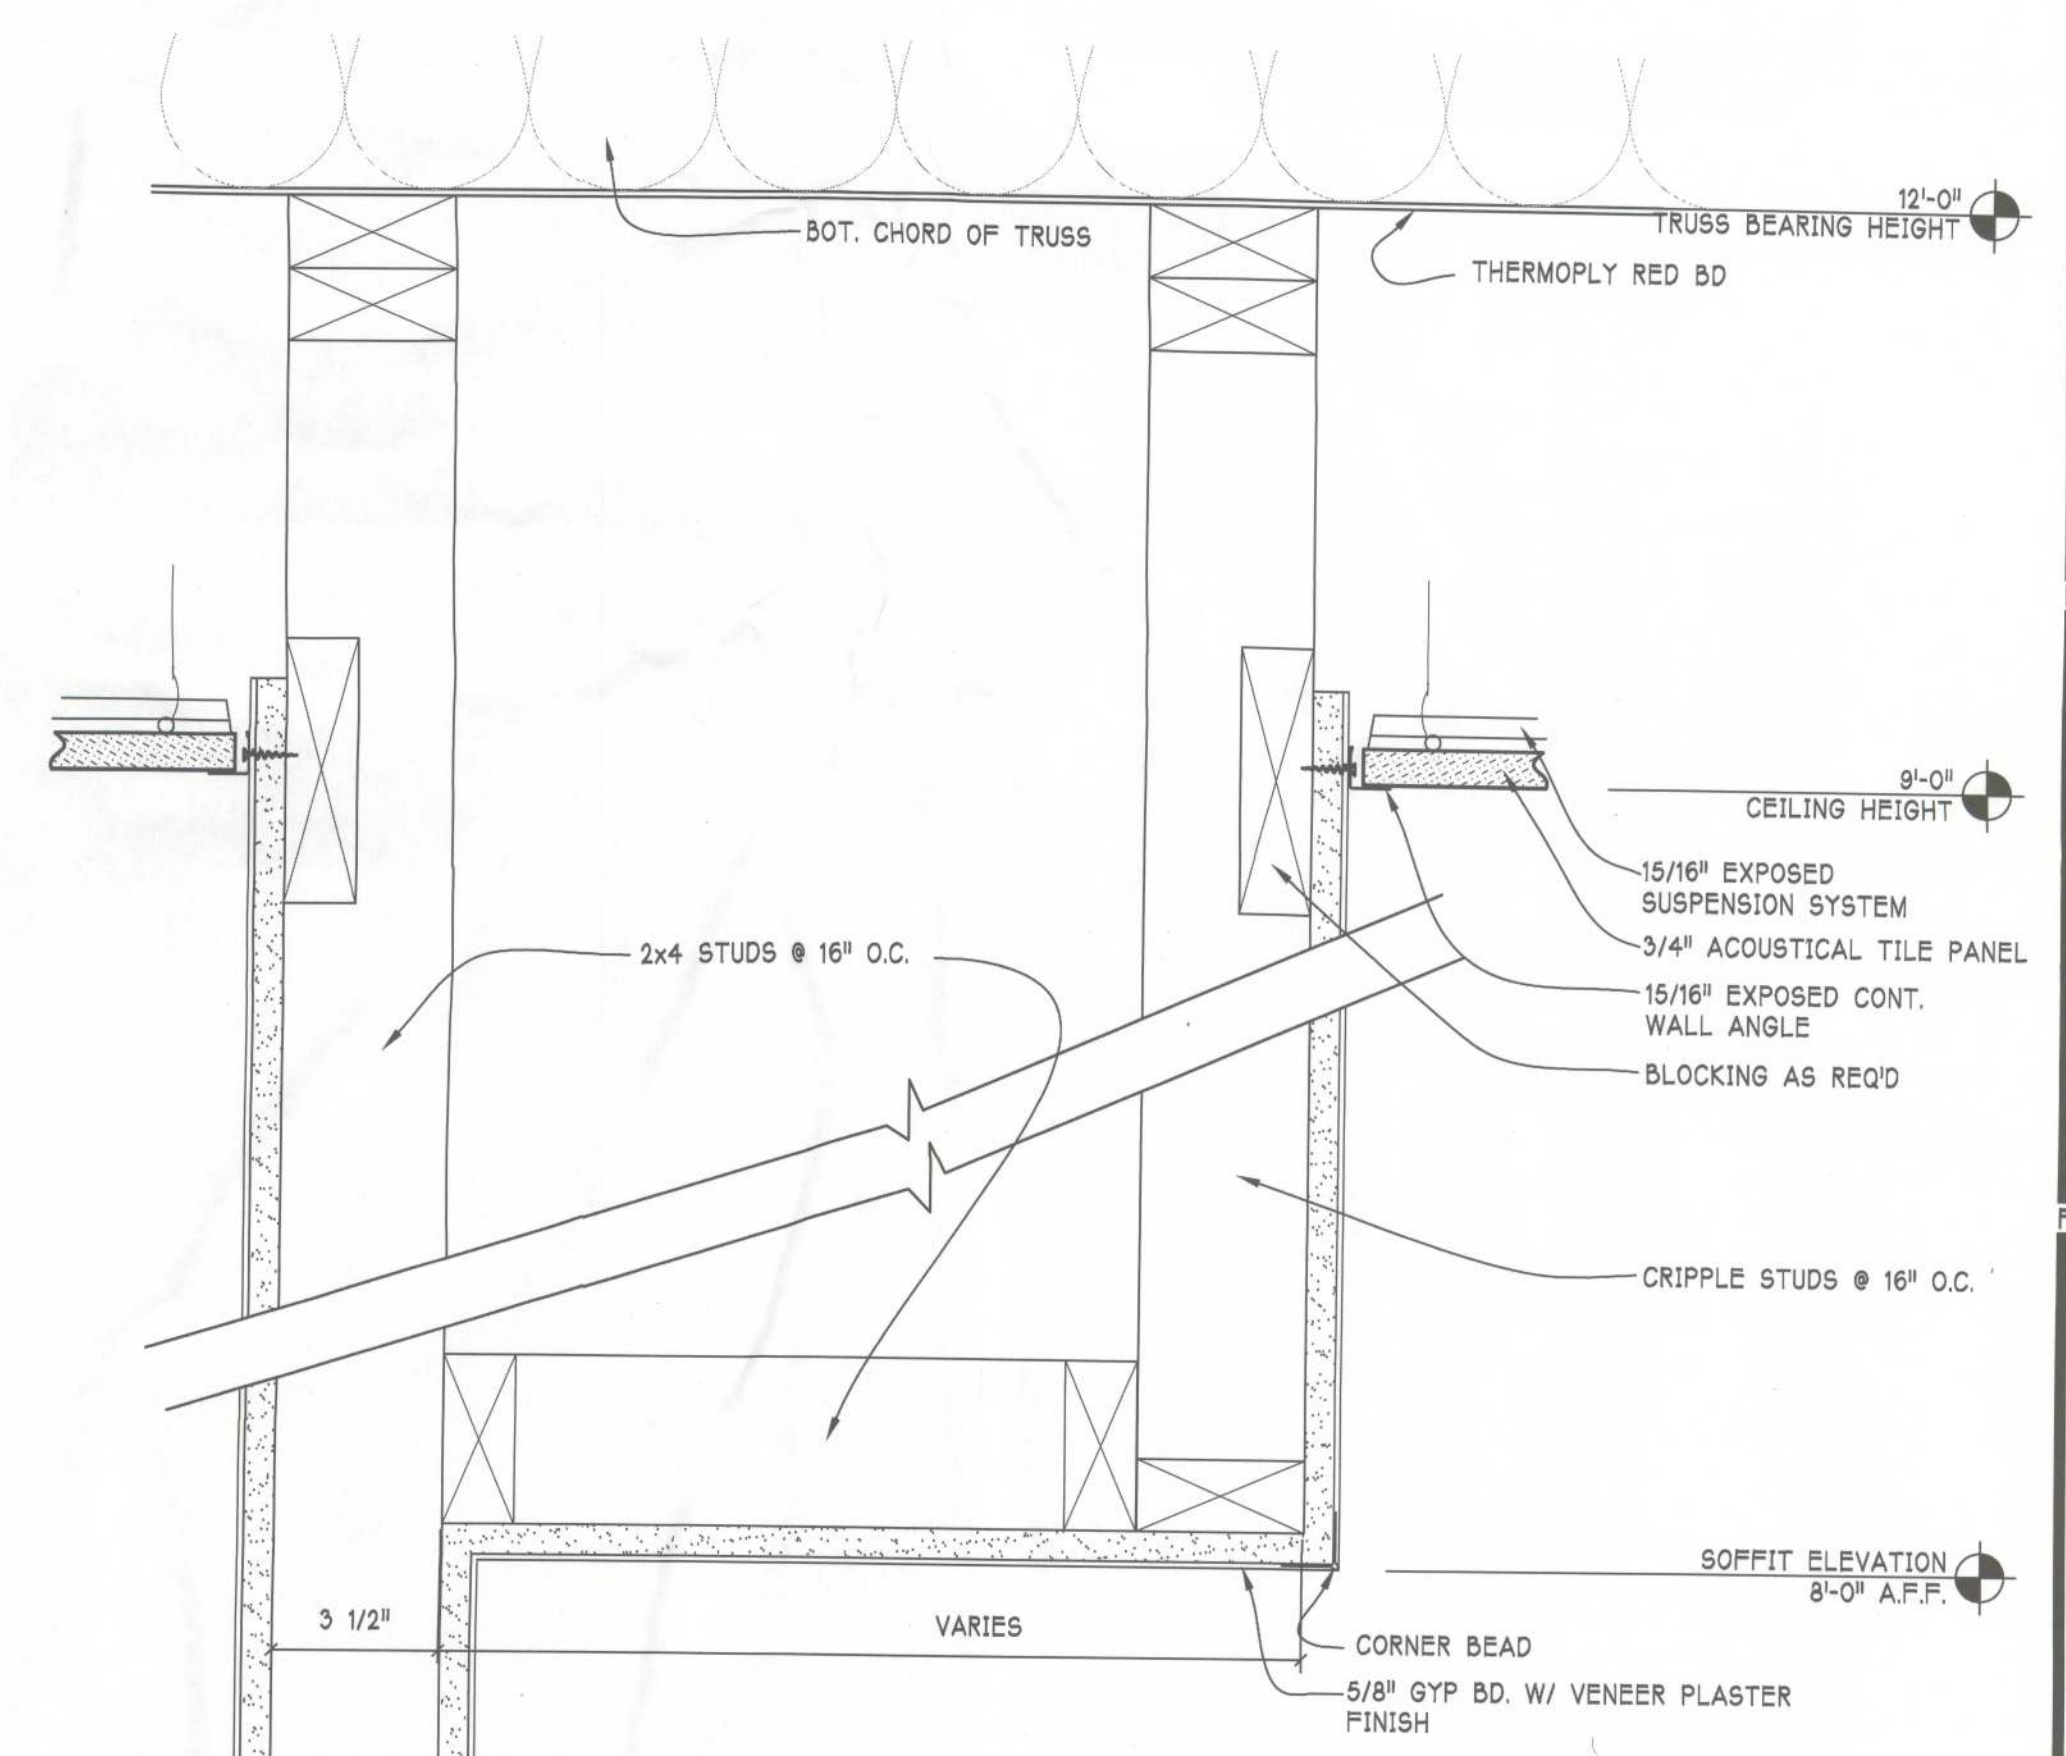

7G SOFFIT DTL
A6.1 SCALE: 3" = 1'-0"

Brame Architects
606 N.E. First Street
Gainesville, Florida 32601
352 / 372-0425
FAX 352 / 372-0427

Clay Electric Cooperative, Inc.
A Touchstone Energy Cooperative

NEW DISTRICT OFFICE
1659 SW State Road 47 Lake City, Florida

WILLIAM W. BRAME
REGISTRATION # AN-0007024
CORP. LIC. NO. AA C000071

REFLECTED CEILING PLAN AND DETAILS

DRAWN GBV, SPL
CHECKED BB
DATE 02/07/2012
CAD 3702060/CD

REVISIONS

FILE NO. 3702.060
SHEET

A6.1

Bid Documents