



REAR ELEVATION

SCALE: 1/4" = 1'-0"




FRONT ELEVATION

SCALE: 1/4" = 1'-0"

REVISIONS SCHEDULE		
Aug. 10th, 2020	PROPOSAL	
Sept. 25th, 2020	REVISIONS	

SPARKS RESIDENCE

LIVE OAK, FLORIDA

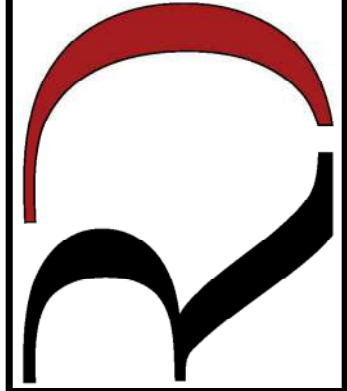

RIDGEPOINT
DESIGN

566 SW ARINGTON BLVD., STE 101, LAKE CITY, FL 32025


P: 386-288-1188

E: RIDGEPOINTDESIGN@GMAIL.COM


SHEET NUMBER

A.1


OF 4 SHEETS

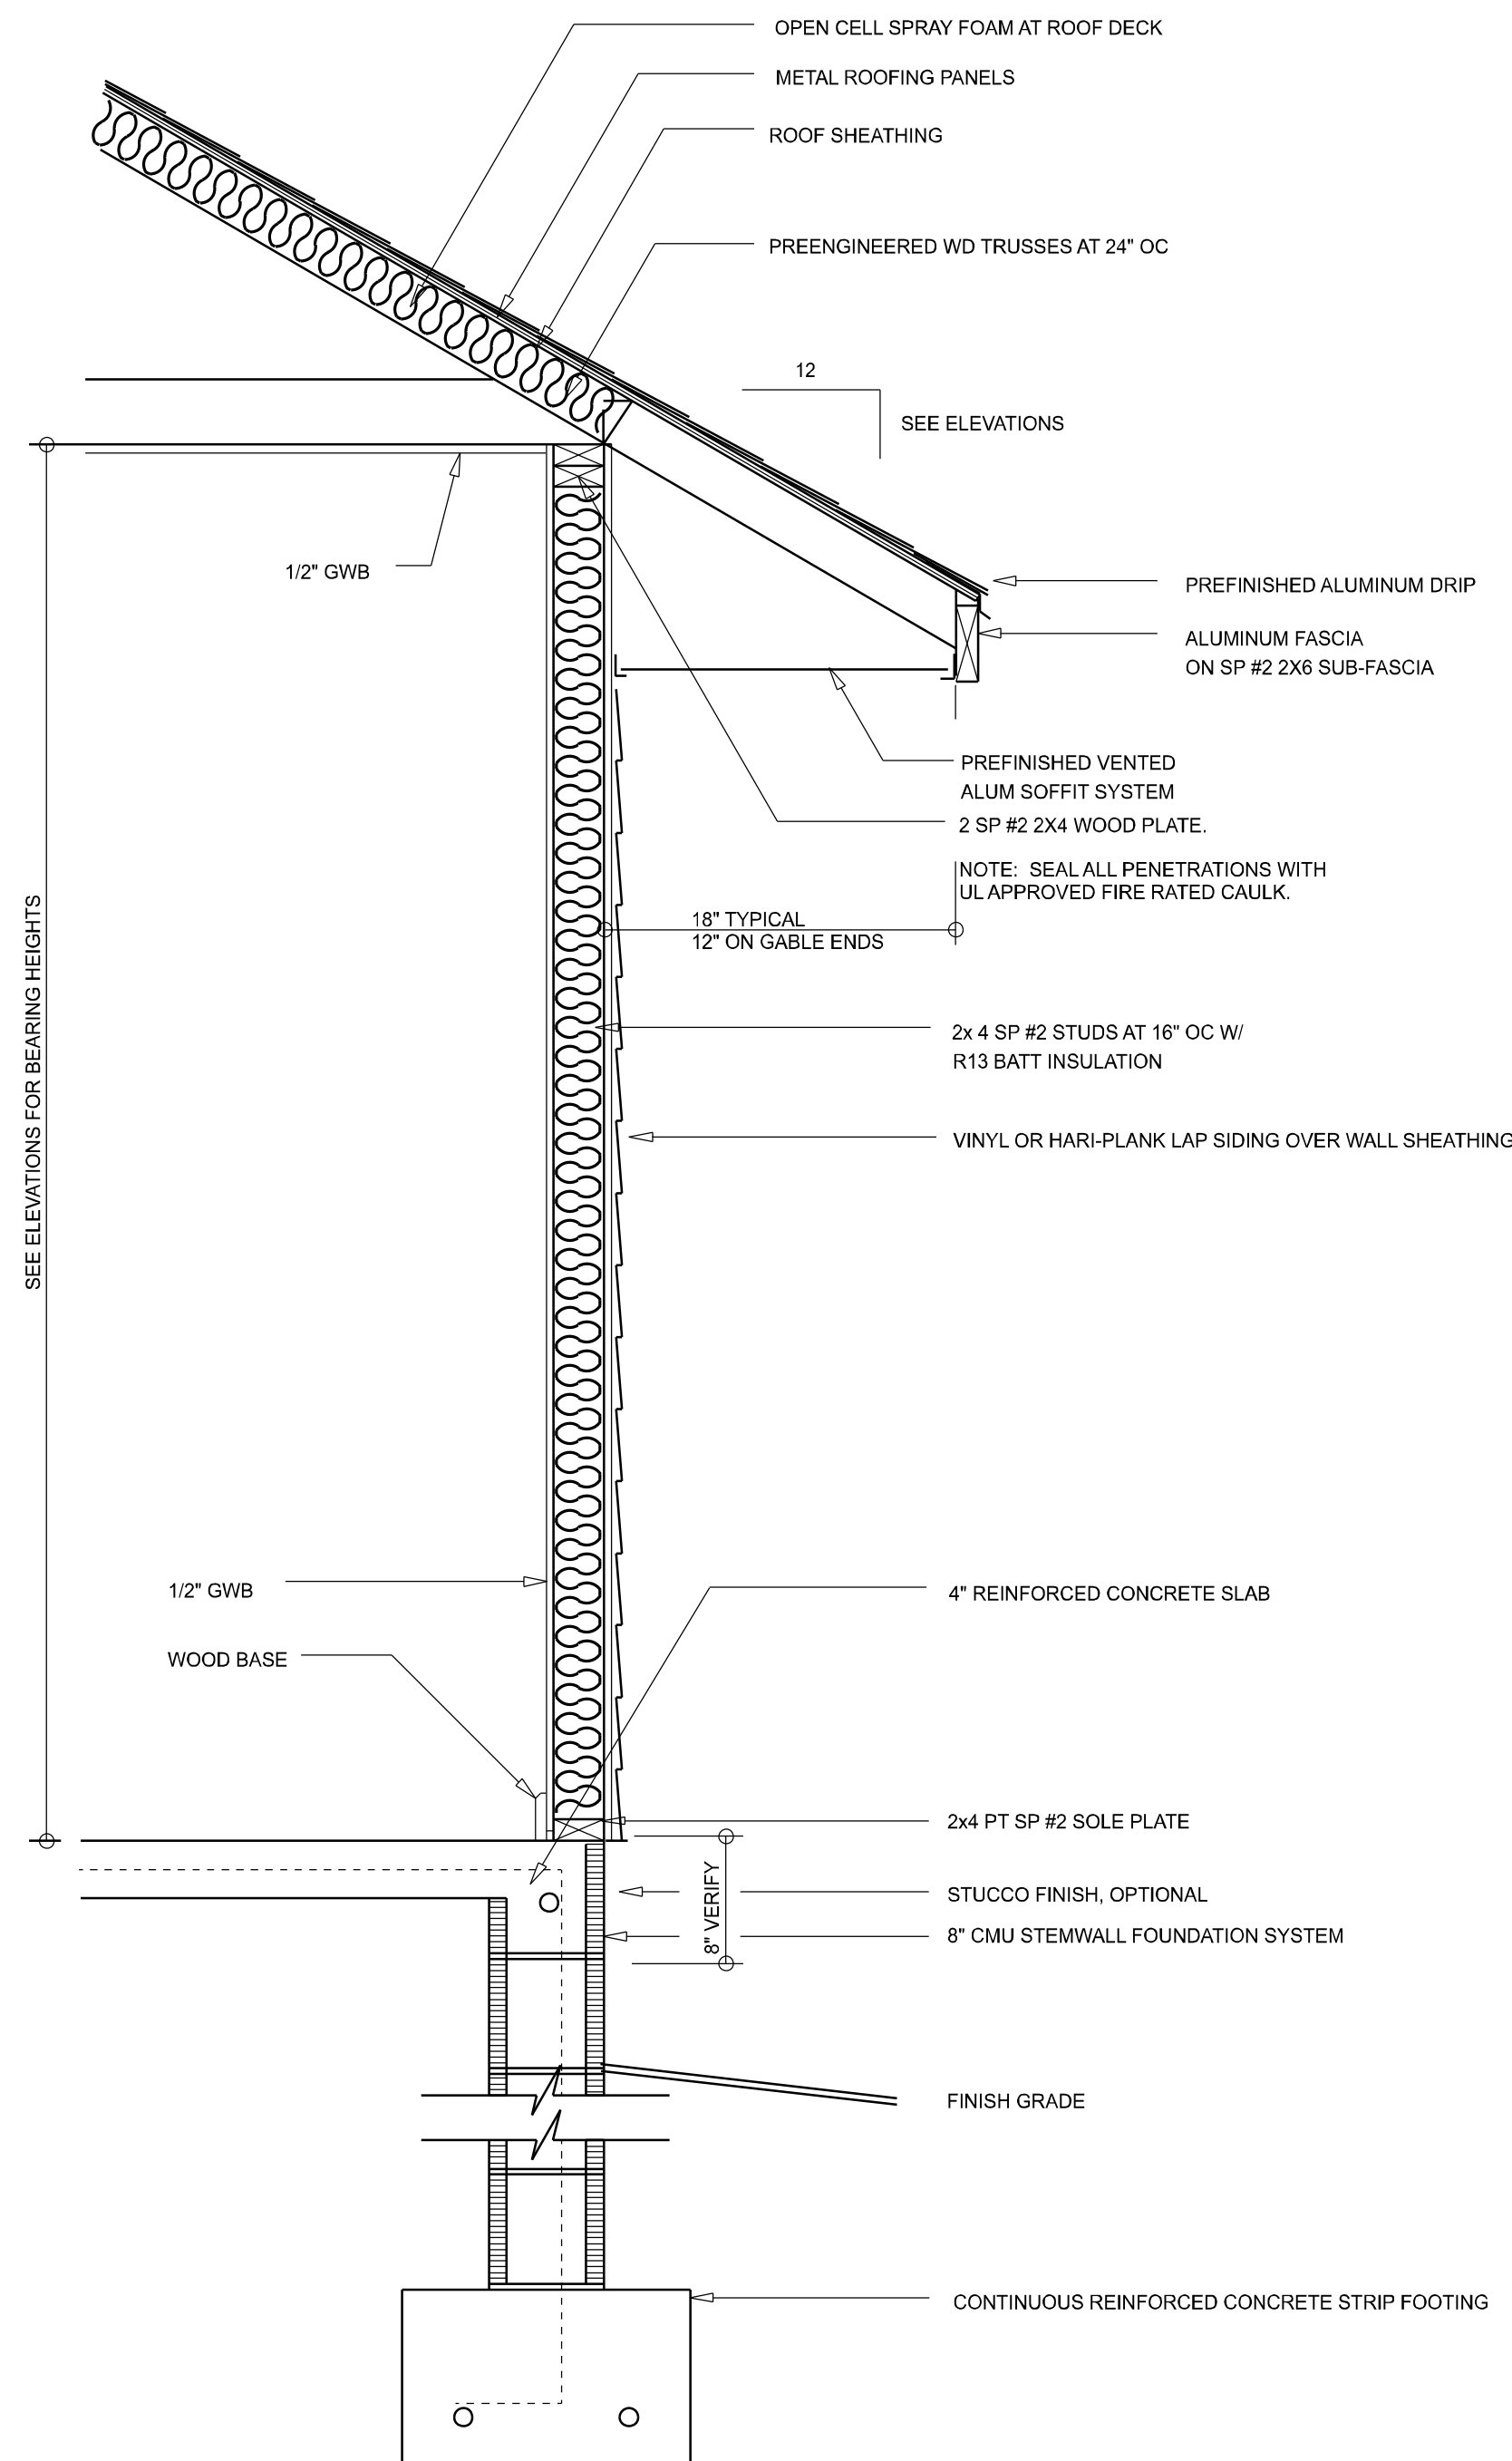

TYPICAL WALL SECTION
SCALE: 1" = 1'-0"

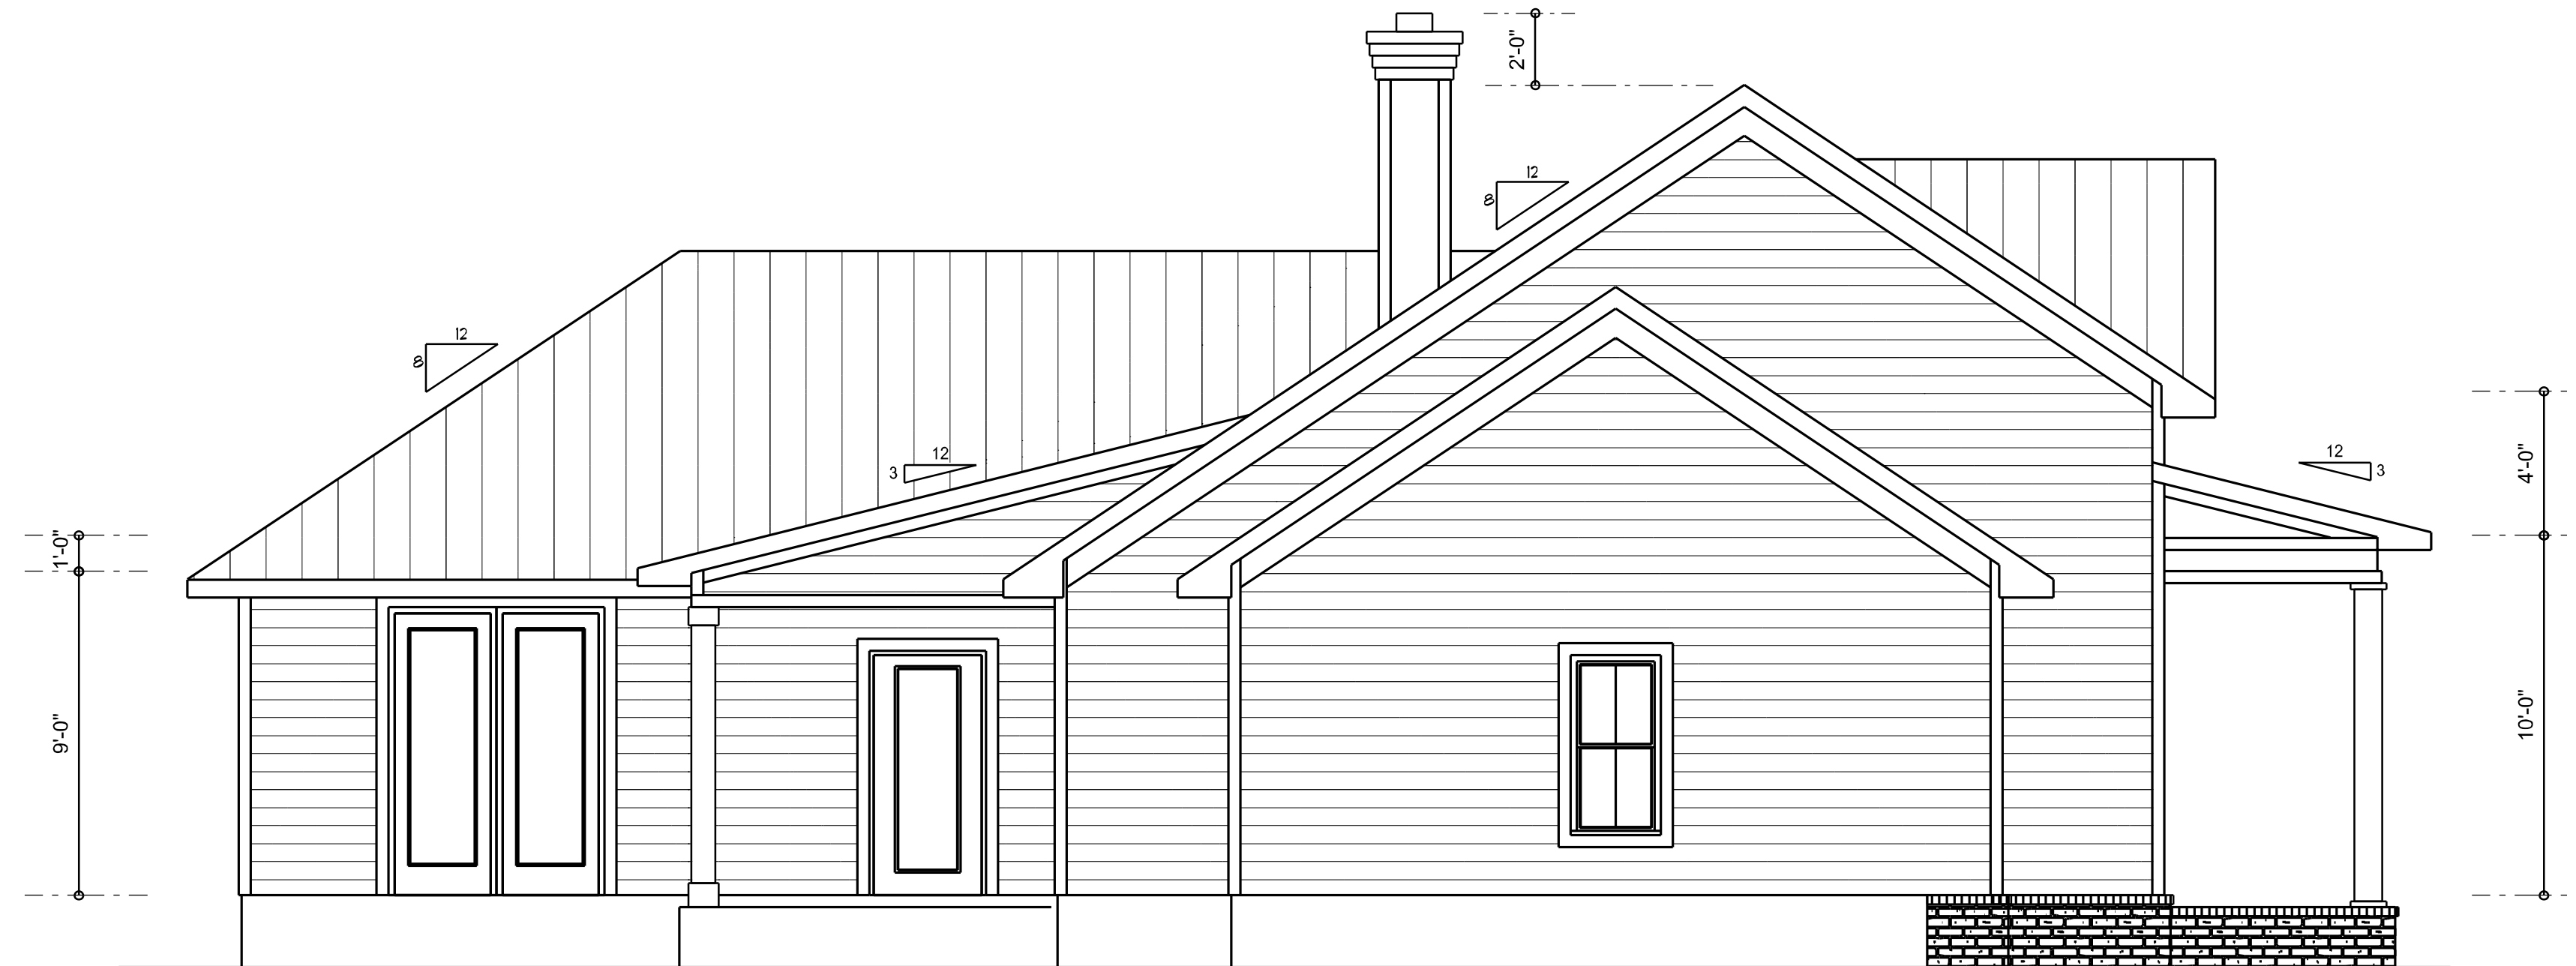

LEFT ELEVATION
SCALE: 1/4" = 1'-0"

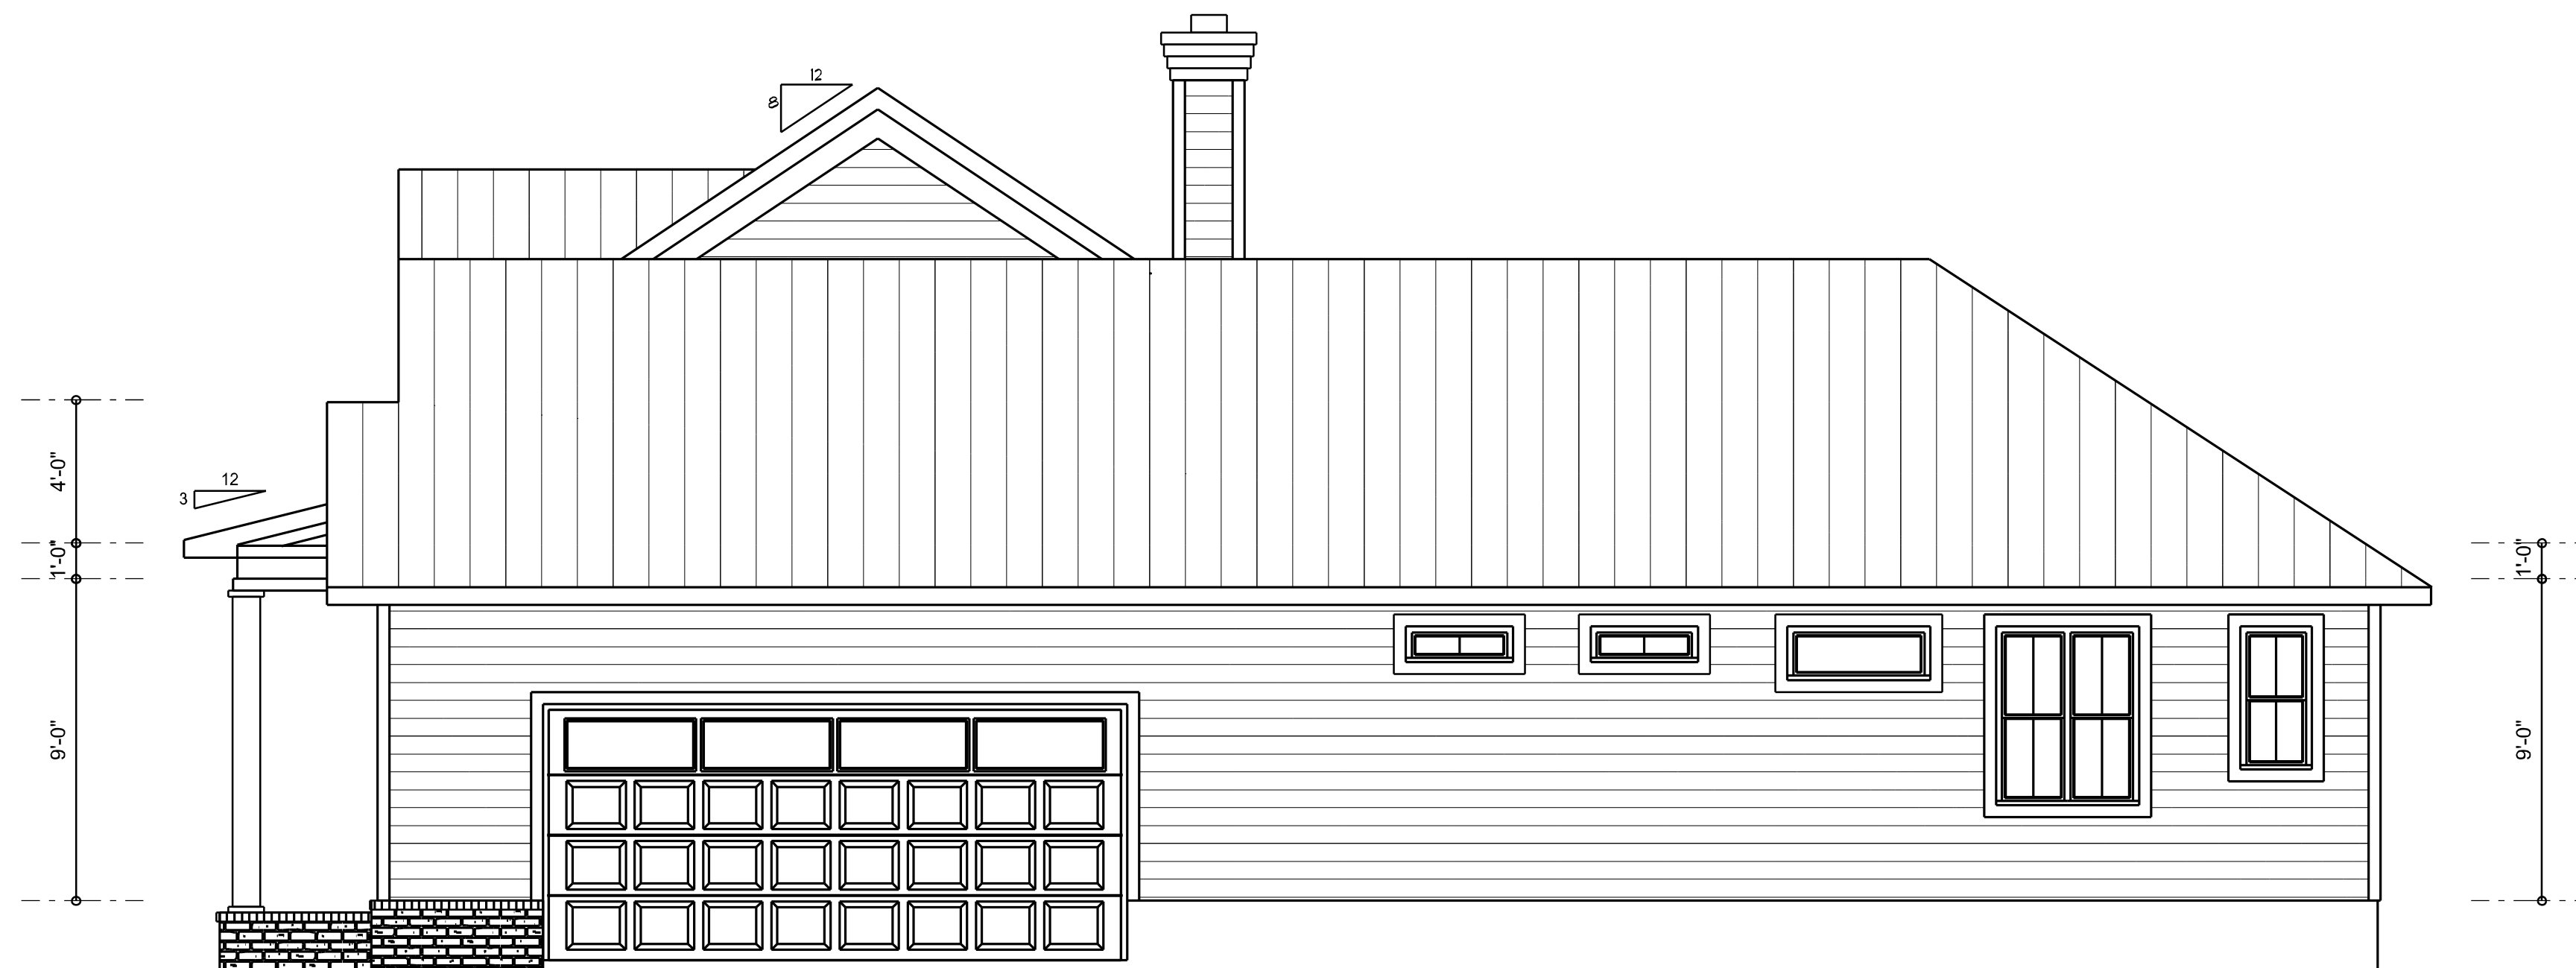


RIGHT ELEVATION
SCALE: 1/4" = 1'-0"


REVISIONS SCHEDULE	
Aug. 10th, 2020	PROPOSAL
Sept. 25th, 2020	REVISIONS

SPARKS RESIDENCE
LIVE OAK, FLORIDA

RIDGEPOINT DESIGN
566 SW ARINGTON BLVD., STE 101, LAKE CITY, FL 32025
P: 386-288-1188
E: RIDGEPOINTDESIGN@GMAIL.COM

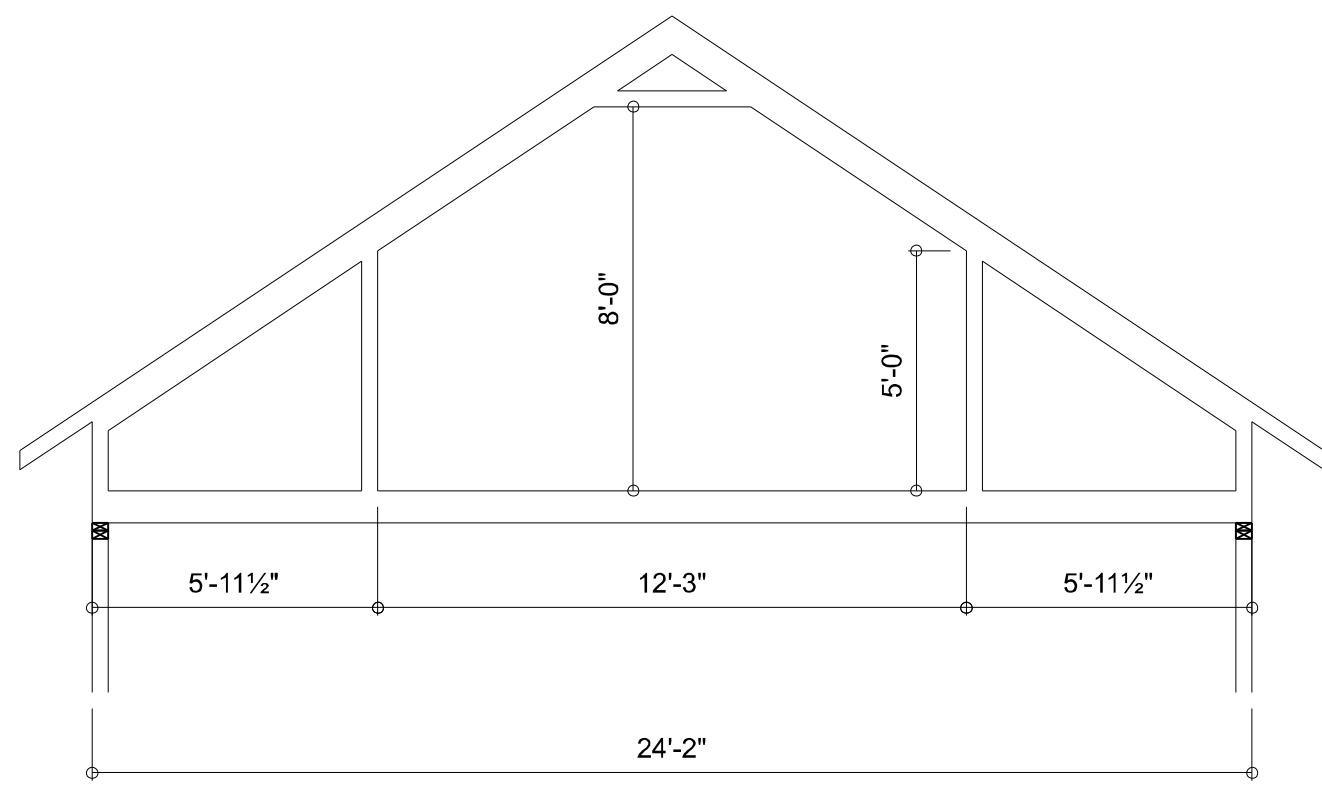


PROPOSED BONUS TRUSS
SCALE: 1/4" = 1'-0"

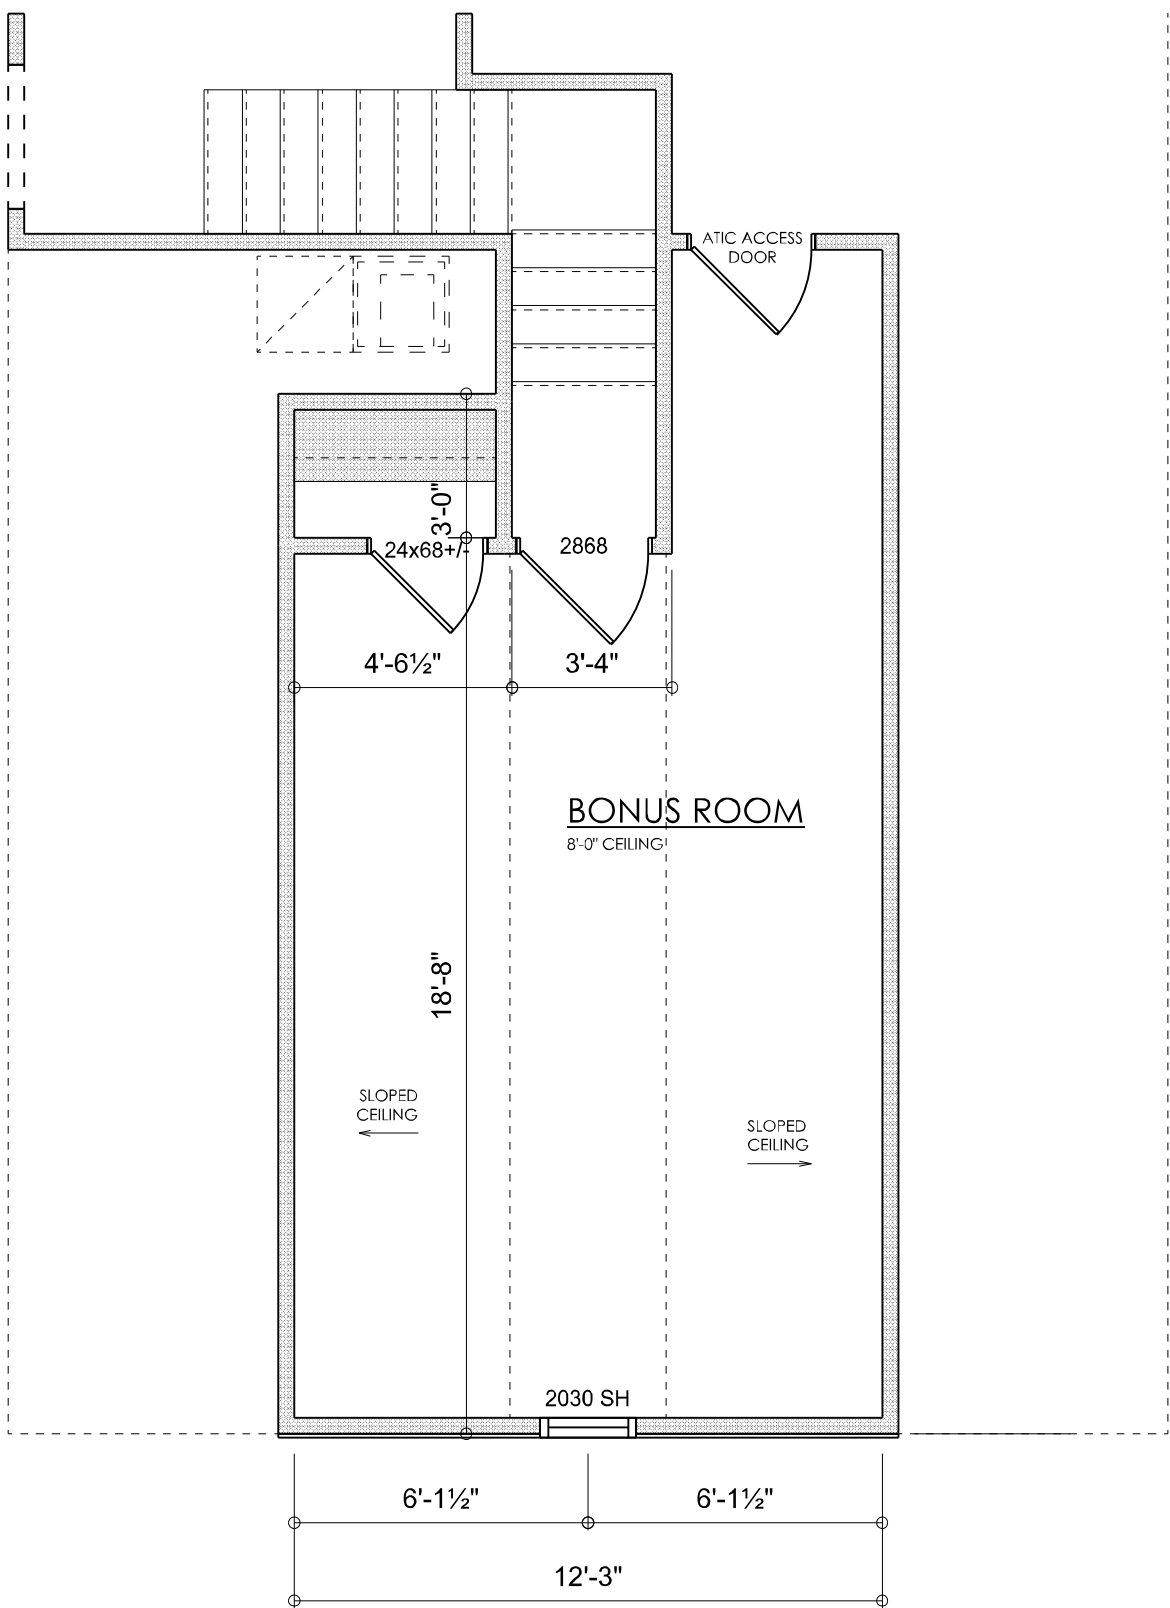

AREA SUMMARY		
LIVING	2,002	S.F.
BONUS ROOM	289	S.F.
TOTAL LIVING	2,291	S.F.
ENTRY PORCH	183	S.F.
REAR PORCH	351	S.F.
GARAGE	625	S.F.
TOTAL UNDER ROOF	3,450	S.F.

PROPOSED HEEL HGT
& GARAGE TRUSSES
(MAIN HOUSE & 6' HEEL?)

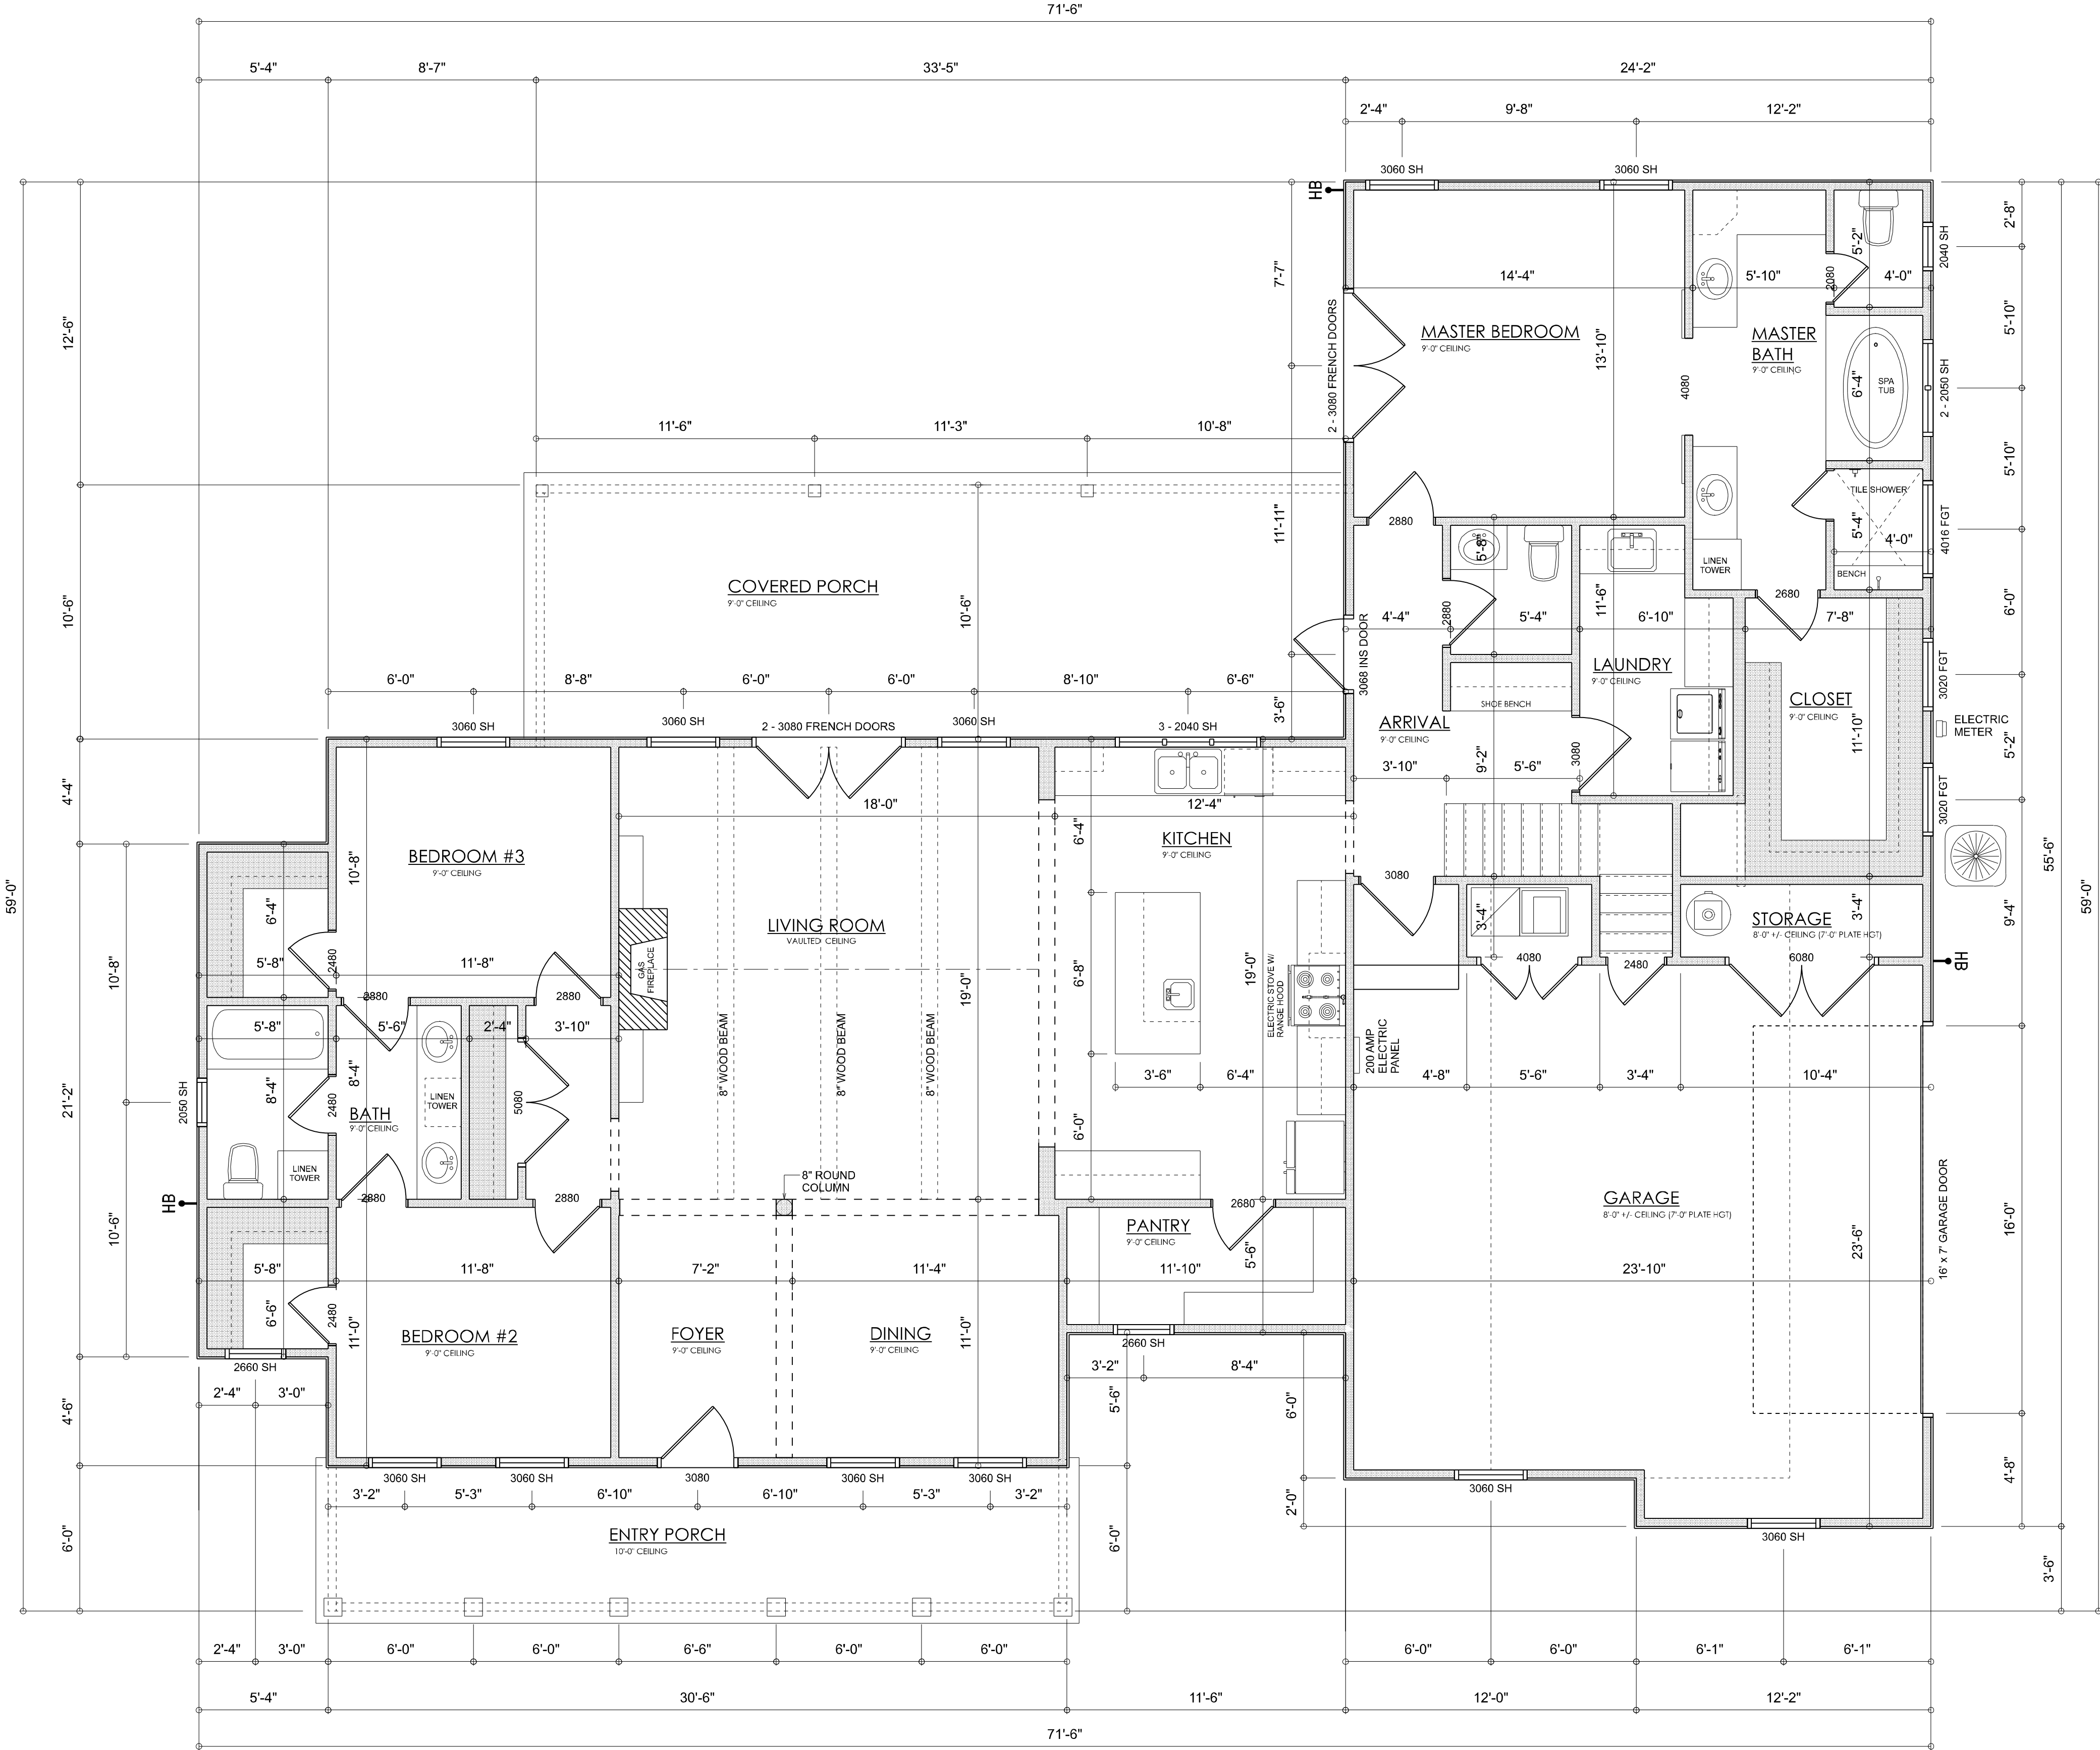

DIMENSIONED FLOOR PLAN
SCALE: 1/4" = 1'-0"

Garage fire separations shall comply with the following:

- The private garage shall be separated from the dwelling unit and its attic area by means of a minimum 1/2-inch (12.7 mm) gypsum board applied to the garage side. Garages beneath habitable rooms shall be separated from all habitable rooms above by not less than 5/8-inch Type X gypsum board or equivalent. Door openings between a private garage and the dwelling unit shall be equipped with either solid wood doors, or solid or honeycomb core steel doors not less than 13/8 inches (34.9 mm) thick, or doors in compliance with Section 715.3.3. Openings from a private garage directly into a room used for sleeping purposes shall not be permitted.
- Ducts in a private garage and ducts penetrating the walls or ceilings separating the dwelling unit from the garage shall be constructed of a minimum 0.019-inch (0.48 mm) sheet steel and shall have no openings into the garage.
- A separation is not required between a Group R-3 and U carport provided the carport is entirely open on two or more sides and there are not enclosed areas above.
- When installing an attic access and/or pull-down stair unit in the garage, devise shall have a minimum 20 min. fire rating.




REVISIONS SCHEDULE	
Aug. 10th, 2020	PROPOSAL
Sept. 25th, 2020	REVISIONS

SPARKS RESIDENCE
LIVE OAK, FLORIDA

RIDGEPOINT
DESIGN

566 SW ARINGTON BLVD., STE 101, LAKE CITY, FL 32025
P: 386-288-1188
E: RIDGEPOINTDESIGN@GMAIL.COM

  SHEET NUMBER
A.3
OF 4 SHEETS

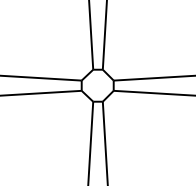ELECTRICAL LEGEND		
ELECTRICAL	COUNT	SYMBOL
ceiling fan 4 bladed 01	7	
ceiling light 17	2	
fluorescent light 1 x 4	6	
pendant cube	2	
pot light	22	
exterior light 01	4	
spotlight double	5	
electrical meter	1	
cable tv outlet	5	
co detector	1	
fan	3	
light	13	
outlet	43	
outlet 220v	5	
outlet gfi	20	
outlet wp	4	
smoke detector	6	
switch	37	
switch 3 way	18	
vanity bar light 02	6	

ELECTRICAL PLAN NOTES:

INSTALLATION SHALL BE PER LATEST NAT'L ELECTRIC CODE.

WIRE ALL APPLIANCES, HVAC UNITS AND OTHER EQUIPMENT PER MANUF. SPECIFICATIONS

CONSULT WITH THE OWNER FOR THE NUMBER OF SEPERATE TELEPHONE LINES TO BE INSTALLED

ALL SMOKE DETECTORS SHALL BE 120v W/ BATTERY BACKUP OF THE PHOTOELECTRIC TYPE, AND SHALL BE INTERLOCKED TOGETHER. INSTALL INSIDE AND NEAR ALL BEDROOMS

TELEPHONE, TELEVISION AND OTHER LOW VOLTAGE DEVICES OR OUTLETS SHALL BE AS PER THE OWNER'S DIRECTIONS, & IN ACCORDANCE W/ APPLICABLE SECTIONS OF NEC-LATEST EDITION.

ALL RECEPTICALS, NOT OTHERWISE NOTED, SHALL BE ARC FAULT INTERRUPTER TYPE, EXCEPT DEDICATED OUTLETS


ALL RECEPTICALS IN WET AREAS SHALL BE GROUND FAULT INTERRUPTER TYPE (GFI)

ALL EXTERIOR RECEPTICALS SHALL BE WEATHERPROOF GROUD FAULT INTERRUPTER TYPE (WP/GFI)

NOTE:
ELECTRICAL CONTR SHALL PREPARE "AS-BUILT" SHOP DWGS INDICATING ALL ELECTRICAL WORK, INCLUDING ANY CHANGES TO THE ELEC. PLAN, ADD'NS TO THE ELEC. PLAN, RISER DIAGRAM, AS-BUILT PANEL SCHEDULE W/ ALL CKTS IDENTIFIED W/ CKT N^o DESCRIPTION & BRKR, SERVICE ENT. & ALL UNDERGROUND WIRE LOCATIONS/ROUTING / DEPTH. RISER DIA. SHALL INCLUDE WIRE SIZES/TYPE & EQUIPMENT TYPE W/ RATINGS & LOADS.
CONTRACTOR SHALL PROVIDE 1 COPY OF AS-BUILT DWGS TO OWNER & 1 COPY TO THE PERMIT ISSUING AUTHORITY

ELECTRICAL PLAN

SCALE: 1/4" = 1'-0"

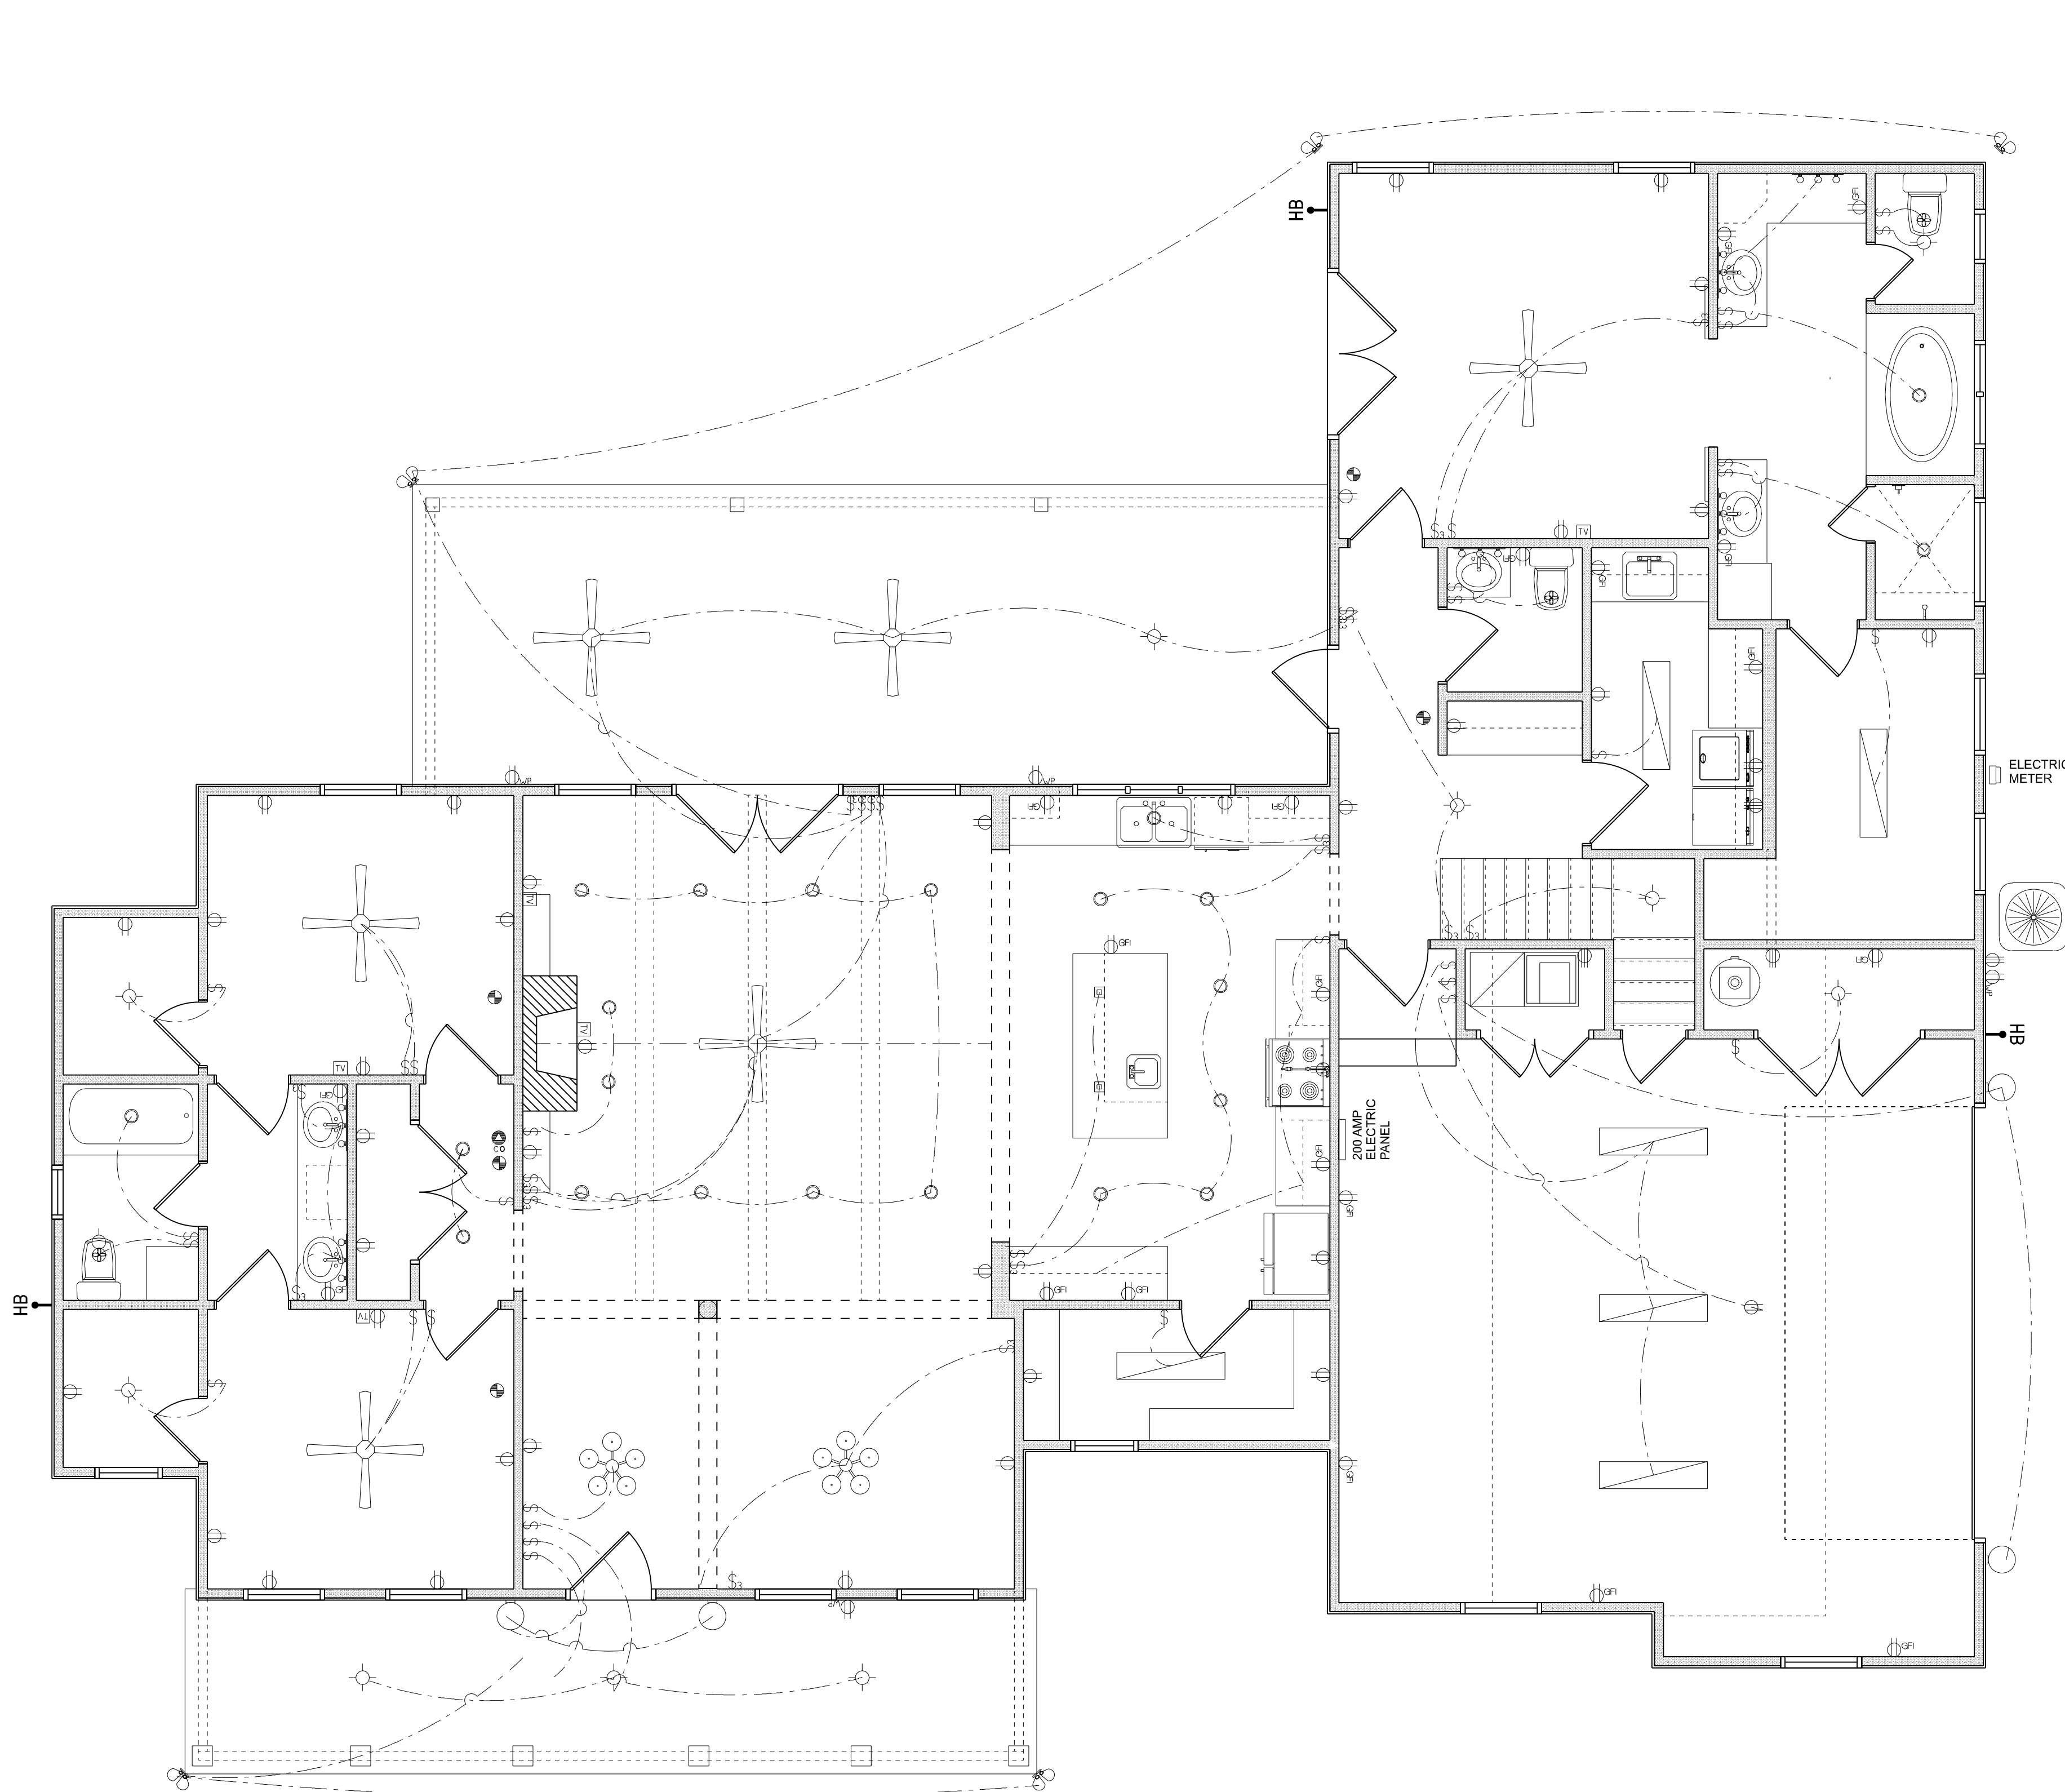

REVISIONS SCHEDULE	
Aug. 10th, 2020	PROPOSAL
Sept. 25th, 2020	REVISIONS

SPARKS RESIDENCE
LIVE OAK, FLORIDA

RIDGEPOINT DESIGN
566 SW ARINGTON BLVD., STE 101, LAKE CITY, FL 32025
P: 386-288-1188
E: RIDGEPOINTDESIGN@GMAIL.COM

SHEET NUMBER
A.4
OF 4 SHEETS