


Adding to End

PHHHS

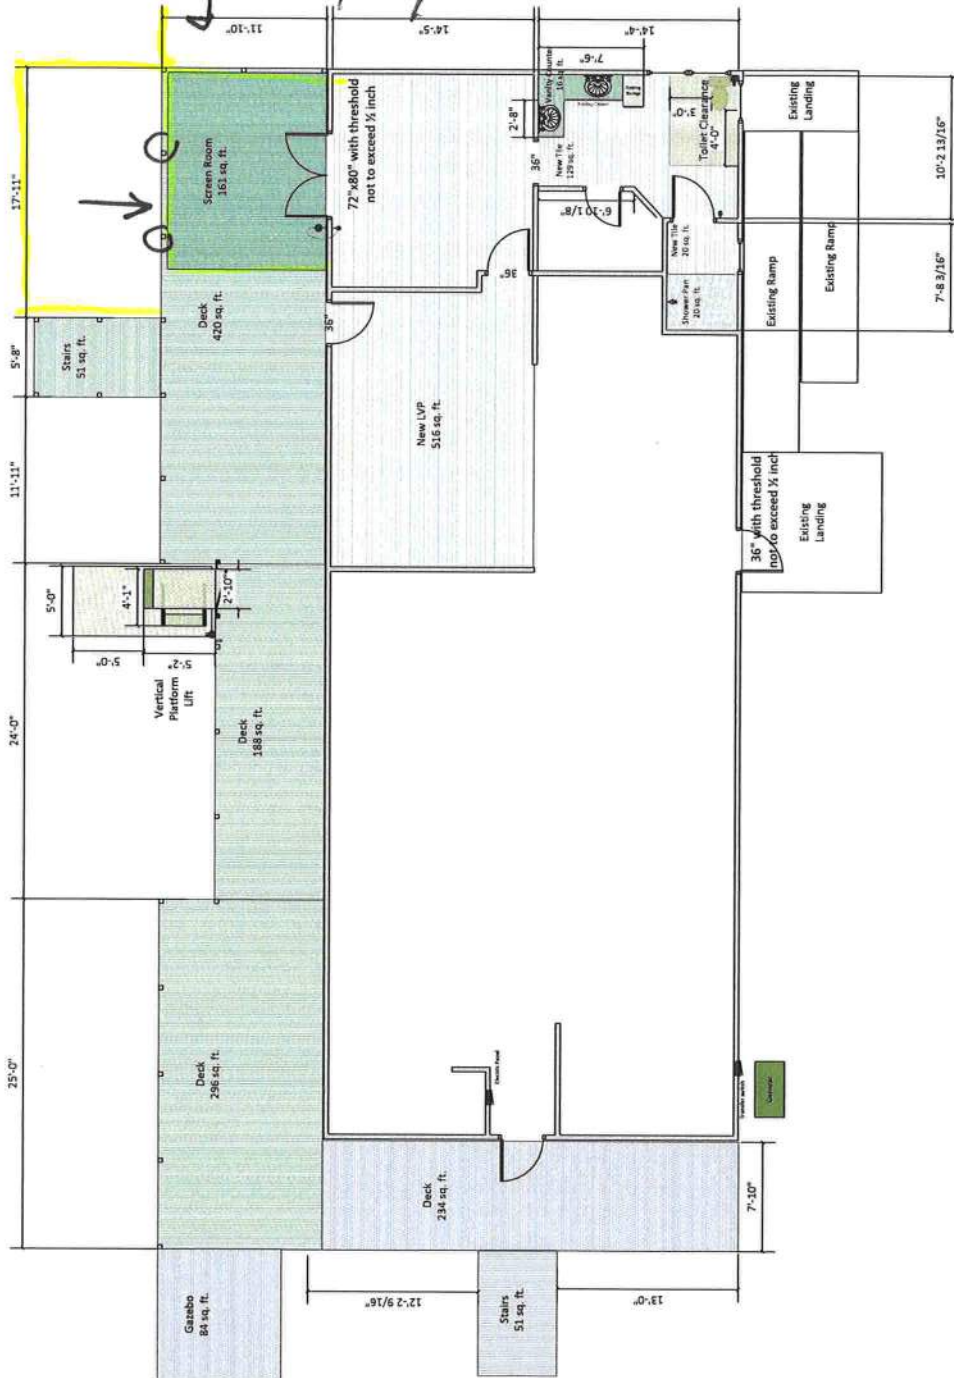

TITLE
The Reeves Residence
2366 SW Fry Ave
Ft. White, FL 32038

DRAWN BY Mike Jones	CREATED DATE 4/12/2021	REVISED DATE 10/8/2021
SHEET NAME Electrical Plan	PAGE 4 OF 4	SCALE 1/4" = 1'-0"
FILENAME REEVES - Layout Drawings - Permitting.vsd		

© 2021 by Universal Design Solutions
All rights reserved
These drawings are not to be reproduced or copied in any form whatsoever without the prior written consent of Universal Design Solutions.

Drawing Sheet Index	
1.	Cover Sheet
2.	As-Is / Demolition
3.	Proposed Floor Plan
4.	Exterior Elevations
5.	Roof Plan
6.	Electrical Plan
7.	Details