


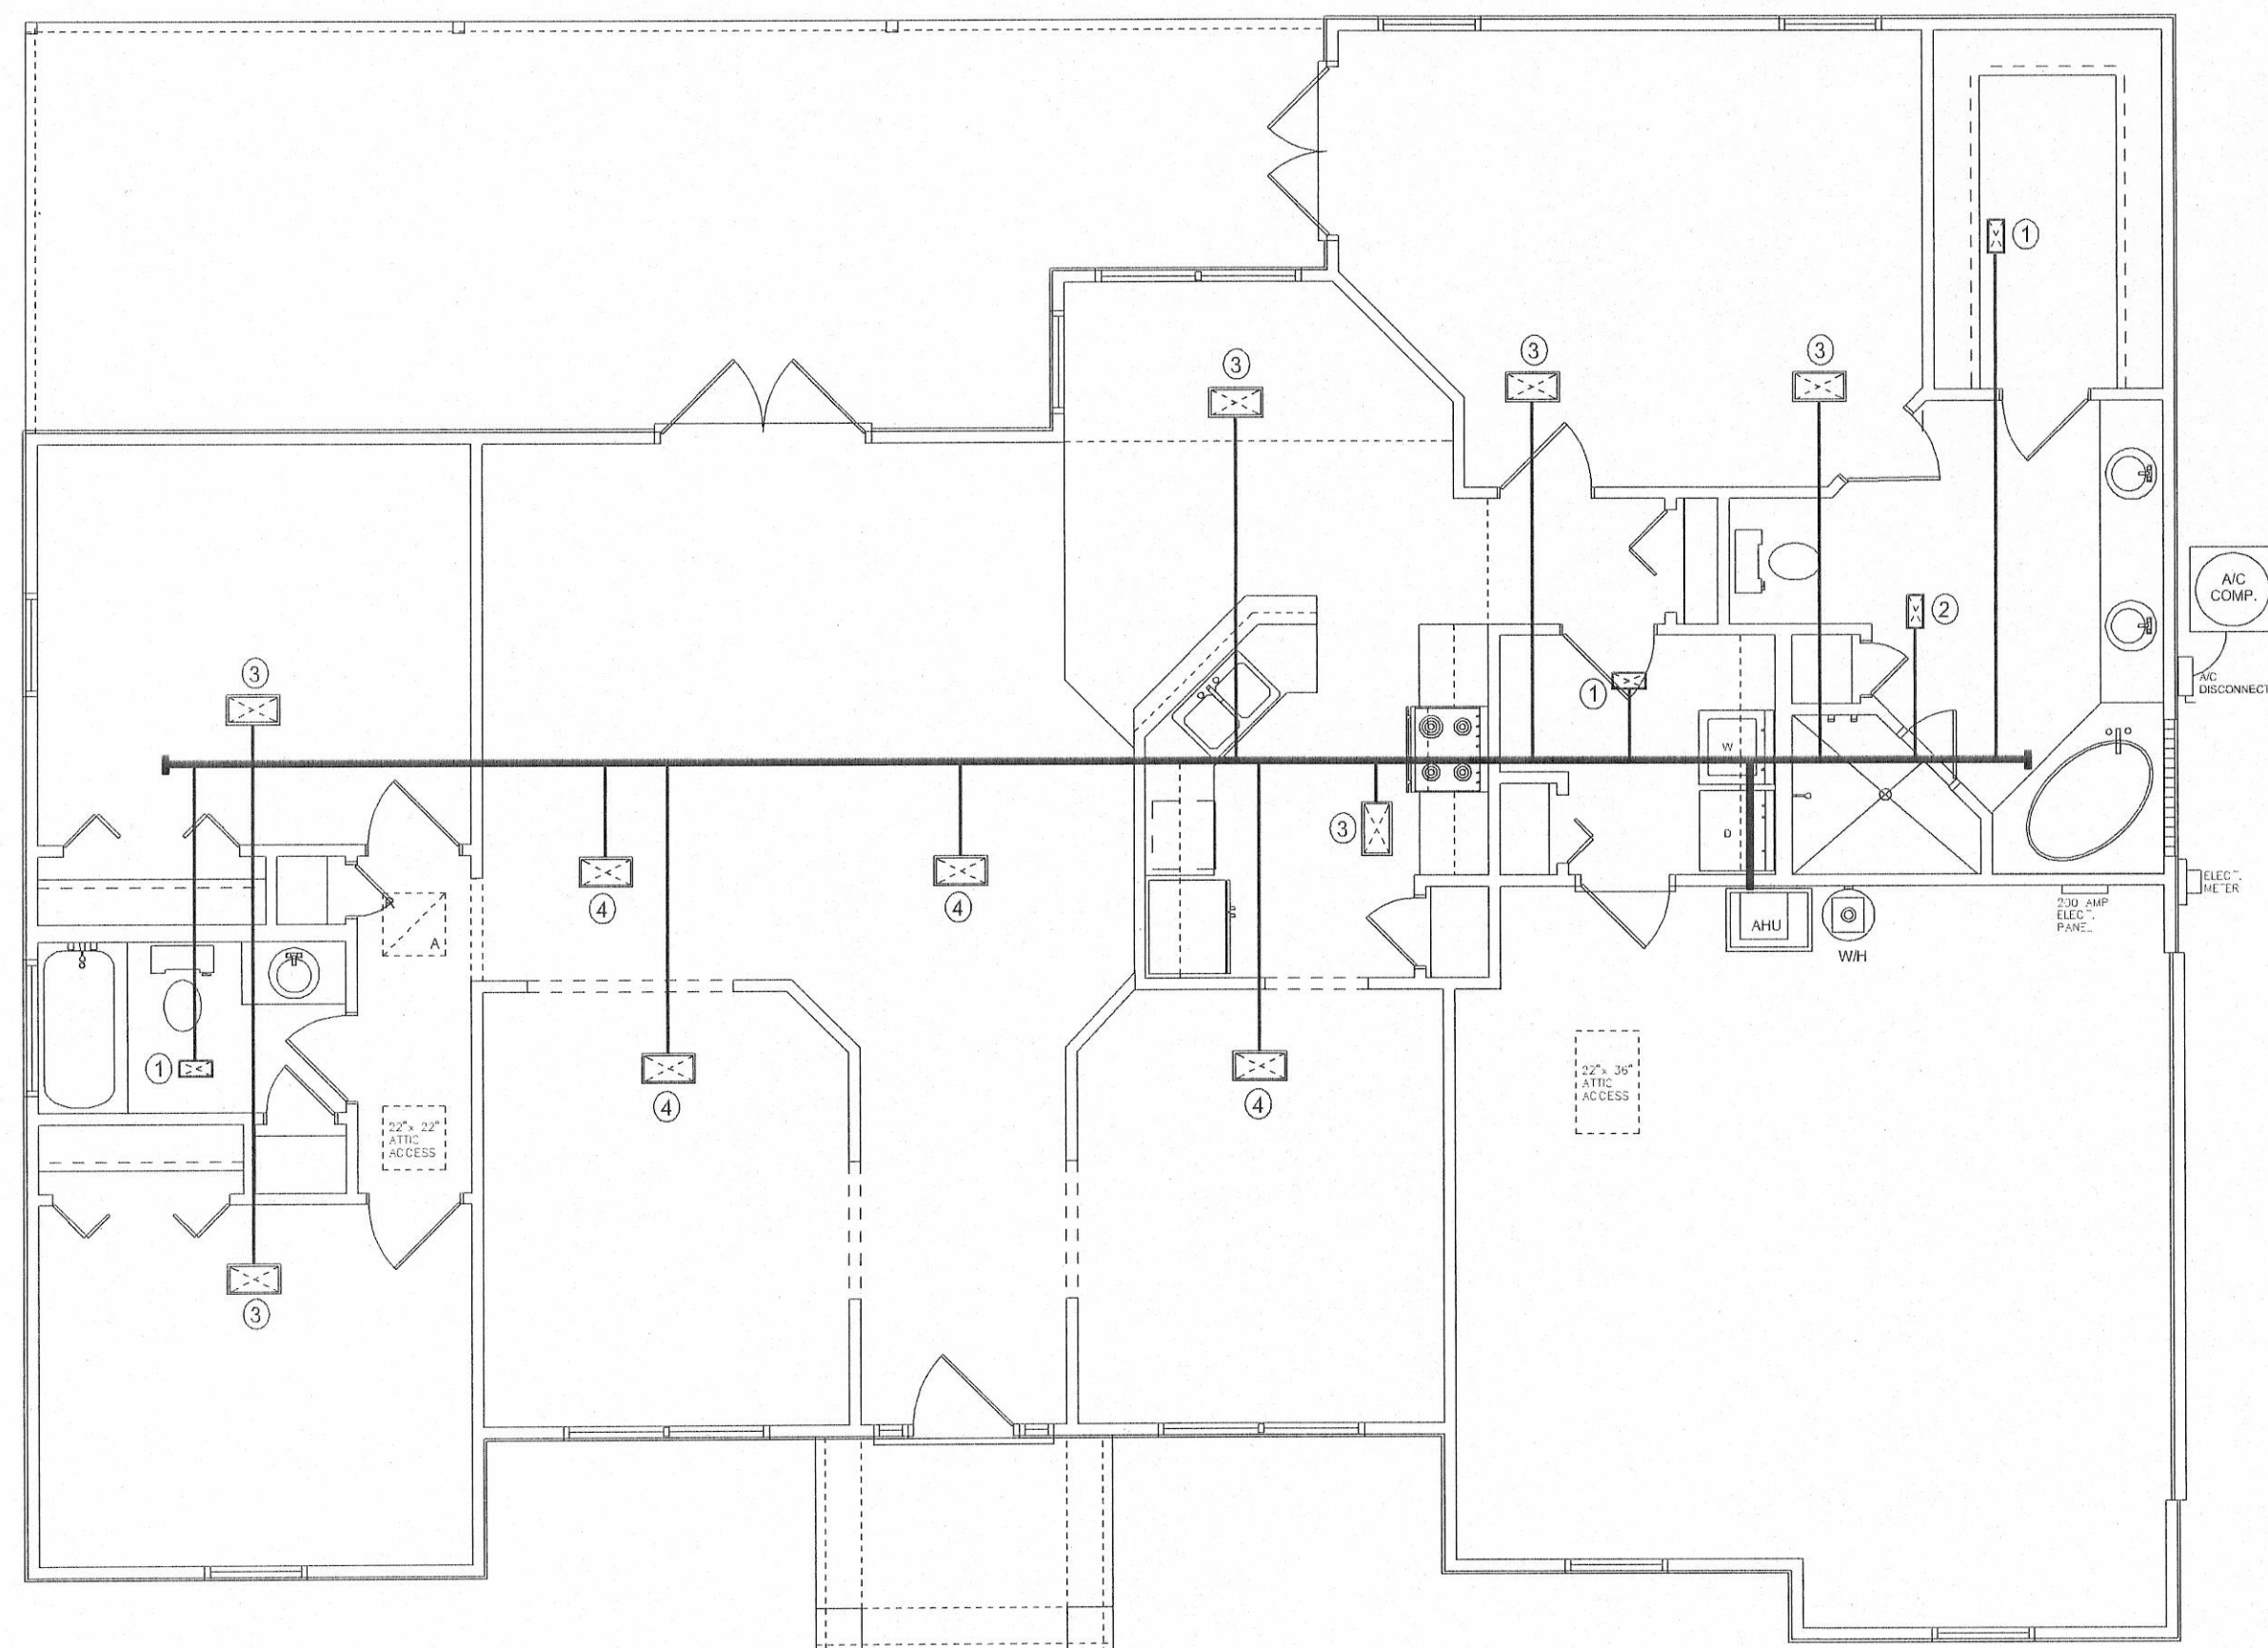


**HVAC PLAN**  
SCALE: 3/16" = 1'-0"

RETURN AIR SYSTEM TO BE  
SIZED BY A/C CONTRACTOR

| HVAC GRILLE SCHEDULE |          |         |     |  |
|----------------------|----------|---------|-----|--|
| MARK                 | SIZE     | DIAM.   | CFM |  |
| ①                    | 4" X 8"  | 4" FLEX | 55  |  |
| ②                    | 6" X 10" | 6" FLEX | 95  |  |
| ③                    | 6" X 10" | 8" FLEX | 130 |  |
| ④                    | 6" X 12" | 6" FLEX | 150 |  |
| ⑤                    | 6" X 12" | 8" FLEX | 175 |  |
| ⑥                    | 7" X 12" | 8" FLEX | 230 |  |

ALL DUCTS AND GRILLES DESIGNED IN  
ACCORDANCE WITH ACCA MANUAL D

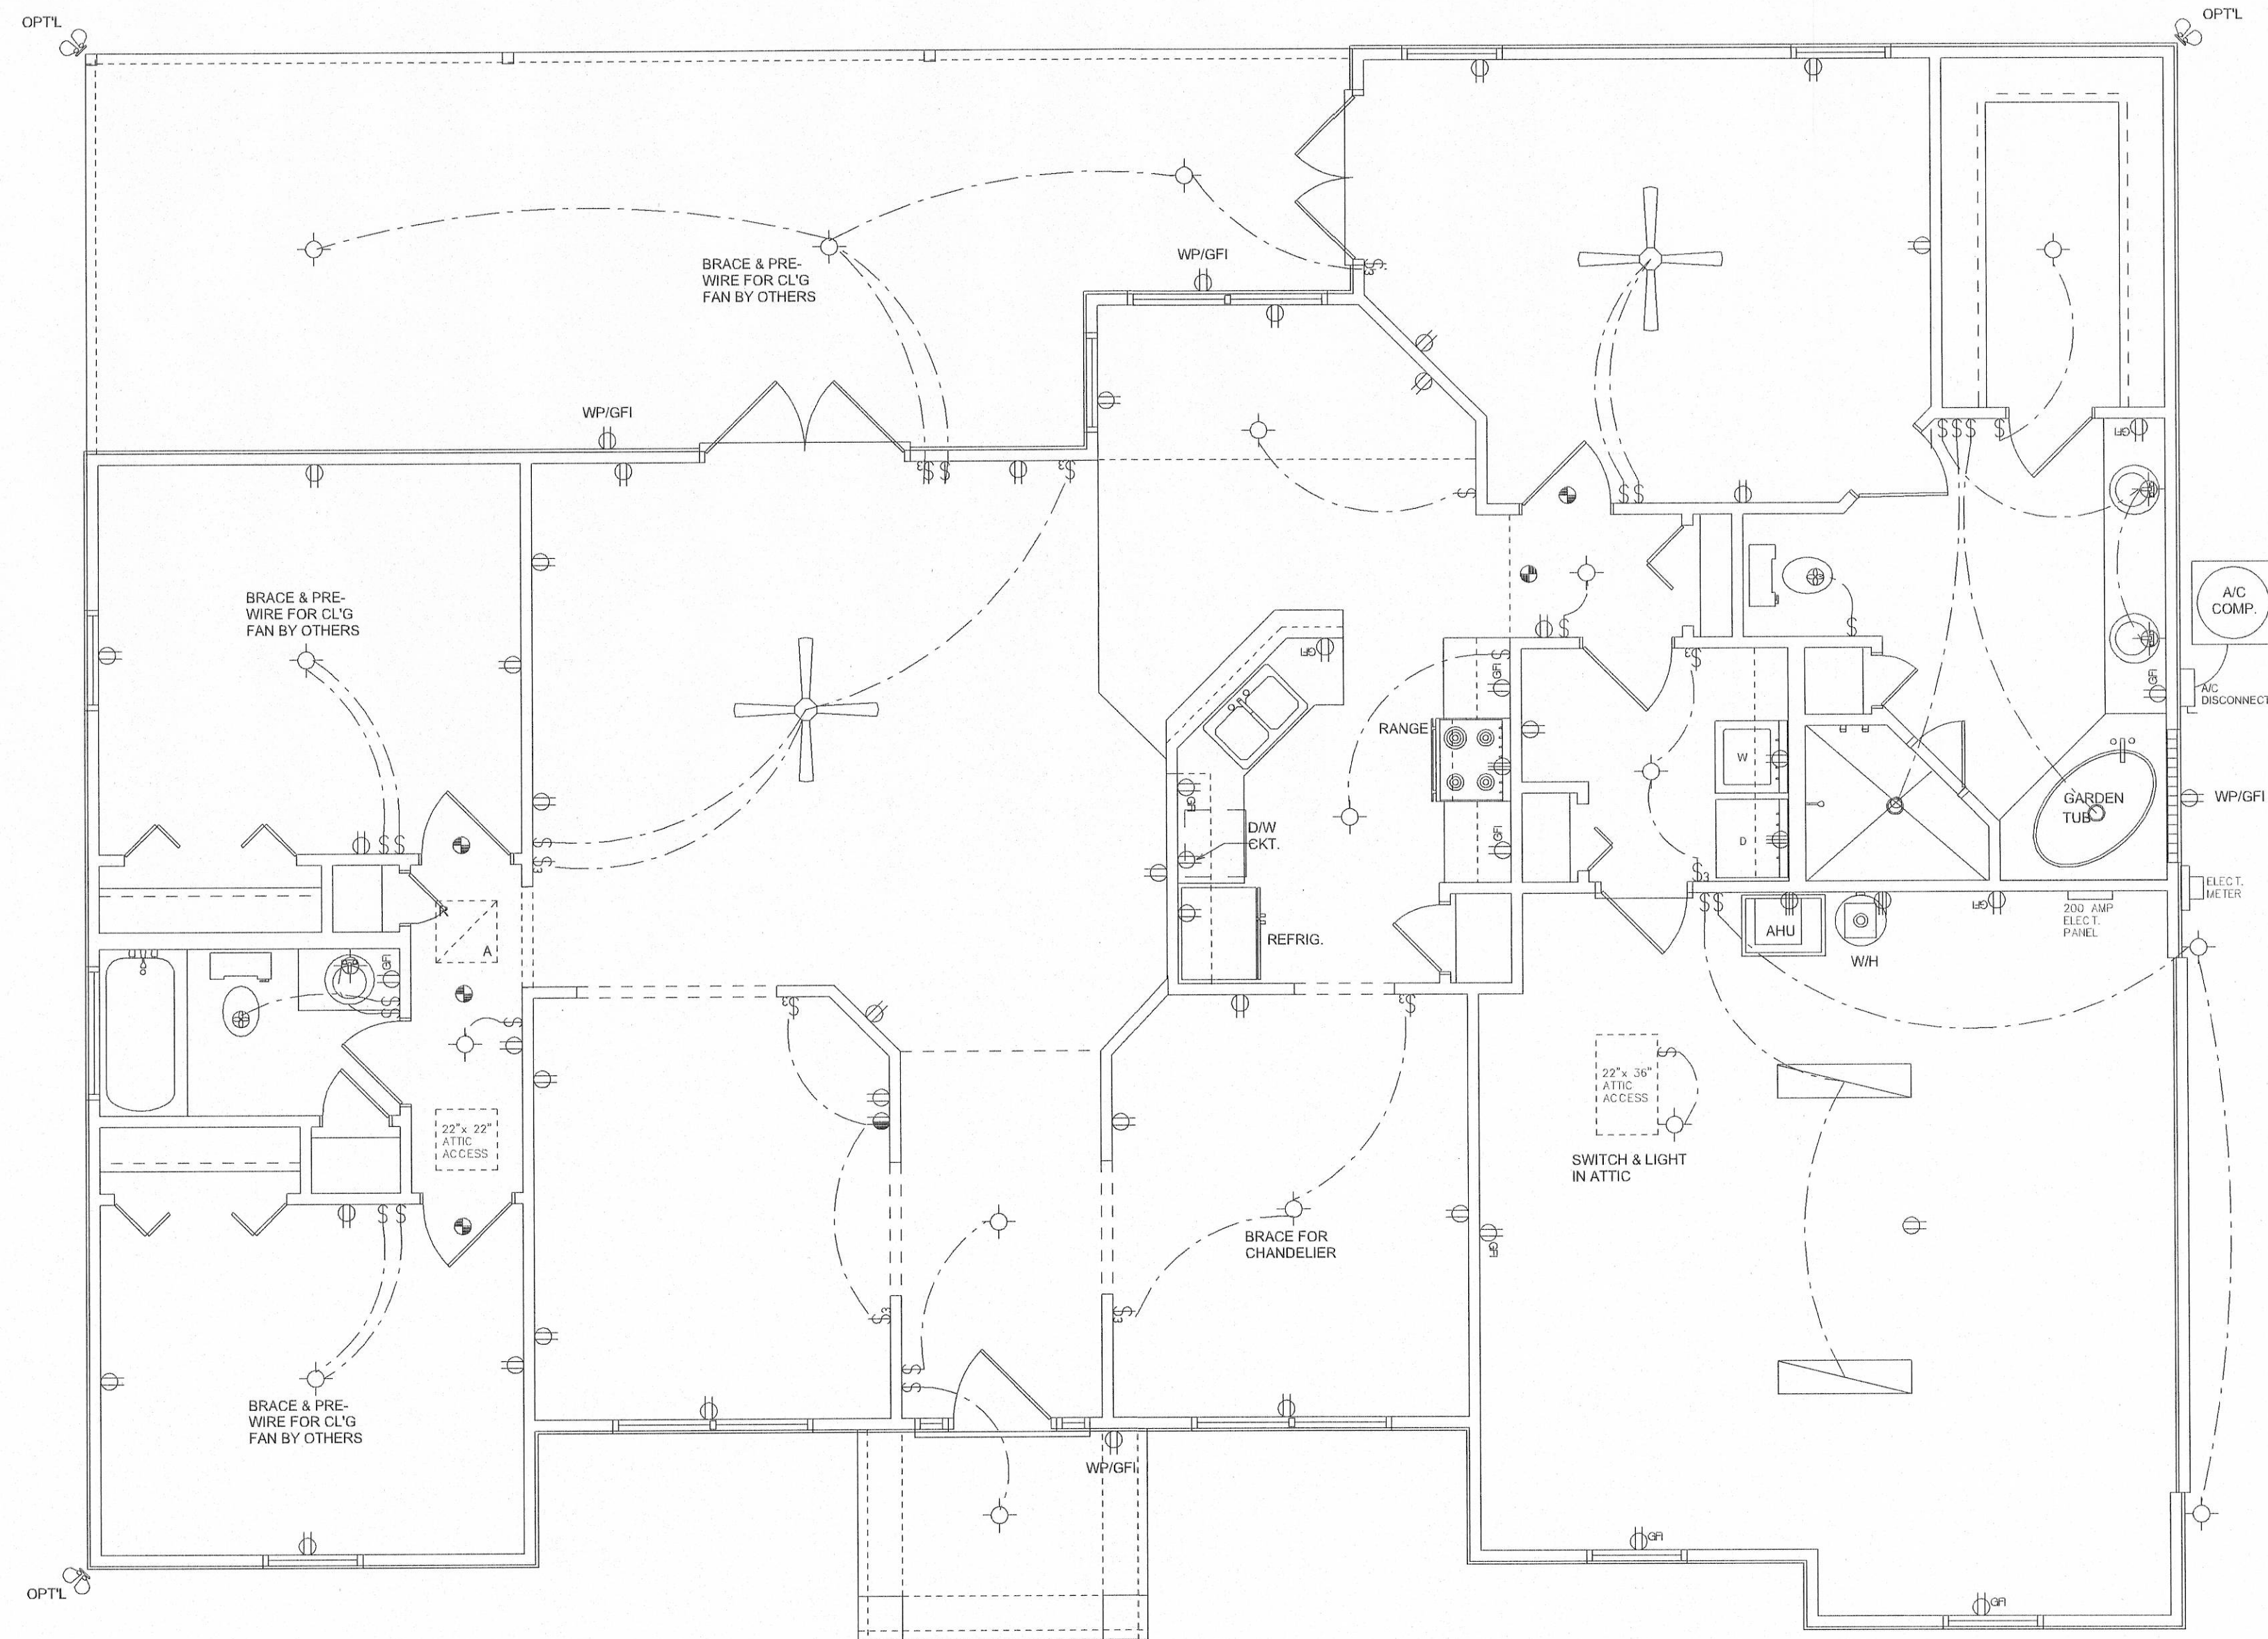

**ELECTRICAL PLAN**  
SCALE: 1/4" = 1'-0"

| ELECTRICAL LEGEND |                                         |
|-------------------|-----------------------------------------|
|                   | CEILING FAN<br>(PRE-WIRE FOR LIGHT KIT) |
|                   | DOUBLE SECURITY<br>LIGHT                |
|                   | RECESSED CAN LIGHT                      |
|                   | BATH EXHAUST FAN                        |
|                   | LIGHT FIXTURE                           |
|                   | DUPLEX OUTLET                           |
|                   | 220v OUTLET                             |
|                   | GFI DUPLEX OUTLET                       |
|                   | SMOKE DETECTOR                          |
|                   | WALL SWITCH                             |
|                   | 3 WAY WALL SWITCH                       |
|                   | WATER PROOF GFI OUTLET                  |
|                   | 2 OR 4 TUB FLUORESCENT FIXTURE          |

NOTE:  
ALL BEDROOM RECEP.TS. SHALL BE AFCI  
(ARC FAULT CIRCUIT INTERRUPT)  
ALL SMOKE DETECTORS SHALL HAVE BATTERY BACKUP POWER  
AND ALL WIRED TOGETHER SO IF ANY ONE UNIT IS ACTUATED THEY  
ALL ACTIVATE


REVISIONS  
August 27, 2003

**ELECTRICAL PLAN**  
SCALE: 1/4" = 1'-0"

**HVAC PLAN**  
SCALE: 3/16" = 1'-0"

**THE EVERGREEN MODEL**  
ADDRESS: LOT 7, CREEKSIDE, LAKE CITY, FL 32055  
**AARON SIMQUE HOMES, INC.**  
ADDRESS: RT. 9 BOX 785-33, LAKE CITY, FL 32024

© WILLIAM MYERS  
DESIGN  
P.O. BOX 1513  
LAKE CITY, FL 32056  
(386) 758-8406  
will@willmyers.net

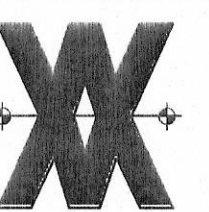

JOB NUMBER  
**020607**

SHEET NUMBER

**A3**  
OF 3 SHEETS

*Wm Myers*