



FRONT ELEVATION

SCALE: 1/4" = 1'-0"



REAR ELEVATION

SCALE: 1/4" = 1'-0"



REVISIONS SCHEDULE	
Mar. 7th, 2024	Proposal Drawing
Mar. 27th, 2024	Revisions




CONSTRUCTION LLC
(352) 827-0264 CBC 123456
818 W DUVAL ST, LAKE CITY, FL 32055

CUSTOM HOME FOR:
CASTAGNA & WEST RESIDENCE
COLUMBIA COUNTY, FLORIDA




**RIDGEPOINT
DESIGN**
566 SW ARLINGTON BLVD, STE 101, LAKE CITY, FL 32025
P: 386-288-1188
E: RIDGEPOINTDESIGN@GMAIL.COM

SHEET NUMBER
A.1
OF 4 SHEETS

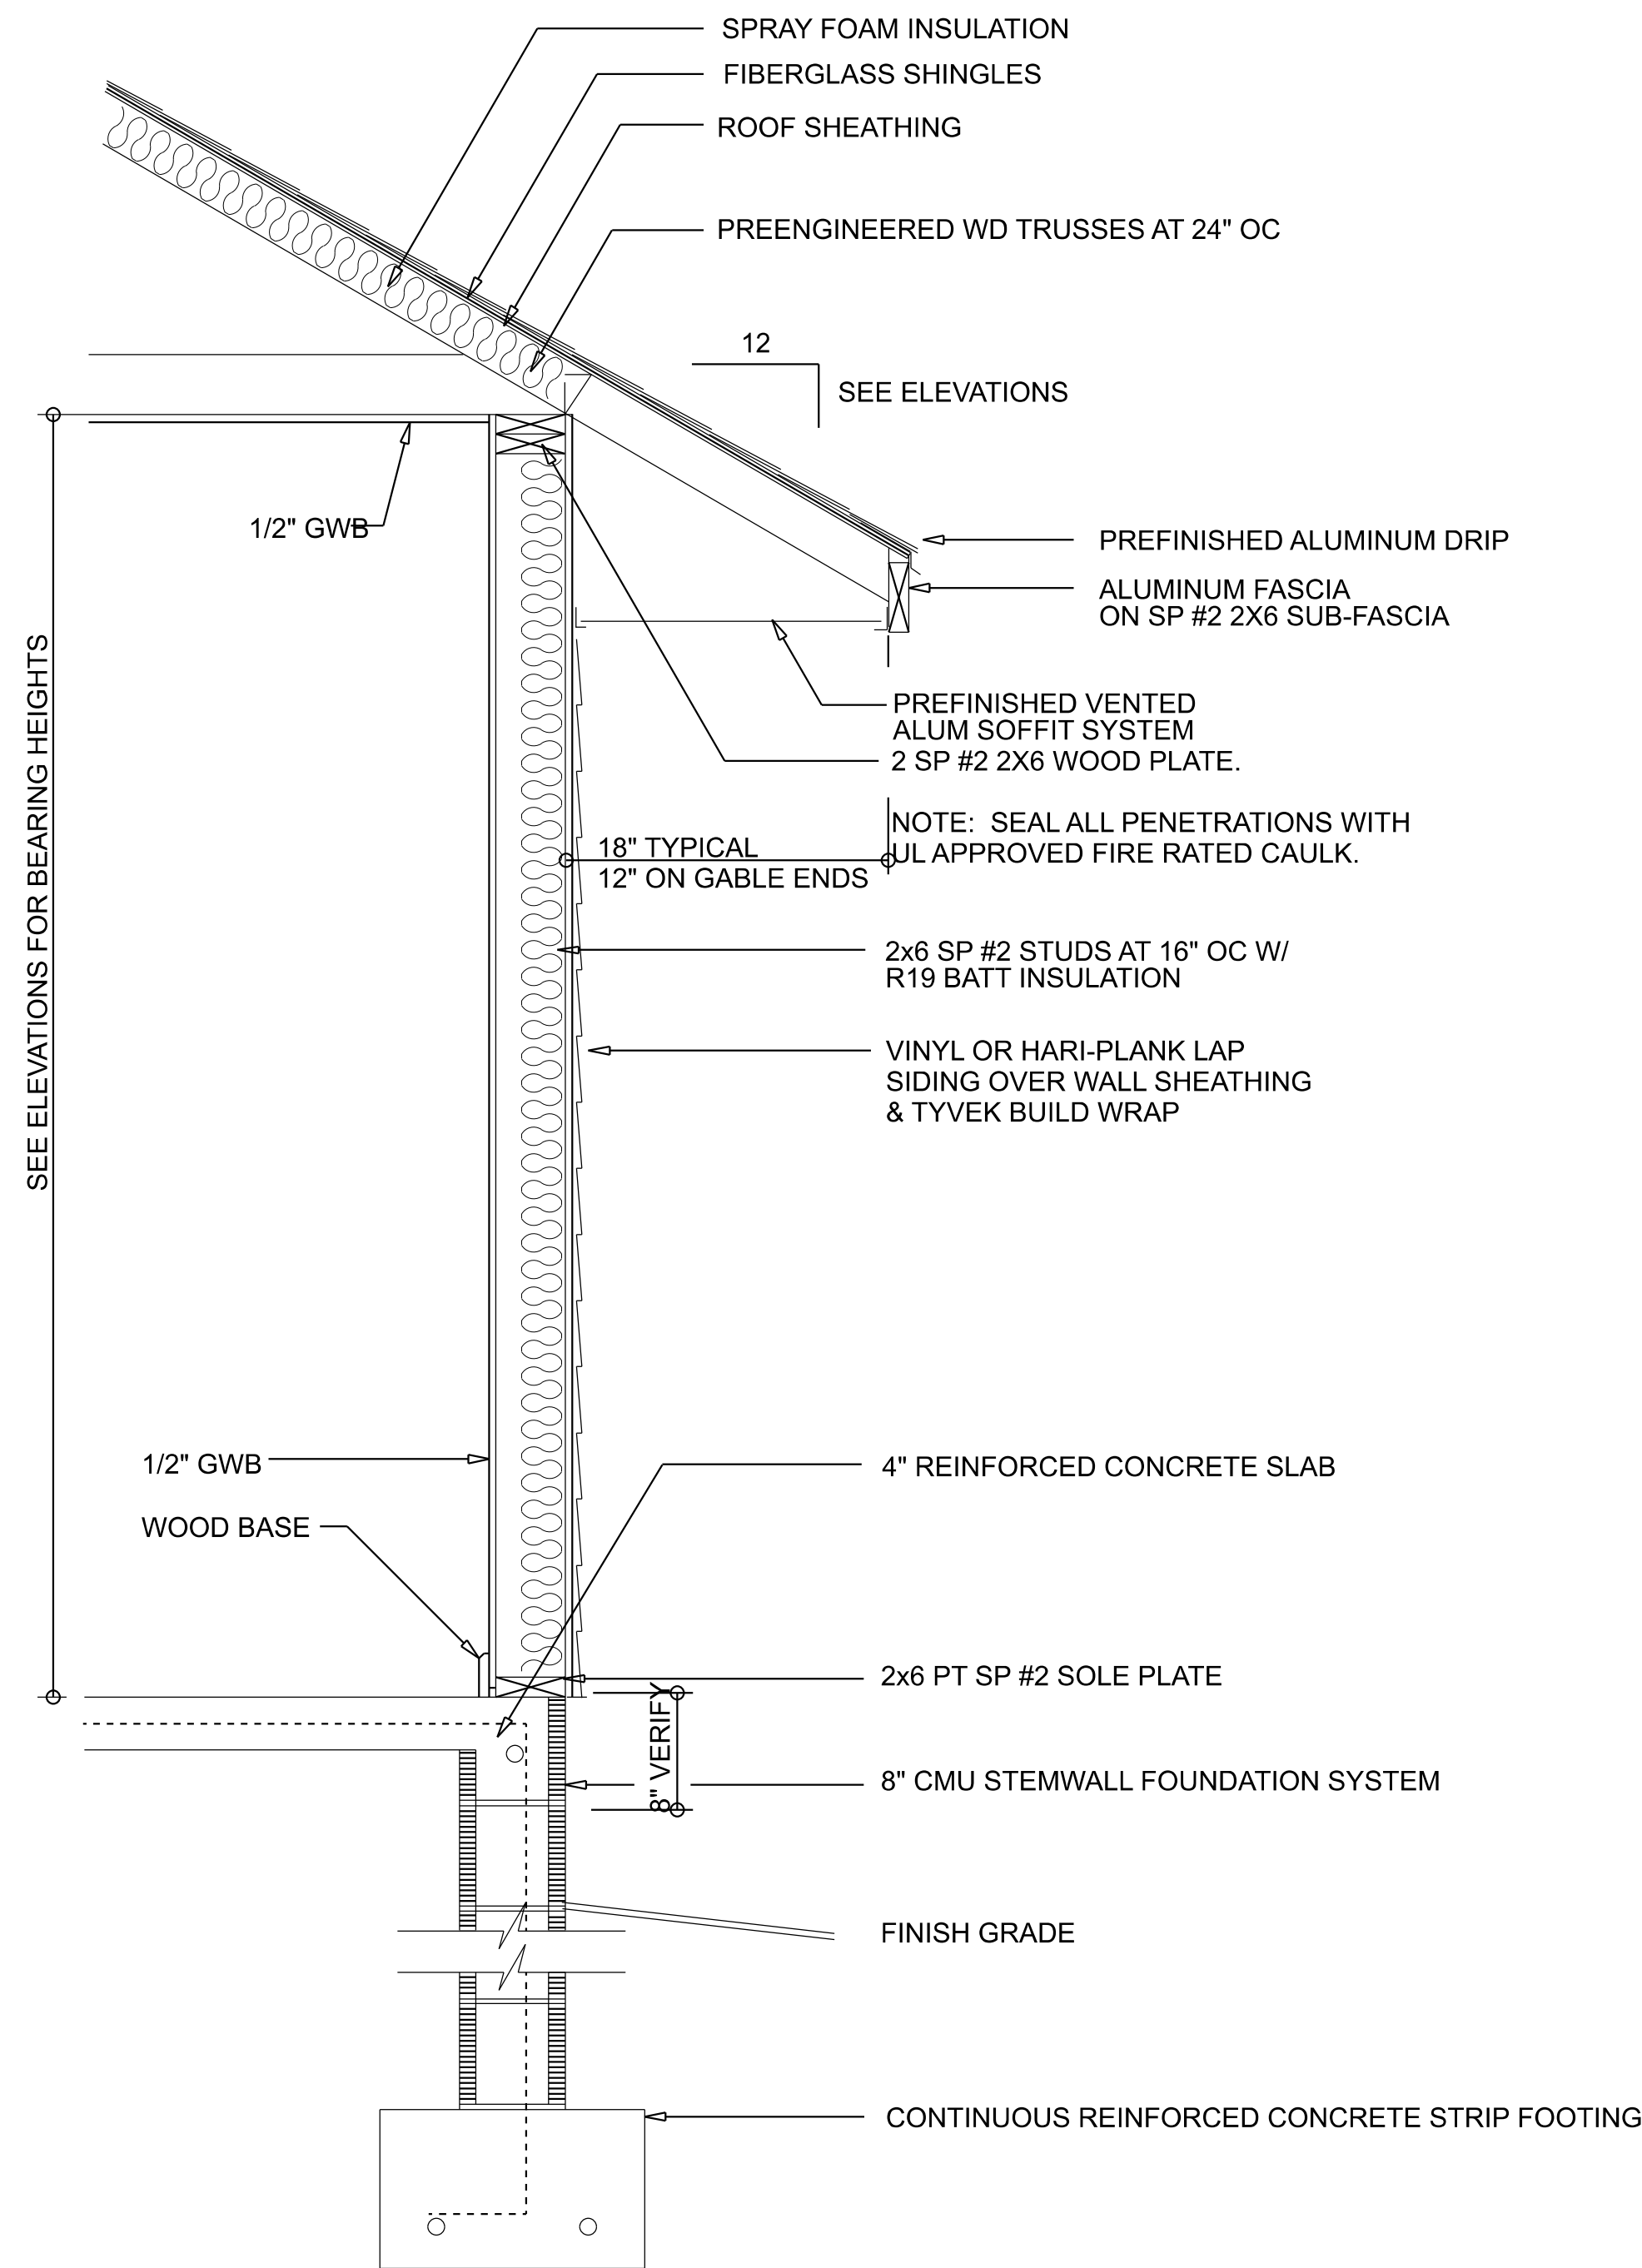

TYPICAL WALL SECTION
SCALE: 1" = 1'-0"

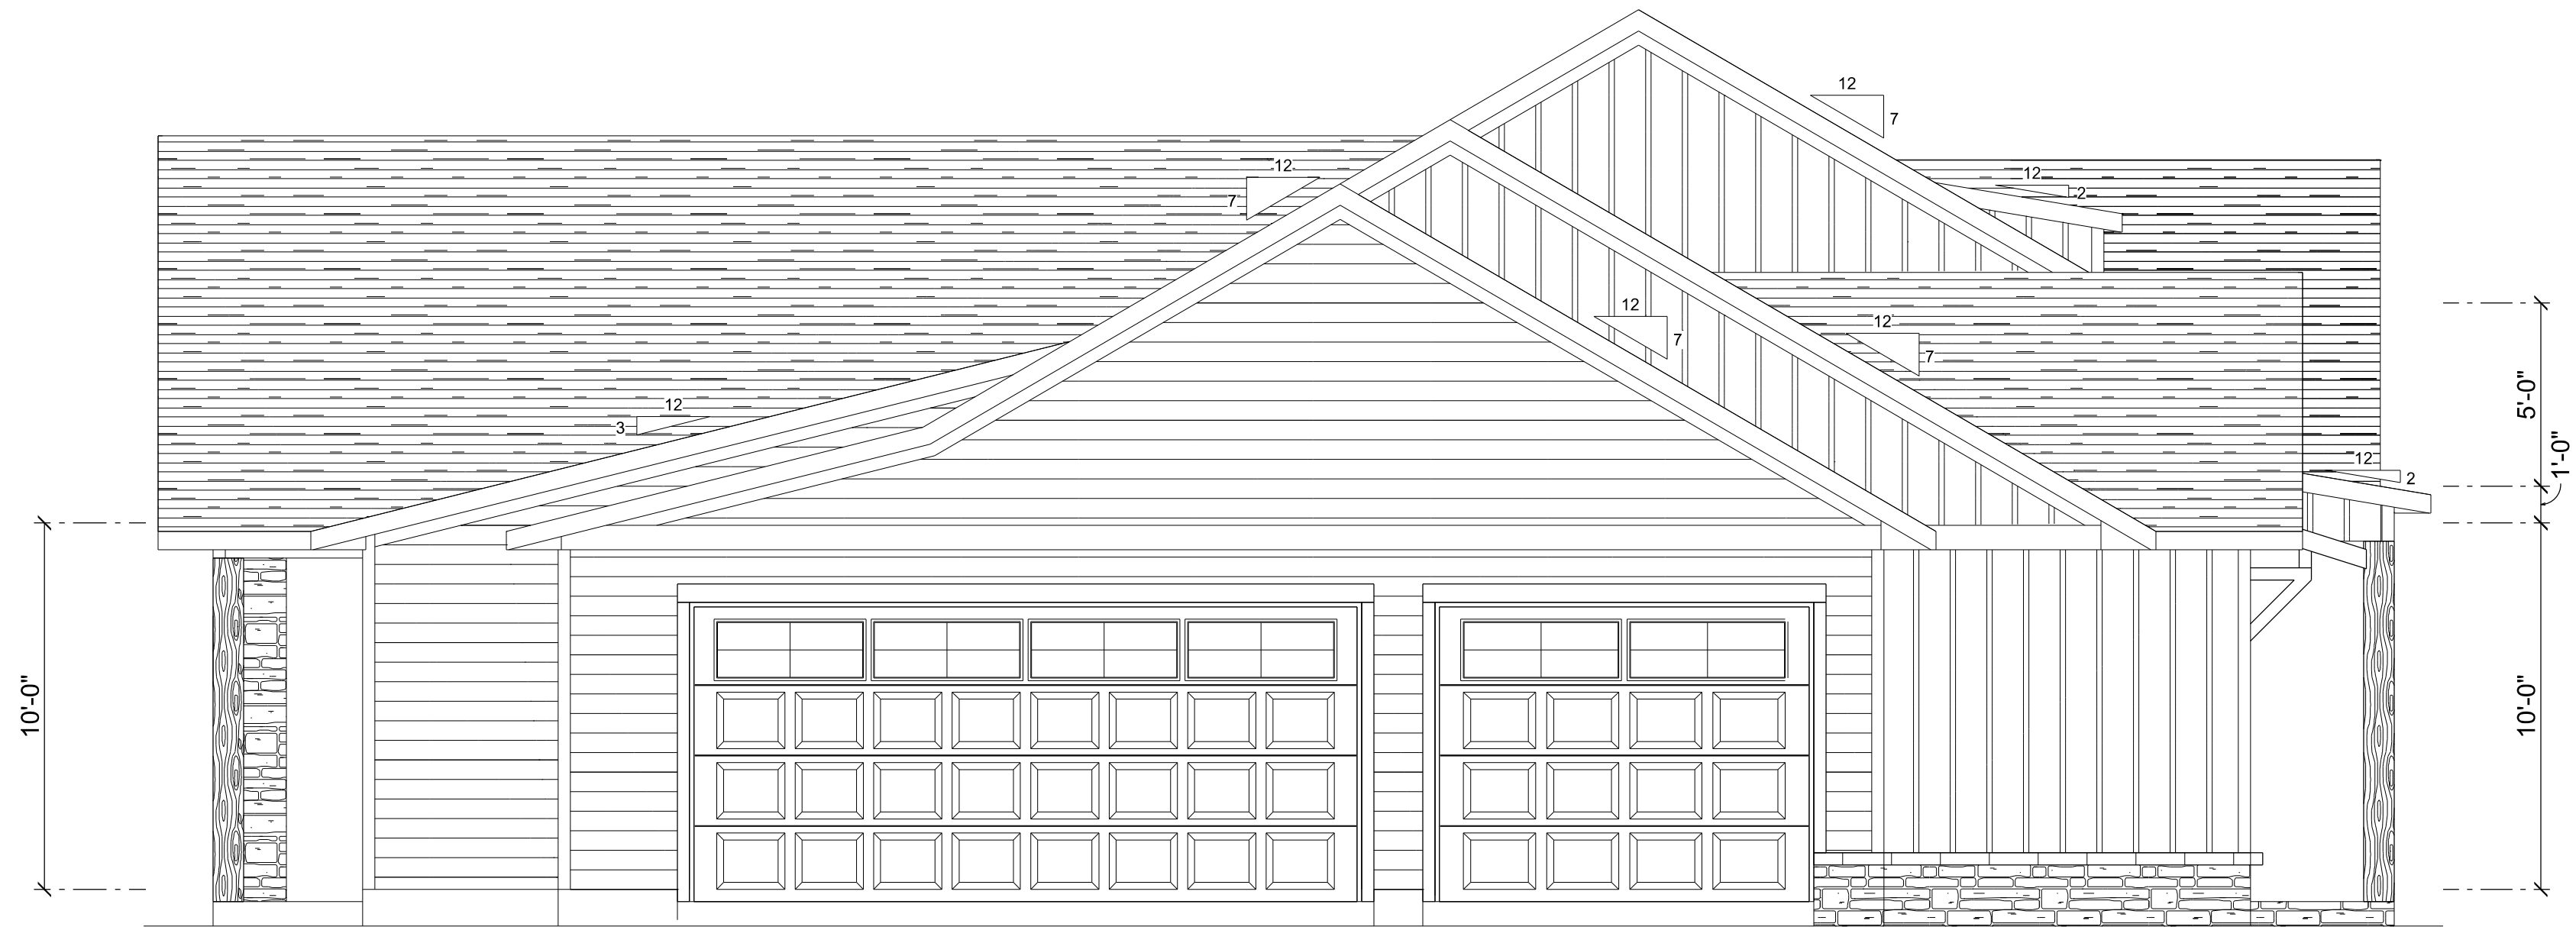

REVISIONS SCHEDULE	
Mar. 7th, 2024	Proposal Drawing
Mar. 27th, 2024	Revisions


 


CUSTOM HOME FOR:
CASTAGNA & WEST RESIDENCE
COLUMBIA COUNTY, FLORIDA



SHEET NUMBER
A.2
OF 4 SHEETS

OF 4 SHEETS

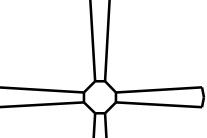ELECTRICAL LEGEND		
ELECTRICAL	COUNT	SYMBOL
CEILING FAN	5	
CAN LIGHT 6inch	47	
CHANDELIER	2	
LED CEILING LIGHT 1x4	4	
PENDANT LIGHT	2	
EXTERIOR SCONCE	4	
ELECTRIC PANEL	1	
AC DISCONNECT	2	
CABLE TV OUTLET	5	
CARBON DETECTOR	2	
EXHAUST FAN	3	
OUTLET	31	
OUTLET 220v	6	
OUTLET GFI	26	
OUTLET WP	8	
SMOKE DETECTOR	5	
STANDARD LIGHT	2	
SWITCH	26	
SWITCH 3 WAY	37	
VANITY BAR LIGHT - SMALL	4	

ELECTRICAL PLAN NOTES:

INSTALLATION SHALL BE PER LATEST NAT'L ELECTRIC CODE.

WIRE ALL APPLIANCES, HVAC UNITS AND OTHER EQUIPMENT PER MANUF. SPECIFICATIONS

CONSULT WITH THE OWNER FOR THE NUMBER OF SEPERATE TELEPHONE LINES TO BE INSTALLED

ALL SMOKE DETECTORs SHALL BE 120V W/ BATTERY BACKUP OF THE PHOTOELECTRIC TYPE, AND SHALL BE INTERLOCKED TOGETHER. INSTALL INSIDE AND NEAR ALL BEDROOMs

TELEPHONE, TELEVISION AND OTHER LOW VOLTAGE DEVICES OR OUTLETs SHALL BE AS PER THE OWNER's DIRECTIONS, & IN ACCORDANCE W/ APPLICABLE SECTIONS OF NEC-LATEST EDITION.


ELECTRICAL CONTR SHALL PREPARE "AS-BUILT" SHOP DUGs INDICATING ALL ELECTRICAL WORK, INCLUDING ANY CHANGES TO THE ELEC. PLAN, ADD'NG TO THE ELEC. PLAN, RISER DIAGRAM, AS-BUILT PANEL SCHEDULE W/ ALL CKTs IDENTIFIED W/ CKT N°. DESCRIPTION & BRKR, SERVICE ENT. & ALL UNDERGROUND WIRE

LOCATIONS/ROUTING / DEPTH, RISER DIA. SHALL INCLUDE WIRE SIZEs/TYPE & EQUIPMENT TYPE W/ RATINGS & LOADs.

CONTRACTOR SHALL PROVIDE 1 COPY OF AS-BUILT DUGs TO OWNER & 1 COPY TO THE PERMIT ISSUING AUTHORITY. ALL RECEPTICALs, NOT OTHERWISE NOTED, SHALL BE ARC FAULT INTERRUPTER TYPE, EXCEPT DEDICATED OUTLETs

ALL RECEPTICALs IN WET AREAs SHALL BE GROUND FAULT INTERRUPTER TYPE (GFI)

ALL EXTERIOR RECEPTICALs SHALL BE WEATHERPROOF GROUD FAULT INTERRUPTER TYPE (WP/GFI)

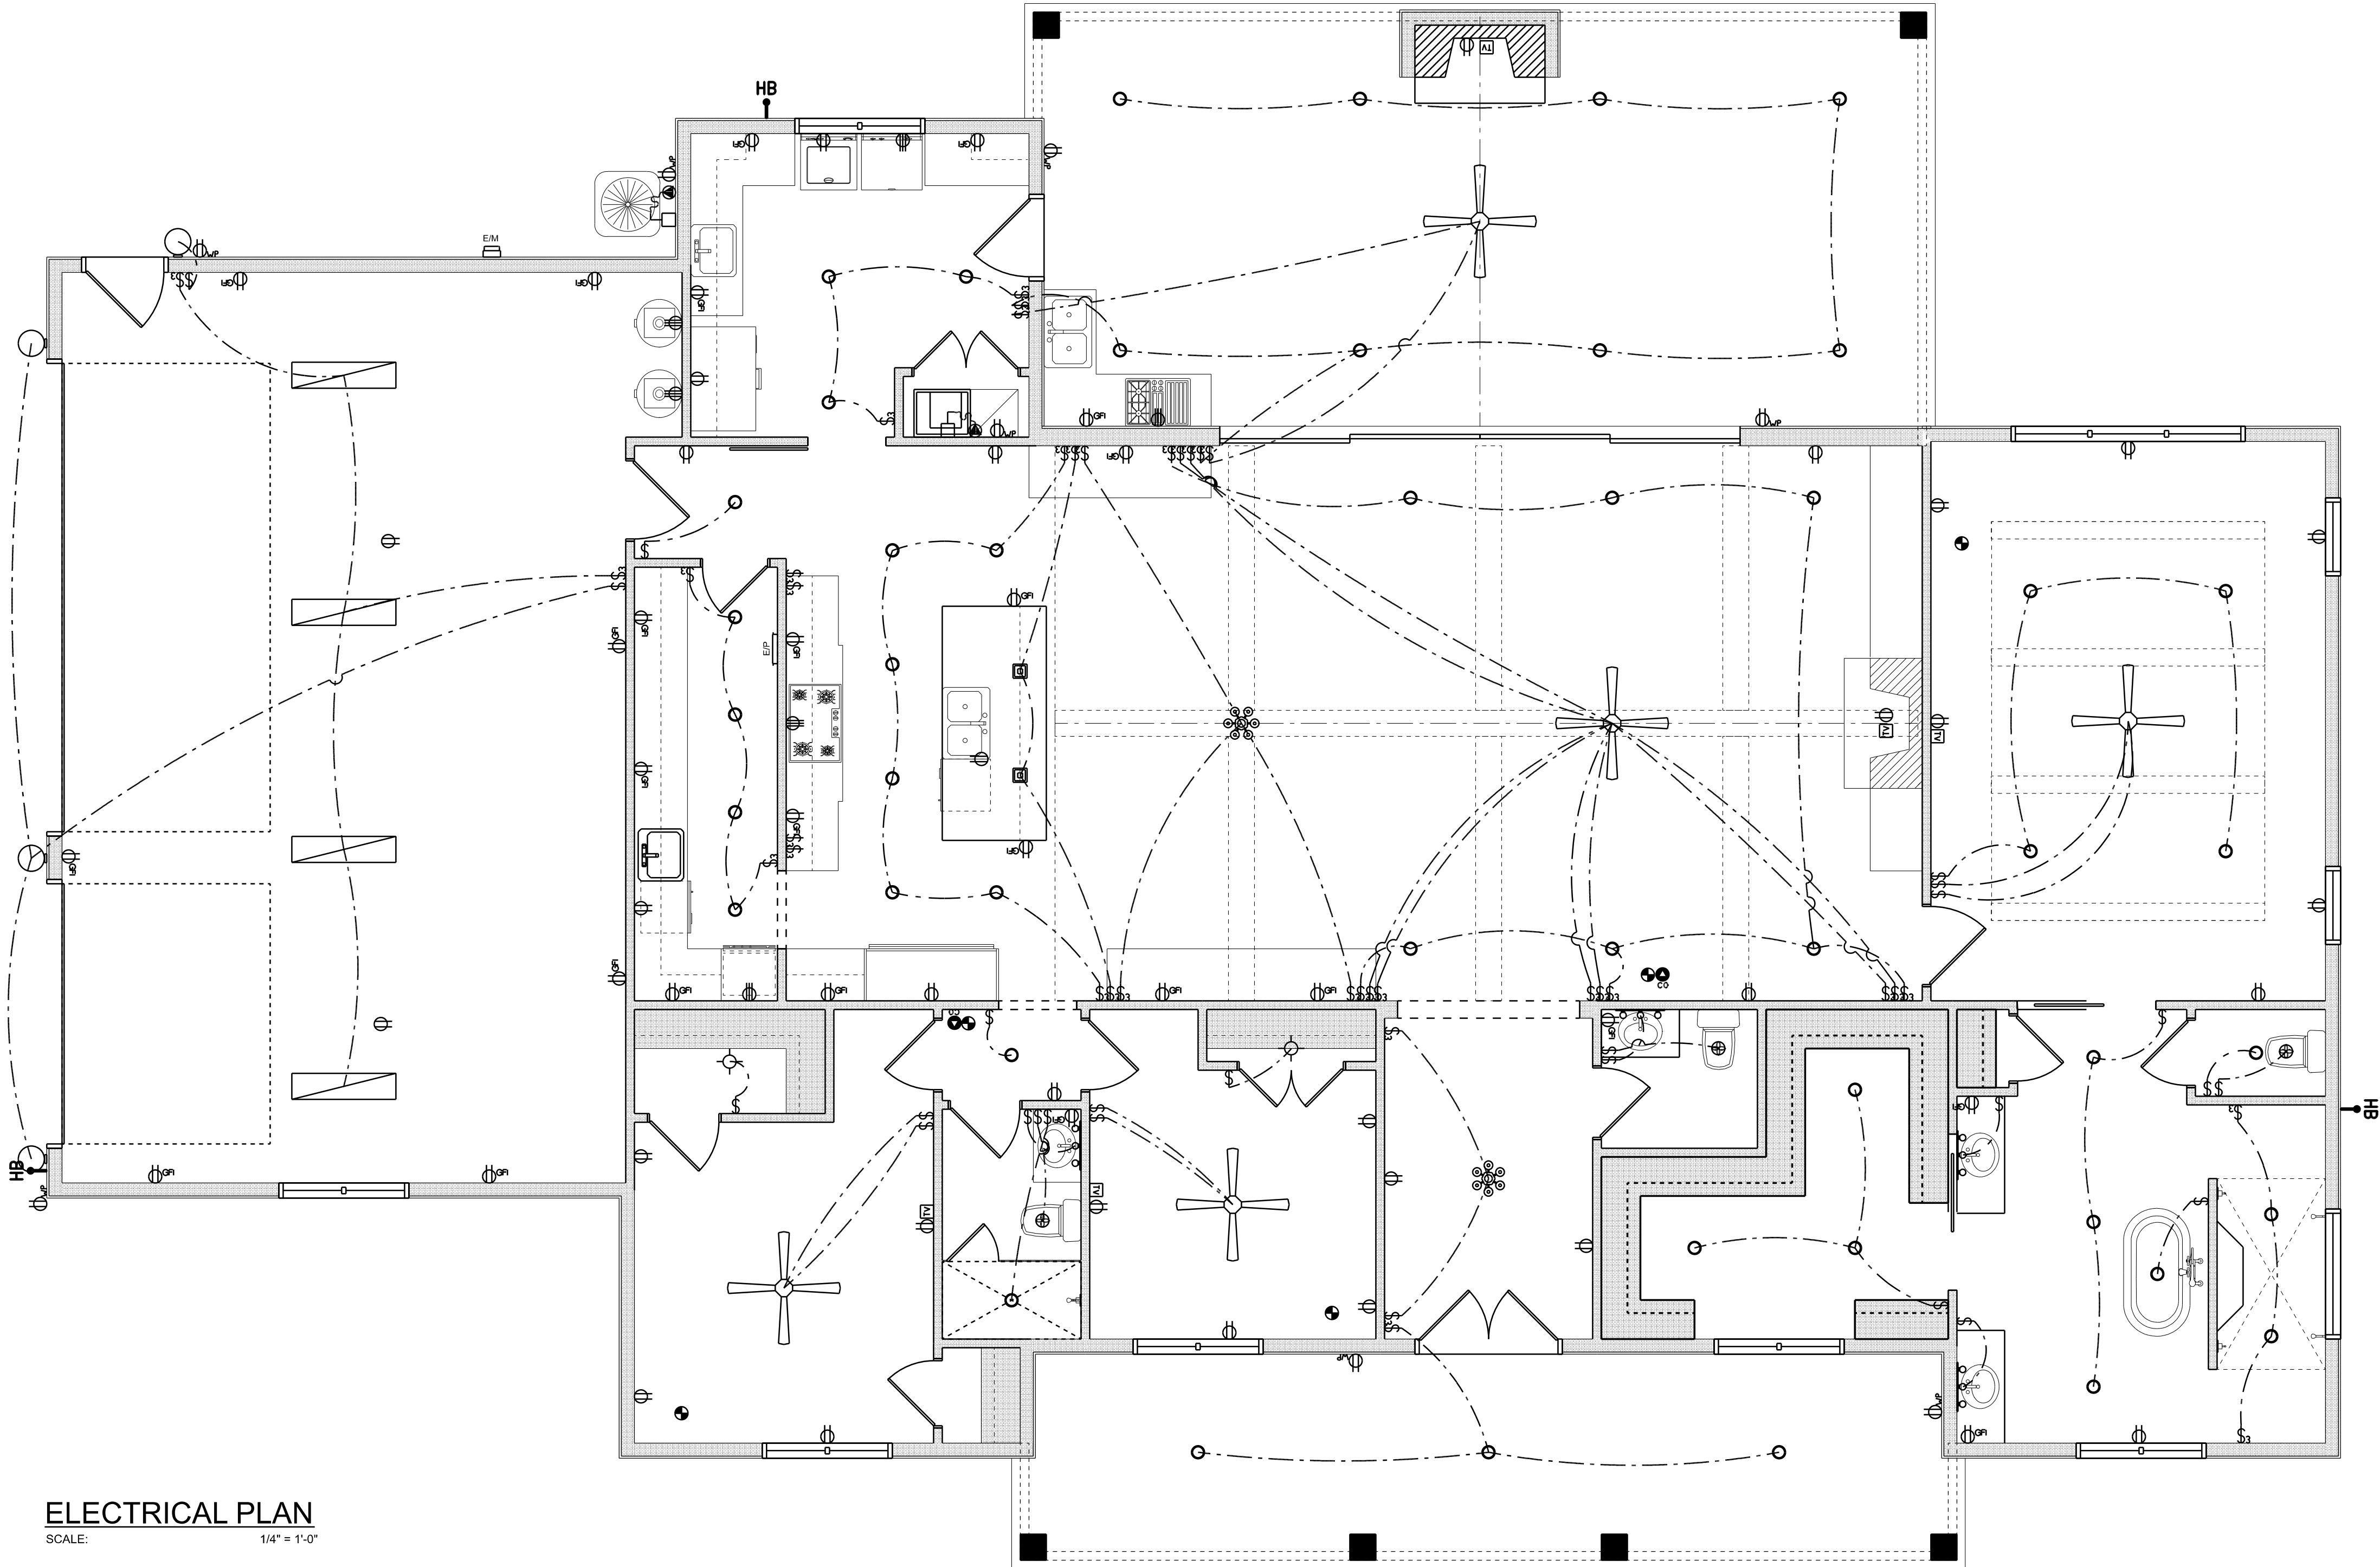

ELECTRICAL PLAN
SCALE: 1/4" = 1'-0"

REVISIONS SCHEDULE	
Mar. 7th, 2024	Proposal Drawing
Mar. 27th, 2024	Revisions



CONSTRUCTION LLC
(866) 867-0864 CEC 137453
818 W DUVAL ST, LAKE CITY, FL 32055

CUSTOM HOME FOR:

CASTAGNA & WEST RESIDENCE

COLUMBIA COUNTY, FLORIDA



**RIDGEPOINT
DESIGN**

566 SW ARLINGTON BLVD, STE 101, LAKE CITY, FL 32025
P: 386-288-1188
E: RIDGEPOINTDESIGN@GMAIL.COM

SHEET NUMBER

A.4

OF 4 SHEETS