


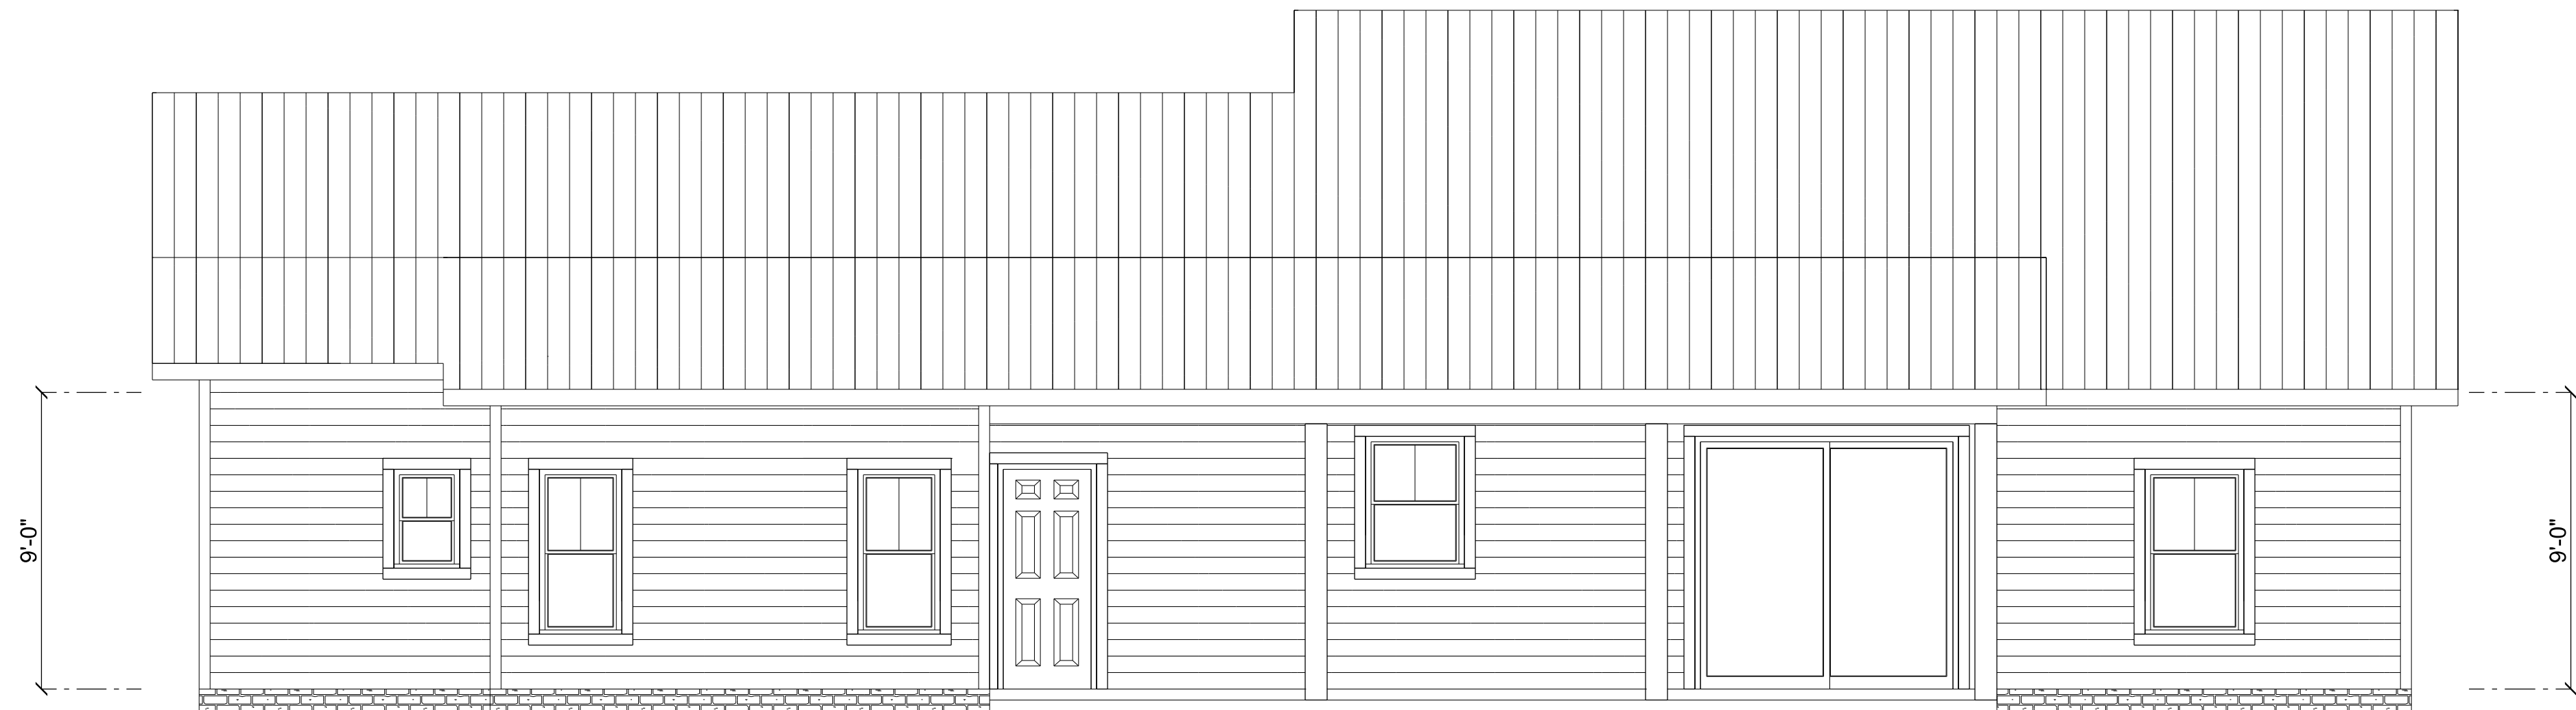


FRONT ELEVATION  
SCALE: 1/4" = 1'-0"



REAR ELEVATION  
SCALE: 1/4" = 1'-0"

| REVISIONS SCHEDULE |                 |  |
|--------------------|-----------------|--|
| PROPOSAL           | Apr. 2nd, 2025  |  |
| PERMIT SET         | Apr. 11th, 2025 |  |
|                    |                 |  |
|                    |                 |  |

CUSTOM HOME FOR:  
**WEBB RESIDENCE**  
466 SW Jeanlea Pl, Fort White, FL 32038

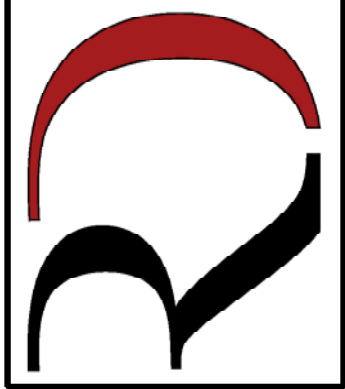**RIDGEPOINT  
DESIGN**

566 SW ARLINGTON BLVD. STE. 101, LAKE CITY, FL 32025  
P: 386-288-1188  
E: RIDGEPOINTDESIGN@GMAIL.COM



Garage fire separations shall comply with the following:

- 
- This architectural elevation drawing shows a single-story house with a gabled roof. The overall height of the house is 9'-0". The roof has a 12/6 pitch, indicated by a triangle with a vertical side of 12 and a horizontal side of 6. The house features a central entrance with a double door, flanked by two windows. A small, rectangular window is centered above the entrance. The roofline is marked with a 12/3 pitch on the left side and a 12/6 pitch on the right side. The drawing includes a brick foundation and a chimney on the right side.

## LEFT ELEVATION

This architectural elevation drawing shows the side profile of a house with a gambrel roof. The main body of the house has horizontal siding and a height of 9'-0". On the left, there is a two-car garage with vertical siding and a height of 9'-0". The roof features a gambrel design with multiple pitches indicated by callouts: 12/6, 12/6, 12/6, and 12/3. A small, square, double-hung window is located on the main level to the right of the garage. The drawing uses dashed lines to indicate the ground level and the vertical dimensions of the structure.

### RIGHT ELEVATION

SCALE:  $1/4" = 1'-0"$

| REVISIONS SCHEDULE |                 |
|--------------------|-----------------|
| PROPOSAL           | Apr. 2nd, 2025  |
| PERMIT SET         | Apr. 11th, 2025 |
|                    |                 |
|                    |                 |
|                    |                 |

CUSTOM HOME FOR:  
**WEBB RESIDENCE**  
466 SW Jeanlea Pl. Fort White, FL 32038


466 SW Jeanlea Pl. Fort White, FL 32038

**RIDGEPOINT  
DESIGN**  
566 SW ARLINGTON BLVD. STE 101, LAKE CITY, FL 32025  
P: 386-288-1188  
E: RIDGEPOINTDESIGN@GMAIL.COM

SHEET NUMBER

## A.2

OF 8 SHEETS

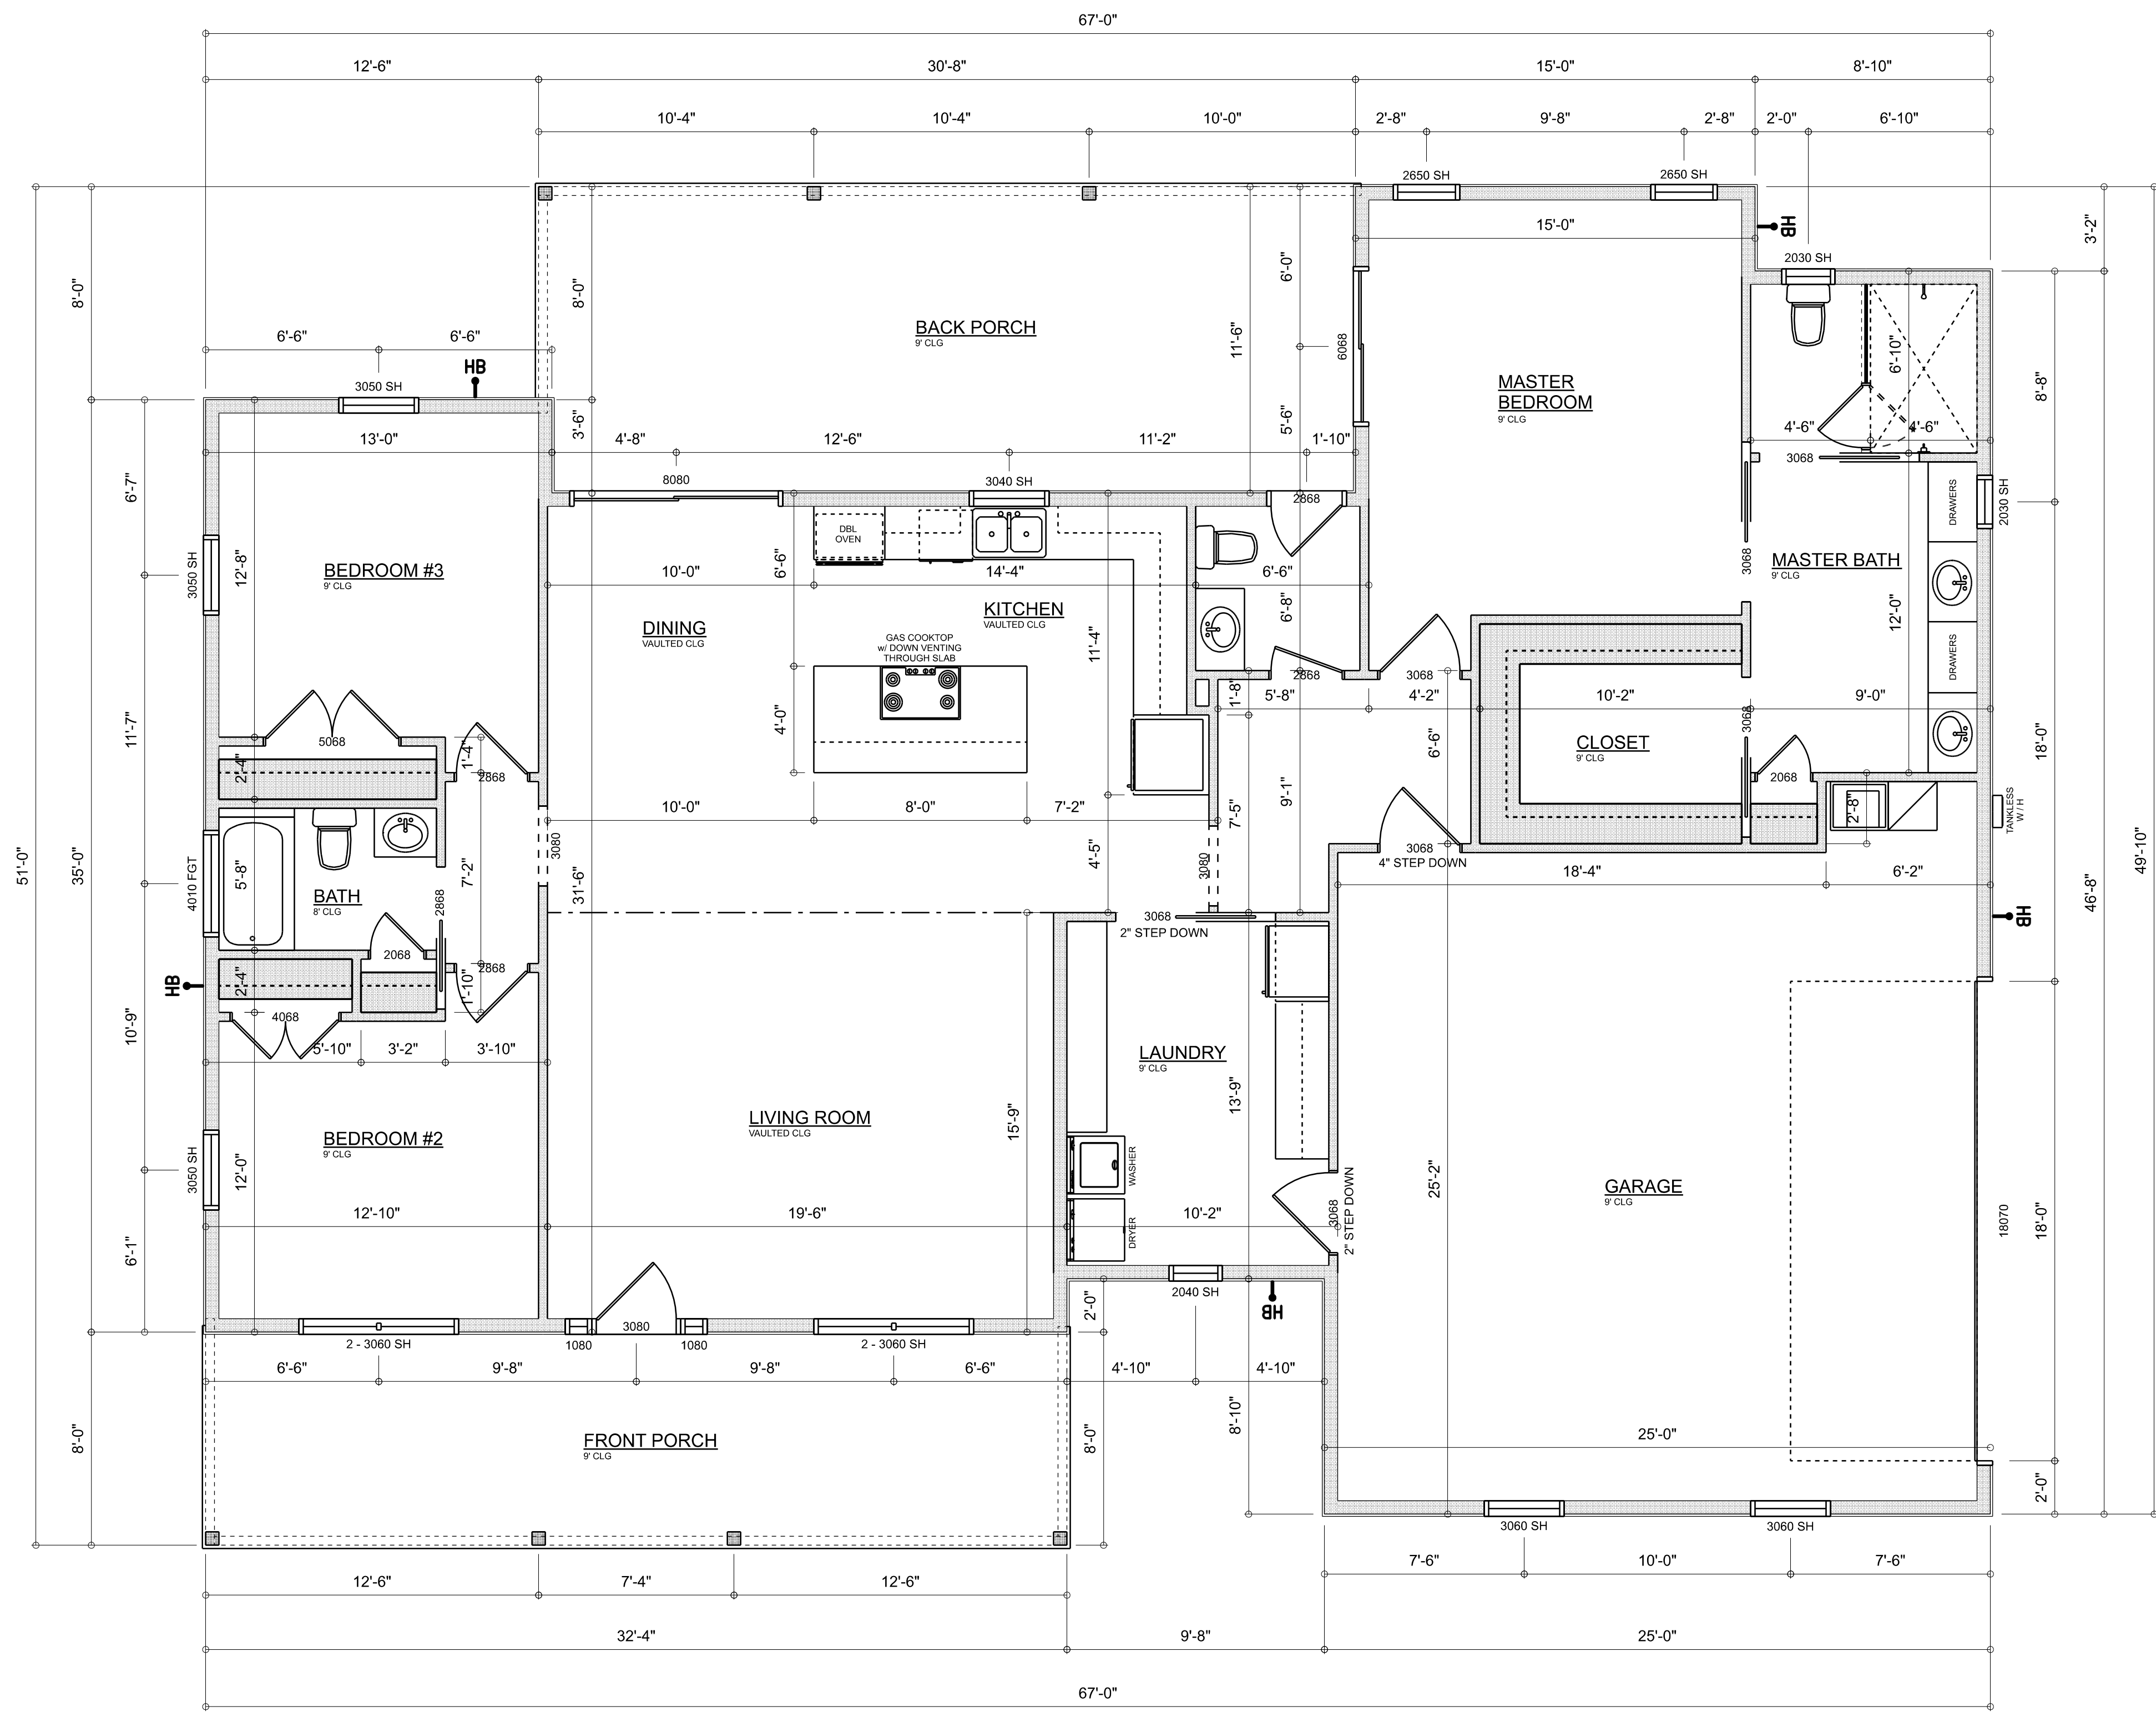


DIMENSIONED FLOOR PLAN  
SCALE: 1/4" = 1'-0"


| AREA SUMMARY |       |      |
|--------------|-------|------|
| LIVING       | 1,917 | S.F. |
| ENTRY PORCH  | 259   | S.F. |
| REAR PORCH   | 353   | S.F. |
| GARAGE       | 634   | S.F. |
| TOTAL AREA   | 3,163 | S.F. |

| REVISIONS SCHEDULE |                 |
|--------------------|-----------------|
| PROPOSAL           | Apr. 2nd, 2025  |
| PERMIT SET         | Apr. 11th, 2025 |
|                    |                 |
|                    |                 |

CUSTOM HOME FOR:  
**WEBB RESIDENCE**  
466 SW Jeanlea Pl, Fort White, FL 32038

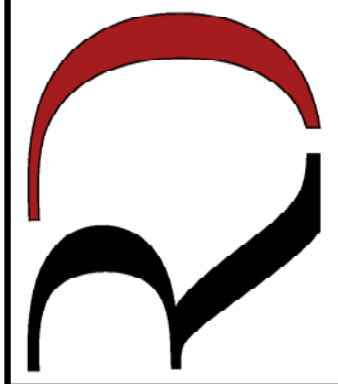**RIDGEPOINT  
DESIGN**

566 SW ARLINGTON BLVD. STE. 101, LAKE CITY, FL 32025  
P: 386-288-1188  
E: RIDGEPOINTDESIGN@GMAIL.COM

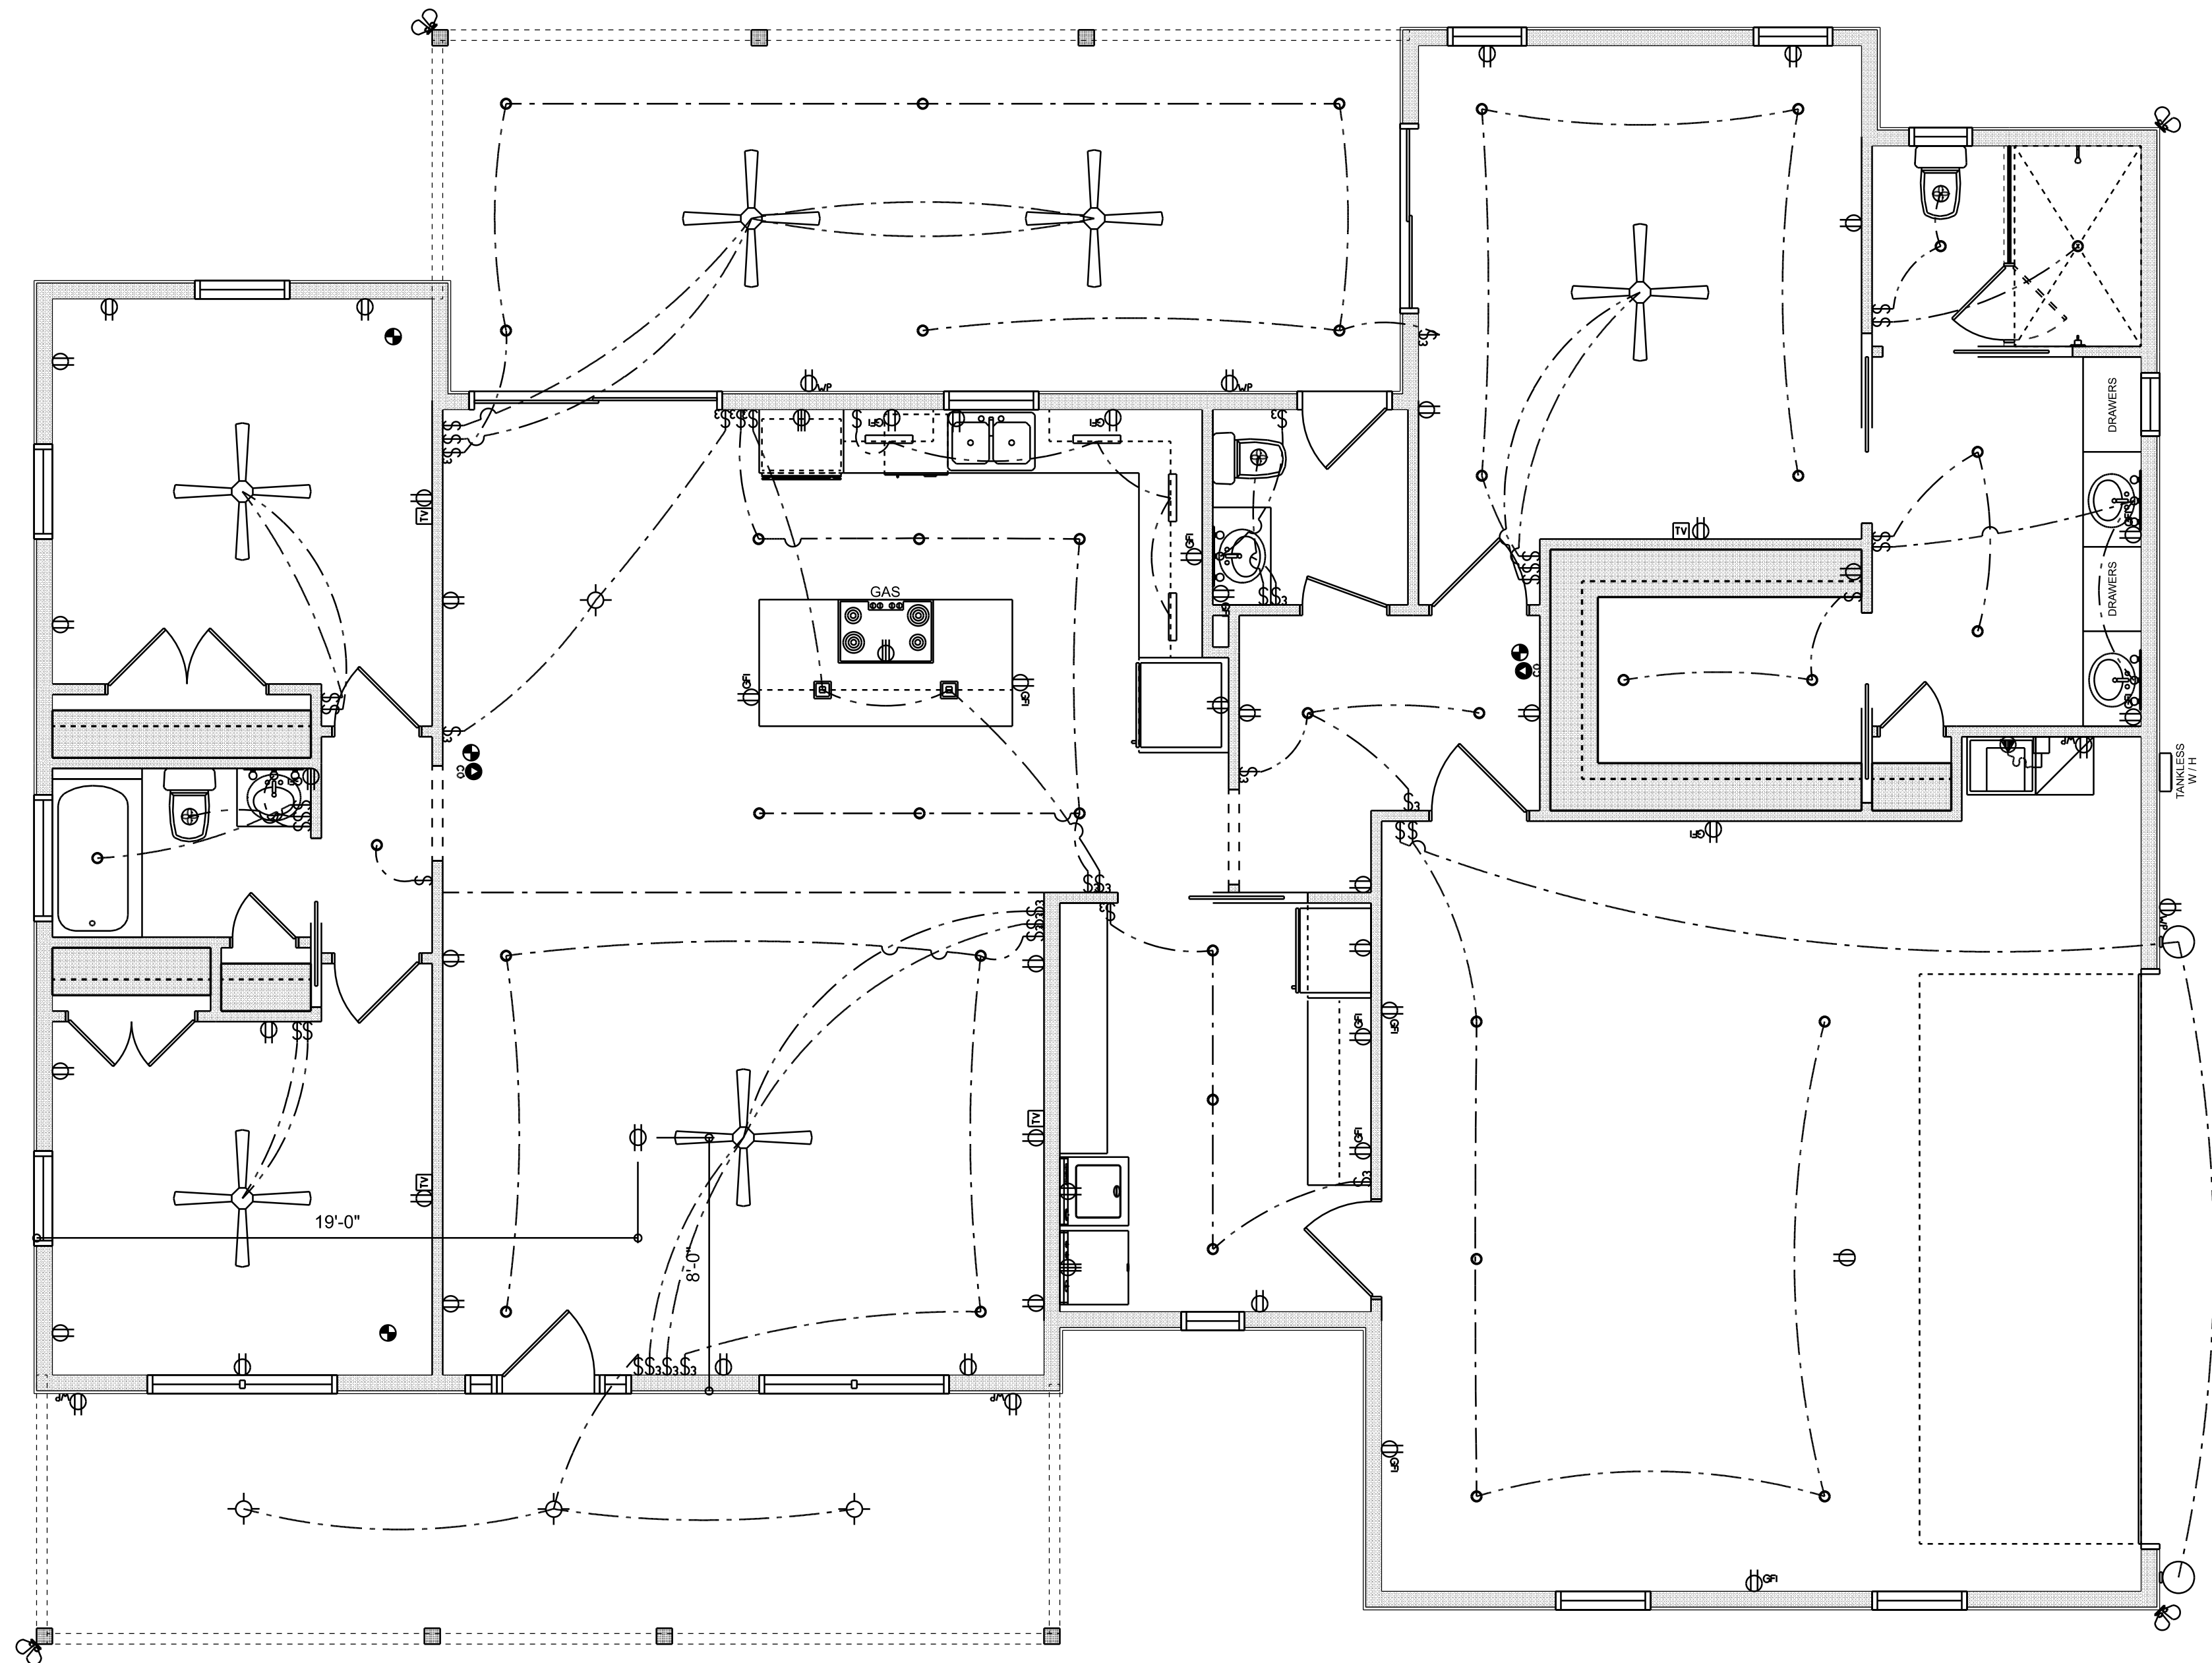

**ELECTRICAL PLAN**  
SCALE: 1/4" = 1'-0"

| ELECTRICAL LEGEND           |       |        |
|-----------------------------|-------|--------|
| ELECTRICAL                  | COUNT | SYMBOL |
| CEILING FAN                 | 6     |        |
| 4" Octagon Box Flush w/ CLG | 38    |        |
| PENDANT LIGHT               | 2     |        |
| EXTERIOR SCONCE             | 2     |        |
| MOTION SECURITY LIGHT       | 4     |        |
| AC DISCONNECT               | 1     |        |
| CABLE TV OUTLET             | 4     |        |
| CARBON DETECTOR             | 2     |        |
| EXHAUST FAN                 | 3     |        |
| FLOOR OULET DUPLEX          | 1     |        |
| OUTLET                      | 33    |        |
| OUTLET 220v                 | 3     |        |
| OUTLET GFI                  | 15    |        |
| OUTLET WP                   | 6     |        |
| SMOKE DETECTOR              | 4     |        |
| STANDARD LIGHT              | 4     |        |
| SWITCH                      | 23    |        |
| SWITCH 3 WAY                | 20    |        |
| VANITY BAR LIGHT - SMALL    | 4     |        |
| uplight                     | 4     |        |

**ELECTRICAL PLAN NOTES:**

INSTALLATION SHALL BE PER LATEST NAT'L ELECTRIC CODE.

WIRE ALL APPLIANCES, HVAC UNITS AND OTHER EQUIPMENT PER MANUF. SPECIFICATIONS

CONSULT WITH THE OWNER FOR THE NUMBER OF SEPERATE TELEPHONE LINES TO BE INSTALLED

ALL SMOKE DETECTORS SHALL BE 120V W/ BATTERY BACKUP OF THE PHOTOELECTRIC TYPE, AND SHALL BE INTERLOCKED TOGETHER. INSTALL INSIDE AND NEAR ALL BEDROOMS

TELEPHONE, TELEVISION AND OTHER LOW VOLTAGE DEVICES OR OUTLETS SHALL BE AS PER THE OWNER'S DIRECTIONS, & IN ACCORDANCE W/ APPLICABLE SECTIONS OF NEC-LATEST EDITION.

ELECTRICAL CONTR SHALL PREPARE "AS-BUILT" SHOP DWGS INDICATING ALL ELECTRICAL WORK, INCLUDING ANY CHANGES TO THE ELEC. PLAN, ADD'NS TO THE ELEC. PLAN, RISER DIAGRAM, AS-BUILT PANEL SCHEDULE W/ ALL CKTS IDENTIFIED W/ CKT N°, DESCRIPTION & BRKR, SERVICE ENT, & ALL UNDERGROUND WIRE

LOCATIONS/ROUTING / DEPTH, RISER DIA, SHALL INCLUDE WIRE SIZES/TYPE & EQUIPMENT TYPE W/ RATINGS & LOADS.

CONTRACTOR SHALL PROVIDE 1 COPY OF AS-BUILT DWGS TO OWNER & 1 COPY TO THE PERMIT ISSUING AUTHORITY

ALL RECEPTICALS, NOT OTHERWISE NOTED, SHALL BE ARC FAULT INTERRUPTER TYPE, EXCEPT DEDICATED OUTLETS

ALL RECEPTICALS IN WET AREAS SHALL BE GROUND FAULT INTERRUPTER TYPE (GFI)

ALL EXTERIOR RECEPTICALS SHALL BE WEATHERPROOF GROUD FAULT INTERRUPTER TYPE (WP/GFI)

| REVISIONS SCHEDULE |                 |
|--------------------|-----------------|
| PROPOSAL           | Apr. 2nd, 2025  |
| PERMIT SET         | Apr. 11th, 2025 |
|                    |                 |
|                    |                 |

CUSTOM HOME FOR:  
**WEBB RESIDENCE**  
466 SW Jeanlea Pl, Fort White, FL 32038

**RIDGEPOINT  
DESIGN**  
566 SW ARLINGTON BLVD STE 101 LAKE CITY, FL 32025  
P: 386-288-1188  
E: RIDGEPOINTDESIGN@GMAIL.COM