

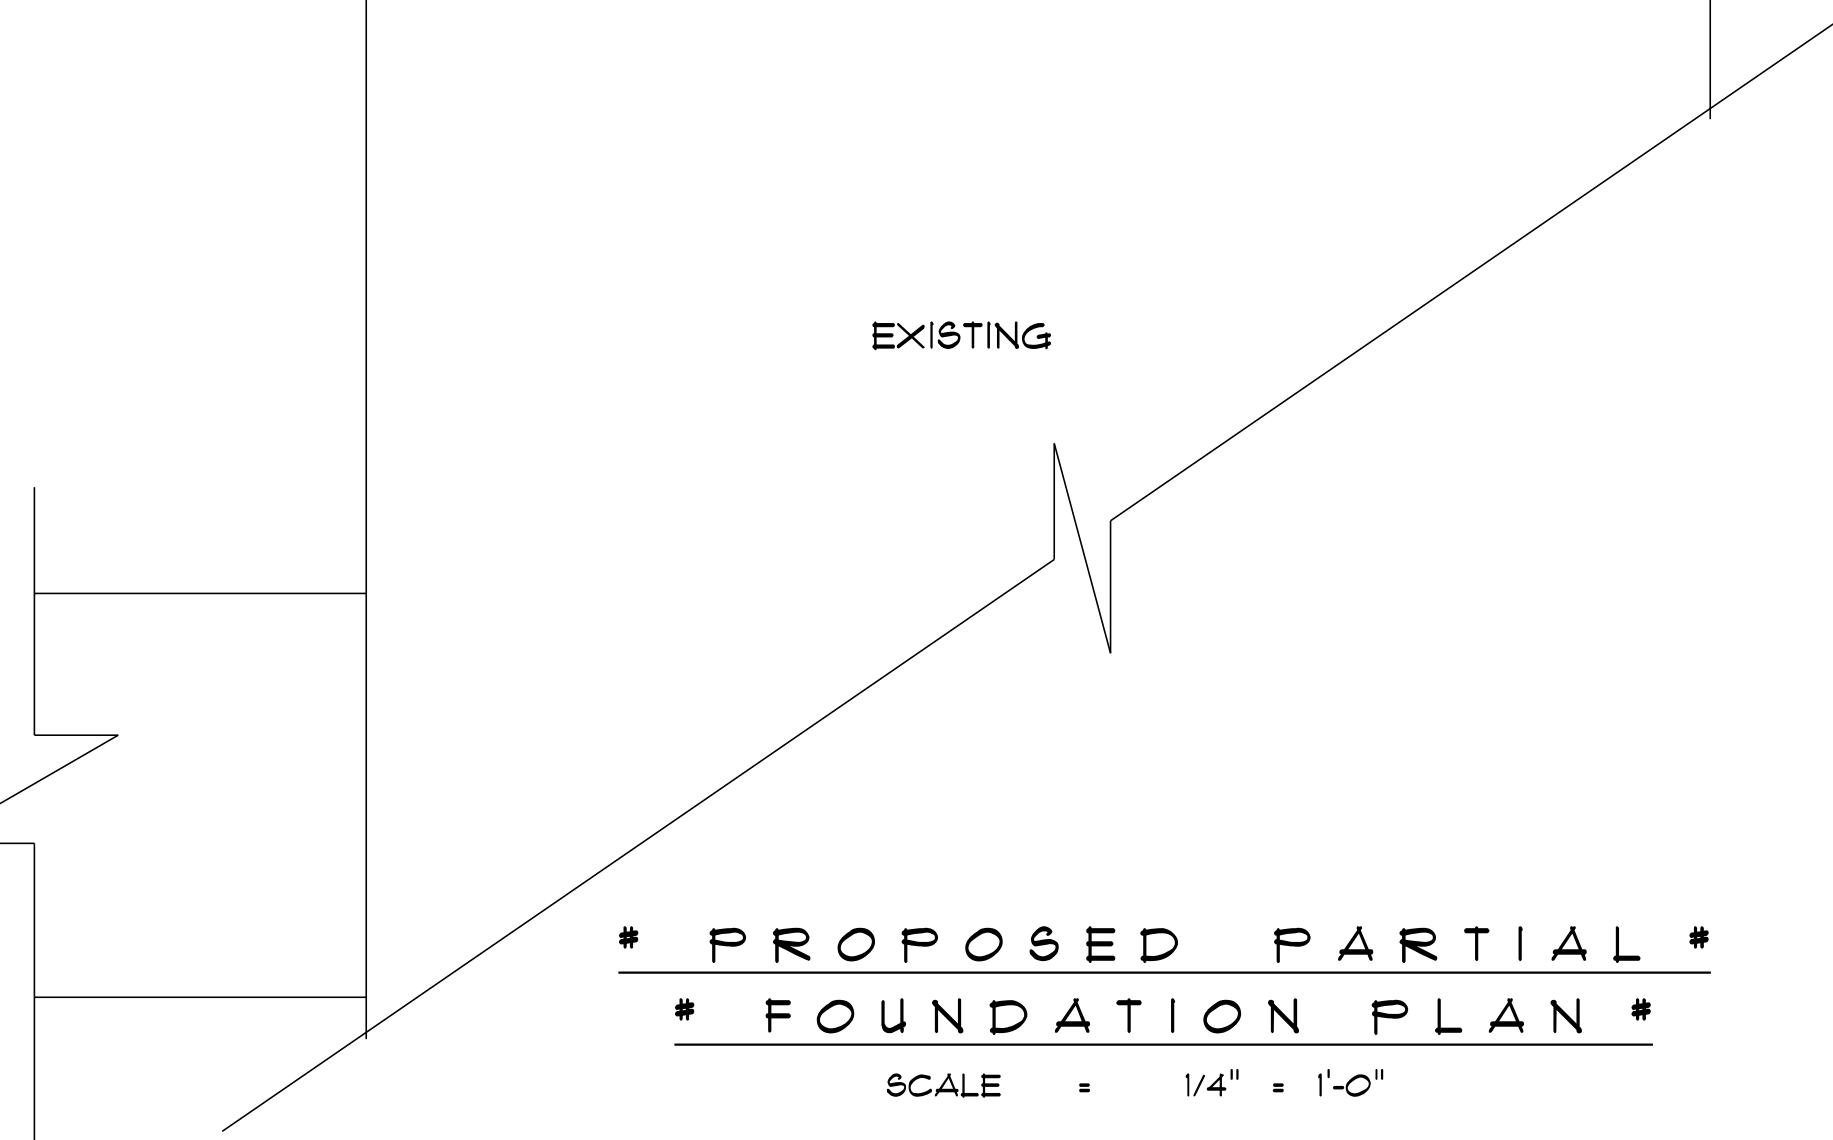


Diagram illustrating the cross-section of a roof-to-wall connection, showing the assembly from the roof structure down to the foundation.

Roof Assembly (from top to bottom):

- FOAM VENT TO KEEP INSULATION OUT OF EYES
- R30 INSULATION
- ARCHITECTURAL FIBERGLASS SHINGLES
- 1/2" OSB ROOF SHEATHING
- PRE-ENGINEERED WOOD ROOF TRUSSES AT 24" O.C. SELECT TRUSS CONNECTORS FROM THE ANCHOR TABLE PER TRUSS UPLIFT LOADS

Wall Assembly (from top to bottom):

- 1/2" GUB
- NOTE: SEAL ALL PENETRATIONS IN TOP PLATE AND FIRE STOP BLOCKING WITH CODE APPROVED SEALANT
- PREFINISHED ALUMINUM DRIP
- ALUMINUM FASCIA ON 1/2" X 4" SUB-FASCIA
- PREFINISHED VENTED ALUM. SOFFIT SYSTEM
- 7/8" X 24" DOUBLE TOP PLATE
- 24" MAX
- 2X4 PRECUT STUDS AT 16" O.C.
- R13 BATT INSULATION
- STUCCO FINISH OVER WALL SHEATHING
- 0.8 B. WALL SHEATHING


Foundation Assembly (from top to bottom):

- 4" CONCRETE FLOOR SLAB
- 2X4 P.T. PINE SOLE PLATE
- CONCRETE BLOCK STEM WALL SEE ENGINEERING FOR SIZE AND REINFORCEMENT APPROX. FINISH GRADE
- POURED CONCRETE STRIP FOOTING SEE ENGINEERING FOR SIZE AND REINFORCEMENT

Other Labels:

- 8'-0" (Vertical dimension on the left)
- SEE FLOOR PLAN (Vertical dimension on the left)
- WOOD BASE
- 1/2" GUB
- 1 (Label near the aluminum fascia)
- 2 (Label near the double top plate)

Architectural drawing of a porch. The drawing shows a cross-section of a porch with a roof. The roof is labeled "EXISTING COVERED PORCH". A new section, labeled "CUT IN NEW 2'-0\" x 6'-0\" 6-PANEL", is shown on the right side of the porch. The new section is indicated by a dashed line and a curved arrow pointing to the existing structure. The drawing also shows a wall on the left and a wall on the right, with a door or window opening on the right wall.

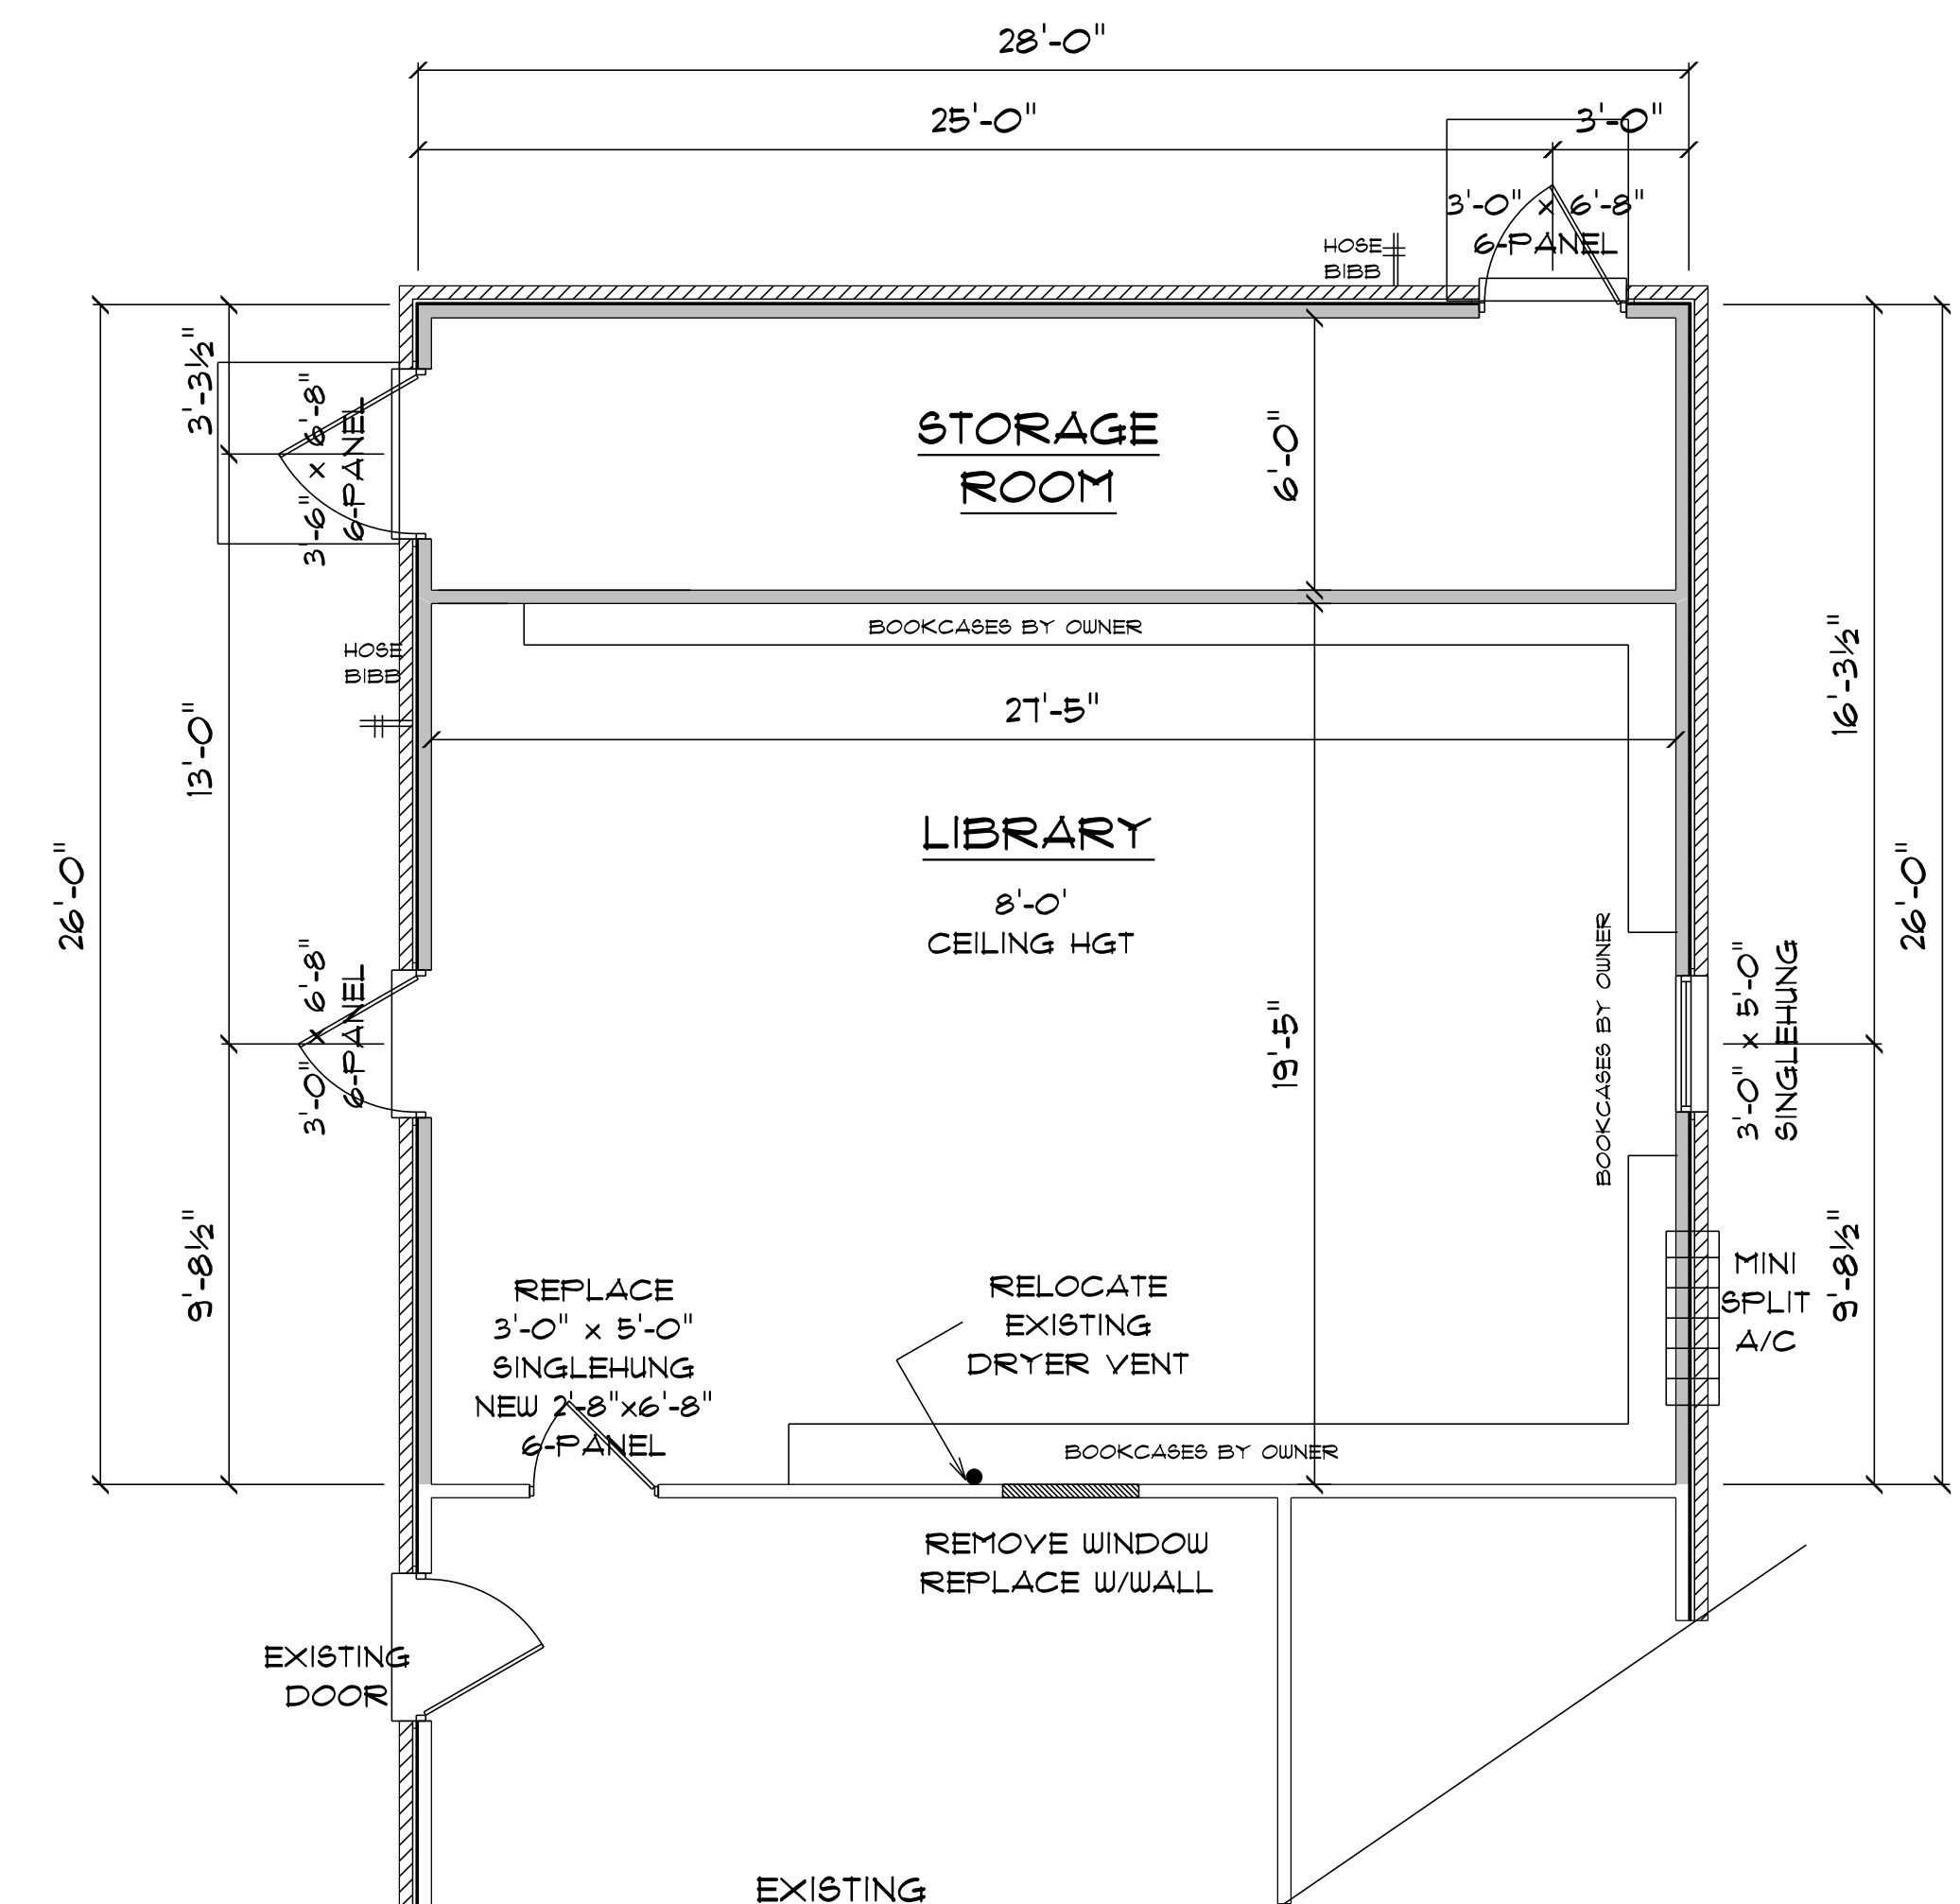

PROPOSED PARTIAL #
FLOOR PLAN #
SCALE = 1/4" = 1'-0"

ADDITION
for
BOB & LANE
DEKLE

9 SW LOBLOLLY PL
LAKE CITY, FLORIDA

Teena M. Ruffo
2925 SW SR 47
S City Florida, 32025
ell: (386) 867 - 1191
: teenaruffo@gmail.com

PRINTED DATE:
Thursday, June 25, 2020

OWN BY:	CHECKED BY:
M. Ruffo	
HIGGING CONTRACTOR	


DATE:	
-------	--

JOB NUMBER:	_____
-------------	-------

DRAWING NUMBER

k-1

2 SHEETS

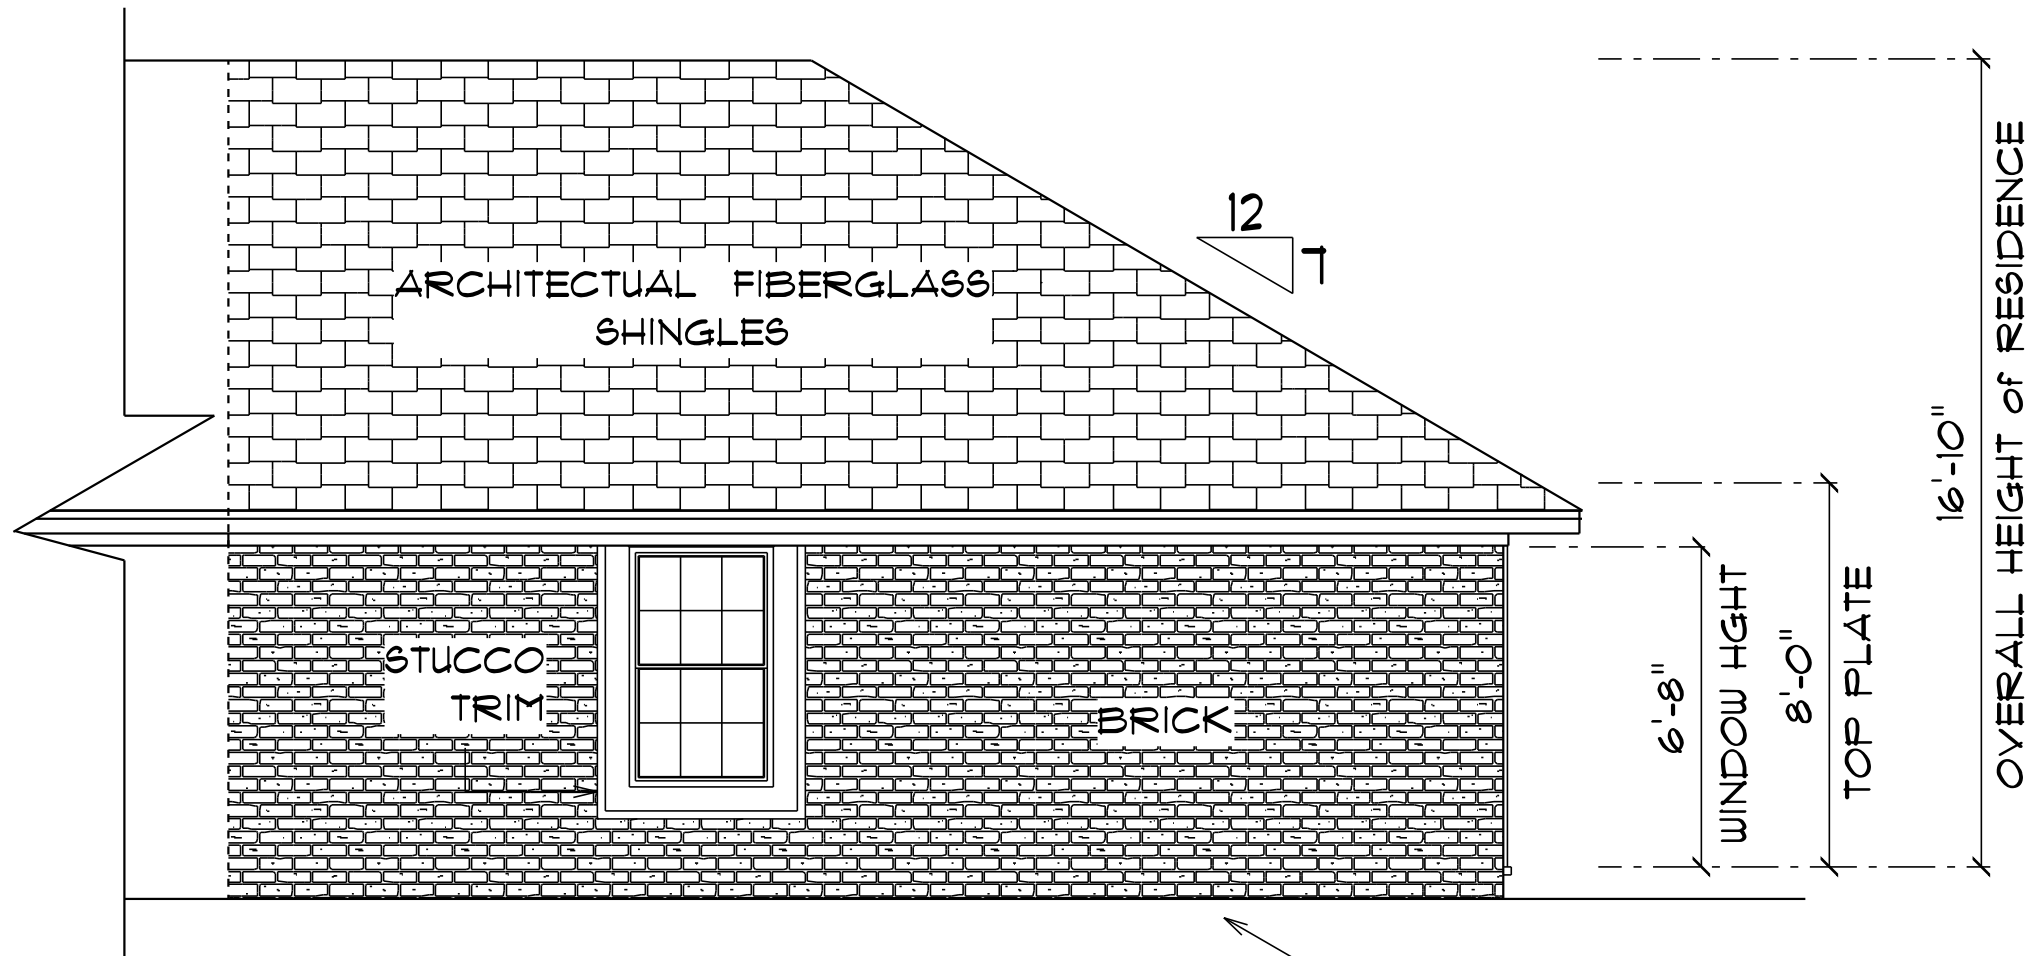


* PARTIAL *
* RIGHT SIDE ELEVATION *

NOTE:
24" OVERHANG ON GABLE ENDS


SCALE : 3/16" = 1'-0"

NOTE:
ALL FINISHES TO MATCH EXISTING

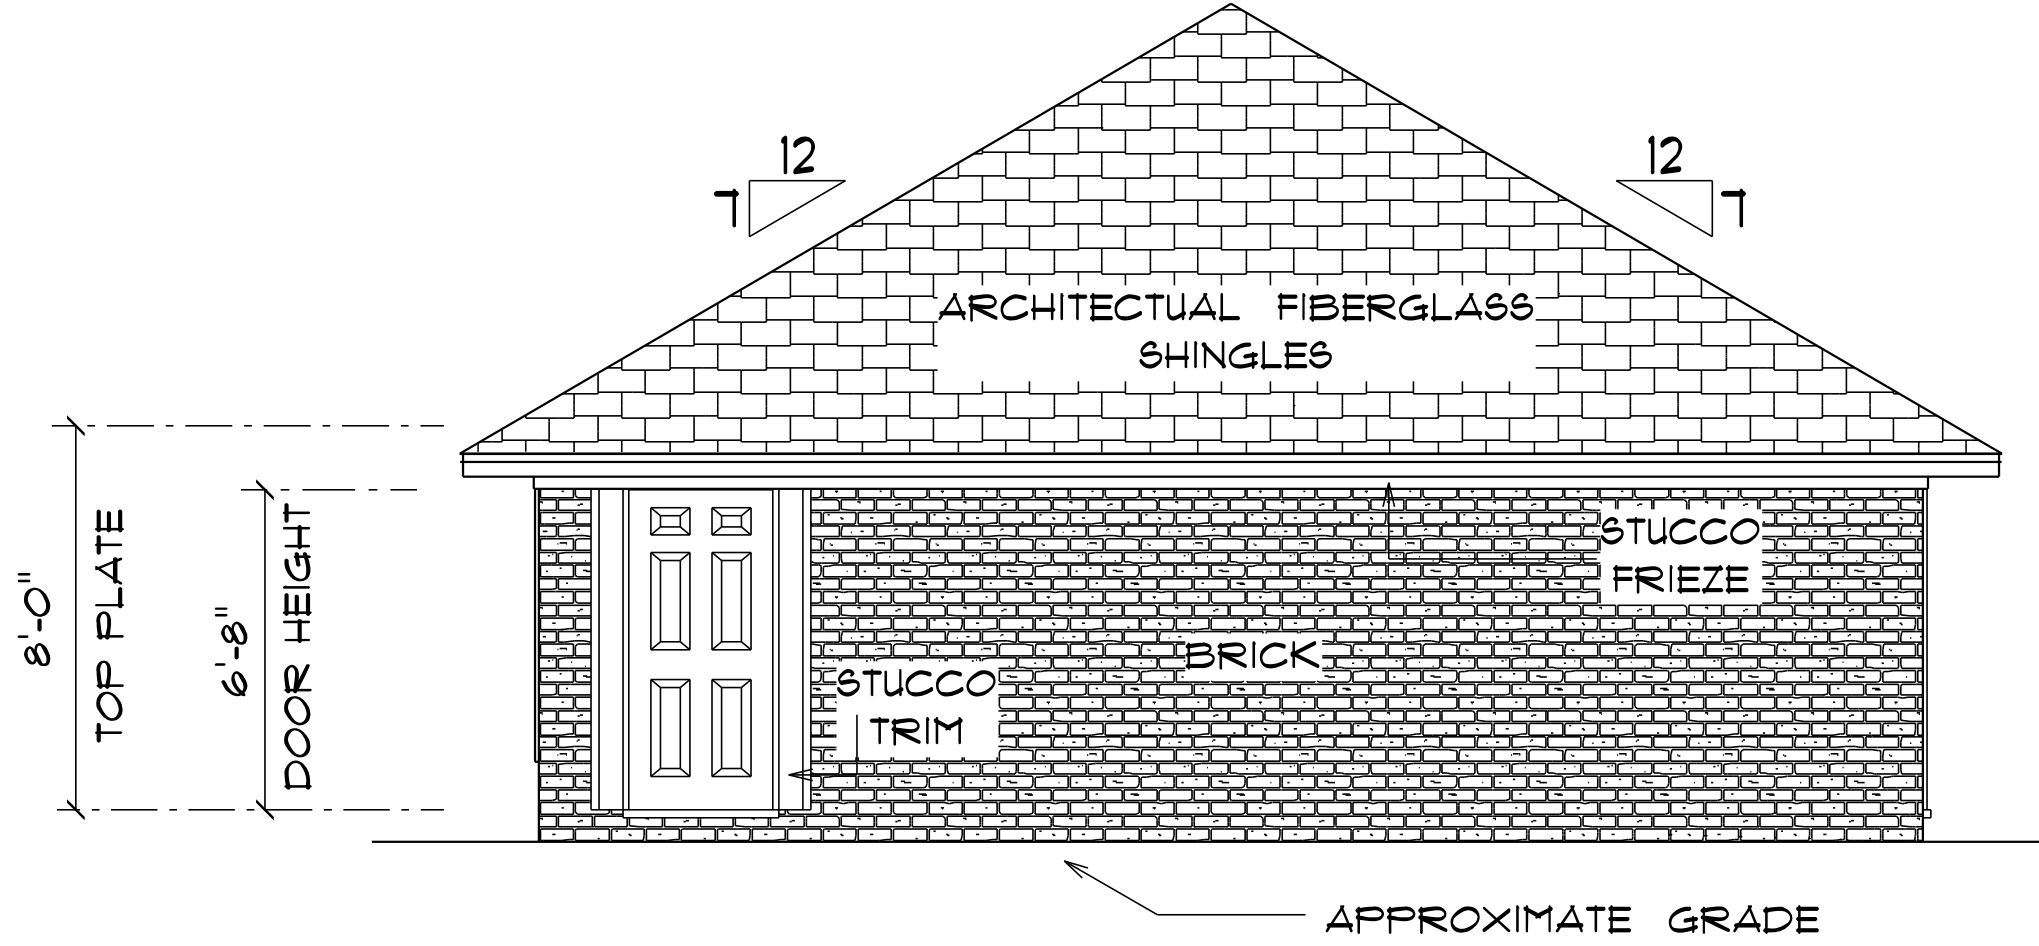

* PARTIAL *
* REAR ELEVATION *



SCALE : 1/4" = 1'-0"

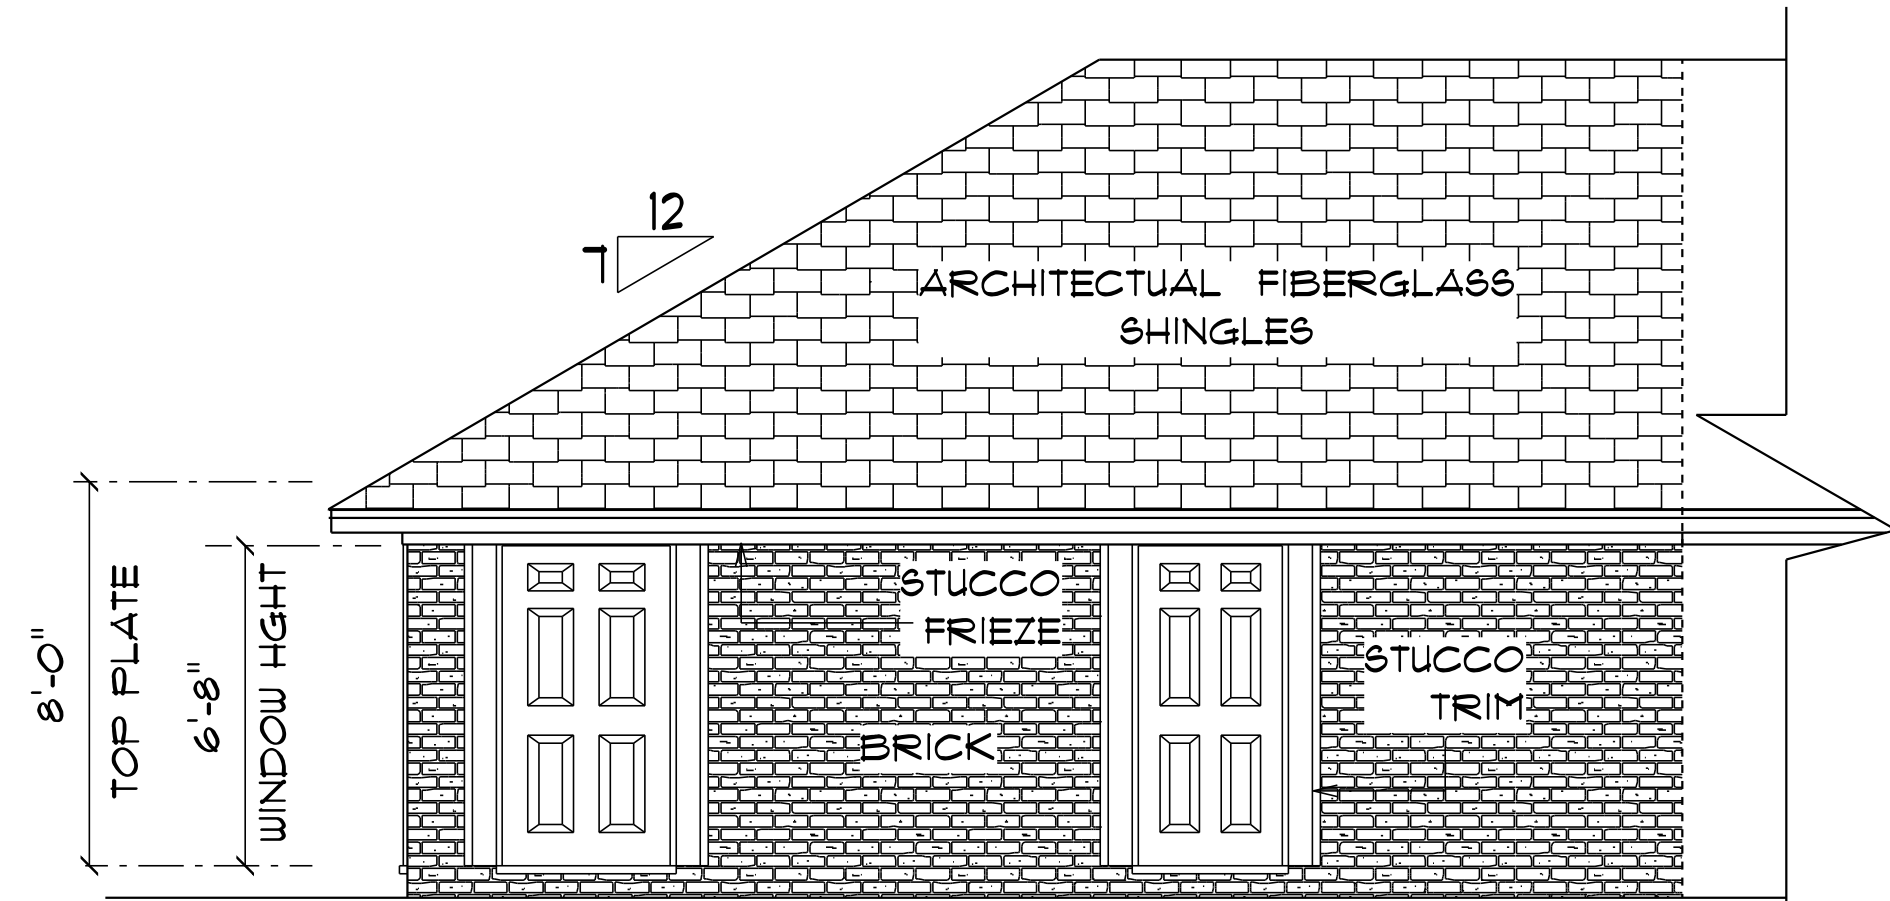

* PARTIAL *
* LEFT SIDE ELEVATION *

SCALE : 1/4" = 1'-0"

ELECTRICAL LEGEND		
ELECTRICAL	COUNT	SYMBOL
ceiling fan globe O1	2	
pot light	9	
exterior light O2	1	
spotlight double	2	
light	3	
outlet	9	
outlet 220v	2	
outlet gfi	3	
outlet wp	1	
switch	4	
switch 3 way	2	

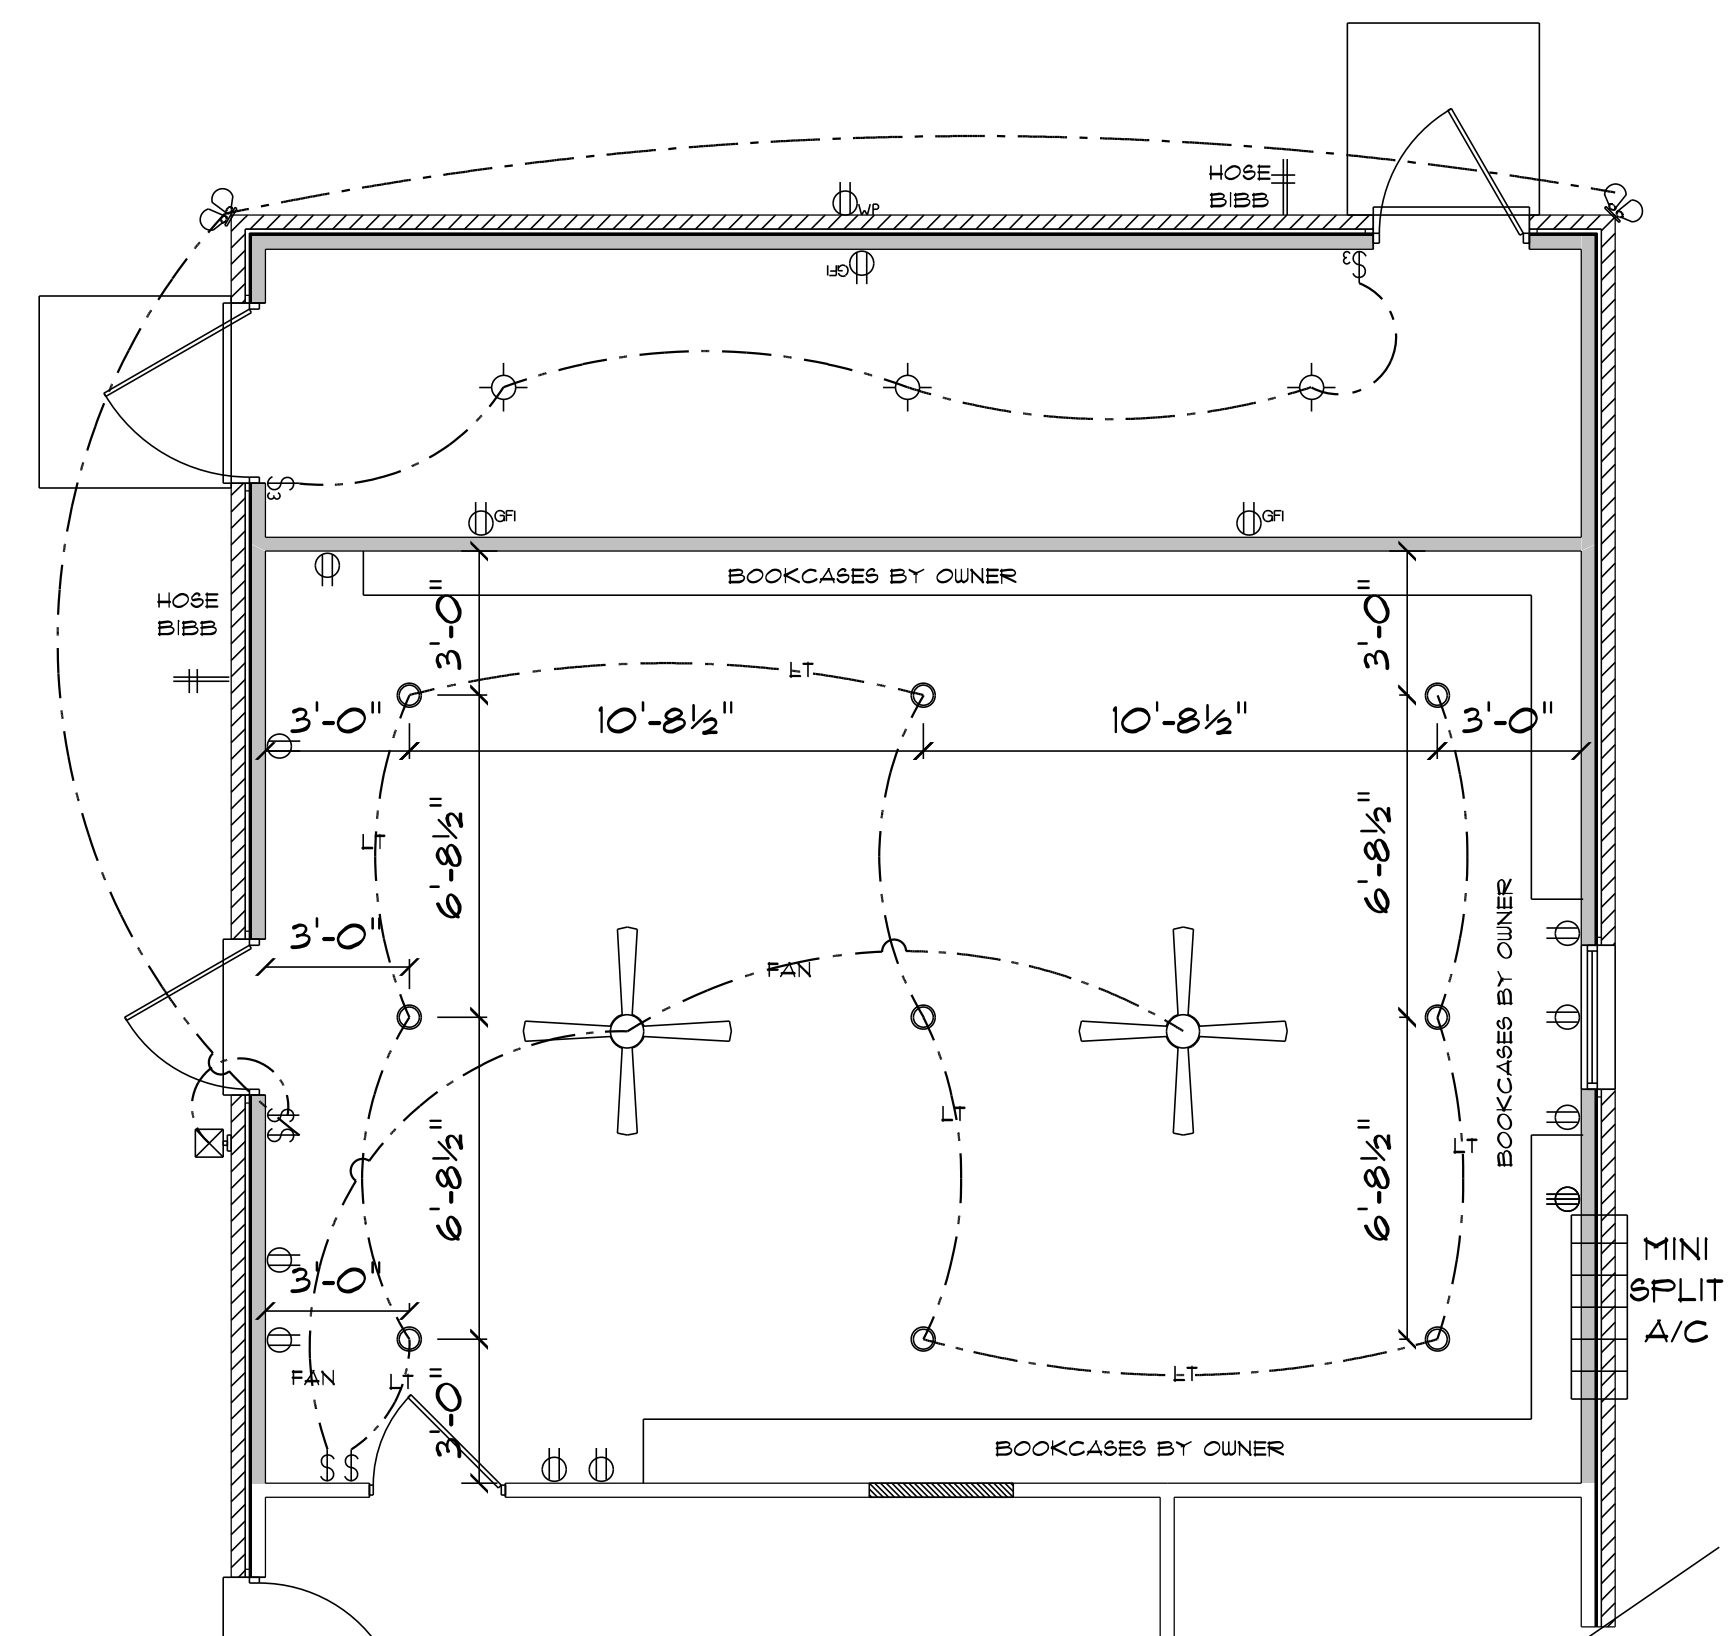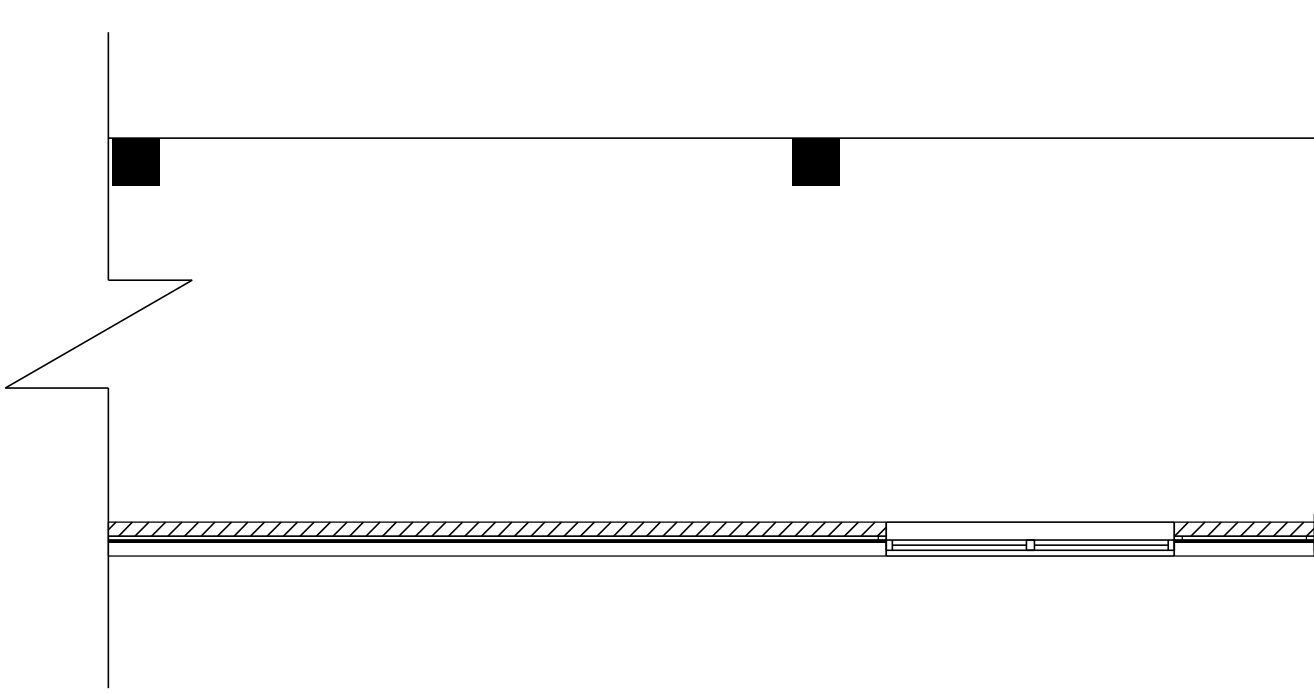

ELECTRICAL PLAN NOTES

- E-1 WIRE ALL APPLIANCES, HVAC UNITS AND OTHER EQUIPMENT PER MANUFACTURERS SPECIFICATIONS.
- E-2 ALL INSTALLATIONS SHALL BE PER NATIONAL ELECTRIC CODE.
- E-3 ELECTRICAL CONTRACTOR SHALL BE RESPONSIBLE FOR THE DESIGN AND SIZING OF ELECTRICAL SERVICE AND CIRCUITS.

* PROPOSED PARTIAL *
* ELECTRICAL PLAN *

SCALE = 1/4" = 1'-0"

ADDITION
for
BOB & LANE
DEKLE

283 SW LOBLOLLY PL
LAKE CITY, FLORIDA

Teena M. Ruffo
2925 SW SR 47
Lake City Florida, 32025
Cell: (386) 867-1191
Email: teenaruffo@gmail.com

PRINTED DATE:
Thursday, June 25, 2020

DRAWN BY: Teena M. Ruffo CHECKED BY:

BUILDING CONTRACTOR

FINALS DATE:

JOB NUMBER:

DRAWING NUMBER

A-2

OF 2 SHEETS