

ELECTRICAL PLAN NOTES:

INSTALLATION SHALL BE PER LATEST NAT'L ELECTRIC CODE.
WIRE ALL APPLIANCES, HVAC UNITS AND OTHER EQUIPMENT
PER MANUF. SPECIFICATIONS

CONSULT WITH THE OWNER FOR THE NUMBER OF SEPERATE
TELEPHONE LINES TO BE INSTALLED

ALL SMOKE DETECTORS SHALL BE 120v W/ BATTERY
BACKUP OF THE PHOTOELECTRIC TYPE, AND SHALL
BE INTERLOCKED TOGETHER. INSTALL INSIDE AND NEAR
ALL BEDROOMS


TELEPHONE, TELEVISION AND OTHER LOW VOLTAGE
DEVICES OR OUTLETS SHALL BE AS PER THE OWNER'S
DIRECTIONS, & IN ACCORDANCE W/ APPLICABLE
SECTIONS OF NEC-LATEST EDITION.

ALL RECEPTICALS, NOT OTHERWISE NOTED, SHALL BE ARC
FAULT INTERRUPTER TYPE, EXCEPT DEDICATED OUTLETS

ALL RECEPTICALS IN WET AREAS SHALL BE GROUND
FAULT INTERRUPTER TYPE (GFI)


ALL EXTERIOR RECEPTICALS SHALL BE WEATHERPROOF
GROUD FAULT INTERRUPTER TYPE (WP/GFI)

NOTE:
ELECTRICAL CONT'R SHALL PREPARE "AS-BUILT" SHOP
DWGS INDICATING ALL ELECTRICAL WORK, INCLUDING ANY
CHANGES TO THE ELEC. PLAN, ADD'NS TO THE ELEC. PLAN,
RISER DIAGRAM, AS-BUILT PANEL SCHEDULE W/ ALL CKTS
IDENTIFIED W/ CKT Nr. DESCRIPTION & BRKR. SERVICE ENT.
& ALL UNDERGROUND WIRE LOCATIONS/ROUTING / DEPTH.
RISER DIA. SHALL INCLUDE WIRE SIZES/TYPE & EQUIPMENT
TYPE W/ RATINGS & LOADS.
CONTRACTOR SHALL PROVIDE 1 COPY OF AS-BUILT DWGS
TO OWNER & 1 COPY TO THE PERMIT ISSUING AUTHORITY

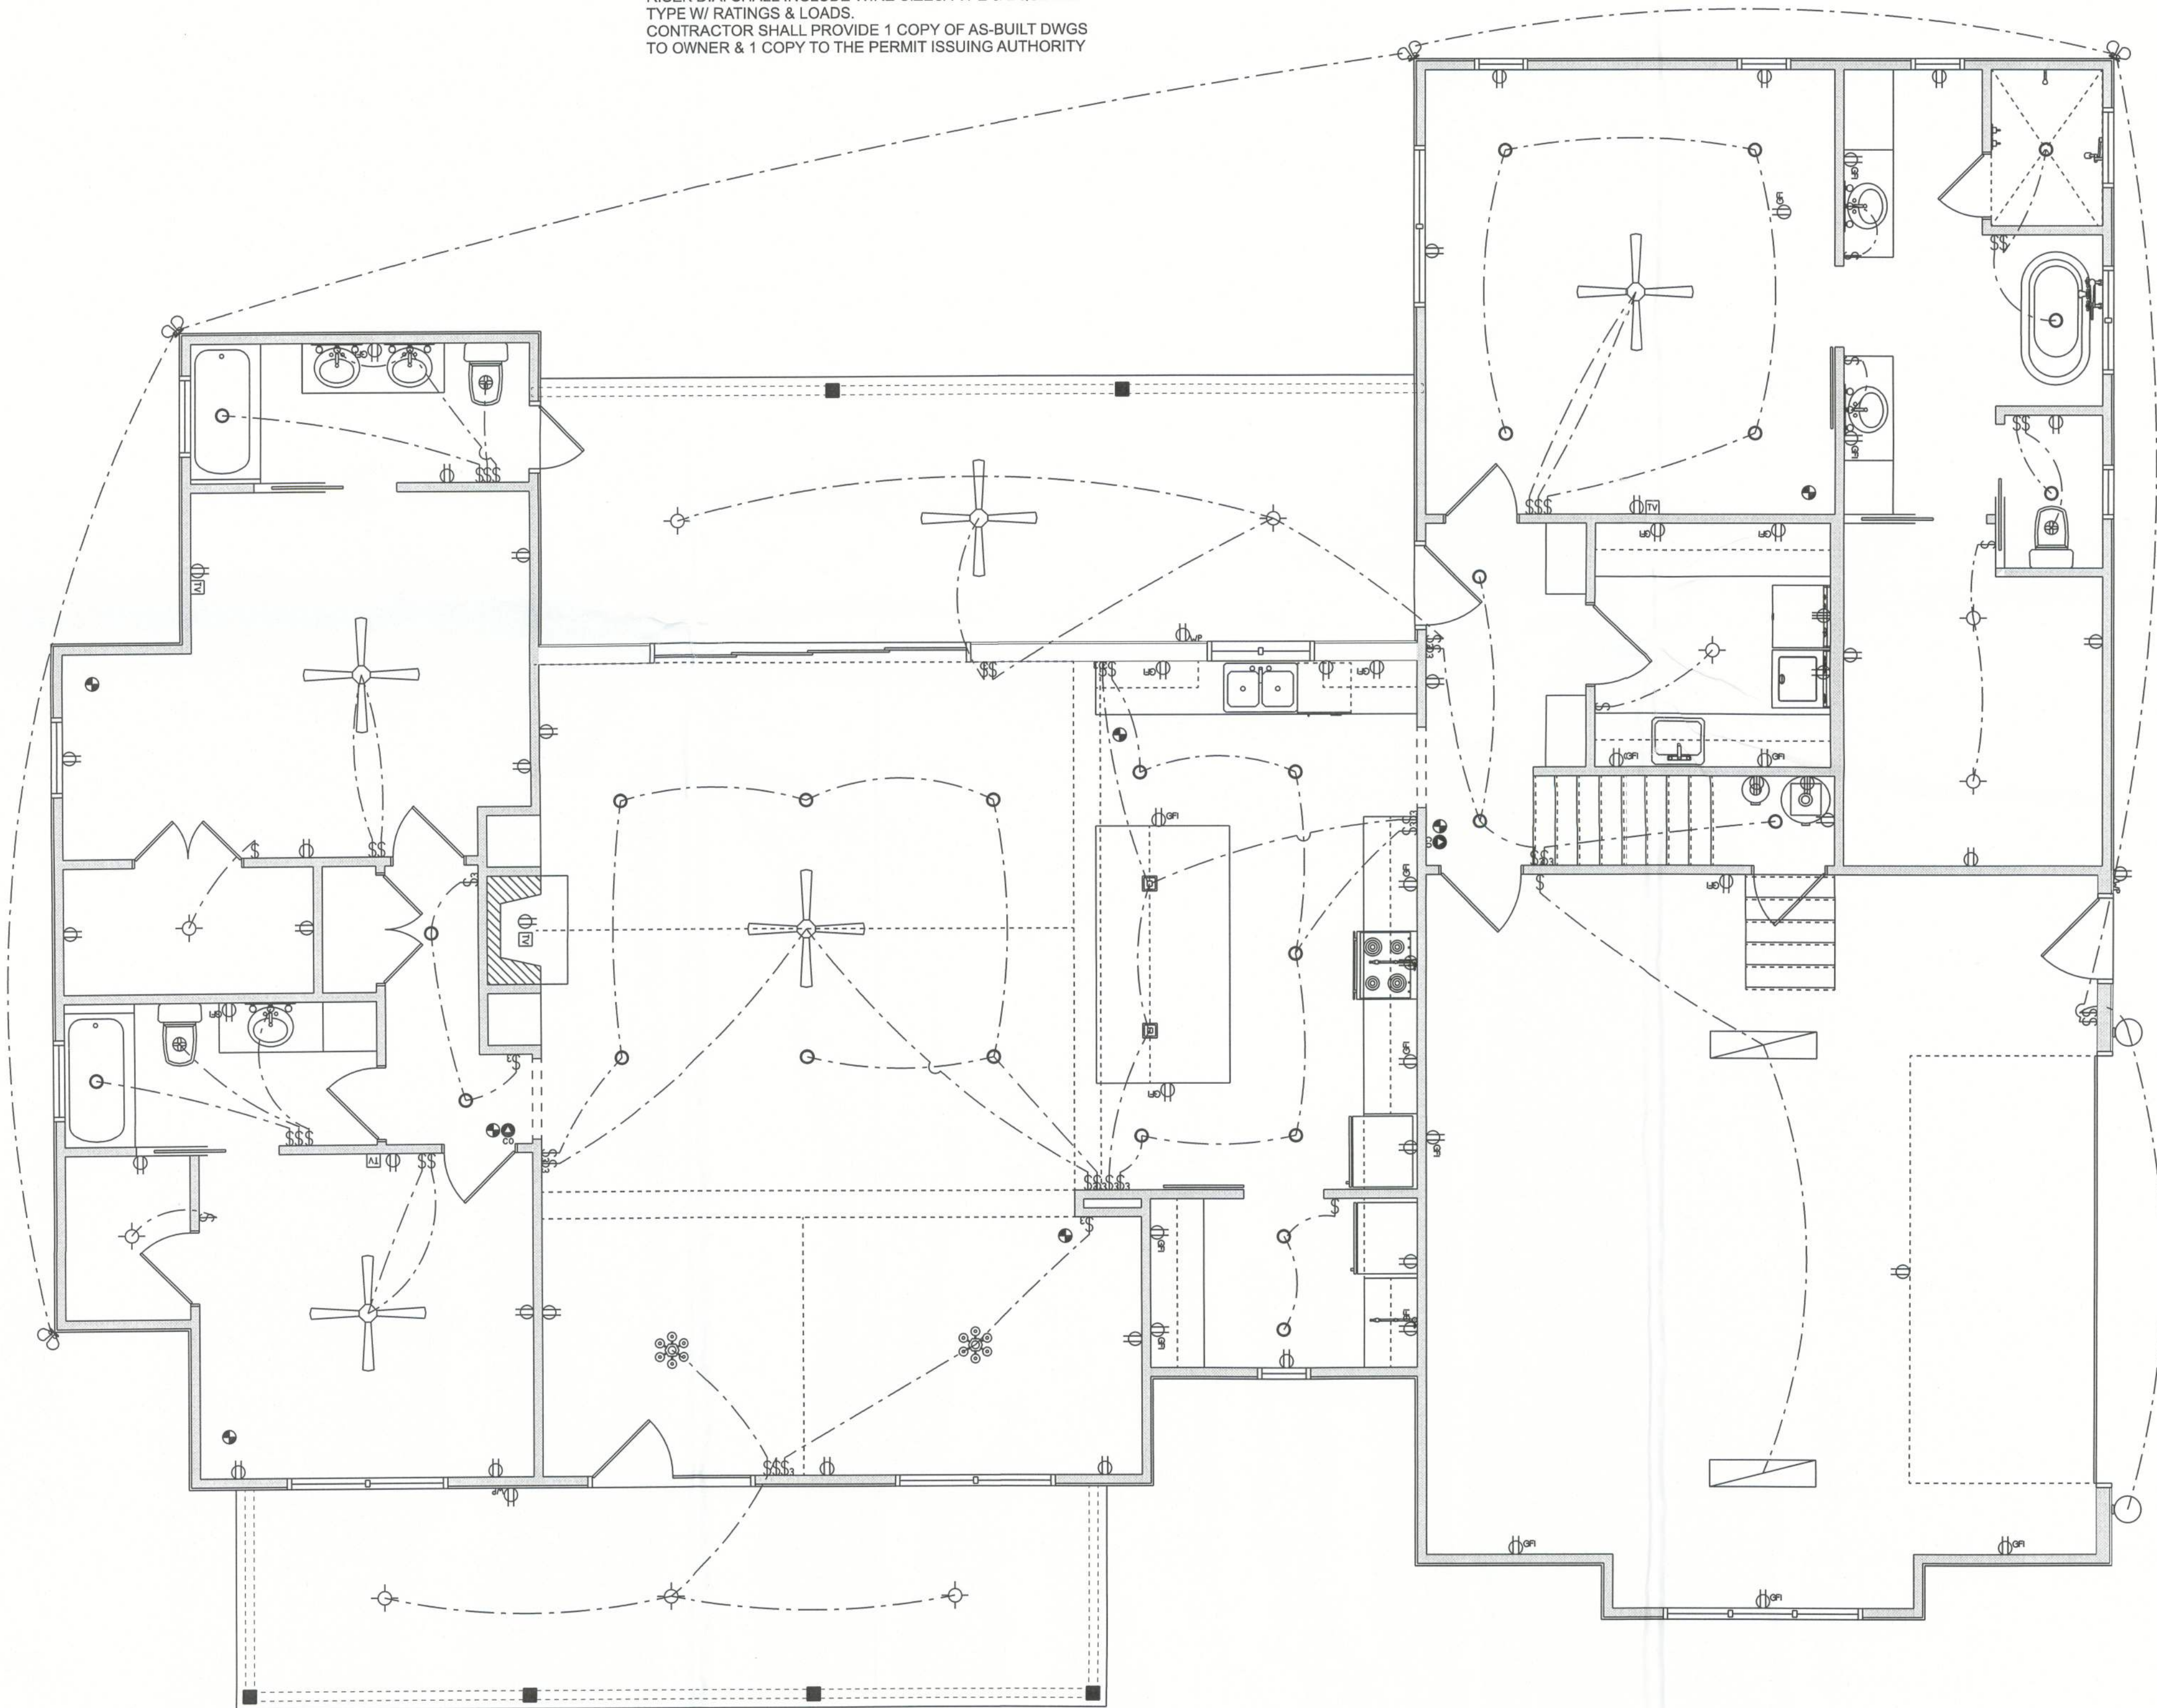

ELECTRICAL PLAN
SCALE: 1/4" = 1'-0"

ELECTRICAL LEGEND		
ELECTRICAL	COUNT	SYMBOL
CEILING FAN	6	
CAN LIGHT 6inch	28	
CHANDELIER	2	
LED CEILING LIGHT 1x4	2	
PENDANT LIGHT	2	
EXTERIOR SCENCE	2	
MOTION SECURITY LIGHT	4	
AC DISCONNECT	1	
CARBON DETECTOR	2	
COAX OUTLET	5	
EXHAUST FAN 50 cfm	3	
OUTLET	42	
OUTLET 220v	5	
OUTLET GFI	23	
OUTLET WP	3	
SMOKE DETECTOR	8	
STANDARD LIGHT	11	
SWITCH	33	
SWITCH 3 WAY	20	
VANITY BAR LIGHT - SMALL	5	

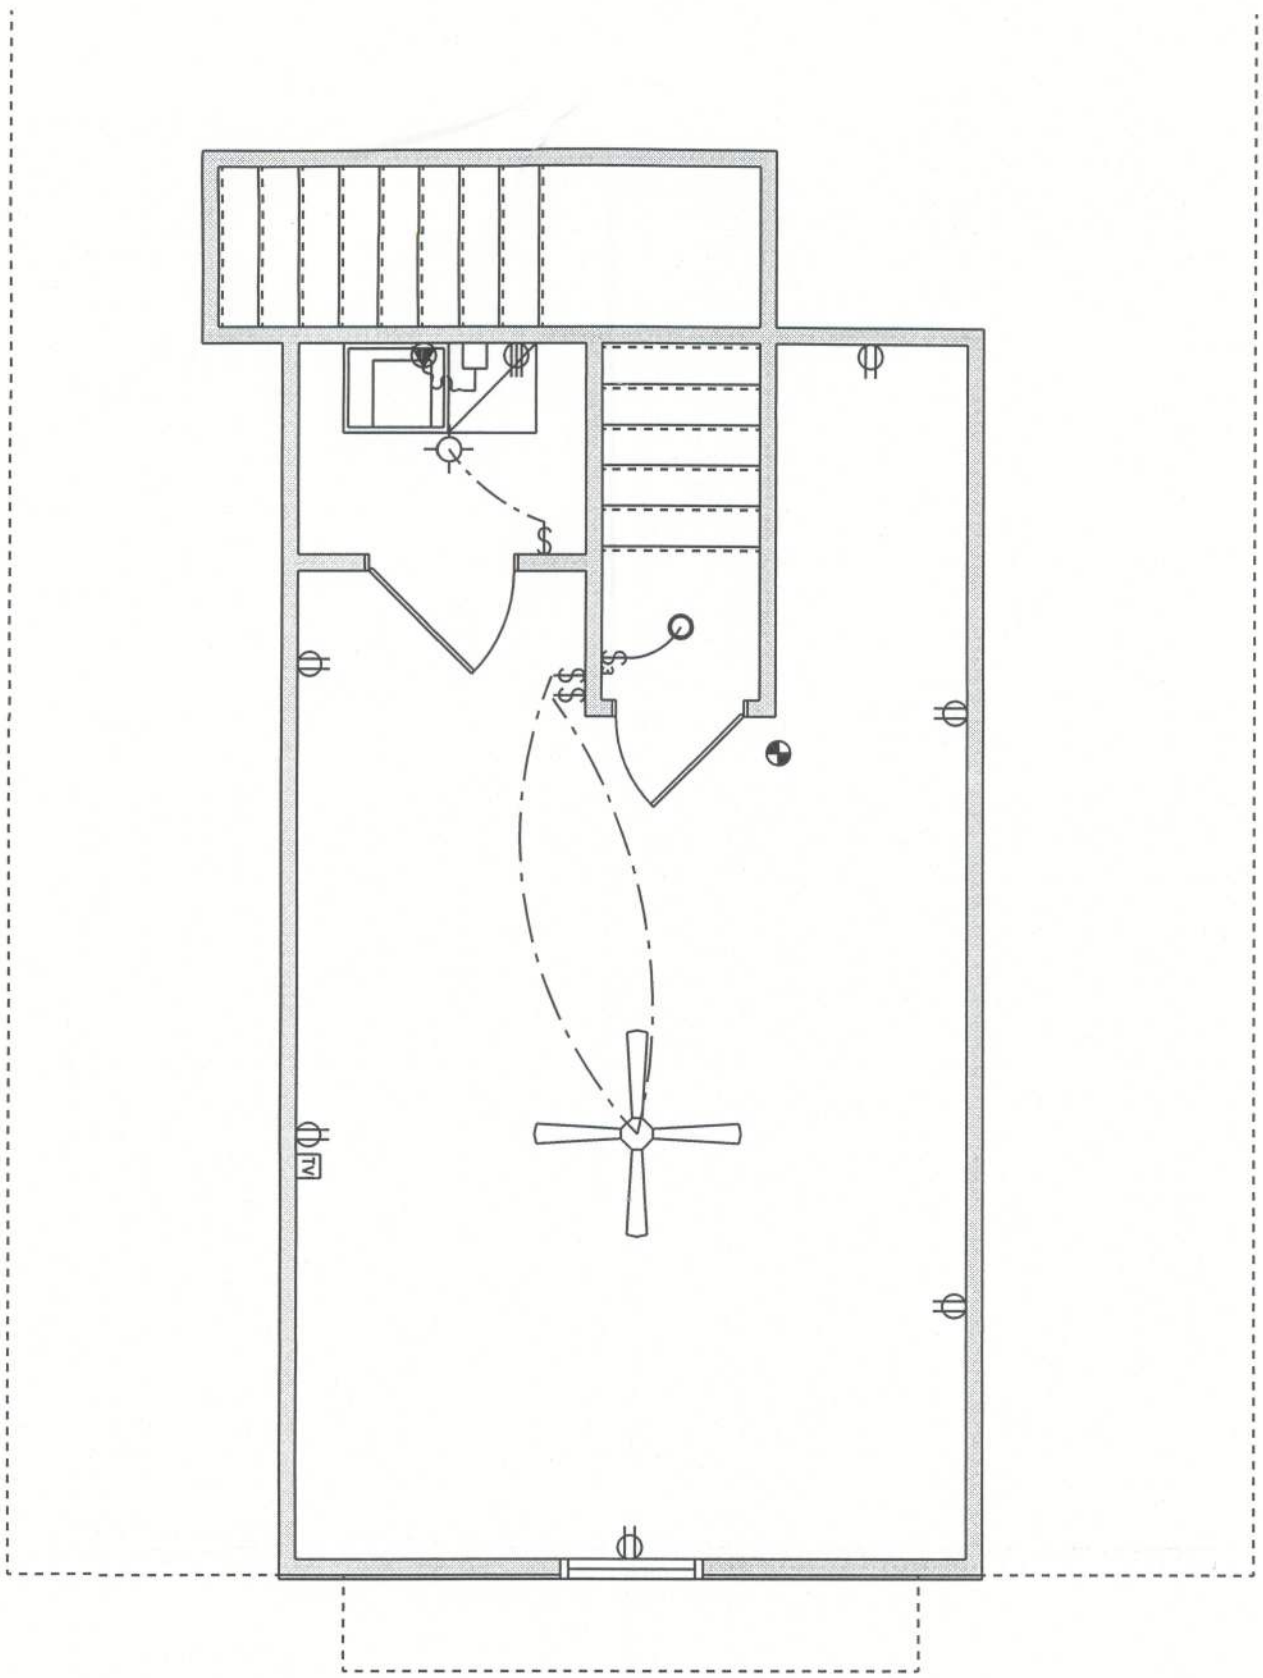

ELECTRICAL BONUS ROOM
SCALE: 1/4" = 1'-0"

REVISIONS SCHEDULE	
NOV. 1ST, 2023	PROPOSAL

OGBURN RESIDENCE
COLUMBIA COUNTY, FL

RIDGEPOINT
DESIGN
566 SW ARLINGTON BLVD. STE 101 LAKE CITY, FL 32025
P: 386-288-1188
E: RIDGEPOINTDESIGN@GMAIL.COM