


[illegible]

BEARING WOOD INTERIOR WALL SCHEDULE					
MARK	STUD SPACING	CONNECTION & FASTENERS		LUMBER SPECIES	UPLIFT CAP (#/F)
		TOP	BOTTOM		
BW1	16"	(2) 16d TOENAILS	(2) 16d TOENAILS	SPF	0
BW2	16"	SP2 W/ (6) 10d NAILS	SP1 W/ (6) 10d NAILS	SPF	402
BW3	16"	SP4 W/ (6) 10d X 1 1/2" NAILS	SP4 W/ (6) 10d X 1 1/2" NAILS	SPF	571
BW4	16"	(2) 16d TOENAILS	(2) 16d TOENAILS	SYN	0
BW5	16"	SP2 W/ (6) 10d NAILS	SP1 W/ (6) 10d NAILS	SYN	439
BW6	16"	SP4 W/ (6) 10d X 1 1/2" NAILS	SP4 W/ (6) 10d X 1 1/2" NAILS	SYN	665
BW7	12"	(2) 16d TOENAILS	(2) 16d TOENAILS	SPF	0
BW8	12"	SP2 W/ (6) 10d NAILS	SP1 W/ (6) 10d NAILS	SPF	535
BW9	12"	SP4 W/ (6) 10d X 1 1/2" NAILS	SP4 W/ (6) 10d X 1 1/2" NAILS	SPF	760
BW10	12"	(2) 16d TOENAILS	(2) 16d TOENAILS	SYN	0
BW11	12"	SP2 W/ (6) 10d NAILS	SP1 W/ (6) 10d NAILS	SYN	585
BW12	12"	SP4 W/ (6) 10d X 1 1/2" NAILS	SP4 W/ (6) 10d X 1 1/2" NAILS	SYN	885

NOTE: 2 X 4 WALLS ARE ASSUMED U.N.O. ON FLOOR PLANS

* ALL LUMBER TO BE GRADE #2
** CONNECTIONS TO BE INSTALLED TO EACH STUD AS INDICATED
*** SPFS & SPSS CAN BE SUB. FOR SPFS W/ RESPECT TO STUD SIZE

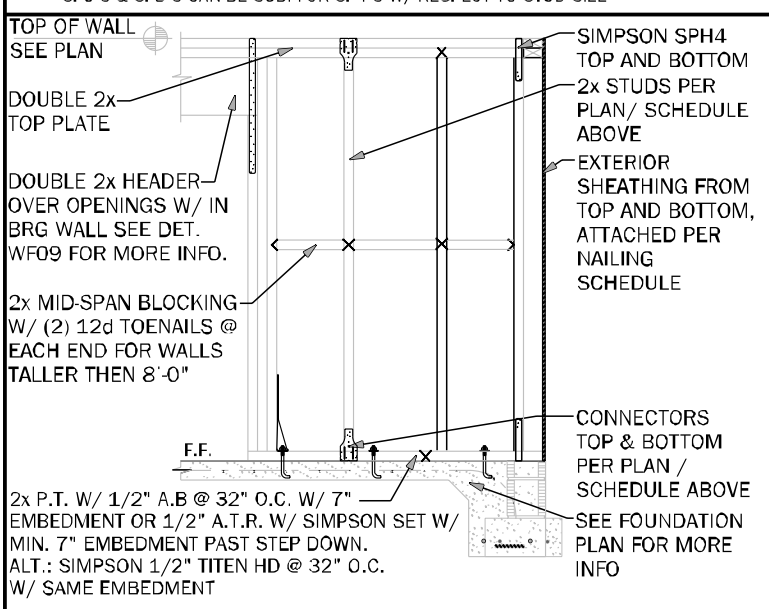

- ### GENERAL NOTES
- SEE FLOOR PLAN FOR WALL SIZE. ASSUME 2x4 STUDS USED U.N.O.
 - ALL STRUCTURAL LUMBER TO BE SYP #1 OR SPF #2 U.N.O. ON PLAN.
 - CONNECTIONS TO BE INSTALLED TO EACH STUD AS INDICATED.
 - CONTACT E.O.R. IF SPS 4 OR SPS 5 OR SPS 6 CONNECTIONS ARE SUBSTITUTED, TO VERIFY THEY MEET THE STRUCTURAL REQUIREMENTS.
 - IF "BIV" IS INDICATED ON SECOND FLOOR BASE CONNECTION TO IGNORED. SEE W905/S3 OR INDICATED DETAIL FOR PROPER CONNECTIONS FOR 2nd FLOOR TO FIRST FLOOR CONNECTIONS. (NOTE: THIS IS FOR 2 STORY PROJECTS ONLY).
 - IF "SW" IS INDICATED THE WALL IS CONSIDERED A SHEARWALL AND REQUIRES MIN. 1/4" OSB PLYWOOD W/ 5d NAILS AT 1" O.C. IN FIELD AND EDGE TO (1) SIDE OF WALL.
 - ALL 2x EXTERIOR WALLS W/ EXTERIOR SHEATHING ATTACHED PER NAILING SCHEDULE ACT AS SHEARWALLS. SEE PLAN AND WALLS SECTIONS FOR STUD SPACING AND GRADE.
 - IF THE BEARING WALL IS INDICATED WITH THE EXCL. B.W. B.W.T. B.W.D. THESE WALLS ARE ONLY SUPPORTING THE FLOOR LOAD AND DO NOT HAVE UPLIFT. THE STUDS ARE TOE NAILS TO THE PLATE AND THE 2x PLATE CAN BE ATTACHED WITH HARD CAGED NAILS (GUN NAILS) AND WILL NOT REQUIRE THE ANCHOR BOLT ATTACHMENT INDICATED IN THE BEARING WALL SCHEDULE.

MARK	COLUMN SIZE	(BASE) CONN. & FASTENER	UPLIFT(LB)
C1	(3) 2 x 4 #2 SPF	(4) - 16d TOENAILS	0
C2	(3) 2 x 4 #2 SPF	DT122 W/ 1/2" WEDGE ANCHOR & (8) 1/4" X 1 1/2" SDS SCREWS	2145
C3	(3) 2 x 4 SYP #1 OR-	(4) - 16d TOENAILS	0
C4	(2) 2 x 4 SPF #2	DT122 W/ 1/2" WEDGE ANCHOR & (8) 1/4" X 1 1/2" SDS SCREWS	2145
C5	4 x 4 P.T. #2 SYP POST	ABU44 W/ 5/8" ATR** & (12) - 16d NAILS	G = 6665 U = 2200
C6	6 x 6 P.T. #2 SYP POST	ABU66 W/ 5/8" ATR** & (12) - 16d NAILS	G = 12000 U = 2300
C7	8 x 8 P.T. #2 SYP POST	ABU88 W/ (2) - 5/8" ATR** & (18) - 16d NAILS	G = 24335 U = 2320
C8	3.5 x 3.5 P.L. 1.8E Rb-2400 PSI (W/OUNNED) (F EXT.)	HOU5-SDS2.5 W/ (14) 1/4" x 2 1/2" SDS WS & 5/8" EPOXY ANCHOR, OR ATR**	5645
C9	3.5 x 3.5 P.L. 1.8E Rb-2400 PSI (W/OUNNED) (F EXT.)	HOU5-SDS2.5 W/ (14) 1/4" x 2 1/2" SDS WS & 5/8" EPOXY ANCHOR, OR ATR**	5645
C10	3.5 x 7 P.L. 1.8E Rb-2400 PSI (W/OUNNED) (F EXT.)	HOU8-SDS2.5 W/ (20) 1/4" x 2 1/2" SDS WS & 7/8" EPOXY ANCHOR, OR ATR**	6970
C11	5.25 x 5.25 P.L. 1.8E Rb-2400 PSI (W/OUNNED) (F EXT.)	HOU8-SDS2.5 W/ (20) 1/4" x 2 1/2" SDS WS & 7/8" EPOXY ANCHOR, OR ATR**	7870
C12	7 x 7 P.L. 1.8E Rb-2400 PSI (W/OUNNED) (F EXT.)	HOU8-SDS2.5 W/ (20) 1/4" x 2 1/2" SDS WS & 7/8" EPOXY ANCHOR, OR ATR**	7870
C13	5.25" x 7" P.L. 1.8E Rb-2400 PSI (W/OUNNED) (F EXT.)	HOU8-SDS2.5 W/ 7/8" ATR AND (20) 1/4" x 1/2" SDS WOOD SCREWS	7870

GENERAL COLUMN NOTES				
1. SEE FLOOR PLAN FOR WALL WIDTH. STUD PICKS TO MATCH WALL WIDTH UNO.				
2. ALL STRUCTURAL LUMBER TO BE SYP #1 OR SPF #2 UNO ON PLAN.				
3. NAIL BUILT UP STUDS PER DETAIL WFS7				
4. MINIMUM BOLT EMBEDMENT:				
5. EMBEDMENT FOR 1/2" ATR				
6. EMBEDMENT FOR 5/8" ATR				
7. EMBEDMENT FOR 7/8" ATR				
8. IF (C) COLUMN IS INDICATED ON SECOND FLOOR, THE BASE CONNECTION IS NOT REQUIRED. (SEE INDICATED CALL OUT ON PLAN FOR ATTACHMENT)				
9. SEE WOOD CONSTRUCTION NOTE #4 ON COVER SHEET FOR CORROSION INFORMATION.				
10. SAME NOMINAL SIZE PARALLEL COLUMNS (L&G) MAY BE SUBSTITUTED FOR ANY P.T. SYP POST NOTED IN THE PLANS				
COMMON NAIL vs. PNEUMATIC GUN NAILS:				
COMMON NAIL	DIA. / LENGTH	PNEUMATIC GUN NAIL	COMMON vs. GUN	APPLICATION
8d	0.131" X 2 1/2"	0.131" X 2 1/2"	SEE PLAN	SPACING
10d OR 12d	0.148" X 3"	0.131" X 3"	SEE PLAN	ROOF
12d	0.148" X 3 1/4"	0.131" X 3 1/4"	SEE PLAN	SHANK UNO PLAN
12d	0.148" X 3 1/4"	0.131" X 3 1/4"	8" - 6" (COMMON) 8" - 6" (GUN NAIL)	BLUOCKING & TIE WALLS & TOP PLATE
10d	0.148" X 3"	0.131" X 3"	8" - 6" (COMMON) 8" - 6" (GUN NAIL)	STUD WALL
16d	0.162" X 3 1/2"	0.131" X 3 1/2"	12" - 6" (COMMON) 12" - 6" (GUN NAIL)	STUD PICK
			2) 16S (COMMON) 2) 16S (GUN NAIL)	SEE PLAN

HEADER SCHEDULE		
MARK	HEADER SIZE	REMARKS
H1	(2) - 2X6 #2 SYP W/ 1/2" FLITCH PLATE	SEE GENERAL HEADER NOTE #5 THIS SHEET
H2	(2) - 2X8 #2 SYP W/ 1/2" FLITCH PLATE	SEE GENERAL HEADER NOTE #5 THIS SHEET
H3	(2) - 2X10 #2 SYP W/ 1/2" FLITCH PLATE	SEE GENERAL HEADER NOTE #5 THIS SHEET
H4	(2) - 2X12 #2 SYP W/ 1/2" FLITCH PLATE	SEE GENERAL HEADER NOTE #5 THIS SHEET
H5	(2) - 1 3/4" X 11 1/4" LVL 2.0E Fb-2600 PSI	ATTACH TOGETHER W/ (2) ROWS 14" X 3 1/2" SDS WOOD SCREWS @ 16" O.C. TYP. EACH SIDE
H6	(2) - 1 3/4" X 9 1/4" LVL 2.0E Fb-2600 PSI	ATTACH TOGETHER W/ (3) ROWS 14" X 3 1/2" SDS WOOD SCREWS @ 16" O.C. TYP. EACH SIDE
HEADER SUPPORT NO. OF JACKS & STUDS REQ. AT OPENINGS		
OPENING SIZE	2x4 WALL	2x6 OR 2x8 WALL
1'-0" - 3'-11"	(1)	(2)
4'-0" - 9'-11"	(2)	(3)
10'-0" - 16'-0"	(3)	(4)



GENERAL HEADER NOTES

- VERIFY W/ PLAN CORRECT LENGTH OF HEADER REQUIRED
- IF HEADER IS ON THE 1st FLOOR SEE PLAN FOR BEARING WALL TYPE AND FOLLOW INSTRUCTIONS WITHIN BEARING WALL SCHEDULE FOR REQUIRED CORRECTIONS U.N.O. ON PLAN
- IF HEADER IS ON THE 2nd FLOOR SEE PLAN FOR INDICATED HEADER CONNECTION FOR REQUIRED CONNECTIONS
- ALL HEADER JACK AND KING STUDS SHALL BE FASTENED TO EACH PER DETAIL WFS7
- FASTEN ALL MULTIPLE HEADERS TOGETHER W/ (2) ROWS 12d COMMON NAILS AT 12" o.c. ALONG EACH EDGE OR (3) ROWS IF 2X10 OR LARGER.
- FASTEN ALL HEADERS TO KING STUDS WITH (3) 12d TOENAILS PER SIDE
- IF HEADER IS NOT SPECIFIED CONTACT E.O.R.

MARK	BEAM SIZE	CONNECTIONS
BM1	(2) - 2 x 8 #2 SYP W/ 7/16" OSB FLITCH PLATE. NAIL BEAM TOGETHER USING (2) ROWS OF 12d NAILS @ 12" O.C. TYP. EACH SIDE	CONNECTION: PROVIDE (2) SIMPSON LSTA24 OR (2) SIMPSON HTS20 TO WOOD POST OR (2) SIMPSON HETA16 TO CMU COL. U.N.O. ON ROOF PLAN.
BM2	(2) - 2 x 10 #2 SYP W/ 7/16" OSB FLITCH PLATE. NAIL BEAM TOGETHER USING (2) ROWS OF 12d NAILS @ 12" O.C. TYP. EACH SIDE	CONNECTION: PROVIDE (2) SIMPSON LSTA24 OR (2) SIMPSON HTS20 TO WOOD POST OR (2) SIMPSON HETA16 TO CMU COL. U.N.O. ON ROOF PLAN.
BM3	(2) - 2 x 12 #2 SYP W/ 7/16" OSB FLITCH PLATE. NAIL BEAM TOGETHER USING (2) ROWS OF 12d NAILS @ 12" O.C. TYP. EACH SIDE	CONNECTION: PROVIDE (2) SIMPSON LSTA24 OR (2) SIMPSON HTS20 TO WOOD POST OR (2) SIMPSON HETA16 TO CMU COL. U.N.O. ON ROOF PLAN.
BM4	(2) - 1 3/4" x 11 1/4" LVL 2.0E Fb-2600 PSI. NAIL BEAM TOGETHER USING (2) ROWS 1/4" x 3 1/2" SDS WOOD SCREWS @ 16" O.C. TYP. EACH SIDE	CONNECTION: PROVIDE (2) SIMPSON LSTA24 OR (2) SIMPSON HTS20 TO WOOD POST OR (2) SIMPSON HETA16 TO CMU COL. U.N.O. ON ROOF PLAN.
BM5	(2) - 1 3/4" x 11 7/8" LVL 2.0E Fb-2600 PSI. NAIL BEAM TOGETHER USING (2) ROWS 1/4" x 3 1/2" SDS WOOD SCREWS @ 16" O.C. TYP. EACH SIDE	CONNECTION: PROVIDE (2) SIMPSON LSTA24 OR (2) SIMPSON HTS20 TO WOOD POST OR (2) SIMPSON HETA16 TO CMU COL. U.N.O. ON ROOF PLAN.
BM6	(2) - 1 3/4" x 9 1/4" LVL 2.0E Fb-2600 PSI. NAIL BEAM TOGETHER USING (2) ROWS 1/4" x 3 1/2" SDS WOOD SCREWS @ 16" O.C. TYP. EACH SIDE	CONNECTION: PROVIDE (2) SIMPSON LSTA24 OR (2) SIMPSON HTS20 TO WOOD POST OR (2) SIMPSON HETA16 TO CMU COL. U.N.O. ON ROOF PLAN.

GENERAL BEAM NOTES

- VERIFY WITH PLAN CORRECT LENGTH OF BEAMS REQUIRED (MIN. 4" BEARING EACH END)
- SEE PLAN FOR TOP OR BOTTOM OF BEAM INDICATIONS
- BEAMS ARE NOT TO BE DRILLED OR NOTCHED IN ANY WAY WITHOUT WRITTEN APPROVAL FROM THE E.O.R.

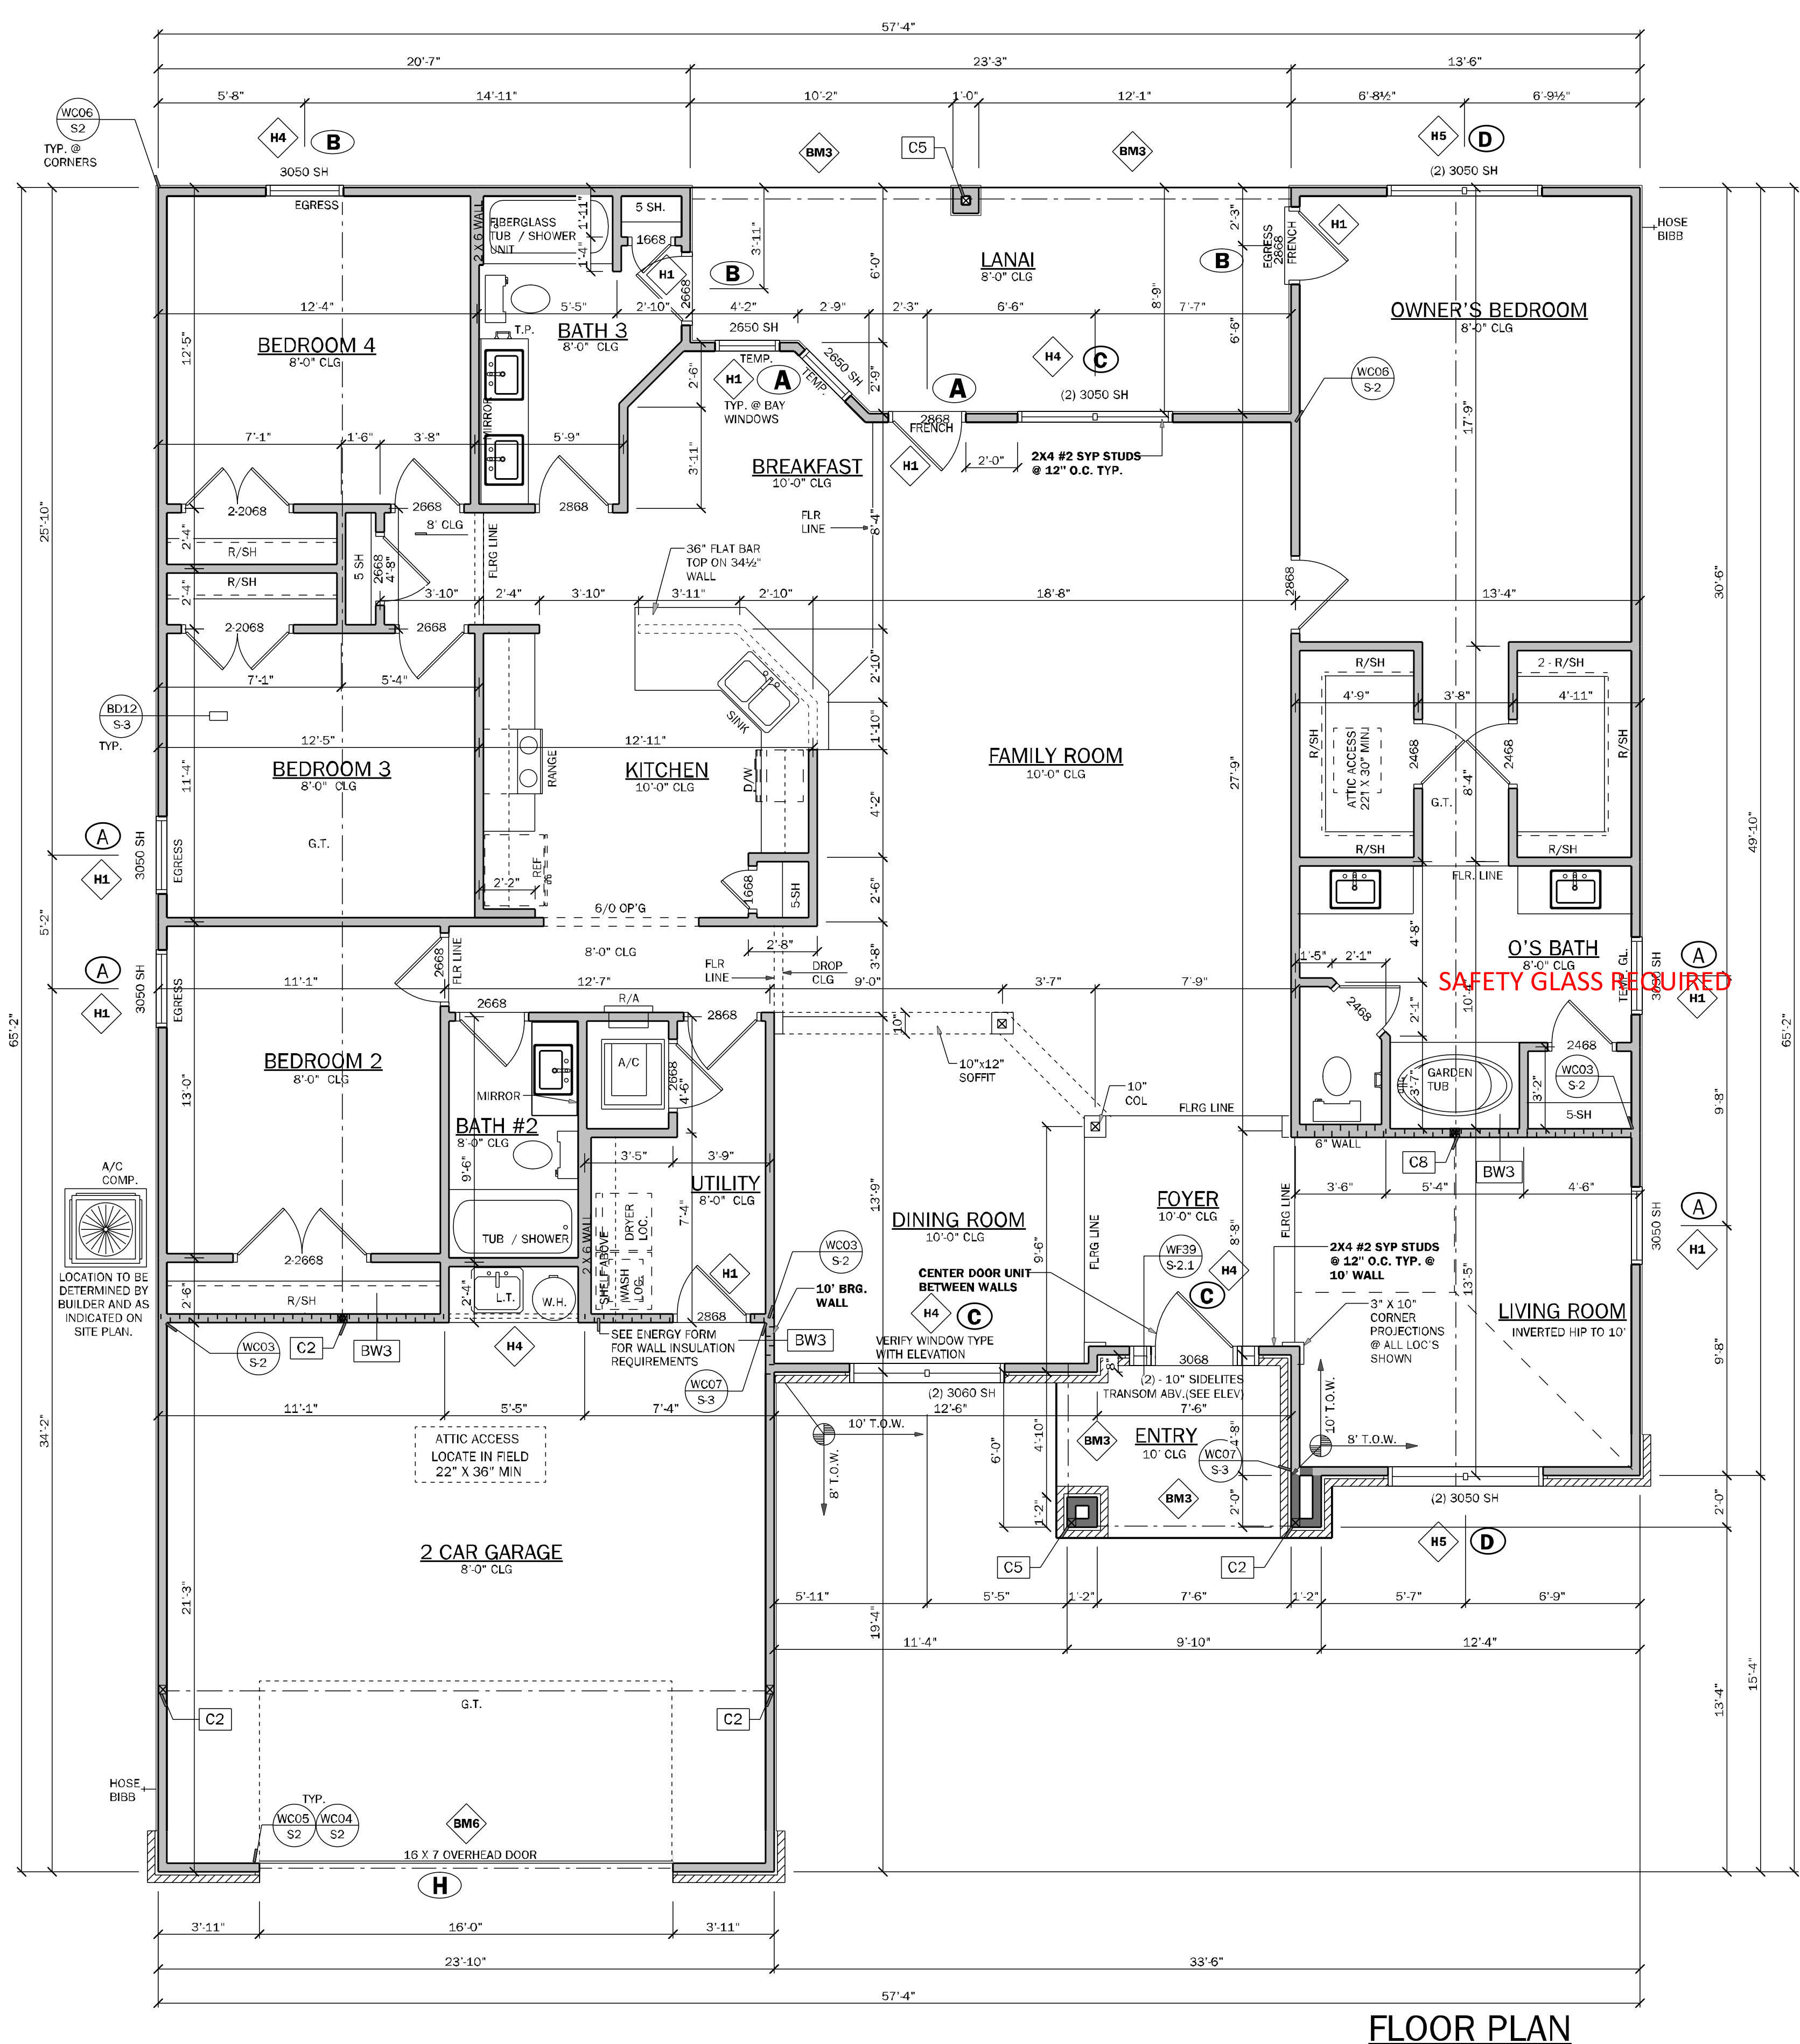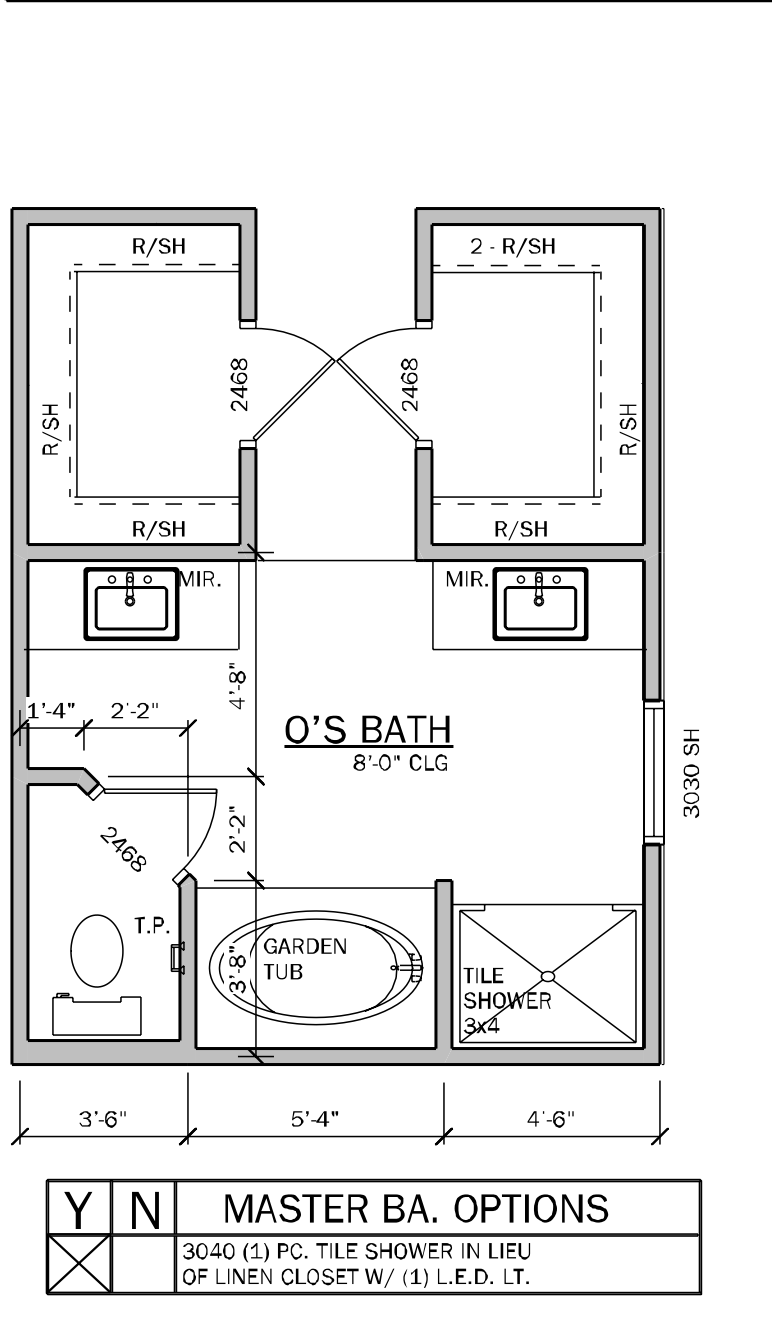

FLOOR PLAN
SCALE: 1/4" = 1'-0"
ELEVATION "A" & "B"

NOTE:
○ INDICATES OPENINGS WIND PRESSURES. SEE WIND LOADING CRITERIA ON COVER SHEET FOR INFORMATION.

- ### WALL LEGEND
- FRAMED WALL
 - BEARING FRAME WALL
 - FRAMED WALL W/ BRICK VENEER
 - FRAMED WALL W/ SIDING OR STUCCO

- ### GENERAL NOTES
- R302.6 (table 302.6) If water based ceiling texture material is used, Provide 1/2" gypsum board for 16" O.C. Framing, or 5/8" gypsum board for 24" O.C. Framing. Note 1/2" sag-resistant gypsum board may be used I.L.O. 5/8" gypsum board. 5/8" type "X" gypsum board must be installed on garage ceiling beneath habitable room(s).
 - R302.5.2 Duct Penetration. Ducts in the garage and ducts penetrating the walls or ceilings separating the dwelling from the garage shall be constructed of a minimum 1/8" thick noncombustible steel, 1 inch minimum rigid noncombustible collar or collar, 1 inch board, or other approved material and shall not have openings into the garage.
 - R302.5.1 Door from garage into house must be a minimum 1 3/8" solid wood door, solid or honeycomb core steel door, or 20 Minute fire rated door.
 - R302.7 Enclosed space under stairs that is accessed by a door or access panel shall have walls, under-stair surface and any soffits protected on the enclosed side with 1/2" gypsum board.
 - Outdoor swimming pools shall be provided with a barrier complying with R4501.17.1.1 through R4501.17.1.14.
 - Bathroom exhaust fans must vent to the exterior of the building. Exhaust to attic space and soffits is not acceptable. Ventilation shall be permitted to exit through the soffit if solid soffit is installed 5'-0" on each side of the venting.
 - R302.6 The garage shall be separated from the residence and its attic as required by Table R302.6. From the residence and attics by not less than 1/2-inch (12.7mm) gypsum board applied to the garage side. Garage beneath rooms shall be separated from all habitable rooms above by not less than 5/8 inch (15.9mm) type X gypsum board or equivalent. Where the separation is a floor-ceiling assembly, the structure supporting the separation shall also protect by not less than 1/2 inch (12.7mm) gypsum board or equivalent.
 - R312.2.1 Window sills. In dwelling units, where the bottom of the clear opening of an operable window opening is located less than 72 inches (910 mm) above the finished floor and greater than 72 inches (1829 mm) above the finished grade or other surface below or the exterior of the building, the operable window shall comply with one of the following:
 - Operable windows with openings that will not allow a 4-inch diameter (102 mm) sphere to pass through the opening where the opening is in its largest opened position.
 - Operable windows that are provided with window fall prevention devices that comply with ASTM F2090.
 - Operable windows that are provided with window opening control devices that comply with Section R312.2.2.
 - R308.4.2 All windows within 2'-0" of doors and in shower or tub areas will be safety tempered glass.
 - E.C. R402.2.4 Vertical or horizontal access doors from conditioned spaces to unconditioned spaces such as attics and crawl spaces shall be weatherstripped and insulated to a level equivalent to the insulation on the surrounding surfaces.
 - M1502.4.5 Duct length. The maximum allowable exhaust duct length shall be determined by one of the methods specified in sections M1502.4.5.1 through M1502.4.5.3.
 - M1502.4.5.1 Duct termination. Exhaust ducts shall terminate on the outside of the building. Exhaust duct terminations shall be in accordance with the dryer manufacturer's installation instructions. If the manufacturer's instructions do not specify a termination location, the exhaust duct shall terminate not less than 3 feet (914 mm) in any direction from openings into buildings, including openings in ventilated soffits. Exhaust duct terminations shall be equipped with a backdraft damper. Screens shall not be installed at the duct termination.
 - Porch Ceilings. (See plan for the following options)
 - Option 1. Gypsum: 1/2" exterior gypsum soffit board shall be attached to all framing members with 2x blocking provided at perimeter and panel edges. The gypsum board shall be attached w/ Type "W" 1x4" drywall screws at 8" O.C. in field and edges.
 - Option 2. Plywood Base: 7/16" OSB on underside of roof trusses shall be attached to all framing members with 2x blocking provided at perimeter and panel edges. The OSB shall be attached w/ 8d nails at 6" O.C. field and 4" O.C. at edges or 7d screw shank 3" O.C. field and 4" edges.
 - Energy Code Compliance Path is Performance Based Path. Code cycle is FBC 2023 8th Edition.

- * ALL INTERIOR AND EXTERIOR WALL FRAMING, INCLUDING FURRING STRIPS ON CMU WALLS, TO BE SPACED AND 16" O.C. (U.N.O.)

AREA CALCULATIONS	
1st FLOOR	2508 S.F.
TOTAL LIVING (AC)	2508 S.F.
GARAGE	543 S.F.
COVERED ENTRY	60 S.F.
COVERED PATIO/LANAI	193 S.F.
TOTAL AREA UNDER ROOF	3304 S.F.

COUNTY SEAL

Thursday, September 26, 2024

FDS ENGINEERS ASSOCIATES

www.fdseng.com

ARCHITECTURE DESIGN PLANNING

2200 W. Main St., Suite 200
Gainesville, TX 77301
737.233.2333
goveesee.com

AA2003115

AD BD

Keese Associates

FLORIDA CONTRACTORS LICENSE NO. CRC1330146

100 WEST GARDEN STREET
PENSACOLA FL 32502

DIVISION LOCATION:
GAINESVILLE

Job Information:

INVENTORY

LOT: 92
BLK:
SEC:
SUB:



 






 





Model Name / Number:
2508

Plan Issue Date:
Thursday, September 26, 2024

KA PROJECT NUMBER:
24-12151

Sheet: 2 Of:


FLOOR PLAN

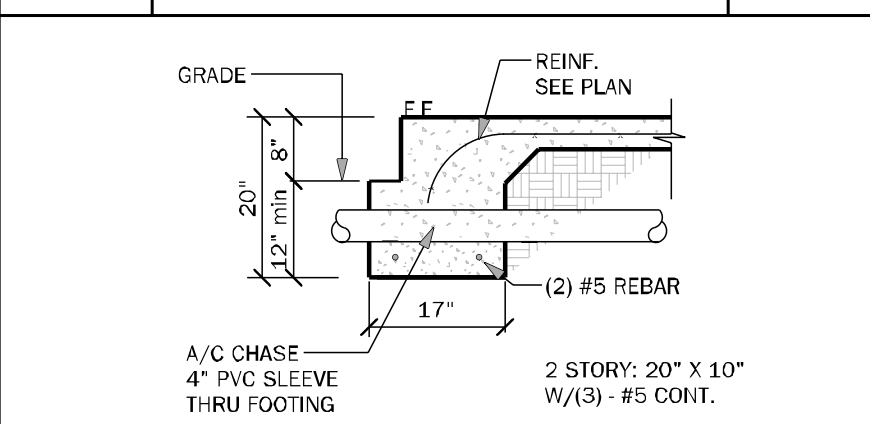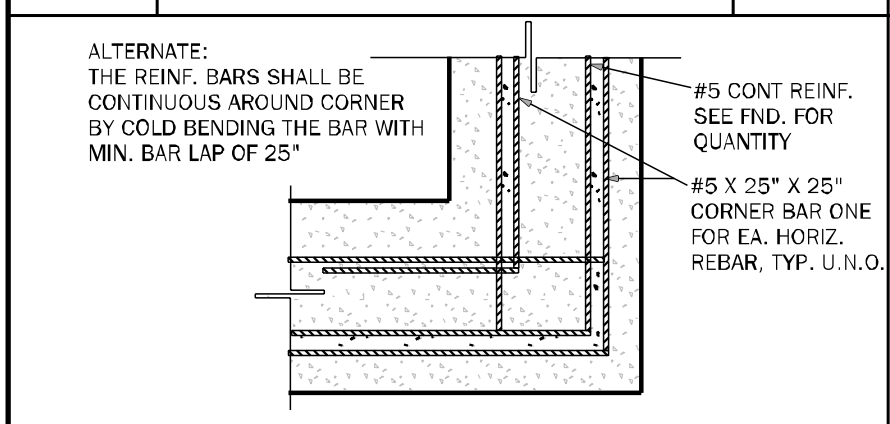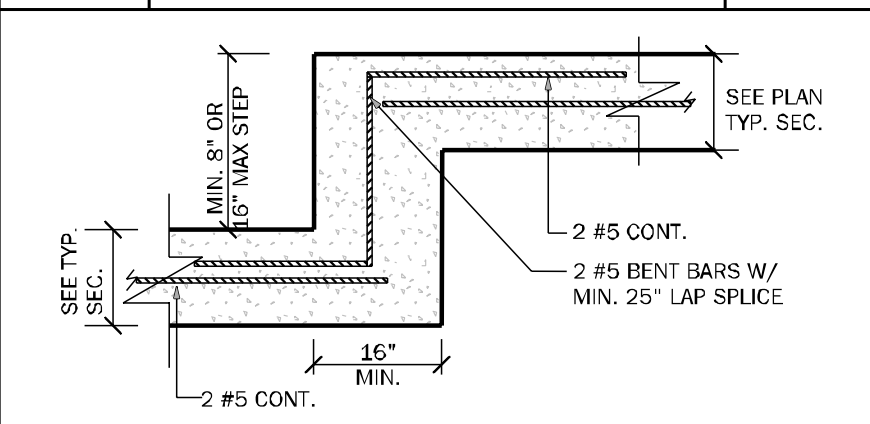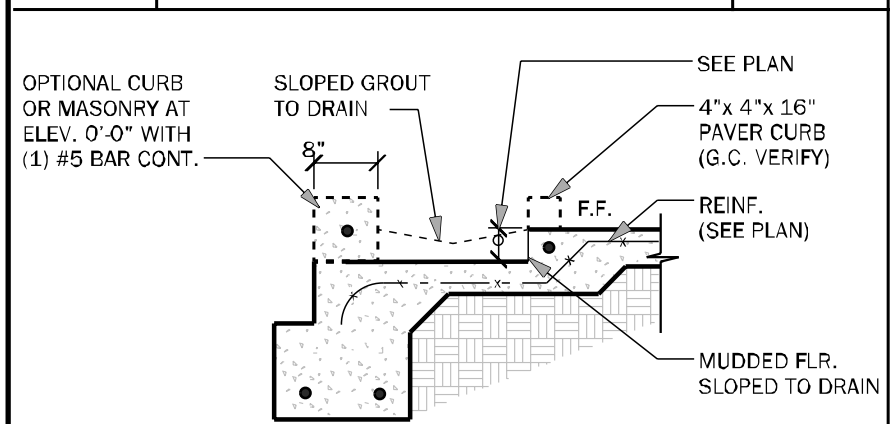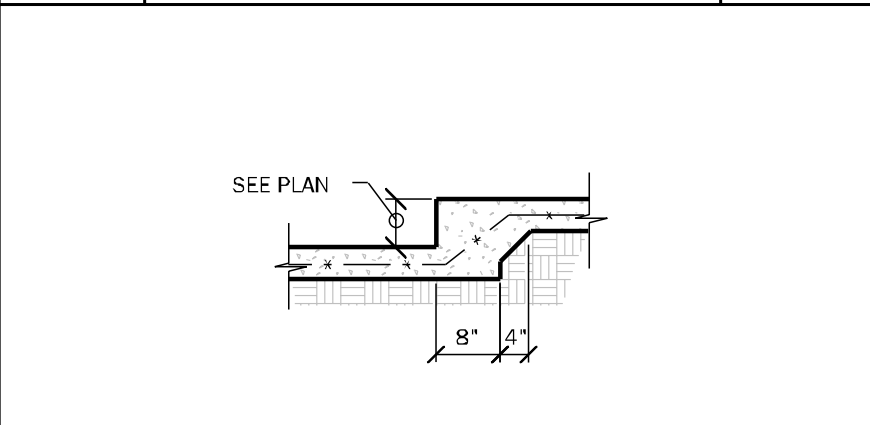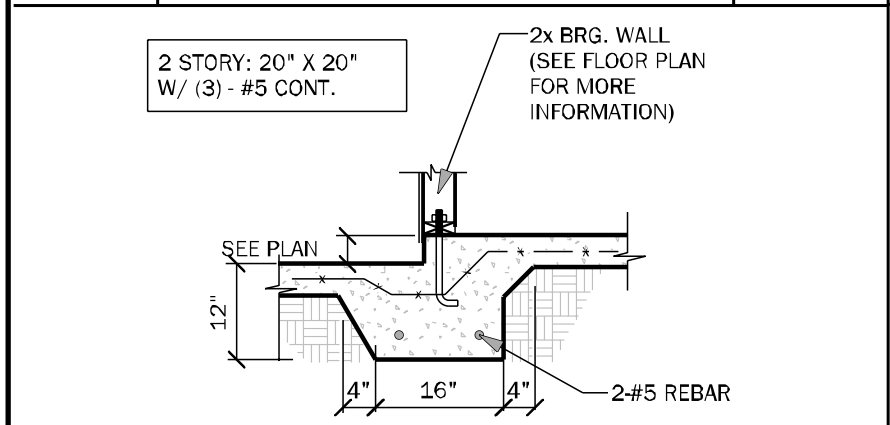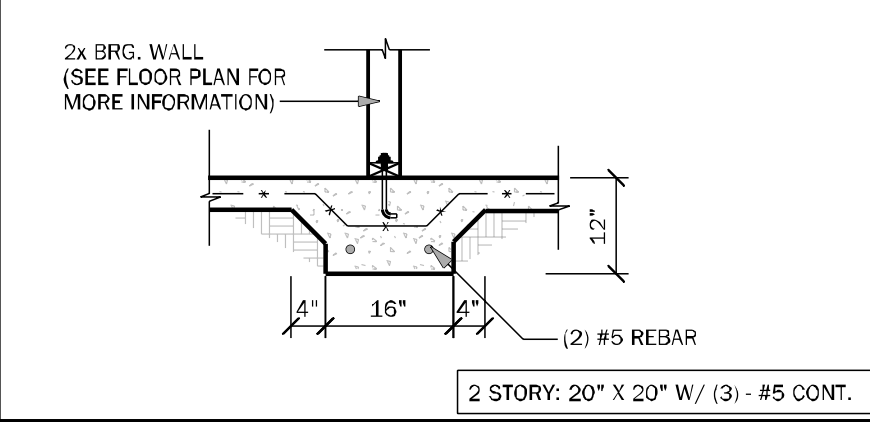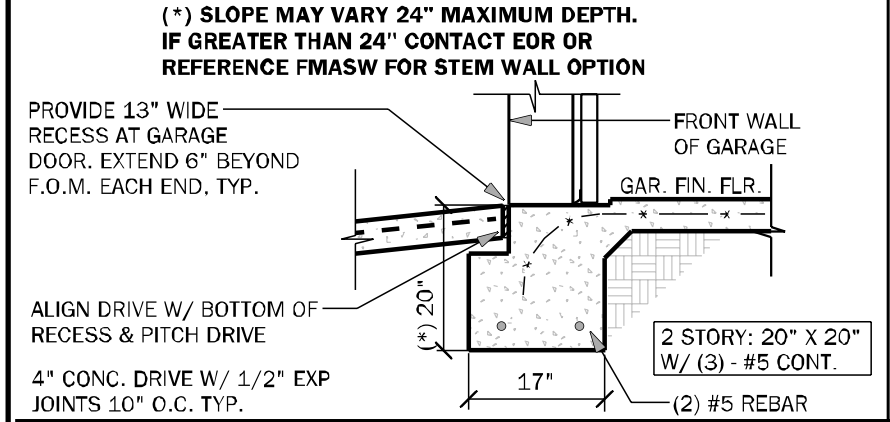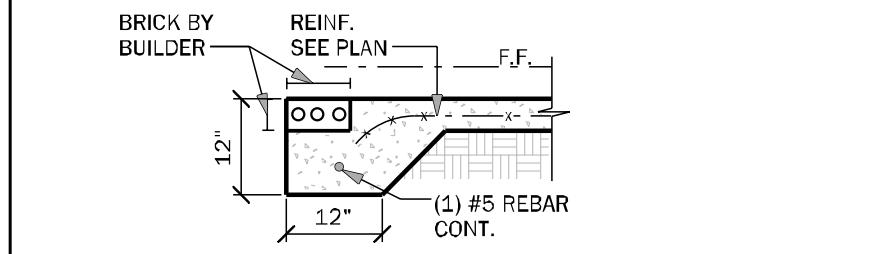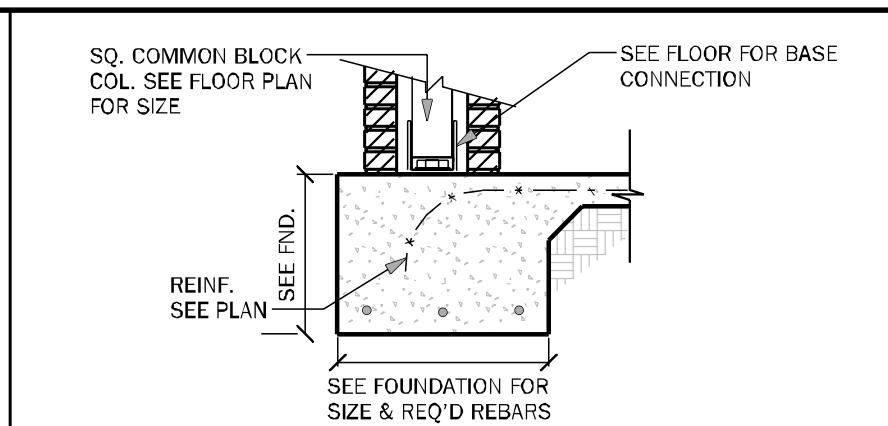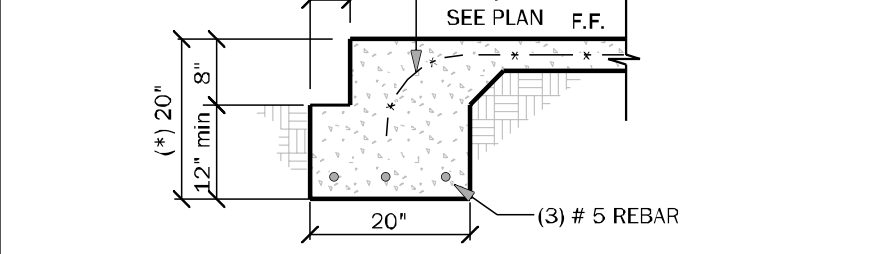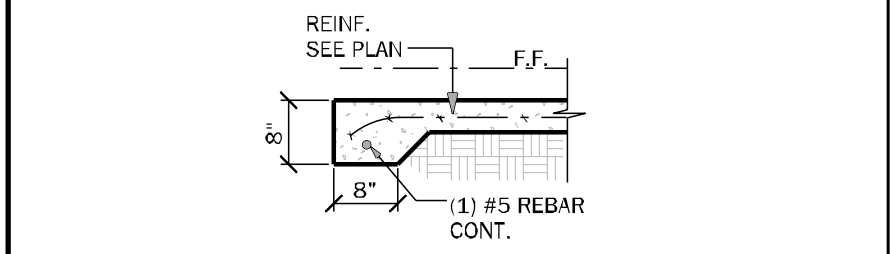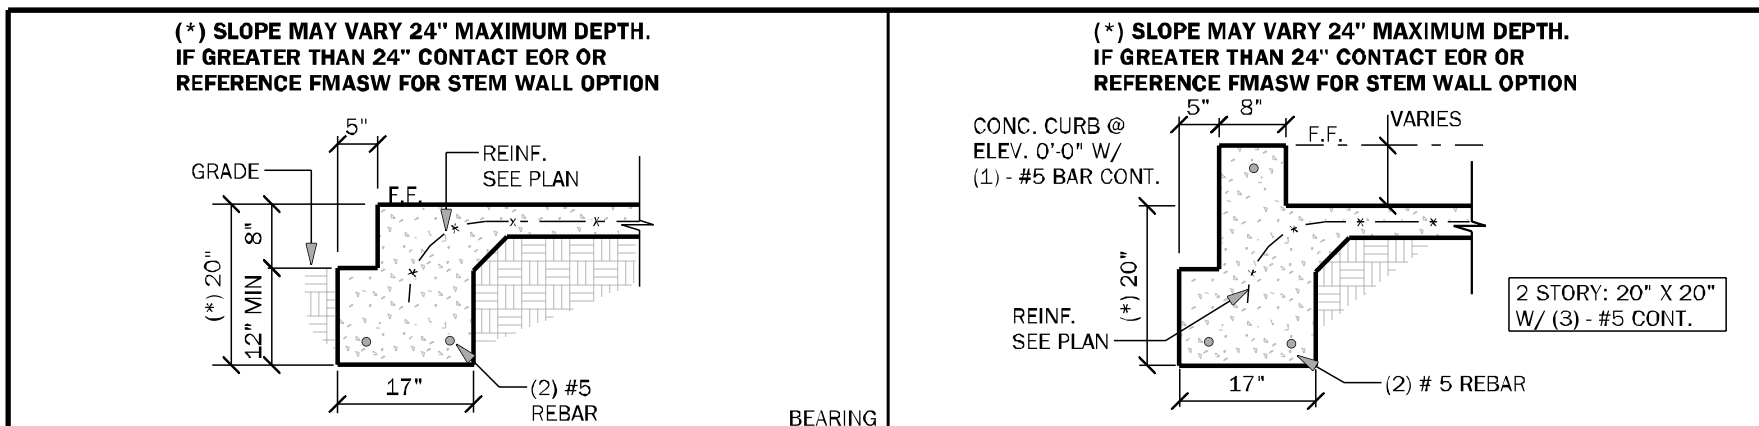

STEMWALL SCHEDULE							
STEMWALL HEIGHT (H)	FOOTING DIMENSION				NUMBER/SIZE OF BARS	LAT.	MAXIMUM F.C. SPACING (O.C.) IN STEM WALL
	d 1 STORY	d 2 STORY	b 1 STORY	b 2 STORY			
0'-0"-2'-0"	8"	10"	16"	20"	W/ (2) #5 BARS	<67#4	6'-8"
>2'-0"-3'-4"	10"	10"	20"	24"	W/ (3) #5 BARS	67#4	5'-4"
>3'-4"-4'-0"	12"	12"	20"	32"	W/ (4) #5 BARS	84#5	4'-0"
>4'-0"-5'-4"	16"	16"	48"	48"	W/ (5) #5 BARS CONT. & #5 @ 18" O.C. TRANSV.	1162#8	2'-8"

NOTES:

1. VERTICAL REINF. IN SOLID GROUTED CELLS AT ALL CORNERS, JAMS, WALL INTERSECTIONS, BELOW GIRDER TRUSS LOCATIONS, AND AT THE MAXIMUM SPACING STATED IN SCHEDULE.
2. W.W.M. IS REQUIRED TO MAKE ADEQUATE CONNECTION BETWEEN SLAB AND WALL. WHEN STEM WALL EXCEEDS 4'-0" FIBERMESH CAN NOT BE USED AND #4 TURN BARS ARE REQUIRED @ EACH FILLED CELL LOCATION. EACH BAR TO TIE INTO VERTICAL BAR AND EXTEND OUT A MIN. 4'-0" INTO SLAB/ STEM.
3. IF STEM IS REQUIRED TO BE HIGHER CONTACT ENGINEER OF RECORD PRIOR TO CONSTRUCTION FOR MORE INFORMATION.
4. G.C. TO PROVIDE ADEQUATE BRACING OF STEM WALL WHEN UNEVEN BACK FILLING IS TAKING PLACE.
5. #5 HORIZONTAL CORNER BARS WITH 4'-0" LEGS IN KNOCKOUT BLOCK @ 16" O.C. VERTICAL, GROUTED SOLID WHEN STEM WALL IS GREATER THAN 4'-0" TALL (TYPICAL ALL CORNERS).
6. IF STEIN WALL IS WITH 5'-0" OF POOL OR WATER FEATURE FOUNDATIONS TO BE A MINIMUM 12" BELOW BOTTOM OF POOL, OR WATER FEATURE.
7. ALL STEM WALLS GREATER THAN (4) COURSES SHALL BE FULLY GROUTED.
8. R.403.1.4 MINIMUM DEPTH: ALL EXTERIOR FOOTINGS (BOTTOM) SHALL BE PLACED AT LEAST 12" BELOW THE UNDISTURBED GROUND SURFACE.
-
- SEE CHART ABOVE
STEM WALL F.C.
SPACING
- SEE CHART ABOVE
STEM WALL F.C.
SPACING
- (1) #5 CONT. TIED
TO EACH VERT.
REINF. BAR
- #4 TURN BAR AT STEM
WALLS GREATER THAN 4'-0"
- IF USED: W.W.M. TO BE
TIED TO #5 CONT. REBAR
- COMPACTED CLEAN
FILL
- SEE SCHEDULE
FOR REINF.
- EXTERIOR SHORING BY CONTRACTOR
AS REQ'D WHEN STEM WALL IS
OVER 4'-0"
- MIN. 8"
COVER
REQ'D
- 3" COVER TYP.
- FINISH GRADE
- h'
- b
- d
- F.F.

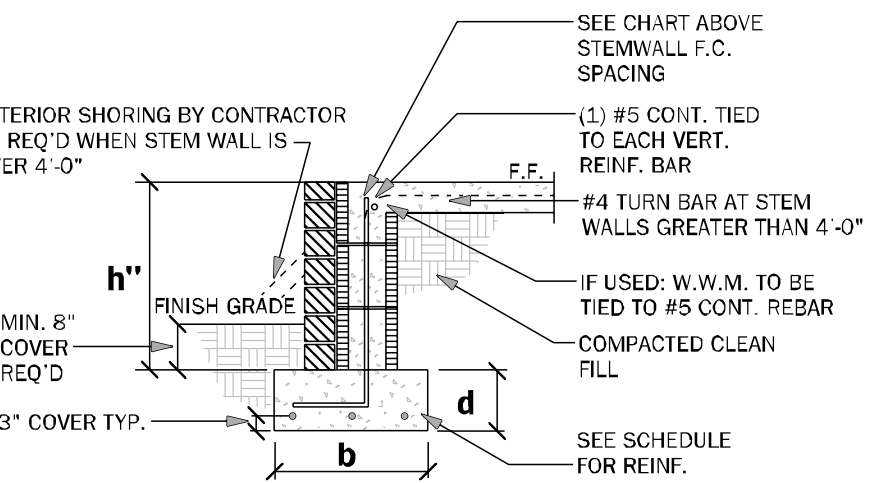

GENERAL FOUNDATION NOTES (U.N.O.)


- 1 PROVIDE MIN. 6 MIL. APPROVED VAPOR BARRIER. ALL JOINTS TO BE LAPPED MIN. 6" AND SEALED.
- 2 4" 2500 PSI CONC. SLAB W/ #6X1 W/ 4 x 1 w/ 4 OR FIBERMESH /FIBERMIX ADDED TO THE CONCRETE. IN ACCORDANCE W/ MANUF.'S INSTRUCTIONS AND NER-284 FOR FIBERMESH OR NER-454 FOR "FIBERMIX OVER 10% SILICATE/VOL VAPOR BARRIER". GC SHALL PROVIDE APPROVED SILL OR BORATE TREATMENT.
- 3 ■ INDICATES FILLED CELL W/ 3000 PSI CONC. FROM FIR. TO ■■ REBAR W/ (1) #5 REBAR TYPICAL ABOVE SLAB. MOORED FTG. DOWELS 17" EMBEDDMENT W/ 30° EXT. ABOVE SLAB.
- 4 CONSULT W/ MANUF. SPECIFICATIONS PRIOR TO POURING OR RECESSING DOOR SILLS OR SLIDING GLASS DOOR SILLS.
- 5 EXTERIOR SLABS SHALL SLOPE MIN. 2% OR 1/4" PER FOOT AWAY FROM HOUSE U.O.N. ON PLAN.
- 6 CONTROL JOINTS (IF SHOWN) ARE NOT REQUIRED BY CODE BUT ARE SUGGESTED (ESPECIALLY WHEN USING FIBER REINF. CONCRETE OR IN EXTERIOR CONDITIONS). CONTROL JOINTS TO BE 1/8" SAW CUT A DEPTH OF 1/4" OF THE THICKNESS OF THE SLAB AND SPACED MAX. 10' APART. FILL CUT W/ APPROVED JOINT MATERIAL OR USE ALTERNATE APPROVED METHOD.
- 7 NO WOOD STAKES PERMITTED IN FOUNDATION.
- 8 PENDING SITE CONDITIONS, FOUNDATION MAY HAVE TO BE STEPPED DOWN. G.C. TO DETERMINE STEP LOCATIONS IF REQUIRED.
- 9 R403.1.4 MINIMUM DEPTH. EXTERIOR FOOTINGS SHALL BE PLACED NOT LESS THAN 12 INCHES BELOW THE FINISHED GRADE OF GROUND SURFACE WHERE APPLICABLE. THE DEPTH OF FOOTINGS SHALL ALSO CONFORM TO SECTION R403.1.4.1.
- 10 MASON TO COORDINATE WITH BUILDER ANY ELECTRICAL REQUIREMENT THROUGH SLAB
- 11 PROVIDE 4" STEPDOWN TO SIDEWALK FROM ENTRY
- 12 ASSUMED ALLOWABLE SOIL BEARING PRESSURE AFTER COMPACTION: 2000 PSF SEE SOILS REPORT AND SPECIFICATIONS FOR COMPACTION EQUIVALENTS IF SOIL CONDITIONS IN THE PROJECT DO NOT MEET OR EXCEED THE CAPACITY THE GENERAL CONTRACTOR SHALL NOTIFY THE ENGINEER PRIOR TO FOUNDATION POUR FOR VERIFICATION OF FOUNDATION DESIGN. SOIL TO BE COMPACTED TO AT LEAST 95% OF MAX. REL. HUMIDITY AS DETERMINED BY ASTM - 1557 (MODIFIED PROCTOR). THE FOUNDATION DESIGN INDICATED ON THE FOUNDATION PLAN HAS BEEN DESIGNED FOR A MINIMUM SOIL BEARING CAPACITY OF 2000 PSF.

FOOTING SCHEDULE	
------------------	--

MARK	SIZE	DEPTH	REINFORCING	GRAVITY CAP. [lbs]
F1.0	1'-0" X CONT.	1'-0"	2 #5 E.W. BOT.	2000
F2.0	2'-0" X 2'-0"	1'-0"	3 #5 E.W. BOT.	7200
F2.5	2'-6" X 2'-6"	1'-0"	3 #5 E.W. BOT.	11000
F3.0	3'-0" X 3'-0"	1'-0"	4 #5 E.W. BOT.	15600
F3.5	3'-6" X 3'-6"	1'-0"	4 #5 E.W. BOT.	21500
F4.0	4'-0" X 4'-0"	1'-0"	5 #5 E.W. BOT.	28000
F4.5	4'-6" X 4'-6"	1'-4"	5 #5 E.W. BOT.	34500
F5.0	5'-0" X 5'-0"	1'-4"	6 #5 E.W. BOT.	42500
F6.0	6'-0" X 6'-0"	1'-4"	7 #5 E.W. BOT.	61500



LEGEND

- | | |
|---|----------------------------------|
|  | - INDICATES SINGLE-STORY FOOTING |
|  | - INDICATES TWO-STORY FOOTING |
|  | - INDICATES PAD FOOTING |

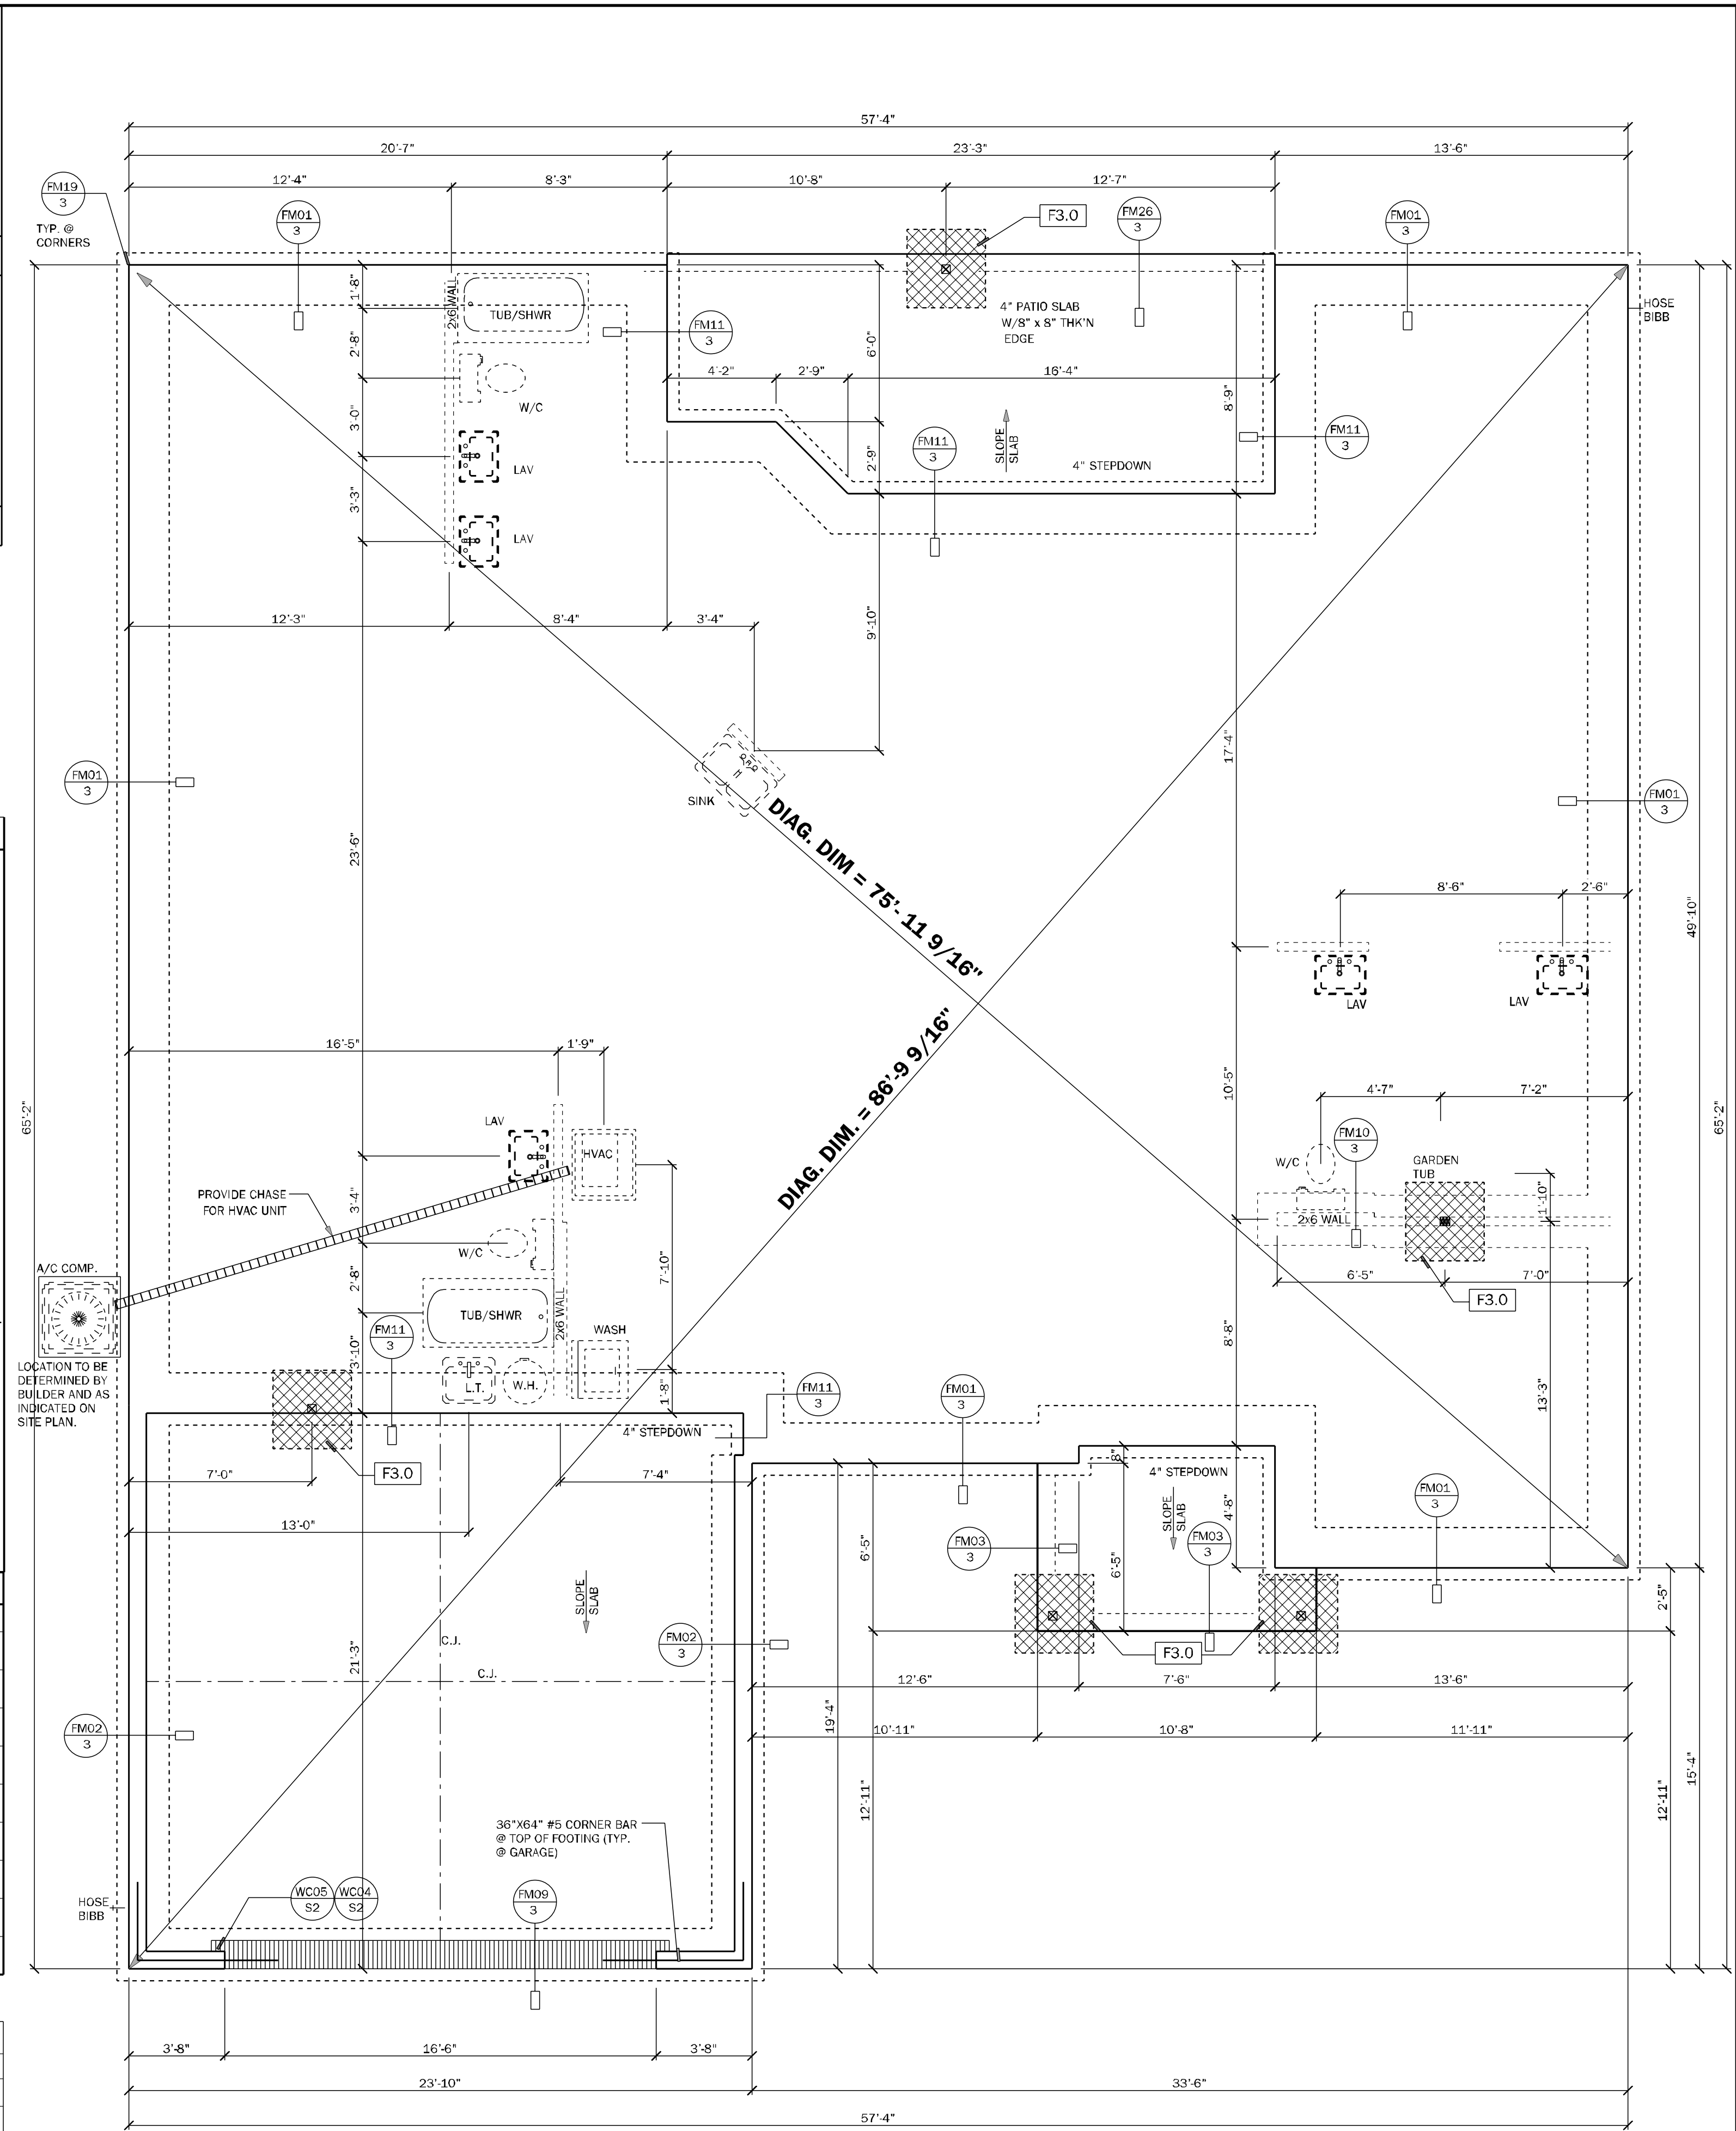

FOUNDATION PLAN
SCALE: 1/4" = 1'-0"
ELEVATION "A" & "B"




LOAD CALCULATIONS	
COOLING GREATER THAN HEATING	
GENERAL LIGHTING & RECEPTACLES	
3 WATTS PER SQUARE FOOT OF LIVING S.F. LIVING = 2,508 X 3 = 7524	
APPLIANCE CIRCUITS	
RANGE	8500
OVEN	NONE
MICRO / HOOD	1000
WATER HEATER	4500
WHIRL POOL	1250
WASHER	1500
DRYER	5000
DISHWASHER	1500
DISPOSAL	600
SMALL APPLIANCE CIRCUITS (3)	4500
BATH FANS (100 WATTS / EACH)	200
GEN LIGHT G & RECEPT. + APP. CIR. = 36,524	
SUBTRACT 100 % OF FIRST 10,000 = 10,000	
A = 26,524	
HVAC CIRCUITS	
A/C (AIR HANDLER & COMP.)	10,000
A/C (AUXILIARY HEAT STRIP)	10,000
B = 20,000	
CIRCUIT CALCULATIONS	
FIRST 10,000 AMPS @ 100%	= 10,000
+ 40% OF "A" = (40 X 26,524)	= 10,610
+ 100% OF "B" = (20,000)	= 20,000
TOTAL WATTAGE	= 40,610
WATTS DIVIDED BY 240 = AMPS	
CALCULATED SERVICE AMPS	= 170

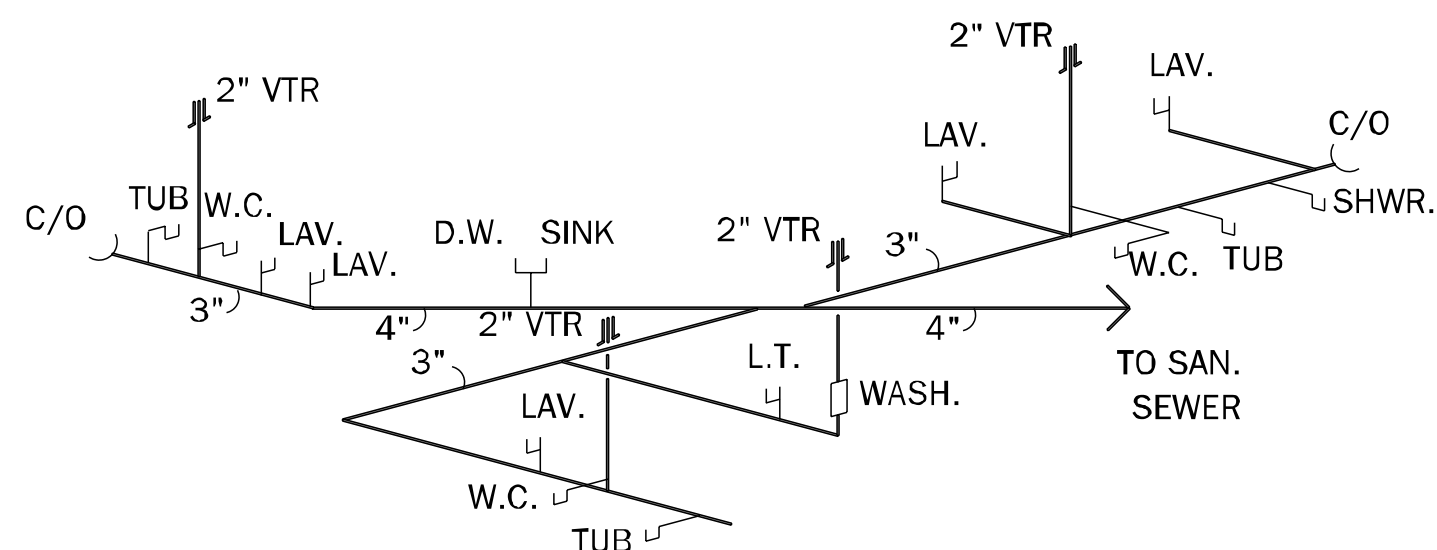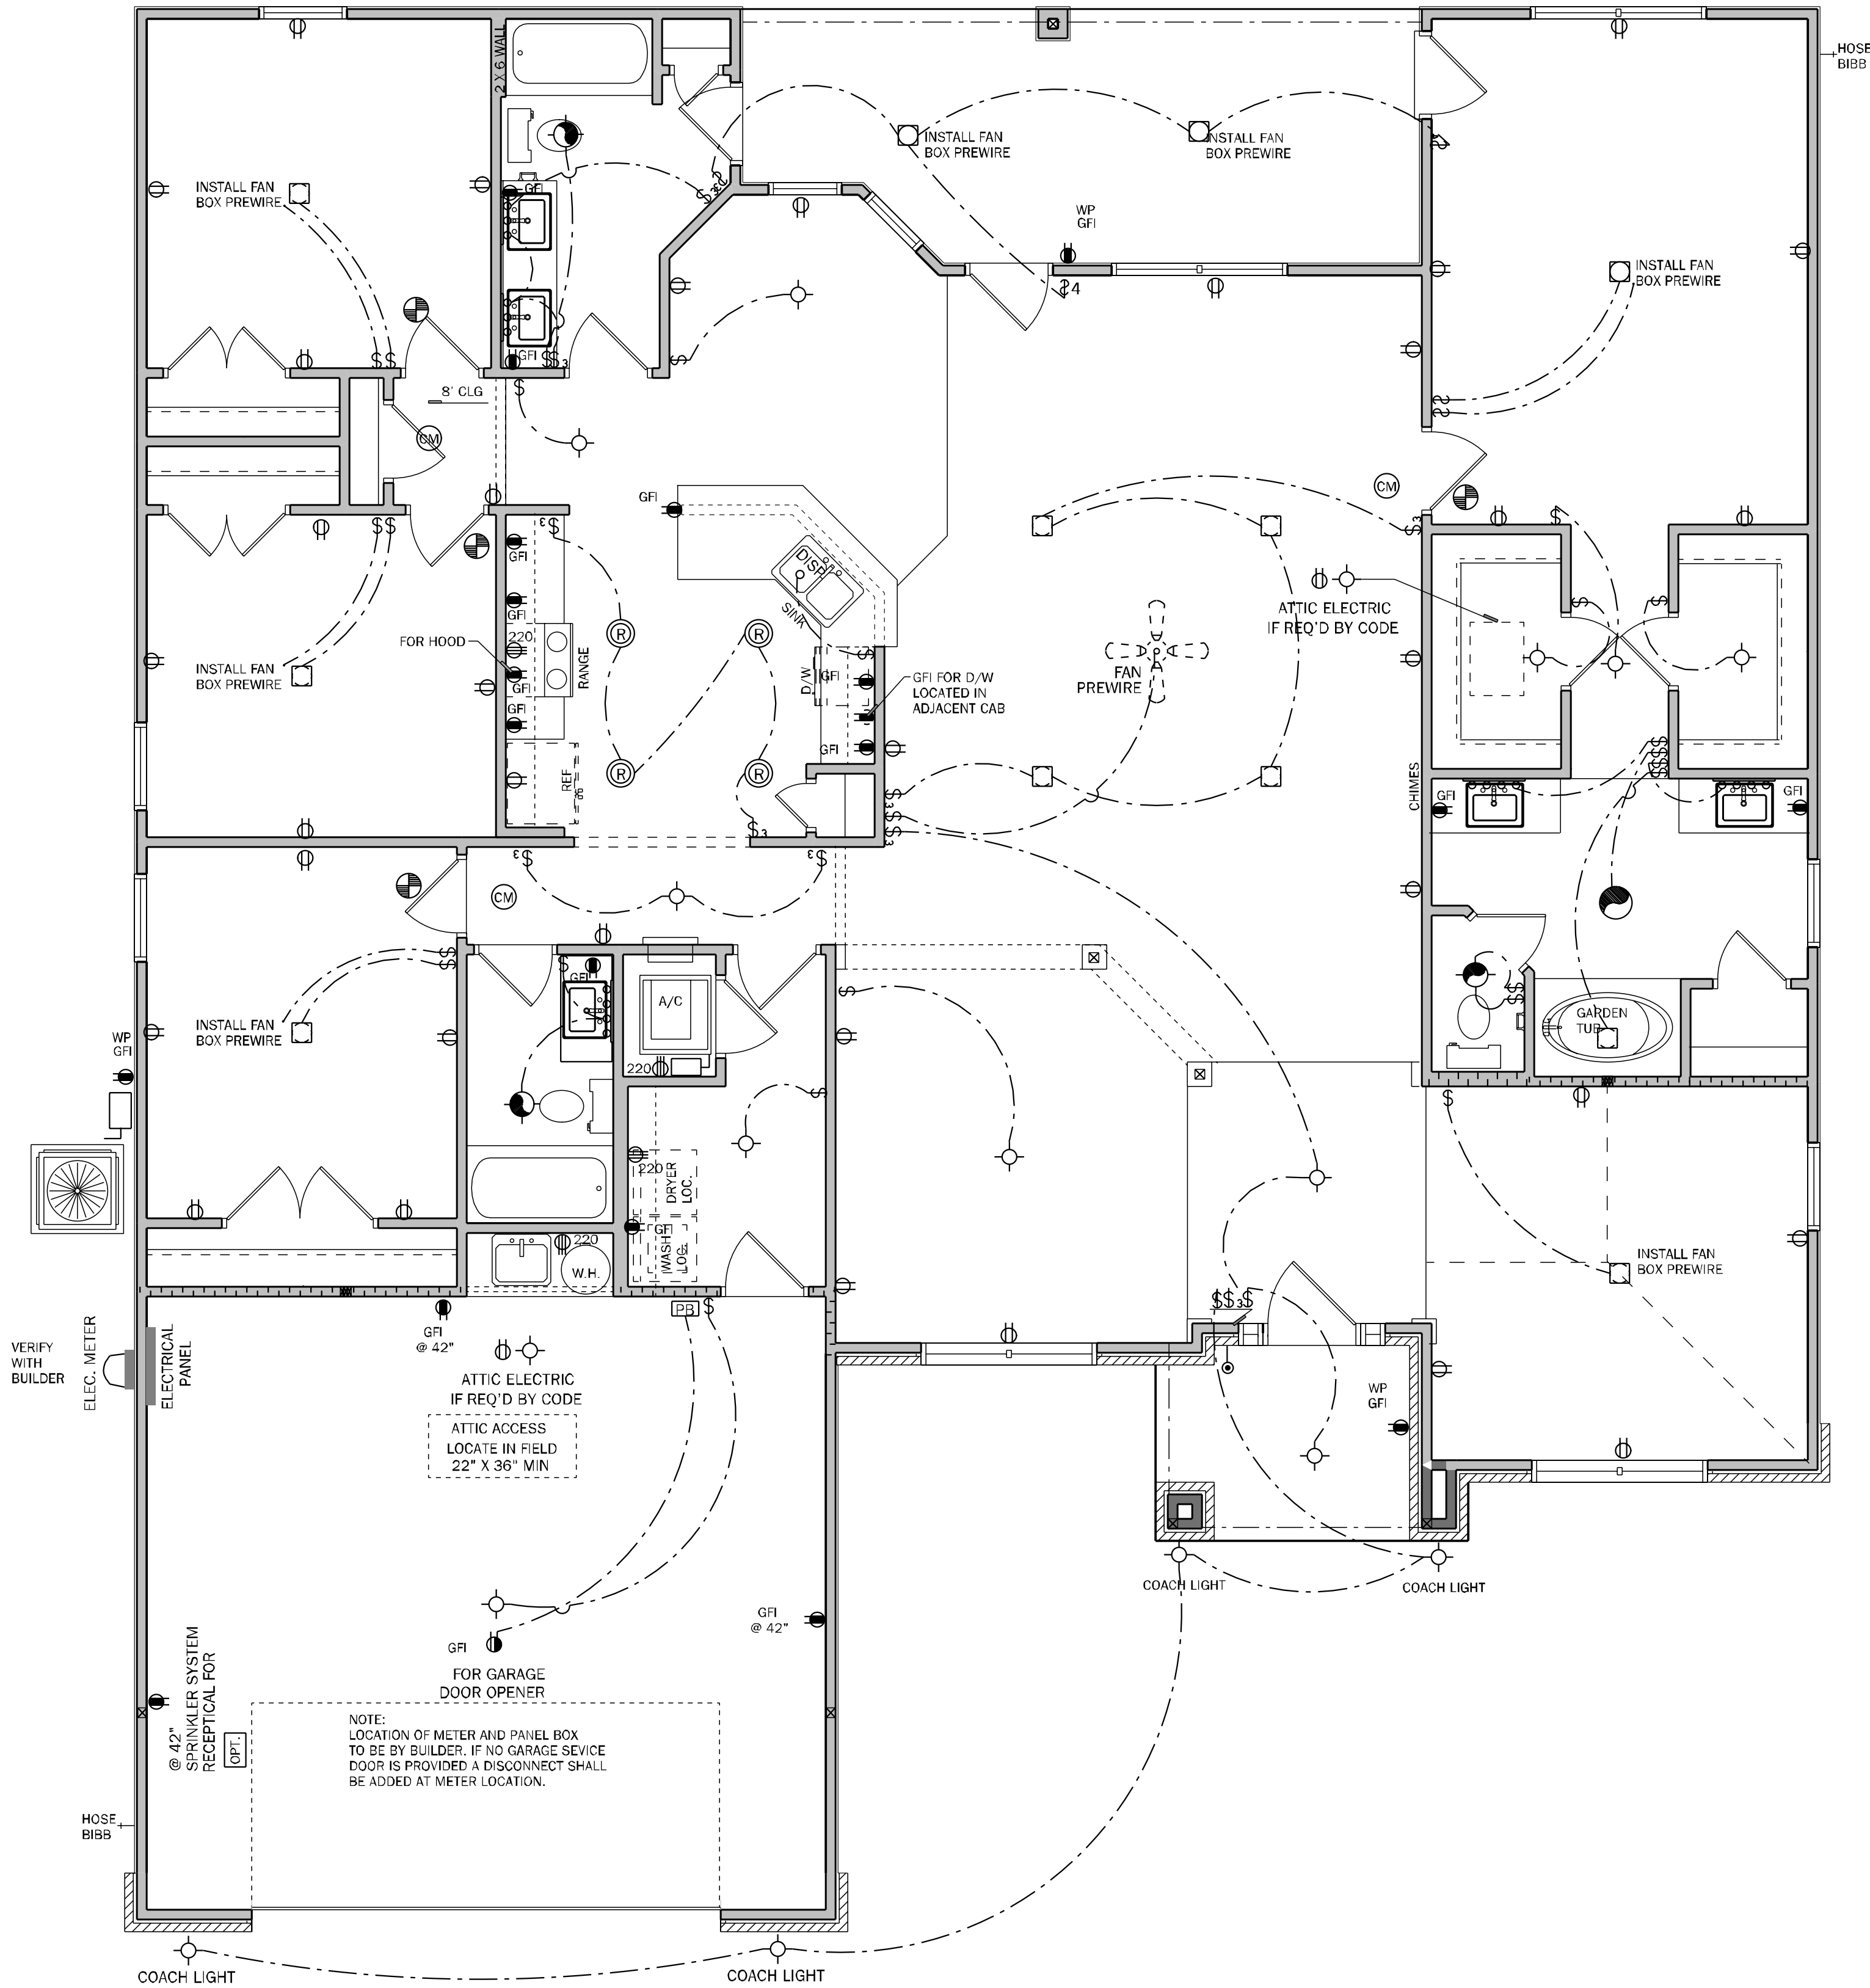


PLUMBING RISER
NTS

ELECTRICAL PLAN
SCALE: 1/4" = 1'-0"

   - ELECTRICAL NOTES:** UNLESS OTHERWISE NOTED.
1. ELECTRICAL OUTLET HEIGHTS AS MEASURED FROM FINISHED FLOOR TO CENTER LINE OF THE BOX TO BE: 16" AFF (GENERAL), IN A FLOOD ZONE, ALL ELECTRICAL EQUIPMENT TO BE AT OR ABOVE DFE.
 2. KITCHEN: 44" AFF
 3. BATHROOM: 39" AFF
 4. LAUNDRY ROOM: 36" AFF
 5. EXTERIOR WATERPROOF: 12" AFF
 6. GARAGE: GENERAL PURPOSE 42" AFF
 7. RANGE: 2" AFF
 8. 2. ALL TRIM PLATES AND DEVICES TO BE GANGED, WHERE POSSIBLE.
 9. ELECTRICAL SWITCHES TO BE AT 42" CENTERLINE ABOVE FINISHED FLOOR.
 10. ELECTRICAL PLAN IS INTENDED FOR BID PURPOSES ONLY. ALL WORK SHALL BE DONE IN STRICT ACCORDANCE WITH THE NATIONAL ELECTRIC CODE (NEC), LATEST EDITION, BY A LICENSED ELECTRICAL CONTRACTOR WHO SHALL BE RESPONSIBLE FOR THE INSTALLATION & SIZING OF ALL ELECTRICAL WIRING & ACCESSORIES.
 11. SMOKE ALARMS SHALL COMPLY WITH NFPA 72 AND SECTION R314 AND SHALL BE LISTED IN ACCORDANCE WITH UL 217 AND UL 2034.
 12. COMBINATION SMOKE AND CARBON MONOXIDE ALARMS SHALL BE LISTED IN ACCORDANCE WITH UL 217 AND UL 2034.
 13. PROVIDE AFCI'S (ARC-FAULT CIRCUIT INTERRUPTERS) COMBINATION TYPE INSTALLED TO PROVIDE PROTECTION OF THE BRANCH CIRCUITS IN ALL DWELLING UNITS PER NFPA 70 (CURRENT EDITION) AND THE NEC AND AS DEFINED IN UL 1699.
 14. PROVIDE TAMPER RESISTANT RECEPTACLES AS REQUIRED BY THE NFPA 70 (CURRENT EDITION).
 15. CARBON MONOXIDE PROTECTION: CARBON MONOXIDE ALARMS OR DETECTORS SHALL BE INSTALLED IN ALL DWELLING UNITS IN ACCORDANCE WITH 240.9.5.1 AND NFPA 70. SUCH DEVICES SHALL BE LISTED BY THE APPROPRIATE STANDARD, EITHER ANSI/UL 2034, STANDARD FOR SINGLE AND MULTIPLE STATION CO ALARMS OR UL 2075, GAS AND VAPOR DETECTOR SENSOR, ACCORDING TO THE INSTALLATION.
 16. R315.1.2 COMBINATION ALARMS: COMBINATION SMOKE/CARBON MONOXIDE ALARMS SHALL BE LISTED AND LABELED BY A NATIONALLY RECOGNIZED TESTING LABORATORY.
 17. KEEP ALL SMOKE DETECTORS MINIMUM OF 36" FROM BATHROOM DOORS.
 18. IN NEW CONSTRUCTION, SMOKE DETECTORS SHALL BE HARDWIRED INTO AN A/C ELECTRICAL POWER SOURCE AND SHALL BE EQUIPPED WITH A MONITORED BATTERY BACKUP.
 19. BATHROOM EXHAUST FANS MUST VENT TO THE EXTERIOR OF THE BUILDING, VENTILATION TO ATTIC SPACE AND SOFFITS IS NOT ACCEPTABLE.
 20. CHAPTER 45 PRIVATE SWIMMING POOLS — OUTDOOR SWIMMING POOLS SHALL BE PROVIDED WITH A BARRIER COMPLYING WITH R4501.17.1.1 THROUGH R4501.17.1.14.
 21. ADD GFCI PROTECTION TO RECEPTACLES IN LAUNDRY ROOMS AND UTILITY ROOMS OF DWELLINGS WHERE INSTALLED WITHIN 6' OF THE OUTSIDE EDGE OF A SINK. THIS WOULD INCLUDE THE RECEPTACLE INSTALLED FOR A WASHING MACHINE. RECEPTACLE OUTLETS SHALL NOT BE REQUIRED ON A WALL DIRECTLY BEHIND A RANGE OR SINK TO FULFILL THE REQUIREMENT OF AN OUTLET EVERY 24". THE WIDTH OF THE SINK OR RANGE IS NOT TO BE INCLUDED IN THE SPACING OF THE OUTLETS UNLESS THE DISTANCE FROM THE SINK OR RANGE IS GREATER THAN 12" FOR STRAIGHT COUNTER TOPS AND 18" FOR SINKS AND RANGES INSTALLED IN CORNER COUNTERS.
 22. WHERE MORE THAN ONE SMOKE ALARM IS REQUIRED TO BE INSTALLED WITHIN AN INDIVIDUAL DWELLING UNIT IN ACCORDANCE WITH SECTION R314.3, THE ALARM DEVICES SHALL BE INTERCONNECTED IN SUCH A MANNER THAT THE ACTIVATION OF ONE ALARM WILL ACTIVATE ALL OF THE ALARMS IN THE INDIVIDUAL DWELLING UNIT. PHYSICAL INTERCONNECTION OF SMOKE ALARMS SHALL NOT BE REQUIRED WHERE LISTED WIRELESS ALARMS ARE INSTALLED AND ALL ALARMS SOUND UPON ACTIVATION OF ONE ALARM.
 23. FOR ONE- AND TWO-FAMILY DWELLING UNITS, ALL SERVICE CONDUCTORS SHALL TERMINATE IN DISCONNECTING MEANS HAVING A SHORT-CIRCUIT CURRENT RATING EQUAL TO OR GREATER THAN THE AVAILABLE FAULT CURRENT, INSTALLED IN A READILY ACCESSIBLE OUTDOOR LOCATION. EACH DISCONNECT SHALL BE ONE OF THE FOLLOWING:
(1) SERVICE DISCONNECTS MARKED AS FOLLOWS:
EMERGENCY DISCONNECT.
SERVICE DISCONNECT.
(2) METER DISCONNECTS INSTALLED PER 230.82(3) AND MARKED AS FOLLOWS:
EMERGENCY DISCONNECT.
METER DISCONNECT.
NOT SERVICE EQUIPMENT.
(3) OTHER LISTED DISCONNECT SWITCHES OR CIRCUIT BREAKERS ON THE SUPPLY SIDE OF EACH SERVICE DISCONNECT THAT ARE SUITABLE FOR USE AS SERVICE EQUIPMENT AND MARKED AS FOLLOWS:
EMERGENCY DISCONNECT.
NOT SERVICE EQUIPMENT.
 24. MARKINGS SHALL COMPLY WITH 110.24(B).
 25. ALL PERMANENTLY INSTALLED LUMINAIRES, EXCLUDING THOSE IN KITCHEN APPLIANCES, SHALL HAVE AN EFFICACY OF AT LEAST 45 LUMENS/PERWATT OR SHALL UTILIZE LAMPS WITH AN EFFICACY OF NOT LESS THAN 65 LUMENS/PERWATT.

ELECTRICAL LEGEND			
\$	SINGLE POLE SWITCH		SMOKE DETECTOR
\$2	DOUBLE POLE SWITCH		CARBON MONOXIDE/ SMOKE DETECTOR
\$3	THREE-WAY SWITCH		COMBO UNIT
\$4	FOUR-WAY SWITCH		FLOOD LIGHT
\$DM	DIMMER SWITCH		FLUORESCENT LIGHTING
	CEILING MOUNTED FIXTURE		TRACK LIGHTING
	SCOUNCE (WALL MOUNTED) FIXTURE		CEILING FAN
	110 VOLT DUPLEX OUTLET		CHIMES
	110 VOLT SPLIT SWITCHED OUTLET		DOOR BELL CHIMES
	GROUND FAULT INTERRUPT		DOOR BELL
	WATER PROOF W/ GROUND FAULT		DISPOSAL
	220 VOLT OUTLET		DISCONNECT SWITCH
	SPECIAL SERVICES OUTLET		PREWIRE SPEAKER
	T.V. CABLE OUTLET		JUNCTION BOX
	TELEPHONE CABLE OUTLET		THERMOSTAT
	RECESSED LIGHTING		LOW VOLTAGE LIGHTING
	WATER PROOF RECESSED LIGHTING		INTERCOM SYSTEM
	BATH FAN		GARAGE DOOR PUSH BUTTON
	BATH FAN W/ LIGHT		
	L.E.D. DISC LIGHT		

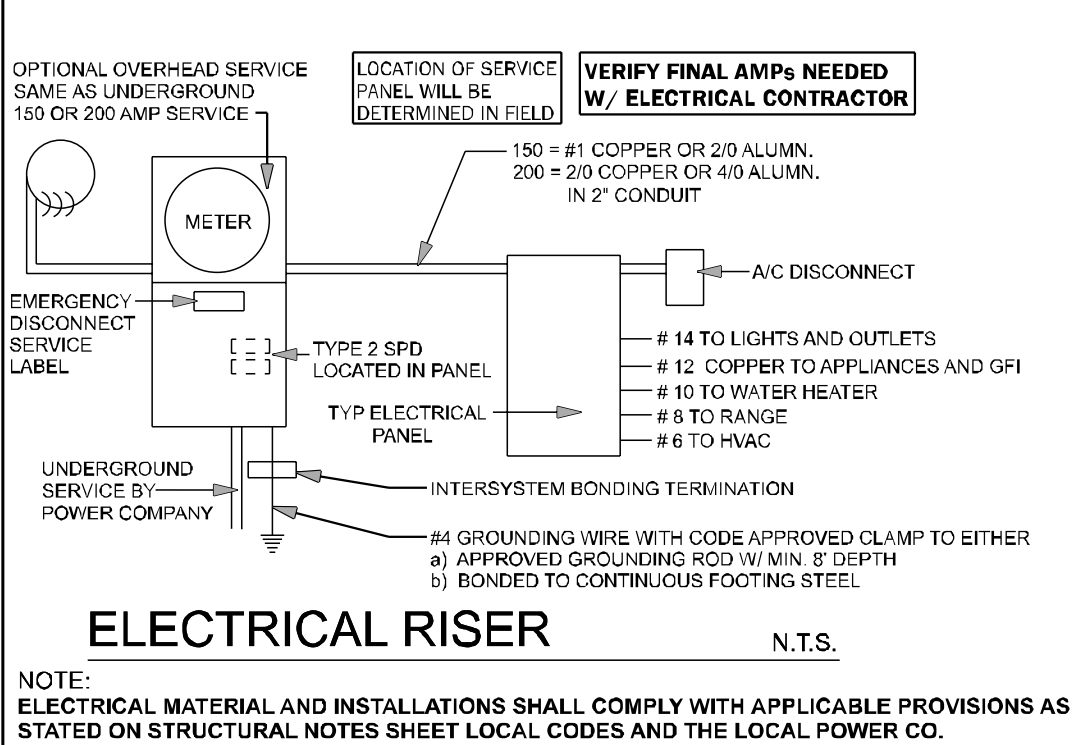

COUNTY SEAL

Thursday, September 26, 2024

ENGINEERS ASSOCIATES
FDS
www.fdseng.com

22407 SEBASTIAN LANE, SUITE 200
DADE COUNTY, FL 33155
TEL: (305) 580-2355
CARL A. BROWN, P.E.
SCOTT A. LEWIS, P.E.
THEN BAO DUONG, P.E.

keesee
associates
ARCHITECTURE | DESIGN | PLANNING
22407 SEBASTIAN LANE, SUITE 200
DADE COUNTY, FL 33155
www.keesee.com

A22003115
AA22003115
f
b
in

DAMS HOMES
FLORIDA CONTRACTORS LICENSE NO. CRC1330148
100 WEST GARDEN STREET
PENSACOLA FL 32502

DIVISION LOCATION:
GAINESVILLE

Job Information:
Model Name / Number:
2508
Plan Issue Date:
Thursday, September 26, 2024
KA PROJECT NUMBER:
24-12151
Sheet: 4 of
ELECTRICAL


INVENTORY
LOT: 92
BLK:
SEC:
SUB: Preserve of Laurel Lake
777 S.W. Rosemary Dr.
Lake City, FL



HIP ROOF > 20 TO 27 DEG.
 $a = \frac{h}{2}$ [4:12] [6:12]

GABLE ROOF > 20 TO 27 DEG.
 $a = \frac{h}{2}$ [4:12] [6:12]

NOTE: 8d NAILS FOR WALL SHEATHING MUST BE MIN. 131" X 2 1/2".
DO NOT OVERDRIVE NAILS. FASTENERS SHALL NOT PENETRATE
SURFACE MORE THAN 1/8"

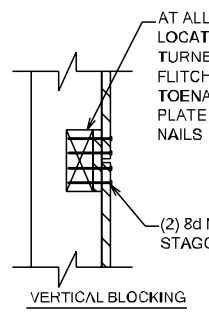

N.T.S.



SCALE: 1/4" = 1'-0"

GENERAL CONNECTOR NOTES:

1. CONNECT ALL FLOOR TRUSSES TO INTERIOR BEARING WOOD WALLS / BEAMS w/ (2) 12d TOENAILS.
2. ALL TRUSSES TO BE CONNECTED AS PER TRUSS MANUFACTURER, U.S.O ON PLAN.
3. G.C. MAY USE EITHER SMIPSON OR USP CONNECTIONS. SEE FRAMING PLAN FOR CONNECTOR CALL OUT.
4. FOR SINGLE PLY TRUSSES, SCAB ON FULL HEIGHT SYP #1 2"x4" TO TRUSS VERTICAL WEB w/ (2) ROWS OF 10d NAILS @ 3" O.C. STAGGERED.
5. 12" MIN A.T.R. EMBEDMENT @ CMU BOND BEAM U.N.O.
6. SCAB TRUSS CHORD w/ 4" O" 2 SYP #2 (MATCH CHORD LUMBER SIZE) w/ (2) ROWS 10d @ 4" FROM END & 4" O.C. STAGGERED. CENTER AT CONNECTOR LOCATION AS MUCH AS POSSIBLE.


ROOF FRAMING NOTES

1. SHINGLE OR METAL ROOFING SYSTEM (SEE ARCH.) SHEATHING - SEE [RSH] SCHEDULE THIS SHEET. FOR SHTG & FASTENERS ON PRE-ENGINEERED WOOD TRUSSES AT 2'-0" O.C. MAX. OF CONVENTIONAL FRAME ROOF (SEE PLAN FOR SIZE AND SPACING. SEE ARCHITECTURAL PLAN FOR TYPICAL ROOF SLOPE AND OTHER INFORMATION).


TILE ROOFING SYSTEM (SEE ARCH.) SEE [RSH] SCHEDULE THIS SHEET

- - - NOTE TO FRAMER - - -


TRUSS LAYOUT SHOWS TRUSS ID'S. THIS LAYOUT HAS BEEN PROVIDED BY THE
 ENGINEER. THE ARCHITECT IS TO USE FOR THE DESIGN OF THIS PROJECT. OTHERWISE
 THE LAYOUT HAS BEEN DETERMINED, BUT PRIOR TO CONSTRUCTION OR TRUSS
 CONSTRUCTION, FINAL TRUSS LAYOUT AND TRUSS SHOP DRAWINGS ARE TO BE SUBMITTED TO
 THE ENGINEER FOR REVIEW (E.O.R.) FOR REVIEW AND APPROVAL. AT THIS TIME THE E.O.R.
 IS THE RIGHT TO REVISE THE PLAN AS REQUIRED PER THE REVIEW OF THE FINAL
 LAYOUT AND TRUSS SHOP DRAWINGS. ADDITIONAL FEES MAY APPLY. STARTING
 CONSTRUCTION OR TRUSS FABRICATION PRIOR TO THIS REVIEW IS NOT ADVISED, AND
 WILL BE AT THE USER'S RISK. COSTS FOR ANY CHANGES TO REVISIONS OF THE PLAN,
 INCLUDING REVISIONS TO THE TRUSS LAYOUT, WILL BE THE USER'S RESPONSIBILITY.
 IF AN ALTERNATE FRAMING IS SHOWN, NO TRUSS APPROVAL IS REQUIRED, UNLESS LAYOUT
 IS NOT W/OUT WRITTEN APPROVAL FROM FDS.

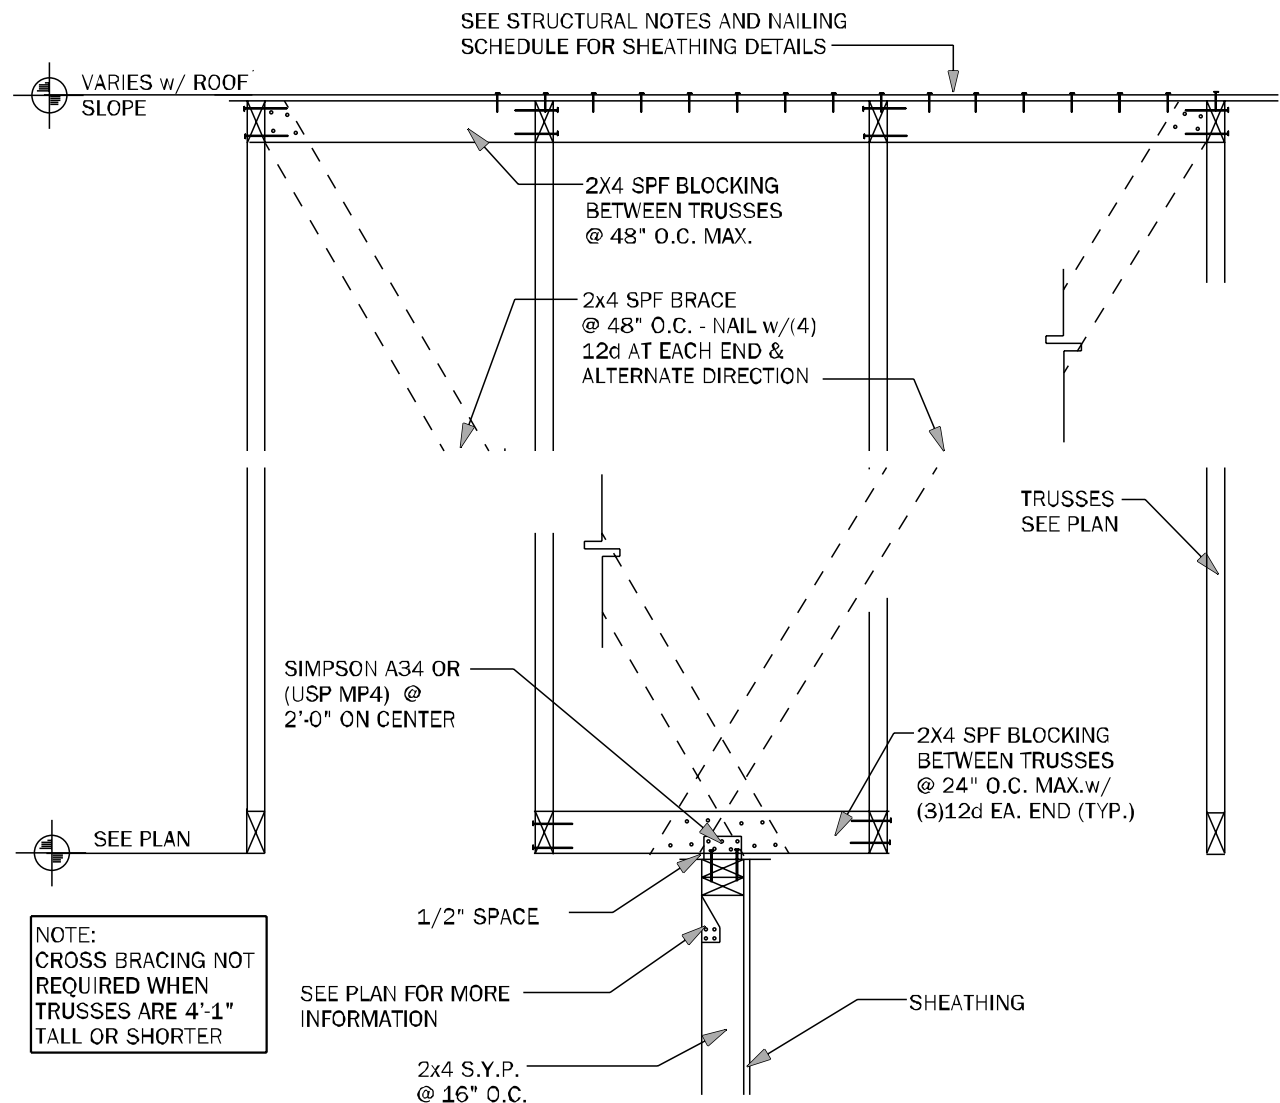


TB15 EXTERIOR NON-BEARING WALL DETAIL N.T.S.

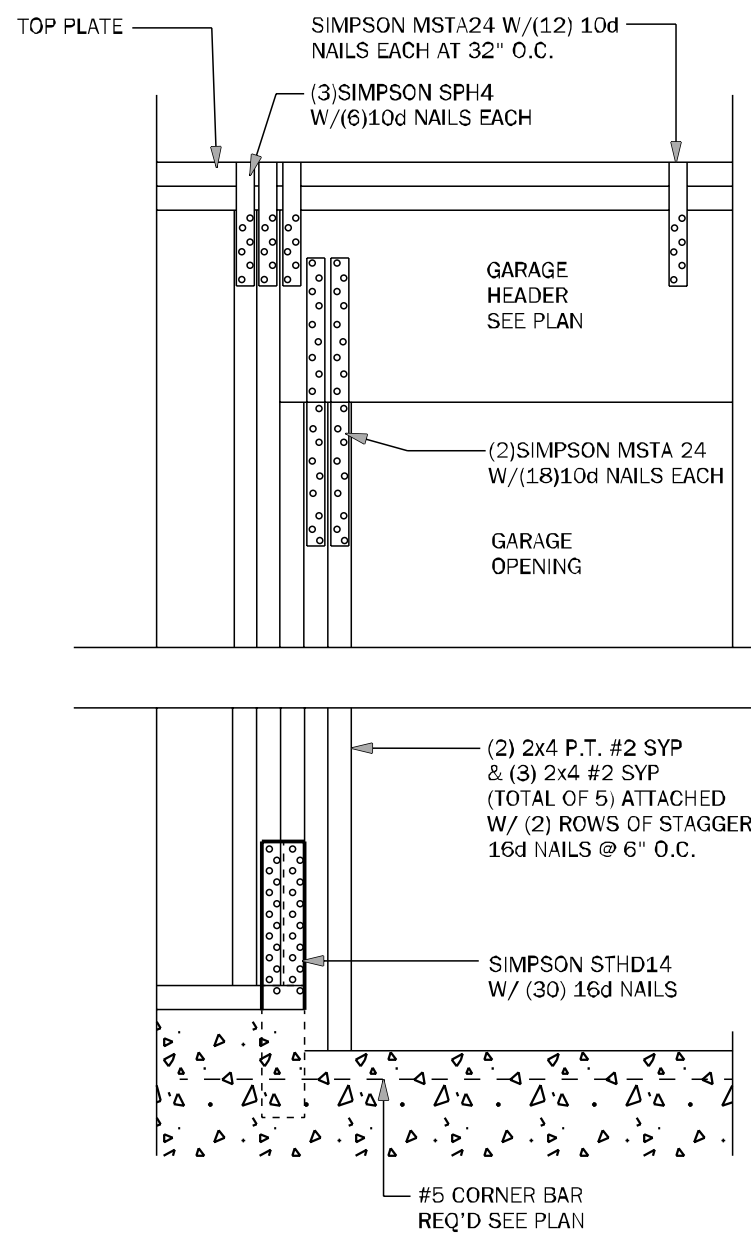


WC04 GARAGE HEADER ANCHOR 3/4" = 1'-0"

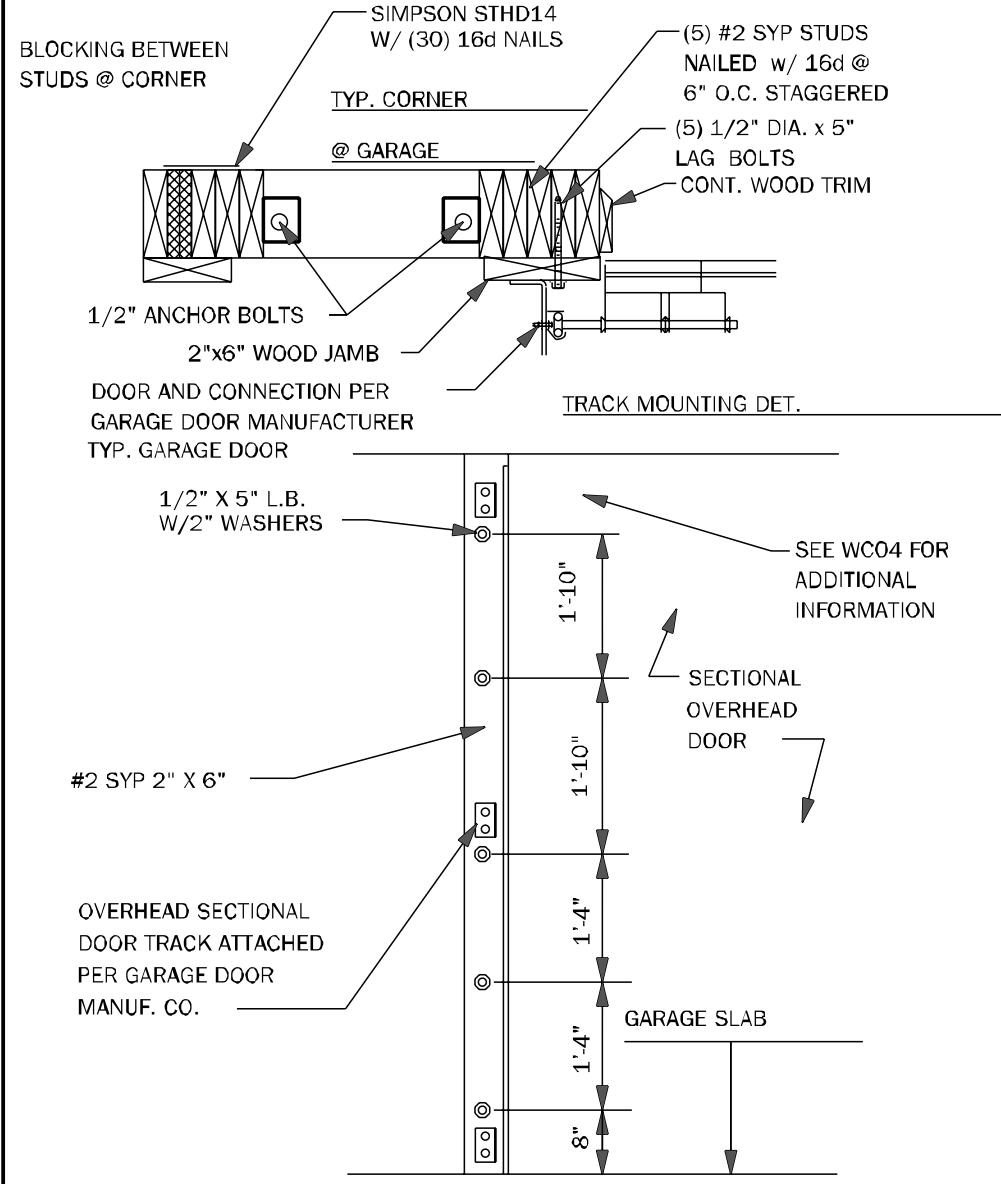


WC05 SECT. OVERHEAD GAR. DOOR INSTALL N.T.S.

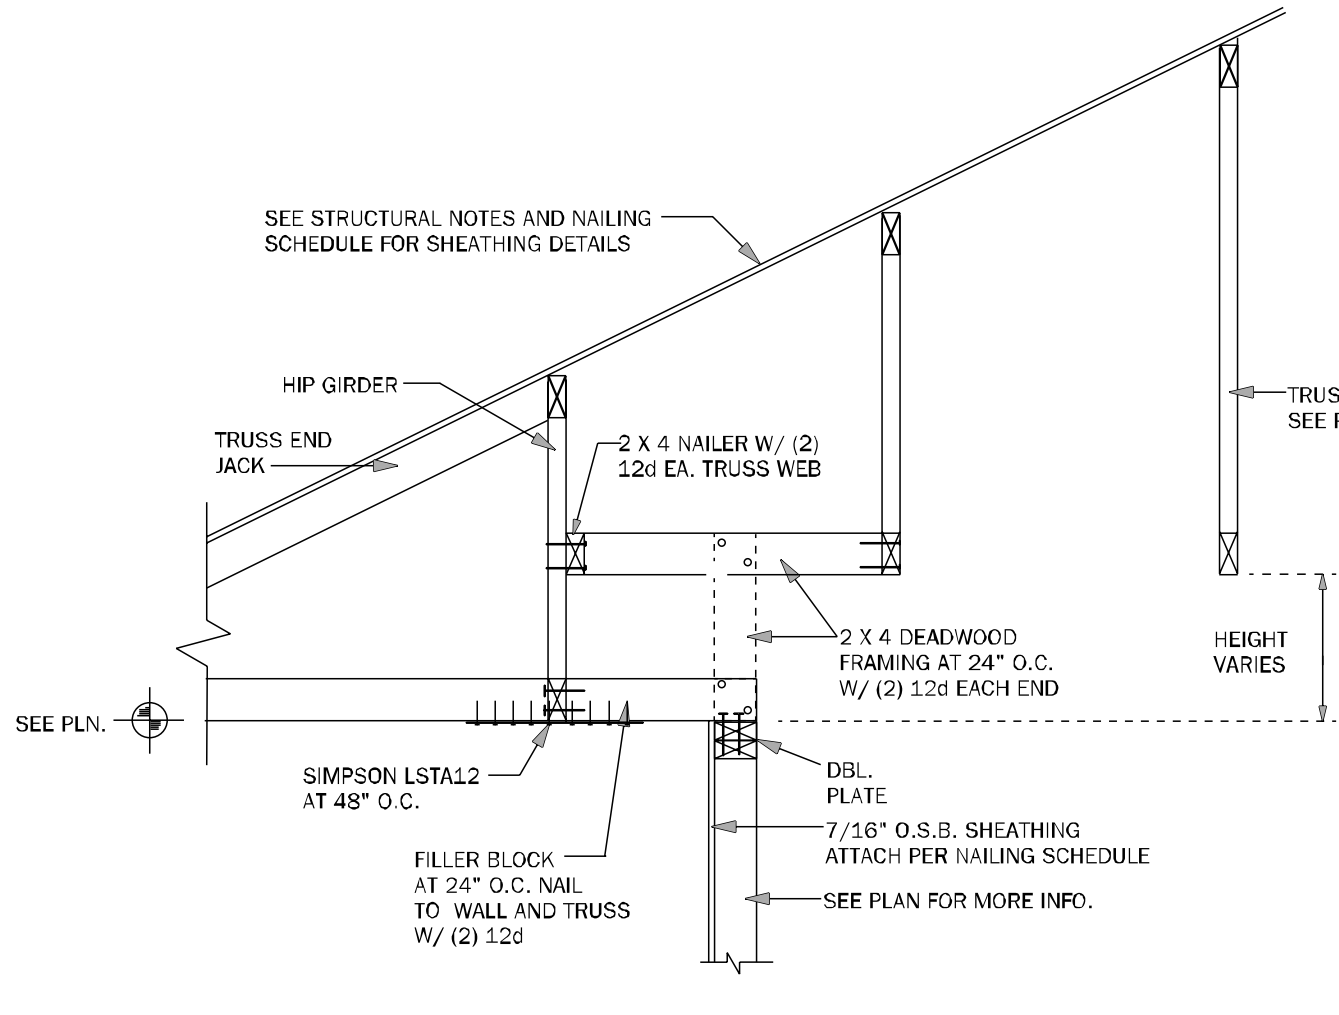


WF64 EXTERIOR NON BRG. WALL DETAIL N.T.S.

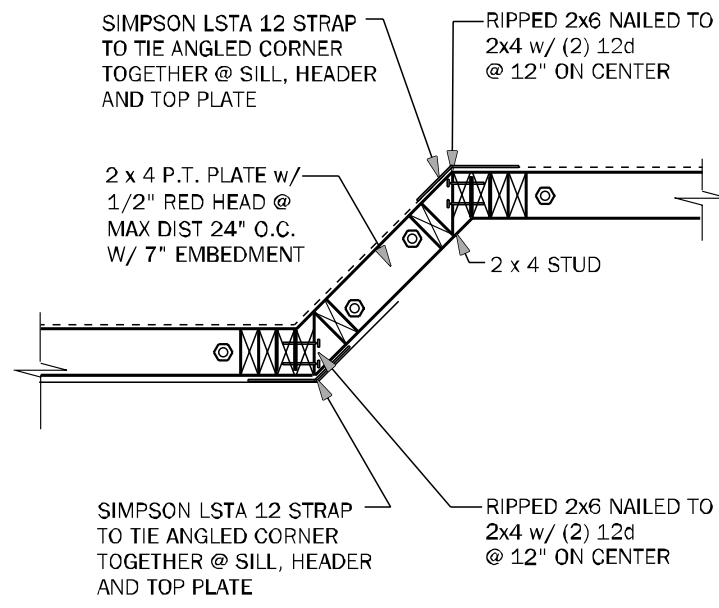


WF43 EXTERIOR ANGLED WALL DETAIL N.T.S.

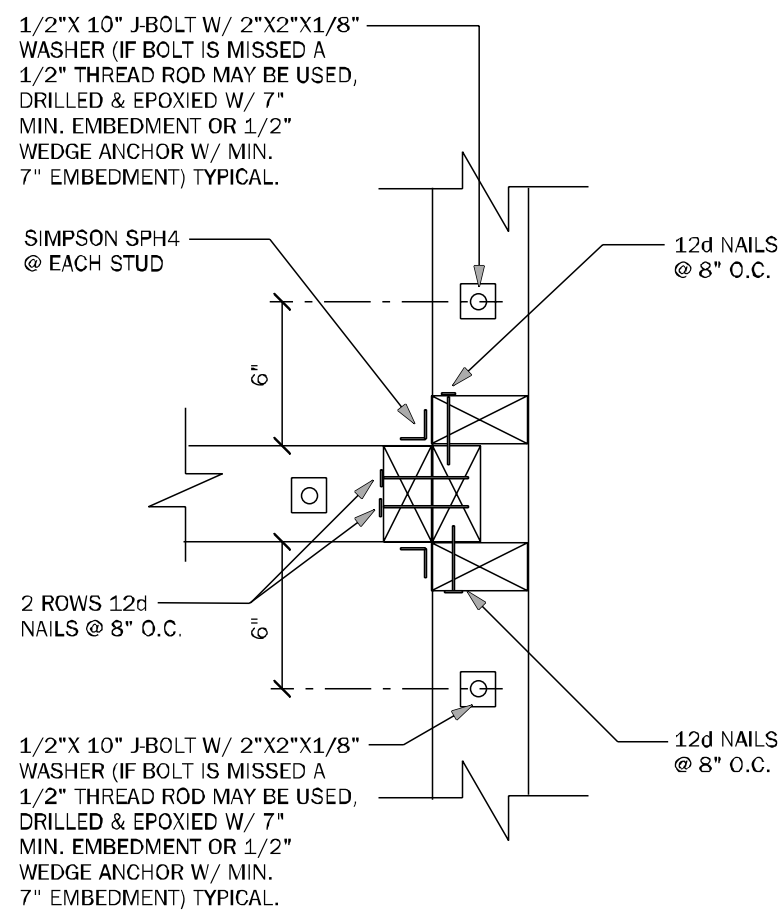


WC03 WALL TO WALL CONN. @ END OF SHEARWALL 1 1/2" = 1'-0"

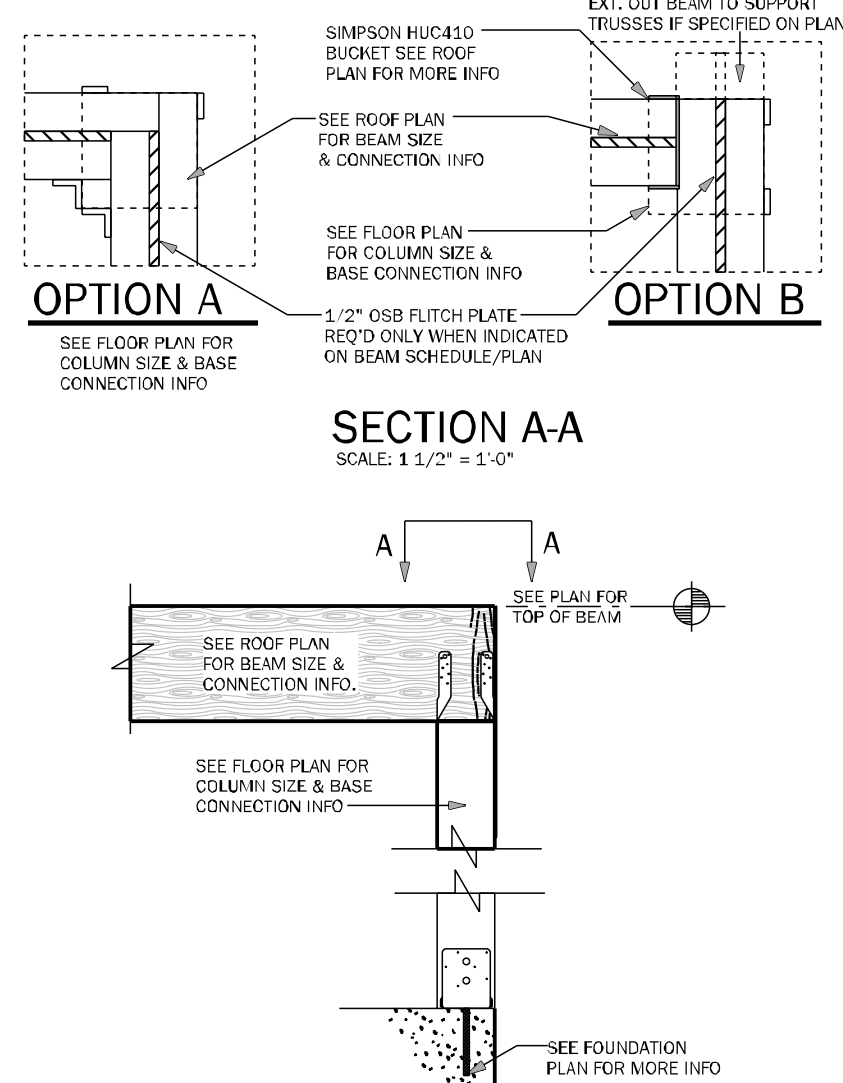


CD11 COMMON BEAM ATTACHMENT N.T.S.

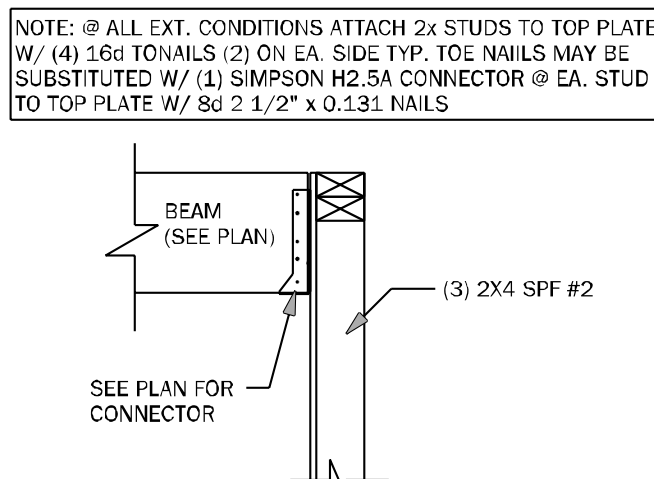


CD25 BEAM TO WALL CONNECTION N.T.S.

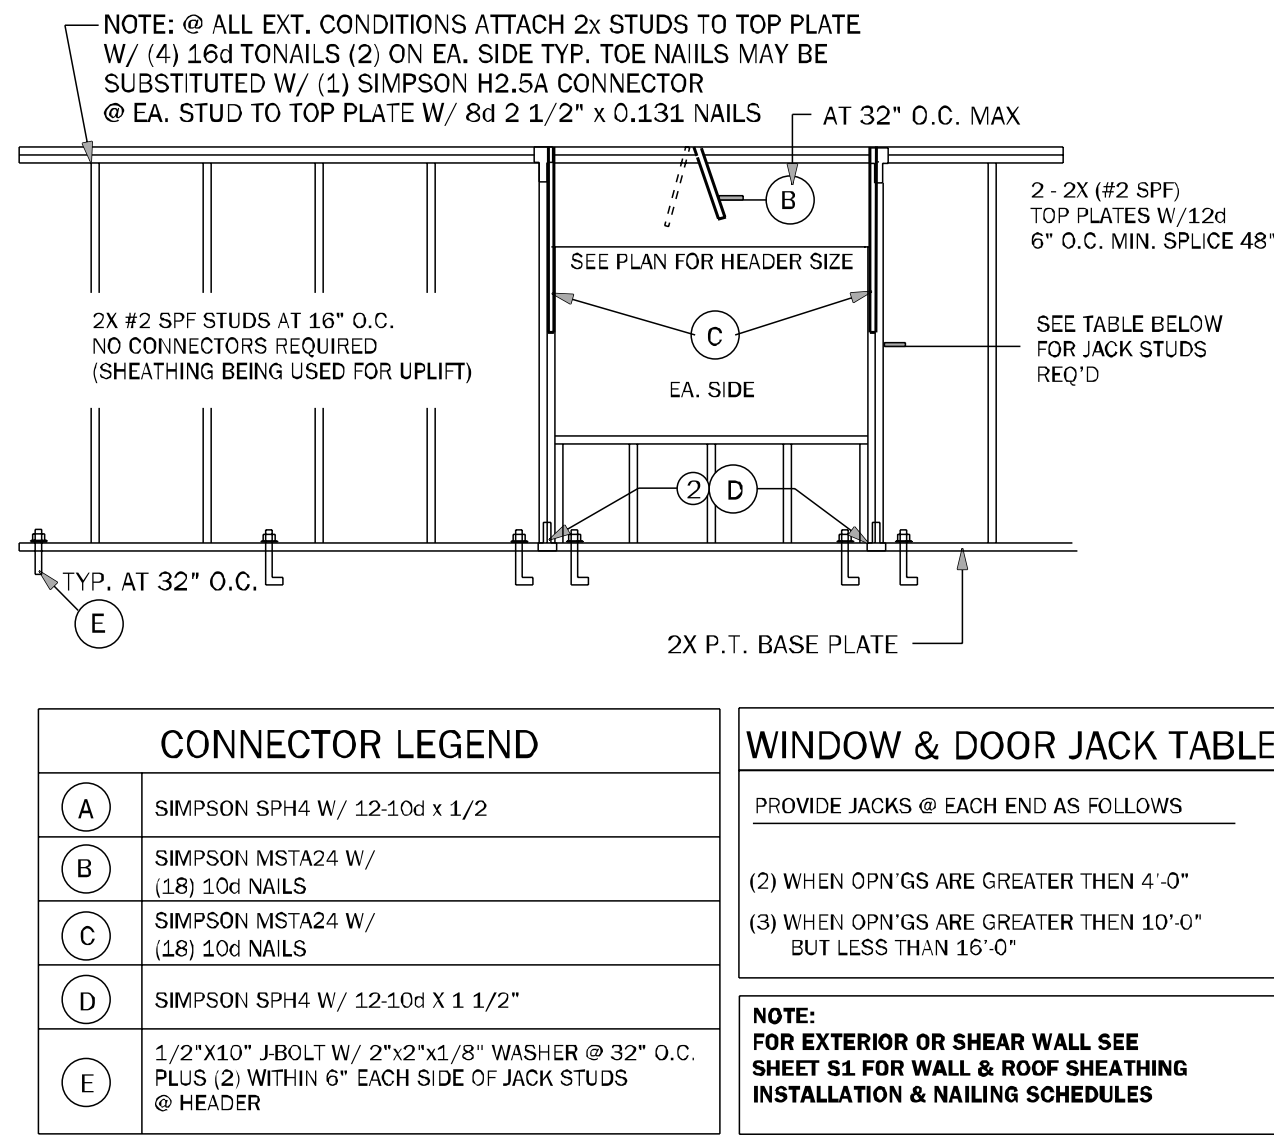


WF66 TYPICAL BEARING WALL N.T.S.

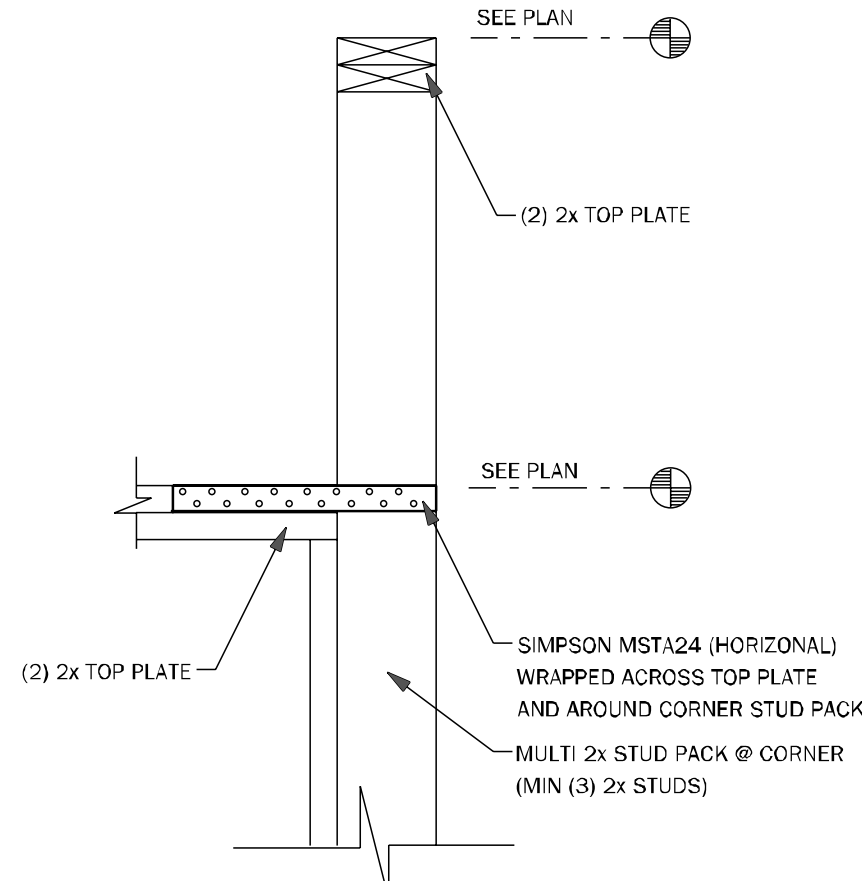


WC09 WALL STEP @ CORNER N.T.S.

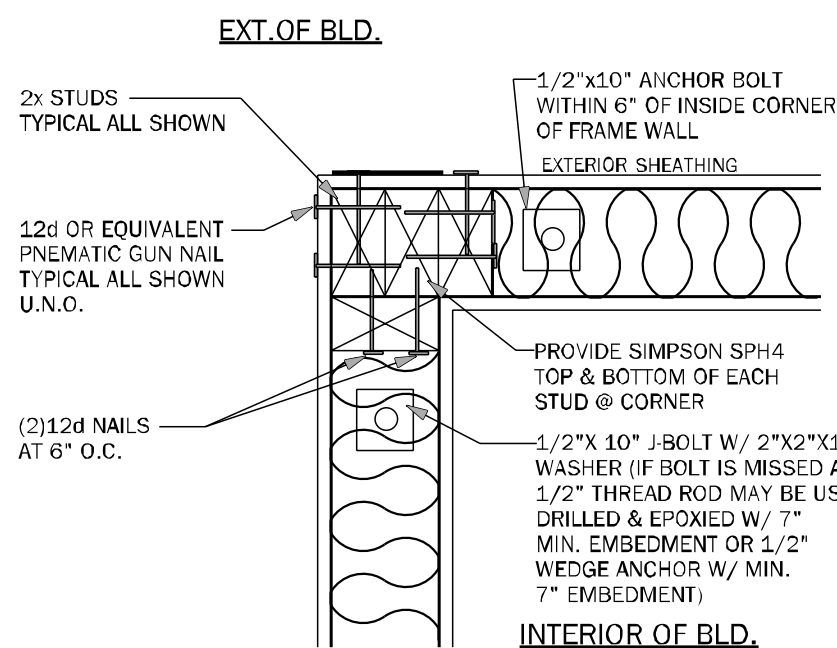


WC06 EXTERIOR FRAME CORNER 3/4" = 1'-0"

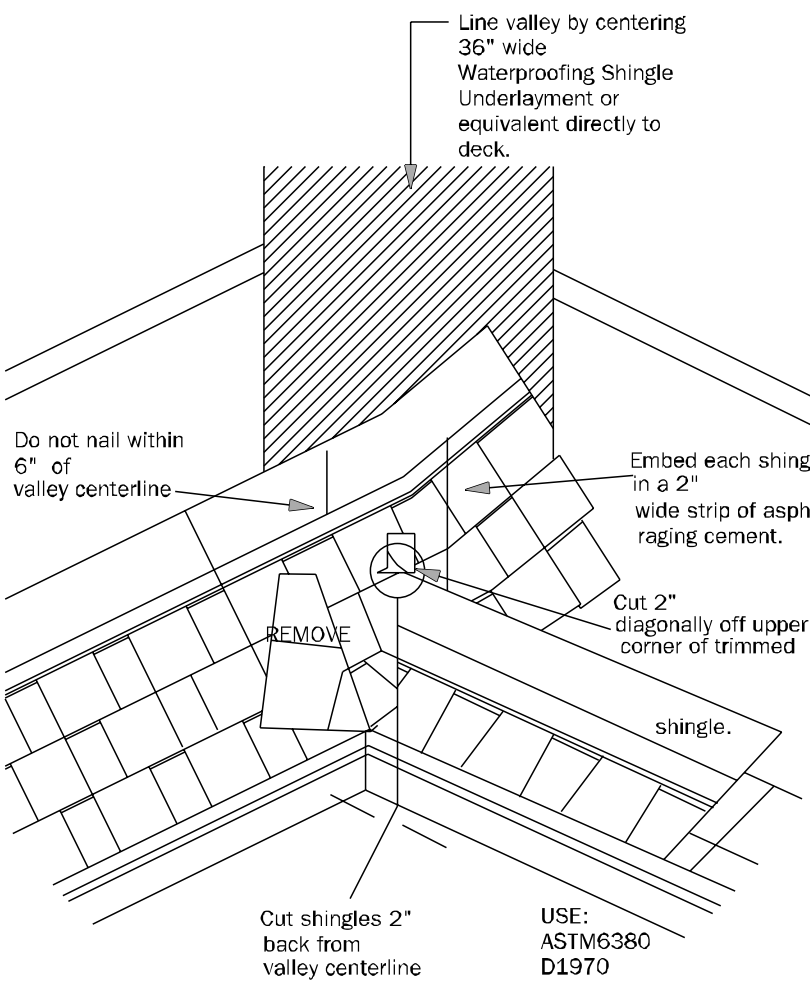

RD01 VALLEY FLASHING DETAIL N.T.S.

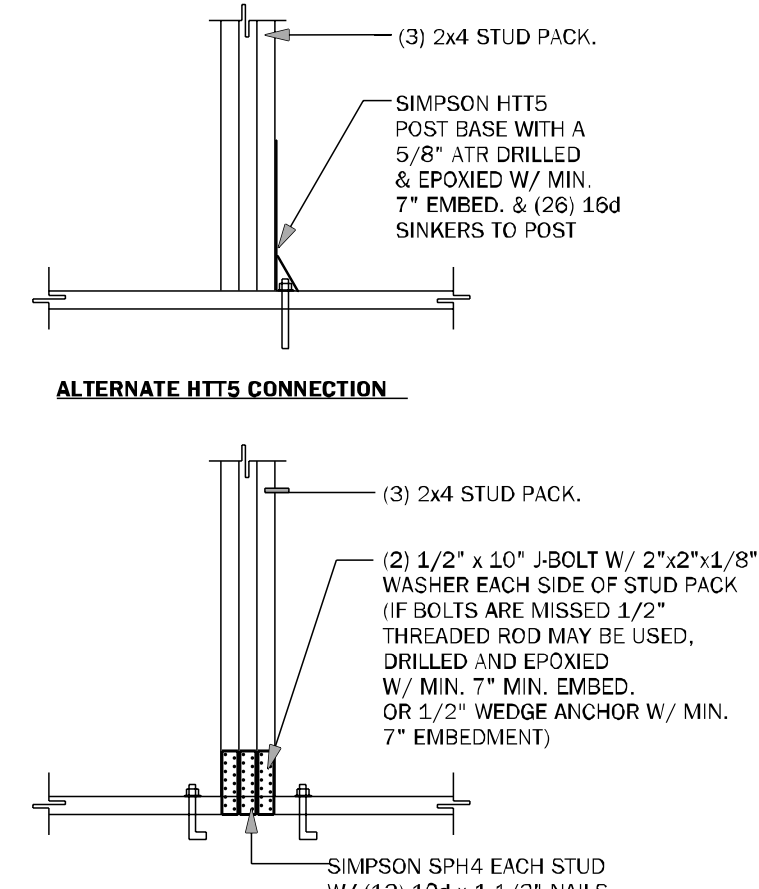

CD26 GIRDER BASE CONNECTION 1/2" = 1'-0"

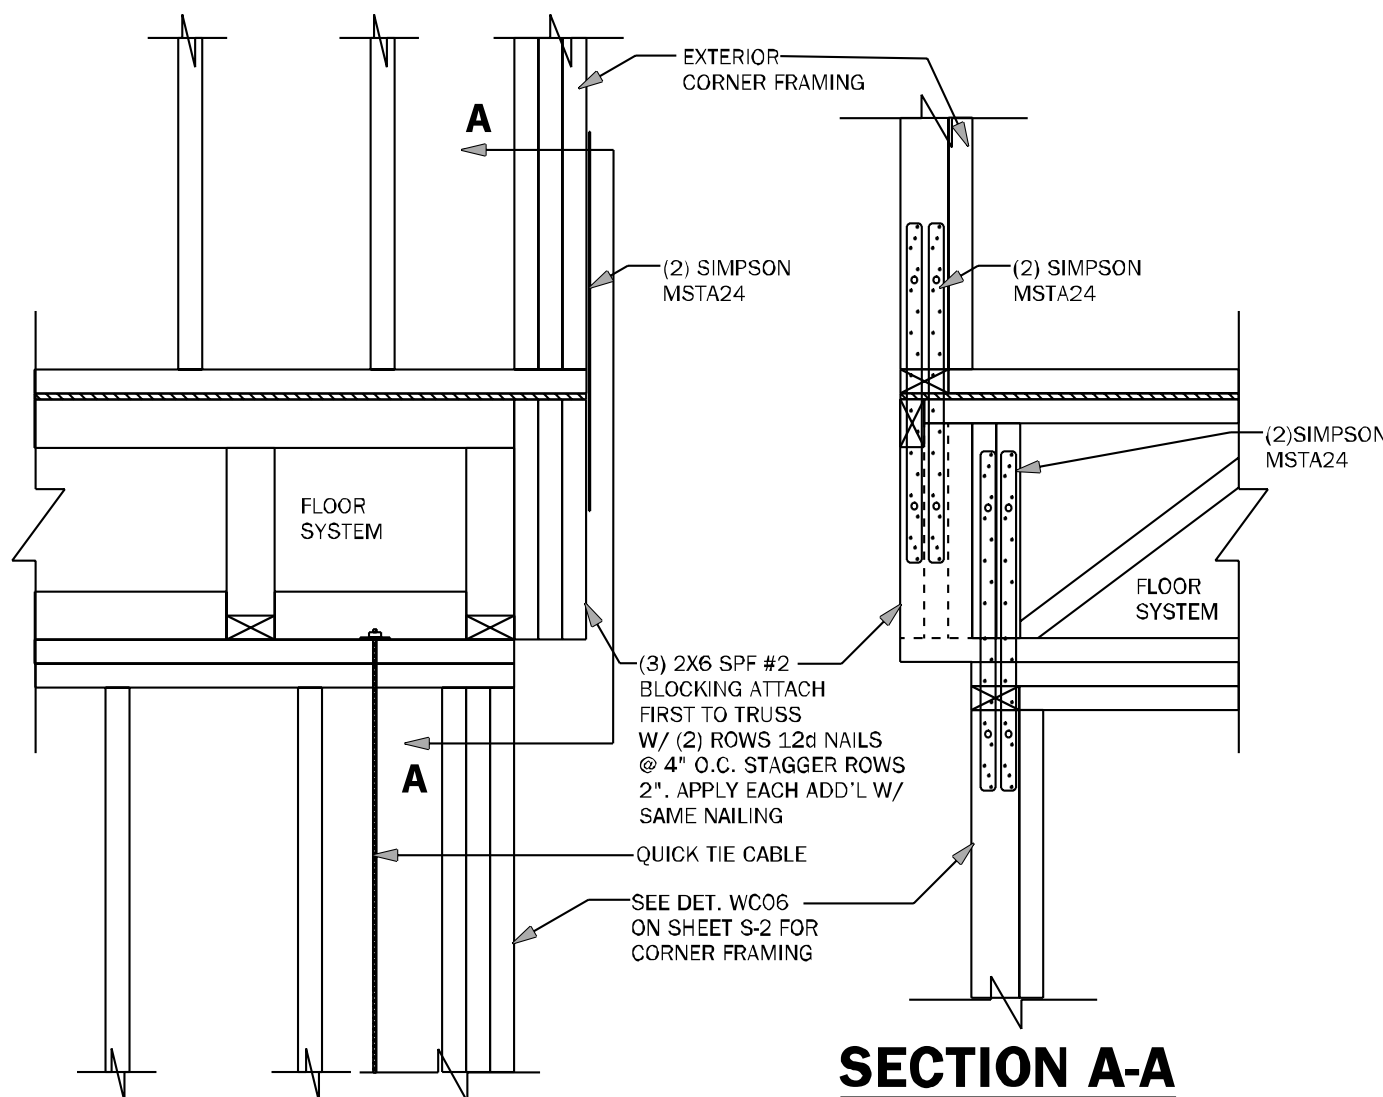

WF68 CORNER CONNECTION N.T.S.

COUNTY SEAL

FDS ENGINEERS & ARCHITECTS

255 Seaboard Lane, Suite 200
Maitland, Florida 32751
Tel: 407.880.2304
Fax: 407.880.2305
www.fdseng.com

Keese Associates

ARCHITECTURE | DESIGN | PLANNING
2407 S.W. 23rd Ave., Miami, FL 33135
Tel: 305.856.2004
www.keese.com

DAMS HOMES

FLORIDA CONTRACTORS LICENSE NO. CRC1330146
100 WEST GARDEN STREET
PENSACOLA FL 32502

DIVISION LOCATION:
GAINESVILLE

Job Information:

INVENTORY

LOT: 92
BLK:
SEC:
SUB: Preserve of Laure Lake
777 S.W. Rosemary Dr.
Lake City, FL

Model Name / Number:
2508


Plan Issue Date:
Thursday, September 26, 2024

KA PROJECT NUMBER:
24-12151


Sheet: **S-2** Of:

TYPICAL FRAMING DETAILS


Thursday, September 26, 2024

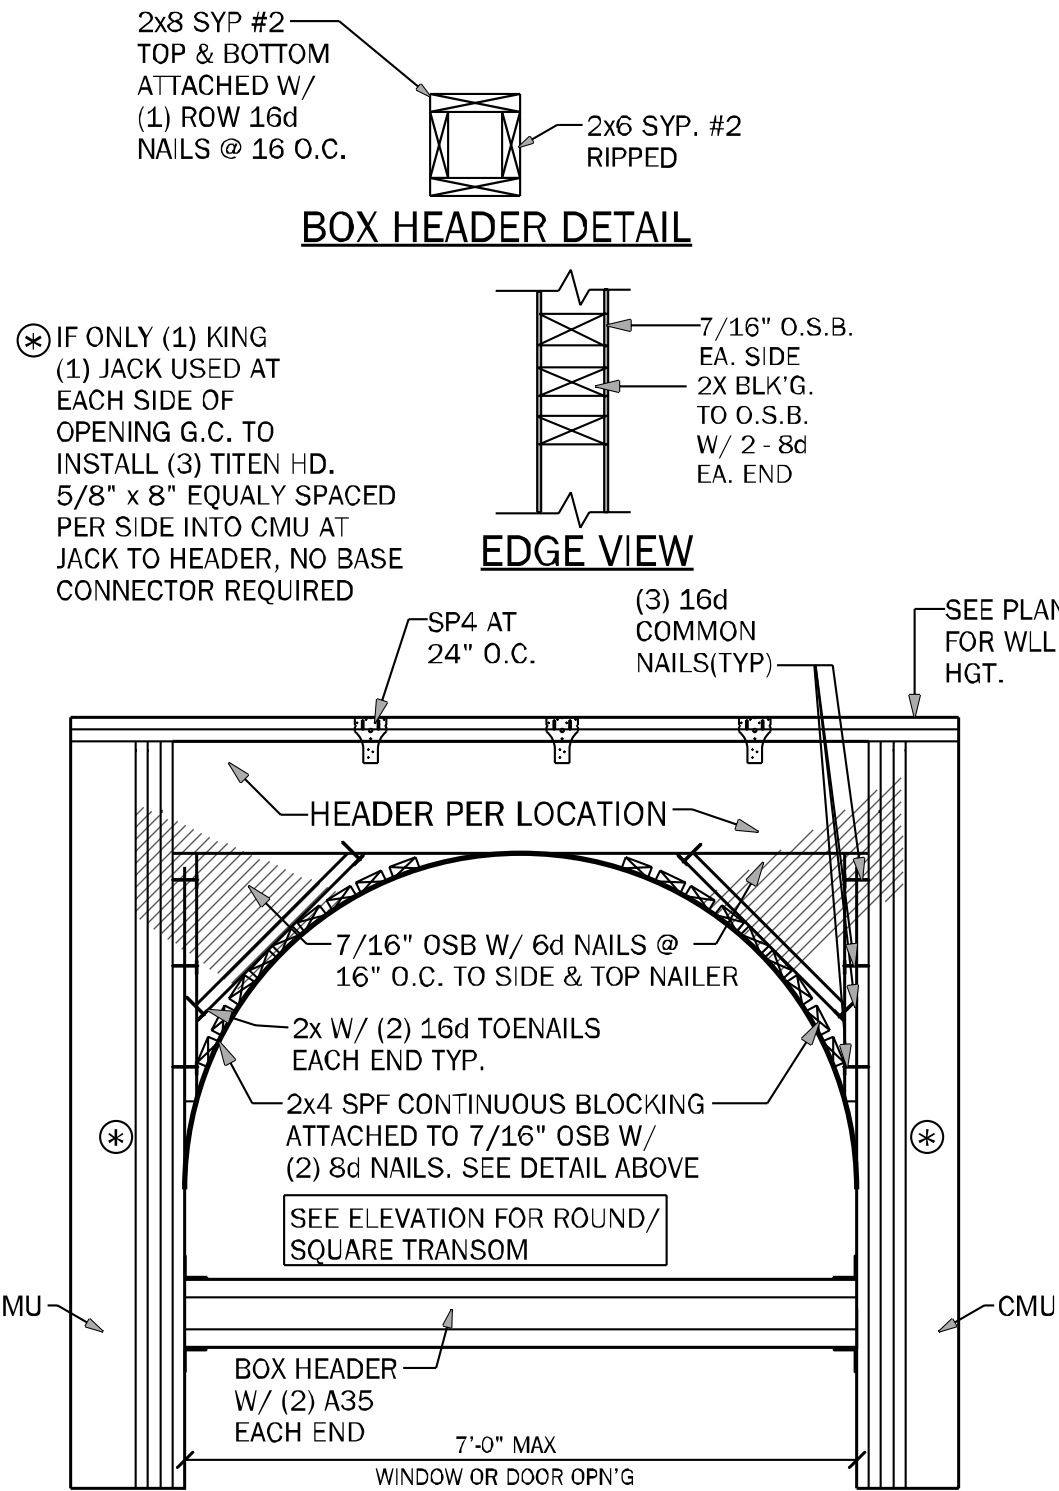

WF39 TRANSOM DETAIL AT ENTRY 1/2" = 1'-0"

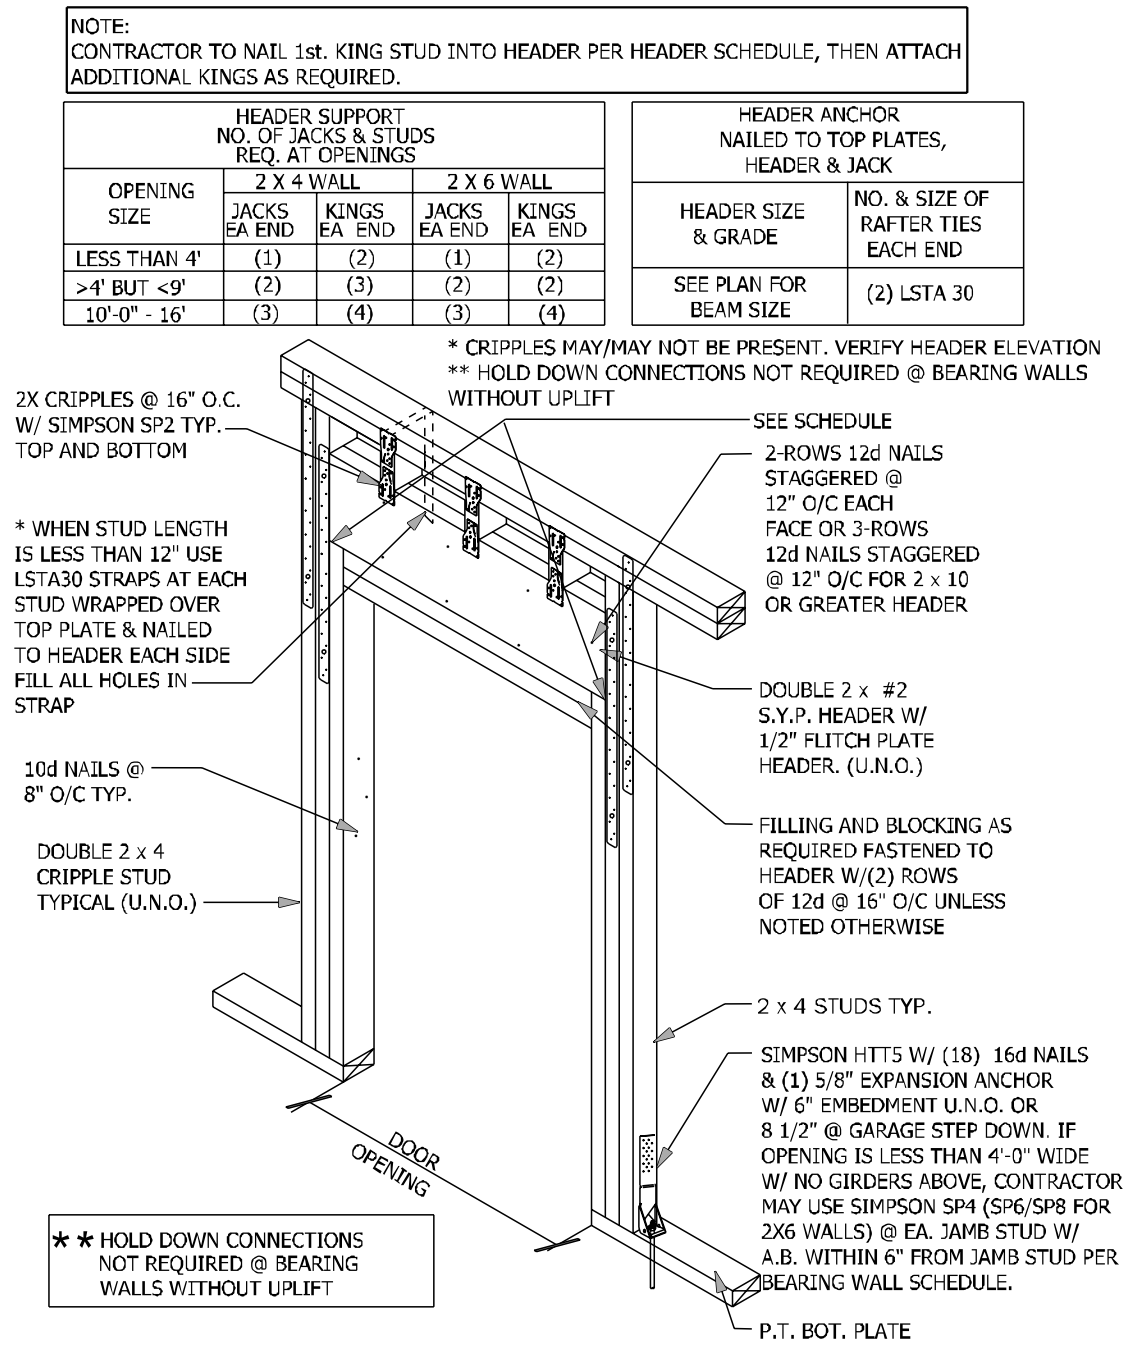

WF09 WALL HEADER DETAIL N.T.S.

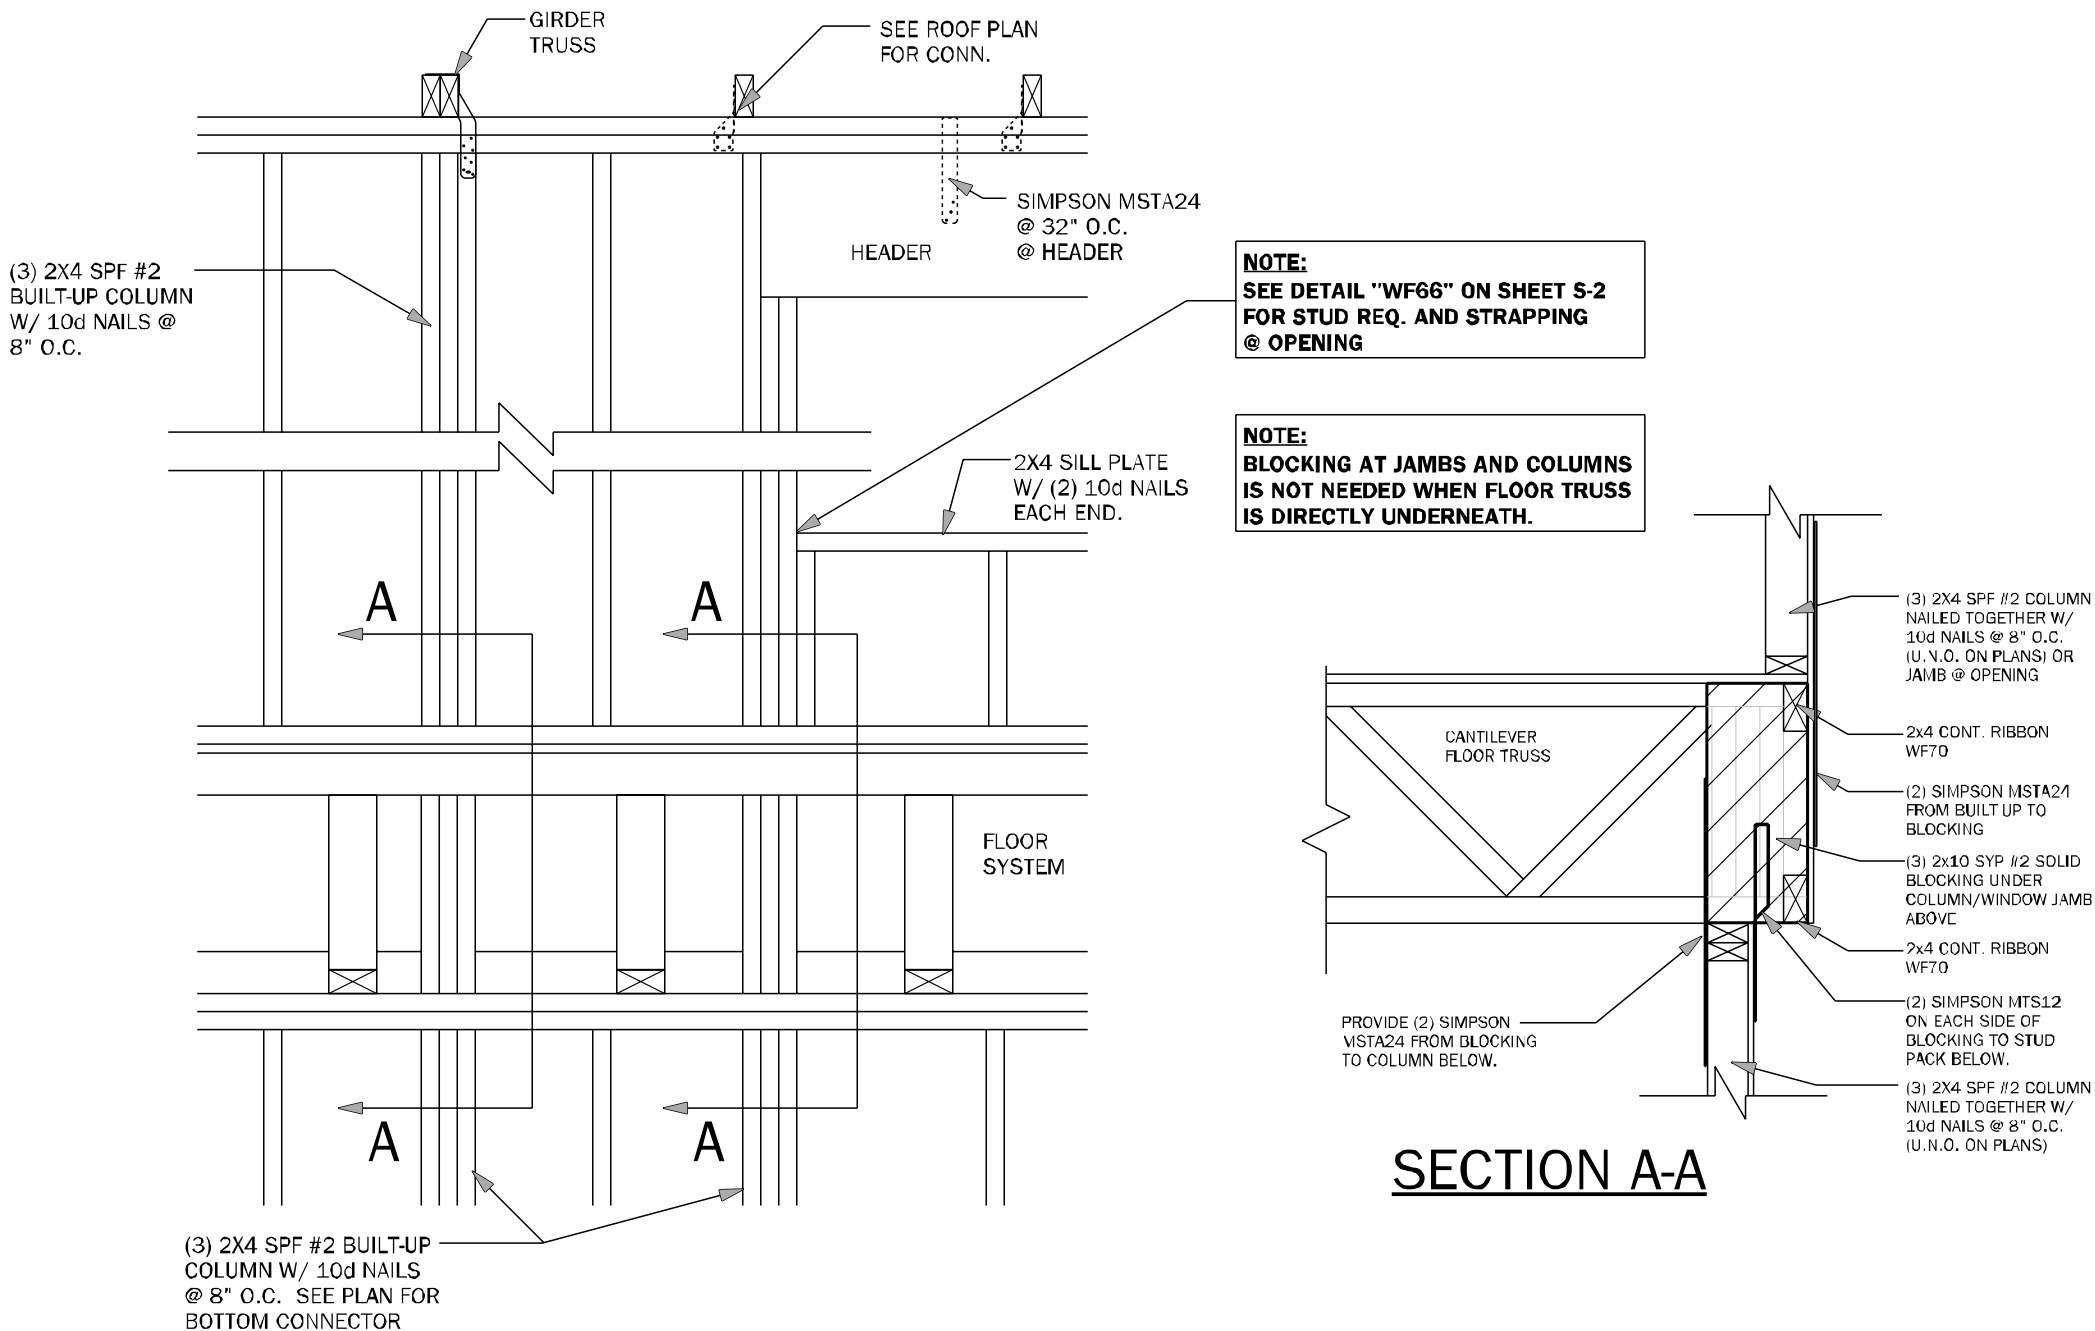

WF67 WALL FRAMING 3/4" = 1'-0"

COUNTY
SEAL

Thursday, September 26, 2024

To the best of the Engineer's knowledge, information, and belief, the design and construction of the above project complies with the applicable building codes and standards, and the Engineer is not providing any warranty or representation other than that the design and construction of the project complies with the applicable building codes and standards.

FDS
ENGINEERING ASSOCIATES
255 Seaboard Lane, Suite 200
Maitland, Florida 32751
407.321.1111
Certificate of Authorization No. 9361

☐ CARL A. BROWN, P.E.
☐ SCOTT A. LEWIS, P.E.
☐ THIEN BAO DUONG, P.E.

www.fdseng.com

keese
associates
ARCHITECTURE | DESIGN | PLANNING
25407 YSBO 2355
g@keese.com

AA2000115

AD

DAMS HOMES
FLORIDA CONTRACTORS LICENSE NO. CRC1330146
**100 WEST GARDEN STREET
PENSACOLA FL 32502**

DIVISION LOCATION:
GAINESVILLE

Job Information:

INVENTORY

LOT: 92
BLK:
SEC:
SUB: Preserve of Laure Lake
777 S.W. Rosemary Dr.
Lake City, FL


Model Name / Number:
2508

Plan Issue Date:
Thursday, September 26, 2024


KA PROJECT NUMBER:
24-12151

Sheet: **S-2.1** Of:


**TYPICAL FRAMING
DETAILS**

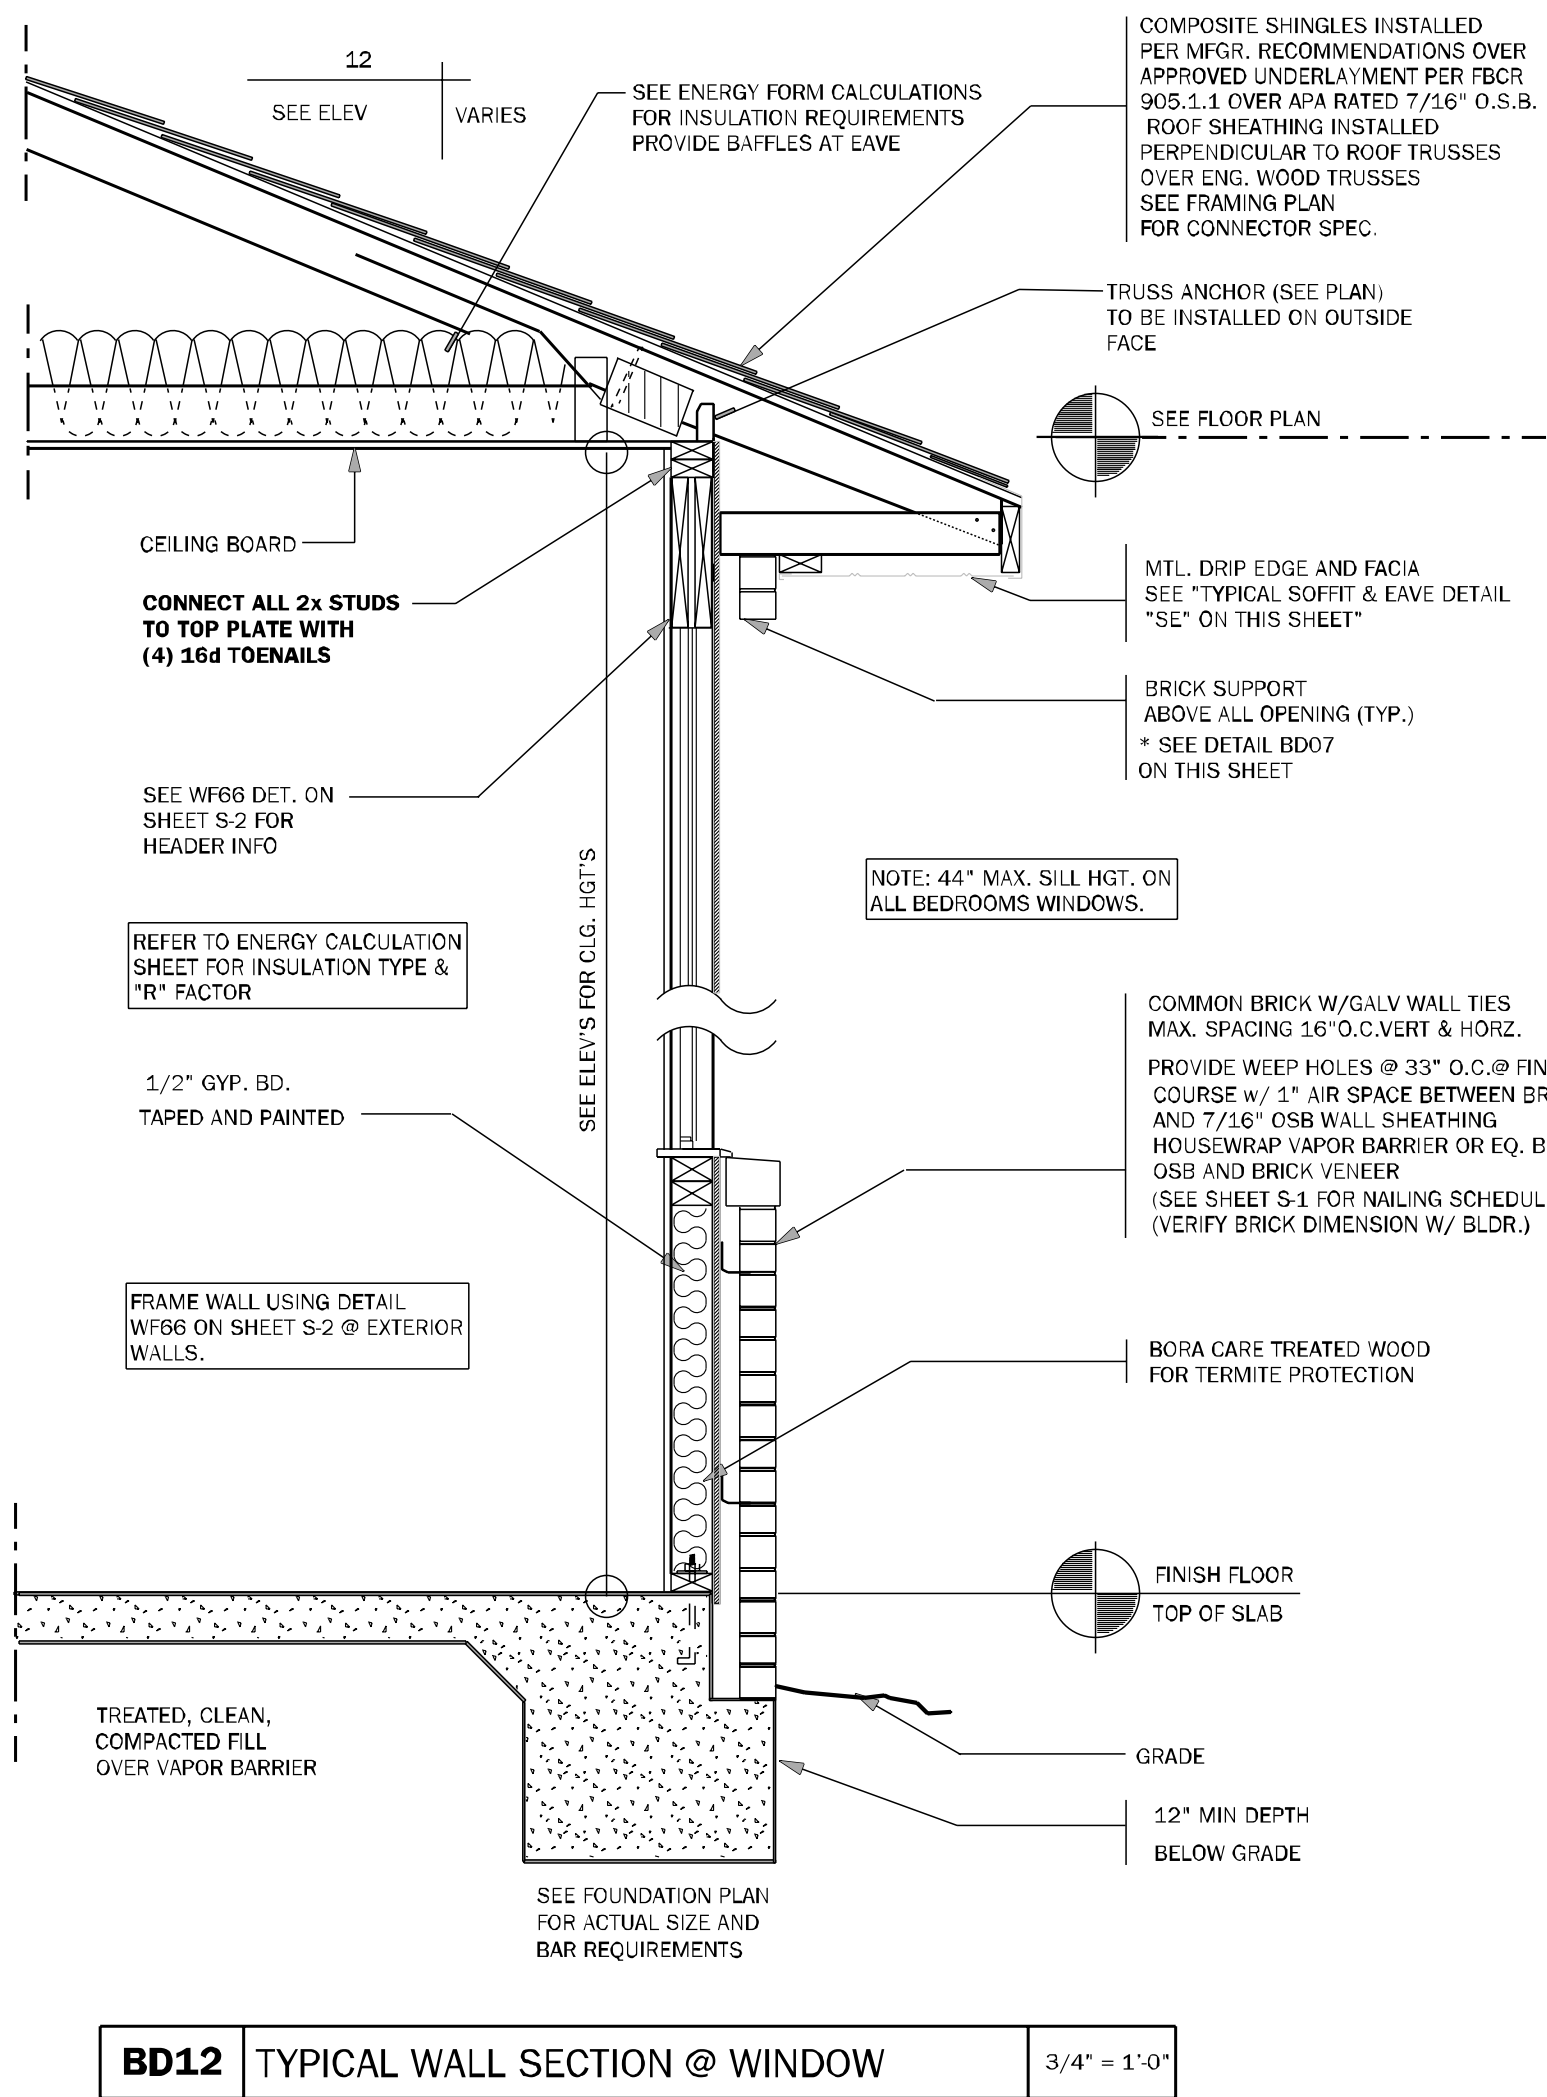


BD12 TYPICAL WALL SECTION @ WINDOW 3/4" = 1'-0"

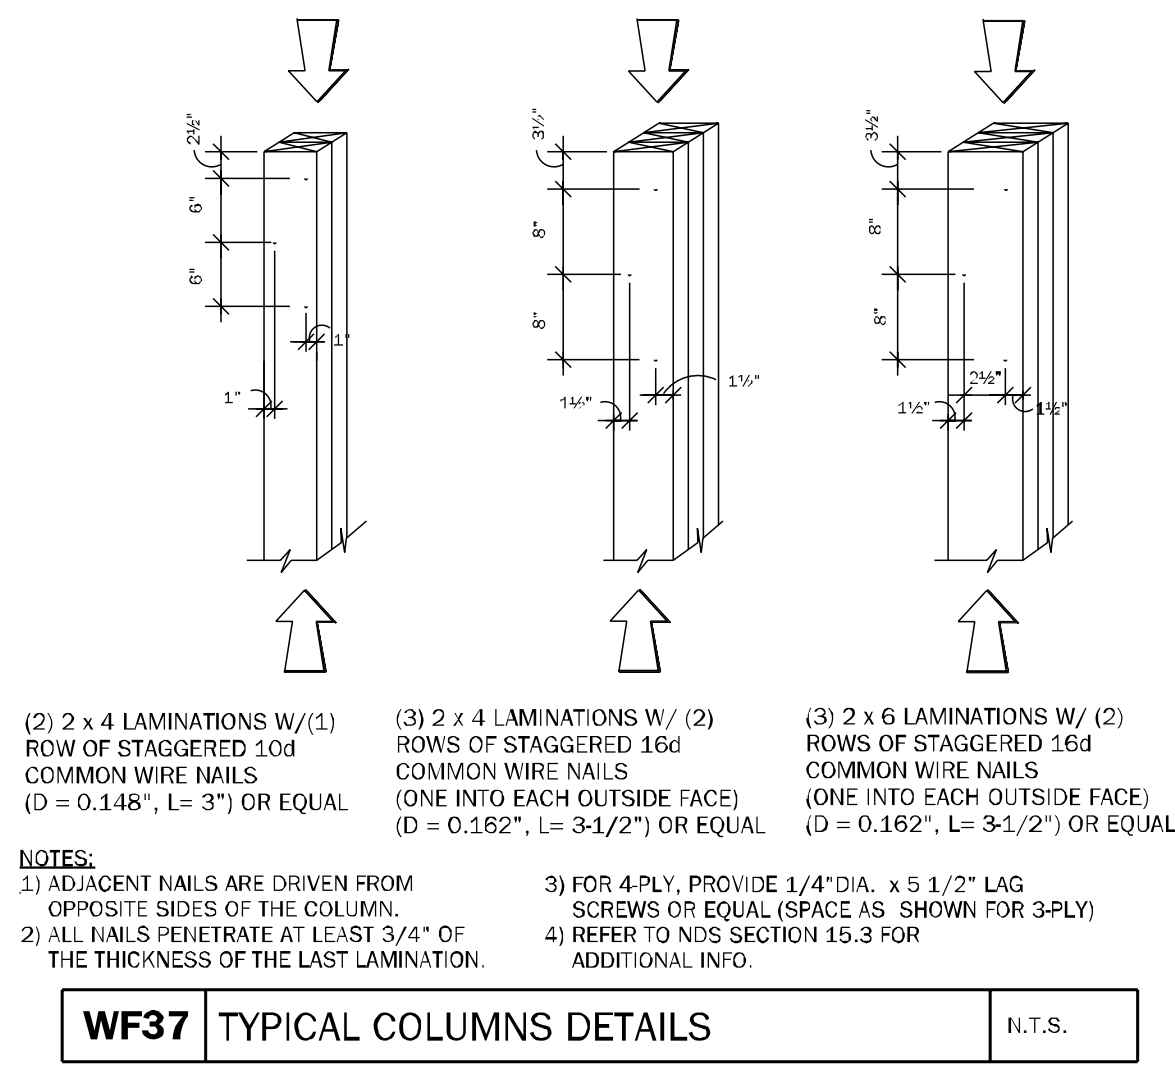


WF37 TYPICAL COLUMNS DETAILS N.T.S.

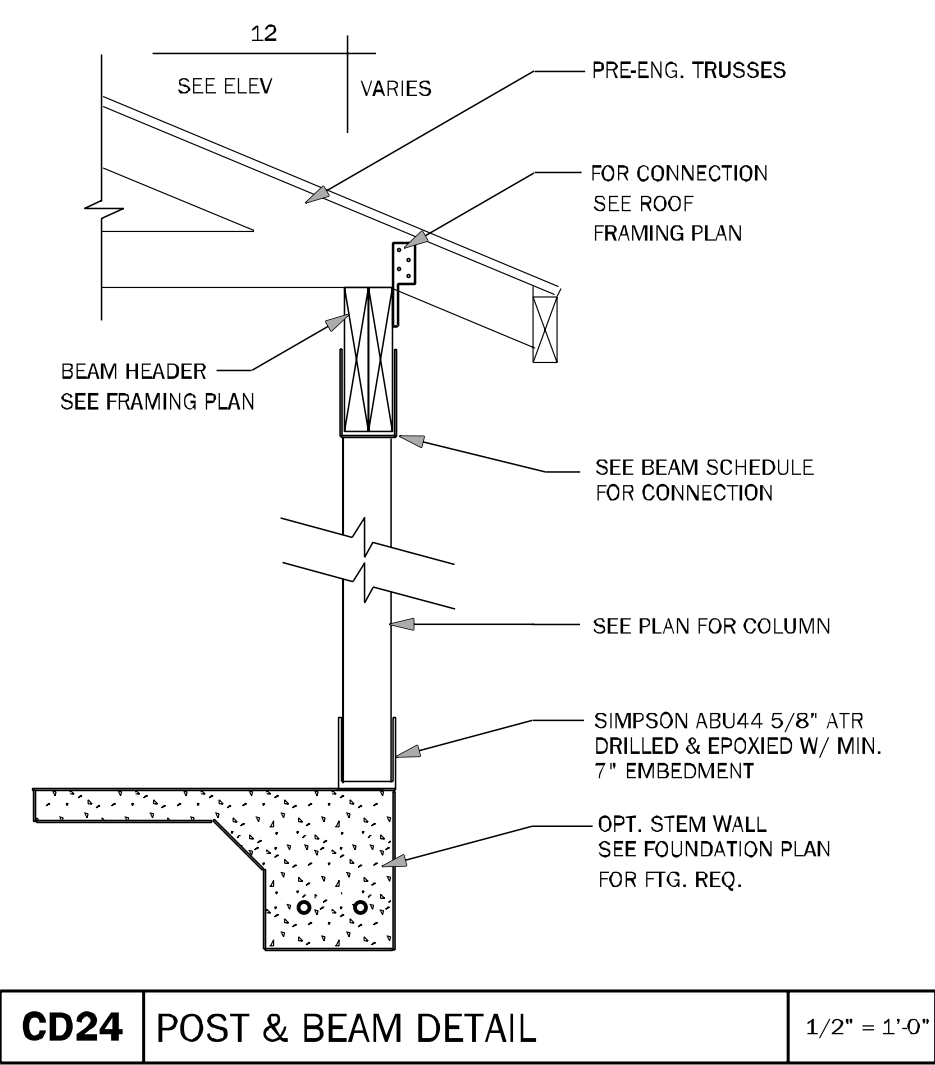


CD24 POST & BEAM DETAIL 1/2" = 1'-0"

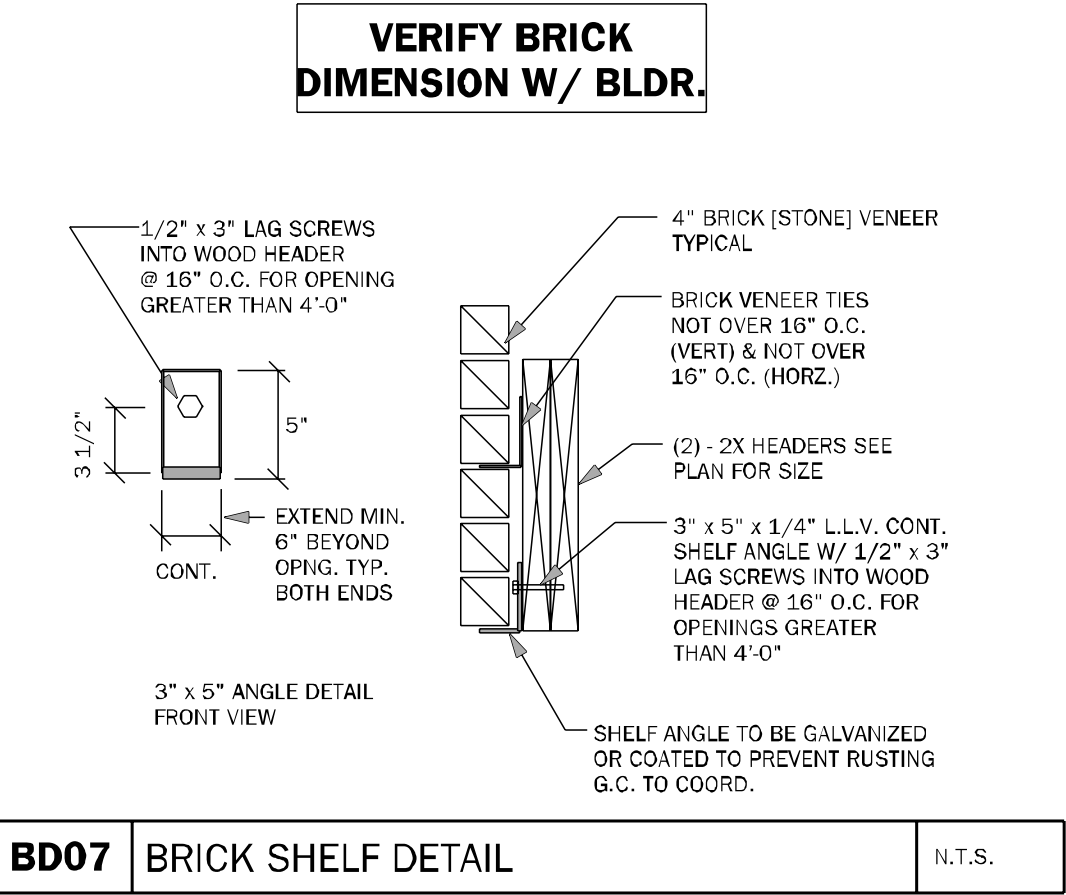


BD07 BRICK SHELF DETAIL N.T.S.

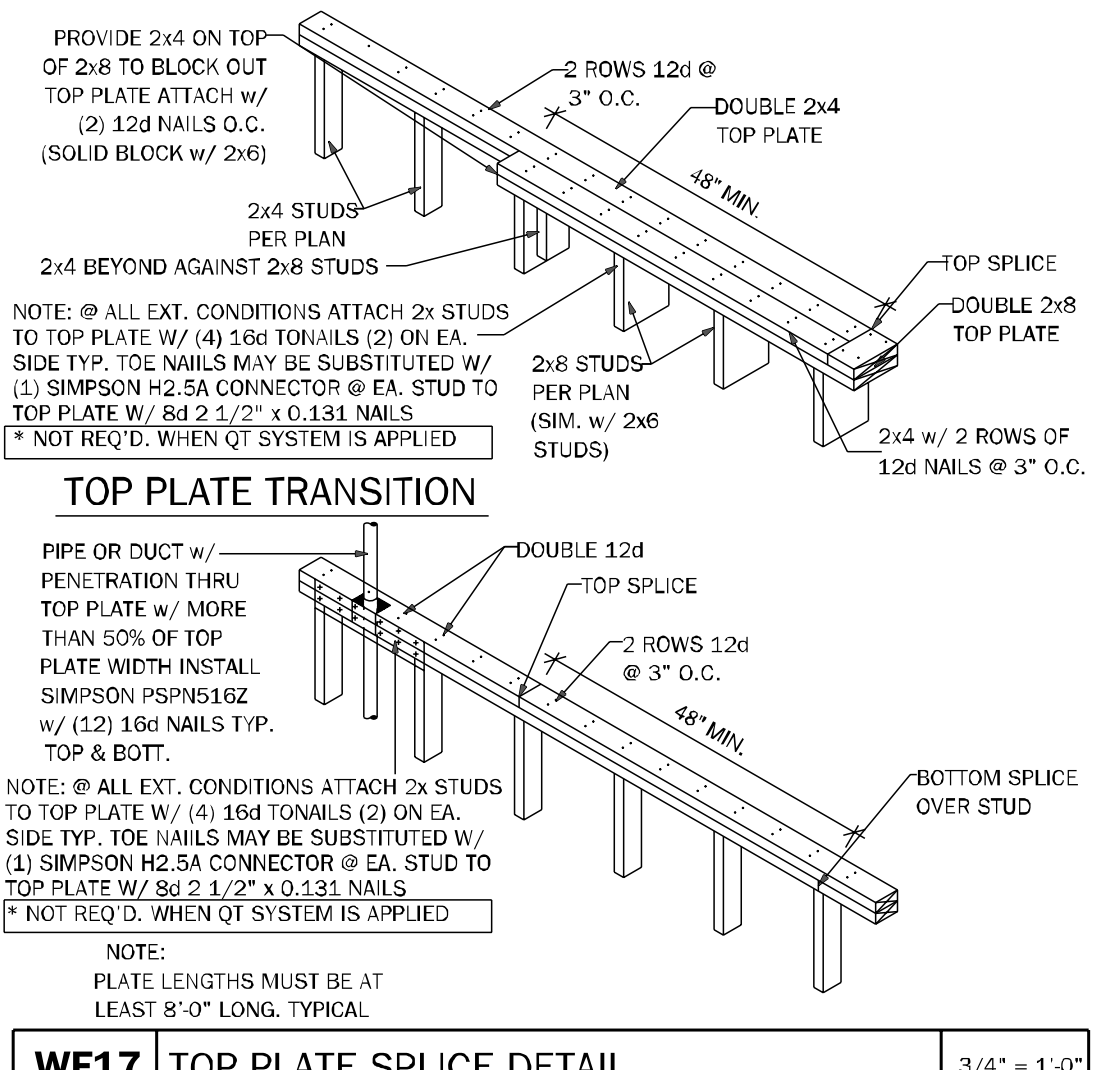


WF17 TOP PLATE SPLICE DETAIL 3/4" = 1'-0"

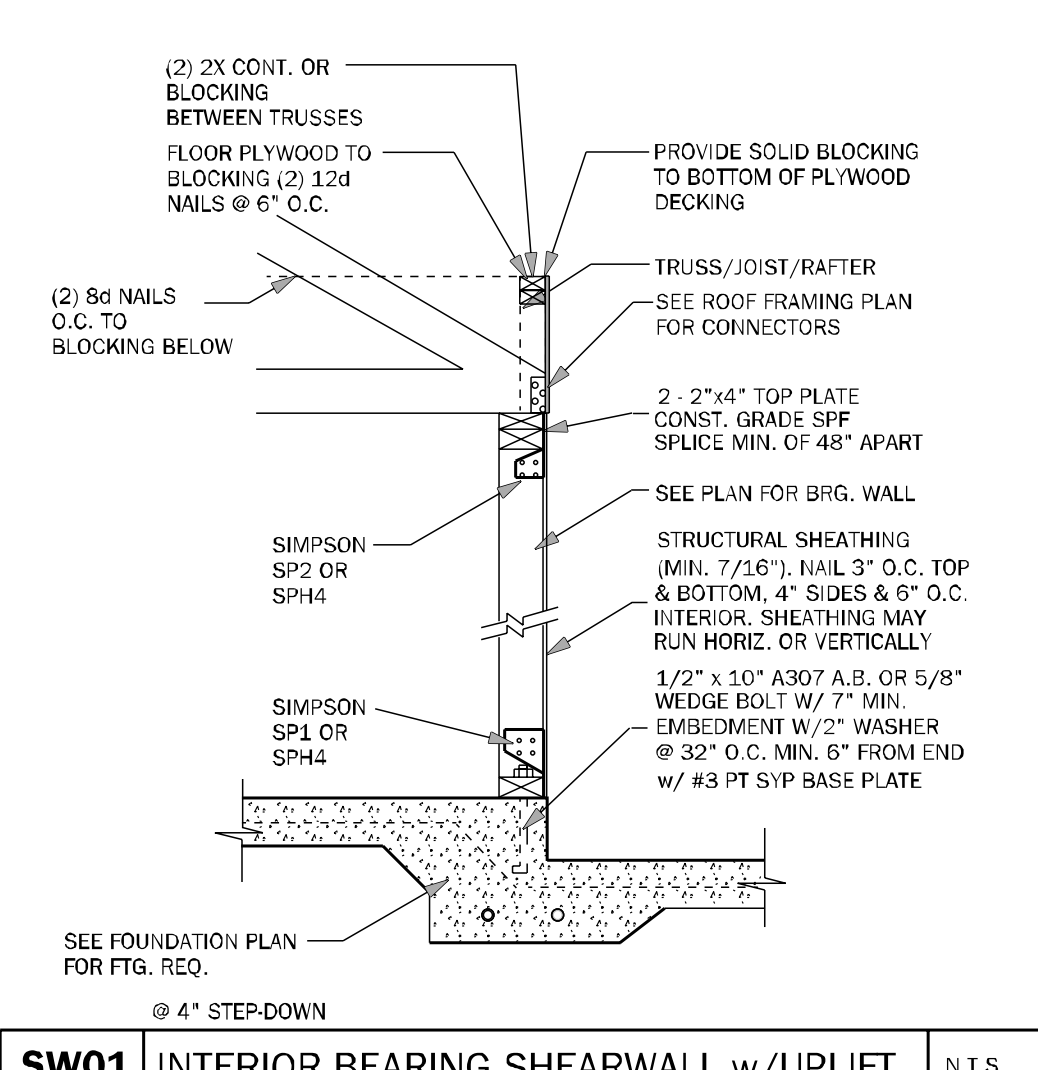


SW01 INTERIOR BEARING SHEARWALL w/UPLIFT N.T.S.

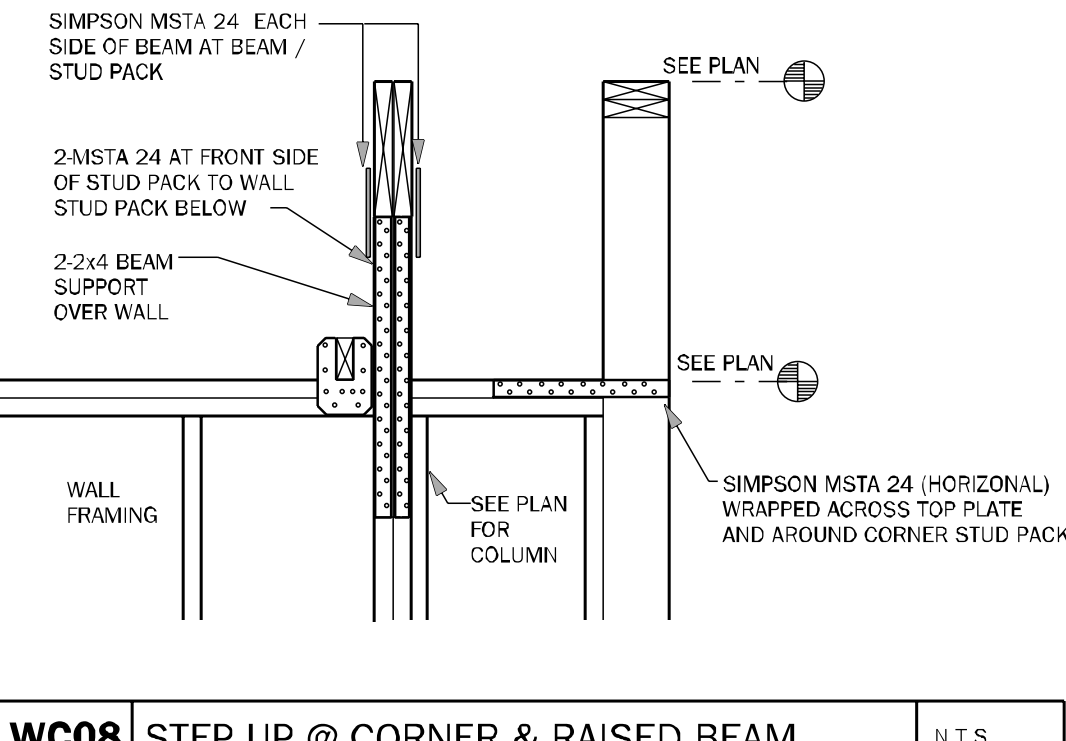


WC08 STEP UP @ CORNER & RAISED BEAM N.T.S.

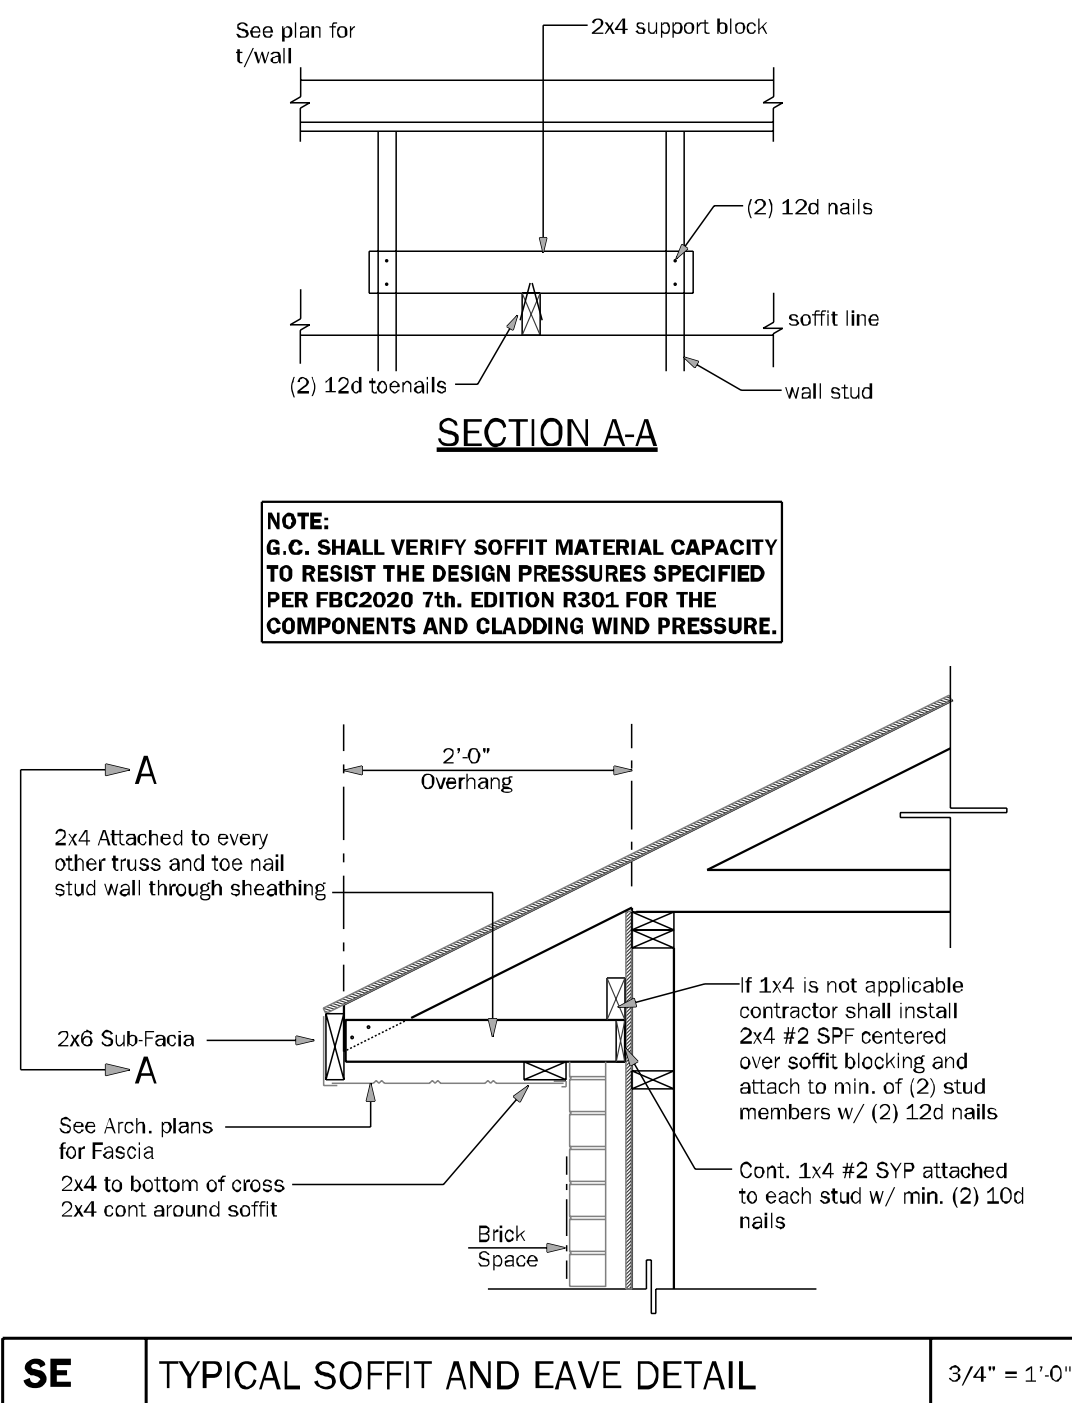


SE TYPICAL SOFFIT AND EAVE DETAIL 3/4" = 1'-0"

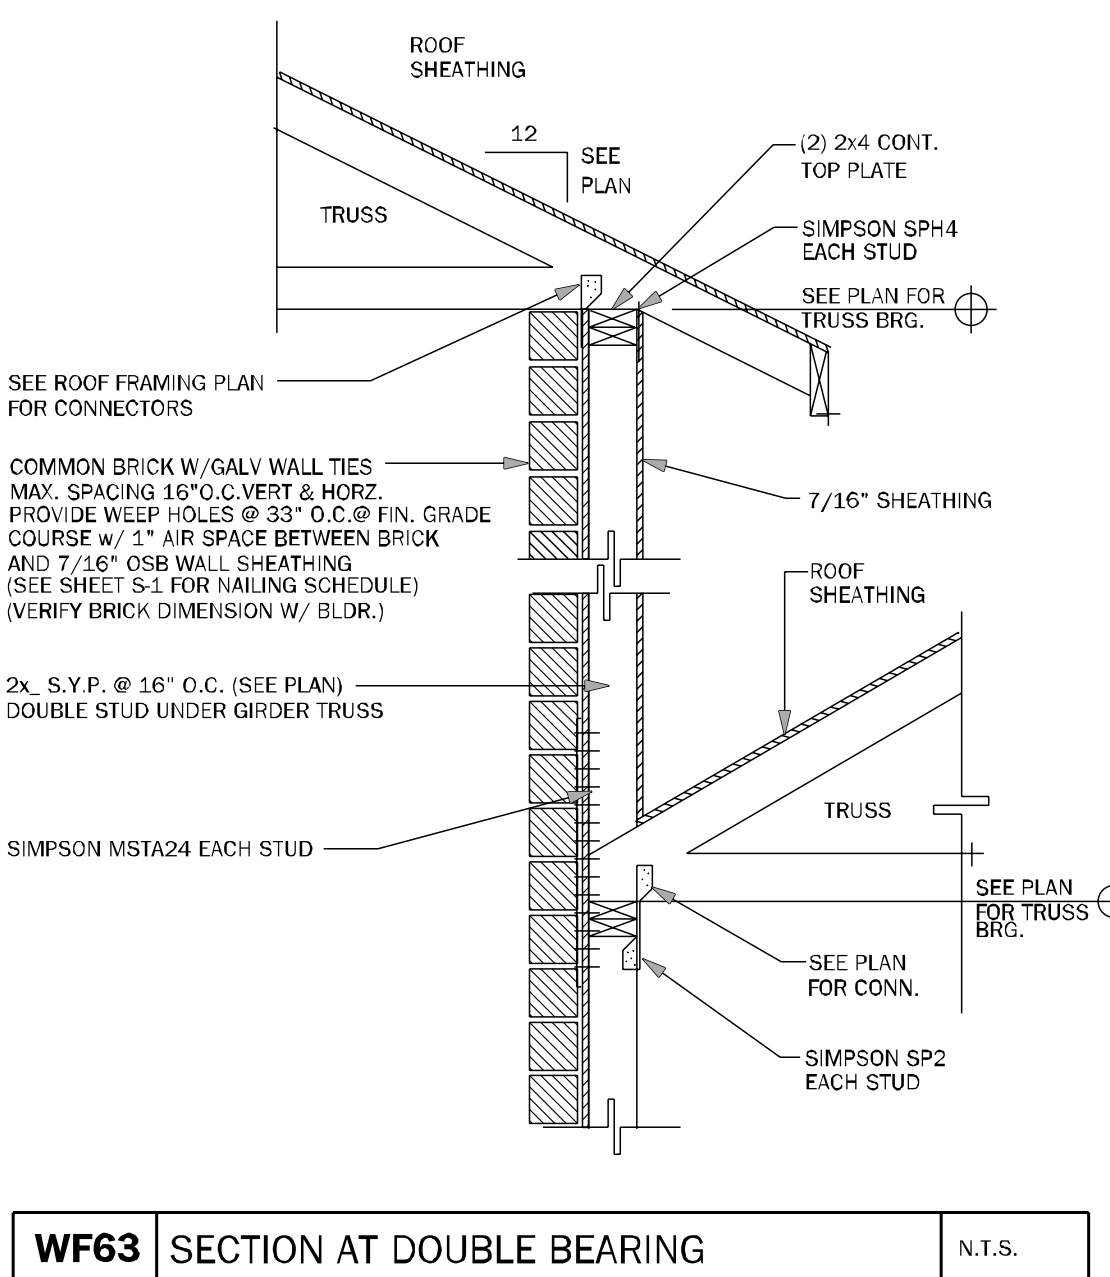

WF63 SECTION AT DOUBLE BEARING N.T.S.

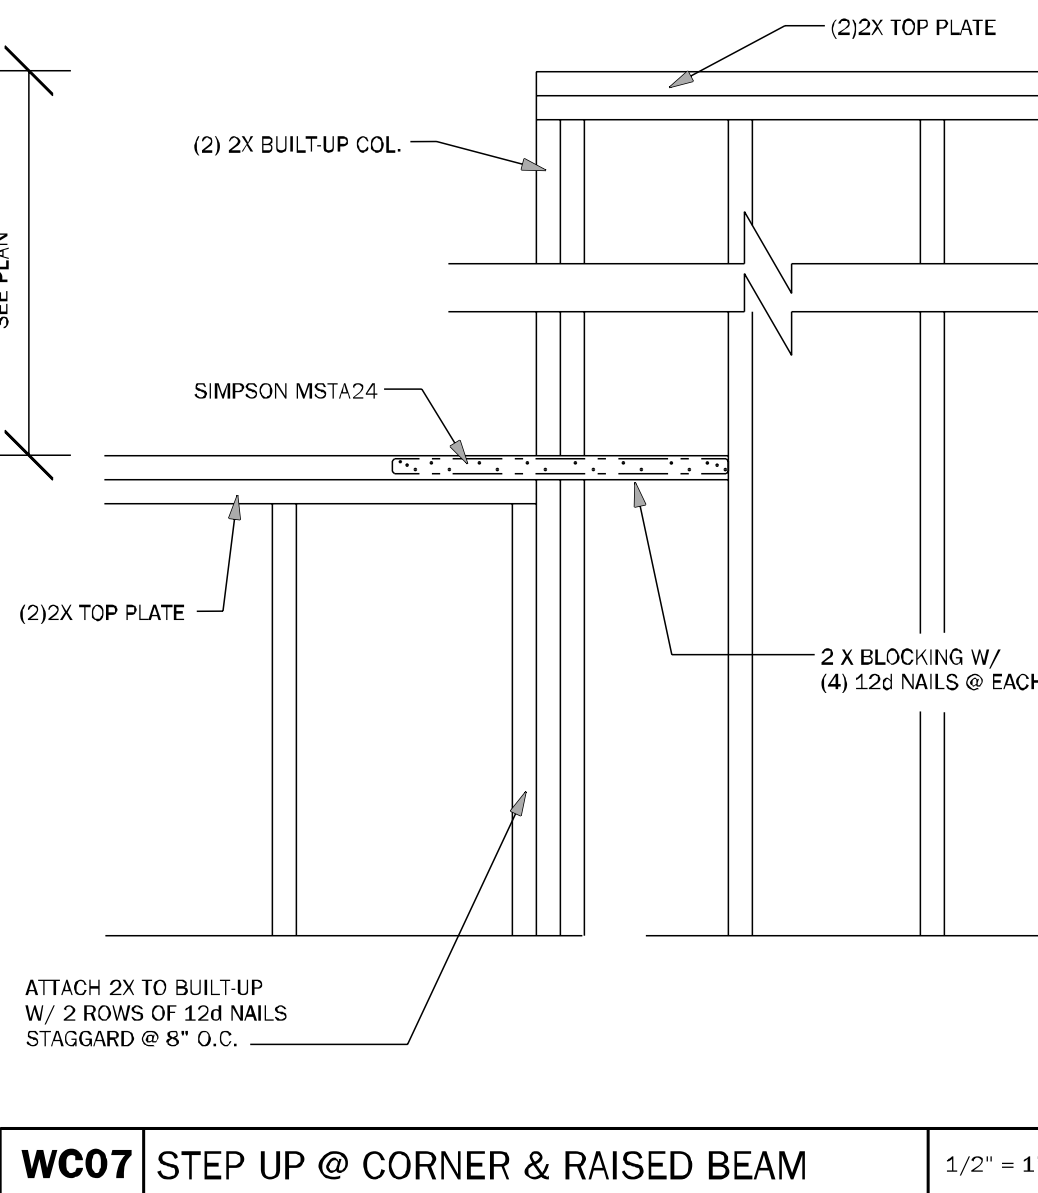

WC07 STEP UP @ CORNER & RAISED BEAM 1/2" = 1'-0"

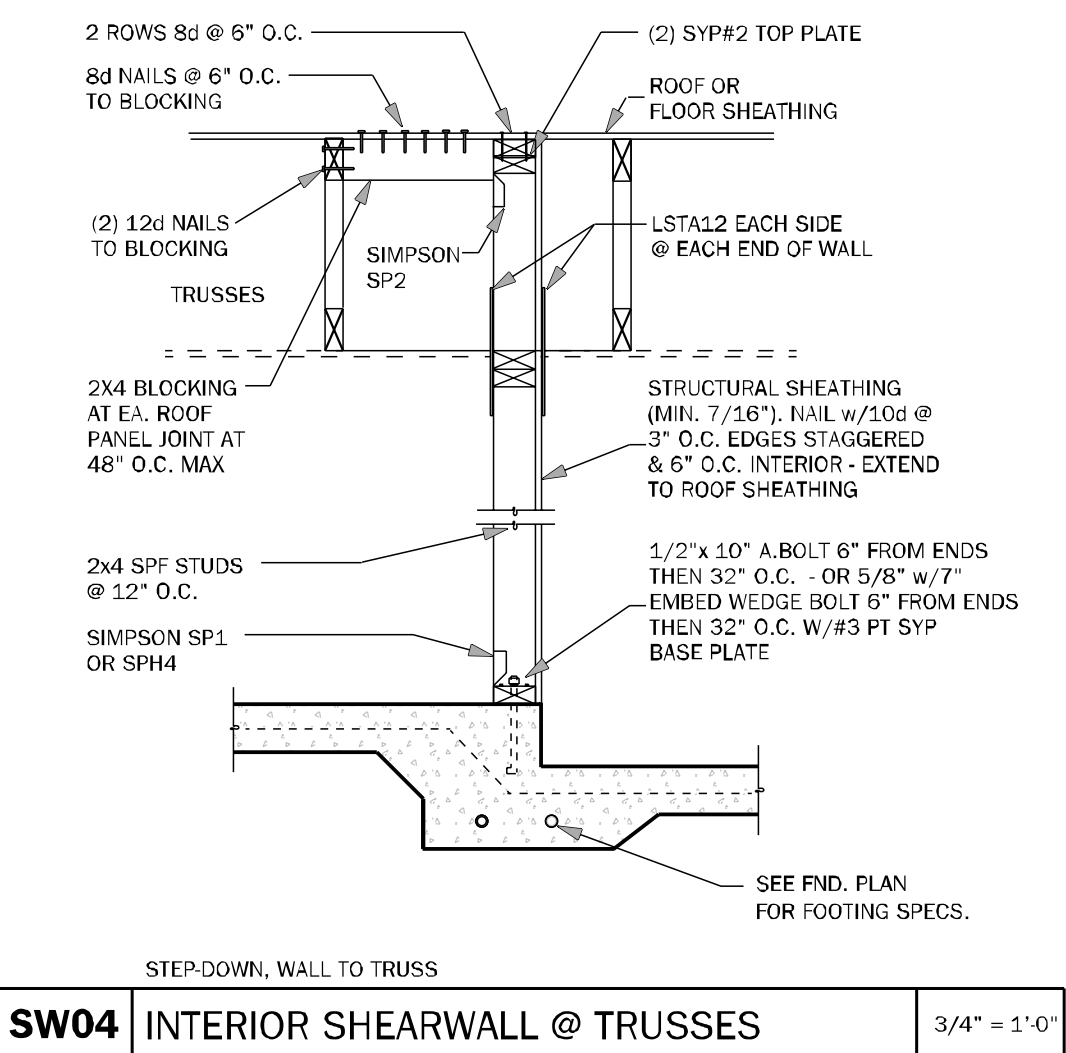

SW04 INTERIOR SHEARWALL @ TRUSSES 3/4" = 1'-0"

COUNTY
SEAL

keese
associates
ARCHITECTURE | DESIGN | PLANNING
2250 W. Highway 90, Suite 200
Gainesville, FL 32608
352.380.2355
gkeese.com

FDS
ENGINEERING ASSOCIATES
2250 W. Highway 90, Suite 200
Gainesville, FL 32608
352.380.2355
Certificate of Authorization No. 9481

AA2003115
C. CARL A. BROWN, P.E.
SCOTT A. LEWIS, P.E.
THAN BAO DUONG, P.E.

FL # 86128
FL # 78750
FL # 94452

DAMS HOMES
FLORIDA CONTRACTORS LICENSE NO. CRC1330148
100 WEST GARDEN STREET
PENSACOLA FL 32502

DIVISION LOCATION:
GAINESVILLE

Job Information:

INVENTORY
LOT: 92
BLK:
SEC:
SUB: Preserve of Laurel Lake
777 S.W. Rosemary Dr.
Lake City, FL

Model Name / Number:
2508



Plan Issue Date:
Thursday, September 26, 2024

KA PROJECT NUMBER:
24-12151

Sheet: **S-3** Of:


TYPICAL WALL DETAILS

Thursday, September 26, 2024

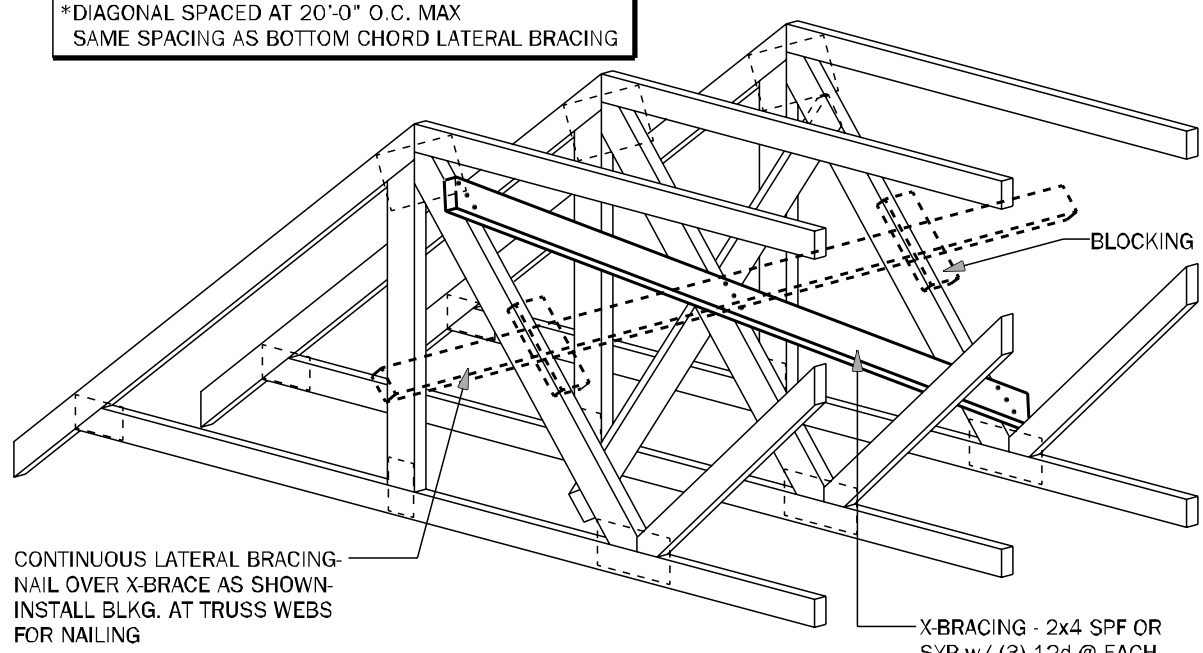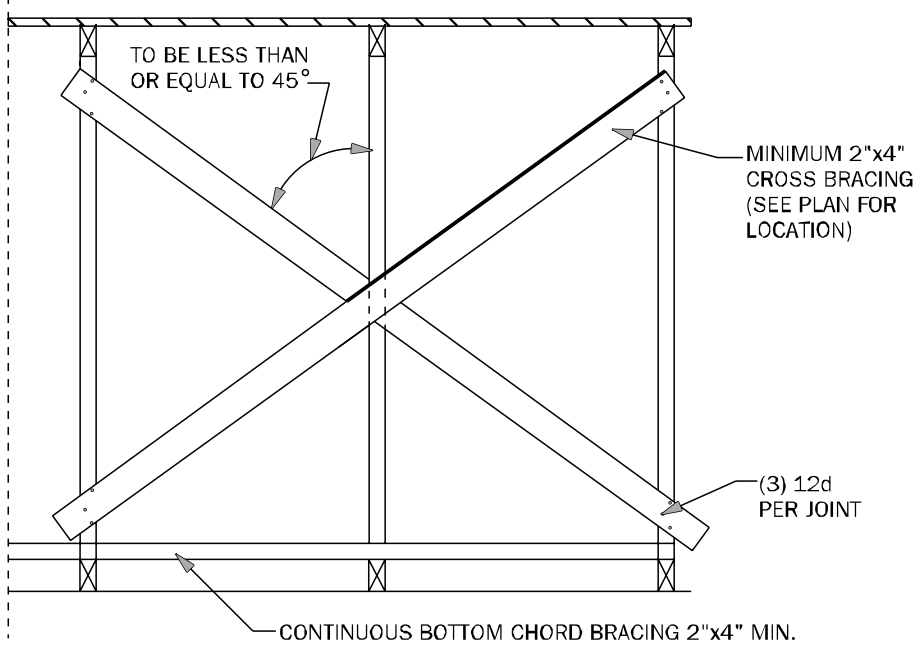


TB01 TYPICAL CROSS BRACING DETAIL N.T.S.

TB02 TYPICAL CROSS BRACING DETAIL N.T.S.

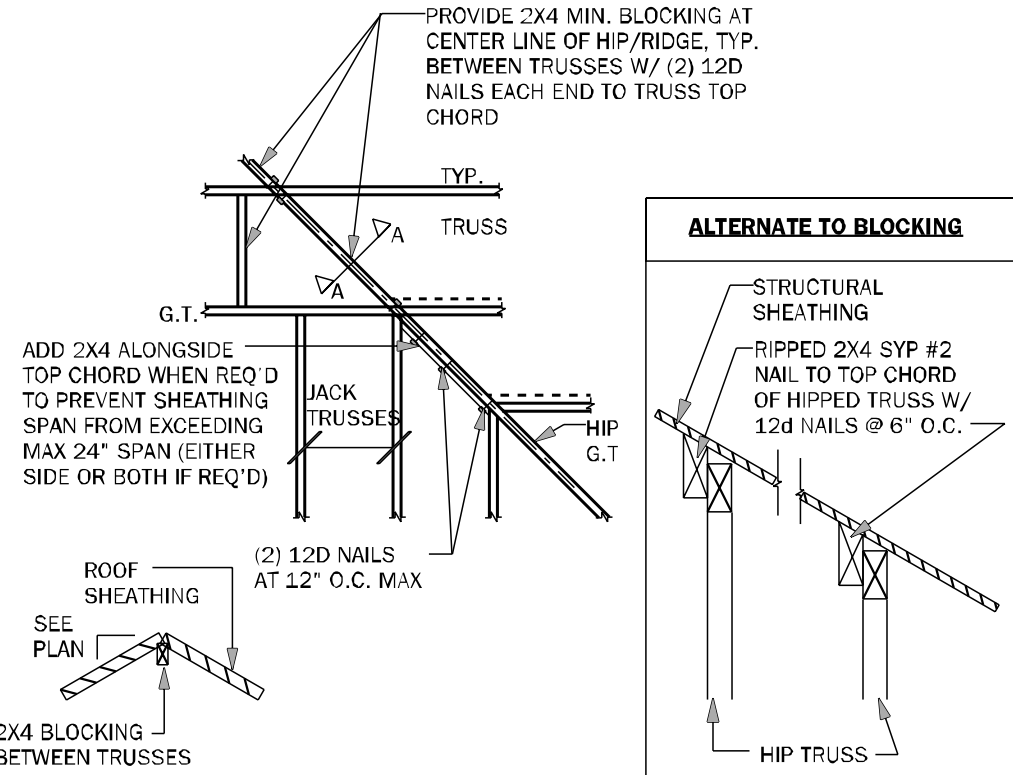




TB03 HIP / RIDGE BLOCKING DETAIL N.T.S.

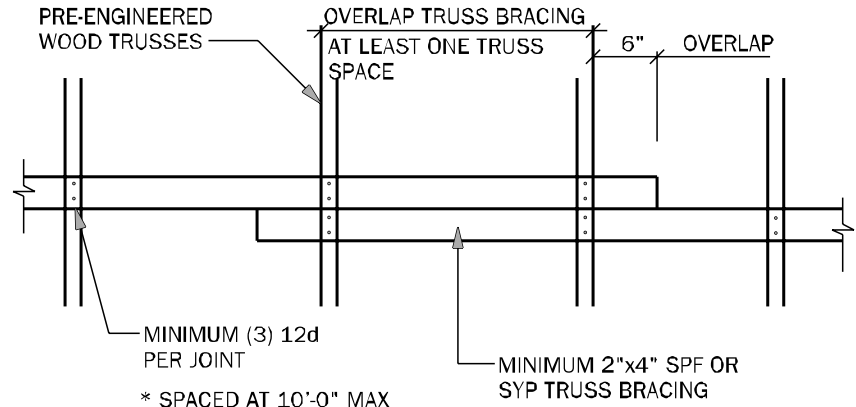

TB04 TRUSS BRACING OVERLAP DETAIL (TYP) N.T.S.

TRUSS NOTES:


- WOOD TRUSS ERECTOR SHALL PROVIDE BRACING ACCORDING TO ANSI/TPI-2014 (TRUSS PLATE INSTITUTE) NOTE THAT THE COMBINED WIND AREA IS GREATER BEFORE THE ROOF SHEATHING IS APPLIED, AND BRACING SHALL THEREFORE BE INSTALLED AS THE TRUSSES ARE ERECTED. INADEQUATE BRACING IS THE MOST COMMON CAUSE OF ACCIDENT IN WOOD TRUSS CONSTRUCTION. FULL BUNDLES OF SHEATHING SHALL NOT BE PLACED ON TRUSSES. THIS CONSTRUCTION LOAD SHOULD BE LIMITED TO 8 SHEETS OF SHEATHING ON ANY PAIR OF TRUSSES & SHALL BE LOCATED ADJACENT TO THE SUPPORTS. NO EXCESS CONCENTRATION OF ANY CONSTRUCTION MATERIAL (SUCH AS GRAVEL OR SHINGLES) SHALL BE PLACED ON THE TRUSSES IN ANY ONE AREA THEY SHALL BE SPREAD OUT EVENLY OVER A LARGE AREA SO AS TO AVOID OVERLOADING ANY ONE TRUSS.
- ALL BRACING (DB, CB, BB) SHOWN ABOVE SHALL BE IN ADDITION TO CONTINUOUS LATERAL BRACING SPECIFIED BY THE TRUSS MANUFACTURER. ALL LATERAL BRACING SPECIFIED BY TRUSS MANUF. SHALL HAVE ADDITIONAL DIAGONAL BRACES AT 20'-0" O.C. MAXIMUM.
- ALL BRACES SHALL BE 2X4 NOMINAL DIMENSION LUMBER & SHALL BE ATTACHED W/ (3) 12d NAILS AT EACH TRUSS INTERSECTION.
- ADDITIONAL BOTTOM CHORD BRACING SHALL BE INSTALLED AS REQUIRED BY TRUSS DESIGN WHEREVER ADEQUATE STRUCTURAL CEILING ARE NOT ATTACHED DIRECTLY TO THE BOTTOM CHORD OF THE TRUSS.
- PROVIDE TRUSS BLOCKING AT ALL TRUSS BEARING SUPPORTS WHERE TRUSS DEPTH EXCEEDS STANDARD HEEL HEIGHT. SEE TYP. TRUSS BLOCKING DETAILS.

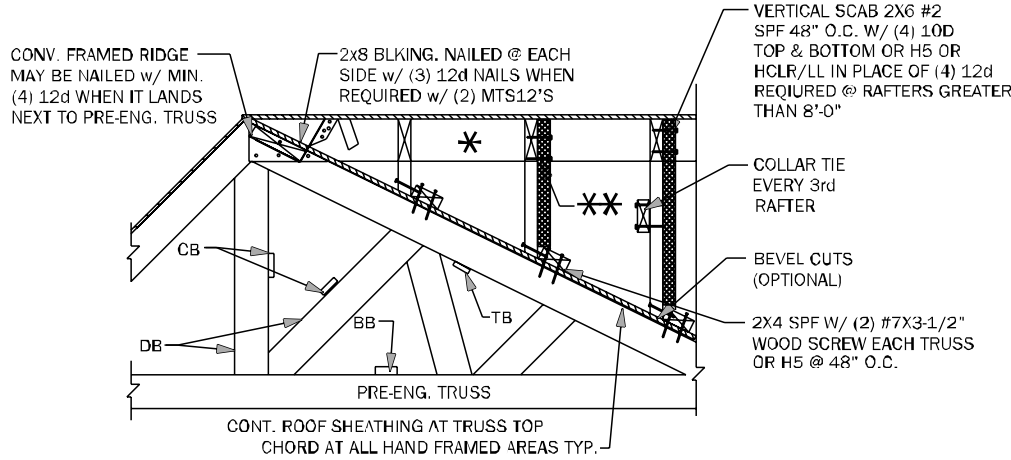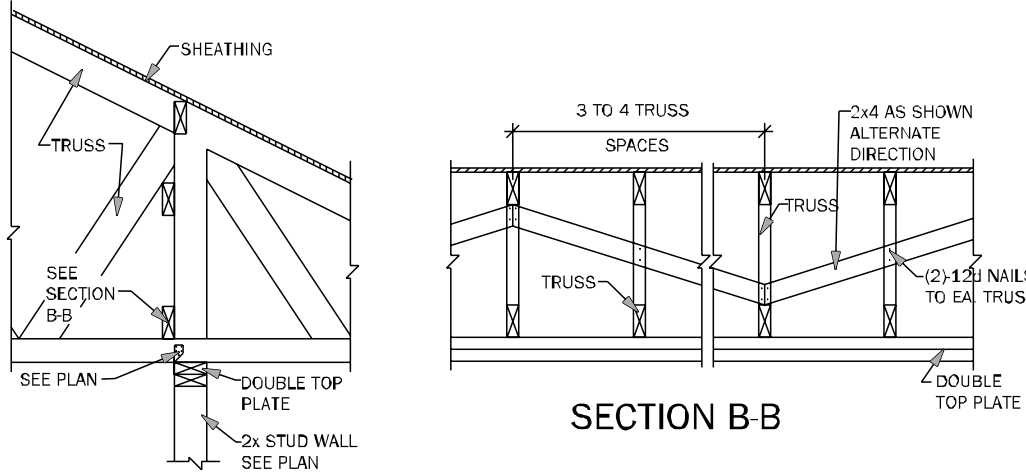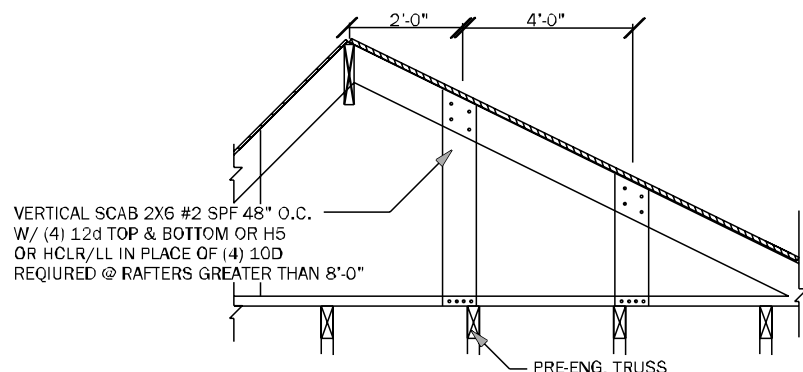


A-A ALTERNATE BLOCKING DETAIL @ INTERIOR BEARING

TB06 BLOCKING AND CONVENTIONAL FRAME DETAILS 3/4" = 1'-0"


THE HEIGHT OF THE CHIMNEY SHOULD EXTEND 2' ABOVE THE POINT WHERE THE CHIMNEY IS 10' FROM THE NEAREST BUILDING SURFACE.

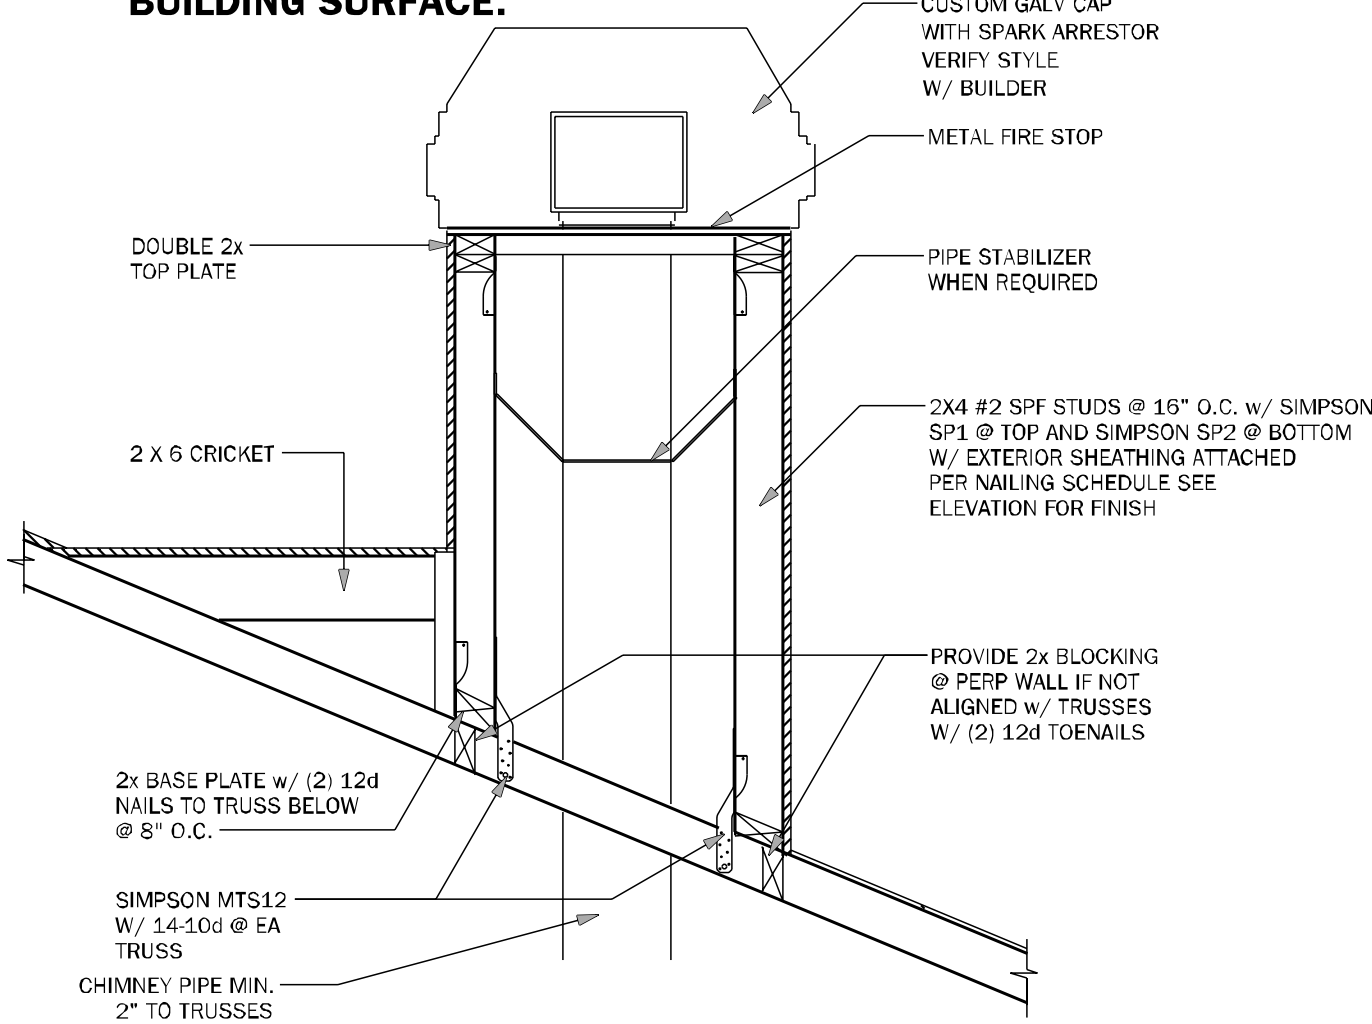


CH01 TYPICAL CHIMNEY FRAME DETAIL 3/4" = 1'-0"

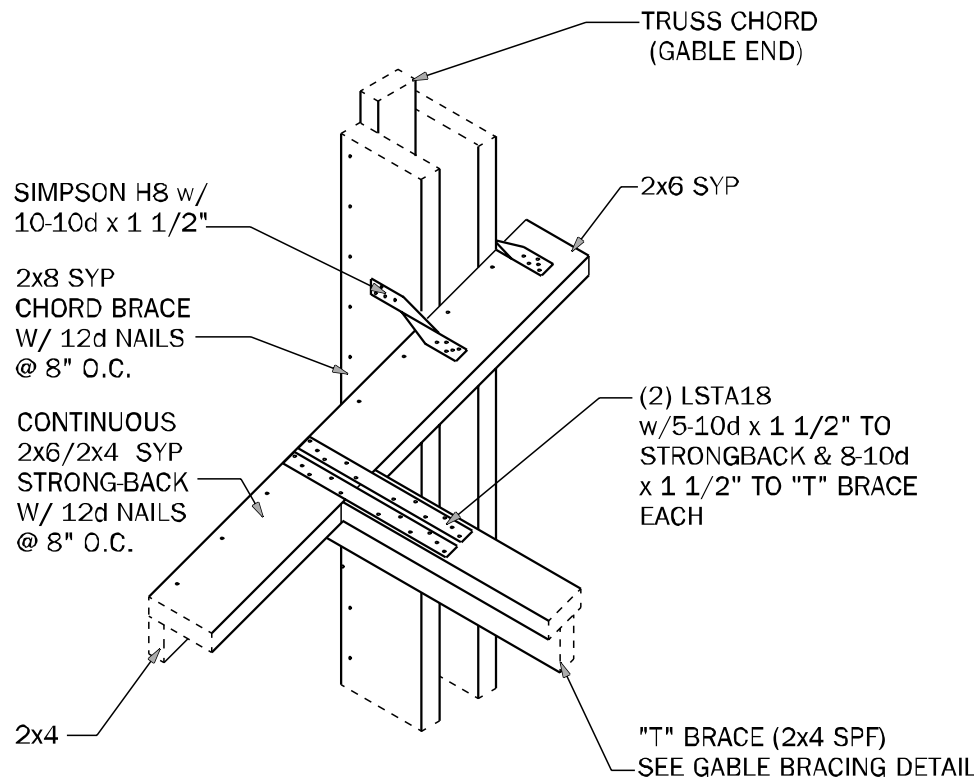

GE04 "T" BRACE CONNECTION @ GABLE END W/ VOLUME CEILING 3/4" = 1'-0"

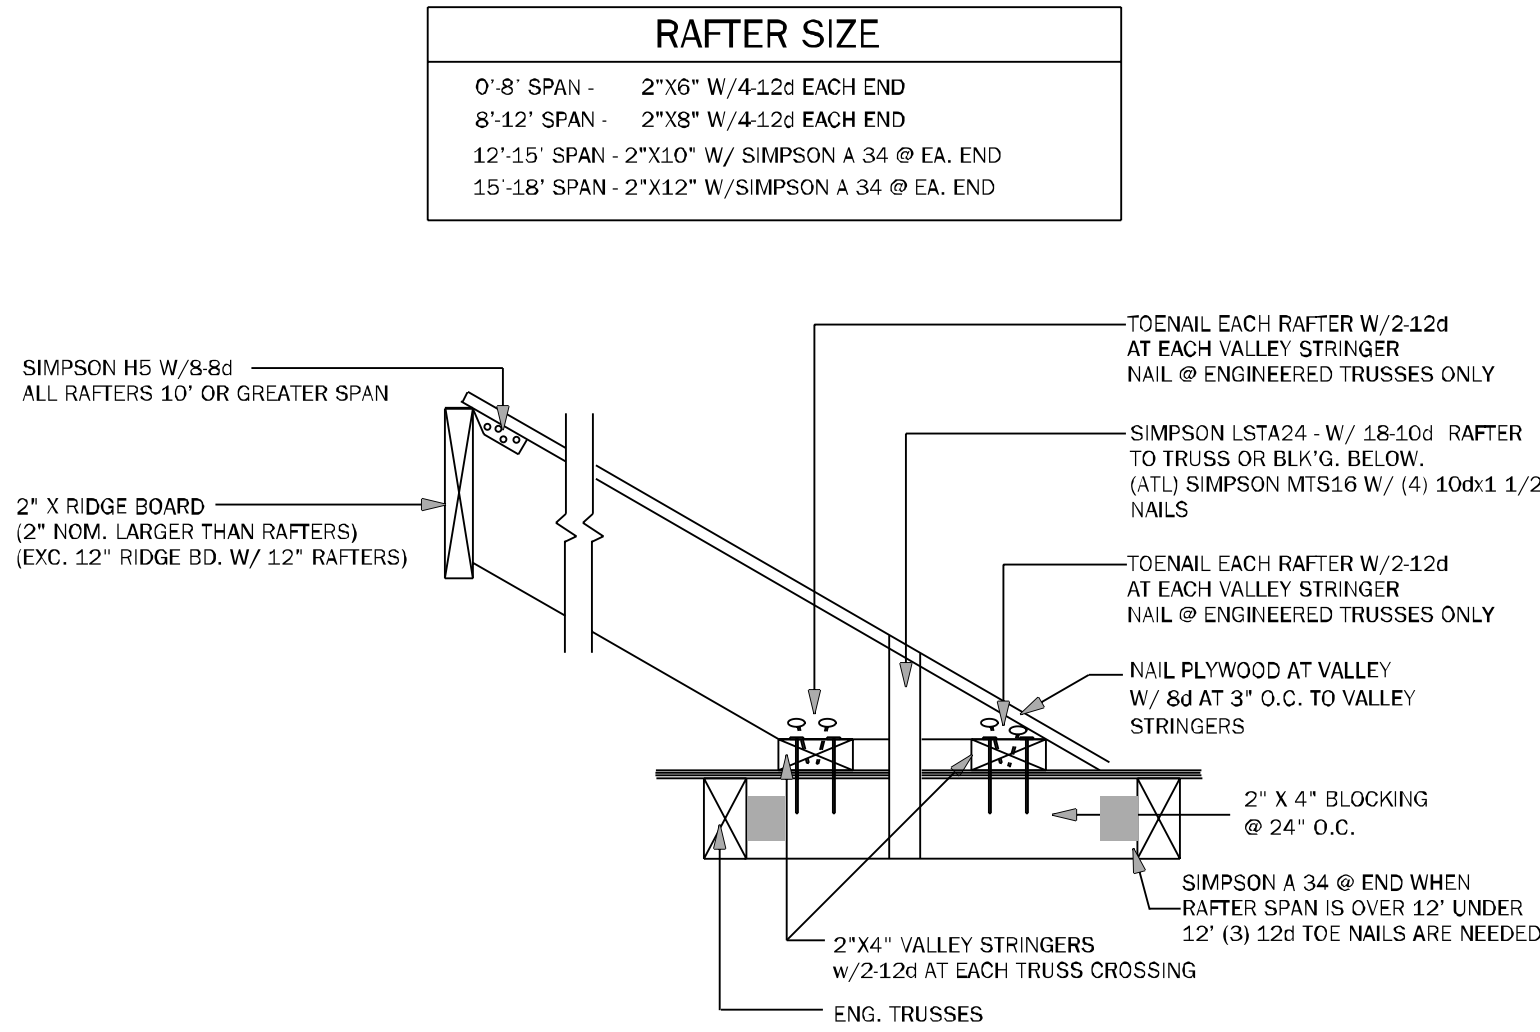

TB17 CONV. FRAMING & VALLEY FRAMING N.T.S.

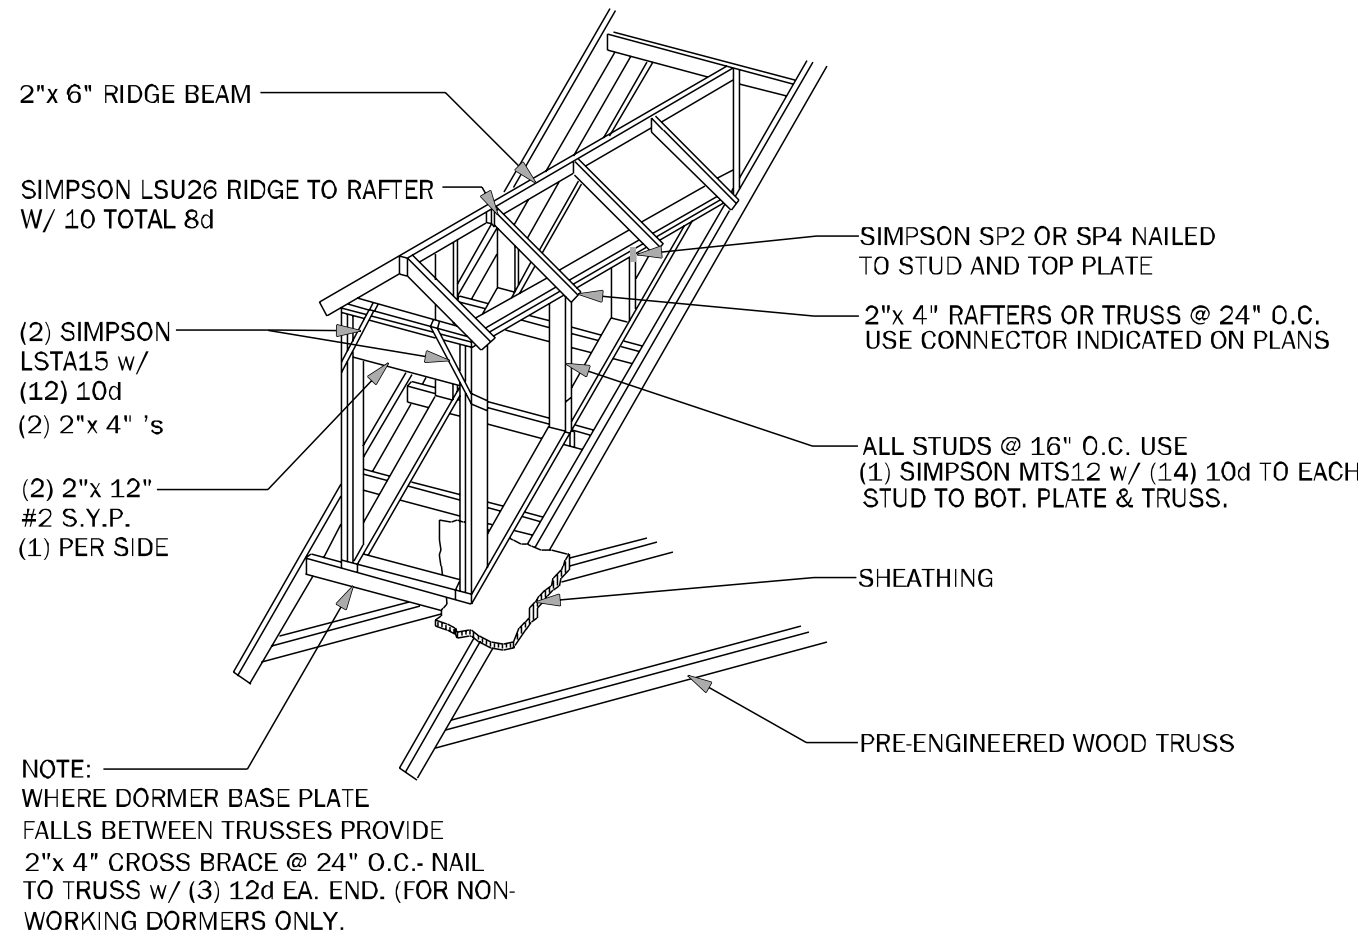

WF05 DORMER FRAMING DETAIL N.T.S.

COUNTY SEAL

To the best of the Engineer's knowledge, information, and belief, the structure shown on this plan complies with the applicable provisions of the Florida Building Code, and the design and construction of the structure is in accordance with the applicable provisions of the Florida Building Code. The Engineer does not warrant the accuracy or completeness of the information provided herein, and the user of this information assumes all liability for any errors or omissions.

FDS
ENGINEERING ASSOCIATES
2550 South Shoreline, Suite 200
Naples, FL 34109
P: 239.438.2304
F: 239.438.2305
www.fdseng.com

Keese
associates
ARCHITECTURE | DESIGN | PLANNING
2550 South Shoreline, Suite 200
Naples, FL 34109
P: 239.438.2304
F: 239.438.2305
www.keese.com

AA20003115
FL # 66126
FL # 78750
FL # 91452

☐ CARL A. BROWN, P.E.
☐ SCOTT A. LEWOWSKI, P.E.
☐ THEN BAO DUONG, P.E.

DAMS HOMES
FLORIDA CONTRACTORS LICENSE NO. CRC1330148
**100 WEST GARDEN STREET
PENSACOLA FL 32502**

**DIVISION LOCATION:
GAINESVILLE**

INVENTORY

LOT: 92
BLK:
SEC:
SUB: Preserve of Laurel Lake
777 S.W. Rosemary Dr.
Lake City, FL


Model Name / Number:
2508

Plan Issue Date:
Thursday, September 26, 2024


KA PROJECT NUMBER:
24-12151

Sheet: **S-4** Of:


**ROOF FRAMING
AND BRACING DETAILS**

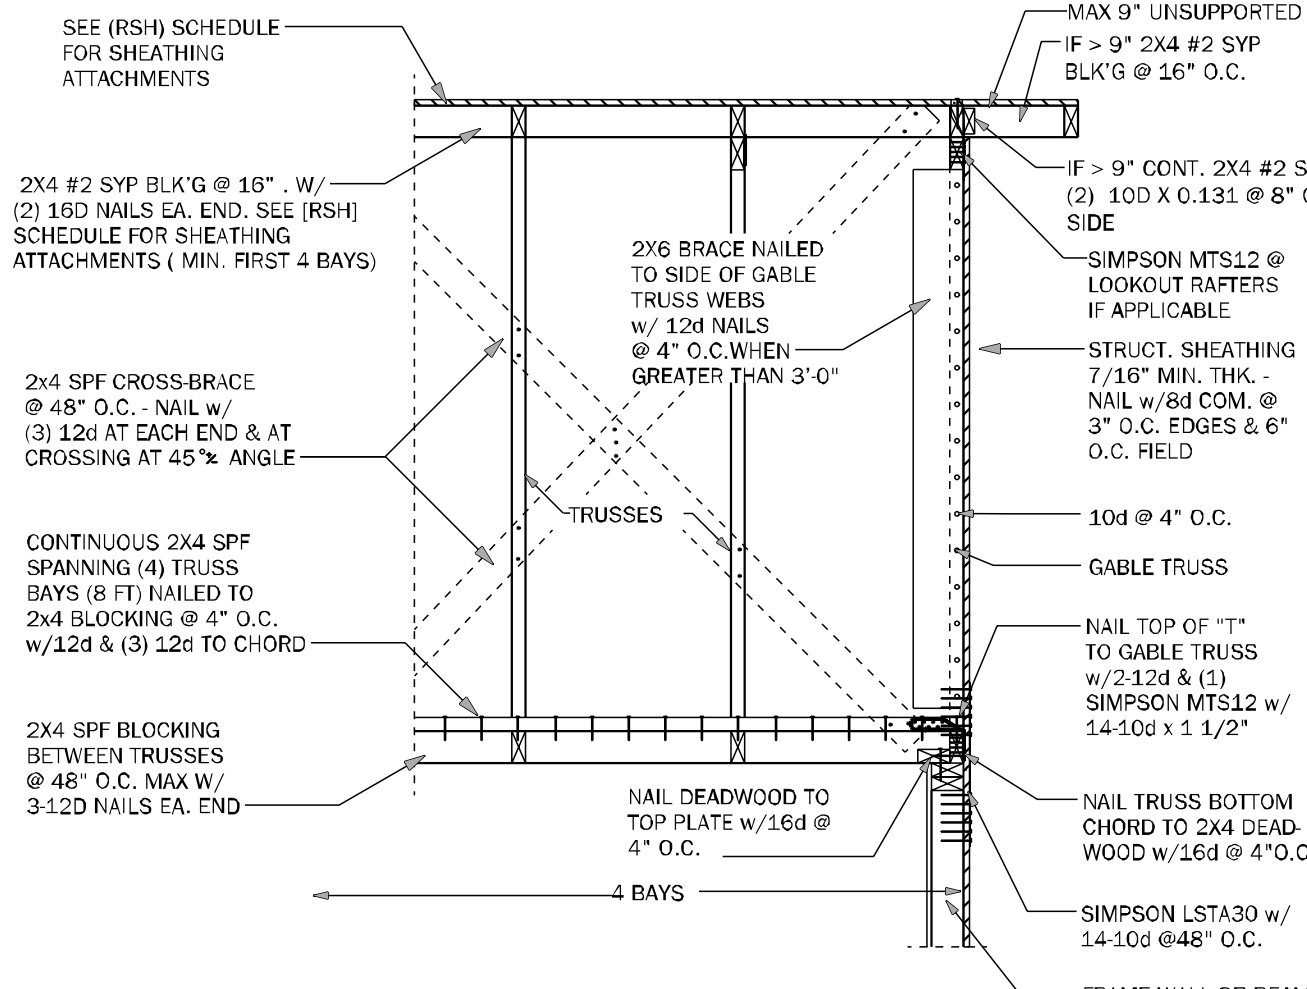


GE05 GABLE END BRACING - FRAME WALL N.T.S.

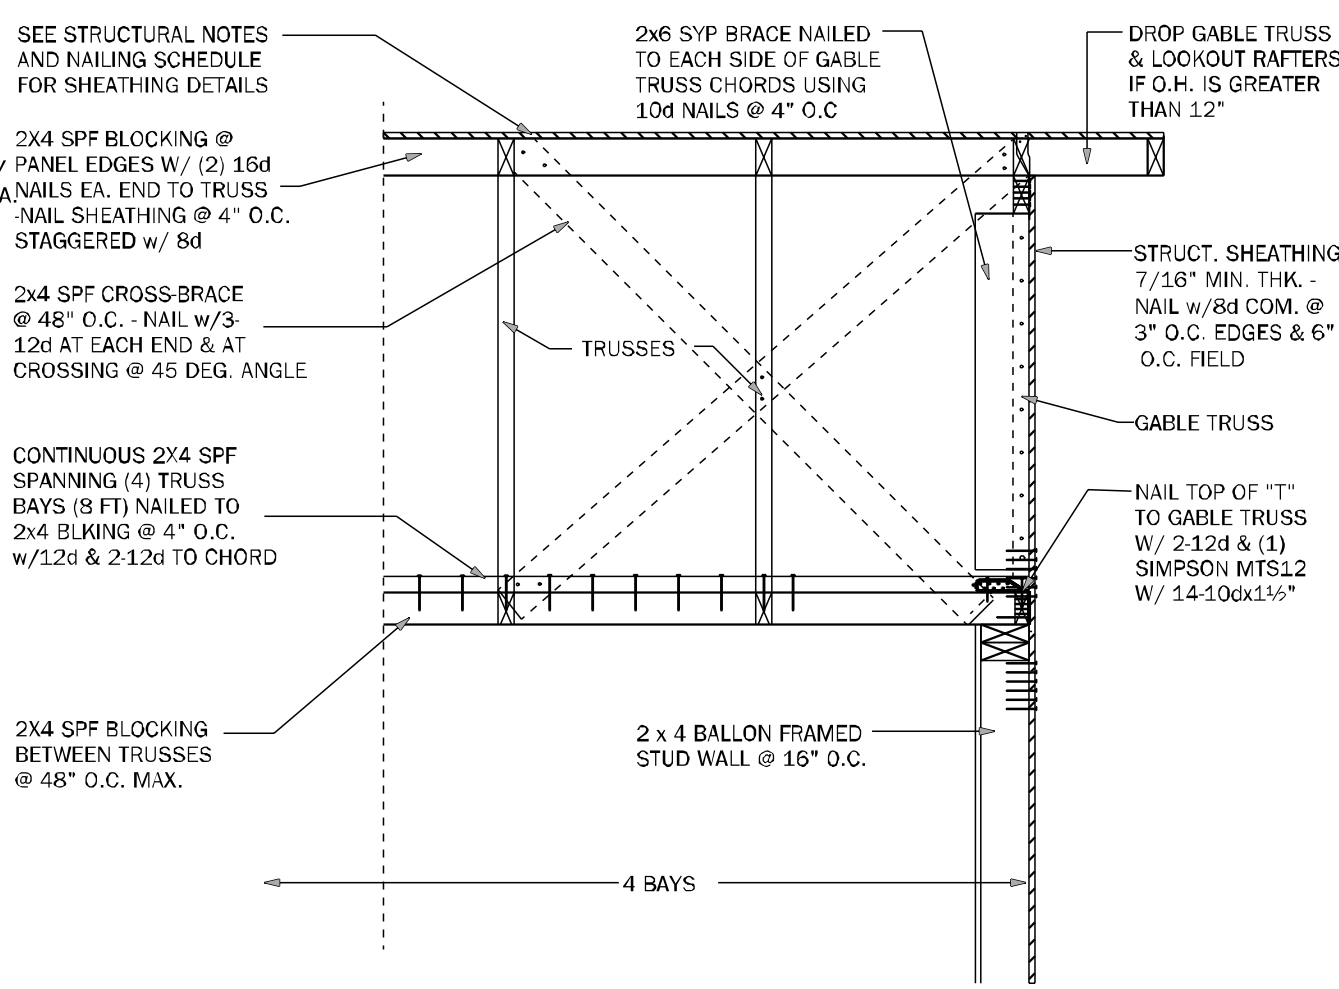


GE22 GABLE END BRACING w/ VOL CEILING 1/2"=1'-0"

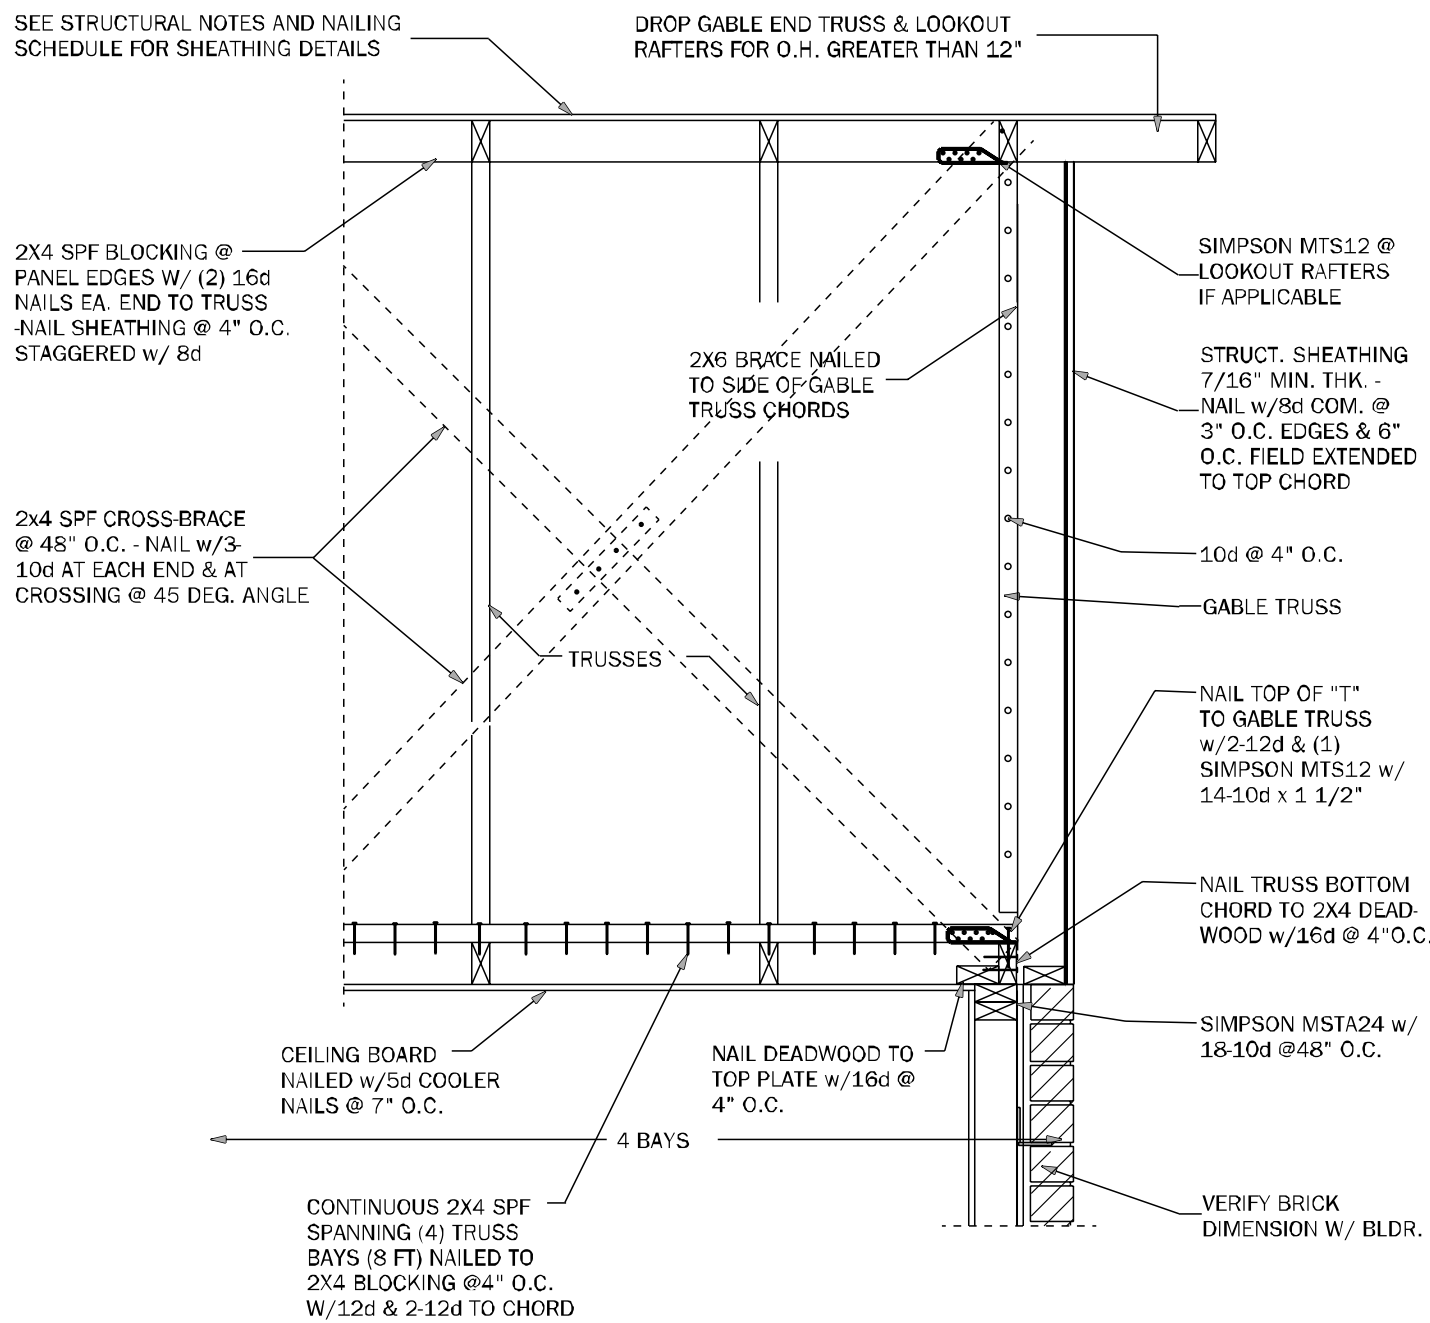


GE23 GABLE END BRACING w/o VOLUME CEILING 1/2"=1'-0"

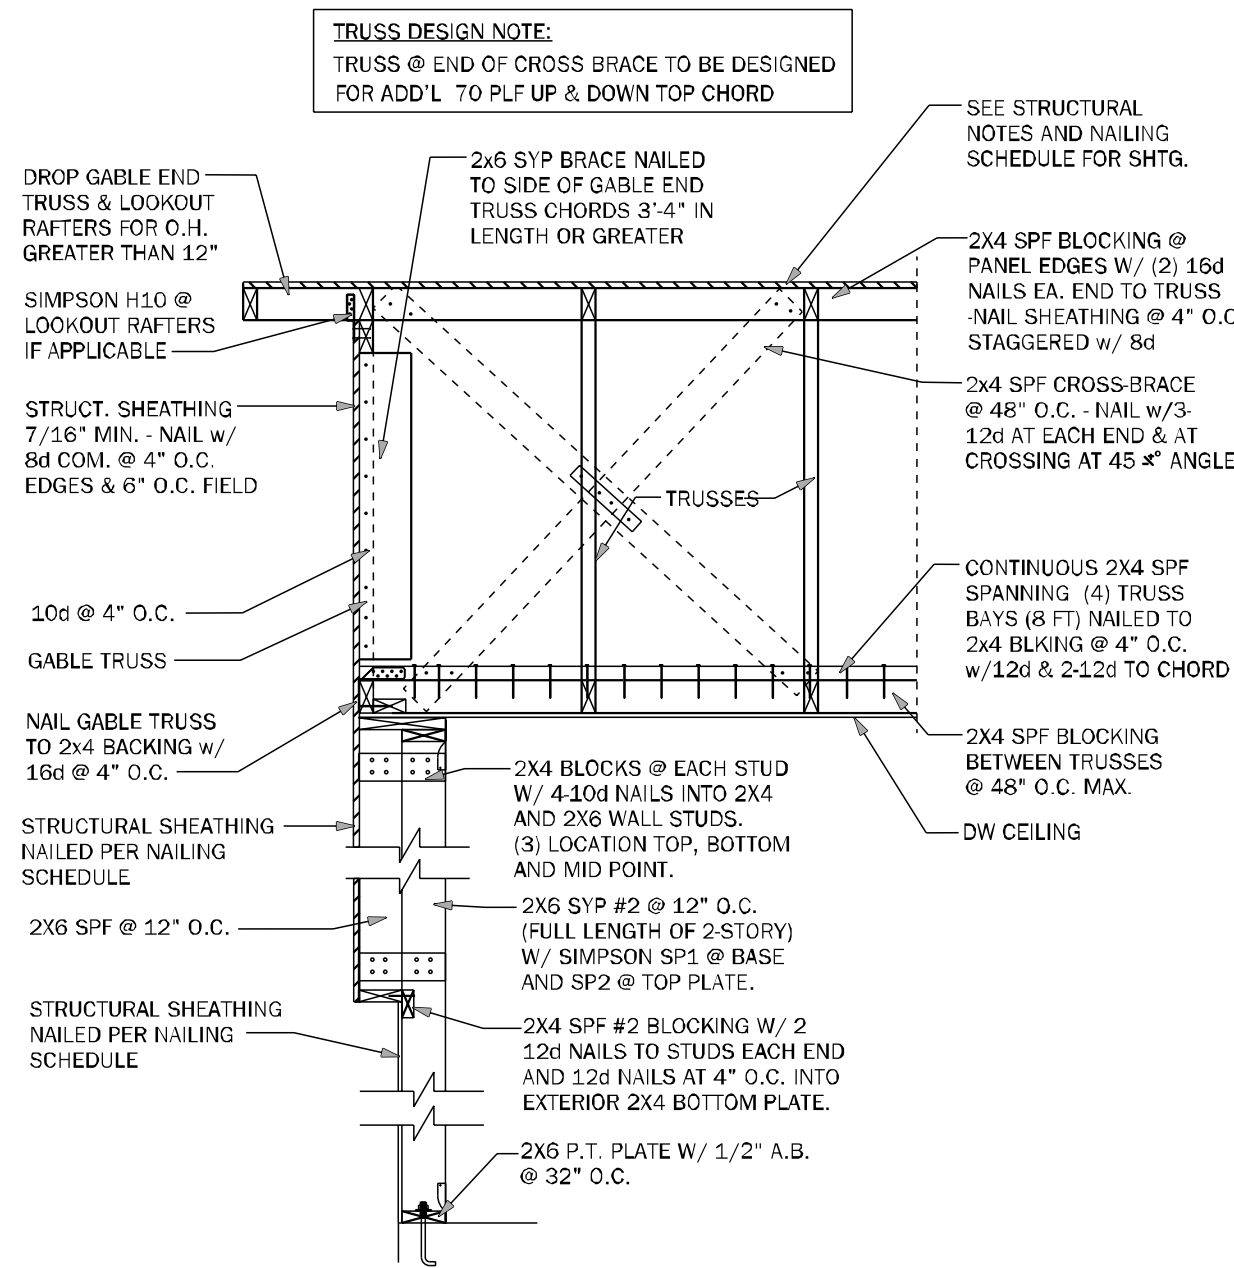


GE24 GABLE @ VAULT N.T.S.

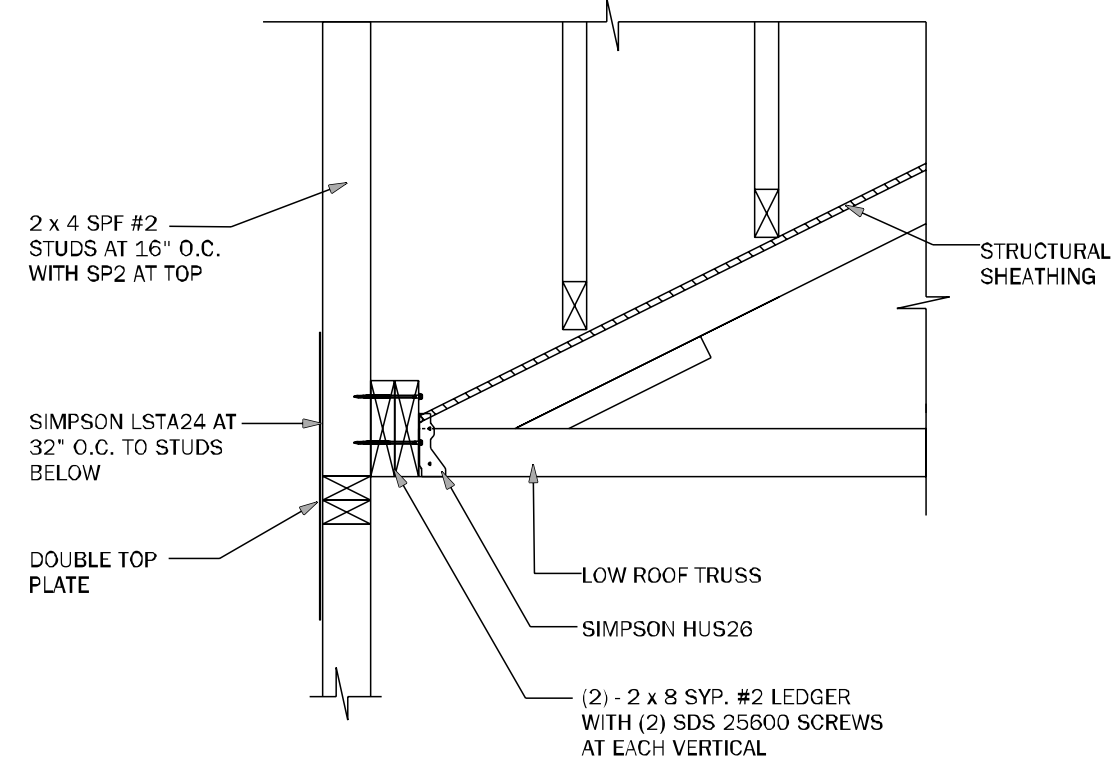


WF72 LEDGER N.T.S.

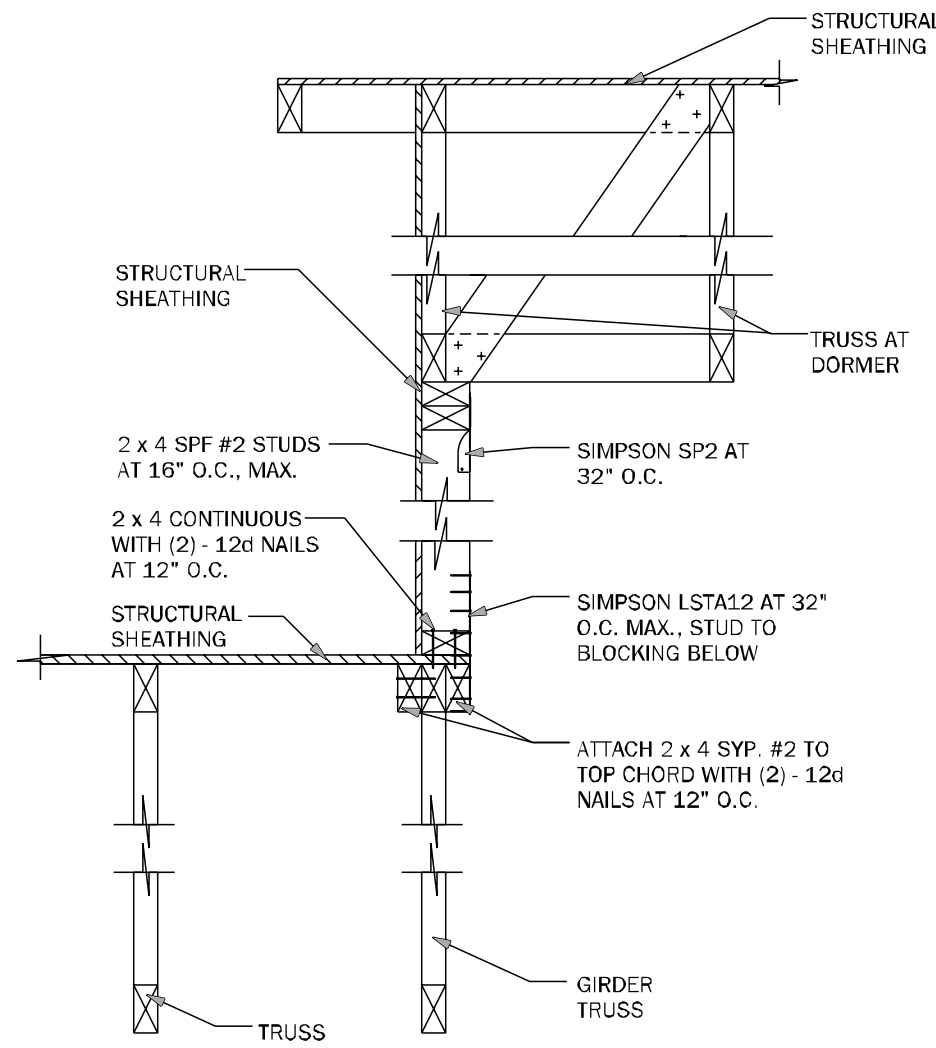


WF73 KNEEWALL @ DORMER N.T.S.

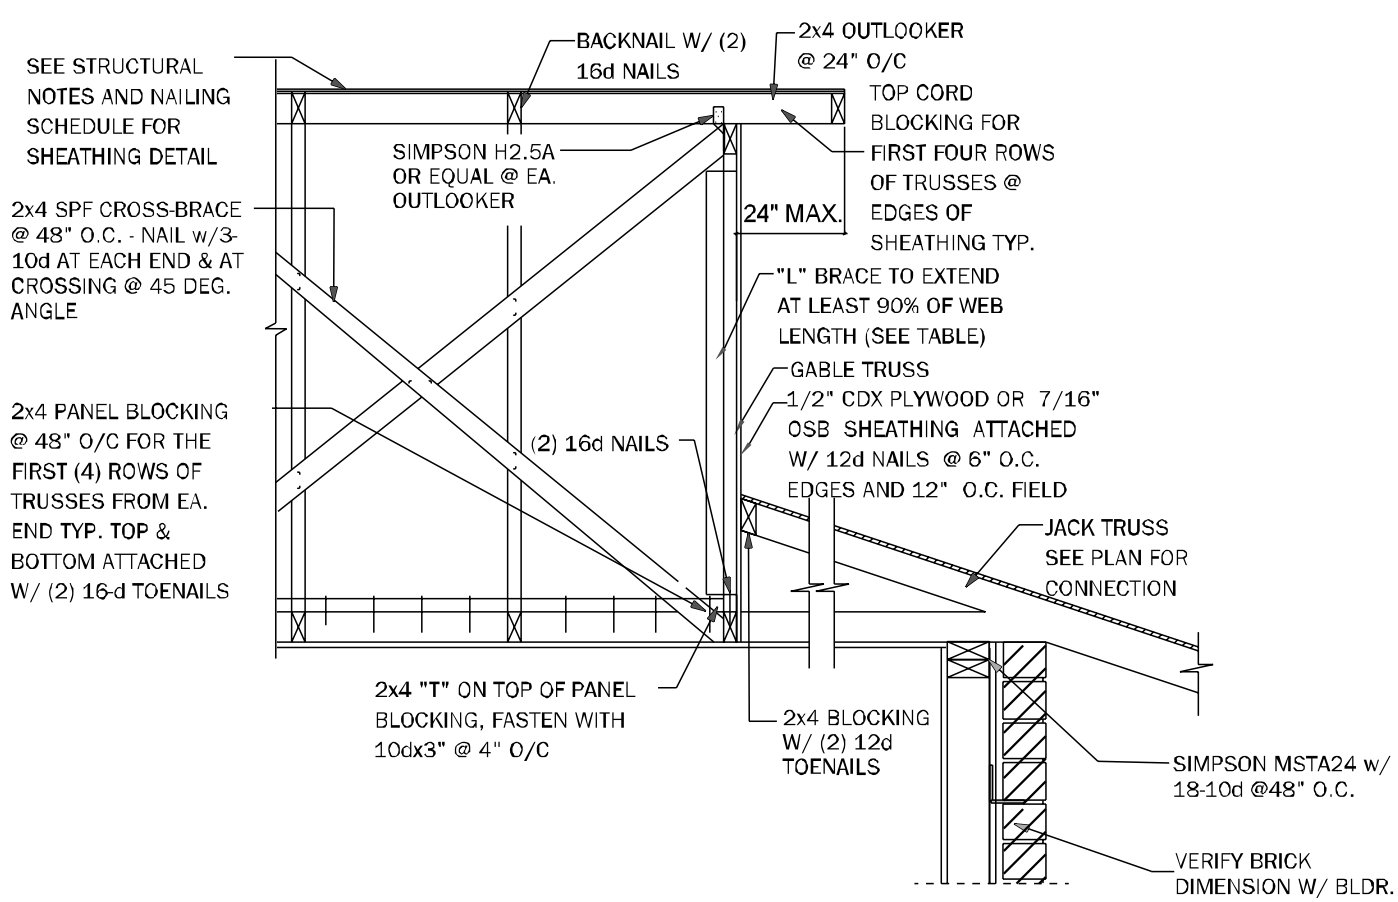



GE21 SECTION @ DUTCH GABLE 3/4"=1'-0"

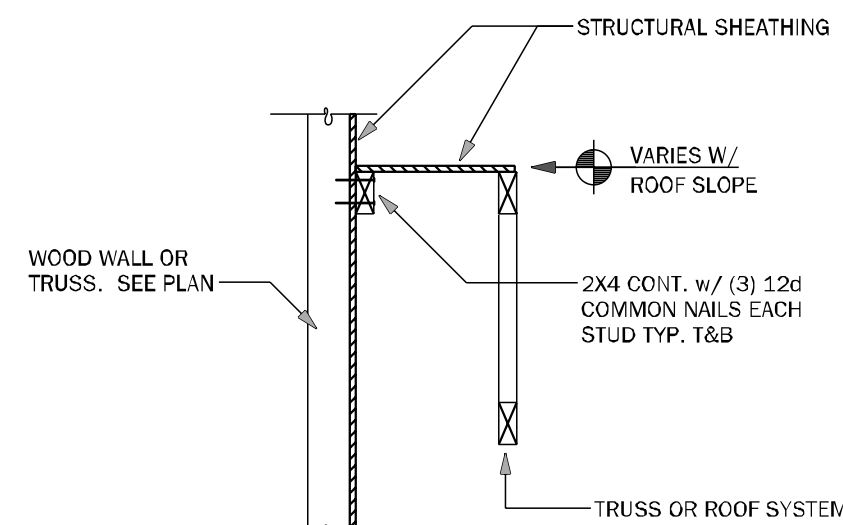

LD02 SHEAR TRANSFER EXTERIOR WALL N.T.S.

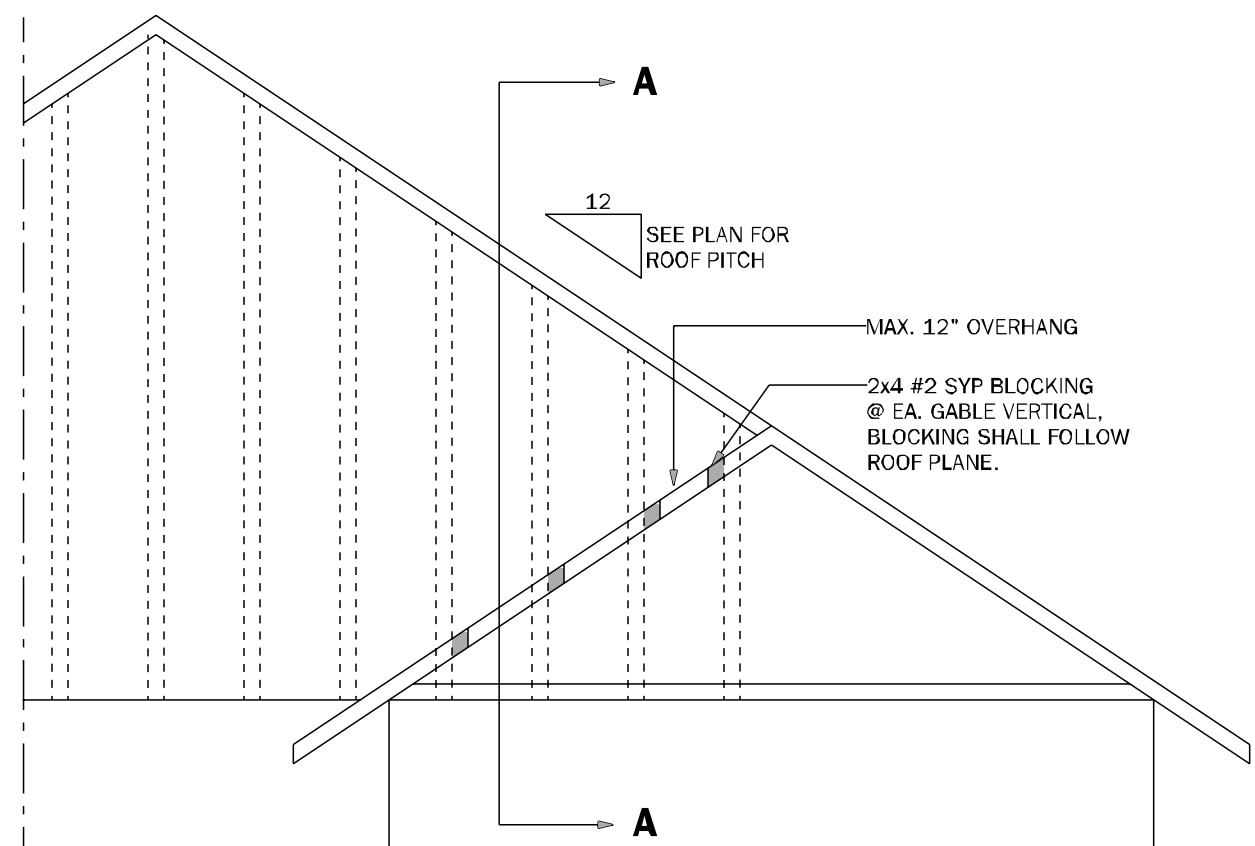

GE23.1 GABLE END OVERHANG 1/2"=1'-0"

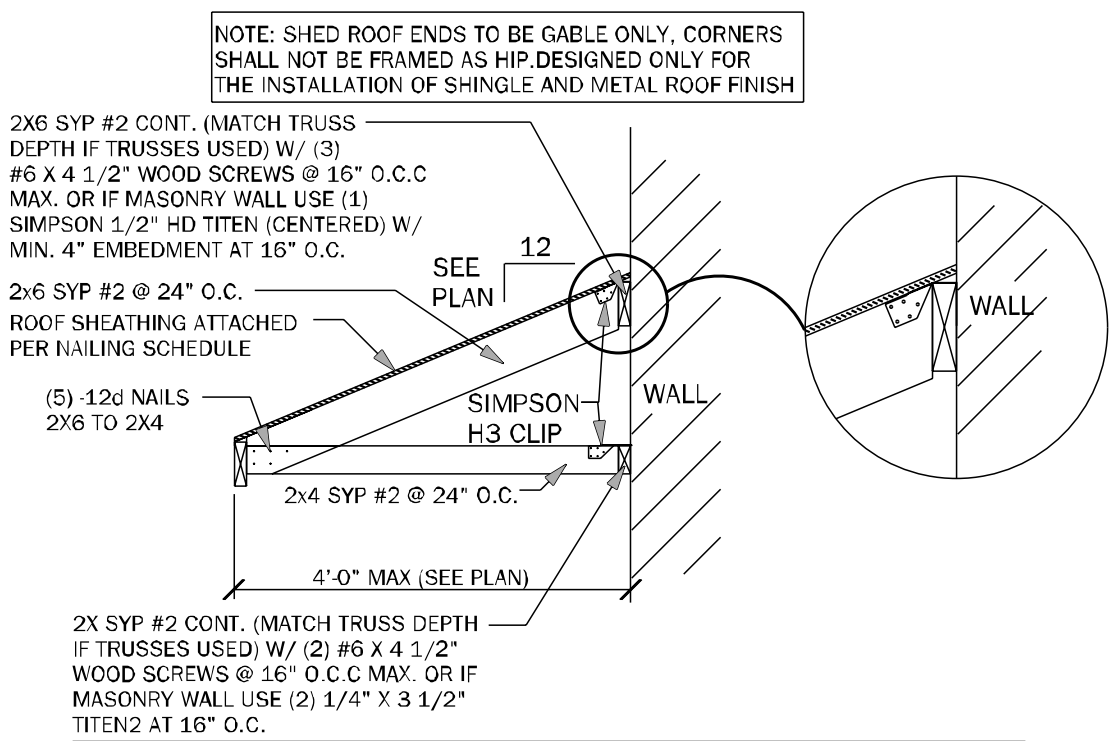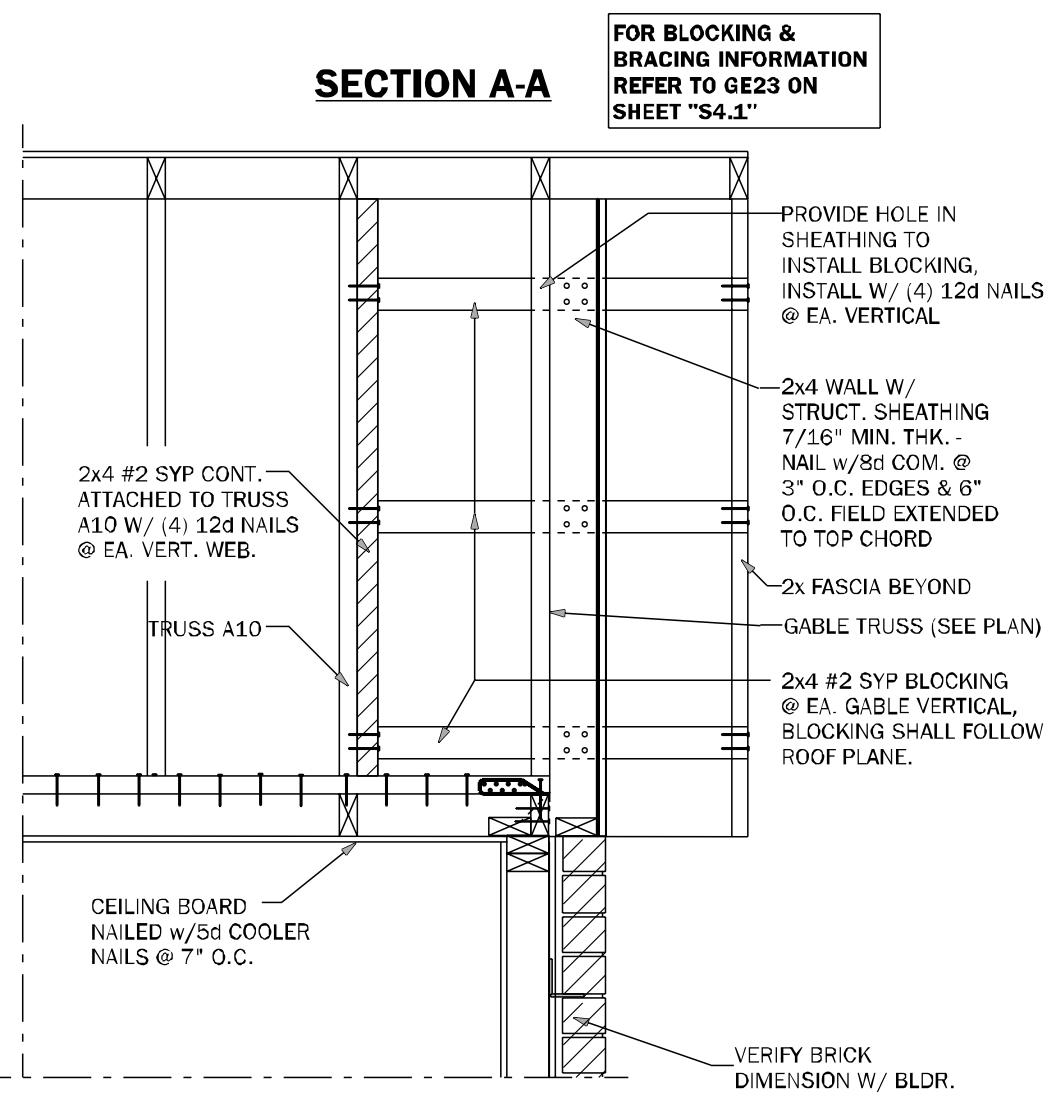

SR01 SECTION AT SHED ROOF 3/4"=1'-0"

COUNTY
SEAL

Thursday, September 26, 2024

To the best of the Engineer's knowledge, information, and belief, the design complies with all applicable codes, regulations, and standards, and no known conflicts exist with the current Florida Building Code. Engineer's signature and seal are not to be used for any project until the Engineer's registration is renewed.

FDS ENGINEERS ASSOCIATES
www.fdseng.com

22507 SBO 2353
gofdseng.com

255 South Lake Ave., Suite 200
Tallahassee, Florida 32309
O (904) 875-8800
F (904) 875-8801

Carl A. Brown, P.E.
Scott A. Lewkowksi, P.E.
Then Bao Clong, P.E.

FL # 89326
FL # 78750
FL # 94152

AA26003115

keesee associates
ARCHITECTURE | DESIGN | PLANNING
22507 SBO 2353
gofdseng.com

AA26003115

DAMS HOMES
FLORIDA CONTRACTORS LICENSE NO. CRC1330146
100 WEST GARDEN STREET
PENSACOLA FL 32502

DIVISION LOCATION:
GAINESVILLE

Job Information:

INVENTORY
LOT: 92
BLK:
SEC:
SUB: Preserve of Laurel Lake
777 S.W. Rosemary Dr.
Lake City, FL

Model Name / Number:
2508

Plan Issue Date:
Thursday, September 26, 2024

KA PROJECT NUMBER:
24-12151

Sheet: **S-4.1** Of:

ROOF FRAMING AND BRACING DETAILS

