
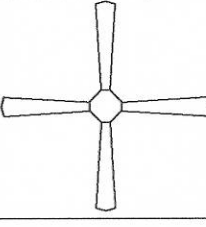


ELECTRICAL LEGEND	
	CEILING FAN (PRE-WIRE FOR LIGHT KIT)
	DOUBLE SECURITY LIGHT
	RECESSED CAN LIGHT
	BATH EXHAUST FAN
	LIGHT FIXTURE
	DUPLEX OUTLET
	220v OUTLET
	GFI DUPLEX OUTLET
	SMOKE DETECTOR (see note below)
	WALL SWITCH
	3 WAY WALL SWITCH
	WATER PROOF GFI OUTLET
	2 OR 4 TUB FLUORESCENT FIXTURE

NOTE:
ALL BEDROOM RECEPTACLES SHALL BE AFCI
(ARC FAULT CIRCUIT INTERRUPT)

ALL SMOKE DETECTORS SHALL HAVE BATTERY BACKUP POWER
AND ALL WIRED TOGETHER SO IF ANY ONE UNIT IS ACTUATED THEY
ALL ACTIVATE.

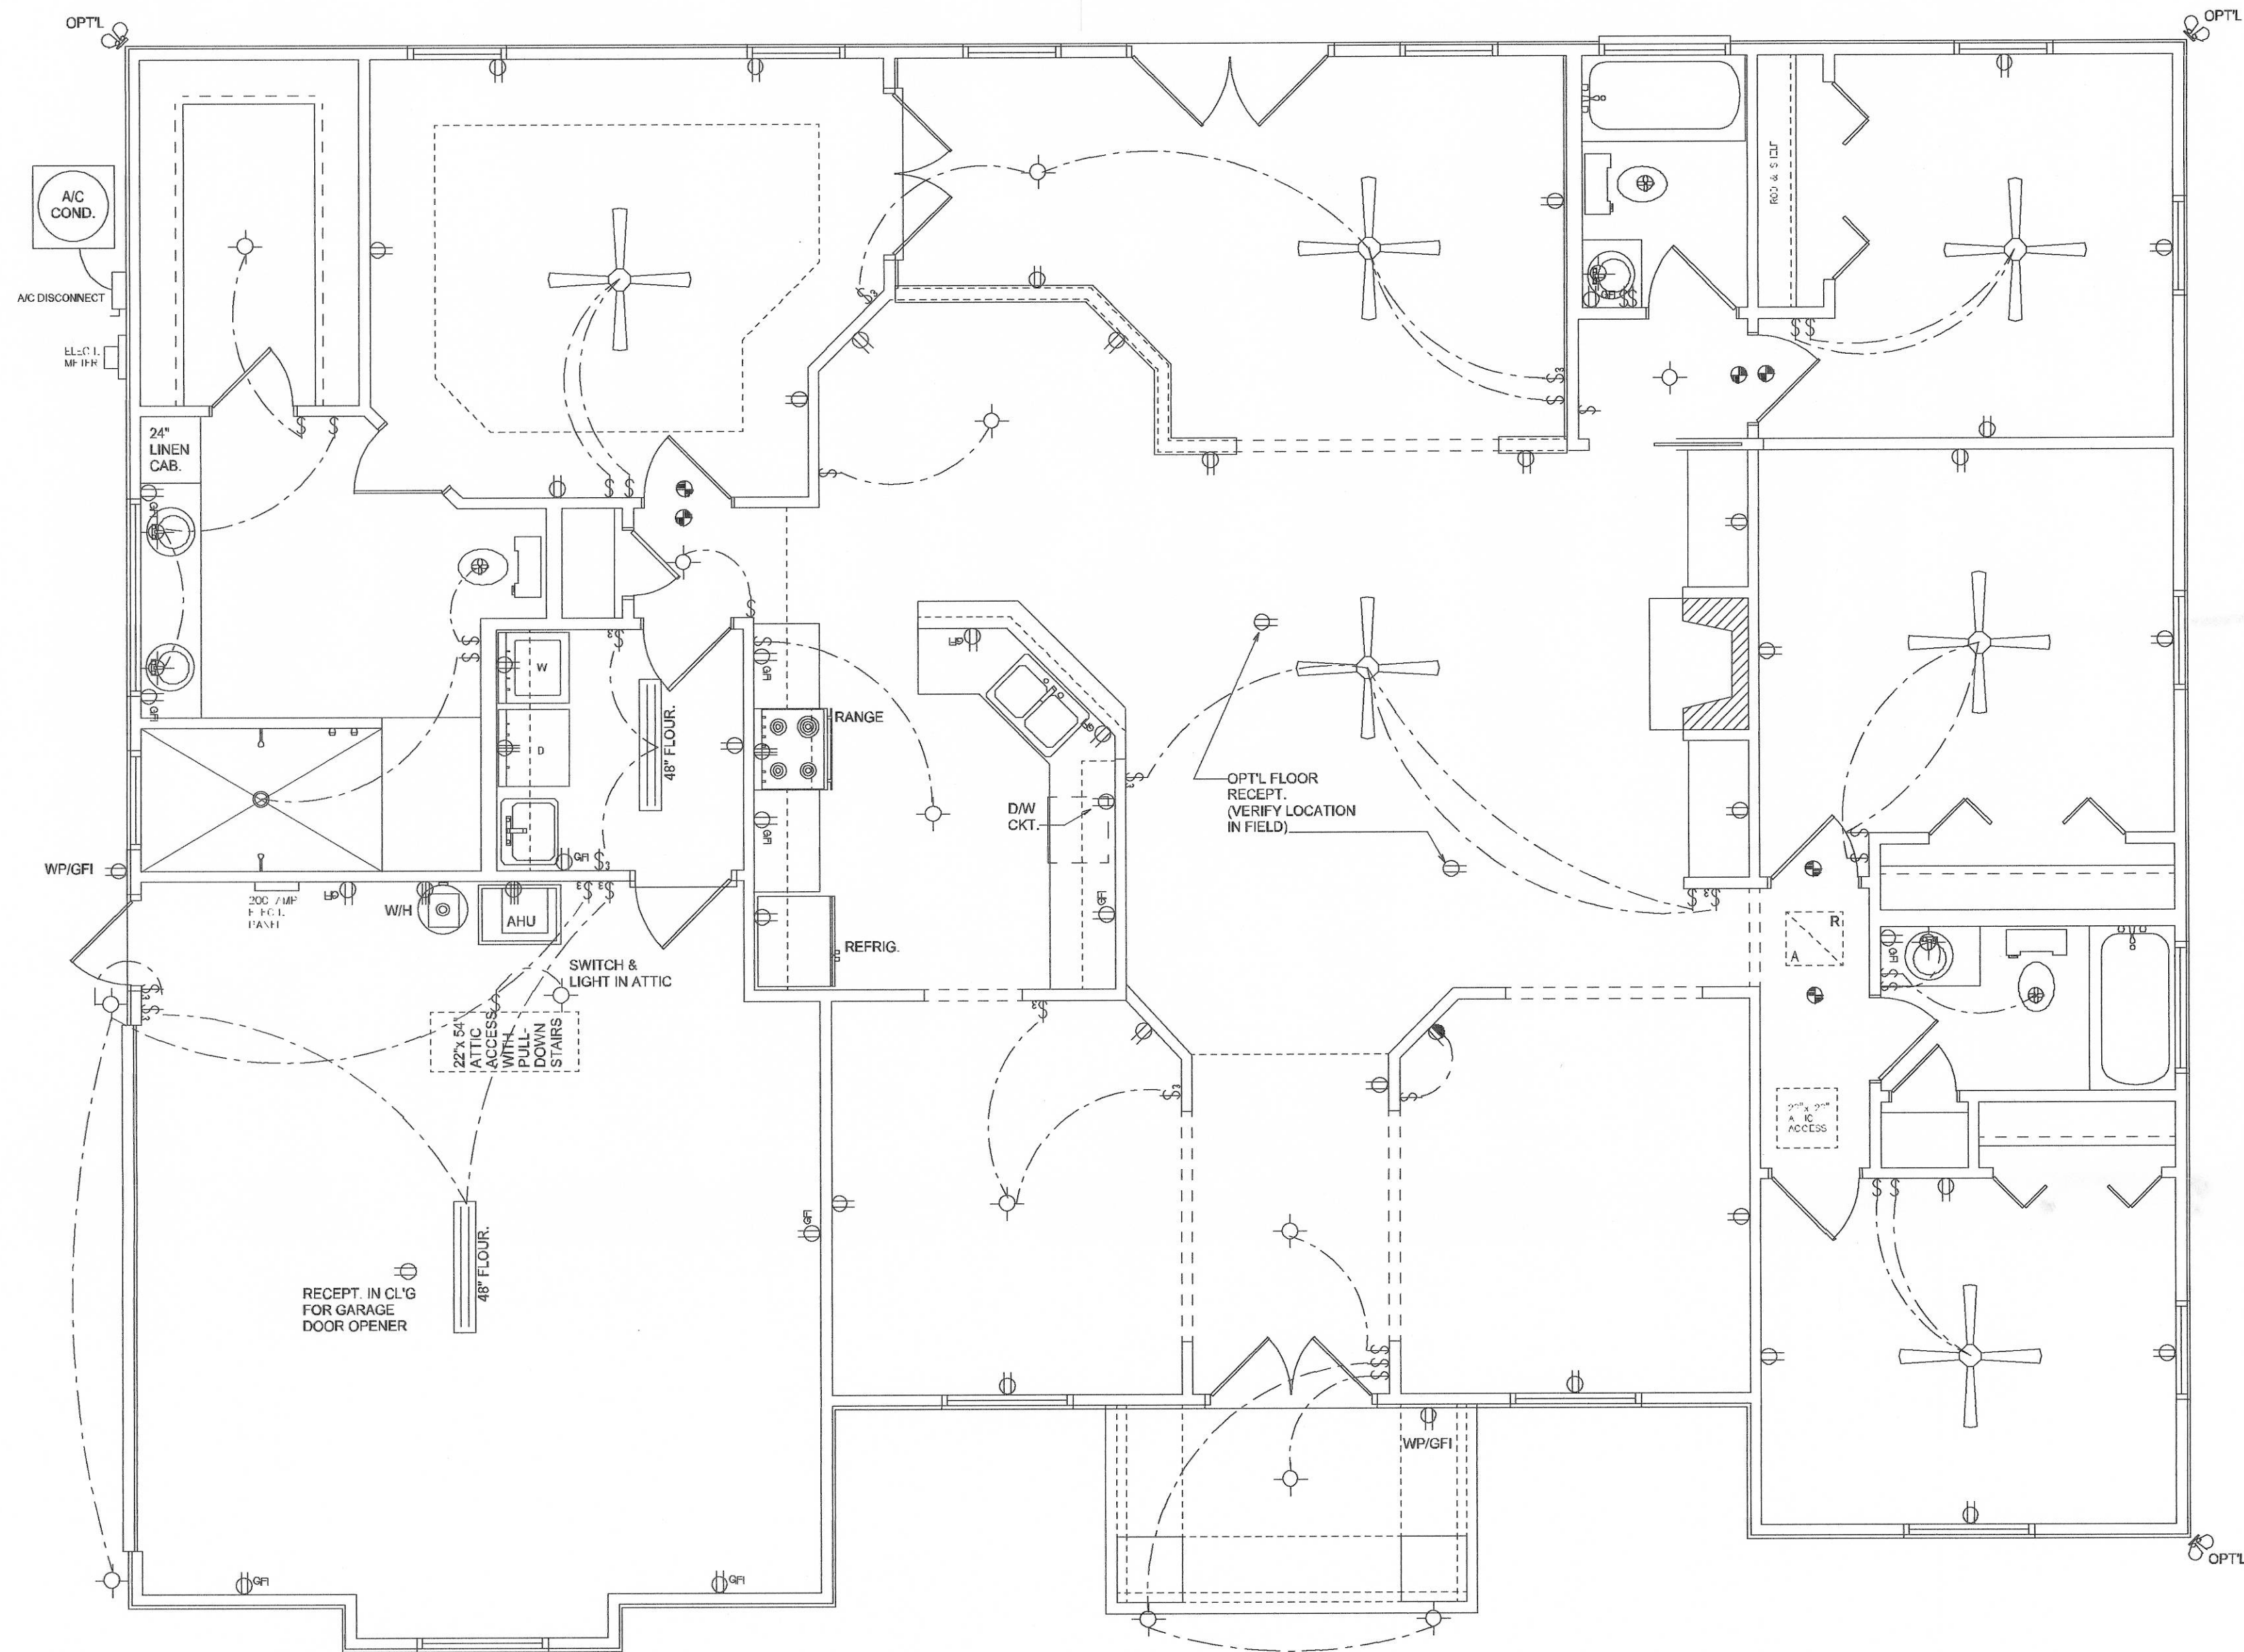

ELECTRICAL PLAN
SCALE: 1/4" = 1'-0"


REVISIONS
November 06, 2003

SOFTPLAN
WITH VIRTUAL DESIGN SOFTWARE

ELECTRICAL PLAN
SCALE: 1/4" = 1'-0"

A CUSTOM ASPEN MODEL FOR:
BOB & CAROLYN SHERIDAN
PROJECT ADDRESS: LOT 23, STARLAKE ESTATES, LAKE CITY, FLORIDA 32055
AARON SIMQUE HOMES, INC.
RT. 8 BOX 785-33, LAKE CITY, FLORIDA 32024

© WILLIAM MYERS
DESIGN
P.O. BOX 1513
LAKE CITY, FL 32055
(386) 758-8406
will@willmyers.net

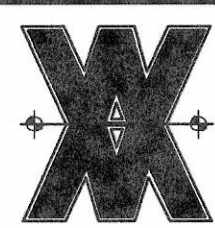

JOB NUMBER
031005

SHEET NUMBER
A4
OF 4 SHEETS

Will C. Myers