



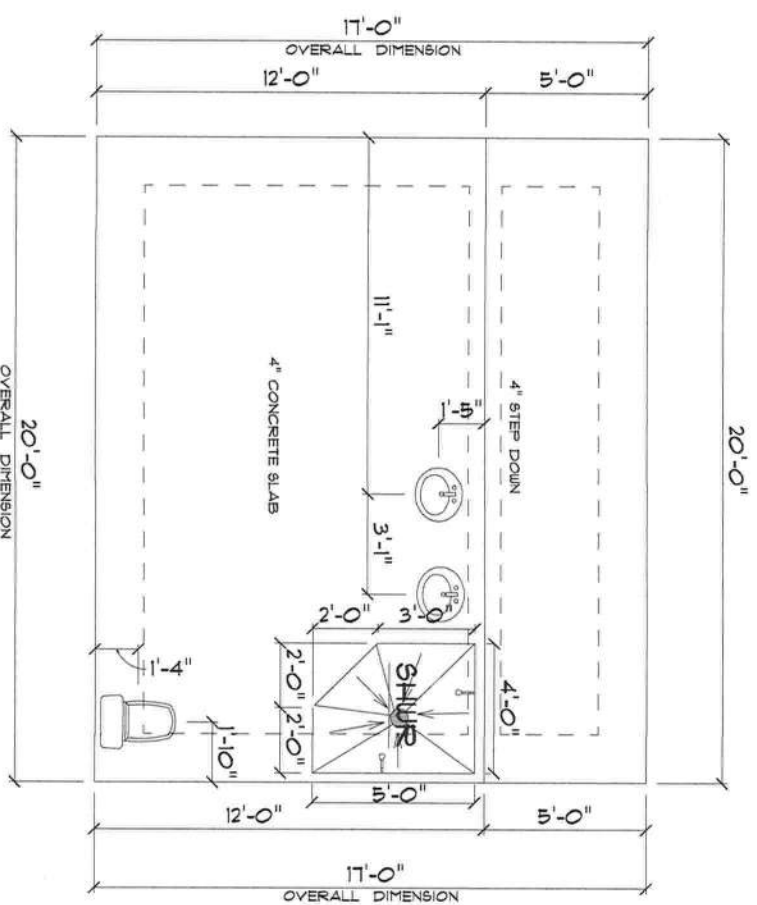

* PROPOSED PARTIAL *
* FOUNDATION/PLUMBING *
PLAN *

SCALE : 3/8" = 1'-0"

ADDITION for JAMES AND CINDY CLAYTON	
Teresa H. Ruffo 1205 5th Ave. N. Lake City, MN 55005 Cell: (360) 867-1193 Email: teresa@teresafor.com	
PRINTED DATE: Tuesday, July 27, 2021	
DRAWN BY: Teresa H. Ruffo	CHECKED BY: GLENWOOD KING
FILING DATE: JOS. NIPERN	
DRAWING NUMBER: A2	
OF 3 SHEETS	

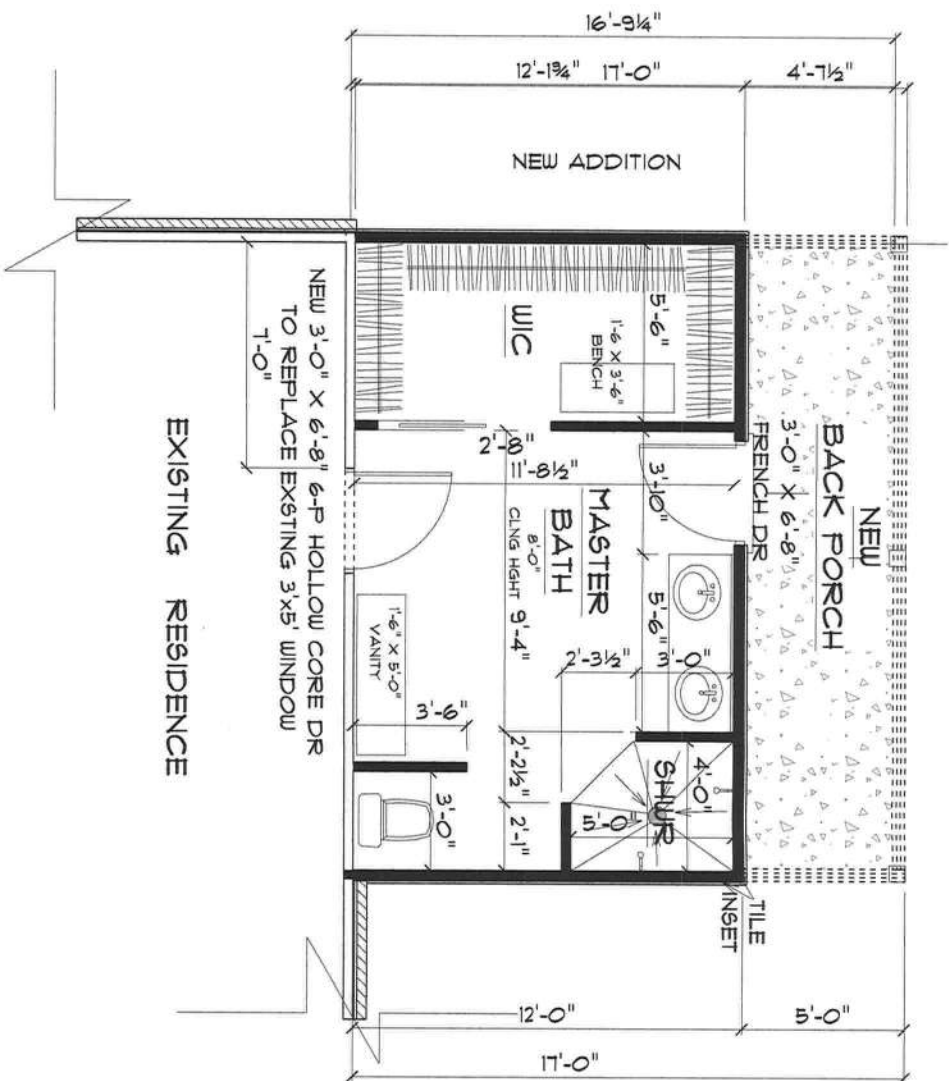

LEGEND	
EXISTING EXTERIOR WALL	
NEW INTERIOR WALL	
NEW 2x4 FRAME EXT WALL	6'-9"
NEW A/C COVERED AREA	= 240 S.F.
NEW NON-A/C COVERED AREA	= 100 S.F.
TOTAL NEW AREA UNDER ROOF	= 340 S.F.

* PROPOSED PARTIAL *

* FLOOR PLAN *

SCALE : 3/8" = 1'-0"

- IMPORTANT NOTES:
1. IT IS THE BUILDER'S RESPONSIBILITY TO VERIFY ALL GEOMETRY AND DIMENSIONS BEFORE ORDERING ANY MATERIALS OR BEGINNING CONSTRUCTION.
 2. THESE PLANS ARE FOR LAYOUT AND DESIGN PURPOSES ONLY. ALL STRUCTURAL NOTES AND DETAILS TO BE PROVIDED BY AN ENGINEER.

ADDITION
for
JAMES AND CINDY
CLAYTON

Travis H. Ruffo
2025 SW 4th St. #1
Lake City, Florida 32025
Cell: (904) 861-1101
Email: travis@travisruffo.com

PRINTED DATE:
Tuesday, July 27, 2021

DRAWN BY: CHECKED BY:
Travis H. Ruffo

FILING DESCRIPTION:
GLENWOOD KING


PLANS DATE:

JOB NUMBER:

DRAWING NUMBER


A3

OF 8 SHEETS

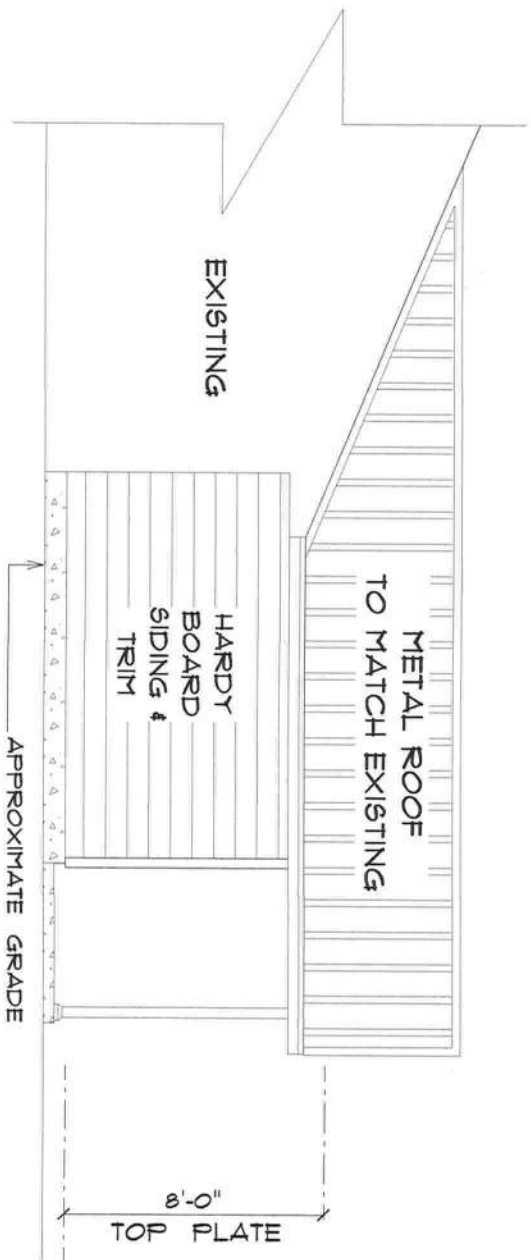


*** PROPOSED RIGHT ELEVATION ***

SCALE : 3/8" = 1'-0"

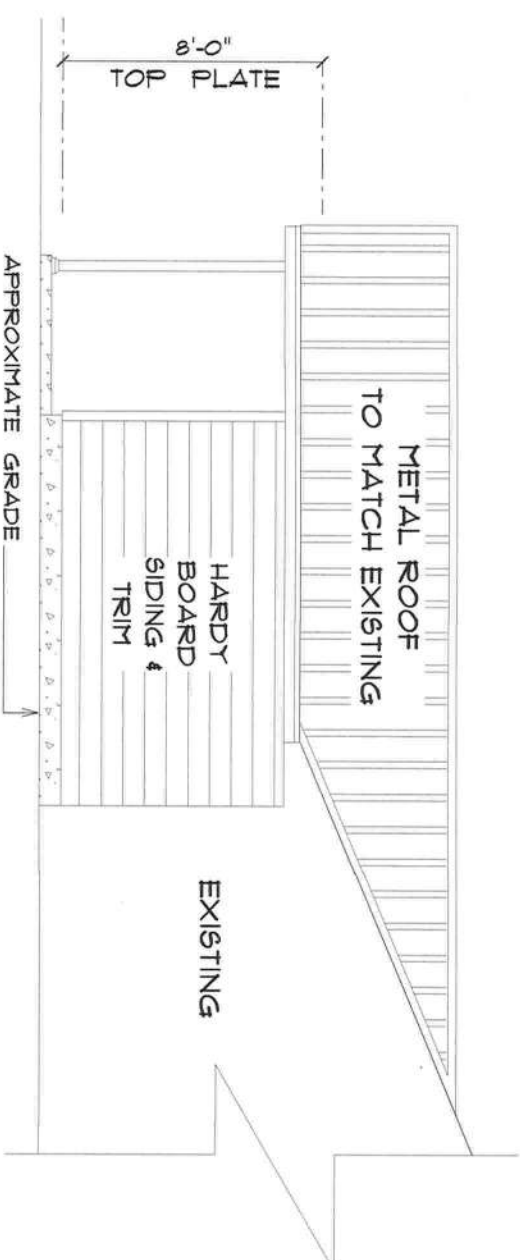

*** PROPOSED LEFT ELEVATION ***

SCALE : 3/8" = 1'-0"

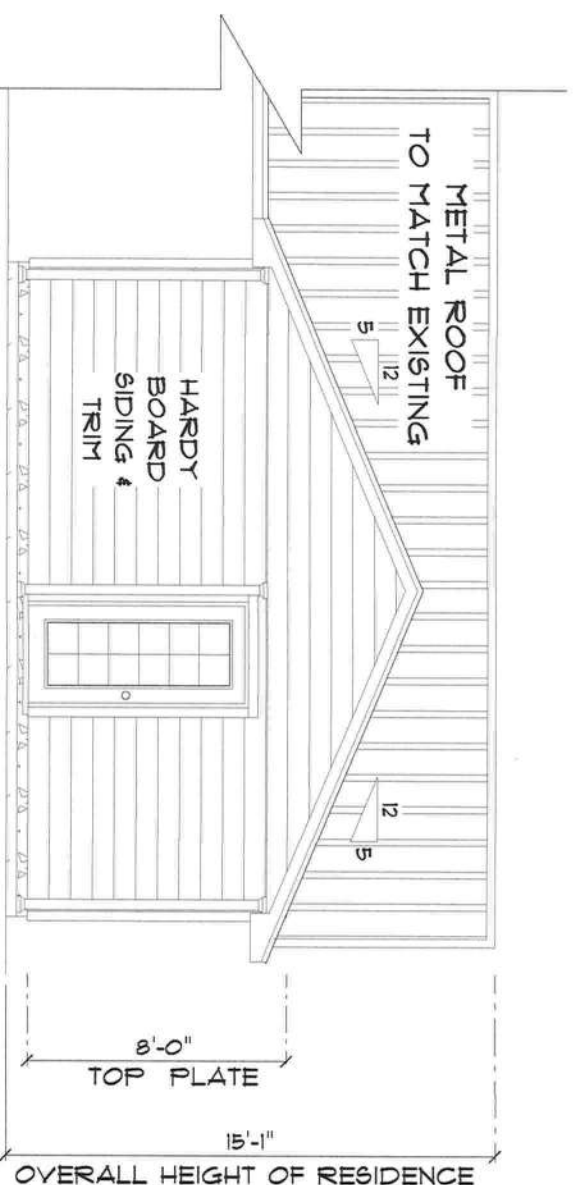

*** PROPOSED REAR ELEVATION ***

SCALE : 3/8" = 1'-0"

ADDITION
for
JAMES AND CINDY
CLAYTON

Teresa H. Ruffo
2025 SW 4th St. #1
Lake City, Florida 32025
Phone: (904) 661-1100
Email: teresa@tcrsolutions.com

PRINTED DATE:
Tuesday, July 27, 2021

DRAWN BY: GLENDOCK KING
CHECKED BY: Teresa H. Ruffo

FILING DESCRIPTION:

INFLS DATE:

JOB NUMBER:

DRAWING NUMBER


A4

OF 5 SHEETS

ELECTRICAL LEGEND		
ELECTRICAL	COUNT	SYMBOL
ceiling fan globe 01	2	
pot light	2	o
spotlight double	2	
Smoke Detector	2	(S)
outlet	13	o
switch	5	s
switch 3 way	2	s

ELECTRICAL PLAN NOTES

- E-1
WIRE ALL APPLIANCES, HVAC UNITS AND OTHER EQUIPMENT PER MANUFACTURER'S SPECIFICATIONS.
- E-2
ALL INSTALLATIONS SHALL BE PER NATIONAL ELECTRIC CODE.
- E-3
ALL SMOKE /CARBON MONOXIDE DETECTORS SHALL BE BOW /BATTERY BACKUP OF THE PHOTOELECTRIC TYPE AND SHALL BE INTERLOCKED TOGETHER. INSTALL INSIDE AND NEAR ALL BEDROOMS AS PER CODE.
- E-4
TELEPHONE, TELEVISION AND OTHER LOW VOLTAGE DEVICES OR OUTLETS SHALL BE AS PER THE OWNER'S DIRECTION AND IN ACCORDANCE WITH APPLICABLE SECTIONS OF NATIONAL ELEC. CODE LATEST EDITION.
- E-5
ELECTRICAL CONTRACTOR SHALL BE RESPONSIBLE FOR THE DESIGN AND SIZING OF ELECTRICAL SERVICE AND CIRCUITS.
- E-5
ALL BEDROOM RECEPTALS ARE TO BE AFCI (ARC FAULT CIRCUIT INTERRUPT)
- 75% OF ALL PERMANENT LIGHTS TO BE ENERGY EFFICIENT.

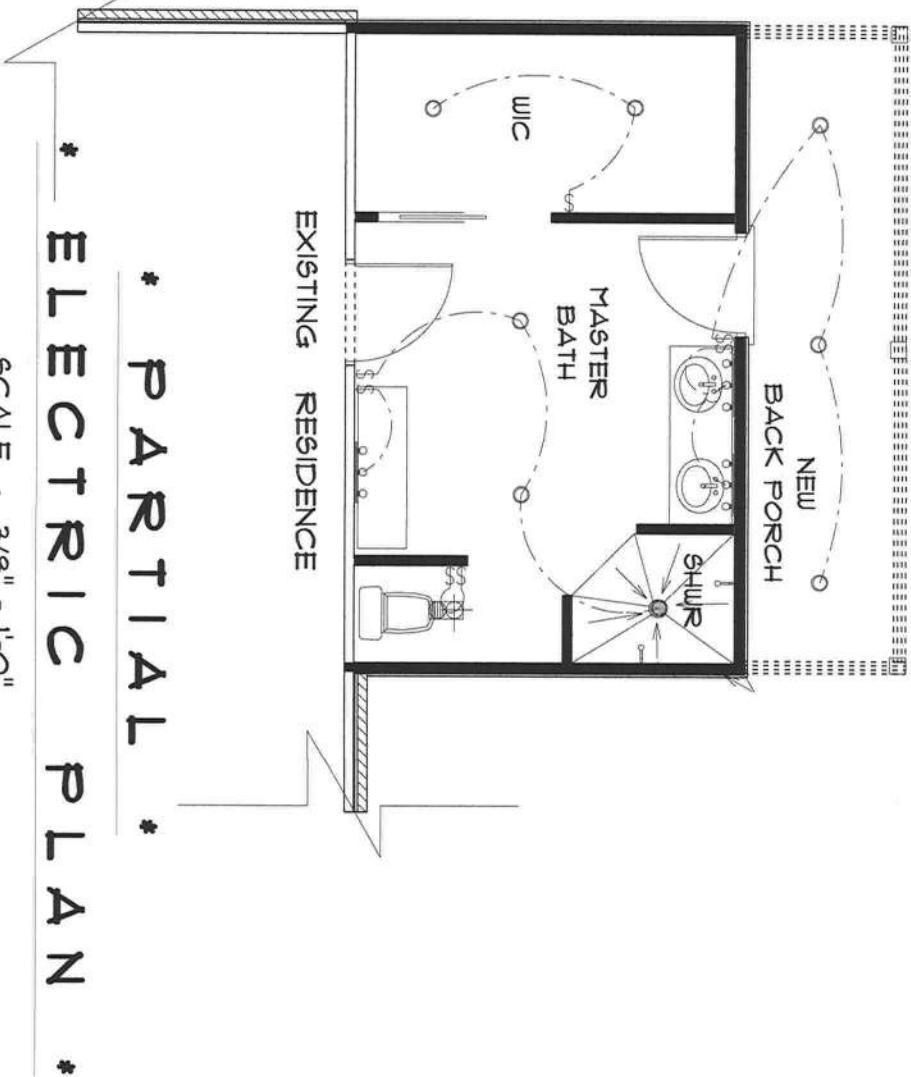

ADDITION
for
JAMES AND CINDY
CLAYTON

Teresa R. Ruffo
2935 SW 9th St. #1
Lake City, Florida 32025
Cell: (386) 881-1151
Email: terraruffo@earthlink.net

PRINTED DATE:
Tuesday, July 21, 2021
DRAWN BY: T. Ruffo
CHECKED BY: T. Ruffo
BILLING CONTACT: GLENDOCK KING
FMAIL DATE:
JOB NUMBER:
DRAWING NUMBER:
AB
OF 5 SHEETS

