

WILLIAMS
SCOTSMAN

052009-200503
 1. CONSIDER THE FOLLOWING DATA FROM THE EDITION (2008):
 ABC INC CODE

2. 2009 MAY 1 2008
 3. 2009 MAY 1 2008
 4. 2009 MAY 1 2008
 189. 2009 MAY 1 2008
 190. 2009 MAY 1

WILLSCOT

(24' X 36')

Digitally signed
by Julio Orbegoso
Date: 2021.12.03
16:38:39 -05'00'

THIS ITEM HAS BEEN ELECTRONICALLY SIGNED AND SEALED BY JULIO GREGORIO P.E. ON THE DATE AND/OR TIME STAMP SHOWN USING A DIGITAL SIGNATURE. PRINTED COPIES OF THIS DOCUMENT ARE NOT CONSIDERED SIGNED AND SEALED AND THE SIGNATURES MUST BE VERIFIED ON ANY ELECTRIC COPIES.

* NOTICE *

ALL DOCUMENTS WILL NO LONGER BE
VALID AFTER THE DATE SIGNED
ON: DECEMBER 24th, 2021

CONSULTING ENGINEER
JUAN ORTIZ-GONSO
202 DORIS DR.
SUITE 103
LAKELAND, FL 33813
CELL: 813.556.4710

REVISION DATE		DATE	
		12.03.2007	
		DRAWN	
		K.C.S.	
		JOB #	
		C-4024	
		SHEET NO.	
		C1	

© COPYRIGHT 2011-2012 JAMES H. HARRIS, JR.

SITE INSTALLED NOTES

NOTE THAT THE LIST DOES NOT NECESSARILY LIST THE
ITEMS FOR A COMPLETE INSTALLATION. ALL SITE RELATED ITEMS ARE
TO BE PROVIDED BY THE CLIENT.

1. THE COMPLETE ELECTRICAL SUPPLY AND THE DOWN SYSTEM
2. RAMP, STAIRS AND GENERAL ACCESS TO THE BUILDING
3. DRAINING FROM THE BUILDING (GUTTERS, CLEANOUTS, AND HOSE
UP TO PLUMBING SYSTEM)
4. LIGHTING, SERVICE HOOKUP (INCLUDES PERMITS) TO THE
BUILDING
5. THE MAIN ELECTRICAL PANEL AND SUB-PANELS (MULTI-PHASE
CONNECTION OF ELECTRICAL, GROUND, FIRE EXTINGUISHER AND NO HAZAR-
DOUS LIQUIDS AND GASES, THREE PHASE OVER 480V)
6. APPROX 200' OF 12" DRAIN, THREE PHASE OVER 480V CONNECTIONS BETWEEN
APPROX 400' AND 1000' HIGH WATER ELEVATION (CONNECTIONS PER CODE,
115, 215, 315, 415, 515, 615, 715, 815, 915, 1015, 1115, 1215, 1315, 1415, 1515, 1615,
1715, 1815, 1915, 2015, 2115, 2215, 2315, 2415, 2515, 2615, 2715, 2815, 2915, 3015,
3115, 3215, 3315, 3415, 3515, 3615, 3715, 3815, 3915, 4015, 4115, 4215, 4315, 4415,
4515, 4615, 4715, 4815, 4915, 5015, 5115, 5215, 5315, 5415, 5515, 5615, 5715, 5815,
5915, 6015, 6115, 6215, 6315, 6415, 6515, 6615, 6715, 6815, 6915, 7015, 7115, 7215,
7315, 7415, 7515, 7615, 7715, 7815, 7915, 8015, 8115, 8215, 8315, 8415, 8515, 8615,
8715, 8815, 8915, 9015, 9115, 9215, 9315, 9415, 9515, 9615, 9715, 9815, 9915, 10015,
10115, 10215, 10315, 10415, 10515, 10615, 10715, 10815, 10915, 11015, 11115, 11215,
11315, 11415, 11515, 11615, 11715, 11815, 11915, 12015, 12115, 12215, 12315, 12415,
12515, 12615, 12715, 12815, 12915, 13015, 13115, 13215, 13315, 13415, 13515, 13615,
13715, 13815, 13915, 14015, 14115, 14215, 14315, 14415, 14515, 14615, 14715, 14815,
14915, 15015, 15115, 15215, 15315, 15415, 15515, 15615, 15715, 15815, 15915, 16015,
16115, 16215, 16315, 16415, 16515, 16615, 16715, 16815, 16915, 17015, 17115, 17215,
17315, 17415, 17515, 17615, 17715, 17815, 17915, 18015, 18115, 18215, 18315, 18415,
18515, 18615, 18715, 18815, 18915, 19015, 19115, 19215, 19315, 19415, 19515, 19615,
19715, 19815, 19915, 20015, 20115, 20215, 20315, 20415, 20515, 20615, 20715, 20815,
20915, 21015, 21115, 21215, 21315, 21415, 21515, 21615, 21715, 21815, 21915, 22015,
22115, 22215, 22315, 22415, 22515, 22615, 22715, 22815, 22915, 23015, 23115, 23215,
23315, 23415, 23515, 23615, 23715, 23815, 23915, 24015, 24115, 24215, 24315, 24415,
24515, 24615, 24715, 24815, 24915, 25015, 25115, 25215, 25315, 25415, 25515, 25615,
25715, 25815, 25915, 26015, 26115, 26215, 26315, 26415, 26515, 26615, 26715, 26815,
26915, 27015, 27115, 27215, 27315, 27415, 27515, 27615, 27715, 27815, 27915, 28015,
28115, 28215, 28315, 28415, 28515, 28615, 28715, 28815, 28915, 29015, 29115, 29215,
29315, 29415, 29515, 29615, 29715, 29815, 29915, 30015, 30115, 30215, 30315, 30415,
30515, 30615, 30715, 30815, 30915, 31015, 31115, 31215, 31315, 31415, 31515, 31615,
31715, 31815, 31915, 32015, 32115, 32215, 32315, 32415, 32515, 32615, 32715, 32815,
32915, 33015, 33115, 33215, 33315, 33415, 33515, 33615, 33715, 33815, 33915, 34015,
34115, 34215, 34315, 34415, 34515, 34615, 34715, 34815, 34915, 35015, 35115, 35215,
35315, 35415, 35515, 35615, 35715, 35815, 35915, 36015, 36115, 36215, 36315, 36415,
36515, 36615, 36715, 36815, 36915, 37015, 37115, 37215, 37315, 37415, 37515, 37615,
37715, 37815, 37915, 38015, 38115, 38215, 38315, 38415, 38515, 38615, 38715, 38815,
38915, 39015, 39115, 39215, 39315, 39415, 39515, 39615, 39715, 39815, 39915, 40015,
40115, 40215, 40315, 40415, 40515, 40615, 40715, 40815, 40915, 41015, 41115, 41215,
41315, 41415, 41515, 41615, 41715, 41815, 41915, 42015, 42115, 42215, 42315, 42415,
42515, 42615, 42715, 42815, 42915, 43015, 43115, 43215, 43315, 43415, 43515, 43615,
43715, 43815, 43915, 44015, 44115, 44215, 44315, 44415, 44515, 44615, 44715, 44815,
44915, 45015, 45115, 45215, 45315, 45415, 45515, 45615, 45715, 45815, 45915, 46015,
46115, 46215, 46315, 46415, 46515, 46615, 46715, 46815, 46915, 47015, 47115, 47215,
47315, 47415, 47515, 47615, 47715, 47815, 47915, 48015, 48115, 48215, 48315, 48415,
48515, 48615, 48715, 48815, 48915, 49015, 49115, 49215, 49315, 49415, 49515, 49615,
49715, 49815, 49915, 50015, 50115, 50215, 50315, 50415, 50515, 50615, 50715, 50815,
50915, 51015, 51115, 51215, 51315, 51415, 51515, 51615, 51715, 51815, 51915, 52015,
52115, 52215, 52315, 52415, 52515, 52615, 52715, 52815, 52915, 53015, 53115, 53215,
53315, 53415, 53515, 53615, 53715, 53815, 53915, 54015, 54115, 54215, 54315, 54415,
54515, 54615, 54715, 54815, 54915, 55015, 55115, 55215, 55315, 55415, 55515, 55615,

[illegible]


ELEVATION NOTES (TYP.)



* NOTICE *

* NOTICE *

[illegible][illegible][illegible][illegible][illegible]

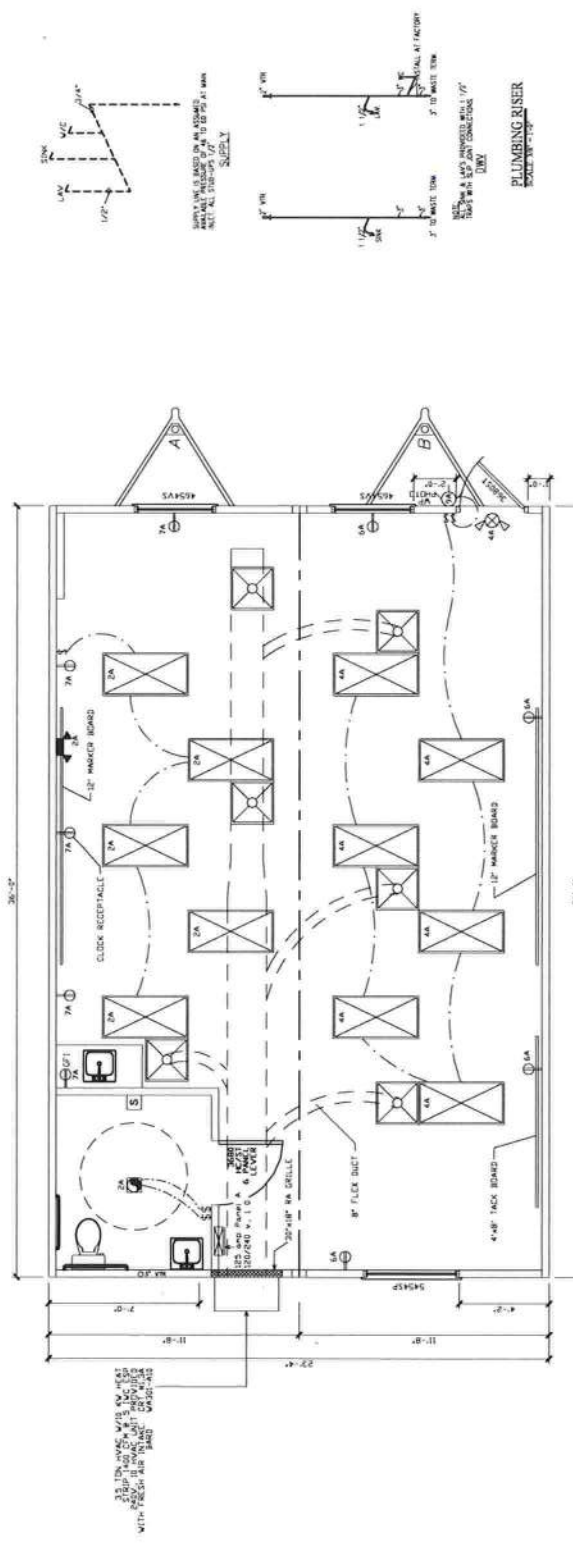

ELECTRICAL PANEL "A" SIZING	
DESCRIPTION	
0025 KW 5F X 8 1/2 SF X 125	12.1
1 HVAC 8 1/2 KW	10.9
11 RECEPTS 180 VA / 100	21.2
22 WATER HEATER 1.9 KW X 125	--
1 FANS @ 3 KW X 125	31.1
TOTAL	16.21 KW
TOTAL / 240 X 100	65.92 AMPS

ELECTRICAL SCHEDULE			
CIRCUIT	NOMINCLATURE	BREAKER (AMPS)	WIRE SIZE CU. MM V.O.
1 & 3	HVAC		PER WIR. SPECS
2 & 4	LIGHTING	250 IP	12-2
5 & 7	RECEPTS	250 IP	12-2
ALL PORTABLE APPLIANCES, INCLUDING W/H TO H/VAC DISCONNECT IF NOT WITHIN VIEW OF ELECTRIC			

[illegible]

Digitally signed
by Julio Orbegoso
Date: 2021.12.03
16:38:52 -05'00'

THIS ITEM HAS BEEN ELECTRONICALLY SIGNED AND SEALED
BY JALLO CHEROKEE P.E. ON THE DATE AND/OR TIME STAMP
SHOWN USING A DIGITAL SIGNATURE PRINTED COPIES OF
THIS DOCUMENT ARE NOT CONSIDERED SIGNED AND SEALED
AND THIS SIGNATURE MUST BE VERIFIED ON ANY ELECTRIC

*** NOTICE ***
DOCUMENTS WILL NO LONGER BE
MAILED AFTER THE DATE SIGNED
BY DECEMBER 24TH, 2021

PLE CHALLENGE #8/108

© COPYRIGHT 2013-2014 PLUMB DESIGN, CO.

WILLSCOT JACKSONVILLE
325 CLARK RD
JACKSONVILLE, FLORIDA 32218
OFFICE: (904) 378-0500
WWW.WILLSCOT.COM

WILLSCOT

MODULAR STRUCTURE FOR:
WILLSCOT
(24' X 36')

DATE	12-03-2021
RAWN	R.C.S
U.S.M	CL-6024

SHEET NO.
A1

WILLSCOT JACKSONVILLE
325 CLARK RD
JACKSONVILLE, FLORIDA 32218
OFFICE: (904) 378-0500
WWW.WILLSCOT.COM



MODULAR STRUCTURE FOR:
WILLSCOT
(24' X 36')

Digitally signed
by Julio Orbegoso
Date: 2021.12.03
16:39:02 -05'00'







THIS ITEM HAS BEEN ELECTRONICALLY SIGNED AND SEALED
BY JULIO ORBEGOSO, A PROFESSIONAL ENGINEER IN THE STATE OF
FLORIDA, LICENSE #33898. THE SIGNATURE AND SEAL ARE REQUIRED
FOR THE DOCUMENT TO BE CONSIDERED VALID. ANY COPIES OF
THIS DOCUMENT MUST BE VERIFIED BY ANY ALLEGED
COPIES.

CONSULTING ENGINEER
JULIO ORBEGOSO
202 DORNBURG
LAKELAND, FL 32813
FL LICENSE #33898

NOTICE
THESE DOCUMENTS SHALL NO LONGER BE
VALID 15 DAYS AFTER THE DATE SIGNED
BY THE ENGINEER. IF THE ENGINEER PAYS FOR
EXTENSION DATE

DATE	12/03/2021
DRAWN	W.L.C.
JOB #	CLJ24
SHEET NO.	A2

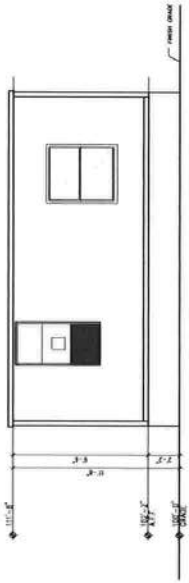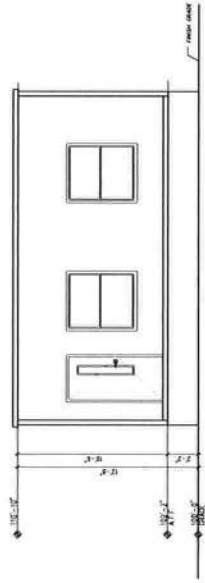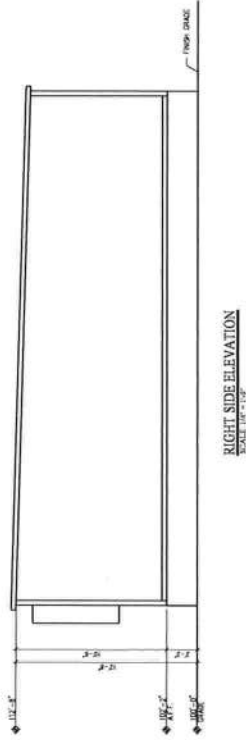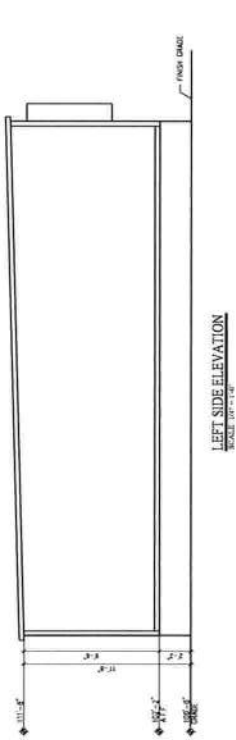



MODULAR STRUCTURE FOR:
WILLSCOT
(24' X 36')

Digitally signed
by Julio Orbegoso
Date: 2021.12.03
16:39:17 -05'00'





THIS ITEM HAS BEEN ELECTRONICALLY SIGNED AND SEALED
BY JULIO ORBEGOSO, PROJECT MANAGER, WILLSCOT
THIS DOCUMENT IS NOT CONSIDERED SIGNED AND SEALED
UNTIL IT IS PRINTED AND SIGNED BY THE PROJECT MANAGER
THIS DOCUMENT MUST BE PRINTED ON PANTHER ELECTRONIC
COPIES


NOTICE:
THIS DOCUMENT IS NOT CONSIDERED
SIGNED AND SEALED UNTIL IT IS
PRINTED AND SIGNED BY THE PROJECT
MANAGER. THIS DOCUMENT MUST BE
PRINTED ON PANTHER ELECTRONIC
COPIES.

DATE	2021.12.03
DRAWN	TEC
JOHN	CLARK
SHEET NO.	A3


© COPYRIGHT 2018 WILLSCOT PAPER CORP. US

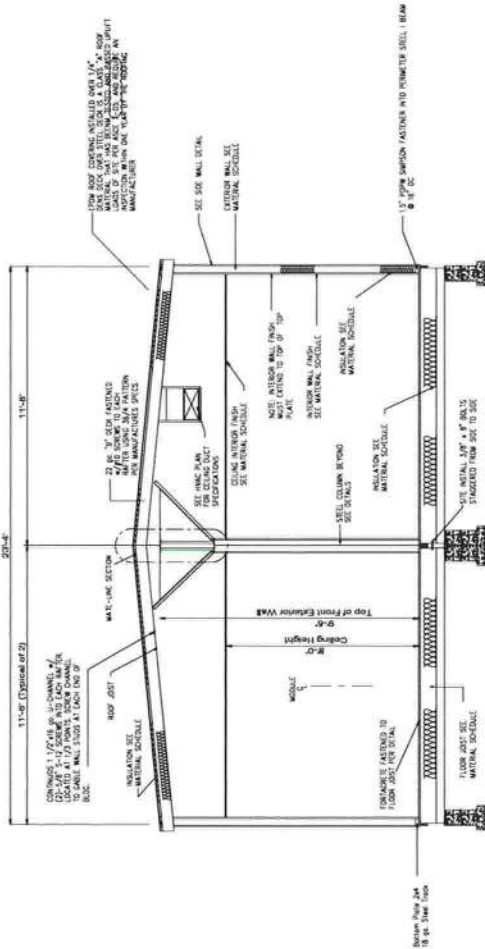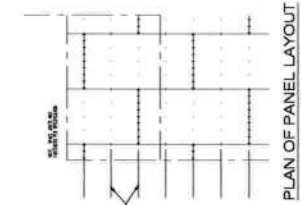

TYPICAL CROSS SECTION
SCALE 1/8"=1'-0"

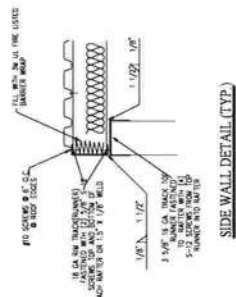

SIDE WALL DETAIL (TYP.)
SCALE 1/8"=1'-0"

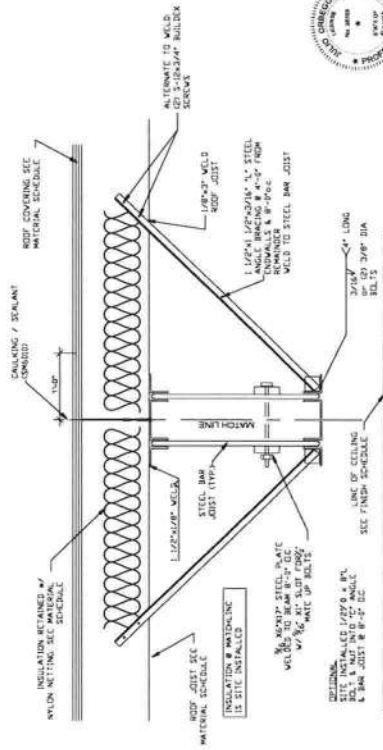

WATERLINE SECTION
SCALE 1/8"=1'-0"

GENERAL NOTES - SECTION NOTES:

1. UNLESS OTHERWISE SPECIFIED, ALL STEEL MUST COMPLY WITH ASTM A500.
2. ALL 1/4" SQUARE MUST COMPLY WITH A504 (HEAT TREATED).
3. 1/4" SQUARE MUST BE BRACED IN ACCORDANCE WITH AISC 360.
4. SPECIFICALLY CHANGING DIMENSIONS SHOWN.

EXTERIOR FINISH MATERIAL

- ROOF: 1/2" POLYURETHANE INSULATION PER MANUFACTURER'S SPECIFICATIONS.
- WALL: 1/2" POLYURETHANE INSULATION PER MANUFACTURER'S SPECIFICATIONS.
- NOTE: ALL ROOF JOINTS SHALL BE CLASS C OR BETTER PER MANUFACTURER'S SPECIFICATIONS. ALL ROOF JOINTS SHALL BE CLASS C OR BETTER PER MANUFACTURER'S SPECIFICATIONS. ALL ROOF JOINTS SHALL BE CLASS C OR BETTER PER MANUFACTURER'S SPECIFICATIONS.

INTERIOR FINISH MATERIAL

- CEILING: 1/2" POLYURETHANE INSULATION PER MANUFACTURER'S SPECIFICATIONS.
- WALL: 1/2" POLYURETHANE INSULATION PER MANUFACTURER'S SPECIFICATIONS.
- FLOOR: 1/2" POLYURETHANE INSULATION PER MANUFACTURER'S SPECIFICATIONS.

FOUNDATION NOTES:

MATERIAL SPECIFICATIONS

MOULDED CONCRETE

1. FOUNDATION DESIGN IS BASED ON AN ALLOWABLE SOIL BEARING PRESSURE OF 2000 PSF. ANY SOIL CONDITIONS THAT MAY DIFFER FROM THIS MUST BE REPORTED TO THE USER.
2. FOUNDATIONS SHALL BE BUILT ON UNDISTURBED SOIL OR PROPERLY COMPACTED FILL MATERIAL. COMPACTED FILL SHALL BE TESTED TO A MINIMUM OF 95% PROCTOR IN ACCORDANCE WITH ASTM D 1557.
3. ALL FOUNDATIONS SHALL BE PROTECTED WITH A MINIMUM OF 1/2" THICK FREE OF ORGANIC MATERIAL, CONSTRUCTION DEBRIS, AND LARGE ROCKS.
4. USER/OWNER IS RESPONSIBLE FOR OBTAINING ALL NECESSARY PERMITS AND MEETING OR EXCEEDING THE REQUIREMENTS SHOWN.

BASE PAD

1. THE FOOTING TYPE "A" SHALL BE 24" X 36" AND THE FOOTING TYPE "B" SHALL BE 24" X 36" X 12" DEEP.
2. THE BASE PADS SHALL HAVE A SPECIFIED COMPRESSIVE STRENGTH OF NO LESS THAN 2500 PSI AT 28 DAYS.

MASONRY UNIT

1. PIERES SHALL BE CONSTRUCTED WITH NOMINAL 8" X 16" CONCRETE MASONRY UNITS CONFORMING TO ASTM C90.

WOOD & SHEET PILING

1. ALL WOOD BLOCKING AND SHEET PILING SHALL BE CEDAR OR PRESSURE TREATED LUMBER.

GROUND ANCHORS

1. GROUND ANCHORS SHALL HAVE A TENSILE ULTIMATE CAPACITY & SHALL BE INSTALLED IN ACCORDANCE WITH MANUFACTURER SPECIFICATIONS.

TIE-DOWN STRAPS

1. THE TIE-DOWN STRAP SHALL BE 1/2" X 4" X 16' GALVANIZED STEEL OR 3/4" X 1/2" X 16' GALVANIZED STEEL.
2. THE TIE-DOWN STRAP SHALL BE 1/2" X 4" X 16' GALVANIZED STEEL OR 3/4" X 1/2" X 16' GALVANIZED STEEL.

INSTALLATION SPECIFICATIONS

MOULDED CONCRETE

1. BEFORE WATER IMPACTS THE GROUND FROM A ROOF VALLEY, DOWN SPOUT, SCUPPER, OR OTHER RAINWATER COLLECTION OR DIVERSION DEVICE, PROVISIONS SHALL BE MADE TO PREVENT FLOODING AND DAMAGE TO THE WATER MAIN FROM THE FOUNDATION.
2. FINISH GRADE SHALL BE SLOPED AWAY FROM THE FOUNDATION FOR DRAINAGE.
3. THE AREA UNDER FOOTINGS, FOUNDATIONS, AND CONCRETE SLAB ON GRADE SHALL BE PROTECTED WITH A MINIMUM OF 1/2" THICK FREE OF ORGANIC MATERIAL, CONSTRUCTION DEBRIS, AND LARGE ROCKS.
4. REMOVED PRIOR TO THEIR CONSTRUCTION, FILL MATERIAL SHALL BE FREE OF VEGETATION AND FOREIGN MATERIAL.

MASONRY UNIT

1. LAYOUT AND DIMENSION OF ALL PIERS MAY BE INSTALLED PERPENDICULAR OR PARALLEL TO THE FRAME. MAXIMUM OF 16' ON CENTER (17' 0" ON CENTER).
2. CONCRETE MASONRY UNITS SHALL CONFORM TO THE ASTM C90 STANDARDS.
3. CONSTRUCTION OF UNSTACKED, EXPOSED BOND MASONRY WALLS WHEN PROTECTED, INCLUDING STACKING AND LEVELING OF ALL UNITS, JOINTS AND THE PROTECTION OF MORTAR, CURING AND PROTECTION SHALL COMPLY WITH ASTM C900.

TIE-DOWN STRAP


1. THE TIE-DOWN STRAP SHALL BE 1/2" X 4" X 16' GALVANIZED STEEL OR 3/4" X 1/2" X 16' GALVANIZED STEEL.
2. THE TIE-DOWN STRAP SHALL BE 1/2" X 4" X 16' GALVANIZED STEEL OR 3/4" X 1/2" X 16' GALVANIZED STEEL.

Digitally signed by
Julio Orbegoso
Date: 2021.12.03
16:39:28 -0500




THIS FILE HAS BEEN ELECTRONICALLY SIGNED AND SEALED
BY THE USER. THE SIGNATURE IS VALID AND THE DOCUMENT IS
UNALTERED. THE SIGNATURE IS VALID AND THE DOCUMENT IS
UNALTERED. THE SIGNATURE IS VALID AND THE DOCUMENT IS
UNALTERED.

NOTICE -
THESE DOCUMENTS SHALL NO LONGER BE
VALID 7 DAYS AFTER THE DATE SHOWN ON
THIS NOTICE. EXPIRATION DATE: 12/10/2022
P.E. LICENSE #97876

CONSULTING ENGINEER
JULIO ORBEGOSO
2021 LICENSED IN
FLORIDA AND P.E. 12013
P.E. LICENSE #97876

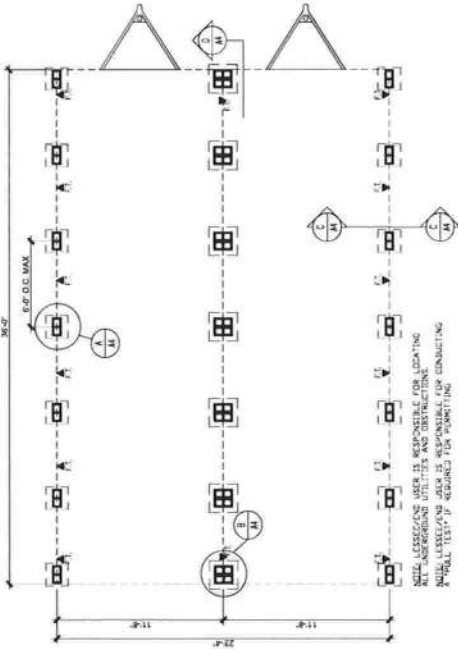




FOUNDATION PLAN
SCALE: 1/8" = 1'-0"

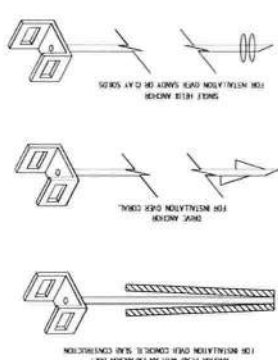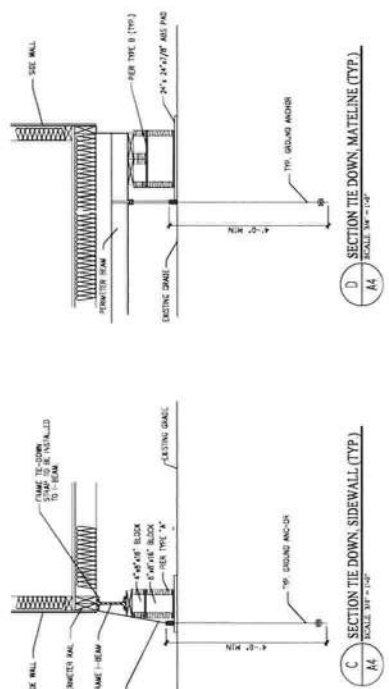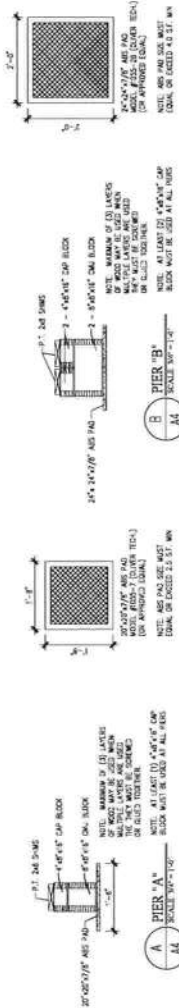

TYPICAL GROUND ANCHOR DETAIL
SCALE: 1/8" = 1'-0"

ITEM	QUANTITY	UNIT	PRICE
1. FOUNDATION PIERES	8	PIERES	120.00
2. FOUNDATION STRAPS	8	STRAPS	120.00
3. FOUNDATION ANCHORS	8	ANCHORS	120.00
4. FOUNDATION WALL	1	WALL	120.00
5. FOUNDATION MATELINE	1	MATELINE	120.00
6. FOUNDATION SIDEWALL	1	SIDEWALL	120.00
7. FOUNDATION FLOOR	1	FLOOR	120.00
8. FOUNDATION ROOF	1	ROOF	120.00
9. FOUNDATION DOOR	1	DOOR	120.00
10. FOUNDATION WINDOW	1	WINDOW	120.00
11. FOUNDATION VENT	1	VENT	120.00
12. FOUNDATION DRAIN	1	DRAIN	120.00
13. FOUNDATION SPOUT	1	SPOUT	120.00
14. FOUNDATION SCUPPER	1	SCUPPER	120.00
15. FOUNDATION VALLEY	1	VALLEY	120.00
16. FOUNDATION DOWN SPOUT	1	DOWN SPOUT	120.00
17. FOUNDATION RAINWATER COLLECTION	1	RAINWATER COLLECTION	120.00
18. FOUNDATION DIVERSION DEVICE	1	DIVERSION DEVICE	120.00
19. FOUNDATION FLOODING	1	FLOODING	120.00
20. FOUNDATION DAMAGE	1	DAMAGE	120.00

ITEM	QUANTITY	UNIT	PRICE
1. FOUNDATION PIERES	8	PIERES	120.00
2. FOUNDATION STRAPS	8	STRAPS	120.00
3. FOUNDATION ANCHORS	8	ANCHORS	120.00
4. FOUNDATION WALL	1	WALL	120.00
5. FOUNDATION MATELINE	1	MATELINE	120.00
6. FOUNDATION SIDEWALL	1	SIDEWALL	120.00
7. FOUNDATION FLOOR	1	FLOOR	120.00
8. FOUNDATION ROOF	1	ROOF	120.00
9. FOUNDATION DOOR	1	DOOR	120.00
10. FOUNDATION WINDOW	1	WINDOW	120.00
11. FOUNDATION VENT	1	VENT	120.00
12. FOUNDATION DRAIN	1	DRAIN	120.00
13. FOUNDATION SPOUT	1	SPOUT	120.00
14. FOUNDATION SCUPPER	1	SCUPPER	120.00
15. FOUNDATION VALLEY	1	VALLEY	120.00
16. FOUNDATION DOWN SPOUT	1	DOWN SPOUT	120.00
17. FOUNDATION RAINWATER COLLECTION	1	RAINWATER COLLECTION	120.00
18. FOUNDATION DIVERSION DEVICE	1	DIVERSION DEVICE	120.00
19. FOUNDATION FLOODING	1	FLOODING	120.00
20. FOUNDATION DAMAGE	1	DAMAGE	120.00

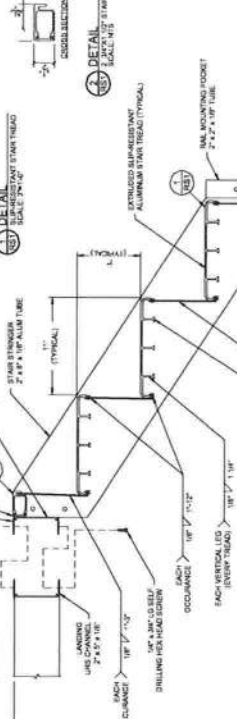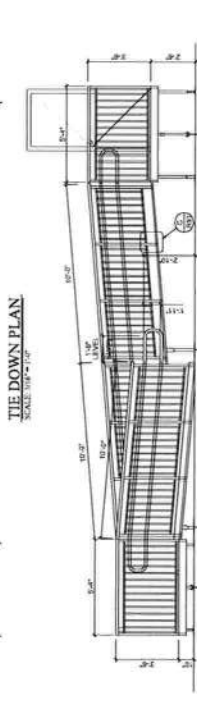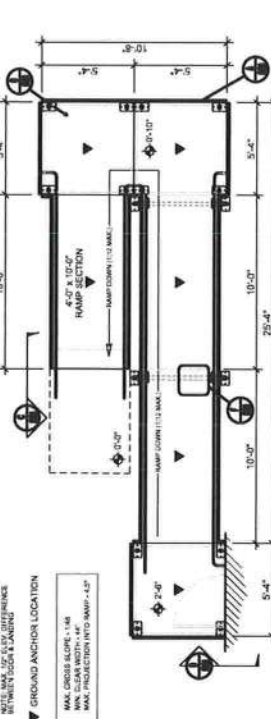

GENERAL NOTES:

[illegible]

RAMP TO RAIL CONNECTION

ISO @ RAMP W/ RAILING

5'-4" SO LANDING

① 5'-4" LANDING RAIL




RAMP TO RAIL CONNECTION

NO STABILIZER PLATE.
BEHIND ANCHOR.
100% NEW CASTING

/

each occurrence

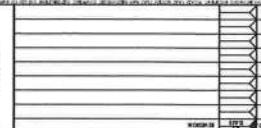

WILLSCOT MODULAR
LIFE SAFETY PLAN

PERMIT
20034-09
02.14.22
A102

GENERAL NOTES

A. INFORMATION REQUIRED ON THE LIFE SAFETY PLAN INDICATES GARDEN REQUIREMENTS. THIS INFORMATION IS REQUIRED FOR ALL BUILDINGS.

B. FIRE ALARM DEVICES SHOWN FOR REFERENCE ONLY. FIRE ALARM DESIGN TO BE SUBMITTED UNDER SEPARATE PERMIT APPLICATION.

C. BUILDING MUST BE EQUIPPED WITH A GARDEN EXTINGUISHER TO THE EXTERIOR ARE NOT REQUIRED TO HAVE EXTINGUISHERS LOCATED WITHIN THE BUILDING.


D. PER FIRE CODE, SINGLE EXIT CLASSROOMS ALLOWED WITH A MINIMUM OCCUPANCY OF 40 PEOPLE AND CORRIDOR PATH OF TRAVEL LESS THAN 75'-0".

APPLICABLE BUILDING CODES

FLORIDA BUILDING CODE, 7TH EDITION (2009) BUILDING
FLORIDA FIRE PREVENTION CODE, 7TH EDITION (2009)
LIFE SAFETY CODE, 7TH EDITION (2009)

CODE SUMMARY	
AREA	1ST FLOOR
BUILDING TYPE	TYPE V
USE	TYPE V (SCHOOL)
OCCUPANCY	9000 SF
PLANNED BLOCK AREA (FLOOR AREA)	9000 SF
ALTERNATE SMOKELESS SYSTEM (NFA 1)	NO
MINIMUM ALLOWABLE TRAVEL DISTANCE	200'-0" FRC 100'-0" FRC
OCCUPANT LOAD	30
DESIGNATED NUMBER OF EXITS	1
MINIMUM GARDEN WIDTH LEVEL (2')	75'
GARDEN WIDTH PROVIDED	1 EXIT DOORS AT 34' x 34'

LIFE SAFETY LEGEND	
SYMBOL	DESCRIPTION
T.D.	TRAVEL DISTANCE NOT MORE THAN 100'
T.R.P.	TRAVEL DISTANCE NOT MORE THAN 100'
GARDEN	GARDEN (SEE NFA 1)
FIRE EXTINGUISHER	TYPE 2A, ABC, BT CODE
EXIT LIGHT	EXIT LIGHT
EMERGENCY LIGHT	EMERGENCY LIGHT

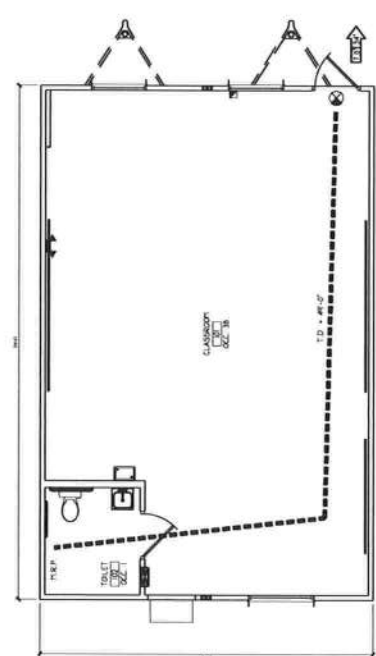

LIFE SAFETY PLAN
SCALE: 1/8" = 1'-0"