



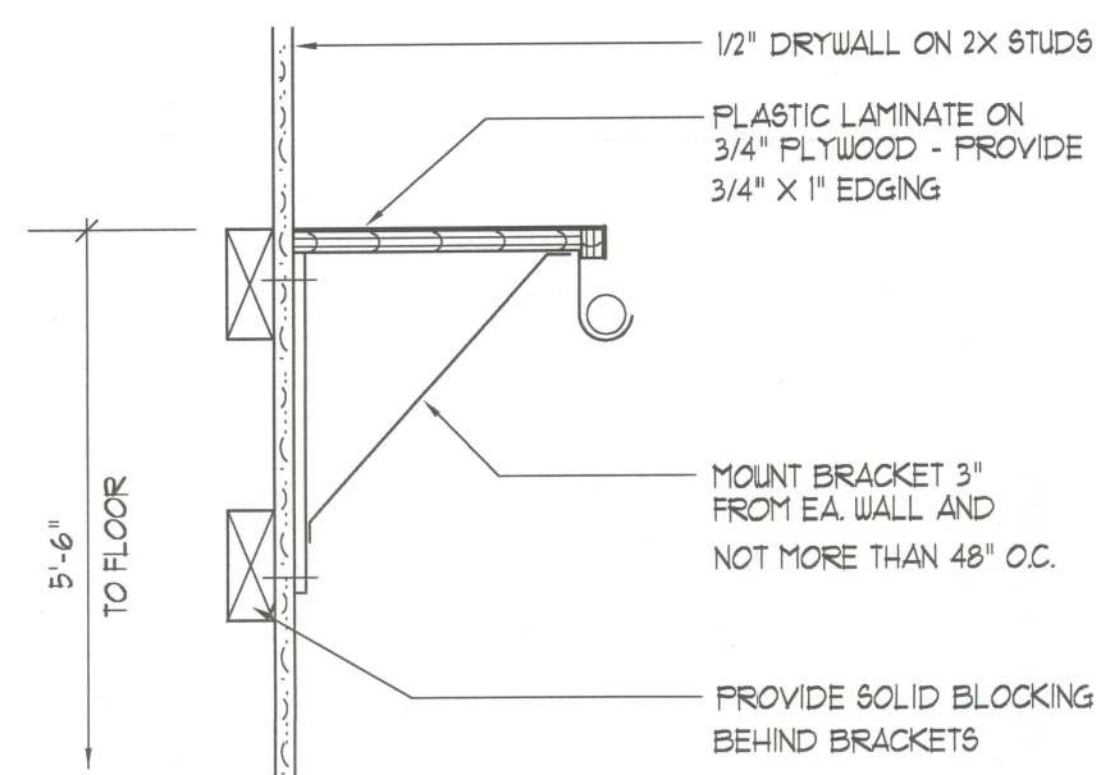


Closet Rod & Shelf Detail

SCALE: NONE

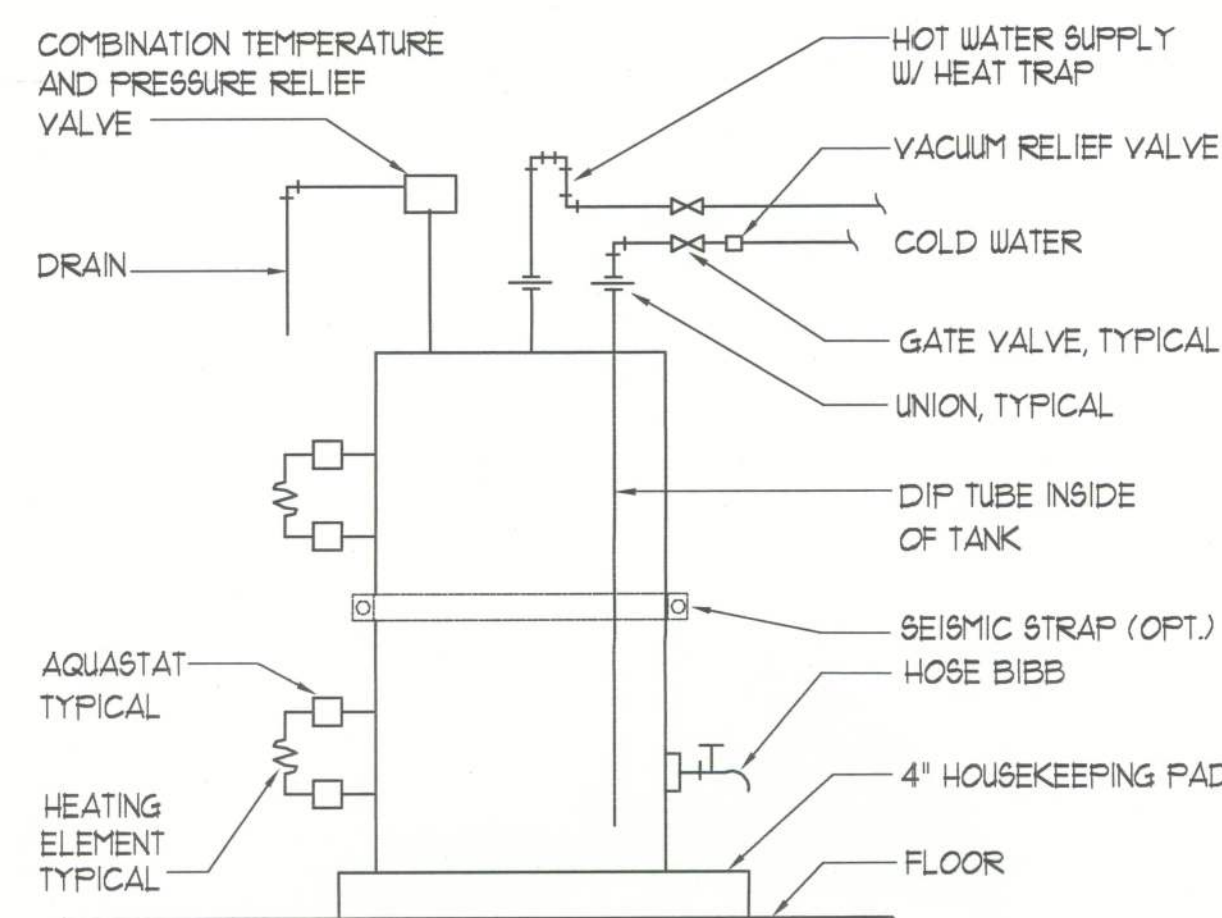


Electric Water Heater DETAIL

SCALE: NONE

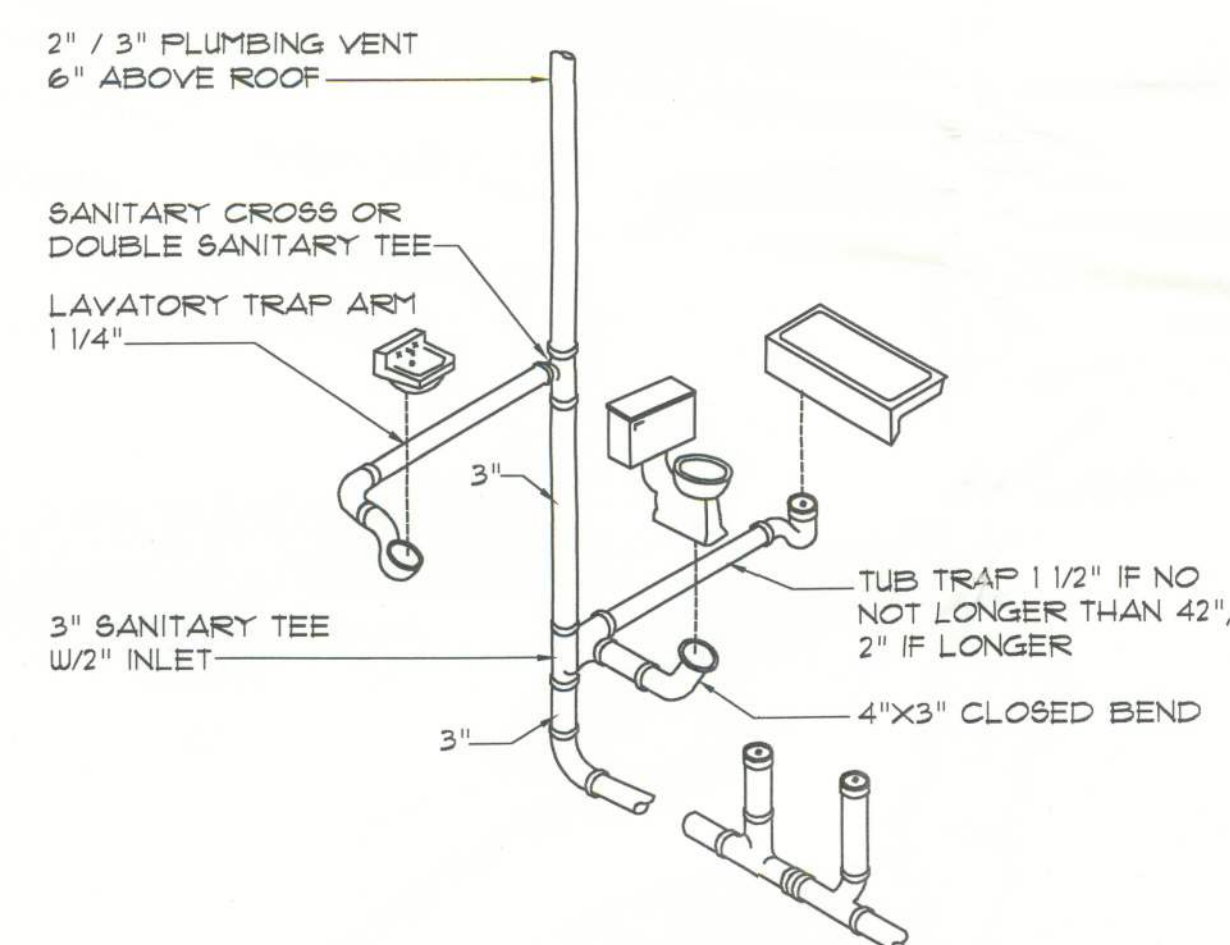


Typ. One Bath Plumbing DET.

N.T.S.
N.T.S. - THIS PLUMBING DIAGRAM IS GENERAL IN NATURE, REFER TO THE "PLUMBING RISER DIAGRAM" FOR INFORMATION.

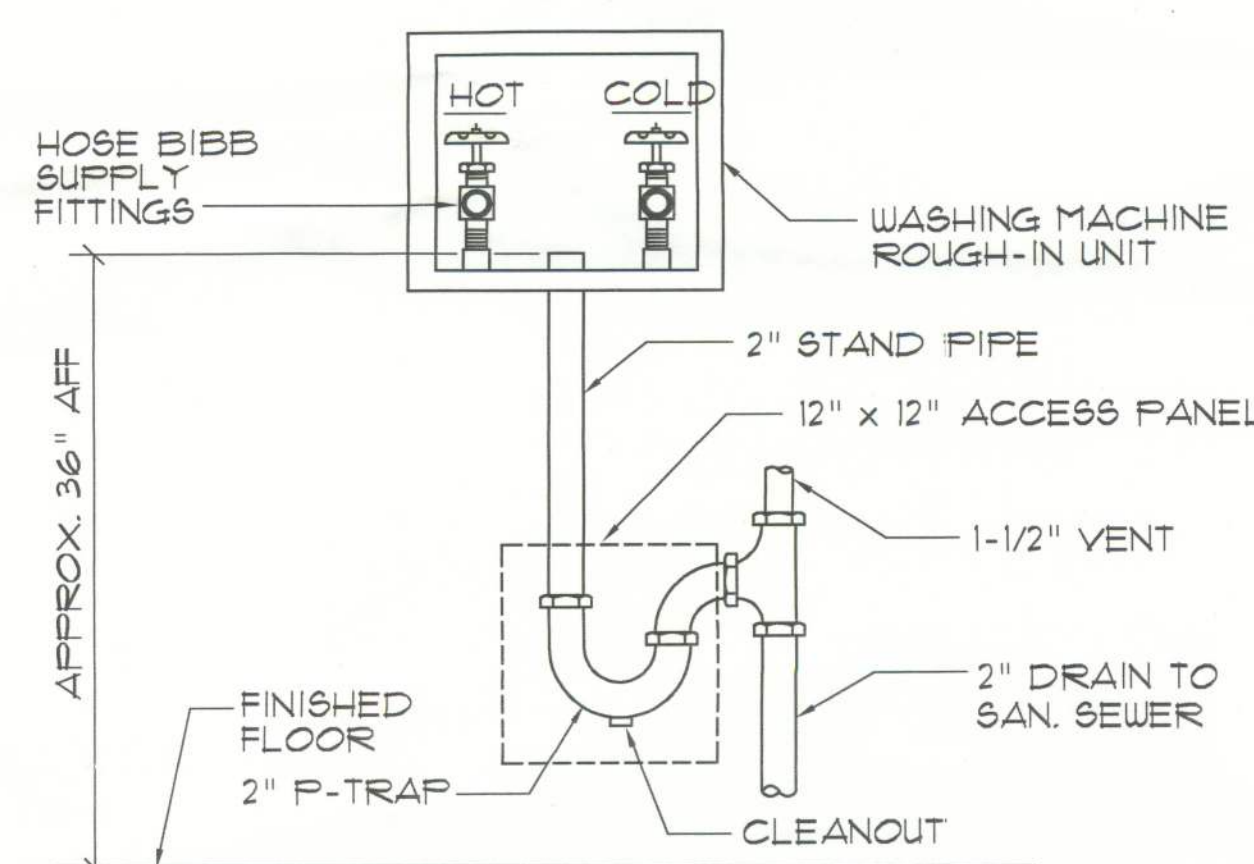


Washing Machine Hook-up DET.

N.T.S.

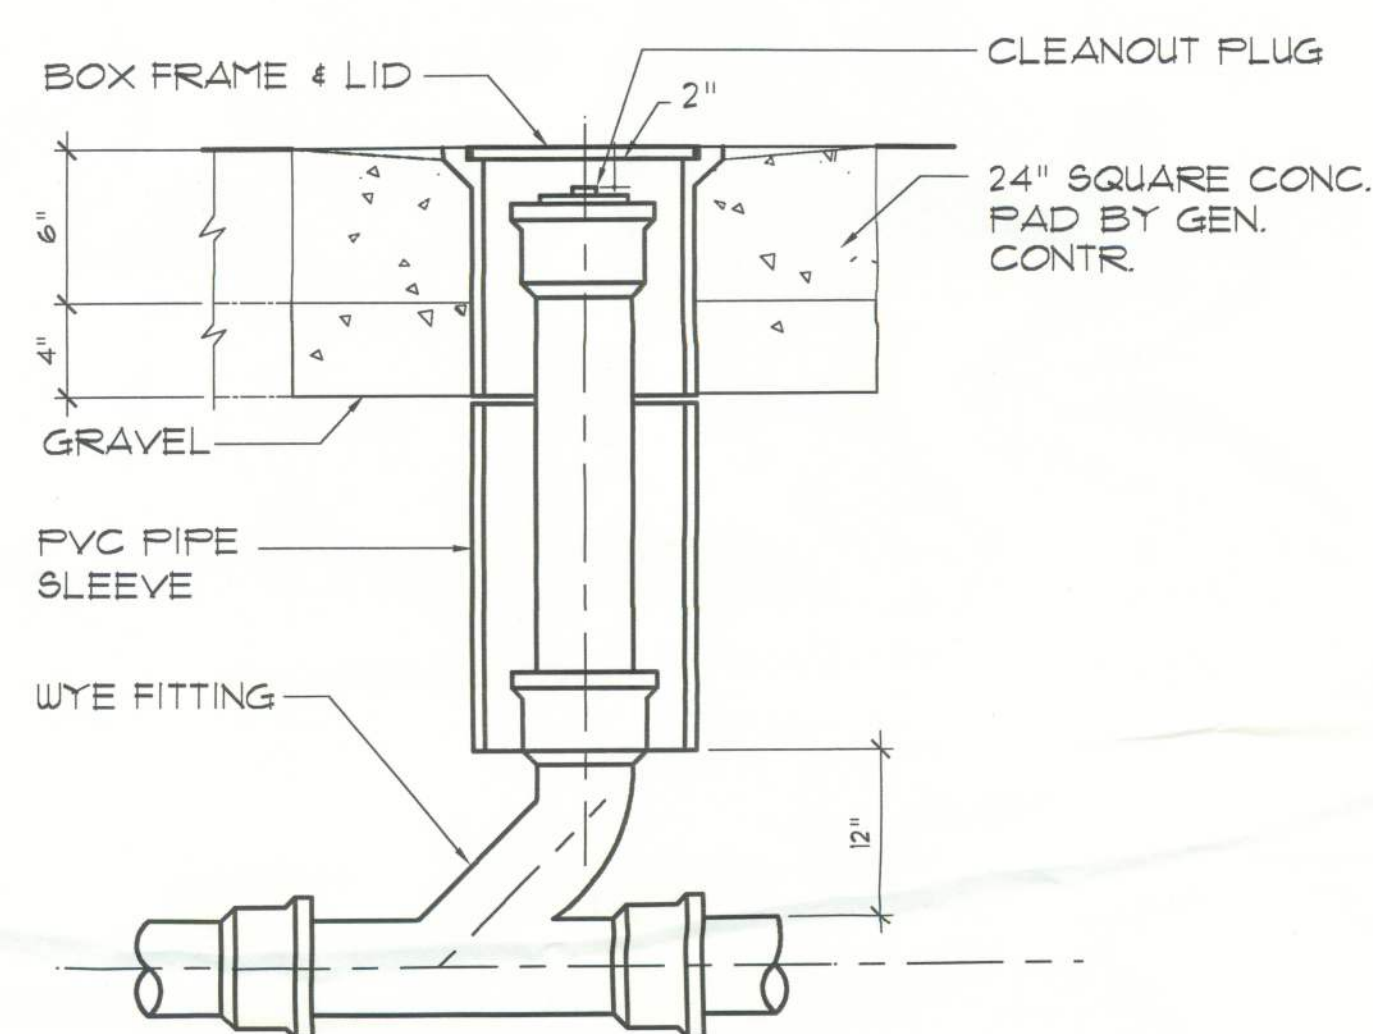


Outdoor Cleanout DETAIL

N.T.S.

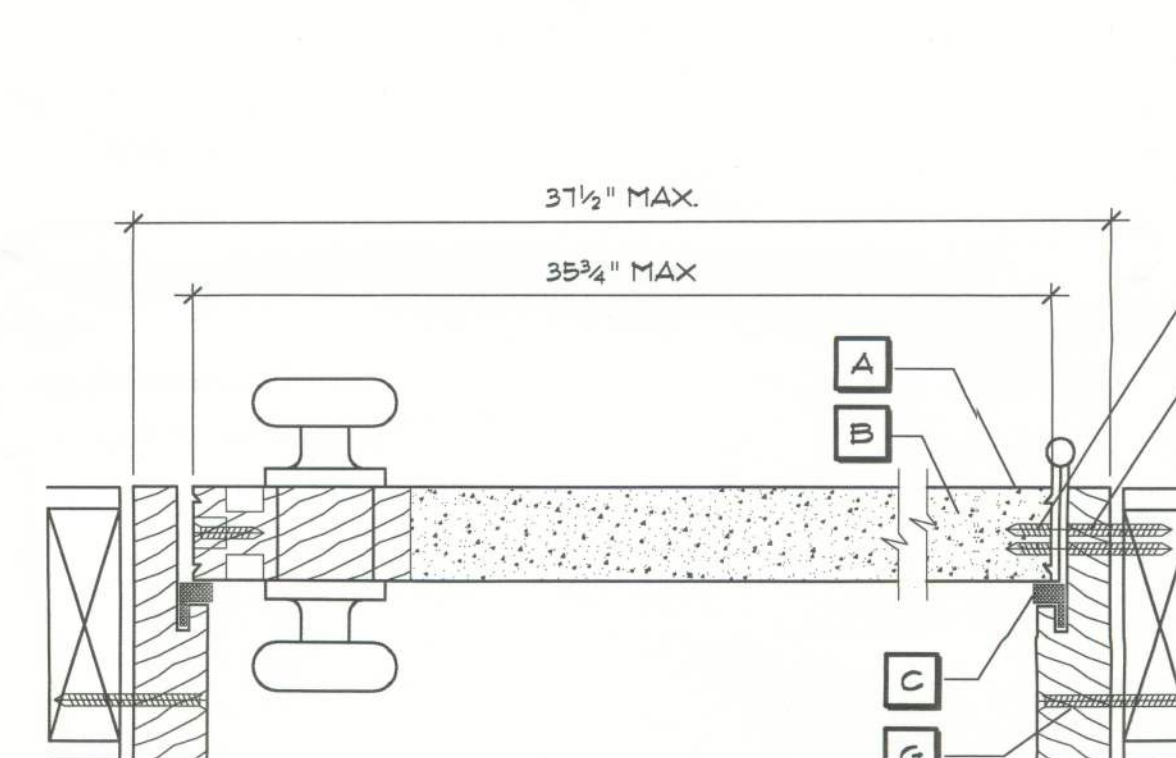

HORIZONTAL SECTION - SINGLE DOOR

NOTE, VERIFY ROUGH OPENING DOOR REQUIREMENTS PRIOR TO CONSTRUCTION.

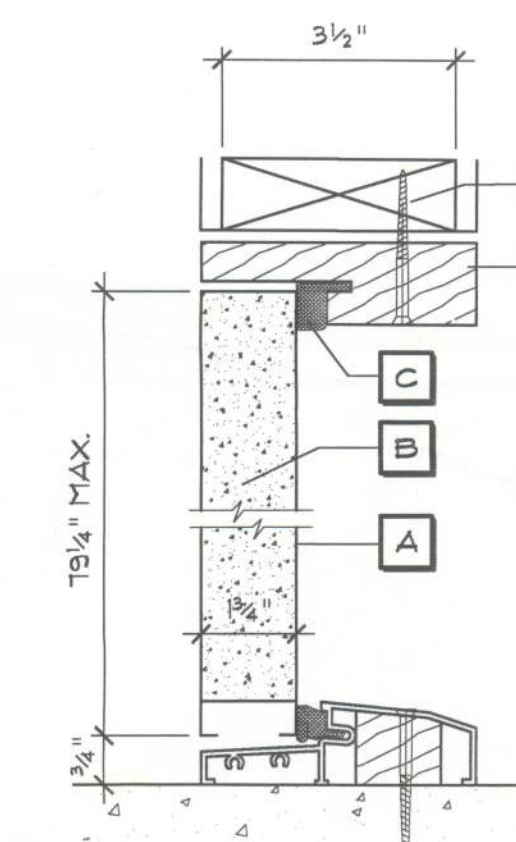

TYPICAL VERTICAL SECTION

DESIGN PRESSURE RATINGS *	
POSITIVE	+160 PSF
NEGATIVE	-160 PSF


* WHERE WATER INFILTRATION REQUIREMENT IS NOT NEEDED

NOTE !!!
EXTERIOR DOORS SHALL MEET OR EXCEED THE WIND RESISTANCE OF THE FOLLOWING PRODUCT:


SERIES ENTERGY 6-8 W/ INSULING
OPAQUE RESIDENTIAL INSULATED
STEEL DOOR W/ STEEL FRAME AS
MFG'D BY "FREMDOR ENTRY SYSTEMS"

Exterior Door DETAILS

SCALE: NONE

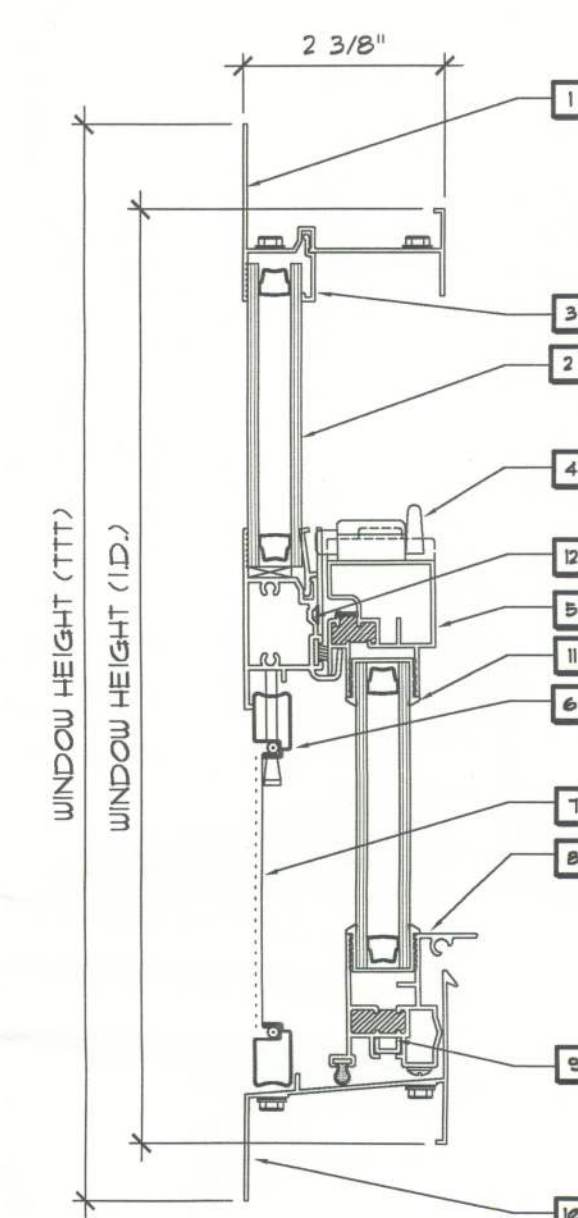

VERTICAL SECTION - SINGLE HUNG WINDOW

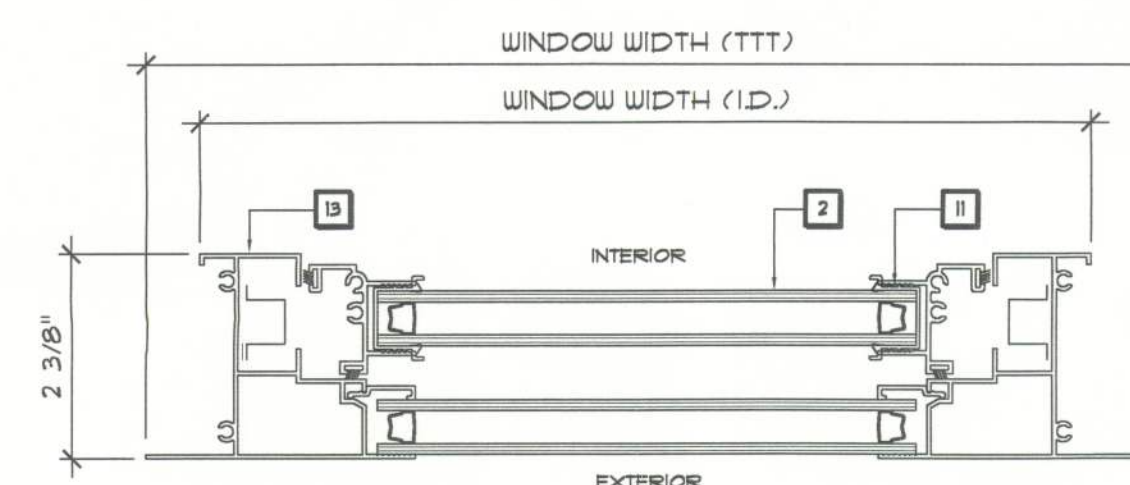

HORIZONTAL SECTION - SINGLE HUNG WINDOW

INSTALLATION	MODEL
1" ROOF'G. NAILS @ 6" FROM CORNERS, 18" O.C.	SERIES 450
5 - 1" ROOF'G. NAILS EA. FLANGE, MAX. 18" O.C.	SERIES 650

NOTE !!!
ALL WINDOWS ARE INSULATED AND LEATHERSTRIPPED AS MANUFACTURED BY "MI HOME PRODUCTS, INC." - OTHER MANUFACTURERS/PRODUCTS SHALL BE CONSIDERED AS EQUAL IF THEIR WIND DESIGN PERFORMANCE MEETS OR EXCEEDS THESE UNITS.

NOTE, VERIFY ROUGH OPENING WINDOW REQUIREMENTS PRIOR TO CONSTRUCTION.

N1 - COMPLETE WITH PAN LITE AS PER SERIES 450

N2 - TESTING AS PER ASTM E1300

Window Notes

- 1 FLANGED HEAD
- 2 INSULATED GLASS
- 3 GLAZING BEAD
- 4 LOCK
- 5 SASH TOP RAIL
- 6 SCREEN FRAME
- 7 FIBERGLASS MESH
- 8 BOTTOM SASH RAIL
- 9 PIVOT BAR
- 10 FLANGED SILL
- 11 MARINE GLAZING
- 12 FIXED MEETING RAIL
- 13 FLANGED JAMB

Typ. Window Sash DETAILS

SCALE: NONE

NOTICE
These plans are prepared and used and not be copied or
reproduced in whole or in part without the prior written
consent of the architect. Any reproduction of these plans
without the prior written consent of the architect is
prohibited. The architect assumes no responsibility for
any errors or omissions in these plans.

RESIDENTIAL DESIGNS BY KEVIN GRAY, INC.
10751 Deerwood Park Blvd.
Jacksonville, Florida 32256
Phone: (904) 384-3265
Fax: (904) 389-1200
www.kevingray.com

A Joint Venture
Partnership

NICHOLAS
PLASTER
ARCHITECT
N.C.A.R.E. Certified
1758 NW Brown Rd.
Jacksonville, FL 32255
Phone: 904-755-8021

HUBER RESIDENCE
THE NW 1/4 OF NE 1/4, SECTION 1
T 5 - S, R 16 - E
COLUMBIA COUNTY, FLORIDA

DRAWN BY:	BY, RFF, AUD
CHECKED BY:	YPS
DATE:	7/13/05
SCALE:	1/4" = 1'-0"
JOB NUMBER:	4800
REVISED:	
DWG NO:	5 OF 13

21 OCT 2005