


Office copy

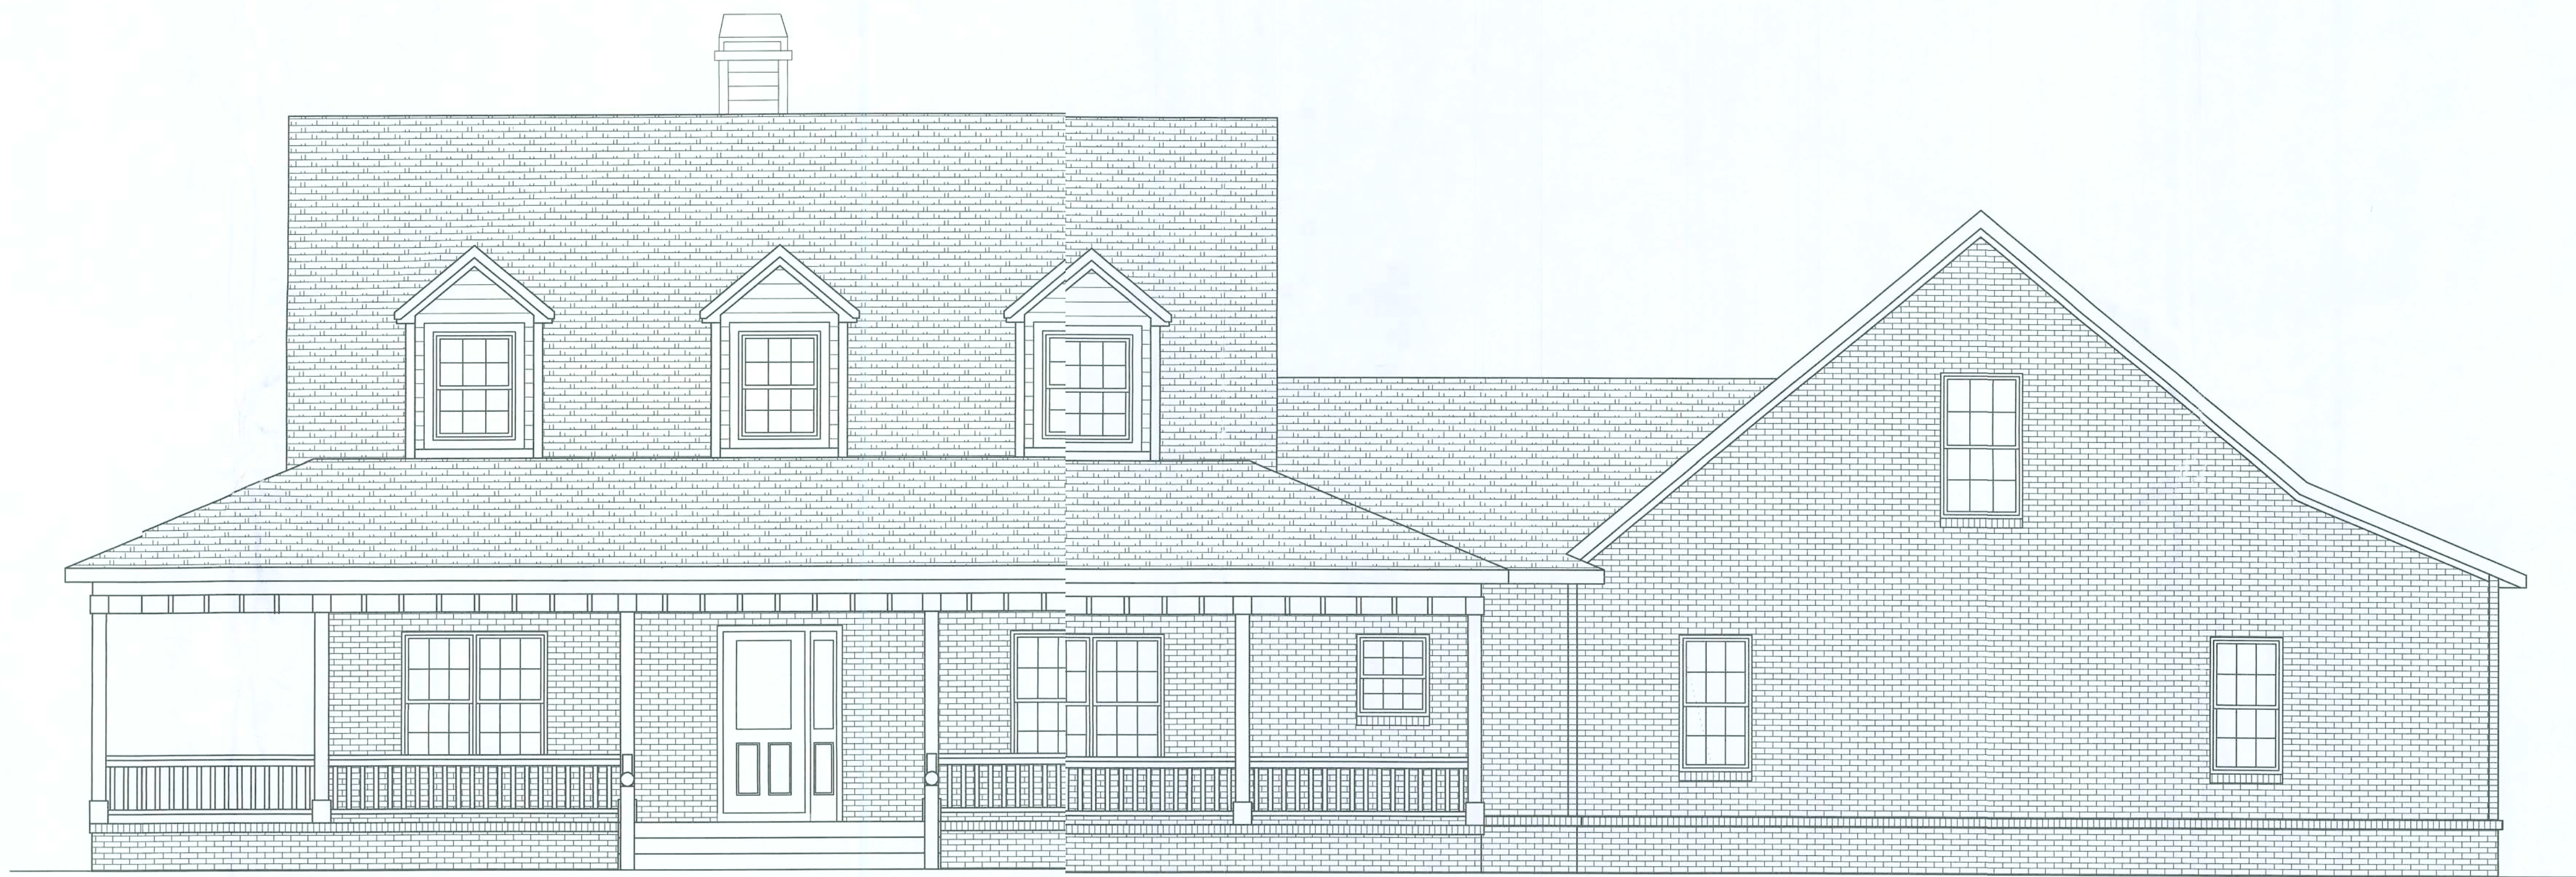

SHEET NO:

235 N.E. 2nd St.
P.O. Box 1633, High Springs, FL 32655
Phone: (386)454-2476 - Fax: (386)454-4244
Email: oneilconstruction@alltel.net
License # CGC061581

JOB NUMBER:

SCALE: N/A

DATE:

SEPTEMBER 14, 2006

PROJECT:


DAVE & HELLISA WATSON

SHEET TITLE:

COVER SHEET

DRAWN BY: STEVE RYALL

Steve Ryall Architectural Drafting
16194 NW 212th Terrace
High Springs, Florida 32643
(352)871-0251 houseplan@alltel.net

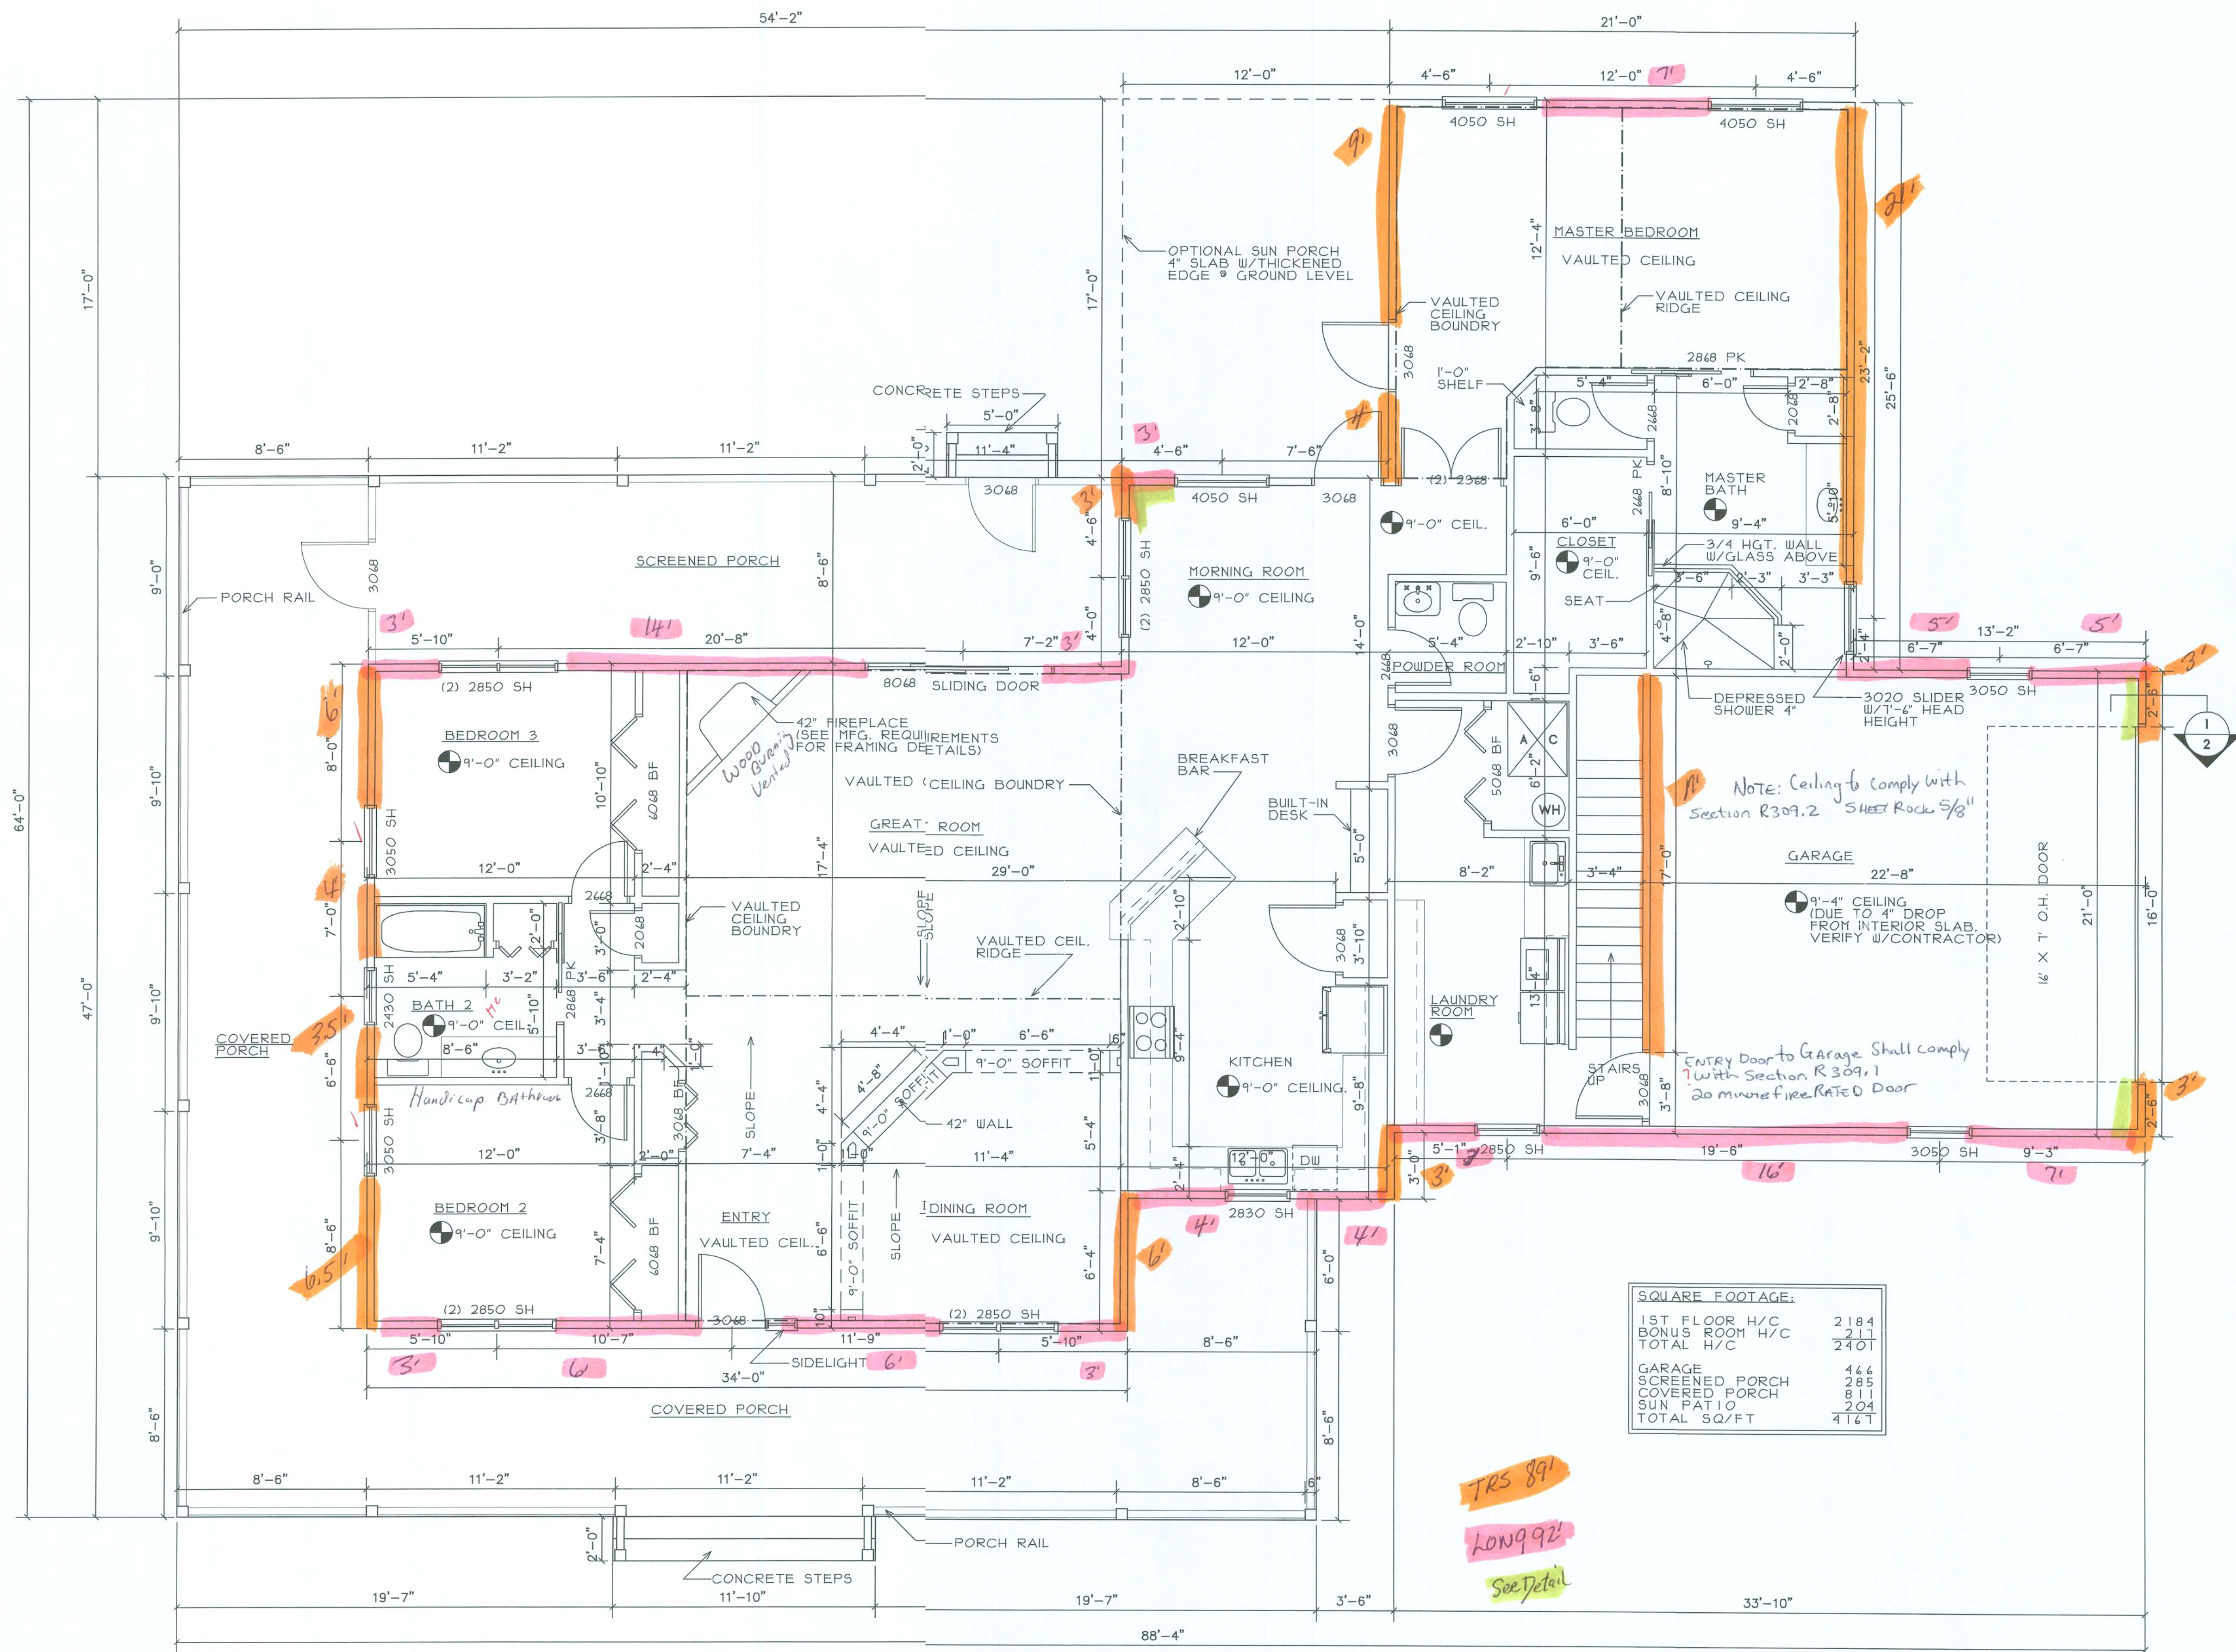

SQUARE FOOTAGE:


1ST FLOOR H/C	2184
BONUS ROOM H/C	211
TOTAL H/C	2401
GARAGE	466
SCREENED PORCH	285
COVERED PORCH	811
SUN PATIO	204
TOTAL SQ/FT	4167


FIRST FLOOR PLAN
SCALE: 1/4" = 1'-0"


DRAWN BY: STEVE RYALL
Steve Ryall Architectural Drafting
12194 NW 22th Terrace
High Springs, Florida 32643
(352)871-0251 houseplan@alltel.net

PROJECT: DAVE & MELISSA WATSON
JOB NUMBER: SCALE: 1/4" = 1'-0"
SHEET TITLE: FIRST FLOOR PLAN
DATE: SEPTEMBER 14, 2004


235 N.E. 2nd St.
P.O. Box 1633, High Springs, FL 32655
Phone: (386)454-2416 - Fax: (386)454-4244
E-Mail: oneilconstruction@alltel.net
License # CGC061581

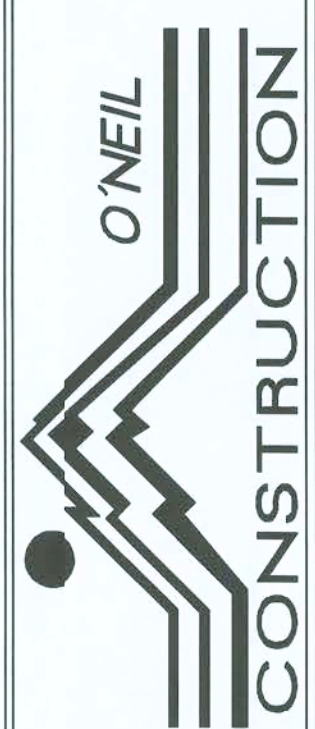

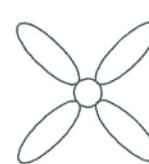
LIGHTING & ELECTRICAL LEGEND	
	CEILING FAN WITH INCANDESCENT LIGHT FIXTURE
	SINGLE SWITCH
	DUPLEX RECEPTACLE
	TV/CABLE OUTLET
	PHONE/ETHERNET

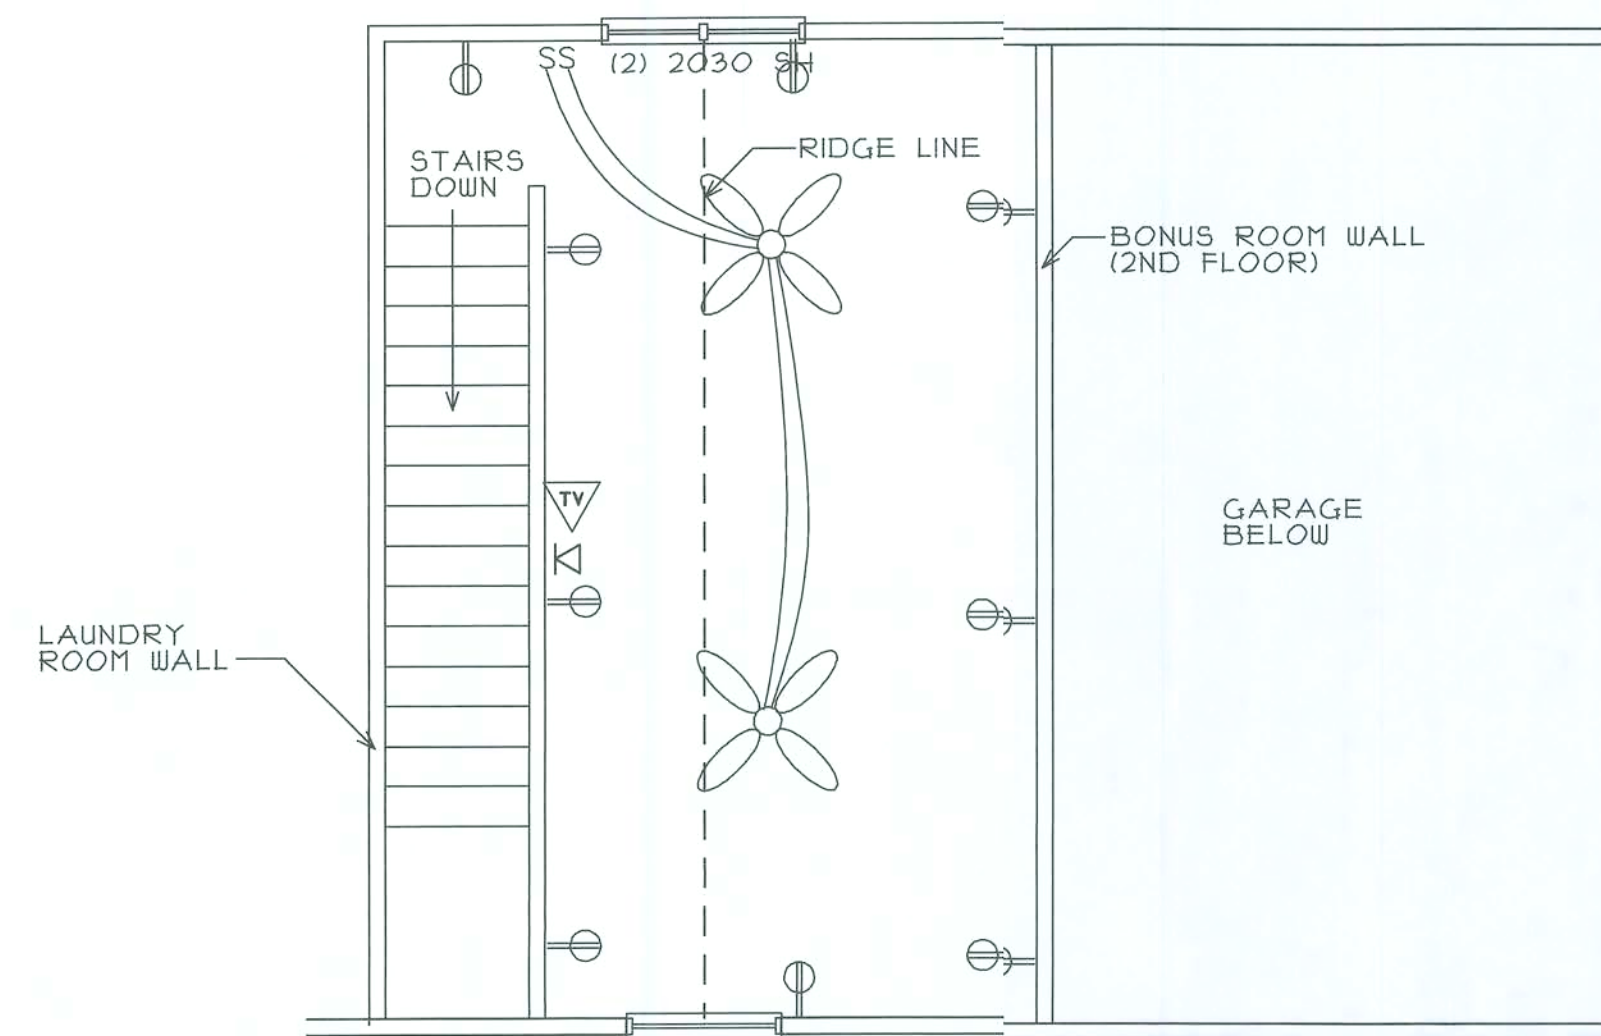


BONUS ROOM ELECTRICAL PLAN
SCALE: 1/4" = 1'-0"

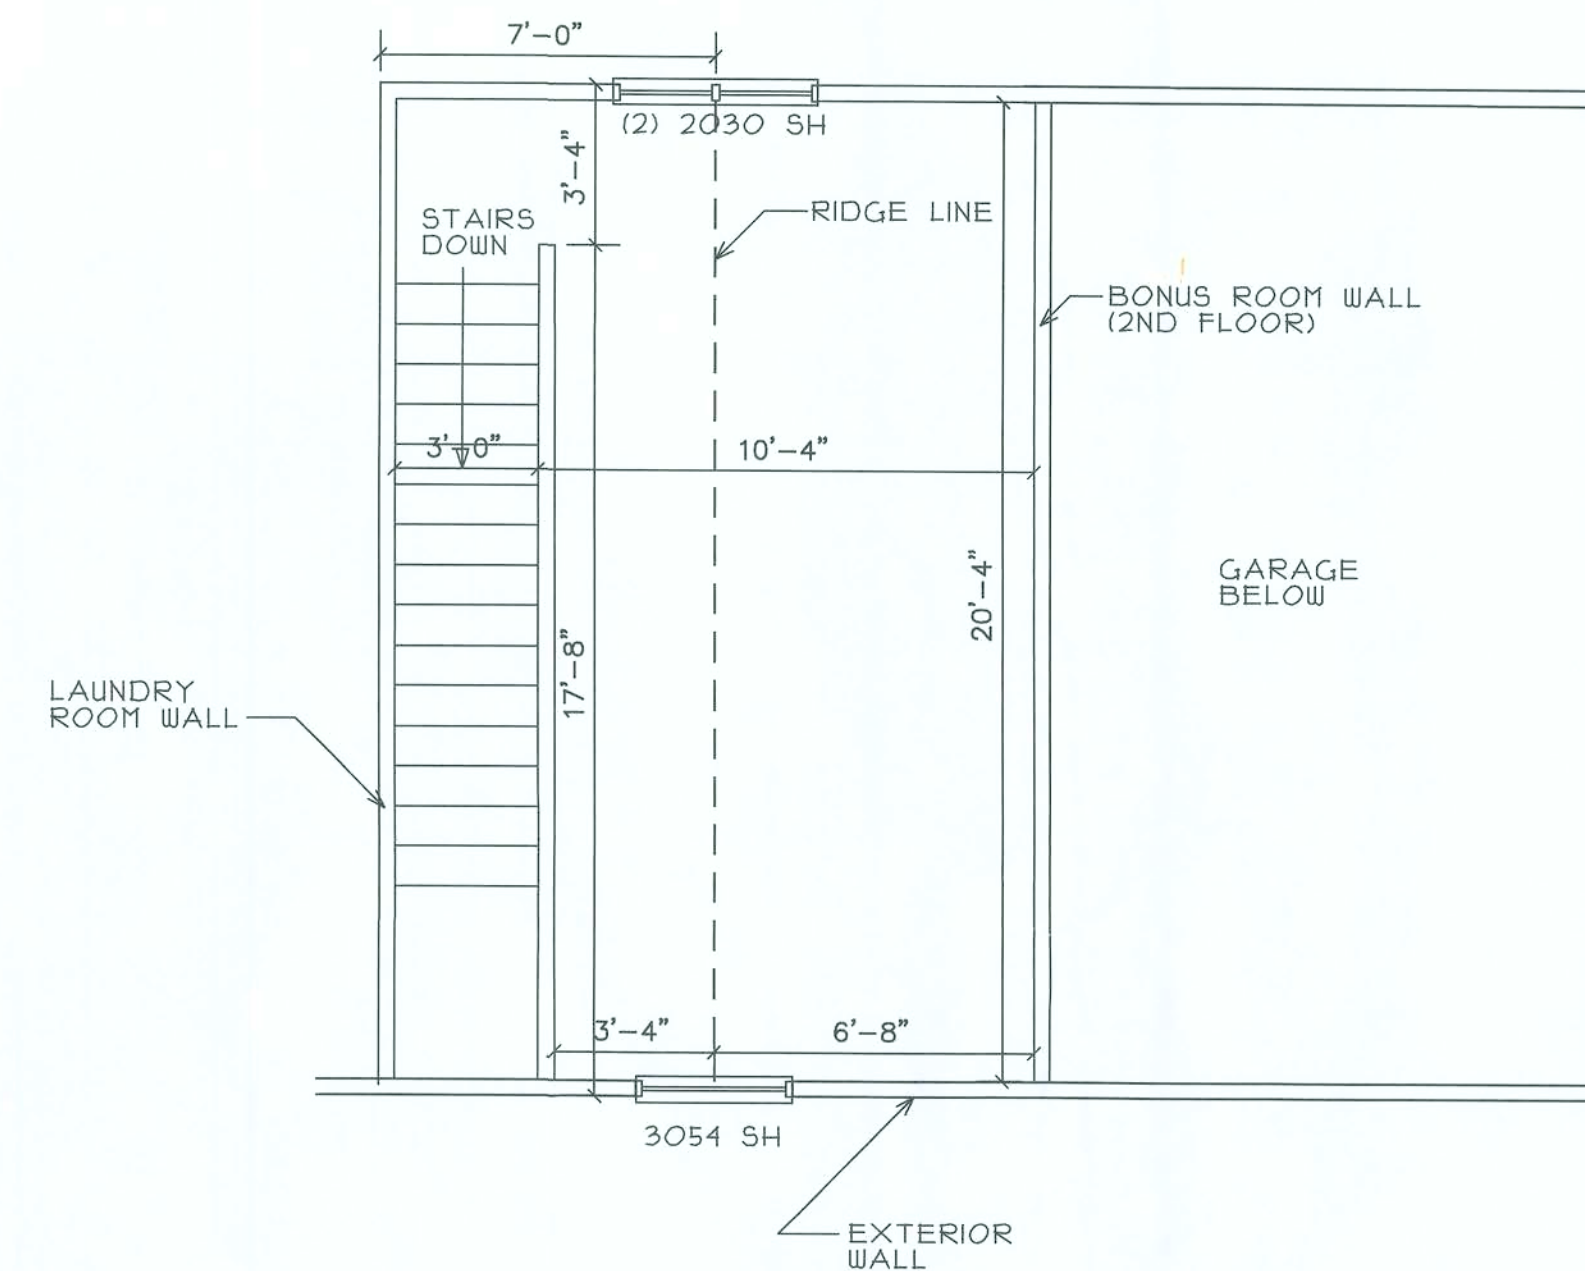

BONUS ROOM
SCALE: 1/4" = 1'-0"

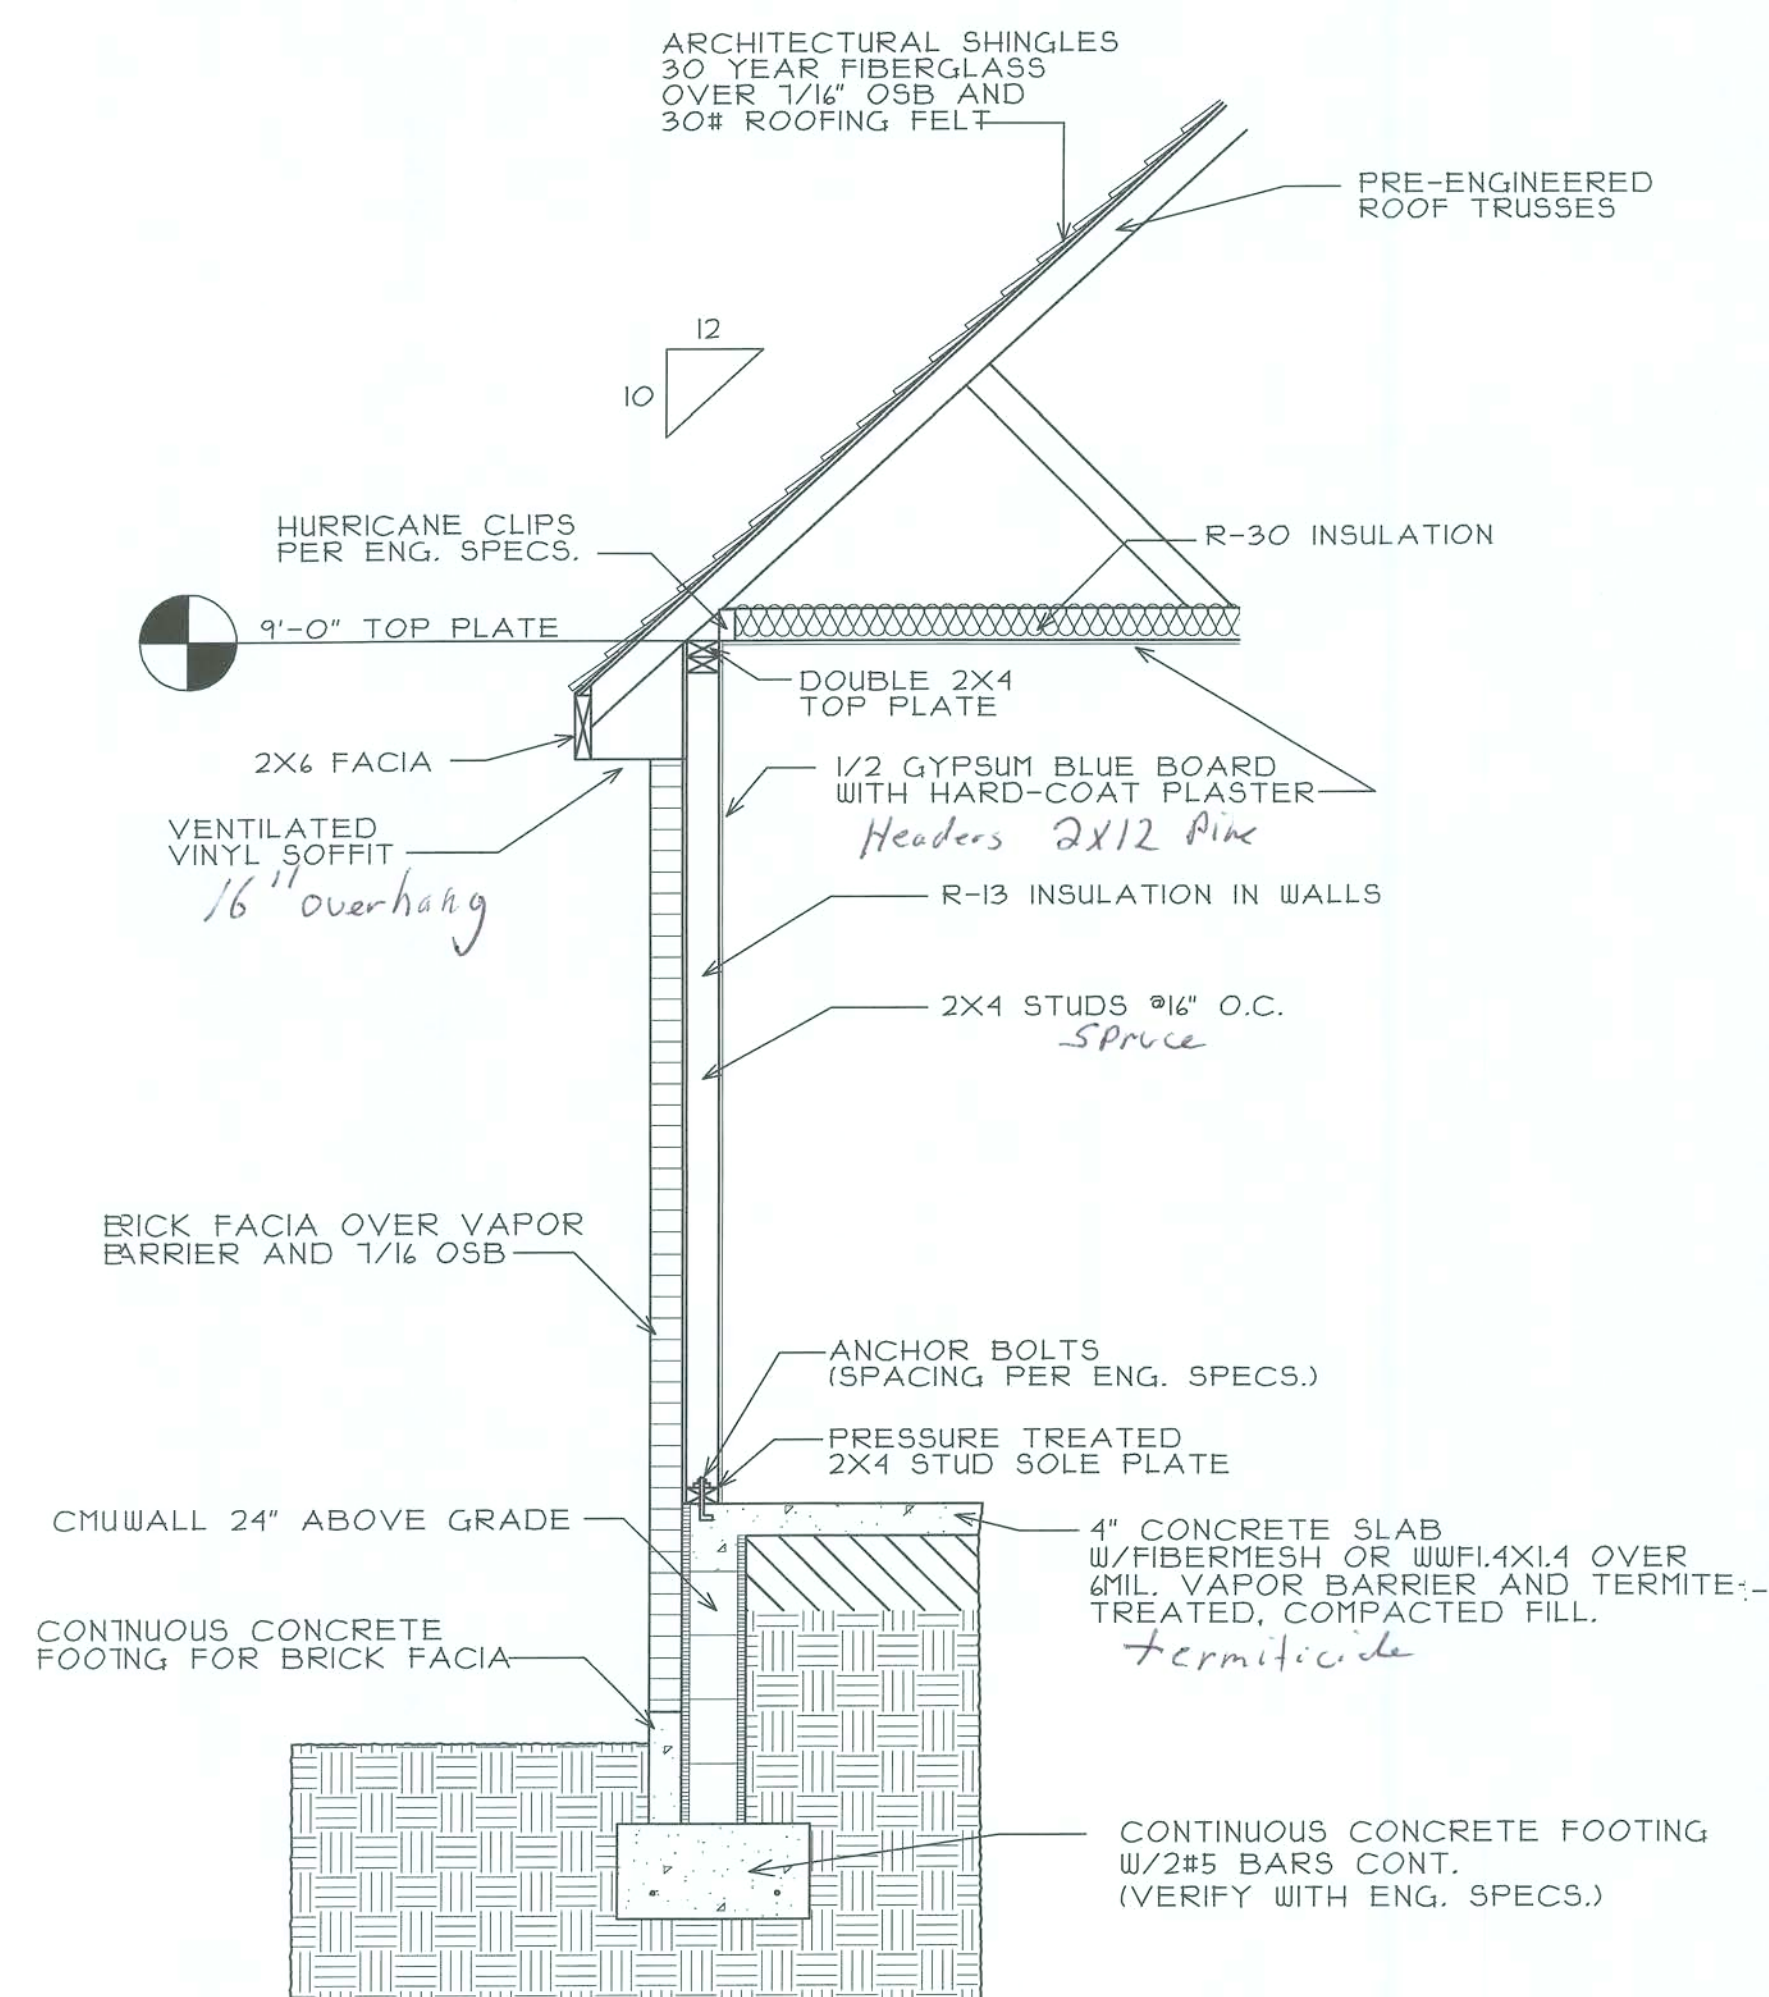

WALL/FOUNDATION SECTION @ GARAGE
SCALE: 1/2" = 1'-0"

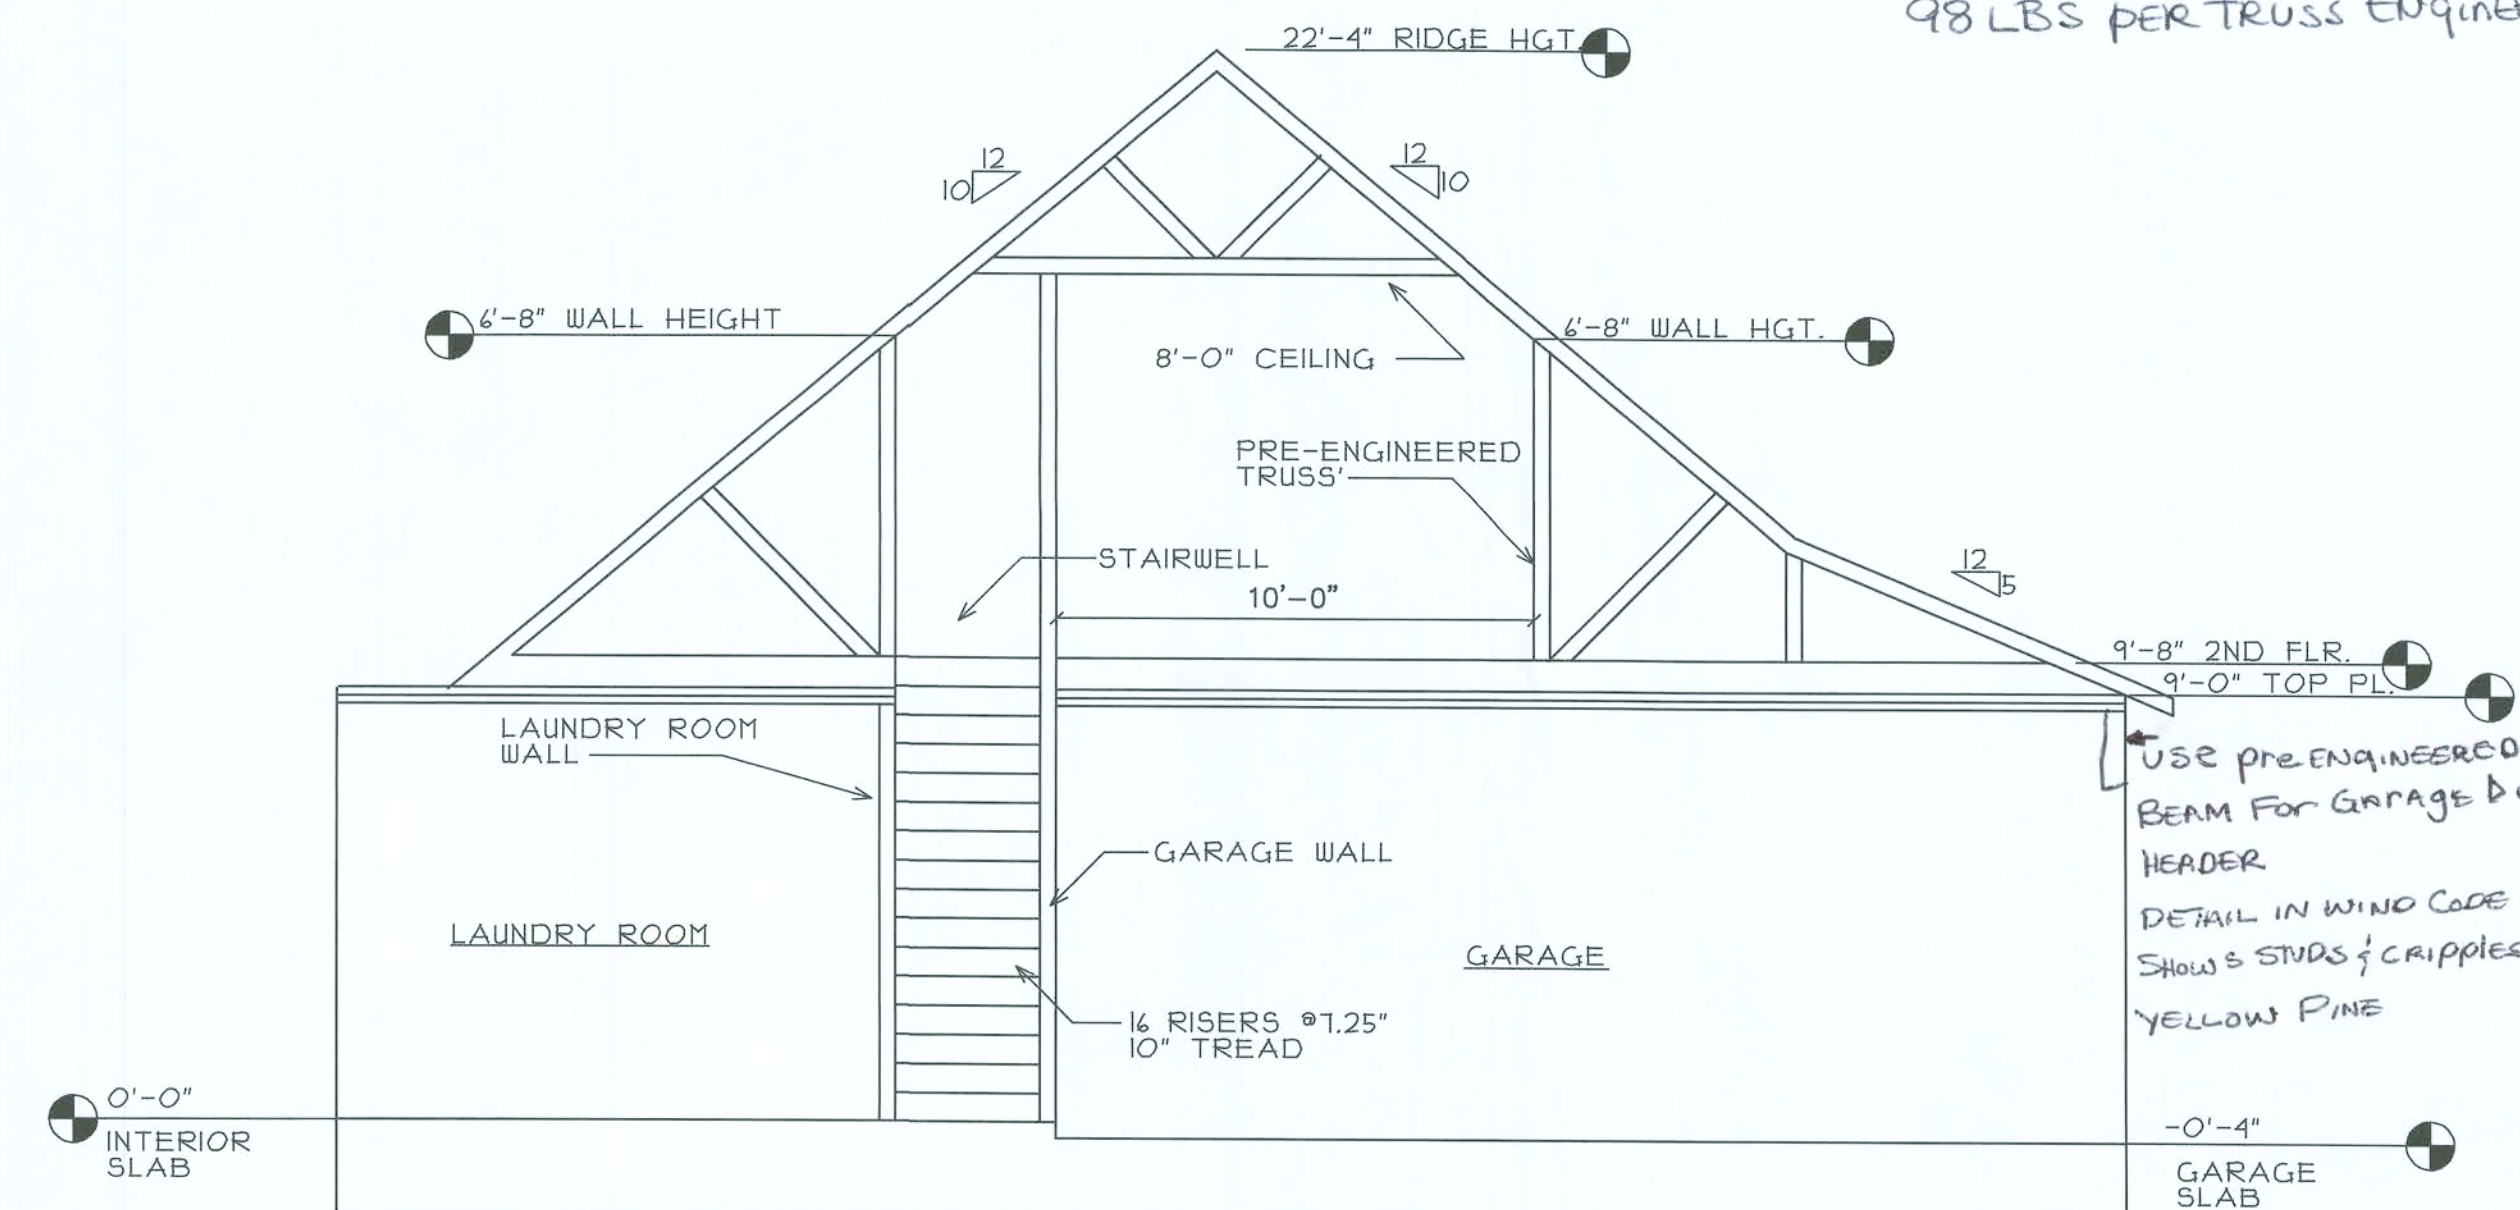

BONUS ROOM STAIR LAYOUT
SCALE: 1/4" = 1'-0"

NOTE: Dormer Walls 2X4 PINE
DOUBLE 2X4 TOP PLATE
1/2" CDX plywood on WALLS
COVERED WITH HARDI BOARD
PRE-ENGINEERED TRUSSES
USE Simpson H8 @ EACH STUD
Connect to truss below USE #2S
From Dormer Truss to Top plate
Uplift @ Each Truss Dormer's
98 LBS PER TRUSS ENGINEERING


TOTAL Uplift ON BEAM
7 TRUSS @ 287 LBS ea Equals
A TOTAL of 2009 LBS Divide
By 2 = 1005 LBS. on EACH
END of BEAM USE Simpson
MGT w 5/8" Anchor Bolt
ON EACH END of BEAM

DRAWN BY: STEVE RYALL
Steve Ryall Architectural Drafting
16194 NW 212th Terrace
High Springs, Florida 32643
(352) 811-4251 houseplan@alltel.net


PROJECT: DAVE & MELISSA WATSON
SHEET TITLE: 2ND FLOOR PLAN

JOB NUMBER: SCALE: 1/4" = 1'-0"
DATE: SEPTEMBER 14, 2004

235 N.E. 2nd St.
P.O. Box 1233, High Springs, FL 32655
Phone: (386) 454-2416 Fax: (386) 454-4244
Email: oneilconstruction@alltel.net
License # CGC061581

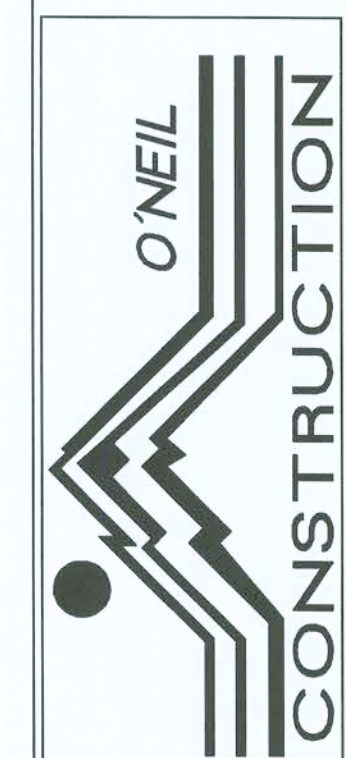

SHEET NO:
3

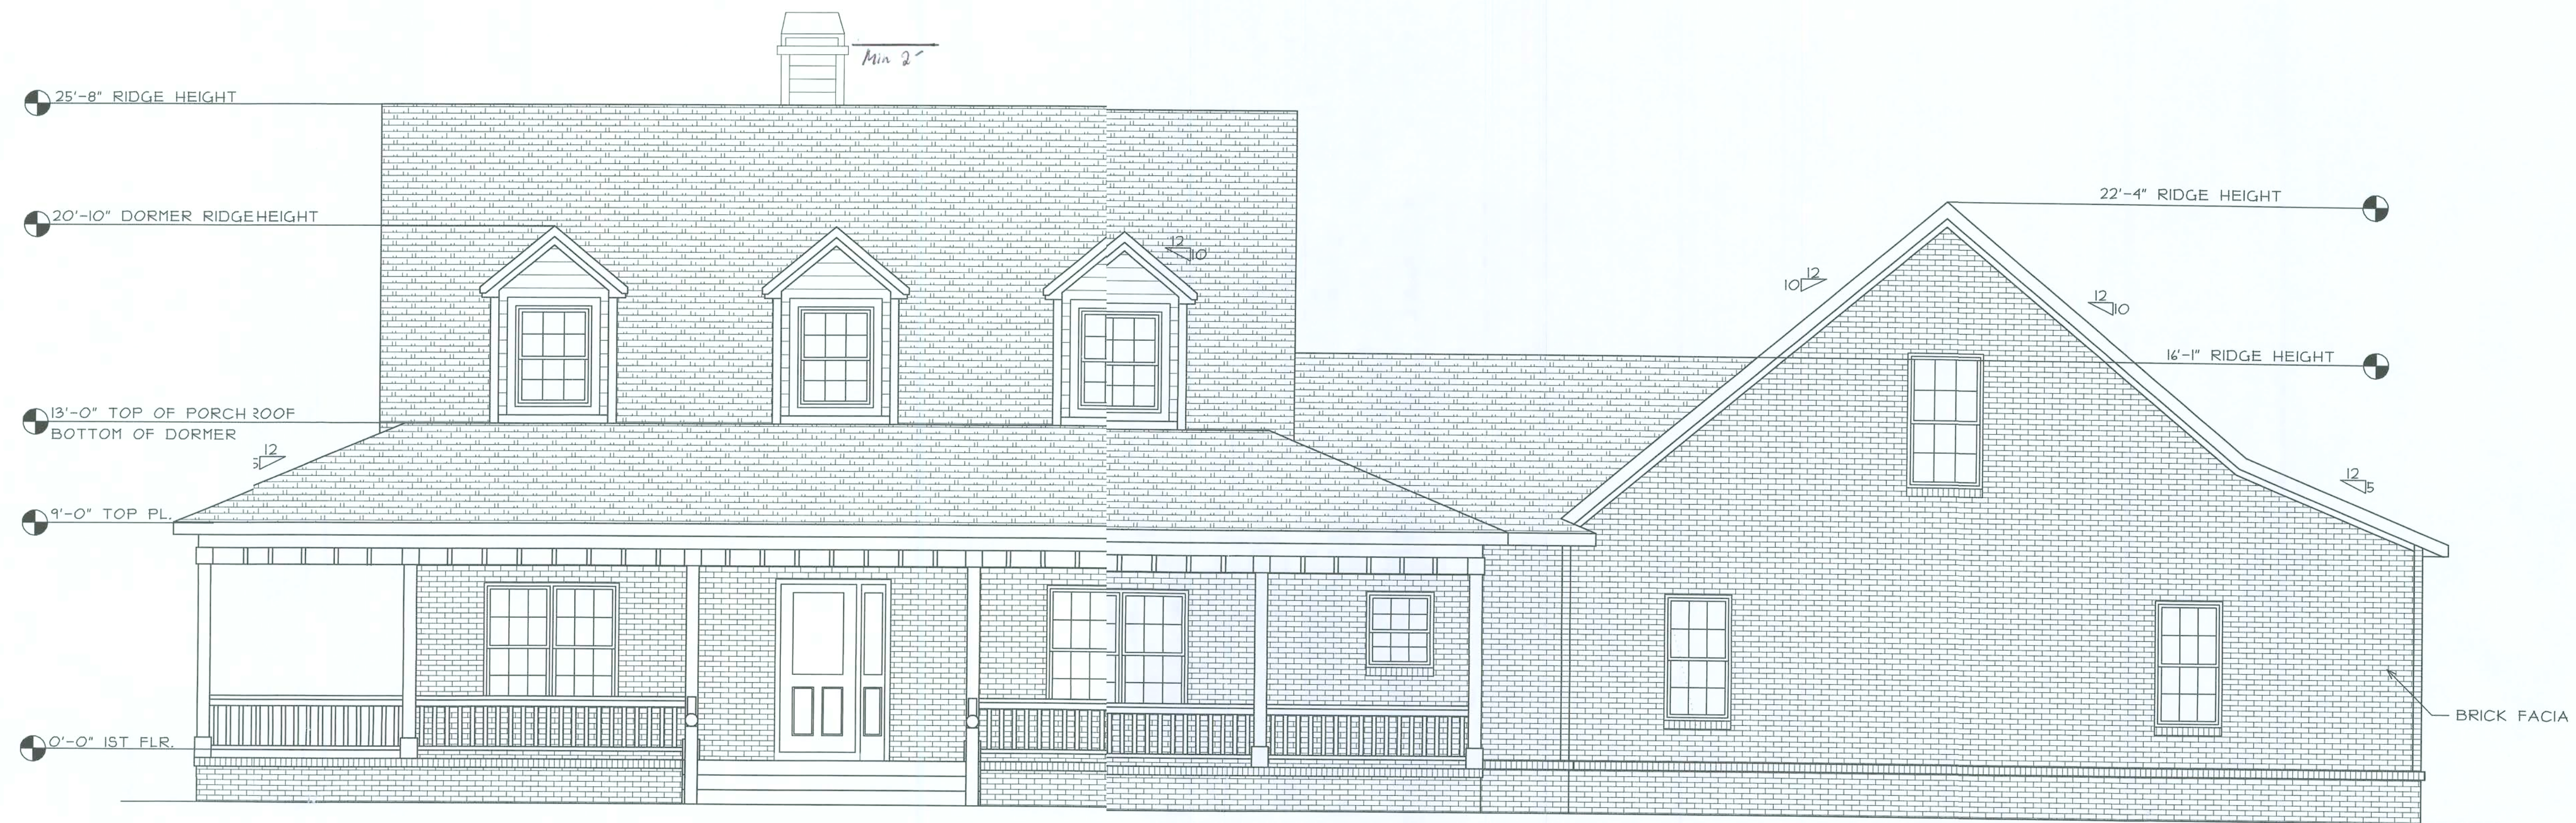

FRONT ELEVATION
SCALE: 1/4" = 1'-0"



REAR ELEVATION
SCALE: 1/4" = 1'-0"

DRAWN BY: STEVE RYALL
Steve Ryall Architectural Drafting
16194 NW 22th Terrace
High Springs, Florida 32643
(352)871-4251 houseplan@alltel.net

PROJECT: DAVE & MELISSA WATSON
SHEET TITLE: ELEVATIONS


JOB NUMBER:
SCALE: 1/4" = 1'-0"
DATE: SEPTEMBER 14, 2004

235 N.E. 2nd St.
P.O. Box 1633, High Springs, FL 32655
Phone: (386)454-2416 - Fax: (386)454-4244
E-Mail: oneilconstruction@alltel.net
License # CGCO61581




SHEET NO:

4

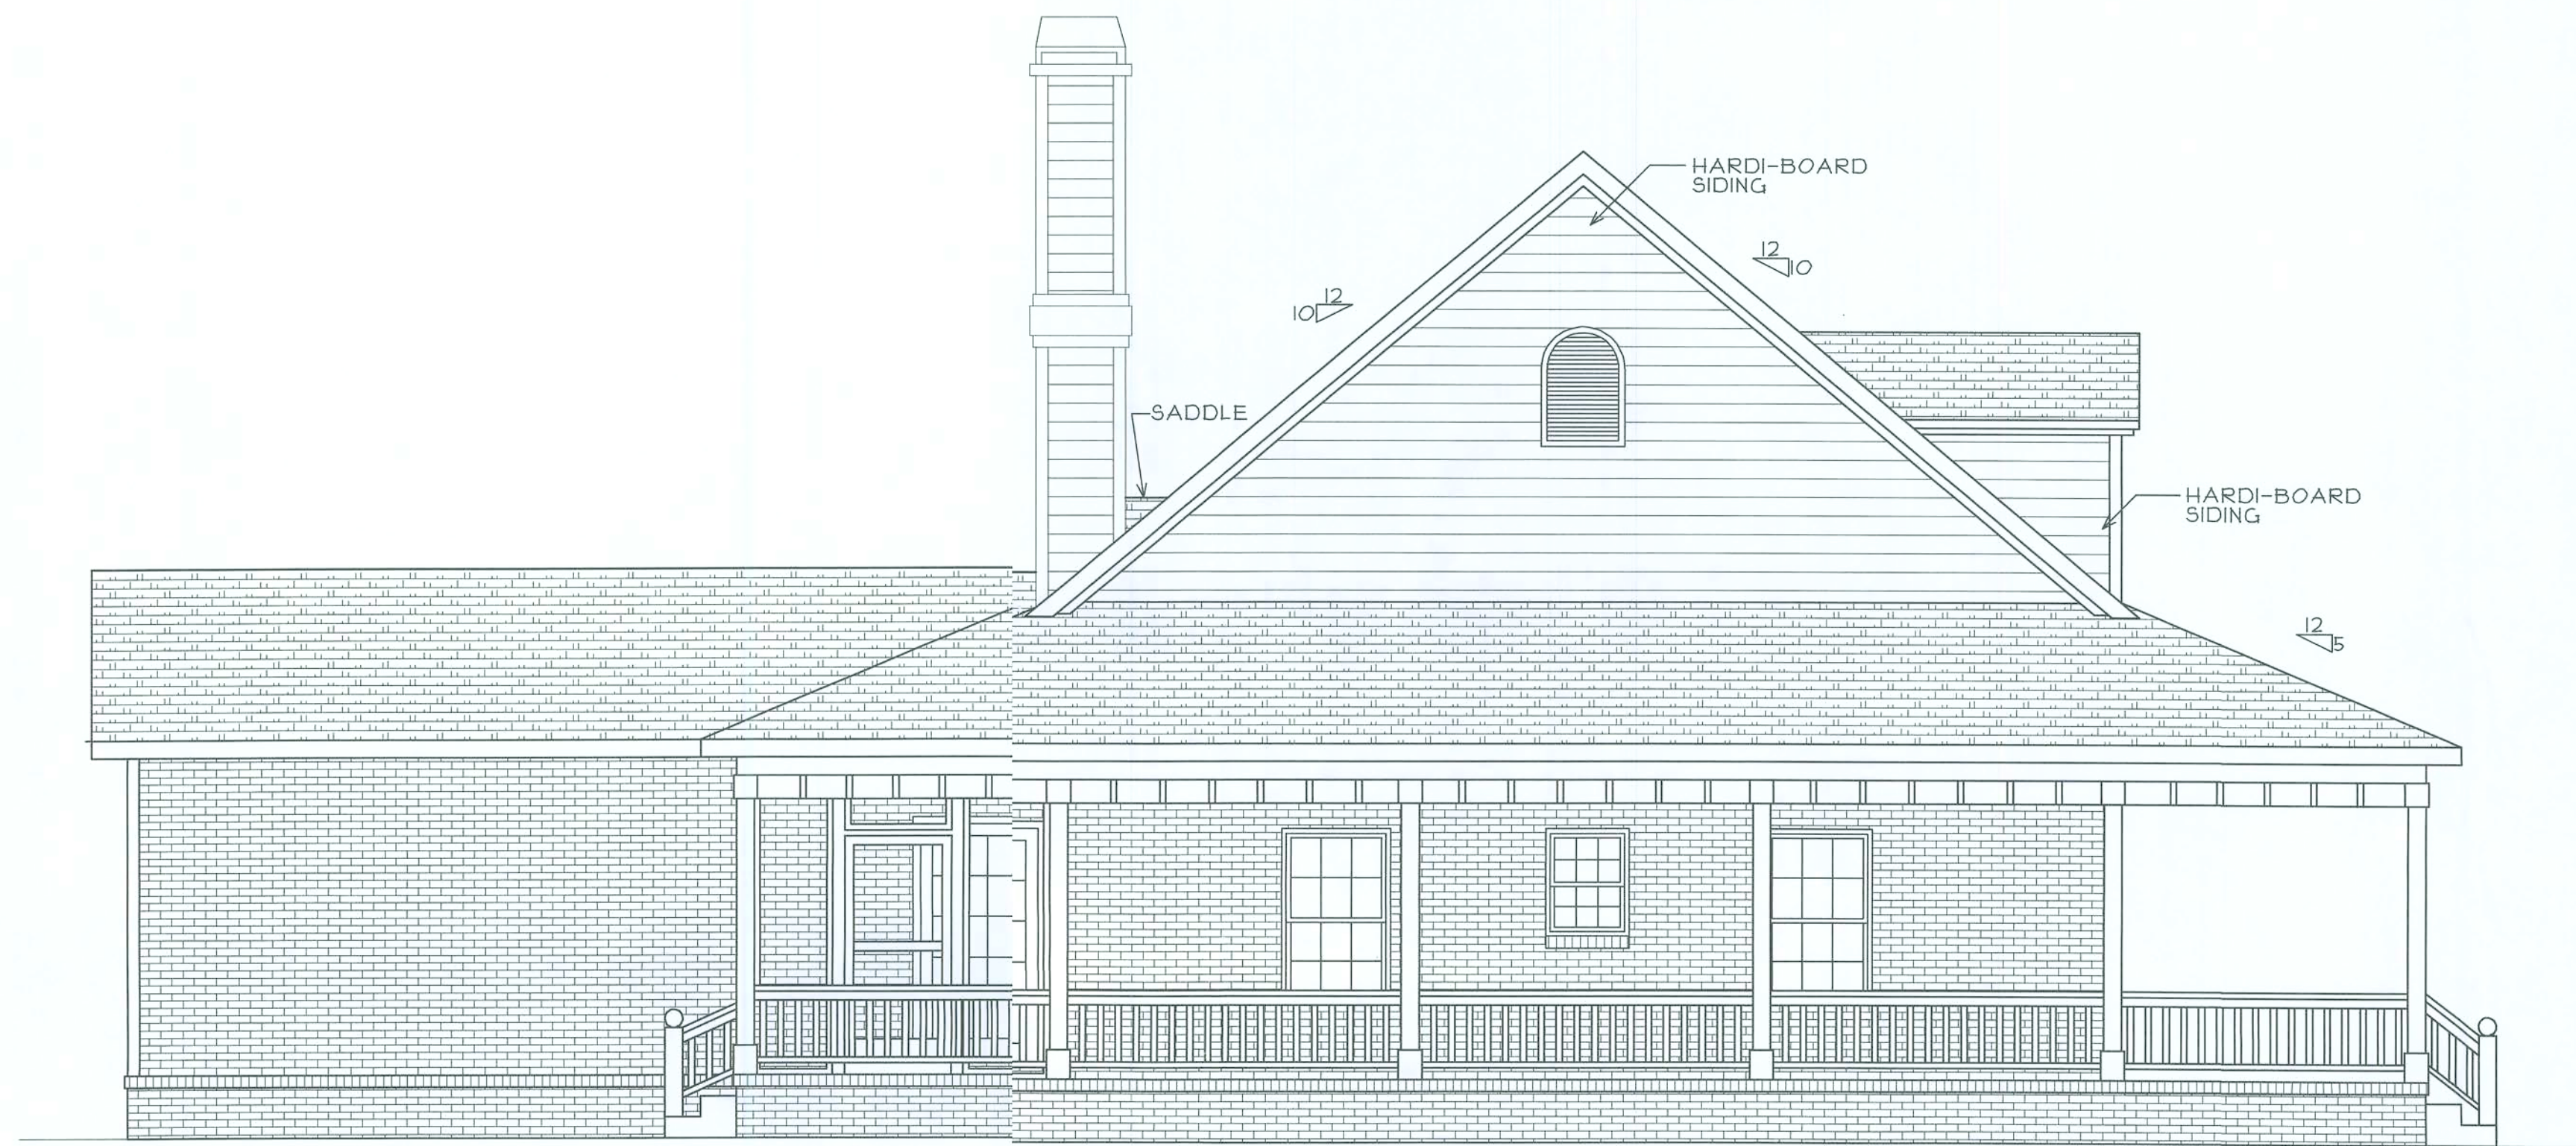

LEFT ELEVATION
SCALE: 1/4" = 1'-0"

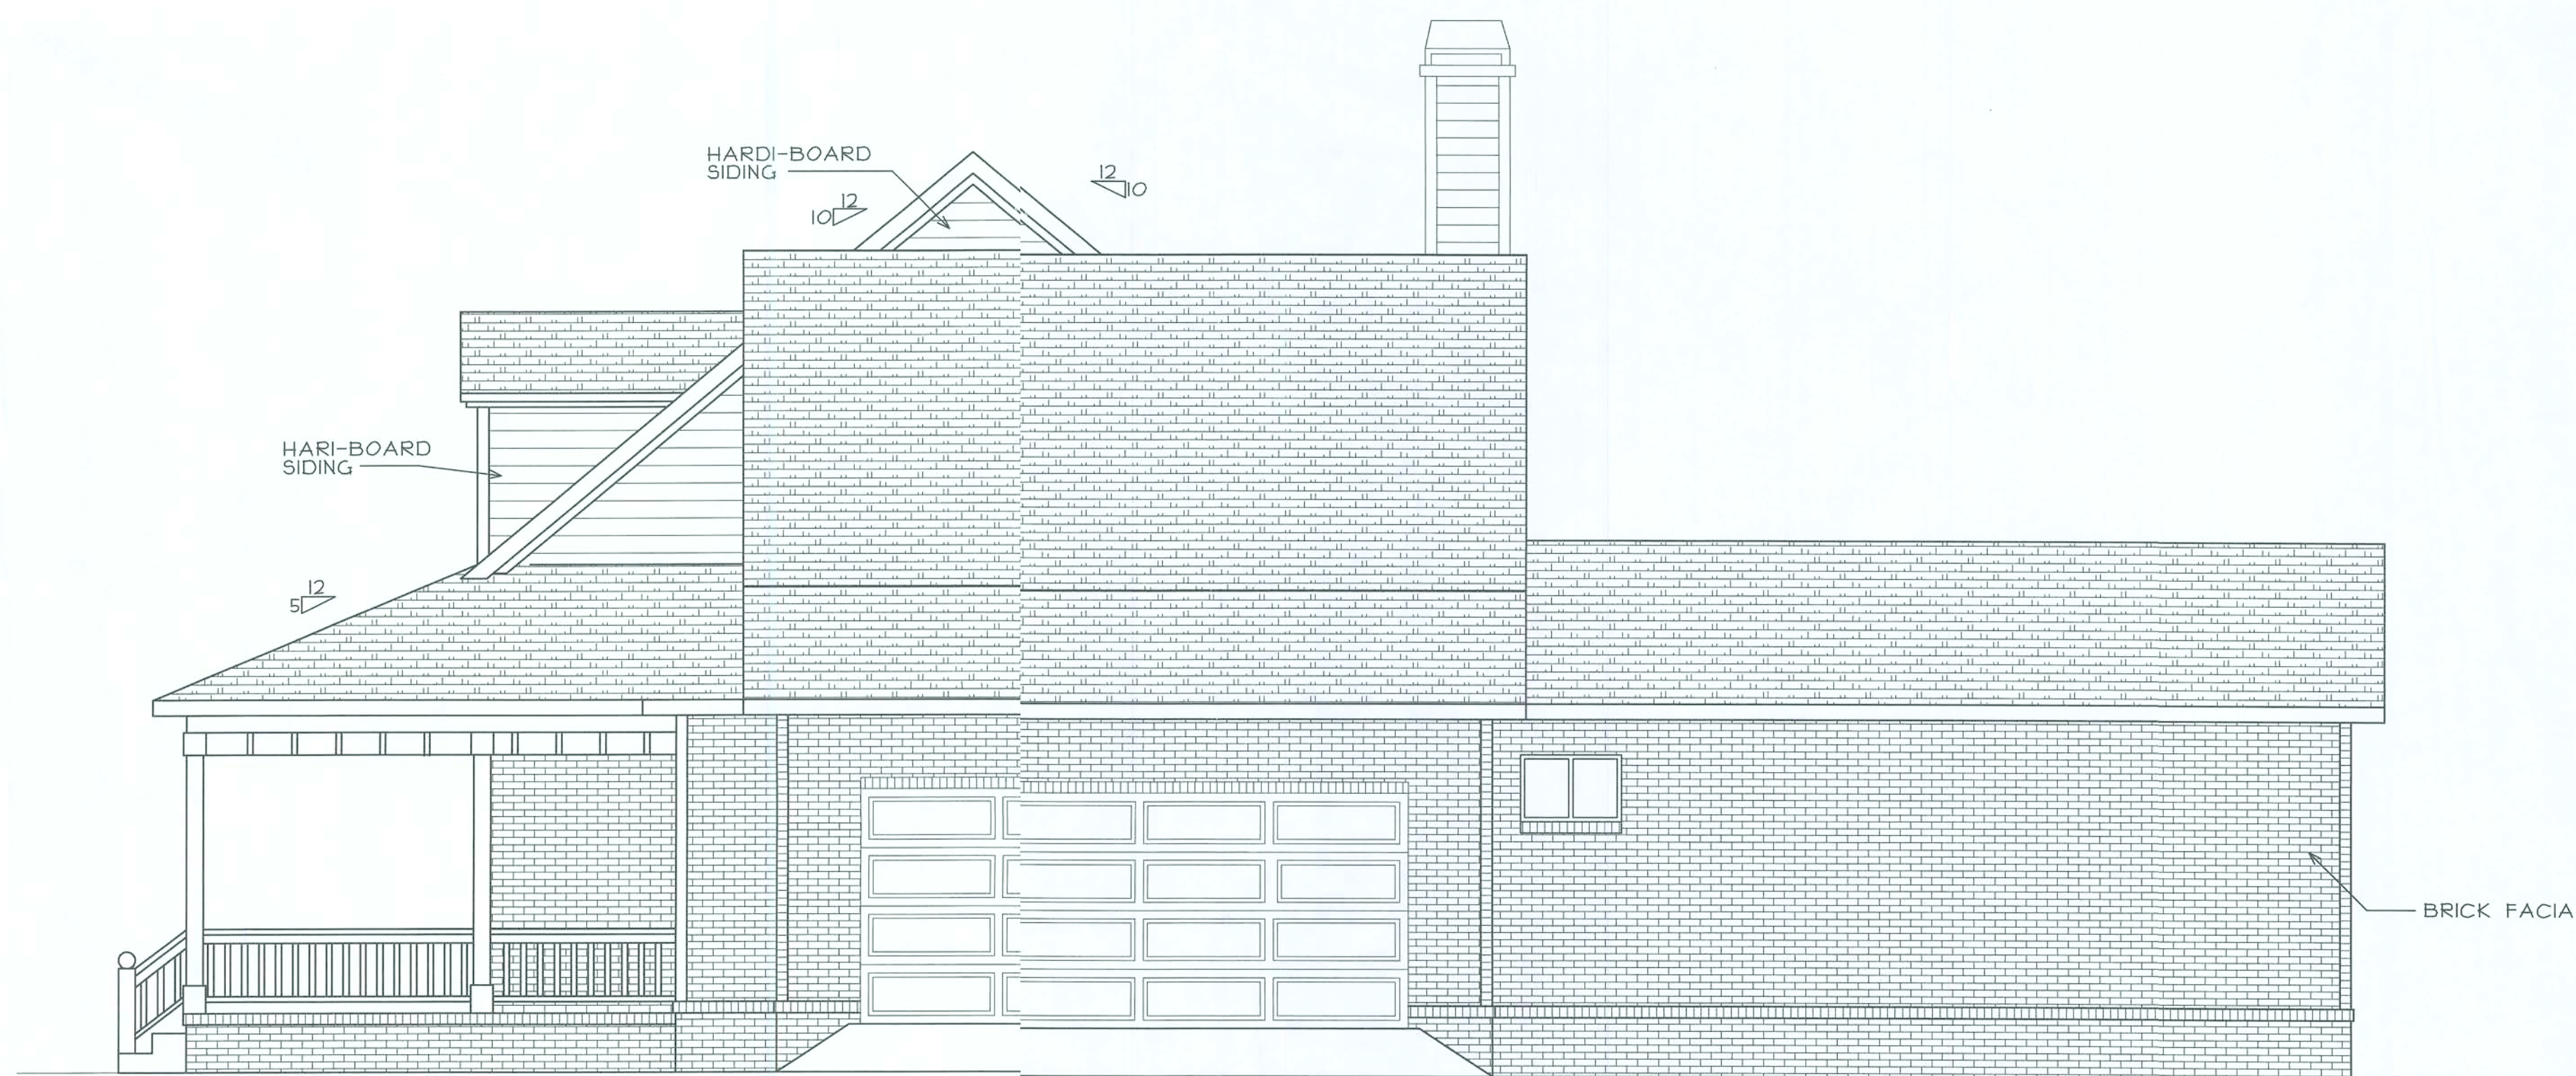

RIGHT ELEVATION
SCALE: 1/4" = 1'-0"

DRAWN BY: STEVE RYALL
Steve Ryall Architectural Drafting
1614 NW 22nd Terrace
High Springs, Florida 32443
(352)811-6251 hoaseplan@alltel.net

PROJECT:
DAYE & HELOSA WATSON

SHEET TITLE:
ELEVATIONS

JOB NUMBER:
SCALE: 1/4" = 1'-0"

DATE:
SEPTEMBER 14, 2006

235 N.E. 2nd St.
P.O. Box 1633, High Springs, FL 32655
Phone: (386)454-2416 - Fax: (386)454-4244
E-Mail: onelconstruction@alltel.net
License # CGCO6581




SHEET NO:


5

LIGHTING & ELECTRICAL LEGEND	
	CEILING FAN WITH INCANDESCENT LIGHT FIXTURE
	SMOKE DETECTOR
	RECESSED INCANDESCENT
	SINGLE SWITCH
	3-WAY SWITCH
	DUPLEX RECEPTACLE
	DUPLEX GFI RECEPTACLE
	ARC-FAULT RECEPTACLE
	220 OUTLET
	RANGE RECEPTACLE
	WEATHER-PROTECTED DUPLEX
	SWITCHED DUPLEX
	PENDANT LIGHT FIXTURE
	DISHWASHER
	GARBAGE DISPOSAL
	REFRIGERATOR
	MICROWAVE/FAN
	GAS RANGE
	CLOTHES WASHER
	GAS SUPPLY
	SECURITY LIGHT
	TV/CABLE OUTLET
	PHONE/ETHERNET
	EXHAUST FAN
	EXHAUST FAN W/LIGHT
	2X4 SURFACE FLOURESCENT
	SURFACE FLOURESCENT
	WALL-MOUNTED INCANDESCENT
	SURFACE-MOUNTED LIGHT FIXTURE

NOTE:
ALL BRANCH CIRCUITS SUPPLYING OUTLETS
WITHIN A BEDROOM SHALL BE PROTECTED
BY ARC-FAULT INTERRUPTER DEVICES

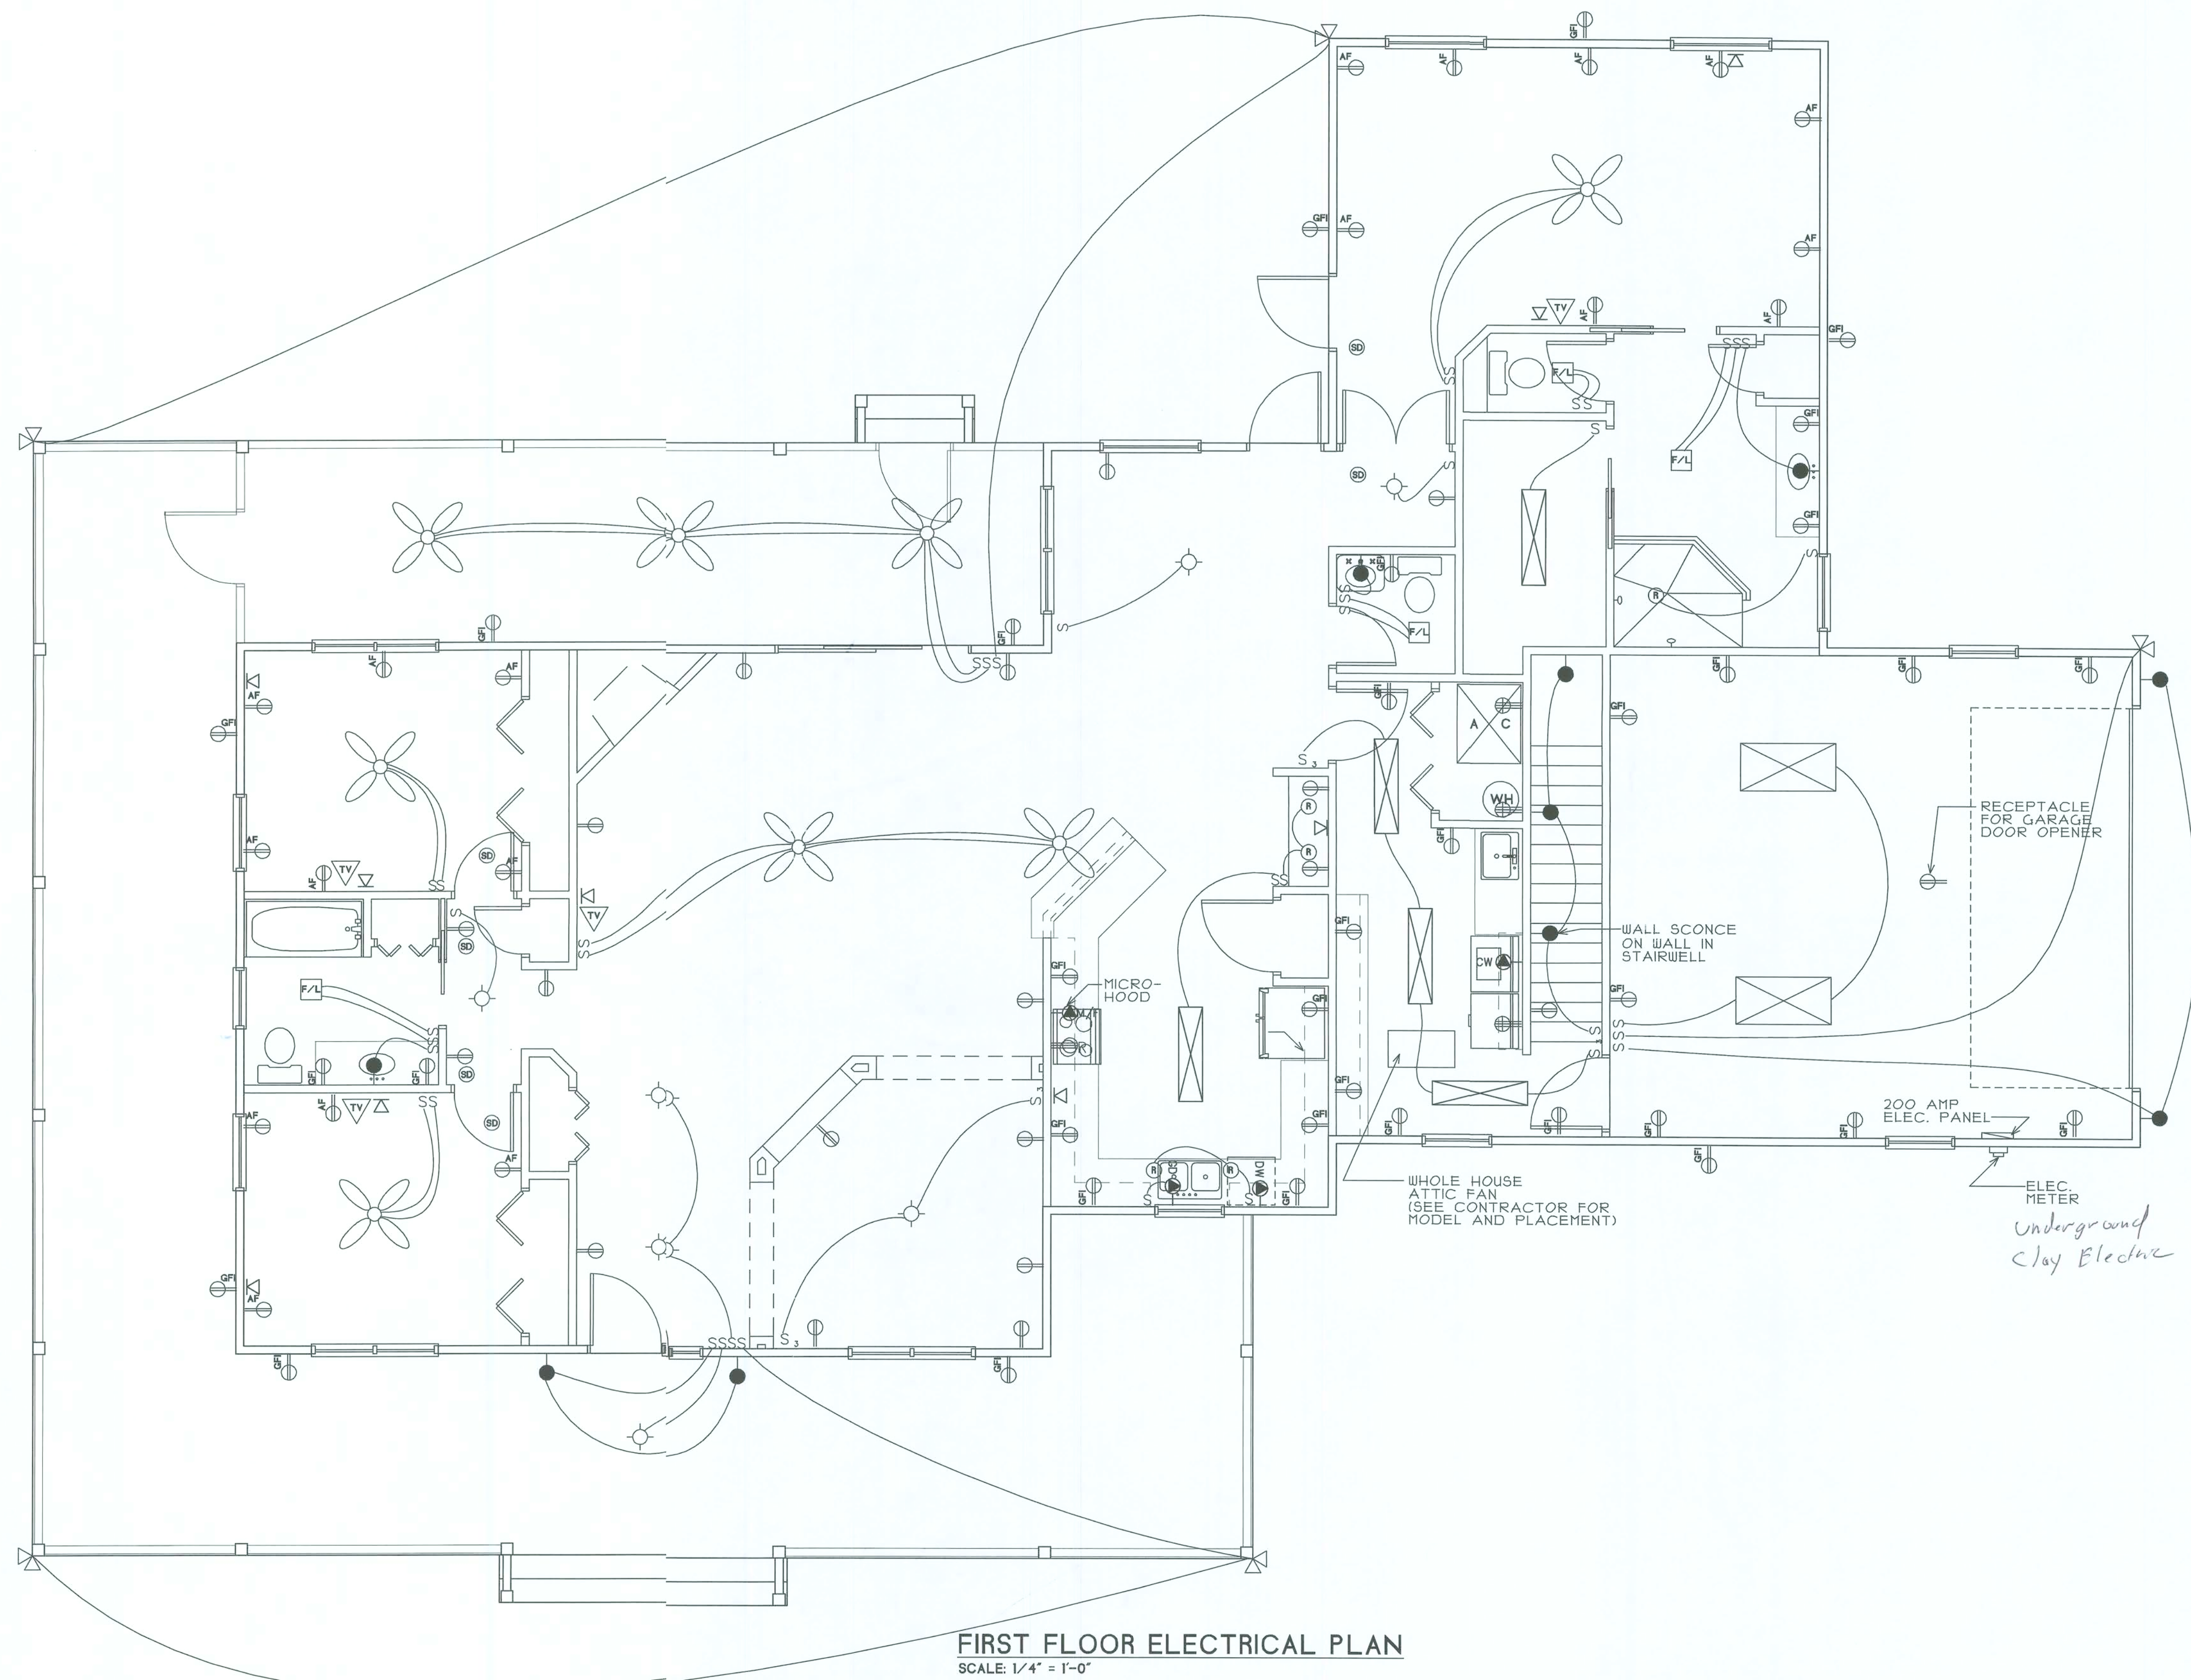

FIRST FLOOR ELECTRICAL PLAN
SCALE: 1/4" = 1'-0"

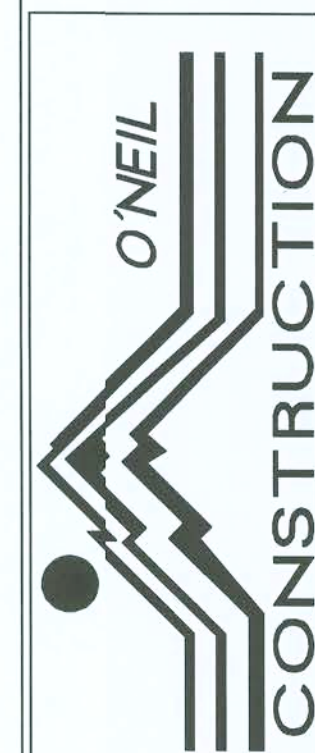

SHEET NO:

6


235 N.E. 2nd St.
P.O. Box 1633, High Springs, FL 32655
Phone: (386)454-2476 - Fax: (386)454-4244
Email: onelconstruction@alltel.net
License # CGC061581

JOB NUMBER:
SCALE: 1/4" = 1'-0"
DATE: SEPTEMBER 14, 2004

PROJECT: DAVE & MELISSA WATSON
SHEET TITLE: FIRST FLOOR ELECTRICAL PLAN

DRAWN BY: STEVE RYALL
Steve Ryall Architectural Drafting
16144 NW 212th Terrace
High Springs, Florida 32643
(352)871-4251 houseplan@alltel.net

- TRUSS NOTES:**
1. ALL TRUSSES SHALL CARRY MANUFACTURERS STAMP.
 2. ALL TRUSSES SHALL BE INSTALLED & BRACED TO MANUFACTURERS SPECIFICATIONS.
 3. DESIGN DETAILS AND DRAWINGS FOR ALL TRUSSES SHALL BE ON-SITE FOR FRAMING INSPECTION.
 4. TRUSSES SHALL NOT BE FIELD ALTERED WITHOUT PRIOR BUILDING DEPT. APPROVAL OF ENG. CALCULATIONS.
 5. NON-BEARING WALLS SHOULD BE HELD DOWN FROM THE TRUSSES' BOTTOM CHORD W/ SIMPSON STC TO INSURE THE TRUSSES' BOTTOM CHORD WILL NOT BEAR ON THE WALL.
 6. ALL CONNECTIONS OF RAFTERS, JACK OR HIP TRUSSES TO MAIN GIRDER TO BE PROVIDED BY TRUSS MANUFACTURER.
 7. ALL ROOF FRAMING 24" O.C.
 8. MAIN ROOF PITCH & DORMERS 10:12. ALL OTHERS 5:12.
 9. ALL OVERHANGS 1'-0" EXCEPT DORMERS (6").

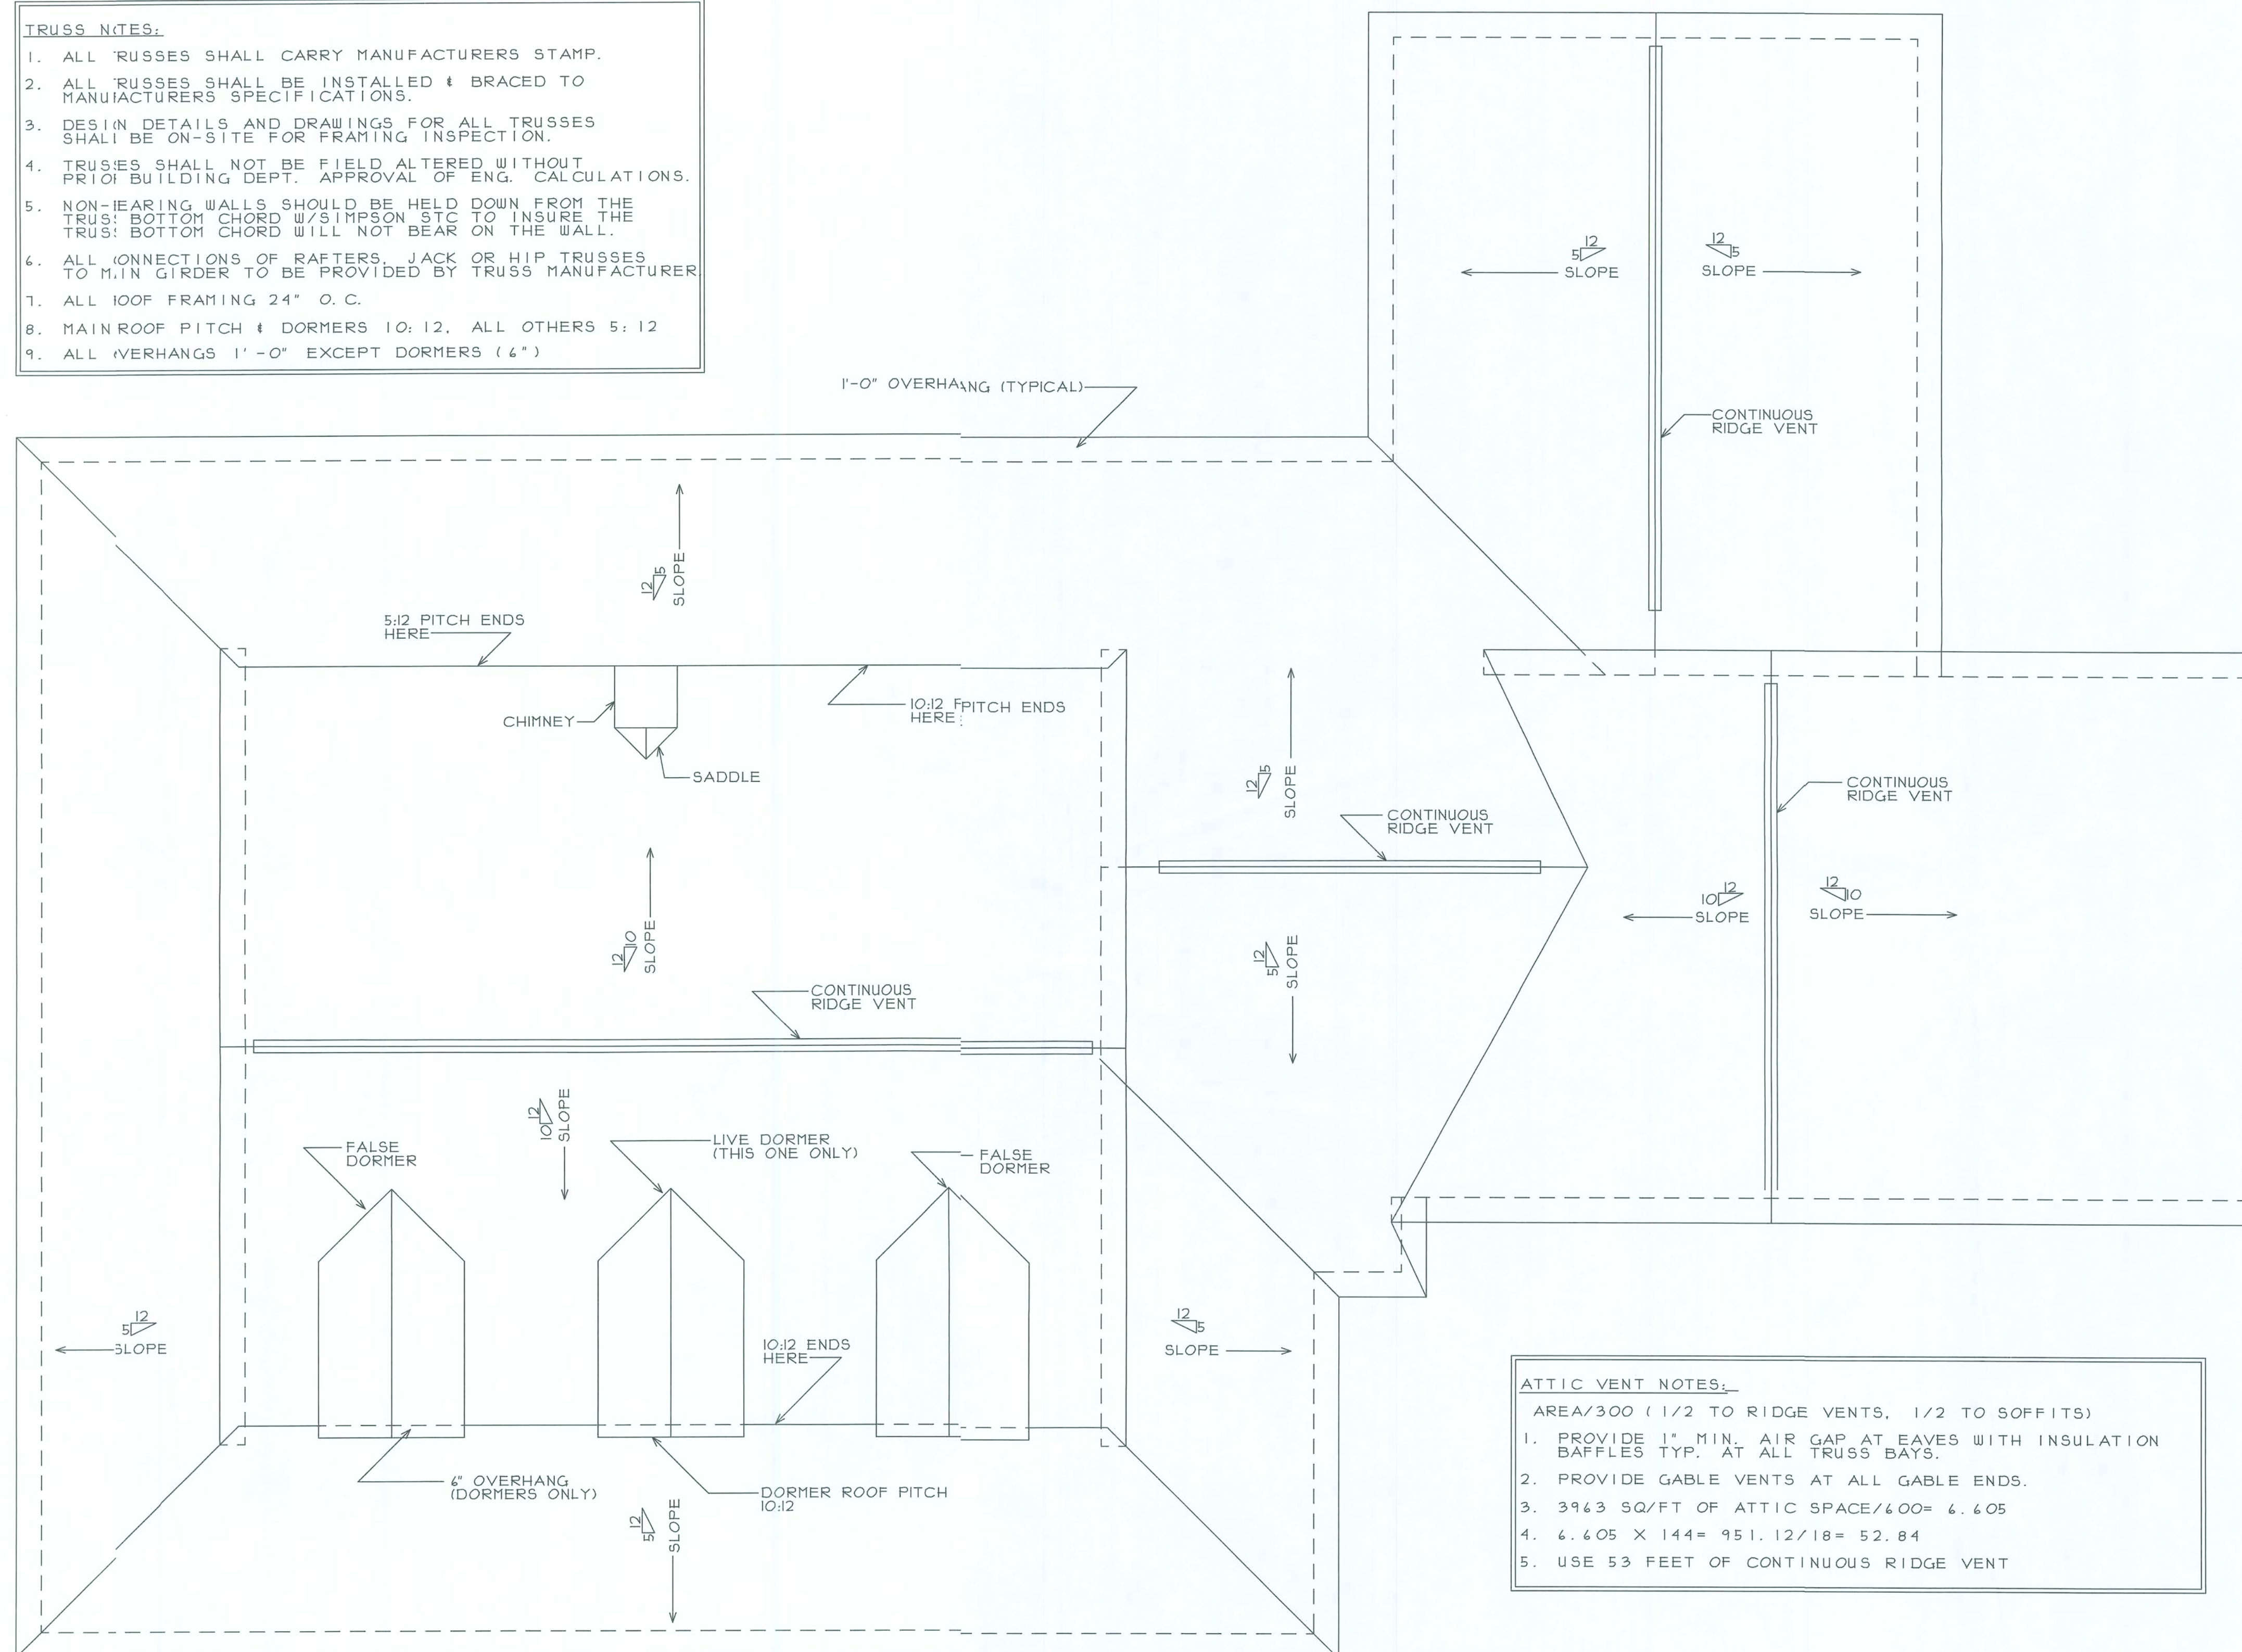

ROOF PLAN
SCALE: 1/4" = 1'-0"

- ATTIC VENT NOTES:**
- AREA/300 (1/2 TO RIDGE VENTS, 1/2 TO SOFFITS)
1. PROVIDE 1" MIN. AIR GAP AT EAVES WITH INSULATION Baffles TYP. AT ALL TRUSS BAYS.
 2. PROVIDE GABLE VENTS AT ALL GABLE ENDS.
 3. 3963 SQ/FT OF ATTIC SPACE/600= 6.605
 4. 6.605 X 144= 951.12/18= 52.84
 5. USE 53 FEET OF CONTINUOUS RIDGE VENT



SHEET NO:

7

235 N.E. 2nd St.
P.O. Box 1232, High Springs, FL 32665
Phone: (386)454-2476 - Fax: (386)454-4244
Email: oneilconstruction@att.net
License # CGC061581

JOB NUMBER:
SCALE: 1/4" = 1'-0"
DATE: SEPTEMBER 14, 2004

PROJECT: DAVE & MELISSA WATSON
SHEET TITLE: ROOF PLAN

DRAWN BY: STEVE RYALL
Steve Ryall Architectural Drafting
1494 NW 20th Terrace
High Springs, Florida 32643
(352)811-4251 houseplan@att.net