


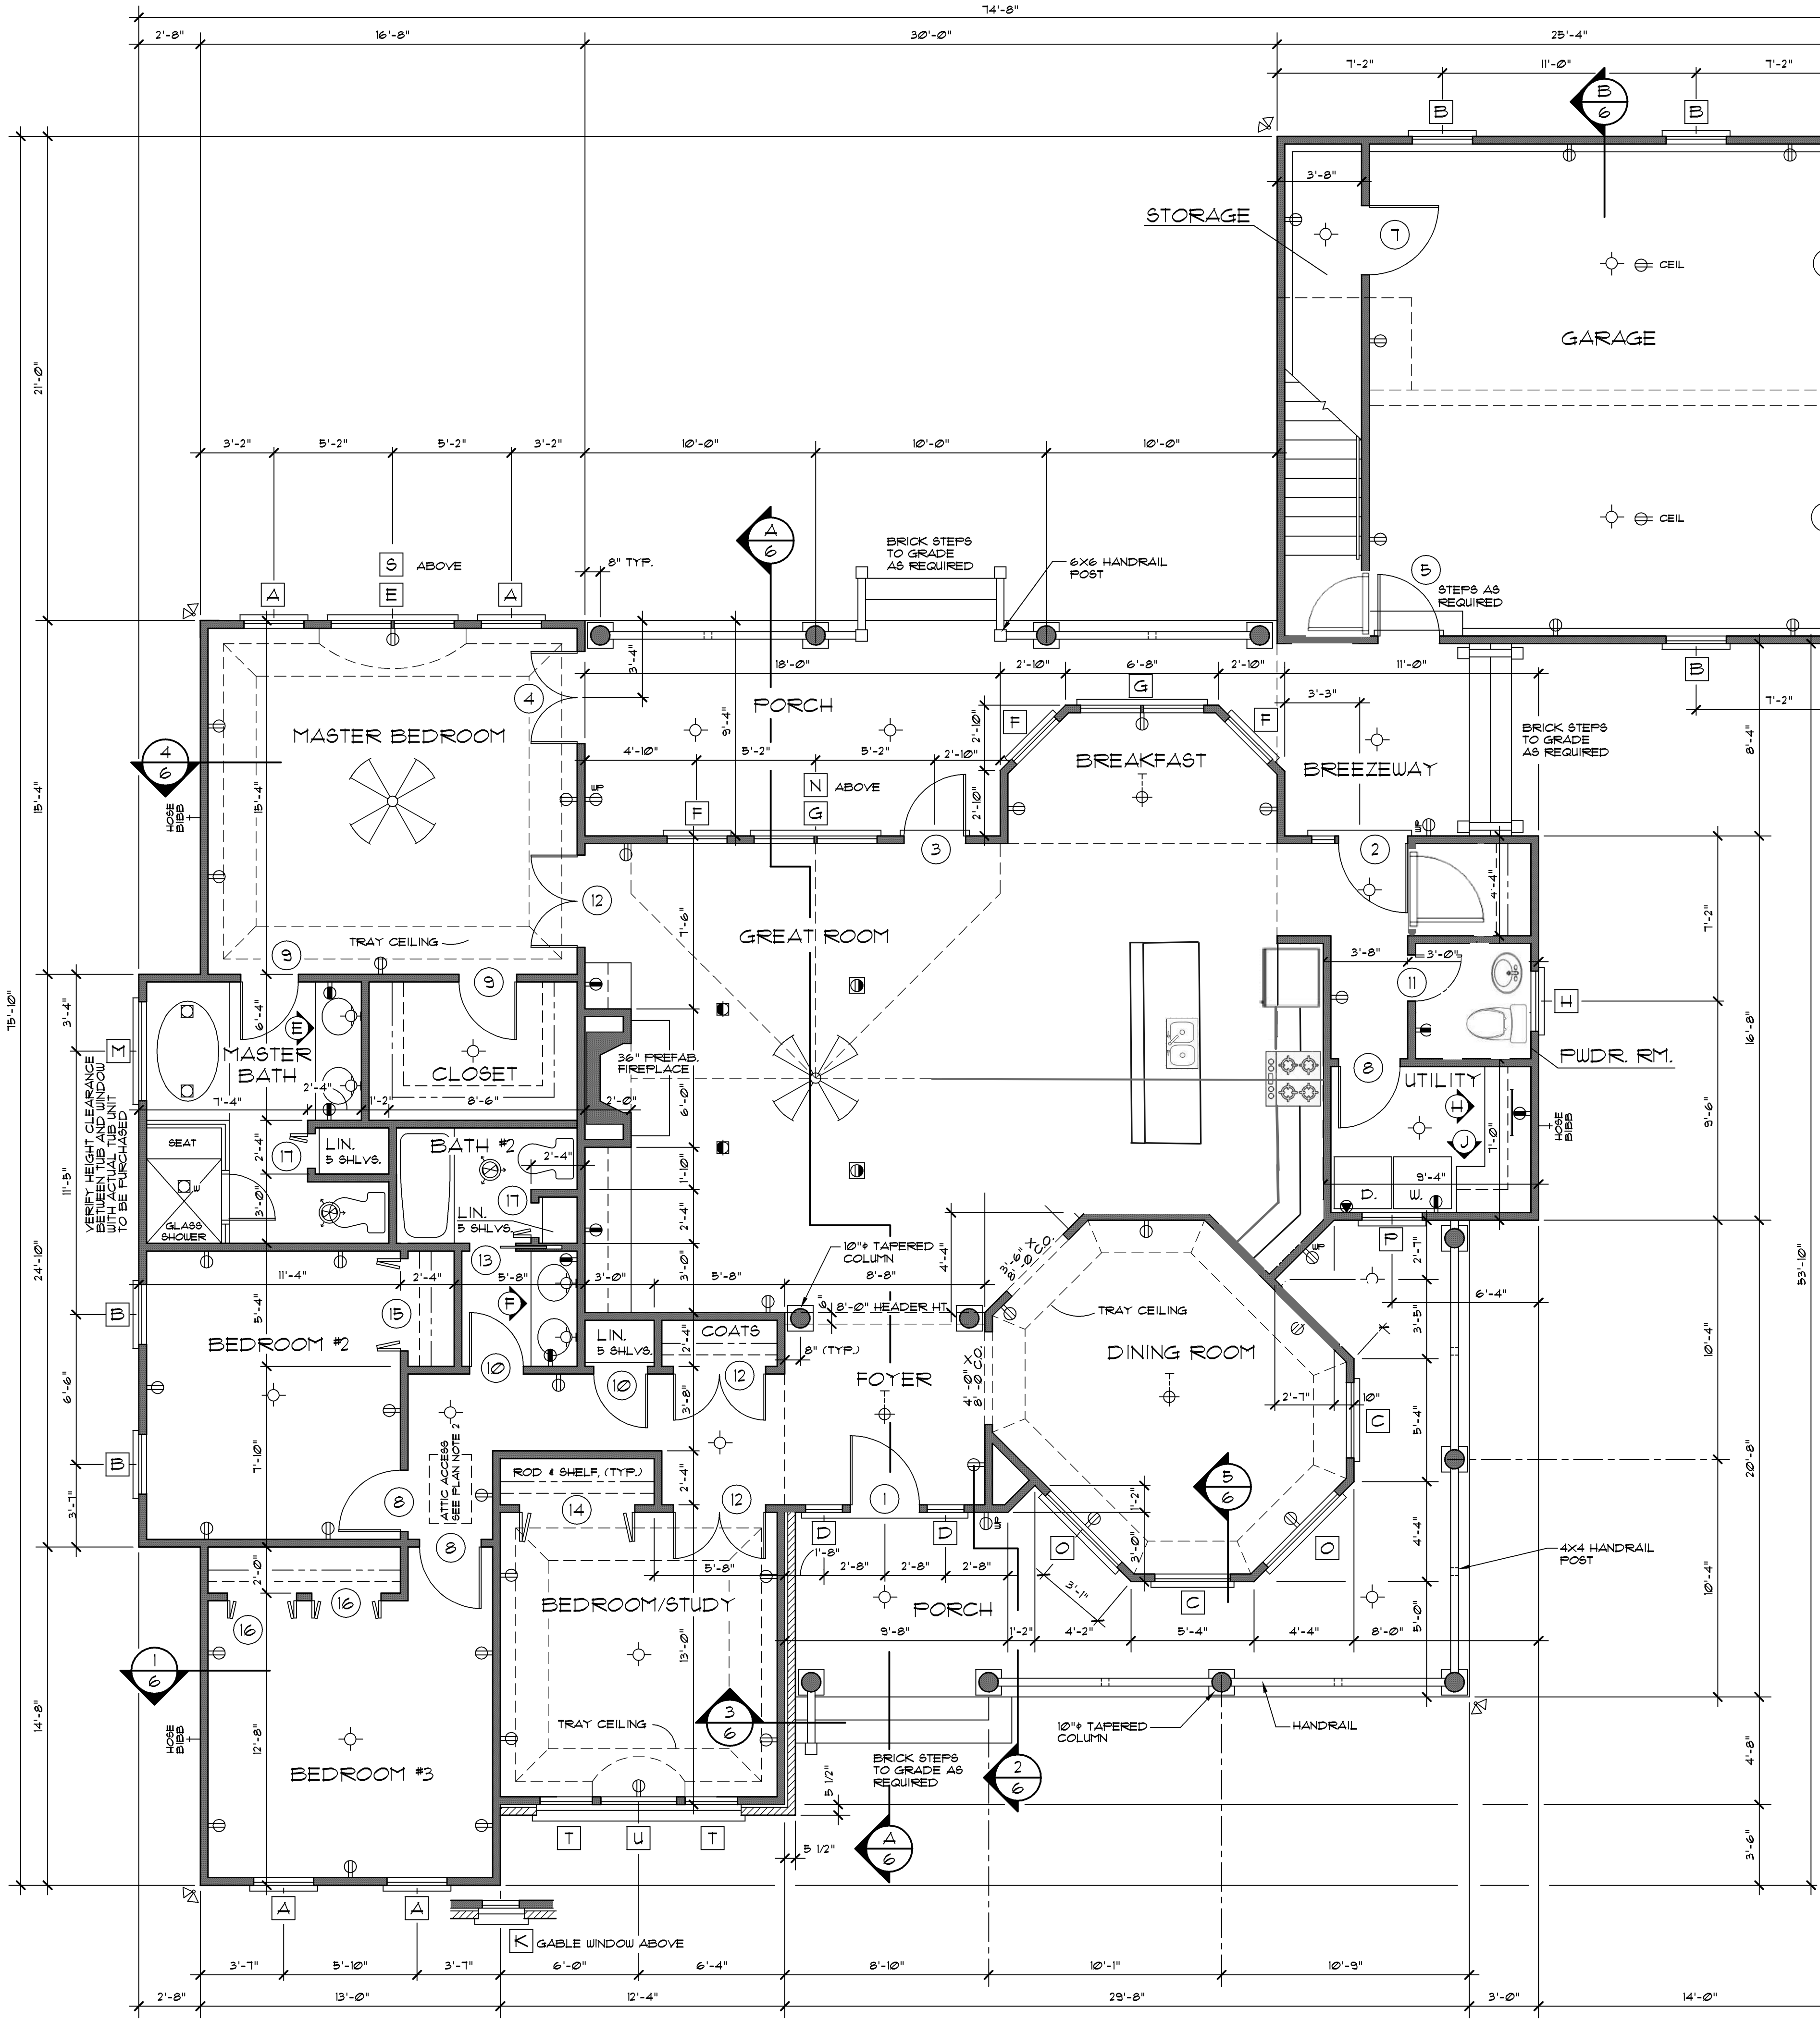

FLOOR PLAN

TOTAL LIVING 2273 sq. ft.
GARAGE + STORAGE 528 sq. ft.
BONUS ROOM 342 sq. ft.

BONUS ROOM FLOOR PLAN

1/4" = 1'-0"

ELECTRICAL LEGEND

SYMBOL	DESCRIPTION
	DUPLEX OUTLET (GROUNDED TYPE)
	WEATHER PROOF DUPLEX OUTLET
	WALL SWITCH CONTROLLED DUPLEX OUTLET
	ABOVE COUNTER LOCATION
	FLUSH FLOOR WALL SWITCH CONTROLLED DUPLEX OUTLET, OWNER VERIFY LOCATION
	220 VOLT OUTLET OR CONNECTION
	CEILING MOUNTED LIGHT FIXTURE
	WALL BRACKET MOUNTED LIGHT FIXTURE
	SUSPENDED CEILING MOUNTED LIGHT FIXTURE
	RECESSED DIRECTIONAL LIGHT FIXTURE
	RECESSED CEILING LIGHT FIXTURE
	RECESSED LIGHT FOR WET AREA
	UNDER COUNTER FLUORESCENT LIGHT
	EXTERIOR CAST ALUMINUM FLOOD LIGHTS
	CEILING MOUNTED FADDLE FAN w/ LIGHT
	CEILING MOUNTED FAN - EXHAUST
	CEILING MOUNTED FAN AND HEATER
	CEILING MOUNTED FAN, LIGHT, AND HEATER

PLAN NOTES:

1. VERIFY ALL LOCAL CODES, ENERGY TYPES, AND SITE CONDITIONS PRIOR TO CONSTRUCTION.
2. REVIEW SELECTED MECHANICAL SYSTEMS WITH OWNER PRIOR TO CONSTRUCTION.
REVIEW SUB-CONTRACTOR'S LOCATIONS OF THE WATER HEATER AND HVAC UNIT(S) WITH THE OWNER PRIOR TO CONSTRUCTION. VERIFY LOCAL BUILDING CODE REQUIREMENTS AND MANUFACTURER REQUIREMENTS FOR ATTIC OR GARAGE LOCATIONS.
H.V.A.C. EQUIPMENT IN THE ATTIC SPACE SHALL BE ACCESSIBLE BY AN OPENING LARGER THAN THE LARGEST PIECE OF EQUIPMENT (TO ALLOW REMOVAL OF THE EQUIPMENT) AND IN NO CASE LESS THAN 22"x36".
3. SEE STRUCTURAL DRAWINGS FOR ADDITIONAL INFORMATION.
4. INSULATE AROUND ALL BATHS AND UTILITY ROOM.
5. TYPICAL WALL, 2x4'S @ 16" O.C., UNLESS OTHERWISE DIMENSIONED.
6. PROVIDE SMOKE DETECTORS AS REQUIRED BY CODE.
7. PROVIDE DOORBELLS, TRANSFORMER, AND CHIME.


DOOR SCHEDULE

MARK	SIZE	QUAN.	DESCRIPTION
1	5'-6" x 6'-8"	1	EXT. Front door w/14" side lights
2	3'-0" x 6'-8"	1	EXT. 3/4 GLASS w/ 12" SIDELITE
3	2'-8" x 6'-8"	1	EXT. 3/4 GLASS
4	(2) 2'-0" x 6'-8"	1	EXT. 3/4 GLASS
5	2'-8" x 6'-8"	2	EXT.
6	8'-0" x 7'-0"	2	EXT. GARAGE
7	3'-0" x 6'-8"	1	INT.
8	2'-8" x 6'-8"	4	INT.
9	2'-6" x 6'-8"	2	INT.
10	2'-4" x 6'-8"	2	INT.
11	2'-0" x 6'-8"	1	INT.
12	(2) 2'-0" x 6'-8"	3	INT.
13	2'-0" x 6'-8"	1	INT. POCKET
14	5'-0" x 6'-8"	1	INT. BI-FOLD
15	4'-0" x 6'-8"	1	INT. BI-FOLD
16	3'-0" x 6'-8"	3	INT. BI-FOLD
17	1'-6" x 6'-8"	2	INT. BI-FOLD

WINDOW SCHEDULE


MARK	SIZE	QUAN.	DESCRIPTION
A	2'-8" x 6'-0	4	SH
B	2'-8" x 6'-0	5	SH
C	3' x 6'-0	3	SH
D	Front Door (part of)		
E	2'-8" x 6'-0	1	SH twin
F	2'-8" x 6'-0	3	SH
G	(2) 2'-8" x 6'-0	2	SH
H	2'-8" x 3'-6"	1	SH
J	3'-0 x 5'-0	2	SH Egress bonus room
K	1'-8" x 4'-0	1	Fixed circle top
L	2'-8" x 5'-6"	2	FIXED w/ CIRCULAR HEAD (Dormers)
M	4'-0 x 5'-0	1	FIXED
N	7'-4" DIA.	1	FIXED, CIRCLEHEAD
O	4'-0 x 6'-0	2	FIXED
P	2'-8" x 3'-0	1	FIXED
NO SKYLIGHTS			
S	5'-4" DIA.	1	FIXED, CIRCLEHEAD
T	2'-4" x 6'-0	2	SH
U	3'-4" x 6'-0	1	SH

ALL WINDOWS ARE INSULATED AND WEATHERSTRIPPED.
VERIFY LOCAL CODE EGRESS WINDOW REQUIREMENTS PRIOR TO CONSTRUCTION.
WINDOW MANUFACTURER TO PROVIDE TYPED GLASS WHERE REQUIRED BY CODE.
* SEE ELEVATION FOR TRANSOM.
* * VERIFY SKYLIGHT INSTALLATION REQUIREMENTS BEFORE CONSTRUCTION. IF CURB INSTALLATION IS RECOMMENDED DUE TO CLIMATIC CONDITIONS, MODEL NUMBER AND/OR ROUGH OPENING SIZE MAY VARY.

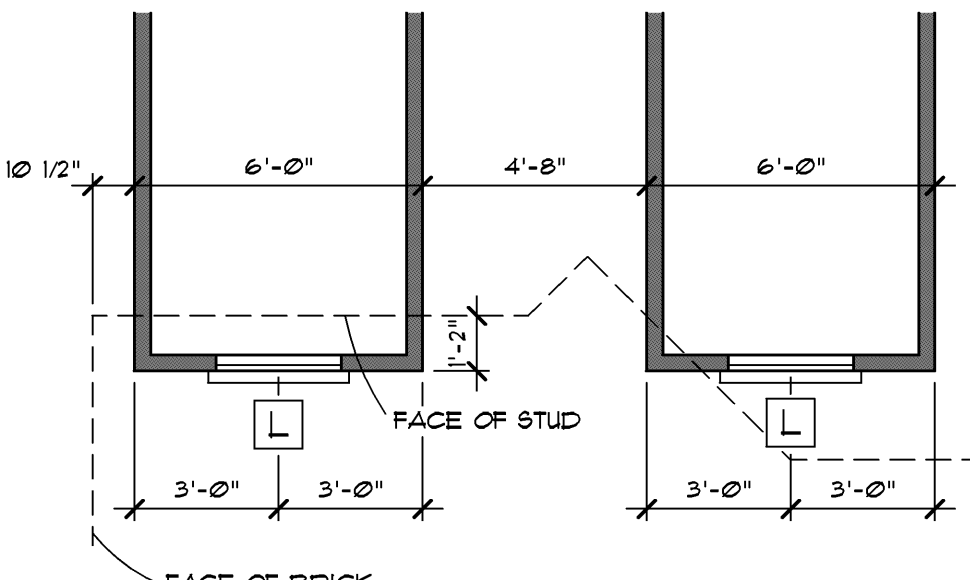

DORMER PLAN

1/4" = 1'-0"

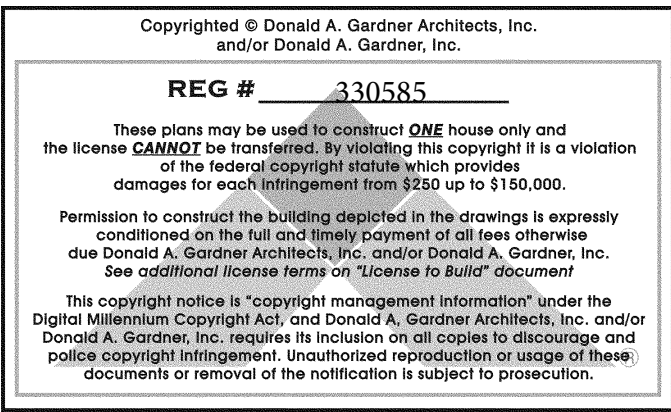

DO NOT SCALE DRAWINGS.
COPYRIGHT © 11/1/97 ALL RIGHTS RESERVED BY DONALD A. GARDNER, ARCHITECT, INC.
NOT TO BE COPIED OR REPRODUCED WITHOUT WRITTEN PERMISSION

DONALD A. GARDNER, INC.
P.O. BOX 26178 • GREENVILLE S.C. • 29616
864 • 288 • 7580
www.dongardner.com

DESIGN NO. 538-B
SHEET OF 3
FLOOR PLAN