
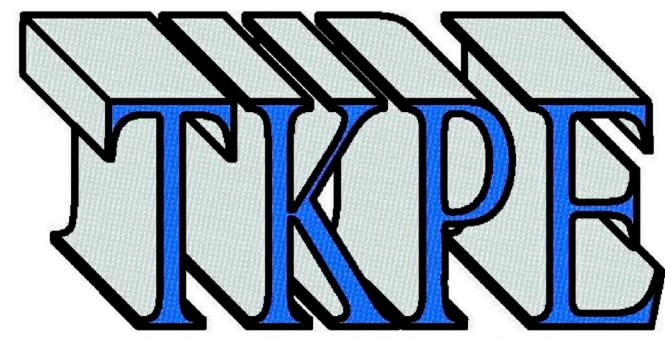


Dana & Carol (Wendy) Anderson Residence

SW Meadowlands Drive
Lake City, Florida

LOT 22 MEADOWLANDS S/D PHS 2. AFD 1029-257, WD 1148-1345, WD 1515-2011,

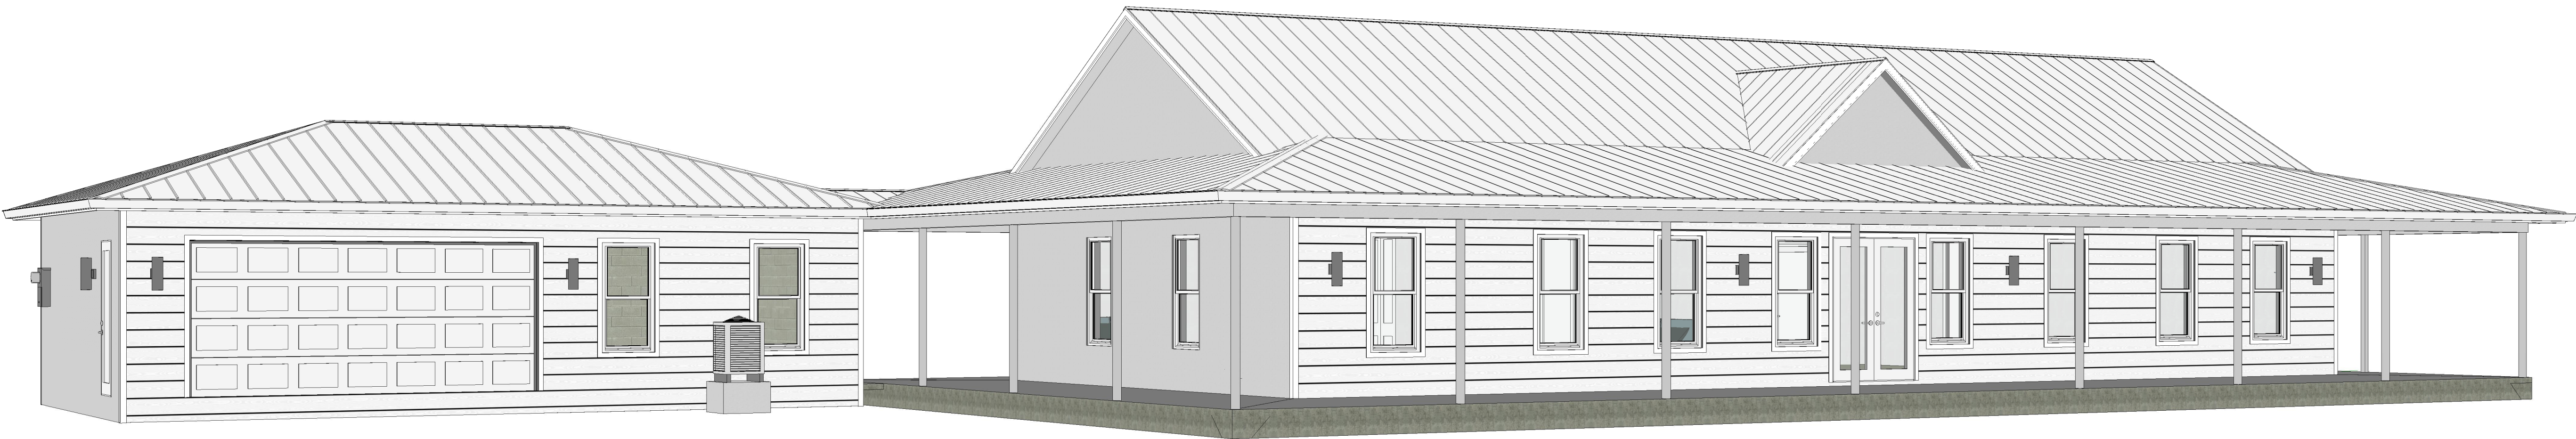


Thomas M. Kelaher, P.E.
Structural Consultants
Florida Rg. No 40159
1108 S.E. 14th Terrace
Deerfield Beach, FL 33441
Phone (954) 360.9628
Fax (954) 360.0173
tkelaherengr@comcast.net

Dana & Carol (Wendy) Anderson
Residence

SW Meadowlands Drive
Lake City, Florida

Vicinity Map

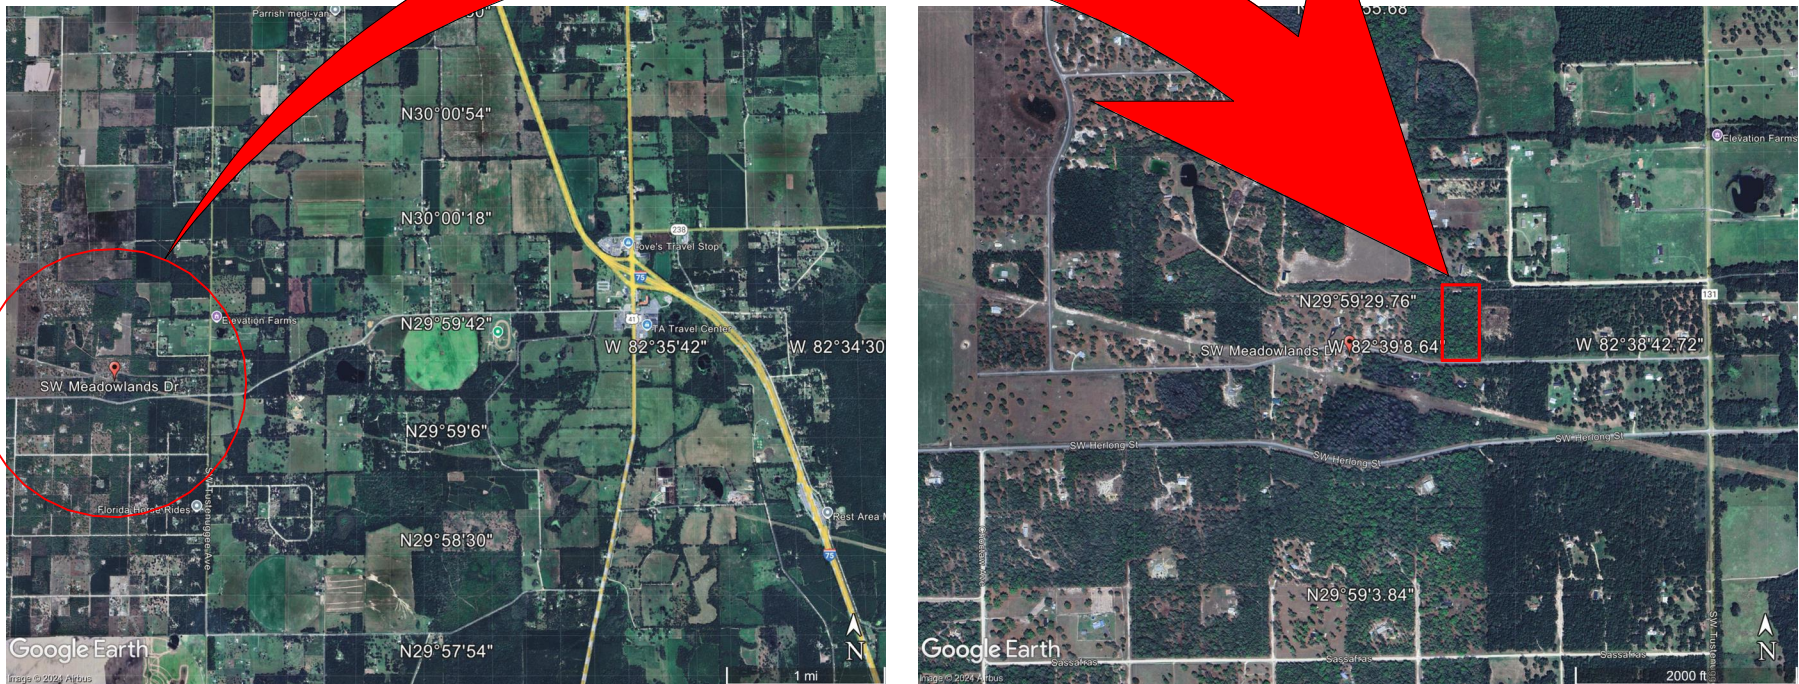

SINGLE FAMILY DWELLING

A/C AREA:.....2,224 SF
COVERED PORCH:.....2,144 SF
GARAGE AREA:.....1,040 SF
TOTAL AREA:.....5,408 SF

FLORIDA BUILDING CODE 2023 8TH EDITION
ASCE 7-22
140 MPH 3-SECONDD ULTIMATE GUST VELOCITY
INTERNAL PRESSURE COEFFICIENT = +/-0.18
EXPOSURE "C"
CATEGORY II
ENCLOSED BUILDING

Sheet List				
Sheet Number	Sheet Name	Sheet Issue Date	Current Revision	Current Revision Date
A100	Cover Sheet	12/25/2024		
A101	Overall Site Plan & Setback	12/25/2024		
A102	Overall Floor Plan & Schedule	12/25/2024		
A103	Floor Plan	12/25/2024		
A104	Overall Reflected Ceiling Plan	12/25/2024		
A105	Reflected Ceiling Plan	12/25/2024		
A106	Overall Roof Plan View	12/25/2024		
A107	Exterior Elevations	12/25/2024		
A108	Wall Types	12/25/2024		
A109	Building Sections	12/25/2024		
A110	Interior Elevations	12/25/2024		
E100	Notes & Garage Electric Plan	12/25/2024		
E101	Electric - Lighting Plan	12/25/2024		
E102	Electric Power Plan	12/25/2024		
P100	Plumbing - Sanitary Plan	12/25/2024		
S100	Structural Notes 1	12/25/2024		
S101	Structural Notes 2	12/25/2024		
S102	Stem Wall Foundation Plan	12/25/2024		
S102.1	Stem Wall Elevations	12/25/2024		
S102.2	Foundation Plan	12/25/2024		
S103	Roof Framing Plan & Schedule	12/25/2024		
S104	Beam Lintel Schedule & Detail	12/25/2024		
S105	Structural Wall Sections	12/25/2024		
S106	Structural Wall Sections	12/25/2024		

No.	Description	Date

Proposed Residence

Cover Sheet

Project number	24-045
Date	12/25/2024
Drawn by	A.O.
Checked by	T.K.
A100	
Scale	1" = 20'-0"