



Note:  
These Plans Shall Conform to the 2014 Florida Building  
Code-Residential and to all State and Local Ordinances  
  
It is the Responsibility of the Builder to Verify all  
Dimensions Prior to Construction

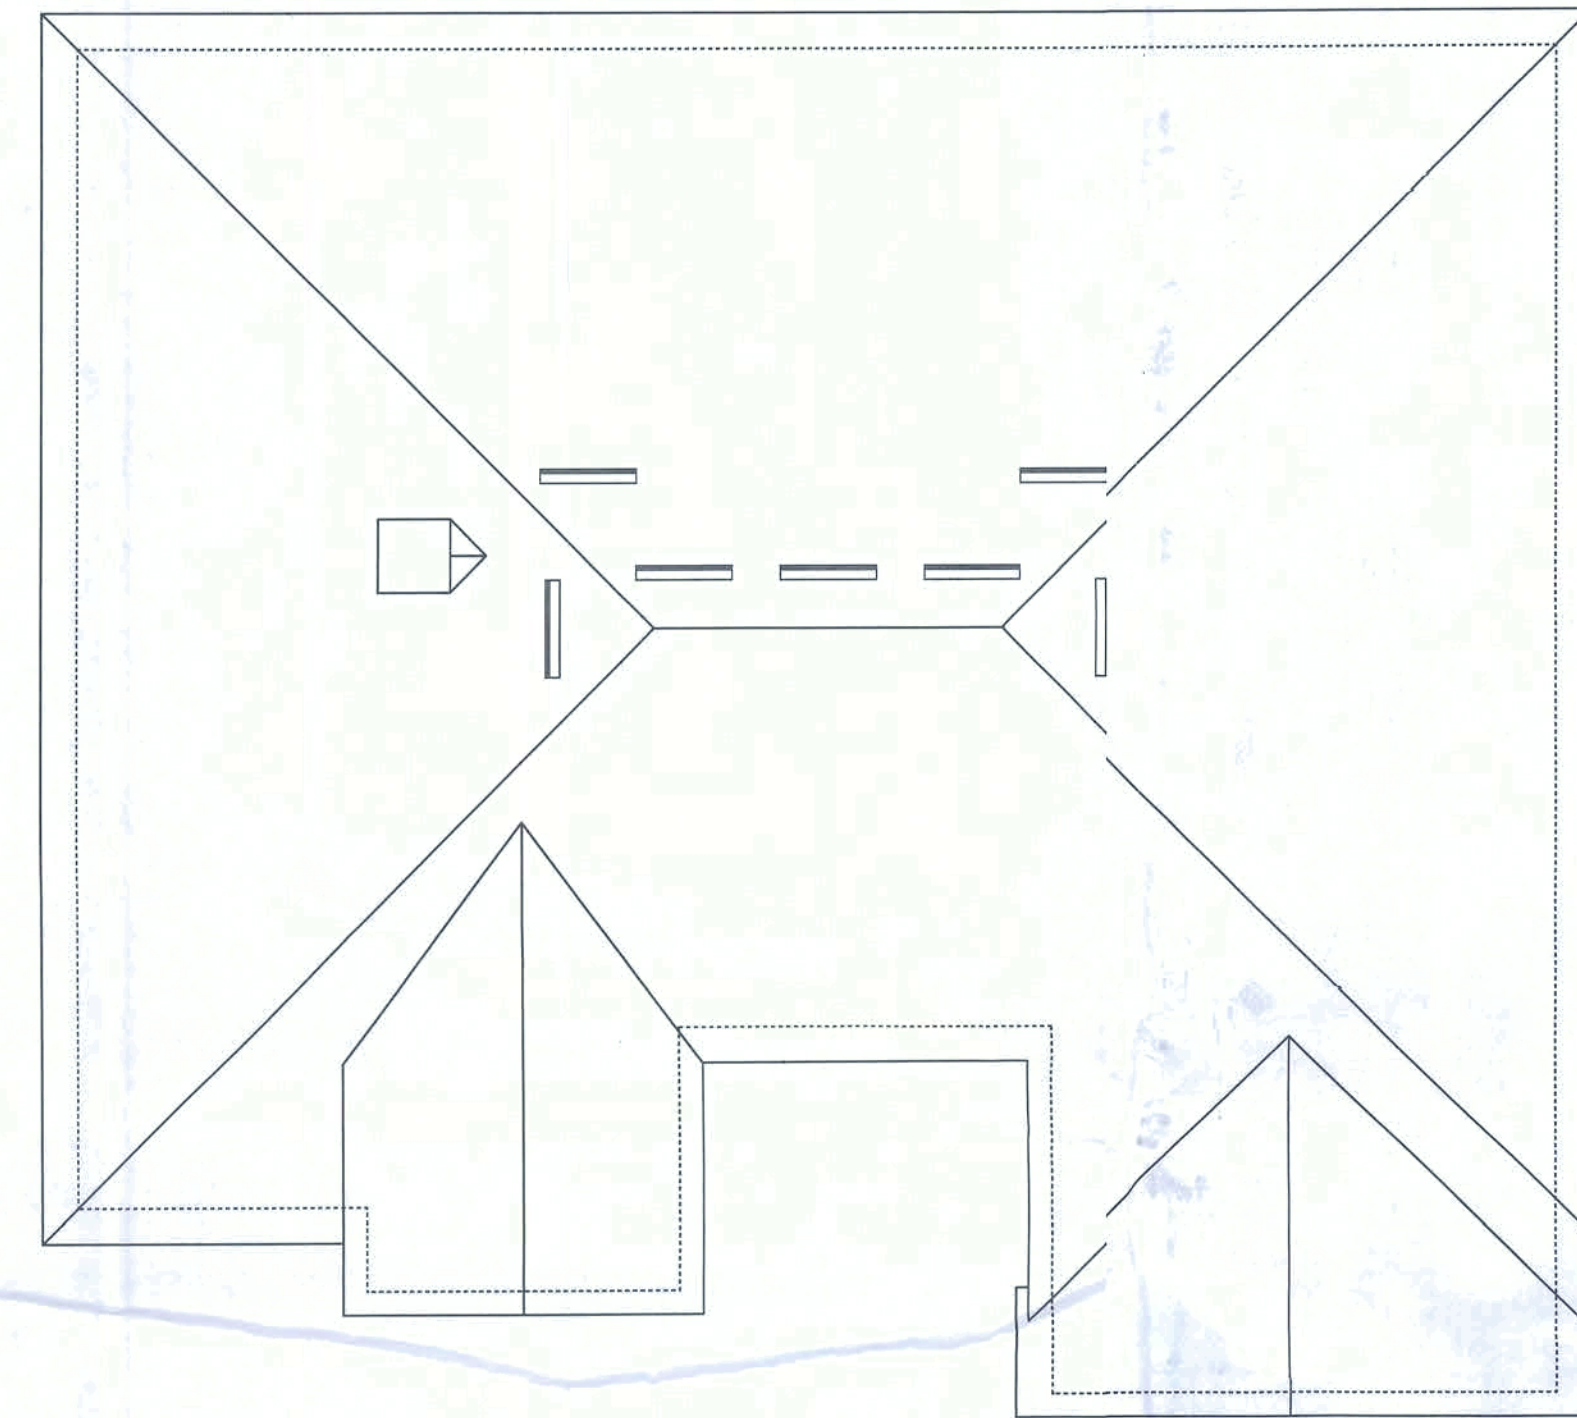

ROOF PLAN  
1/8" = 1'-0"

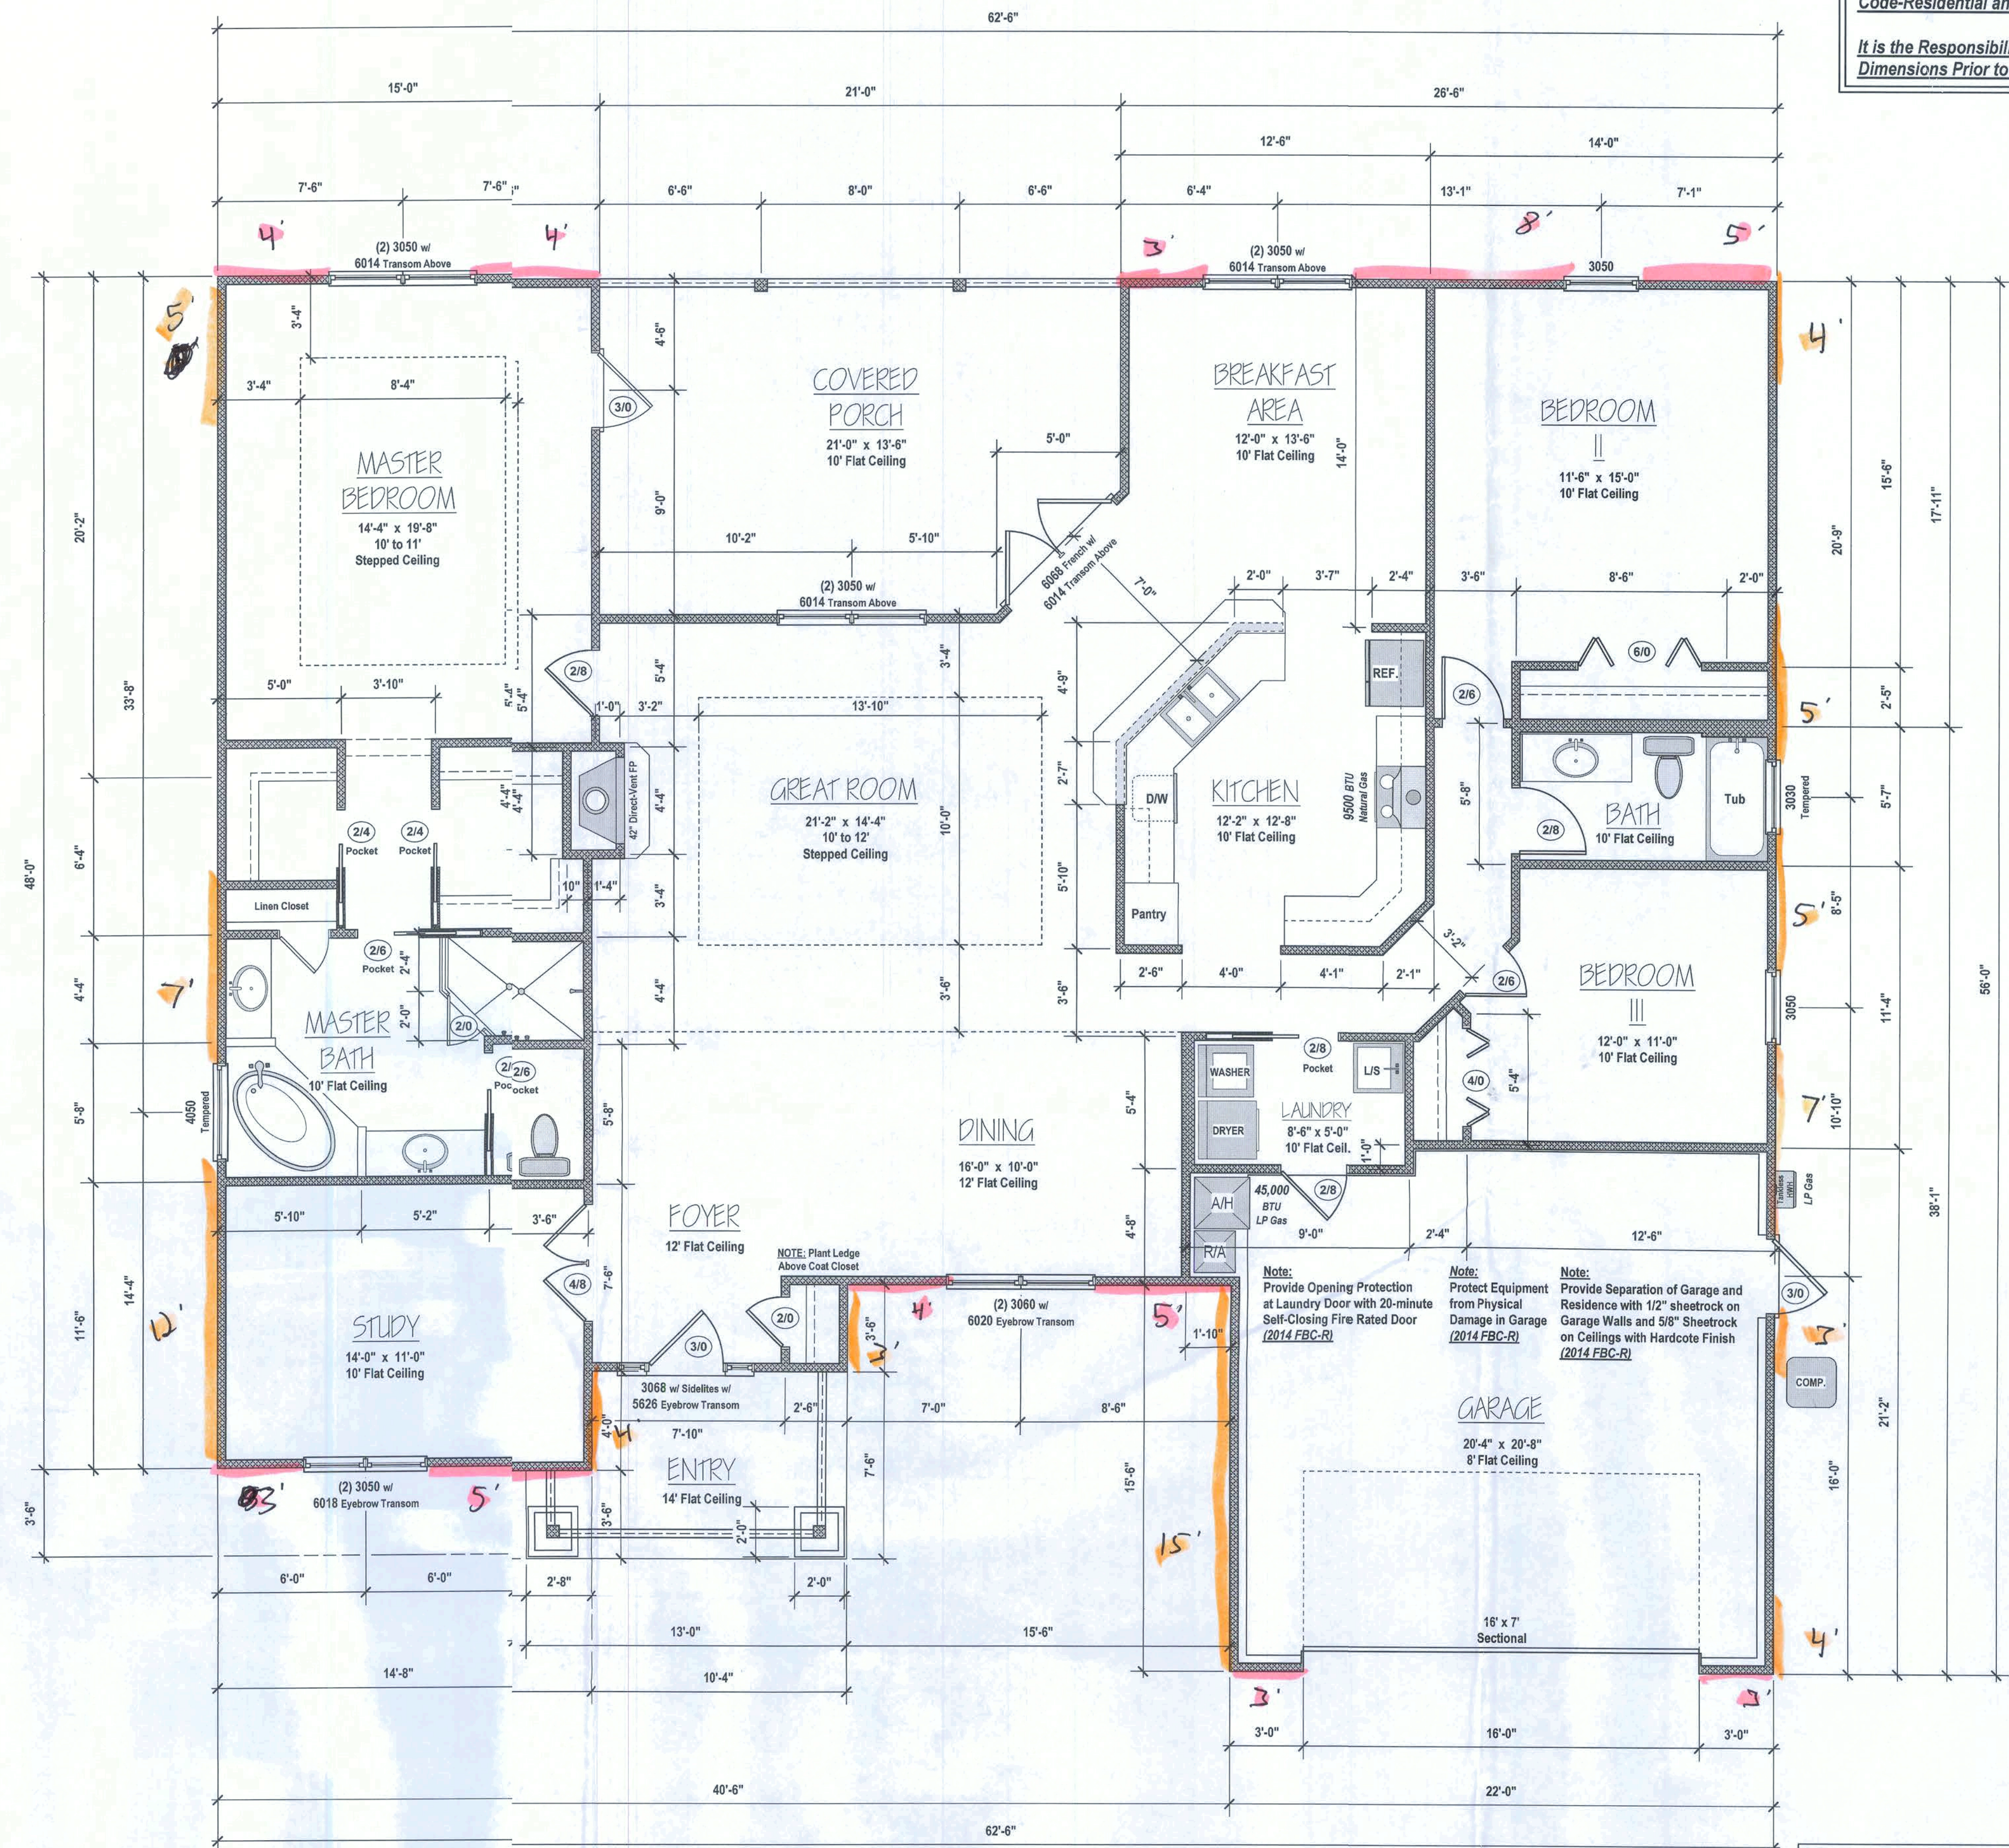


FLOOR PLAN  
1/4" = 1'-0"

|               |   |              |
|---------------|---|--------------|
| HEATED AREA   | = | 2290 SQ. FT. |
| GARAGE        | = | 462 SQ. FT.  |
| COVERED PORCH | = | 271 SQ. FT.  |
| ENTRY         | = | 87 SQ. FT.   |
| TOTAL AREA    | = | 3110 SQ. FT. |




Note:  
These Plans Shall Conform to the 2014 Florida Building  
Code-Residential and to all State and Local Ordinances


It is the Responsibility of the Builder to Verify all  
Dimensions Prior to Construction

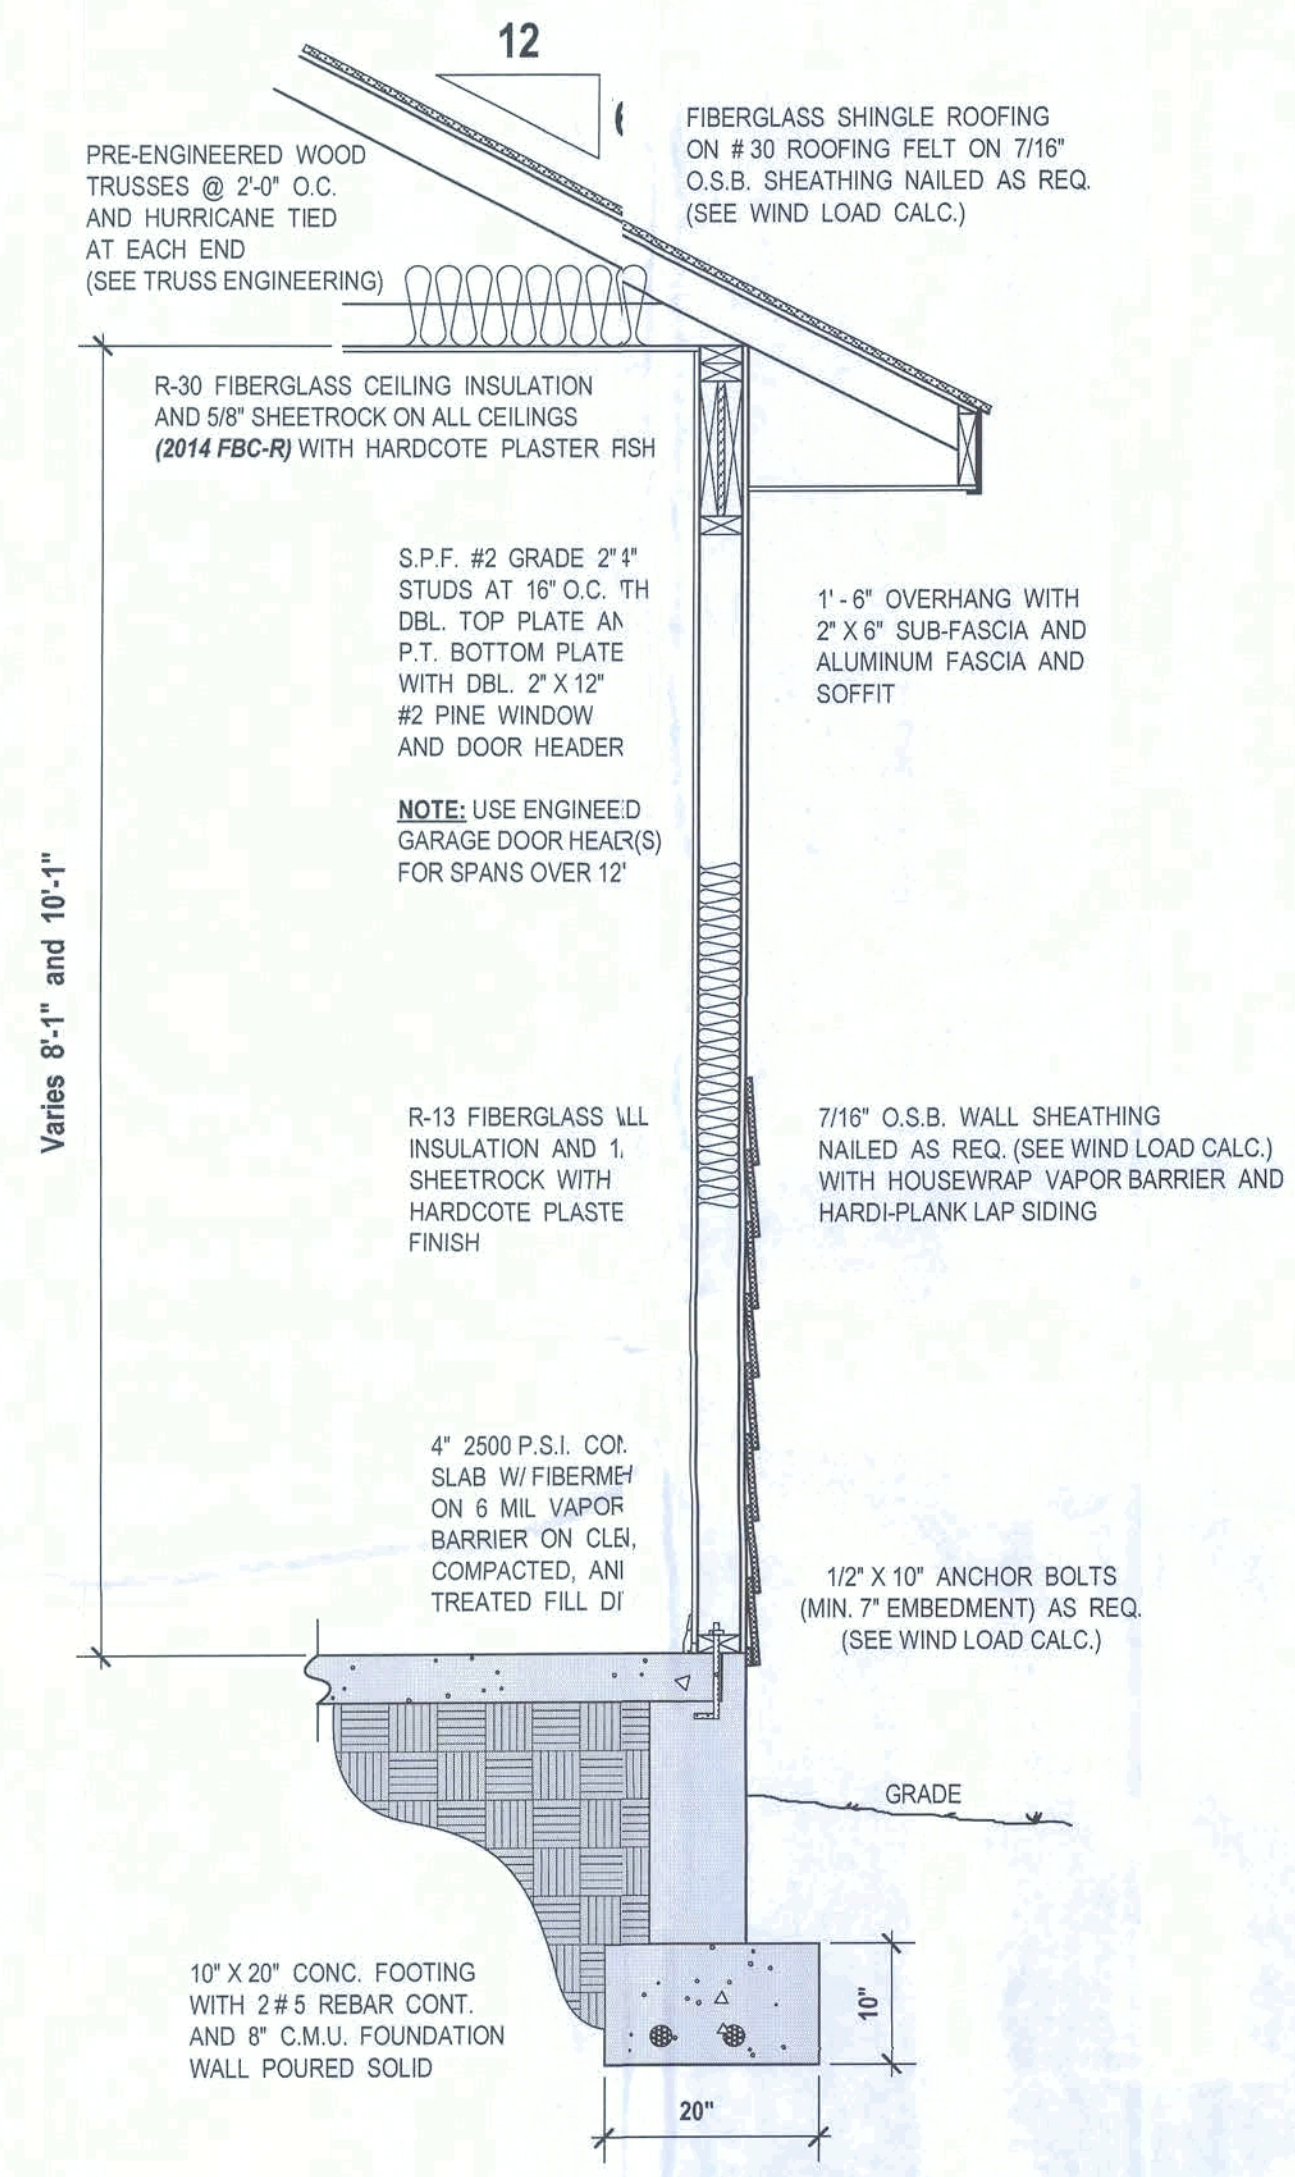

WALL SECTION  
3/4" = 1'-0"

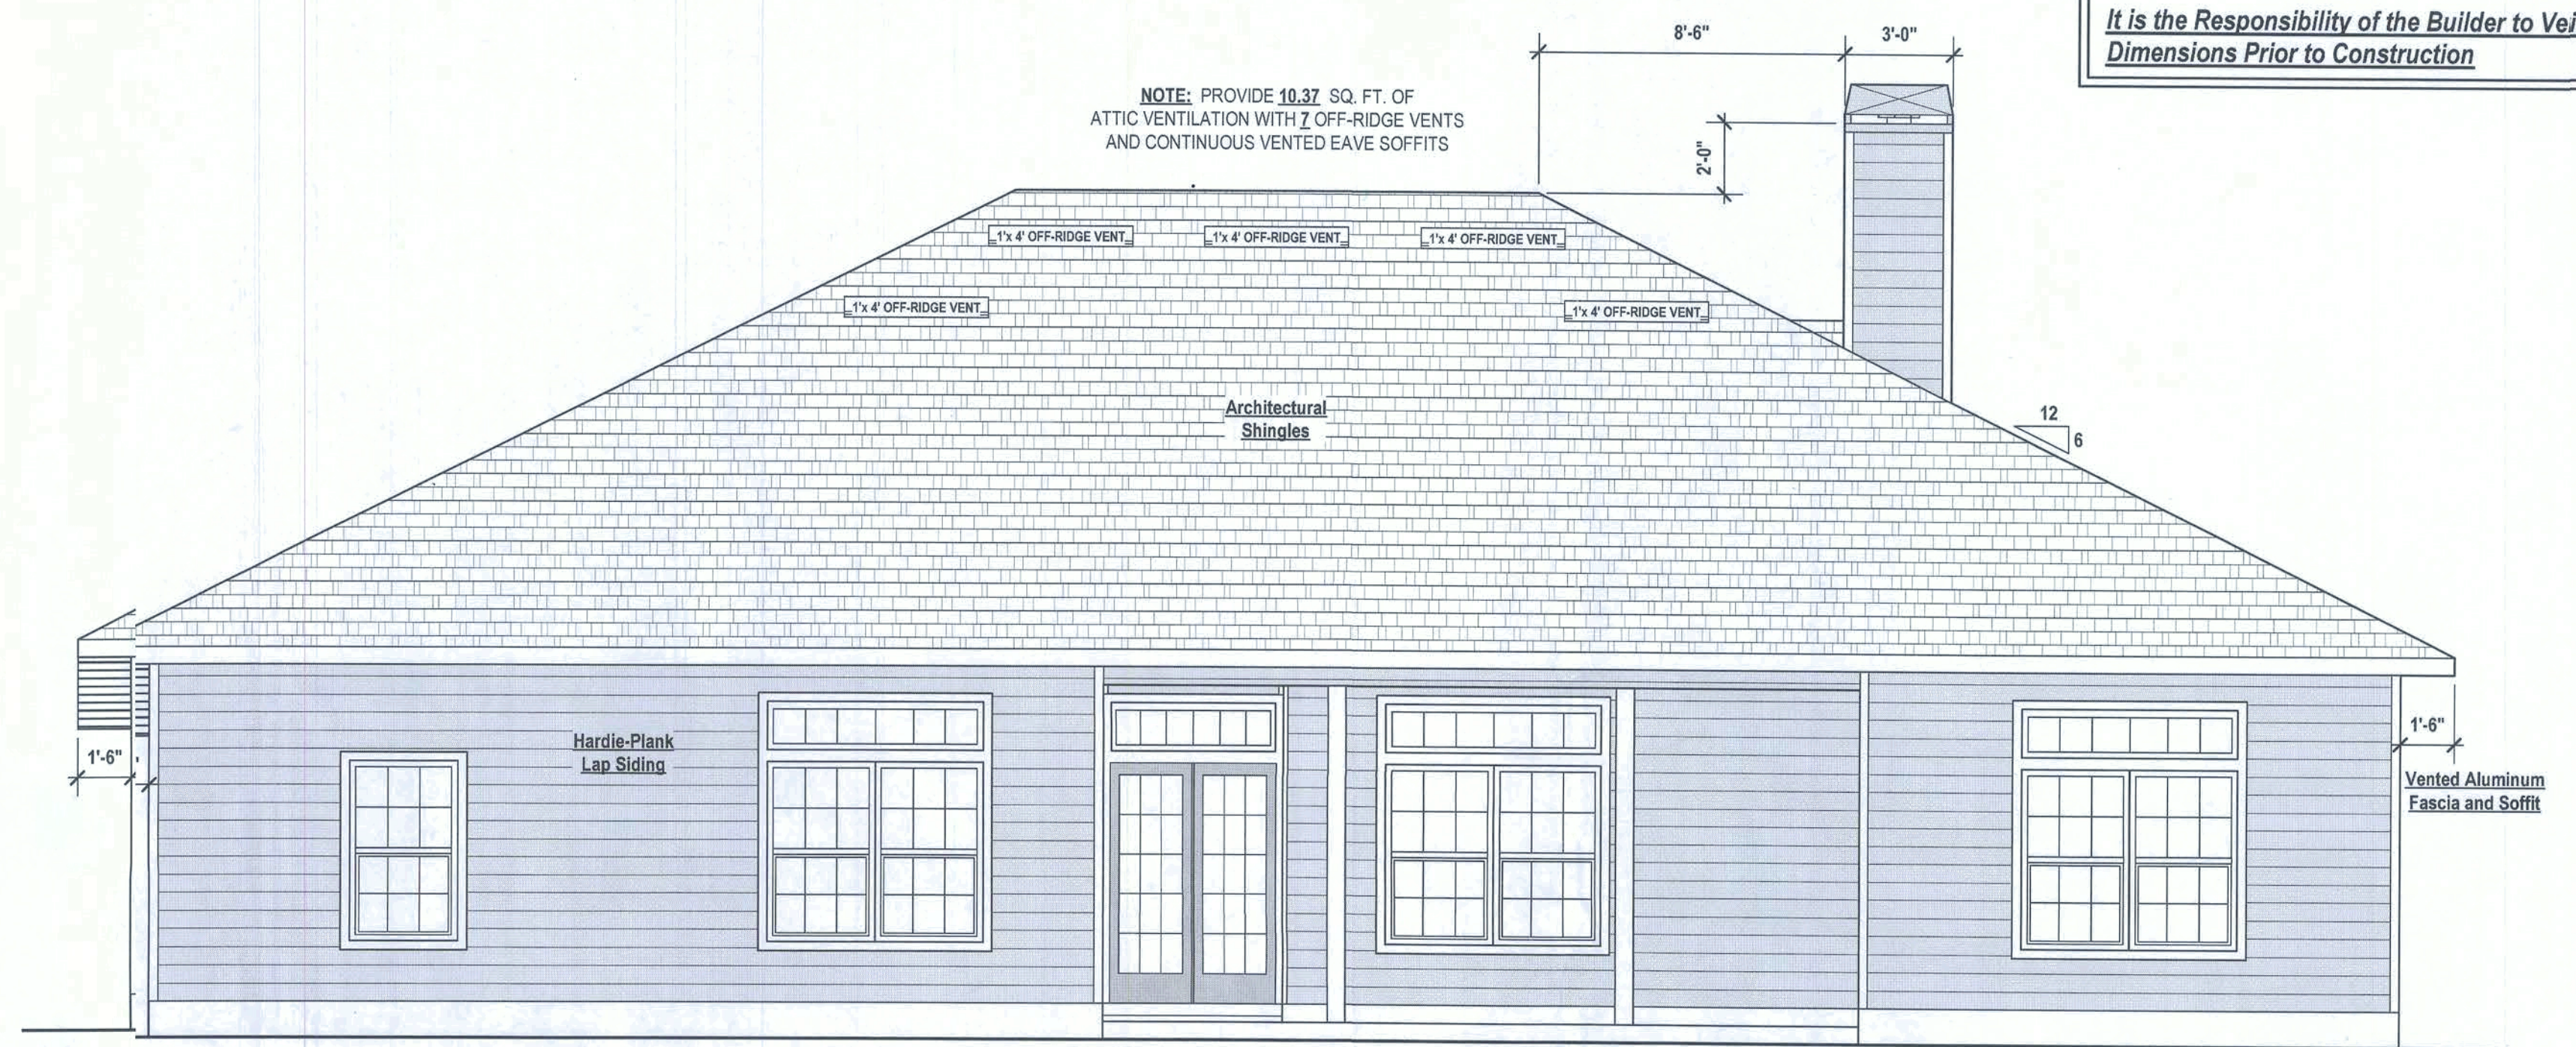

REAR ELEVATION  
1/4" = 1'-0"

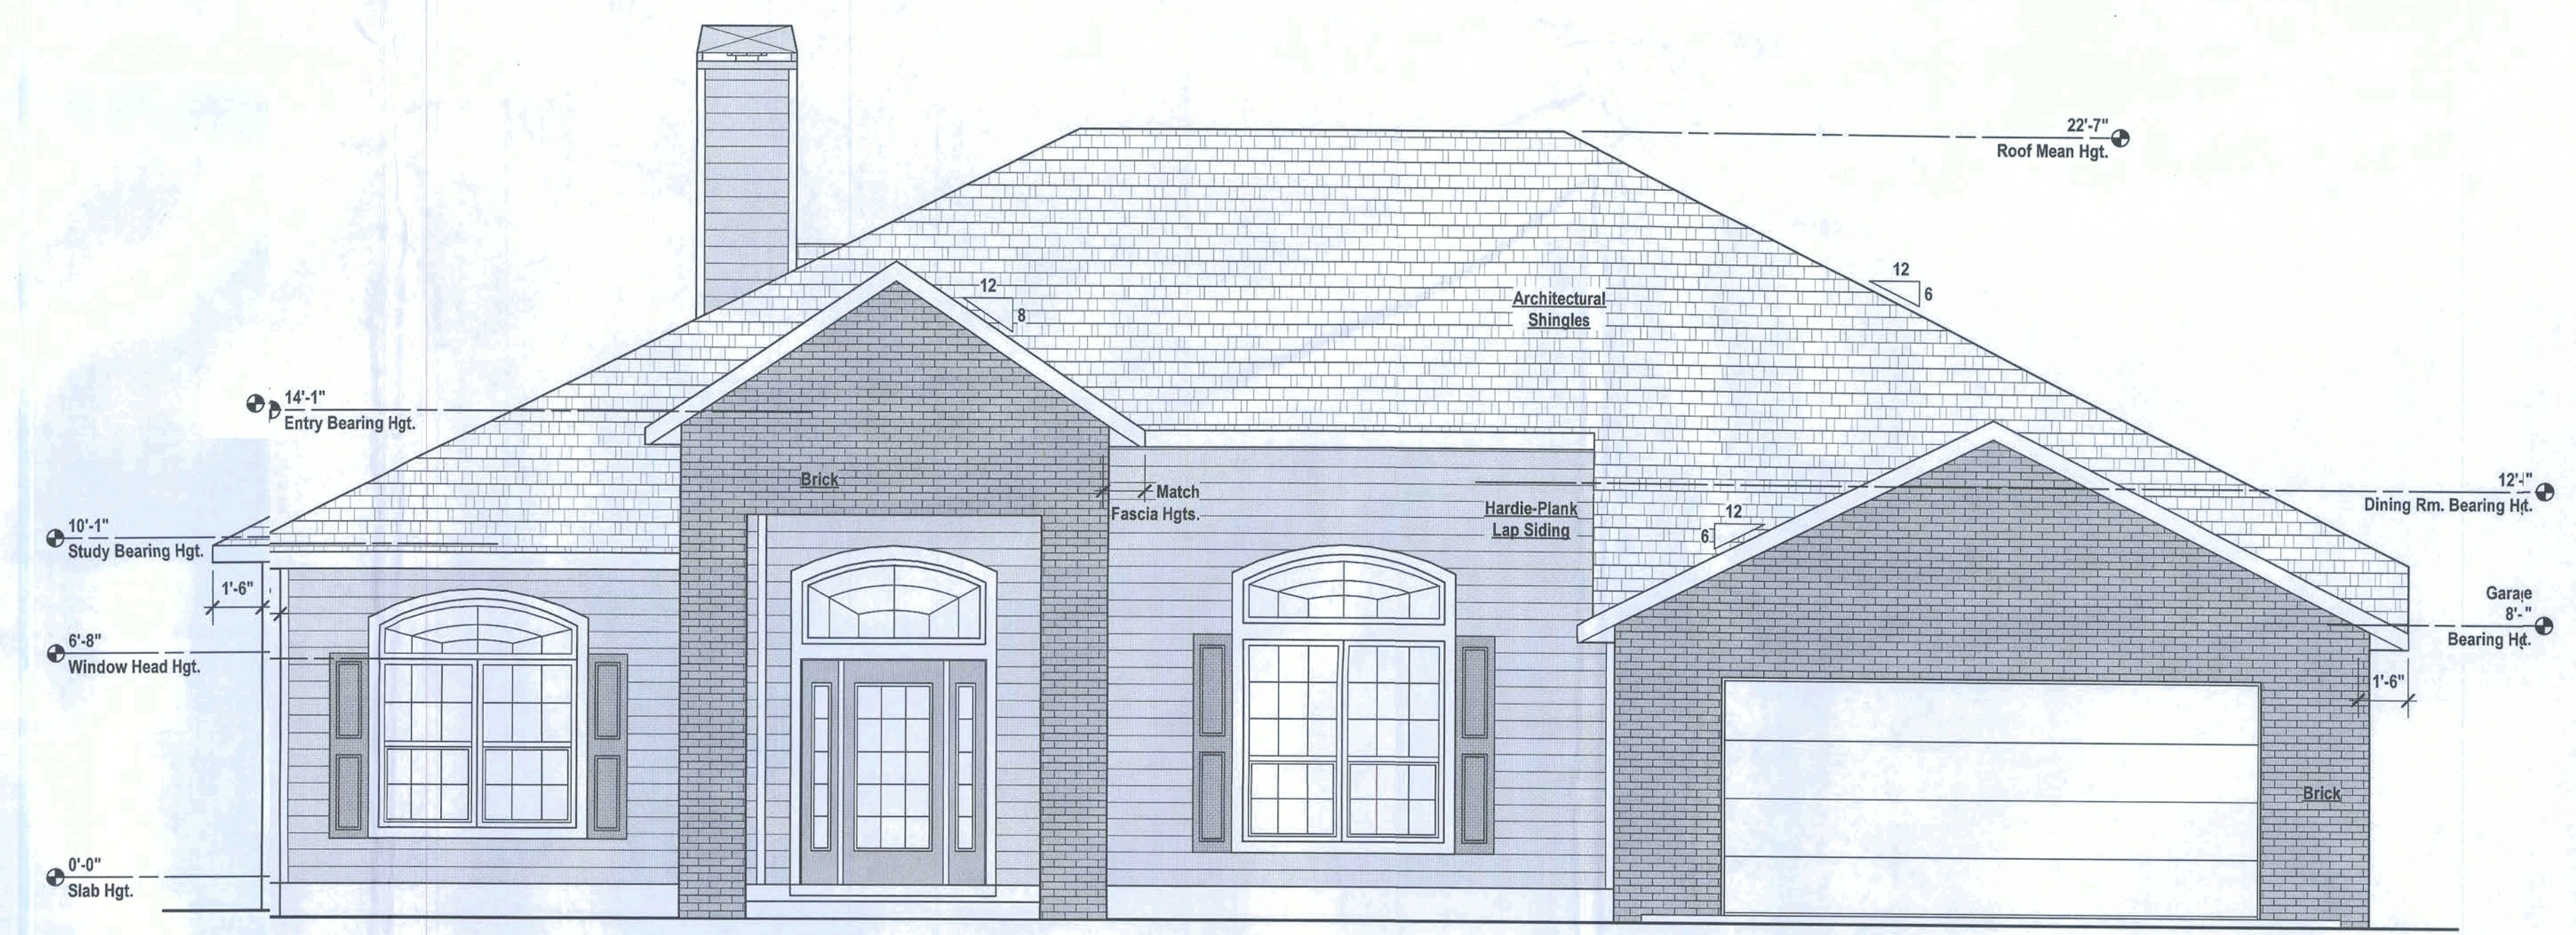

FRONT ELEVATION  
1/4" = 1'-0"




Note:  
 These Plans Shall Conform to the 2014 Florida Building  
 Code-Residential and to all State and Local Ordinances  
 It is the Responsibility of the Builder to Verify all  
 Dimensions Prior to Construction



RIGHT ELEVATION

1/4" = 1'-0"

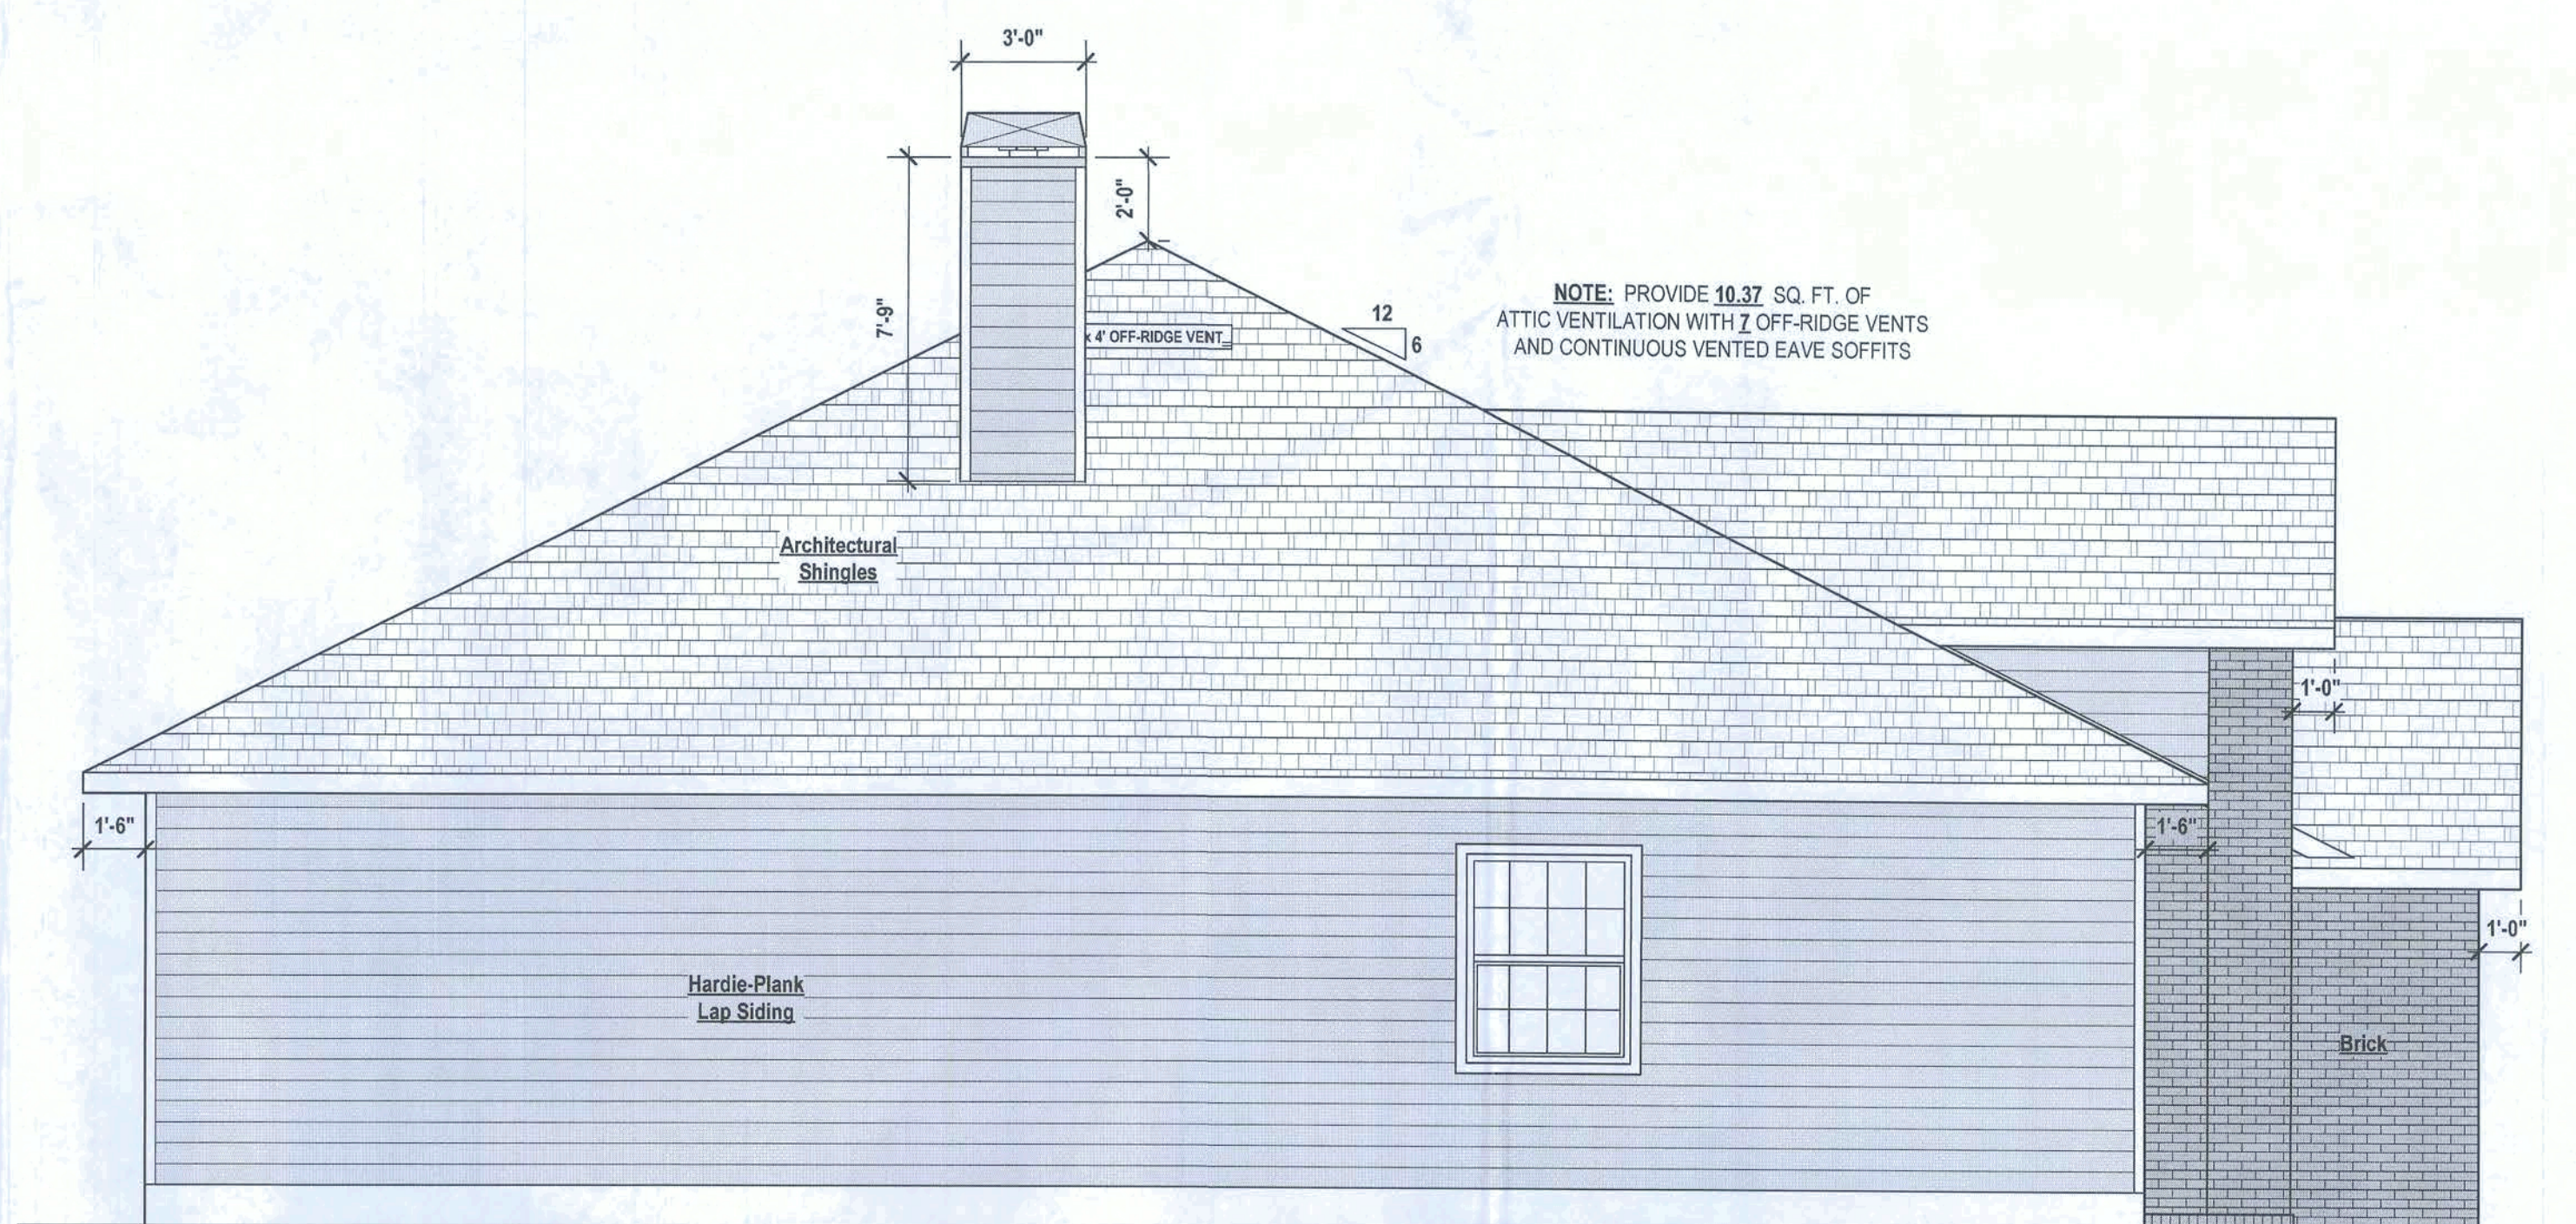


LEFT ELEVATION

1/4" = 1'-0"



**Note:**  
These Plans Shall Conform to the 2014 Florida Building  
Code-Residential and to all State and Local Ordinances  
  
It is the Responsibility of the Builder to verify all  
Dimensions Prior to Construction

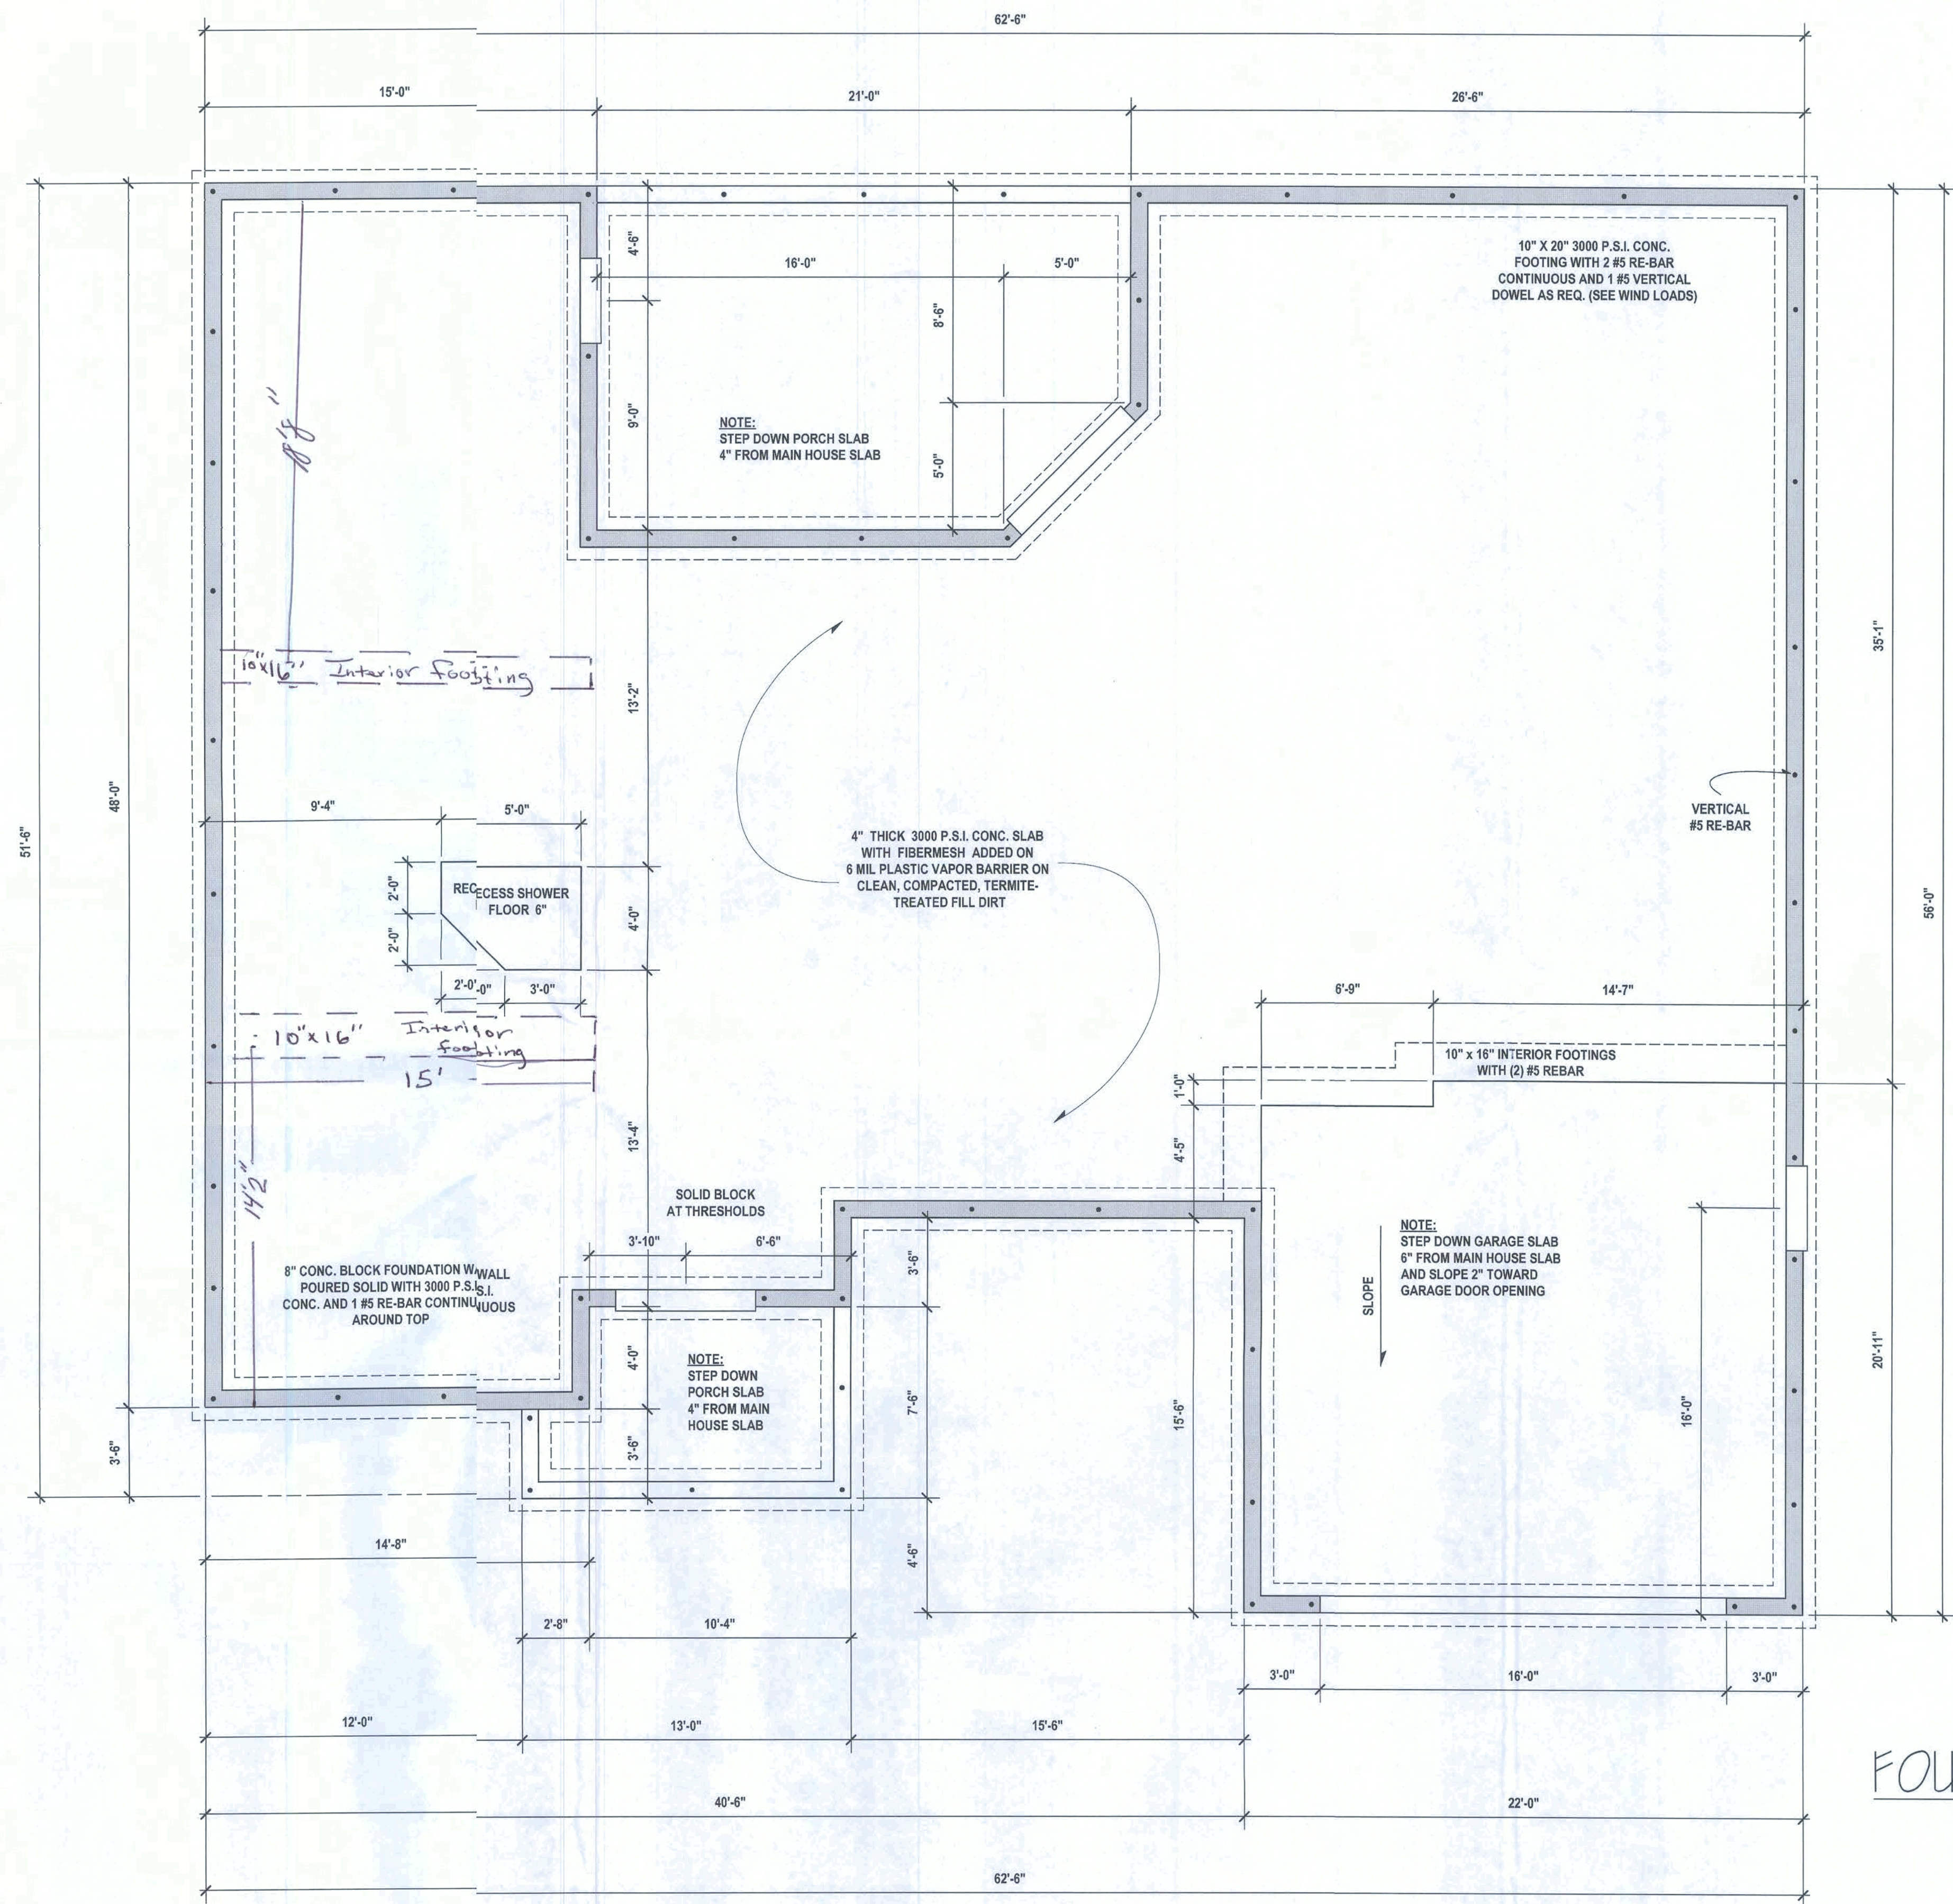


FOUNDATION PLAN  
1/4" = 1'-0"



Note:  
These Plans Shall Conform to the 2014 Florida Building  
Code-Residential and to all State and Local Ordinances

It is the Responsibility of the Builder to Verify all  
Dimensions Prior to Construction

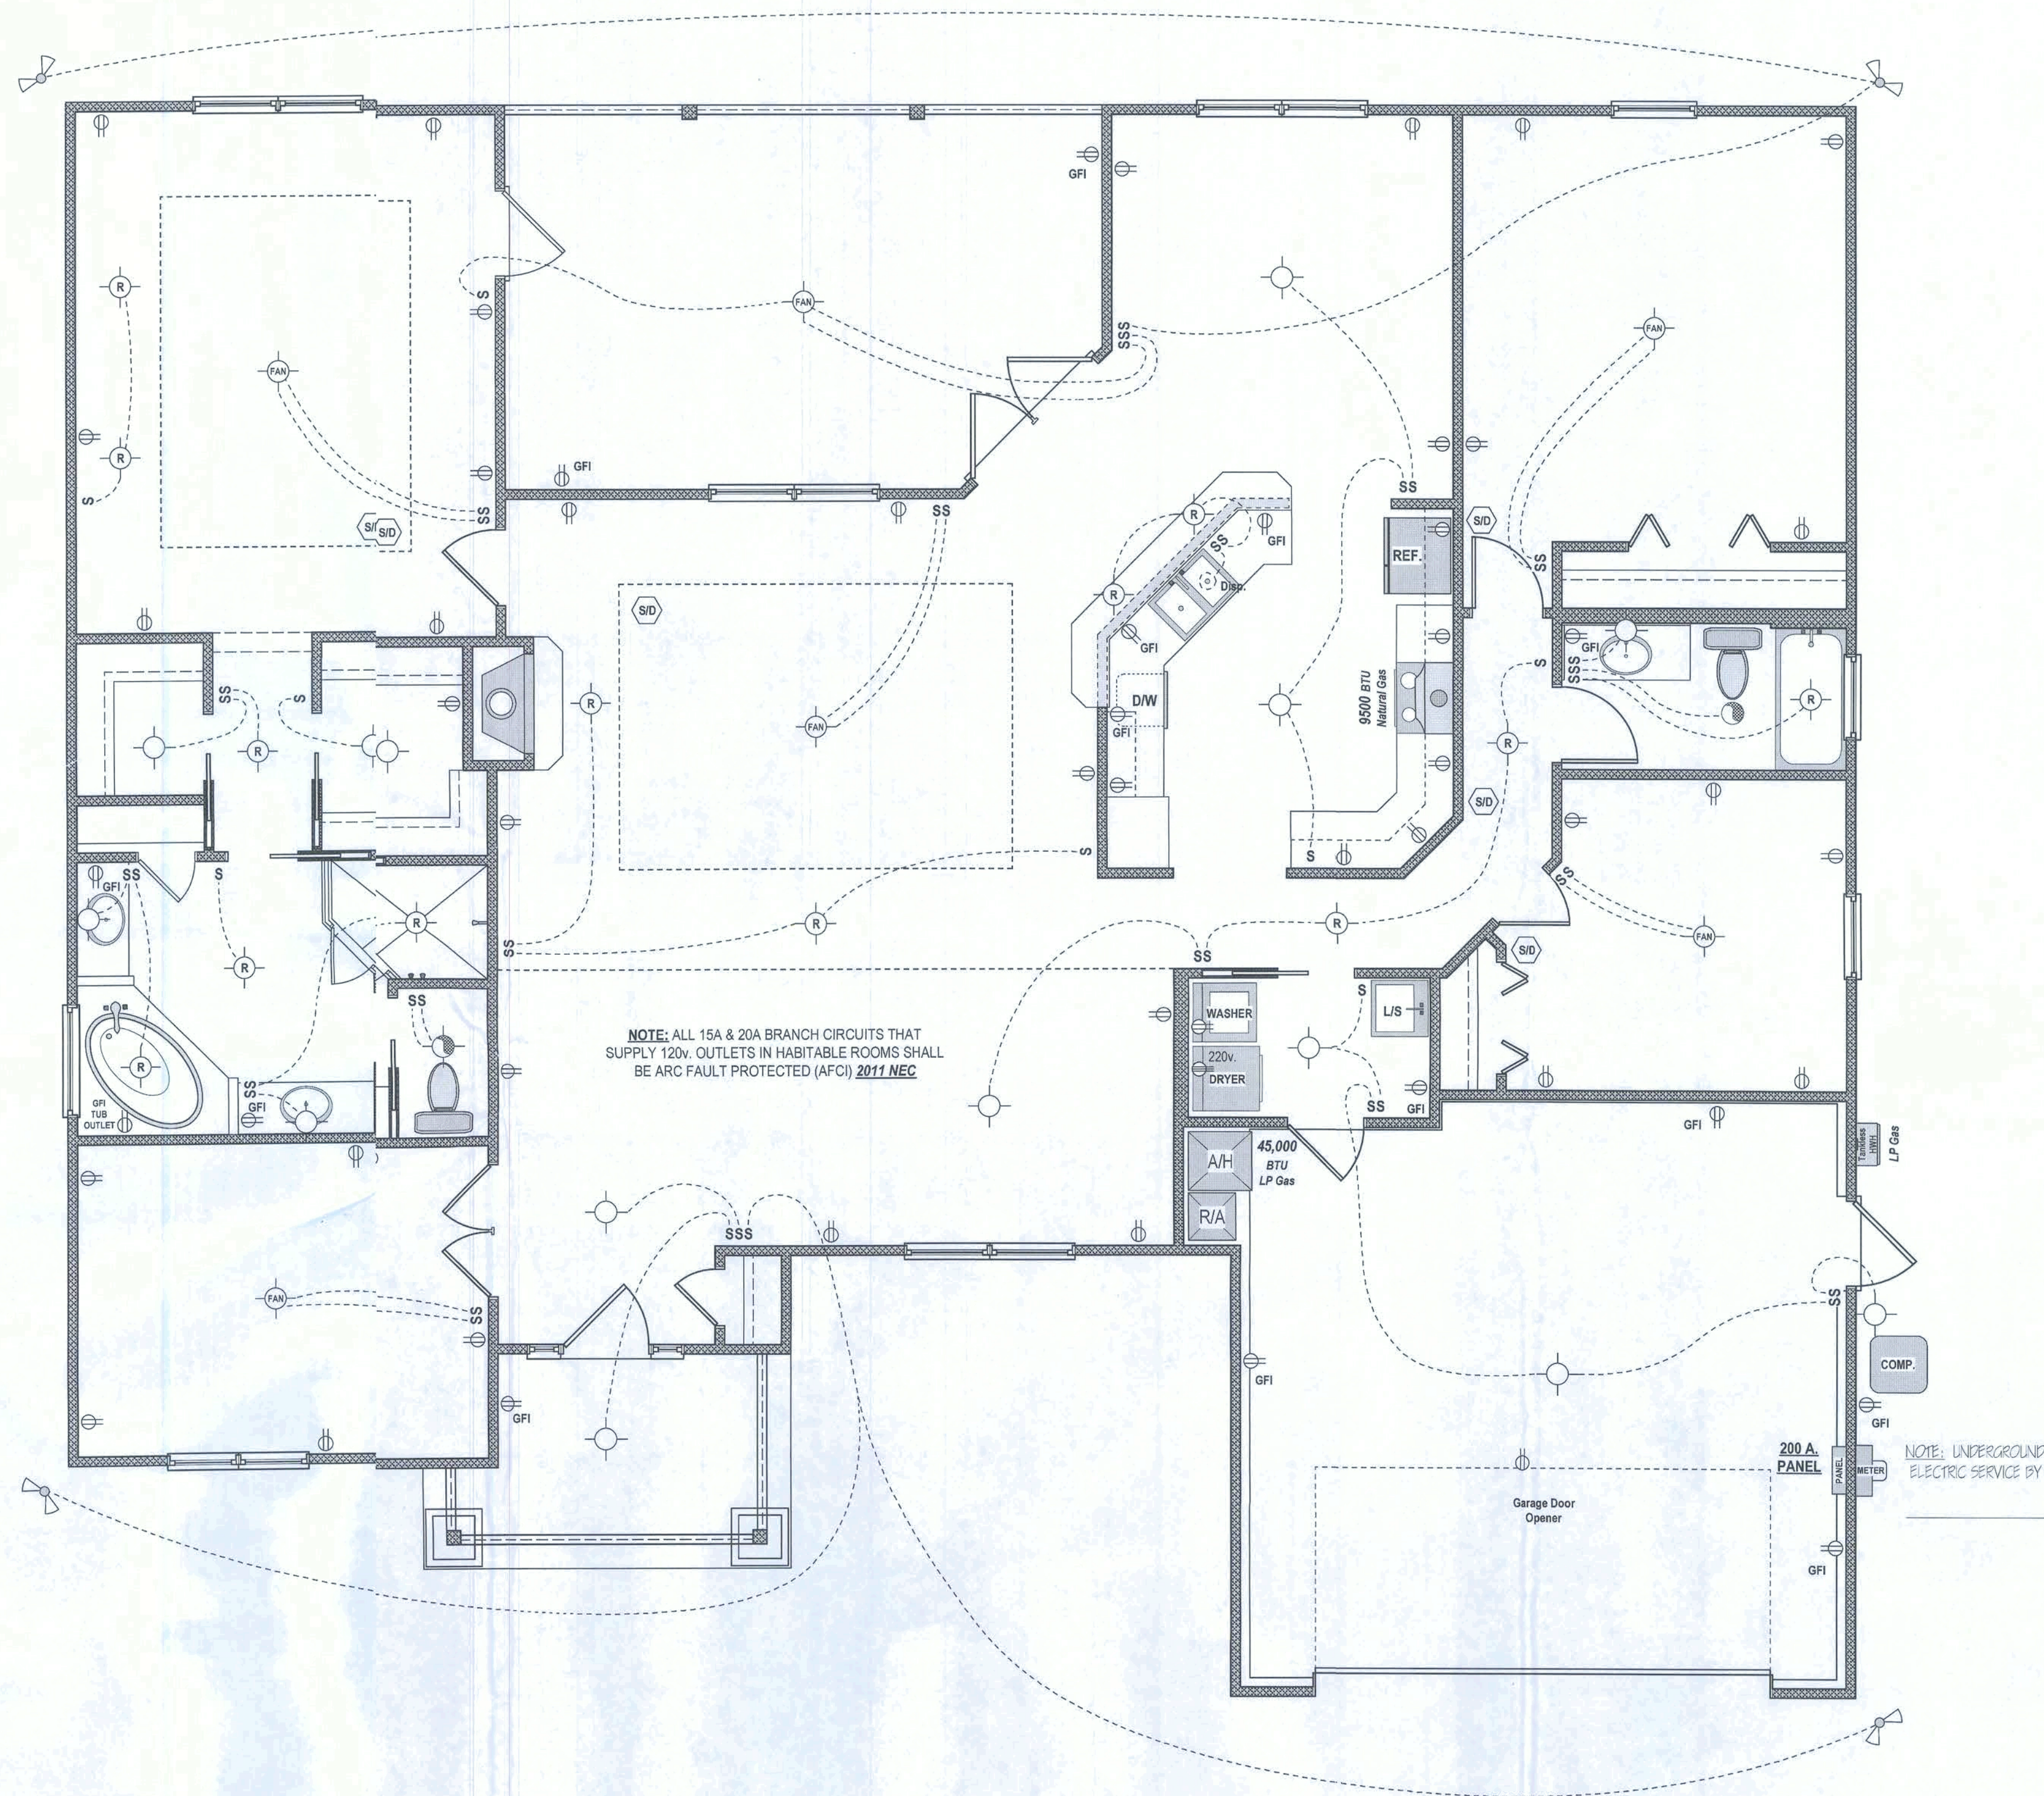

ELECTRICAL PLAN  
1/4" = 1'-0"

SYMBOL LEGEND

|                                          |  |
|------------------------------------------|--|
| 110 v. Electrical Outlet                 |  |
| 220 v. Electrical Outlet                 |  |
| Light Fixture                            |  |
| Recessed Light Fixture                   |  |
| Ceiling Fan Outlet                       |  |
| Bathroom Exhaust Fan                     |  |
| Smoke Detector                           |  |
| Food Light                               |  |
| Light Switch                             |  |
| Ground Fault/Protected Electrical Outlet |  |
| Electric Meter                           |  |
| Circuit Breaker Panel                    |  |

DATE:  
NOV - 30 - 2016

DRAWN BY:  
**CLIFF MARTIN**  
352-538-1087

DESIGNED BY:  
**ELWOOD CONSTRUCTION, INC.**



**THE MANCHESTER MODEL 2016**

REVISION:  
11-06-2016/001  
11-11-2016/002

FILE #:  
2290/3110/ELWOOD




**Note:**  
 These Plans Shall Conform to the 2014 Florida Building Code-Residential and to all State and Local Ordinances  
 It is the Responsibility of the Builder to Verify all Dimensions Prior to Construction

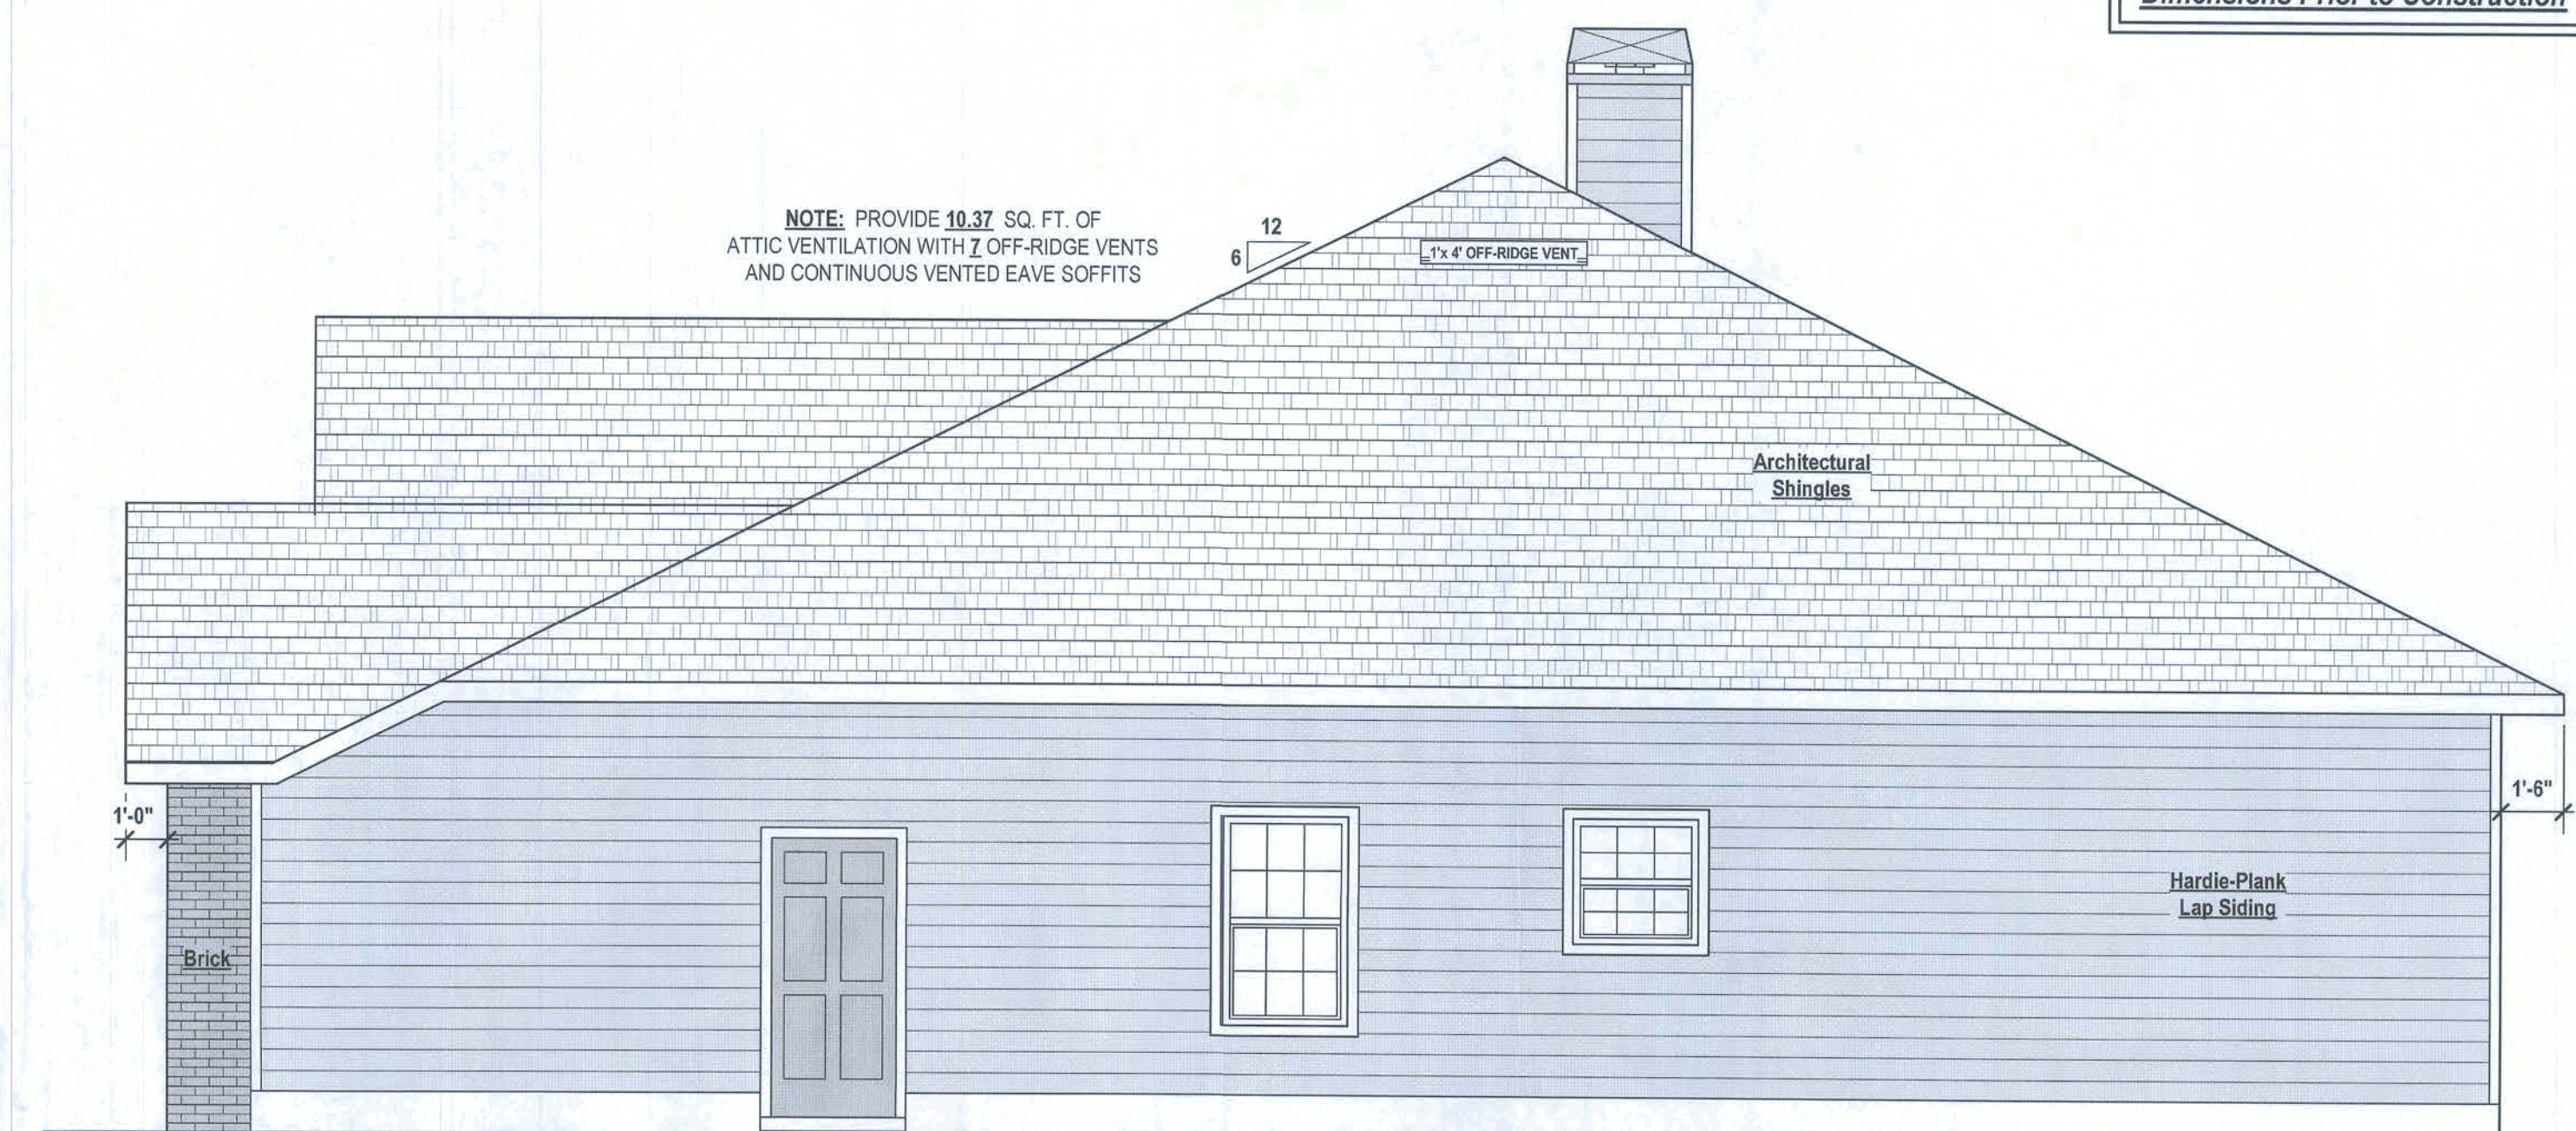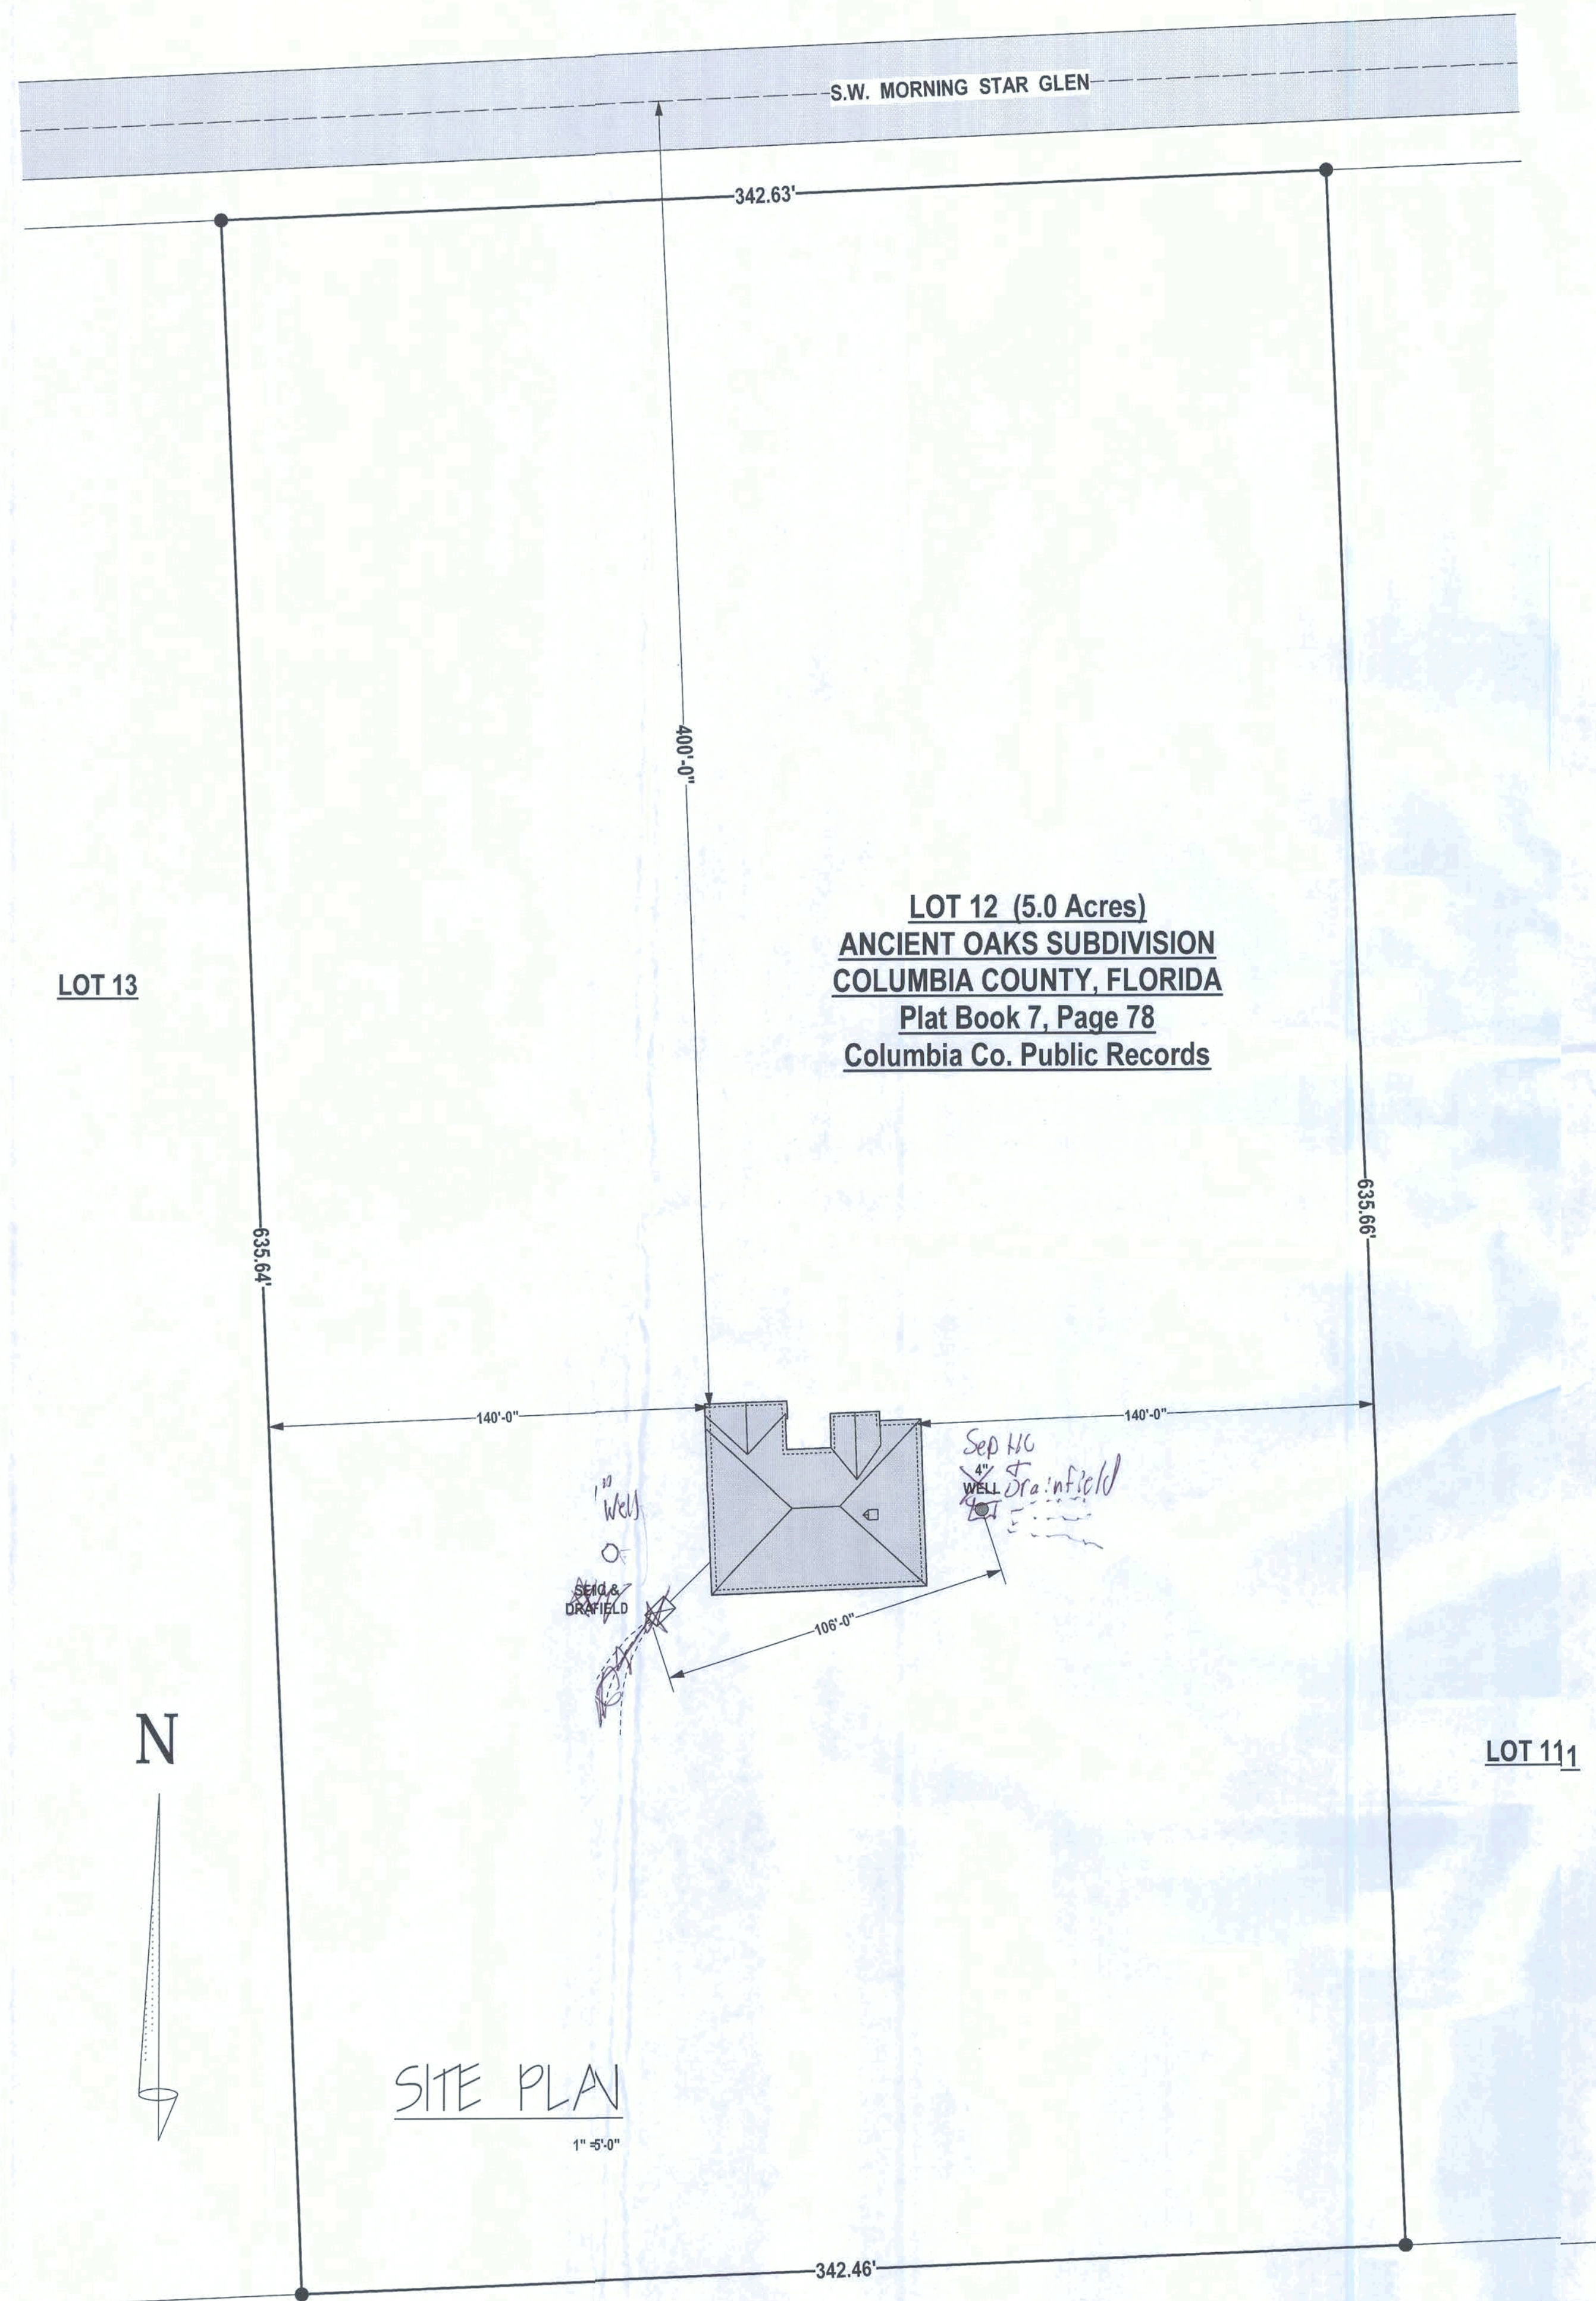

**RIGHT ELEVATION**

**1/4" = 1'-0"**

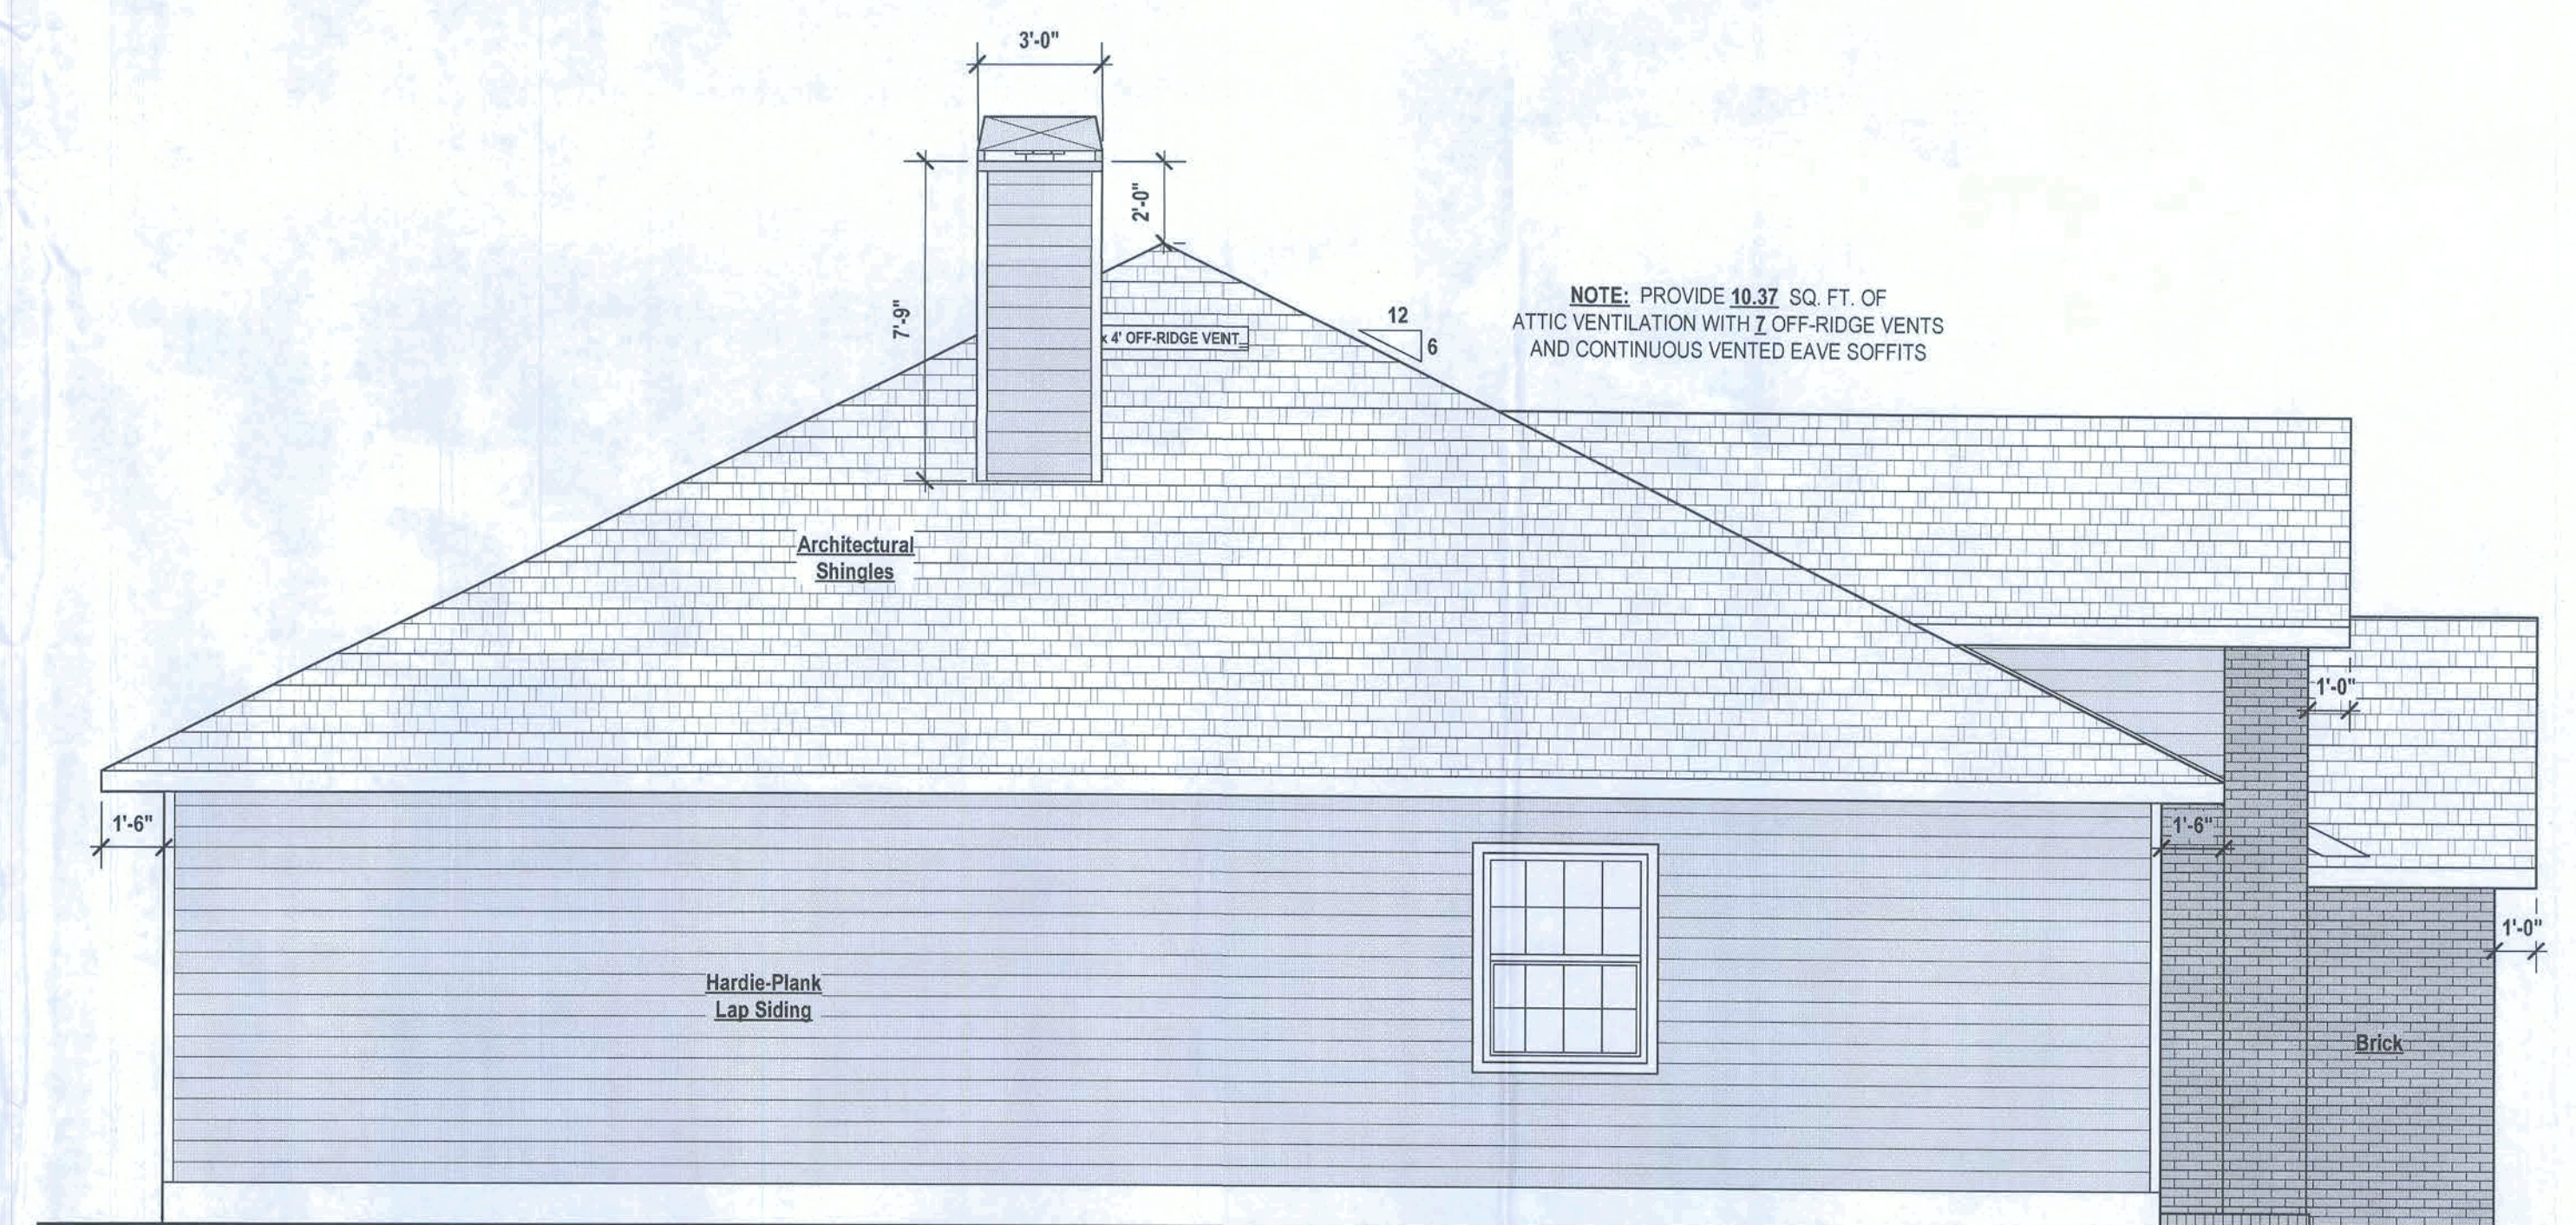

**LEFT ELEVATION**

**1/4" = 1'-0"**