
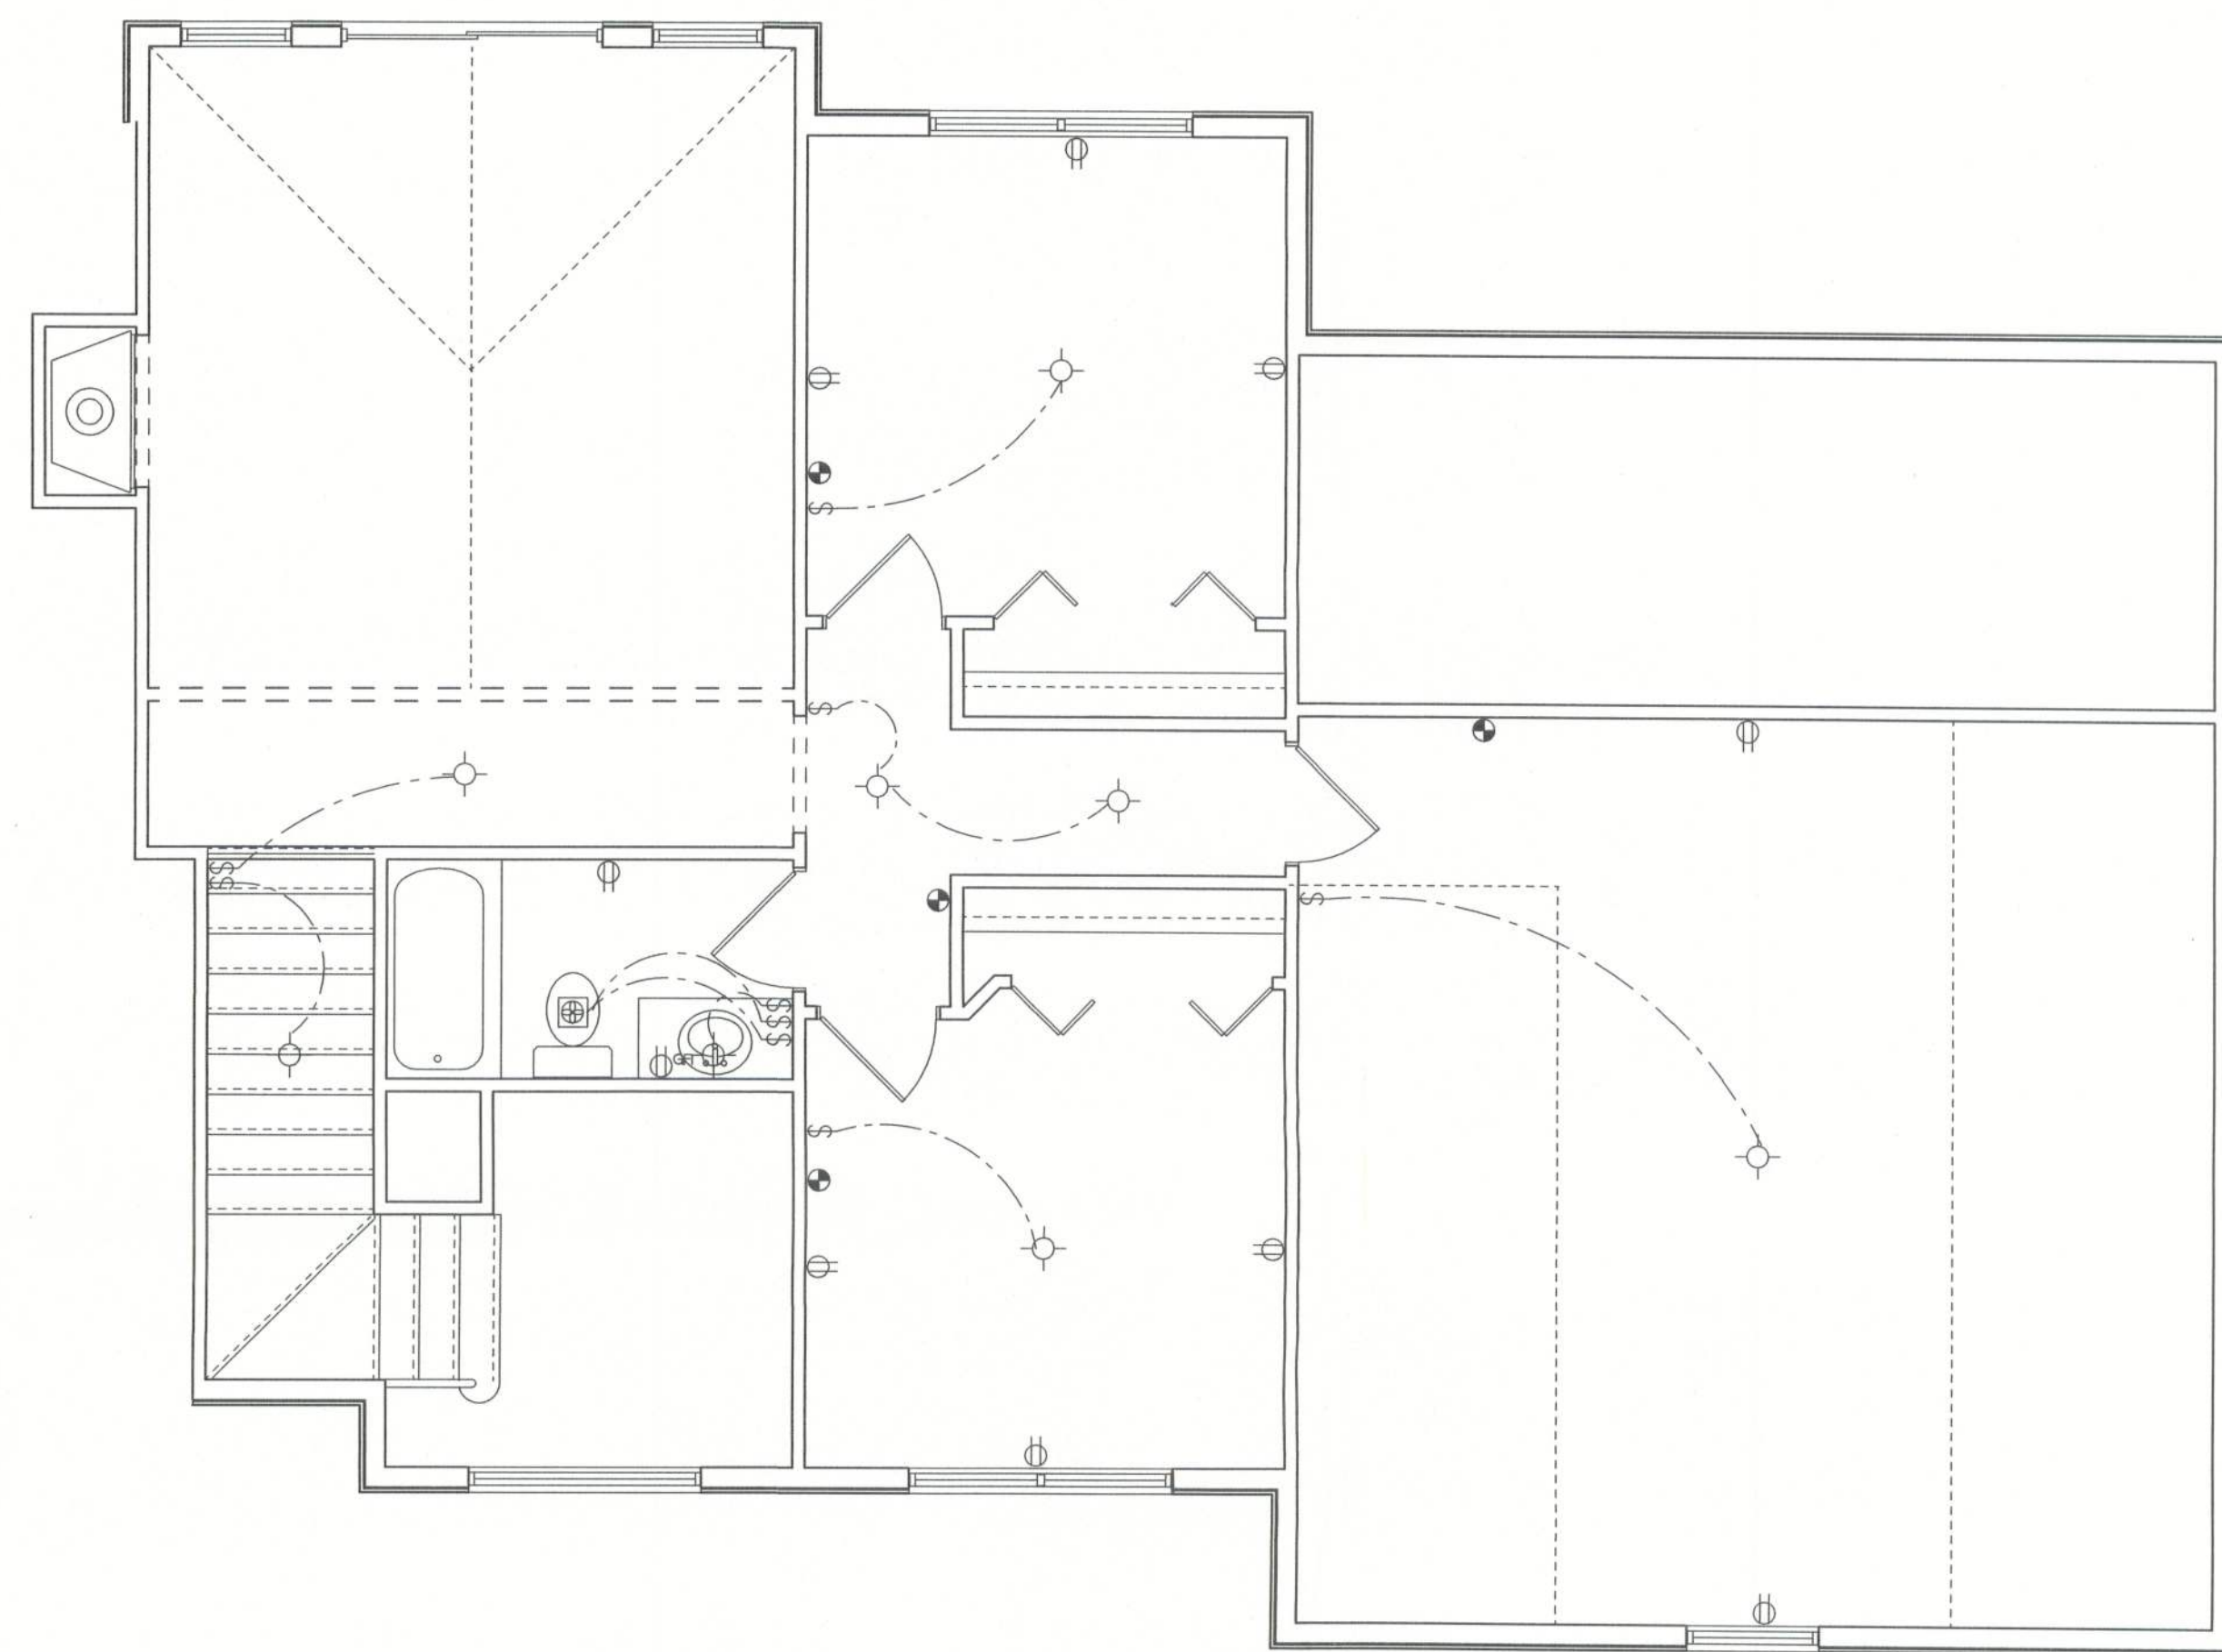


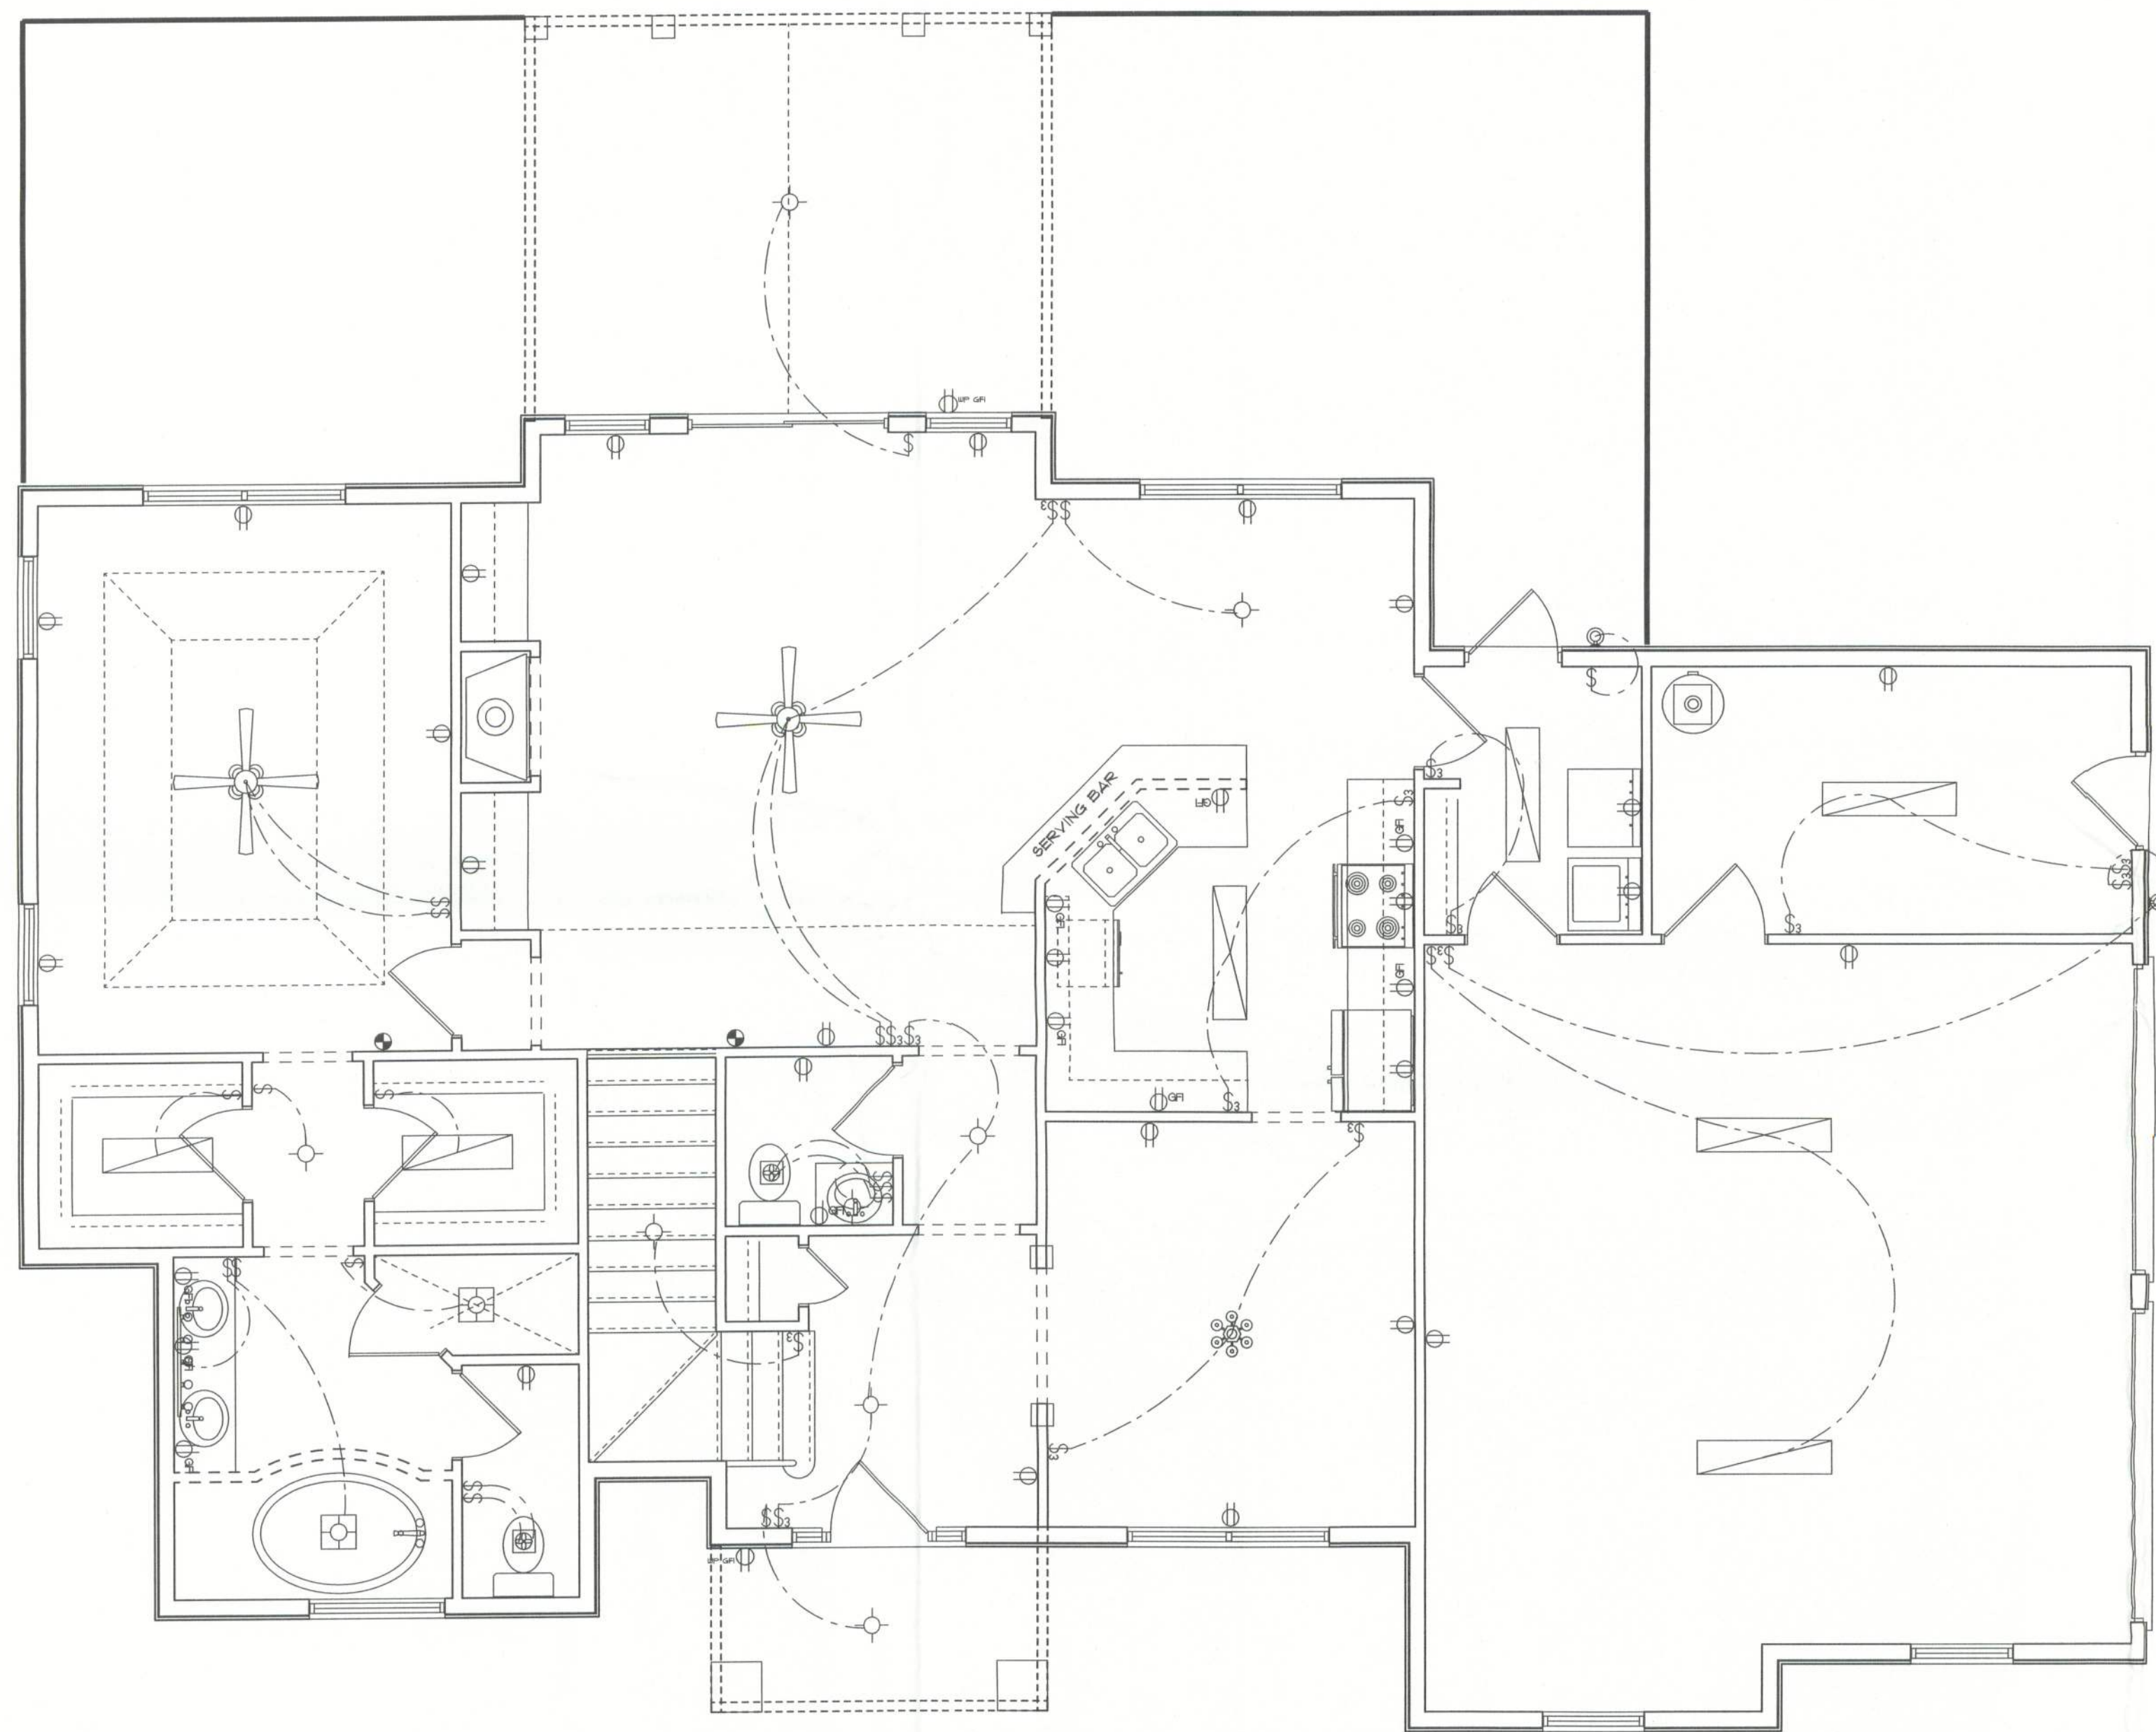

AREA SUMMARY	
1ST FLOOR	1395.8 SF
2ND FLOOR	476.0 SF
GARAGE	610.6 SF
BONUS ROOM	465.6 SF
PORCHES	239.4 SF
TOTAL AREA	3187.4 SF

ELECTRICAL PLAN
SCALE: 1/4"=1'-0"

FIRST IMPRESSIONS
ARCHITECTURAL DESIGN, LLC
DESIGNER: BRIAN CRAWFORD
PHONE: (386) 755-8887

DATE:
CHECKED BY:
SHEET NUMBER

A-4
OF 4 SHEETS

NEW CUSTOM HOME FOR:
WILLARD & MARLENE GRAHAM