



A Custom Carport for :
Mr. and Mrs. Richardson
 Columbia County, FL

Drawing Index

C.S.	DRAWING INDEX & STRUCTURAL SUMMARY
A.1	ELEVATIONS, ELECTRICAL & DIMENSION PLANS W/NOTES
A.2	FOUNDATION AND ROOF FRAMING PLANS
A.3	BUILDING SECTION AND NOTES

ALL WIND LOADS ARE IN ACCORDANCE WITH SECTION R301, FLORIDA BUILDING CODE, 2004 EDITION.	
BASIC WIND SPEED:	110 MPH
WIND IMPORTANCE FACTOR (I):	I = 1.00
BUILDING CATEGORY:	CATEGORY II
WIND EXPOSURE:	"B"
INTERNAL PRESSURE COEFFICIENT:	+/- 0.18
WINDS PER TABLE R301(2) (FBC 2004)	ROOF: - 23.1 PSF
DESIGN WIND PRESSURES:	WALLS: + 26.6 PSF
	EAVES: - 32.3 PSF
COMPONENTS & CLADDING PER TABLE R301(2) (FBC 2004)	OPENINGS: + 21.8 / - 29.1 PSF
DESIGN WIND PRESSURES:	EAVES: - 68.3 PSF
	ROOF: + 19.5 / - 25.5 PSF

SUWANNEE RIVER LOG HOMES, INC.
 Manufacturers
 Specializing in Cypress & Cedar Custom Homes
 4349 HIGHWAY 90, WELLSBORO, FLORIDA 32094
 Phone: (386) 362-3678
 Fax: (386) 362-6133
 Auth. #: 9401





Gary J. Gill, P.E. #51942
 P.O. Box 187
 130 West Howard Street
 Live Oak, FL 32064
 Phone: (386) 362-3678
 Fax: (386) 362-6133
 Auth. #: 9401

A Custom Carport For:
MR. & MRS. RICHARDSON
 COLUMBIA CO., FL

These drawings, or any portions of service, are the sole property of the architect, and may not be used, copied or reproduced in whole or in part for use on or incorporated within any other job without specific and individual authorization by the architect.


DATE	DRAWN	REVISION	SHEET
01JUN06	JS		C.S.
COMMA	REVIEWED		
L0648	GJG		

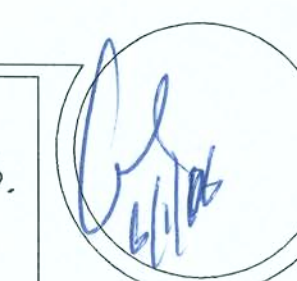

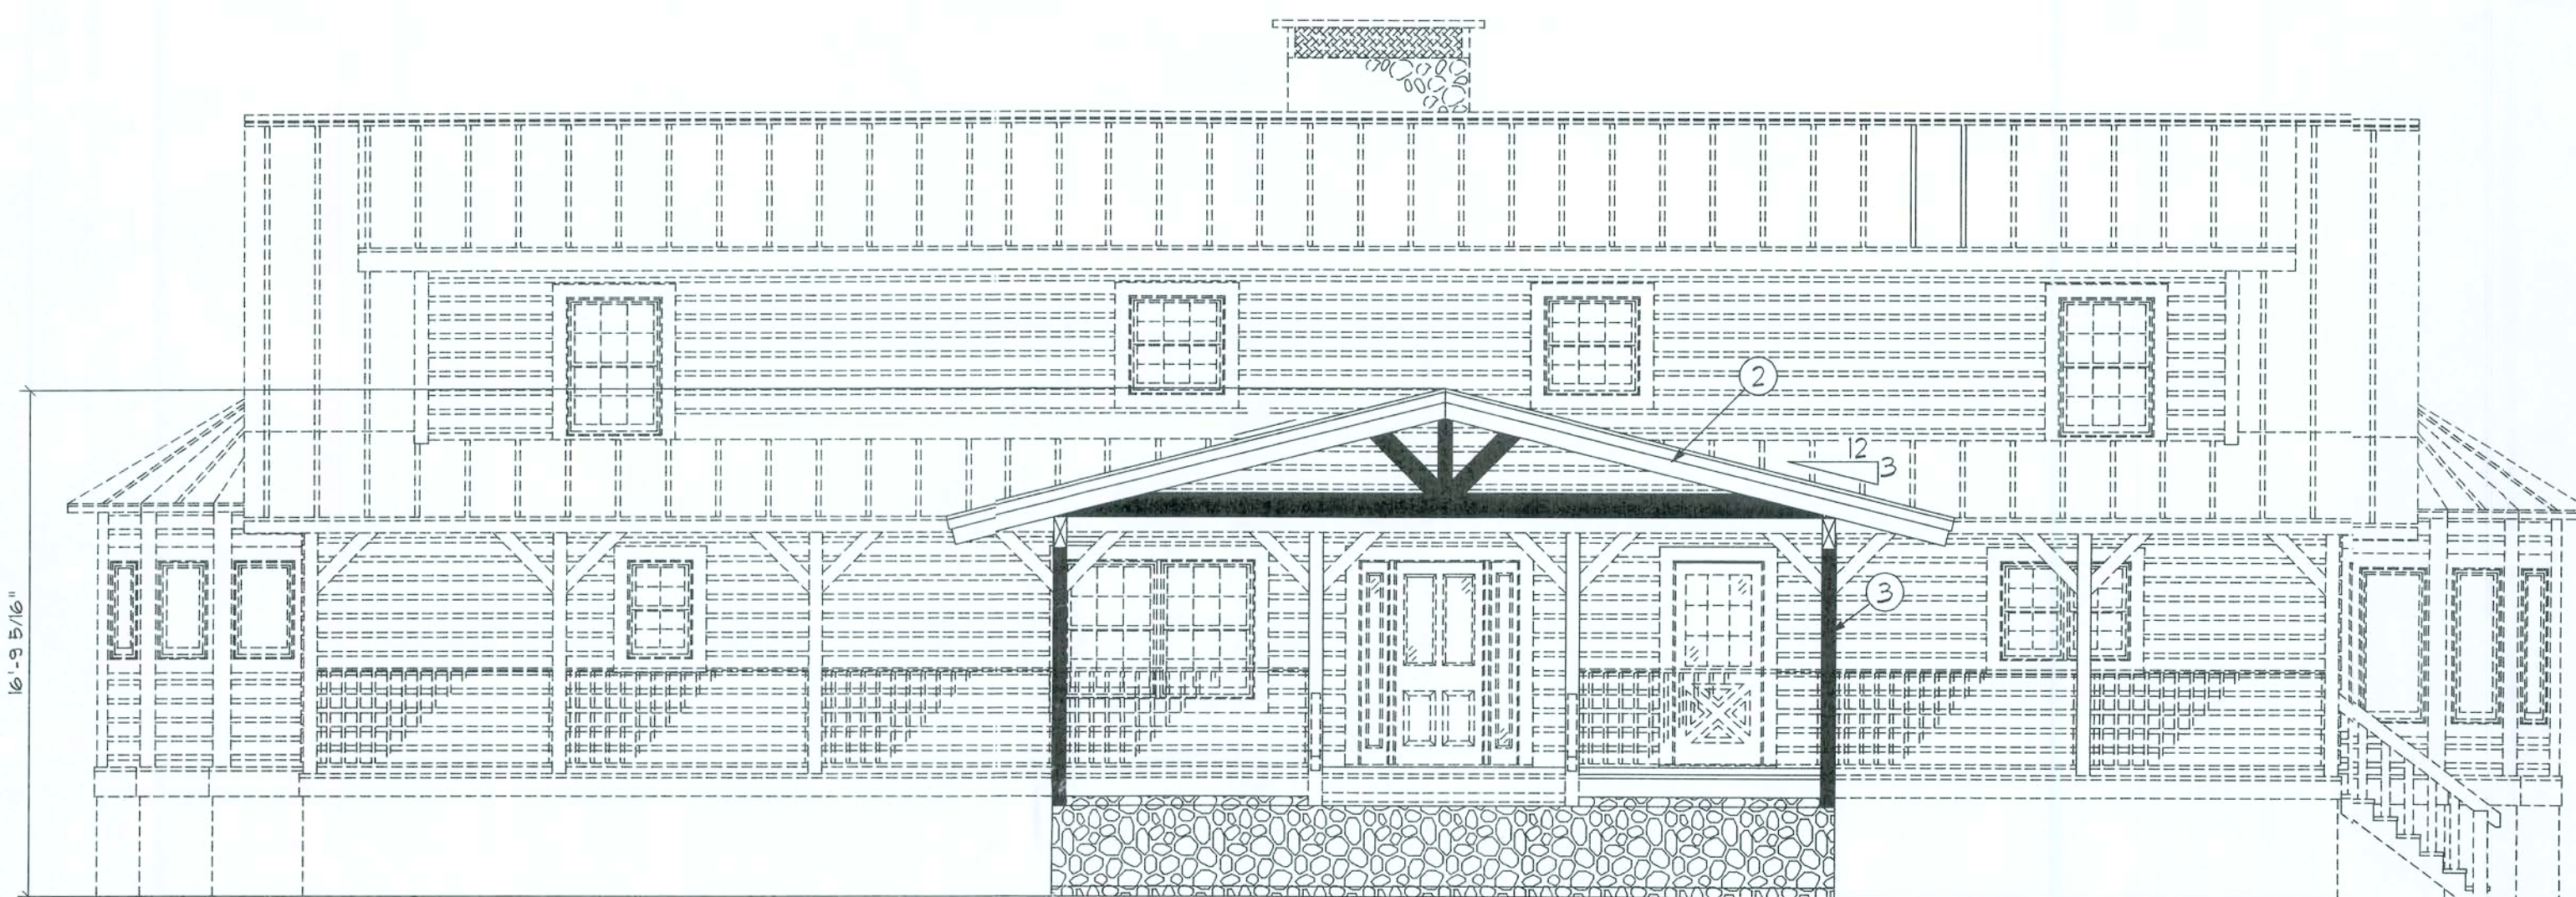

End ELEVATION

SCALE: 1/4" = 1'-0"

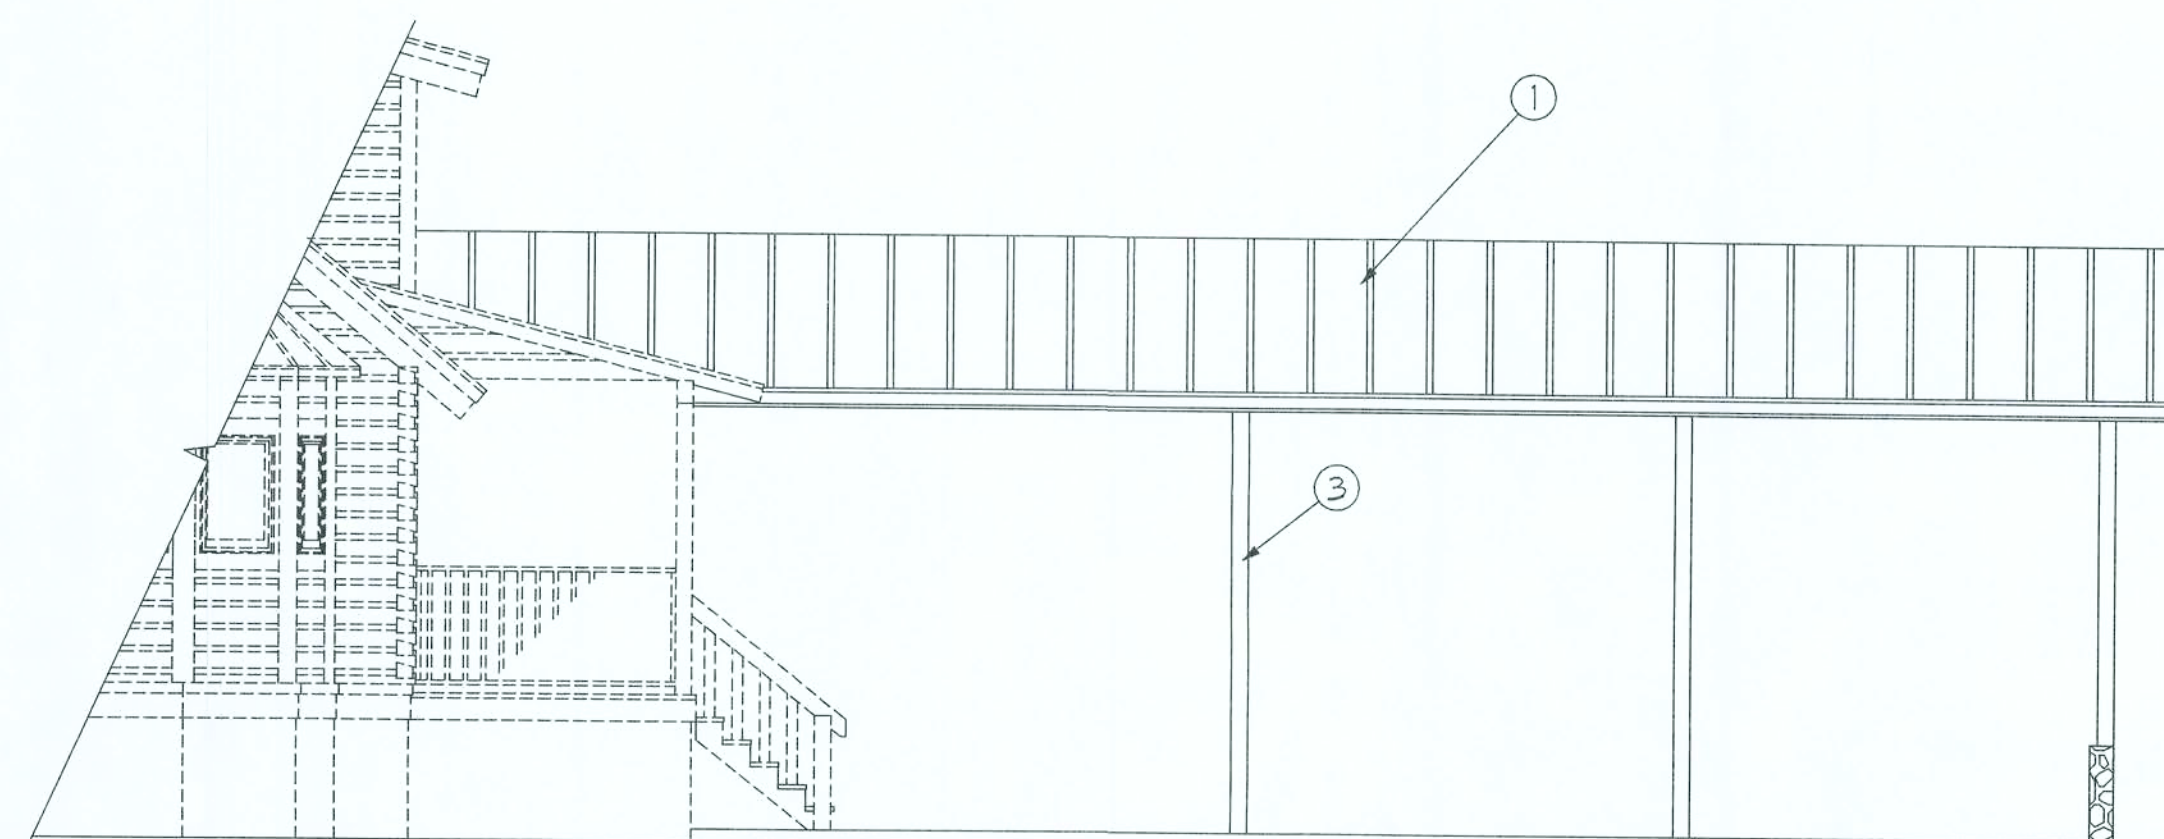

Side ELEVATION

SCALE: 1/4" = 1'-0"

GENERAL NOTES:

- ① METAL ROOFING AS SELECTED BY OWNER
- ② CONT. METAL FLASHING
- ③ 8 x 8 CYP, SUPPORT POSTS

Electrical SYMBOLS

○ FLUORESCENT LIGHT

— SWITCH/FIXTURE WIRING

ELECTRICAL PLAN NOTES


WIRE ALL APPLIANCES, HVAC UNITS AND OTHER EQUIPMENT PER MANUF. SPECIFICATIONS.

INSTALLATION SHALL BE PER NAT'L. ELECTRIC CODE.

TELEPHONE, TELEVISION AND OTHER LOW VOLTAGE DEVICES OR OUTLETS SHALL BE AS PER THE OWNER'S DIRECTIONS. IN ACCORDANCE W/ APPLICABLE SECTIONS OF NEC - LATEST EDITION.


ELECTRICAL CONTR. SHALL PREPARE "AS-BUILT" SHOP DUGS INDICATING ALL ELECTRICAL WORK INCLUDING ANY CHANGES TO THE ELEC. PLAN, ADDING TO THE ELEC. PLAN, RISER DIAGRAM, AS-BUILT PANEL SCHEDULE W/ ALL CKTS IDENTIFIED W/ CKT N. DESCRIPTION & BRKR. SERVICE ENT. & ALL UNDERGROUND WIRE LOCATIONS/ROUTING/DEPTH. RISER DIA. SHALL INCLUDE WIRE SIZES/TYPE & EQUIPMENT

CONTRACTOR SHALL PROVIDE 1 COPY OF AS-BUILT DUGS TO OWNER & 1 COPY TO THE PERMIT ISSUING AUTHORITY. TYPE W/ RATINGS & LOADS.

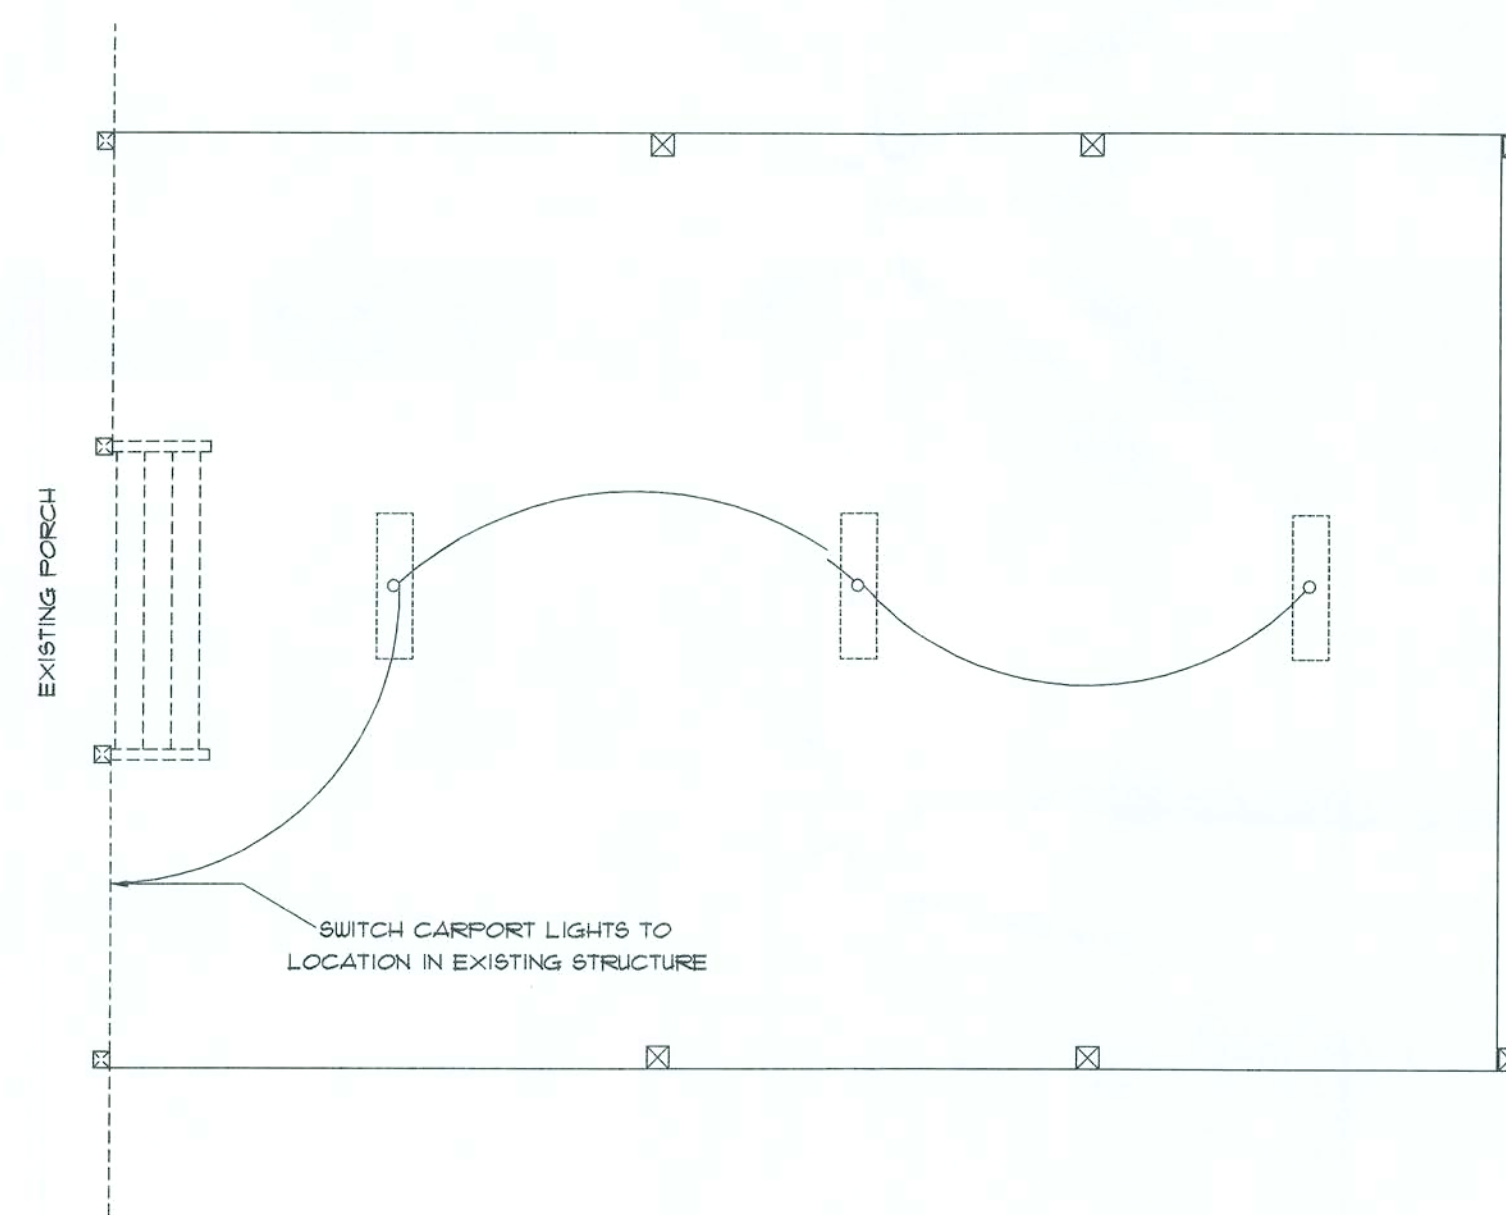

ELECTRICAL PLAN

SCALE: 1/4" = 1'-0"

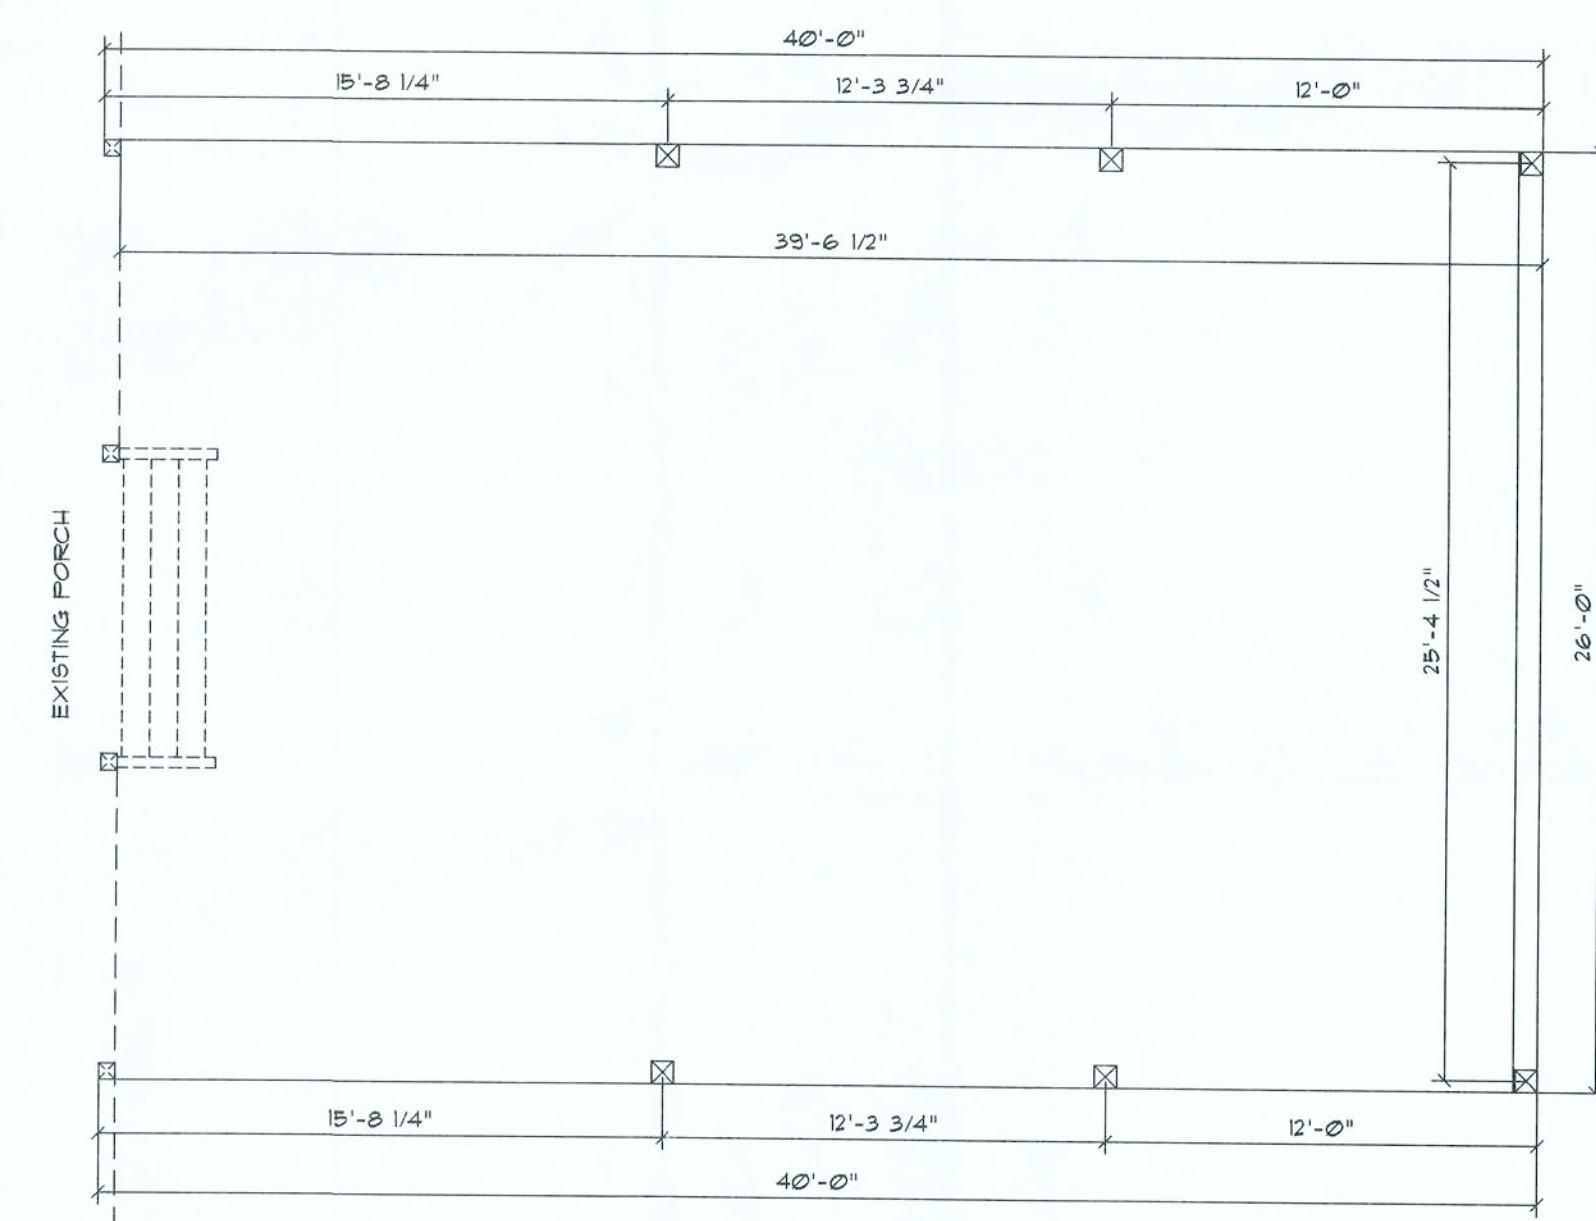

DIMENSION PLAN

SCALE: 1/4" = 1'-0"

NOTE:
ALL HIDDEN LINES REFER
TO EXISTING STRUCTURE

NOTE:
ELEVATION MARKS ARE FOR REFERENCE ONLY.
FINAL ELEVATIONS ARE DETERMINED BY THE
FINISHED LOG WALL - FIELD MEASURE.

AREA CALCULATION

CARPORT AREA: 1,242.00 SF

SUYANNEE RIVER LOG HOMES, INC.
Manufacturers
Specializing in Cypress & Cedar Custom Homes
4345 HIGHWAY 90, WELLSBORO, FLORIDA 32094
386-5631, 386-5641 / 1-800-362-LOGS(5641)

GJ
Gary J. Gill, P.E. #51942
P.O. Box 187
130 West Howard Street
Live Oak, FL 32064
Phone: (386) 362-3678
Fax: (386) 362-6133
Auth. #: 9461

A Custom Carport For:
MR. & MRS. RICHARDSON
COLUMBIA CO., FL


These drawings, in testimony of work, are the sole property of the architect, and may not be used, copied or reproduced in whole or in part for use on or incorporated within any other job without specific and individual authorization by the architect.

DATE: 01JUN06
DRAWN: JS
CHECKED: GJG
LO648

REVISION:
REVIEWED:
GJG



SHEET:
A.1
1 OF 3

 Handwritten signature and date 6/1/06



NOTE!
ALL REQUIRED ANCHOR BOLTS, STRAPS OR OTHER EMBEDDED
ITEMS, SHALL BE IN-PLACE PRIOR TO THE POURING OF CONCRETE.
VERIFY & COORDINATE PLANS AND OTHER FOUNDATION DETAILS.

  SCALE: N.T.S



SM-Rib Metal Panel
General Roofing NOTES:

[illegible]SCALE: NONE_E

 **SUWANNEE RIVER**
LOG HOMES, INC.
Manufacturers
Specializing in Cypress & Cedar Custom Homes
4345 HIGHWAY 90, WELLBORN, FLORIDA 32094
386.9631, CGS(56-47) / 1800.9621, CGS(56-47)



Gary J. Gill, P.E. #51942
P.O. Box 187
130 West Howard Street
Live Oak FL, 32064
Phone: (386) 362-3678
Fax: (386) 362-6133
Auth. #: 9461

A Custom Carport For:
R. & MRS. RICHARDSON
COLUMBIA CO., FL


These drawings, as instruments of service, are the sole property of Columbia Co., Inc. and are not to be used, copied or reproduced in whole or in part for any other purpose without the written consent of Columbia Co., Inc.

may not be used, copied or reproduced in whole or in part for use on or incorporated within any other job without specific and individual authorization by the architect.







DATE: 01JUN06	DRAWN: JS	REVISION:	SHEET: A.2
COMM:	REVIEWED:		
L0648	GJG		2 OF 3

A.2
2 OF 3

2 OF 3

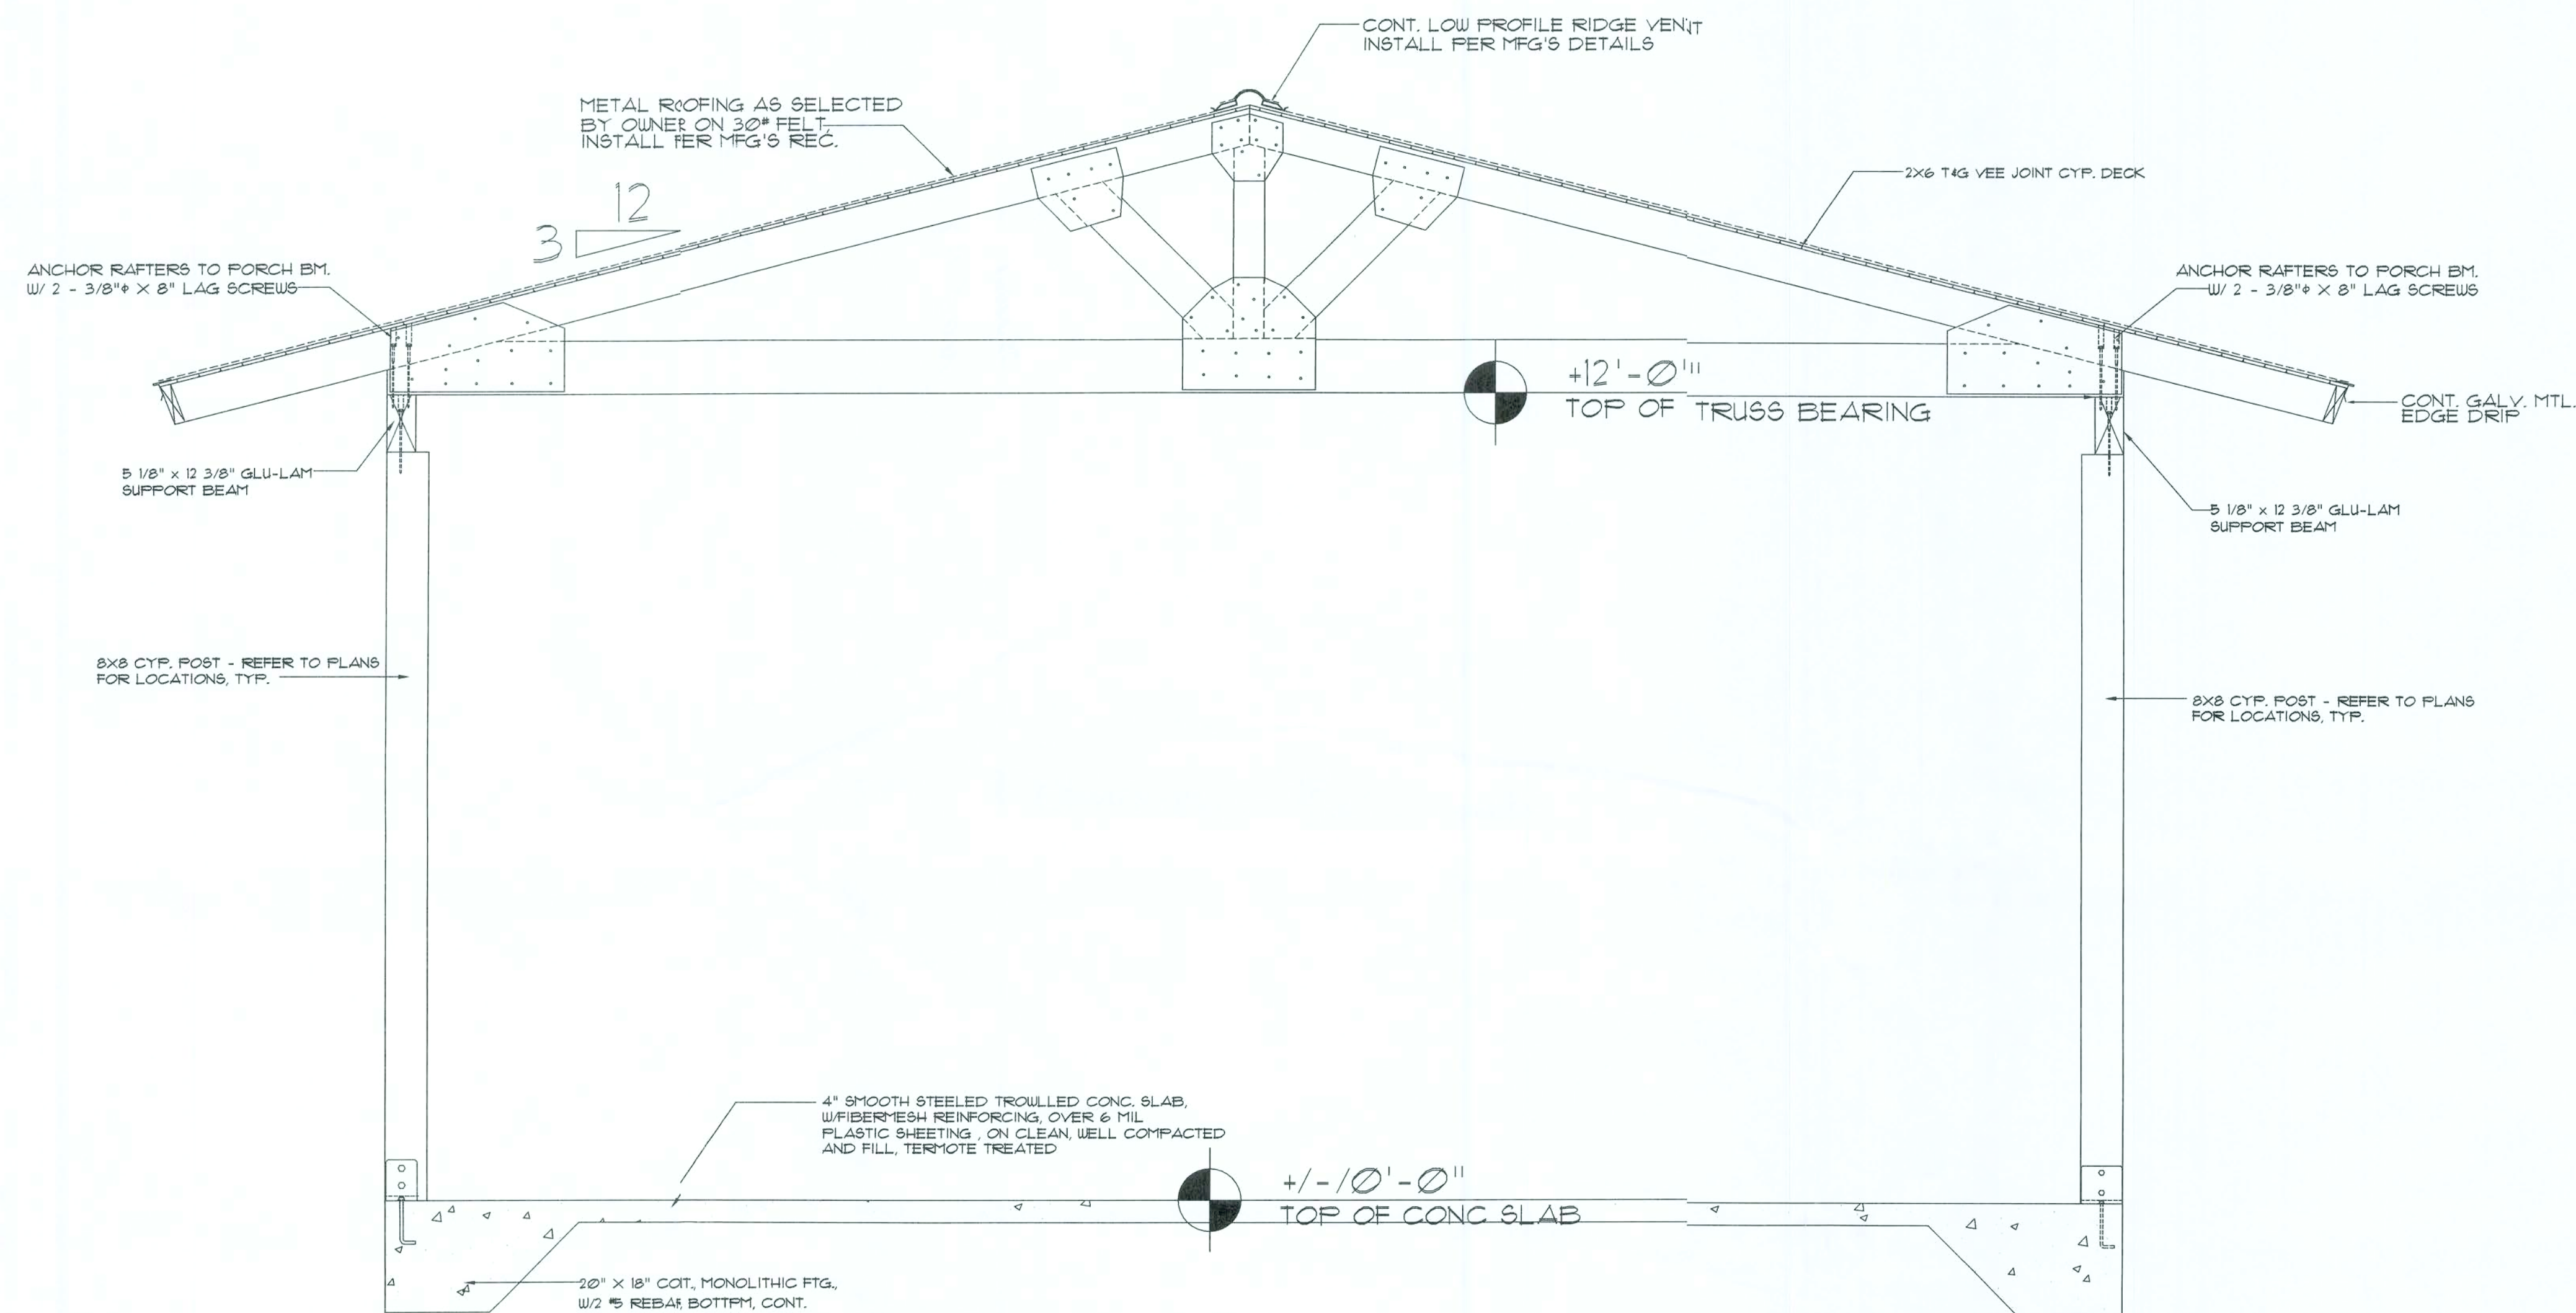

BUILDING SECTION
SCALE: N.T.S.

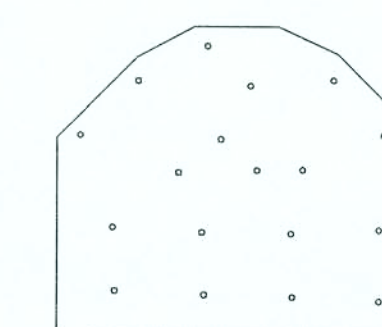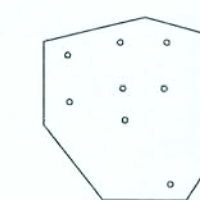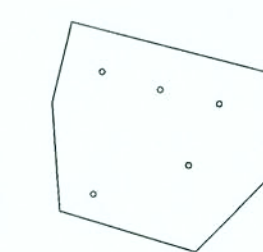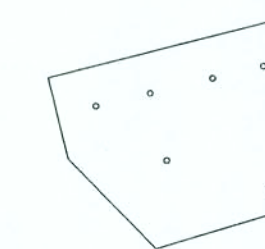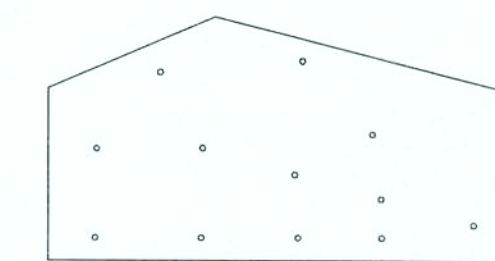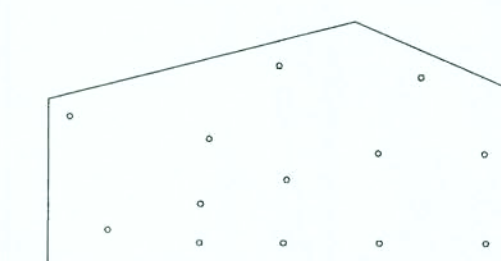

3/8" STEEL GUSSETS, W/
W/ 9/16" HOLES FOR
5/8" THRU-BOLTS

SUWANNEE RIVER LOG HOMES, INC.
Manufacturers
Specializing in Cypress & Cedar Custom Homes
4345 HIGHWAY 90, WELLSBORO, FLORIDA 32094
386-363-LOGS/56471 / 1800-362-LOGS/56471

GJ
Gary J. Gill, P.E. #51942
P.O. Box 187
130 West Howard Street
Live Oak, FL 32064
Phone: (386) 362-3678
Fax: (386) 362-6133
Auth. #: 9461

A Custom Carport For:
MR. & MRS. RICHARDSON
COLUMBIA CO., FL

These drawings, or instruments of service, are the sole property of the architect, and may not be used, copied or reproduced in whole or in part for use on or incorporated within any other job without specific and individual authorization by the architect.

DATE: 01JUN06	DRAWN: JS	REVISION:	SHEET: A.3
COMMENTS: L0648	REVIEWED: GJG		3 OF 3

[Handwritten signature]