



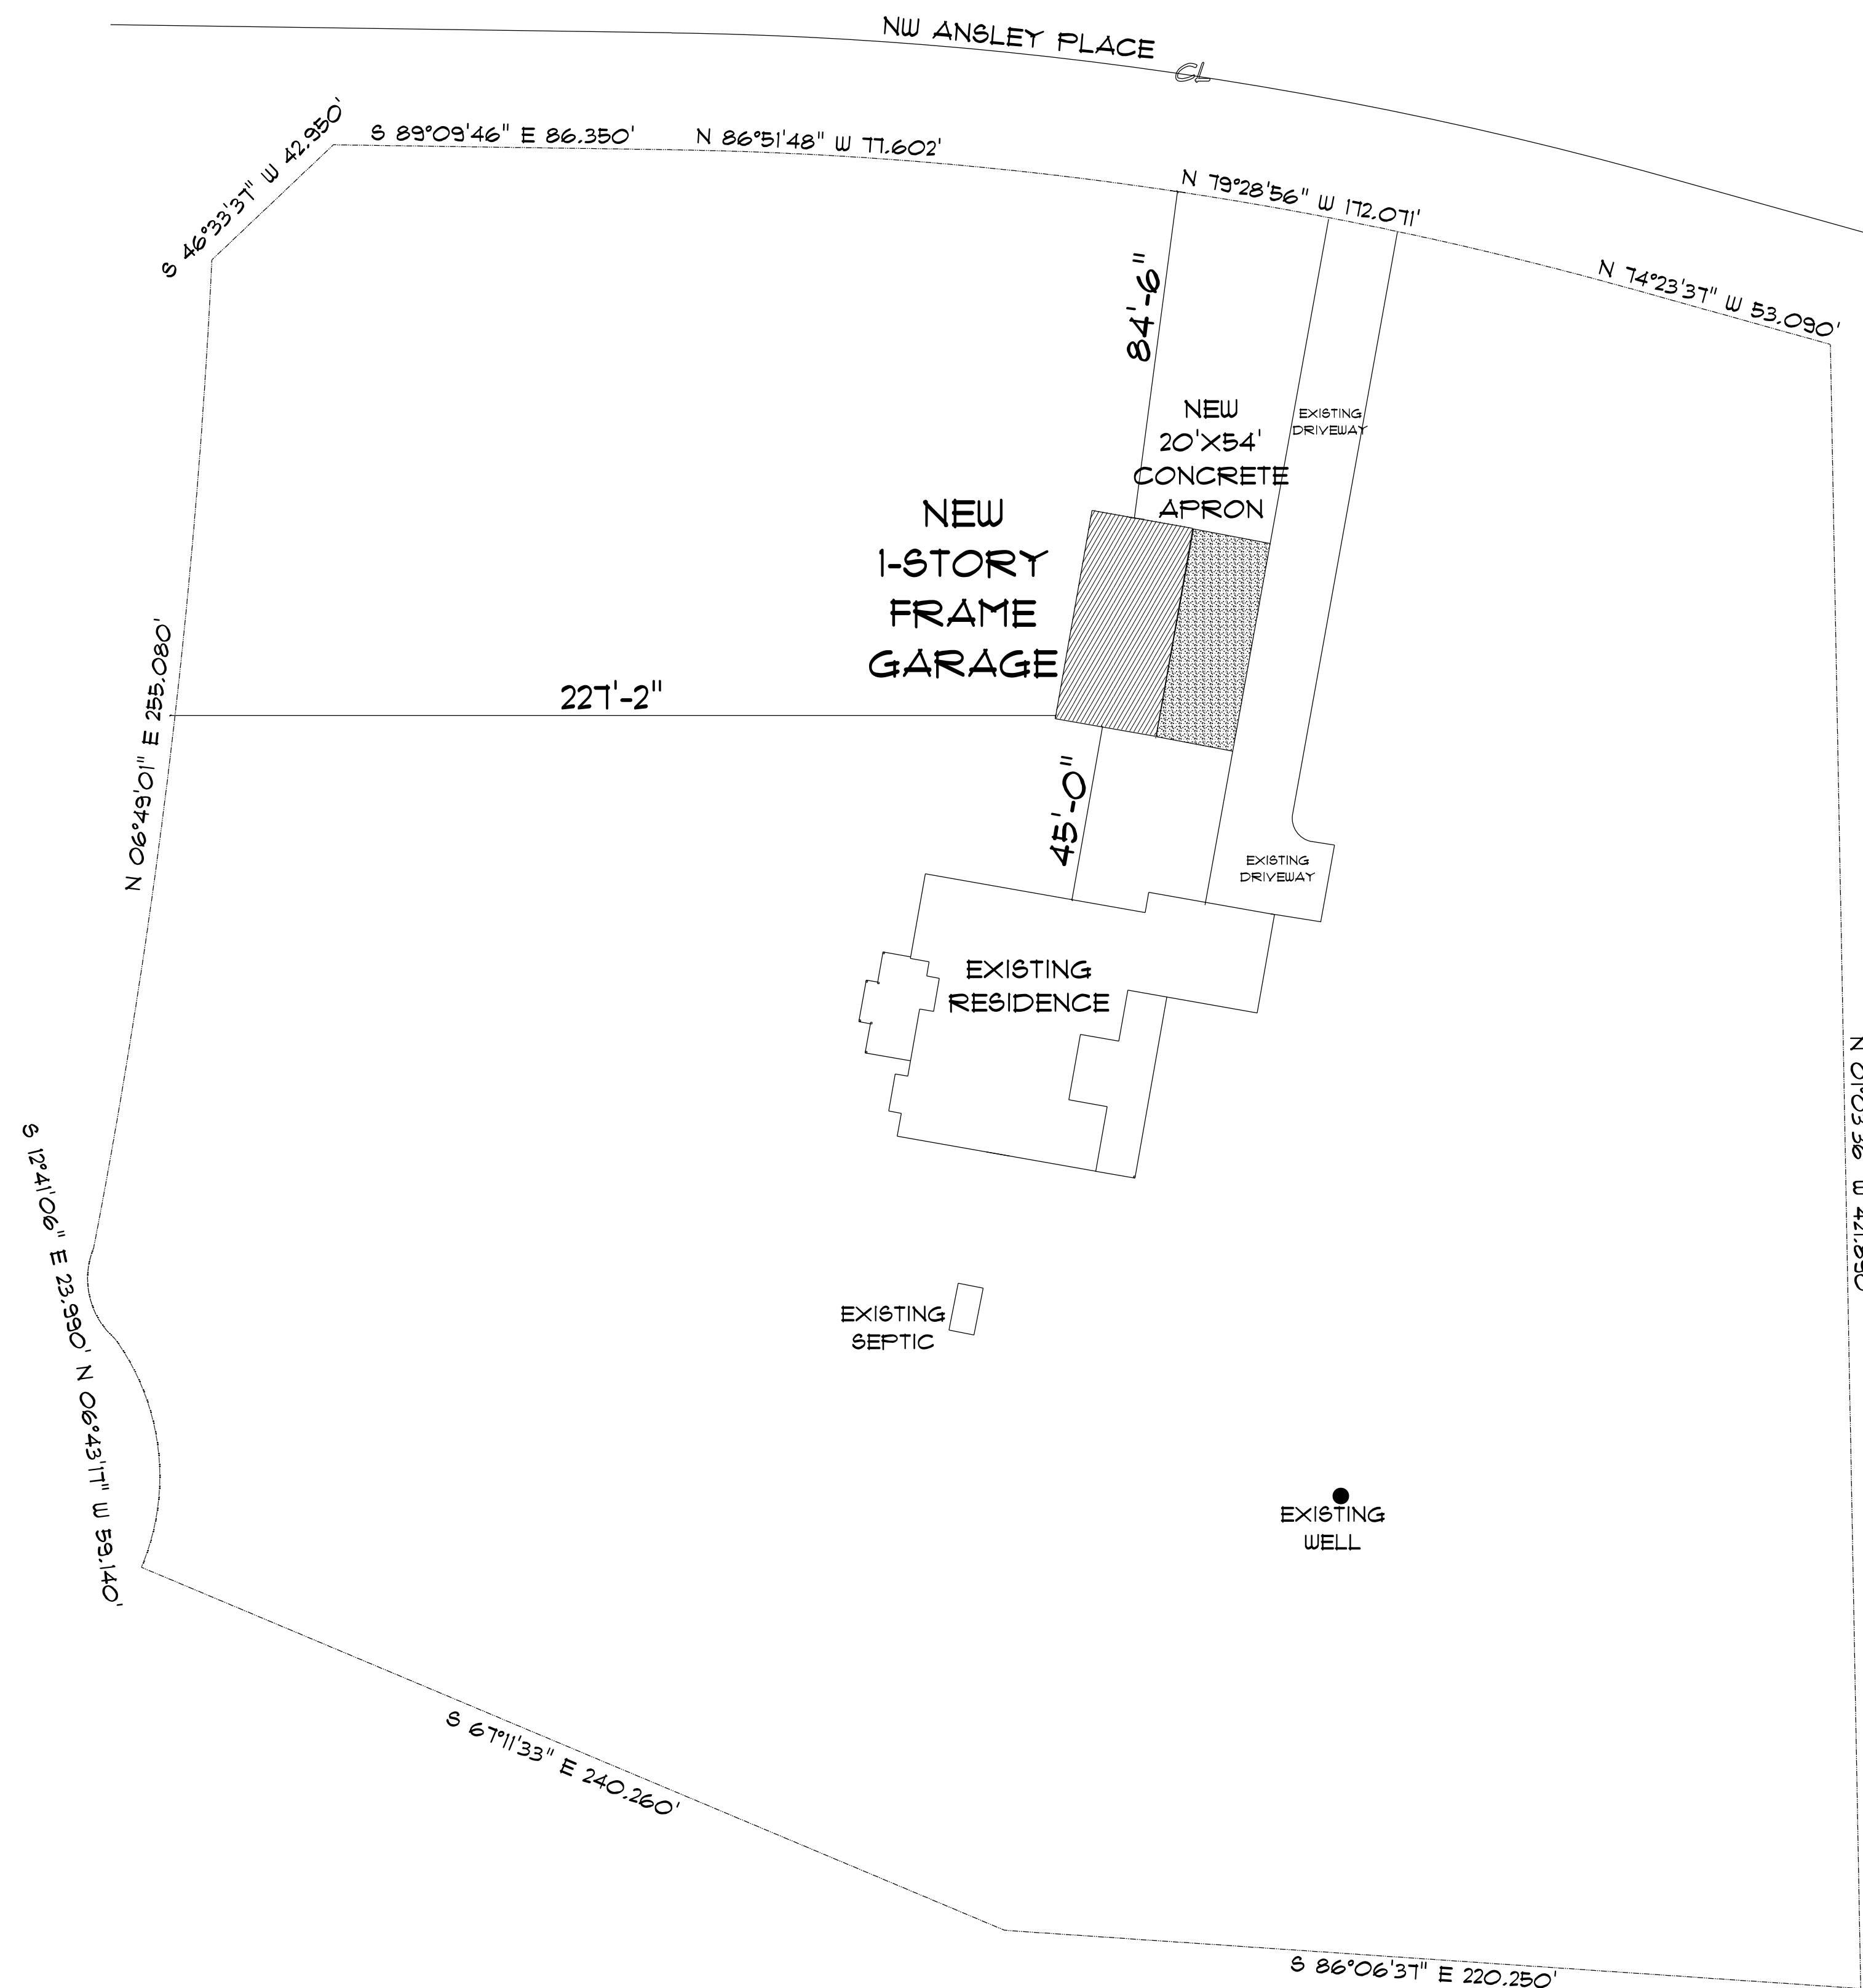

* SITE PLAN *

SCALE : 1" = 30'-0"

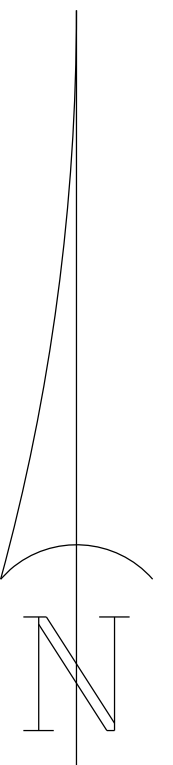

GARAGE
for
EDDIE & LINDA
HAZEN

Teena M. Ruffo
2925 SW 8R 47
Lake City Florida, 32025
Cell: (386) 867-1191
Email: teenaruffo@gmail.com

PRINTED DATE:
Tuesday, April 2, 2024

DRAWN BY: Teena M. Ruffo
CHECKED BY:


BUILDING CONTRACTOR:
LITTLE AND WILLIAMS INC

FINAL DATE:

JOB NUMBER:

DRAWING NUMBER
A-1

OF 5 SHEETS

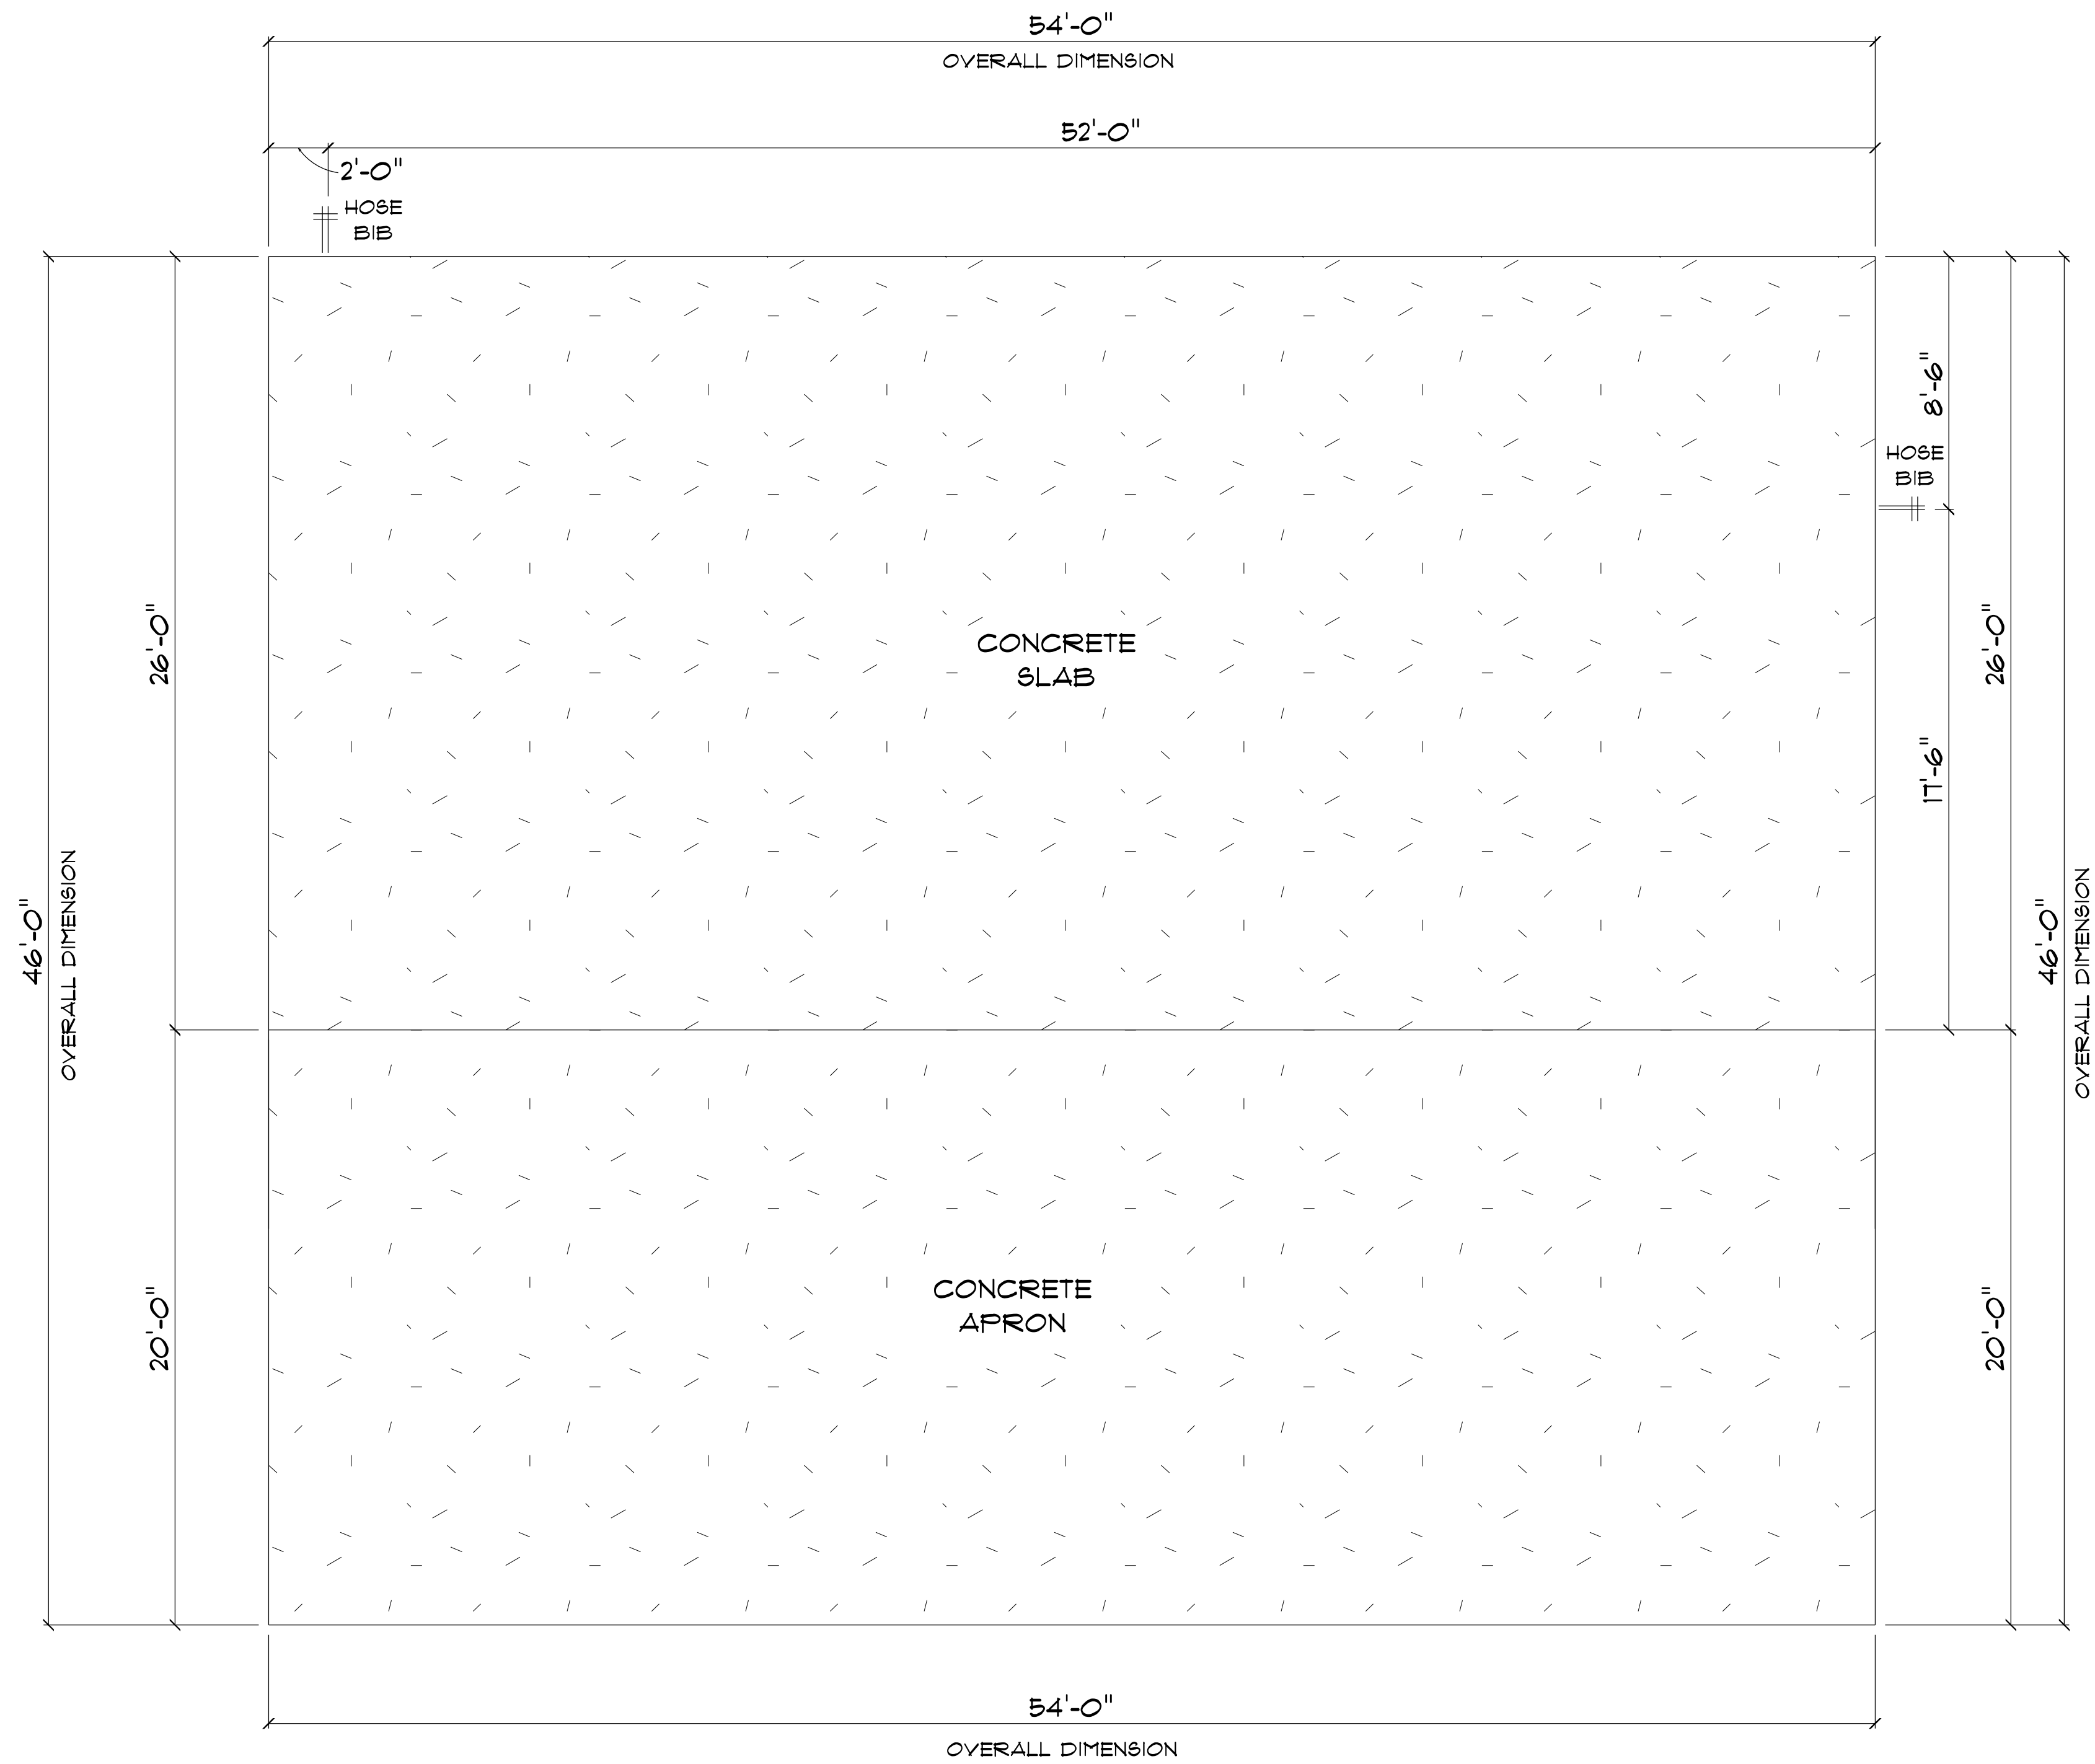

* FOUNDATION PLAN *

SCALE : 1/4" = 1'-0"

IMPORTANT NOTES:

1. IT IS THE BUILDER'S RESPONSIBILITY TO VERIFY ALL GEOMETRY AND DIMENSIONS BEFORE ORDERING ANY MATERIALS OR BEGINNING CONSTRUCTION.
2. THESE PLANS ARE FOR LAYOUT AND DESIGN PURPOSES ONLY ALL STRUCTURAL NOTES AND DETAILS TO BE PROVIDED BY AN ENGINEER.

GARAGE
for
EDDIE & LINDA
HAZEN

Teena M. Ruffo
2925 SW SR 47
Lake City Florida, 32025
Cell: (386) 867-1191
Email: teenaruffo@gmail.com

PRINTED DATE:
Tuesday, April 2, 2024

DRAWN BY: Teena M. Ruffo CHECKED BY:

BUILDING CONTRACTOR
LITTLE AND WILLIAMS INC


FINAL DATE:

JOB NUMBER:

DRAWING NUMBER

A-2

OF 5 SHEETS

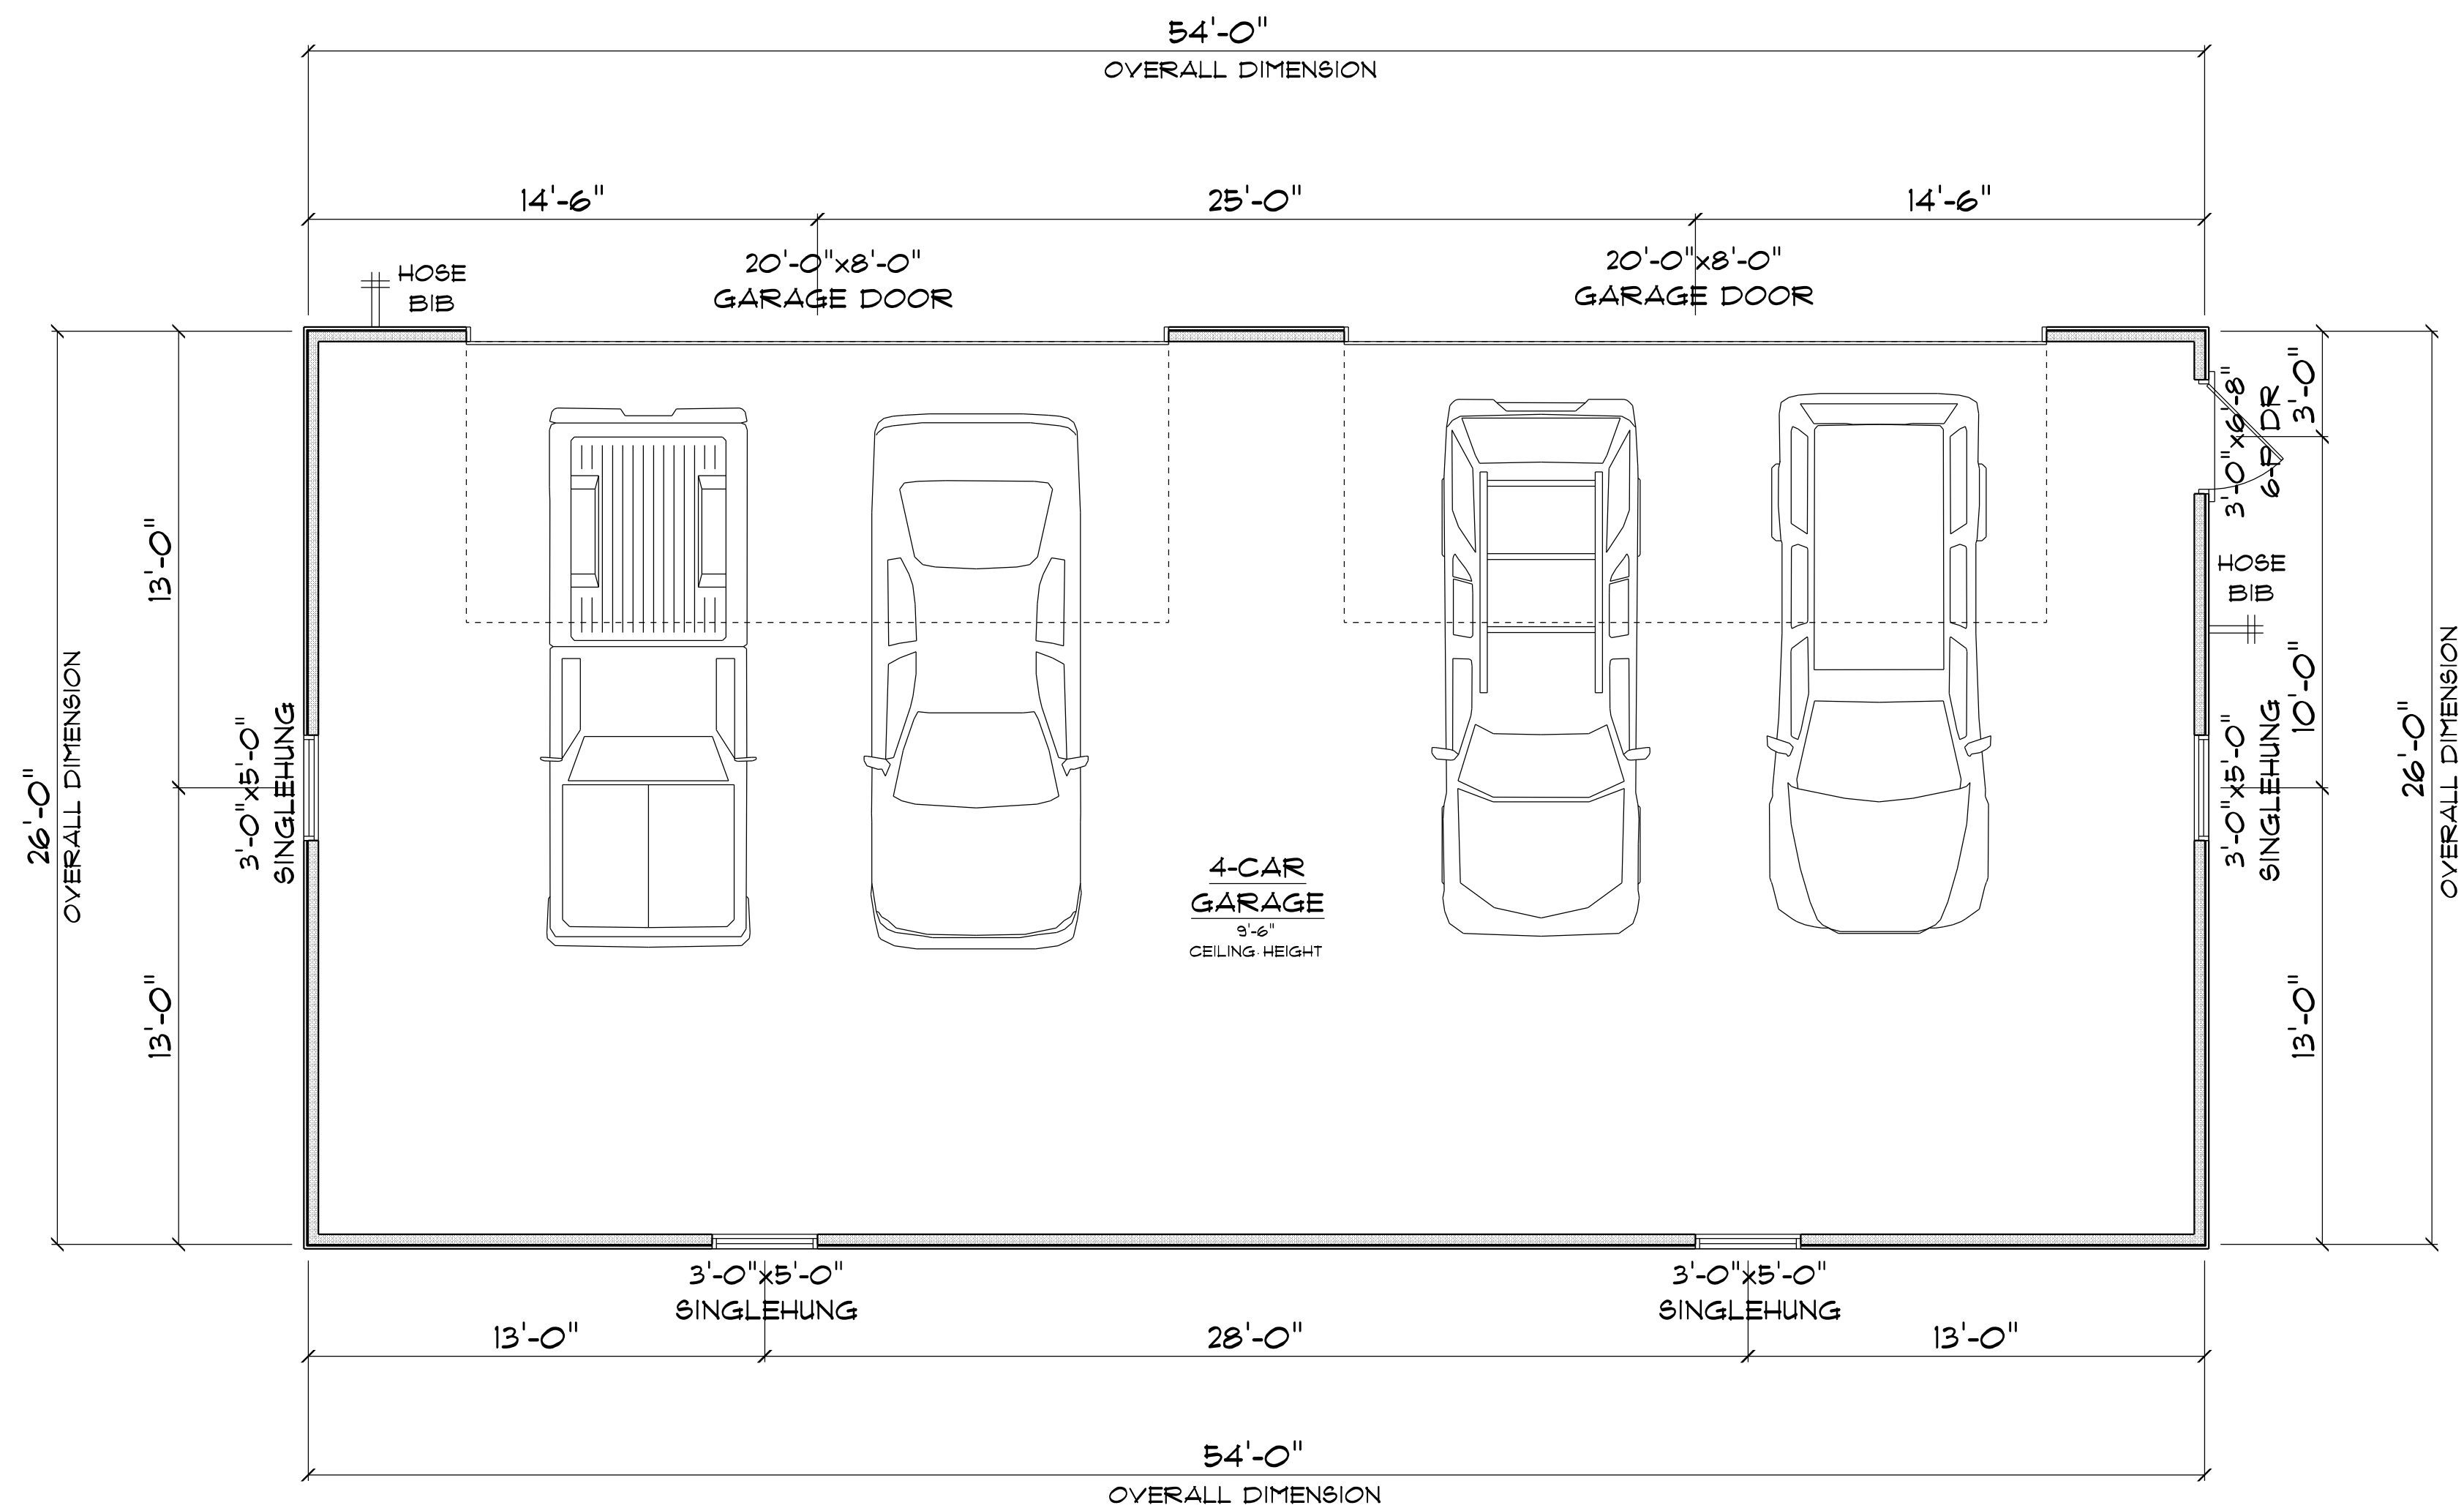

* FLOOR PLAN *

SCALE : 1/4" = 1'-0"

4-CAR GARAGE	=	1,404 S.F.
TOTAL AREA UNDER ROOF	=	1,404 S.F.

IMPORTANT NOTES:

1. IT IS THE BUILDER'S RESPONSIBILITY TO VERIFY ALL GEOMETRY AND DIMENSIONS BEFORE ORDERING ANY MATERIALS OR BEGINNING CONSTRUCTION.
2. THESE PLANS ARE FOR LAYOUT AND DESIGN PURPOSES ONLY. ALL STRUCTURAL NOTES AND DETAILS TO BE PROVIDED BY AN ENGINEER.
3. ALL EXTERIOR WALLS ARE 2X4 FRAME.

GARAGE
for
EDDIE & LINDA
HAZEN

Teena M. Ruffo
2925 SW SR 47
Lake City, Florida, 32025
Cell: (386) 867-1191
Email: teenaruffo@gmail.com

PRINTED DATE:
Tuesday, April 2, 2024

DRAWN BY: Teena M. Ruffo
CHECKED BY:

BUILDING CONTRACTOR:
LITTLE AND WILLIAMS INC


FINAL DATE:

JOB NUMBER:

DRAWING NUMBER

A-3


OF 5 SHEETS

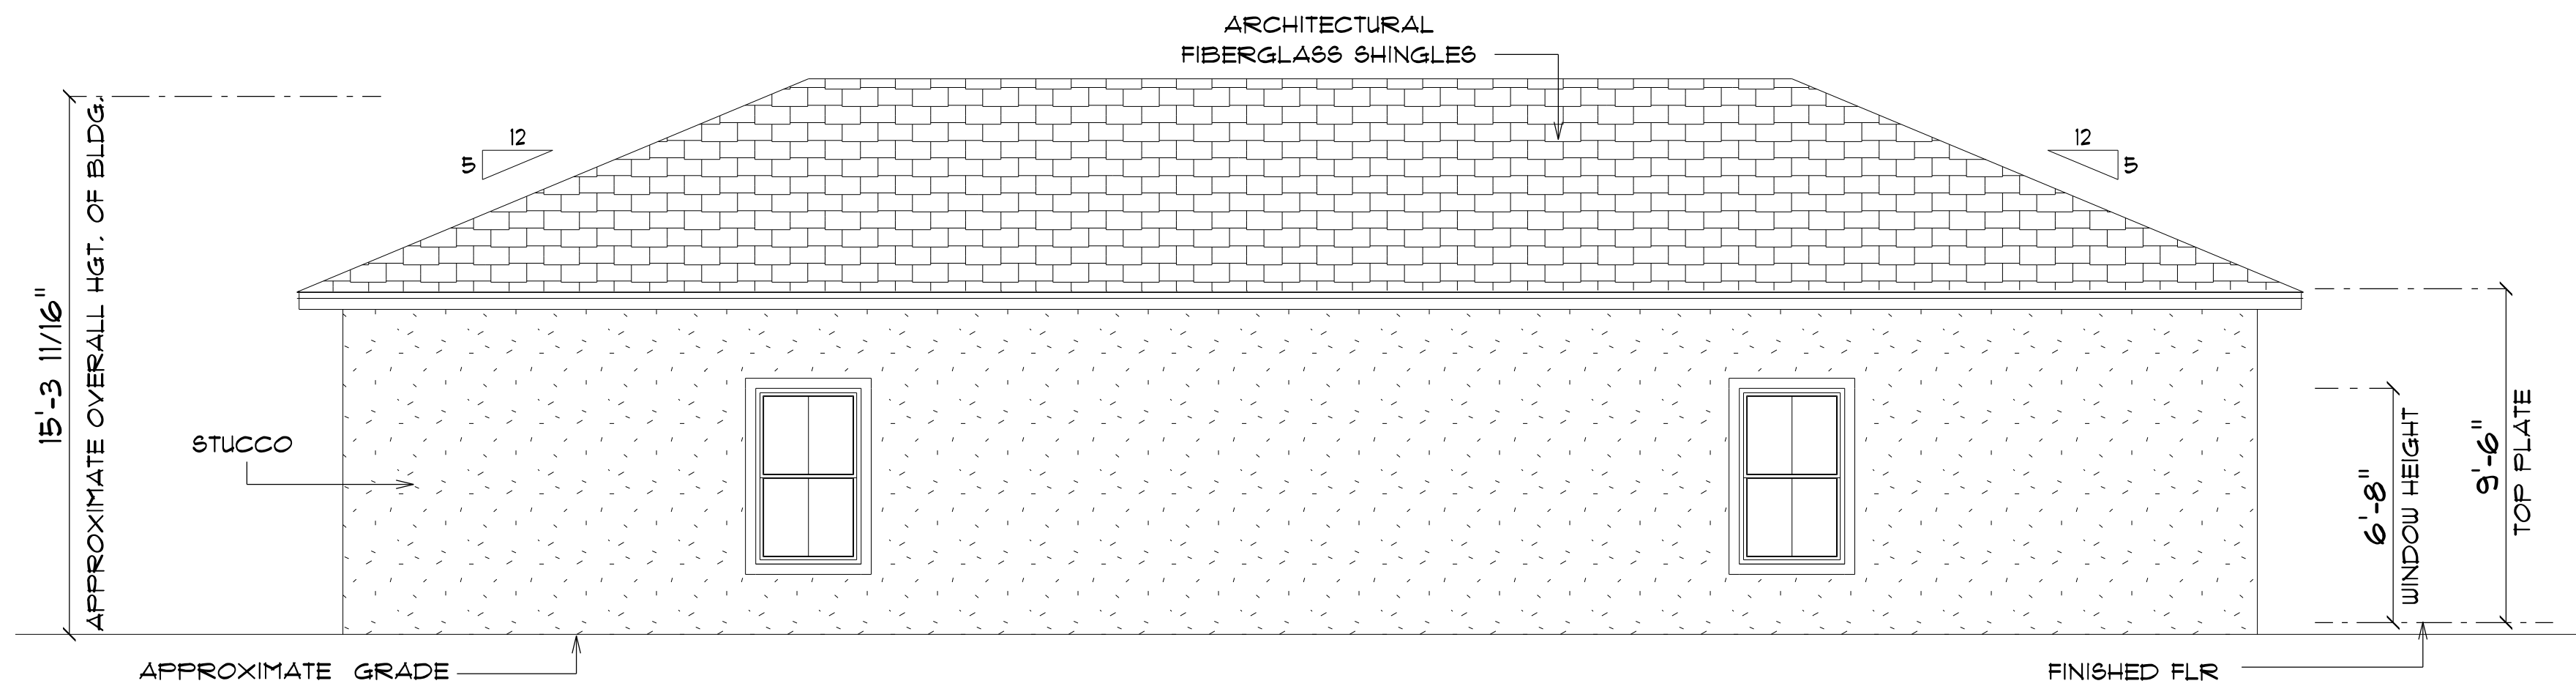

* FRONT ELEVATION *

SCALE : 1/4" = 1'-0"


NOTE: 18" OVERHANGS

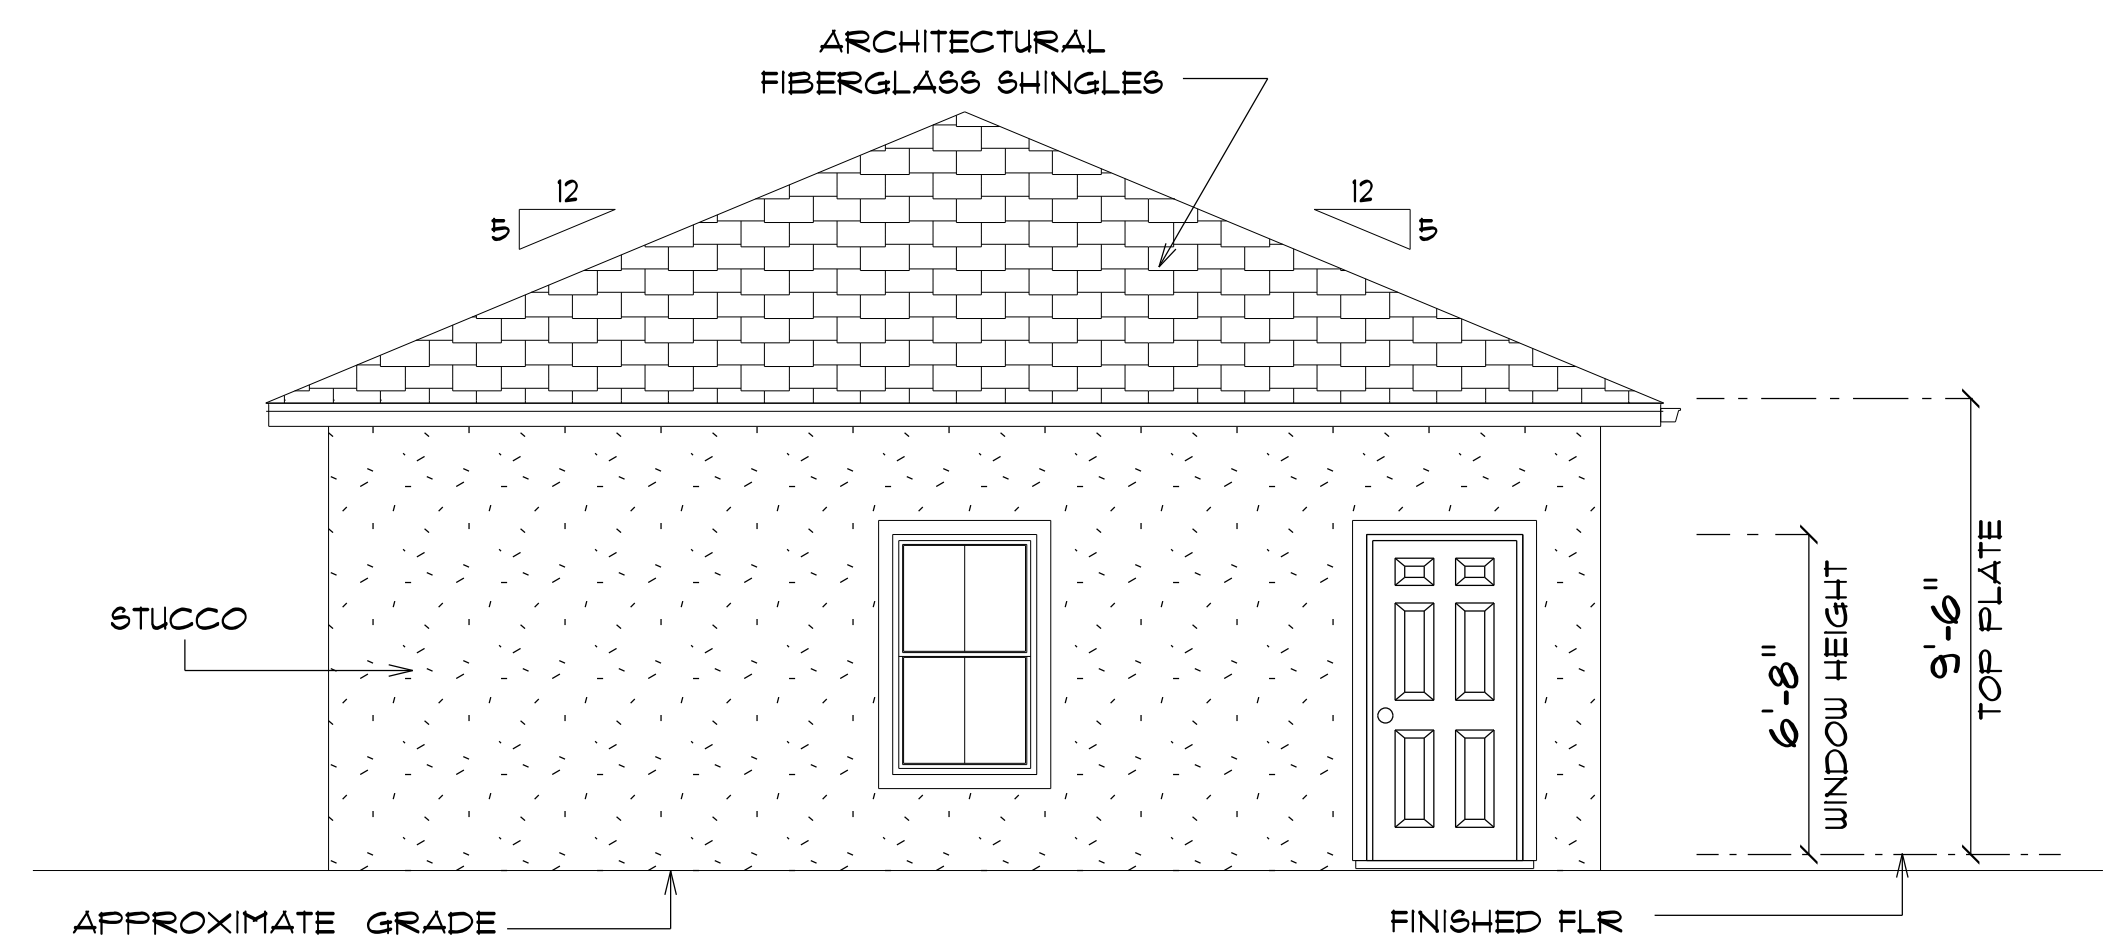

* RIGHT ELEVATION *

SCALE : 1/4" = 1'-0"


NOTE: 18" OVERHANGS

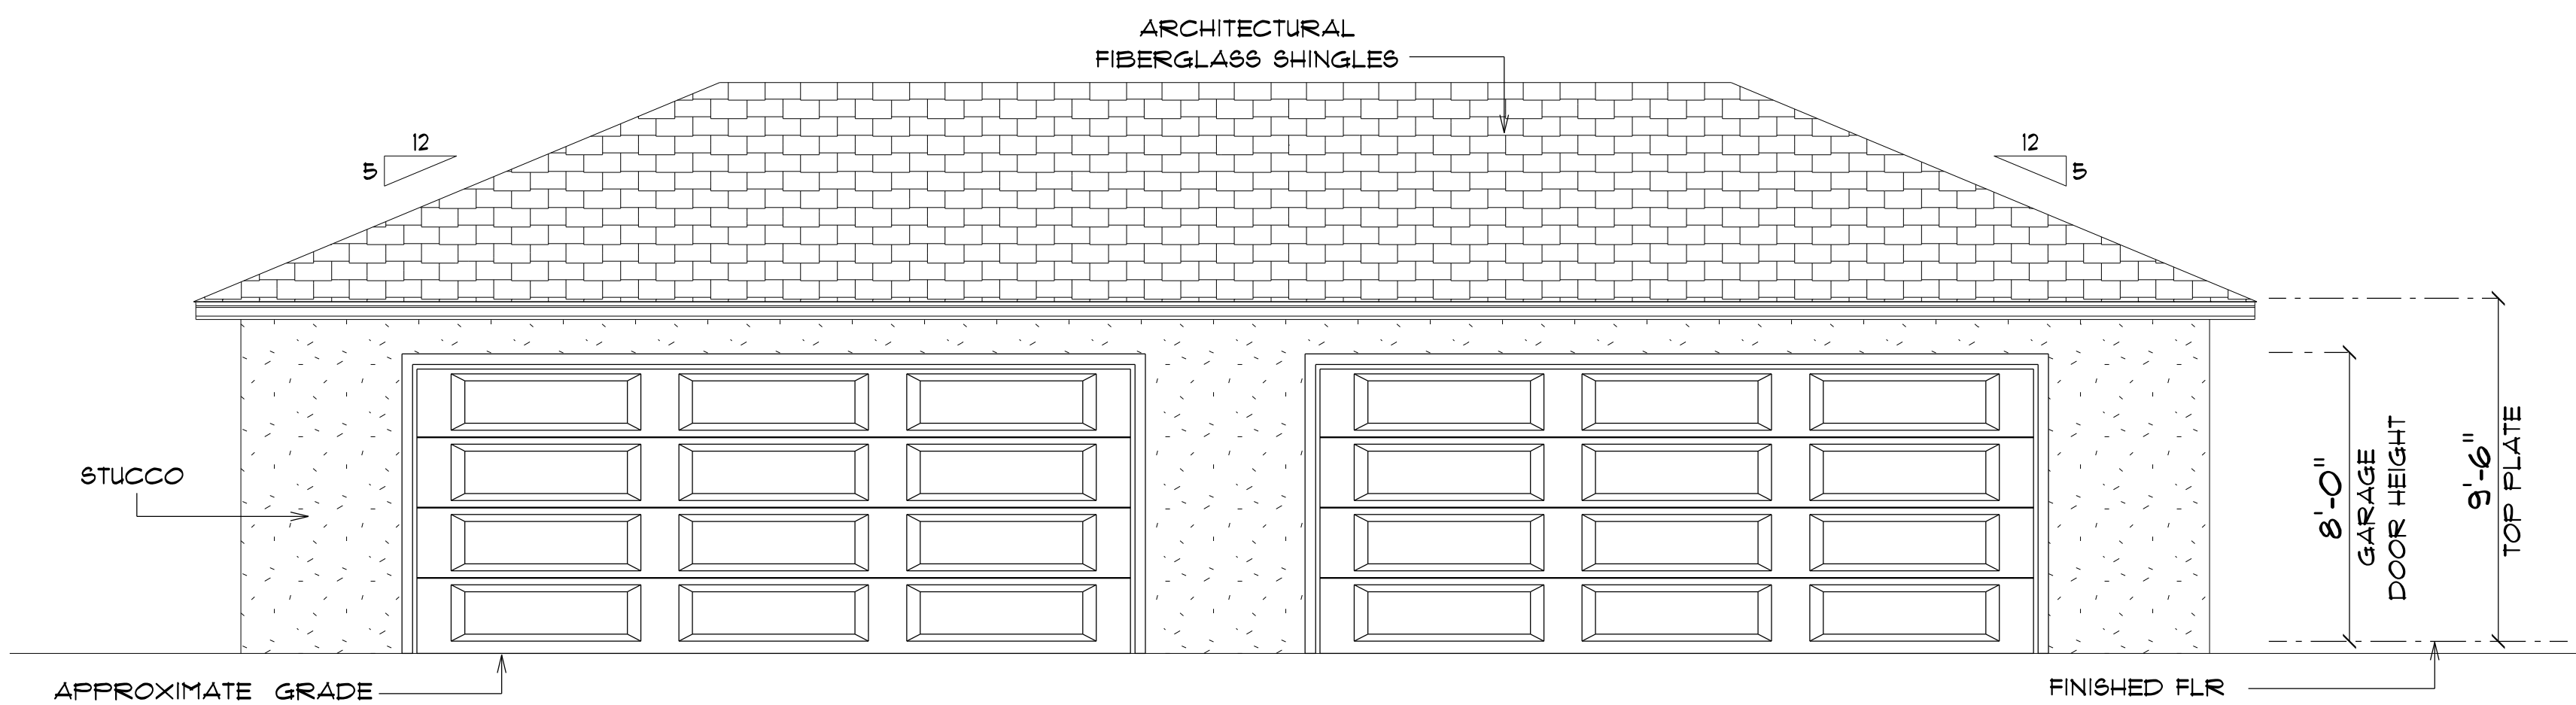

* REAR ELEVATION *

SCALE : 1/4" = 1'-0"

NOTE: 18" OVERHANGS

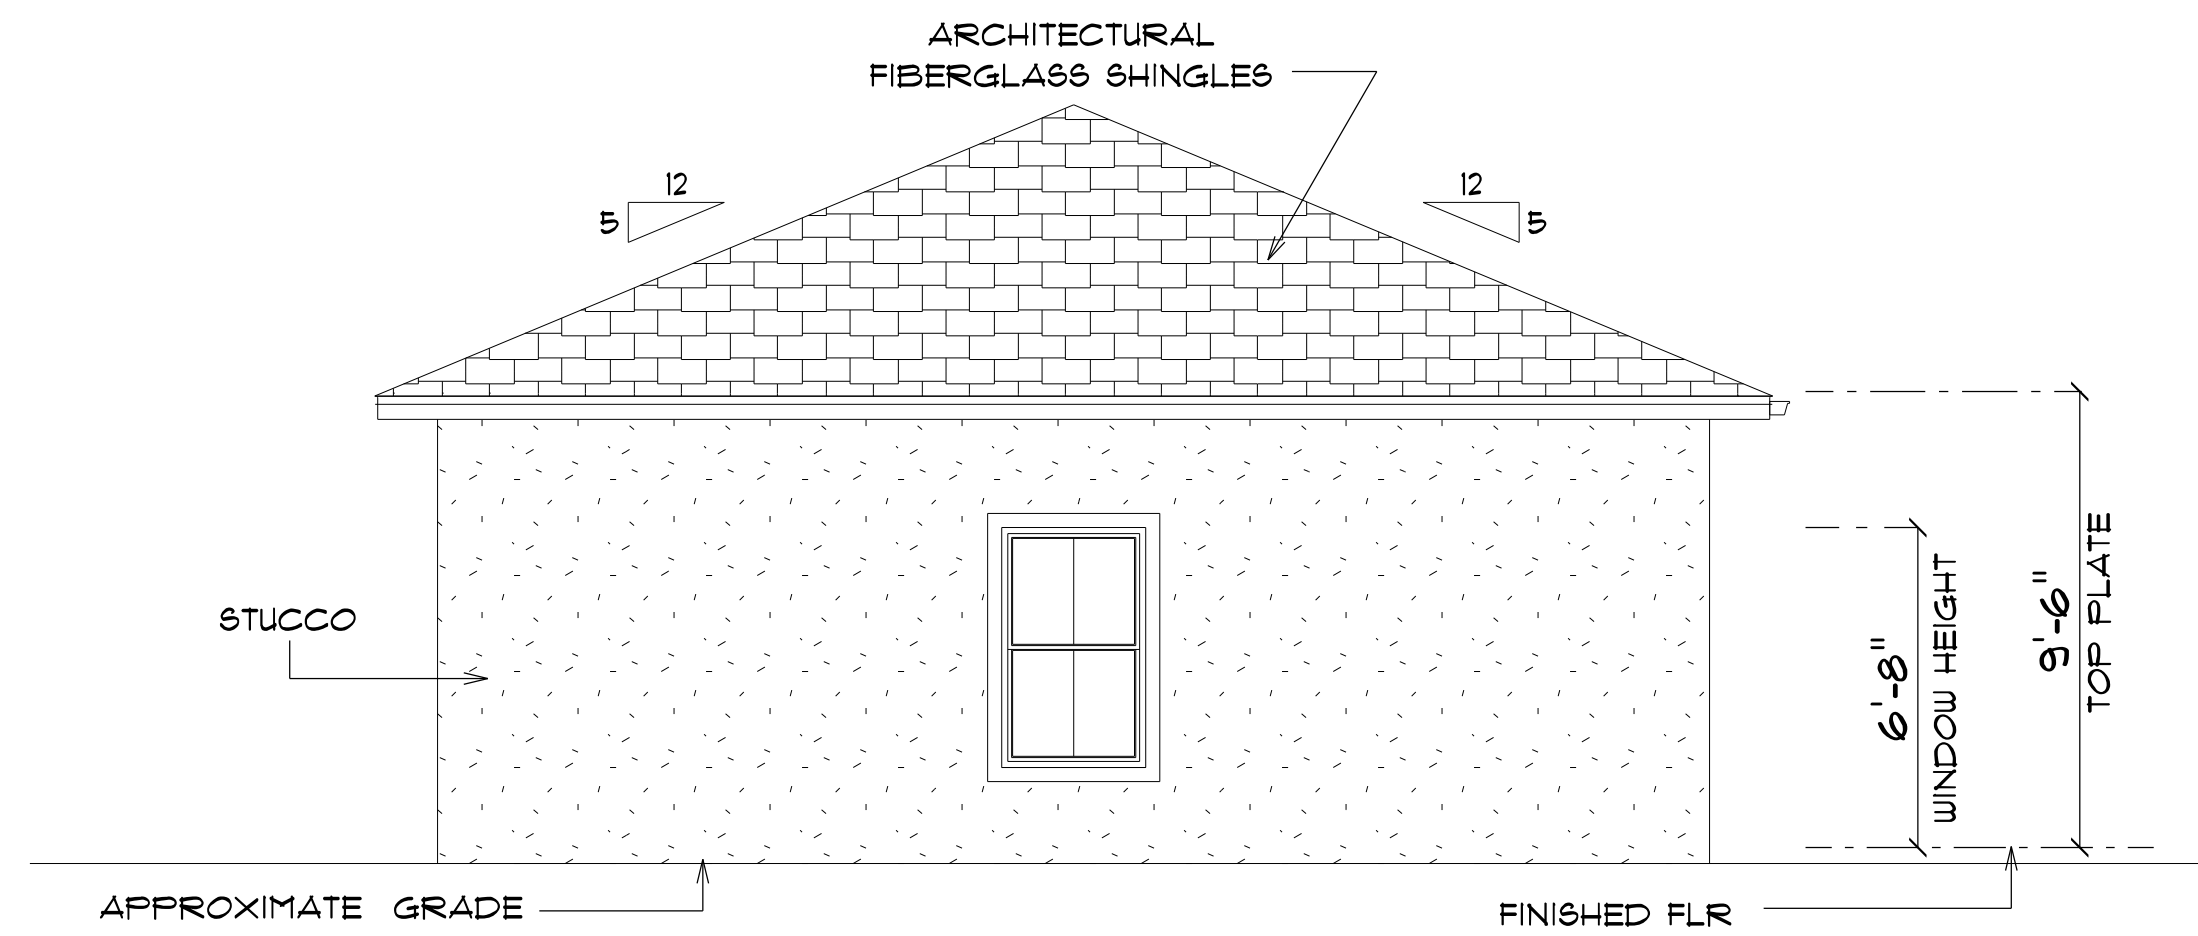

* LEFT ELEVATION *

SCALE : 1/4" = 1'-0"

NOTE: 18" OVERHANGS


GARAGE
for
EDDIE & LINDA
HAZEN

Teena M. Ruffo
2925 SW SR 41
Lake City Florida, 32025
Cell: (386) 861 - 1191
Email: teenaruffo@gmail.com

PRINTED DATE:
Tuesday, April 2, 2024
DRAWN BY: Teena M. Ruffo
CHECKED BY:
BUILDING CONTRACTOR:
LITTLE AND WILLIAMS INC
FINAL DATE:
JOB NUMBER:

DRAWING NUMBER
A-4

OF 5 SHEETS

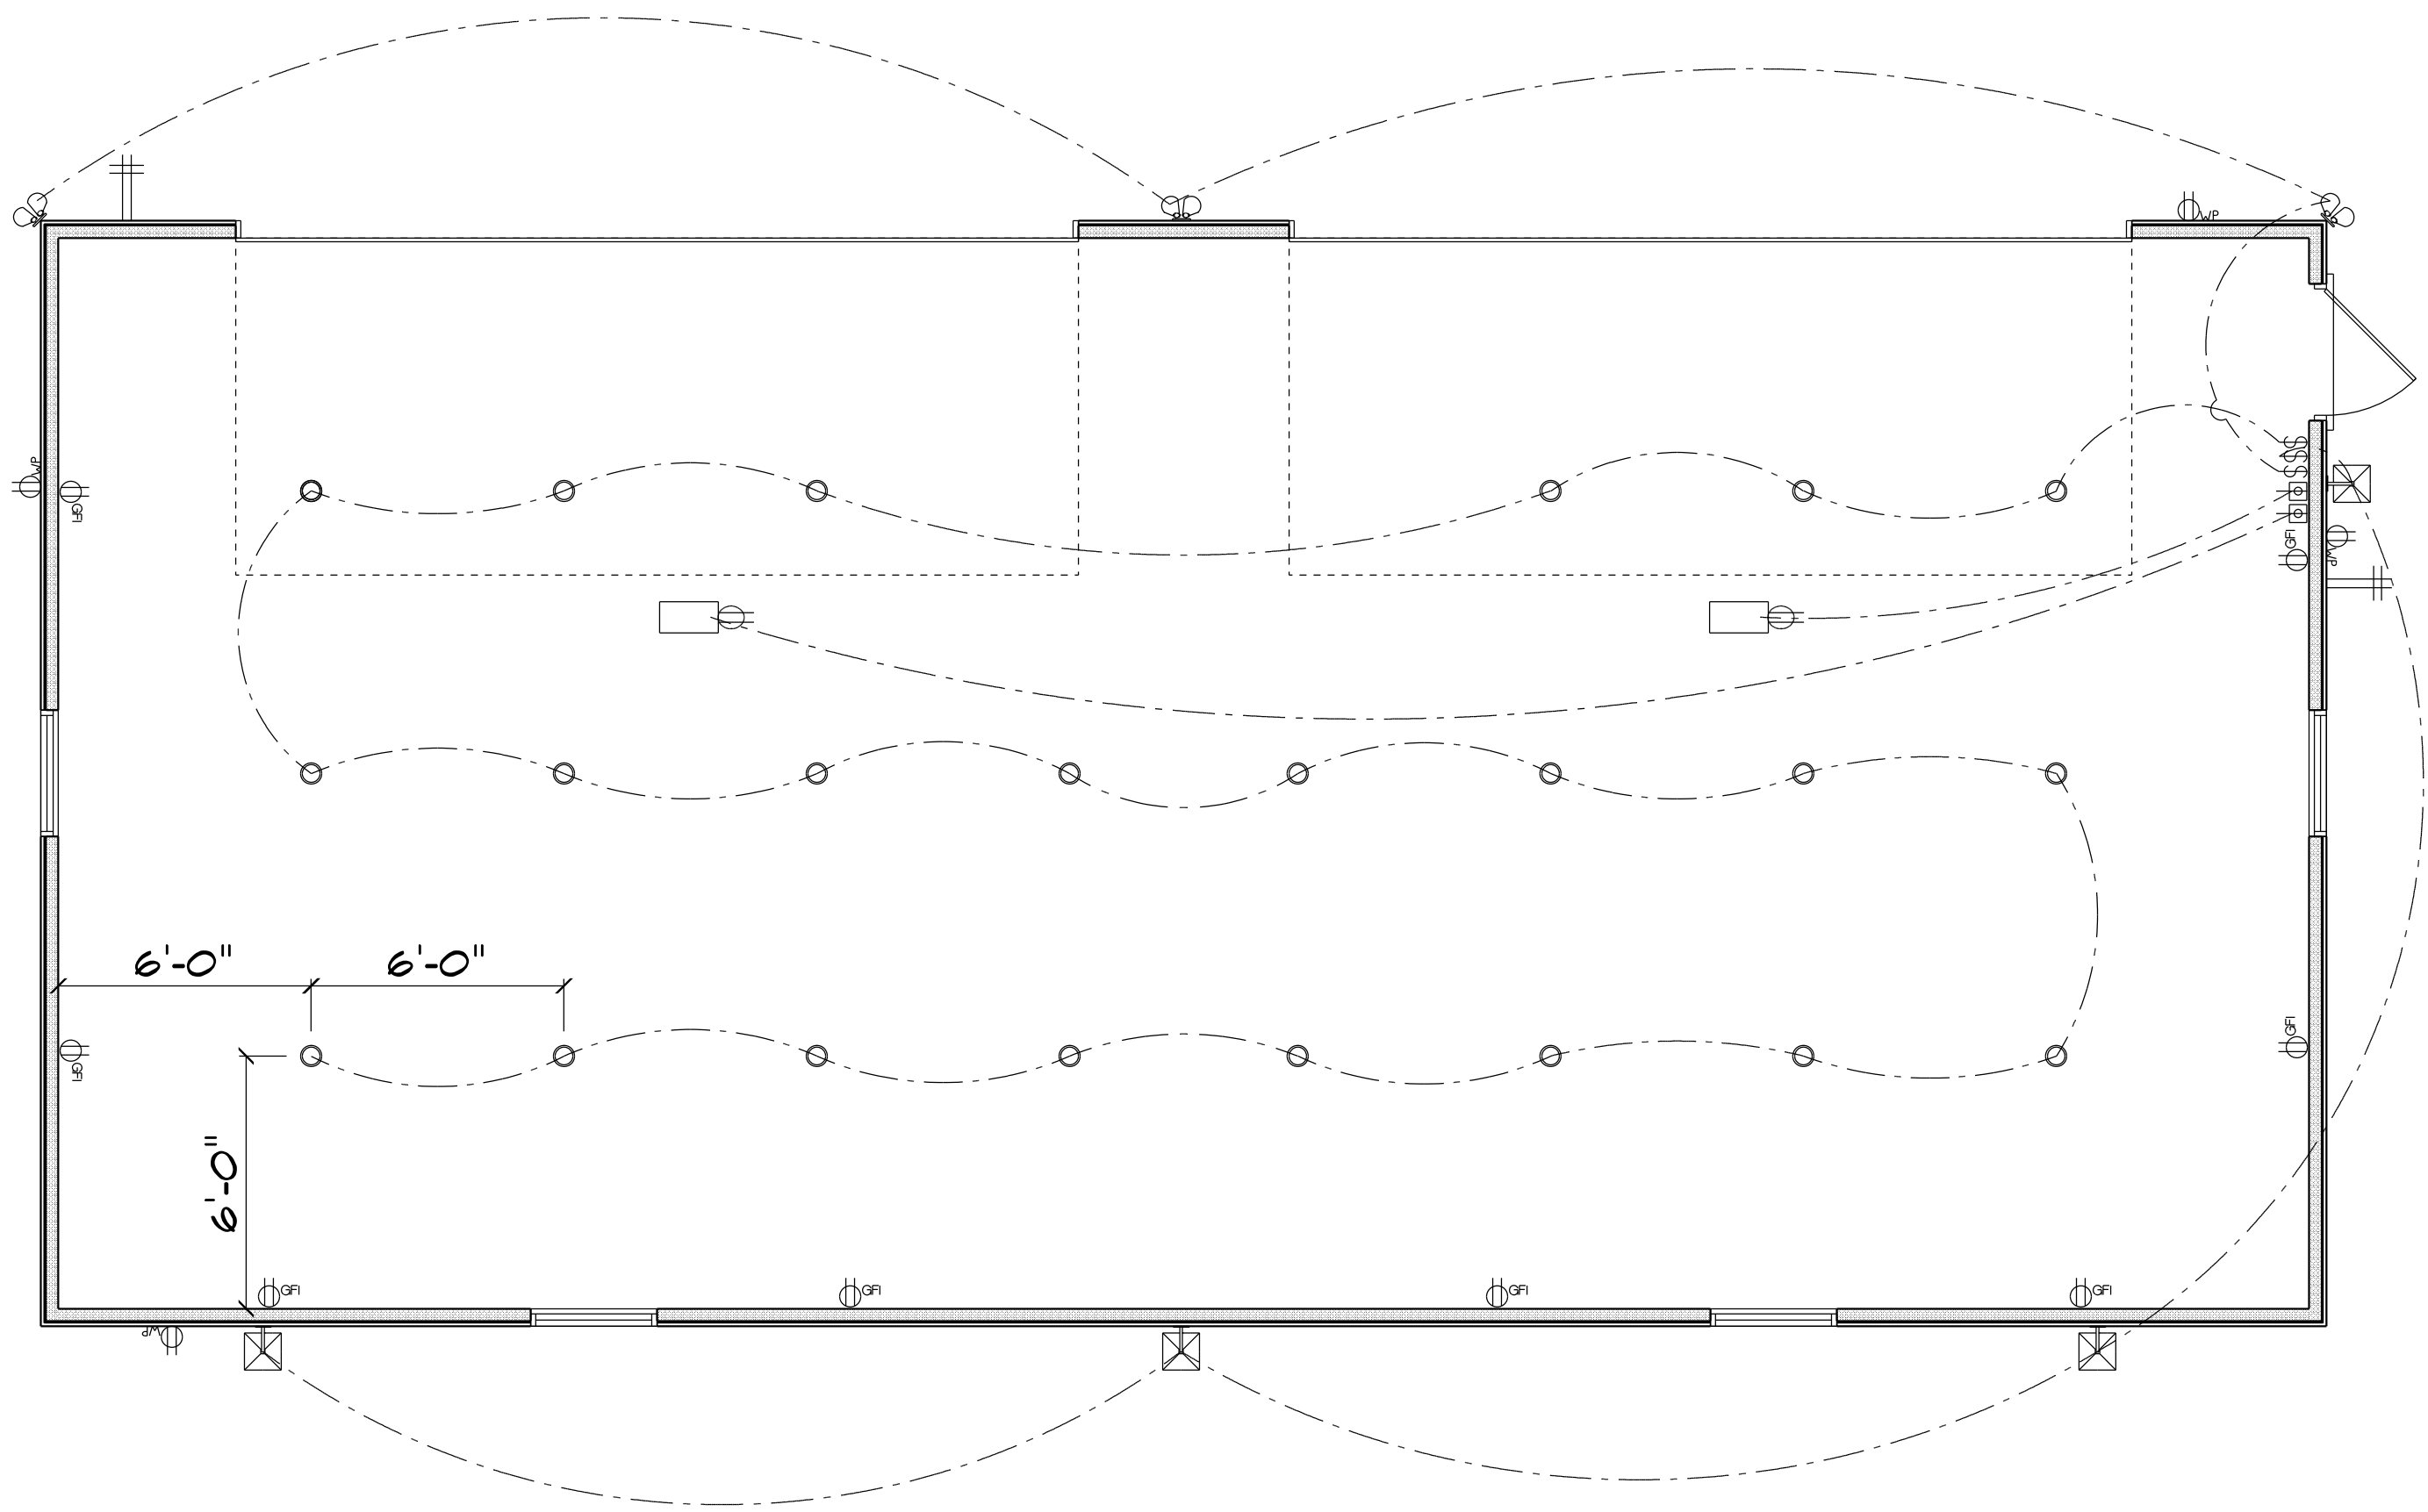

ELECTRICAL LEGEND		
ELECTRICAL	COUNT	SYMBOL
pot light	23	○
exterior deco light	4	⊠
flood light	3	⊕
automatic garage dr opener	2	⊕
garage dr opener	2	⊕
outlet gfi	8	⊕GFI
outlet wp	4	⊕WP
switch	3	\$

ELECTRICAL PLAN NOTES

- E-1 WIRE ALL APPLIANCES, HVAC UNITS AND OTHER EQUIPMENT PER MANUFACTURERS SPECIFICATIONS.
- E-2 CONSULT THE OWNER FOR THE NUMBER OF SEPERATE TELEPHONE LINES TO BE INSTALLED.
- E-3 ALL INSTALLATIONS SHALL BE PER NATIONAL ELECTRIC CODE.
- E-4 ALL SMOKE DETECTORS SHALL BE 120V W/BATTERY BACKUP OF THE PHOTOELECTRIC TYPE, AND SHALL BE INTERLOCKED TOGETHER. INSTALL INSIDE AND NEAR ALL BEDROOMS.
- E-5 TELEPHONE, TELEVISION AND OTHER LOW VOLTAGE DEVICES OR OUTLETS SHALL BE AS PER THE OWNERS DIRECTION AND IN ACCORDANCE WITH APPLICABLE SECTIONS OF NATIONAL ELCT. CODE LATEST EDITION.
- E-6 ELECTRICAL CONTRACTOR SHALL BE RESPONSIBLE FOR THE DESIGN AND SIZING OF ELECTRICAL SERVICE AND CIRCUITS.
- E-7 ENTRY OF SERVICE UNDERGROUND OR OVERHEAD) IS TO BE DETERMINED BY THE POWER COMPANY.
- E-8 ALL BEDROOM RECEPTICALS ARE TO BE AFCI (ARC FAULT CIRCUIT INTERRUPT).

GARAGE
for
EDDIE & LINDA
HAZEN

Teresa M. Ruffo
2925 SW SR 41
Lake City Florida, 32025
Cell: (386) 861 - 1191
Email: tesnaruffo@gmail.com

PRINTED DATE:
Tuesday, April 2, 2024

DRAWN BY: Teresa M. Ruffo CHECKED BY:

BUILDING CONTRACTOR:
LITTLE AND WILLIAMS INC

FINAL\$ DATE:

JOB NUMBER:

DRAWING NUMBER
A-5

OF 5 SHEETS