


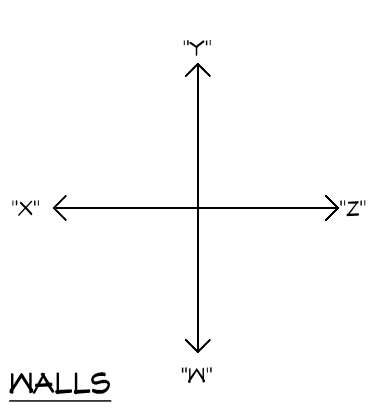

07/15/20 DSM
10/18/21 BSC - A1



ARHOMES



THE LANCASTER 1752F - L - VAN VOORHIS RESIDENCE


BUILDER: BRYAN ZECHER HOMES, INC.
LAKE CITY, FLORIDA
AN INDEPENDENTLY OWNED AND OPERATED FRANCHISE

FLOOR PLAN


5

REFLECTED CEILING PLAN
1/4" = 1'-0"

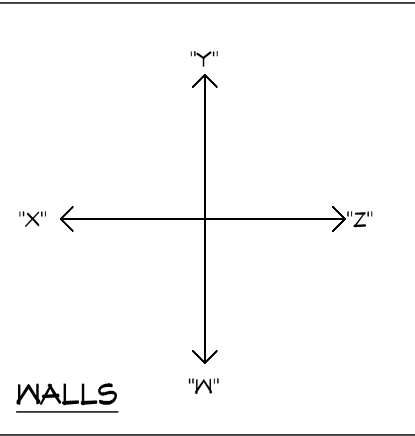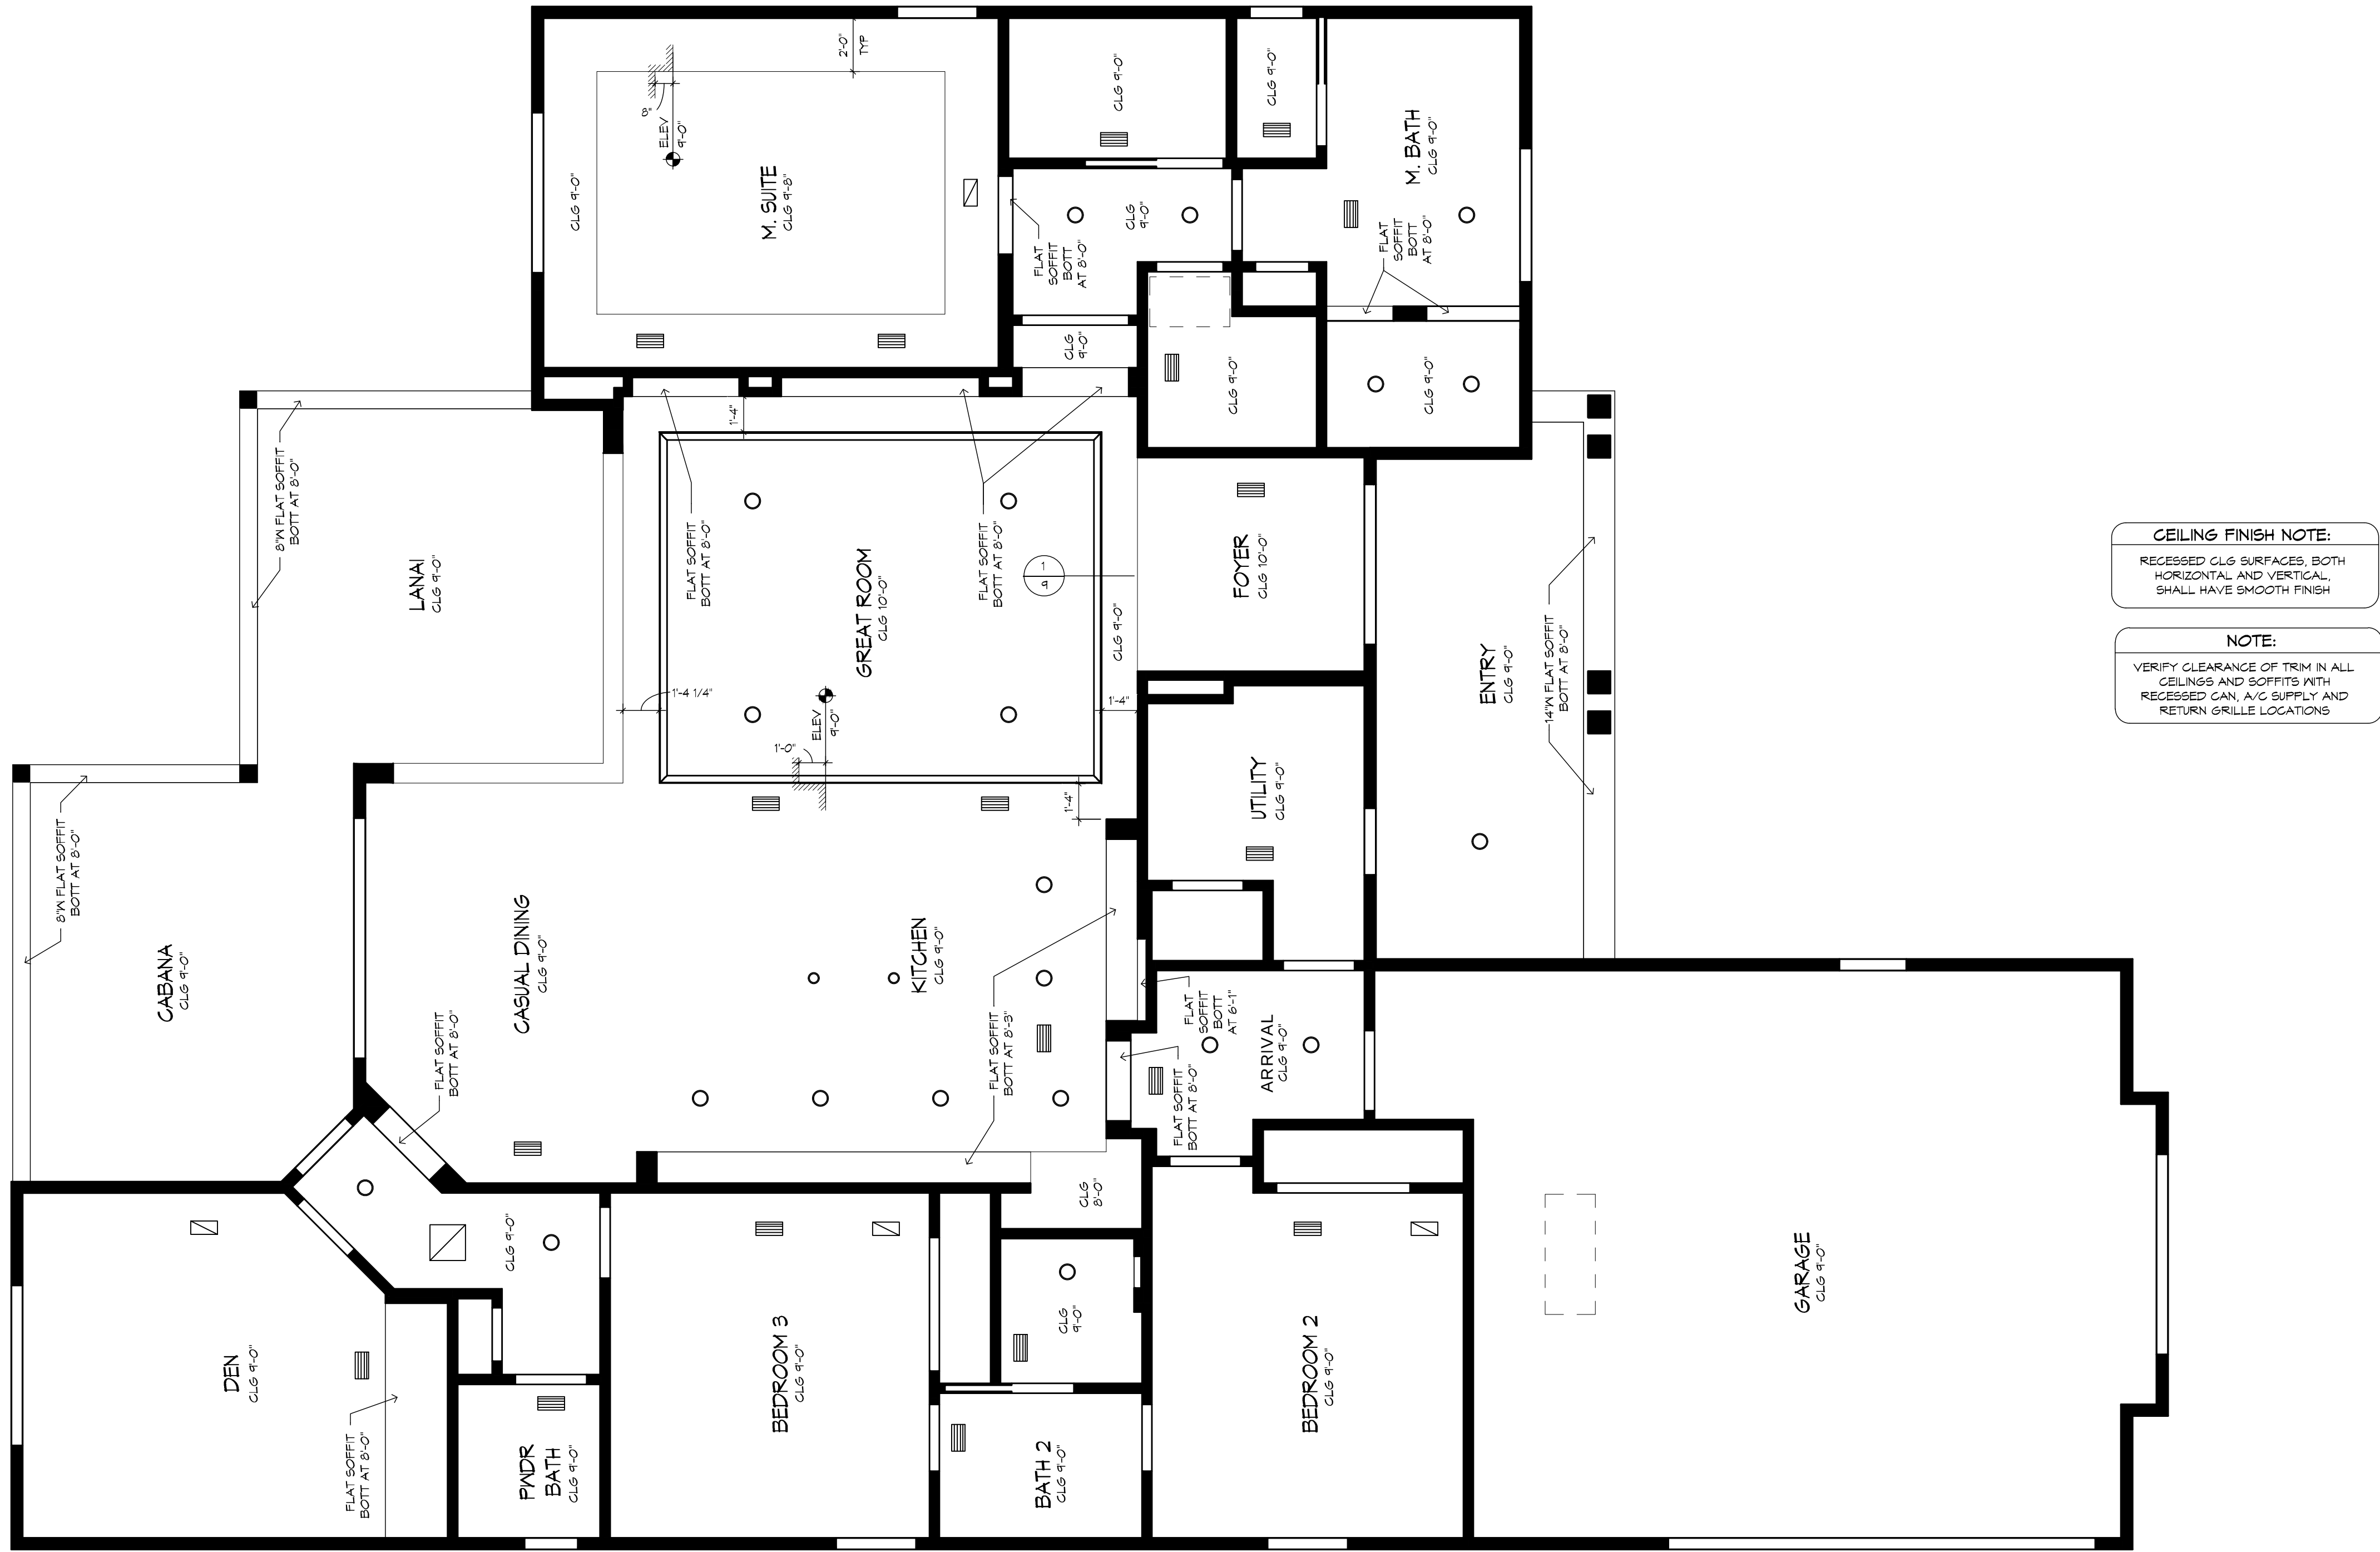


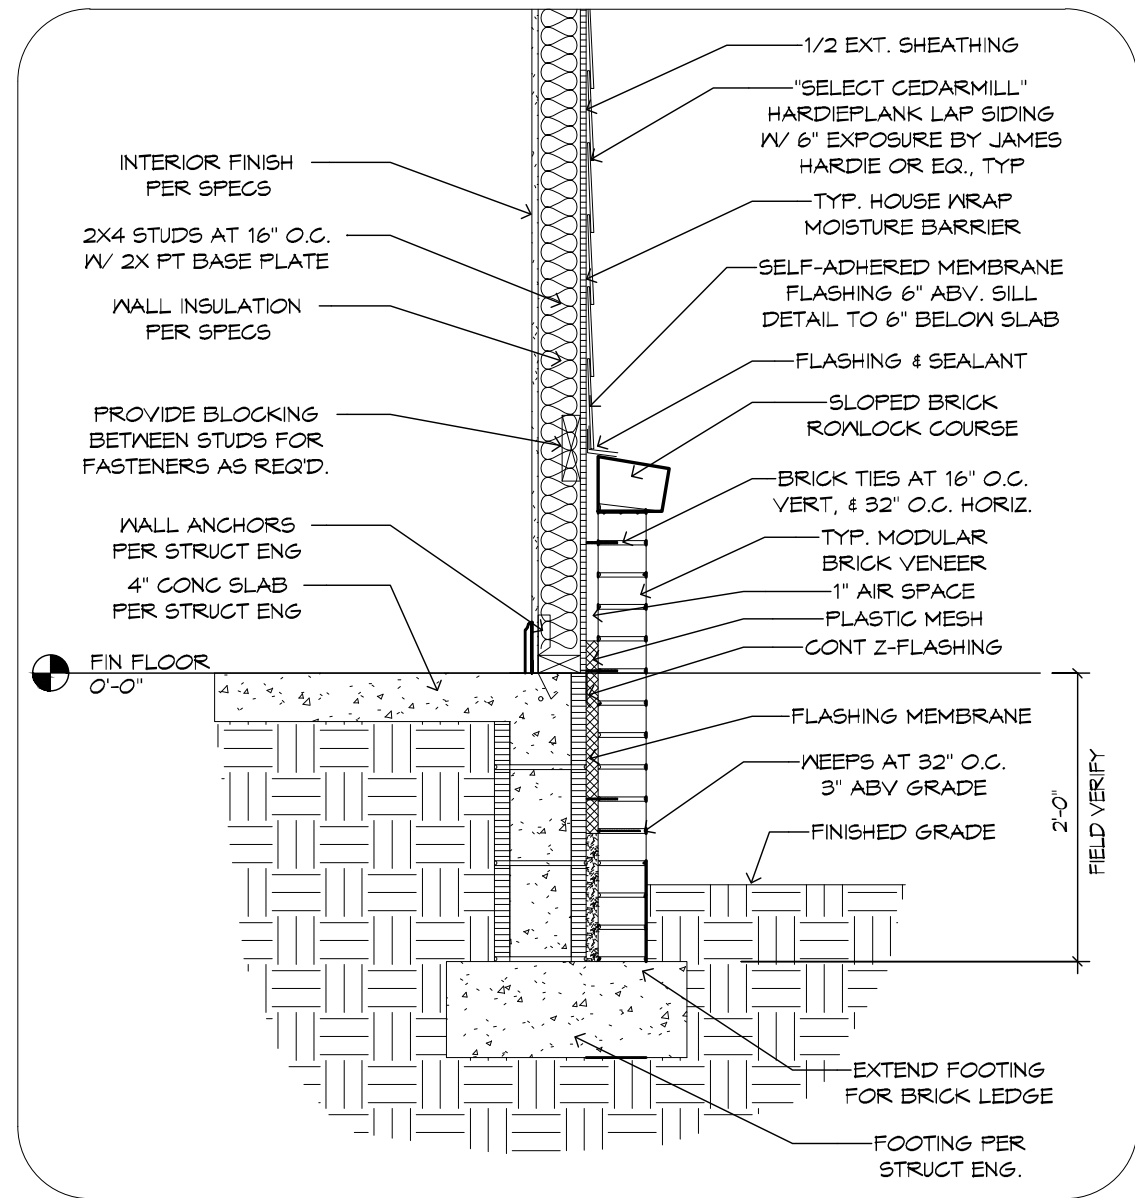


3 BRICK WAINSCOT DETAIL AT SLAB
3/4" = 1'-0"

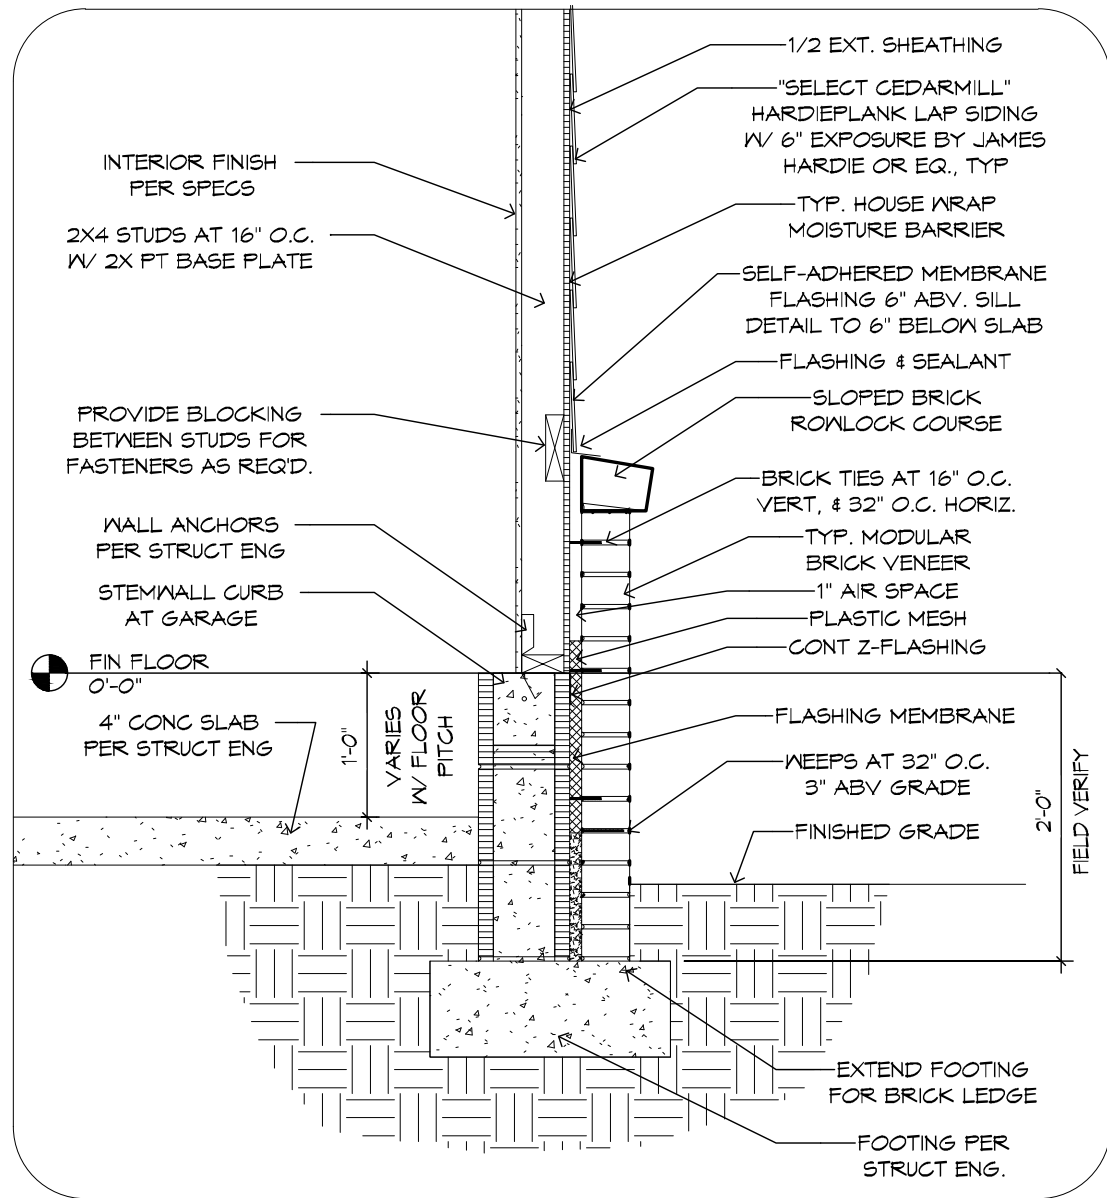


4 BRICK WAINSCOT DETAIL AT GARAGE
3/4" = 1'-0"

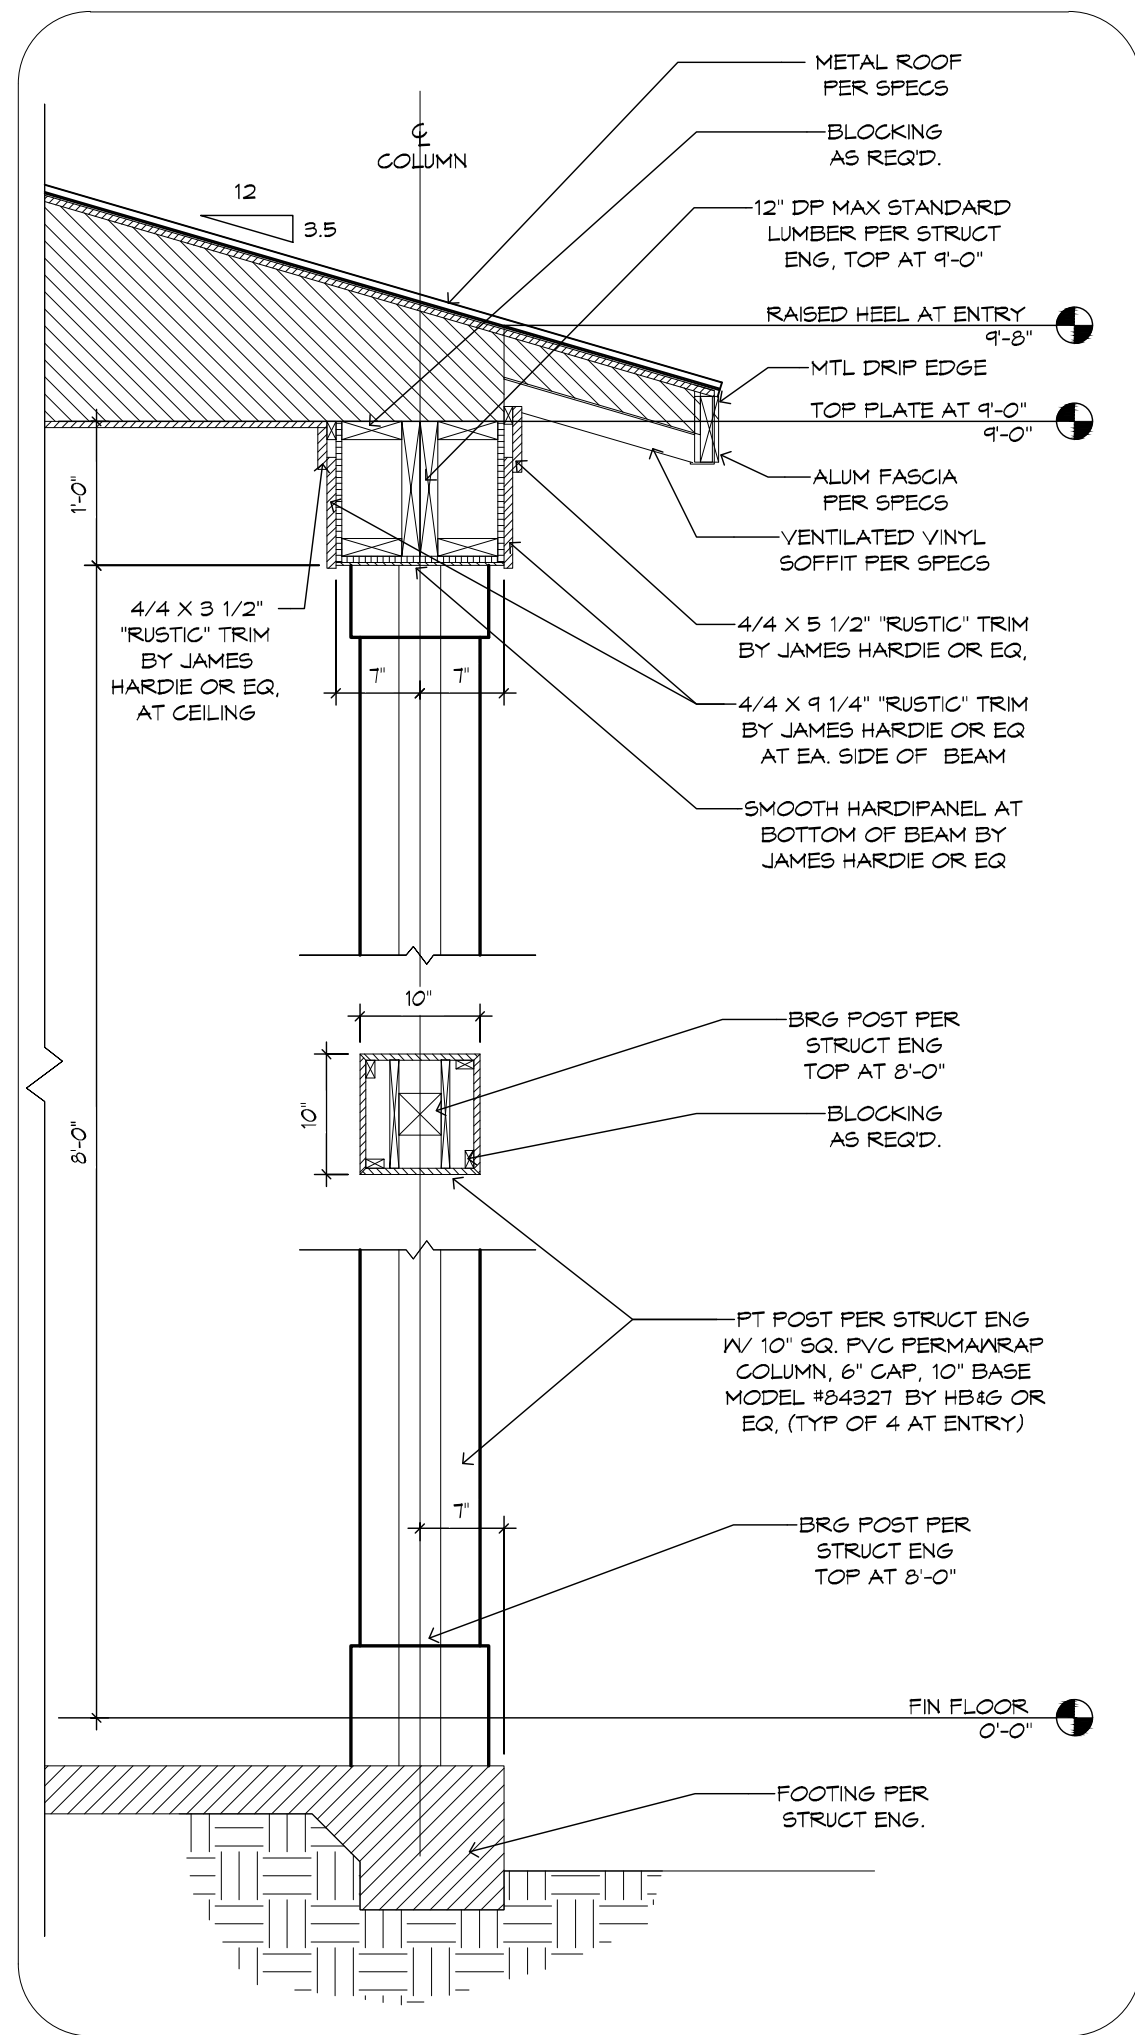


1 COLUMN DETAIL AT ENTRY
3/4" = 1'-0"

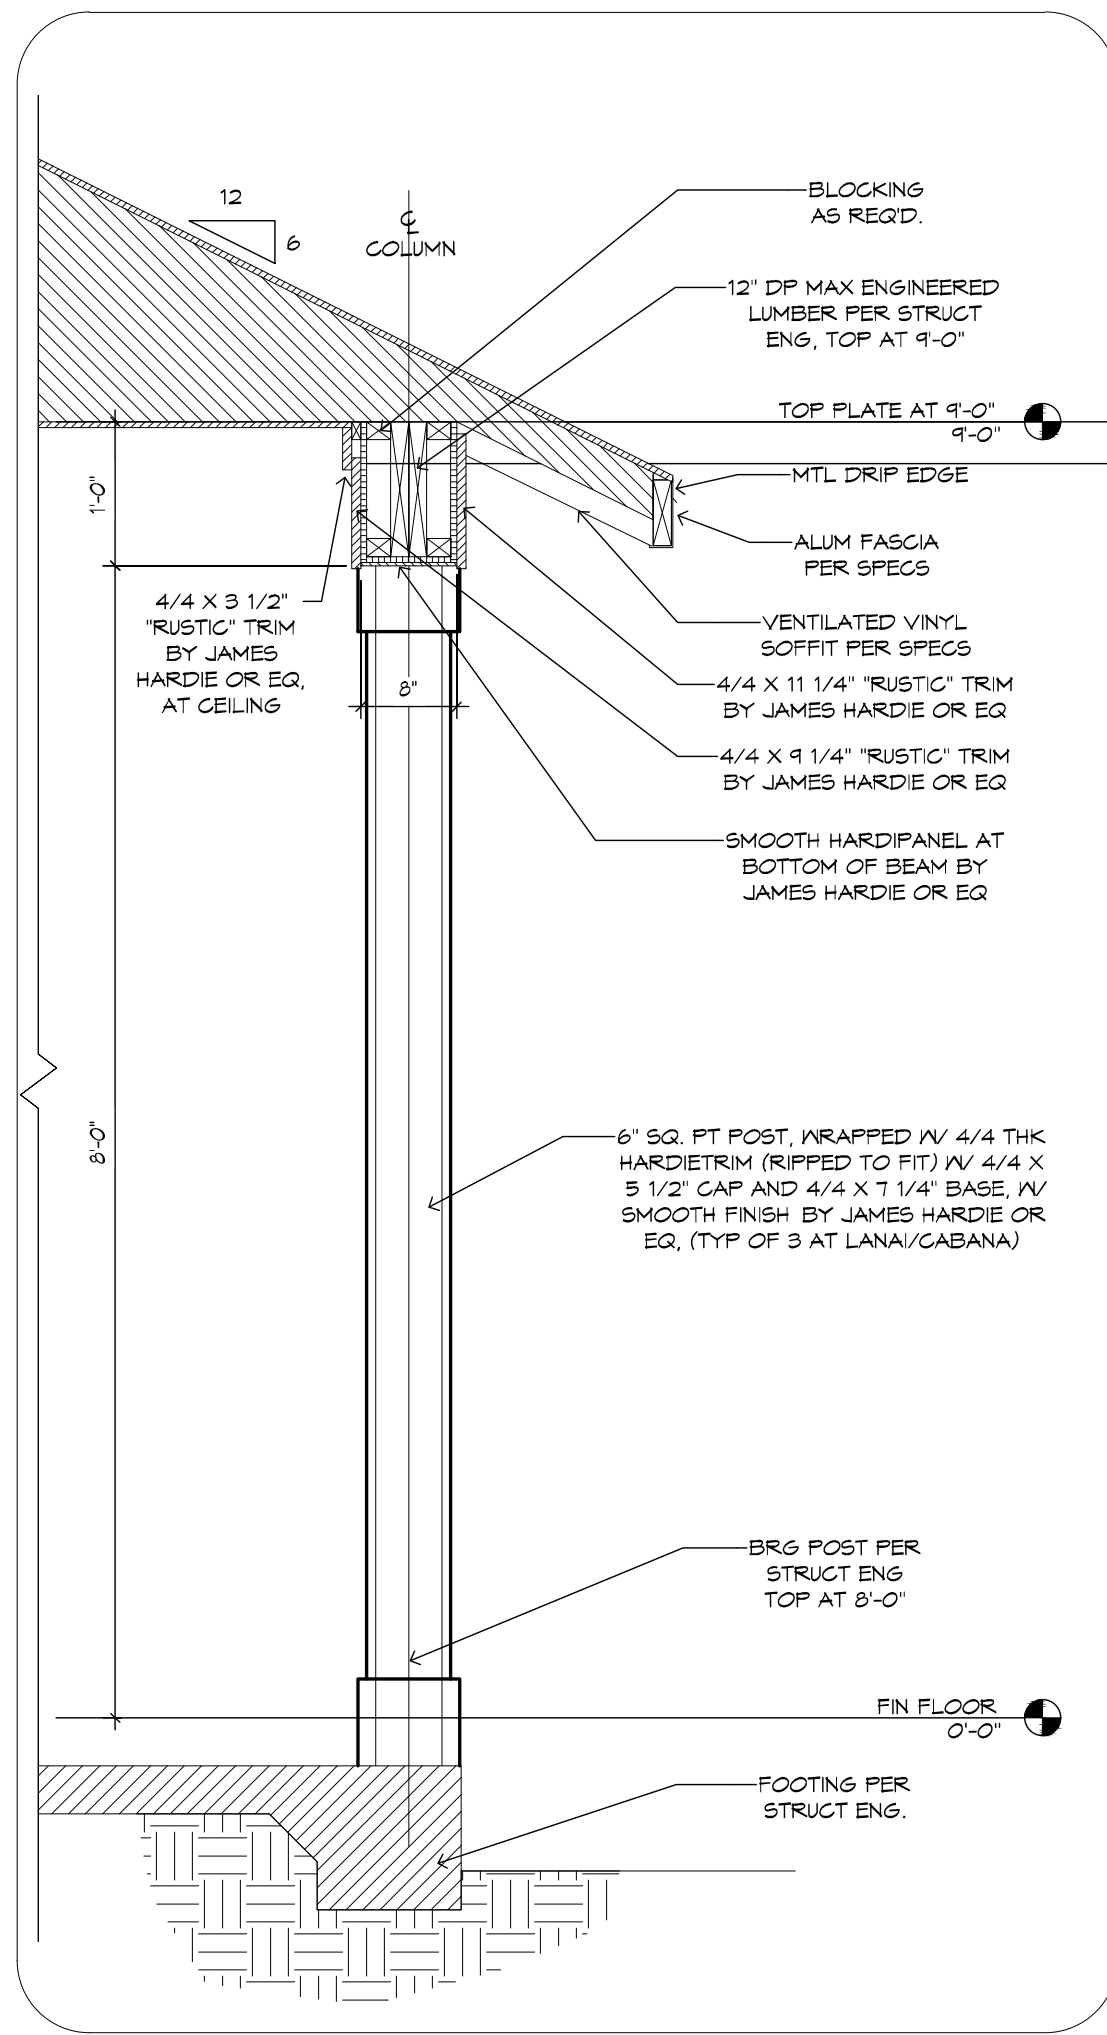

2 COLUMN DETAIL AT LANAI
3/4" = 1'-0"

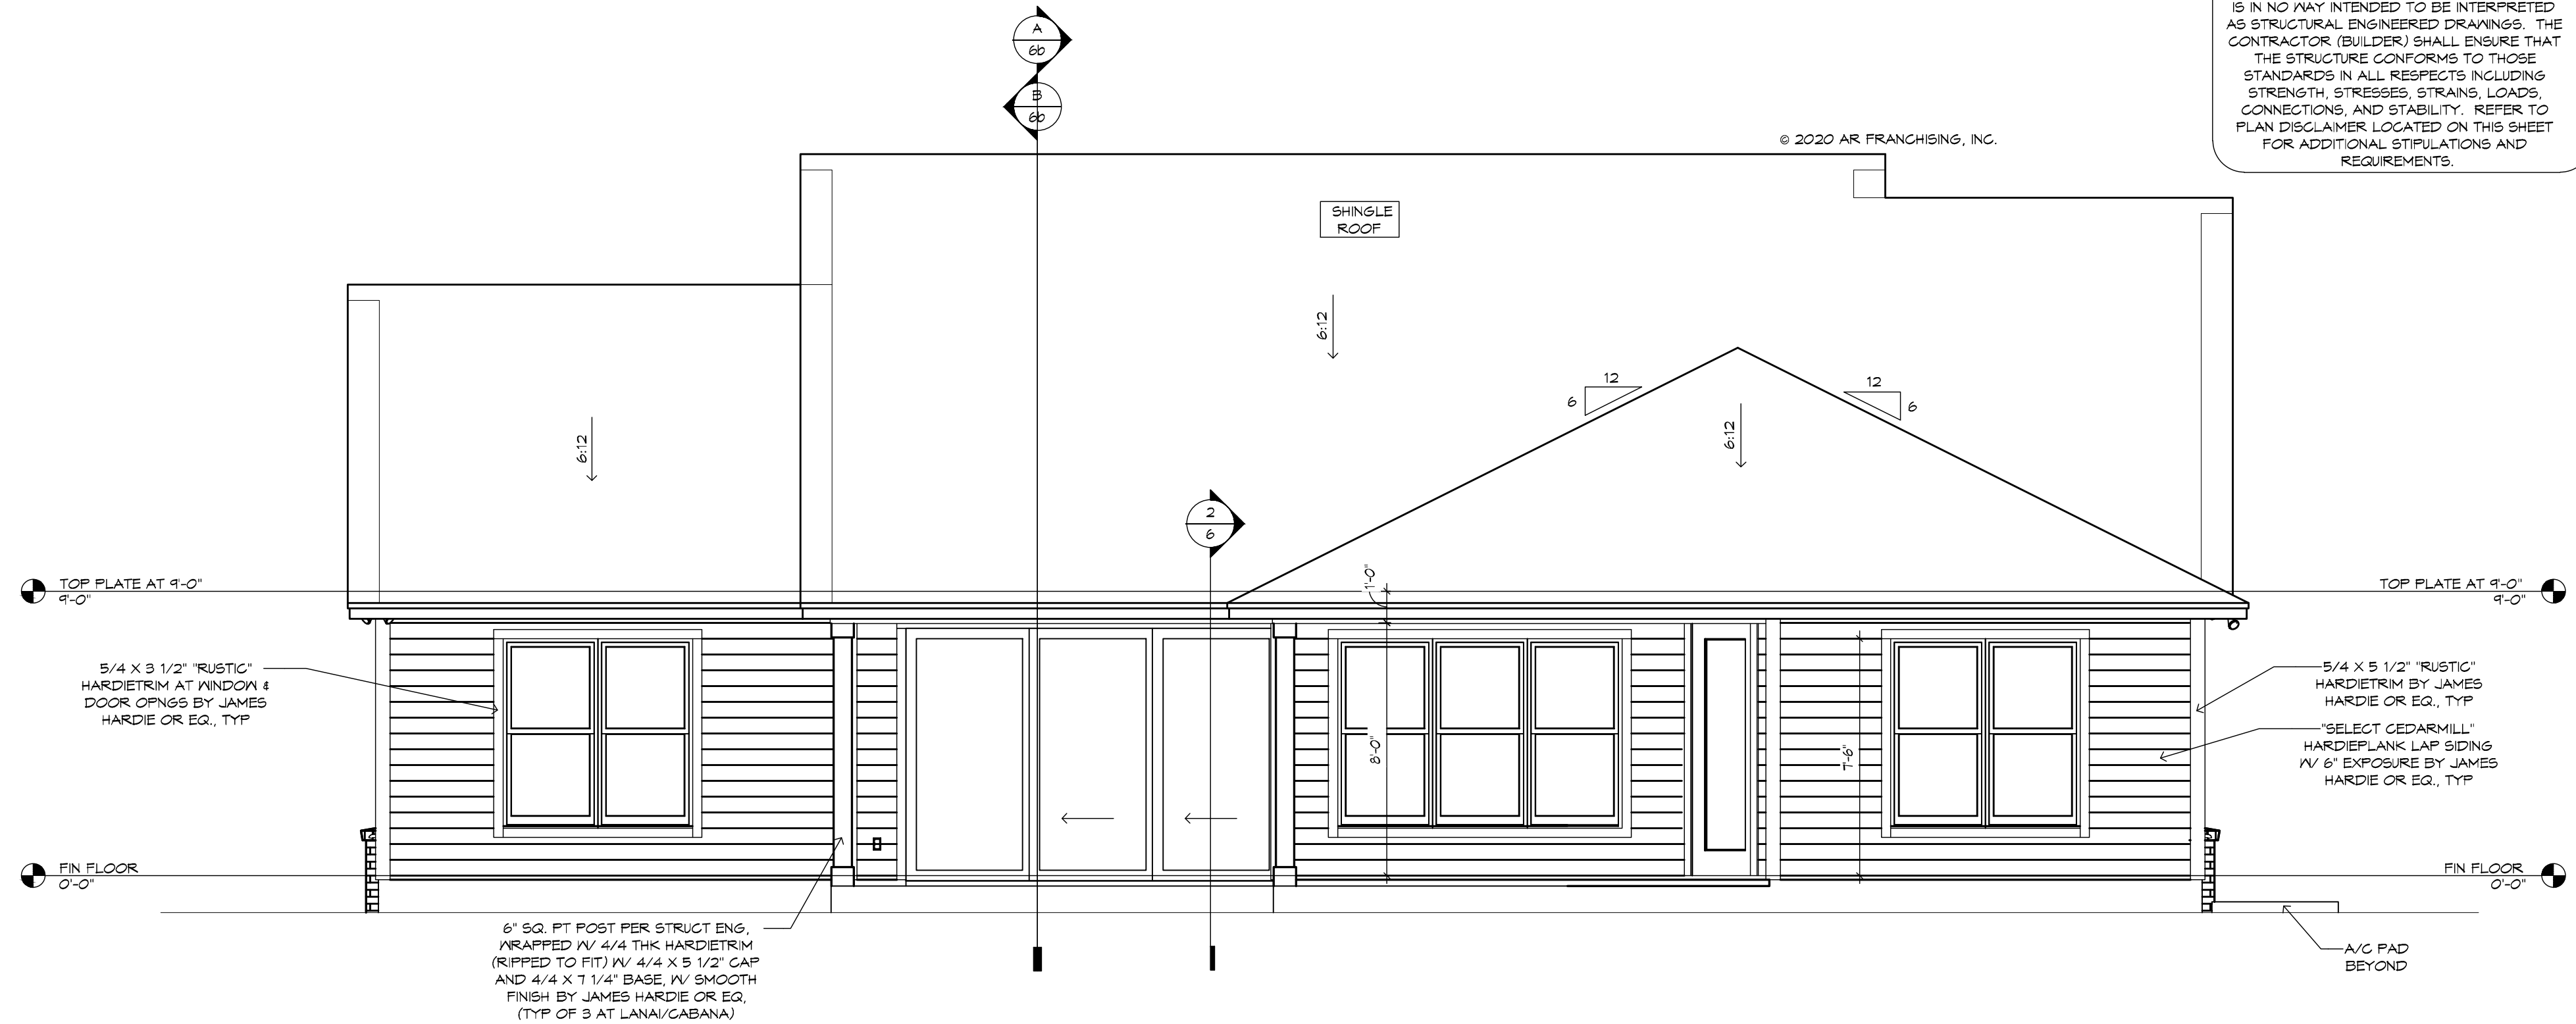

REAR ELEVATION
1/4" = 1'-0"

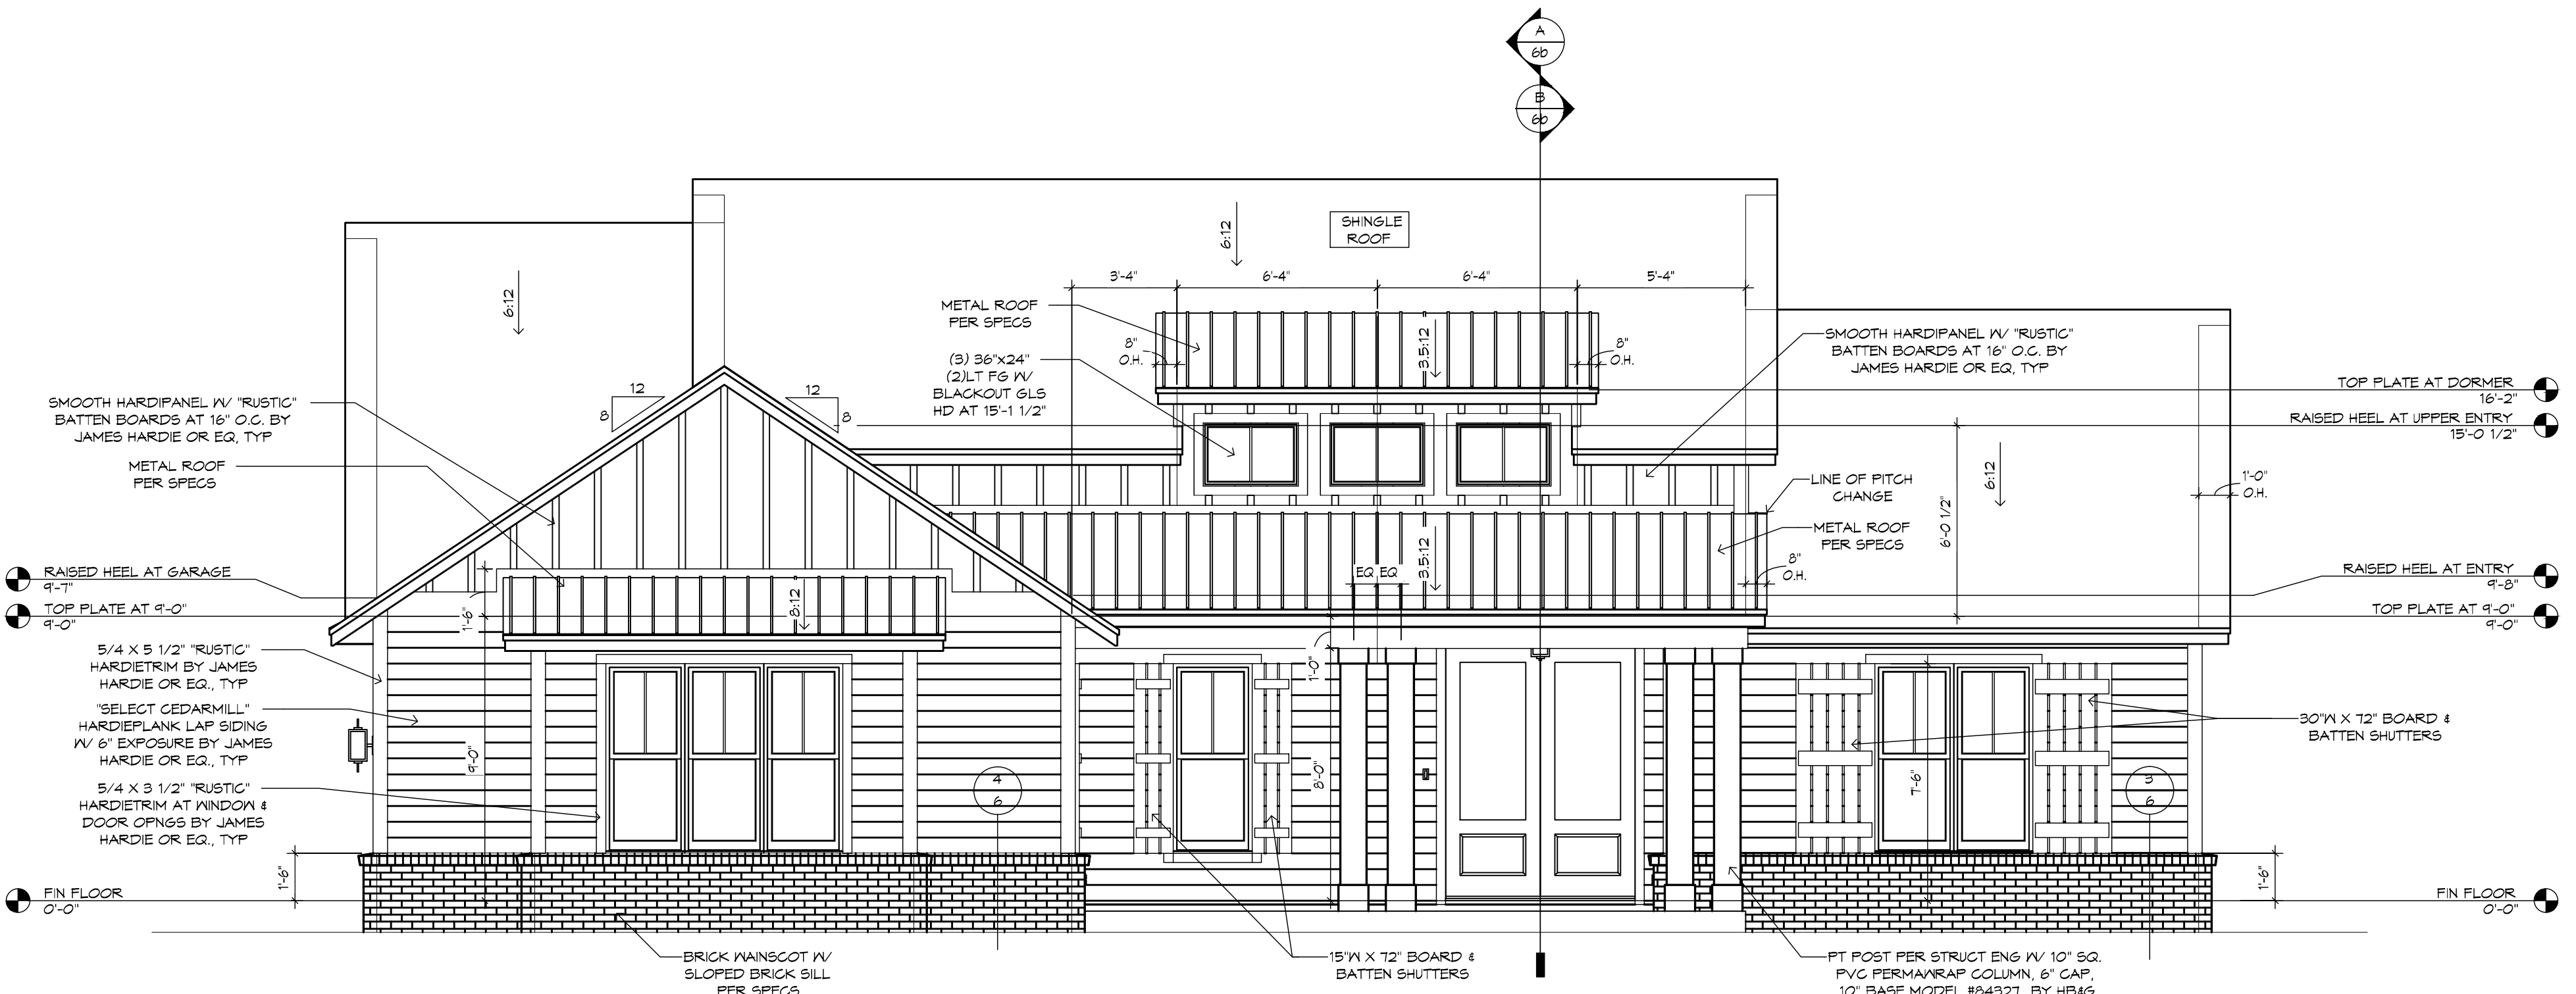

FRONT ELEVATION
1/4" = 1'-0"

!! ATTENTION !!
NOTE: IT IS THE RESPONSIBILITY OF THE BUILDER TO COORDINATE THE INSTALLATION OF ALL WATER PROOFING METHODS NECESSARY TO PROVIDE A WATER TIGHT BUILDING ENVELOPE. REFER TO MFR INSTALLATION RECOMMENDATION FOR ALL SELECTED WATERPROOFING MATERIALS, FLASHING, SEALERS AND AD-MIX COMPONENTS.

FRAMING PLAN DISCLAIMER
THE FRAMING PLANS REPRESENTED IN THESE DRAWINGS ARE INTENDED TO ESTABLISH PROPOSED FRAMING MEMBER LOCATIONS, FRAMING MEMBER DEPTH, POTENTIAL BEARING LOCATIONS AND ELEVATIONS, AND IS IN NO WAY INTENDED TO BE INTERPRETED AS STRUCTURAL ENGINEERED DRAWINGS. THE CONTRACTOR (BUILDER) SHALL ENSURE THAT THE STRUCTURE CONFORMS TO THOSE STANDARDS IN ALL RESPECTS INCLUDING STRENGTH, STRESSES, STRAINS, LOADS, CONNECTIONS, AND STABILITY. REFER TO PLAN DISCLAIMER LOCATED ON THIS SHEET FOR ADDITIONAL STIPULATIONS AND REQUIREMENTS.

GENERAL NOTES:
• FLAT SOFFIT AT PERIMETER OF HOUSE UNLESS NOTED OTHERWISE.
• VERIFY ALL WINDOW AND DOOR ROUGH OPENINGS W/ MFR SPECS.
• LOCATE ALL PLUMBING STACKS BEYOND THE FRONT ELEV. ROOF RIDGES, IF ALLOWABLE PER CODE.
• ROOF VENTS SHOWN FOR LOCATION PURPOSES ONLY.
• NUMBER OF ROOF VENTS TO BE DETERMINED BY BUILDER.
• WHERE EPS CORNICE OCCURS, PROVIDE 1/2" PNT GRADE PLYWOOD SOFFIT, ING.

NOTE: IT IS THE RESPONSIBILITY OF THE BUILDER TO COORDINATE THE INSTALLATION OF ALL WATER PROOFING METHODS NECESSARY TO PROVIDE A WATER TIGHT BUILDING ENVELOPE. REFER TO MFR INSTALLATION RECOMMENDATION FOR ALL SELECTED WATERPROOFING MATERIALS, FLASHING, SEALERS AND AD-MIX COMPONENTS

DRAWINGS ARE INTENDED TO ESTABLISH PROPOSED FRAMING MEMBER LOCATIONS, FRAMING MEMBER DEPTH, POTENTIAL BEARING LOCATIONS AND ELEVATIONS, AND IS IN NO WAY INTENDED TO BE INTERPRETED AS STRUCTURAL ENGINEERED DRAWINGS. THE CONTRACTOR (BUILDER) SHALL ENSURE THAT THE STRUCTURE CONFORMS TO THOSE STANDARDS IN ALL RESPECTS INCLUDING STRENGTH, STRESSES, STRAINS, LOADS, CONNECTIONS, AND STABILITY. REFER TO PLAN DISCLAIMER LOCATED ON THIS SHEET FOR ADDITIONAL STIPULATIONS AND REQUIREMENTS.



07/15/20 DSM
0/18/21 BSC - A1

THE LANCASTER 1752F - L - VAN VOOHIS RESIDENCE

SIDE ELEVATIONS

6a

NOTE: IT IS THE RESPONSIBILITY OF THE BUILDER TO COORDINATE THE INSTALLATION OF ALL WATER PROOFING METHODS NECESSARY TO PROVIDE A WATER TIGHT BUILDING ENVELOPE. REFER TO MFR INSTALLATION RECOMMENDATION FOR ALL SELECTED WATERPROOFING MATERIALS, FLASHING, SEALERS AND AD-MIX COMPONENTS

DRAWINGS ARE INTENDED TO ESTABLISH PROPOSED FRAMING MEMBER LOCATIONS, FRAMING MEMBER DEPTH, POTENTIAL BEARING LOCATIONS AND ELEVATIONS, AND IS IN NO WAY INTENDED TO BE INTERPRETED AS STRUCTURAL ENGINEERED DRAWINGS. THE CONTRACTOR (BUILDER) SHALL ENSURE THAT THE STRUCTURE CONFORMS TO THOSE STANDARDS IN ALL RESPECTS INCLUDING STRENGTH, STRESSES, STRAINS, LOADS, CONNECTIONS, AND STABILITY. REFER TO PLAN DISCLAIMER LOCATED ON THIS SHEET FOR ADDITIONAL STIPULATIONS AND REQUIREMENTS.

BUILDING SECTION "A"
1/4" = 1'-0"

PLAN DISCLAIMERS


AS FRANCHISING, INC., THE FRANCHISOR, IS RESPONSIBLE FOR THE PREPARED ARCHITECTURAL DRAWINGS ONLY AS REPRESENTED IN THESE DRAWINGS (PLANS), BUT NOT FOR ANY STRUCTURAL INFORMATION OR CONTENT, THE BUILDERS ARE RESPONSIBLE FOR ANY AND ALL STRUCTURAL INFORMATION, INCLUDING BUT NOT LIMITED TO, THE FOUNDATION, ROOFING, MECHANICAL, ELECTRICAL, PLUMBING, AND LOCAL BUILDING CODES, ORDINANCES AND LAWS. CRITERIA, BUT NOT LIMITED TO, THE FOLLOWING: EASEMENTS, THE SWIFT™ TYPICAL COASTS, FLOOD ZONE CRITERIA, HURRICANE CODES, PRE-ENGINEERED ROOFING, AND THE SWIFT™ TYPICAL COASTS. THE BUILDERS ARE RESPONSIBLE FOR ANY AND ALL REVISIONS MADE TO THESE DRAWINGS BY THEIR OWNERS, ARCHITECTS, OR ENGINEERS. THE BUILDERS ARE RESPONSIBLE FOR ANY AND ALL REVISIONS MADE TO THESE DRAWINGS, AND SUBCONTRACTORS ACKNOWLEDGE AND AGREE TO THESE DISCLAIMERS.

BUILDING SECTIONS

PLAN 1752F-25-01-D*
JOB # 88-2115-A1

6b

BUILDING SECTION "B"
1/4" = 1'-0"

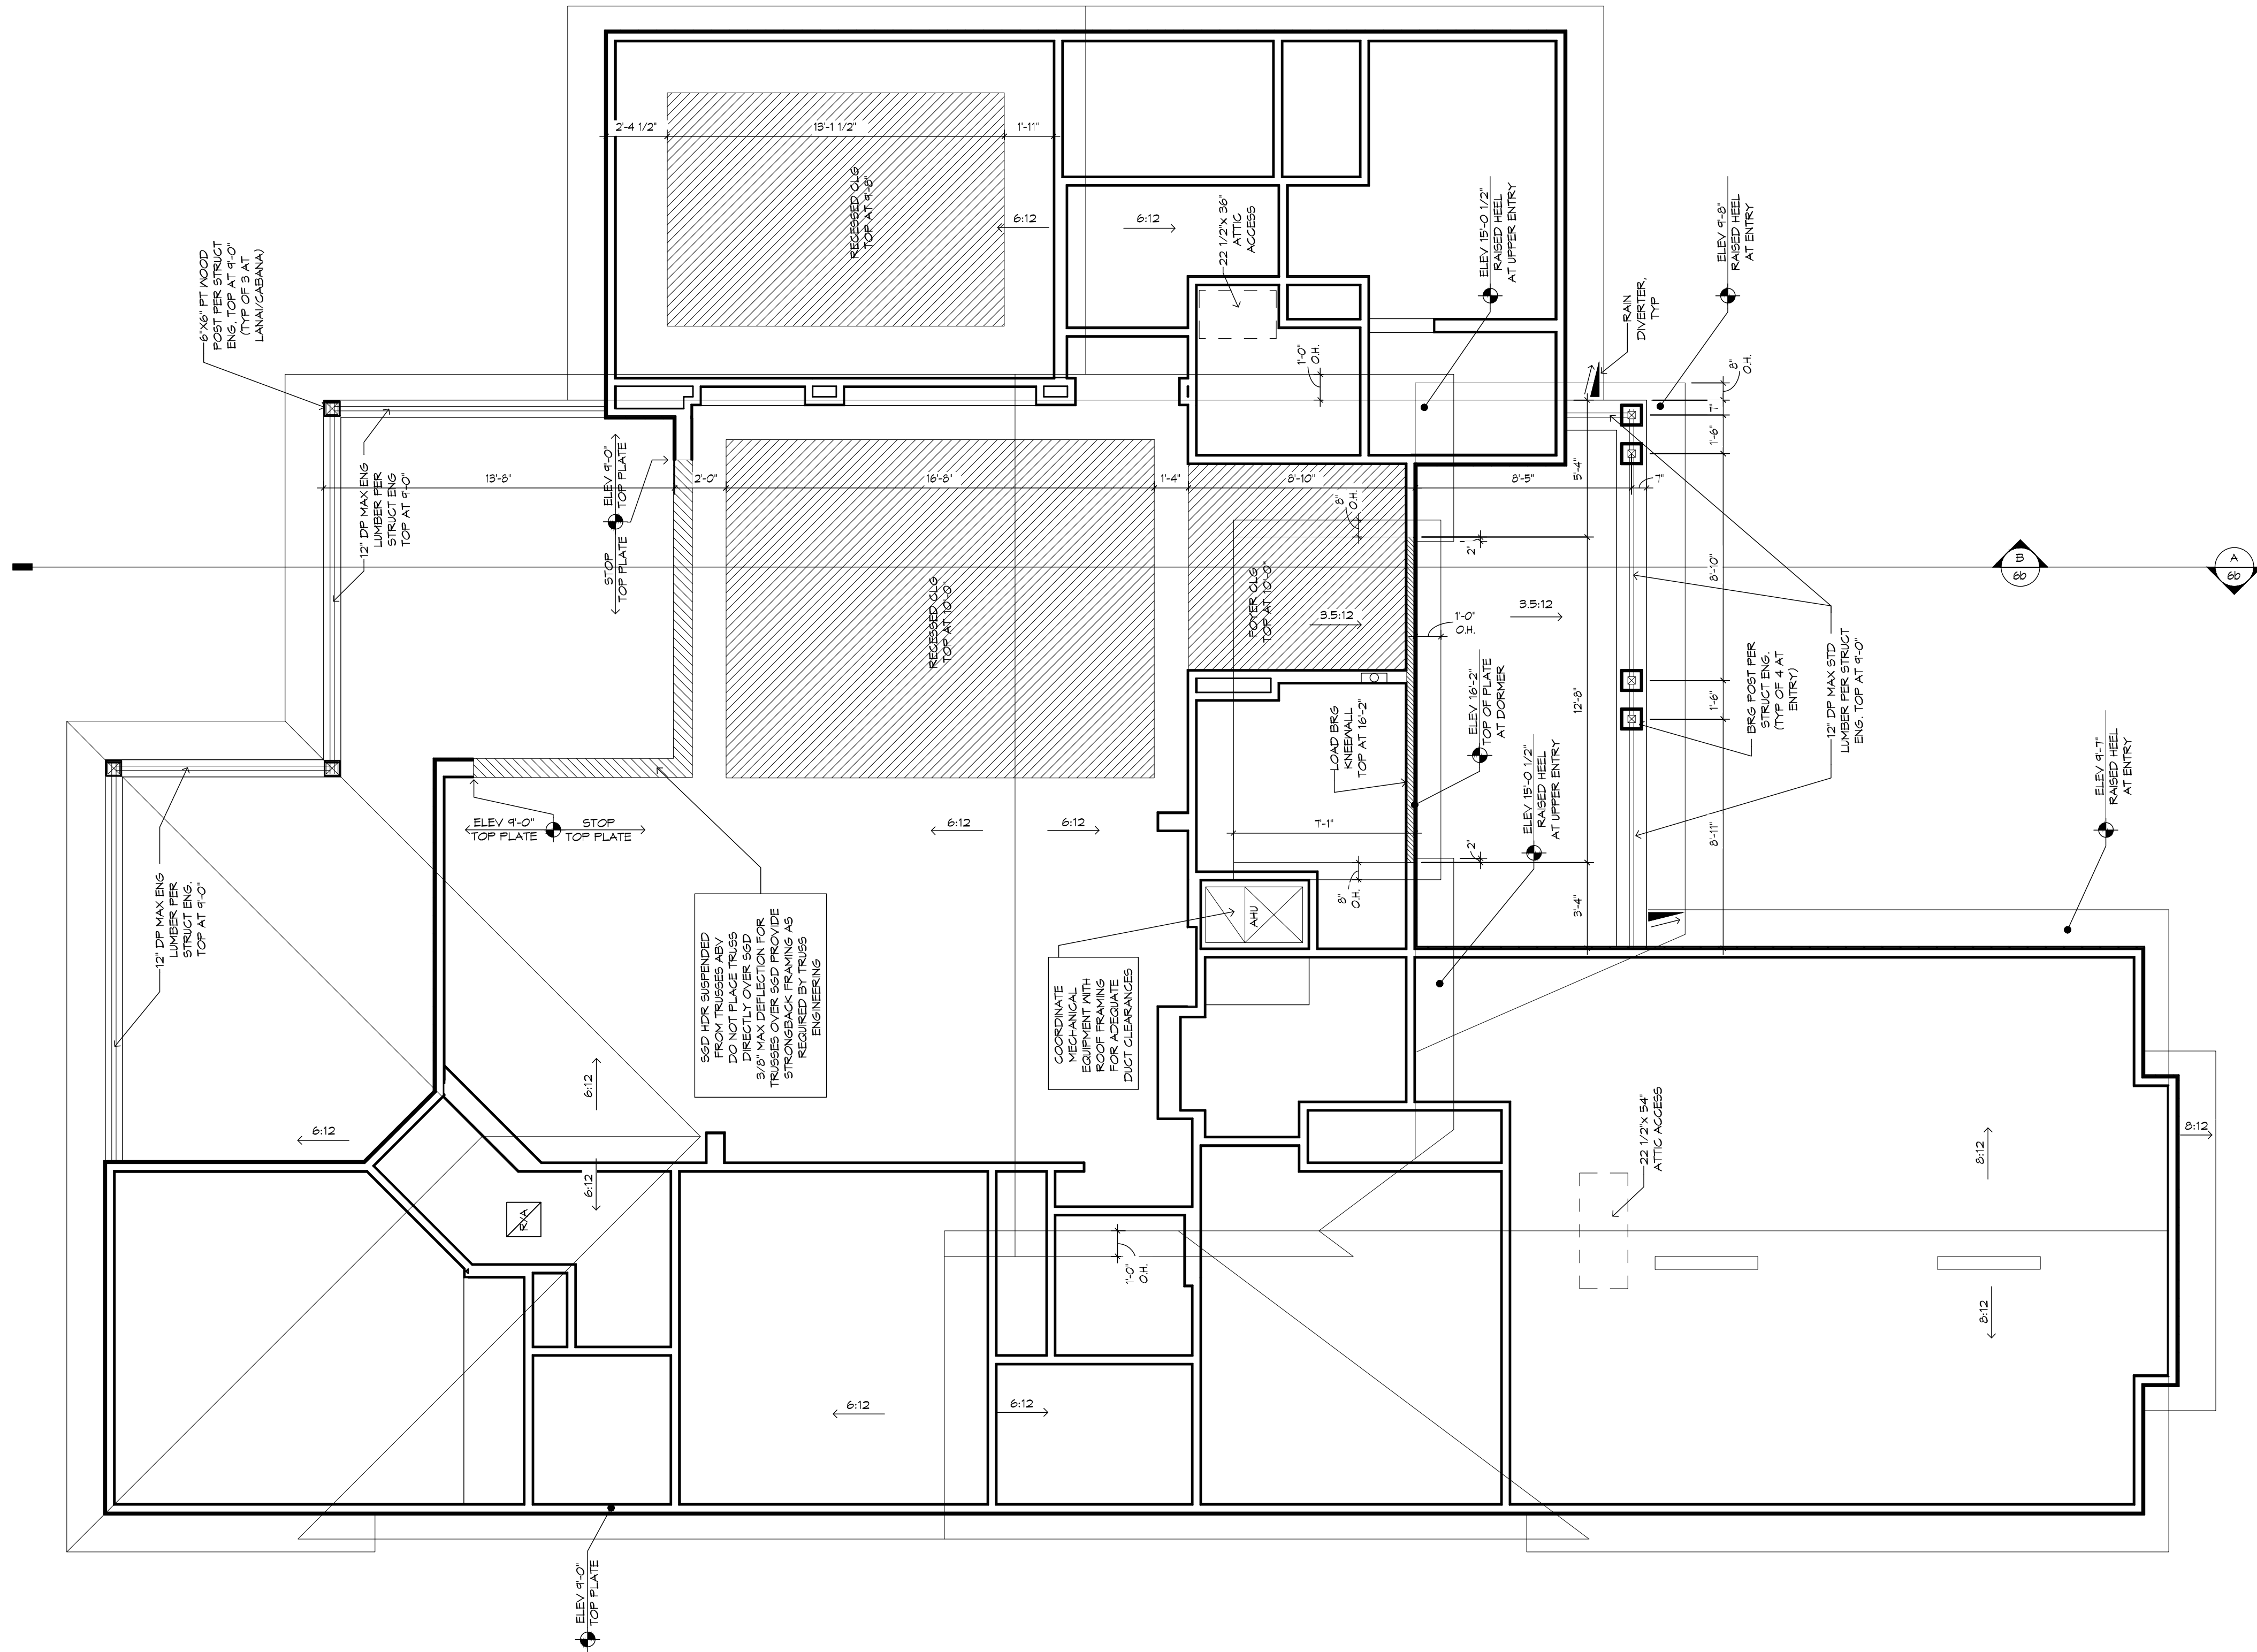

ROOF PLAN
1/4" = 1'-0"

MECHANICAL DISCLAIMER


ANY DUCT ROUTING AND HVAC EQUIPMENT SHOWN ON THESE DRAWINGS ARE DIAGRAMMATIC ONLY. THE BUILDER IS SOLELY RESPONSIBLE FOR COORDINATING ALL ASPECTS OF MECHANICAL INSTALLATION WITH ALL TRADES. THE BUILDER SHALL COORDINATE BETWEEN THE PRE-ENGINEERED TRUSS MFR AND/OR FRAMING REQUIREMENTS, WITH THE MECHANICAL CONTRACTOR TO INSURE ADEQUATE SPACE FOR DUCT ROUTING AND EQUIPMENT PLACEMENT AND SUPPORT. HVAC INSTALLATION SHALL BE INSTALLED ACCORDING TO ALL CURRENT STATE AND LOCAL MECHANICAL CODES.

!! ATTENTION !!

NOTE: IT IS THE RESPONSIBILITY OF THE BUILDER TO COORDINATE THE INSTALLATION OF ALL WATER PROOFING METHODS NECESSARY TO PROVIDE A WATER TIGHT BUILDING ENVELOPE. REFER TO MFR INSTALLATION RECOMMENDATION FOR ALL SELECTED WATERPROOFING MATERIALS, FLASHING, SEALERS AND AD-MIX COMPONENTS.

FRAMING PLAN DISCLAIMER

THE FRAMING PLANS REPRESENTED IN THESE DRAWINGS ARE INTENDED TO ESTABLISH PROPOSED FRAMING MEMBER LOCATIONS, FRAMING MEMBER DEPTH, POTENTIAL BEARING LOCATIONS AND ELEVATIONS, AND IS IN NO WAY INTENDED TO BE INTERPRETED AS STRUCTURAL ENGINEERED DRAWINGS. THE CONTRACTOR (BUILDER) SHALL ENSURE THAT THE STRUCTURE CONFORMS TO THOSE STANDARDS IN ALL RESPECTS INCLUDING STRENGTH, STRESSES, STRAINS, LOADS, CONNECTIONS AND STABILITY. REFER TO PLAN DISCLAIMER LOCATED ON THIS SHEET FOR ADDITIONAL STIPULATIONS AND REQUIREMENTS.

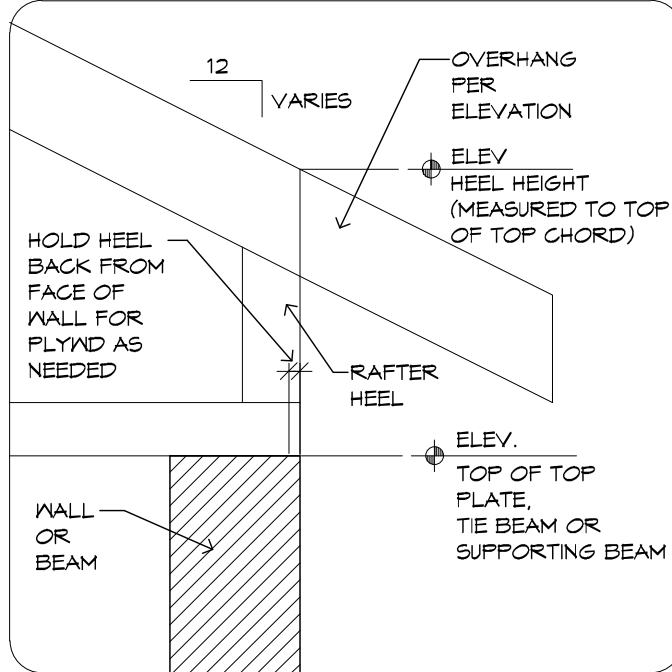

RAISED HEEL DETAIL
1" = 1'-0"

SHINGLE & METAL ROOF

ALL OVERHANGS TO BE 1'-6" UNO. GABLE END OVERHANGS TO BE 1'-0" UNO.

SEE SHEETS 5 & 5a FOR CLG HEIGHTS, REC CLG SIZES AND LOCATIONS

PROVIDE SOLID BLOCKING BELOW ALL KNEEWALLS AND OVERFRAMING PER TRUSS MFR AND STRUCT ENG

ROOF PITCH 6:12 UNO

ROOF PLAN

PLAN 1152F-25-01-1-D
JOB # 88-215-A1
©2024 RHOMES, INC.
ALL RIGHTS RESERVED

THE LANCASTER 1152F - L - VAN VOORHIS RESIDENCE


AS FRANCHISING, INC. THE DESIGNER IS RESPONSIBLE FOR THE ARCHITECTURAL DESIGN ONLY, AS REPRESENTED IN THESE DRAWINGS (PLANS), BUT NOT FOR ANY STRUCTURAL INFORMATION INCLUDED OR OMITTED. THE BUILDER IS RESPONSIBLE FOR OBTAINING ALL NECESSARY PERMITS AND FOR THE DESIGN OF THE FOUNDATION, STRUCTURAL FRAMING, TRUSSES, FRAMING MEMBERS, FLASHING AND MOISTURE PROTECTION. AS FRANCHISING, INC. IS NOT RESPONSIBLE FOR THE DESIGN OF THE FOUNDATION, STRUCTURAL FRAMING, TRUSSES, FRAMING MEMBERS, FLASHING AND MOISTURE PROTECTION. THE BUILDER SHALL ENSURE THAT THE STRUCTURE CONFORMS TO THOSE STANDARDS IN ALL RESPECTS INCLUDING STRENGTH, STRESSES, STRAINS, LOADS, CONNECTIONS AND STABILITY. REFER TO PLAN DISCLAIMER LOCATED ON THIS SHEET FOR ADDITIONAL STIPULATIONS AND REQUIREMENTS.

07/15/22 DBM

07/15/22 BSC - AI

RHOMES
©2024 RHOMES, INC.
ALL RIGHTS RESERVED

6c

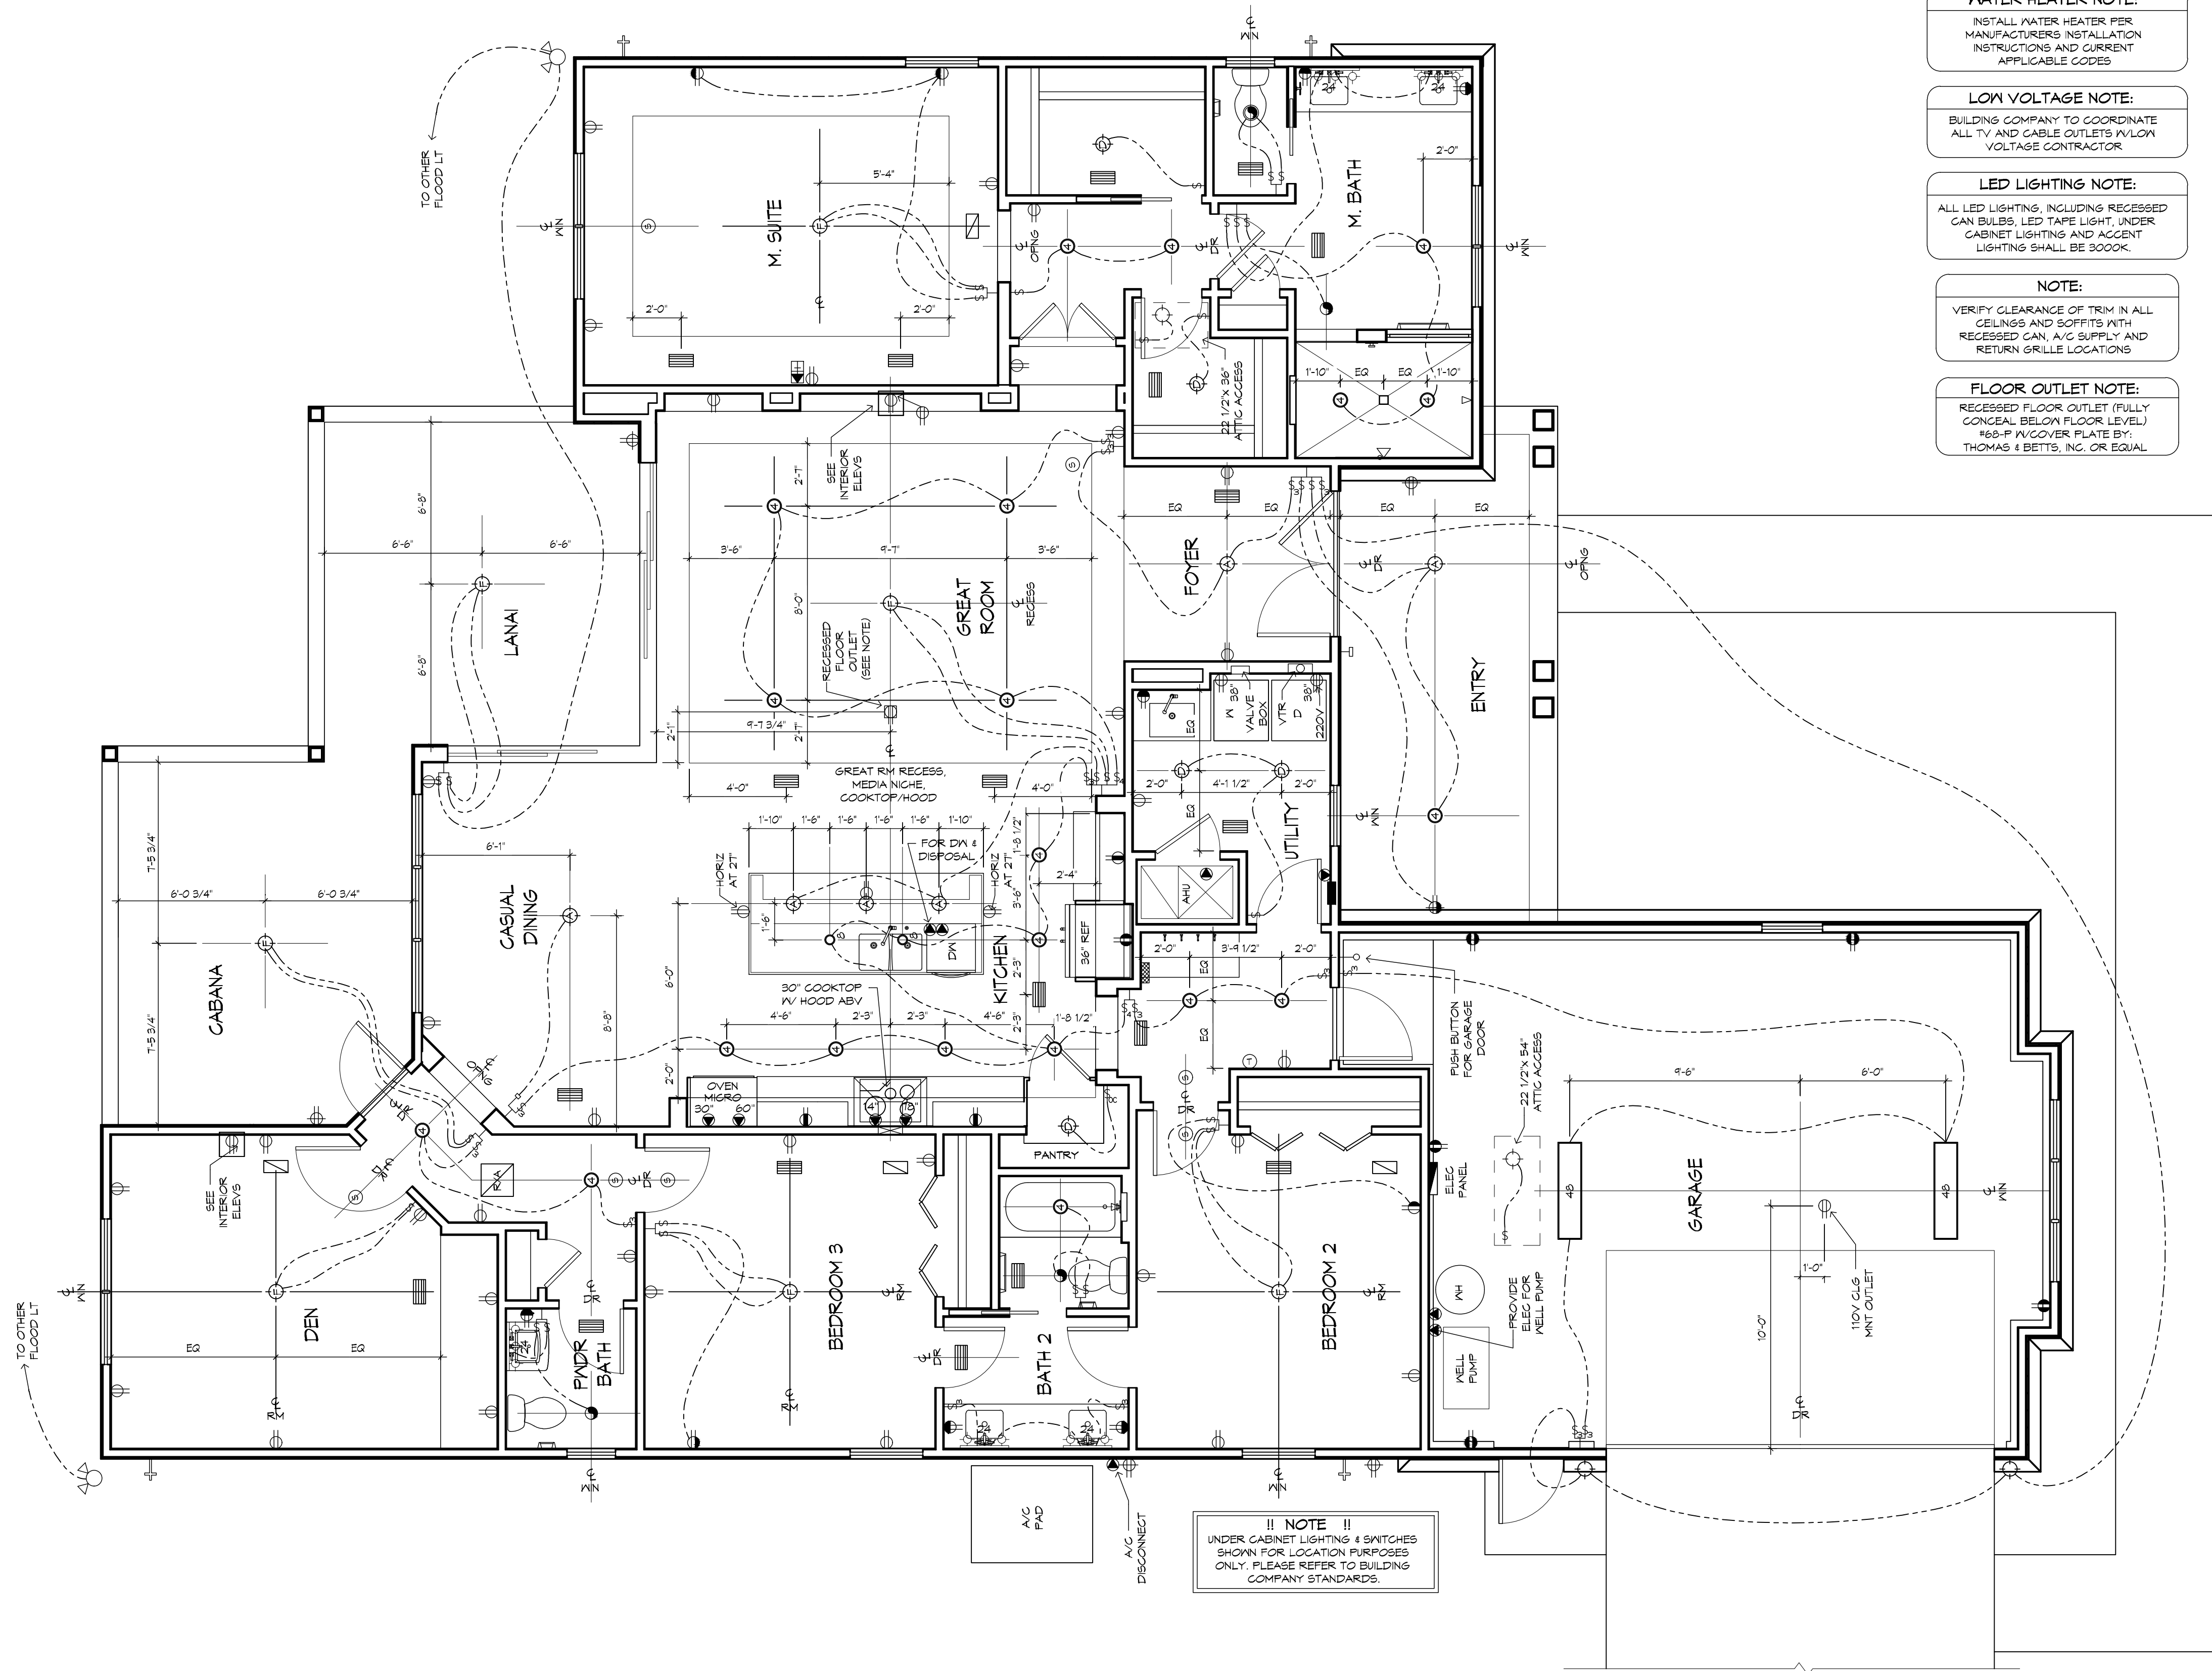

!! NOTE !!
UNDER CABINET LIGHTING & SWITCHES
SHOWN FOR LOCATION PURPOSES
ONLY. PLEASE REFER TO BUILDING
COMPANY STANDARDS.

!! NOTE !!
UNDER CABINET LIGHTING & SWITCHES
SHOWN FOR LOCATION PURPOSES
ONLY. PLEASE REFER TO BUILDING
COMPANY STANDARDS.


WATER HEATER NOTE:
INSTALL WATER HEATER PER
MANUFACTURERS INSTALLATION
INSTRUCTIONS AND CURRENT
APPLICABLE CODES

LOW VOLTAGE NOTE:
BUILDING COMPANY TO COORDINATE
ALL TV AND CABLE OUTLETS W/LOW
VOLTAGE CONTRACTOR


LED LIGHTING NOTE:
ALL LED LIGHTING, INCLUDING RECESSED
CAN BULBS, LED TAPE LIGHT, UNDER
CABINET LIGHTING AND ACCENT
LIGHTING SHALL BE 3000K.

NOTE:
VERIFY CLEARANCE OF TRIM IN ALL
CEILINGS AND SOFFITS WITH
RECESSED CAN, A/C SUPPLY AND
RETURN GRILLE LOCATIONS

FLOOR OUTLET NOTE:
RECESSED FLOOR OUTLET (FULLY
CONCEAL BELOW FLOOR LEVEL)
#68-P W/COVER PLATE BY:
THOMAS & BETTS, INC. OR EQUAL

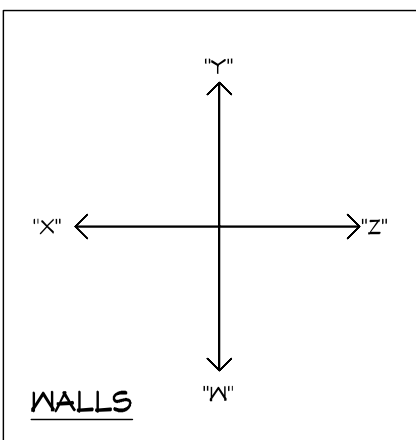

MECHANICAL DISCLAIMER
ANY DUCT ROUTING AND HVAC EQUIPMENT SHOWN ON THESE DRAWINGS
ARE DIAGRAMMATIC ONLY. THE BUILDER IS SOLELY RESPONSIBLE FOR
COORDINATING ALL ASPECTS OF MECHANICAL INSTALLATION WITH ALL
TRADES. THE BUILDER SHALL COORDINATE BETWEEN THE FRE
ENGINEERED TRUSS MFR AND/OR FRAMING REQUIREMENTS WITH THE
MECHANICAL CONTRACTOR TO ENSURE ADEQUATE SPACE FOR DUCT
ROUTING AND EQUIPMENT PLACEMENT AND SUPPORT. HVAC INSTALLATION
SHALL BE INSTALLED ACCORDING TO ALL CURRENT STATE AND LOCAL
MECHANICAL CODES.

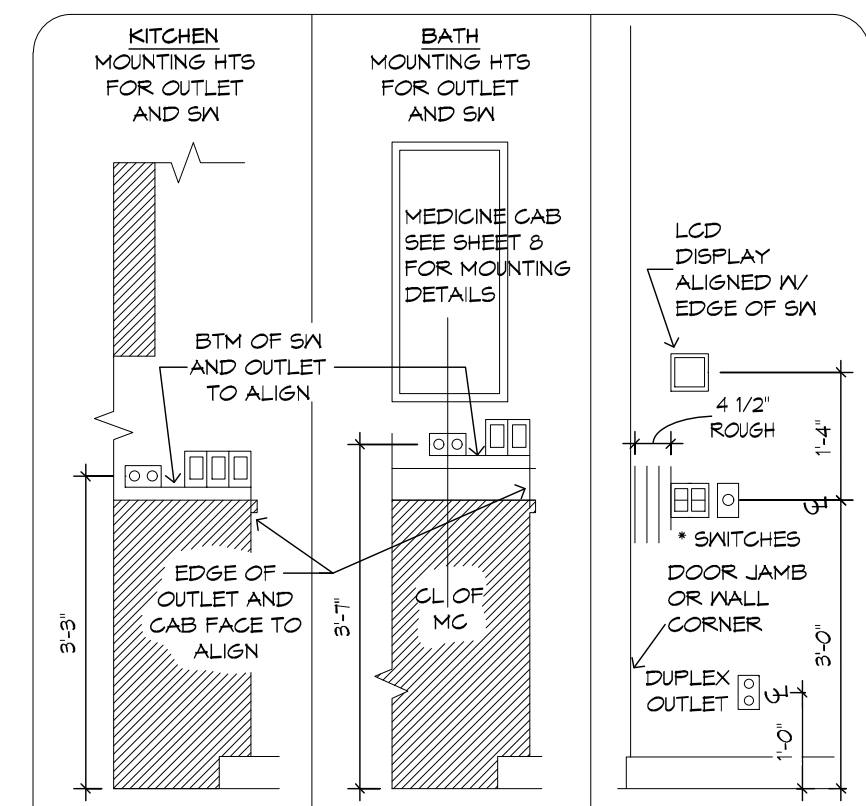

THE ITEMS BELOW ARE SHOWN FOR LOCATION
PURPOSES ONLY. PLEASE REFER TO LOCAL SPECS TO
DETERMINE WHETHER OR NOT THE FOLLOWING ITEMS
ARE INCLUDED:

- LIGHTING OR ELECTRONICS (LCD
DISPLAY OR LIGHTING AUTOMATION
PUSH BUTTON CONTROLLER)
- VOLUME CONTROL KNOB


* USE MAX OF 6 GANG BOXES.
FOR GANG BOXES OF 3 OR MORE THAT ARE LOCATED ON
BLOCK WALL, CHIP OUT THE BLOCK TO ACCOMMODATE DEEPER
BOX.

NOTE: ALL DIMENSIONS ARE FOR ROUGH FRAMING


ELECTRICAL DETAILS
SCALE: 1/2"=1'-0" UPDATED 10/14/16

- ELECTRICAL LEGEND**
- DUPLEX OUTLET (110V AT 12" OR AS NTD)
 - DUPLEX OUTLET (110V AT 36") *
 - DUPLEX OUTLET (110V AT 48") *
 - DUPLEX OUTLET (110V AT 48") *
 - SPLIT DUPLEX OUTLET (110V AT 12") TOP IS HOT
 - WEATHERPROOF DUPLEX OUTLET (110V AT 12")
 - WEATHERPROOF DUPLEX OUTLET (110V AT 12")
 - TOP PLUG IS HOT
 - 220V OUTLET
 - RECESS FLOOR OUTLET
 - SPECIAL PURPOSE CONN
 - STRUCTURED WIRE COMBO OUTLET
 - USB PORT FOR OUTLETS (110V AT 12" OR AS NTD)
 - SN SEE ELEC DTL
 - 3-WAY SN SEE ELEC DTL
 - 4-WAY SN SEE ELEC DTL
 - 1-GANG COMBINATION FAN / LIGHT SWITCH
 - OCCUPANCY/MOTION DETECTOR SWITCH
 - PUSH-BUTTON FOR GARAGE DOOR AT 60"
 - DIMMER SN AT 36"
 - PUSH-BUTTON DOORBELL
 - CLG MNT LST FIXTURE
 - CLG MNT PREWIRE - FIXTURE BY OWNER
 - SURFACE MNT FIXTURE
 - T SURFACE MNT 3000K, 1000 LUMEN, LED FIXTURE
 - WALL MNT FIXTURE
 - 6" ROUND RECESS 3000K LED RETROFIT TRIM W/OPEN BAFFLE
 - 4" MINI ROUND RECESS 3000K LED RETROFIT TRIM W/OPEN BAFFLE
 - 4" MINI ROUND RECESS 3000K LED EYEBALL TRIM
 - 6" ROUND SLOPE CLG RECESS WITH 3000K LED BULB (INTERIOR SLOPED CLG)
 - 2 1/2" MINI ROUND LED 3000K
 - CLG FAN/LIGHT PREWIRE AND SWITCHES
 - SMOKE DETECTOR OR COMBO SMOKE & CARBON MONOXIDE DETECTOR, PER CODE
 - UNDER CBT LED 9"
 - UNDER CBT LED 14"
 - UNDER CBT LED 22"
 - UNDER CBT LED 30"
 - 48" 48" CLG MNT 3000K, LED FIXTURE
 - 24" VANITY LIGHTING (SEE SPECS)
 - 36" VANITY LIGHTING (SEE SPECS)
 - EXHAUST FAN / LIGHT FIXTURE COMBO
 - EXHAUST FAN
 - SOFFIT MNT FLOOD LIGHT
 - CLG MNT SPEAKER
 - CHIMES
 - ELEC PANEL
 - STRUCTURED WIRING PANEL
 - CLG RETURN AIR
 - A/C REGISTER
 - THERMOSTAT
 - SECURITY PAD
- * NOTE: ALL OUTLETS ABOVE COUNTERS SHALL BE MOUNTED HORIZONTALLY
- * NOTE: ALL 125V, 15 AND 20 AMP OUTLETS TO BE TAMPER-RESISTANT IN AREAS SPECIFIED BY NEC 2014 406.12
- * NOTE: ALL EXTERIOR OUTLETS, OUTLETS IN GARAGE, WALL OUTLETS IN KITCHENS AND BATHROOMS AND ALL OUTLETS WITHIN 6'-0" OF A WATER SOURCE SHALL BE GFI
- * ALL NON-GFI OR 220V OUTLETS ARE PROTECTED BY AN ARC-FAULT CIRCUIT INTERRUPTER. ALL HEIGHTS TO CENTERLINE AFF
- * NOTE: LIGHTS, FANS, SMOKE DETECTORS, A/C SUPPLIES AND RETURN AIRS TO BE PLACED ON CENTERLINES OF DOORS, HALLWAYS, TYP UNO
- * NOTE: COMBINATION SMOKE & CARBON MONOXIDE DETECTORS SHALL BE INSTALLED PER NFPA72 CHAPTER 93 AND FBC-R, 6TH EDITION, SECTION R514 & 515
- * NOTE: COORDINATE LOCATION OF ALL REQ ELECTRICAL, CABLE, AUDIO/VIDEO & DATA RECEPTACLES W/ MOUNTING HARDWARE & MFR INSTALLATION REQ FOR ALL FLAT PANEL DISPLAYS.
- UPDATED 6/30/20


ELECTRICAL PLAN
1/4" = 1'-0"

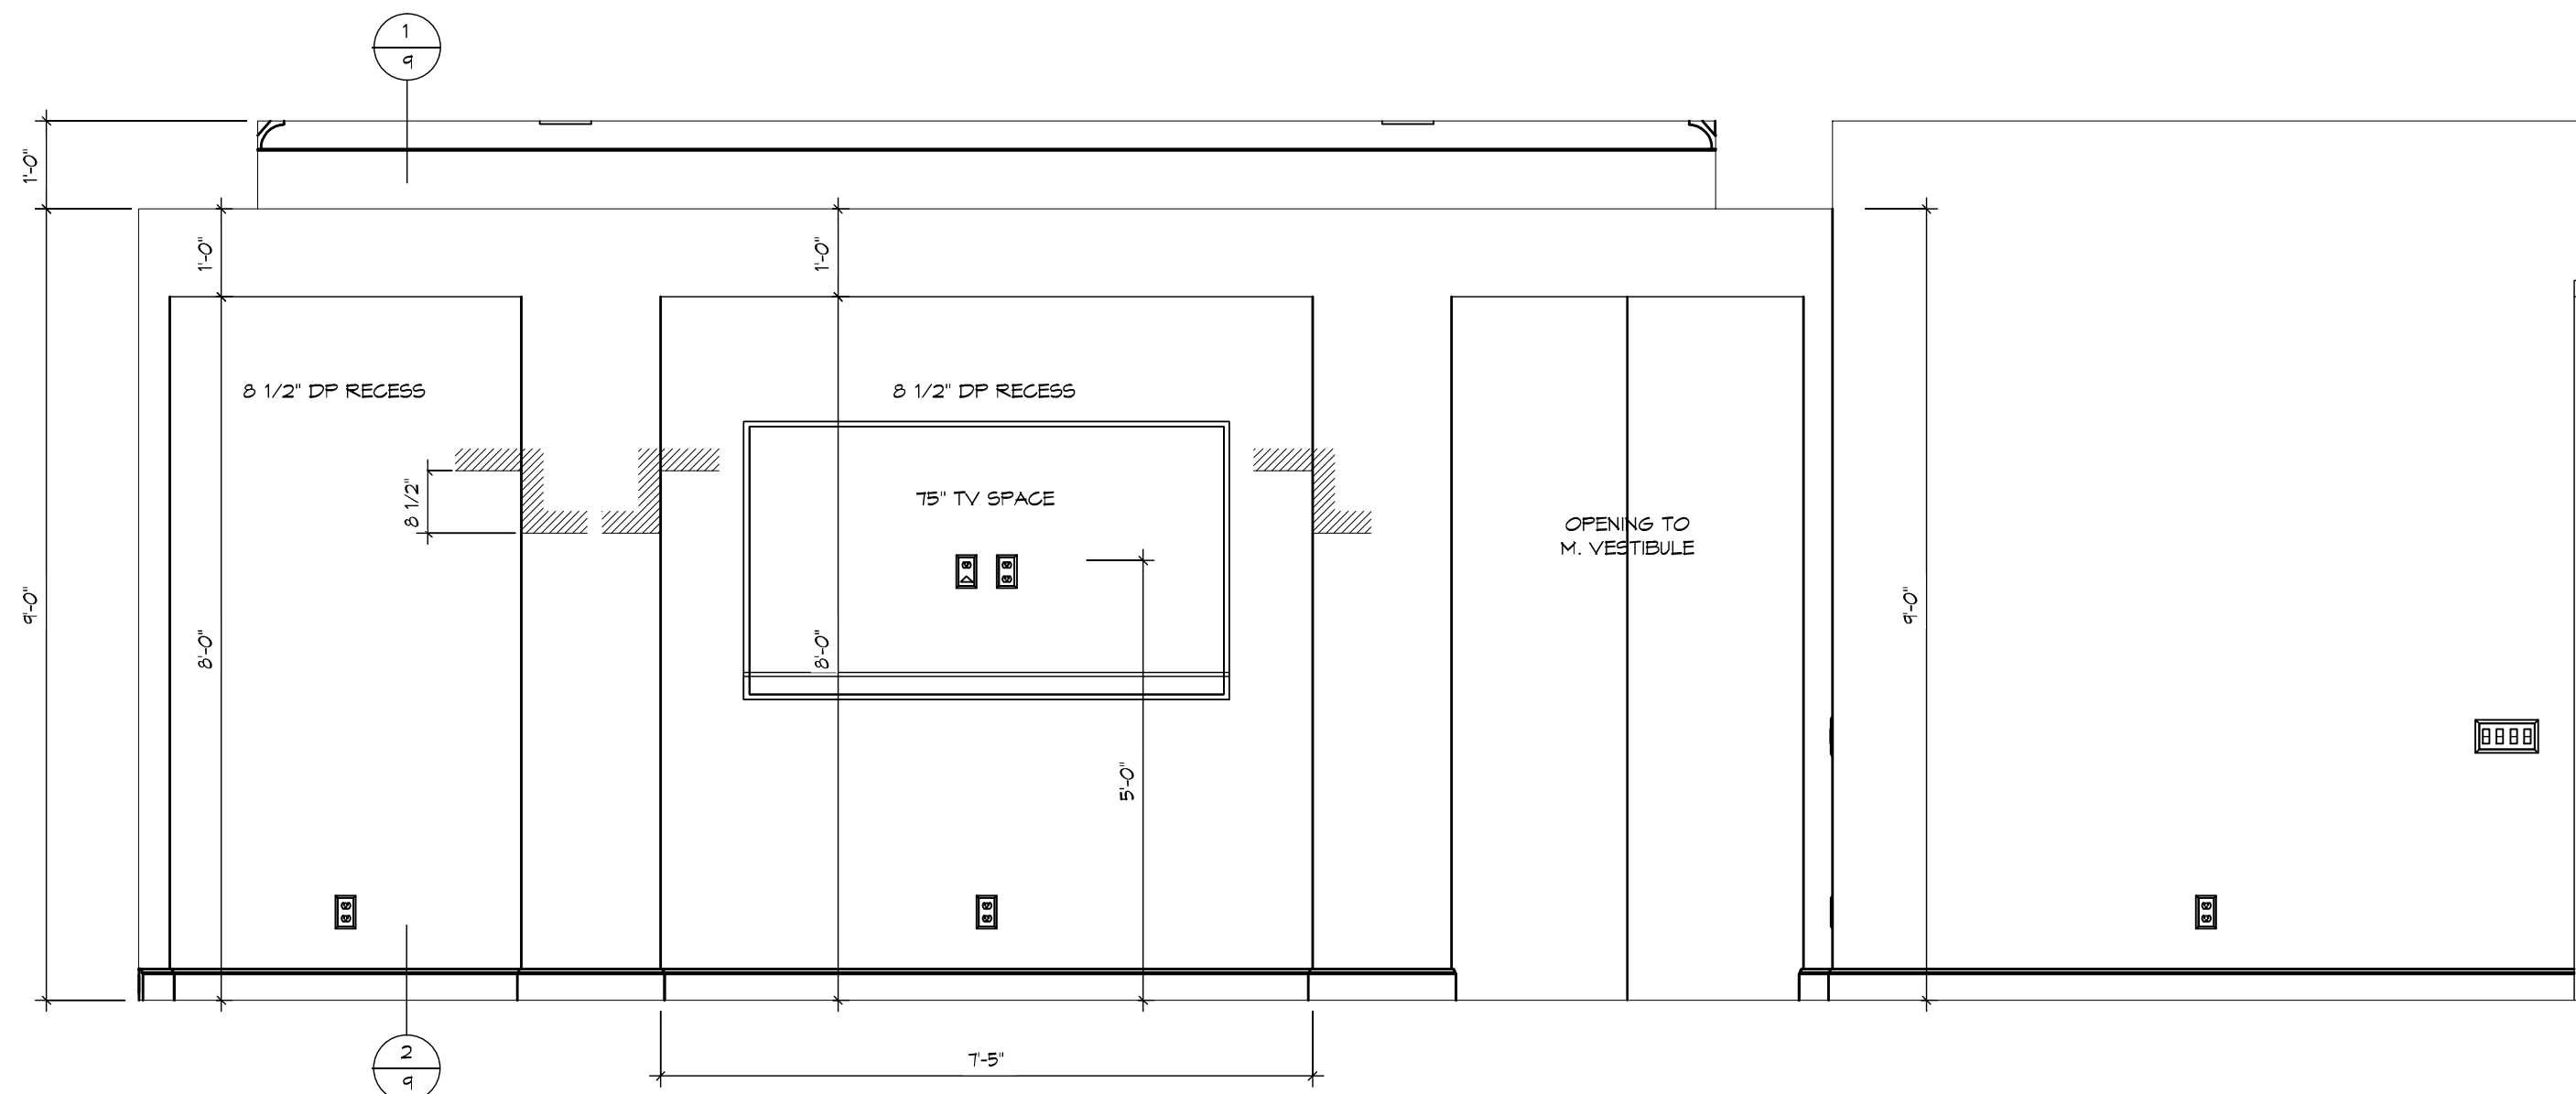


GREAT ROOM / FOYER - "Y"
1/2" = 1'-0"

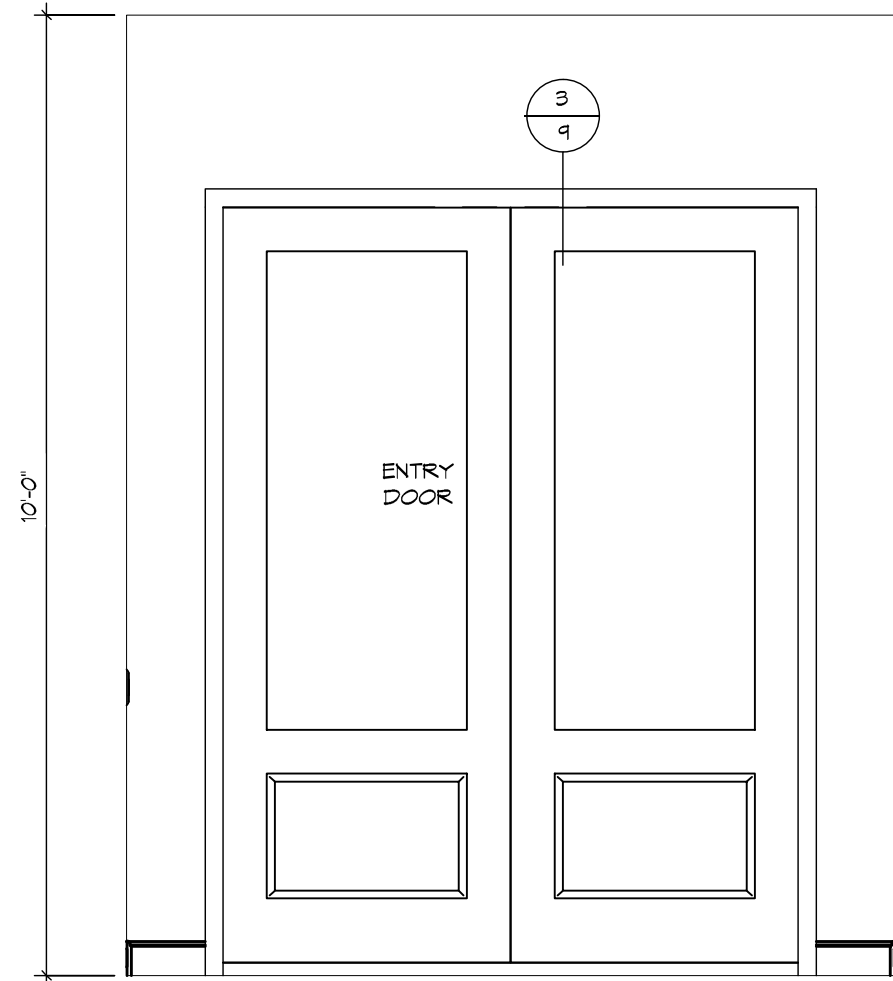


FOYER - "Z"
1/2" = 1'-0"

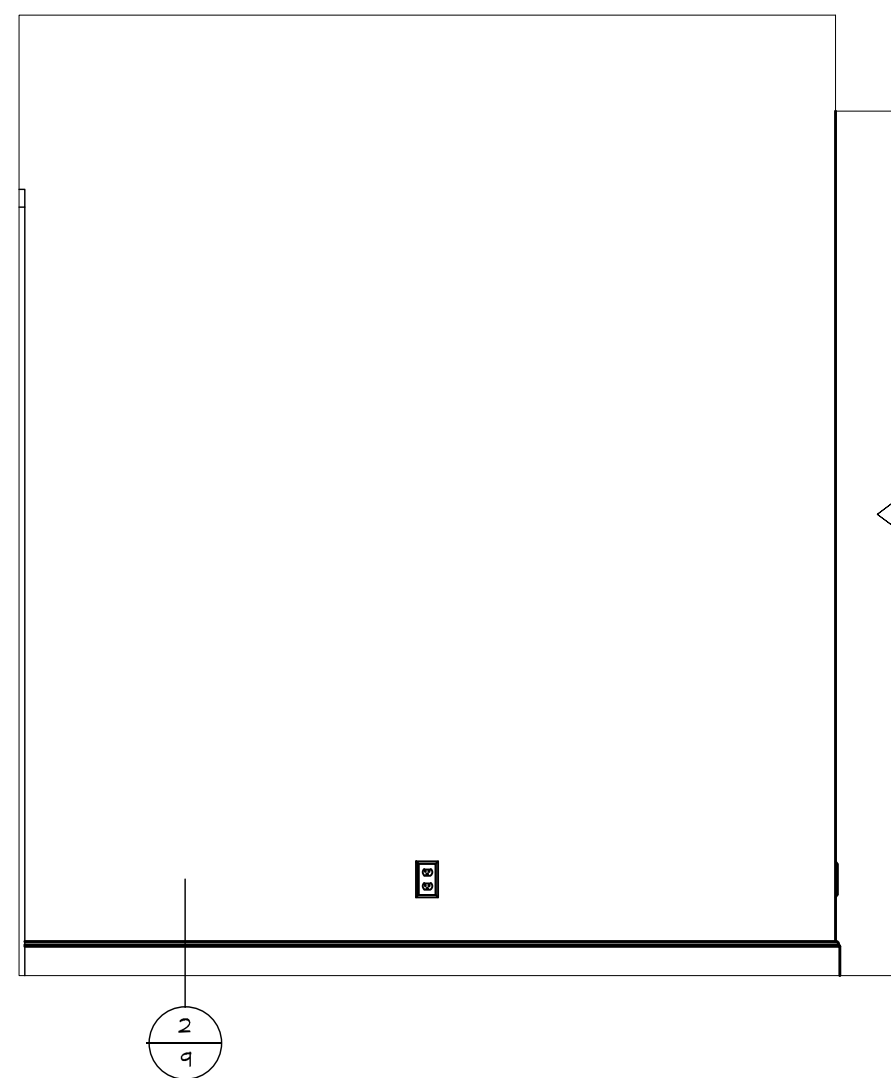


FOYER - "W"
1/2" = 1'-0"

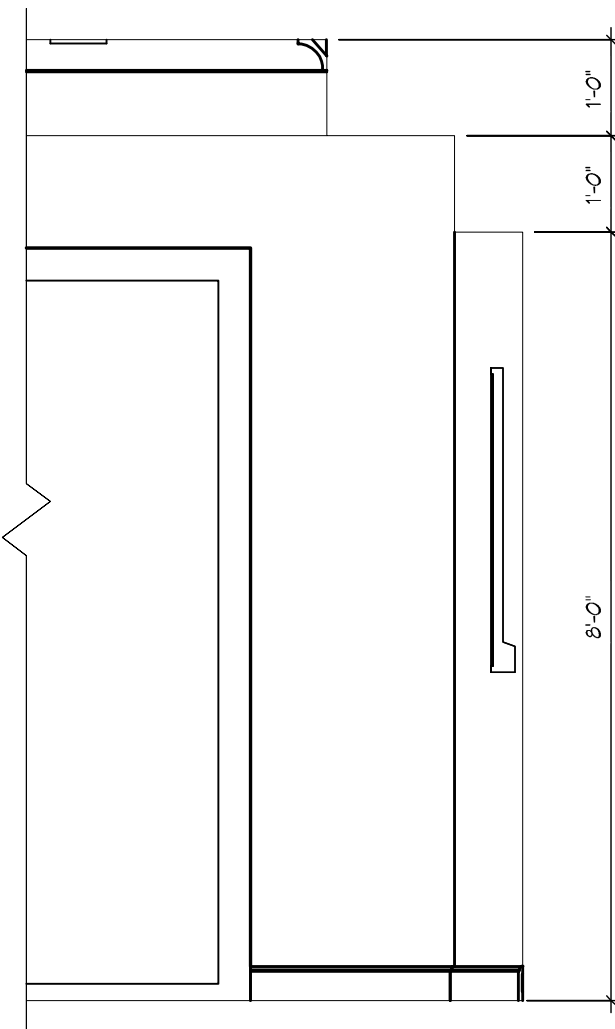


GREAT ROOM - "Z"
1/2" = 1'-0"

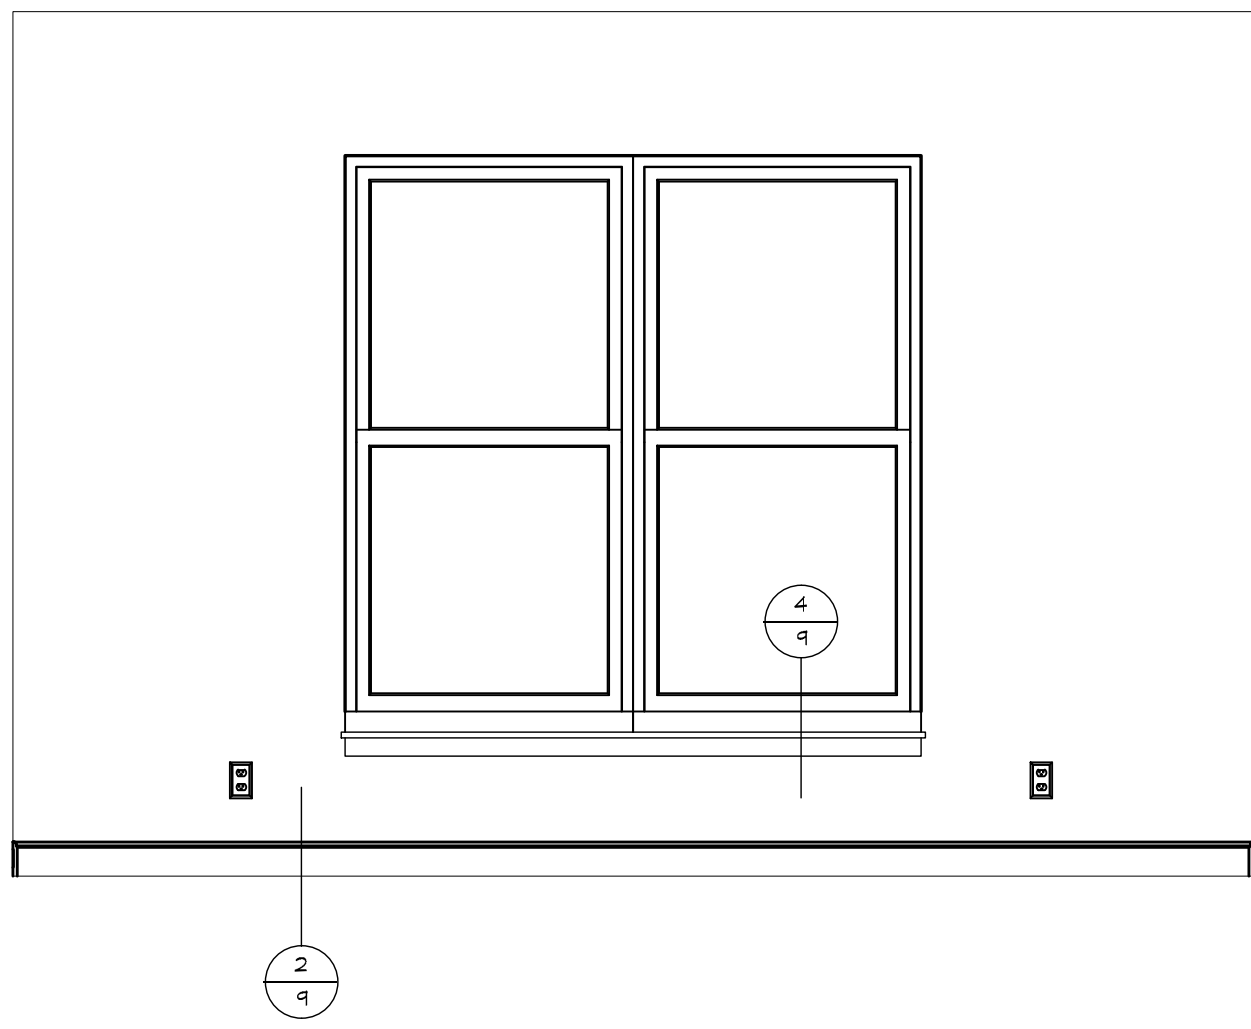


DEN - "X"
1/2" = 1'-0"

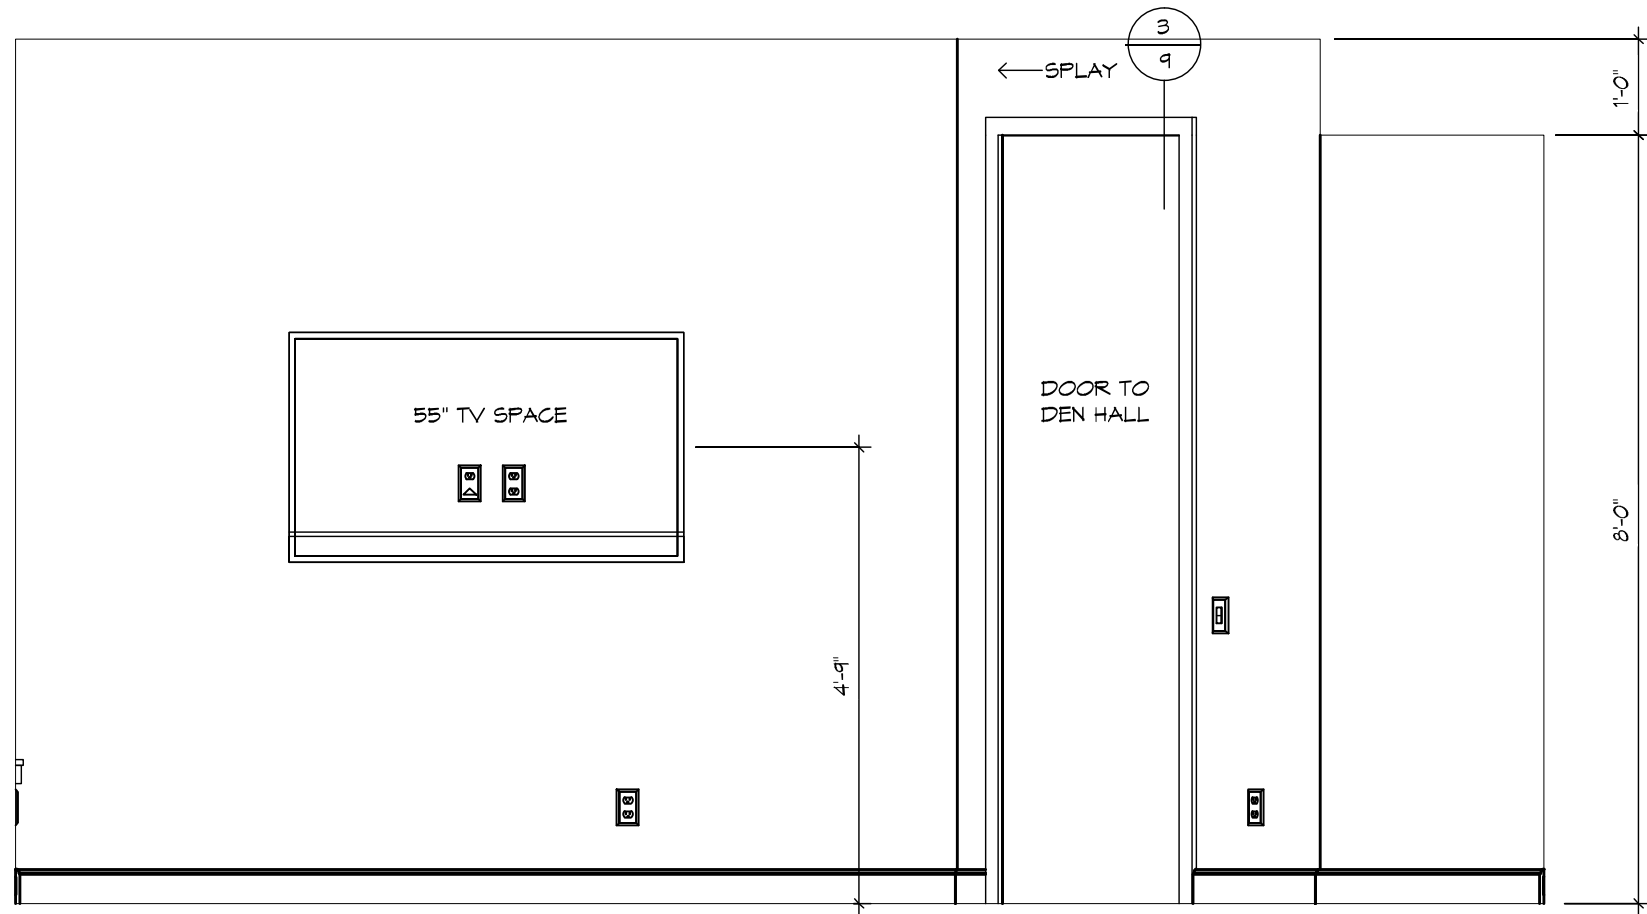


DEN - "Y"
1/2" = 1'-0"

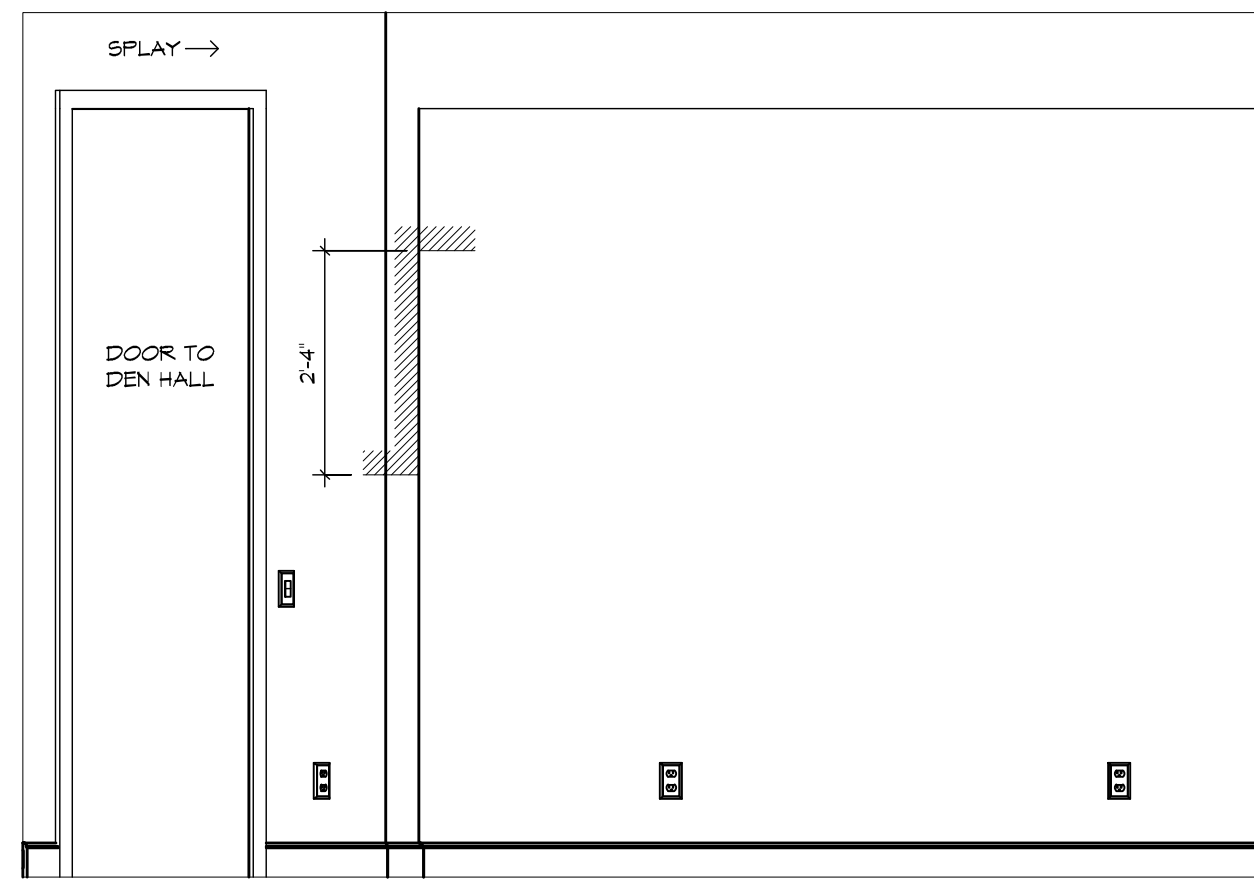


DEN - "Z"
1/2" = 1'-0"

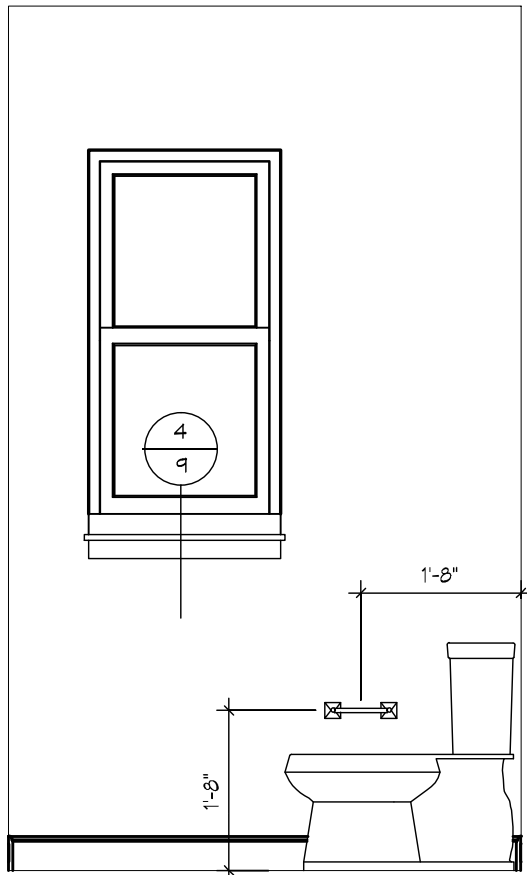

POWDER BATH - "W"
1/2" = 1'-0"

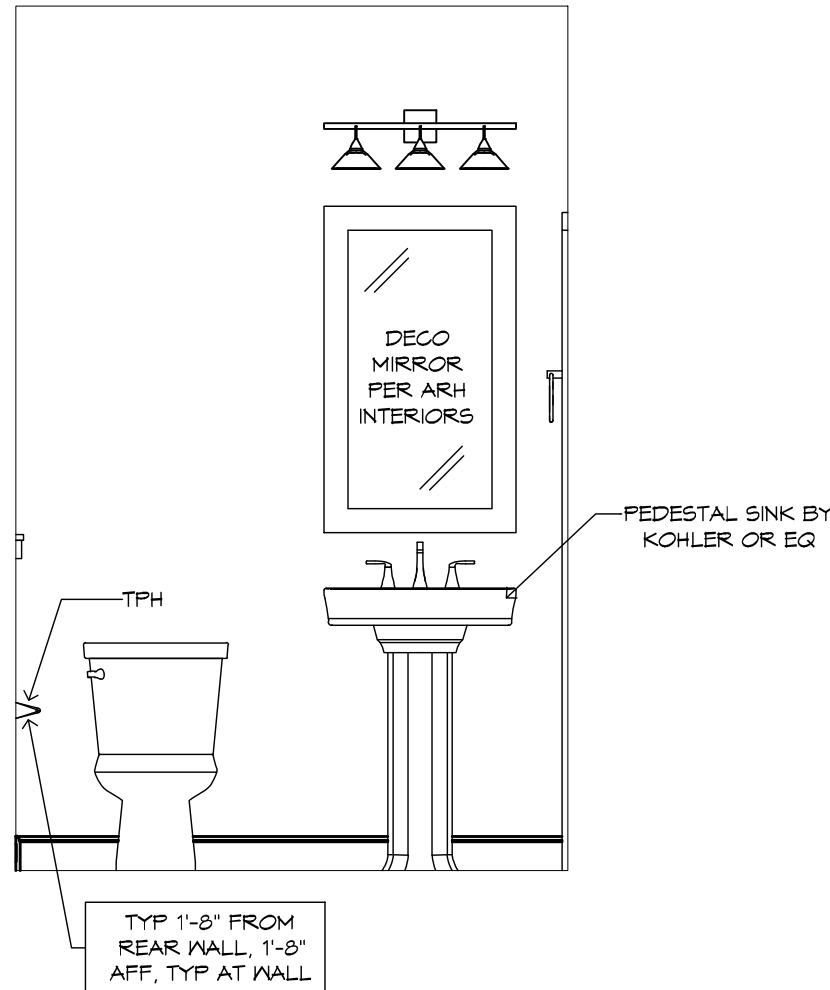

POWDER BATH - "X"
1/2" = 1'-0"

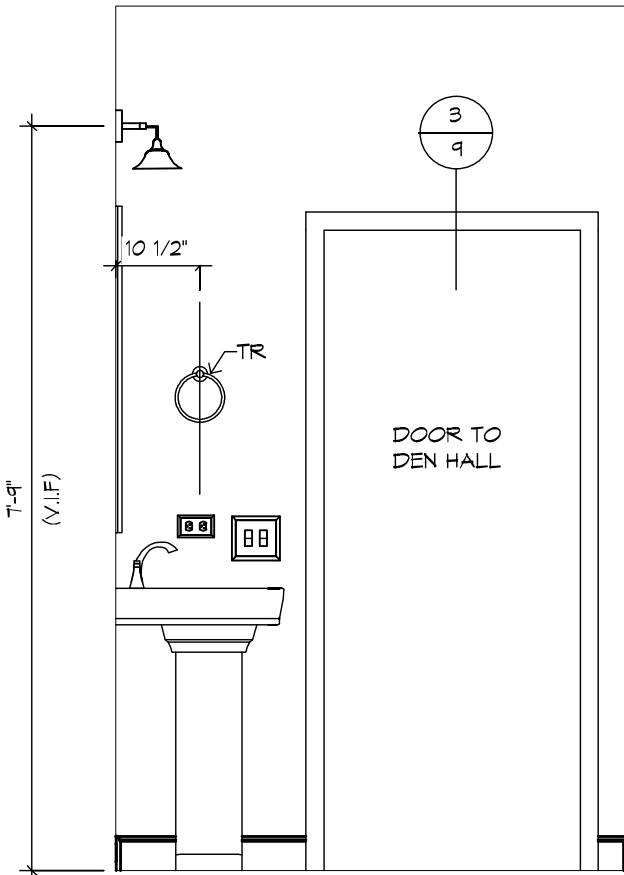

POWDER BATH - "Y"
1/2" = 1'-0"


GENERAL NOTES:

CABINET ELEVATIONS AND LIGHTING ARE GRAPHIC REPRESENTATIONS ONLY. REFERENCE SHOULD BE MADE TO THE ELECTRICAL SHEET, CABINET MFR. DRAWINGS AND SPECS FOR FURTHER INFORMATION.


REFER TO CABINET SHOP DRAWINGS FOR CABINET & VANITY TOP DIMENSIONS.

THE TOE KICK IS 4".


PLUMBING, TILE, BASE MLDs, DOOR CASING & DECORATIVE LIGHTING & DECORATIVE MIRRORS ARE ILLUSTRATED FOR LOCATION PURPOSES ONLY. PLEASE REFER TO COMMUNITY STANDARDS FOR SIZES & SPECS.

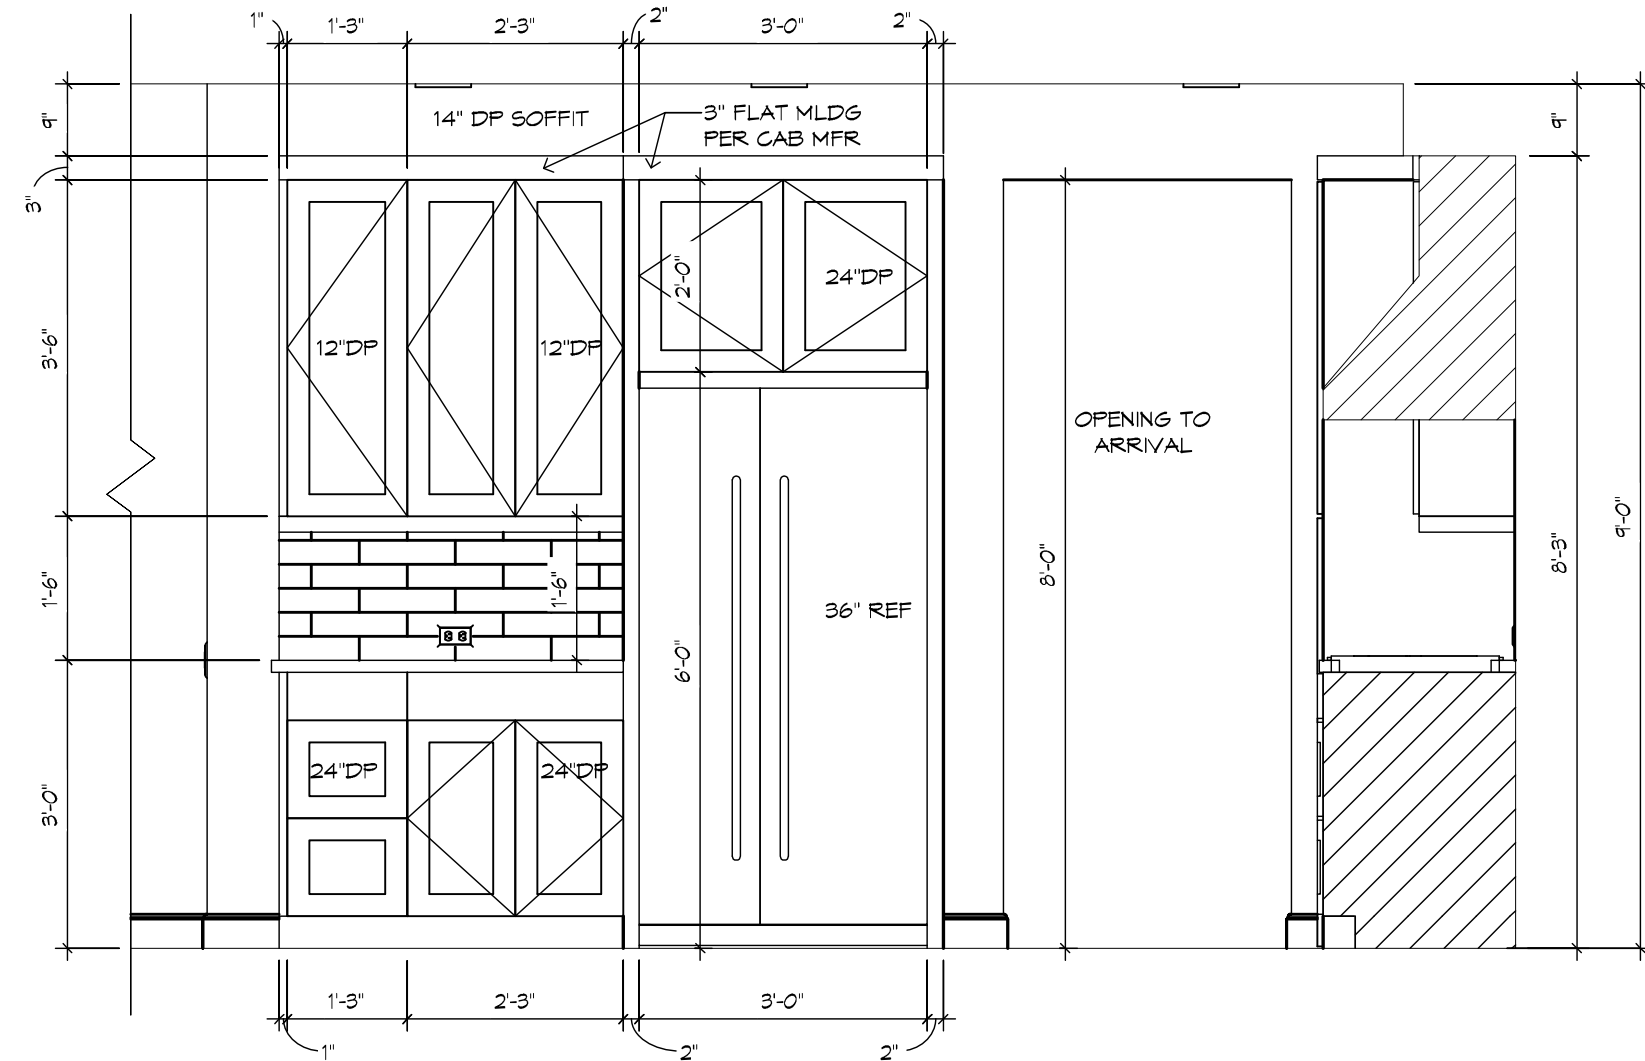


KITCHEN - "Z"
1/2" = 1'-0"

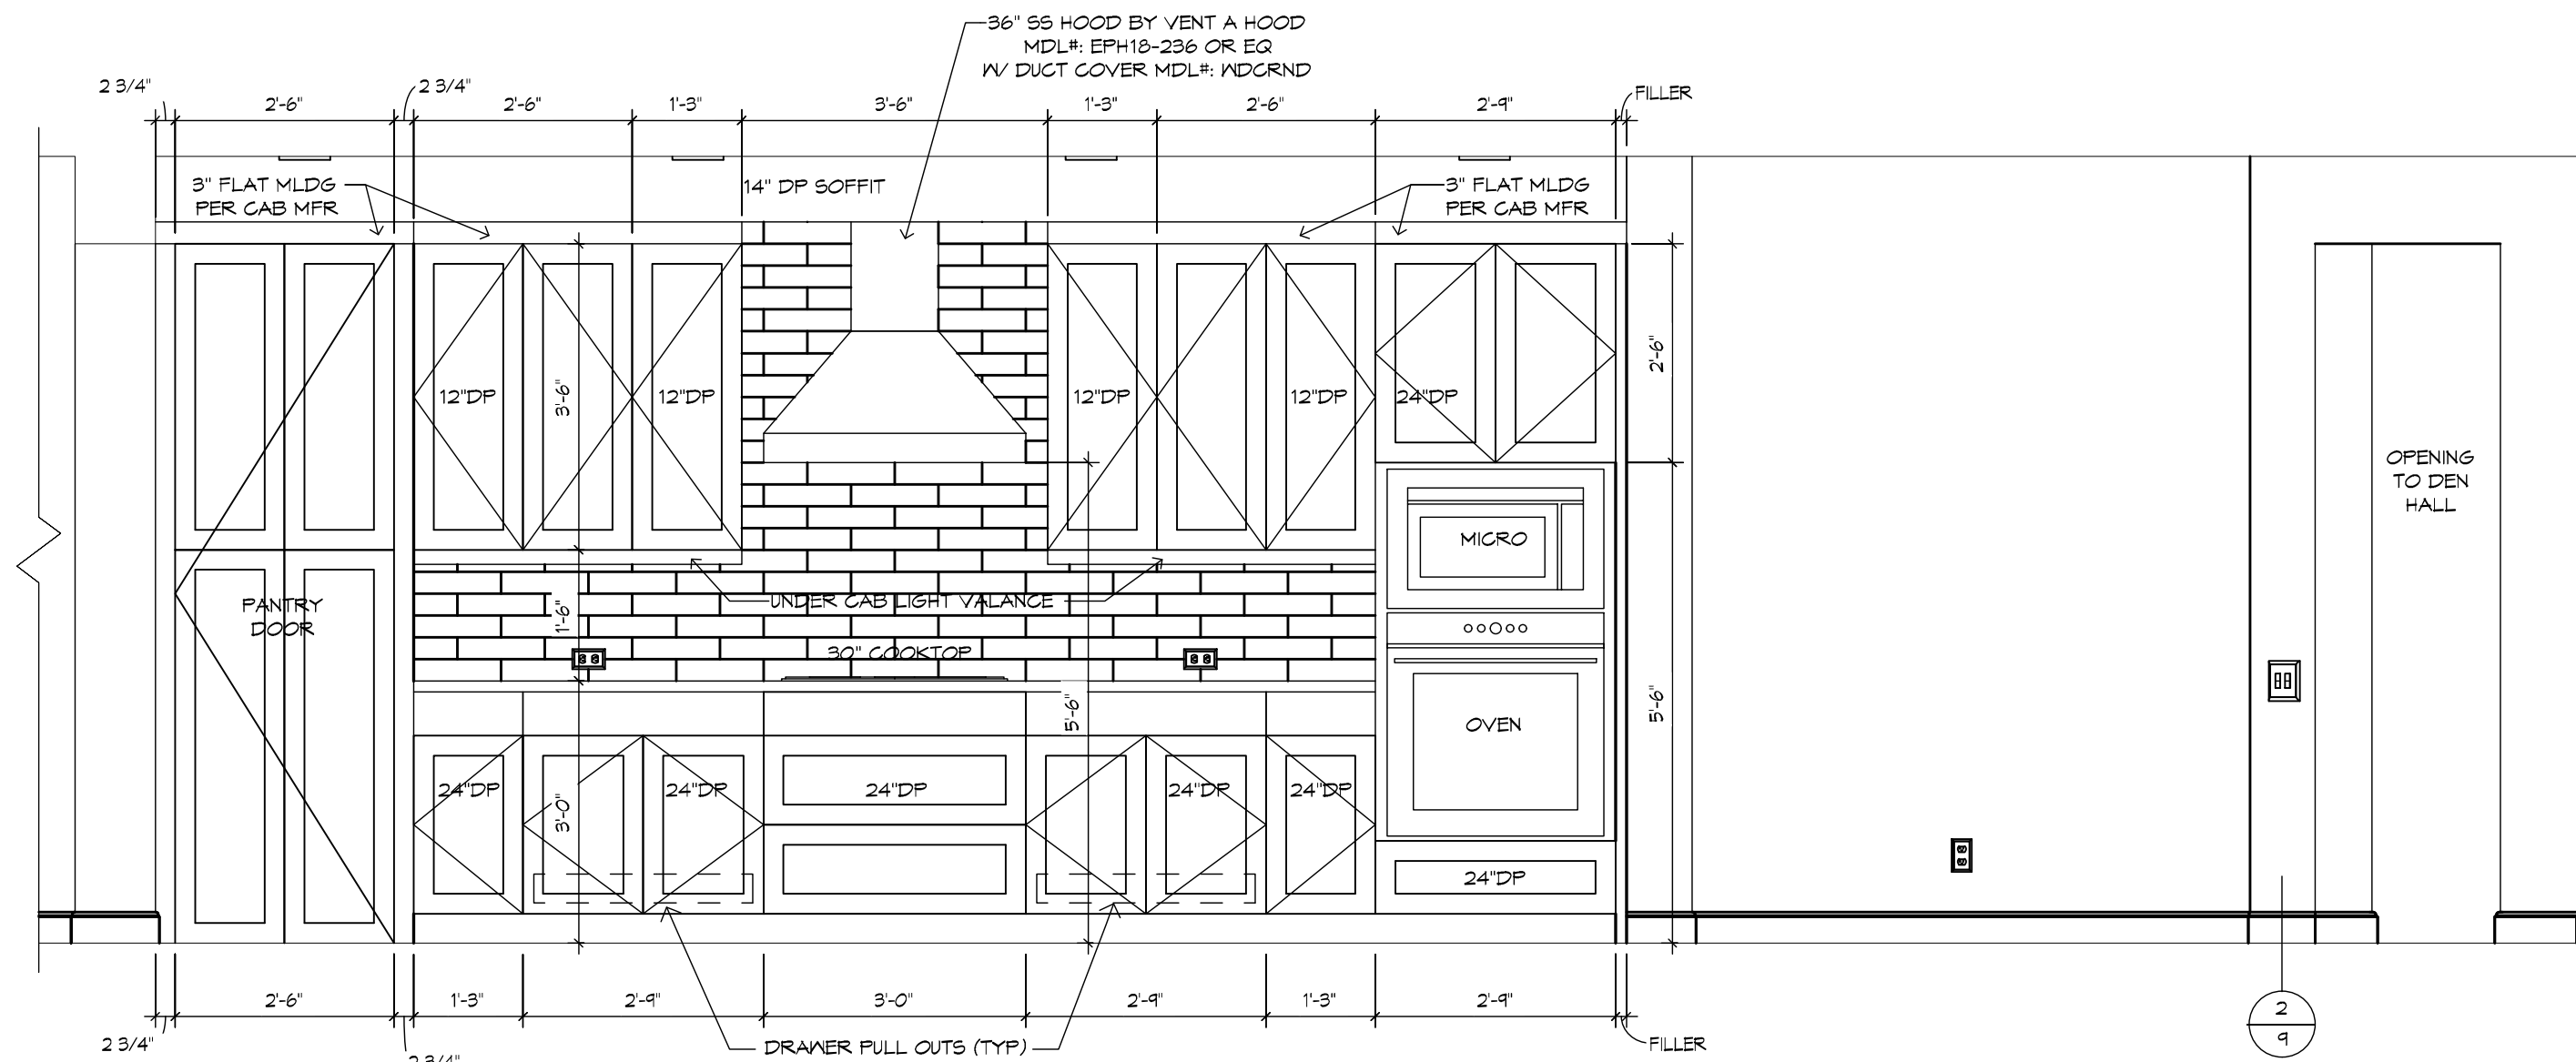


KITCHEN - "W"
1/2" = 1'-0"

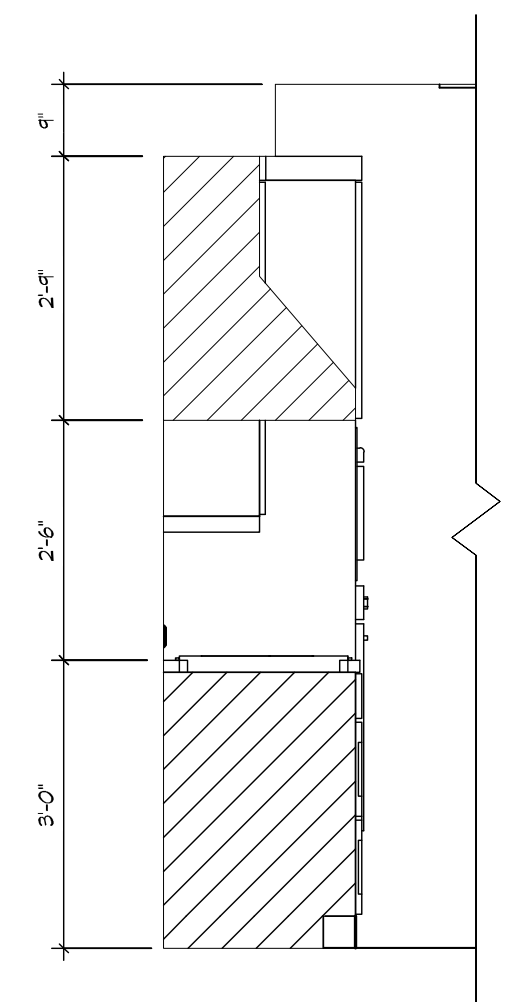


A KITCHEN SECTION

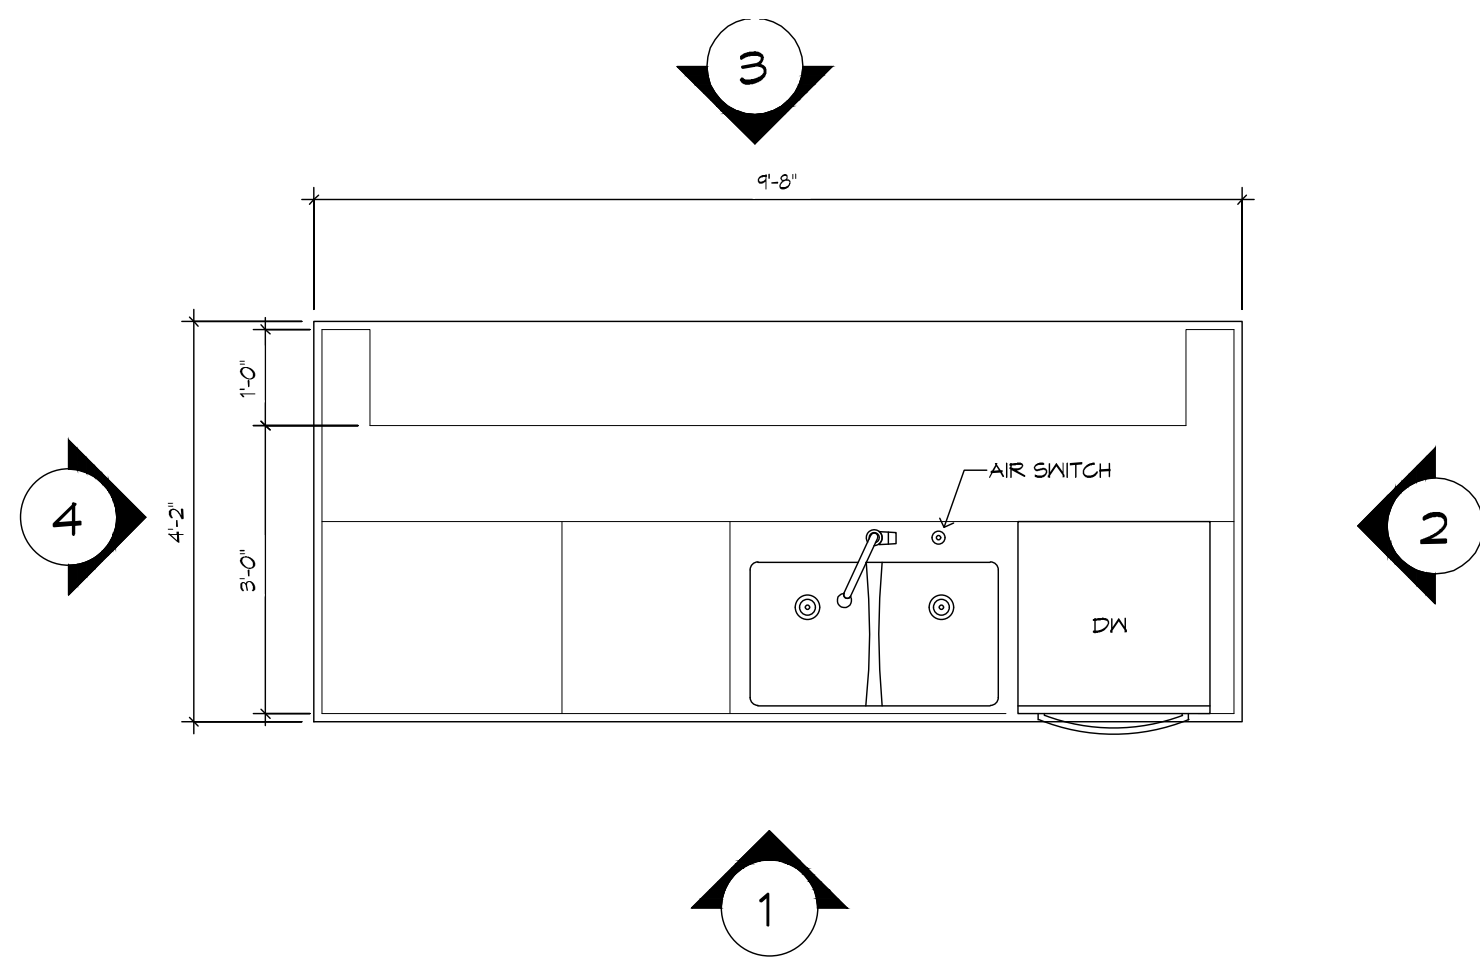


KITCHEN ISLAND PLAN
1/2" = 1'-0"

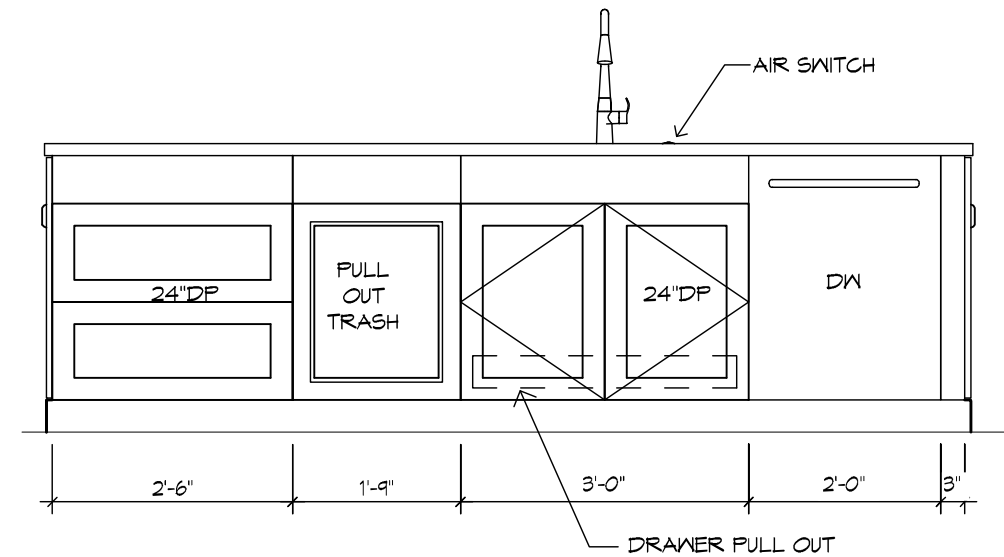


1 1/2" = 1'-0"

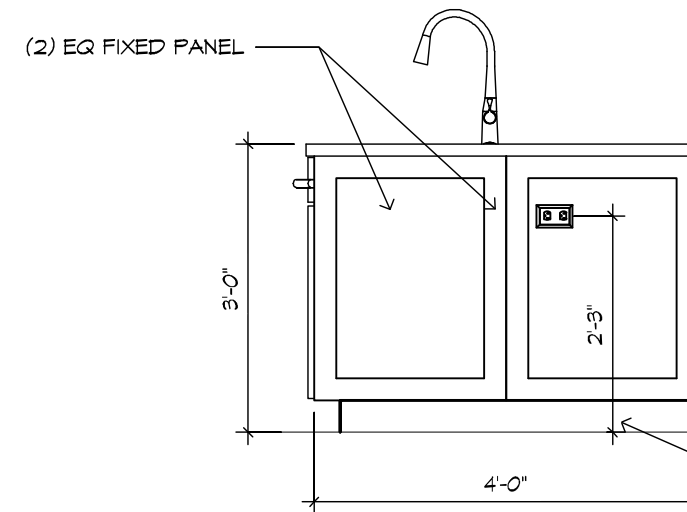

2 1/2" = 1'-0"

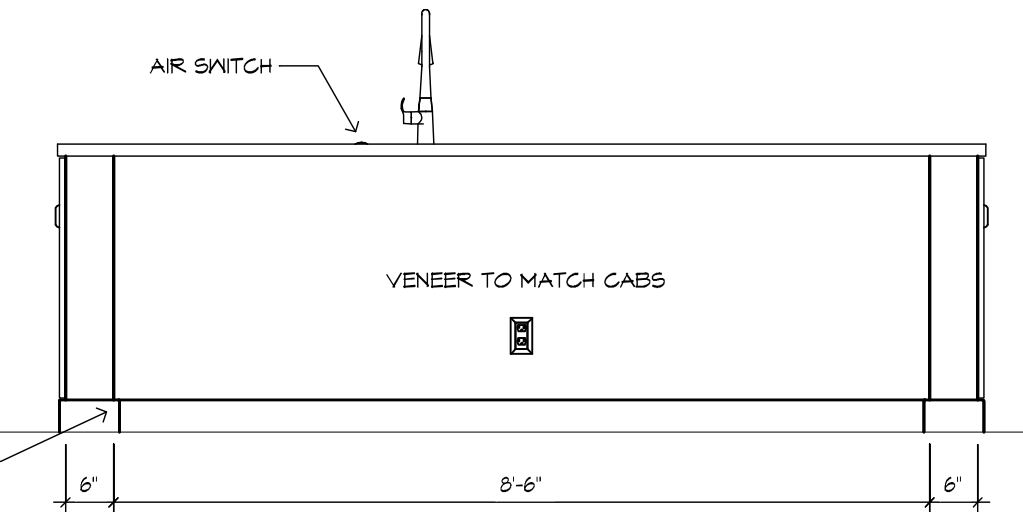


3 1/2" = 1'-0"

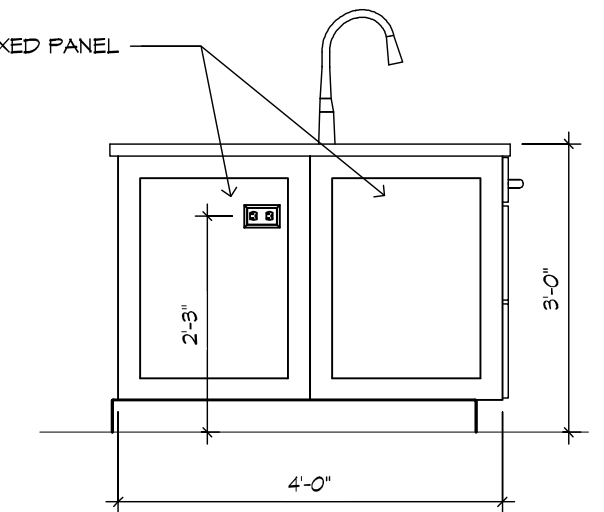


4 1/2" = 1'-0"

GENERAL NOTES:


CABINET ELEVATIONS AND LIGHTING ARE GRAPHIC REPRESENTATIONS ONLY. REFERENCE SHOULD BE MADE TO THE ELECTRICAL SHEET, CABINET MFR DRAWINGS AND SPECS FOR FURTHER INFORMATION. REFER TO CABINET SHOP DRAWINGS FOR CABINET 1 VANITY TOP DIMENSIONS. THE TOE KICK IS 4". PLUMBING, TILE, BASE MLDG, DOOR CASING 4 DECORATIVE LIGHTING 4 DECORATIVE MIRRORS ARE ILLUSTRATED FOR LOCATION PURPOSES ONLY. PLEASE REFER TO COMMUNITY STANDARDS FOR SIZES 4 SPECS.

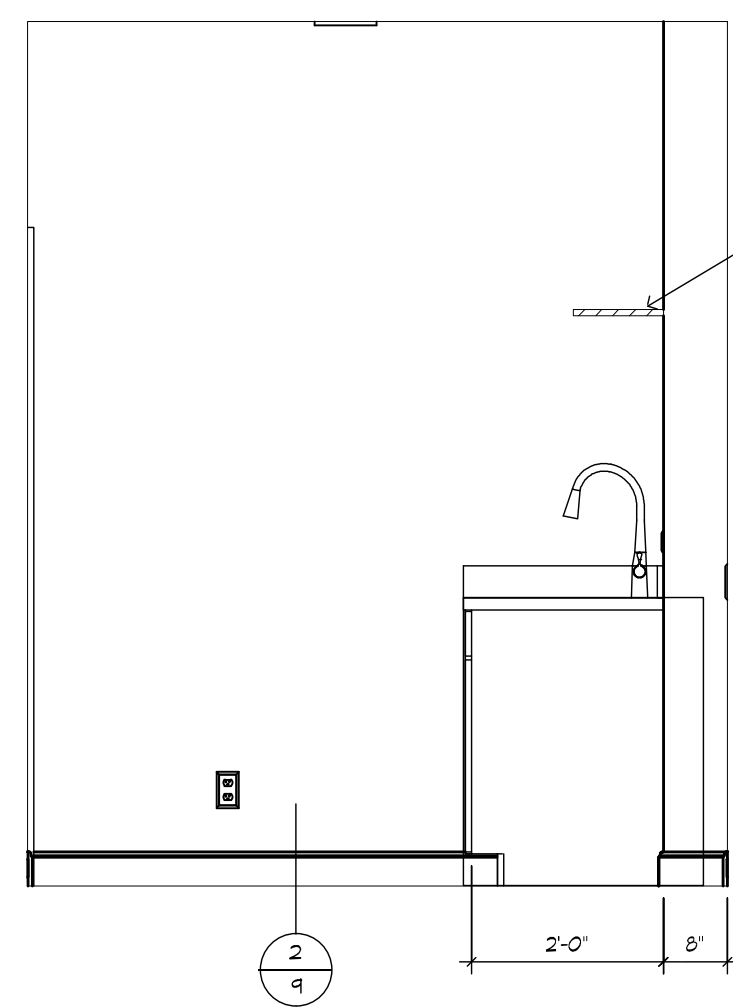


UTILITY - "X"
1/2" = 1'-0"

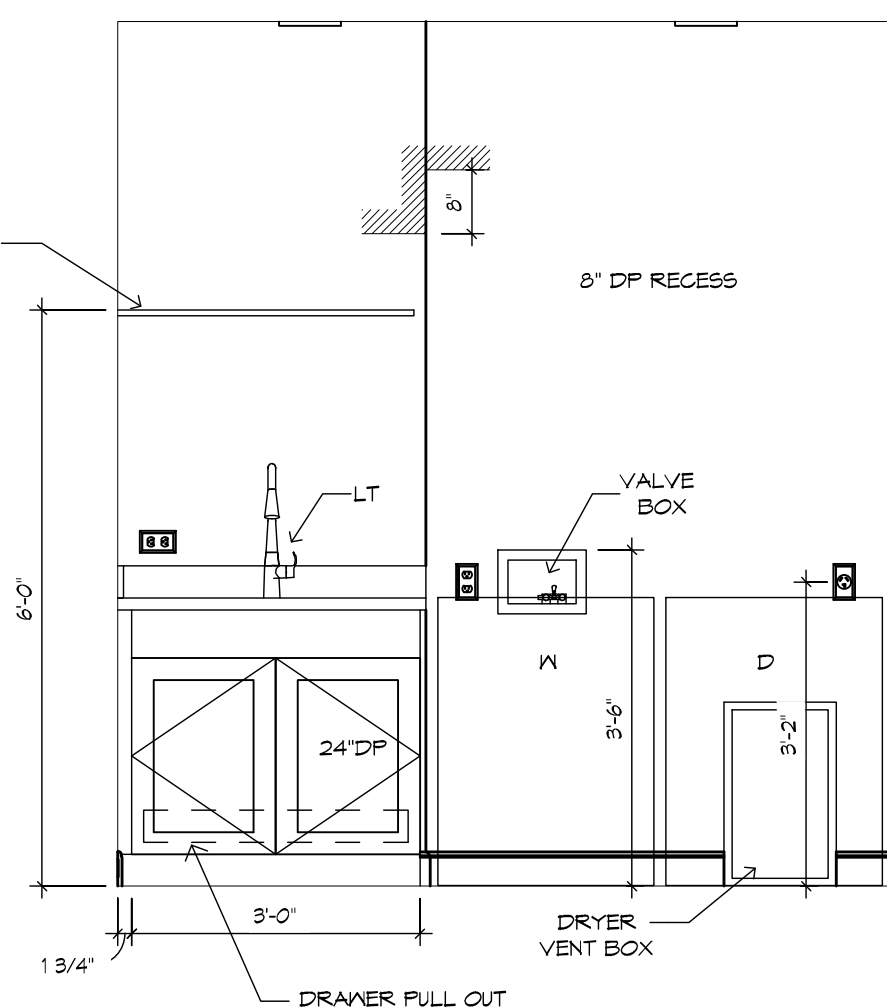


UTILITY - "Y"
1/2" = 1'-0"

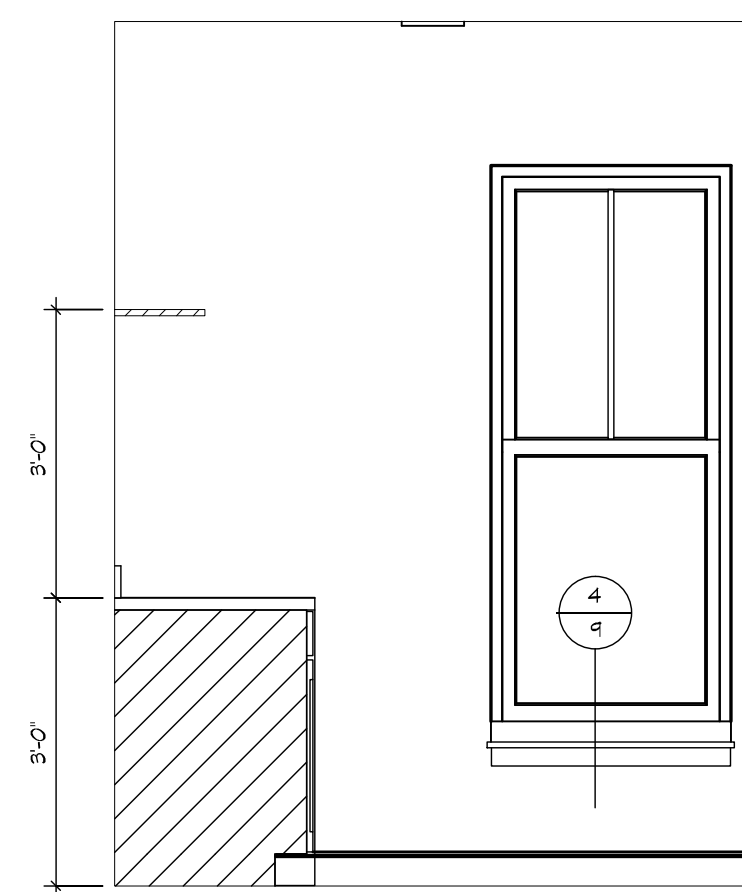

UTILITY - "Z"
1/2" = 1'-0"

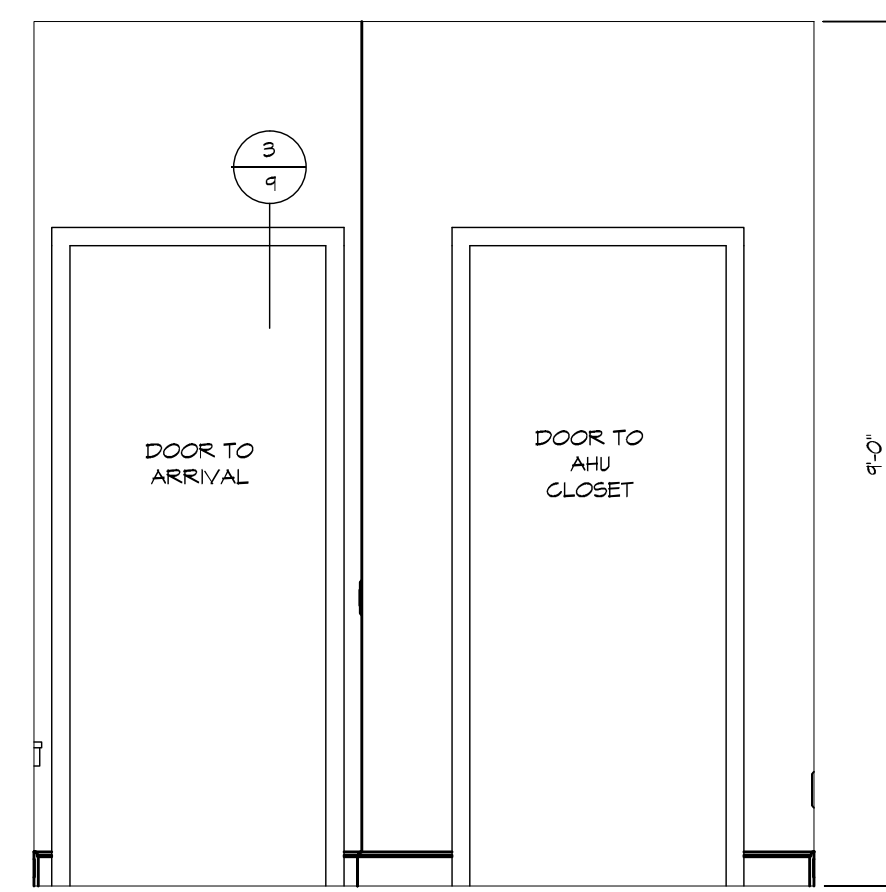


UTILITY - "W"
1/2" = 1'-0"

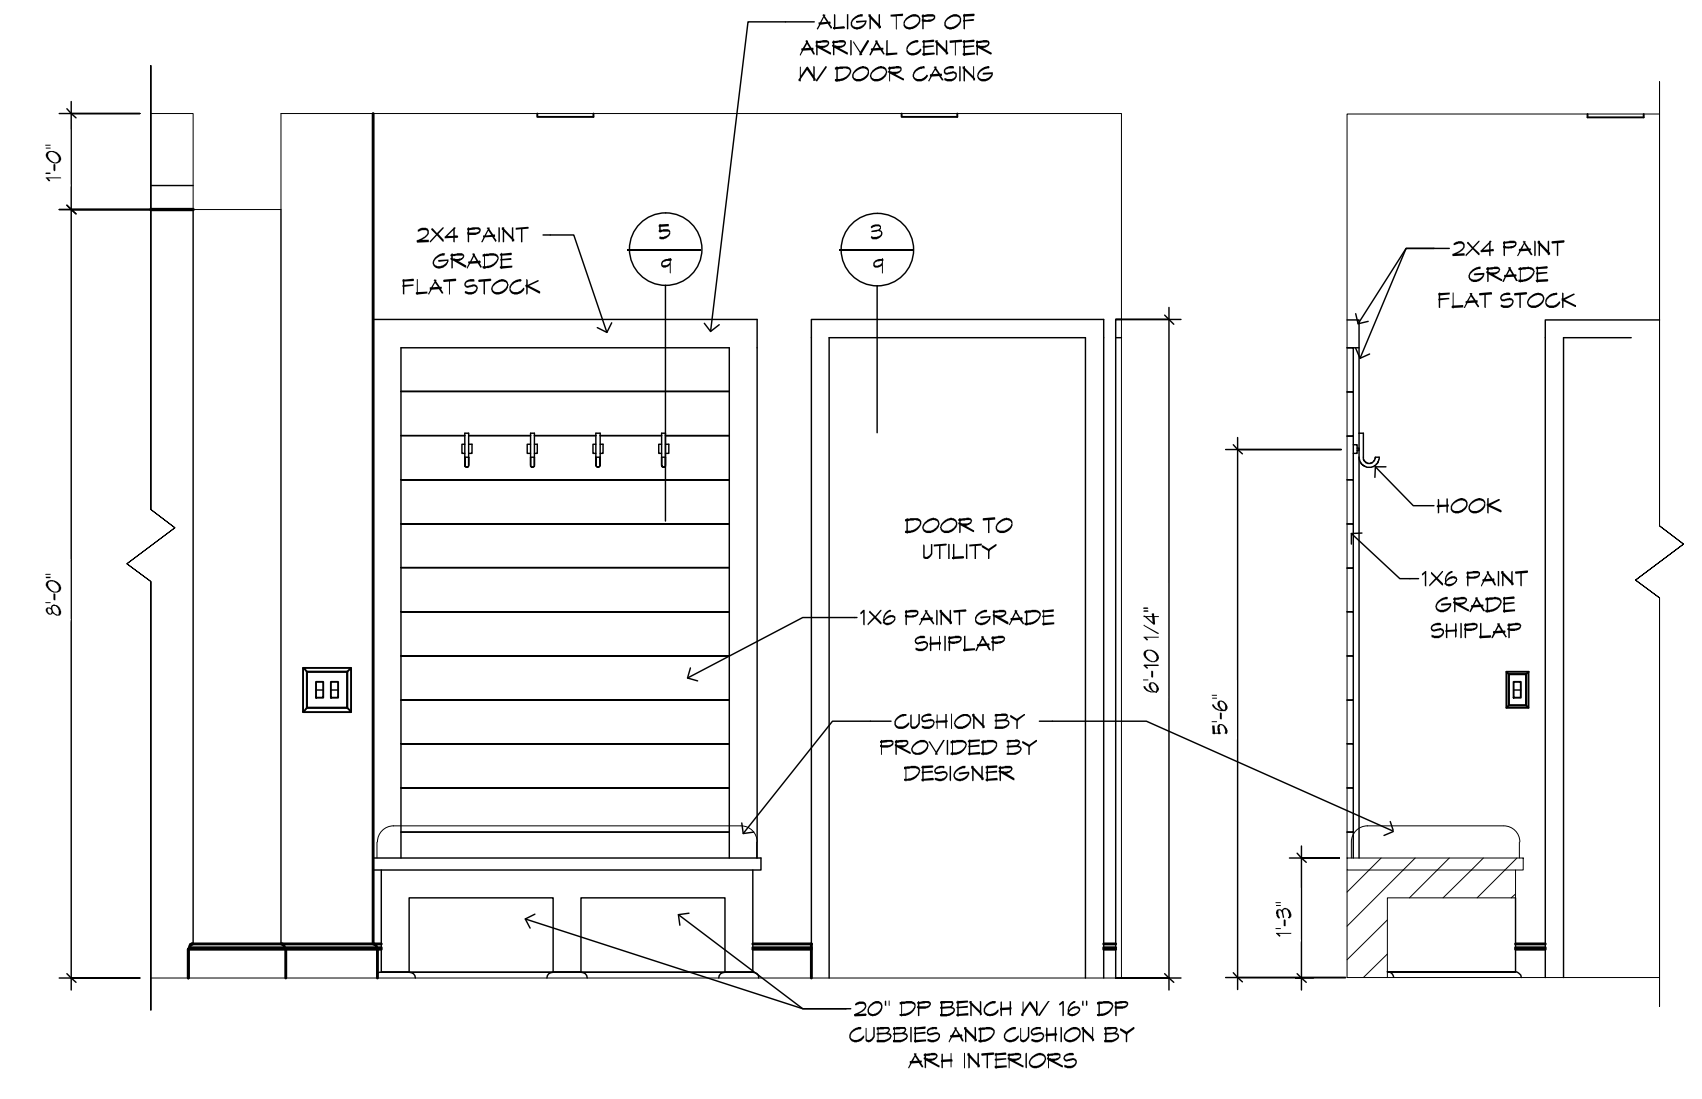


ARRIVAL - "Y"
1/2" = 1'-0"


ARRIVAL SECTION
1/2" = 1'-0"

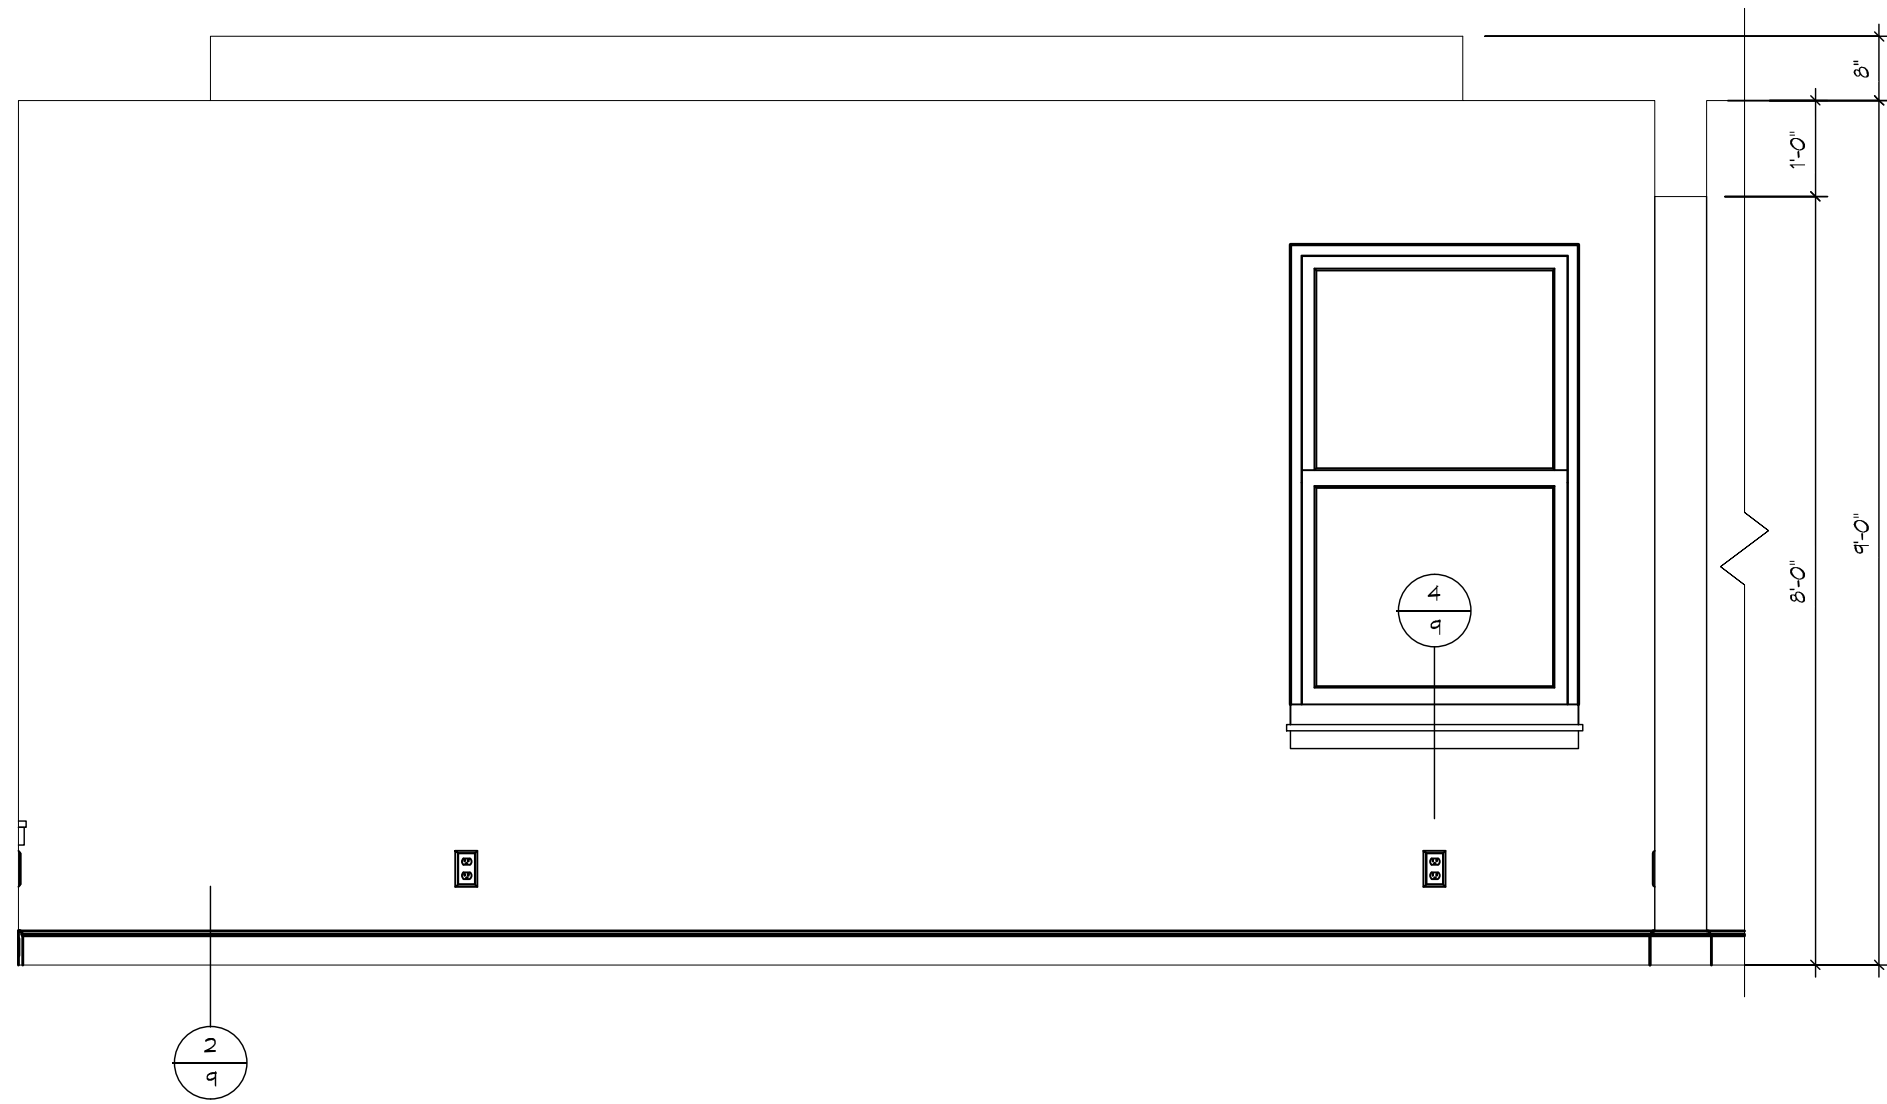


M. SUITE - "Y"
1/2" = 1'-0"

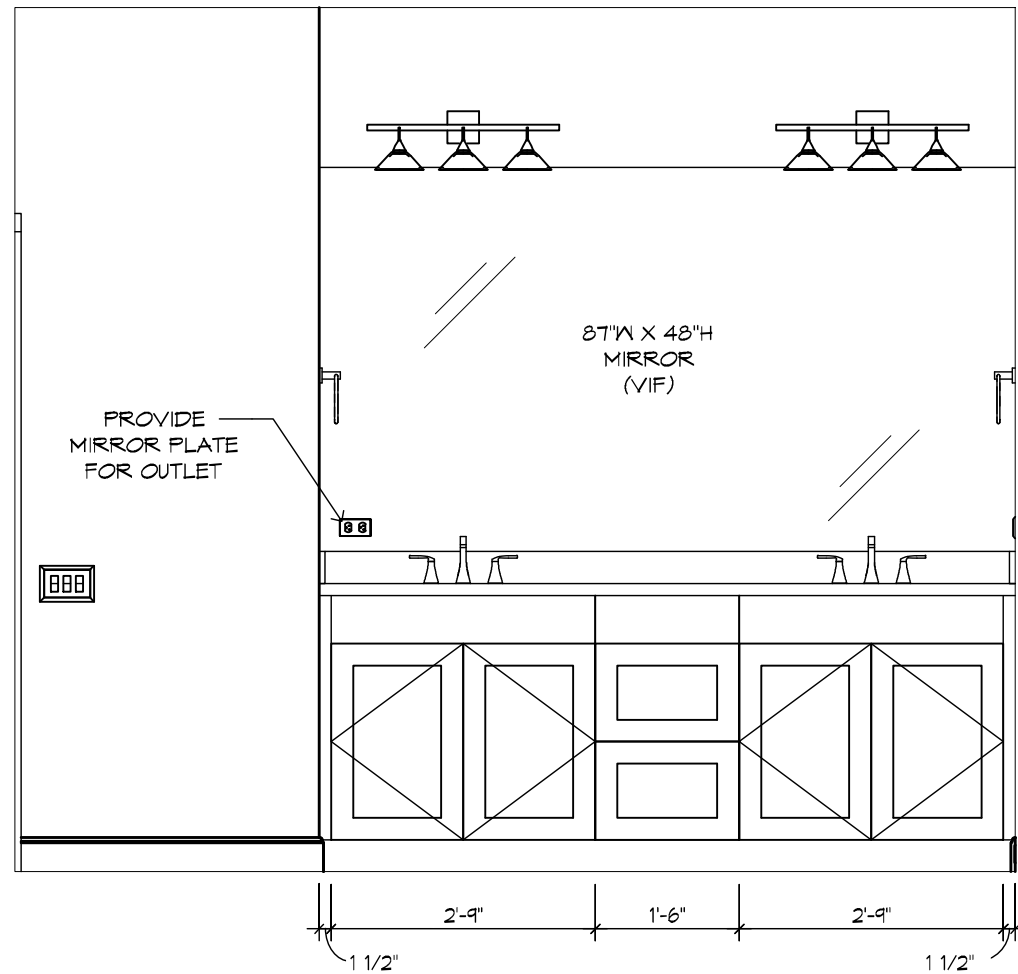


M. BATH - "Y"
1/2" = 1'-0"

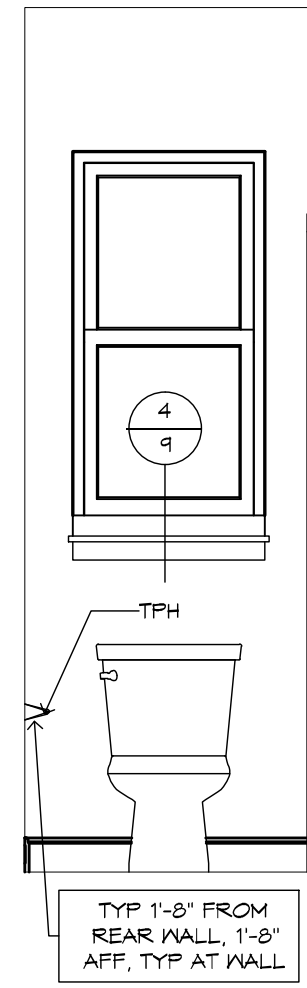


M. BATH W.C. - "Y"
1/2" = 1'-0"

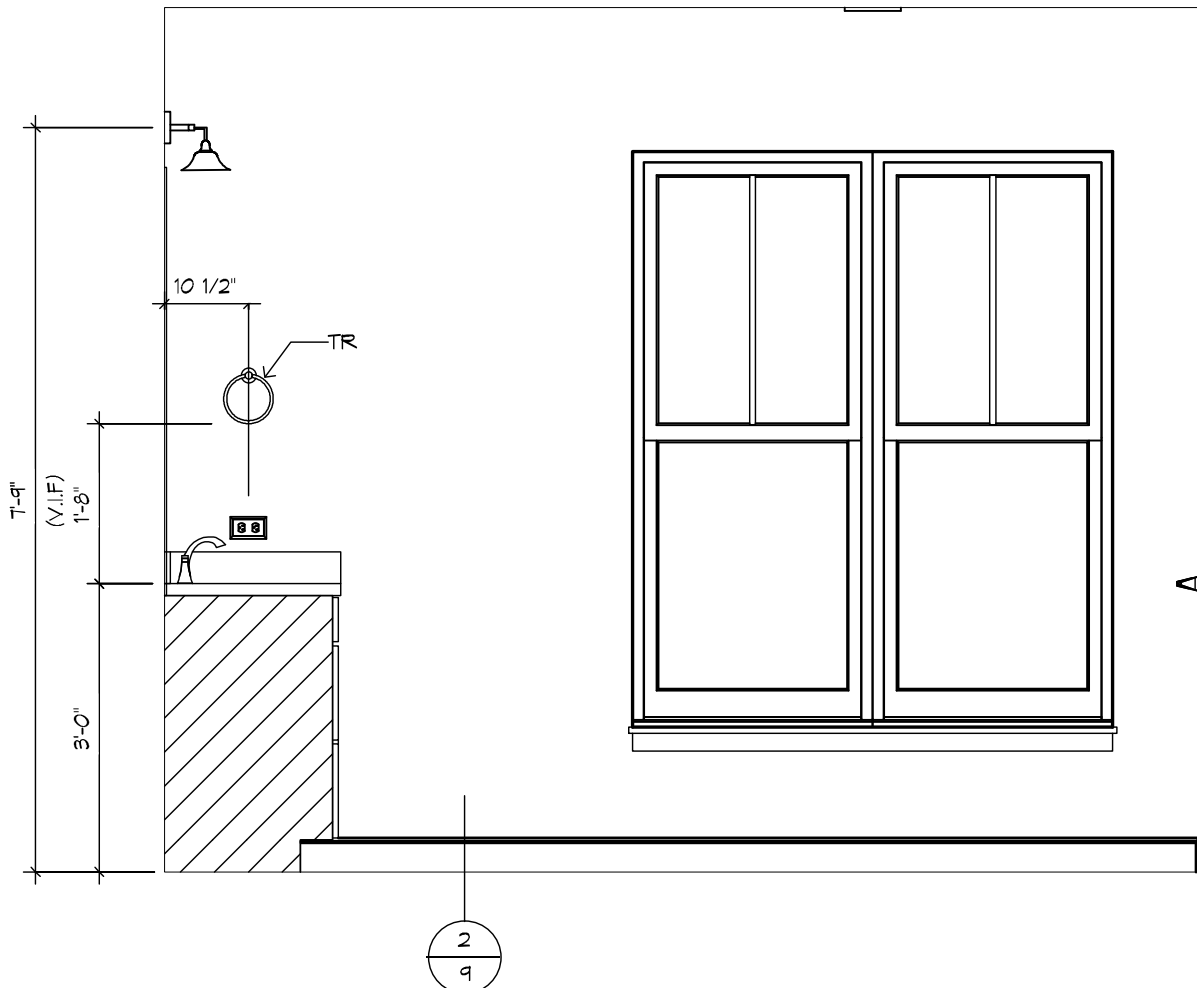


M. BATH - "Z"
1/2" = 1'-0"

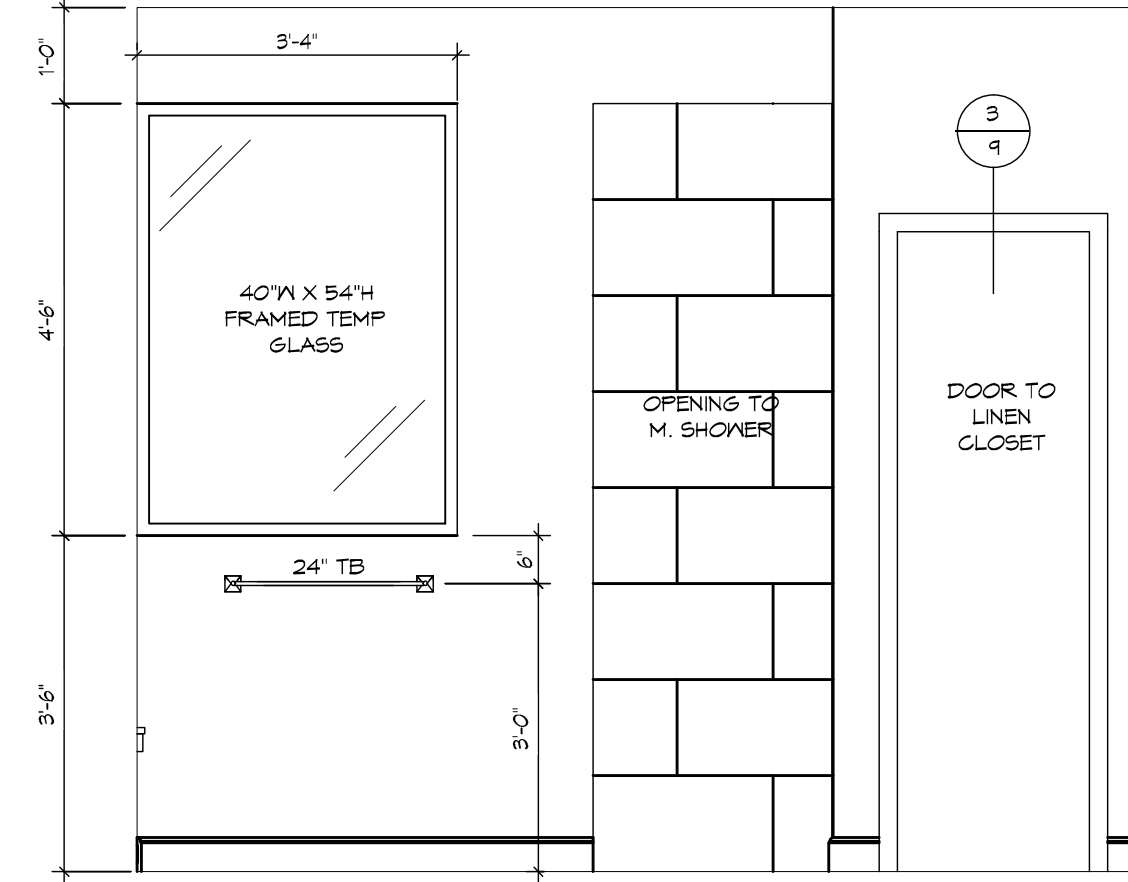


M. BATH - "W"
1/2" = 1'-0"

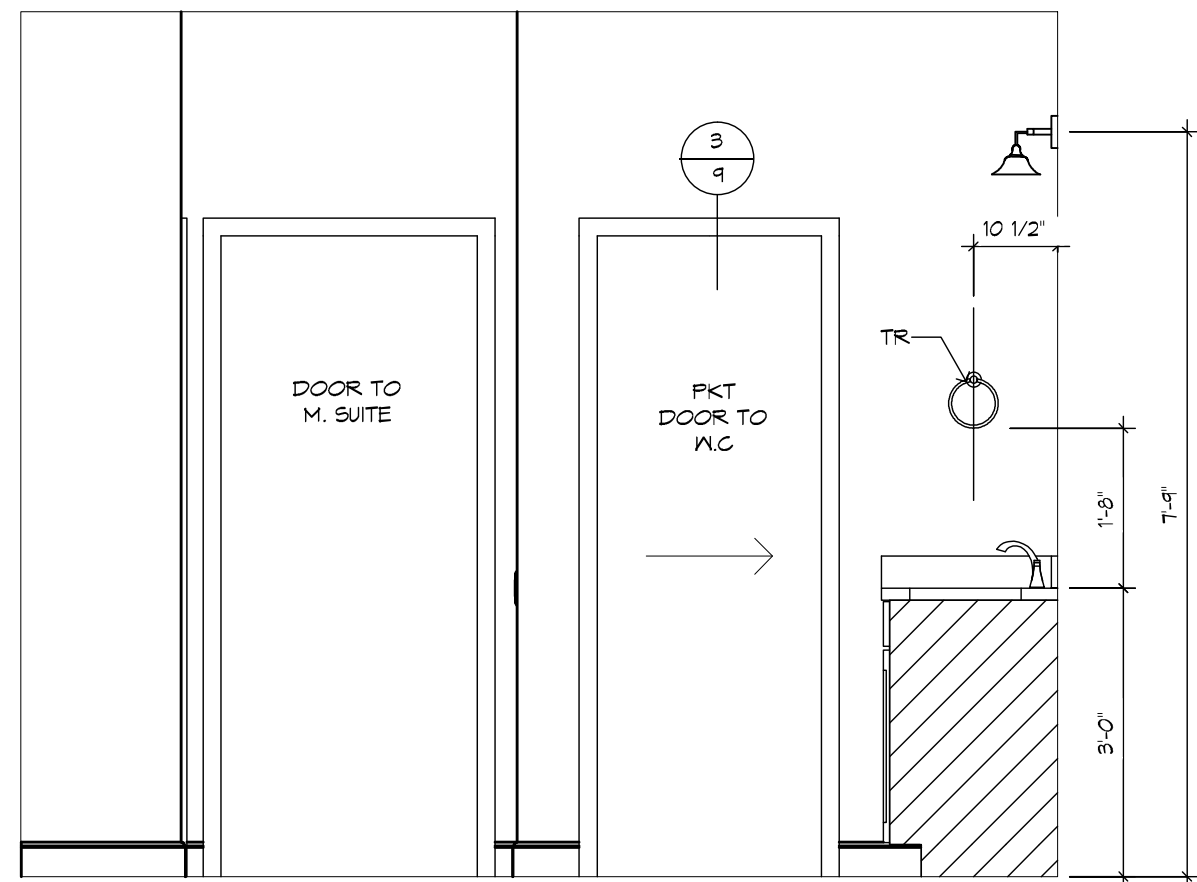


M. BATH - "X"
1/2" = 1'-0"

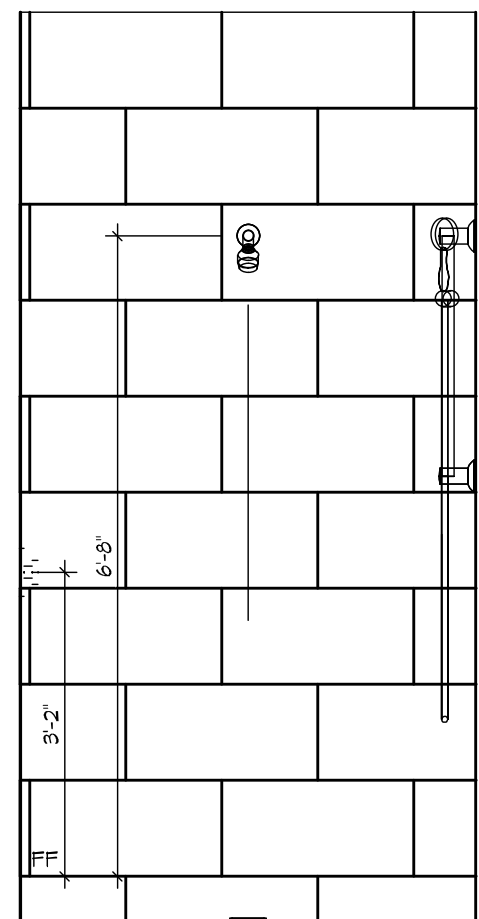


M. BATH SHOWER - "Z"
1/2" = 1'-0"

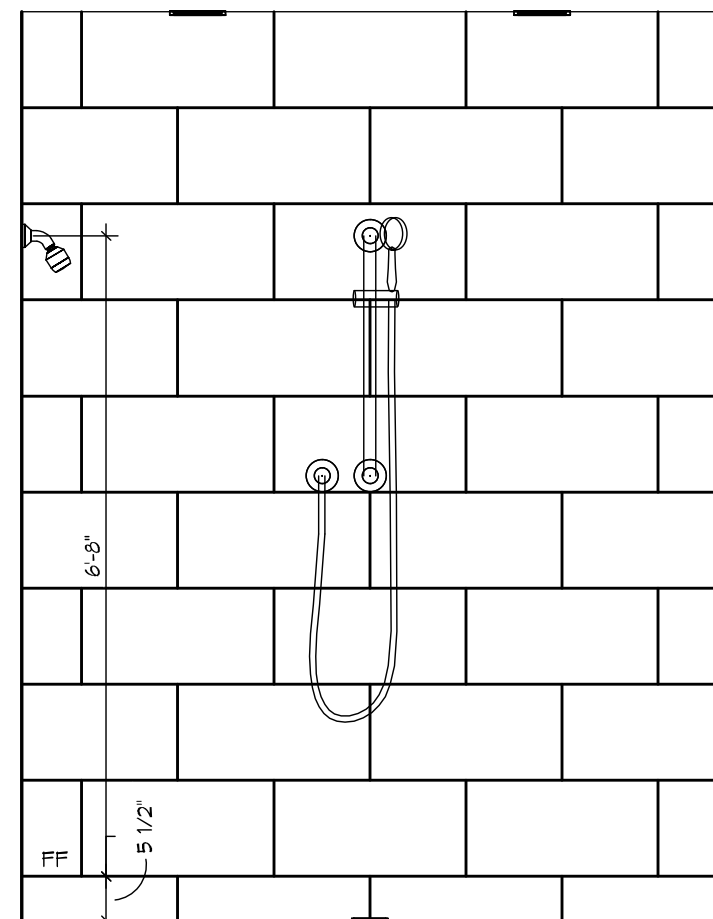


M. BATH SHOWER - "W"
1/2" = 1'-0"

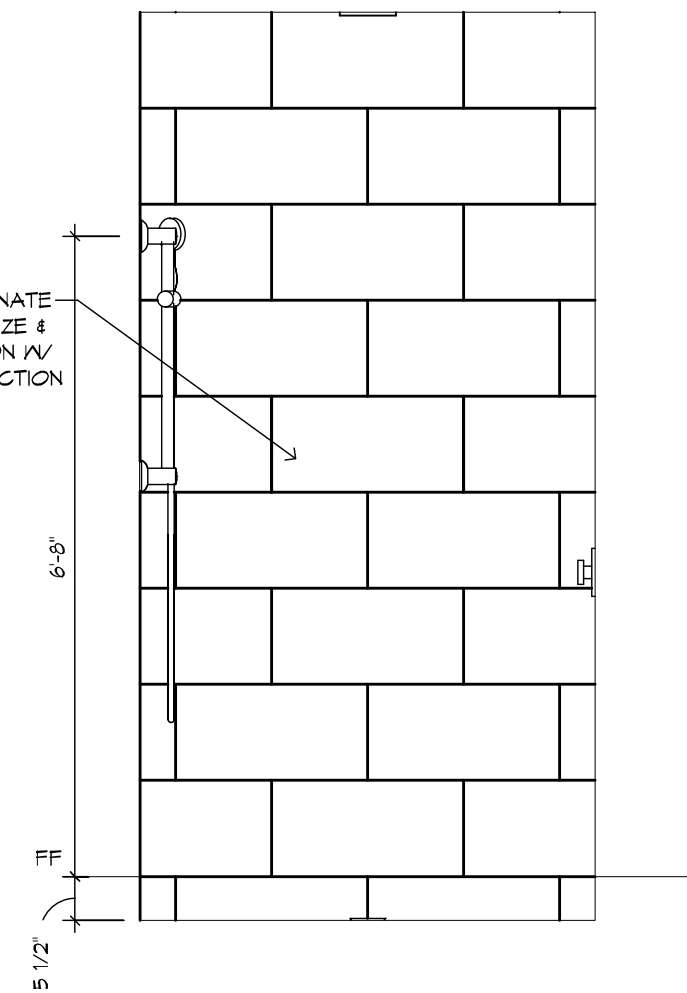


M. BATH SHOWER - "X"
1/2" = 1'-0"

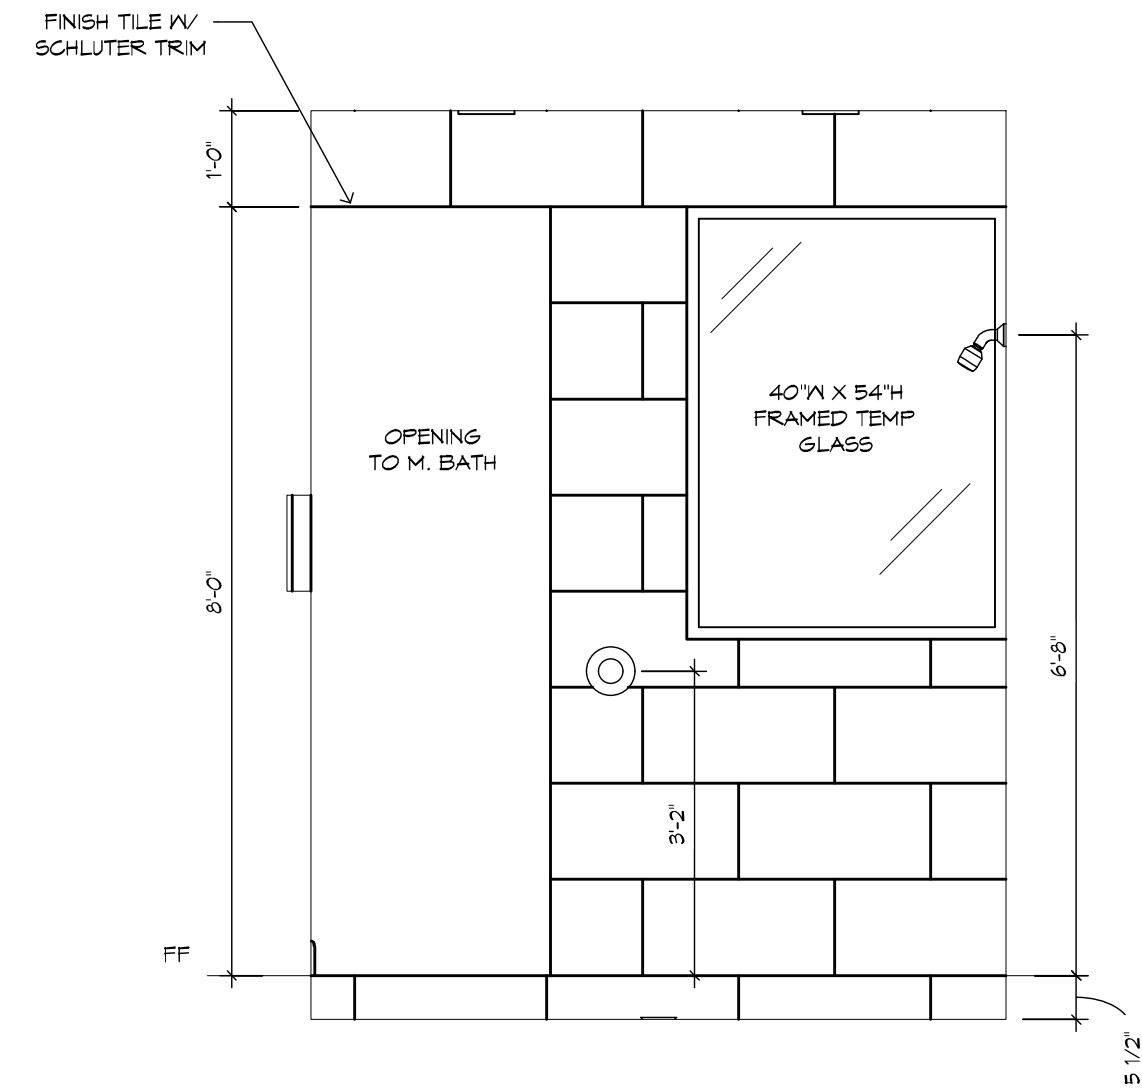


M. BATH SHOWER - "Y"
1/2" = 1'-0"

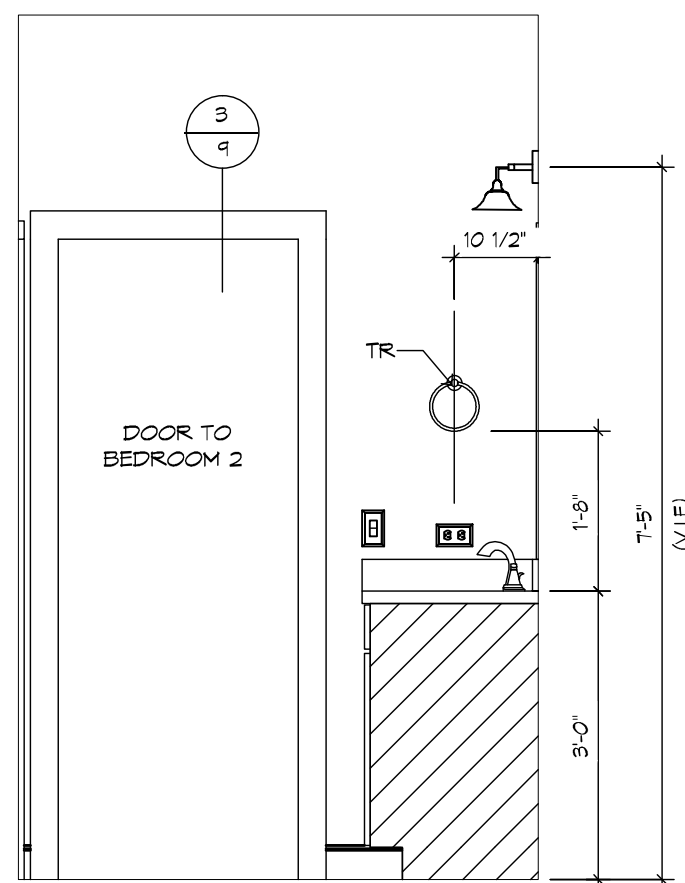


BATH 2 - "Z"
1/2" = 1'-0"

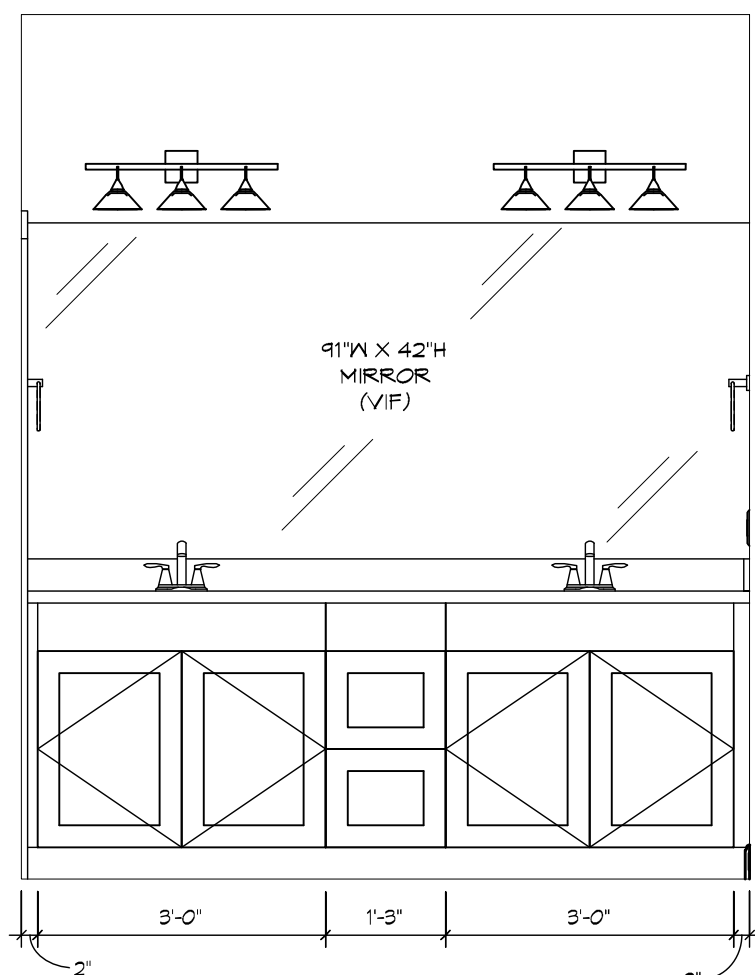


BATH 2 - "W"
1/2" = 1'-0"

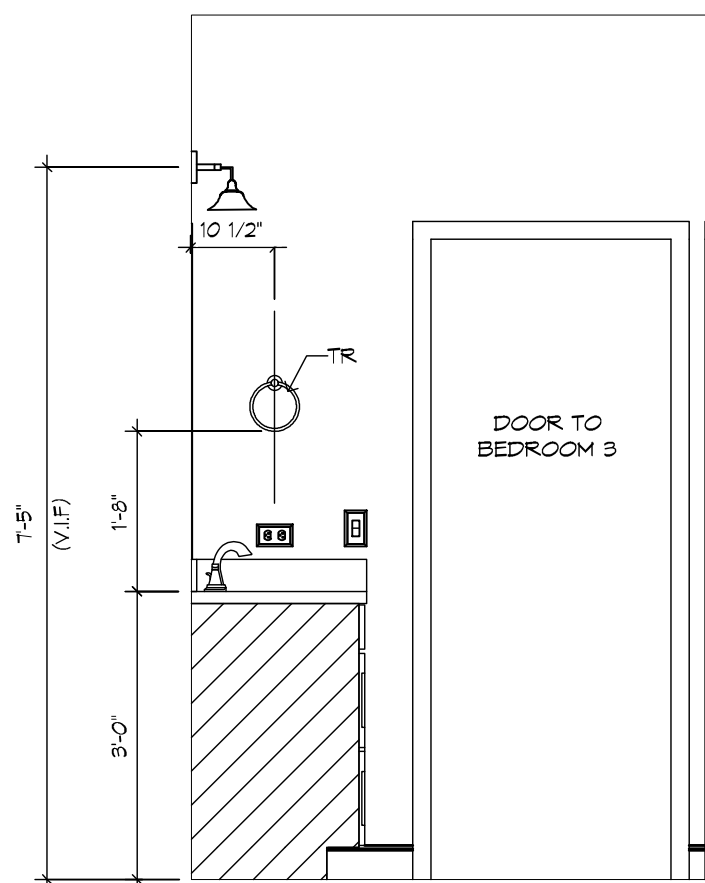


BATH 2 - "X"
1/2" = 1'-0"

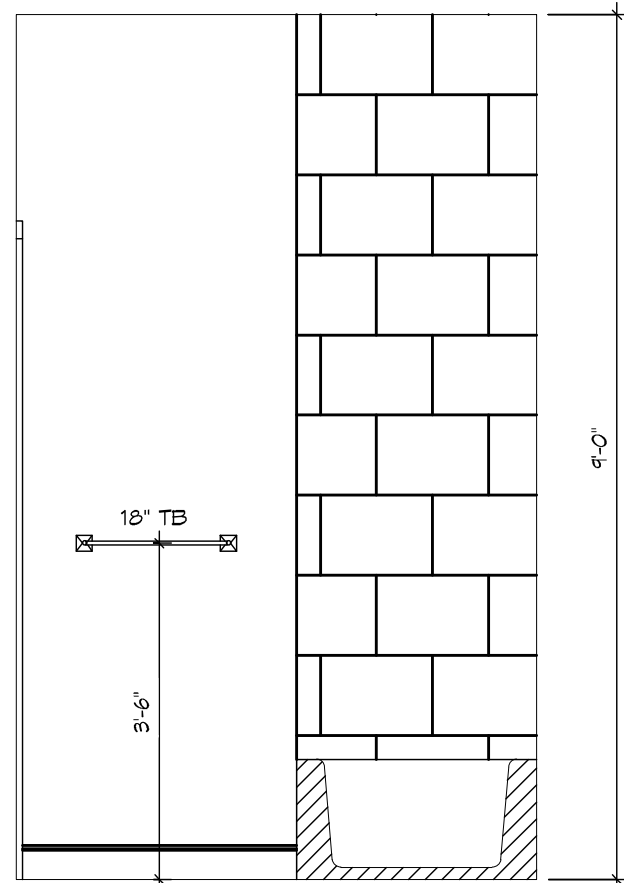


BATH 2 W.C. - "X"
1/2" = 1'-0"

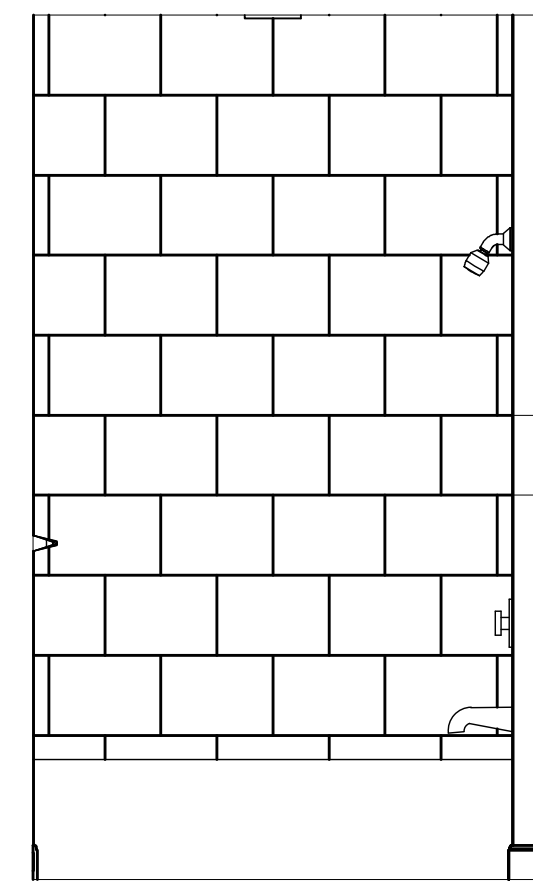



BATH 2 W.C. - "Y"
1/2" = 1'-0"

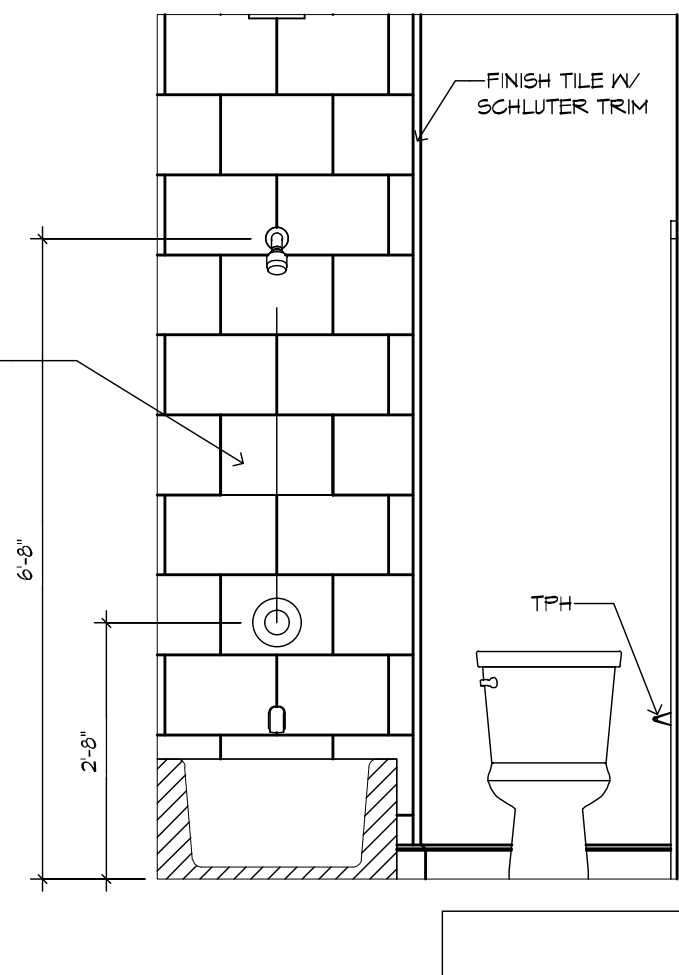

BATH 2 W.C. - "Z"
1/2" = 1'-0"

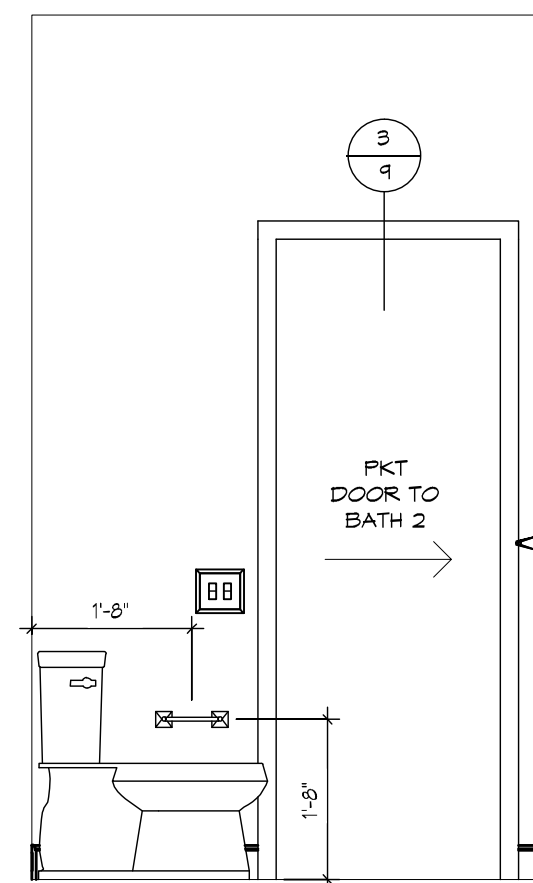

BATH 2 W.C. - "W"
1/2" = 1'-0"

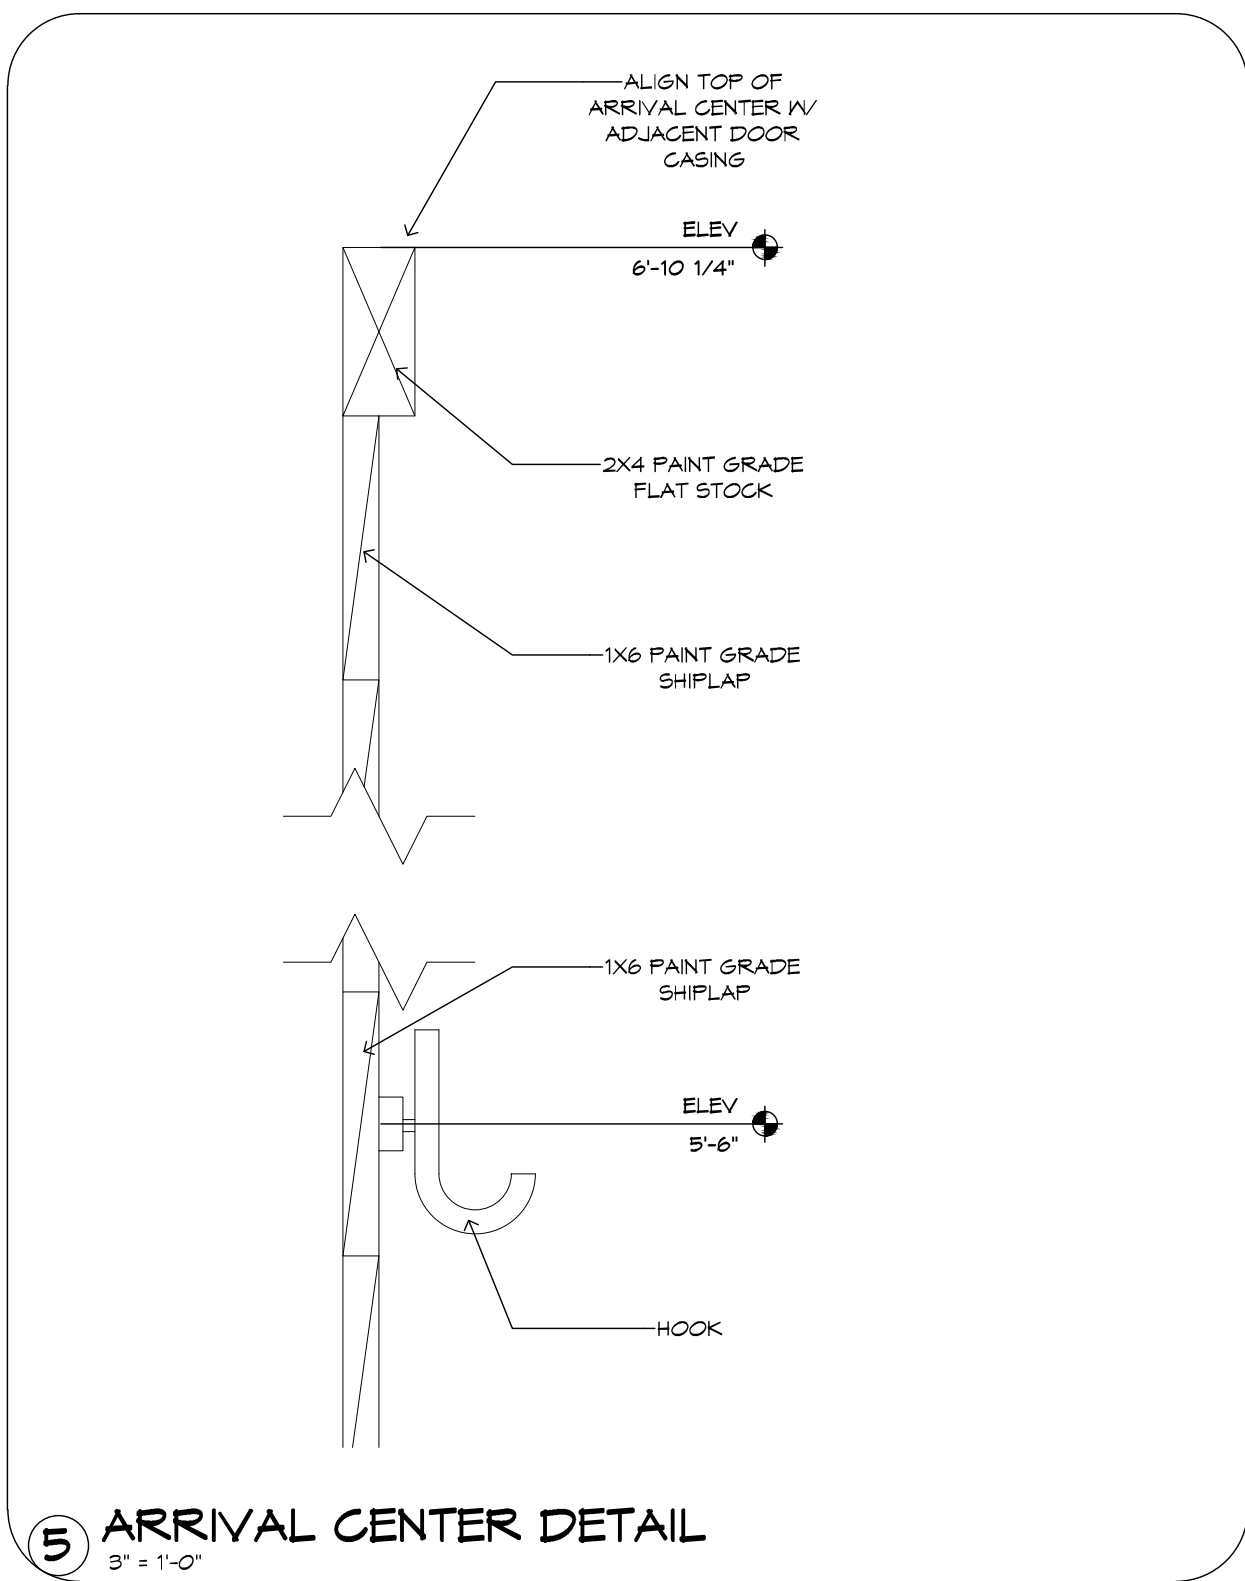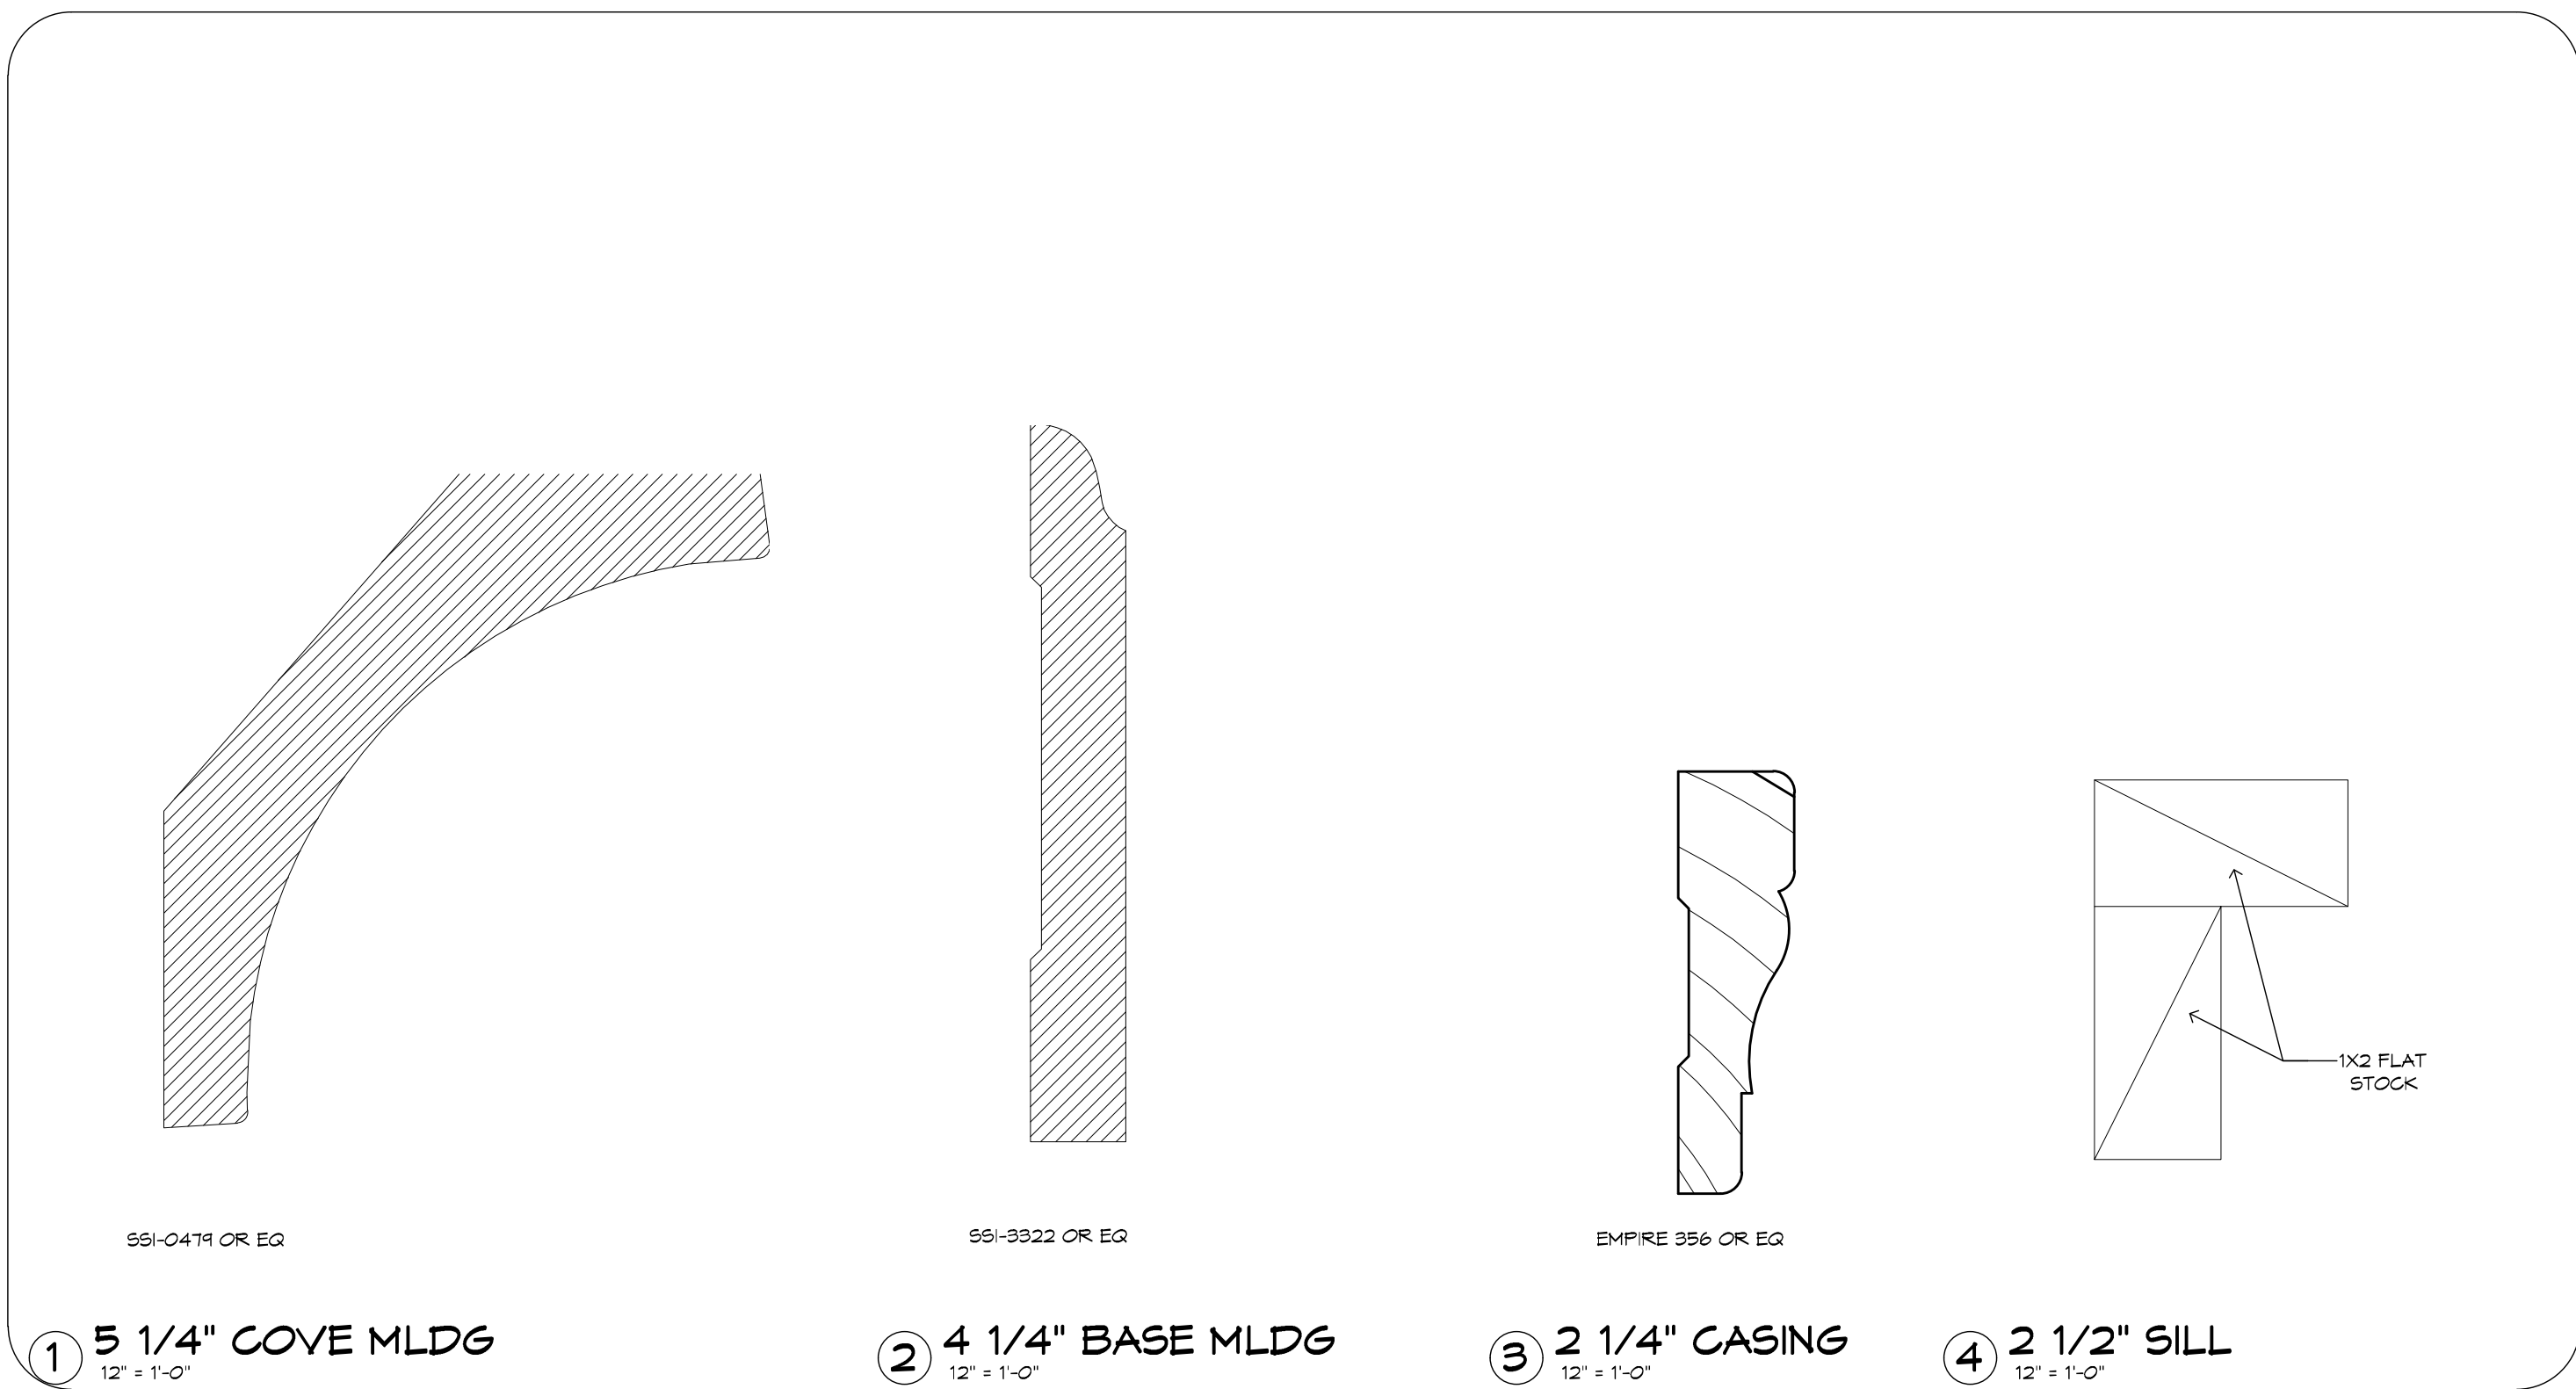

GENERAL NOTES:

CABINET ELEVATIONS AND LIGHTING ARE GRAPHIC REPRESENTATIONS ONLY. REFERENCE SHOULD BE MADE TO THE ELECTRICAL SHEET, CABINET MFR DRAWINGS AND SPECS FOR FURTHER INFORMATION.

REFER TO CABINET SHOP DRAWINGS FOR CABINET &
VANITY TOP DIMENSIONS.

THE TOE KICK IS 4".

PLUMBING, TILE, BASE MLDG, DOOR CASING &
DECORATIVE LIGHTING & DECORATIVE MIRRORS ARE
ILLUSTRATED FOR LOCATION PURPOSES ONLY.
PLEASE REFER TO COMMUNITY STANDARDS FOR
SIZES & SPECS.