




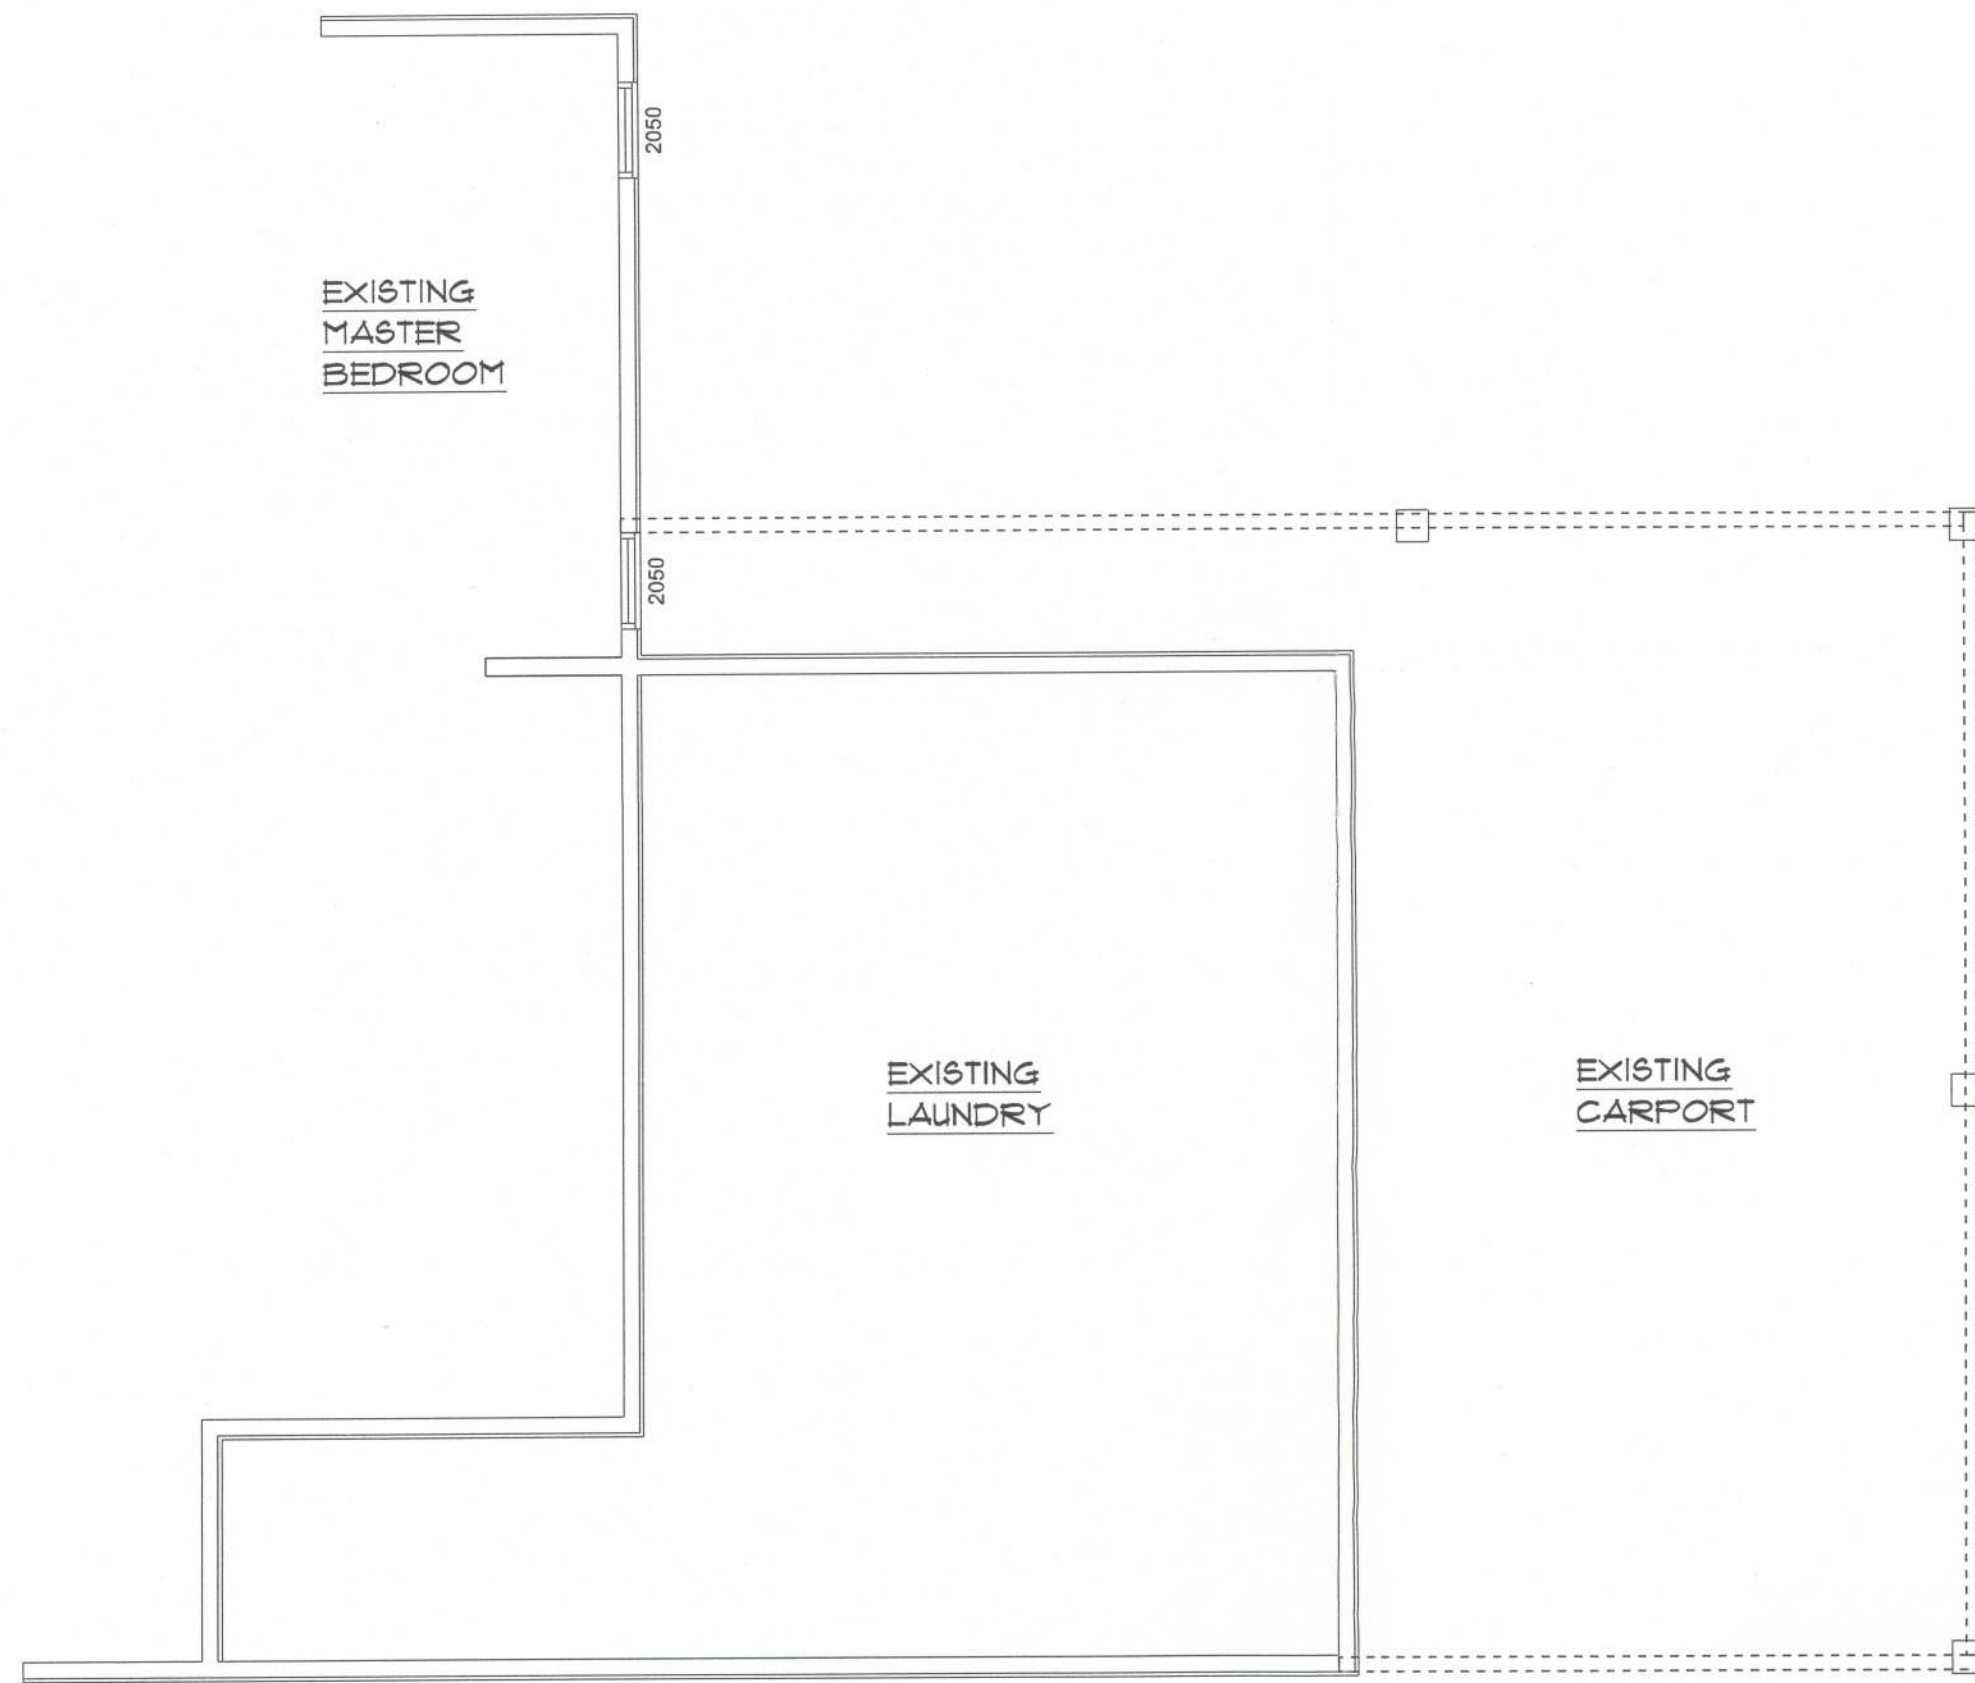


EXISTING FLOOR PLAN  
SCALE: 1/4" = 1'-0"

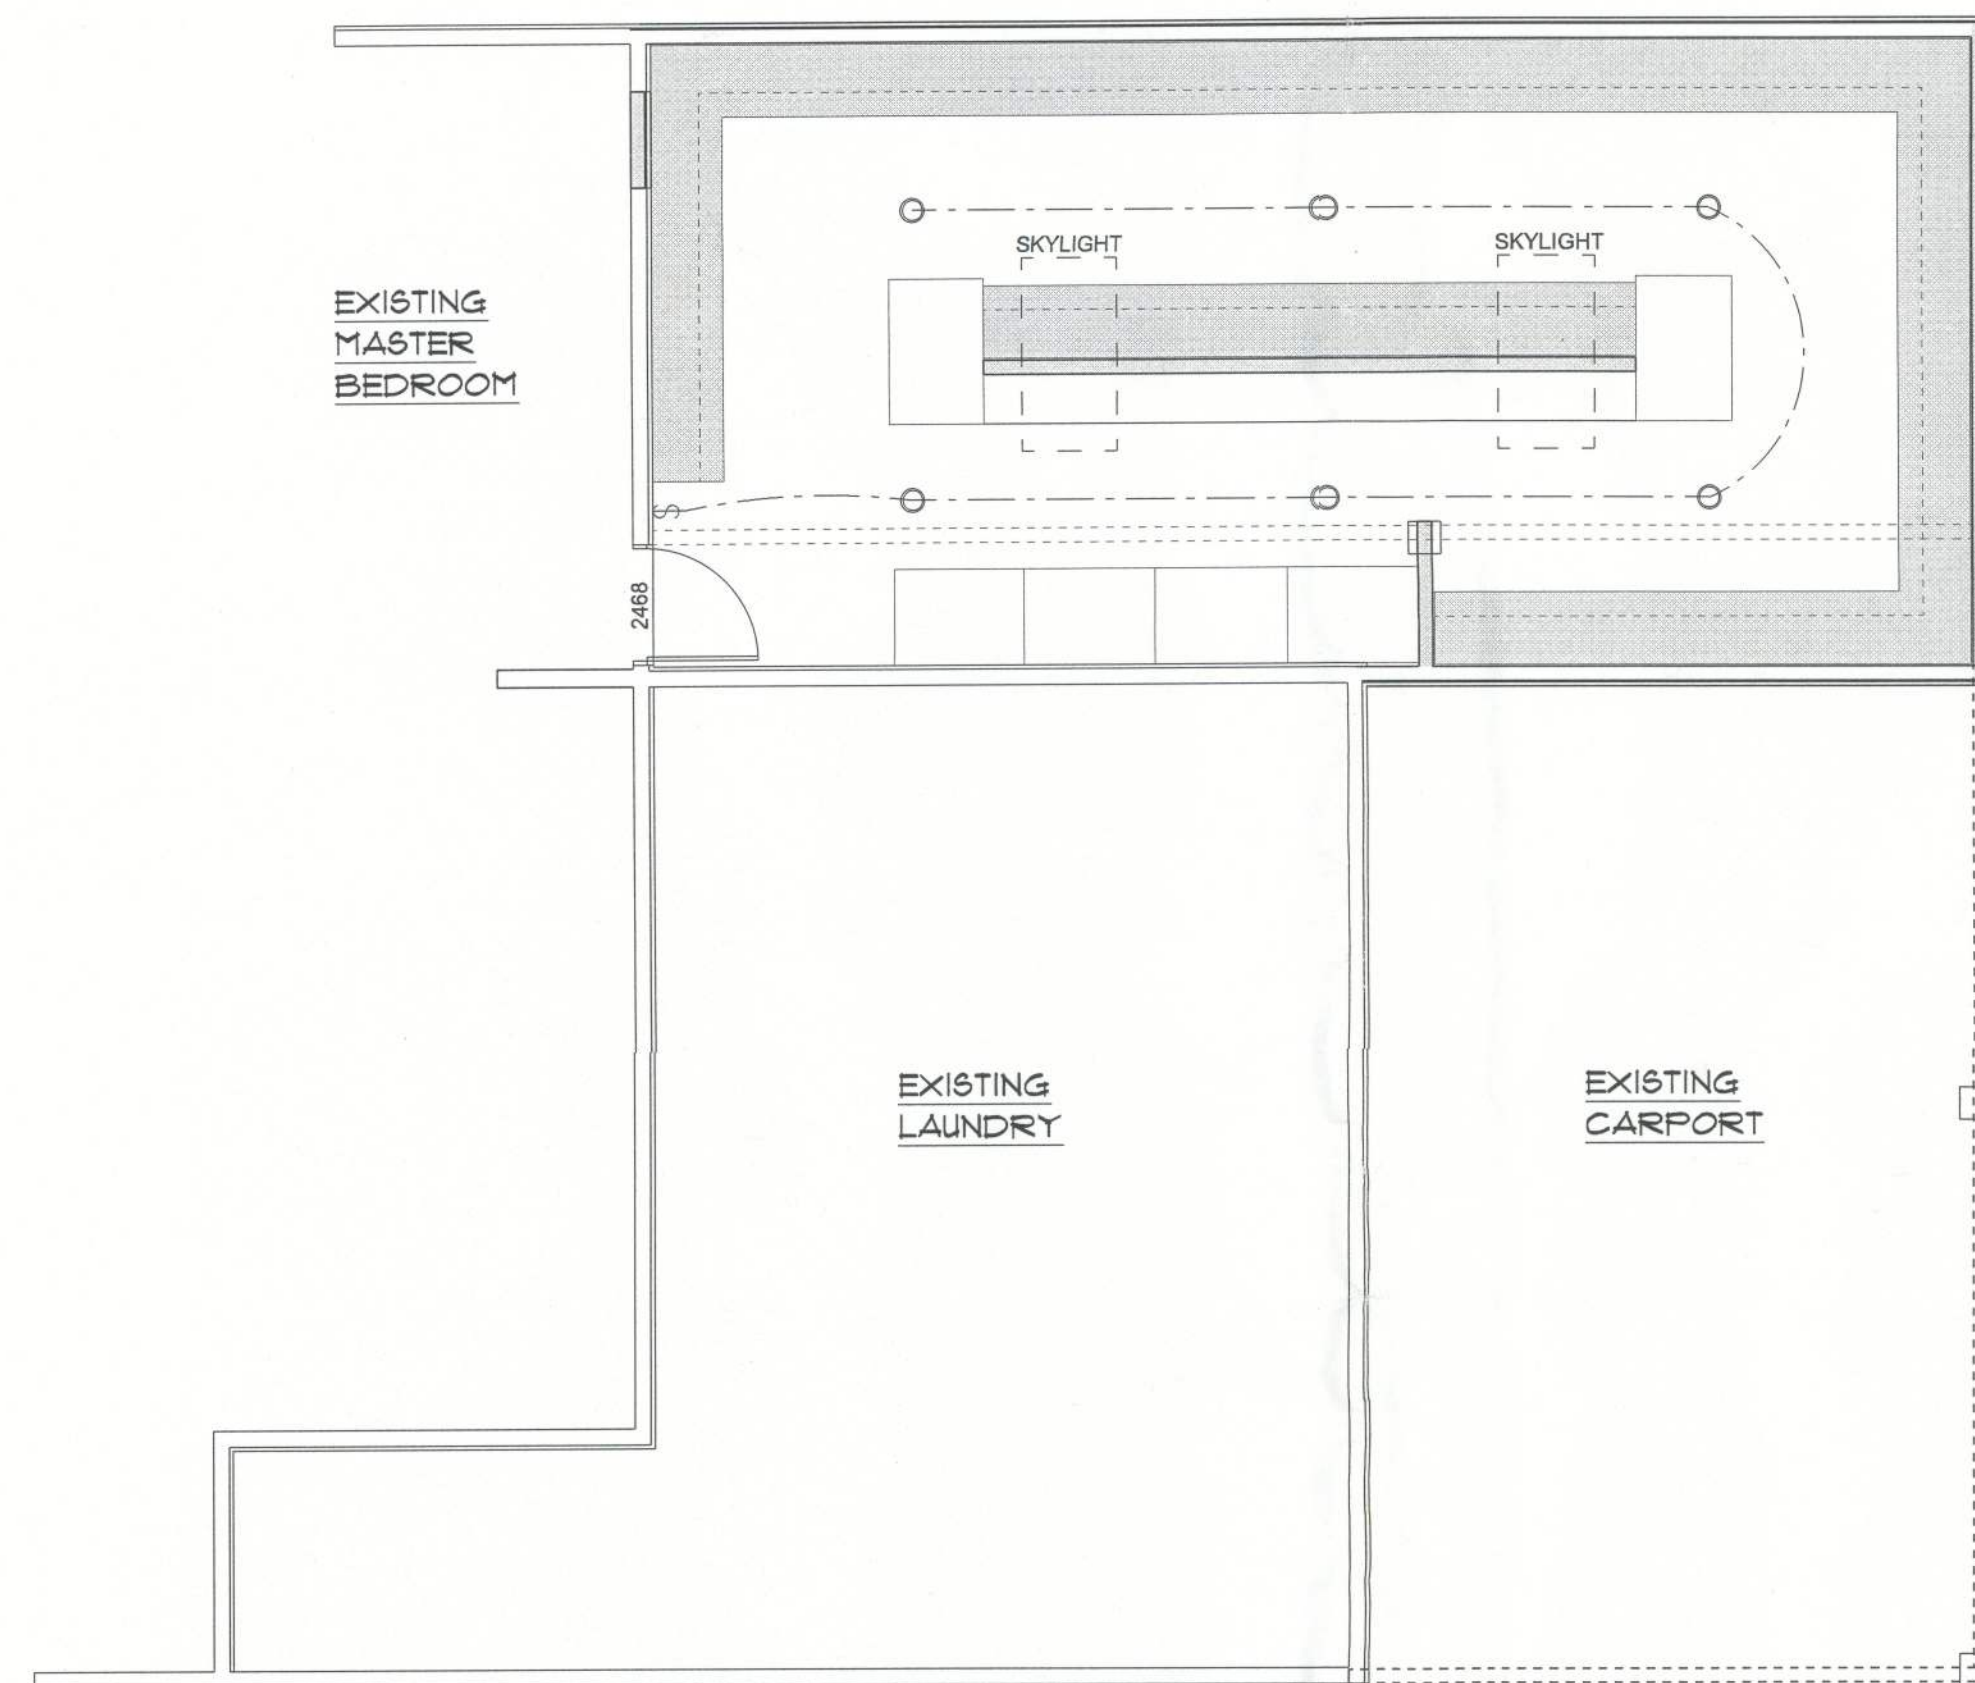


CLOSET ELECTRICAL PLAN  
SCALE: 1/4" = 1'-0"

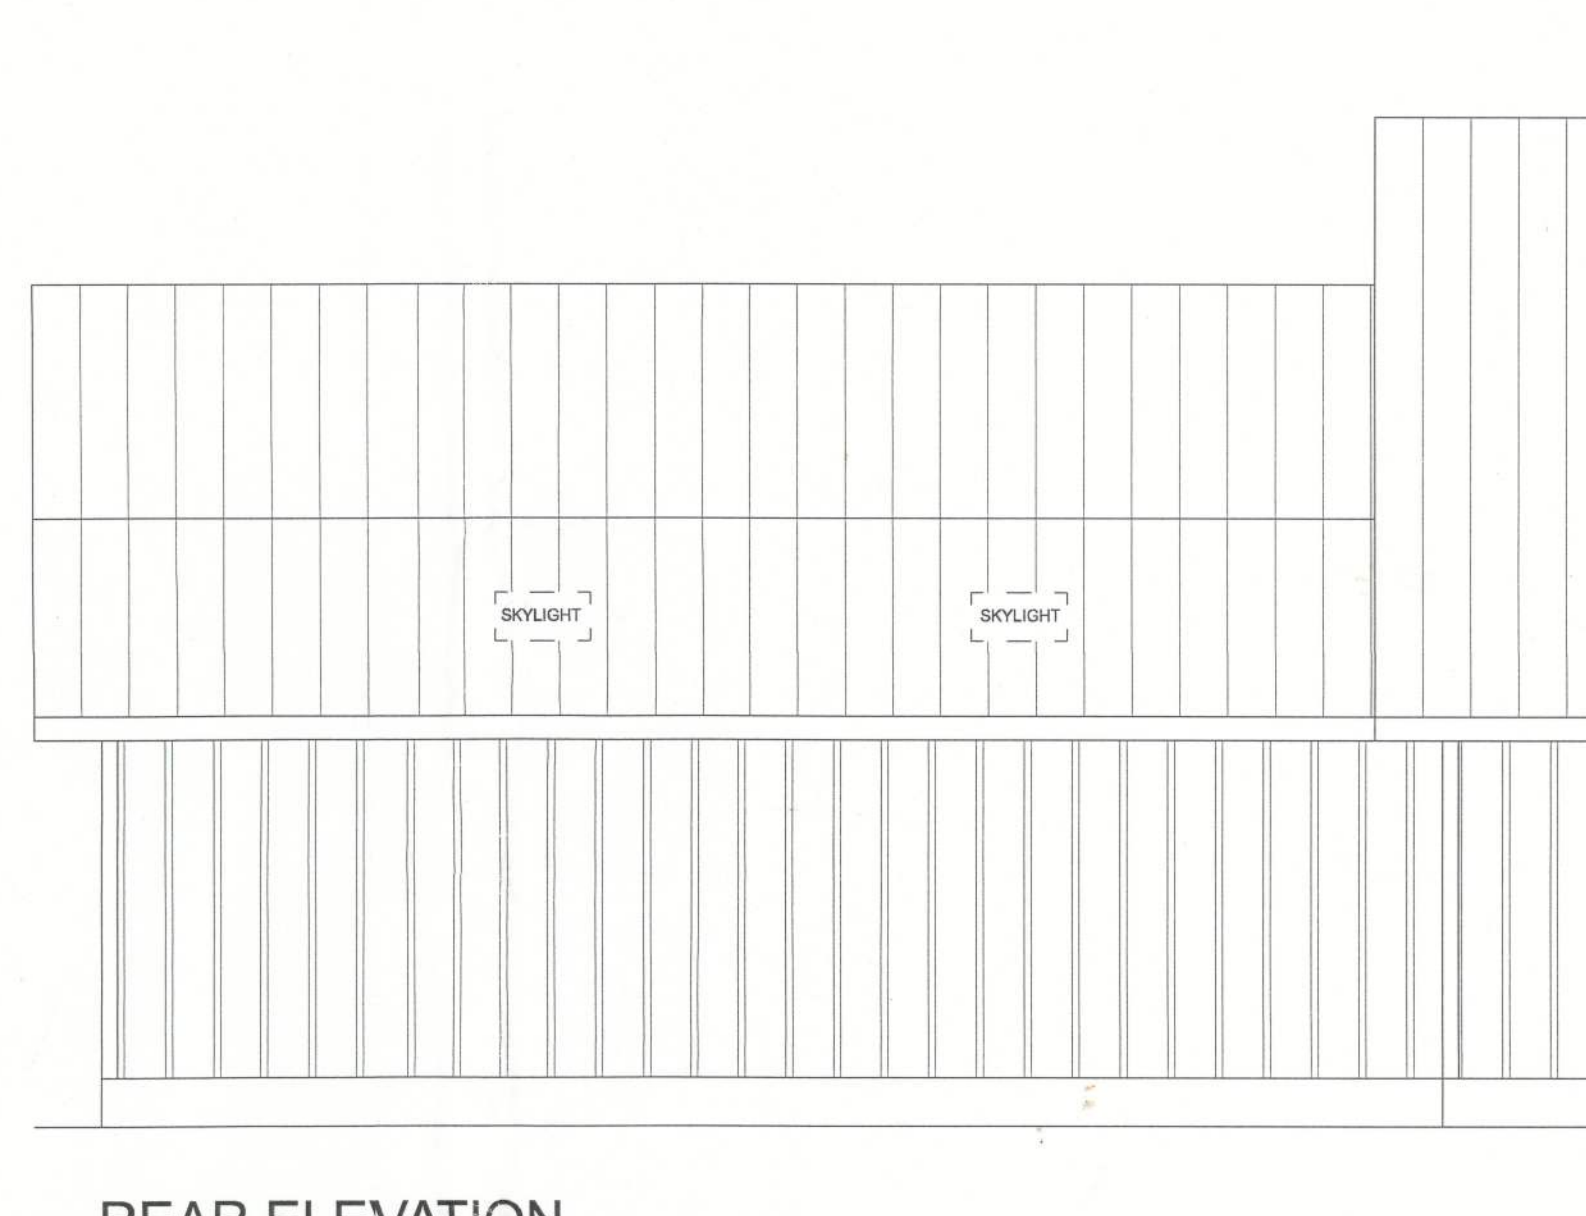

REAR ELEVATION  
SCALE: 1/4" = 1'-0"

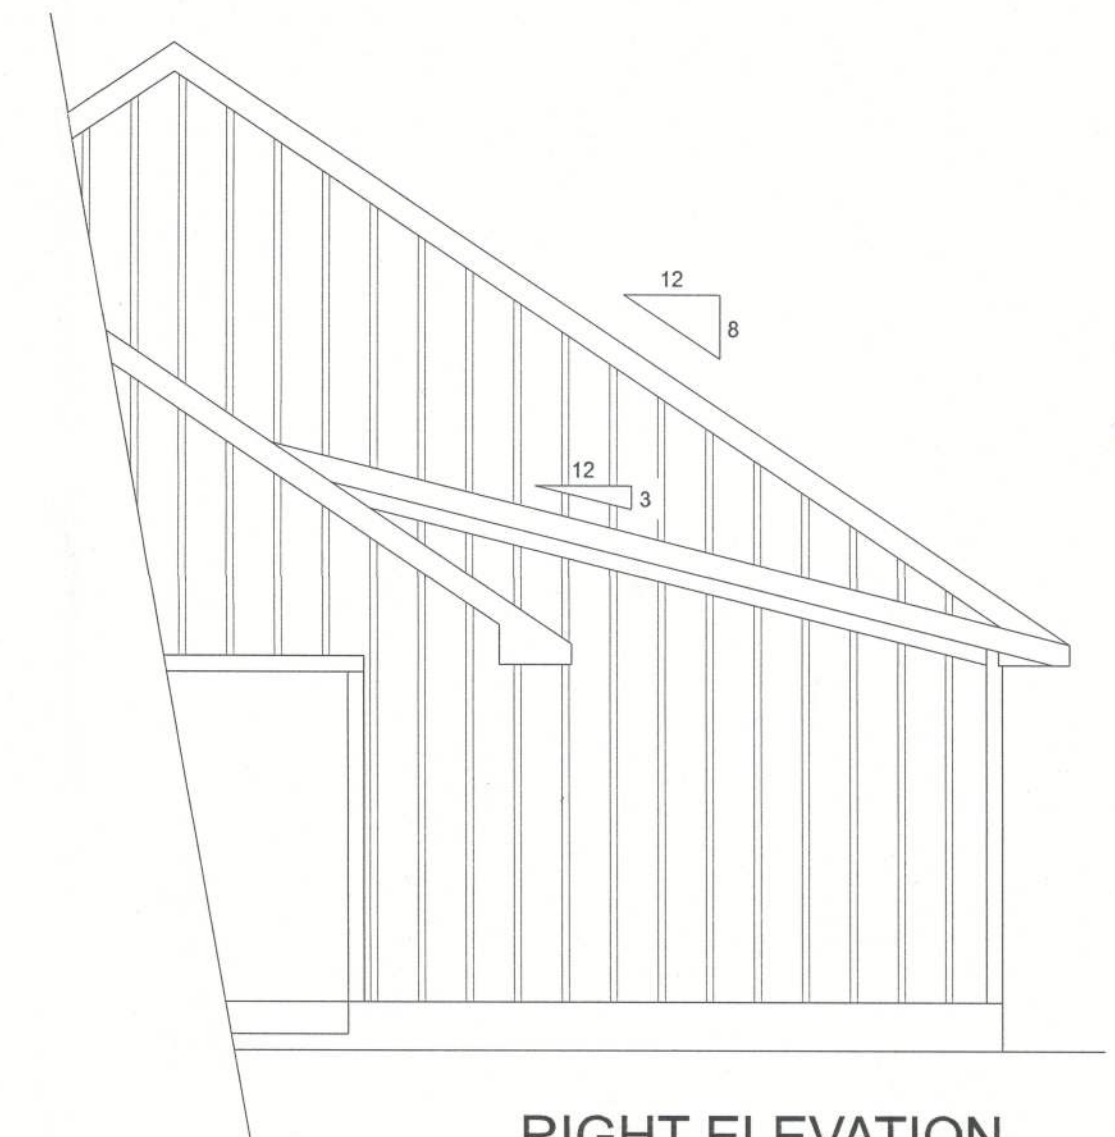

RIGHT ELEVATION  
SCALE: 1/4" = 1'-0"

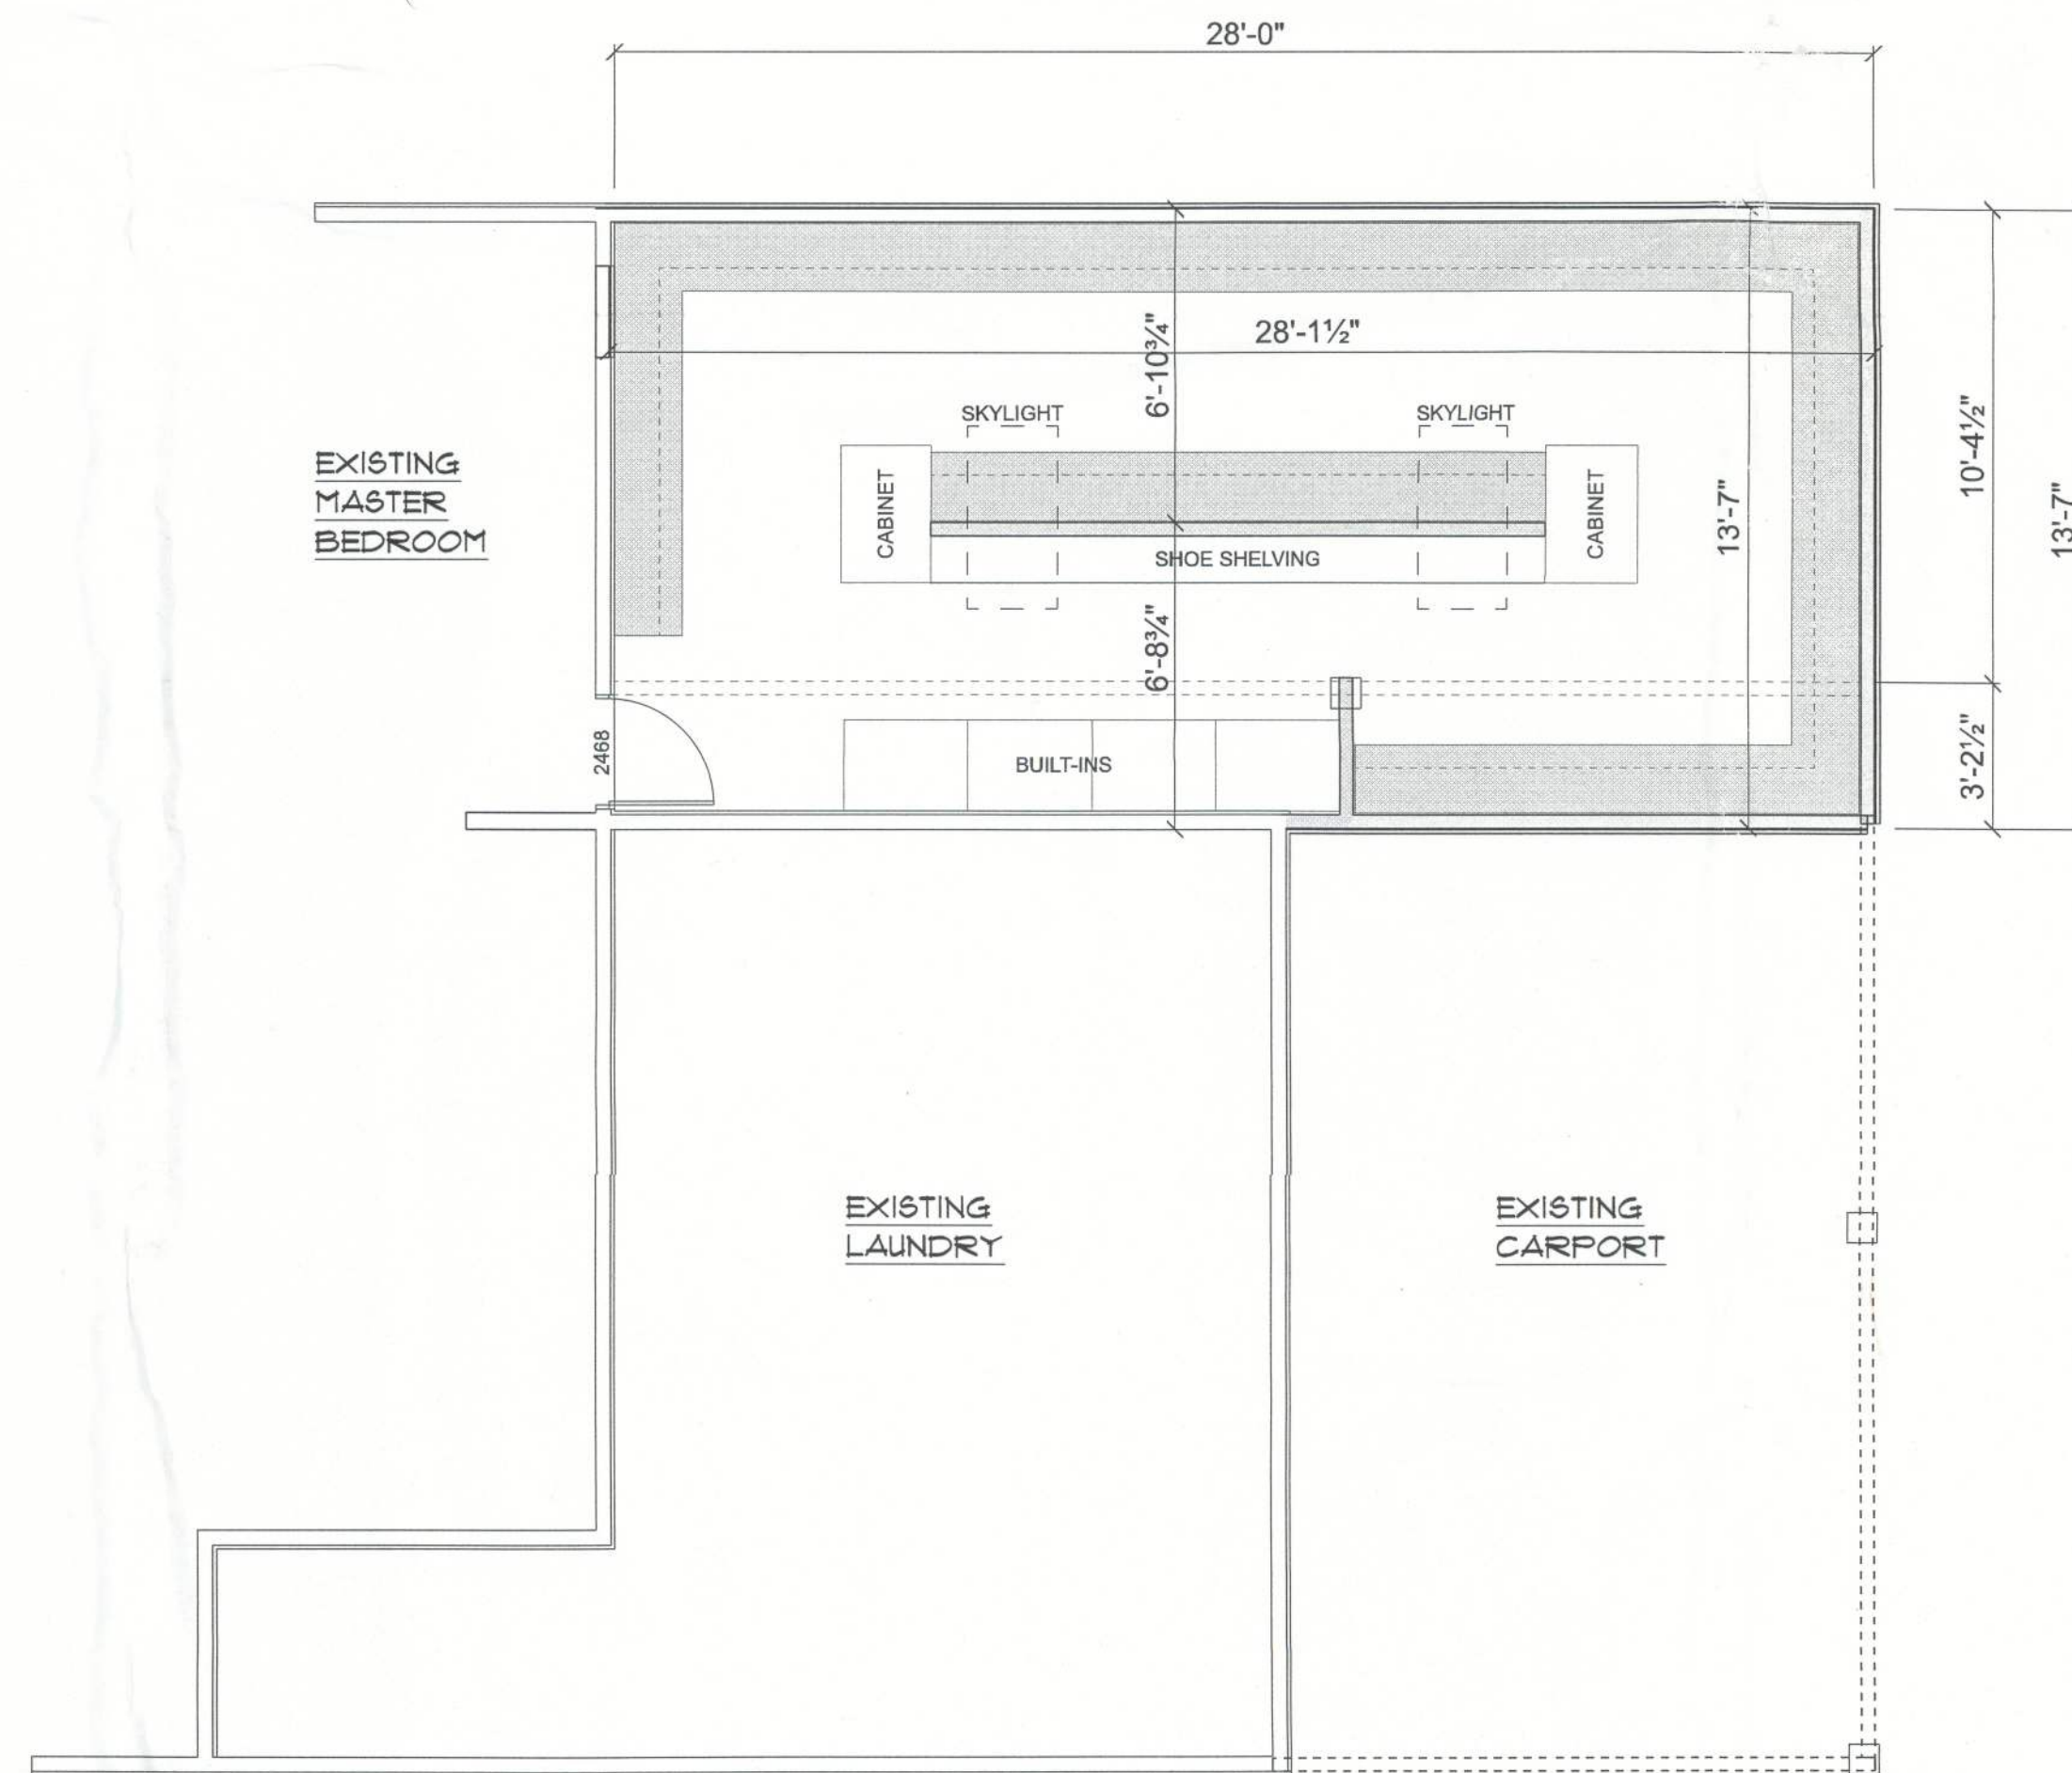

CLOSET ADDITION PLAN  
SCALE: 1/4" = 1'-0"



50190

Existing Home Renovations For:

GREG & JUDY DENT RESIDENCE  
COLUMBIA COUNTY, FLORIDA



566 SW ARLINGTON BLVD, STE 101, LAKE CITY, FL 32025  
P: 386-288-1188  
E: RIDGEPOINTDESIGN@GMAIL.COM

SHEET NUMBER  
A.1  
OF 7 SHEETS