


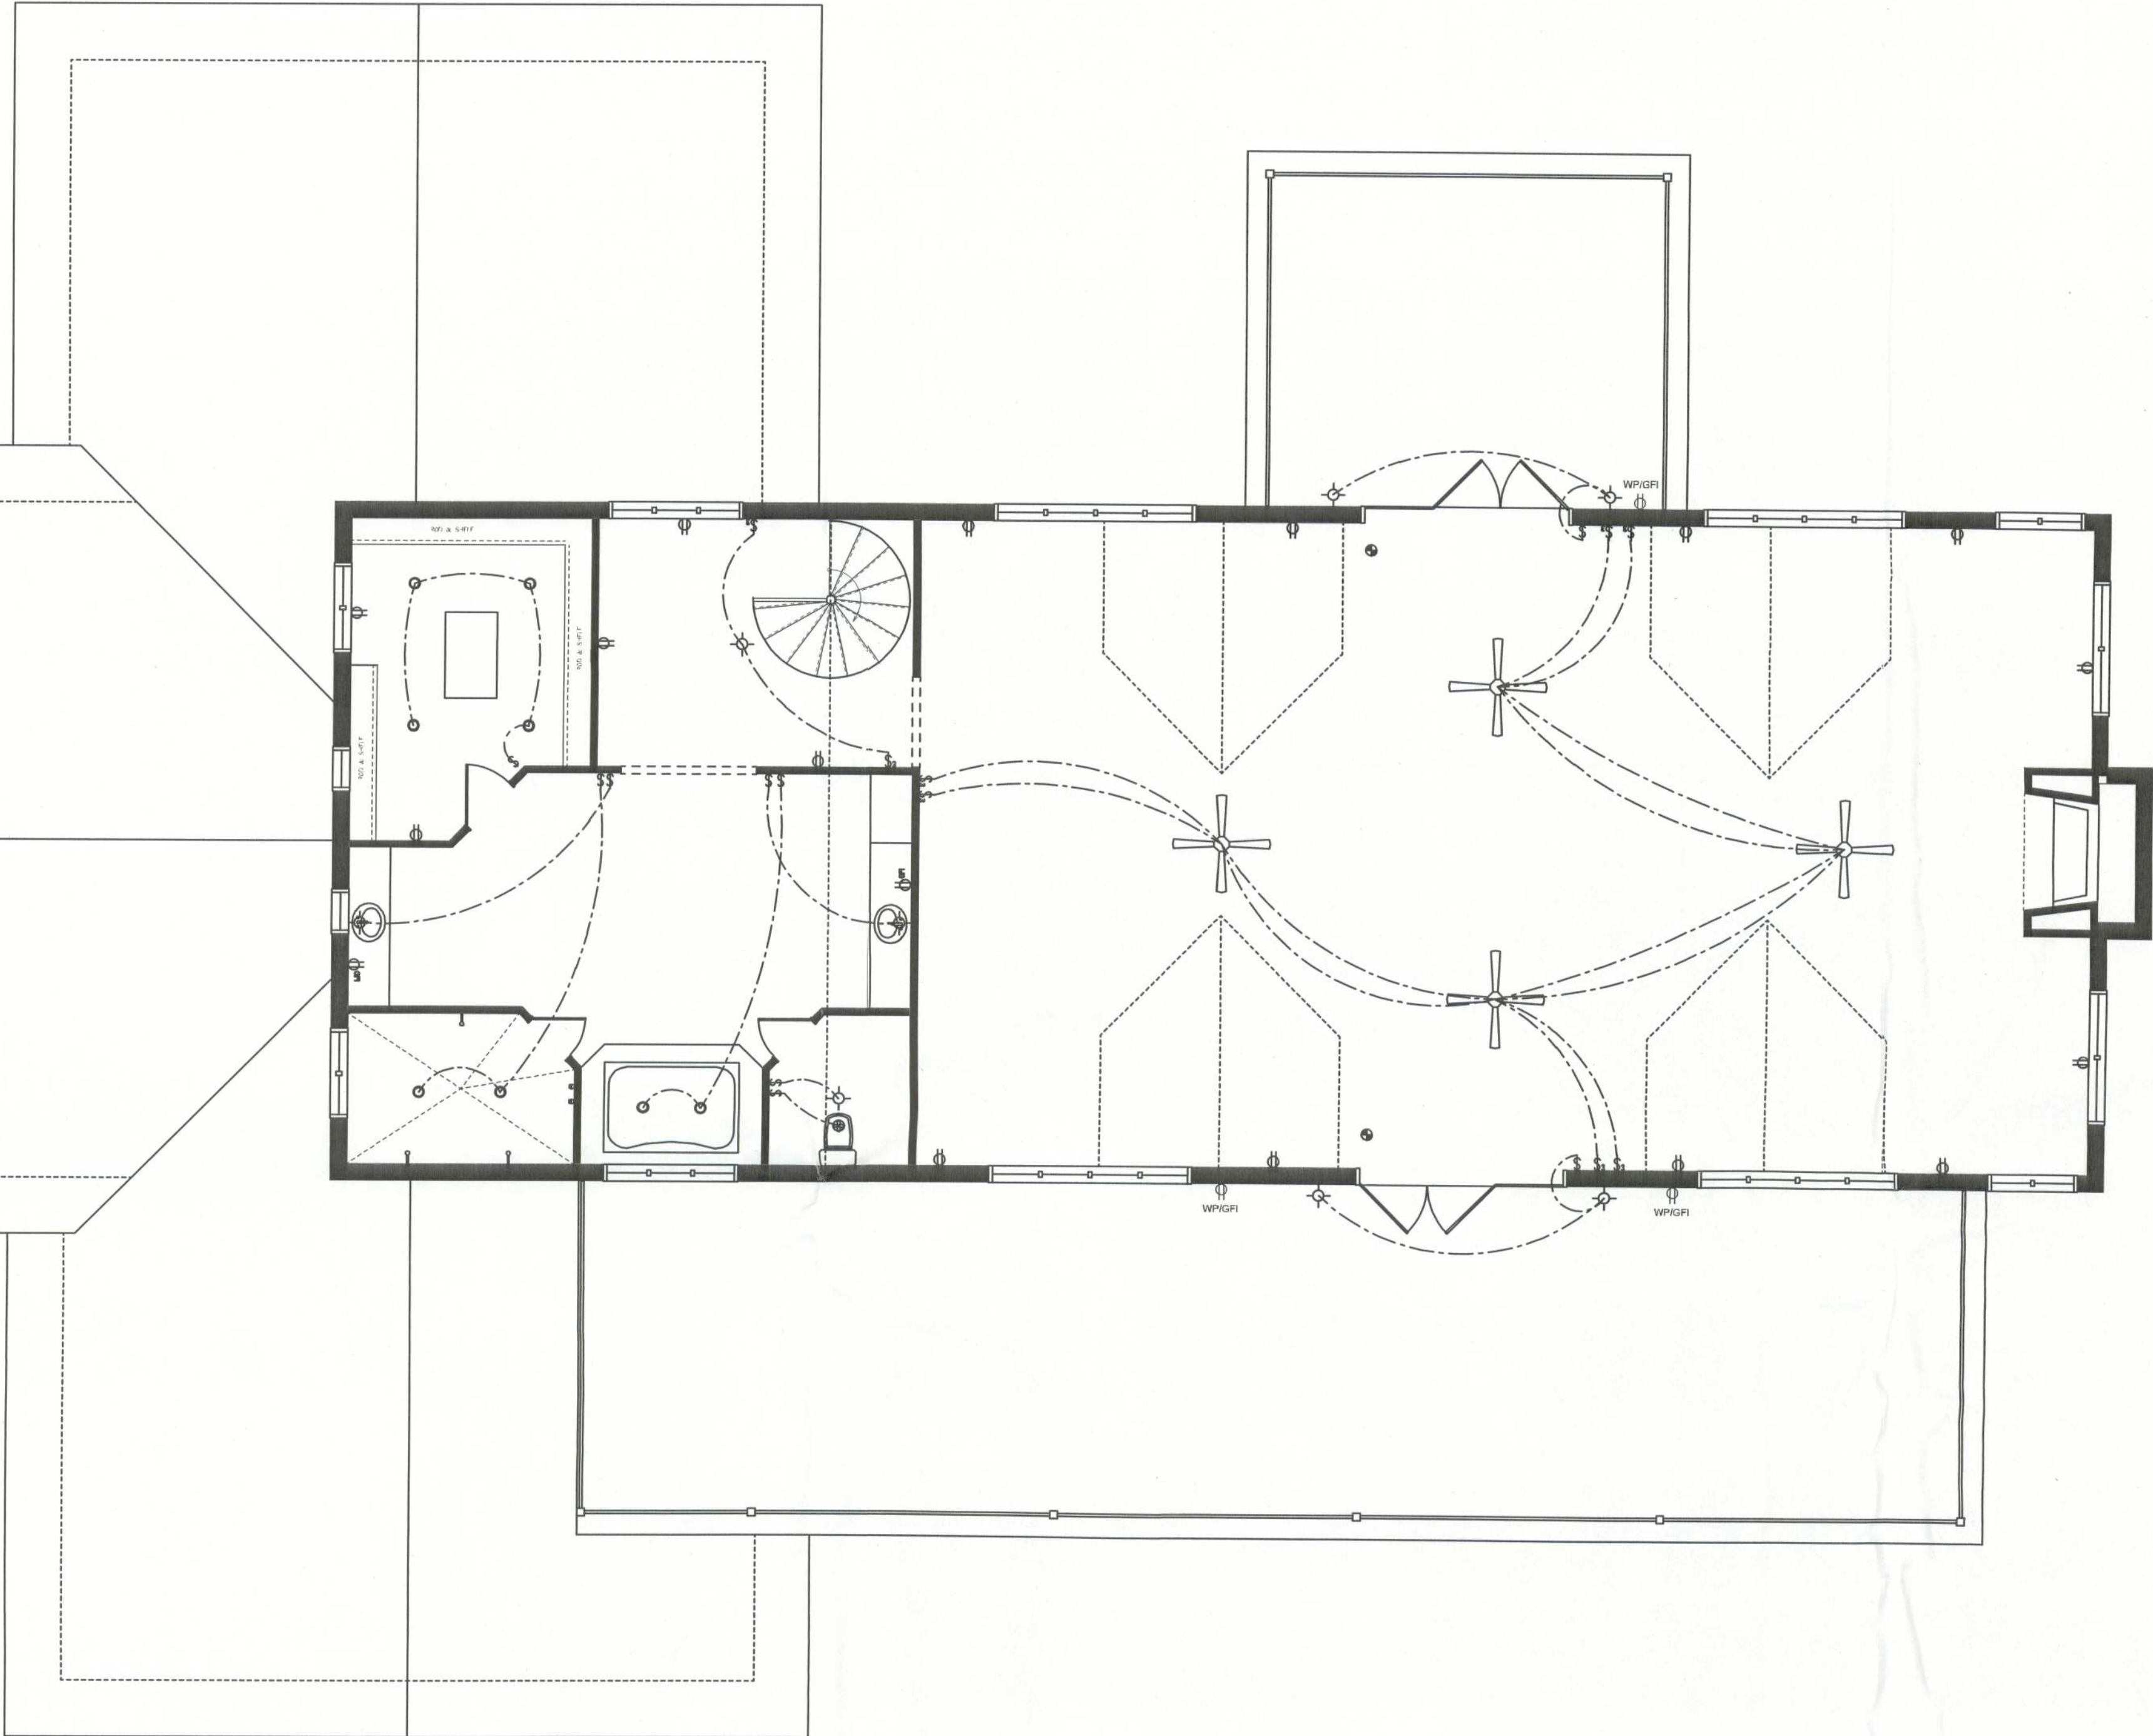

ELECTRICAL LEGEND	
	CEILING FAN (PRE-WIRE FOR LIGHT KIT)
	DOUBLE SECURITY LIGHT
	RECESSED CAN LIGHT
	BATH EXHAUST FAN
	LIGHT FIXTURE
	DUPLEX OUTLET
	220v OUTLET
	GFI DUPLEX OUTLET
	SMOKE DETECTOR (see note below)
	WALL SWITCH
	3 WAY WALL SWITCH
	WATER PROOF GFI OUTLET
	2 OR 4 TUB FLUORESCENT FIXTURE

NOTE:
ALL BEDROOM RECEPTACLES SHALL BE AFCI
(ARC FAULT CIRCUIT INTERRUPT)

ALL SMOKE DETECTORS SHALL HAVE BATTERY BACKUP POWER
AND ALL WIRED TOGETHER SO IF ANY ONE UNIT IS ACTUATED THEY
ALL ACTIVATE.

NOTE!
UFER grounding required per N.E.C.
Arc fault breakers required per N.E.C.
GFCI breakers required per N.E.C.
Tamper resistant recepricies required per N.E.C.

ELECTRICAL PLAN
SCALE: 3/16" = 1'-0"
NOTE: VERIFY ALL EXISTING ELECTRICAL!

REVISIONS SCHEDULE	
March 12, 2010	ORIGINAL DRAWINGS

A CUSTOM REMODEL FOR:

JEFF & LINDA GANSKOP

SOUTH WOOD ACRES, LAKE CITY, FLORIDA 32024

JONATHAN MORRIS DRAFTING SERVICES

263 SW 17TH AVE.
LAKE CITY, FL 32009
(386) 466-7338
jmorris@att.net