


REVISIONS

SOFTPLAN
ARCHITECTURAL DESIGN SOFTWARE

ELECTRICAL	COUNT	SYMBOL
12 x 48 fluorescent lt fixture	6	—
automatic garage dr opener	1	⬇
cable tv outlet	2	*
ceiling fan	3	+
garage dr opener	1	⬇
gfi waterproof outlet	5	⬆
light	15	+
outlet	13	⬆
outlet 220v	2	⬆
outlet gfi	15	⬆
recessed can light	3	+
smoke detector	2	*
switch	12	⬆
switch 3 way	12	⬆
telephone	1	*
vent light combo	1	⬆

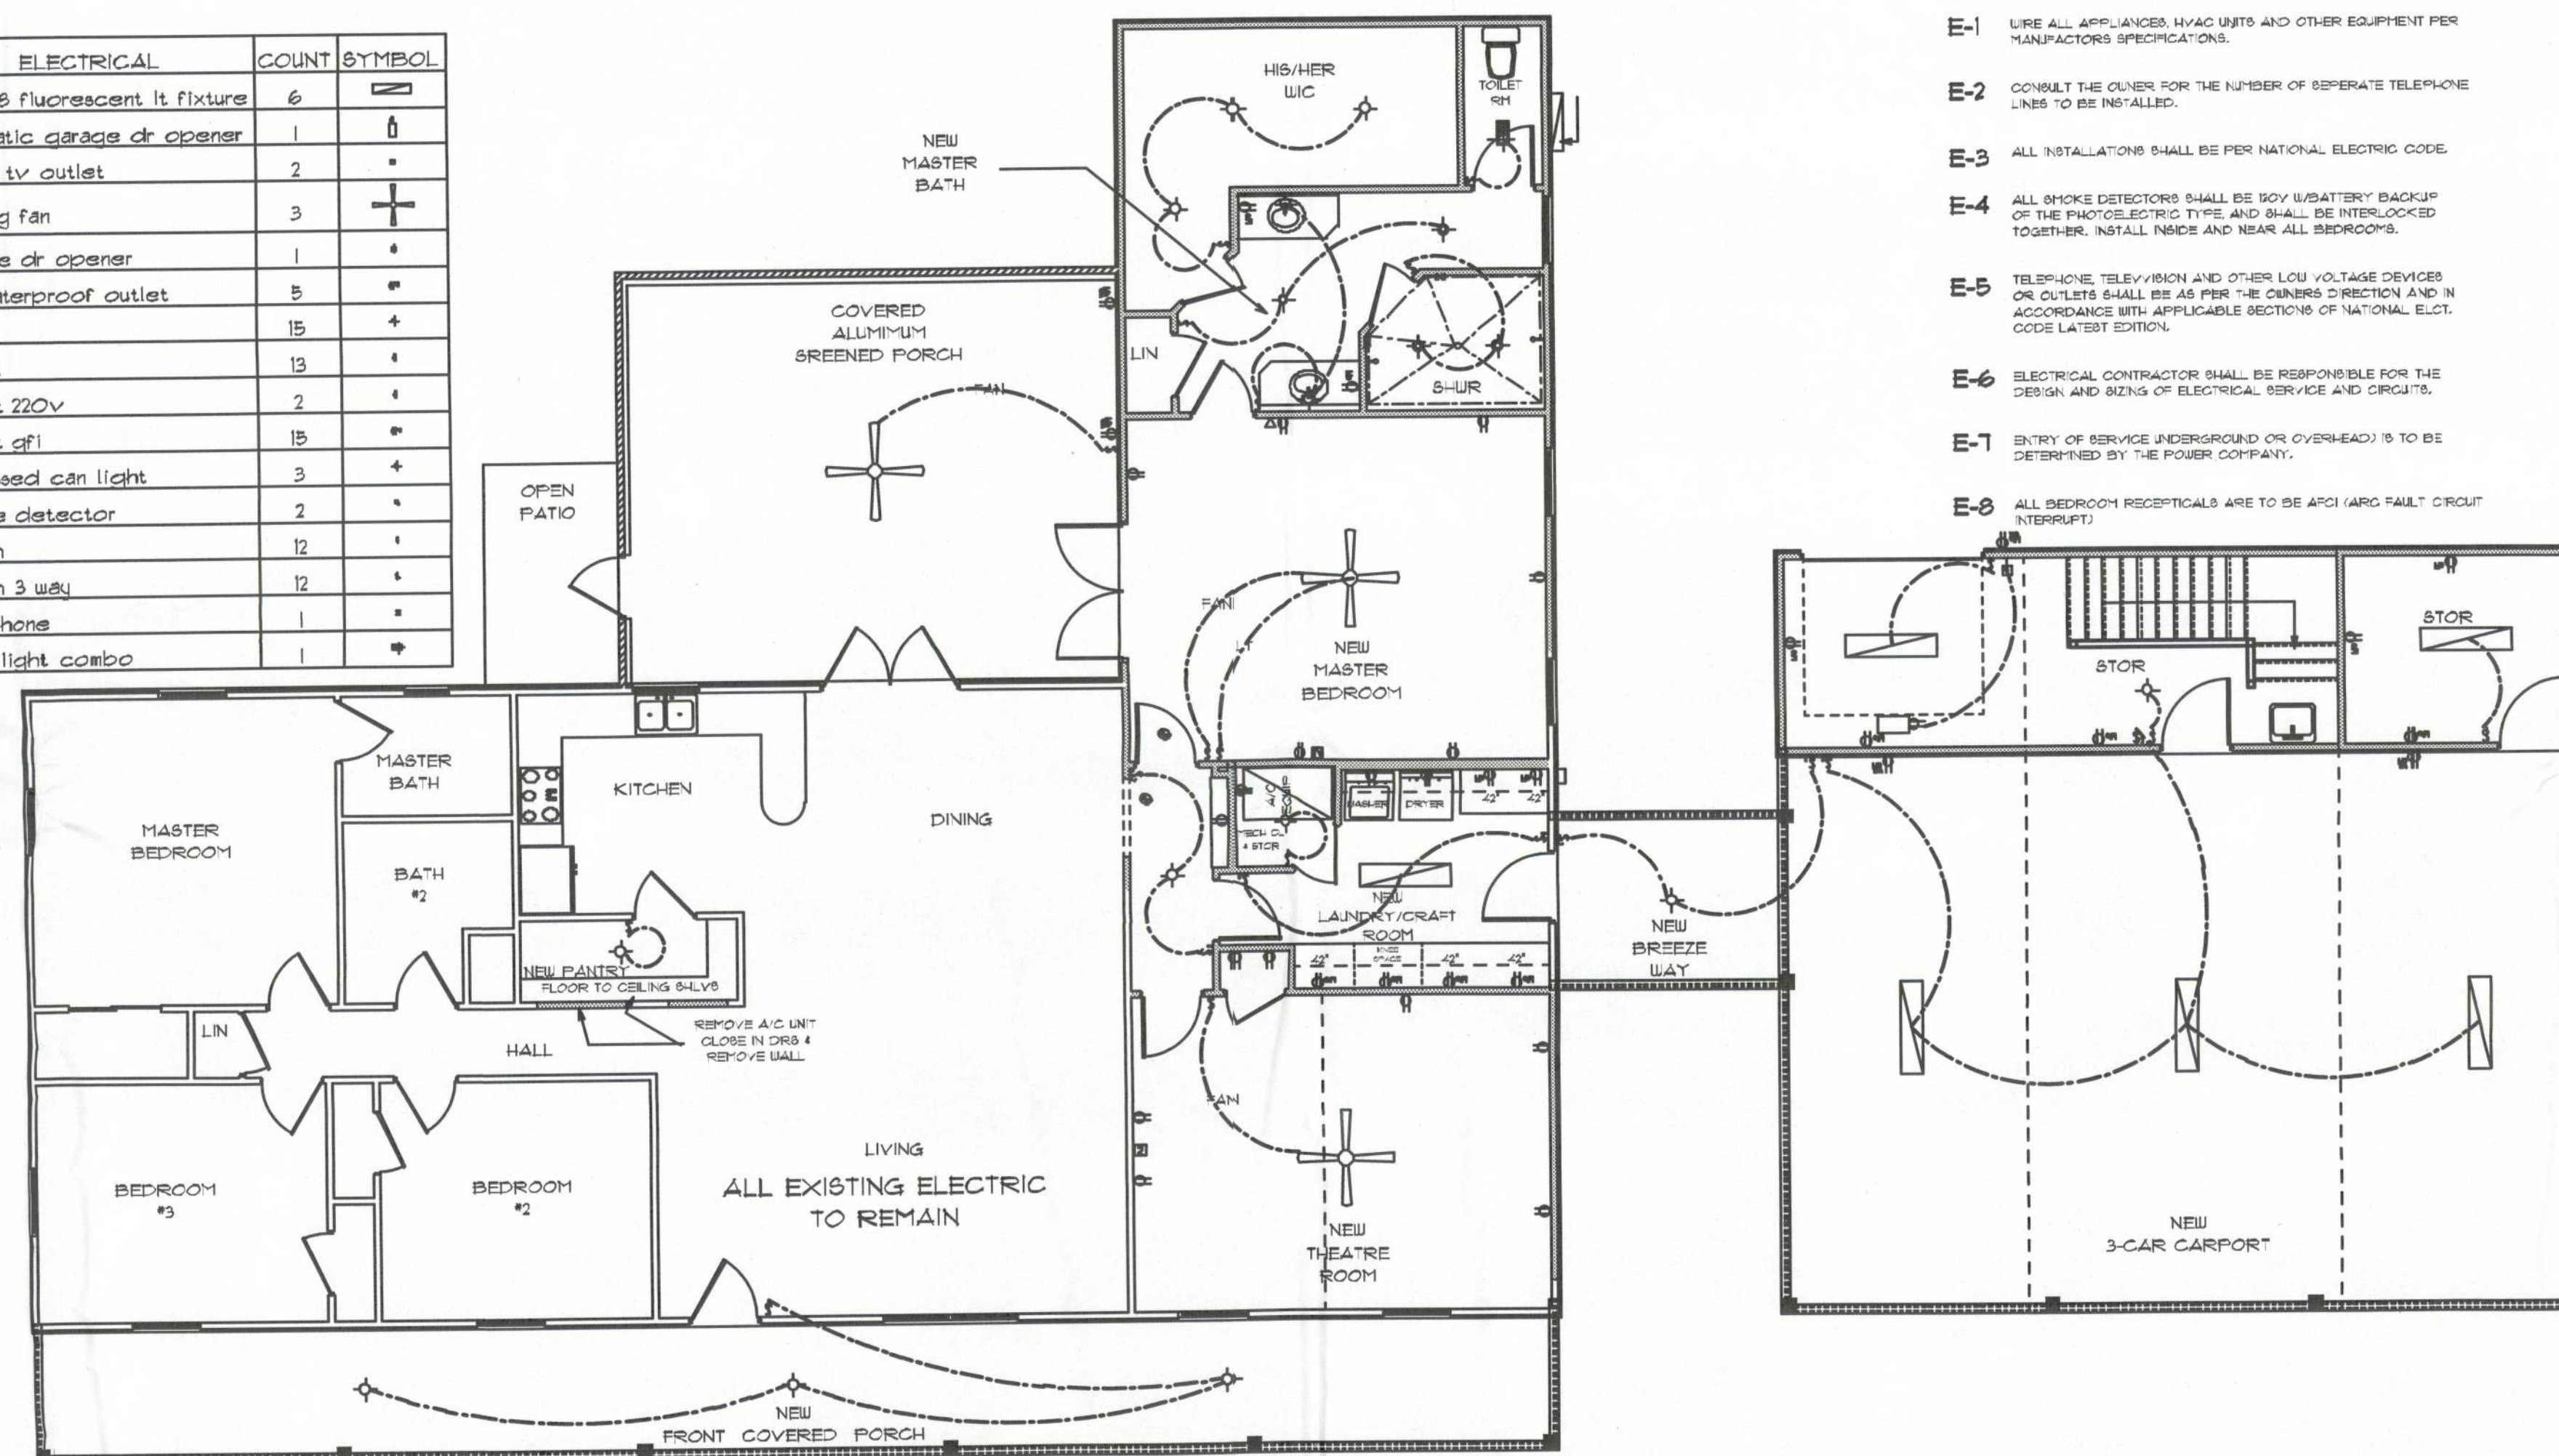

ELECTRICAL PLAN NOTES

- E-1 WIRE ALL APPLIANCES HVAC UNITS AND OTHER EQUIPMENT PER MANUFACTURER'S SPECIFICATIONS.
- E-2 CONSULT THE OWNER FOR THE NUMBER OF SEPARATE TELEPHONE LINES TO BE INSTALLED.
- E-3 ALL INSTALLATIONS SHALL BE PER NATIONAL ELECTRIC CODE.
- E-4 ALL SMOKE DETECTORS SHALL BE BOV (BATTERY BACKUP) OF THE PHOTOELECTRIC TYPE AND SHALL BE INTERLOCKED TOGETHER. INSTALL INBES AND NEAR ALL BEDROOMS.
- E-5 TELEPHONE, TELEVISION AND OTHER LOW VOLTAGE DEVICES OR OUTLETS SHALL BE AS PER THE OWNER'S DIRECTION AND IN ACCORDANCE WITH APPLICABLE SECTIONS OF NATIONAL ELEC. CODE LATEST EDITION.
- E-6 ELECTRICAL CONTRACTOR SHALL BE RESPONSIBLE FOR THE DESIGN AND SIZING OF ELECTRICAL SERVICE AND CIRCUITS.
- E-7 ENTRY OF SERVICE UNDERGROUND OR OVERHEAD IS TO BE DETERMINED BY THE POWER COMPANY.
- E-8 ALL BEDROOM RECEPTALS ARE TO BE AFCI (ARC FAULT CIRCUIT INTERRUPT).

* PROPOSED ELECTRIC PLAN *

SCALE: 3/16" = 1'-0"

BRYAN & SUMMER

BUCKLES
ADDITION

FLORIDA

Teena M. Ruffo
6429 NW Lake Jeffrey Road
Lake City, Florida 32005
Phone: (386) 719-4944
Cell: (386) 867-1191
Email: mferndesigns@aol.net

PRINTED DATE:
May 23, 2009

DRAWN BY: Teena M. Ruffo CHECKED BY:

DESIGNED BY:

FINALS DATE:

CONTRACTOR:
BLAKE CONSTRUCTION

DRAWING NUMBER

A 4

OF 4 SHEETS