
 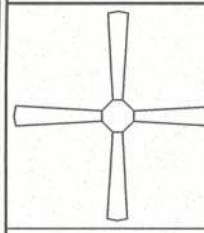
 
 
 
 
 
 
 



ELECTRICAL LEGEND	
	CEILING FAN (PRE-WIRE FOR LIGHT KIT)
	DOUBLE SECURITY LIGHT
	RECESSED CAN LIGHT
	BATH EXHAUST FAN
	LIGHT FIXTURE
	DUPLEX OUTLET
	220v OUTLET
	GFI DUPLEX OUTLET
	S.D. SMOKE DETECTOR (see note below)
	C.M.D. CARBON MONOXIDE DETECTOR
	WALL SWITCH
	3 WAY WALL SWITCH
	WATER PROOF GFI OUTLET
	2 OR 4 TUB FLUORESCENT FIXTURE

NOTE:
ALL BEDROOM RECEPTACLES SHALL BE AFCI
(ARC FAULT CIRCUIT INTERRUPT)

ALL SMOKE DETECTORS SHALL HAVE BATTERY BACKUP POWER
AND ALL WIRED TOGETHER SO IF ANY ONE UNIT IS ACTUATED THEY
ALL ACTIVATE.

NOTE!
UFER grounding required per N.E.C.
Arc fault breakers required per N.E.C.
GFCI breakers required per N.E.C.
Tamper resistant receptacles required per N.E.C.

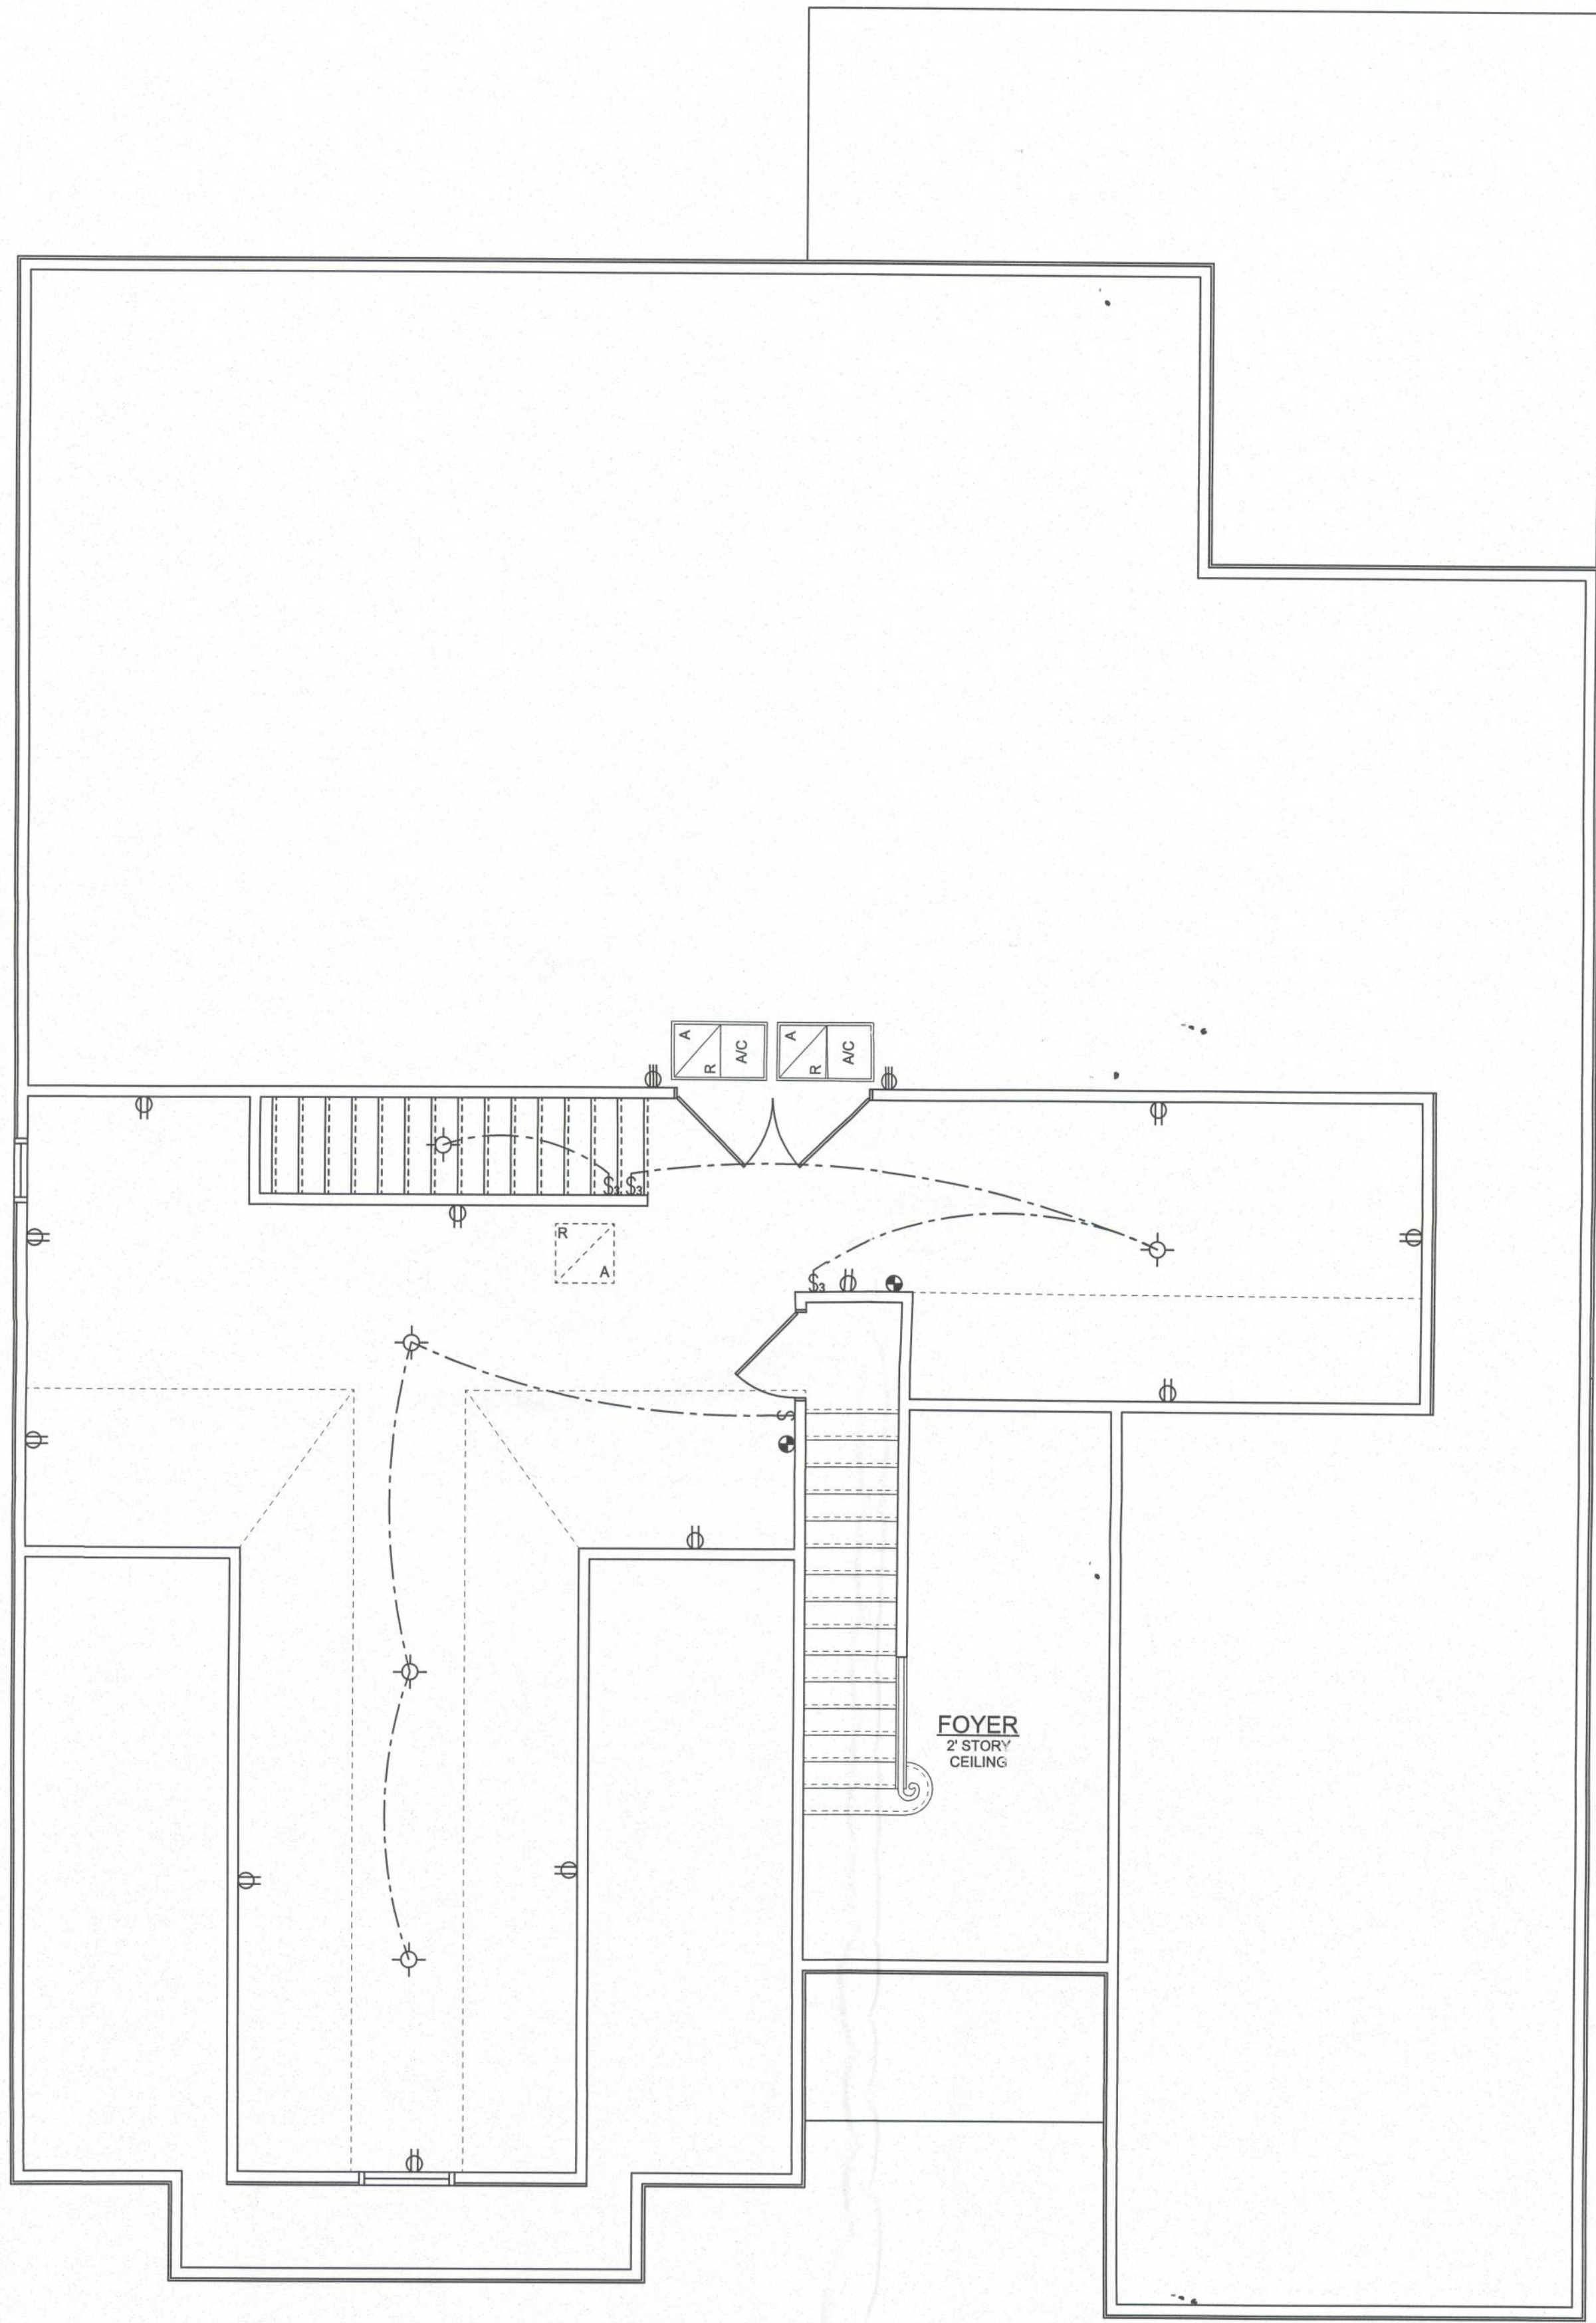

PROPOSED BONUS ROOM PLAN ELECTRIC

SCALE:

1/4" = 1'-0"

VERIFY ALL BONUS ROOM SIZING WITH TRUSS ENGINEERING

REVISIONS SCHEDULE			
6/10/2011	ORIGINAL DRAWINGS		
6/12/2011	FINAL DRAWINGS		
6/21/2011	COMPLETE PERMIT SET		

CUSTOM HOME DESIGN FOR:	
MATT & CARRIE CASON	
LOT 7, HICKORY COVE S/D, LAKE CITY, FL 32224	
CONCEPT CONSTRUCTION OF N. FLORIDA INC.	
3324 W UNIVERSITY AVE #210, GAINESVILLE, FL 32607	

JONATHAN MORRIS	
DRAFTING SERVICES	
263 SW ERM GUN LAKE CITY, FLORIDA (386) 466-7338 jmorris69@att.net	

SHEET NAME
A.6
OF 5 SHEETS