


NOTE: THE CONTRACTOR IS DIRECTED TO REVIEW ALL CONSTRUCTION DRAWINGS & SPECIFICATIONS FOR ACCURACY & COMPLETENESS. ANY CONFLICTING INFORMATION SHALL BE BROUGHT TO THE IMMEDIATE ATTENTION OF THE ENGINEER OF RECORD FOR RESOLUTION & CLARIFICATION.

SCALE NOTE:
PLAN VIEW: 1/8" = 1'-0"

STORAGE BUILDING MECHANICAL FLOOR PLAN VIEW

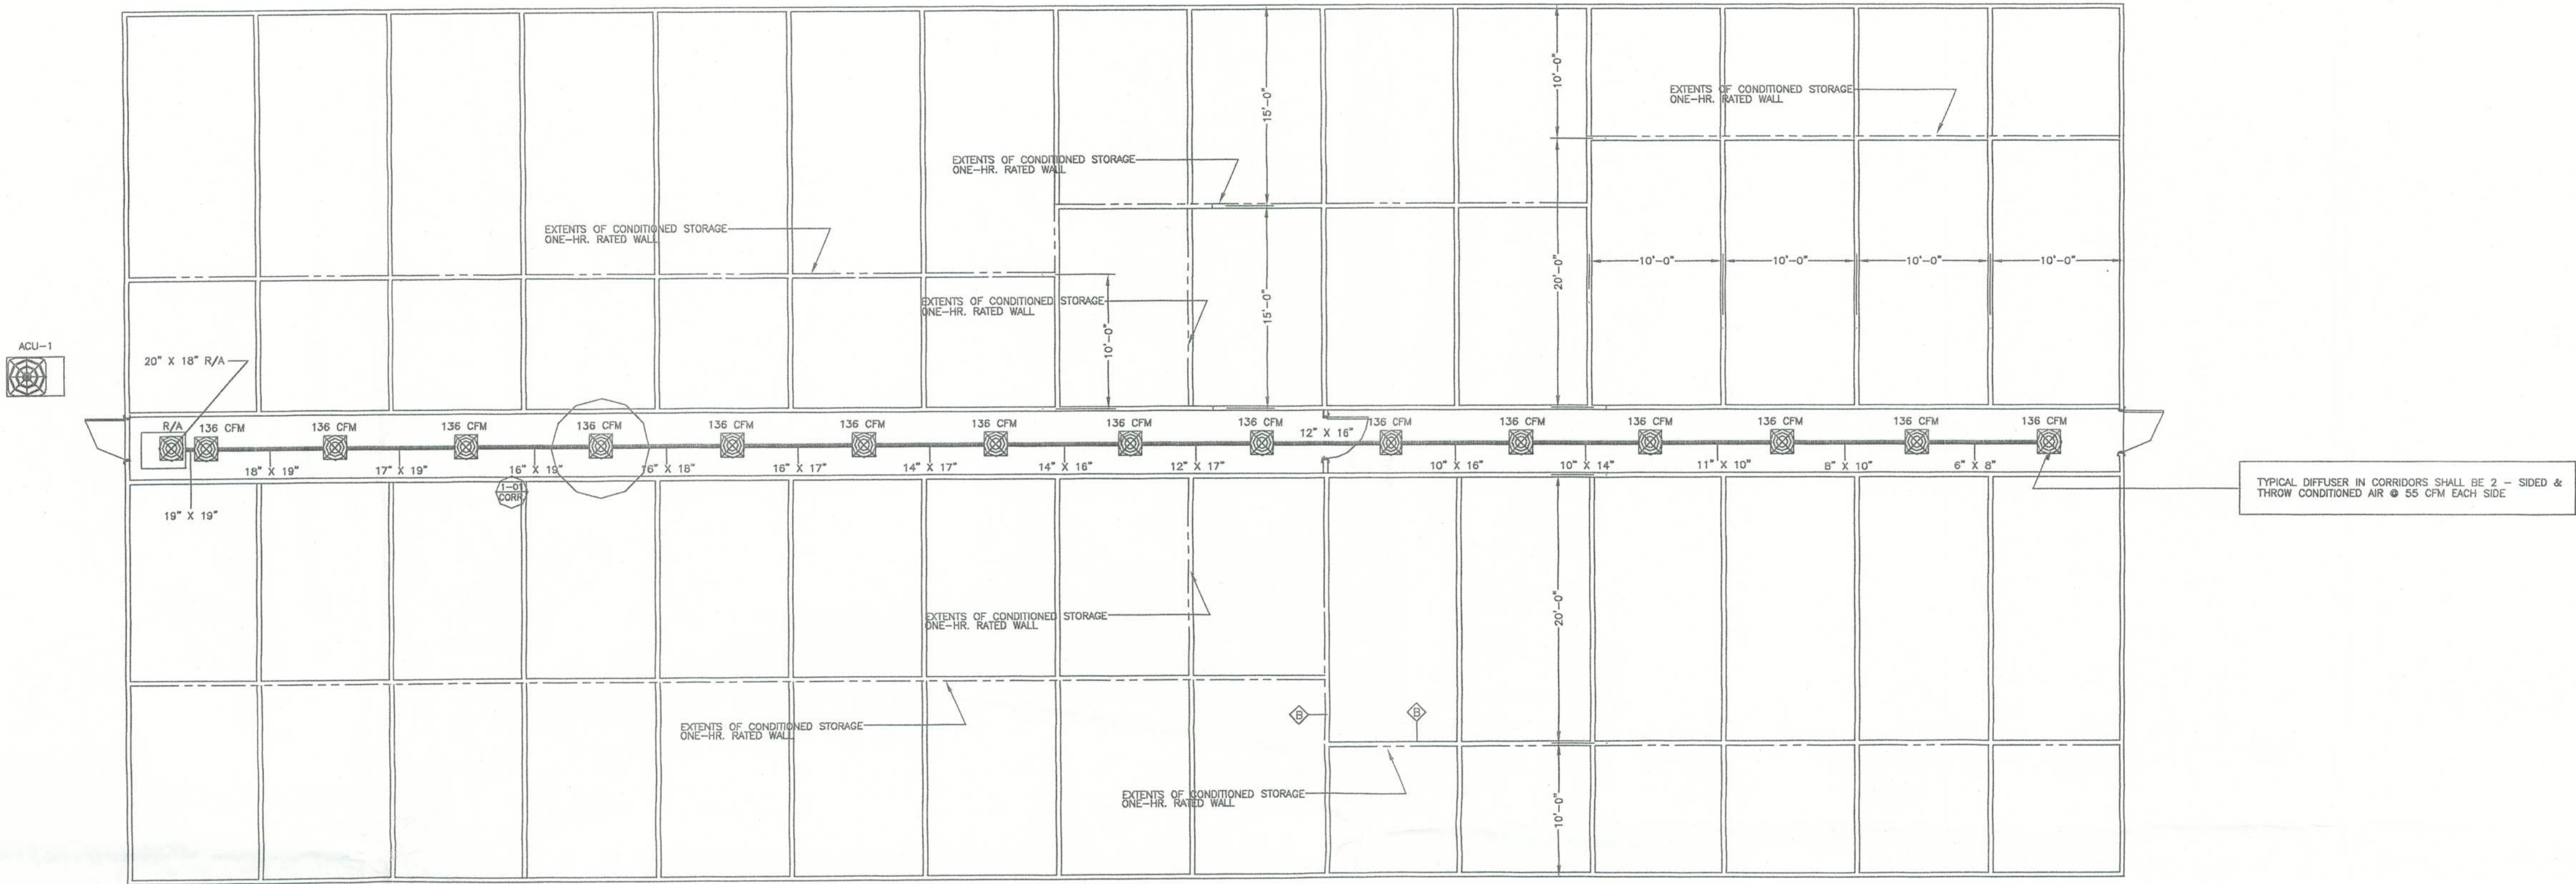

HAC					
AHU-1	5.0 TON	2050 CFM	SEER 10.5	COP 3.00	TRANE TWED60 OR EQUAL
AHU-1	5.0 TON	2050 CFM	SEER 10.5	COP 3.00	TRANE 2TWR1060A OR EQUAL

- ① BASED UPON 96" AIR ENTERING CONDENSER
② PROVIDE FLEXIBLE CONNECTIONS @ ALL AIR HANDLING UNITS
- CONTRACTOR TO PROVIDE FOR ADEQUATE CONDENSATION DRAINAGE TO PREVENT FREE WATER FLOW FROM HEAT PUMP UNITS AND TO THOROUGHLY SEAL/GASKET HEAT PUMP UNIT PENETRATION AGAINST MOISTURE AND AIR INFILTRATION.

9263 OR 417
LIVE OAK, FLORIDA 32060
386-362-4787
ENG. LIC. EB 3761

KEEN ENGINEERING
& SURVEYING, INC.

RECORD STORAGE OF LAKE CITY
LAKE CITY, FLORIDA

11/10/03

STORAGE BUILDING MECHANICAL FLOOR PLAN VIEW
MISC. NOTES, REFERENCES & INSTRUCTIONS
SCHEDULES

PROJECT No.
RECORDS-142.0.DWG
SHEET No.
M2.0.0

DRAWN BY:
DATE
11/04/03

Curtis Keen
11/10/03