



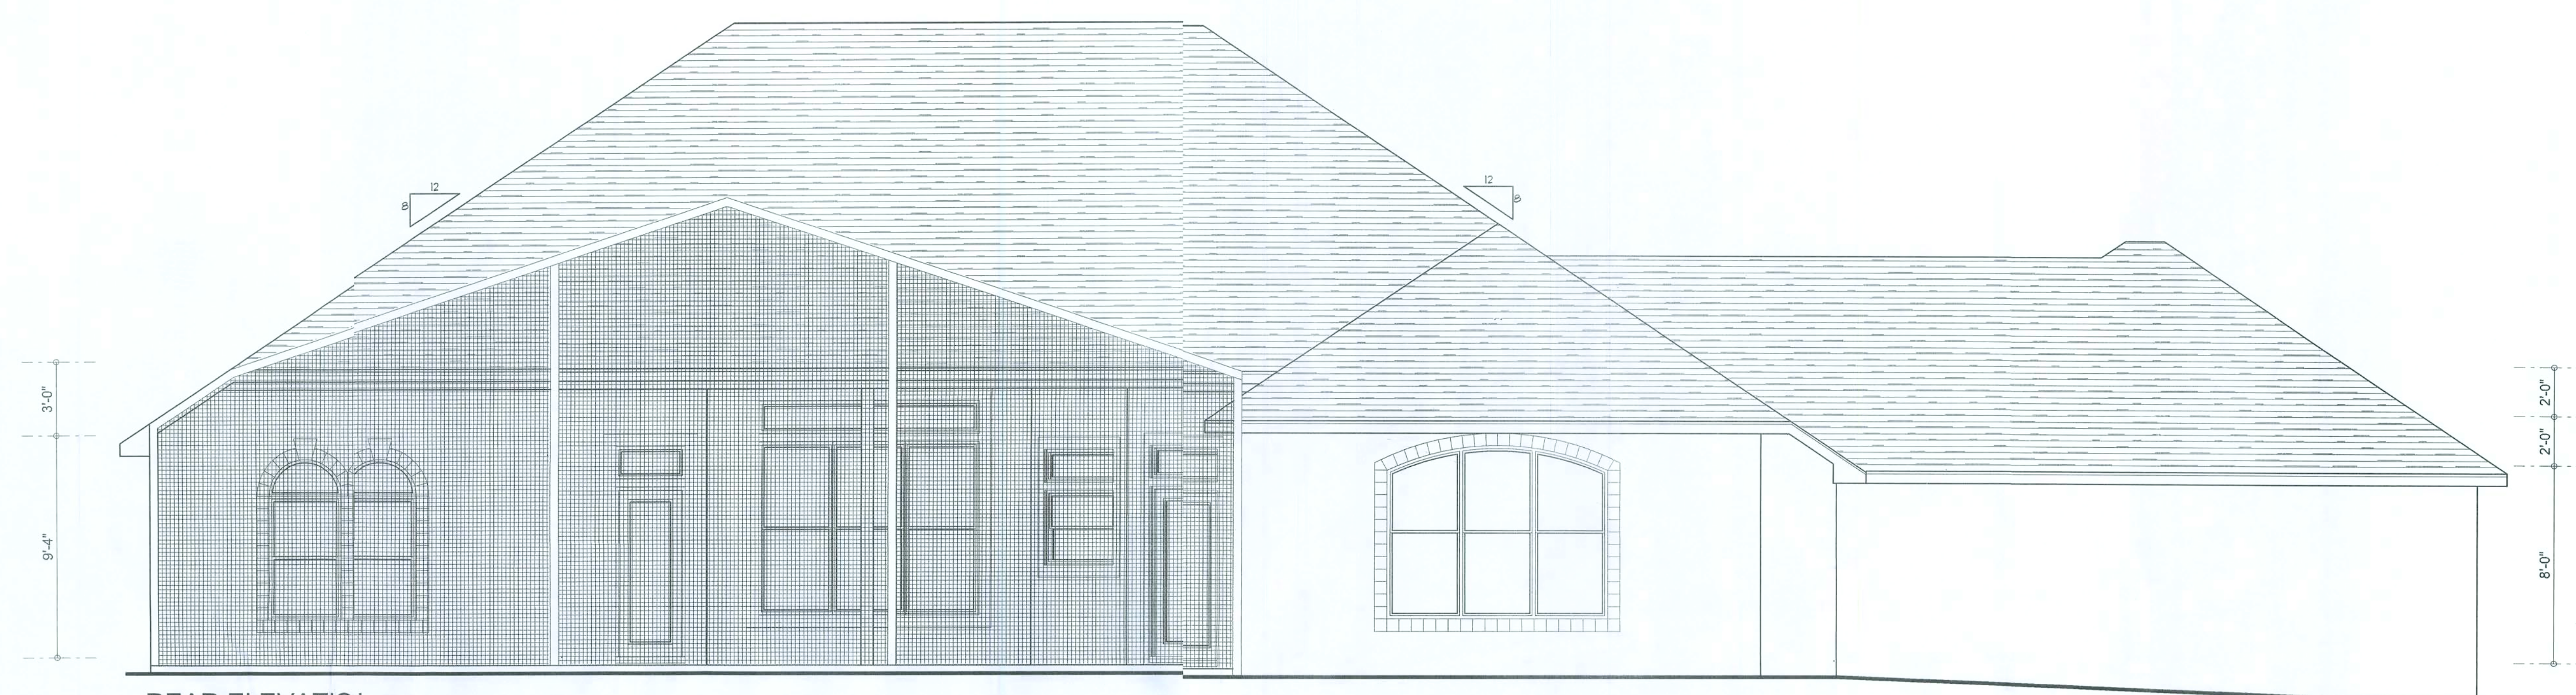

REAR ELEVATION
SCALE: 1/4" = 0'

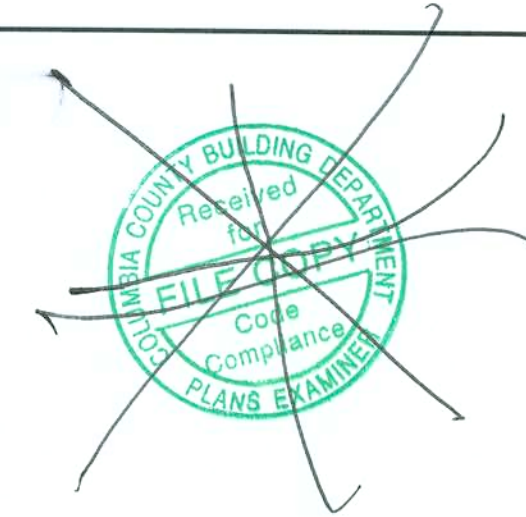

FRONT ELEVATION
SCALE: 1/4" = 1'-0"

NOTE: ALL DRAWINGS NOT TO BE SCALED, WRITTEN DIMENSIONS TAKE PRECEDENCE OVER SCALED DIMENSIONS


REVISIONS
October 31, 2008

SOFTPLAN
ARCHITECTURAL DESIGN SOFTWARE

FRONT & REAR ELEVATION
SCALE: SEE DRAWING
SITE PLAN
SCALE: NTS

A CUSTOM RESIDENCE FOR:
SURESH & DAXA PATEL
PROJECT ADDRESS: LOT 7, CYPRESS LAKE PHASE II, LAKE CITY, FLORIDA 32025
ISAAC CONSTRUCTION, LLC.
LAKE CITY, FLORIDA 32025


©WILLIAM MYERS
DESIGN
P.O. BOX 1513
LAKE CITY, FL 32056
(386) 758-8406
will@willmyers.net

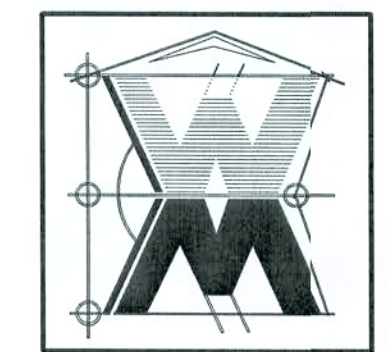


JOB NUMBER
080902

SHEET NUMBER
A.1
OF 4 SHEETS

William Myers

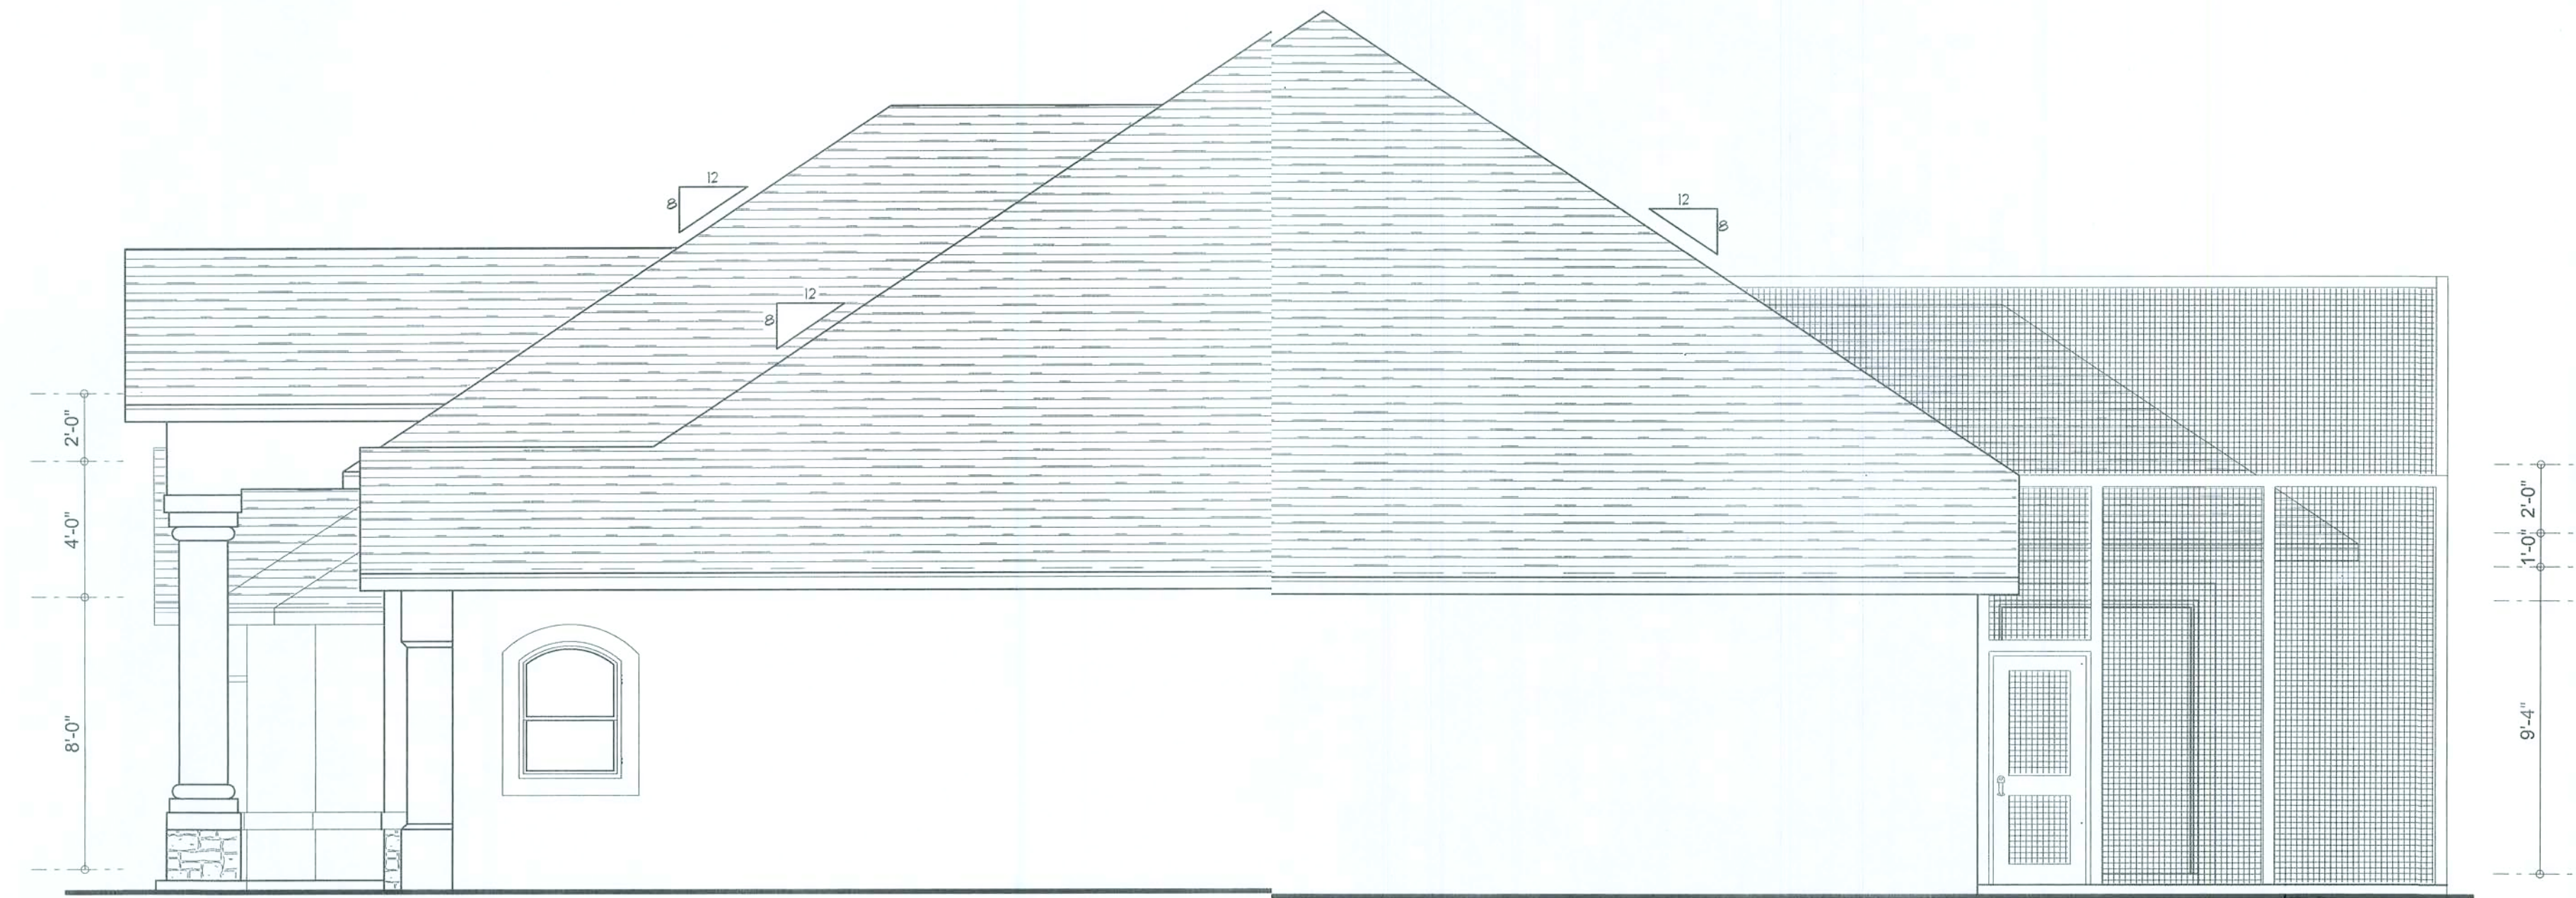

RIGHT ELEVATION
SCALE: 1/4" = 1'-0"

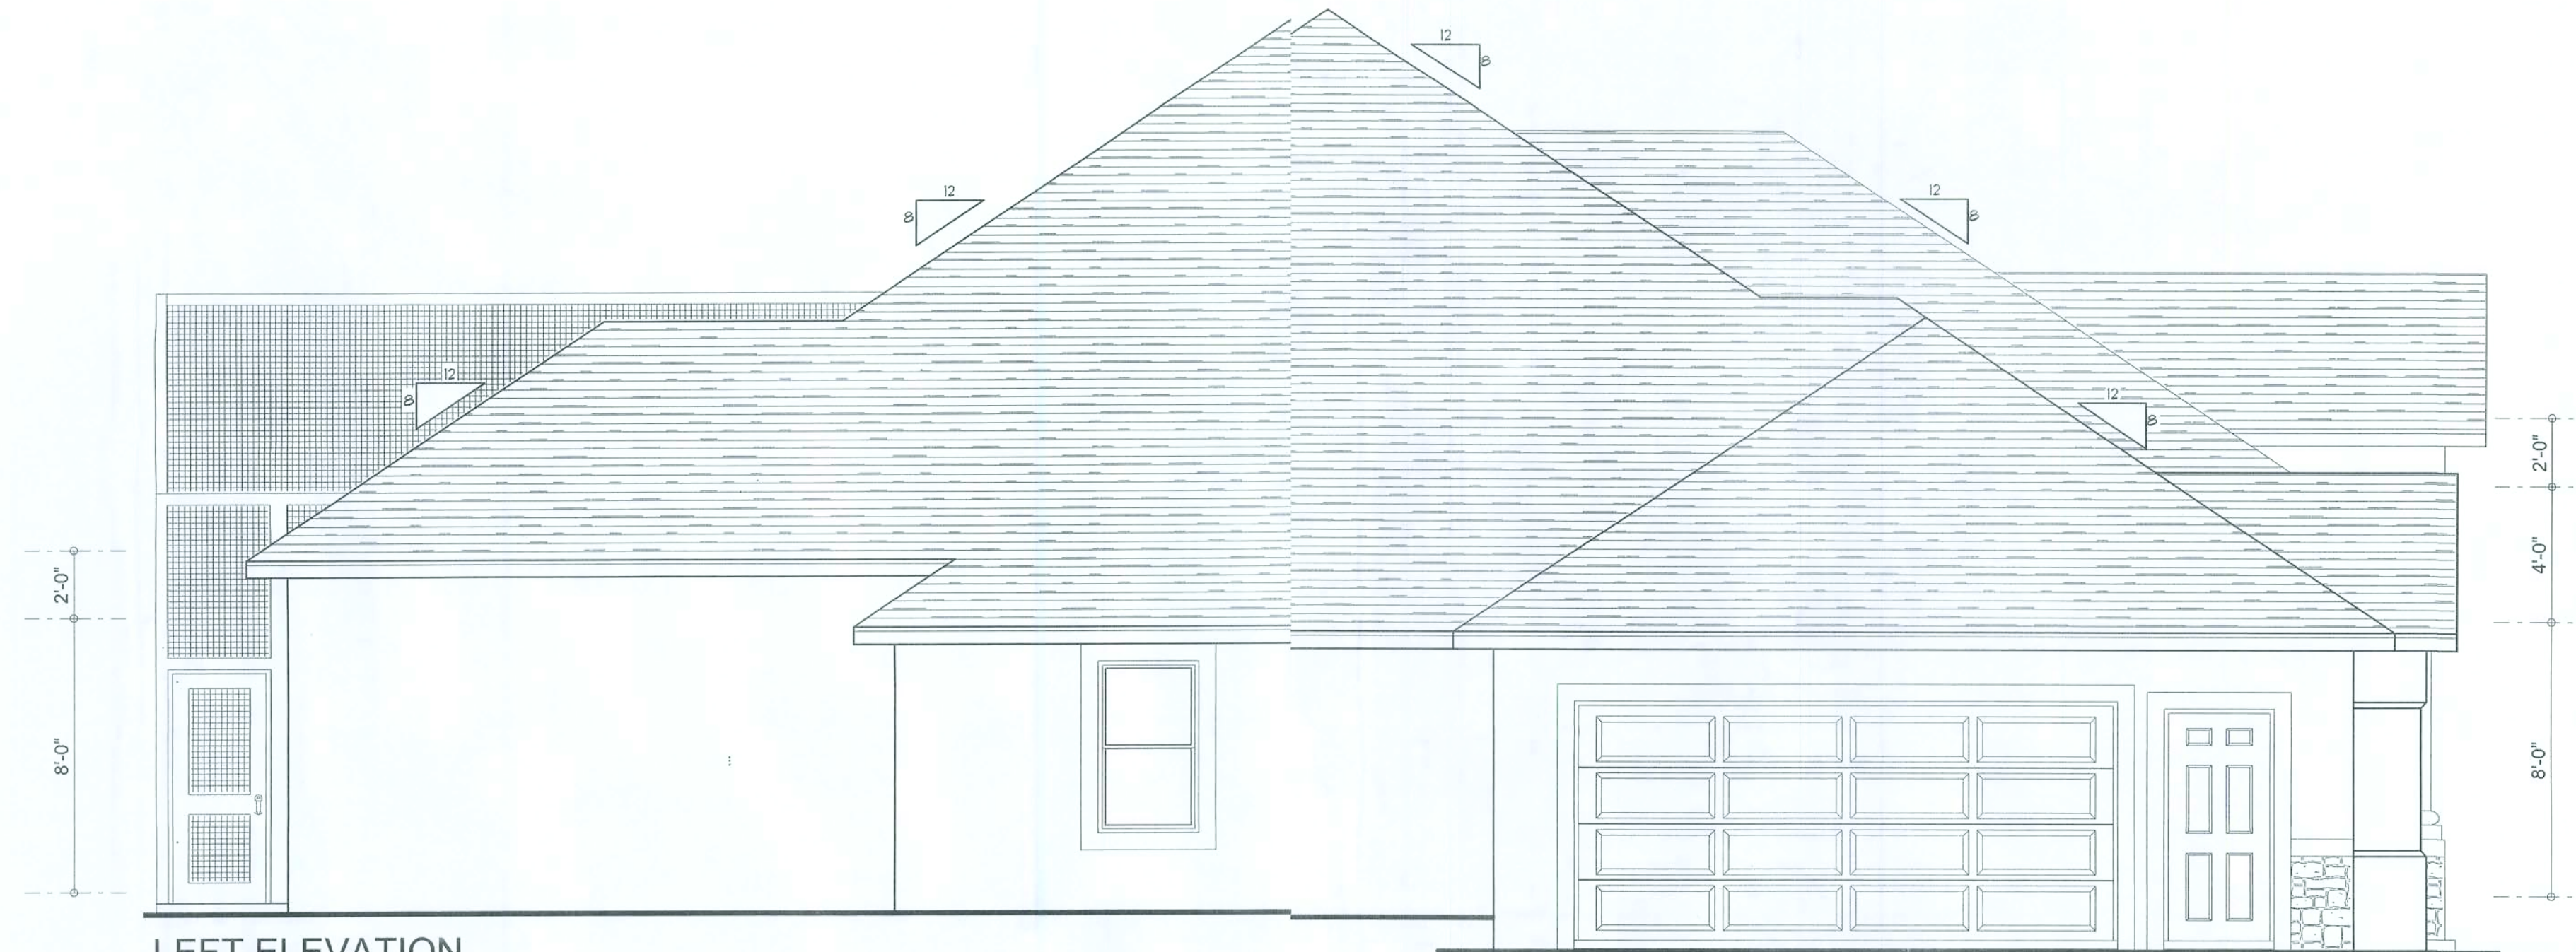

LEFT ELEVATION
SCALE: 1/4" = 1'-0"

NOTE: ALL DRAWINGS NOT TO BE SCALED, WRITTEN DIMENSIONS TAKE PRECEDENCE OVER SCALED DIMENSIONS

REVISIONS	
October 31, 2008	


SOFTPLAN
ARCHITECTURAL DESIGN SOFTWARE

RIGHT ELEVATION
SCALE: 1/4" = 1'-0"

LEFT ELEVATION
SCALE: 1/4" = 1'-0"

A CUSTOM RESIDENCE FOR:
SURESH & DAXA PATEL
PROJECT ADDRESS: LOT 7, CYPRESS LAKE PHASE II, LAKE CITY, FLORIDA 32025
ISAAC CONSTRUCTION, LLC.
LAKE CITY, FLORIDA, 32025

©WILLIAM MYERS
DESIGN
P.O. BOX 1513
LAKE CITY, FL 3206
(386) 758-8416
will@willmyers.net

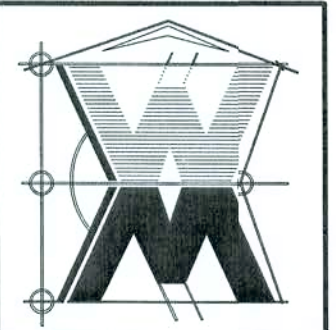

JOB NUMBER
080902

SHEET NUMBER
A.2
OF 4 SHEETS

William Myers

AREA SUMMARY

LIVING AREA	3109	S.F.
GARAGE AREA	613	S.F.
ENTRY PORCH AREA	92	S.F.
COVERED PORCH AREA	352	S.F.
SCREENED PORCH AREA	615	S.F.
TOTAL AREA	4781	S.F.

FLOOR PLAN
SCALE: 1/4" = 1'-0"

NOTE: ALL DRAWINGS NOT TO BE SCALED, WRITTEN DIMENSIONS TAKE PRECEDENCE OVER SCALED DIMENSIONS


Garage fire separations shall comply with the following:

1. The private garage shall be separated from the dwelling unit and its attic area by means of a minimum 1/2-inch (12.7 mm) gypsum board applied to the garage side. Garages beneath habitable rooms shall be separated from all habitable rooms above by not less than 5/8-inch Type X gypsum board. All openings between a private garage and the dwelling unit shall be equipped with either solid wood doors or doors constructed of steel doors not less than 1 3/8 inches (34.9 mm) thick, or doors in compliance with Section 715.3. Openings from a private garage directly into a room used for sleeping purposes shall not be permitted.
2. Ducts in a private garage and ducts penetrating the walls or ceilings separating the dwelling unit from the garage shall be constructed of a minimum 0.019-inch (0.48 mm) sheet steel and shall have no openings into the garage.
3. A separation is not required between a Group R-3 and U carport provided the carport is entirely open on two or more sides and there are not enclosed areas above.
4. When installing an attic access and/or pull-down stair unit in the garage, device shall have a minimum 20 min. fire rating.

A CUSTOM RESIDENCE FOR:

SURESH & DAXA PATEL
PROJECT ADDRESS: LOT 7, CYPRESS LAKE PHASE II, LAKE CITY, FLORIDA 32025
ISAAC CONSTRUCTION, LLC.
LAKE CITY, FLORIDA 32025

©WILLIAM MYERS
DESIGN
P.O. BOX 1513
LAKE CITY, FL 32866
(386) 758-8406
will@williammyers.net

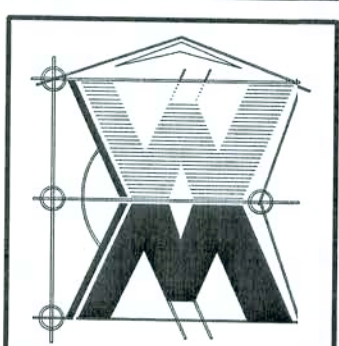

JOB NUMBER
080902

SHEET NUMBER
A.3
OF 4 SHEETS

REVISIONS
October 31, 2008

SOFTPLAN
ARCHITECTURAL DESIGN SOFTWARE


FLOOR PLAN
SCALE: 1/4" = 1'-0"

ELECTRICAL LEGEND	
	CEILING FAN (PRE-WIRE FOR LIGHT KIT)
	DOUBLE SECURITY LIGHT
	RECESSED CAN LIGHT
	BATH EXHAUST FAN
	LIGHT FIXTURE
	DUPLEX OUTLET
	220V OUTLET
	GFI DUPLEX OUTLET
	TELEVISION JACK
	TELEPHONE JACK
	SMOKE DETECTOR (see note 3/low)
	WALL SWITCH
	3 WAY WALL SWITCH
	WATER PROOF GFI OUTLET
	2 OR 4 TUB FLUORESCENT FIXTURE

NOTE:
ALL BEDROOM RECEPTACLES SHALL BE AFCI
(ARC FAULT CIRCUIT INTERRUPT)

ALL SMOKE DETECTORS SHALL HAVE BATTERY BACKUP POWER
AND ALL WIRED TOGETHER SO IF ANY ONE UNIT ACTUATED THEY
ALL ACTIVATE.

THE ELECTRICAL SERVICE OVERCURRENT PROTECTION DEVICE SHALL BE
INSTALLED ON THE EXTERIOR OF STRUCTURES 1 SERVE AS A DISCONNECT MEANS.
CONDUCTORS USED FROM THE EXTERIOR DISCONNECTING MEANS TO A PANEL OR SUB
PANEL SHALL HAVE FOUR-WIRE CONDUCTORS, (WHICH ONE CONDUCTOR
SHALL BE USED AS AN EQUIPMENT GROUND).

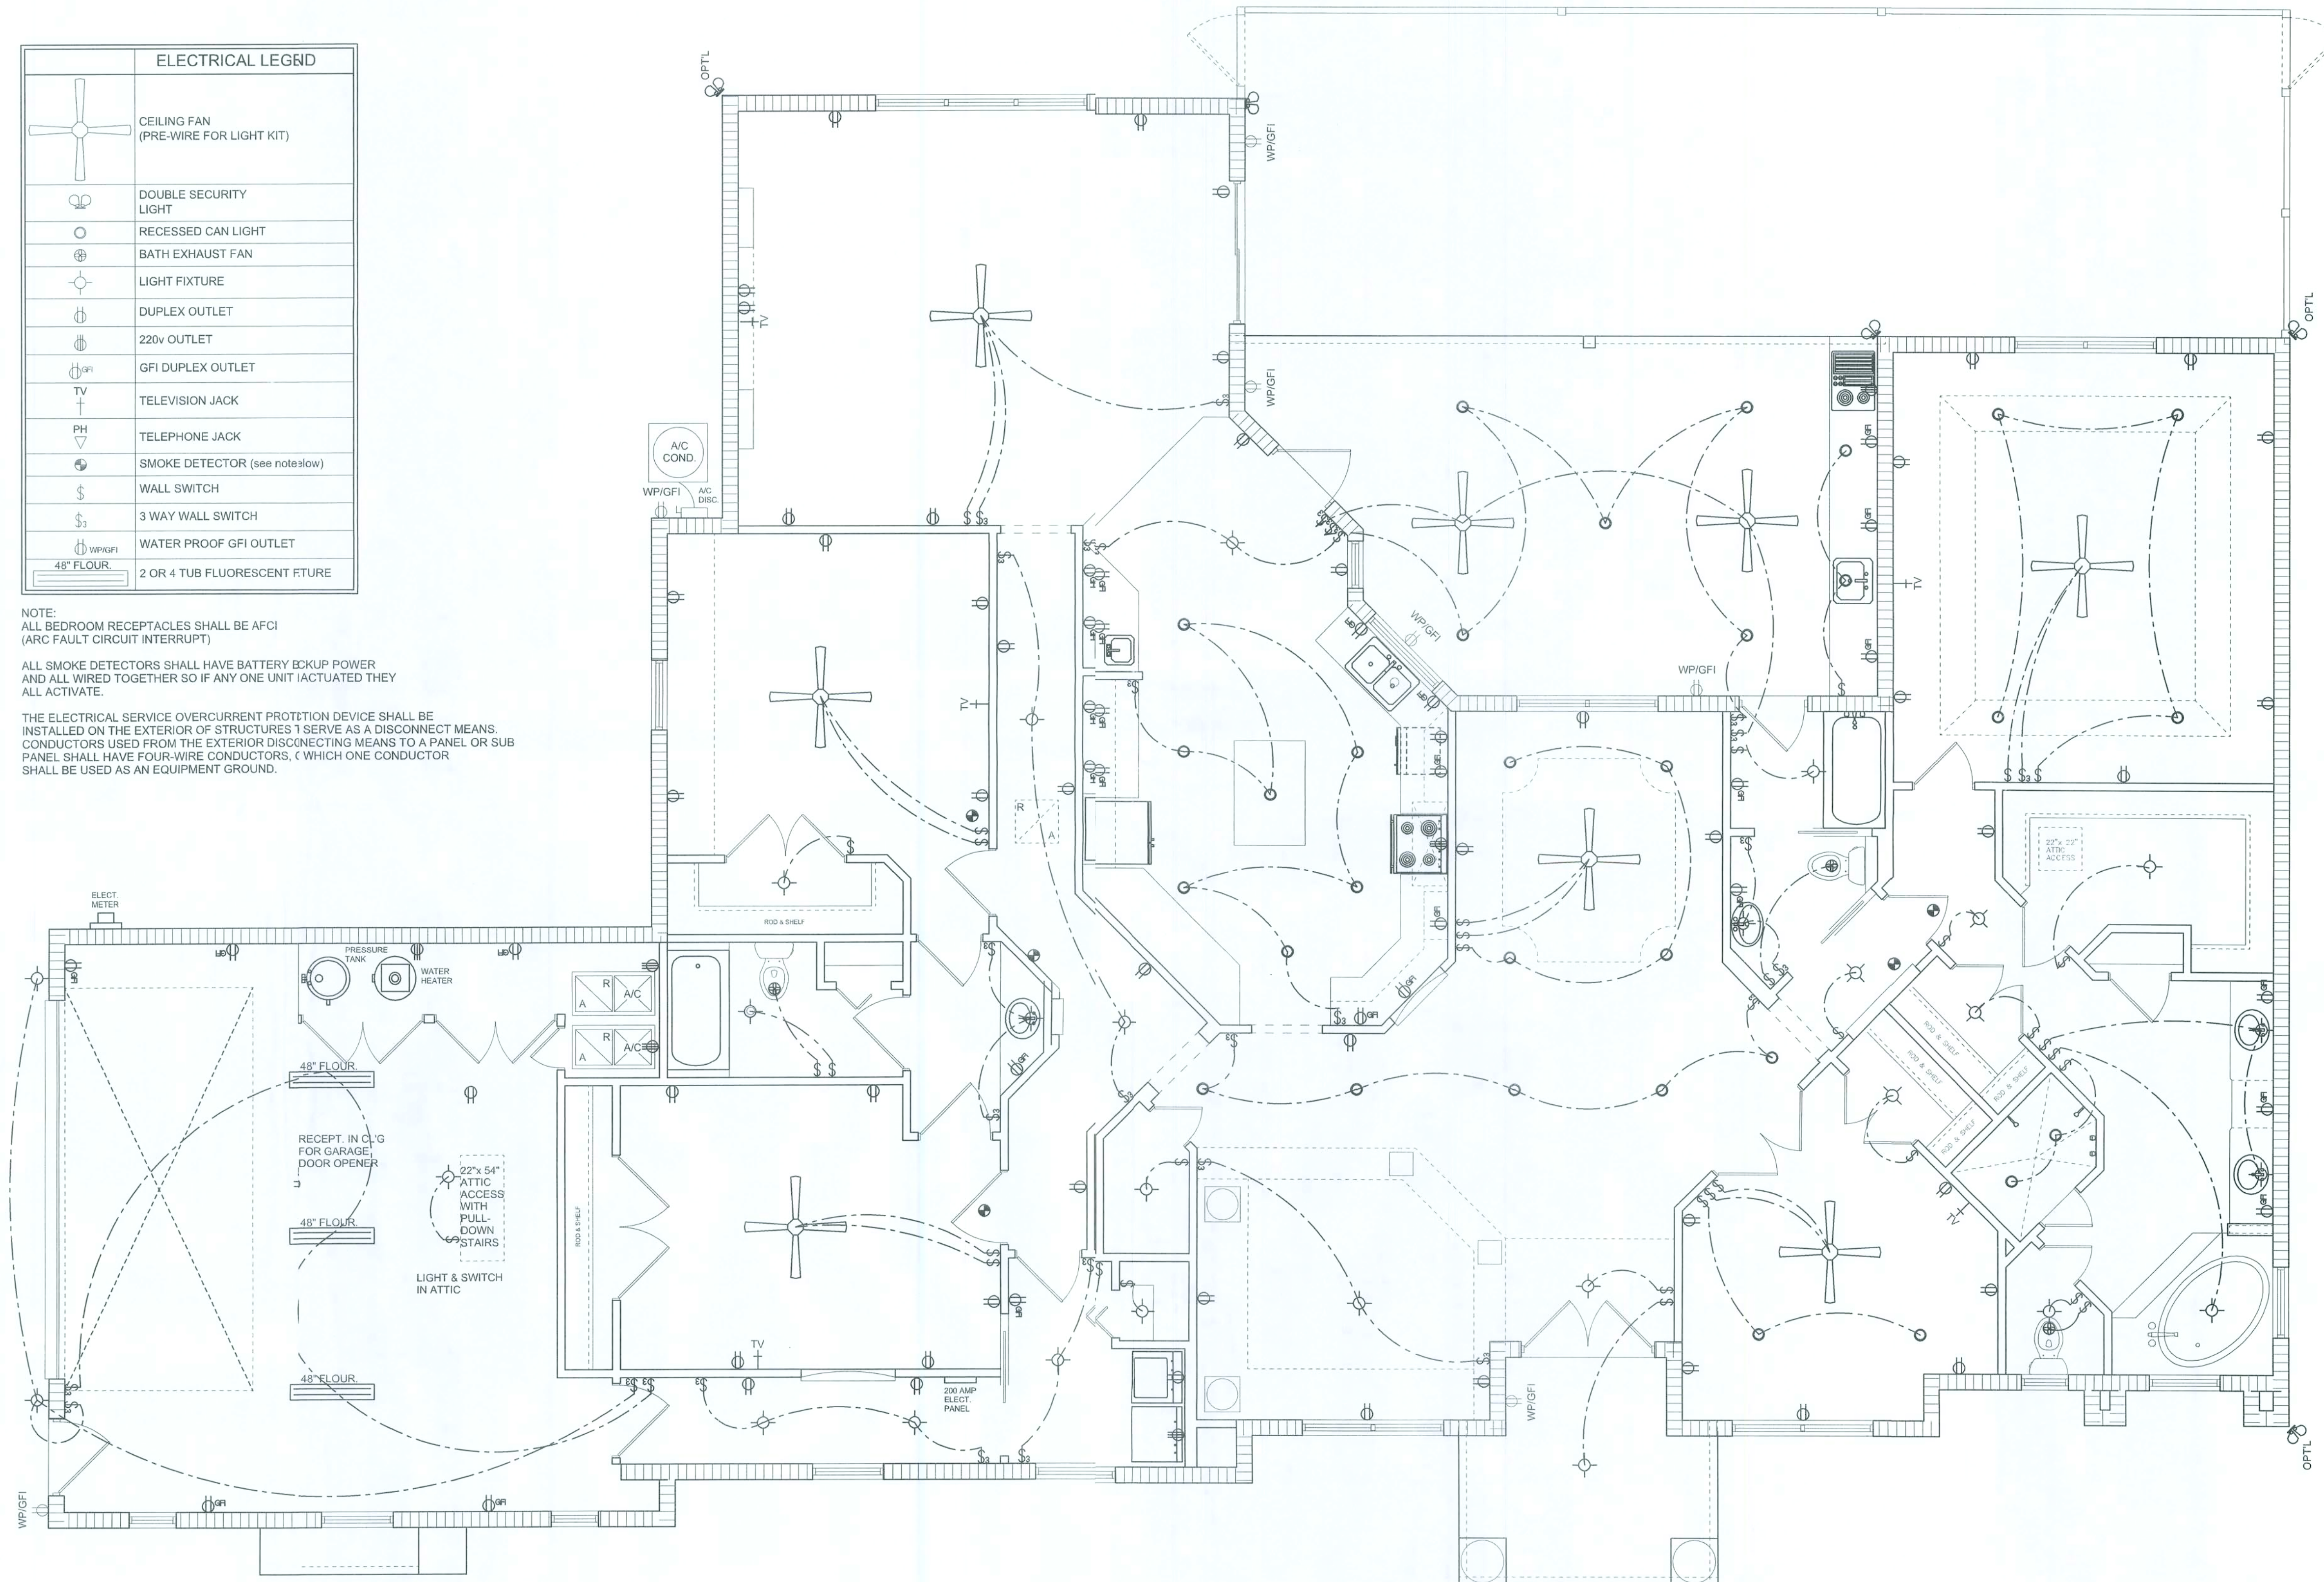

ELECTRICAL PLAN
SCALE: 1/4" = 1'-0"

NOTE: ALL DRAWINGS NOT TO BE SCALED, WRITTEN DIMENSIONS TAKE PRECEDENCE OVER SCALED DIMENSIONS


REVISIONS
October 31, 2008

SOFTPLAN
ARCHITECTURAL DESIGN SOFTWARE

ELECTRICAL PLAN
SCALE: 1/4" = 1'-0"

A CUSTOM RESIDENCE FOR:
SURESH & DAXA PATEL
PROJECT ADDRESS: LOT 7, CYPRESS LAKE PHASE II, LAKE CITY, FLORIDA 32025
ISAAC CONSTRUCTION, I.I.C.
LAKE CITY, FLORIDA, 32025


©WILLIAM MYERS
DESIGN
P.O. BOX 1513
LAKE CITY, FL 32056
(386) 758-6406
will@williammyers.net

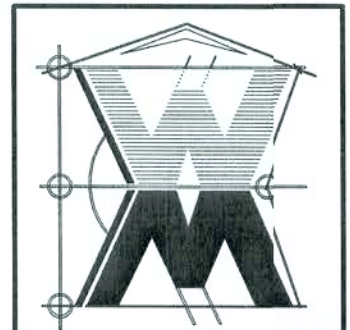


JOB NUMBER
080902

SHEET NUMBER
A.4
OF 4 SHEETS

William Myers

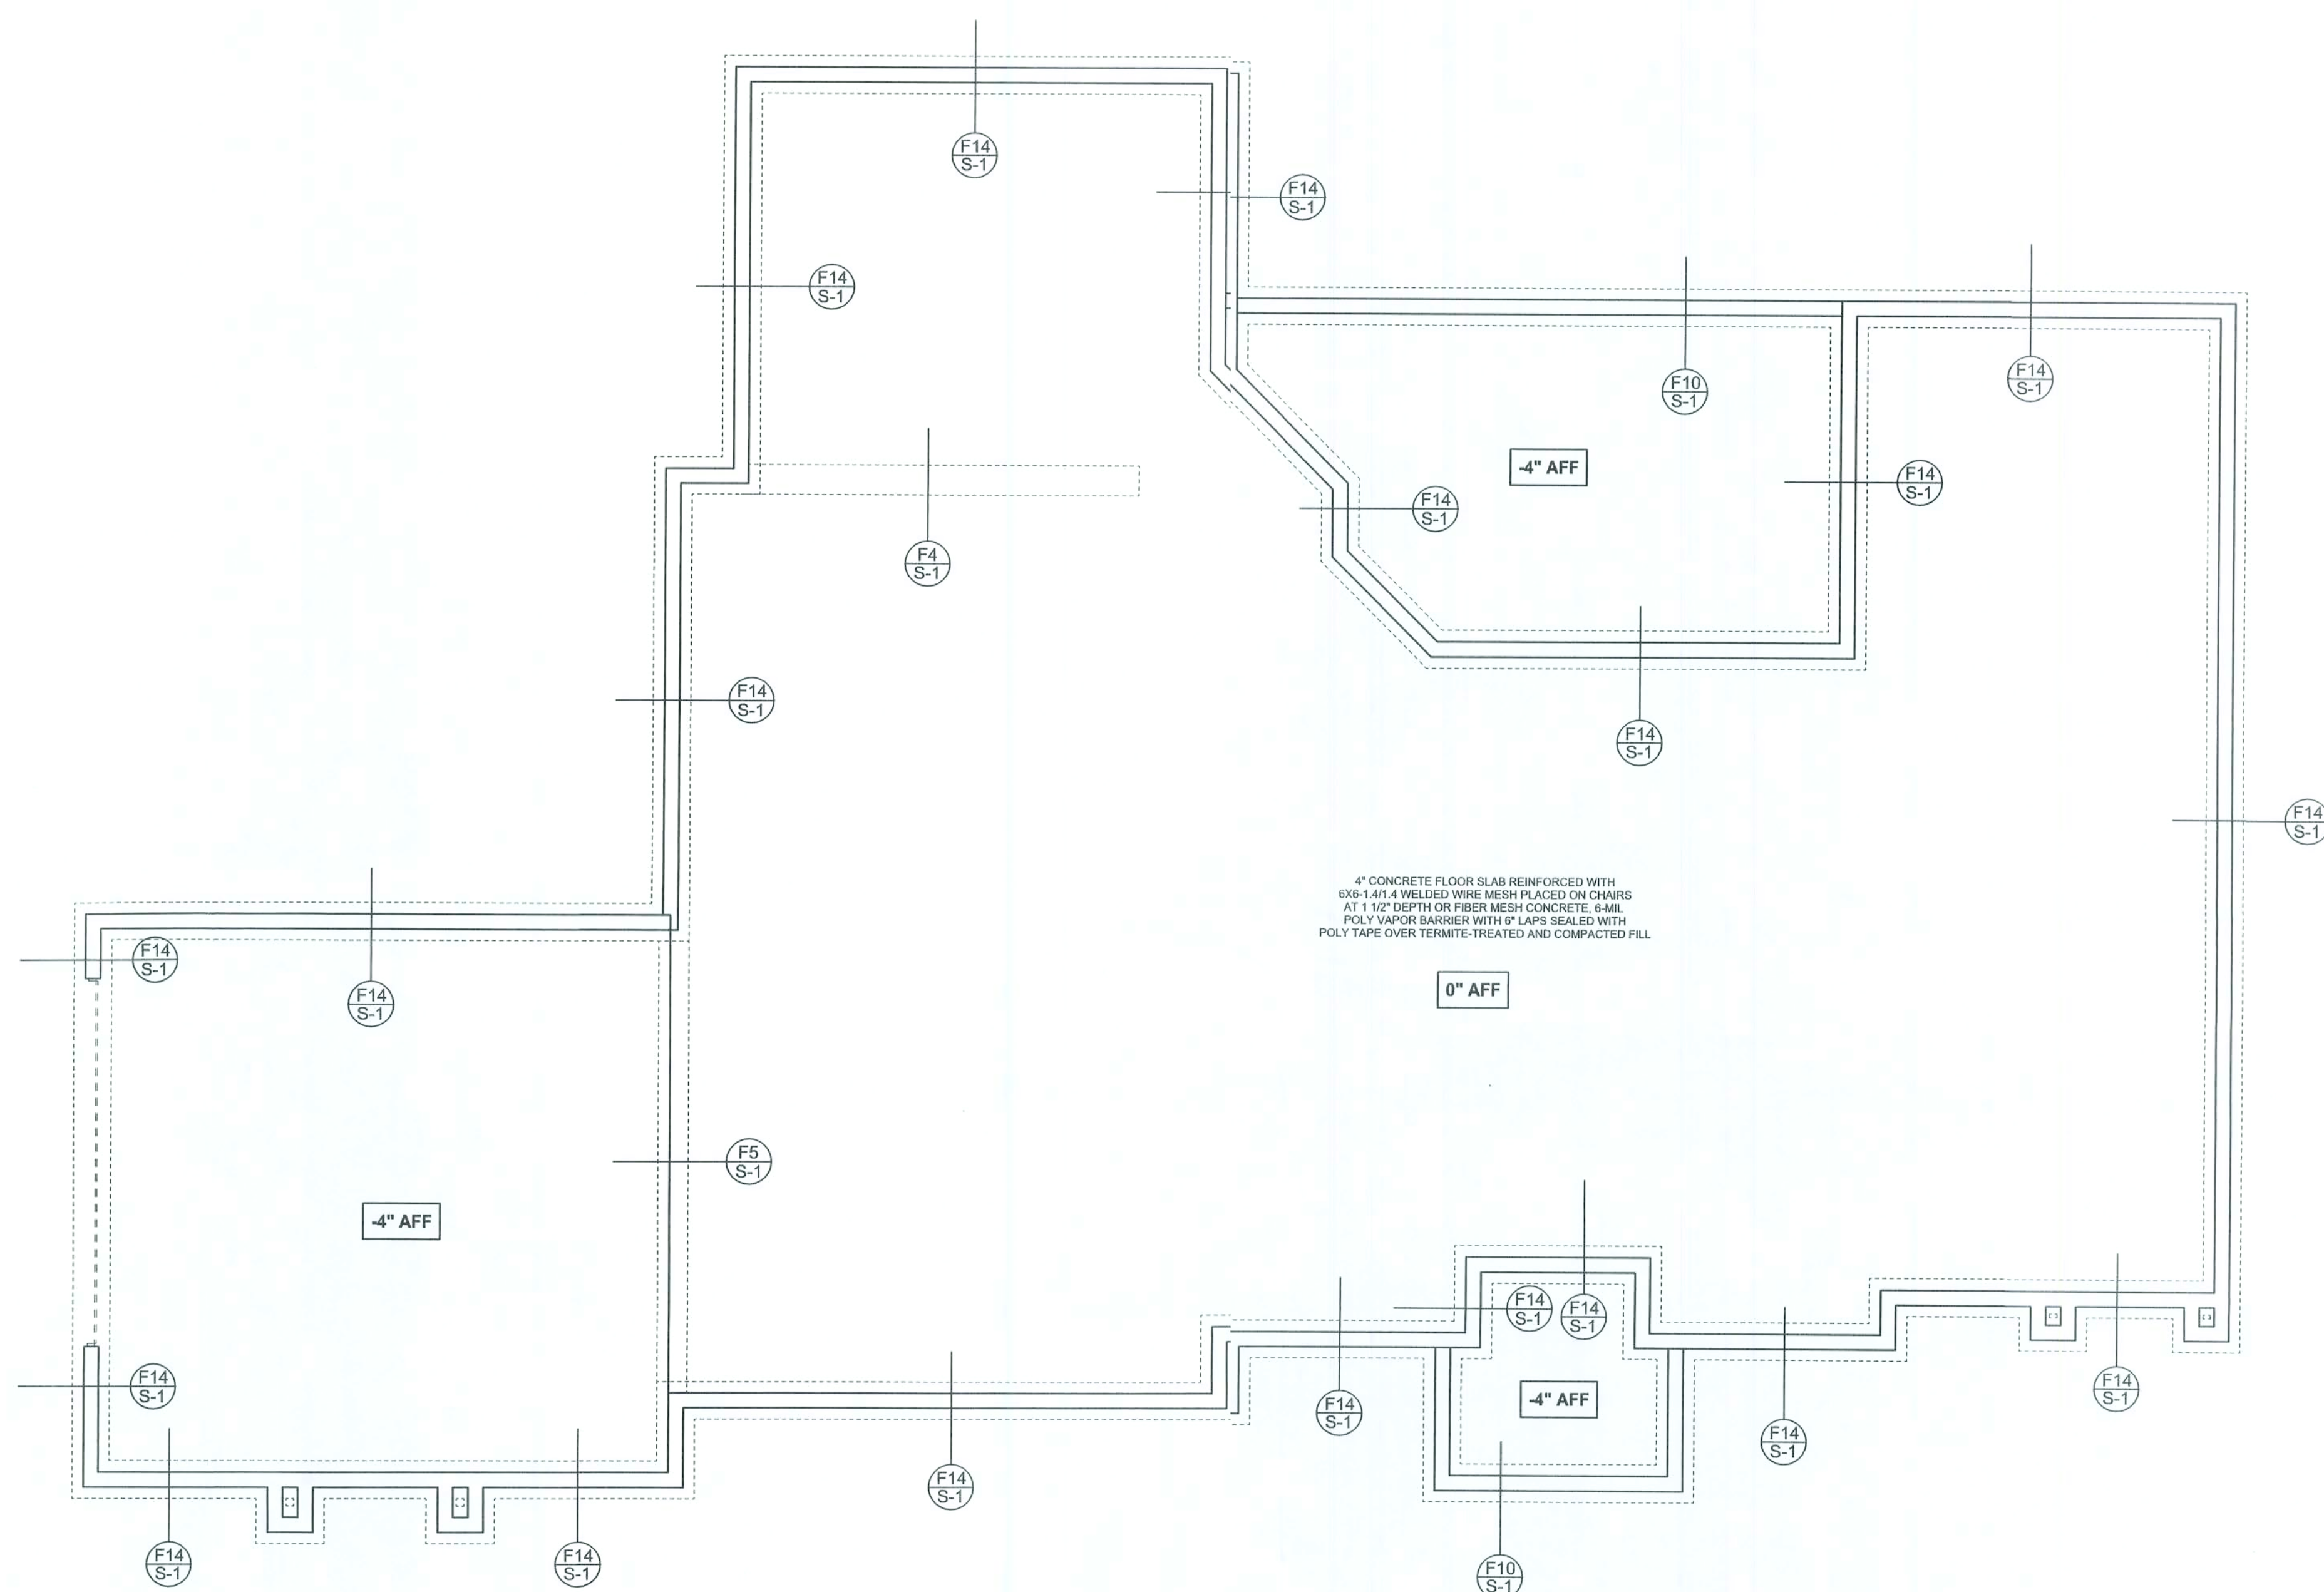

FOUNDATION PLAN
 SCALE: 3/8" = 1'-0"
 DIMENSIONS ON STRUCTURAL SHEETS
 ARE NOT EXACT. REFER TO ARCHITECTURAL
 FLOOR PLAN FOR ACTUAL DIMENSIONS

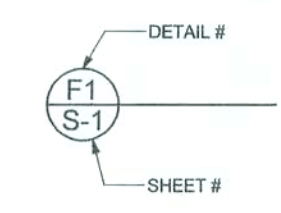

REVISIONS	



WINDLOAD ENGINEER:
 Mark Disosway, P.E.
 No. 53815, P.O.B. 868, Lake City, FL 32056,
 386-754-0419

DIMENSIONS:
 Stated dimensions supersede scaled dimensions. Refer all questions to Mark Disosway, P.E. for resolution. Do not proceed without clarification.

COPYRIGHTS AND PROPERTY RIGHTS:
 Mark Disosway, P.E. hereby expressly reserves its common law copyrights and property right in these instruments of service. This document is not to be reproduced, altered or copied in any form or manner without first the express written permission and consent of Mark Disosway.

CERTIFICATION: I hereby certify that I have examined this plan, and the applicable portions of the plan, relating to wind engineering comply with section R301.2.1, Florida building code residential 2004, to the best of my knowledge.

LIMITATION: This design is valid for one building, at specified location.

MARK DISOSWAY
 P.E. 53815

Mark Disosway
 23 OCT 08
 SEAL

Isaac Construction

Suresh & Daxa
 Patel Residence

ADDRESS:
 Columbia County, Florida

Mark Disosway P.E.
 P.O. Box 868
 Lake City, Florida 32056
 Phone: (386) 754 - 5419
 Fax: (386) 269 - 4871


PRINTED DATE:
 October 23, 2008

DRAWN BY: STRUCTURAL BY
 David Disosway

FINALS DATE:
 23 Oct 08

JOB NUMBER:
 809062a

DRAWING NUMBER
S-2
 OF 2 SHEETS

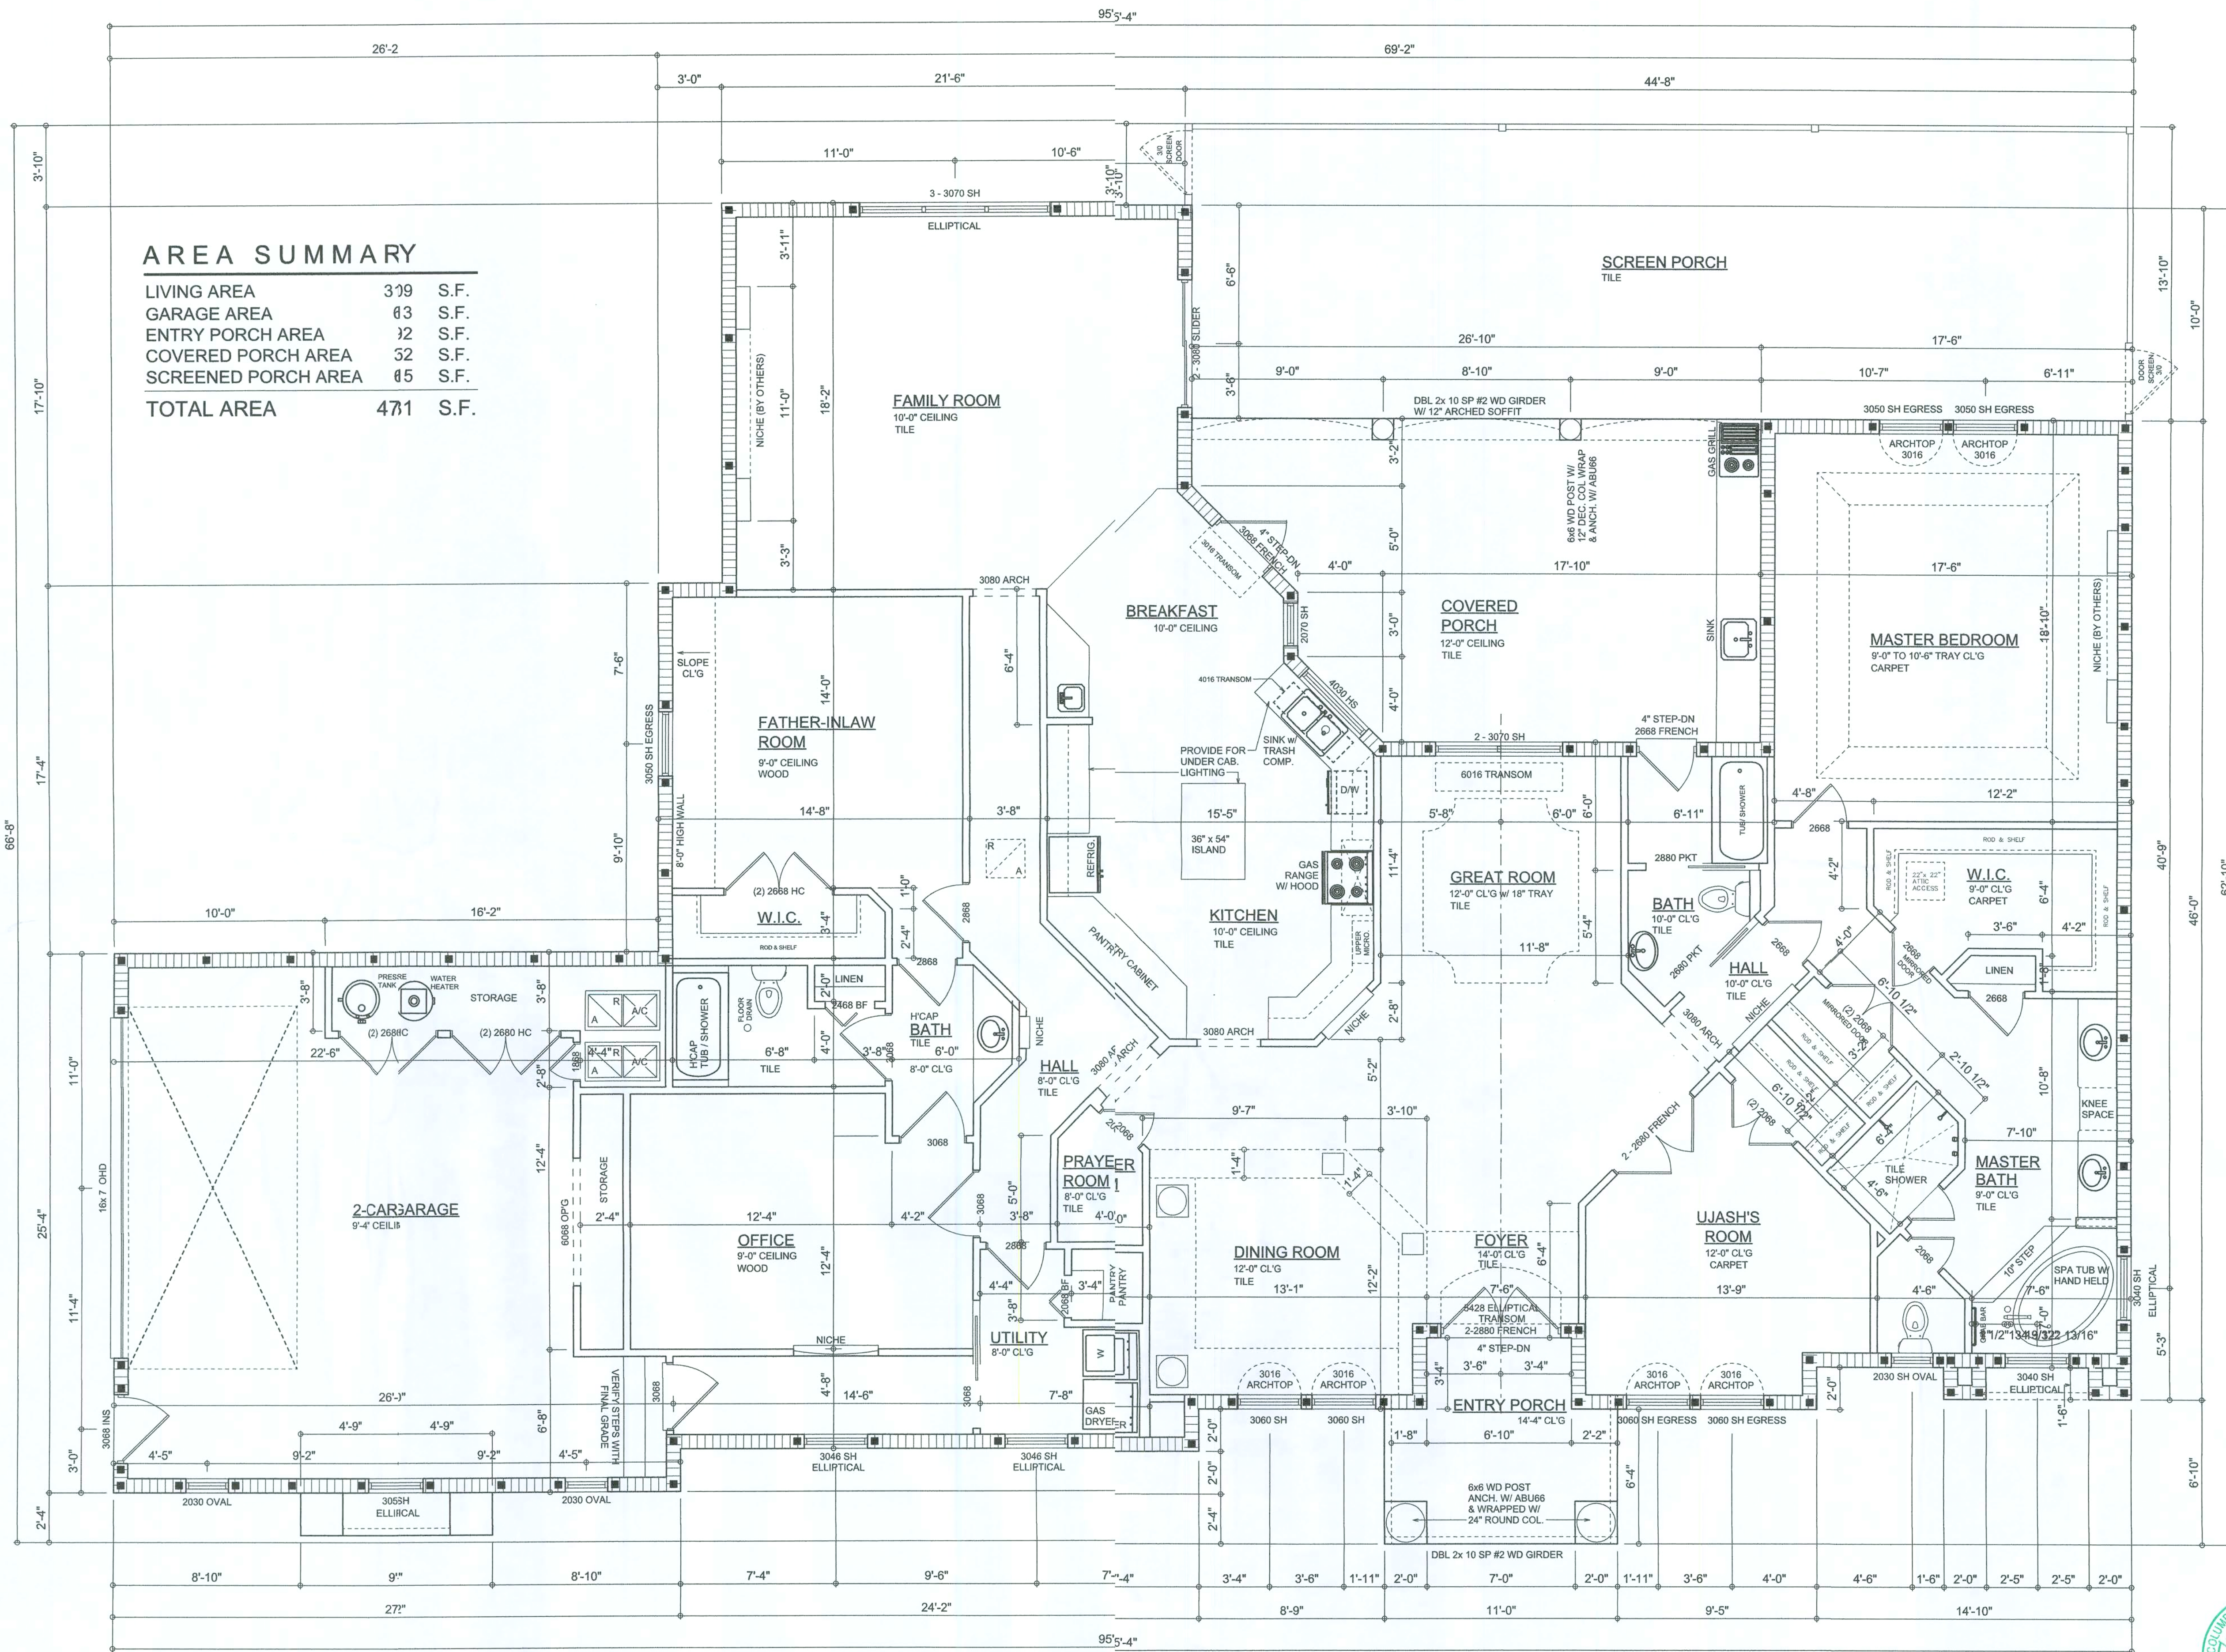


AREA SUMMARY

LIVING AREA	309	S.F.
GARAGE AREA	43	S.F.
ENTRY PORCH AREA	32	S.F.
COVERED PORCH AREA	32	S.F.
SCREENED PORCH AREA	45	S.F.
TOTAL AREA	471	S.F.

FLOOR PLAN
SCALE: 1/4" = 1'-0"

NOTE: ALL DRAWINGS NOT TO BE SCALED, WRITTEN DIMENSIONS TAKE PRECEDENCE OVER SCALED DIMENSIONS

- Garage fire separations shall comply with the following:
- The private garage shall be separated from the dwelling unit and its attic area by means of a minimum 1/2-inch (12.7 mm) gypsum board applied to the garage side. Garages shall be separated from the dwelling unit by a minimum 1/2-inch (12.7 mm) gypsum board or equivalent. Door openings between a private garage and the dwelling unit shall be equipped with either solid wood doors, or solid or honeycomb core steel doors not less than 1 3/8 inches (34.9 mm) thick, or doors in compliance with Section 715.3.3. Openings from a private garage directly into a room used for sleeping purposes shall not be permitted.
 - Ducts in a private garage and ducts penetrating the walls or ceilings separating the dwelling unit from the garage shall be constructed of a minimum 0.019-inch (0.48 mm) sheet steel and shall have no openings into the garage.
 - A separation is not required between a Group R-3 and U carport provided the carport is entirely open on two or more sides and there are not enclosed areas above.
 - When installing an attic access and/or pull-down stair unit in the garage, devise shall have a minimum 20 min. fire rating.

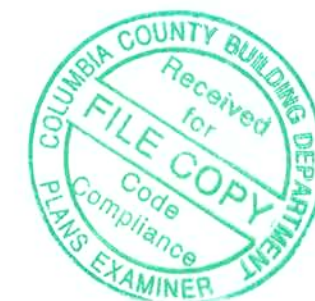

REVISIONS


November 19, 2008	0811-23
-------------------	---------

SOFTPLAN
ARCHITECTURAL DESIGN SOFTWARE

FLOOR PLAN
SCALE: 1/4" = 1'-0"

A CUSTOM RESIDENCE FOR:
SURESH & DANA PATEL
PROJECT ADDRESS: LOT 7, CYPRESS LAKE PHASE II, LAKE CITY, FLORIDA 33025
ISAAC CONSTRUCTION, LLC.
LAKE CITY, FLORIDA 33025

WILLIAM MYERS
P.E.
P.O. BOX 113
LAKE CITY, FL 33025
(386) 758-3406
will@willmyers.net

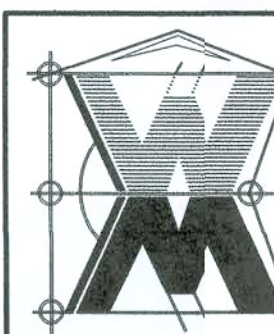

JOB NUMBER
0809C2


SHEET NUMBER
A.3
OF 4 SHEETS

ELECTRICAL LEGEND	
	CEILING FAN (PRE-WIRE FOR LIGHT)
	DOUBLE SECURITY LIGHT
	RECESSED CAN LIGHT
	BATH EXHAUST FAN
	LIGHT FIXTURE
	DUPLEX OUTLET
	220v OUTLET
	GFI DUPLEX OUTLET
	TELEVISION JACK
	TELEPHONE JACK
	SMOKE DETECTOR (see note below)
	WALL SWITCH
	3 WAY WALL SWITCH
	WATER PROOF GFI OUTLET
	2 OR 4 TUB FLUORESCENT FIXTURE

NOTE:
ALL BEDROOM RECEPTACLES SHALL BE ADI
(ARC FAULT CIRCUIT INTERRUPT)

ALL SMOKE DETECTORS SHALL HAVE BATTERY BACKUP POWER
AND ALL WIRED TOGETHER SO IF ANY ONE UNIT IS ACTUATED THEY
ALL ACTIVATE.

THE ELECTRICAL SERVICE OVERCURRENT PROTECTION DEVICE SHALL BE
INSTALLED ON THE EXTERIOR OF STRUCTURE TO SERVE AS A DISCONNECT MEANS.
CONDUCTORS USED FROM THE EXTERIOR DISCONNECTING MEANS TO A PANEL OR SUB
PANEL SHALL HAVE FOUR-WIRE CONDUCTORS, OF WHICH ONE CONDUCTOR
SHALL BE USED AS AN EQUIPMENT GROUND.

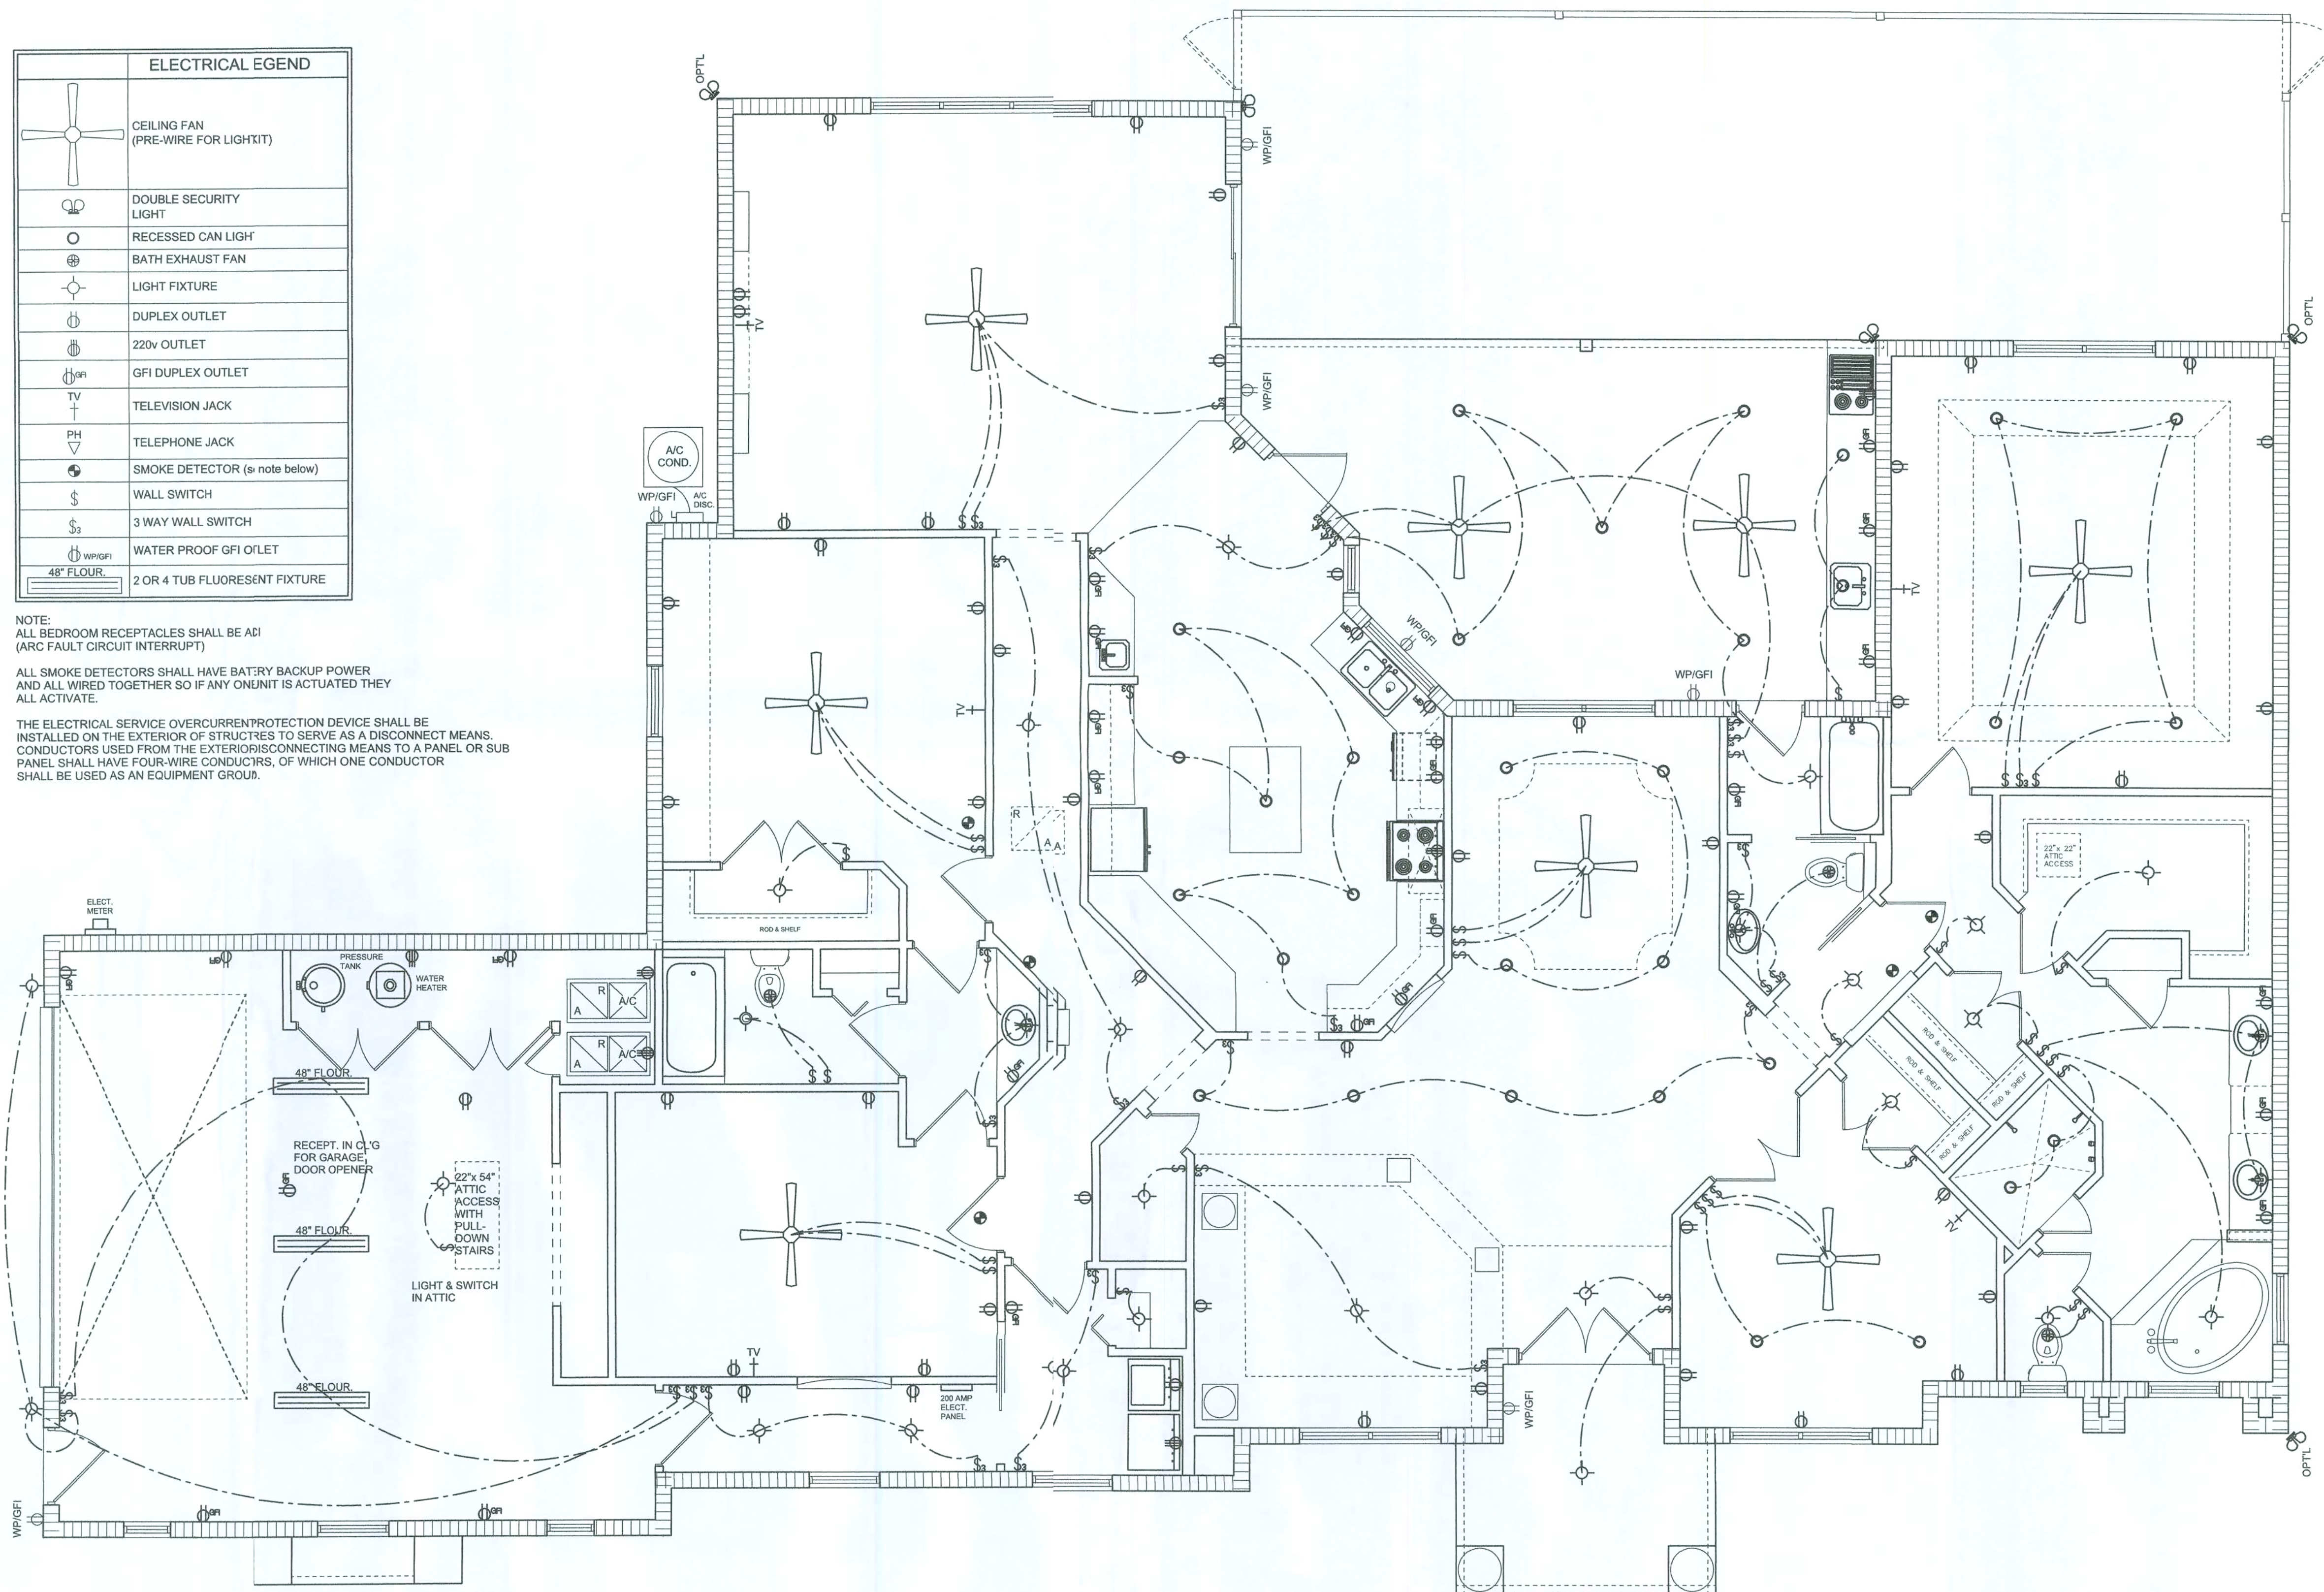

ELECTRICAL PLAN
SCALE: 1/4"=1'-0"

NOTE: ALL DRAWINGS NOT TO BE SCALED, WRITTEN DIMENSIONS TAKE PRECEDENCE OVER SCALED DIMENSIONS


REVISIONS
November 19, 2008

SOFTPLAN
ARCHITECTURAL DESIGN SOFTWARE

ELECTRICAL PLAN

A CUSTOM RESIDENCE FOR:
SURESH & DAXA PATEL
PROJECT ADDRESS: LOT 7, CYPRESS LAKE PHASE II, LAKE CITY, FLORIDA 32025
ISAAC CONSTRUCTION, LLC.
LAKE CITY, FLORIDA 32025


©WILLIAMMYERS
DESIGN
P.O. BOX 51513
LAKE CITY, IL 32056
(386) 758-8406
will@willmrs.net

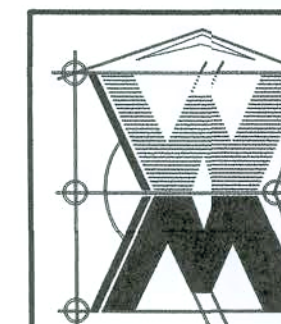

JOB NUMBER
080902

SHEET NUMBER
A.4
OF 4 SHEETS

William Myers

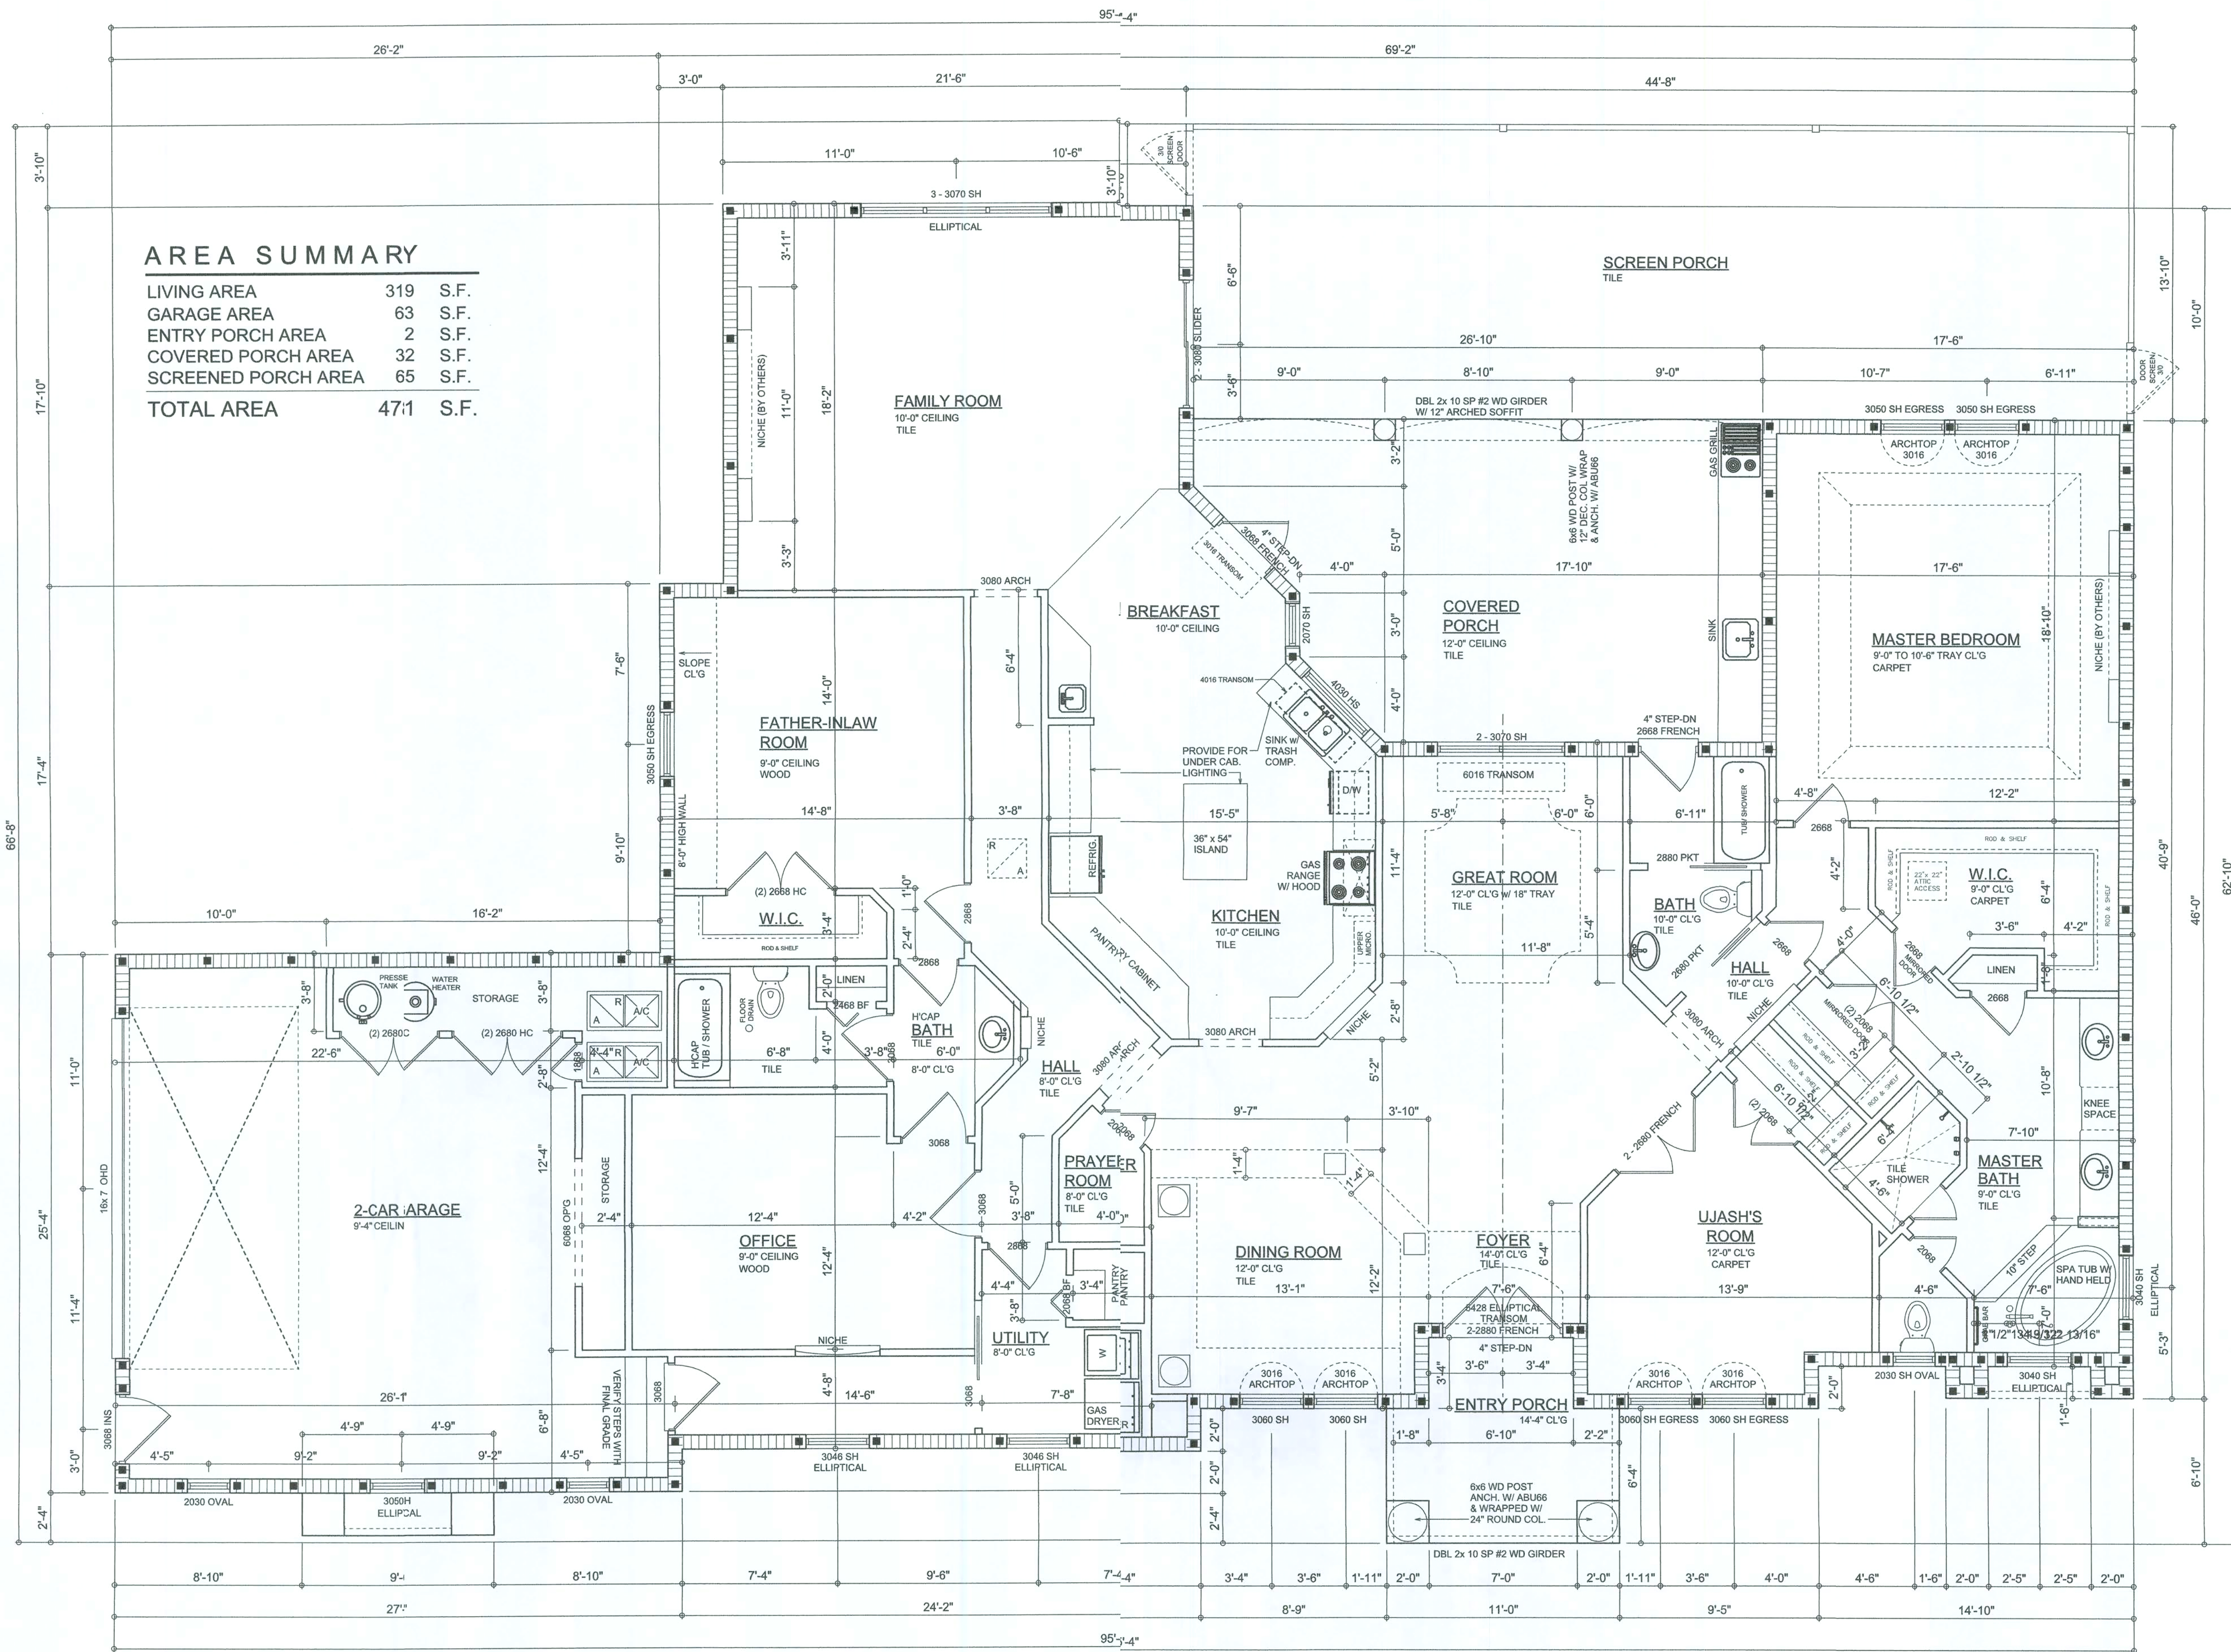

AREA SUMMARY		
LIVING AREA	319	S.F.
GARAGE AREA	63	S.F.
ENTRY PORCH AREA	2	S.F.
COVERED PORCH AREA	32	S.F.
SCREENED PORCH AREA	65	S.F.
TOTAL AREA	471	S.F.

FLOOR PLAN
SCALE: 1/4" = 1'-0"

NOTE: ALL DRAWINGS NOT TO BE SCALED, WRITTEN DIMENSIONS TAKE PRECEDENCE OVER SCALED DIMENSIONS

- Garage fire separations shall comply with the following:
1. The private garage shall be separated from the dwelling unit and its attic area by means of a minimum 1/2 inch (12.7 mm) gypsum board applied to the garage side. Garages beneath habitable rooms shall be separated from all habitable rooms above by not less than 5/8 inch Type X gypsum board or equivalent. Door openings between a private garage and the dwelling unit shall be equipped with either solid wood doors, or solid or honeycomb core steel doors not less than 1 3/8 inches (34.9 mm) thick, or doors in compliance with Section 715.3.3. Openings from a private garage directly into a room used for sleeping purposes shall not be permitted.
 2. Ducts in a private garage and ducts penetrating the walls or ceilings separating the dwelling unit from the garage shall be protected with a minimum 0.019-inch (0.48 mm) sheet steel and shall have no openings into the garage.
 3. A separation is not required between a Group R-3 and U carport provided the carport is entirely open on two or more sides and there are not enclosed areas above.
 4. When installing an attic access and/or pull-down stair unit in the garage, devise shall have a minimum 20 min. fire rating.

REVISIONS
November 19, 2008

SOFTPLAN
ARCHITECTURAL DESIGN SOFTWARE

FLOOR PLAN
SCALE: 1/4" = 1'-0"

A CUSTOM RESIDENCE FOR:
SURESH & DAXA PATEL
PROJECT ADDRESS: LOT 7, CYPRESS LAKE PHASE II, LAKE CITY, FLORIDA 32025
ISAAC CONSTRUCTION, LLC.
LAKE CITY, FLORIDA, 32025

©WILLIAM MYERS
DESIGN
P.O. BOX 183
LAKE CITY, FL 32056
(386) 758-4406
will@willmyers.net

JOB NUMBER
080902

SHEET NUMBER
A.3
OF 4 SHEETS


WMC

ELECTRICAL LEGEND	
	CEILING FAN (PRE-WIRE FOR LIGHTIT)
	DOUBLE SECURITY LIGHT
	RECESSED CAN LIGHT
	BATH EXHAUST FAN
	LIGHT FIXTURE
	DUPLEX OUTLET
	220v OUTLET
	GFI DUPLEX OUTLET
	TELEVISION JACK
	TELEPHONE JACK
	SMOKE DETECTOR (see note below)
	WALL SWITCH
	3 WAY WALL SWITCH
	WATER PROOF GFI OUTLET
	2 OR 4 TUB FLUORESCENT FIXTURE

NOTE:
ALL BEDROOM RECEPTACLES SHALL BE AFCI
(ARC FAULT CIRCUIT INTERRUPT)

ALL SMOKE DETECTORS SHALL HAVE BATTERY BACKUP POWER
AND ALL WIRED TOGETHER SO IF ANY ONE UNIT IS ACTUATED THEY
ALL ACTIVATE.

THE ELECTRICAL SERVICE OVERCURRENT PROTECTION DEVICE SHALL BE
INSTALLED ON THE EXTERIOR OF STRUCTURE TO SERVE AS A DISCONNECT MEANS.
CONDUCTORS USED FROM THE EXTERIOR TO CONNECTING MEANS TO A PANEL OR SUB
PANEL SHALL HAVE FOUR-WIRE CONDUCTORS, OF WHICH ONE CONDUCTOR
SHALL BE USED AS AN EQUIPMENT GROUND.

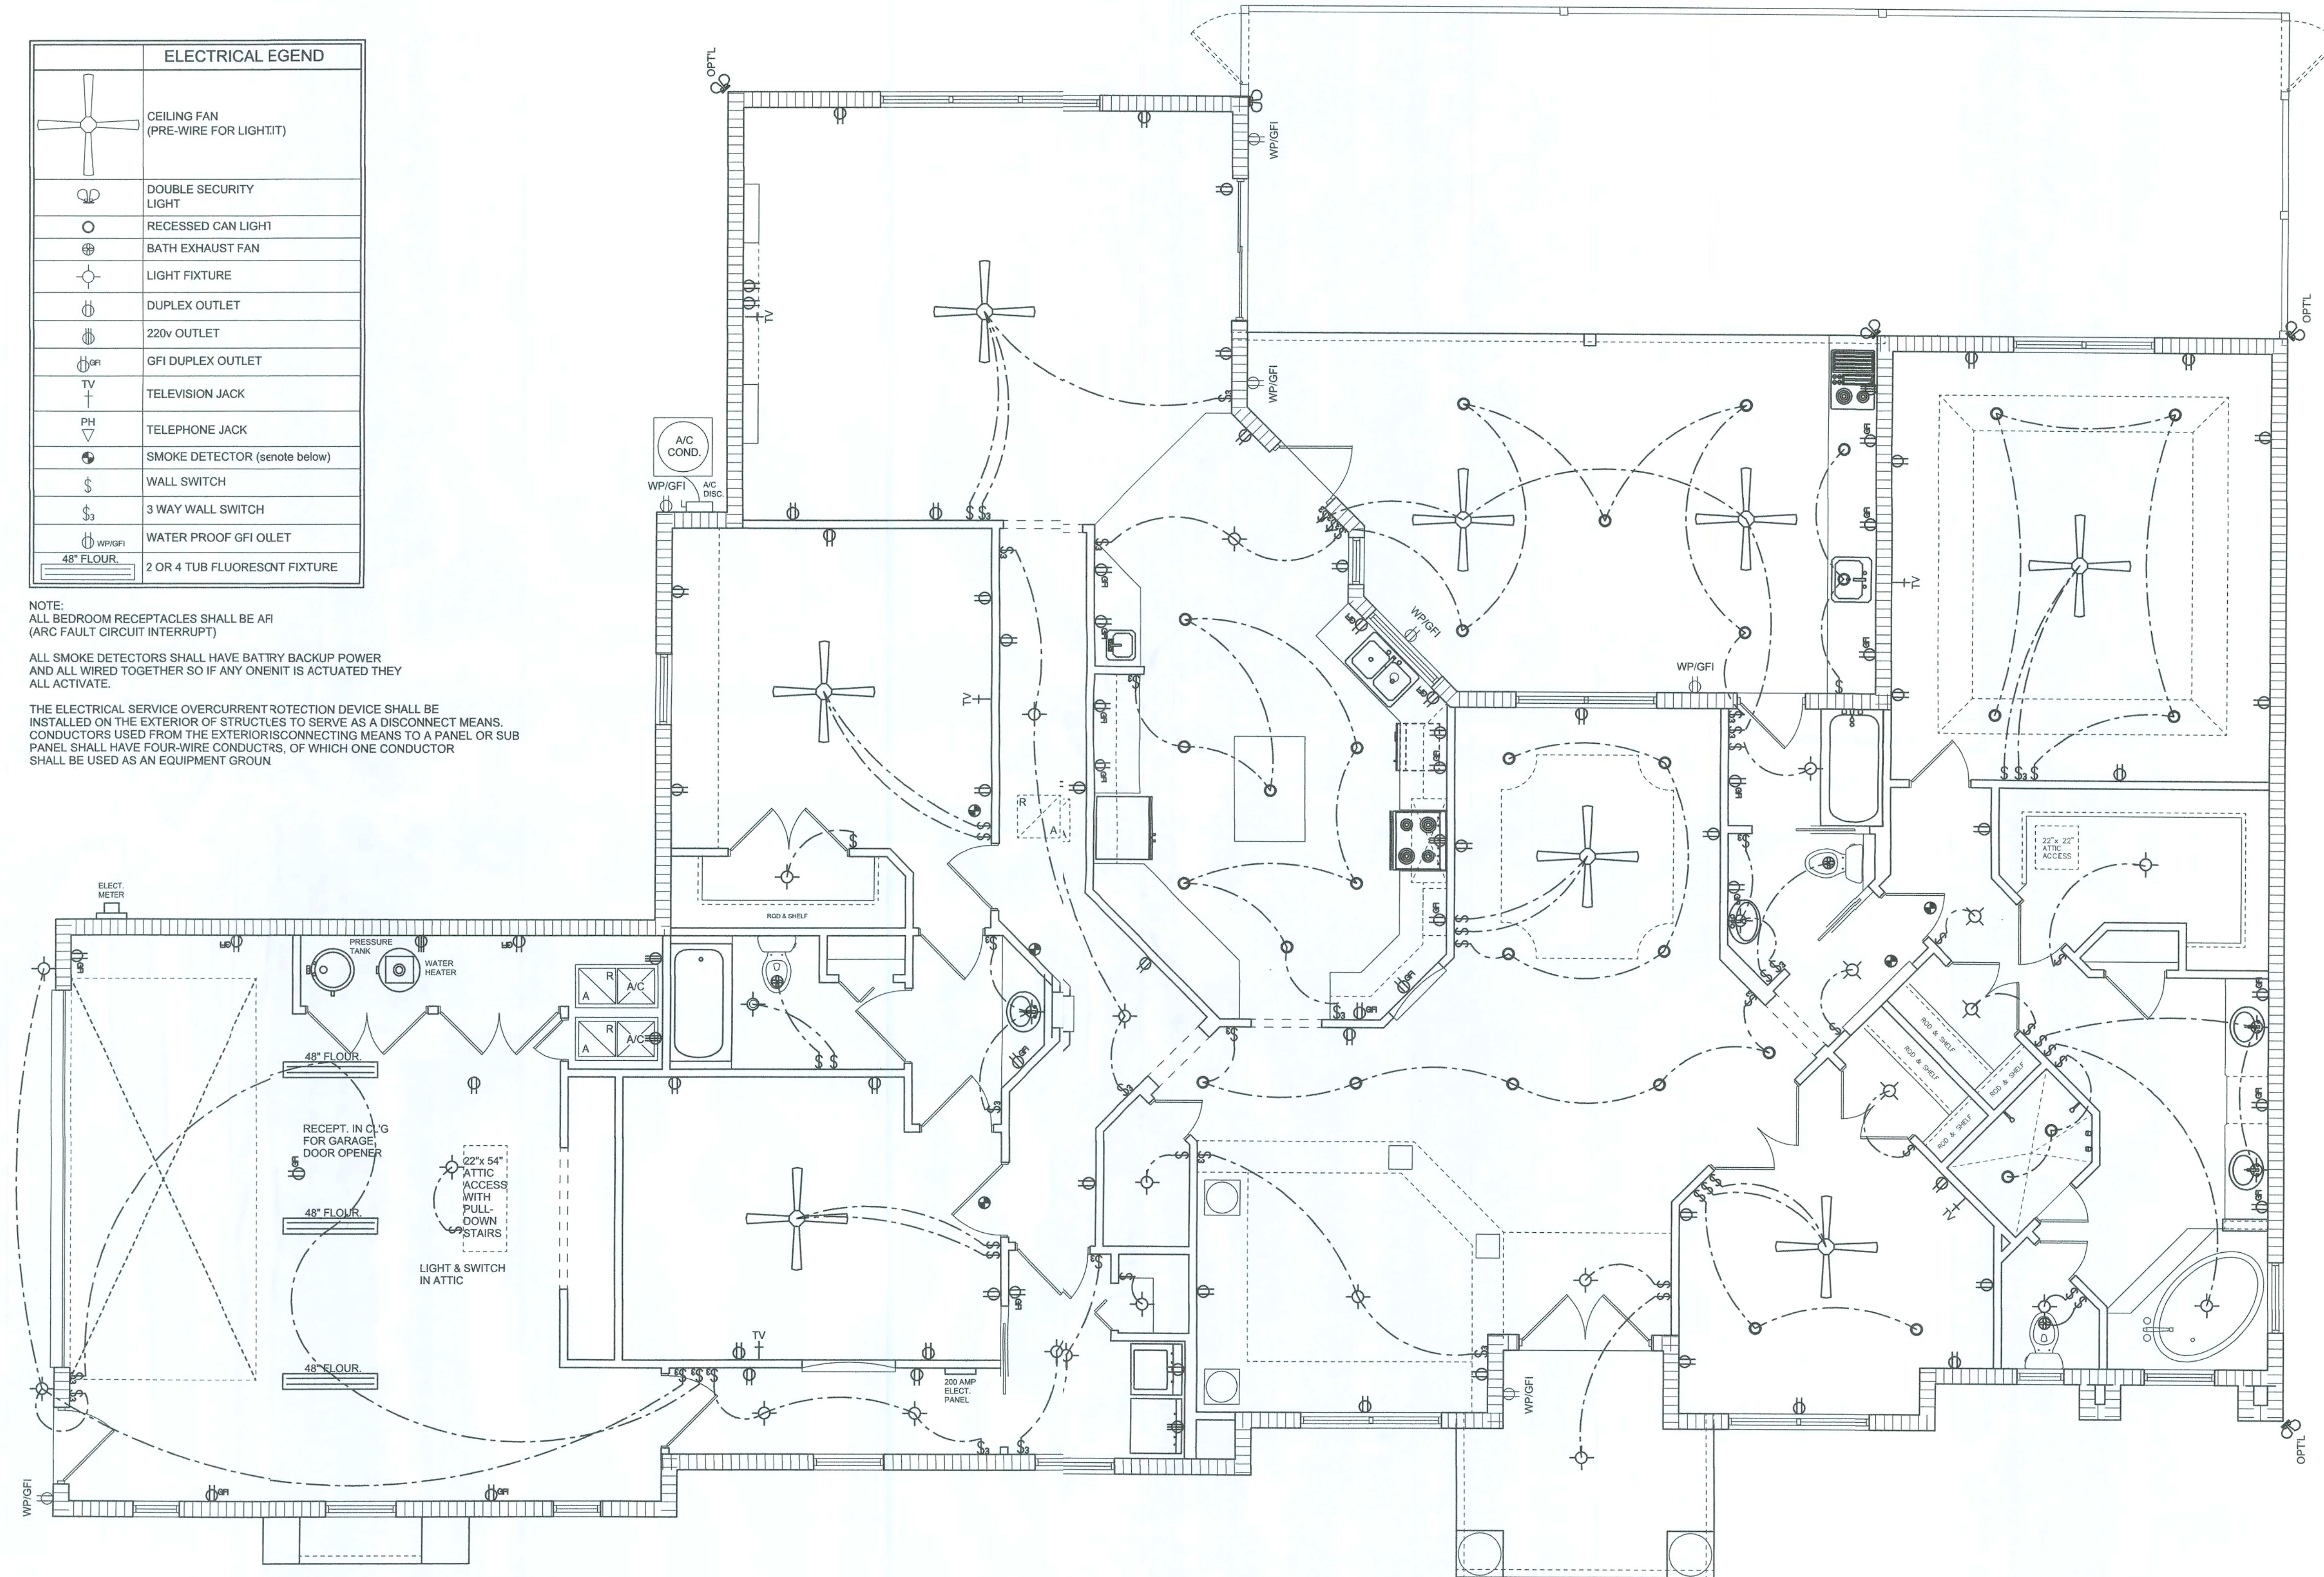

ELECTRICAL PLAN
SCALE: 1/4" = 0'

NOTE: ALL DRAWINGS NOT TO BE SCALED, WRITTEN DIMENSIONS TAKE PRECEDENCE OVER SCALED DIMENSIONS

REVISIONS
November 19, 2008

SOFTPLAN
ARCHITECTURAL DESIGN SOFTWARE

ELECTRICAL PLAN
SCALE: 1/4" = 0'

A CUSTOM RESIDENCE FOR:
SURESH & DAXA PATEL
PROJECT ADDRESS: LOT 7, CYPRESS LAKE PHASE II, LAKE CITY, FLORIDA 32025
ISAAC CONSTRUCTION, LLC.
LAKE CITY, FLORIDA 32025

©WILLIAM MYERS
DESIGN
P.O. BOX 513
LAKE CITY, FL 32056
(386) 7588406
will@willmyers.net



JOB NUMBER
080902

SHEET NUMBER

A.4

OF 4 SHEETS

W.M.C. Myers

