



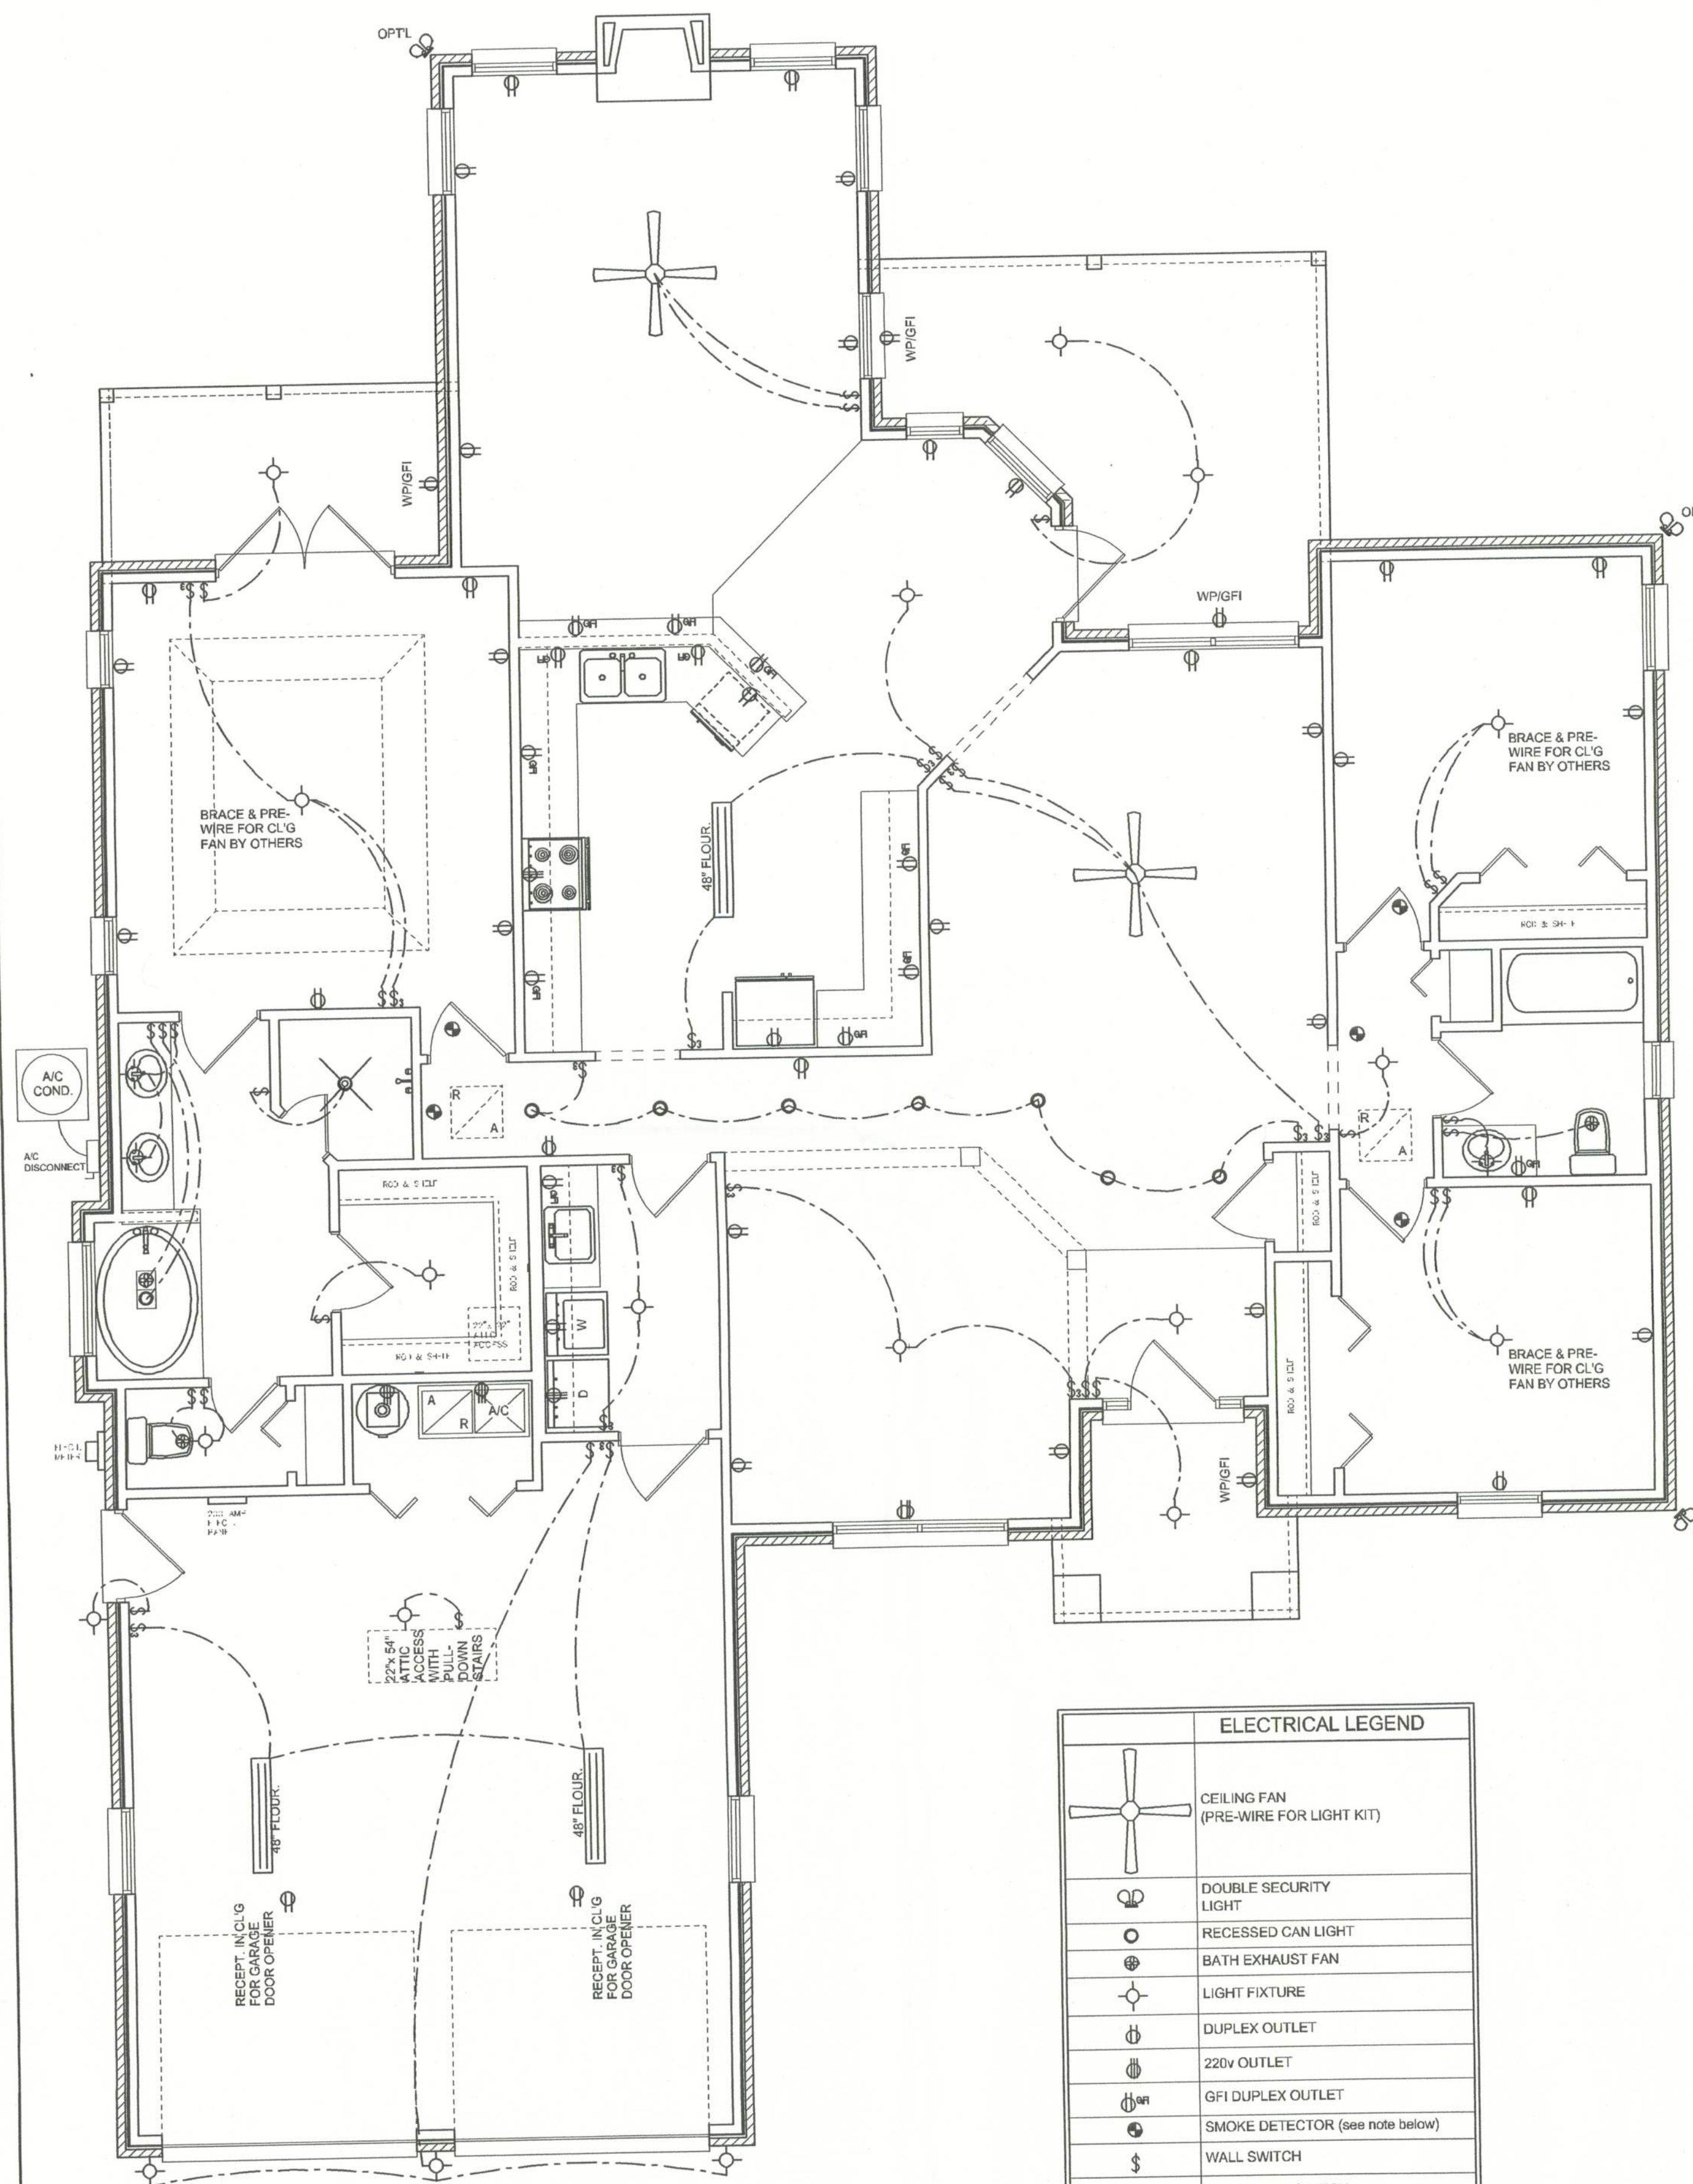

ELECTRICAL PLAN
SCALE: 1/4" = 1'-0"

NOTE:
ALL BEDROOM RECEPTACLES SHALL BE AFCI
(ARC FAULT CIRCUIT INTERRUPT)
ALL SMOKE DETECTORS SHALL HAVE BATTERY BACKUP POWER
AND ALL WIRED TOGETHER SO IF ANY ONE UNIT IS ACTUATED THEY
ALL ACTIVATE.

ELECTRICAL LEGEND	
	CEILING FAN (PRE-WIRE FOR LIGHT KIT)
	DOUBLE SECURITY LIGHT
	RECESSED CAN LIGHT
	BATH EXHAUST FAN
	LIGHT FIXTURE
	DUPLEX OUTLET
	220V OUTLET
	GFI DUPLEX OUTLET
	SMOKE DETECTOR (see note below)
	WALL SWITCH
	3 WAY WALL SWITCH
	WATER PROOF GFI OUTLET
	2 OR 4 TUB FLUORESCENT FIXTURE

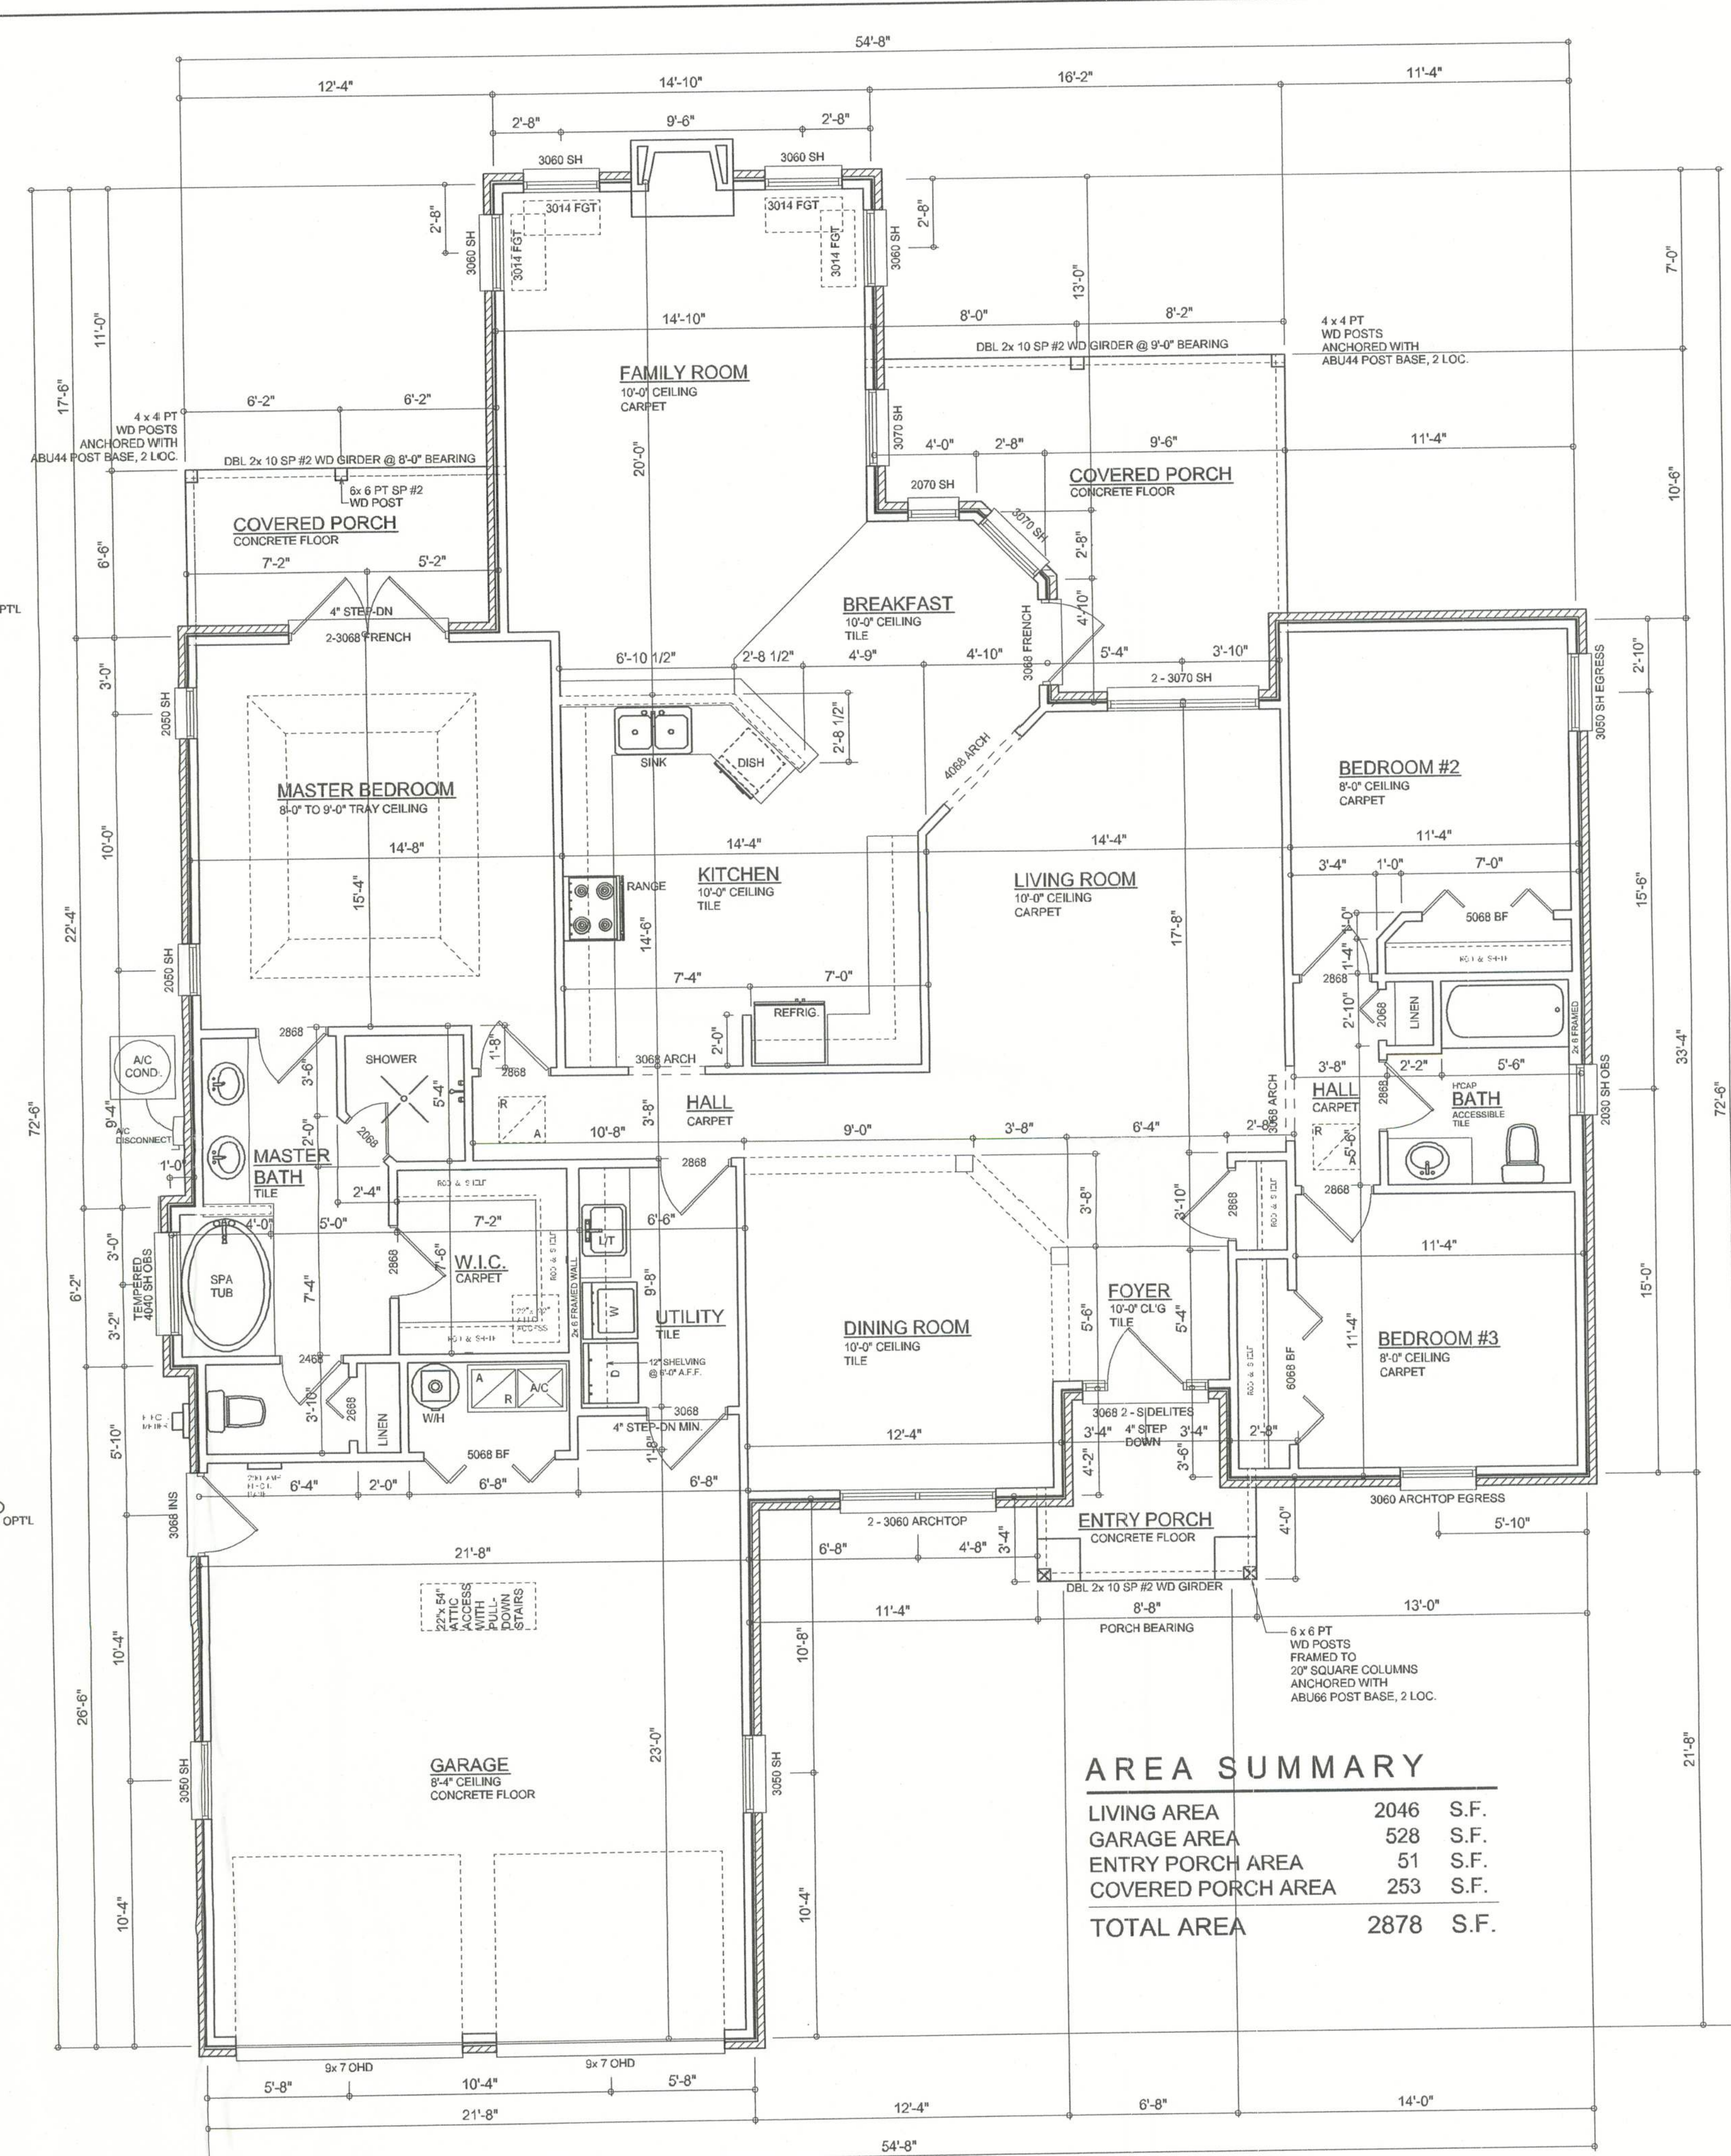

FLOOR PLAN
SCALE: 1/4" = 1'-0"

AREA SUMMARY	
LIVING AREA	2046 S.F.
GARAGE AREA	528 S.F.
ENTRY PORCH AREA	51 S.F.
COVERED PORCH AREA	253 S.F.
TOTAL AREA	2878 S.F.

REVISIONS
September 12, 2005

SOFTPLAN
ARCHITECTURAL DESIGN SOFTWARE

FLOOR PLAN
SCALE: 1/4" = 1'-0"
ELECTRICAL PLAN
SCALE: 1/4" = 1'-0"

THE CALLAWAY MODEL:
CADY HOMES & ASSOCIATES
PROJECT ADDRESS: LOT 79, CALLAWAY PHASE III, LAKE CITY, FLORIDA 32025

©WILLIAM MYERS
DESIGN
P.O. BOX 1513
LAKE CITY, FL 32056
(386) 758-8406
will@williamymyers.net

JOB NUMBER

SHEET NUMBER
A.3
OF 3 SHEETS

William Myers